


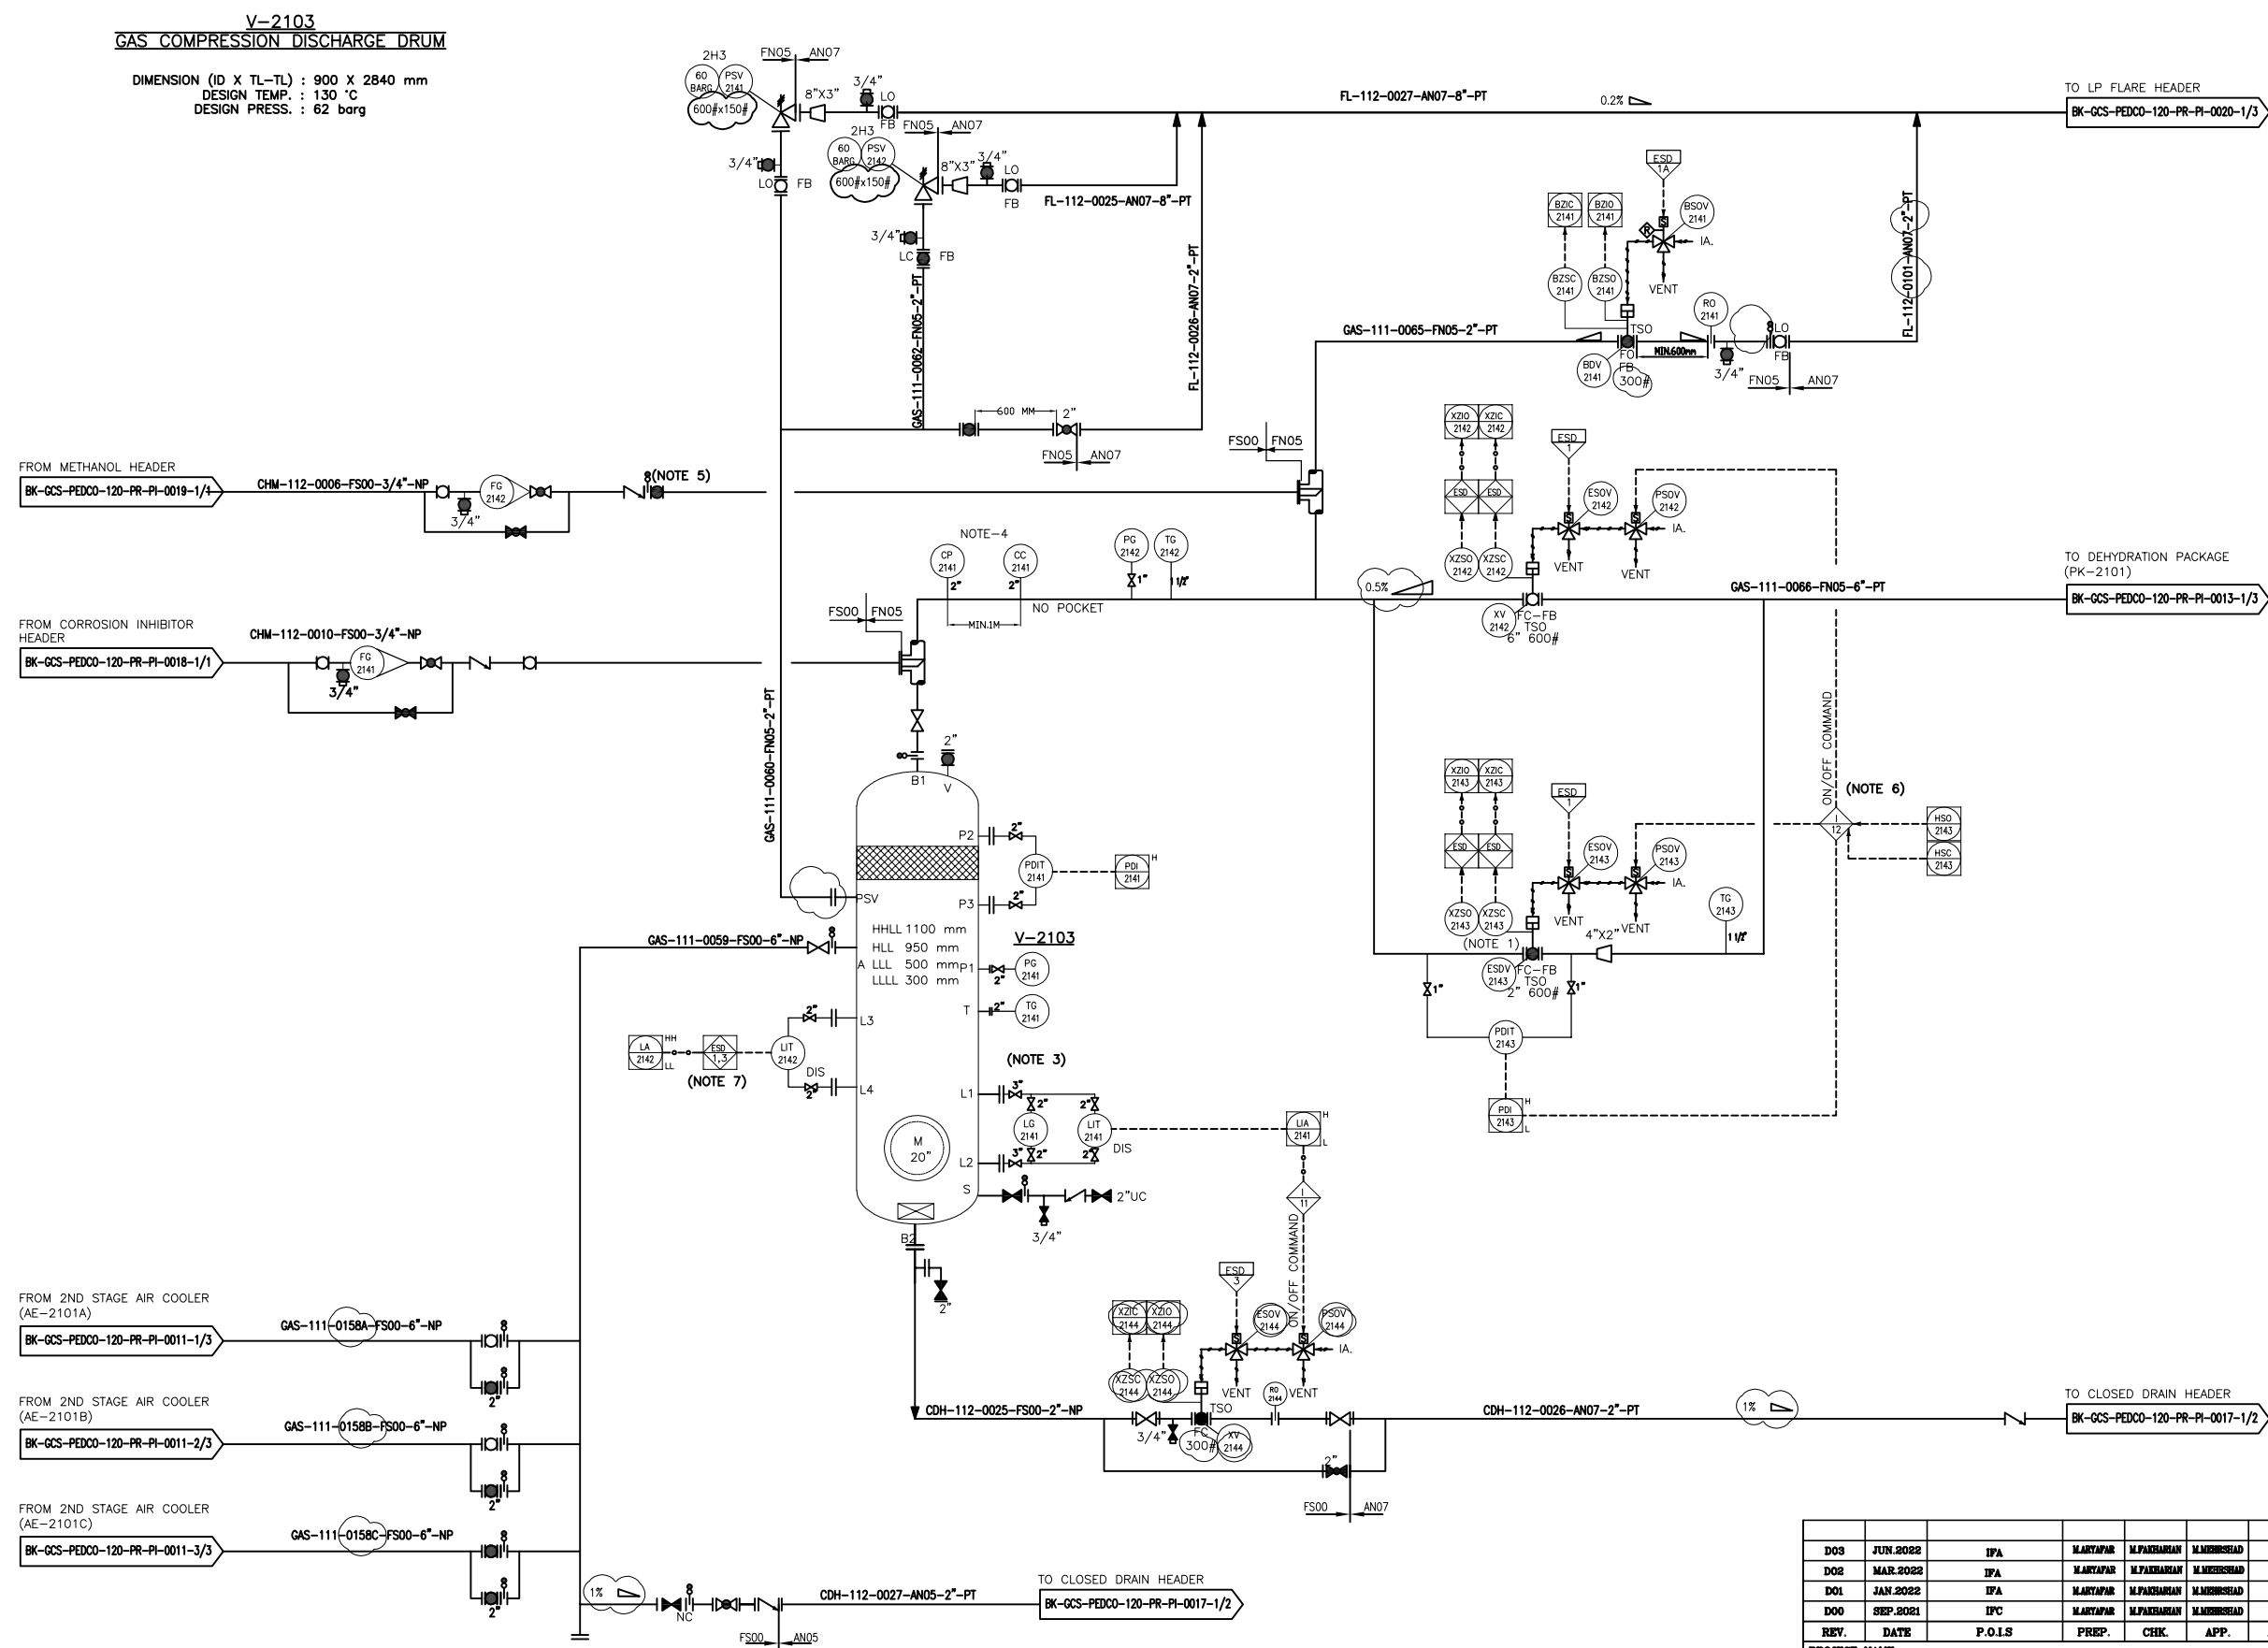


NOTES	
1-	DELETED.
2-	DELETED.
3-	DELETED.
4-	ONE PORTABLE METER FOR CORROSION PROBES TO BE PROVIDED PER SITE TO RECOVERY MONITOR CORROSION DATA.
5-	BEFORE IN CASE OF COLD DEPRESSURIZING, MANUAL VALVE WILL BE OPEN BY OPERATOR.
6-	OPEN/CLOSE COMMAND BY OPERATOR WILL BE IMPLEMENTED BY EQUALIZING LOGIC DURING START UP.
7-	ESD LEVEL 1 FOR HH AND 3 FOR LL LIQUID LEVEL.

LEGEND

REFERENCE DRAWING	DRG. No.
Process Flow Diagram	BK-GCS-PEDCO-120-PR-PF-0001
Symbol & Legend For PFD and P&ID	BK-GCS-PEDCO-120-PR-PI-0001

KEY PLAN

TYPE 1

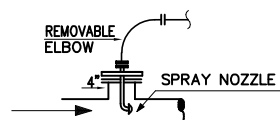

INJECTION DEVICE PERMANENTLY CONNECTED
(GAS SERVICE)

[illegible]