
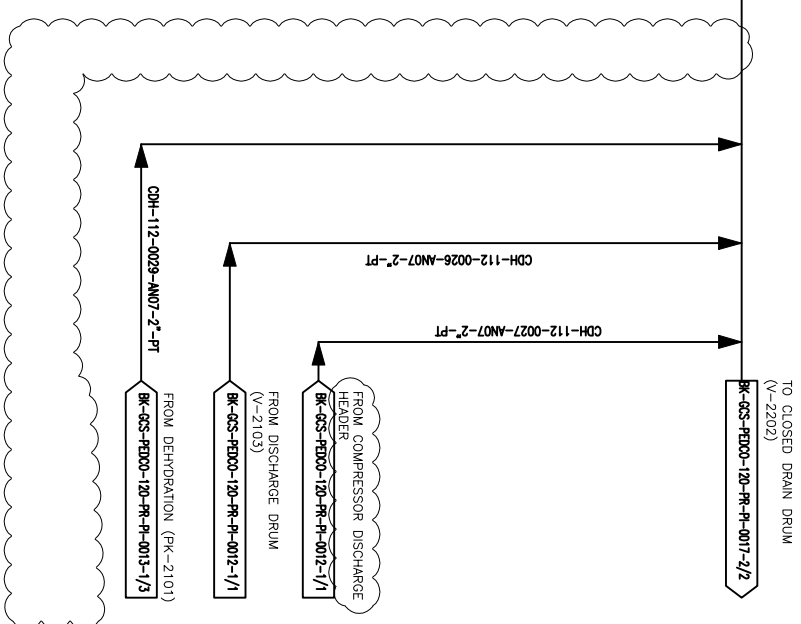
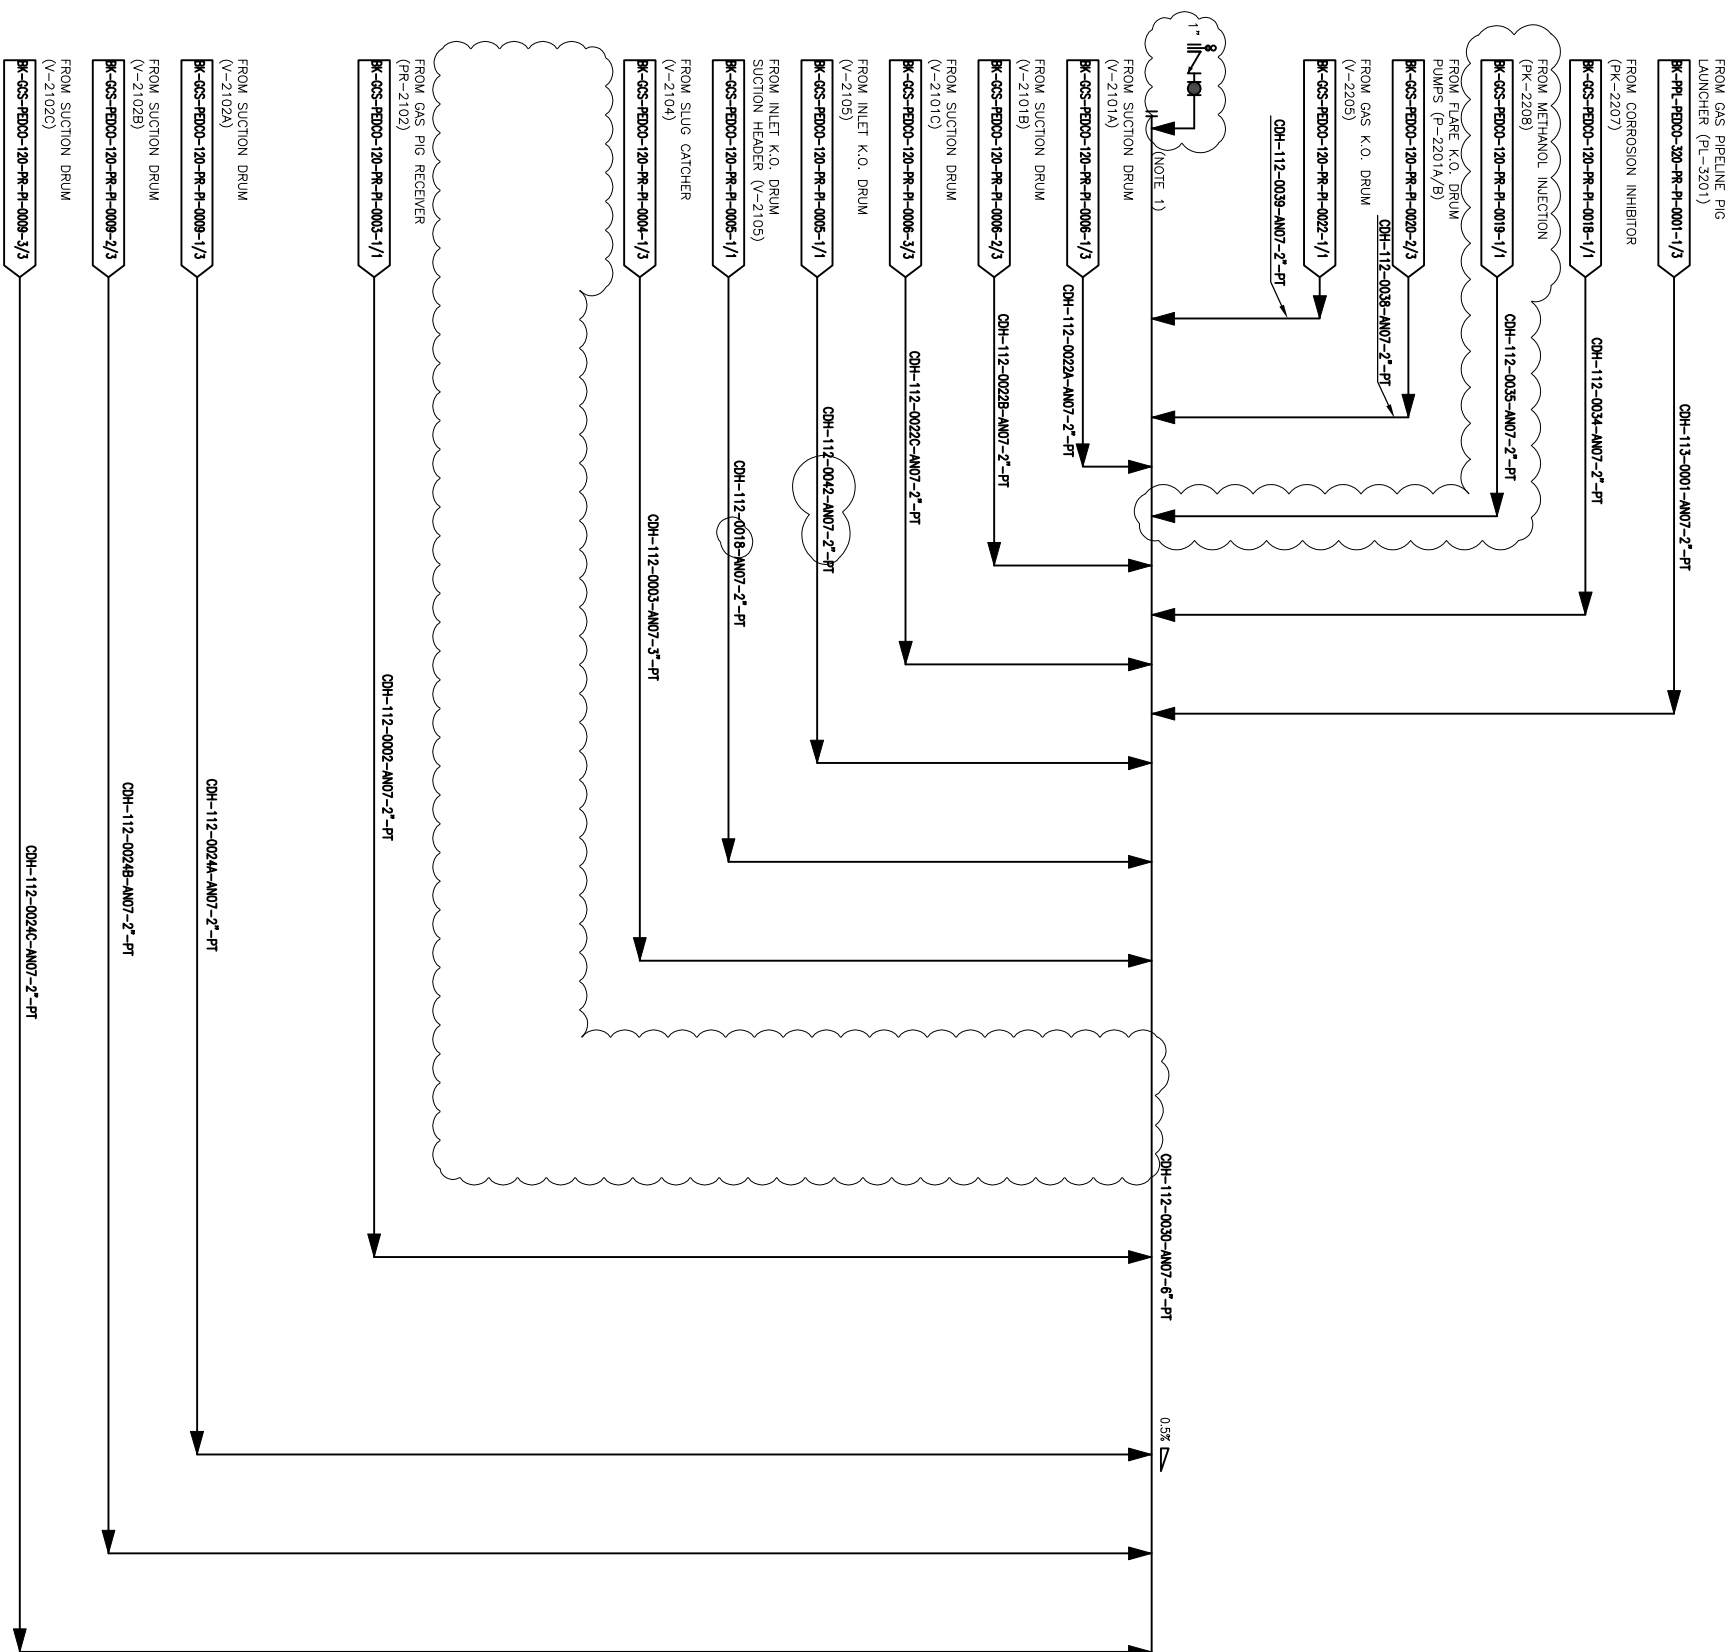


[illegible]

V-2202
CLOSED DRAIN DRUM
DIMENSION (D X TL-TL) : 2600 X 7800 mm
NOMINAL CAPACITY : 46 m³
DESIGN TEMP : 85 °C
DESIGN PRESS : 7.5 barg

SU-2201
LP FLARE K.O. DRUM AND CLOSED DRAIN
DRAIN SUMP

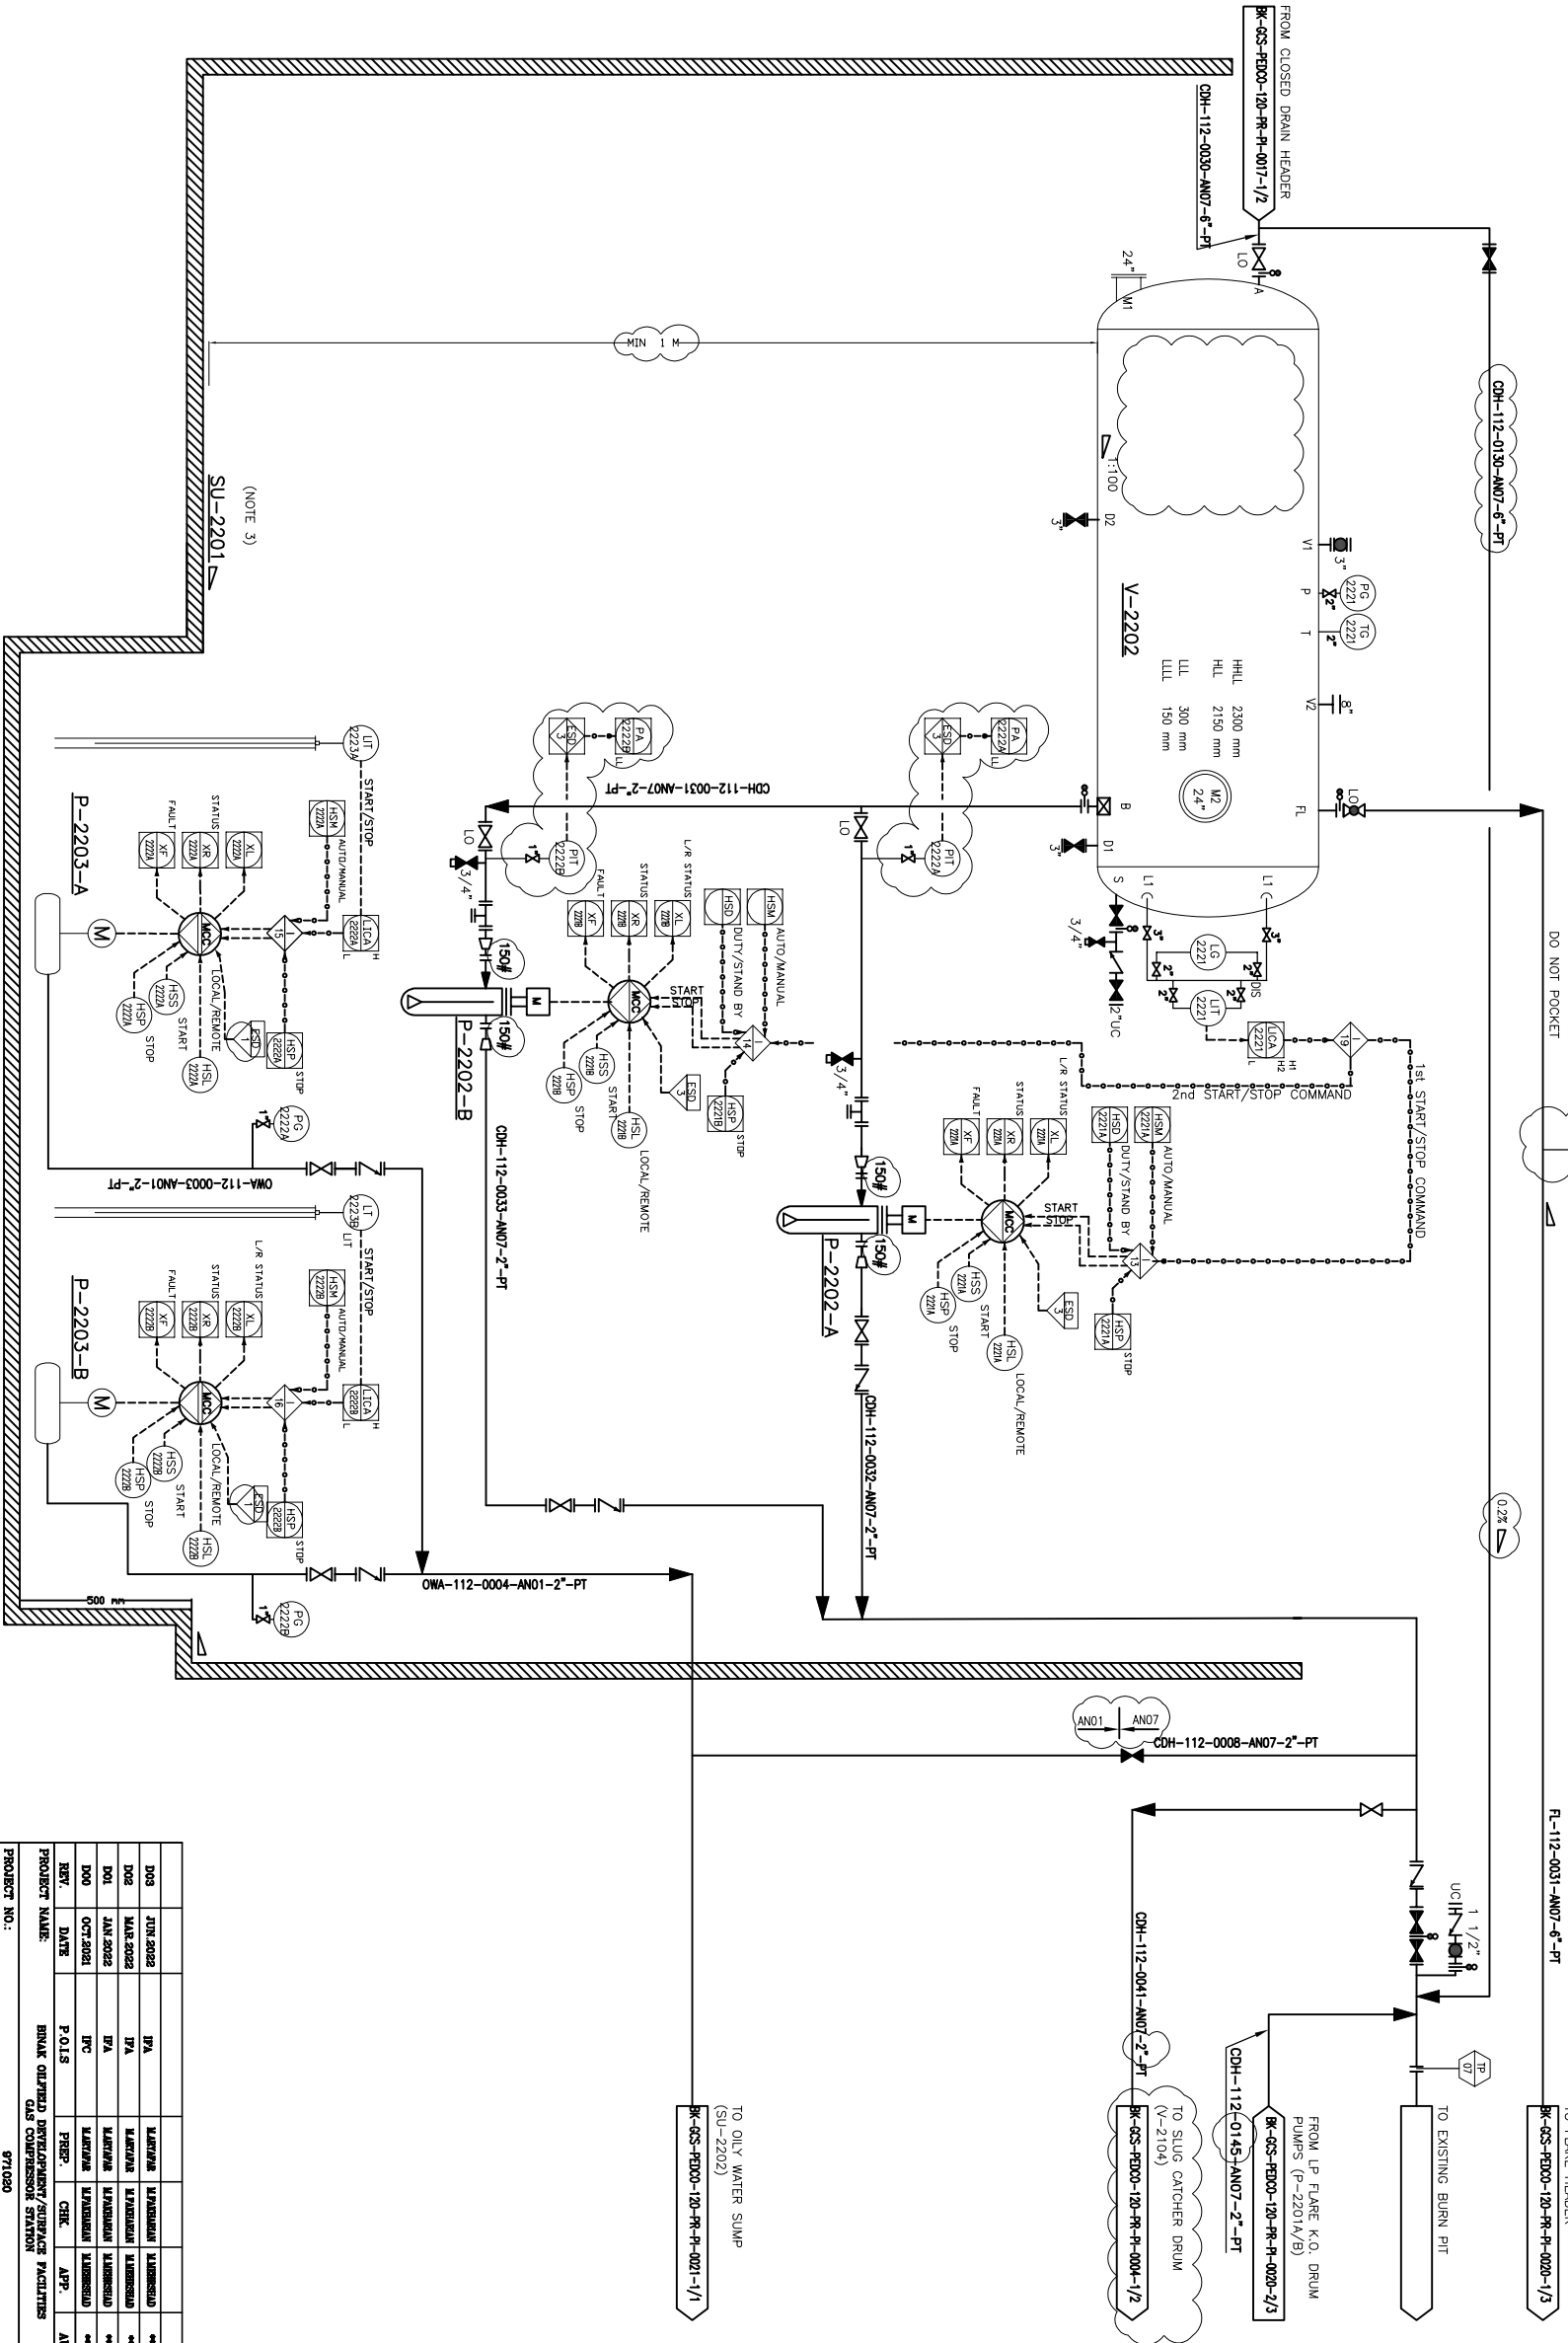

- NOTES
- 1- IN CASE OF LOW LEVEL OF UA-2221, THE CONTROL SYSTEM STOPS BOTH PUMPS. IF LIQUID LEVEL OF V-2202 REACHES H1 LEVEL, LEAD PUMP WILL BE STARTED. IN CASE OF H2 LEVEL ALARM, LAG PUMP WILL BE STARTED.
 - 2- DELETED.
 - 3- FLARE K.O. DRUM, CLOSE DRAIN AND RELATED PUMPS ARE IN COMMON PIT.

GENERAL NOTE

LEGEND

REFERENCE DRAWING	DRG. No.
Utility Flow Diagram	BK-GS-PB00-120-PR-UP-001
Symbol & Legend For PFD & P&ID	BK-GS-PB00-120-PR-P-001

KEY PLAN

REV.	DATE	DESCRIPTION	BY	DATE	REV.	DATE	DESCRIPTION	BY	DATE
001	2022-06-01	ISSUED FOR P&ID	...	...	001	2022-06-01	ISSUED FOR P&ID	...	...
002	2022-06-01	ISSUED FOR P&ID	...	...	002	2022-06-01	ISSUED FOR P&ID	...	...
003	2022-06-01	ISSUED FOR P&ID	...	...	003	2022-06-01	ISSUED FOR P&ID	...	...
004	2022-06-01	ISSUED FOR P&ID	...	...	004	2022-06-01	ISSUED FOR P&ID	...	...
005	2022-06-01	ISSUED FOR P&ID	...	...	005	2022-06-01	ISSUED FOR P&ID	...	...
006	2022-06-01	ISSUED FOR P&ID	...	...	006	2022-06-01	ISSUED FOR P&ID	...	...
007	2022-06-01	ISSUED FOR P&ID	...	...	007	2022-06-01	ISSUED FOR P&ID	...	...
008	2022-06-01	ISSUED FOR P&ID	...	...	008	2022-06-01	ISSUED FOR P&ID	...	...
009	2022-06-01	ISSUED FOR P&ID	...	...	009	2022-06-01	ISSUED FOR P&ID	...	...
010	2022-06-01	ISSUED FOR P&ID	...	...	010	2022-06-01	ISSUED FOR P&ID	...	...

DRAWING TITLE: P&ID - Close Drain System									
SCALE	SIZE	DRAWING NO.	SHEET NO.	REV.	DATE	REV.	DATE	REV.	DATE
AS	A3	BK-GS-PB00-120-PR-P-0017	2 OF 2	001	2022-07-01	002	2022-07-01	003	2022-07-01

P-2202 A/B
CLOSED DRAIN DRUM PUMPS
RATED CAPACITY : 3.3 m³/hr
DIFFERENTIAL PRESS. : 7 bar

P-2203 A/B
SUMP PUMPS
RATED CAPACITY : 5.5 m³/hr
DIFFERENTIAL PRESS. : 2 bar