


SU-2202
OILY WATER SUMP

DIMENSION (H X W X L) : 2500 X 3000 X 4000 mm

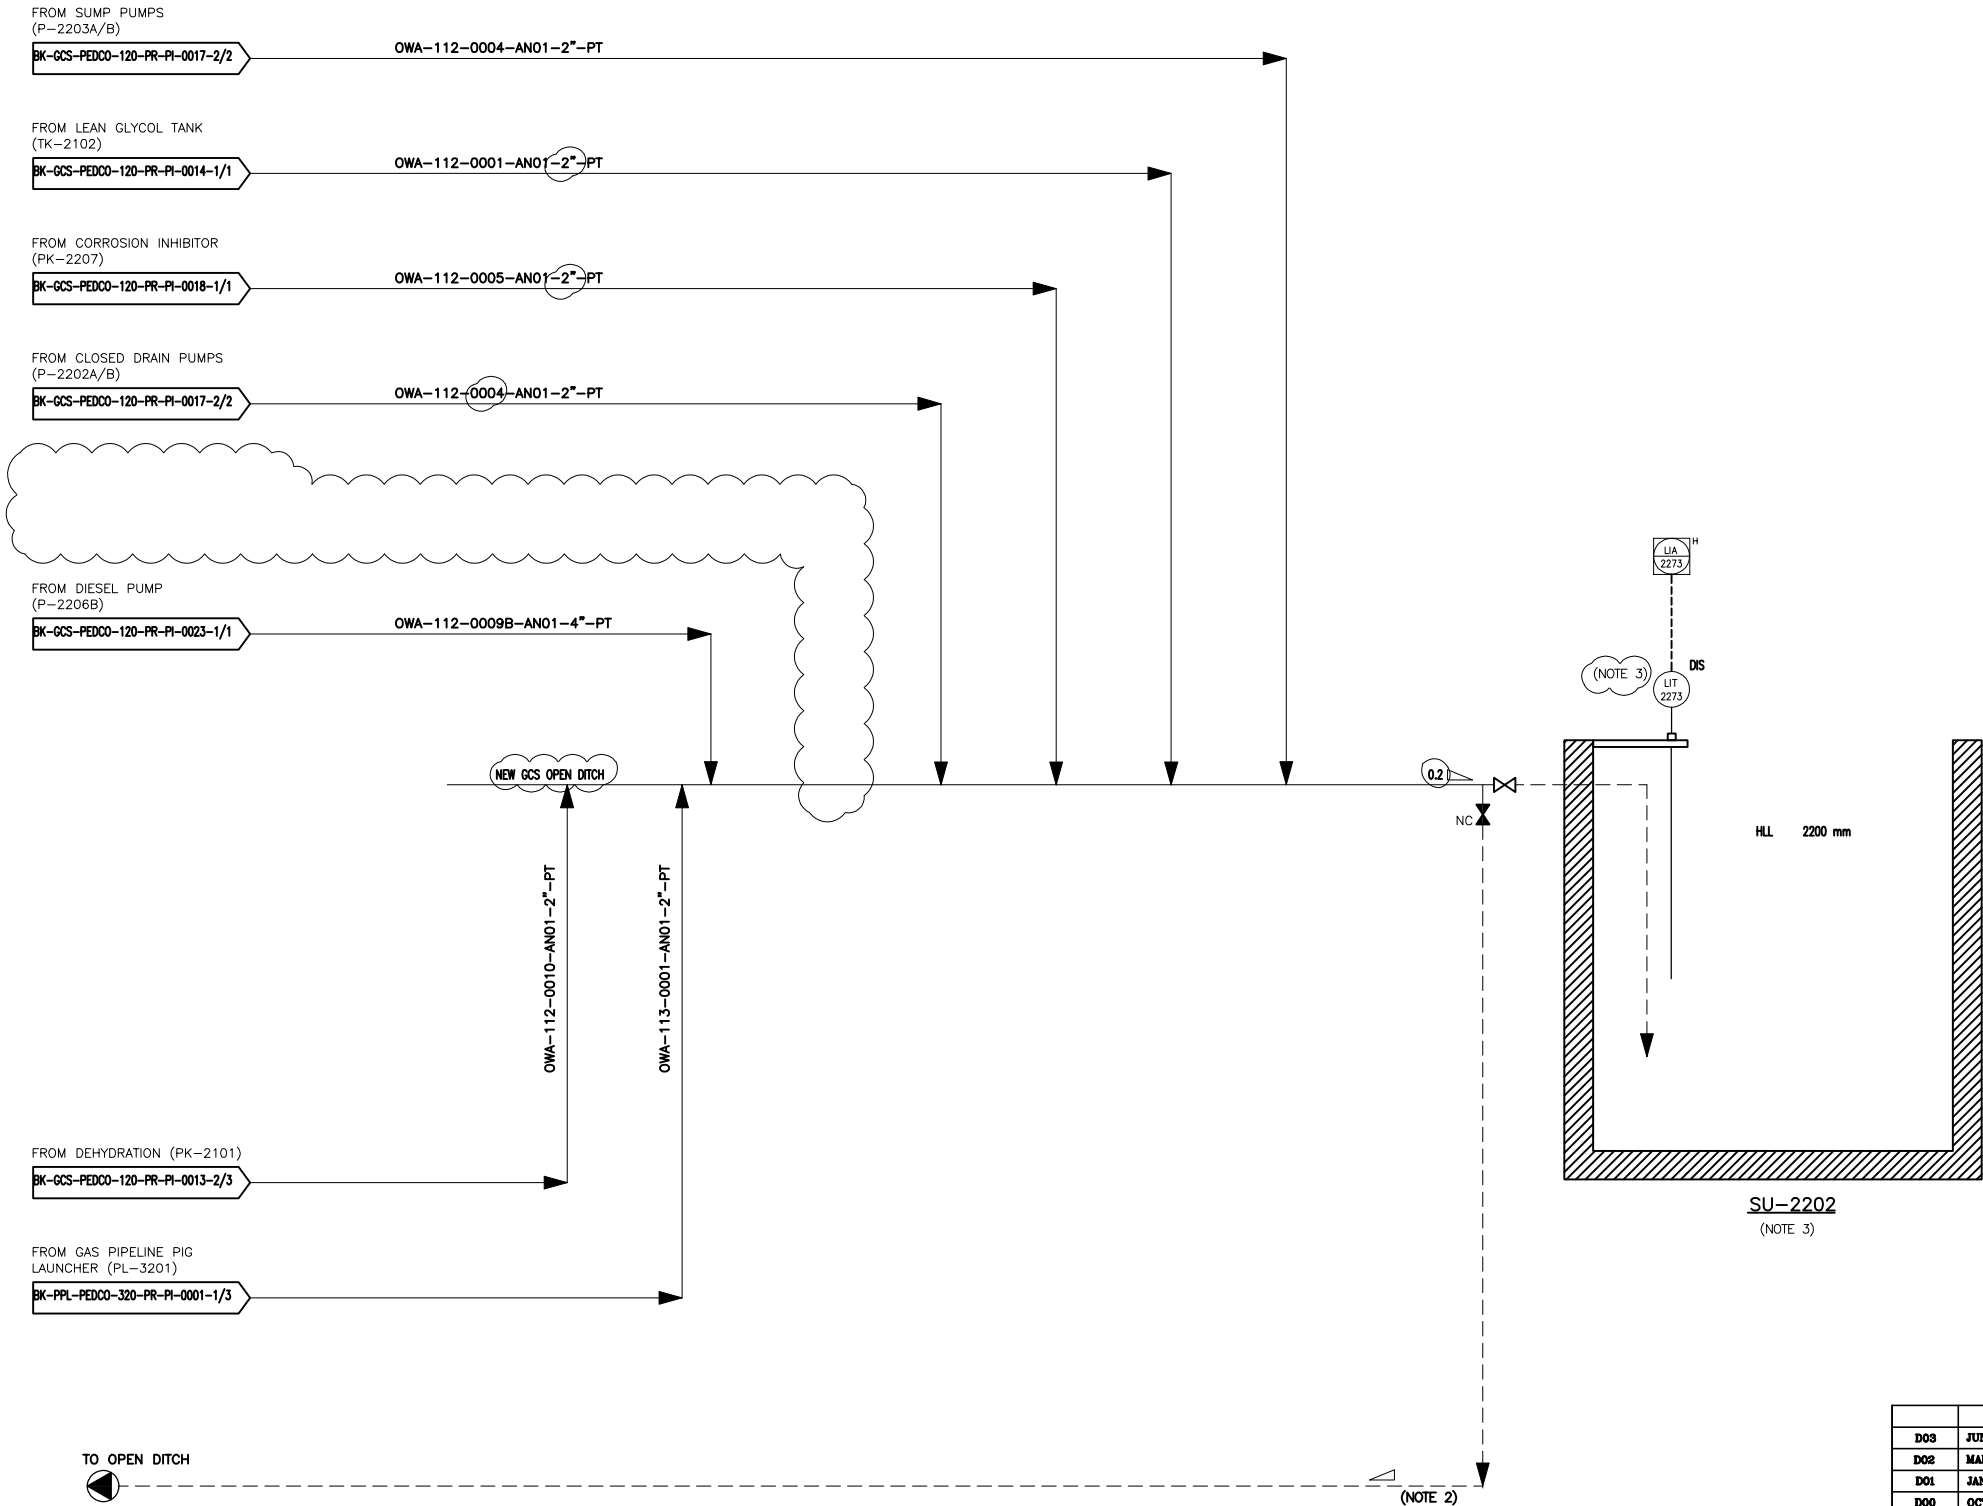






- NOTES
- 1-DELETED.
 - 2- IT IS ASSUMED THAT OILY WATER FROM PAVING AREA SHALL BE ROUTED TO NON-CONTAMINATED SEWER AFTER 15 MINUTES OF RAIN.
 - 3- SU-2202 WILL BE UNLOADED BY PORTABLE PUMP (OUT OF SCOPE).
 - 4- TOP MOUNTED DISPLACER LEVEL TRANSMITTER WILL BE INSTALLED ON A PLATE AT SUMP GROUND LEVEL)NO PIPING CONNECTION REQUIRED.)

GENERAL NOTE

LEGEND

REFERENCE DRAWING	DRG. No.
Utility Flow Diagram	BK-GCS-PEDCO-120-PR-UF-0001
Symbol & Legend For PFD & P&ID	BK-GCS-PEDCO-120-PR-PI-0001

KEY PLAN

D03	JUN.2022	IPA	MARYAM	M.PAKHRAHAN	M.MOHSEHAD	00.00																										
D02	MAR.2022	IPA	MARYAM	M.PAKHRAHAN	M.MOHSEHAD	00.00	000	0000000000	00.00	000.0000	00.00	000.0000																				
D01	JAN.2022	IPA	MARYAM	M.PAKHRAHAN	M.MOHSEHAD	00.00	REV.	DESCRIPTION	BY	DATE	BY	DATE																				
D00	OCT.2021	IPC	MARYAM	M.PAKHRAHAN	M.MOHSEHAD	00.00					CHECKED		REV.	APPR.																		
REV.	DATE	P.O.I.S	PREP.	CHK.	APP.	AUT.	<div></div> <div>THE ORIGINAL AND ALL COPIES OF THIS DRAWING TOGETHER WITH THE COPYRIGHT THEREIN ARE THE SOLE PROPERTY OF N.I.S.O.C./ FIELDS</div>																									
PROJECT NAME:						BINAK OILFIELD DEVELOPMENT/SURFACE FACILITIES GAS COMPRESSOR STATION																										
PROJECT NO.:						971020																										
EPC CONTRACTOR:			<div></div> <div>HIRGAN ENERGY - DESIGN & INSPECTION COMPANIES</div>			EPD/EPC CONTRACTOR (GC):			<div></div> <div>PETROIRAN DEVELOPMENT COMPANY</div>									BINAK OILFIELD DEVELOPMENT SURFACE FACILITIES GAS COMPRESSOR STATION														
<div></div> <div>P&ID - Oily Water Sewer</div>						<div></div> <div>PEDCO</div>												DATE			SCALE			DRAWING BY			CHECKED BY			PROJECT ENG.		
DRAWING TITLE:						P&ID - Oily Water Sewer						NO CONSTRUCTION PERMITTED UNLESS DRAWING APPROVED																				
						APPROVED FOR CONSTRUCTION						BY:			DATE:																	
SCALE	SIZE	DRAWING NO.				SHEET NO.	REV.	BUDGET REF.	LOCATION	SIZE	CLASS	SERIAL NO.	SHEET	REVISION																		
NS	A3	BK-GCS-PEDCO-120-PR-PI-0021				1 OF 1	D03	063-073-9184	F	2	A	708799	1 OF 1	D03																		

THE ORIGINAL AND ALL COPIES OF THIS DRAWING TOGETHER WITH THE COPYRIGHT THEREIN ARE THE SOLE PROPERTY OF N.I.S.O.C./ FIELDS

BINAK OILFIELD DEVELOPMENT SURFACE FACILITIES GAS COMPRESSOR STATION

DATE	SCALE	DRAWING BY	CHECKED BY	PROJECT ENG.
------	-------	------------	------------	--------------

NO CONSTRUCTION PERMITTED UNLESS DRAWING APPROVED				
APPROVED FOR CONSTRUCTION			BY:	DATE:

BUDGET REF.	LOCATION	SIZE	CLASS	SERIAL NO.	SHEET	REVISION
-------------	----------	------	-------	------------	-------	----------

053-073-9184	F	2	A	708799	1 OF 1	D03
--------------	---	---	---	--------	--------	-----

(VENDOR TITLE BLOCK)**