
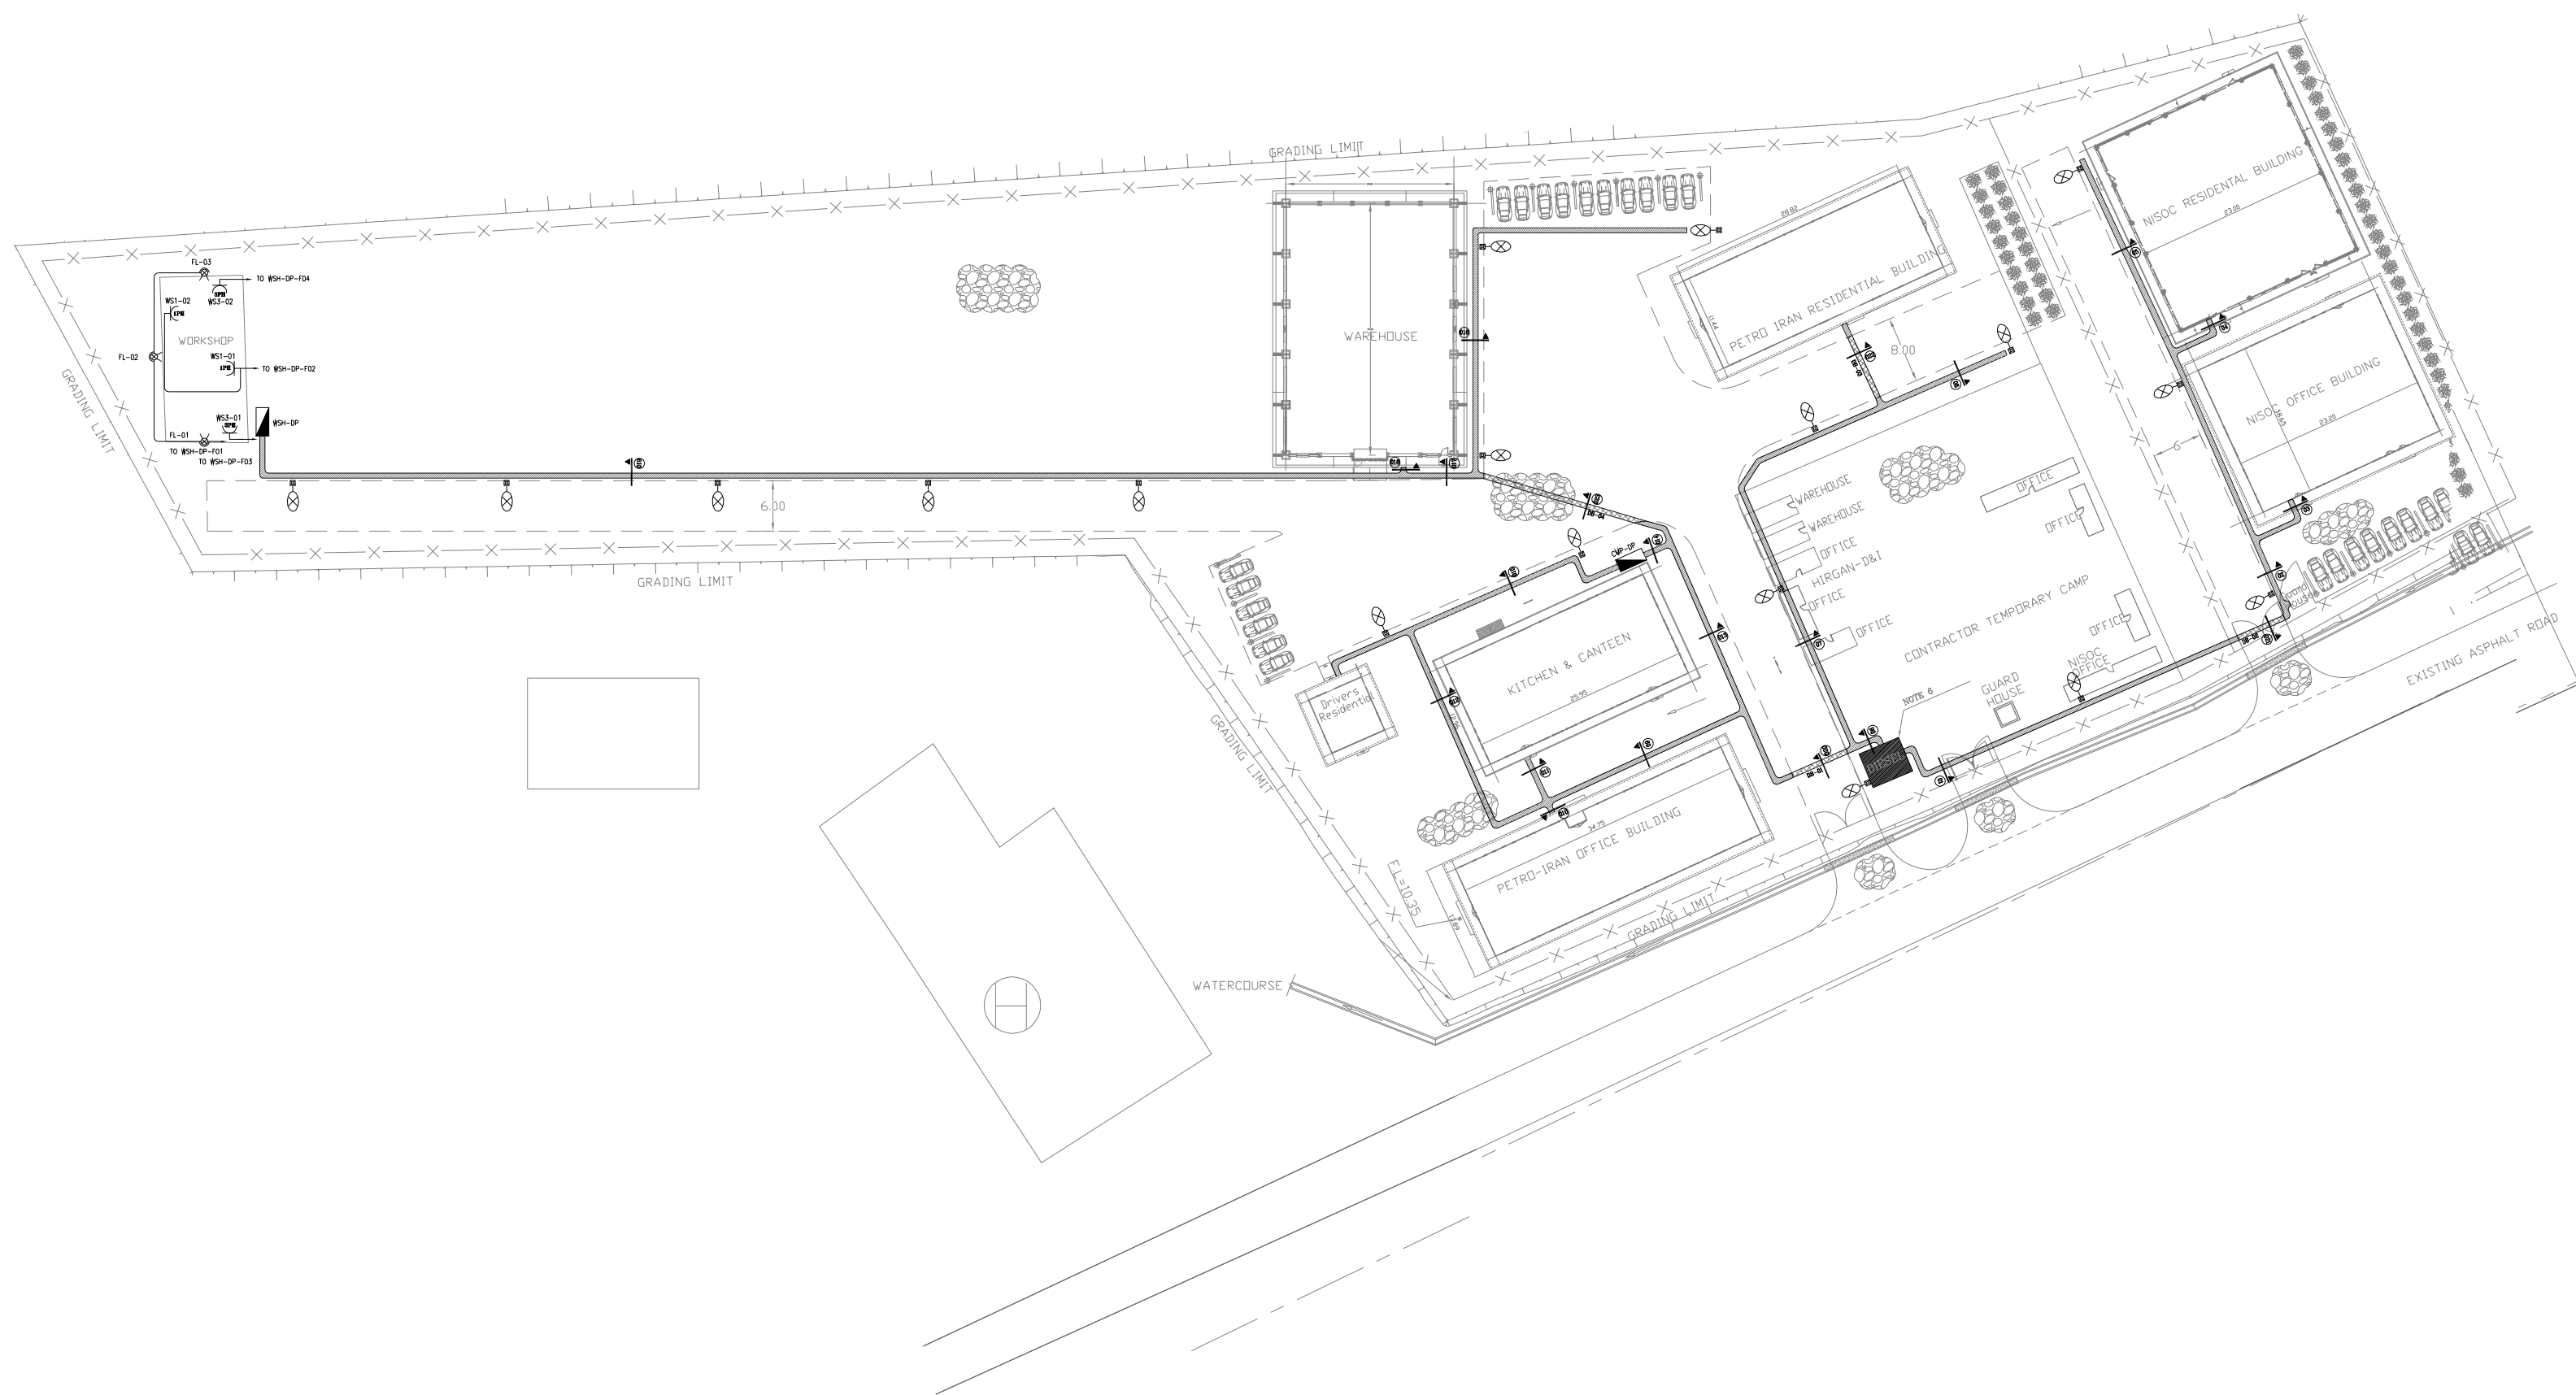


CABLE ROUTE FOR CAMP AREA

NOTES									
LEGEND									
REFERENCE DRAWING					DRG. No.				
OVERALL LAYOUT FOR CAMP AREA					BK-GNRL-PEDCO-220-CV-PY-0001				
LIGHTING & SMALL POWER LAYOUT FOR CAMP AREA					BK-GNRL-PEDCO-220-EL-PY-0002				
KEY PLAN									
***	*****	**, **	***, ****	**, **	***, ****				
REV.	DESCRIPTION	BY	DATE	BY	DATE				
		CHECKED			REV. APPR.				
اصل و کاپیہ نسخہ این نقشہ و حق اقتباس متعلق بہ شرکت ملی مناطق نفت خیز جنوب میباشد. THE ORIGINAL AND ALL COPIES OF THIS DRAWING TOGETHER WITH THE COPYRIGHT THEREIN ARE THE SOLE PROPERTY OF N.I.S.O.C./ FIELDS									
BINAK OILFIELD DEVELOPMENT GENERAL									
DATE	SCALE	DRAWING BY	CHECKED BY	PROJECT ENG.					
NO CONSTRUCTION PERMITTED UNLESS DRAWING APPROVED									
APPROVED FOR CONSTRUCTION			BY:		DATE:				
BUDGET REF.	LOCATION	SIZE	CLASS	SERIAL NO.	SHEET	REVISION			
053-073-9184	F	4	P	707103	01 OF 11	D01			


[illegible]

SECTION-01SECTION-02

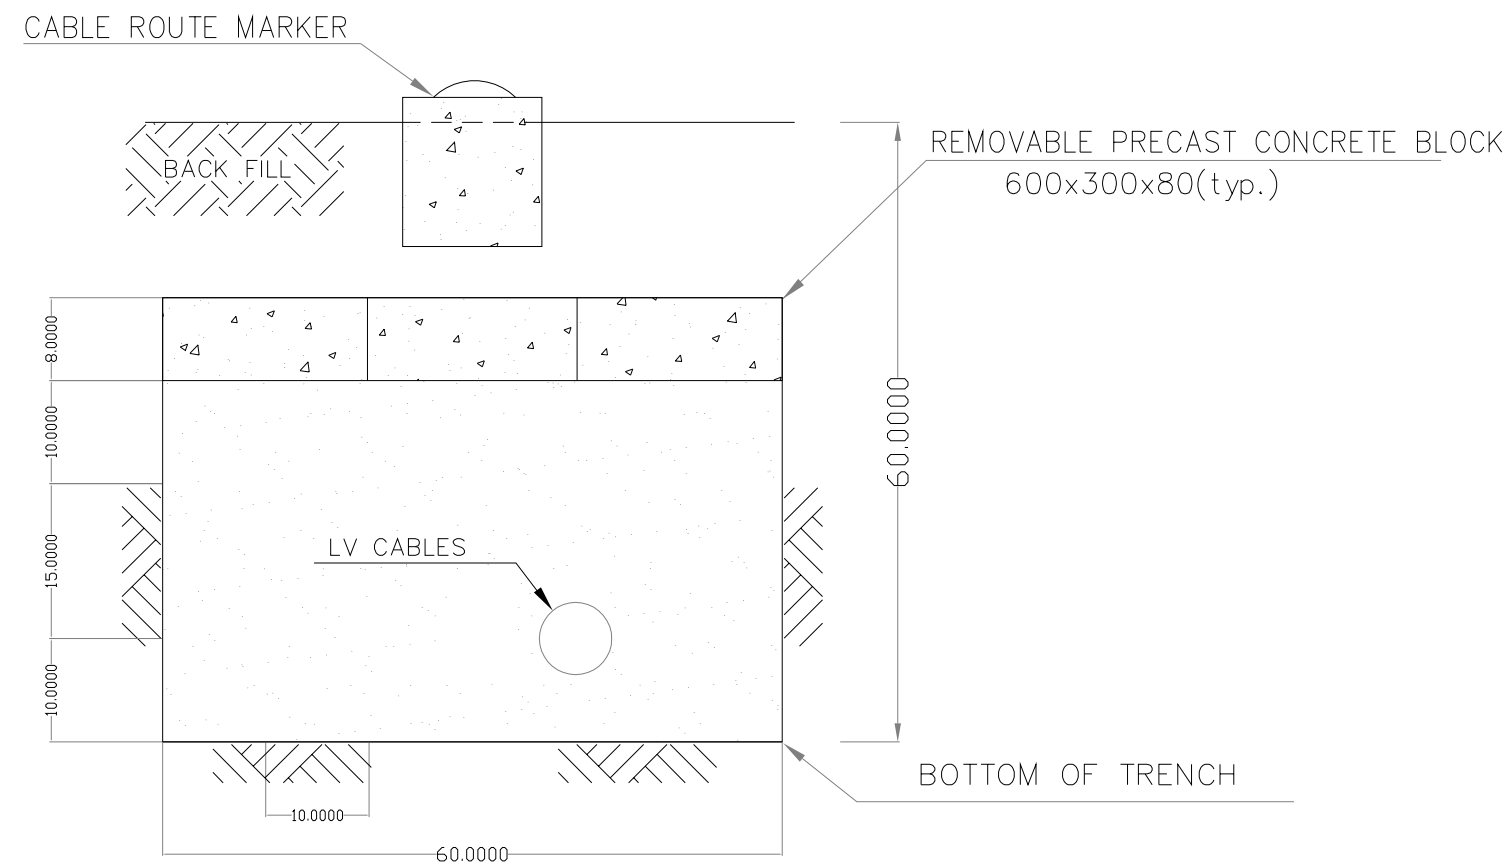

SECTION-03

SECTION-03		
ITEM	CABLE TAG	CABLE SIZE
1	NO-DP	3x185+95

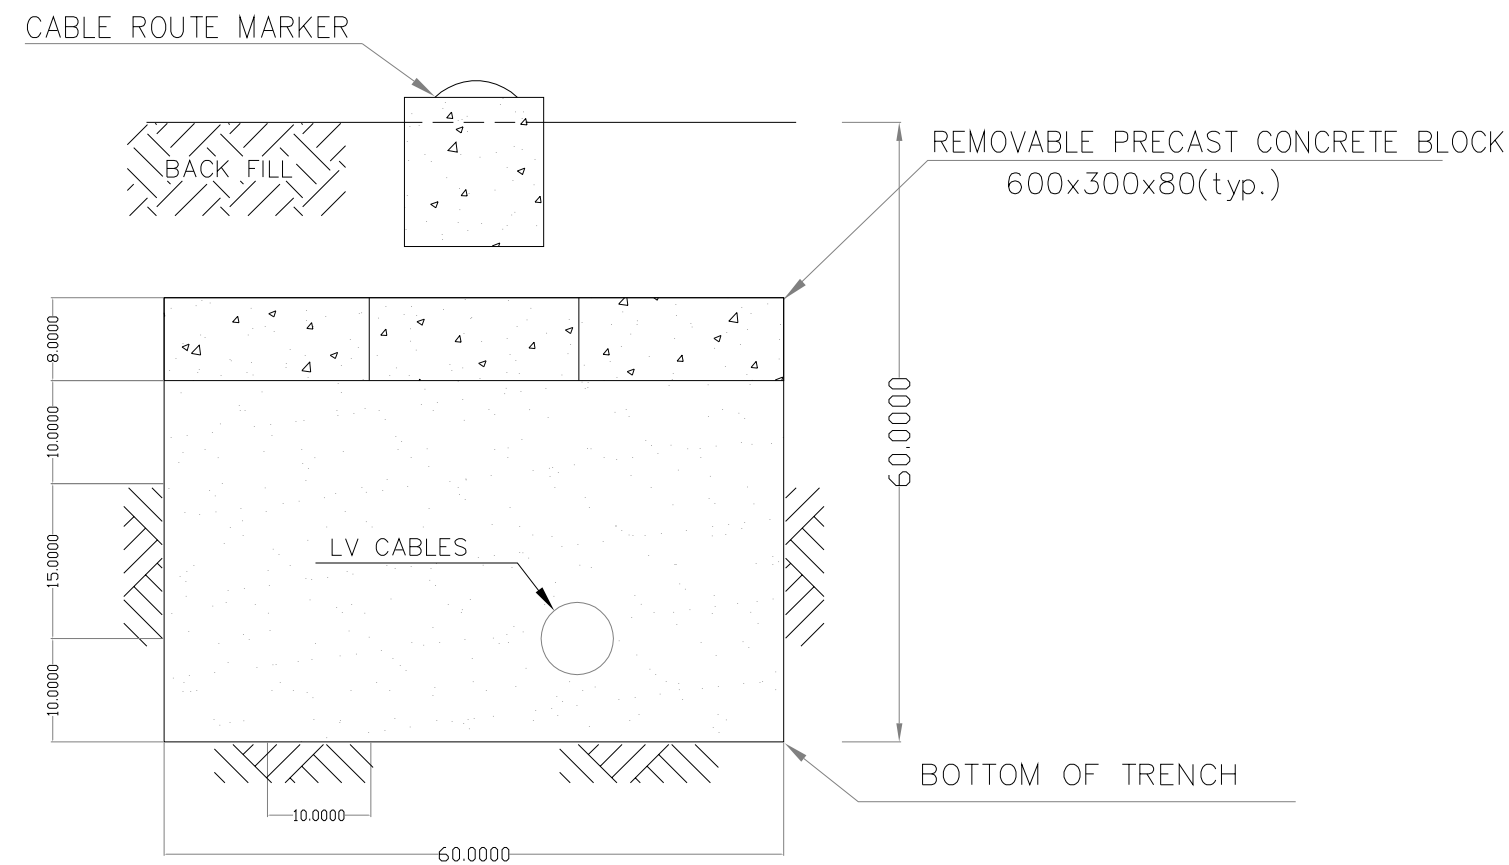

SECTION-05

SECTION-05		
ITEM	CABLE TAG	CABLE SIZE
1	CMP-DP-F05	3x4

SECTION-04

SECTION-04		
ITEM	CABLE TAG	CABLE SIZE
1	NR-DP	3x185+95

[illegible]

(VENDOR TITLE BLOCK)**



SECTION-06		
ITEM	CABLE TAG	CABLE SIZE
1	CMP-DP	4x35
2	PR-DP	3x120+70
3	PO-DP	3x95+50
4	RES-DP	3x95+50
5	DVR-DP	4x35
6	WR-DP	4x10
7	WSH-DP	3x120+70
8	CMP-DP-F04	3x4



SECTION-07		
ITEM	CABLE TAG	CABLE SIZE
1	PR-DP	3x120+70
2	CMP-DP-F04	3x4

[illegible]




SECTION-08		
ITEM	CABLE TAG	CABLE SIZE
1	CMP-DP-F04	3x4



SECTION-09		
ITEM	CABLE TAG	CABLE SIZE
1	DVR-DP	4x35
2	PO-DP	3x95+50
3	RES-DP	3x95+50

[illegible]

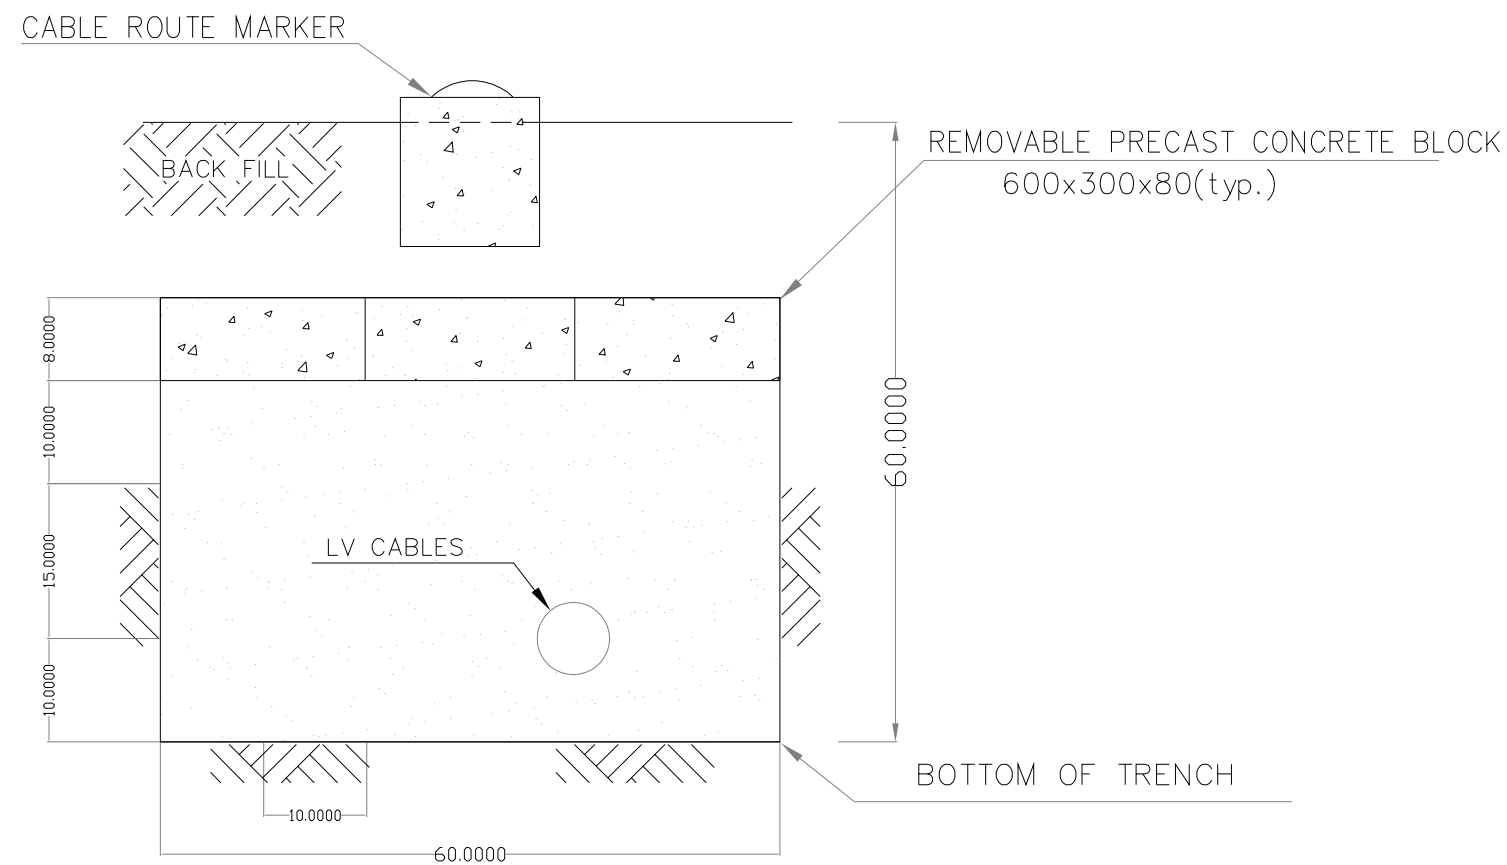

SECTION-010


SECTION-010		
ITEM	CABLE TAG	CABLE SIZE
1	PO-DP	3x95+50

SECTION-011

SECTION-011		
ITEM	CABLE TAG	CABLE SIZE
1	RES-DP	3x95+50

SECTION-012

SECTION-012		
ITEM	CABLE TAG	CABLE SIZE
1	DVR-DP	4x35

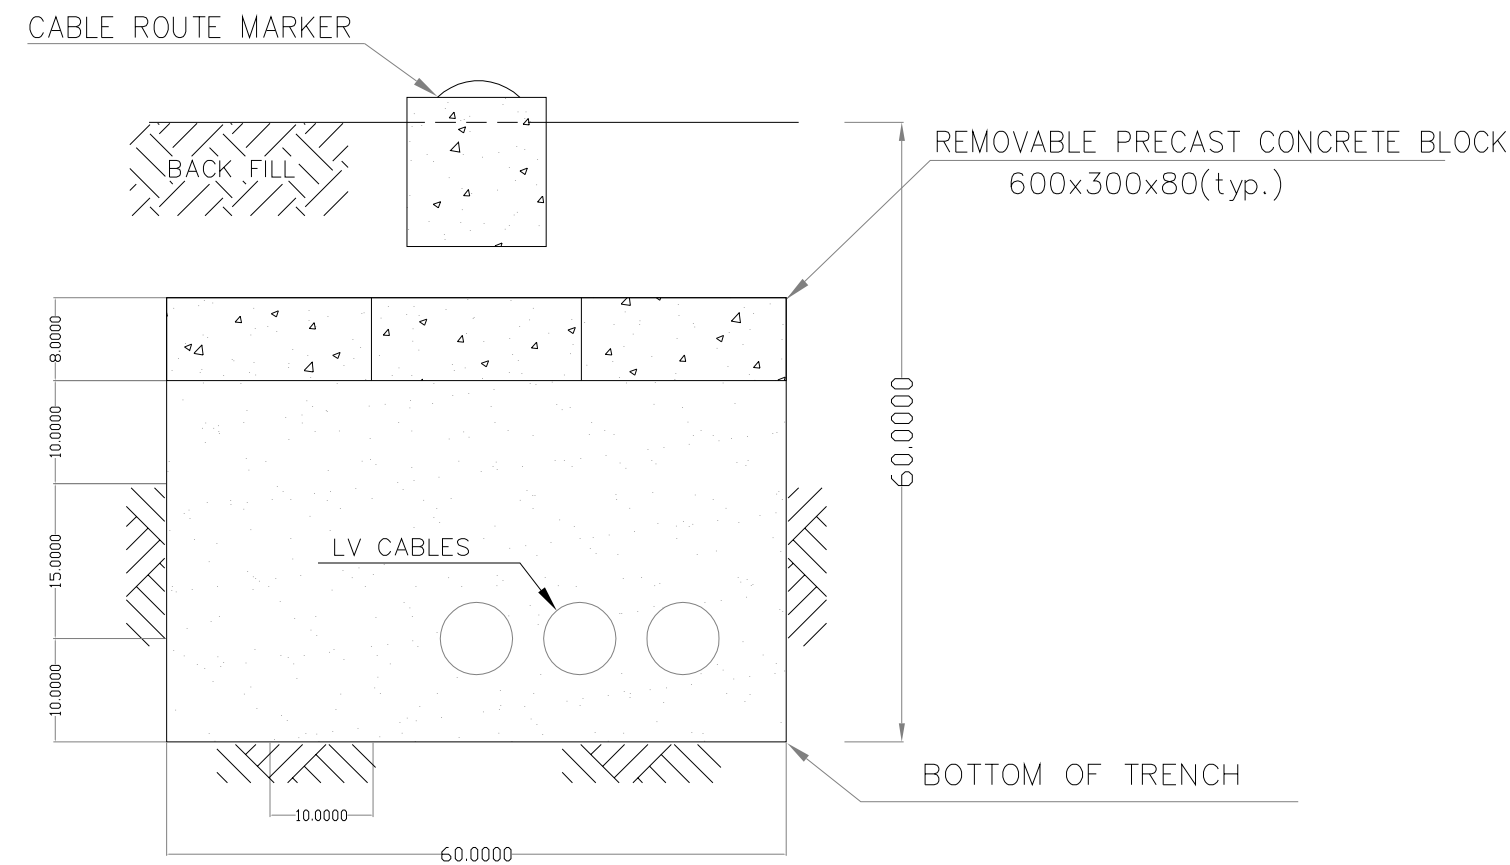

SECTION-013

SECTION-013		
ITEM	CABLE TAG	CABLE SIZE
1	WR-DP	4x10
2	CMP-DP	4x35
3	WSH-DP	3x120+70

SECTION-014

SECTION-014		
ITEM	CABLE TAG	CABLE SIZE
1	CMP-DP	4x35
2	CMP-DP-F01	3x4
3	CMP-DP-F02	3x4

[illegible]

(VENDOR TITLE BLOCK)**

NOTES

LEGEND

REFERENCE DRAWING	DRG. No.
OVERALL LAYOUT FOR CAMP AREA	BK-GNRL-PEDCO-220-CV-PY-0001
LIGHTING & SMALL POWER LAYOUT FOR CAMP AREA	BK-GNRL-PEDCO-220-EL-PY-0002

KEY PLAN


اصل و کلیه نسخ این نقشه و حق اقتباس متعلق به شرکت ملی مناطق نفت خیز جنوب می باشد.

THE ORIGINAL AND ALL COPIES OF THIS DRAWING TOGETHER WITH
THE COPYRIGHT THEREIN ARE THE SOLE PROPERTY OF
N.I.S.O.C./ FIELDS

BINAK OILFIELD DEVELOPMENT GENERAL				
DATE	SCALE	DRAWING BY	CHECKED BY	PROJECT ENG

NO CONSTRUCTION PERMITTED UNLESS DRAWING APPROVED

BUDGET REF.	LOCATION	SIZE	CLASS	SERIAL NO.	SHEET	REVISION
-------------	----------	------	-------	------------	-------	----------

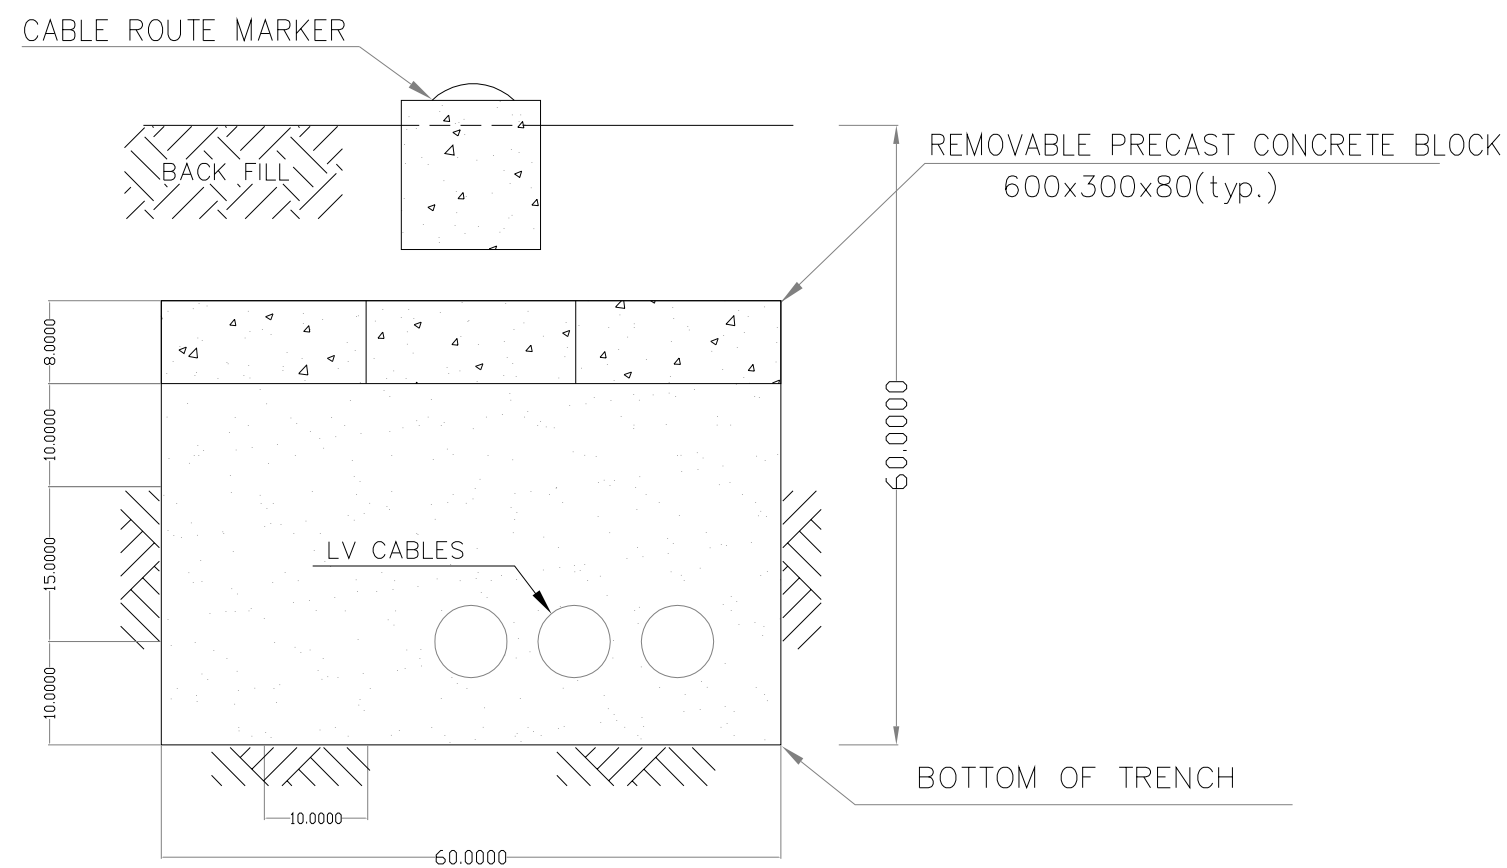


SECTION-017		
ITEM	CABLE TAG	CABLE SIZE
1	WSH-DP	3x120+70
2	CMP-DP-F01	3x4
3	WR-DP	4x10

SECTION-015		
ITEM	CABLE TAG	CABLE SIZE
1	CMP-DP-F03	3x4


SECTION-016		
ITEM	CABLE TAG	CABLE SIZE
1	CMP-DP-F02	3x4

[illegible]

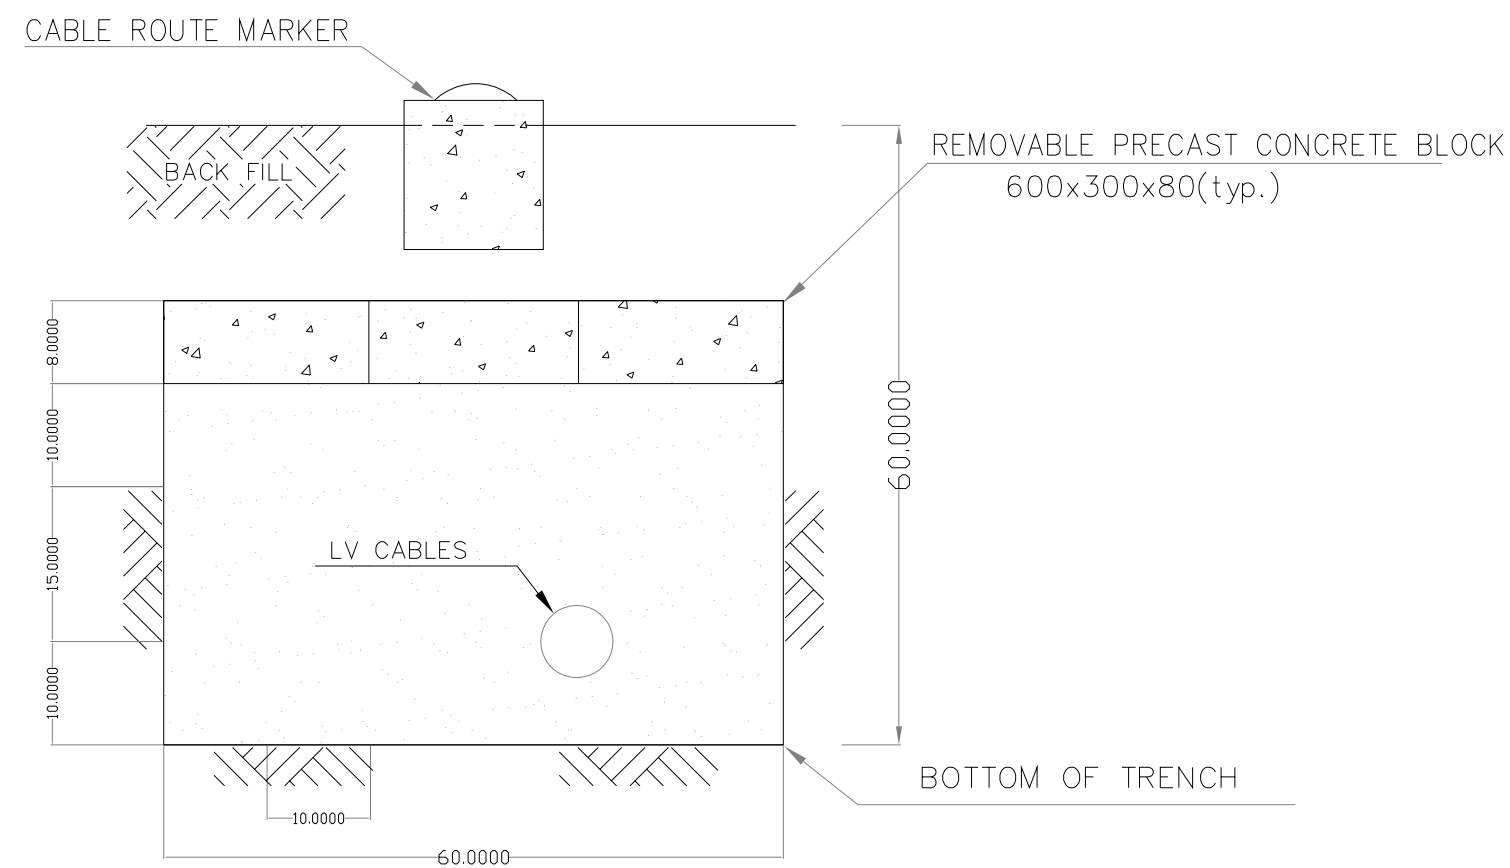

SECTION-018

SECTION-018		
ITEM	CABLE TAG	CABLE SIZE
1	WR-DP	4x10

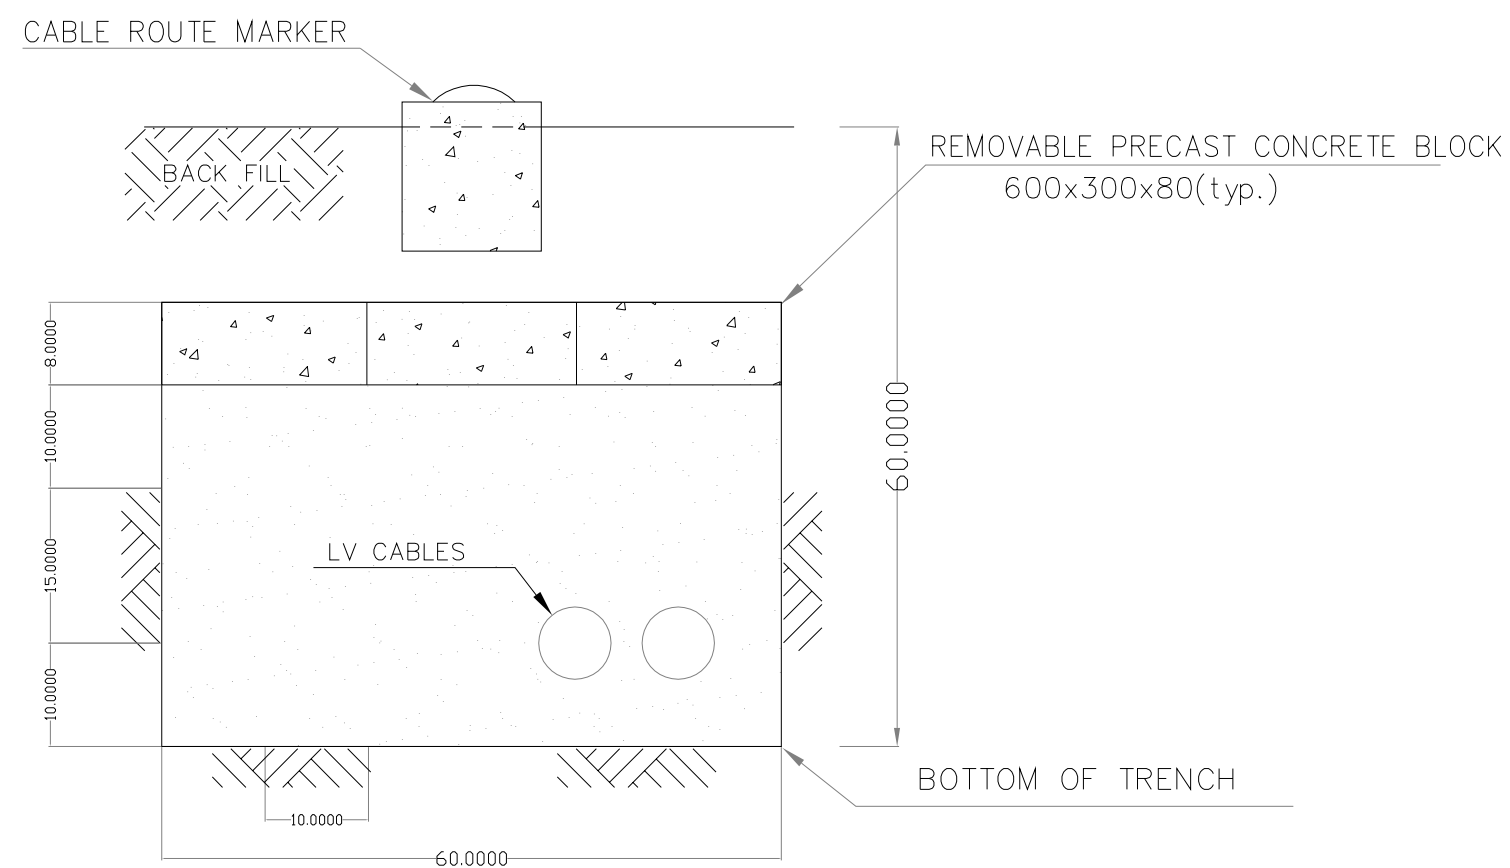


SECTION-019

SECTION-019		
ITEM	CABLE TAG	CABLE SIZE
1	CMP-DP-F01	3x4
2	WSH-DP	3x120+70


NOTES					
LEGEND					
REFERENCE DRAWING				DRG. No.	
OVERALL LAYOUT FOR CAMP AREA				BK-GNRL-PEDCO-220-CV-PY-0001	
LIGHTING & SMALL POWER LAYOUT FOR CAMP AREA				BK-GNRL-PEDCO-220-EL-PY-0002	
KEY PLAN					

REV.	DESCRIPTION	BY	DATE	BY	DATE
		CHECKED	REV. APPR.		
اسل و کلیه نسخ این نقشه و حق اقتباس متعلق به شرکت ملی مناطق نفت خیز جنوب میباشد.  THE ORIGINAL AND ALL COPIES OF THIS DRAWING TOGETHER WITH THE COPYRIGHT THEREIN ARE THE SOLE PROPERTY OF N.I.S.O.C./ FIELDS					
BINAK OILFIELD DEVELOPMENT GENERAL					
DATE	SCALE	DRAWING BY	CHECKED BY	PROJECT ENG	
NO CONSTRUCTION PERMITTED UNLESS DRAWING APPROVED					
APPROVED FOR CONSTRUCTION			BY:	DATE:	
BUDGET REF.	LOCATION	SIZE	CLASS	SERIAL NO.	SHEET
053-073-9184	F	4	P	707103	09 OF 11
					DOI

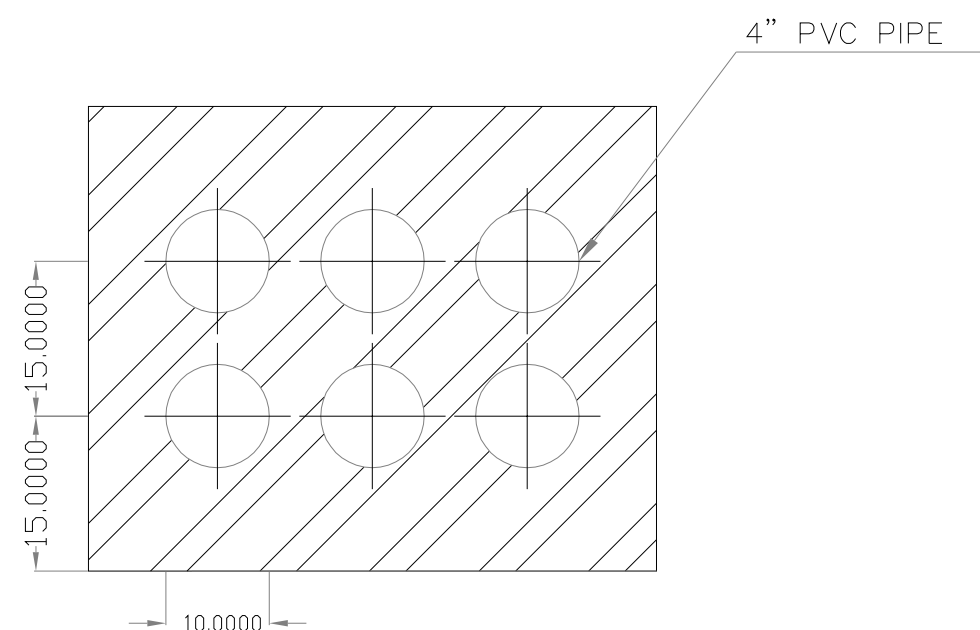

SECTION-020
DB-01

DUCT BANK-01		
ITEM	CABLE TAG	CABLE SIZE
1	CMP-DP	4x35
2	WSH-DP	3x120+70
3	WR-DP	4x10
4	DVR-DP	4x35
5	RES-DP	3x95+50
6	PO-DP	3x95+50

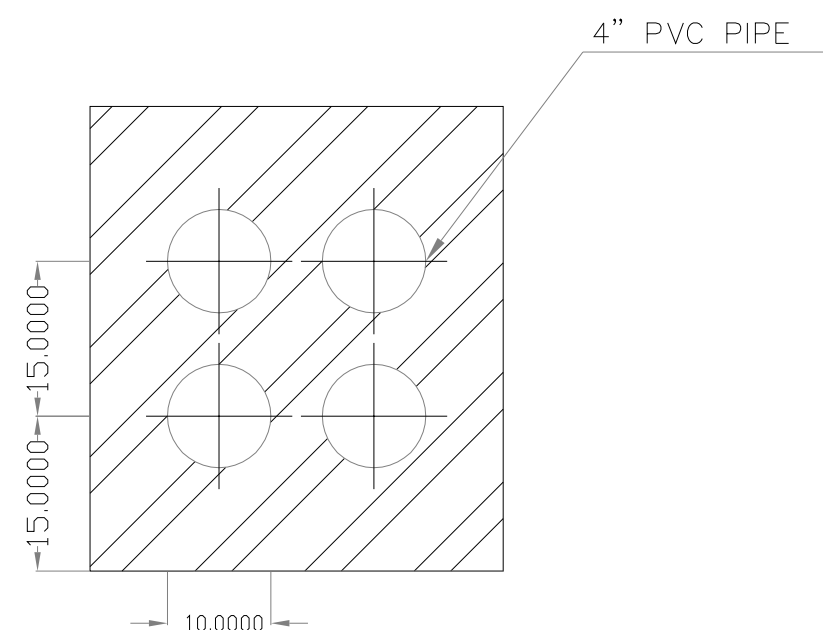

SECTION-021
DB-02

DUCT BANK-02		
ITEM	CABLE TAG	CABLE SIZE
1	CMP-DP-F05	3x4
2	GH-DP	4x10
3	NR-DP	3x185+95
4	NO-DP	3x185+95

NOTES	
LEGEND	
REFERENCE DRAWING	DRG. No.
OVERALL LAYOUT FOR CAMP AREA	BK-GNRAL-PEDCO-220-CV-PY-0001
LIGHTING & SMALL POWER LAYOUT FOR CAMP AREA	BK-GNRAL-PEDCO-220-EL-PY-0002

KEY PLAN

[illegible]

(VENDOR TITLE BLOCK)**



SECTION-022
DB-03



SECTION-023
DB-04

(VENDOR TITLE BLOCK)**