


PR-1002
EXISTING GAS PIG RECEIVER

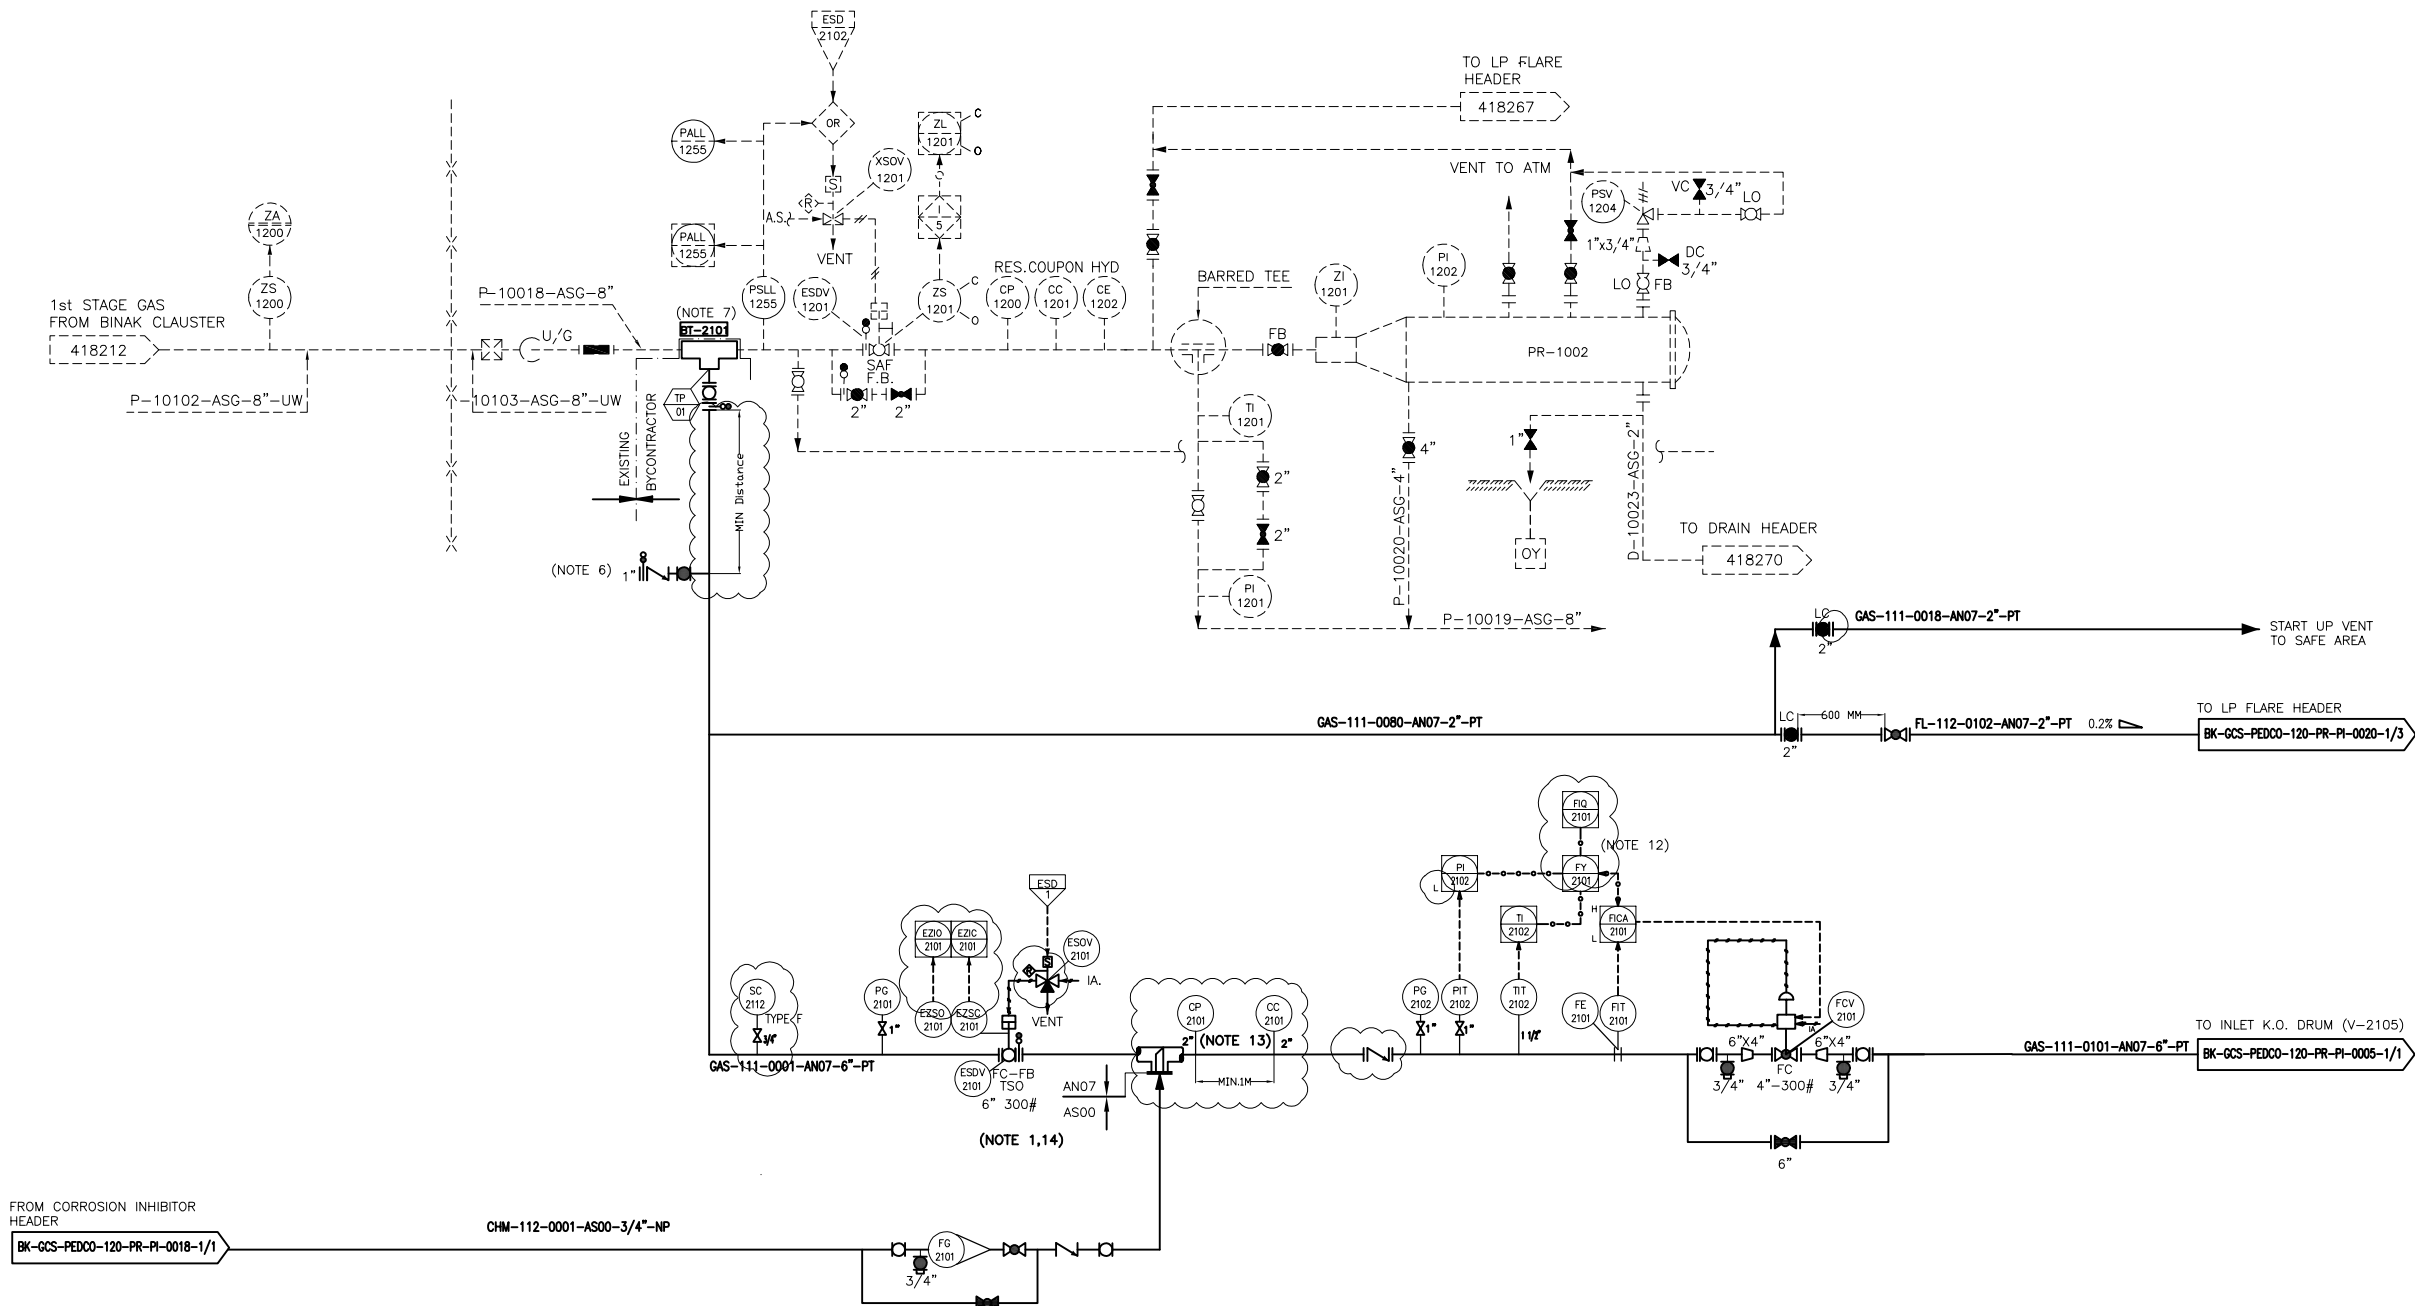

NOTES


- 1- THE ESD VALVE SHOULD WORK AS FIRE ZONE ISOLATION DURING EMERGENCY CONDITION.
- 2- DELETED.
- 3- DELETED.
- 4- DELETED.
- 5- DELETED.
- 6- PURGE CONNECTION.
- 7- TIE IN IS TAKEN FROM EXISTING BINAK PIPELINE.
- 8- DELETED.
- 9- DELETED.
- 10- DELETED.
- 11- DELETED.
- 12- FLOW QUANTITY WILL BE COMPENSATED BY TT AND PT.
- 13- ONE PORTABLE METER FOR CORROSION PROBES TO BE PROVIDE PER SITE TO RECOVERY MONITOR CORROSION DATA.
- 14- PARTIAL STROK DEVICE TO BE CONSIDERED FOR ALL ESDV'S ACTIVATED BY ESD 1,0.

LEGEND

REFERENCE DRAWING	DRG. No.
Process Flow Diagram	BK-GCS-PEDCO-120-PR-PF-0001
Symbol & Legend For PFD and P&ID	BK-GCS-PEDCO-120-PR-PI-0001

KEY PLAN

TYPE 1

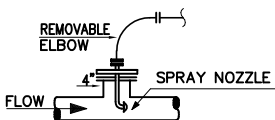

INJECTION DEVICE PERMANENTLY CONNECTED
(GAS SERVICE)

DD4	AUG.2022	IFA	MARYAM	M.PAKHMAN	M.MOHSEAD	00.00									
DD3	JUN.2022	IFA	MARYAM	M.PAKHMAN	M.MOHSEAD	00.00									
DD2	MAR.2022	IFA	MARYAM	M.PAKHMAN	M.MOHSEAD	00.00	000	0000000000	00.00	000.0000	00.00		000.0000		
DD1	JAN.2022	IFA	MARYAM	M.PAKHMAN	M.MOHSEAD	00.00									
DD0	SEP.2021	IPC	MARYAM	M.PAKHMAN	SELGHAKAR	00.00	REV.	DESCRIPTION	BY	DATE	BY	DATE			
REV.	DATE	P.O.I.S	PREP.	CHK.	APP.	AUT.			CHECKED			REV.	APPR.		
PROJECT NAME: BINAK OILFIELD DEVELOPMENT/SURFACE FACILITIES GAS COMPRESSOR STATION							اصل و کاپیه نسخ این نقشه و حق اقدایی متعلق به شرکت ملی مناطق نفت خیز جنوب می باشد.								
PROJECT NO.: 971020							 THE ORIGINAL AND ALL COPIES OF THIS DRAWING TOGETHER WITH THE COPYRIGHT THEREON ARE THE SOLE PROPERTY OF N.I.S.O.C./ FIELDS								
EPC CONTRACTOR:			EPD/EPC CONTRACTOR (GC):				BINAK OILFIELD DEVELOPMENT SURFACE FACILITIES GAS COMPRESSOR STATION								
 HURGAN ENERGY - DESIGN & INSPECTION COMPANIES			 PETROIRAN DEVELOPMENT COMPANY				DATE SCALE DRAWING BY CHECKED BY PROJECT EN								
DRAWING TITLE: P&ID - Gas Compression Inlet Gas Pipeline (Binak)							NO CONSTRUCTION PERMITTED UNLESS DRAWING APPROVED								
SCALE		SIZE		DRAWING NO.		SHEET NO.	REV.	BUDGET REF.	LOCATION	SIZE	CLASS	SERIAL NO.	SHEET	REVISION	
NS		A3		BK-GCS-PEDCO-120-PR-PI-0002		1 OF 1	D04	053-073-9184	F	2	A	708780	1 OF 1	D04	