



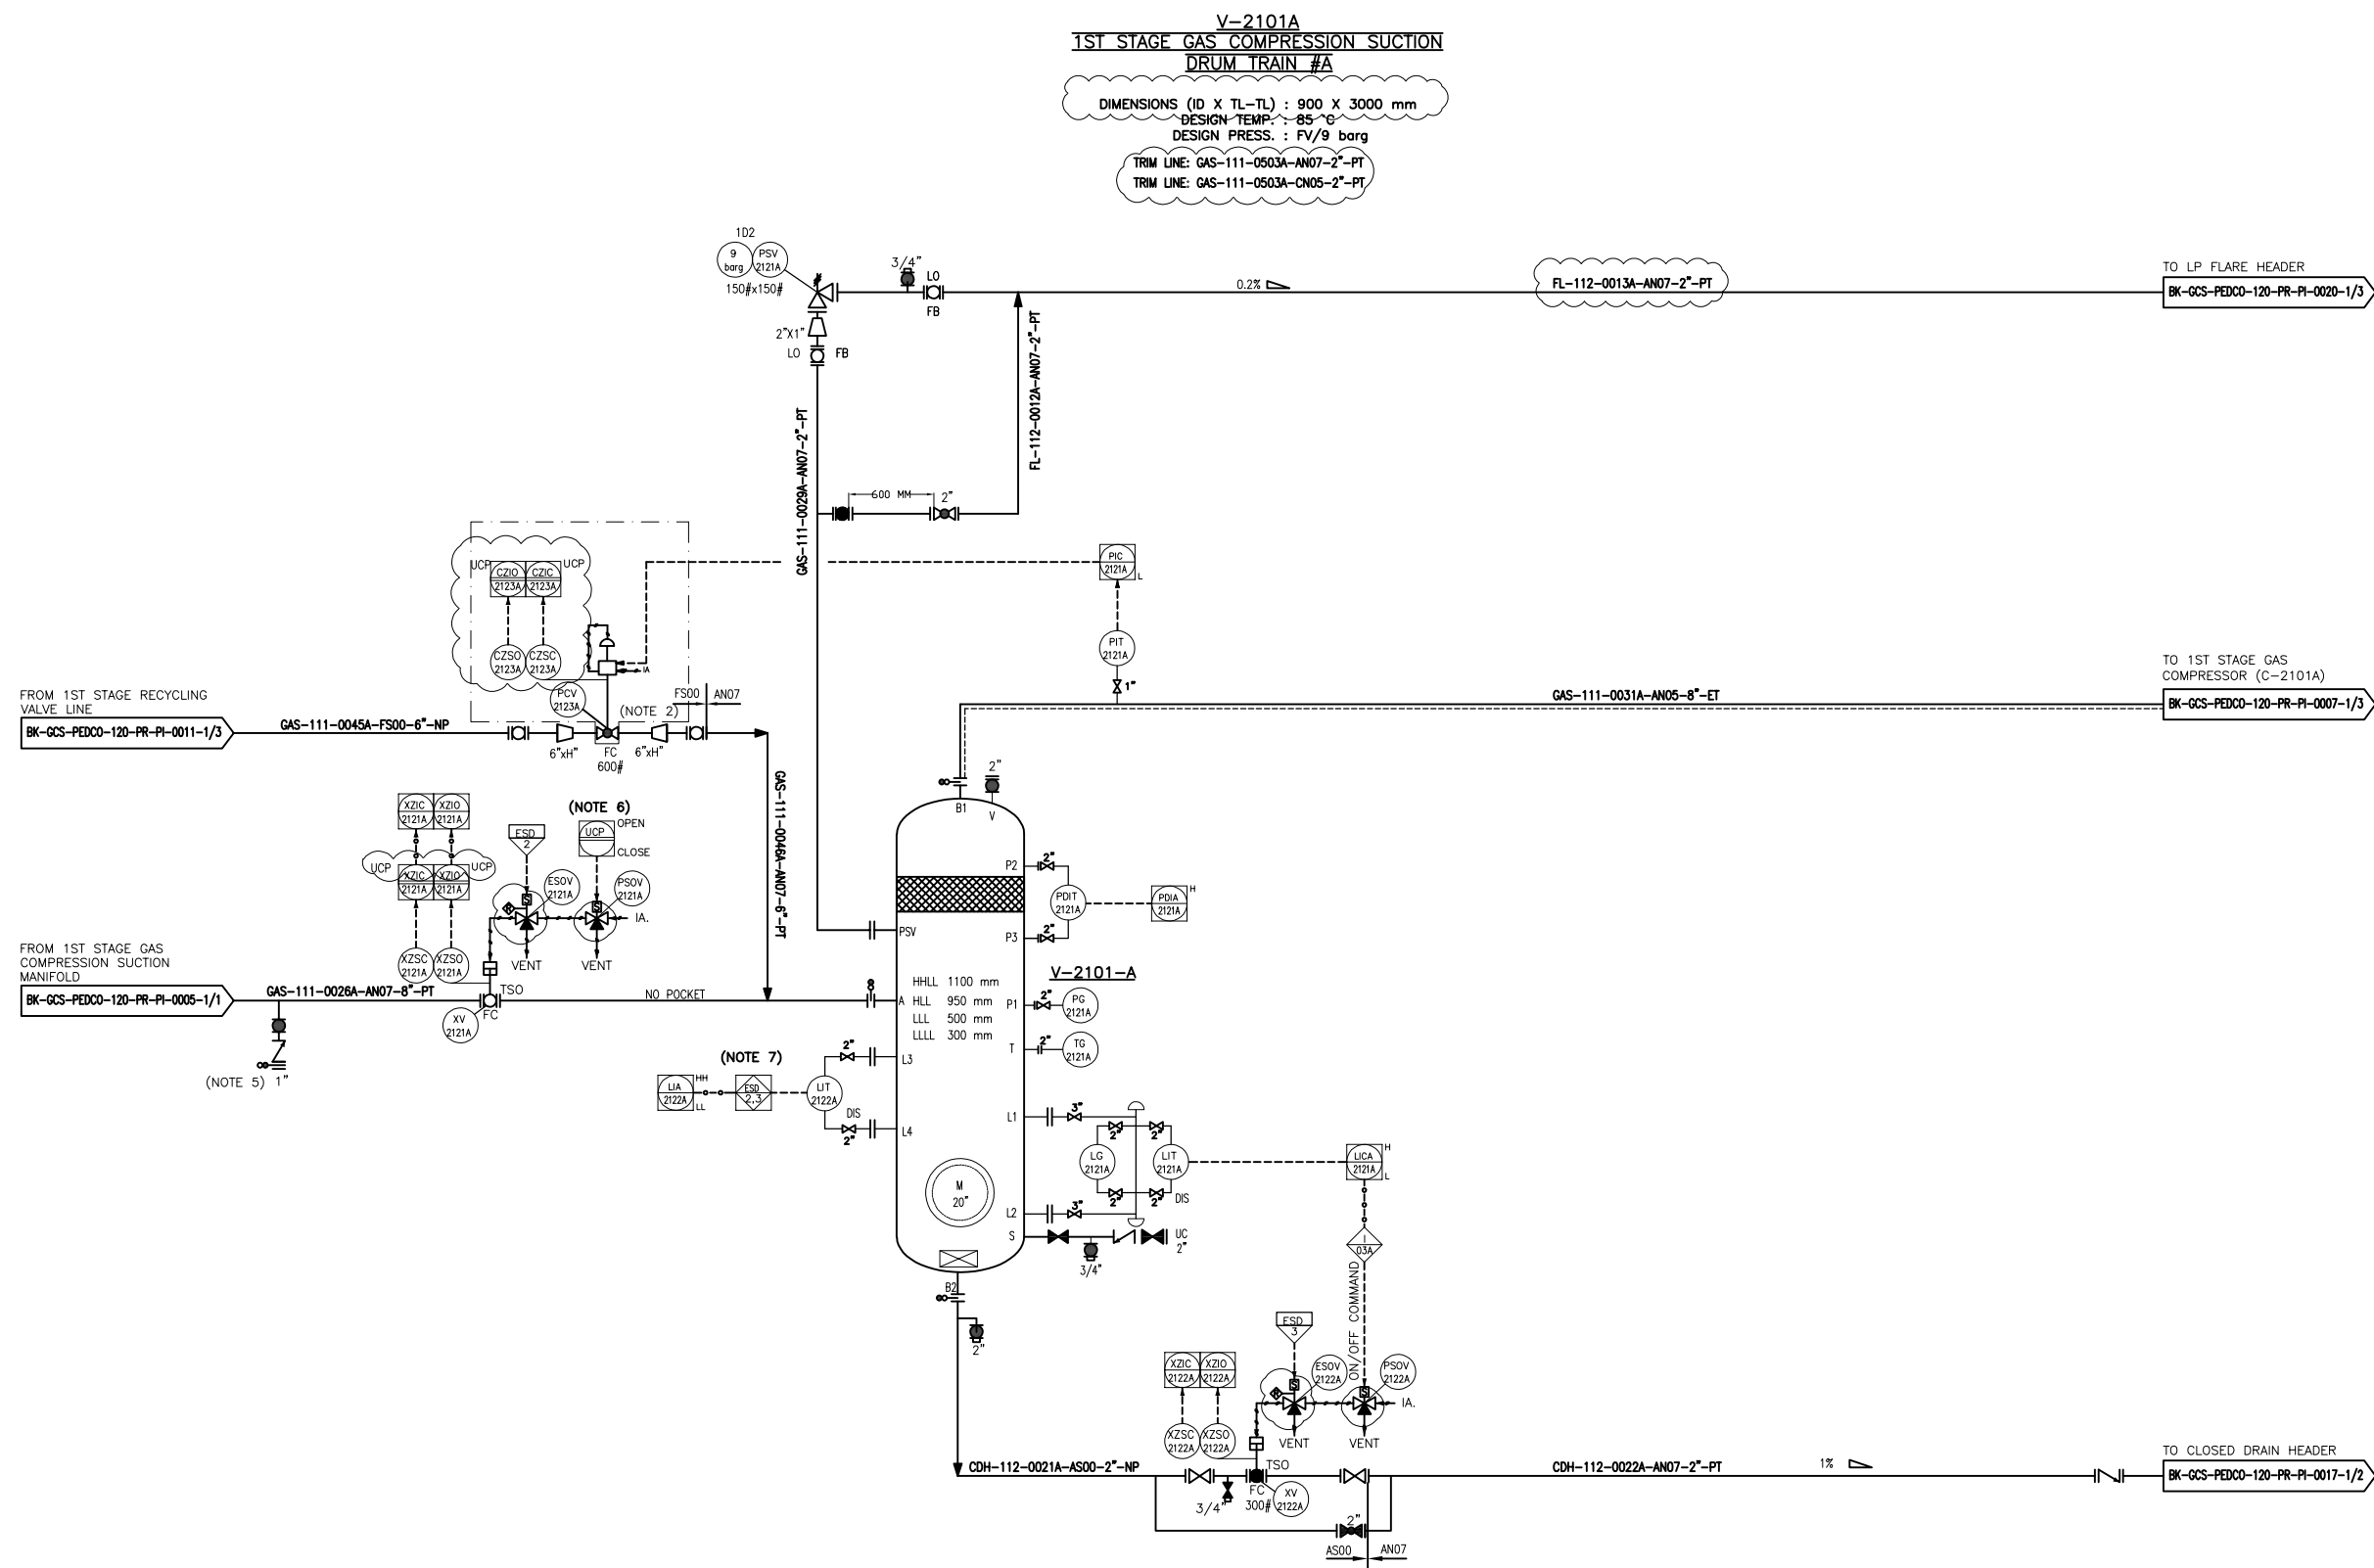

V-2101B
1ST STAGE GAS COMPRESSION SUCTION
DRUM TRAIN #B

DIMENSIONS (ID X TL-TL) : 900 X 3000 mm
DESIGN TEMP. : -85 °C
DESIGN PRESS. : FV/9 barg
TRIM LINE: GAS-111-0503B-AN07-2"-PT
TRIM LINE: GAS-111-0503B-CN05-2"-PT

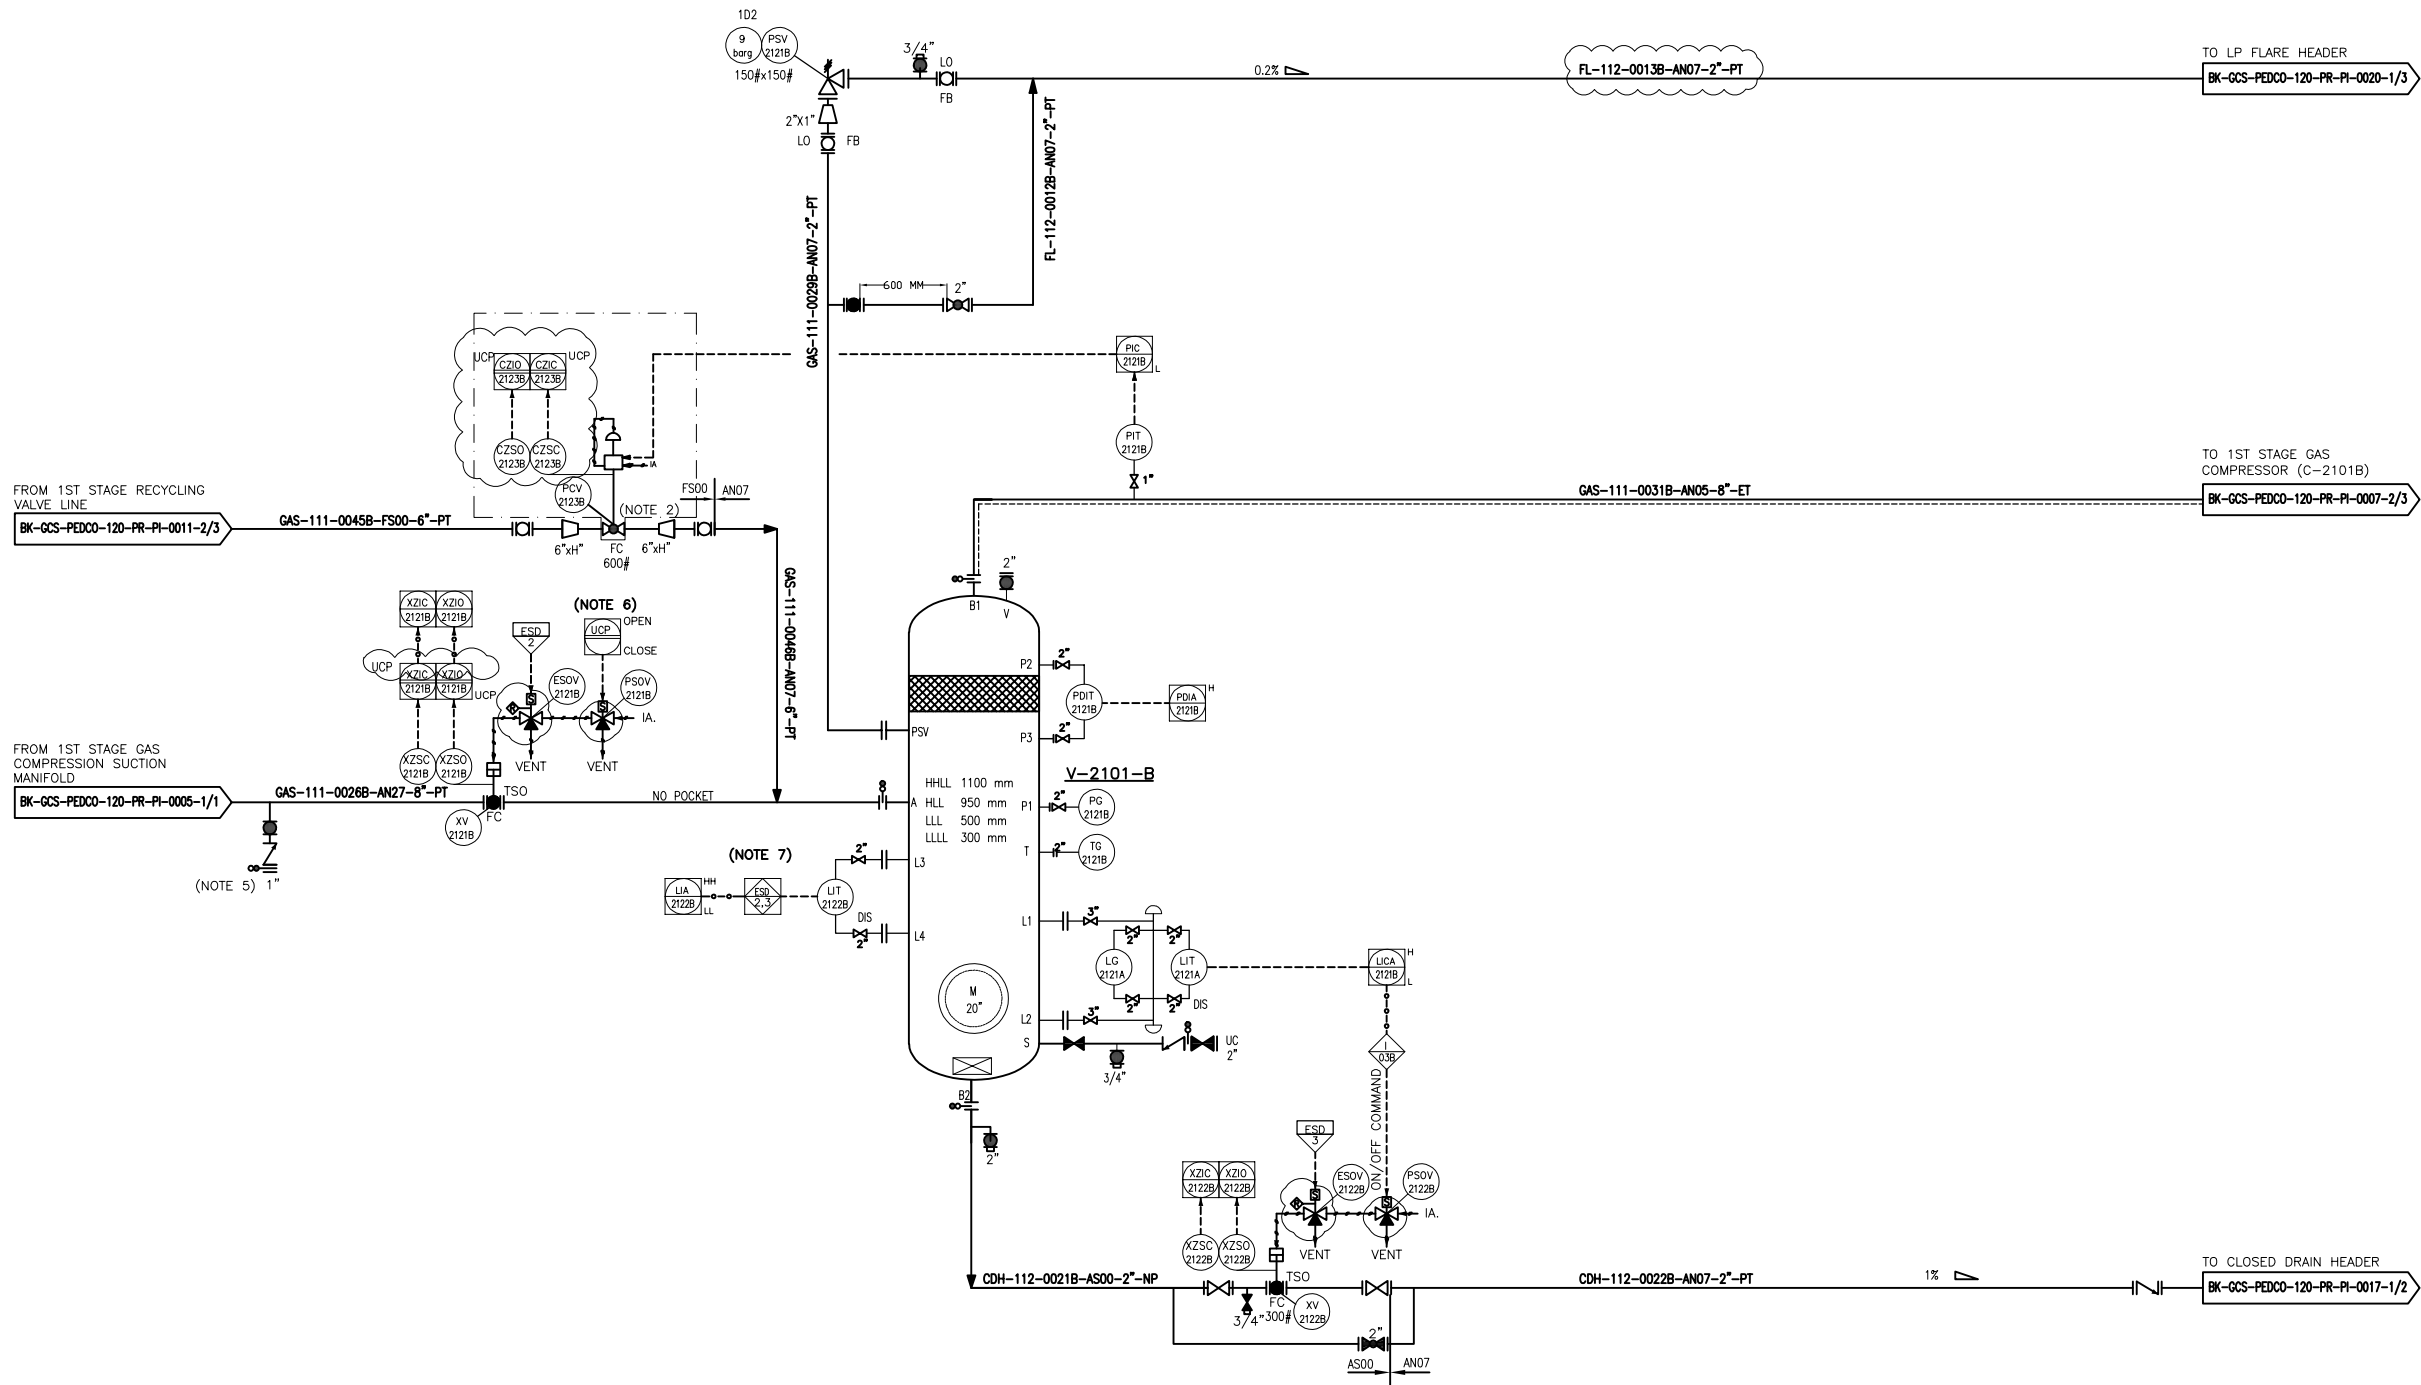

NOTES

- 1- LOAD SHARING CONTROL SYSTEM WILL BE FINALIZED BY VENDOR.
- 2- SPILL BACK VALVE TO BE SUPPLIED BY COMPRESSOR VENDOR.
- 3- DELETED.
- 4- THE LAG OUT OF SPILL BACK VALVE WILL BE FINALIZED BY VENDOR.
- 5- PURGE CONNECTION.
- 6-START/STOP SEQUENC IN STARTUP STAGE TO BE IMPLIMENT BY COMPRESSOR VENDOR.
- 7-ESD LEVEL 2 FOR HH AND ESD LEVEL 3 FOR LL TO BE CONSIDERED AS PER PROJECT ESD LEVEL

LEGEND

REFERENCE DRAWING	DRG. No.
Process Flow Diagram	BK-GCS-PEDCO-120-PR-PF-0001
Symbol & Legend For PFD and P&ID	BK-GCS-PEDCO-120-PR-PI-0001

KEY PLAN

DD4	AUG.2022	IFA	MARTAPAR	M.PAKHMANIAN	M.MOHSESHAD	00.00							
DD3	JUN.2022	IFA	MARTAPAR	M.PAKHMANIAN	M.MOHSESHAD	00.00							
DD2	MAR.2022	IFA	MARTAPAR	M.PAKHMANIAN	M.MOHSESHAD	00.00	000	0000000000	00.00	000.0000	00.00	000.0000	
DD1	JAN.2022	IFA	MARTAPAR	M.PAKHMANIAN	M.MOHSESHAD	00.00							
DD0	SEP.2021	IPC	MARTAPAR	M.PAKHMANIAN	M.MOHSESHAD	00.00	REV.	DESCRIPTION	BY	DATE	BY	DATE	
REV.	DATE	P.O.I.S	PREP.	CHK.	APP.	AUT.			CHECKED		REV.	APPR.	
PROJECT NAME: BINAK OILFIELD DEVELOPMENT/SURFACE FACILITIES GAS COMPRESSOR STATION							اصل و کلیه نسخ این نقشه و حق اقبالی متعلق به شرکت حق اقبالی مناطق نفت جنوب می باشد						
PROJECT NO.: 971020							 THE ORIGINAL AND ALL COPIES OF THIS DRAWING TOGETHER WITH THE COPYRIGHT THEREIN ARE THE SOLE PROPERTY OF N.I.S.O.C./ FIELDS						
EPC CONTRACTOR:			EPD/EPC CONTRACTOR (GC):				BINAK OILFIELD DEVELOPMENT SURFACE FACILITIES GAS COMPRESSOR STATION						
 HURGAN ENERGY - DESIGN & INSPECTION COMPANIES			 PETROIRAN DEVELOPMENT COMPANY				DATE SCALE DRAWING BY CHECKED BY PROJECT ENG.						
DRAWING TITLE: 1st STAGE GAS COMPRESSION SUCTION DRUMS							NO CONSTRUCTION PERMITTED UNLESS DRAWING APPROVED						
							APPROVED FOR CONSTRUCTION			BY:		DATE:	
SCALE	SIZE	DRAWING NO.		SHEET NO.	REV.	BUDGET REF.	LOCATION	SIZE	CLASS	SERIAL NO.	SHEET	REVISION	
NS	A3	BK-GCS-PEDCO-120-PR-PI-0006		2 OF 3	D04	053-073-9184	F	2	A	708784	2 OF 3	D04	

THE ORIGINAL AND ALL COPIES OF THIS DRAWING TOGETHER WITH THE COPYRIGHT THEREIN ARE THE SOLE PROPERTY OF N.I.S.O.C./ FIELDS

DATE	SCALE	DRAWING BY	CHECKED BY	PROJECT ENG.

(VENDOR TITLE BLOCK)**

