


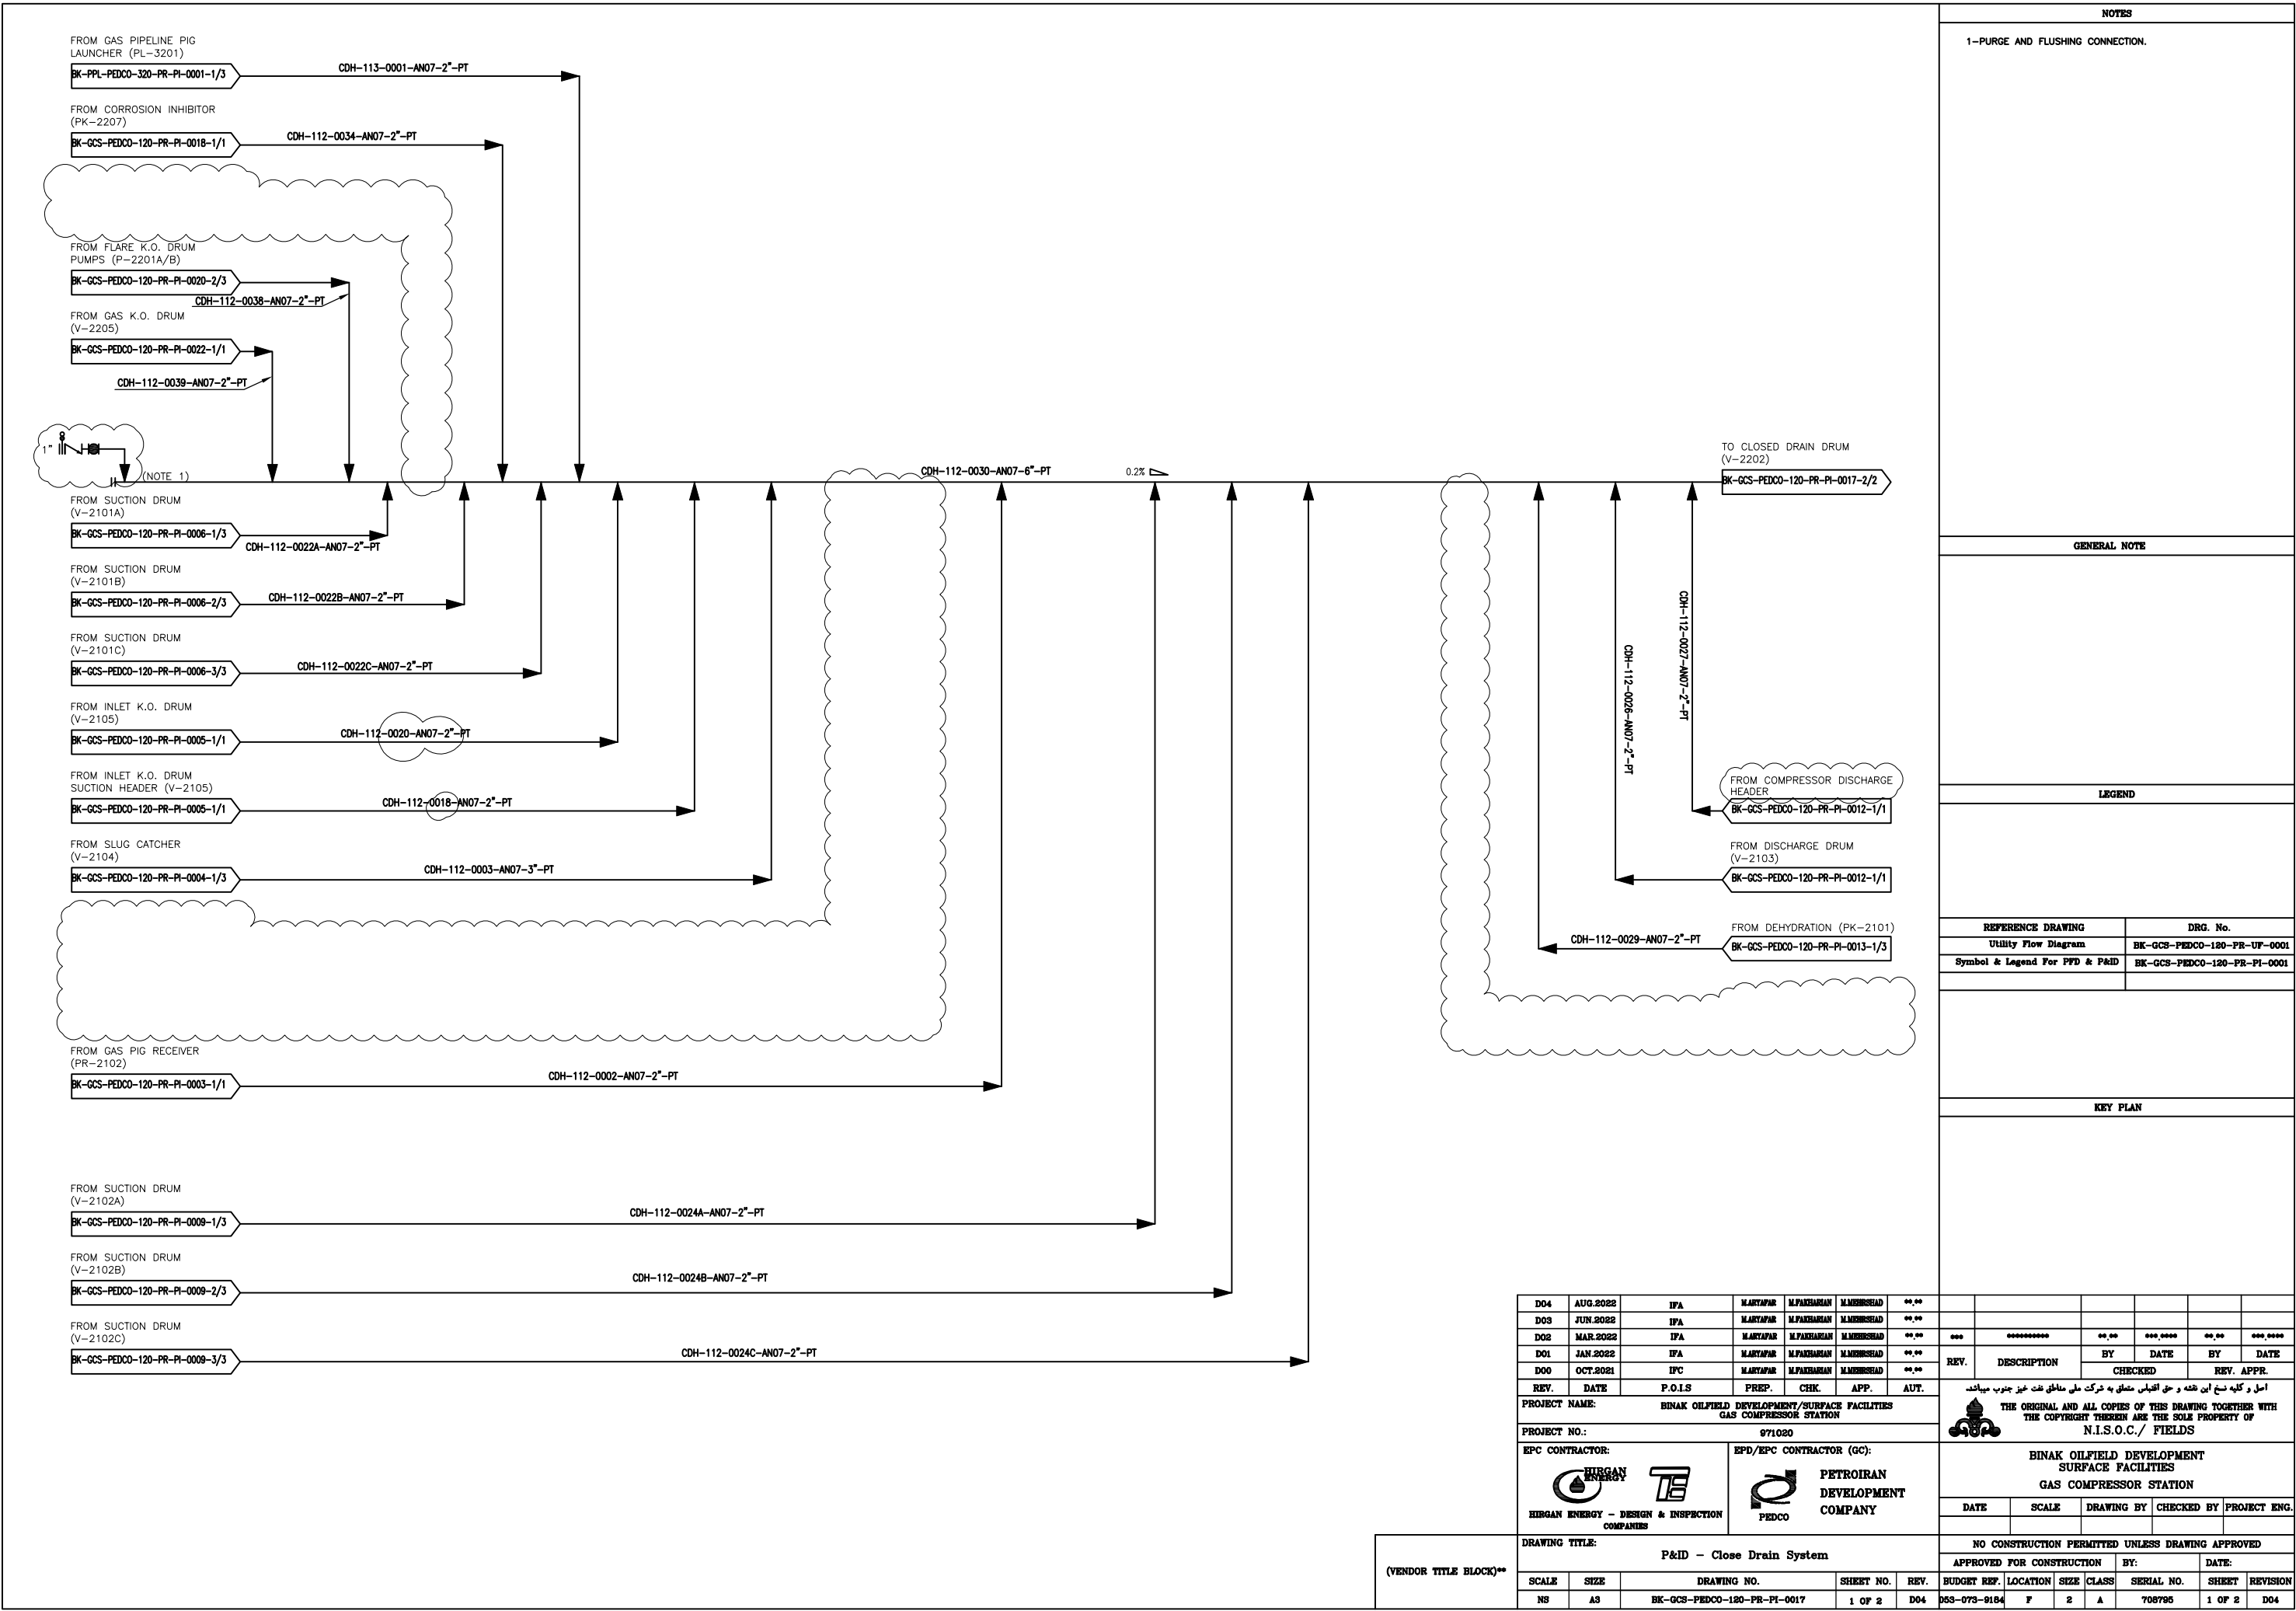



1- IN CASE OF LOW LEVEL OF LIA-2221, THE CONTROL SYSTEM
STOPS BOTH PUMPS, IF LIQUID LEVEL OF V-2202 REACHES H1
LEVEL, LEAD PUMP WILL BE STARTED. IN CASE OF H2 LEVEL ALARM,
LAG PUMP WILL BE STARTED.

2- DELETED.

3- FLARE K.O. DRUM, CLOSE DRUM AND RELATED PUMPS ARE IN
COMMON PIT.

GENERAL NOTE

LEGEND

REFERENCE DRAWING	DRG. No.
Utility Flow Diagram	BK-GCS-PEDCO-120-PR-UF-0001
Symbol & Legend For PFD & P&ID	BK-GCS-PEDCO-120-PR-PI-0001

KEY PLAN

[illegible]

ب. میبائند۔

THE ORIGINAL AND ALL COPIES OF THIS DRAWING TOGETHER WITH
THE COPYRIGHT THEREIN ARE THE SOLE PROPERTY OF
N.I.S.O.C./ FIELDS

**BINAK OILFIELD DEVELOPMENT
SURFACE FACILITIES
GAS COMPRESSOR STATION**

DATE	SCALE	DRAWING BY	CHECKED BY	PROJECT ENG.
------	-------	------------	------------	--------------

NO CONSTRUCTION PERMITTED UNLESS DRAWING APPROVED

SCALE	SIZE	DRAWING NO.	SHEET NO.	REV.	BUDGET REF.	LOCATION	SIZE	CLASS	SERIAL NO.	SHEET	REVISION
NS	A3	EK-GCS-PEDCO-120-PR-P1-0017	2 OF 2	D04	D63-073-9184	F	2	A	708796	2 OF 2	D04