


TK-2209
POTABLE WATER TANK
DIMENSION (ID X TL-TL) : 3500 X 2600 mm
NOMINAL CAPACITY : 25 m³
DESIGN TEMP. : 85 °C
DESIGN PRESS. : ATM + FULL OF WATER

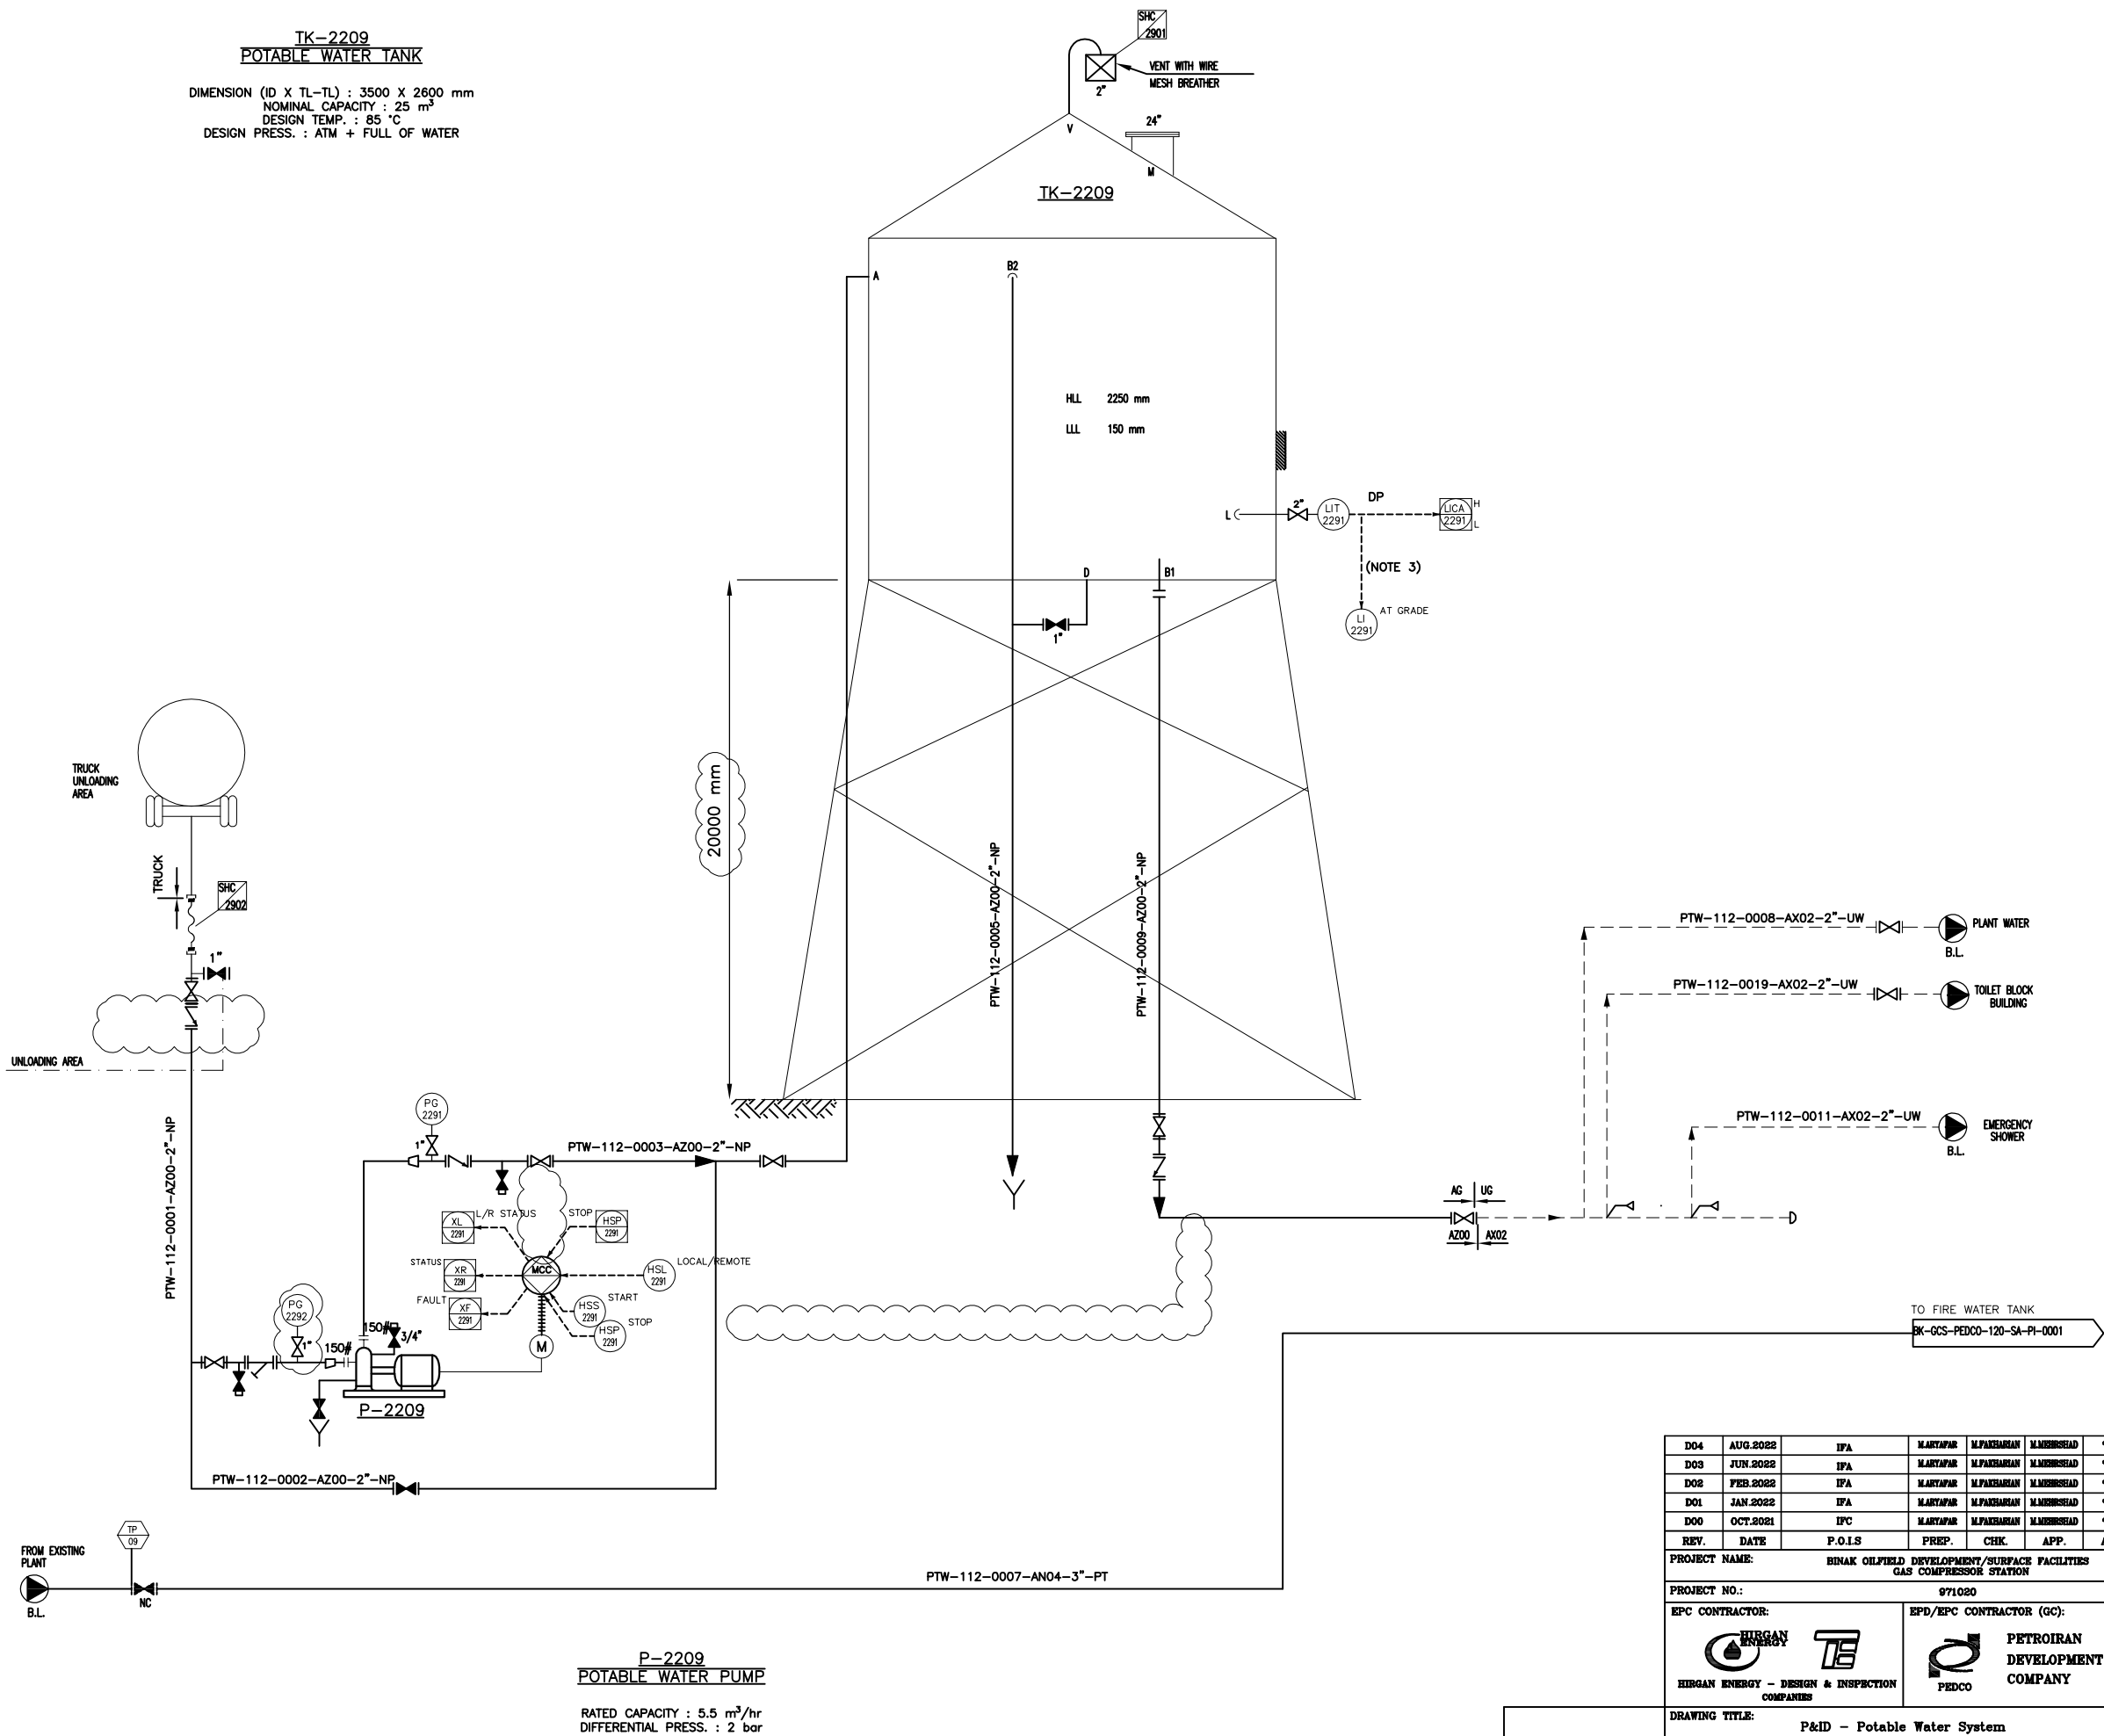

NOTES

1- DELETED.
2- DELETED.
3- LI SHALL BE READABLE AT GROUND.

GENERAL NOTE

LEGEND

PTW-112-0008-AX02-2"-UW

PLANT WATER

B.L.

PTW-112-0019-AX02-2"-UW

TOILET BLOCK BUILDING

B.L.

PTW-112-0011-AX02-2"-UW

EMERGENCY SHOWER

B.L.

KEY PLAN

TO FIRE WATER TANK

BK-GCS-PEDCO-120-SA-PI-0001

REFERENCE DRAWING		DRG. No.	
Utility Flow Diagram		BK-GCS-PEDCO-120-PR-UF-0001	
Symbol & Legend For PFD & P&ID		BK-GCS-PEDCO-120-PR-PI-0001	

REV.	DESCRIPTION	BY	DATE	BY	DATE	
DD4	AUG.2022	IFA	MARYAPAR	M.PAKHABANIAN	M.MOHSESHAD	00.00
DD3	JUN.2022	IFA	MARYAPAR	M.PAKHABANIAN	M.MOHSESHAD	00.00
DD2	FEB.2022	IFA	MARYAPAR	M.PAKHABANIAN	M.MOHSESHAD	00.00
DD1	JAN.2022	IFA	MARYAPAR	M.PAKHABANIAN	M.MOHSESHAD	00.00
DD0	OCT.2021	IPC	MARYAPAR	M.PAKHABANIAN	M.MOHSESHAD	00.00

اصل و کلیه نسخ این نقشه و حق اقتباس متعلق به شرکت ملی مناطق نفت خیز جنوب میباشد.
THE ORIGINAL AND ALL COPIES OF THIS DRAWING TOGETHER WITH THE COPYRIGHT THEREIN ARE THE SOLE PROPERTY OF N.I.S.O.C./ FIELDS

BINAK OILFIELD DEVELOPMENT
SURFACE FACILITIES
GAS COMPRESSOR STATION

DATE	SCALE	DRAWING BY	CHECKED BY	PROJECT ENG.

NO CONSTRUCTION PERMITTED UNLESS DRAWING APPROVED

APPROVED FOR CONSTRUCTION

BY:

DATE:

SCALE	SIZE	DRAWING NO.	SHEET NO.	REV.	BUDGET REF.	LOCATION	SIZE	CLASS	SERIAL NO.	SHEET	REVISION
NS	A3	BK-GCS-PEDCO-120-PR-PI-0024	1 OF 1	DD4	053-073-9184	F	2	A	708802	1 OF 1	DD4

(VENDOR TITLE BLOCK)**

PROJECT NAME:

BINAK OILFIELD DEVELOPMENT/SURFACE FACILITIES
GAS COMPRESSOR STATION

PROJECT NO.:

971020

EPC CONTRACTOR:

HURGAN ENERGY

TE

HURGAN ENERGY - DESIGN & INSPECTION COMPANIES

EPC CONTRACTOR (GC):

PETROIRAN DEVELOPMENT COMPANY

PEDCO

DRAWING TITLE:

P&ID - Potable Water System