
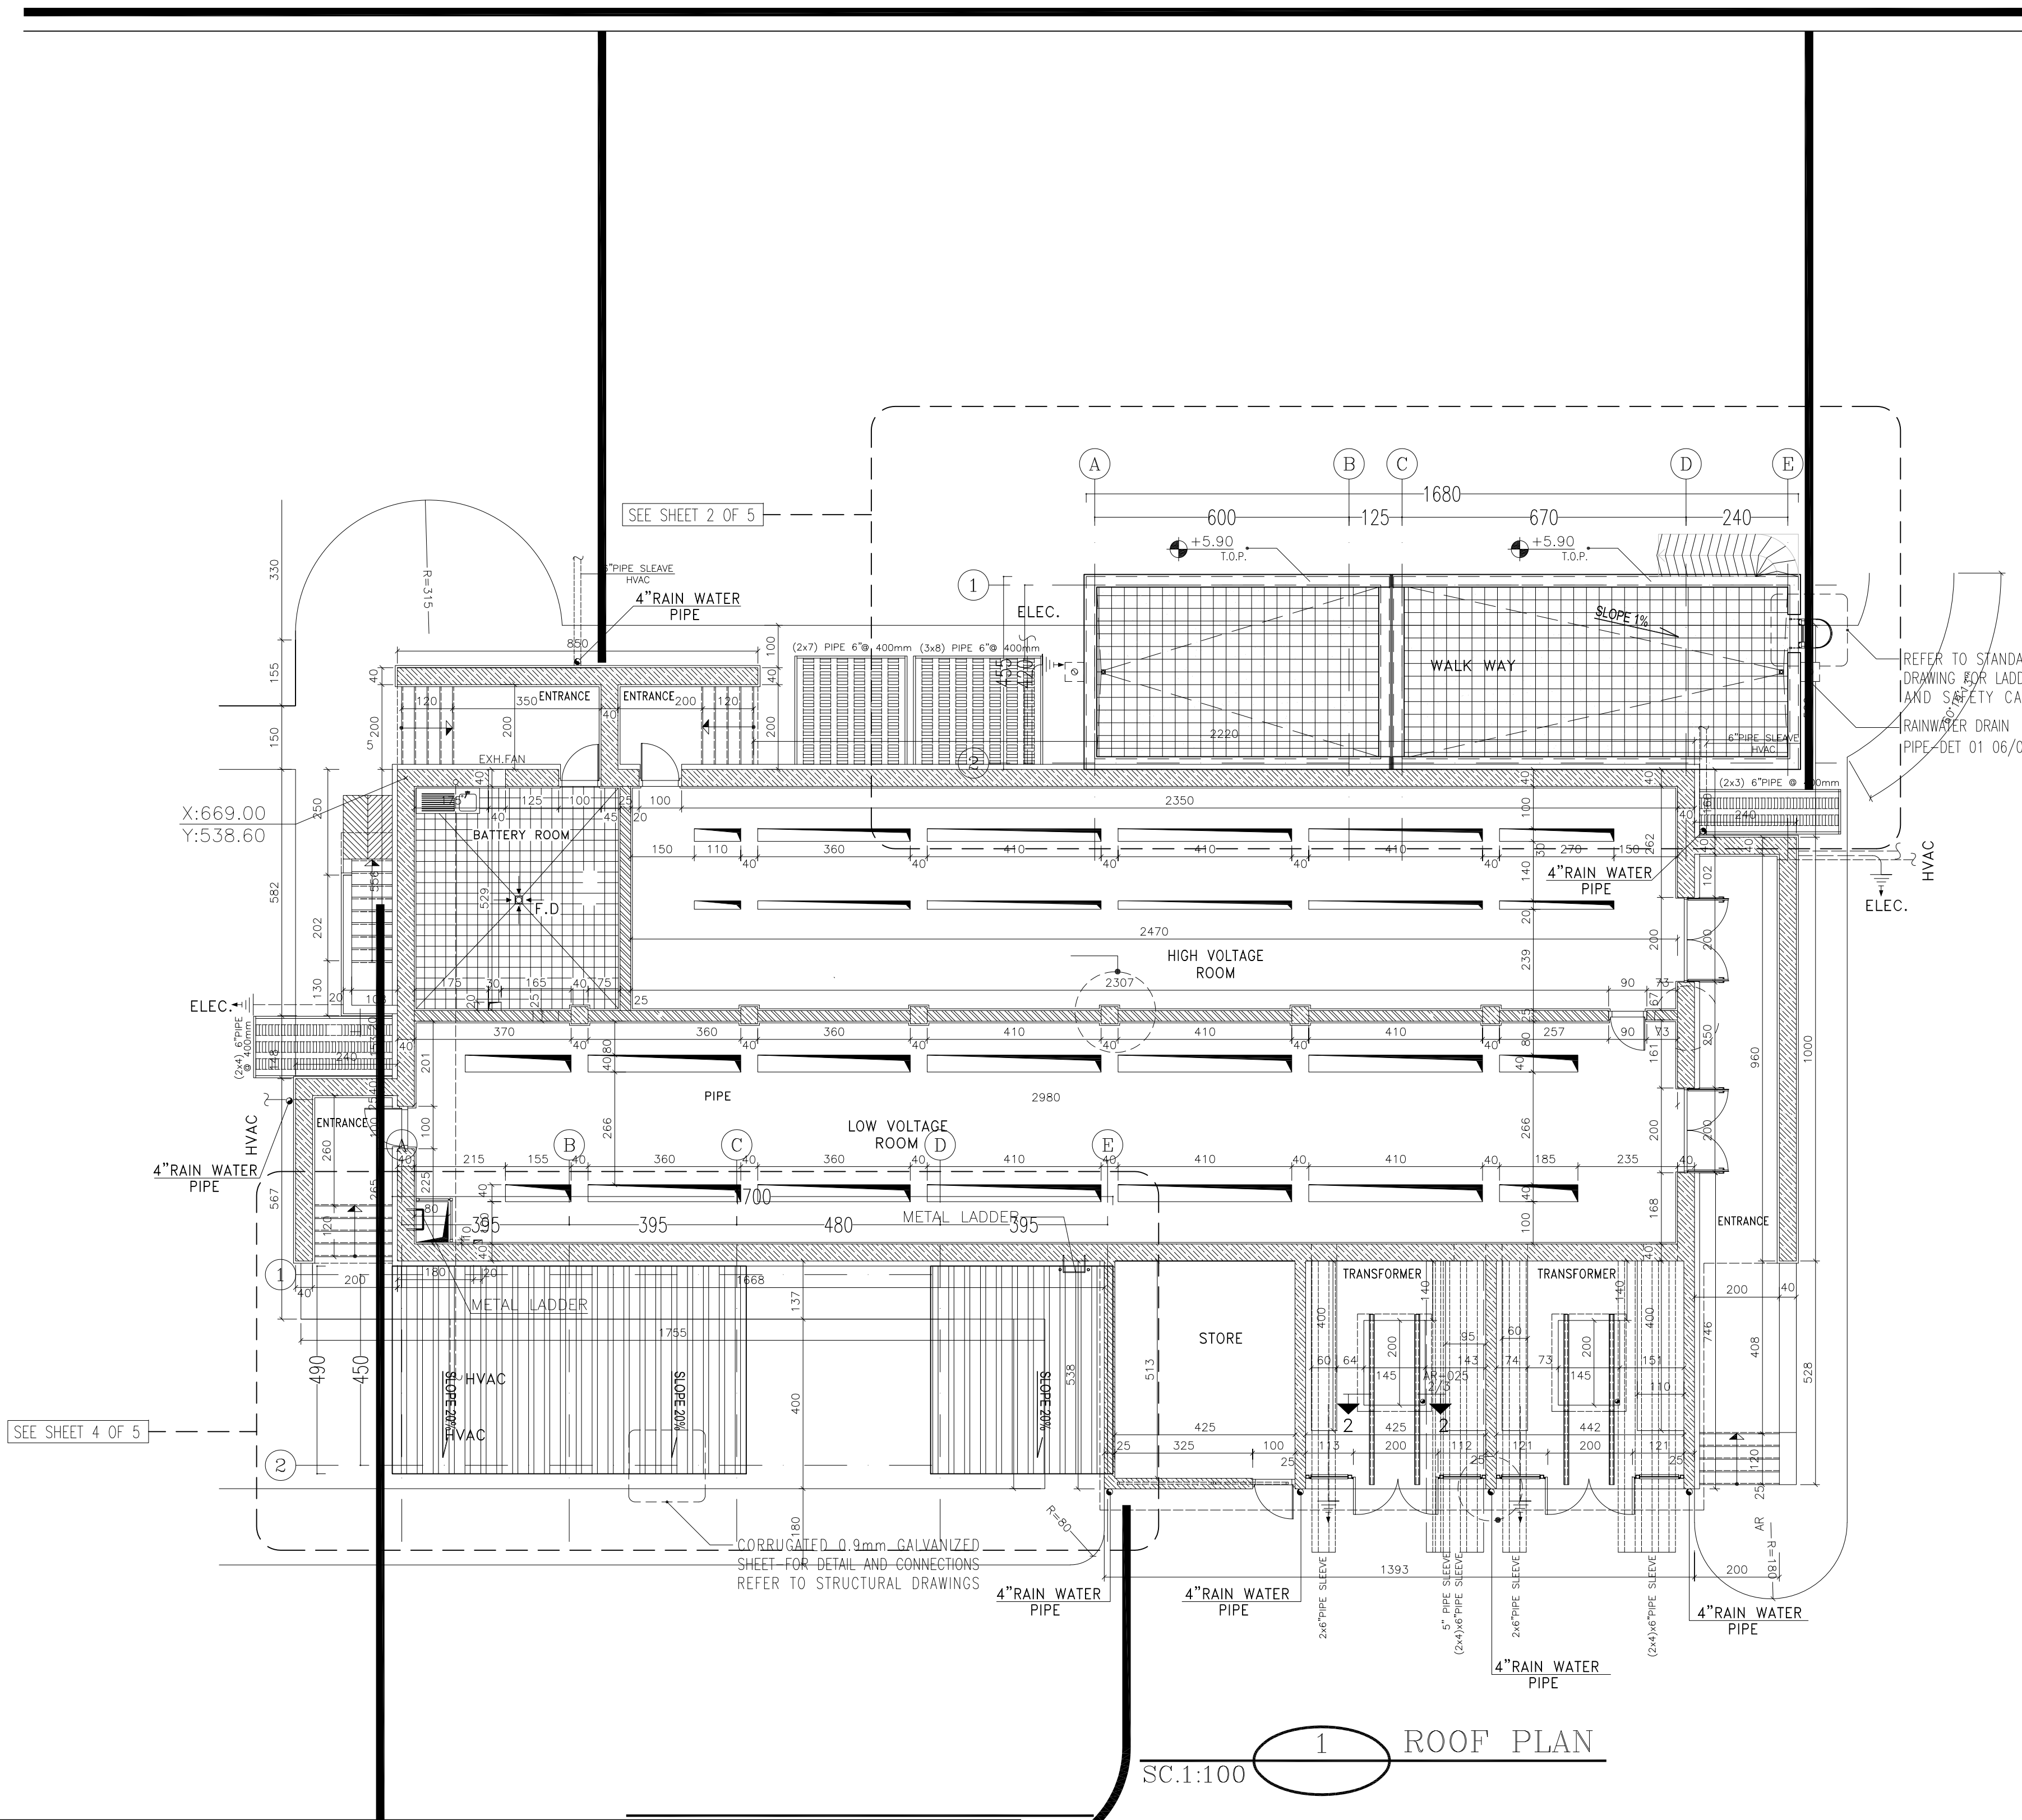


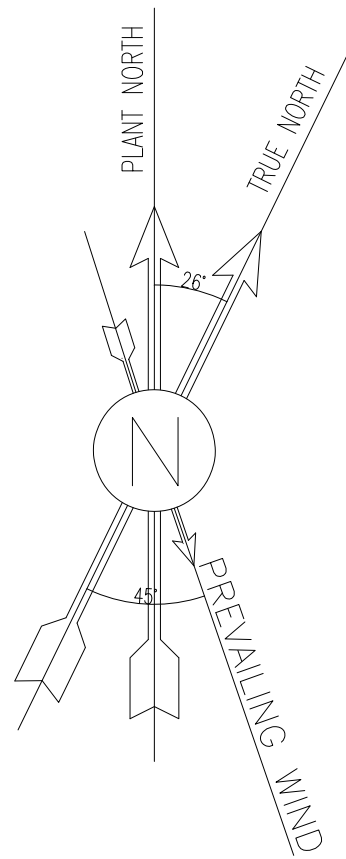

D02


- NOTES
1. ALL DIMENSIONS ARE IN CENTIMETER & ALL ELEVATIONS ARE IN METER.
 2. ALL DIMENSIONS AND ELEVATIONS SHALL BE CHECKED BY THE CONTRACTOR PRIOR TO CONSTRUCTION.
 3. CONTRACTOR SHALL COMPARE ALL ARCHITECTURAL, MECHANICAL, ELECTRICAL, PIPING AND STRUCTURAL DRAWINGS AND IN CASE OF ANY CONFLICTS OR DISCREPANCY, INFORM THE ENGINEER.
 4. ALL MATERIALS ARE SELECTED FROM THE HIGHEST QUALITY AND MUST BE APPROVED BY THE CLIENT.
 5. ALL OPENINGS FOR PIPING/CABLING AND HVAC OPENINGS SHALL BE CONSIDERED AS PER RELATED DRAWINGS BEFORE CONSTRUCTION.
 6. ARCHITECTURAL DETAIL DESIGN WILL BE REVISED BASED ON APPROVED STRUCTURAL DRAWINGS.
 7. ELEVATION CODE : LOCAL $\pm 0.0m$ CORRESPONDS TO GLOBAL $+11.10m$

LEGEND



LEAN CONCRETE	
REINFORCED CONCRETE	
PRESSED BRICK	
STONE	
EXPANSION JOINT FILLER (PLASTOFOAM)	
TERRAZZO TILES FOR ROOF - 30x30cm	

F.F.L.	FINISHED FLOOR	B.O.P.	BOTTOM OF PIT
T.O.WA	TOP OF WALKWAY	F.G.L.	FINISH GRADING LEVEL
T.O.P.	TOP OF PARAPET	T.O.T.	TOP OF TIE BEAM
T.O.FOU.	TOP OF FOUNDATION	C.O.S.	CENTER OF SLEEVE
M.D	METAL DOOR	B.O.S.	BOTTOM OF SLEEVE
T.O.R	TOP OF ROOF	B.O.O.	BOTTOM OF OPENING
T.O.D.	TOP OF DOOR	B.O.T.	BOTTOM OF TRENCH
B.O.Co.	BOTTOM OF CAGE	B.O.P.	BOTTOM OF PIT
T.O.Co.	TOP OF CAGE	R.H.P.	ROOF HIGHEST POINT
B.O.G.	BOTTOM OF GUTTER	R.L.P.	ROOF LOWEST POINT
T.O.Co.	TOP OF CAGE	N.G.R.	NEUTRAL GROUND RESISTOR
M.D.	METAL DOOR	B.P.D.	BLAST-PROOF DOOR
		F.D.	FENCE DOOR




REFERENCE DRAWING	DRG. No.
STANDARD DRAWING FOR ARCHITECTURAL DETAILS	BK-GNRL-PEDCO-000-AR-DW-0001
SITE SEWORAGE SYSTEM LAYOUT & DETAILS	BK-GCS-PEDCO-120-CV-PY-0001
CABLE TRENCH AND DUCT BANK LAYOUT	BK-GCS-PEDCO-120-CV-PY-0002
ROAD, PAVING AND PLANT FINISH GRADING LAYOUT & SECTIONS	BK-GCS-PEDCO-120-CV-PY-0005
ELECTRICAL CABLE ROUTE & SECTION LAYOUT FOR BUILDING & SHELTER	BK-GCS-PEDCO-120-EL-PY-0006
FOUNDATION DRAWING FOR EXTENSION OF EXISTING ELECT. BUILDING	BK-GCS-PEDCO-120-ST-DW-0063
STRUCTURAL DRAWING FOR EXTENSION OF EXISTING ELECT. BUILDING	BK-GCS-PEDCO-120-ST-DW-0064
STANDARD DETAILS FOR LADDER & SAFETY CAGE	BK-GNRL-PEDCO-000-ST-DW-0009

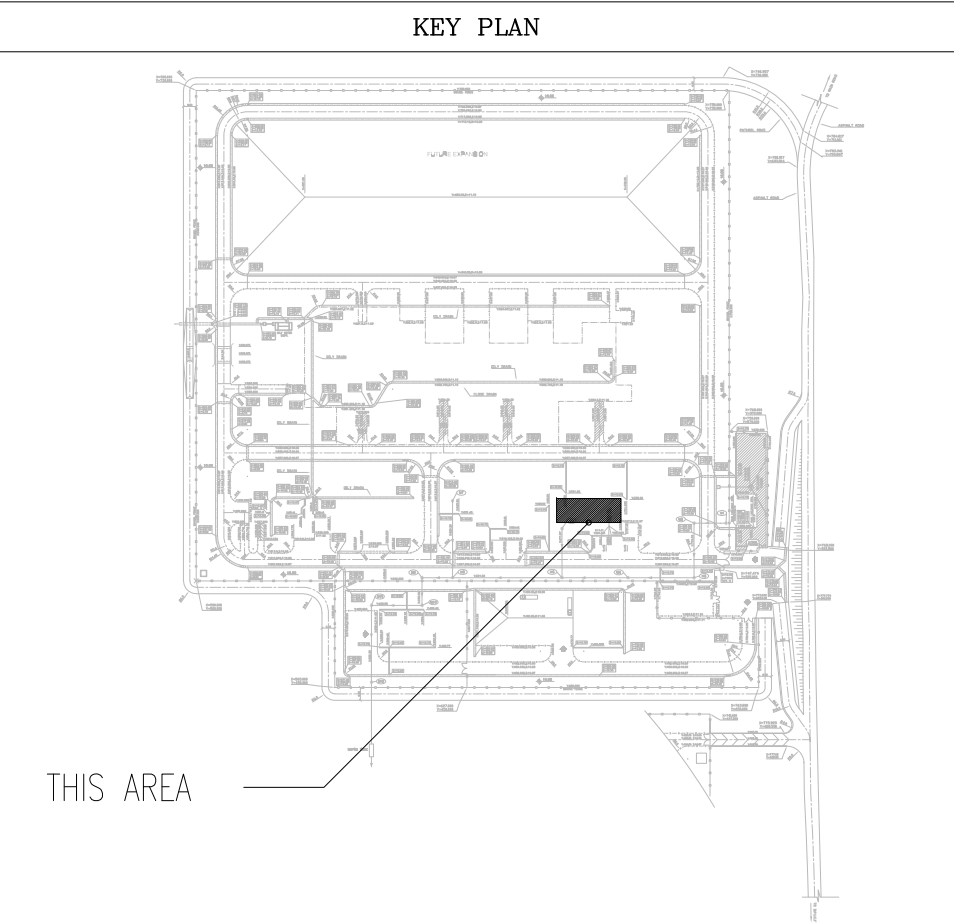

D02	AUG.2022	IFA	R.BERLOUIE	M.PAKHARIAN	M.MEHRSHAD	***	***	*****	***	*****	***	*****
D01	APR.2022	IFA	R.BERLOUIE	M.PAKHARIAN	M.MEHRSHAD	***	REV.	DESCRIPTION	BY	DATE	BY	DATE
D00	JAN.2022	IPC	R.BERLOUIE	M.PAKHARIAN	M.MEHRSHAD	***			CHECKED		REV. APPR.	
REV.	DATE	P.O.I.S	PREP.	CHK.	APP.	AUT.	اصل و کلیه نسخ این نقشه و حق اقتباس متعلق به شرکت ملی مناطق نفت خیز جنوب میباشد.					
PROJECT NAME:			BINAK OILFIELD DEVELOPMENT/SURFACE FACILITIES GAS COMPRESSOR STATION				 THE ORIGINAL AND ALL COPIES OF THIS DRAWING TOGETHER WITH THE COPYRIGHT THEREIN ARE THE SOLE PROPERTY OF N.I.S.O.C./ FIELDS					
PROJECT NO.:			971020									
EPC CONTRACTOR:			EPD/EPC CONTRACTOR (GC):				BINAK OILFIELD DEVELOPMENT SURFACE FACILITIES GAS COMPRESSOR STATION					
 HIRGAN ENERGY – DESIGN & INSPECTION COMPANIES			 PETROIRAN DEVELOPMENT COMPANY				DATE SCALE DRAWING BY CHECKED BY PROJECT ENG.					
DRAWING TITLE:			ARCHITECTURAL DETAIL DRAWING FOR EXTENSION OF EXISTING ELECT. BUILDING GENERAL AND ROOF PLAN				NO CONSTRUCTION PERMITTED UNLESS DRAWING APPROVED					
SCALE		SIZE	DRAWING NO.		SHEET NO.	REV.	APPROVED FOR CONSTRUCTION		BY:		DATE:	
AS SHOWN		A1	BK-GCS-PEDCO-120-AR-DW-0002		01 OF 07	D02	053-073-9184		F	4	B	709100

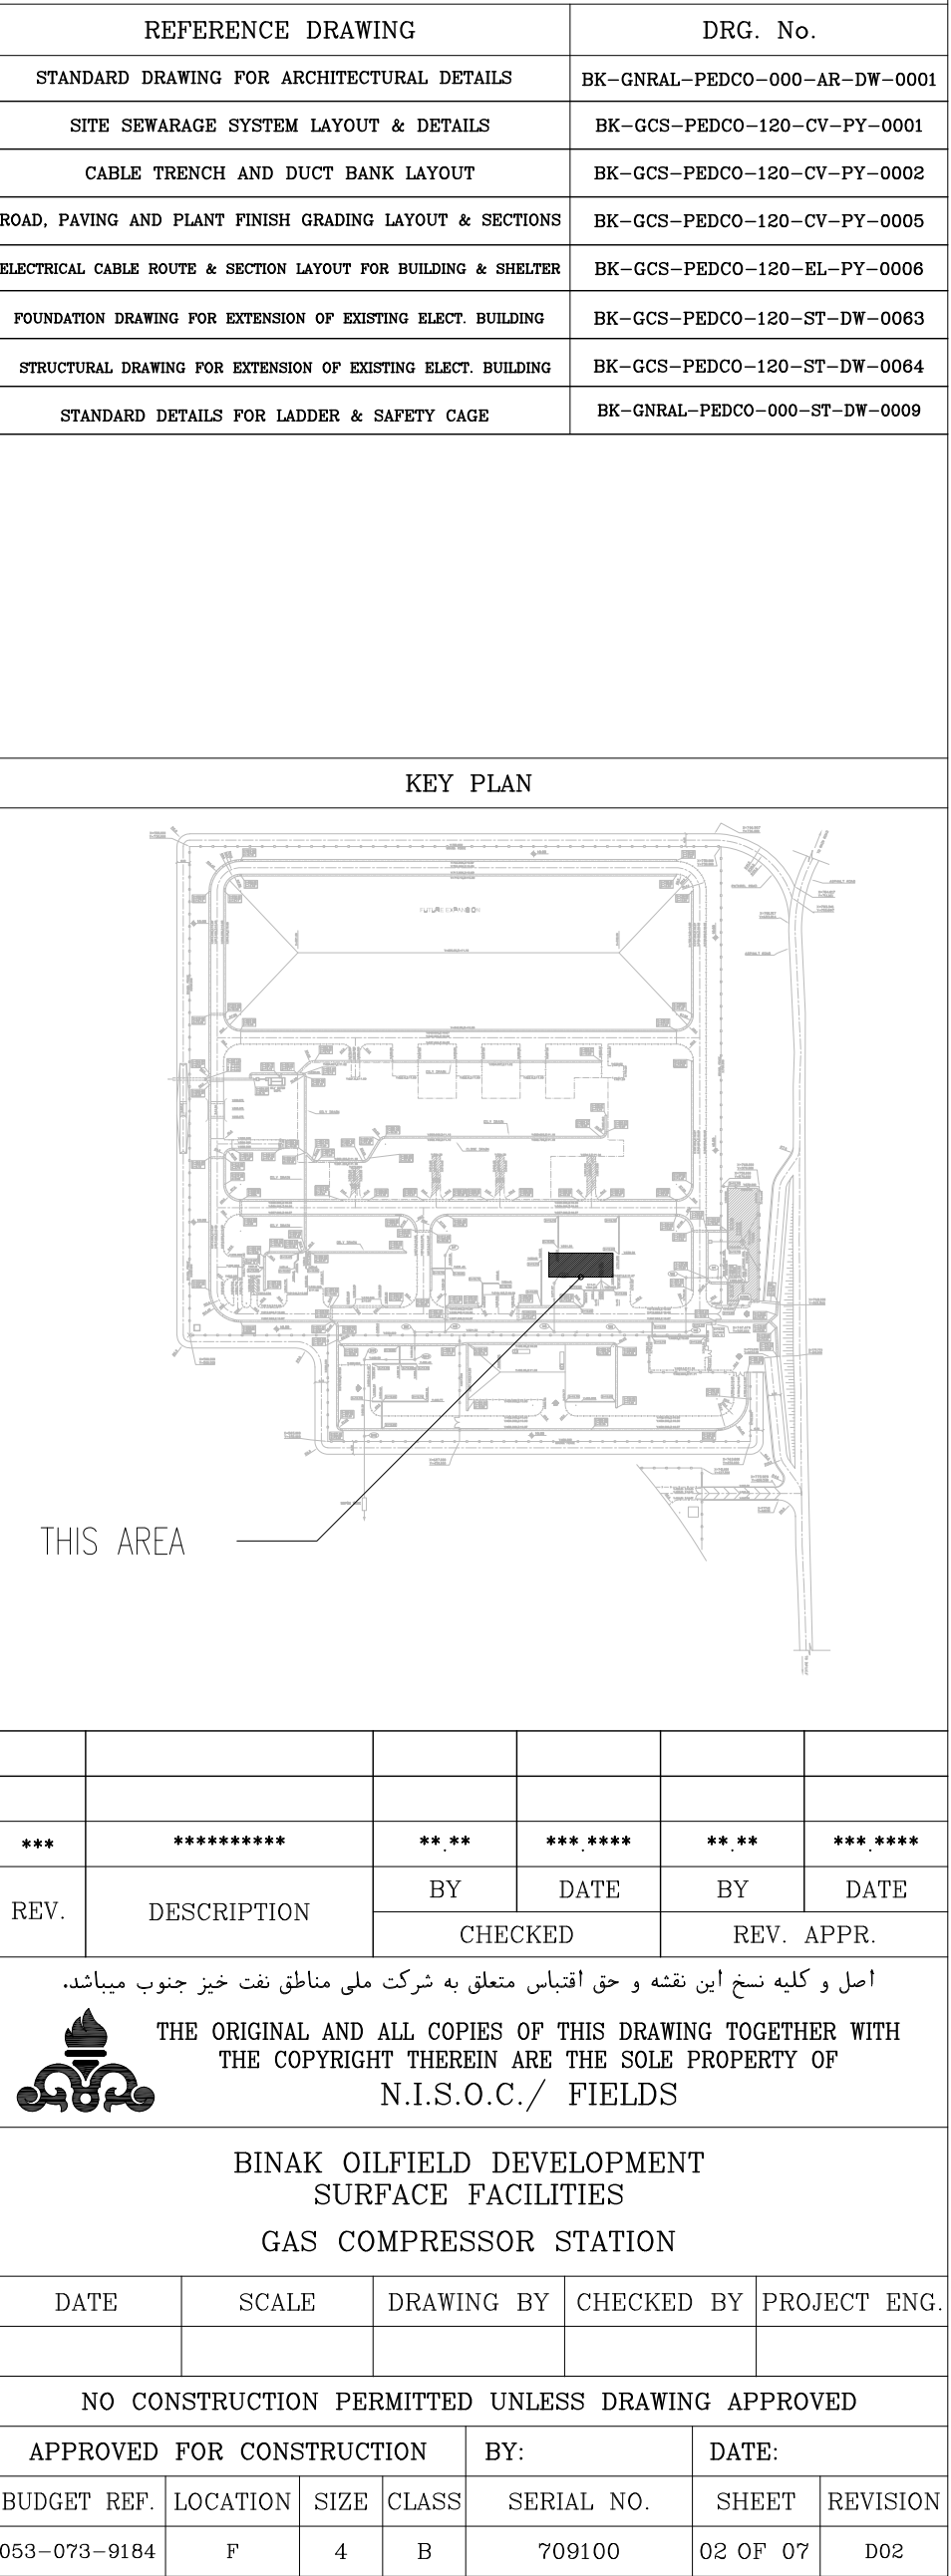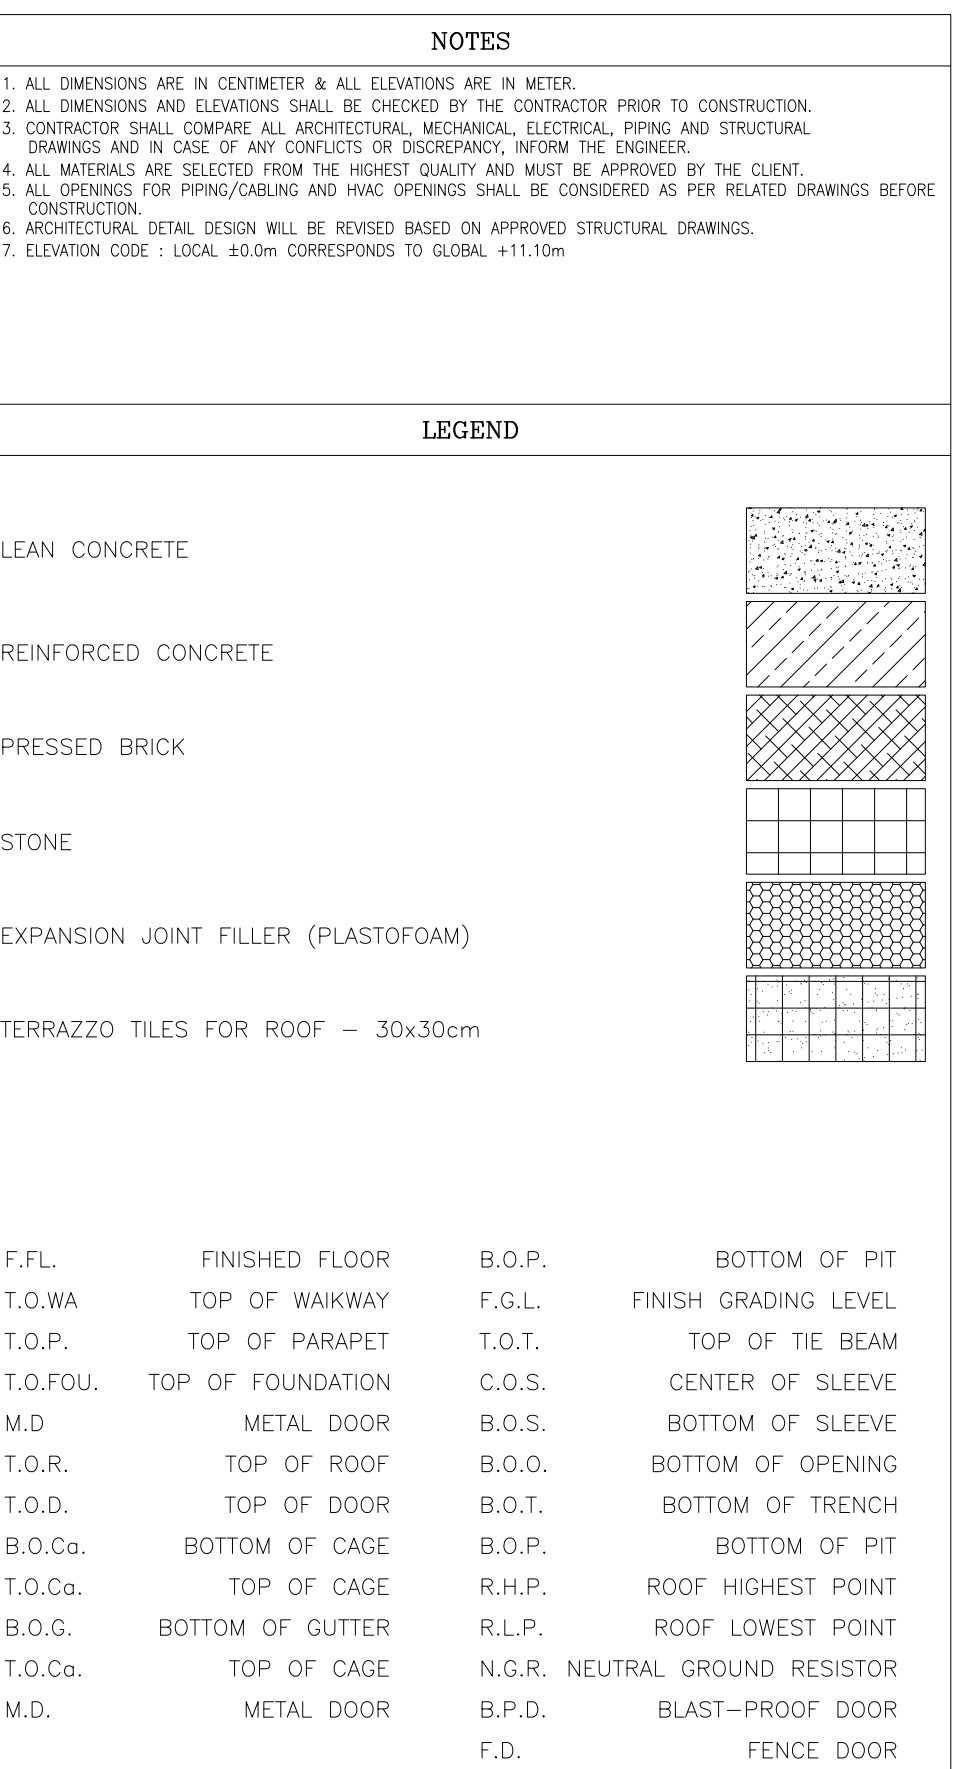


[illegible]

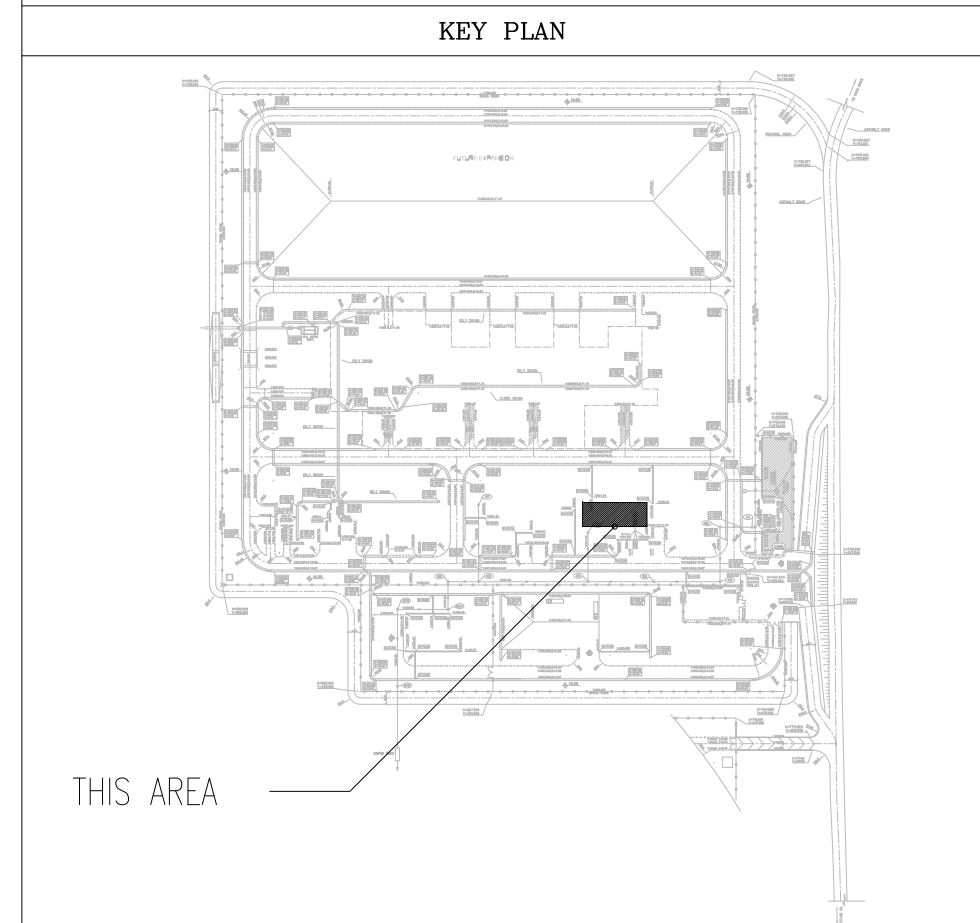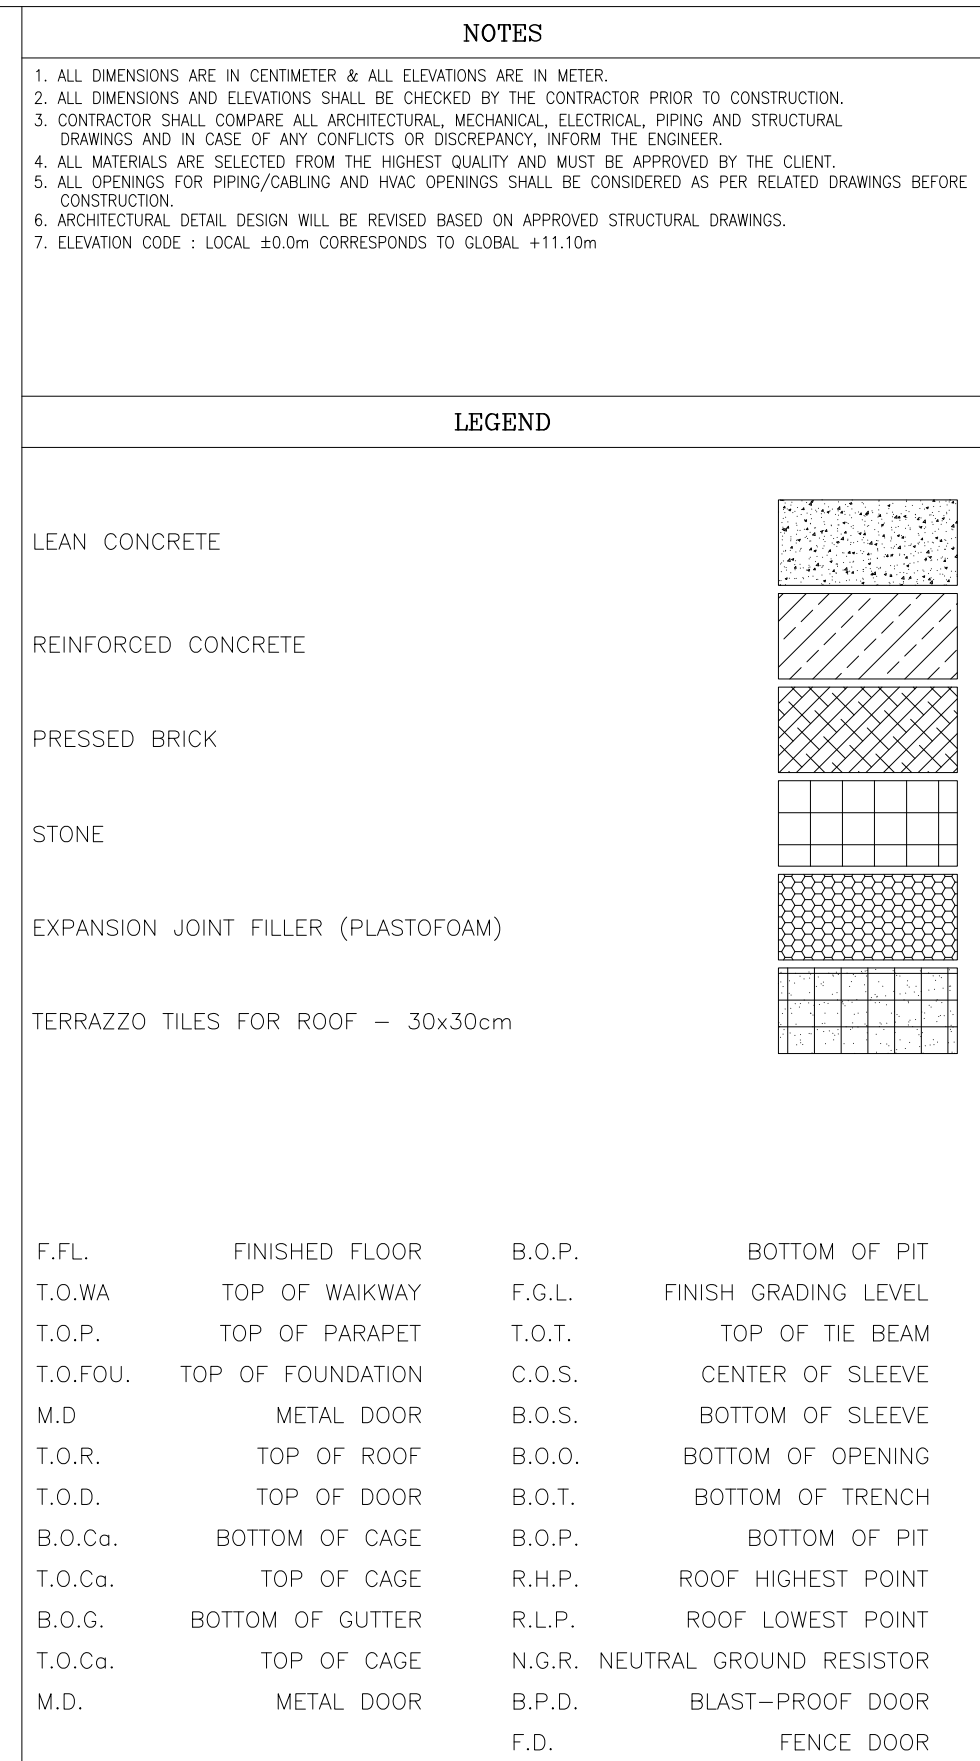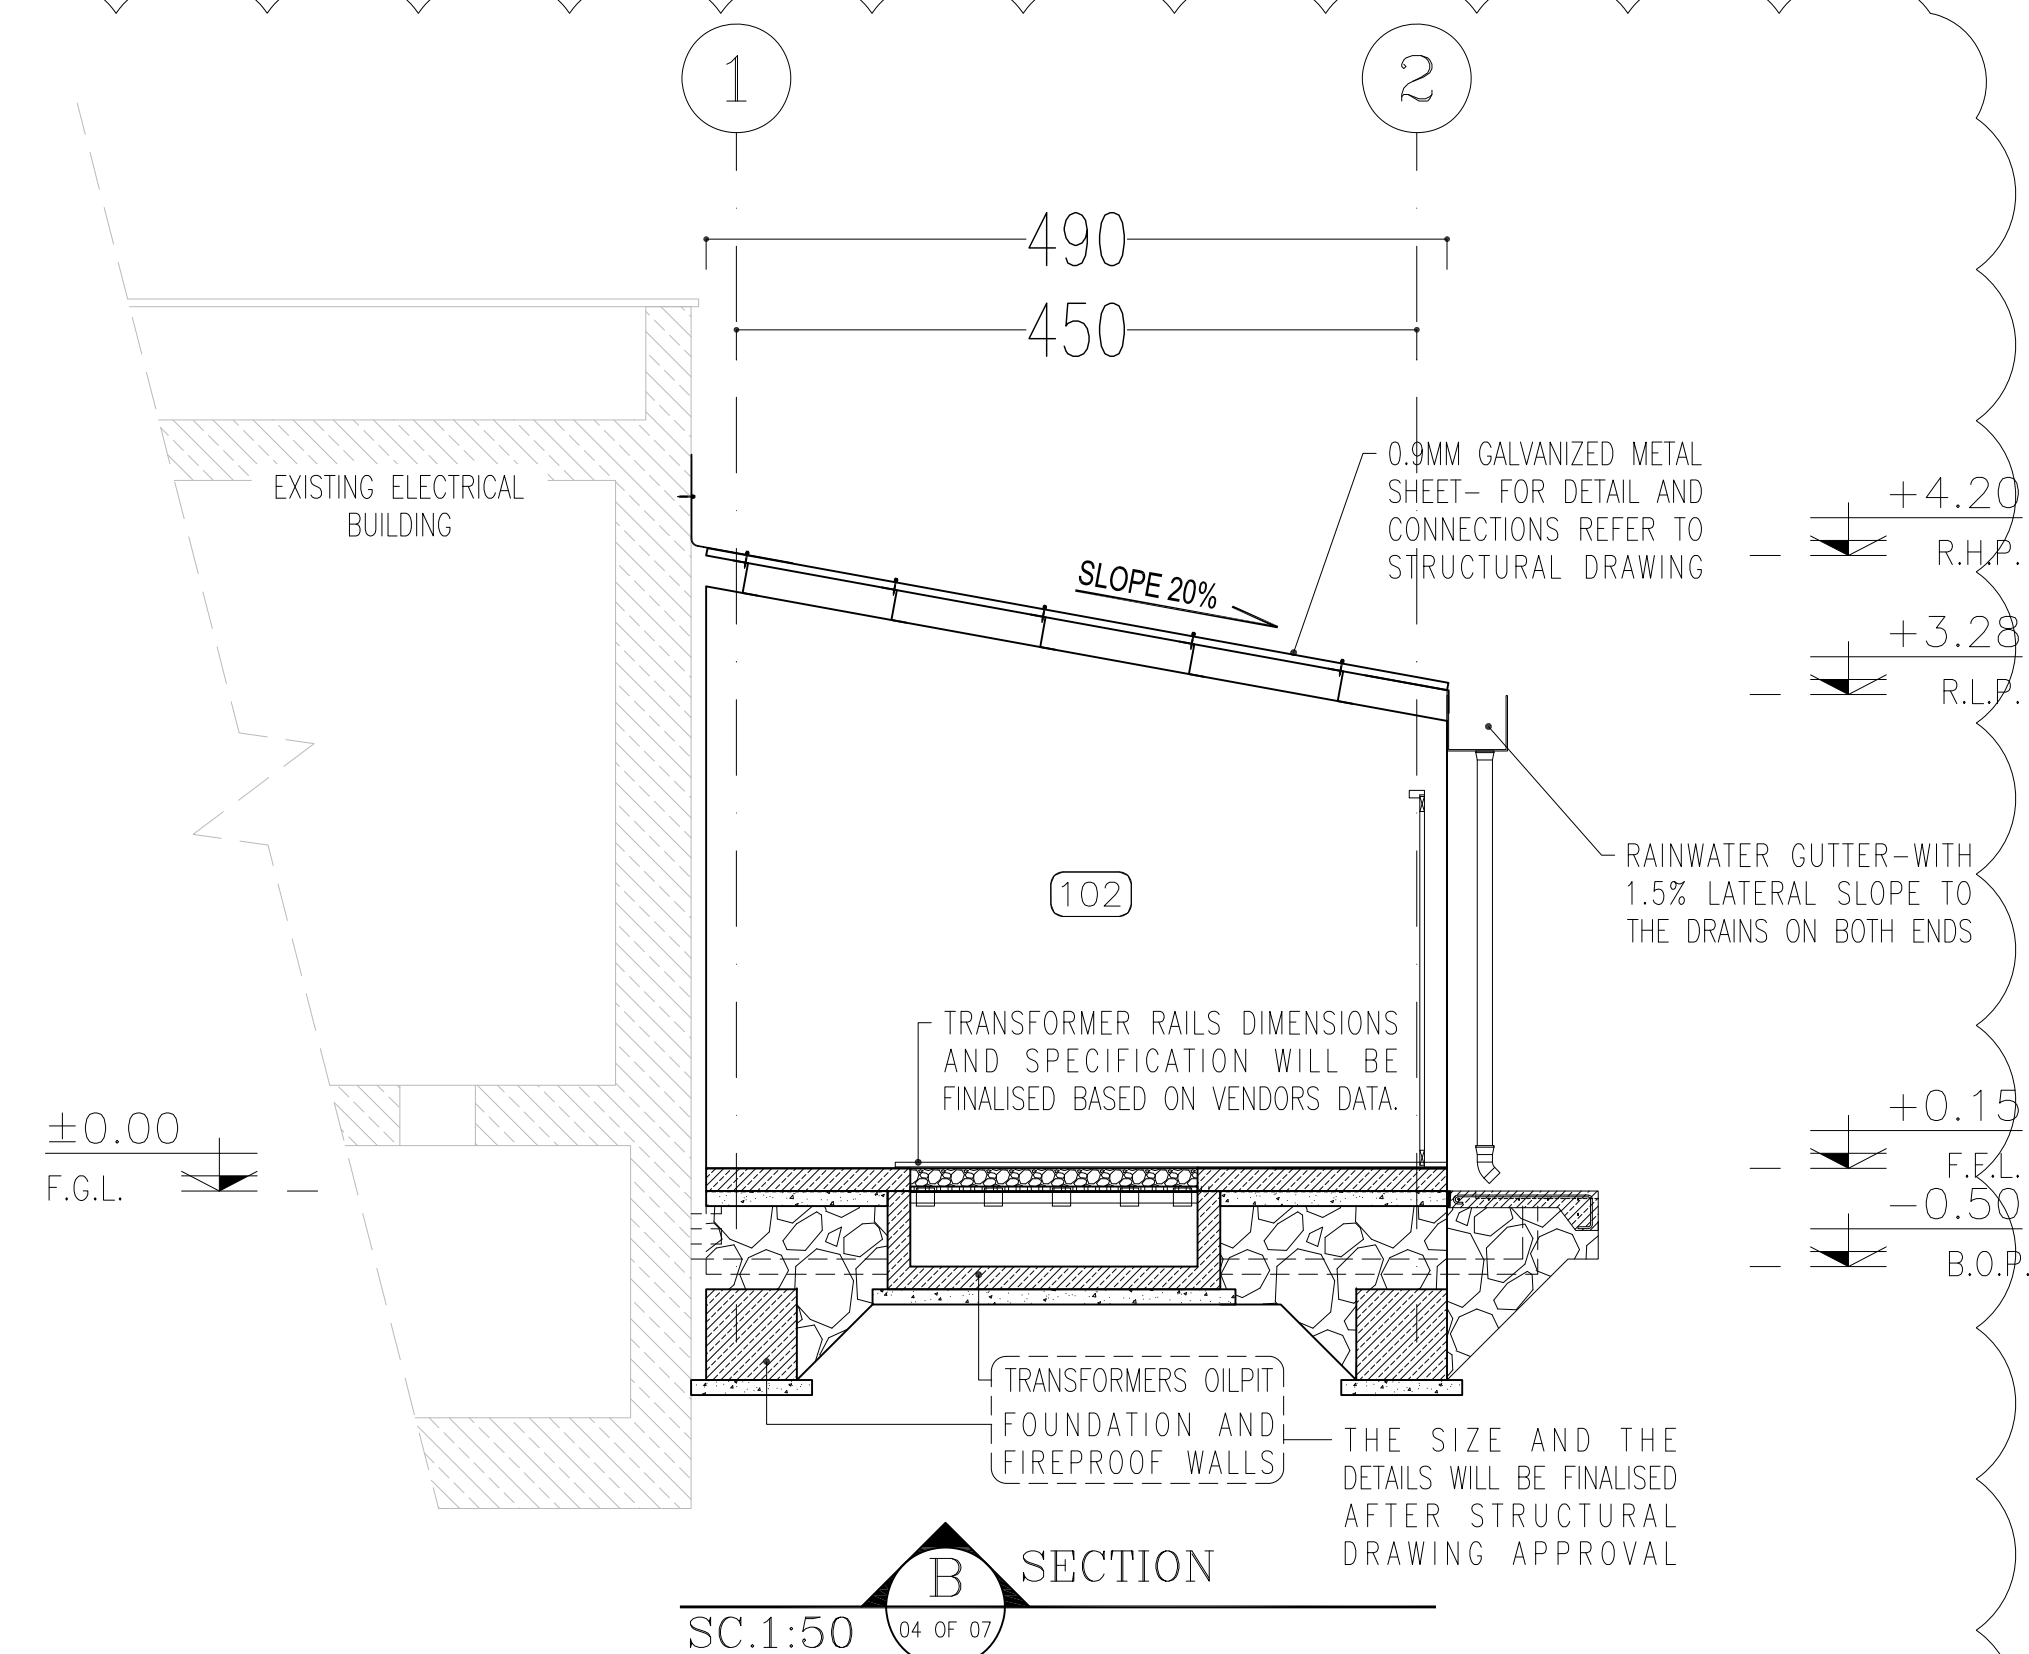[illegible]

SPACE TAG NUMBER

- | | | |
|-----|---|-------------------------------------|
| 100 | { | CAPACITOR BANK |
| 101 | | CO2 ROOM |
| 102 | | TRANSFORMER ROOM |
| 103 | | FIRE-FIGHTING PUMP TRANSFORMER ROOM |

D02

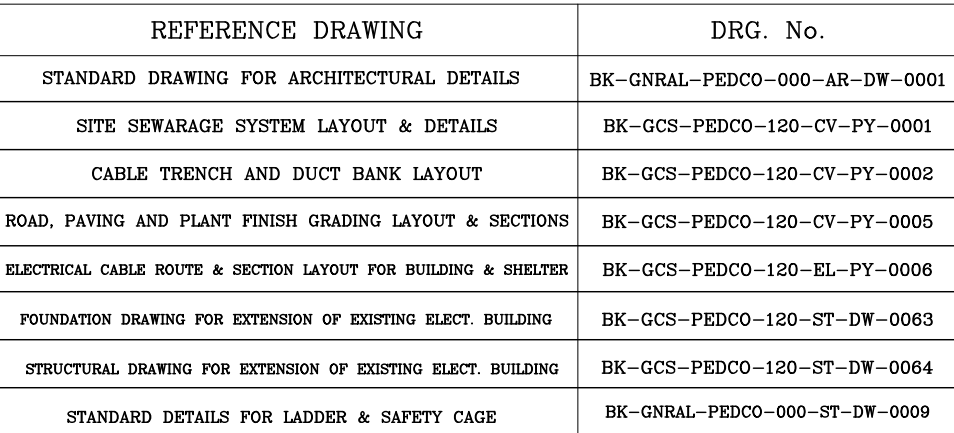D02