


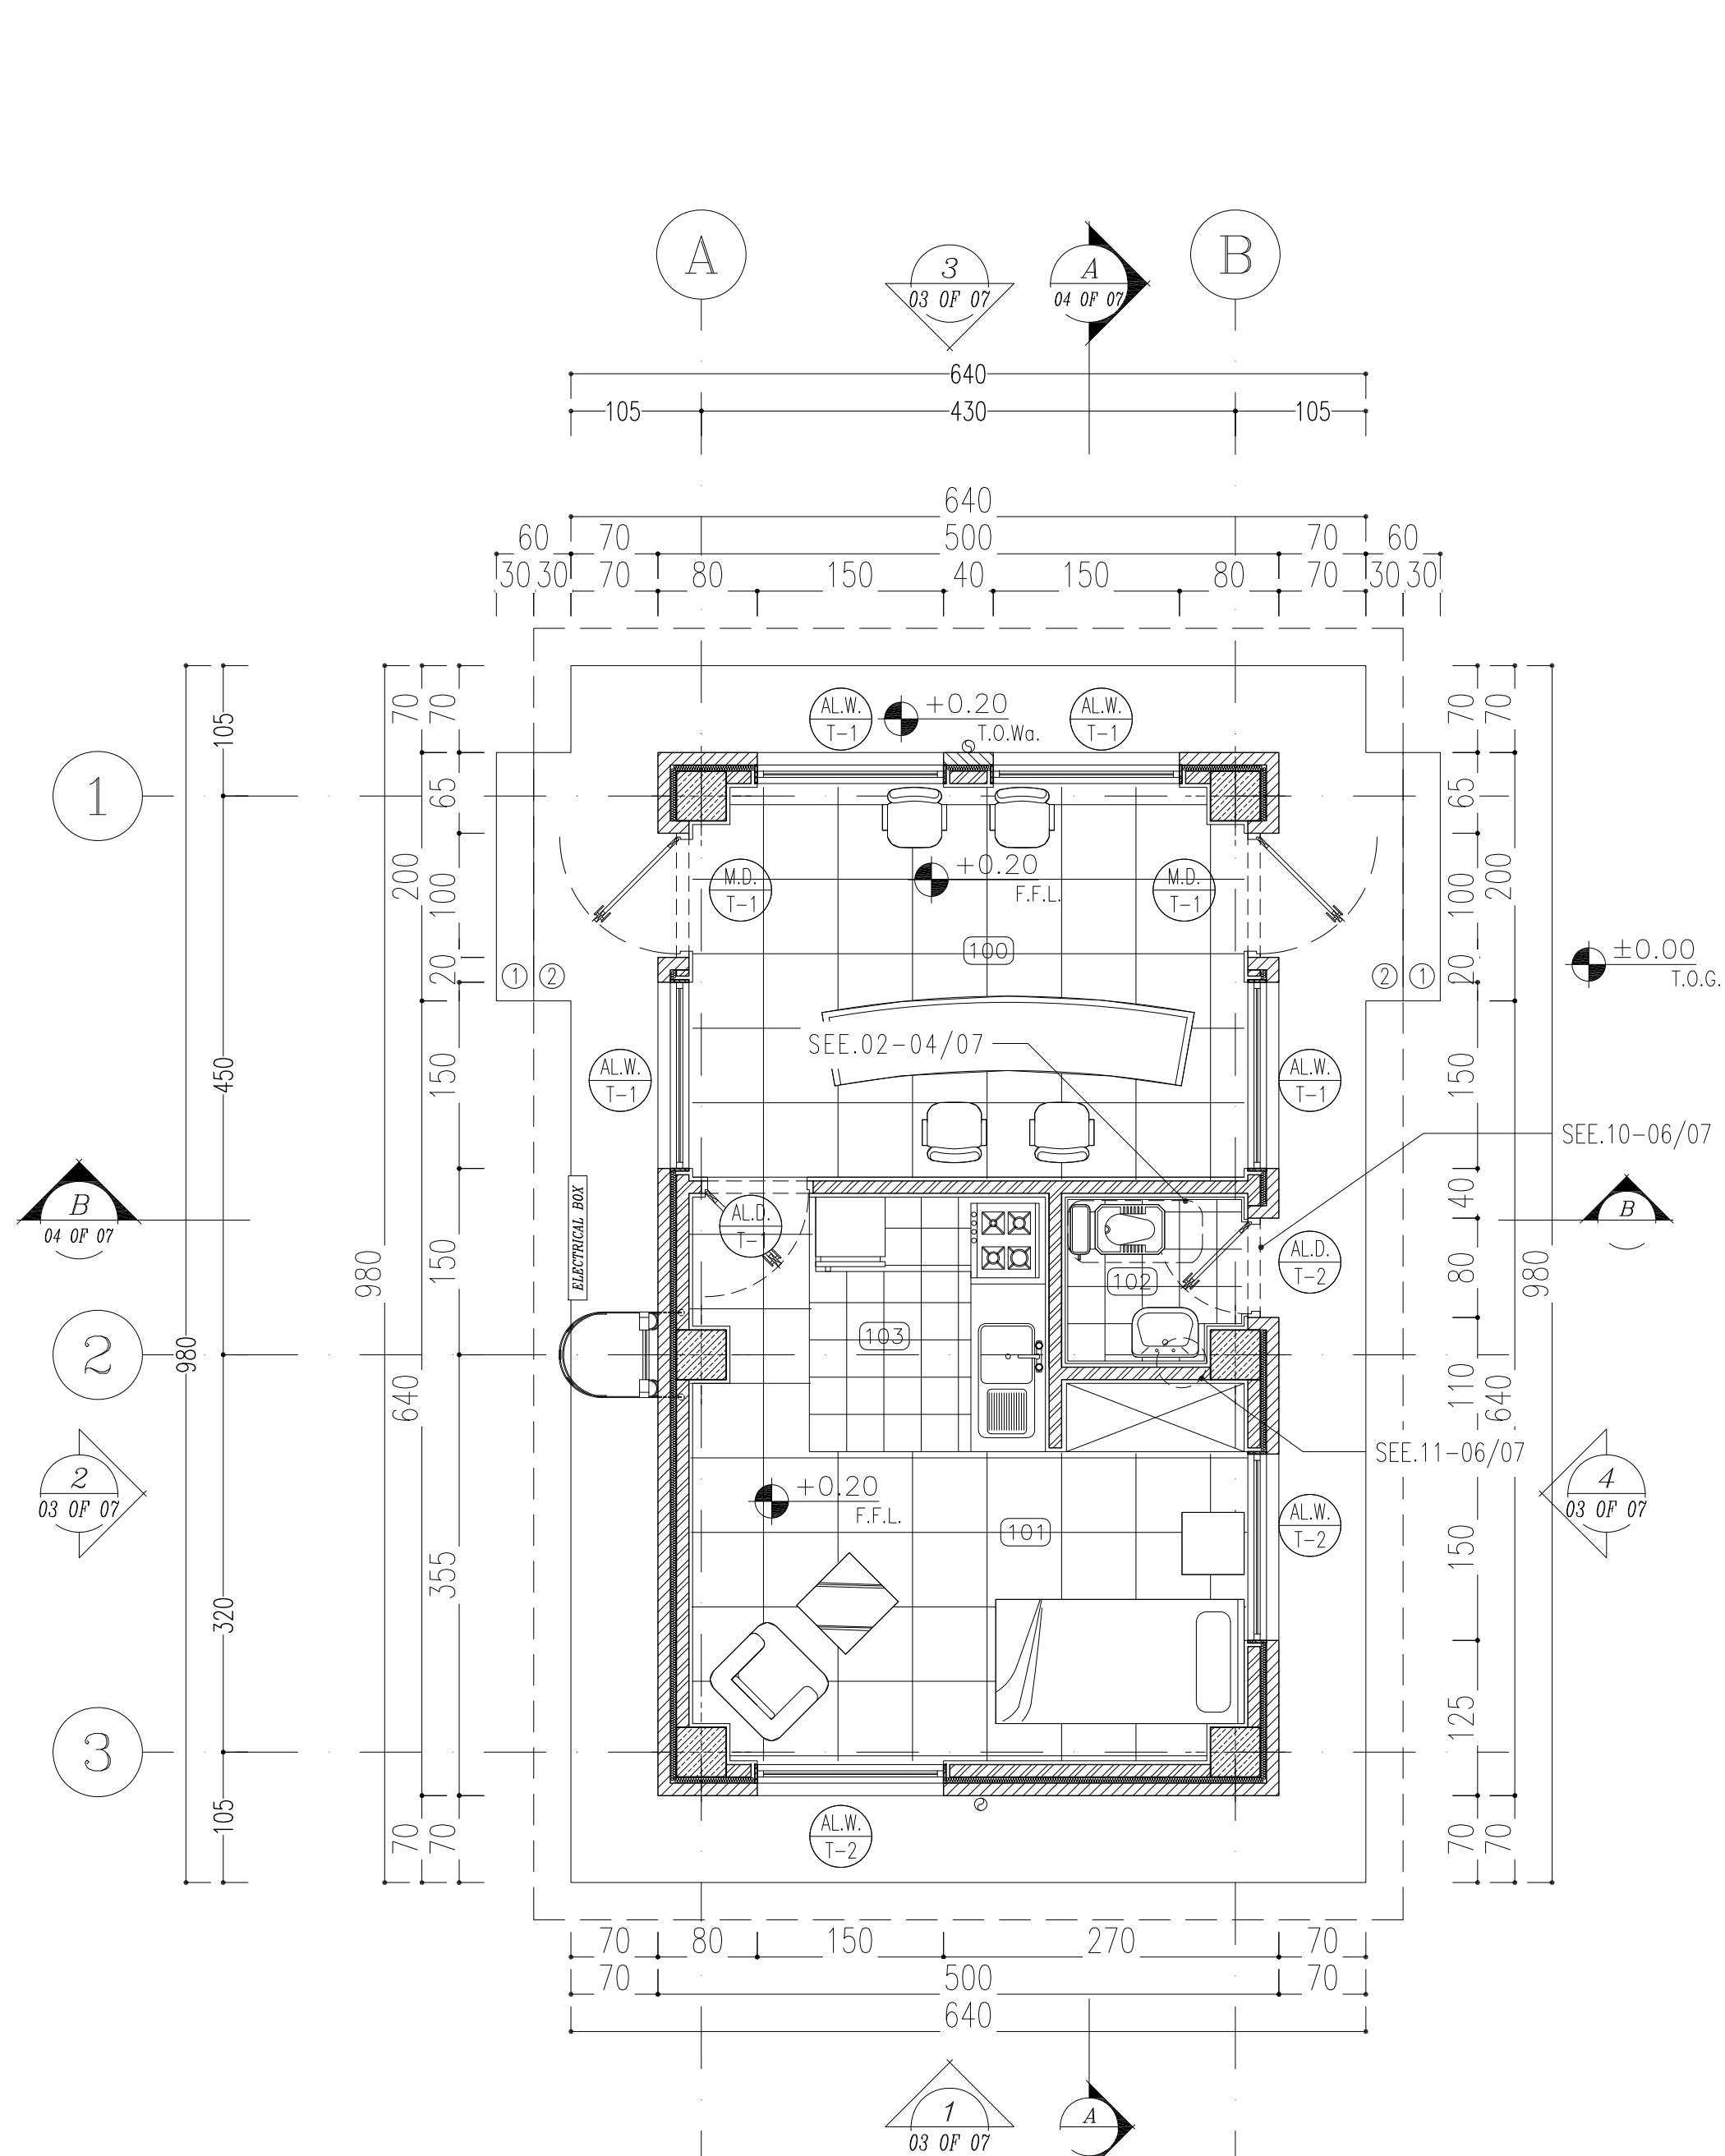


SC.1:50  FURNITURE & FLOORING PLAN

(100)&(101): 60x60cm GRANITE STONE
TILES ON SAND-CEMENT MORTAR
(101)&(102): 30x30cm ANTI-GLAZE
CERAMIC TILES ON SAND CEMENT MORTAR

NOTES	
1-	DIMENSIONS ARE IN "mm" AND ELEVATIONS IN "m" UNLESS SPECIFIED .
2-	ALL DIMENSIONS AND ELEVATIONS SHALL BE CHECKED BY THE CONTRACTOR PRIOR TO CONSTRUCTION.
3-	CONTRACTOR SHALL COMPARE ALL ARCHITECTURAL, MECHANICAL, ELECTRICAL, PIPING AND STRUCTURAL DRAWINGS AND IN CASE OF ANY CONFLICTS OR DISCREPANCY, INFORM THE ENGINEER.
4-	SLAB ON GRADE SHALL BE CONSTRUCTED AFTER EXECUTION OF CABLE TRENCH & EQUIPMENTS FOUNDATION.
5-	ALL MATERIALS ARE SELECTED FROM THE HIGHEST QUALITY AND SHALL BE APPROVED BY THE CLIENT.
6-	FOR COORDINATE REFER TO FINISH GRADING DOCUMENTS.
7)	REFERENCE COORDINATES E=1000.00m , N=1000.00m REFER TO X=435604 , Y=3294379 UTM.
8)	FINISH GRADING LEVEL (WD465) ELEVATION : +57m (Mean Sea Level) +57.05 m (GLOBAL) = ±0.00 (LOCAL)
LEGEND	
	BRICK FACING
	BRICK WORK
	REINFORCED CONCRETE
	LEAN CONCRETE
	BLOCKAGE
	GRAVEL
	FACADE GRANITE STONE
F.F.L.	FINISHED FLOOR LEVEL
T.O.G.	TOP OF GRAVEL
T.O.Wa.	TOP OF WALKWAY
T.O.P.	TOP OF PARAPET
T.O.Fou.	TOP OF FOUNDATION
T.O.D.	TOP OF DOOR
B.O.D.	BOTTOM OF DOOR
T.O.W.	TOP OF WINDOW
B.O.W.	BOTTOM OF WINDOW
T.O.R.	TOP OF ROOF
T.O.D.	TOP OF DOOR
T.O.Ca.	TOP OF CAGE
B.O.Ca.	BOTTOM OF CAGE



REFERENCE DRAWING	DRG. No
STANDARD DRAWING FOR ARCHITECTURAL DETAILS	BK-GNRAL-PEDCO-000-AR-DW-0001
STANDARD DETAILS FOR LADDER & SAFETY CAE	BK-GNRAI-PEDCO-000-ST-DW-0009
PLOT PLAN DRAWING - W046S	BK-W046S-PEDCO-110-PI-DW-0001
FOUNDATION DRAWING FOR SECURITY BUILDING FOR WELL PADS - W046S	BK-W046S-PEDCO-110-ST-DW-0004
STRUCTURAL DRAWING FOR SECURITY BUILDING FOR WELL PADS - W046S	BK-W046S-PEDCO-110-ST-DW-0005
HVAC SYSTEM LAYOUT FOR SECURITY BUILDING - W046S	BK-W046S-PEDCO-110-HV-PI-0002
PLUMBING & SEWAGE PIPING LAYOUT FOR SECURITY BUILDING - W046S	BK-W046S-PEDCO-110-HV-PI-0004
LIGHTING & SMALL POWER LAYOUT FOR SECURITY BUILDING - W046S	BK-SSGRU-PEDCO-110-EL-PI-0005

KEY PLAN

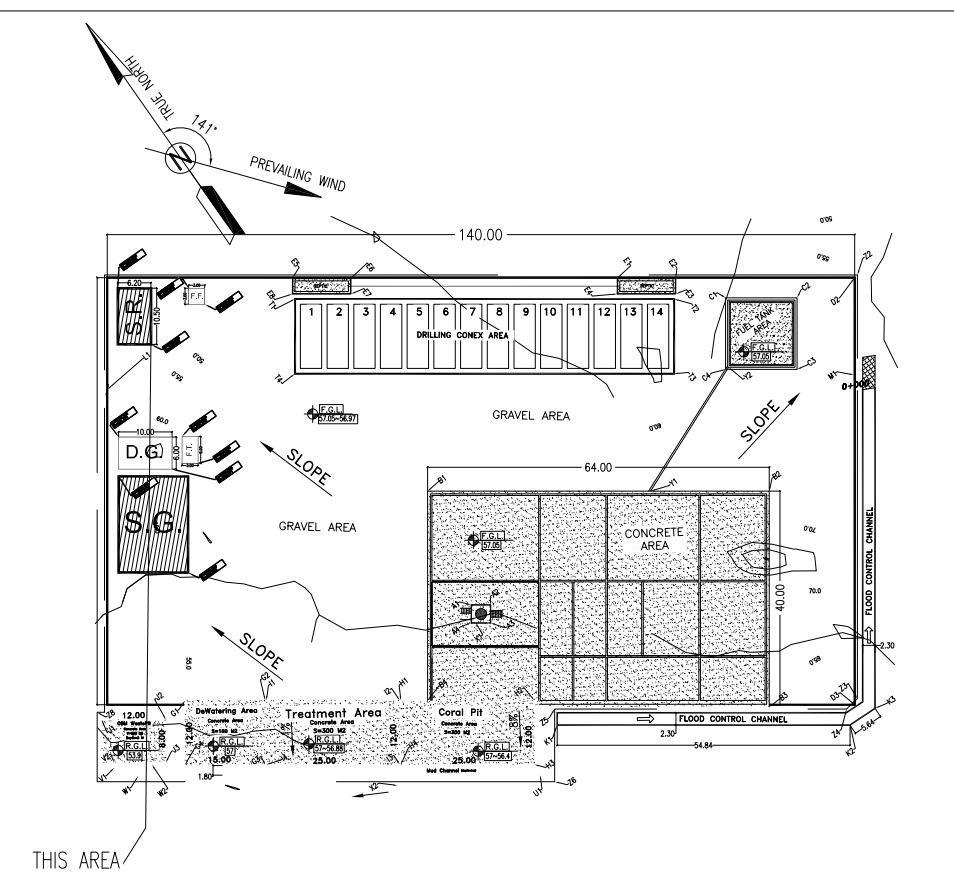
[illegible]

SPACE TAG NUMBER


- 100 SECURITY GUARD ROOM
101 RESTING AREA
102 WC
103 PANTRY

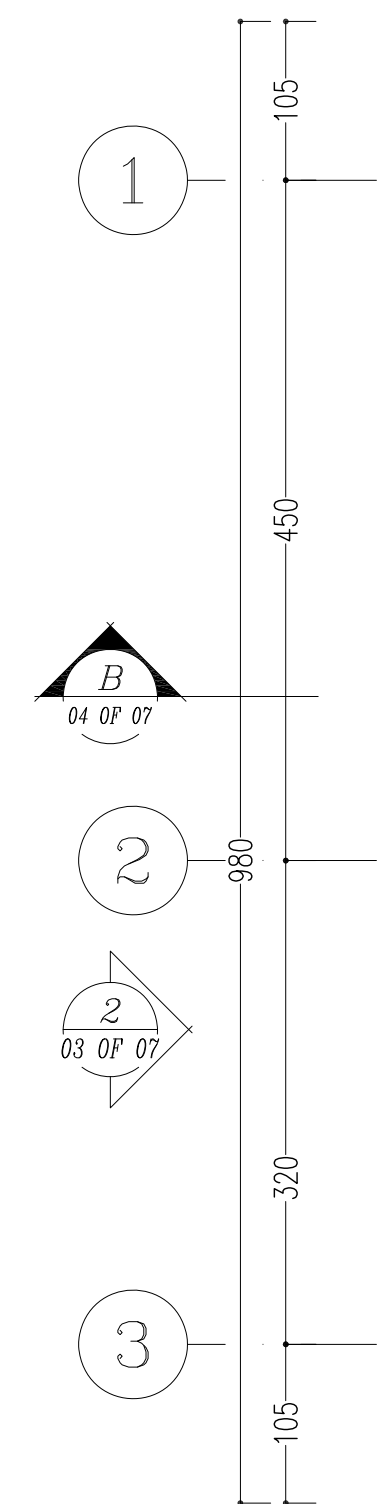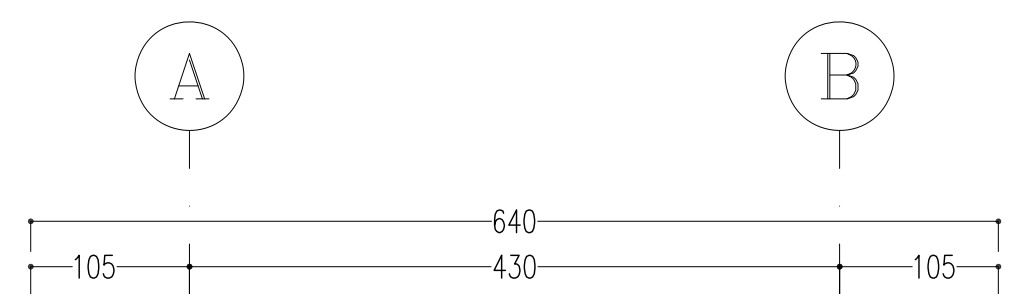


SC.1:50 4 SUSPENDED CEILING PLAN

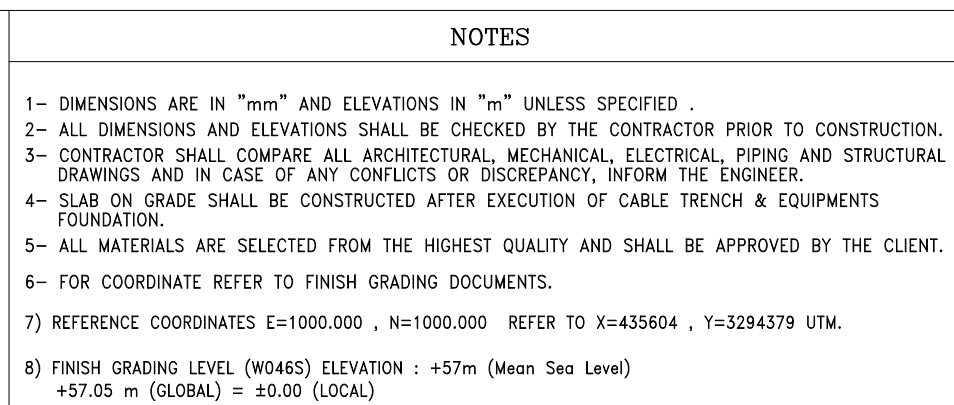

REFERENCE DRAWING	DRG. No.
STANDARD DRAWING FOR ARCHITECTURAL DETAILS	BK-GNRL-PEDCO-000-AR-DW-0000
STANDARD DETAILS FOR LADDER & SAFETY CAGE	BK-GNRL-PEDCO-000-ST-DW-0000
PLOT PLAN DRAWING - W046S	BK-W046S-PEDCO-110-PI-DW-0001
FOUNDATION DRAWING FOR SECURITY BUILDING FOR WELL PADS - W046S	BK-W046S-PEDCO-110-ST-DW-0004
STRUCTURAL DRAWING FOR SECURITY BUILDING FOR WELL PADS - W046S	BK-W046S-PEDCO-110-ST-DW-0005
HVAC SYSTEM LAYOUT FOR SECURITY BUILDING - W046S	BK-W046S-PEDCO-110-HV-PI-0001
PLUMBING & SEWAGE PIPING LAYOUT FOR SECURITY BUILDING - W046S	BK-W046S-PEDCO-110-HV-PI-0004
LIGHTING & SMALL POWER LAYOUT FOR SECURITY BUILDING OF WELL PADS	BK-SSGR-PEDCO-110-EL-PI-0005

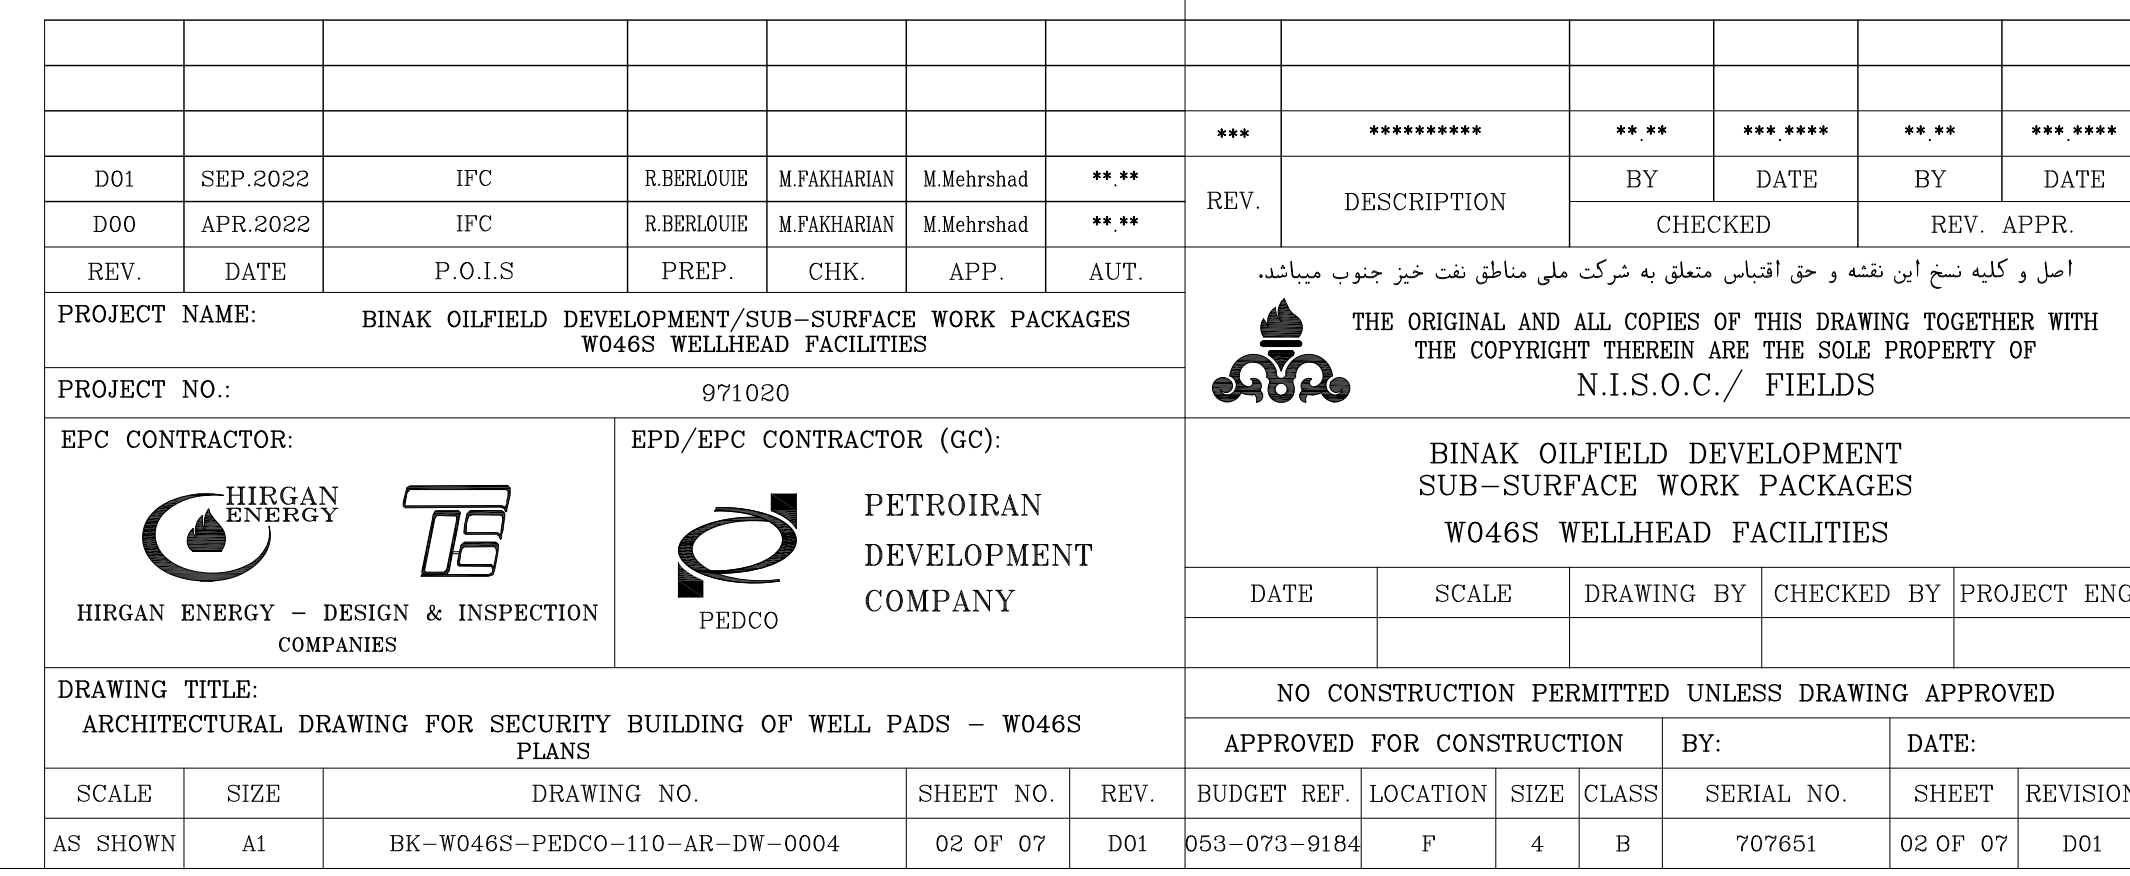

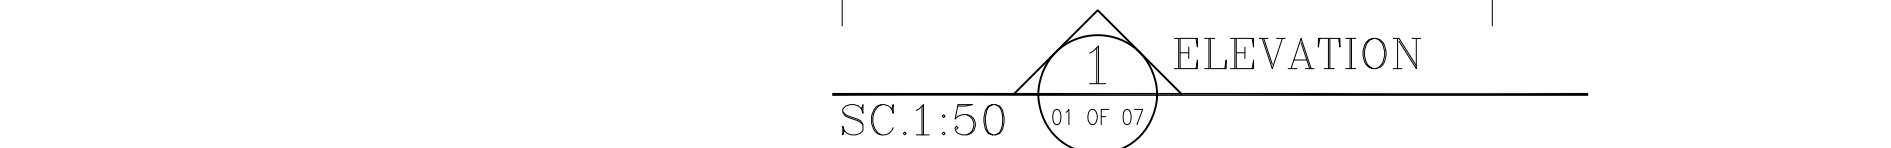



NOTES

- 1- DIMENSIONS ARE IN "mm" AND ELEVATIONS IN "m" UNLESS SPECIFIED .
- 2- ALL DIMENSIONS AND ELEVATIONS SHALL BE CHECKED BY THE CONTRACTOR PRIOR TO CONSTRUCTION.
- 3- CONTRACTOR SHALL COMPARE ALL ARCHITECTURAL, MECHANICAL, ELECTRICAL, PIPING AND STRUCTURAL DRAWINGS AND IN CASE OF ANY CONFLICTS OR DISCREPANCY, INFORM THE ENGINEER.
- 4- SLAB ON GRADE SHALL BE CONSTRUCTED AFTER EXECUTION OF CABLE TRENCH & EQUIPMENTS FOUNDATION.
- 5- ALL MATERIALS ARE SELECTED FROM THE HIGHEST QUALITY AND SHALL BE APPROVED BY THE CLIENT.
- 6- FOR COORDINATE REFER TO FINISH GRADING DOCUMENTS.
- 7) REFERENCE COORDINATES E=1000.000 , N=1000.000 REFER TO X=435604 , Y=3294379 UTM.
- 8) FINISH GRADING LEVEL (WD465) ELEVATION : +57m (Mean Sea Level)
+57.05 m (GLOBAL) = ±0.00 (LOCAL)

LEGEND	
	BRICK FACING
	BRICK WORK
	REINFORCED CONCRETE
	LEAN CONCRETE
	BLOCKAGE
	GRAVEL
	FACADE GRANITE STONE
F.F.L.	FINISHED FLOOR LEVEL
T.O.G.	TOP OF GRAVEL
T.O.Wa.	TOP OF WALKWAY
T.O.P.	TOP OF PARAPET
T.O.Fou.	TOP OF FOUNDATION
T.O.D.	TOP OF DOOR
B.O.D.	BOTTOM OF DOOR
T.O.W.	TOP OF WINDOW
B.O.W.	BOTTOM OF WINDOW
T.O.R.	TOP OF ROOF
T.O.D.	TOP OF DOOR
T.O.Ca.	TOP OF CAGE
B.O.Ca.	BOTTOM OF CAGE

REFERENCE DRAWING	DRG. No.
STANDARD DRAWING FOR ARCHITECTURAL DETAILS	BK-GNAR-PEDCO-000-AR-DW-0001
STANDARD DETAILS FOR LADDER & SAFETY CAGE	BK-GNAR-PEDCO-000-ST-DW-0009
PLOT PLAN DRAWING - W046S	BK-W046S-PEDCO-110-PI-DW-0001
FOUNDATION DRAWING FOR SECURITY BUILDING FOR WELL PADS - W046S	BK-W046S-PEDCO-110-ST-DW-0004
STRUCTURAL DRAWING FOR SECURITY BUILDING FOR WELL PADS - W046S	BK-W046S-PEDCO-110-ST-DW-0005
HVAC SYSTEM LAYOUT FOR SECURITY BUILDING - W046S	BK-W046S-PEDCO-110-HV-PI-0002
PLUMBING & SEWAGE PIPING LAYOUT FOR SECURITY BUILDING - W046S	BK-W046S-PEDCO-110-HV-PI-0005
LIGHTING & SMALL POWER LAYOUT FOR SECURITY BUILDING - W046S	BK-SBSRL-PEDCO-110-EL-PI-0004

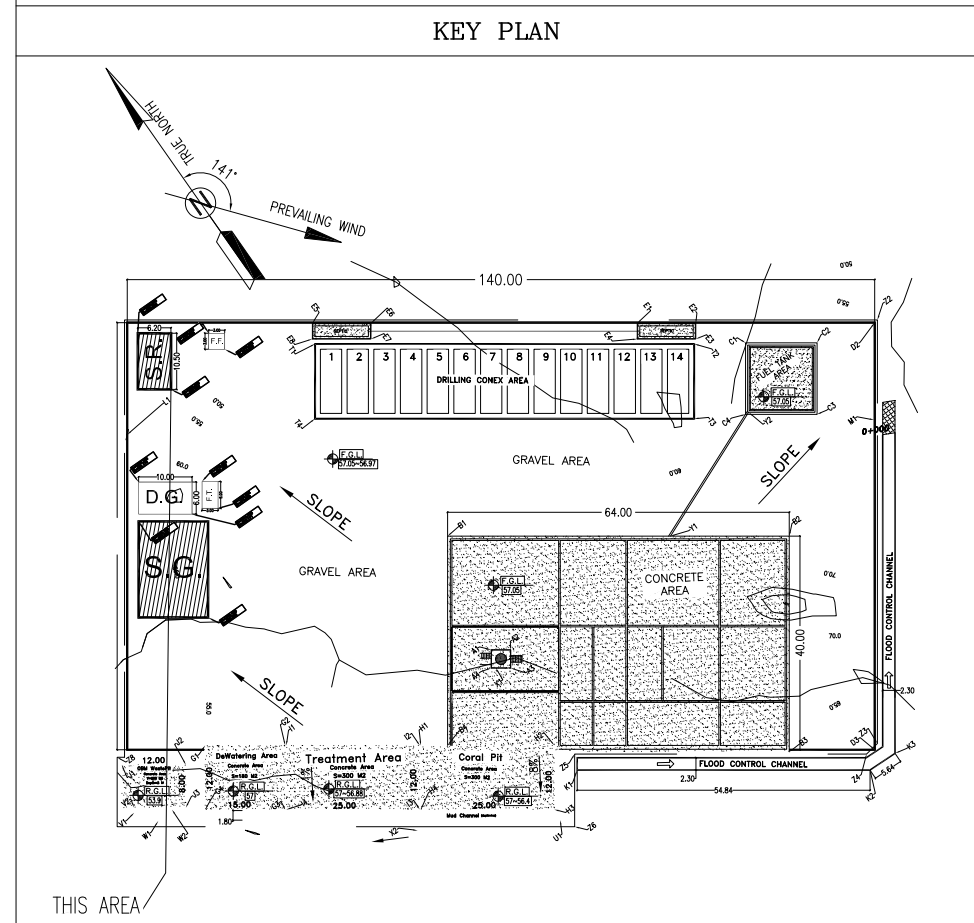[illegible]



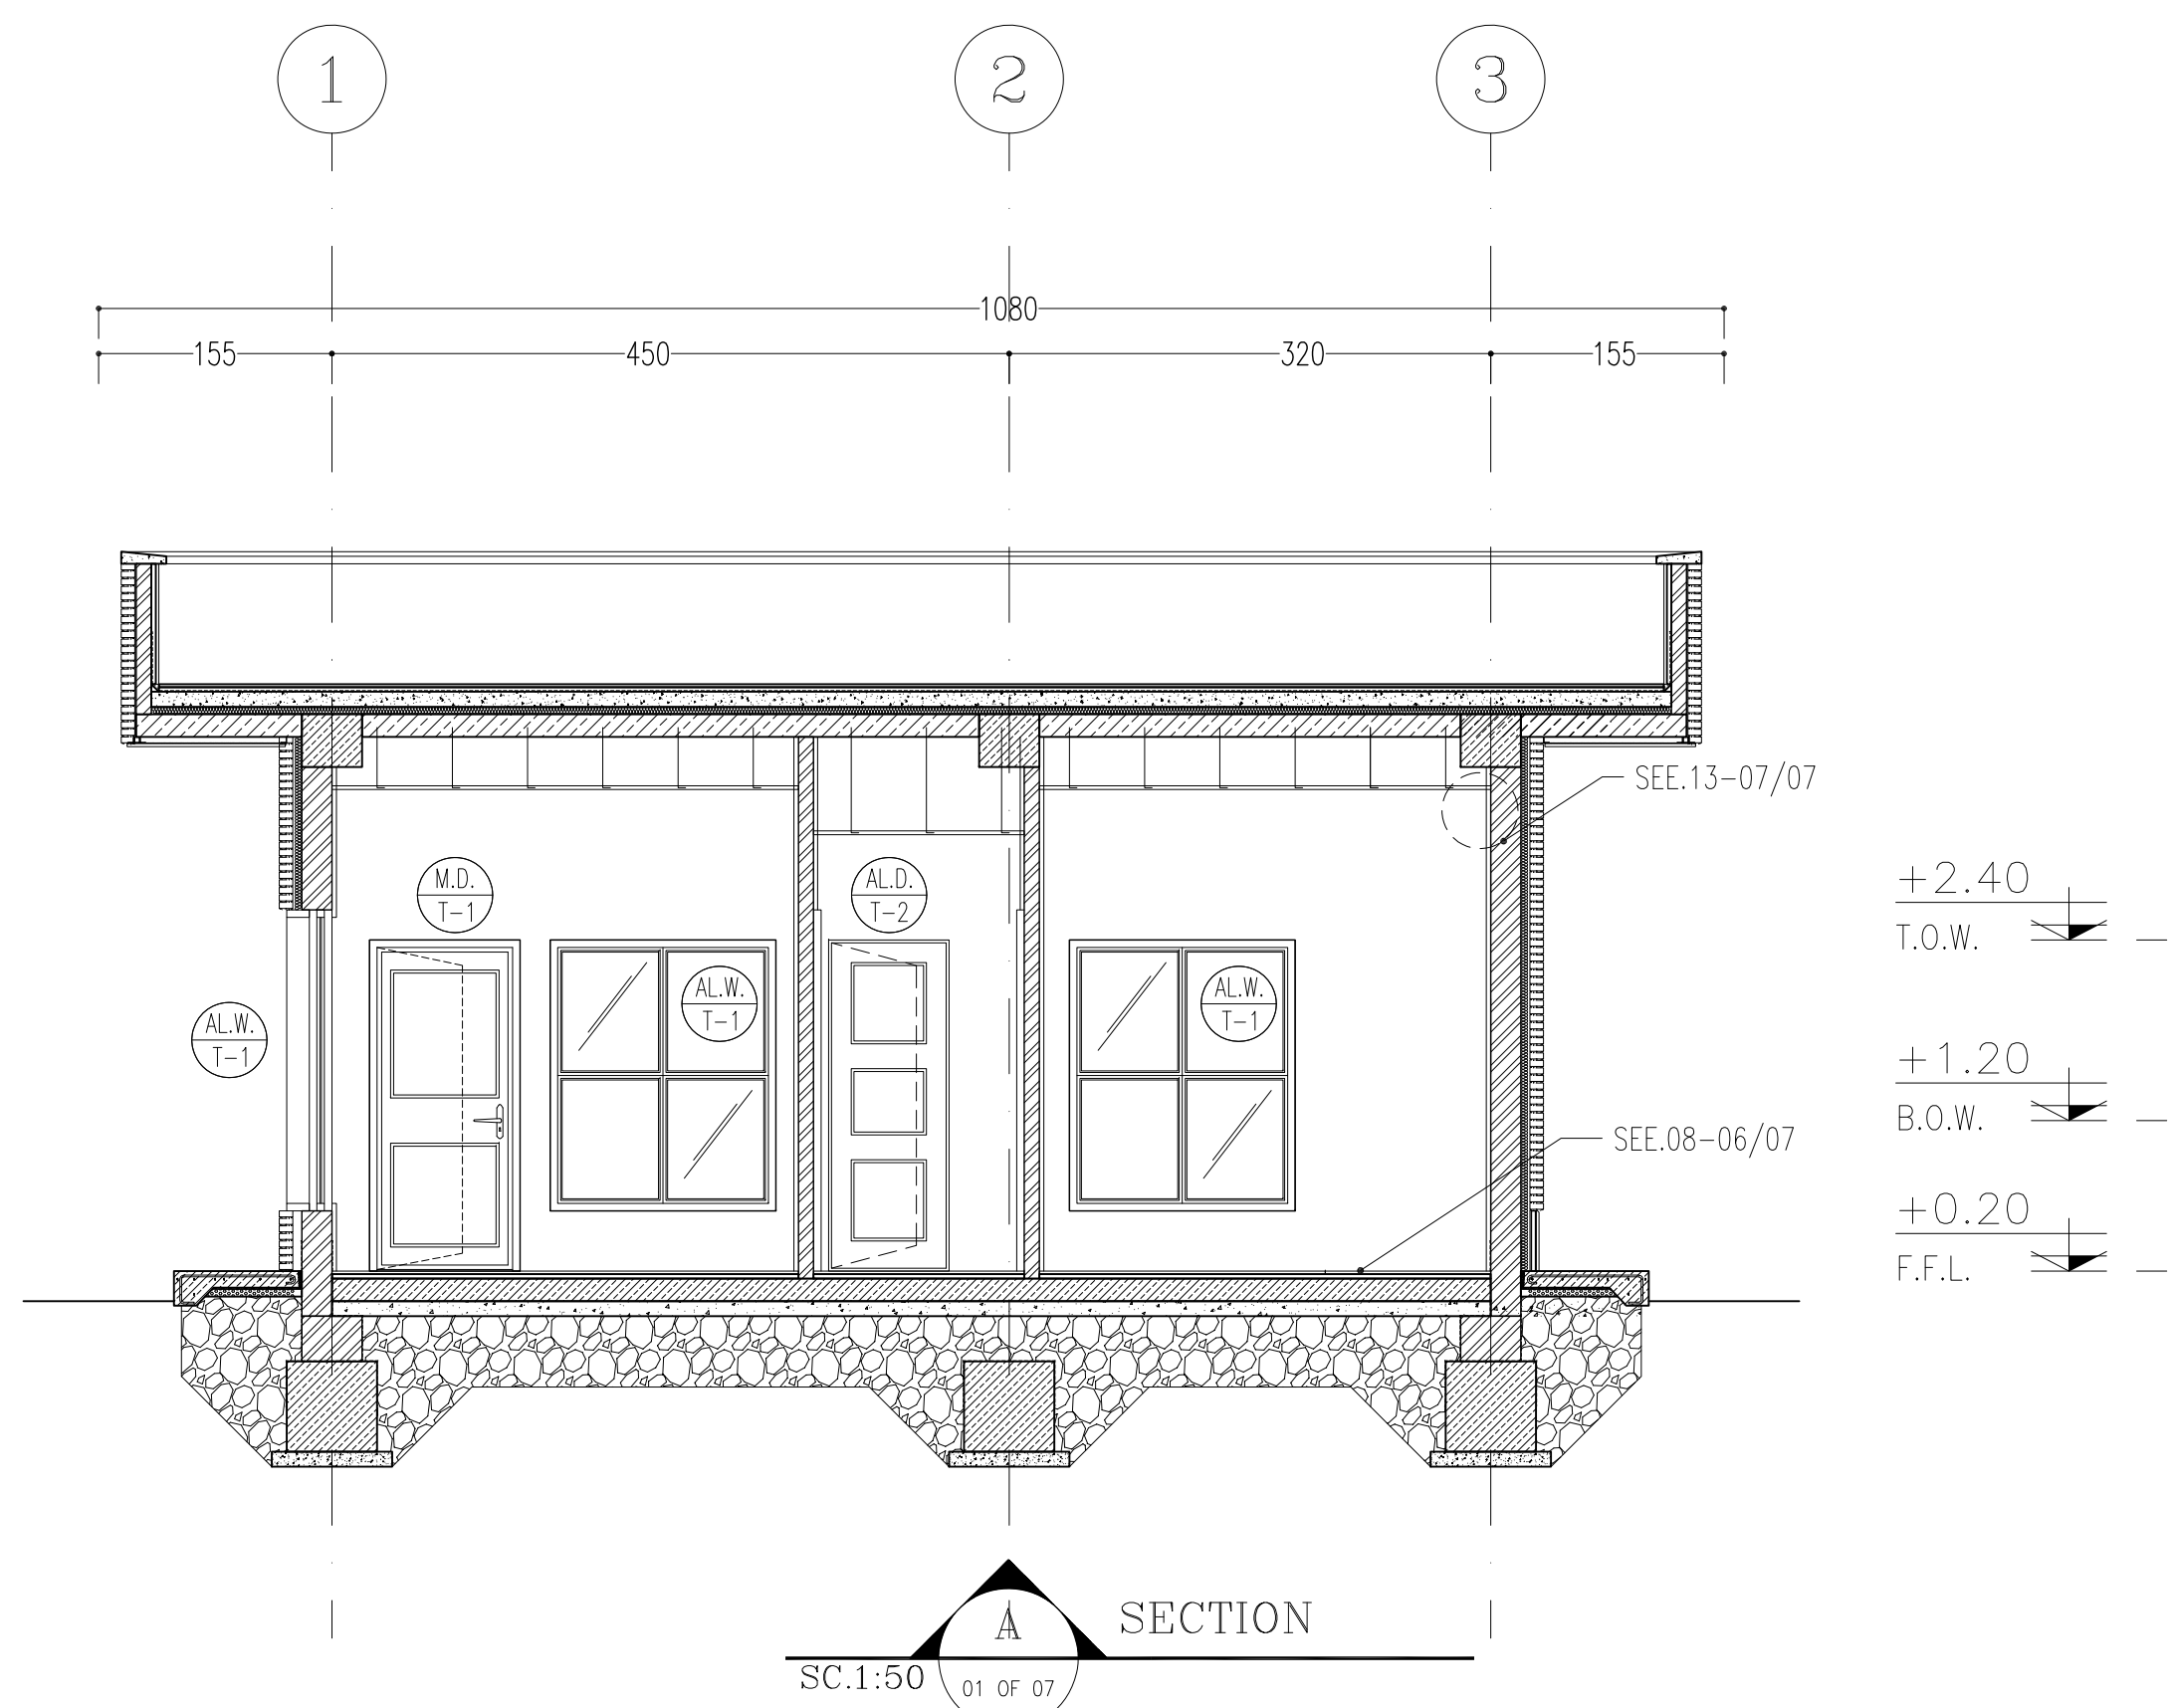


NOTES

- 1- DIMENSIONS ARE IN "mm" AND ELEVATIONS IN "m" UNLESS SPECIFIED .
- 2- ALL DIMENSIONS AND ELEVATIONS SHALL BE CHECKED BY THE CONTRACTOR PRIOR TO CONSTRUCTION.
- 3- CONTRACTOR SHALL COMPARE ALL ARCHITECTURAL, MECHANICAL, ELECTRICAL, PIPING AND STRUCTURAL DRAWINGS AND IN CASE OF ANY CONFLICTS OR DISCREPANCY, INFORM THE ENGINEER.
- 4- SLAB ON GRADE SHALL BE CONSTRUCTED AFTER EXECUTION OF CABLE TRACING & EQUIPMENTS FOUNDATION.
- 5- ALL MATERIALS ARE SELECTED FROM THE HIGHEST QUALITY AND SHALL BE APPROVED BY THE CLIENT.
- 6- FOR COORDINATE REFER TO FINISH GRADING DRAWINGS.
- 7- REFERENCE COORDINATES E=1000,000 , N=1000,000 REFER TO X=435604 , Y=3294379 UTM.
- 8) FINISH GRADING LEVEL (WD465) ELEVATION : +57m (Mean Sea Level)
+57.05 m (GLOBAL) = ±0.00 (LOCAL)

	BRICK FACING
	BRICK WORK
	REINFORCED CONCRETE
	LEAN CONCRETE
	BLOCKAGE
	GRAVEL
	FACADE GRANITE STONE
F.F.L.	FINISHED FLOOR LEVEL
T.O.G.	TOP OF GRAVEL
T.O.Wa.	TOP OF WALKWAY
T.O.P.	TOP OF PARAPET
T.O.Fou.	TOP OF FOUNDATION
T.O.D.	TOP OF DOOR
B.O.D.	BOTTOM OF DOOR
T.O.W.	TOP OF WINDOW
B.O.W.	BOTTOM OF WINDOW
T.O.R.	TOP OF ROOF
T.O.D.	TOP OF DOOR
T.O.Ca.	TOP OF CAGE
B.O.Ca.	BOTTOM OF CAGE

REFERENCE DRAWING	DRG. No.
STANDARD DRAWING FOR ARCHITECTURAL DETAILS	BK-GNRL-PEDCO-000-AR-DW-0001
STANDARD DETAILS FOR LADDER & SAFETY CAGE	BK-GNRL-PEDCO-000-ST-DW-0009
PLOT PLAN DRAWING – W046S	BK-W046S-PEDCO-110-PI-DW-0001
FOUNDATION DRAWING FOR SECURITY BUILDING FOR WELL PADS – W046S	BK-W046S-PEDCO-110-ST-DW-0004
STRUCTURAL DRAWING FOR SECURITY BUILDING FOR WELL PADS – W046S	BK-W046S-PEDCO-110-ST-DW-0005
HVAC SYSTEM LAYOUT FOR SECURITY BUILDING – W046S	BK-W046S-PEDCO-110-HV-PI-0002
PLUMBING & SEWAGE PIPING LAYOUT FOR SECURITY BUILDING – W046S	BK-W046S-PEDCO-110-HV-PI-0004
LIGHTING & SMALL POWER LAYOUT FOR SECURITY BUILDING – WELL PADS	BK-SSGR-PEDCO-110-EL-PI-0005

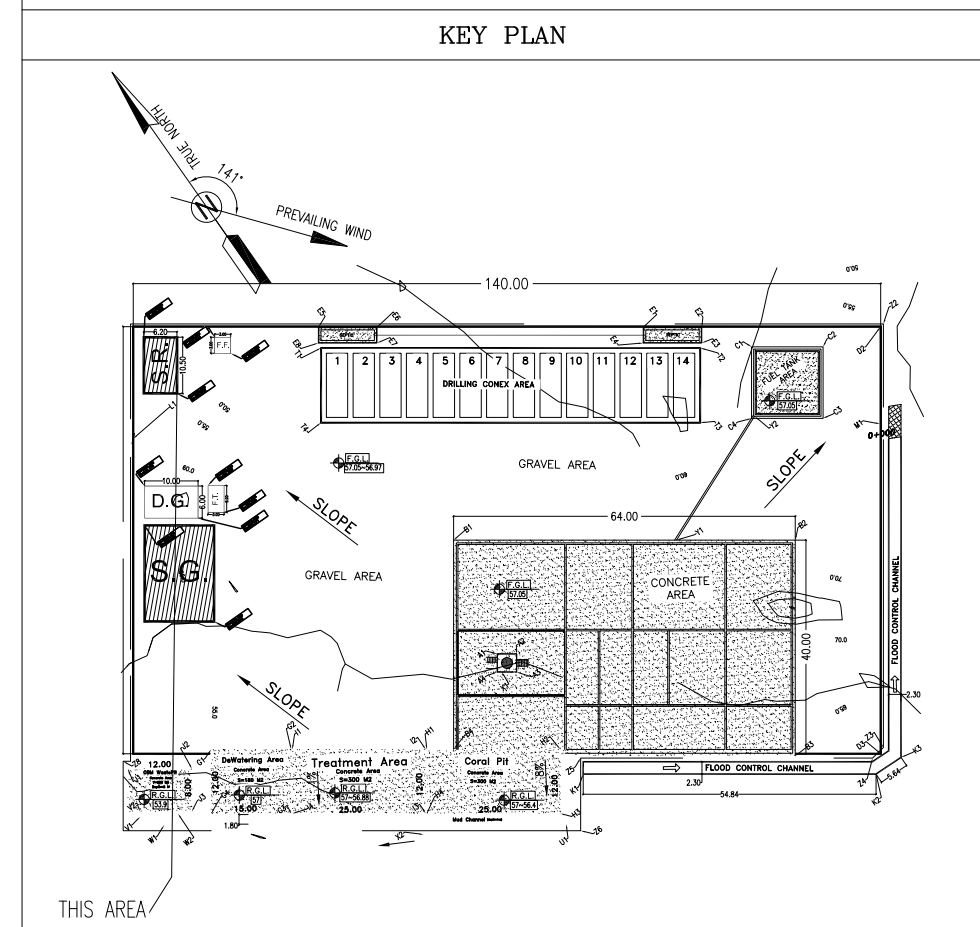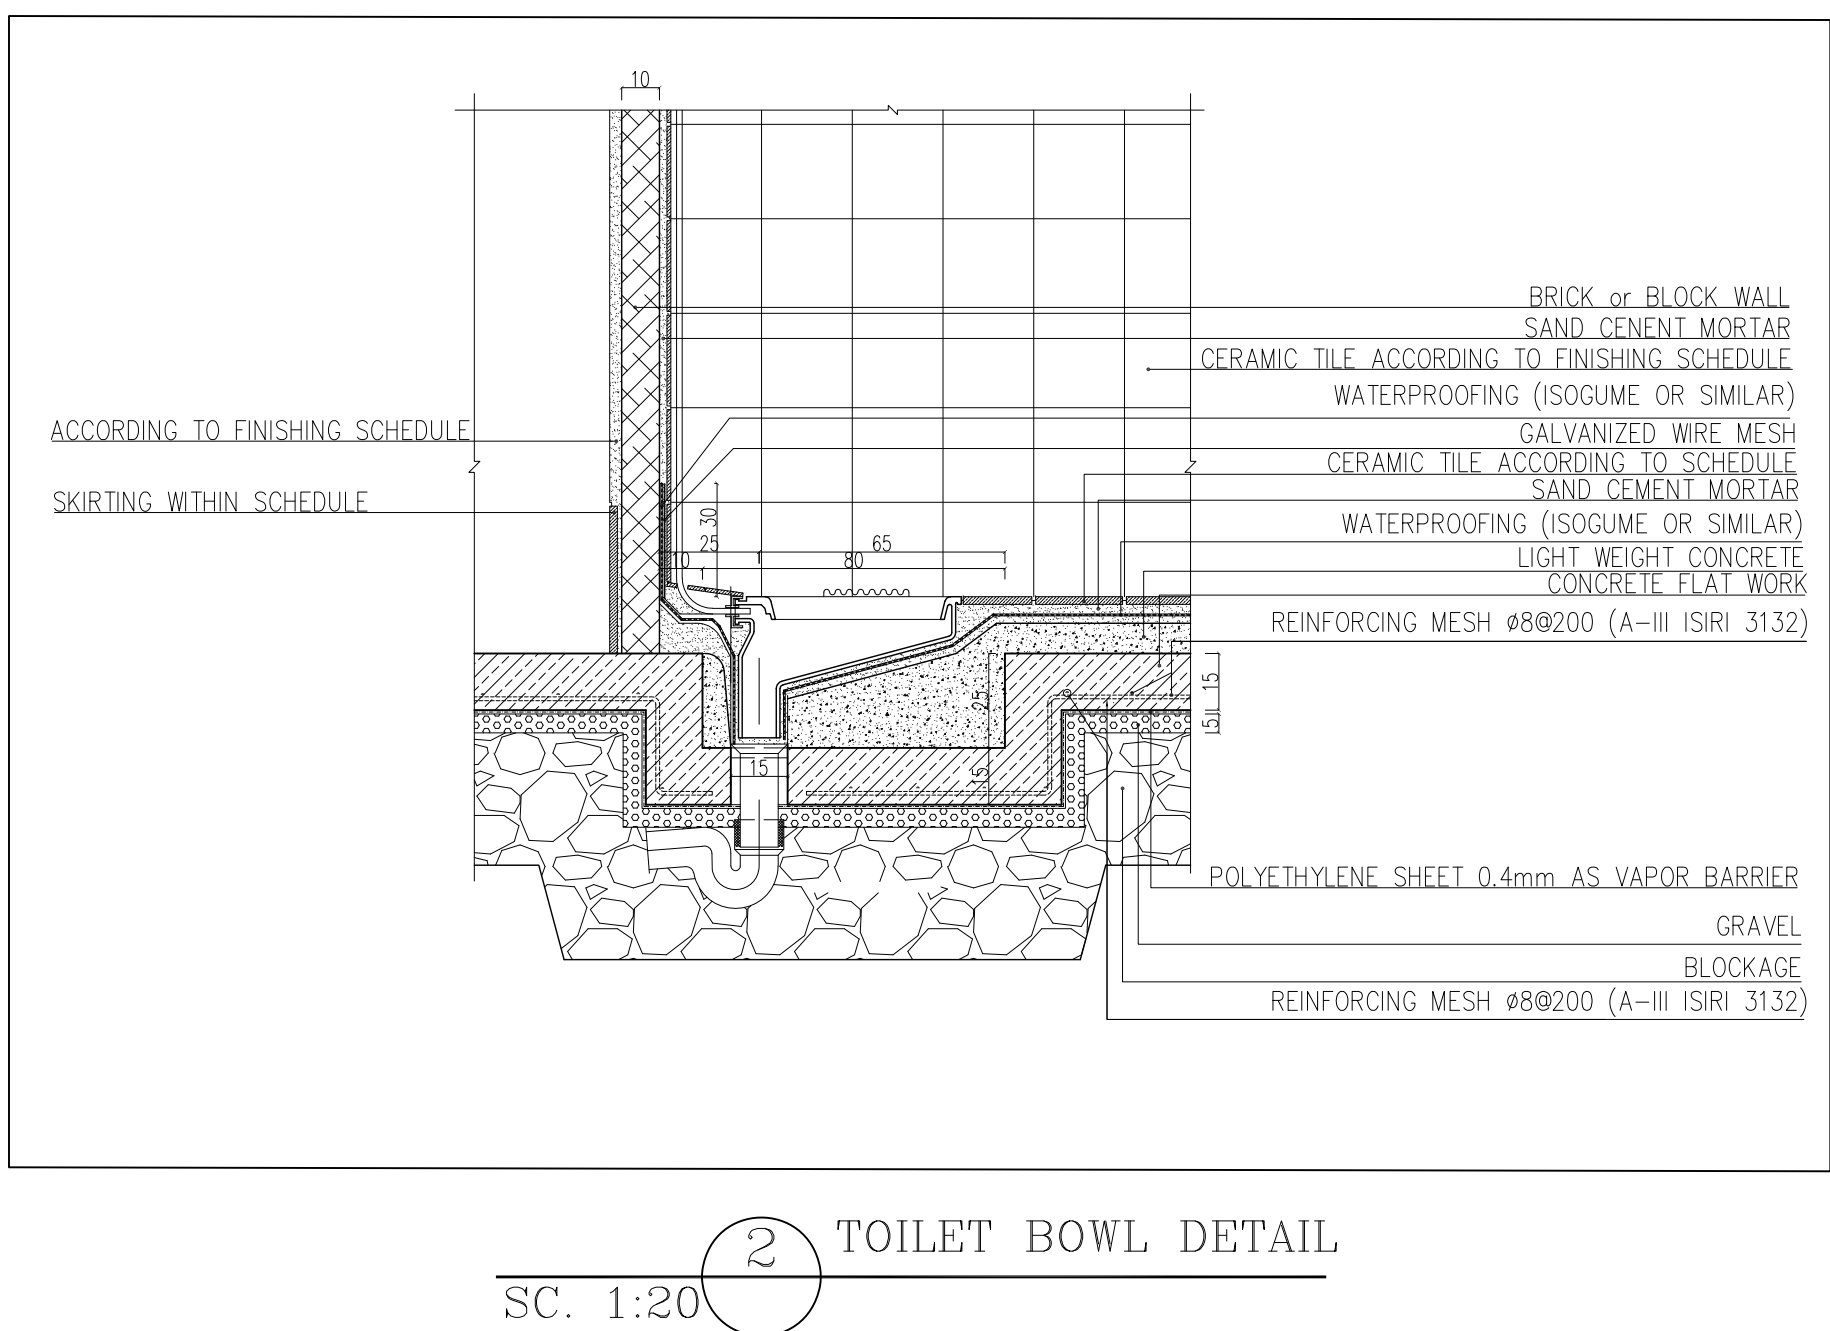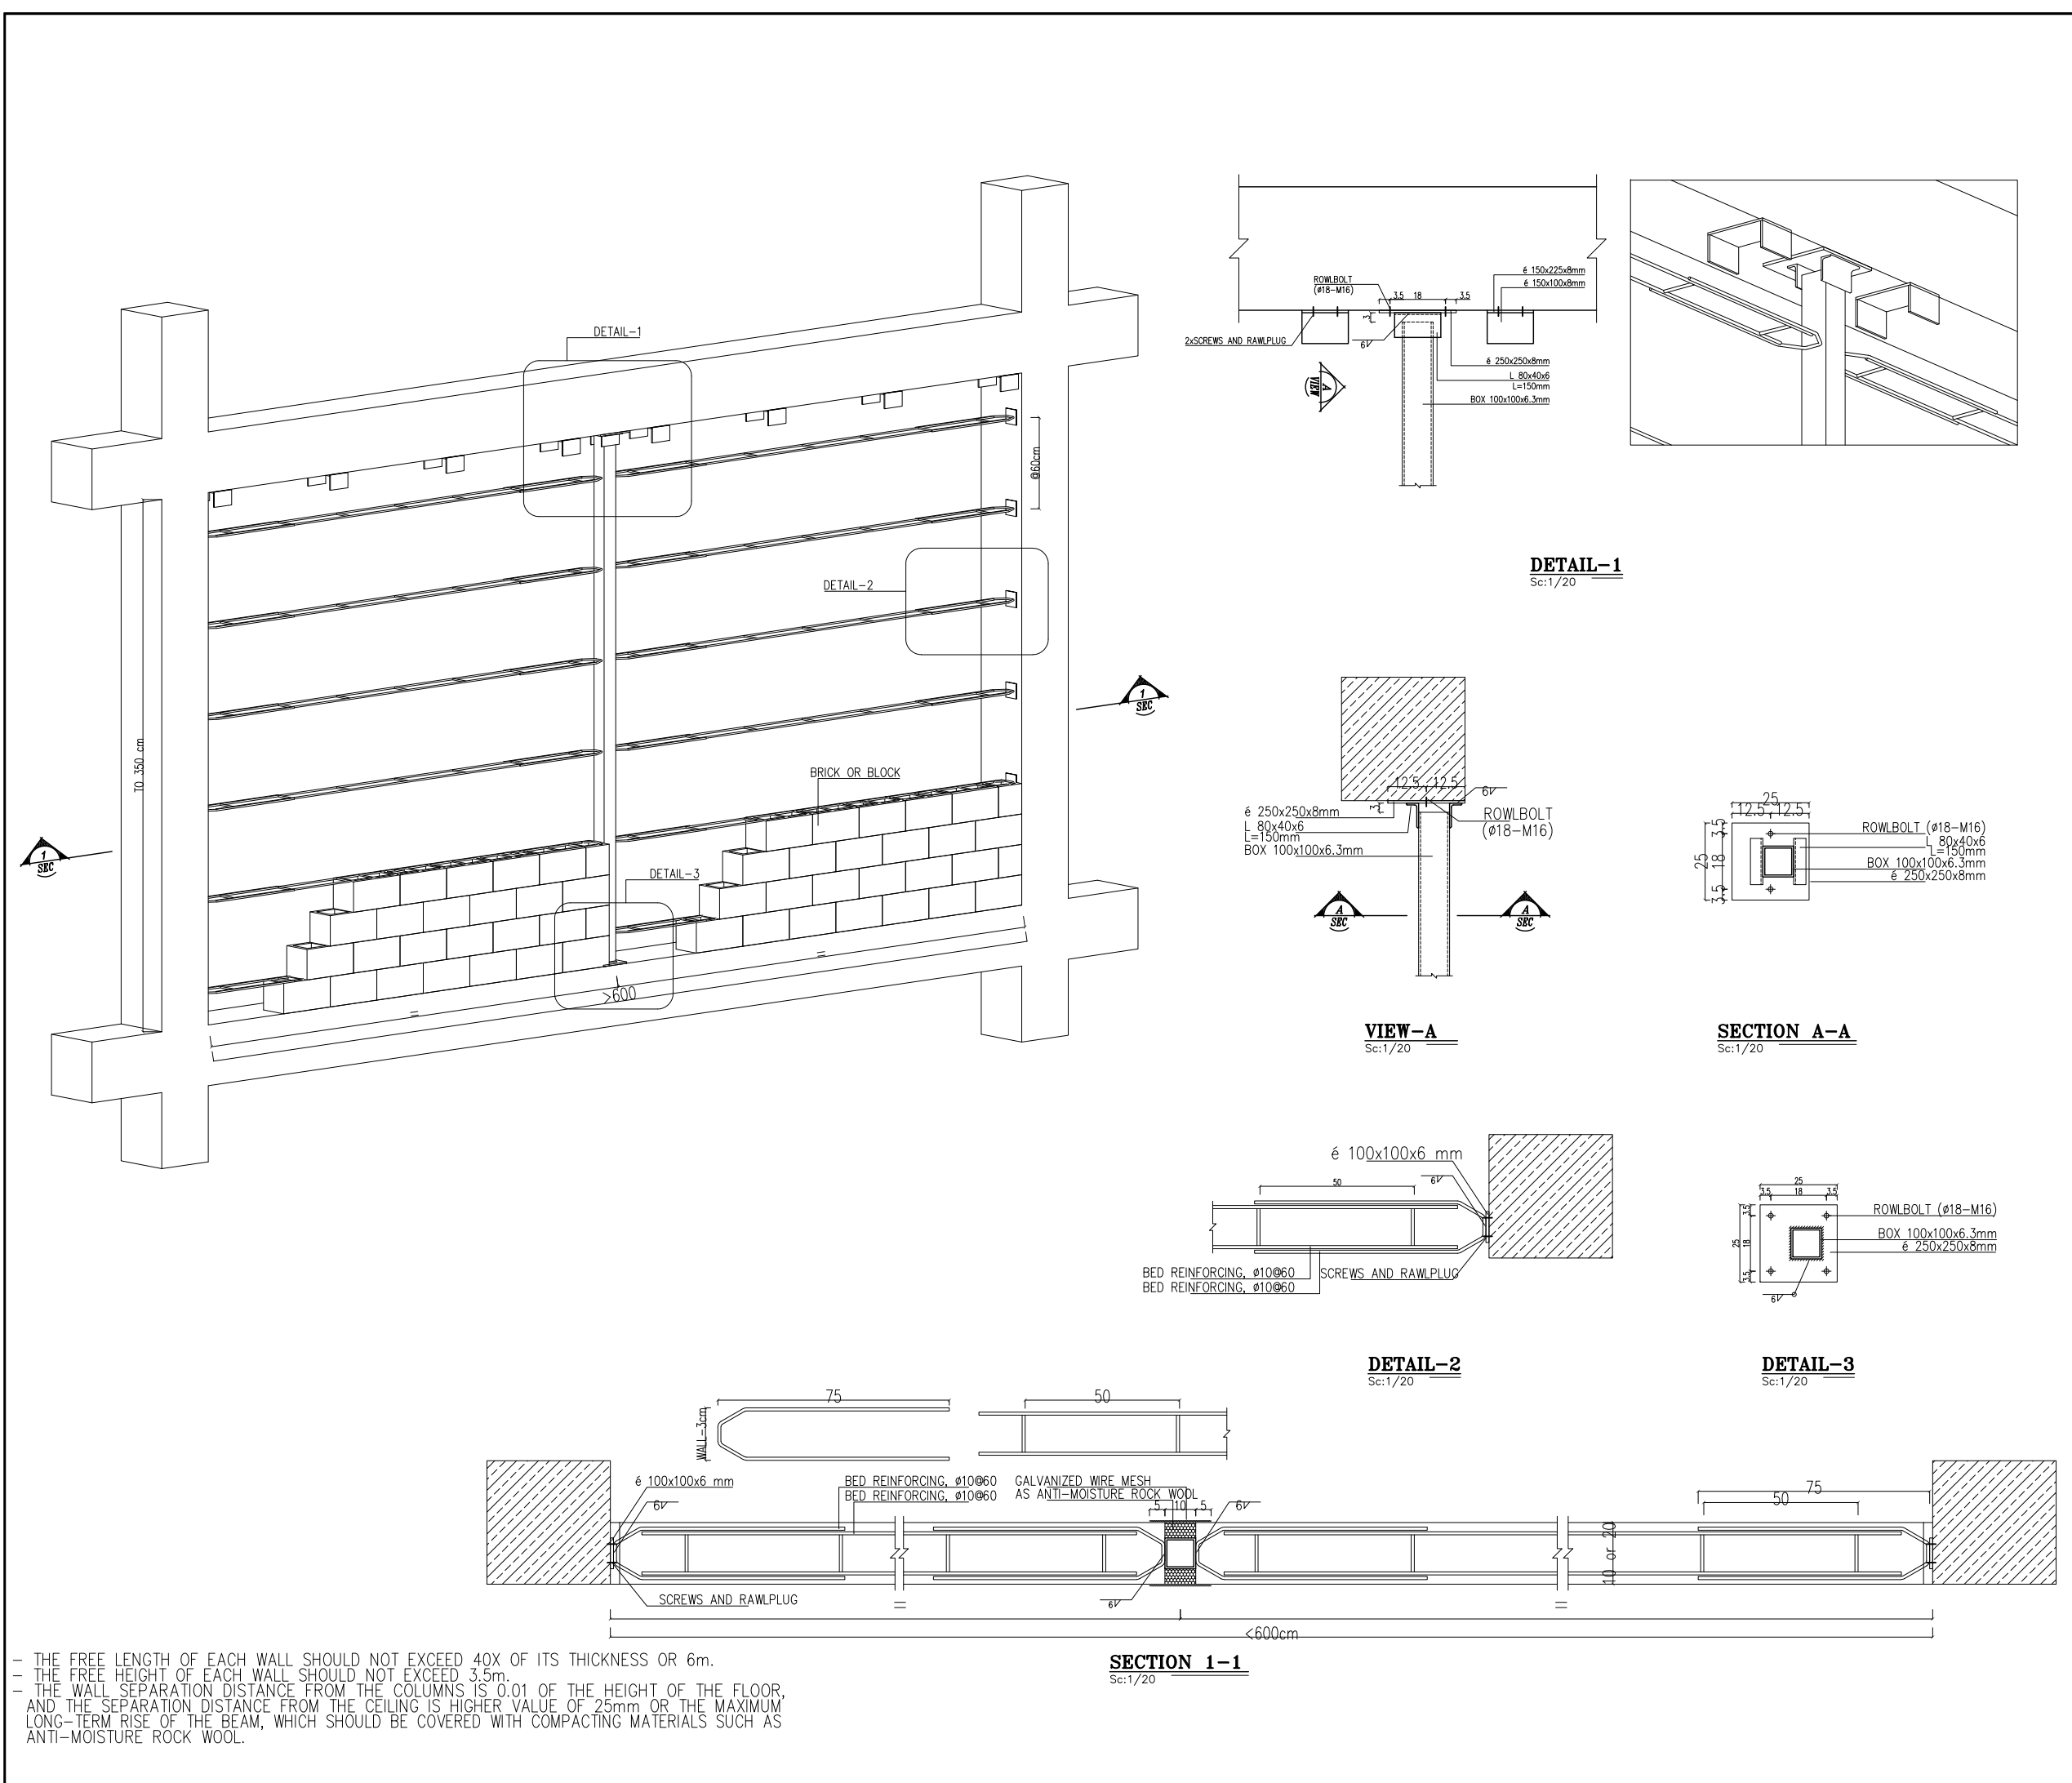[illegible]

FLOOR	SKIRTING	WALL	CEILING
-------	----------	------	---------

SPACE TAG NUMBER

SANITATION : FINE GRADE CHINA FIXTURES – FOR PIPE DETAIL REFER TO PLUMBING AND SEWAGE PIPING LAYOUT

1x DISHWASHING SINK SINGLE-BOWL - HIGHEST GRADE STAINLESS STEEL

TRANSPARENT AREAS: DOUBLE GLAZED WINDOWS – FOR DETAIL REFER TO WINDOW SCHEDULE

SECURITY GUARD ROOM : 4x FULL HEIGHT, DOUBLE OPENING 180cm*150cm WINDOWS

RESTING AREA : 2x NORMAL SIZE, LEFT OPENING 120cm*150cm WINDOWS

4) DOORS AND WINDOWS TYPES



No. : 2

AL.W.
T-1

No. : 4

AL.D.
T-2

No. : 1

RH. : 1

AL.D.
T-1

No. : 1

RH. : 1


M.D.
T-1

No. : 2

RH. : 1

AL.W. - T.1	ALUMINUM WINDOW - 150cm (W) * 120cm (H)
AL.W. - T.2	ALUMINUM WINDOW - 150cm (W) * 180cm (H)

GLASS TYPE: DOUBLE-GLAZED (2*4mm + 16mm gap)

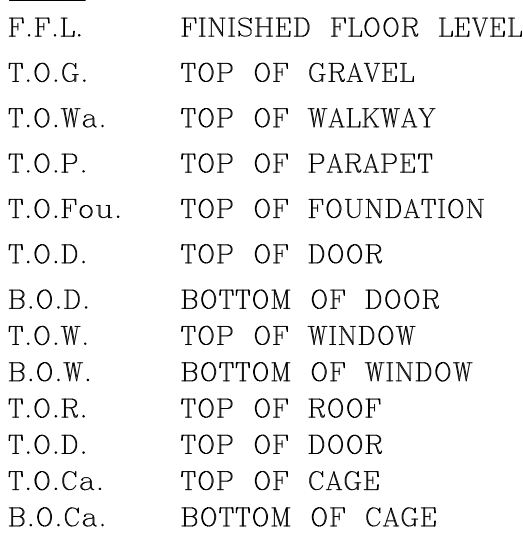

STANDARD DRAWING FOR ARCHITECTURAL DETAILS	BK-CNRAL-PEDCO-000-AR-DW-0001
STANDARD DETAILS FOR LADDER & SAFETY CAE	BK-CNRAL-PEDCO-000-ST-DW-0009
PLOT PLAN DRAWING - W0468	BK-W0468-PEDCO-110-PI-DW-0001
FOUNDATION DRAWING FOR SECURITY BUILDING FOR WELL PADS W0465	BK-W0468-PEDCO-110-ST-DW-0004
STRUCTURAL DRAWING FOR SECURITY BUILDING FOR W0465	BK-W0468-PEDCO-110-ST-DW-0005
HVAC SYSTEM LAYOUT FOR SECURITY BUILDING - W0468	BK-W0468-PEDCO-110-HV-PI-0002
PLUMBING & SWAGE PIPING LAYOUT FOR SECURITY BUILDING W0465	BK-W0468-PEDCO-110-HV-PI-0004
LIGHTING & SMALL POWER LAYOUT FOR SECURITY BUILDING W0465	BK-SSGR-PEDCO-110-EL-PI-0005

KEY PLAN



اصل و کلیه نسخ این نقشه و حق اقتباس متعلق به شرکت ملی مناطق نفت خیز جنوب میباشد.


THE ORIGINAL AND ALL COPIES OF THIS DRAWING TOGETHER WITH
THE COPYRIGHT THEREIN ARE THE SOLE PROPERTY OF
N.I.S.O.C./ FIELDS


BINAK OILFIELD DEVELOPMENT
SUB-SURFACE WORK PACKAGES
W046S WELLHEAD FACILITIES

NO CONSTRUCTION PERMITTED UNLESS DRAWING APPROVED

ARCHITECTURAL DRAWING FOR SCHEDULE FINISHING OF WELL PADS - W046S						APPROVED FOR CONSTRUCTION			BY:	DATE:			
SCALE	SIZE	DRAWING NO.			SHEET NO.	REV.	BUDGET REF.	LOCATION	SIZE	CLASS	SERIAL NO.	SHEET	REVISION
AS SHOWN	A1	BK-W046S-PEDCO-110-AR-DW-0004			05 OF 07	D01	053-073-9184	F	4	B	707651	05 OF 07	D01

[illegible]

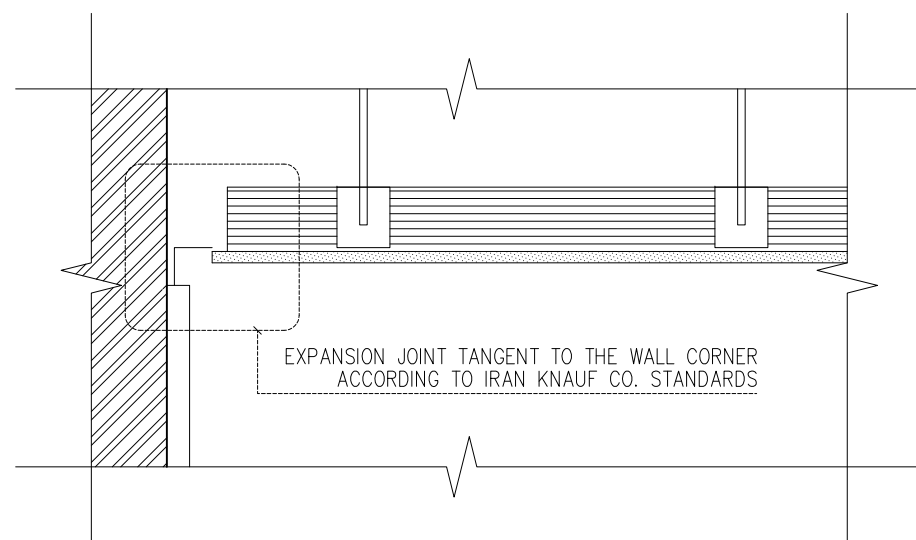

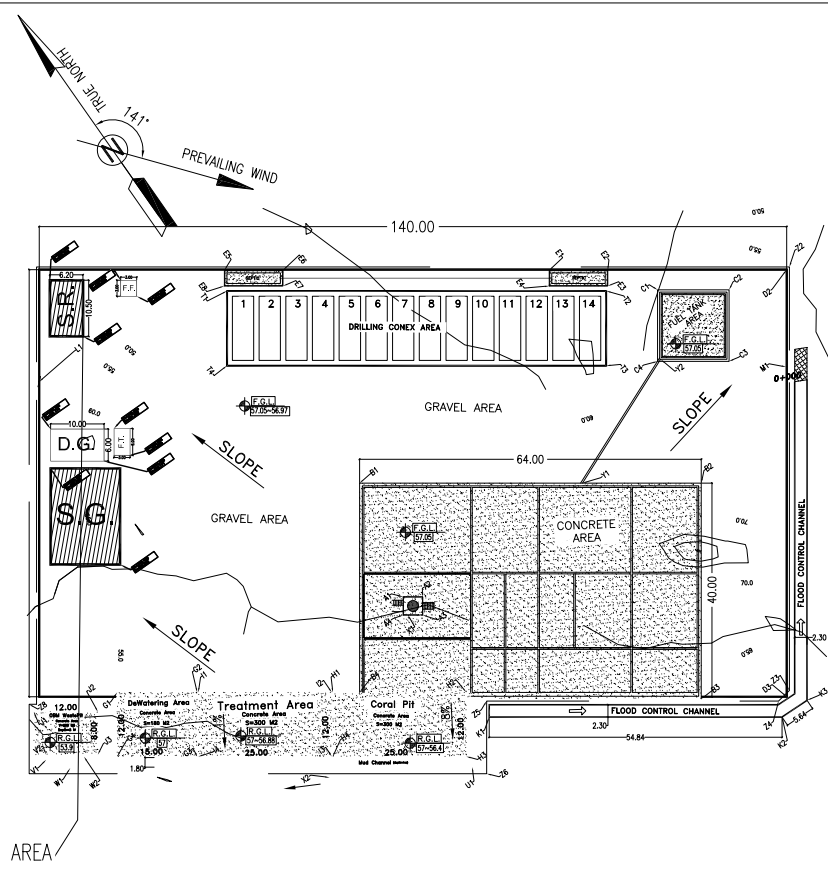SC. 1:10

SC. 1:10

REFERENCE DRAWING	DRG. No
STANDARD DRAWING FOR ARCHITECTURAL DETAILS	BK-GNRAL-PEDCO-000-AR-DW-0001
STANDARD DETAILS FOR LADDER & SAFETY CAGE	BK-GNRAI-PEDCO-000-ST-DW-0009
PLOT PLAN DRAWING - W0468	BK-W0468-PEDCO-110-PI-DW-0001
FOUNDATION DRAWING FOR SECURITY BUILDING FOR WELL PADS - W0465	BK-W0468-PEDCO-110-ST-DW-0004
STRUCTURAL DRAWING FOR SECURITY BUILDING FOR WELL PADS - W0465	BK-W0468-PEDCO-110-ST-DW-0005
HVAC SYSTEM LAYOUT FOR SECURITY BUILDING - W0465	BK-W0468-PEDCO-110-HV-PI-0002
PLUMBING & SEWAGE PIPING LAYOUT FOR SECURITY BUILDING - W0465	BK-W0468-PEDCO-110-HV-PI-0004
LIGHTING & SMALL POWER LAYOUT FOR SECURITY BUILDING - W0465	BK-SSGRU-PEDCO-111-EL-PI-0005

[illegible][illegible]