

DOCUMENT TITLE:

INSTRUMENT LOCATION LAYOUT




DRAWING – W028

NOTES


LEGEND

REFERENCE DRAWING	DRG. No.
P&ID-W028	BK-W028-PEDCO-110-PR-0001
PLOT PLAN DRAWING-W028	BK-W028-PEDCO-110-PI-PY-0001
PDMS MODEL REVIEW REPORT(80%)-W028	BK-W028-PEDCO-110-PI-RT-0001
DATA SHEETS FOR WHCP/HPU-WELLHEADS	BK-SSGRL-PEDCO-110-IN-DT-0001

KEY PLAN

								***	*****	** **	*** ****	** **	*** ****	*** ****			
D01	SEP.2022	IFA	P.HAJISADGHI	M.PAKHARIAN	M.Mehrshad	** **	REV.	DESCRIPTION	BY	DATE	BY	DATE					
D00	MAY.2022	IFC	P.HAJISADGHI	M.PAKHARIAN	M.Mehrshad	** **			CHECKED		REV. APPR.						
REV.	DATE	P.O.I.S	PREP.	CHK.	APP.	AUT.			اصل و کلیه نسخ این نقشه و حق اقتباس متعلق به شرکت ملی مناطق نفت خیز جنوب میباشد.								
PROJECT NAME:						BINAK OILFIELD DEVELOPMENT/SUB-SURFACE WORK PACKAGES W018S WELLHEAD FACILITIES						 THE ORIGINAL AND ALL COPIES OF THIS DRAWING TOGETHER WITH THE COPYRIGHT THEREIN ARE THE SOLE PROPERTY OF N.I.S.O.C./ FIELDS					
PROJECT NO.:						971020											
EPC CONTRACTOR:						EPD/EPC CONTRACTOR (GC):											
 HIRGAN ENERGY - DESIGN & INSPECTION COMPANIES						 PETROIRAN DEVELOPMENT COMPANY						BINAK OILFIELD DEVELOPMENT SUB-SURFACE WORK PACKAGES W018S WELLHEAD FACILITIES					
												DATE	SCALE	DRAWING BY	CHECKED BY	PROJECT ENG.	
DRAWING TITLE:						NO CONSTRUCTION PERMITTED UNLESS DRAWING APPROVED											
INSTRUMENT LOCATION LAYOUT DRAWING - W028						APPROVED FOR CONSTRUCTION			BY:		DATE:						
SCALE	SIZE	DRAWING NO.			SHEET NO.	REV.	BUDGET REF.	LOCATION	SIZE	CLASS	SERIAL NO.	SHEET	REVISION				
AS SHOWN	A3	BK-W028-PEDCO-110-IN-PY-0001			1 OF 2	D01	0-53-073-9184	F	2	J	707537	2	D01				

(VENDOR TITLE BLOCK)\*\*

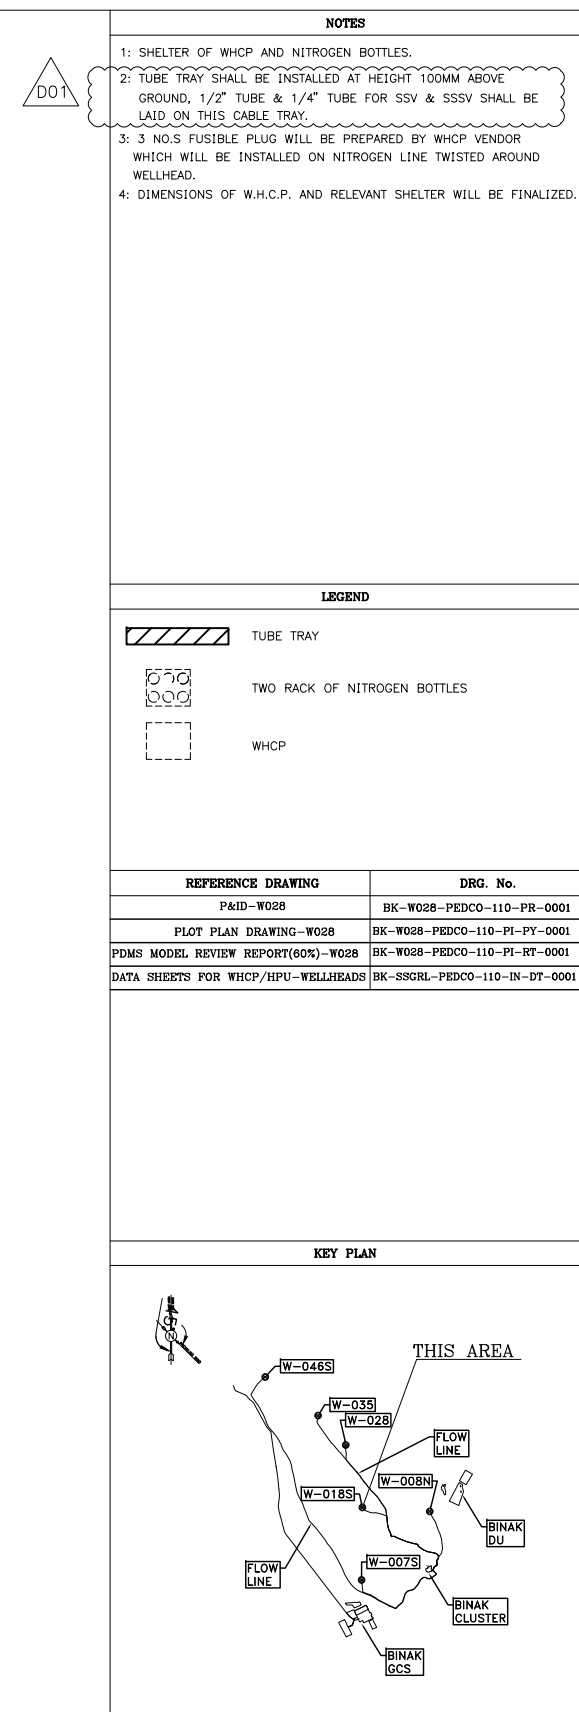

PLOT PLAN DRAWING – W028

---

---

SC: 1/100