



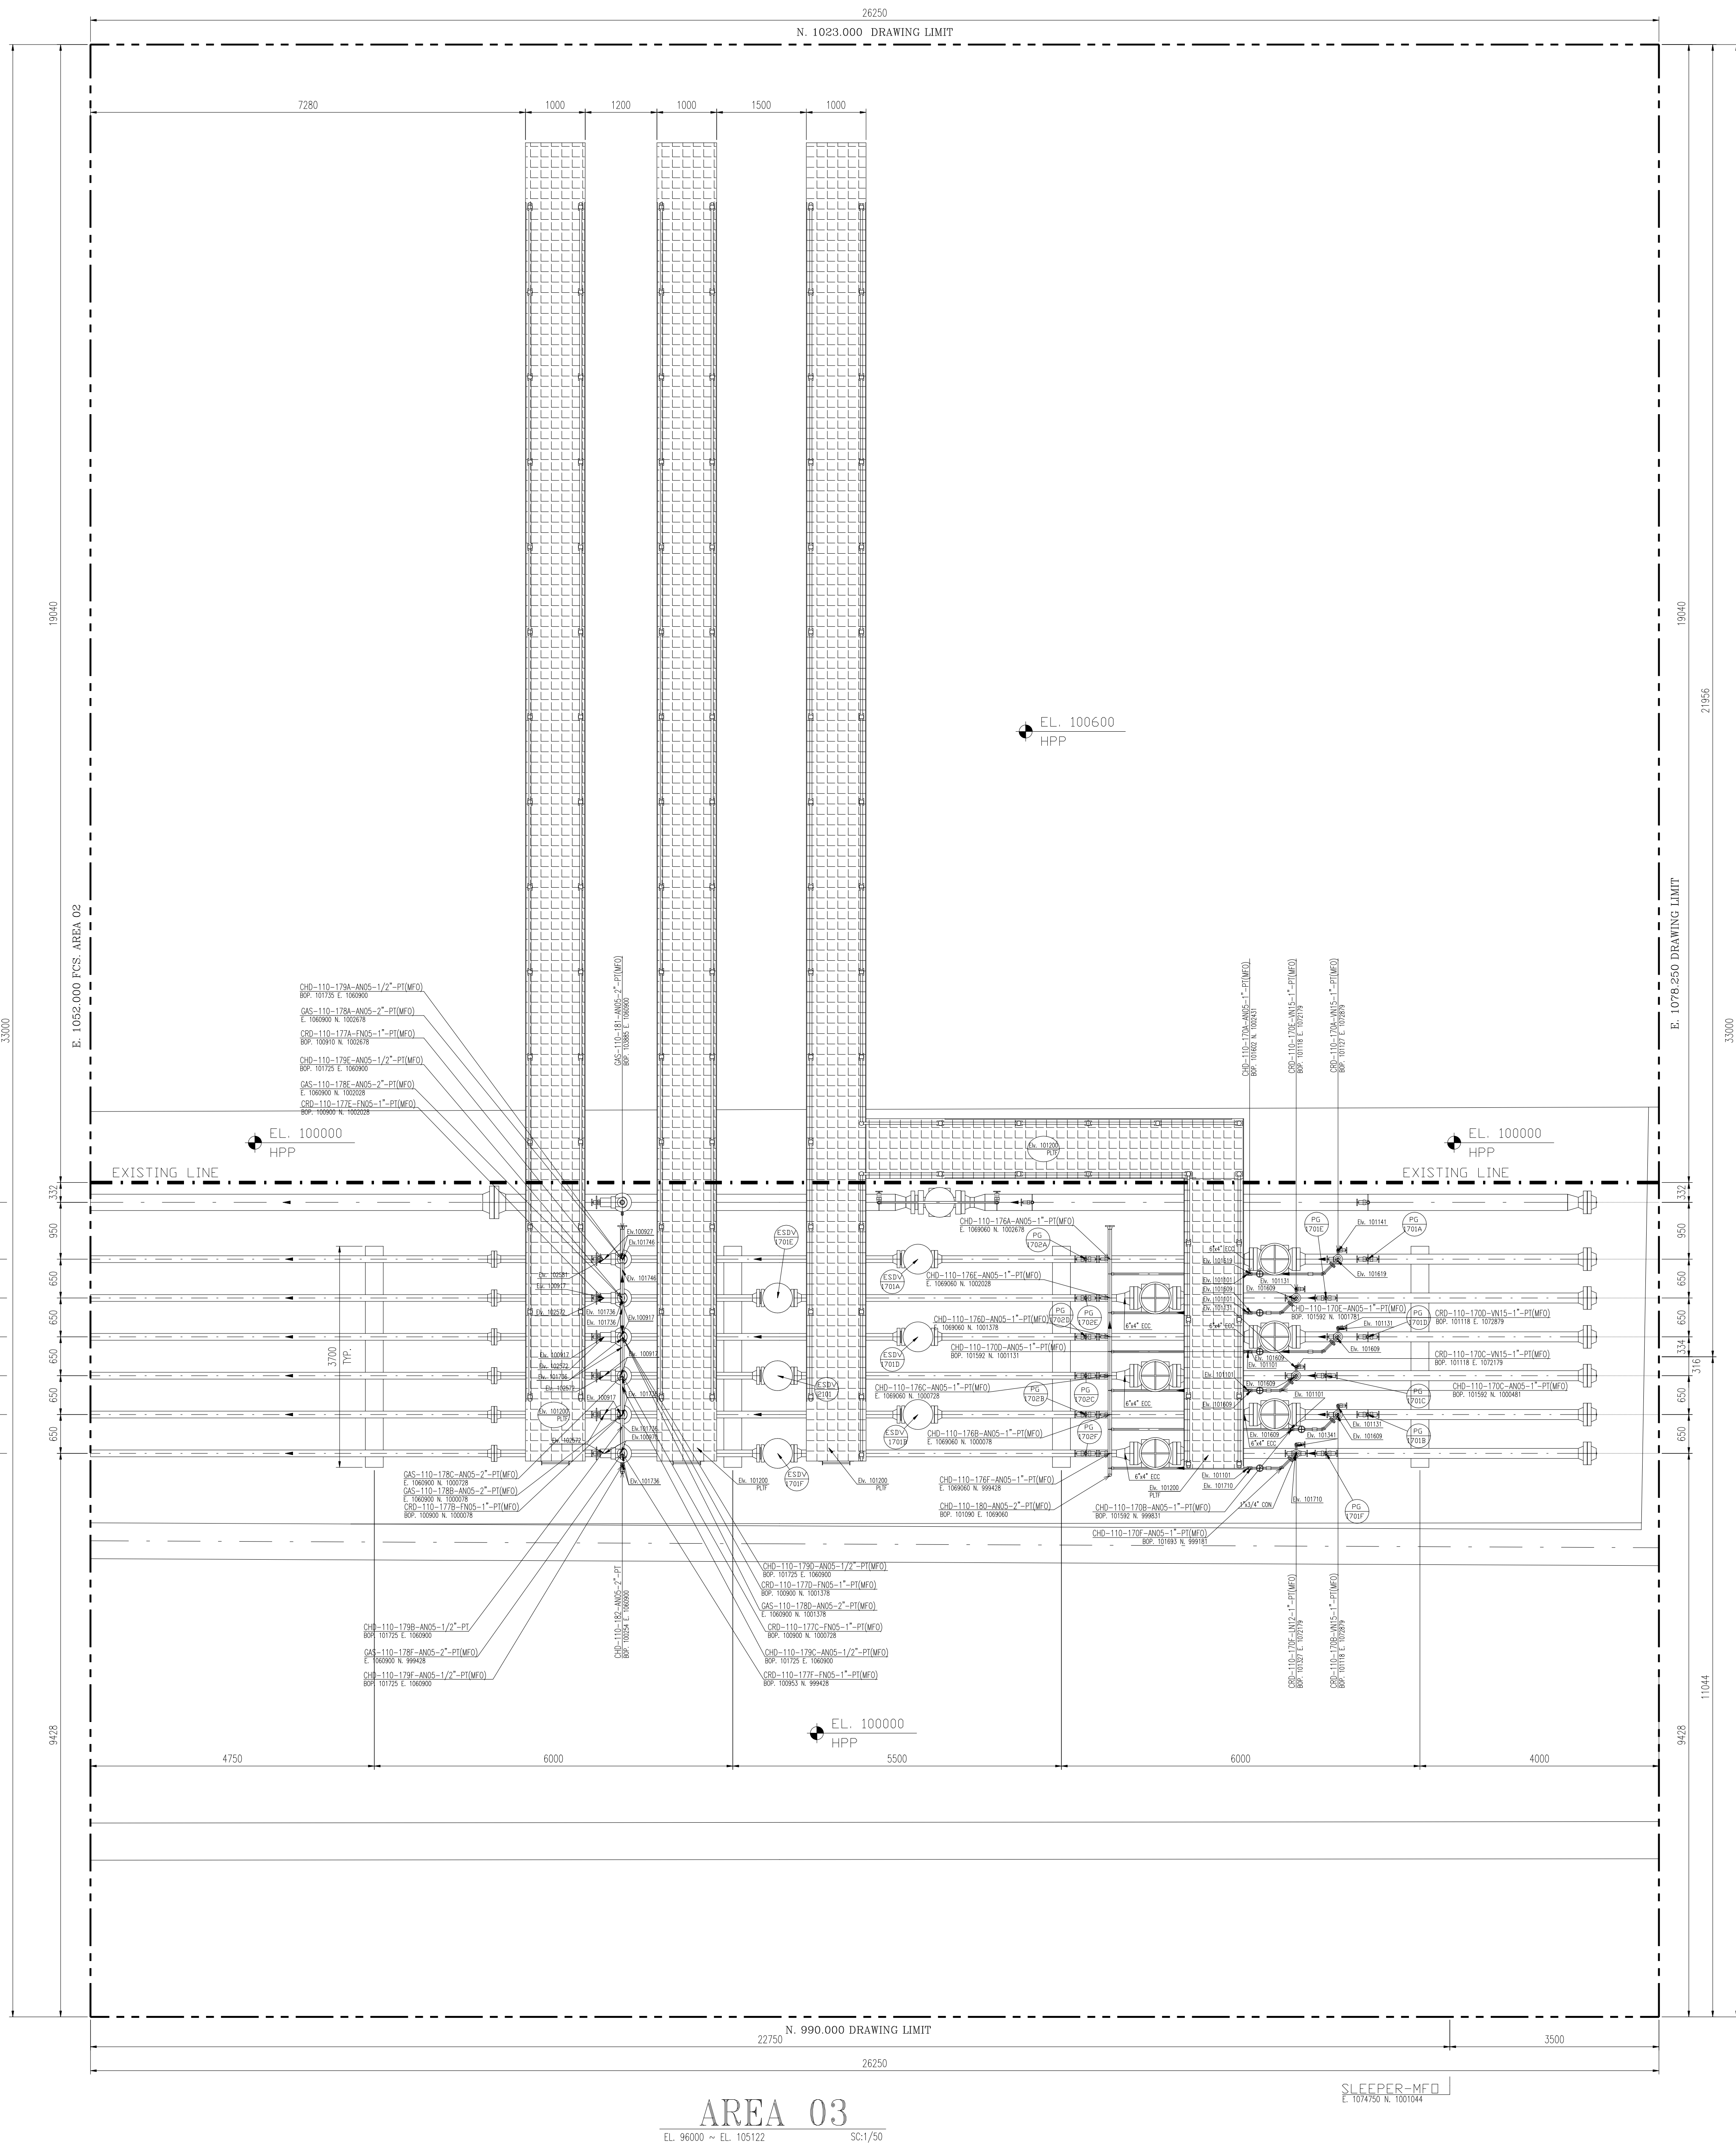


(VENDOR TITLE BLOCK)**

NOTES					
1- ALL DIMENSIONS AND ELEVATIONS ARE IN MILLIMETERS.					
2- ALL COORDINATES ARE IN METERS.					
3- H.P.P, ELEVATION +100.00 CORRESPOND TO +55.0 UTM					
4- ALL COORDINATES = PLANT COORDINATES					
LEGEND					
WP	WORKING POINT ELEVATION (CENTER OF PIPE ELEVATION)				
PF	PLATFORM				
BOP	BOTTOM OF PIPE ELEVATION				
TOS	TOP OF STEEL ELEVATION				
FGL	FINISH GRADE LEVEL				
HPG	HIGH POINT OF GRAVEL				
HPP	HIGH POINT OF PAVEMENT				
MSL	MEAN SEA LEVEL				
SS	STRUCTURE SUPPORT				
PS	PIPE SUPPORT				
SPS	SPECIAL PIPE SUPPORT				
FCS	FOR CONTINUE SEE				
	SLOPE				
			MATCH LINE		
REFERENCE DRAWING			DRG. No.		
Plot Plan Drawing - Extension of Binak B/C Manifold			BK-W007S-PEDCO-110-P1-PY-0001		
P&ID - Extension of Binak B/C Manifold			BK-W007S-PEDCO-110-PR-P1-0001		
KEY PLAN					
***	*****	** **	*** ****	** **	*** *****
REV.	DESCRIPTION	BY	DATE	BY	DATE
		CHECKED		REV. APPR.	
اصل و کليه نسخ این نقشه و حق اقتباس متعلق به شرکت ملی مناطق نفت خیز جنوب میباشد. THE ORIGINAL AND ALL COPIES OF THIS DRAWING TOGETHER WITH THE COPYRIGHT THEREIN ARE THE SOLE PROPERTY OF N.I.S.O.C./ FIELDS					
BINAK OILFIELD DEVELOPMENT[®] SUB-SURFACE WORK PACKAGES W007S WHF & EXTENSION OF BINAK B/C					
DATE	SCALE	DRAWING BY	CHECKED BY	PROJECT ENG.	
NO CONSTRUCTION PERMITTED UNLESS DRAWING APPROVED					
APPROVED FOR CONSTRUCTION			BY:	DATE:	
BUDGET REF.	LOCATION	SIZE	CLASS	SERIAL NO.	REVISION
0-53-073-9184	F	2	J	F2J-707999	1 OF 3 D00

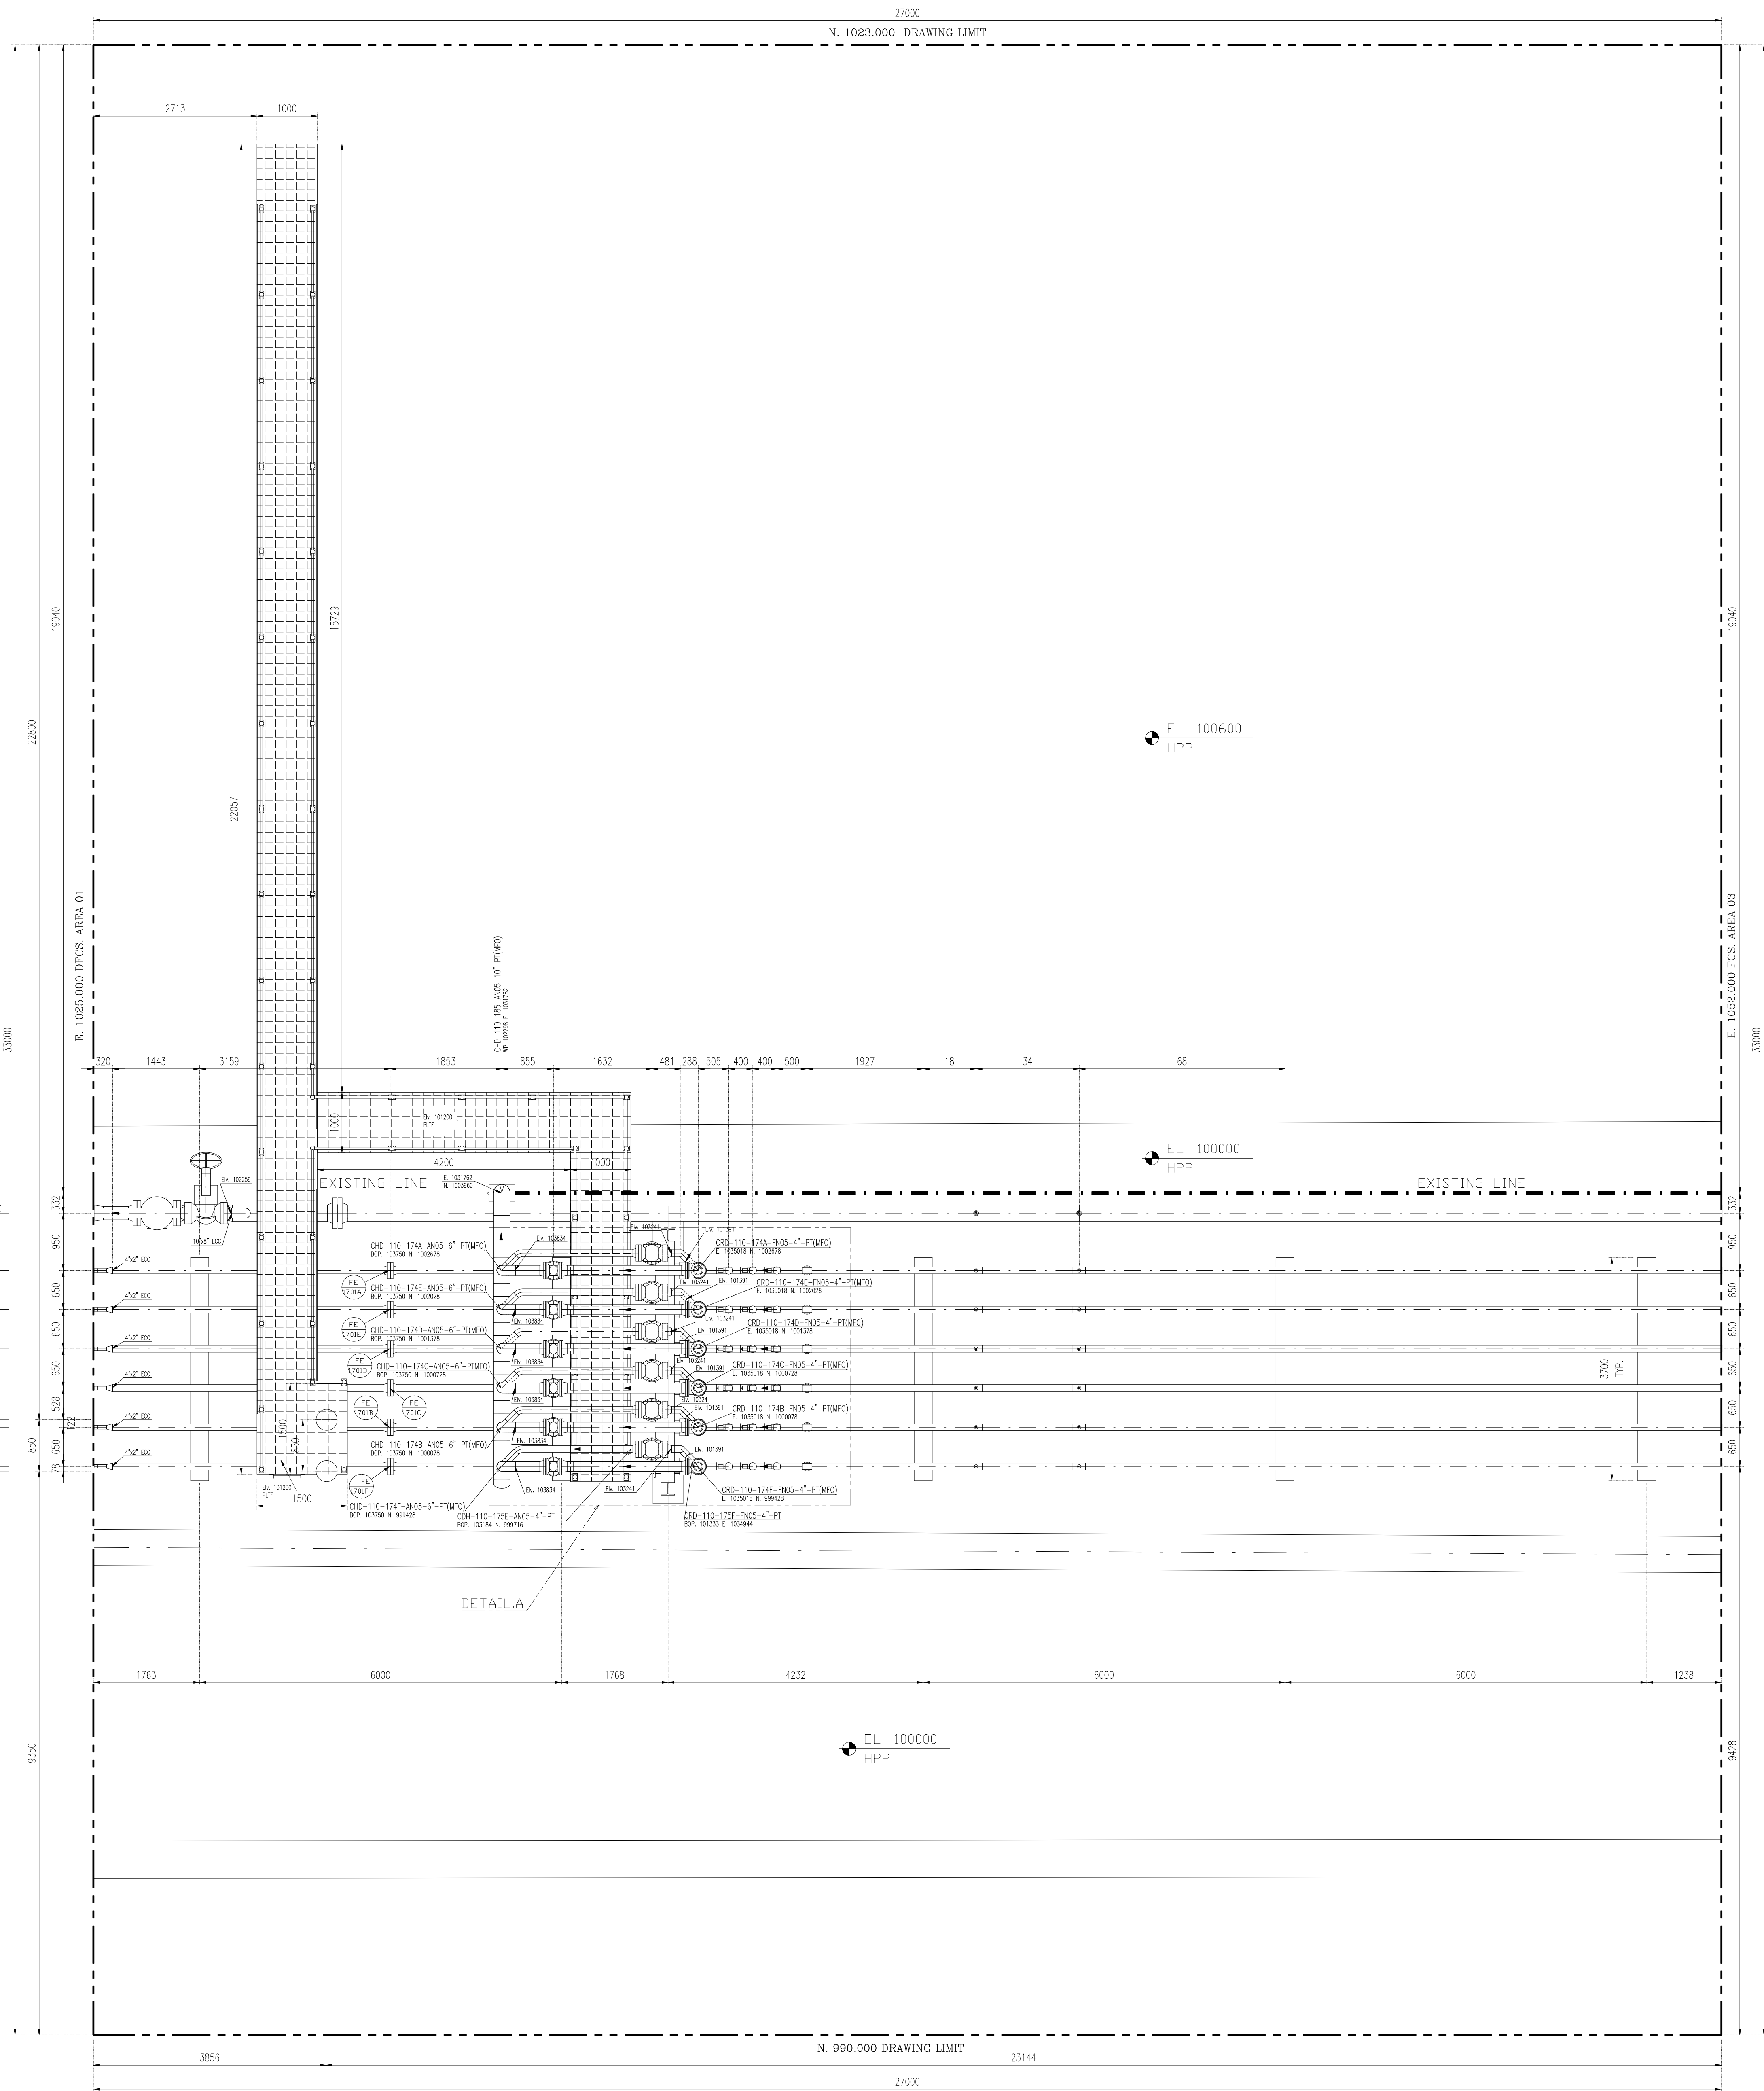

EL. 96000 ~ EL. 105122 SC:1/50

(VENDOR TITLE BLOCK)**

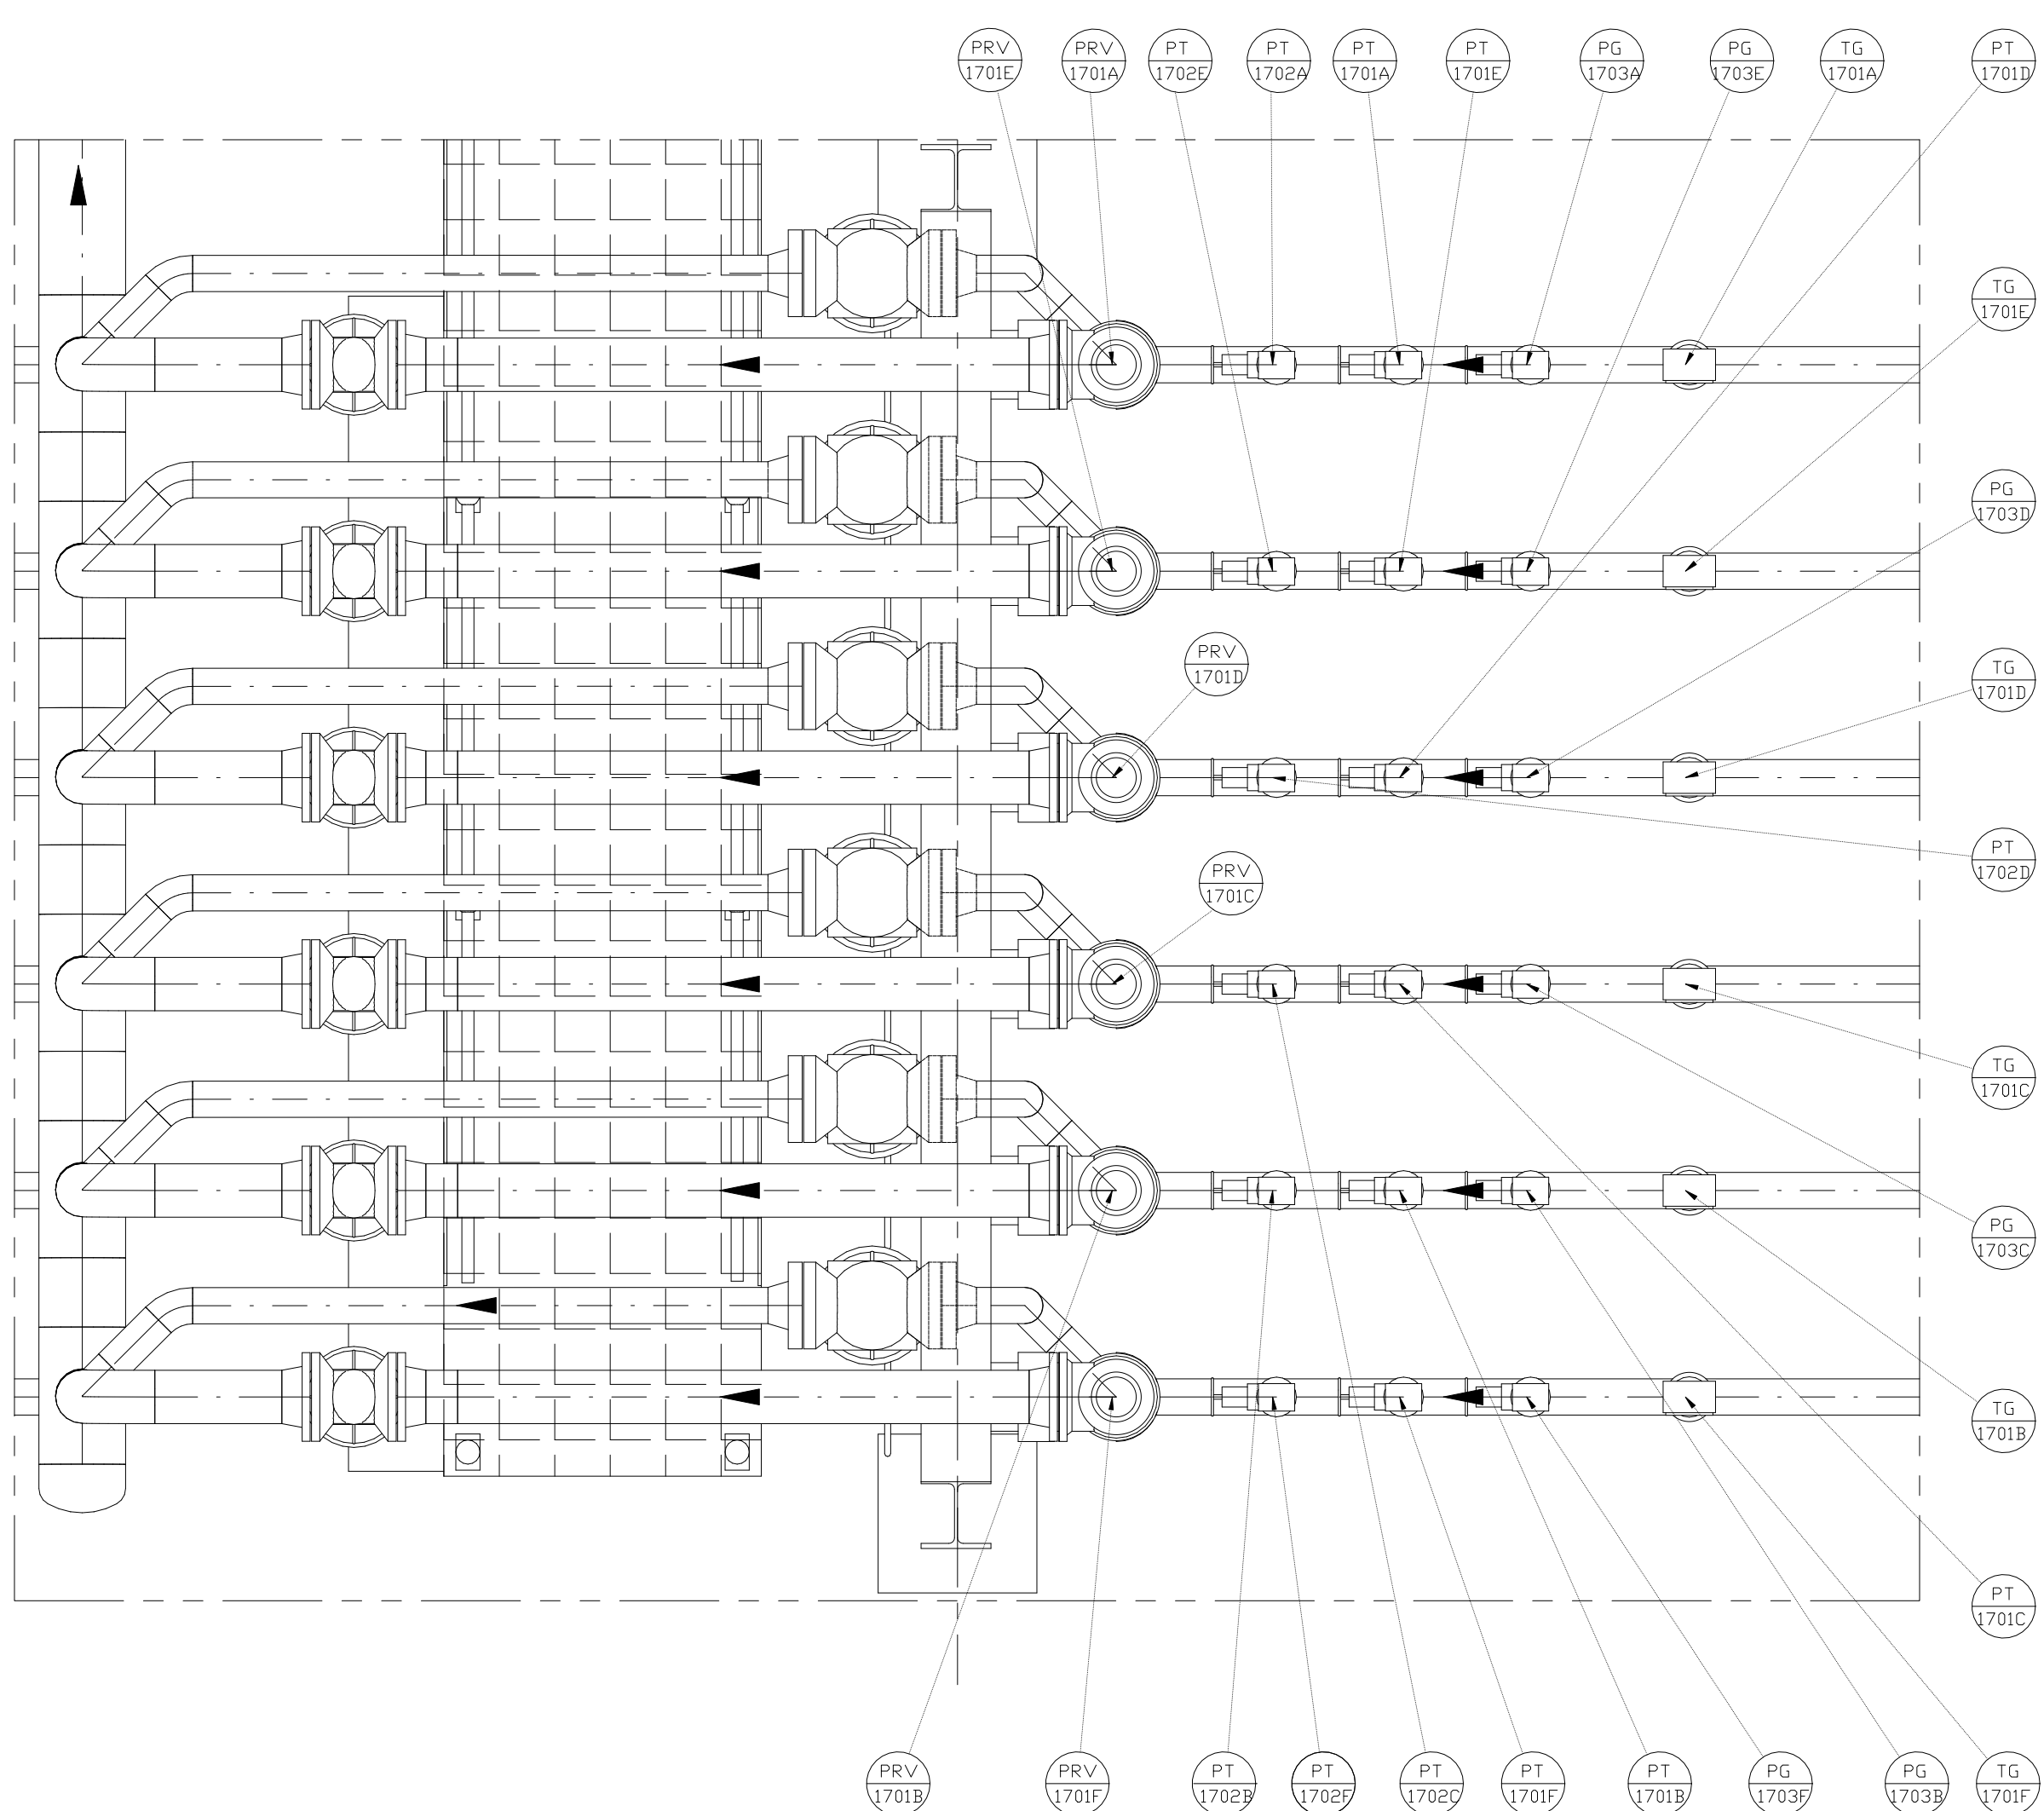


SC:1/20

- 1- ALL DIMENSIONS AND ELEVATIONS ARE IN MILLIMETERS.
- 2- ALL COORDINATES ARE IN METERS.
- 3- H.P.P. ELEVATION +100.00 CORRESPOND TO +55.0 UTM.
- 4- ALL COORDINATES = PLANT COORDINATES


WP	WORKING POINT ELEVATION (CENTER OF PIPE ELEVATION)
PF	PLATFORM
BOP	BOTTOM OF PIPE ELEVATION
TOS	TOP OF STEEL ELEVATION
FGL	FINISH GRADE LEVEL
HPG	HIGH POINT OF GRAVEL
HPP	HIGH POINT OF PAVEMENT
MSL	MEAN SEA LEVEL
SS	STRUCTURE SUPPORT
PS	PIPE SUPPORT
SPS	SPECIAL PIPE SUPPORT
FCS	FOR CONTINUE SEE
	SLOPE
-----	MATCH LINE

REFERENCE DRAWING	DRG. No.
Plot Plan Drawing – Extension of Binak B/C Manifold	BK-W007S-PEDCO-110-PI-PY-0001
P&ID – Extension of Binak B/C Manifold	BK-W007S-PEDCO-110-PR-PI-0001

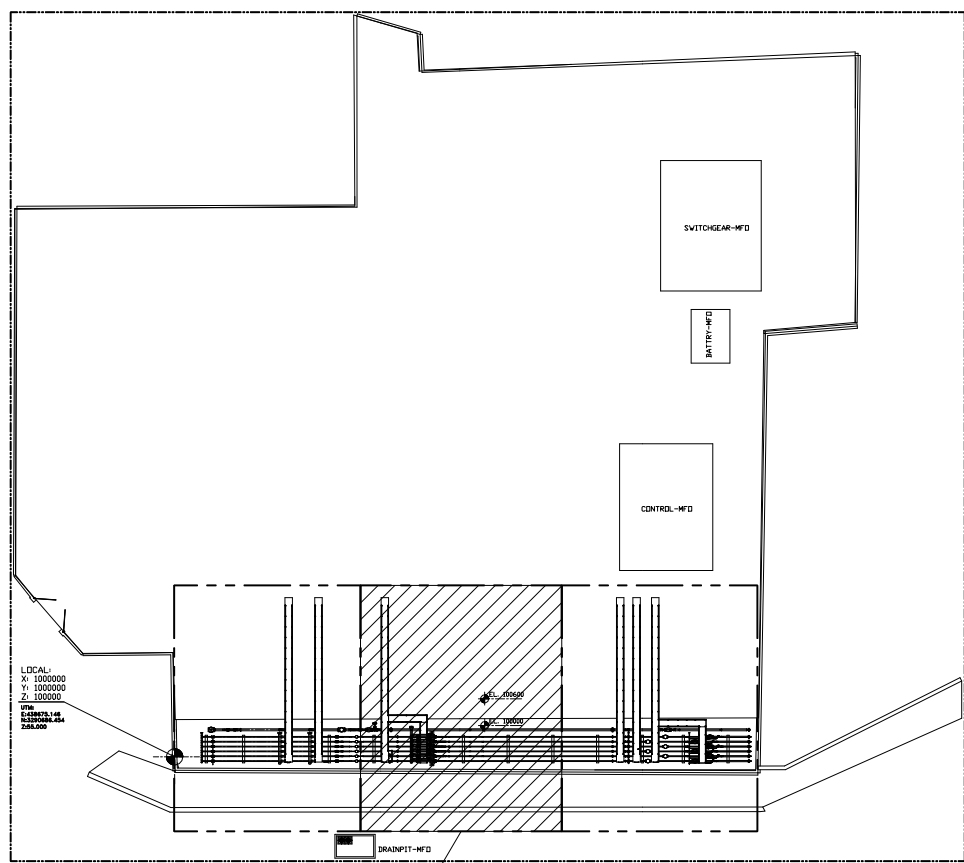

↳ This Drawing

[illegible]

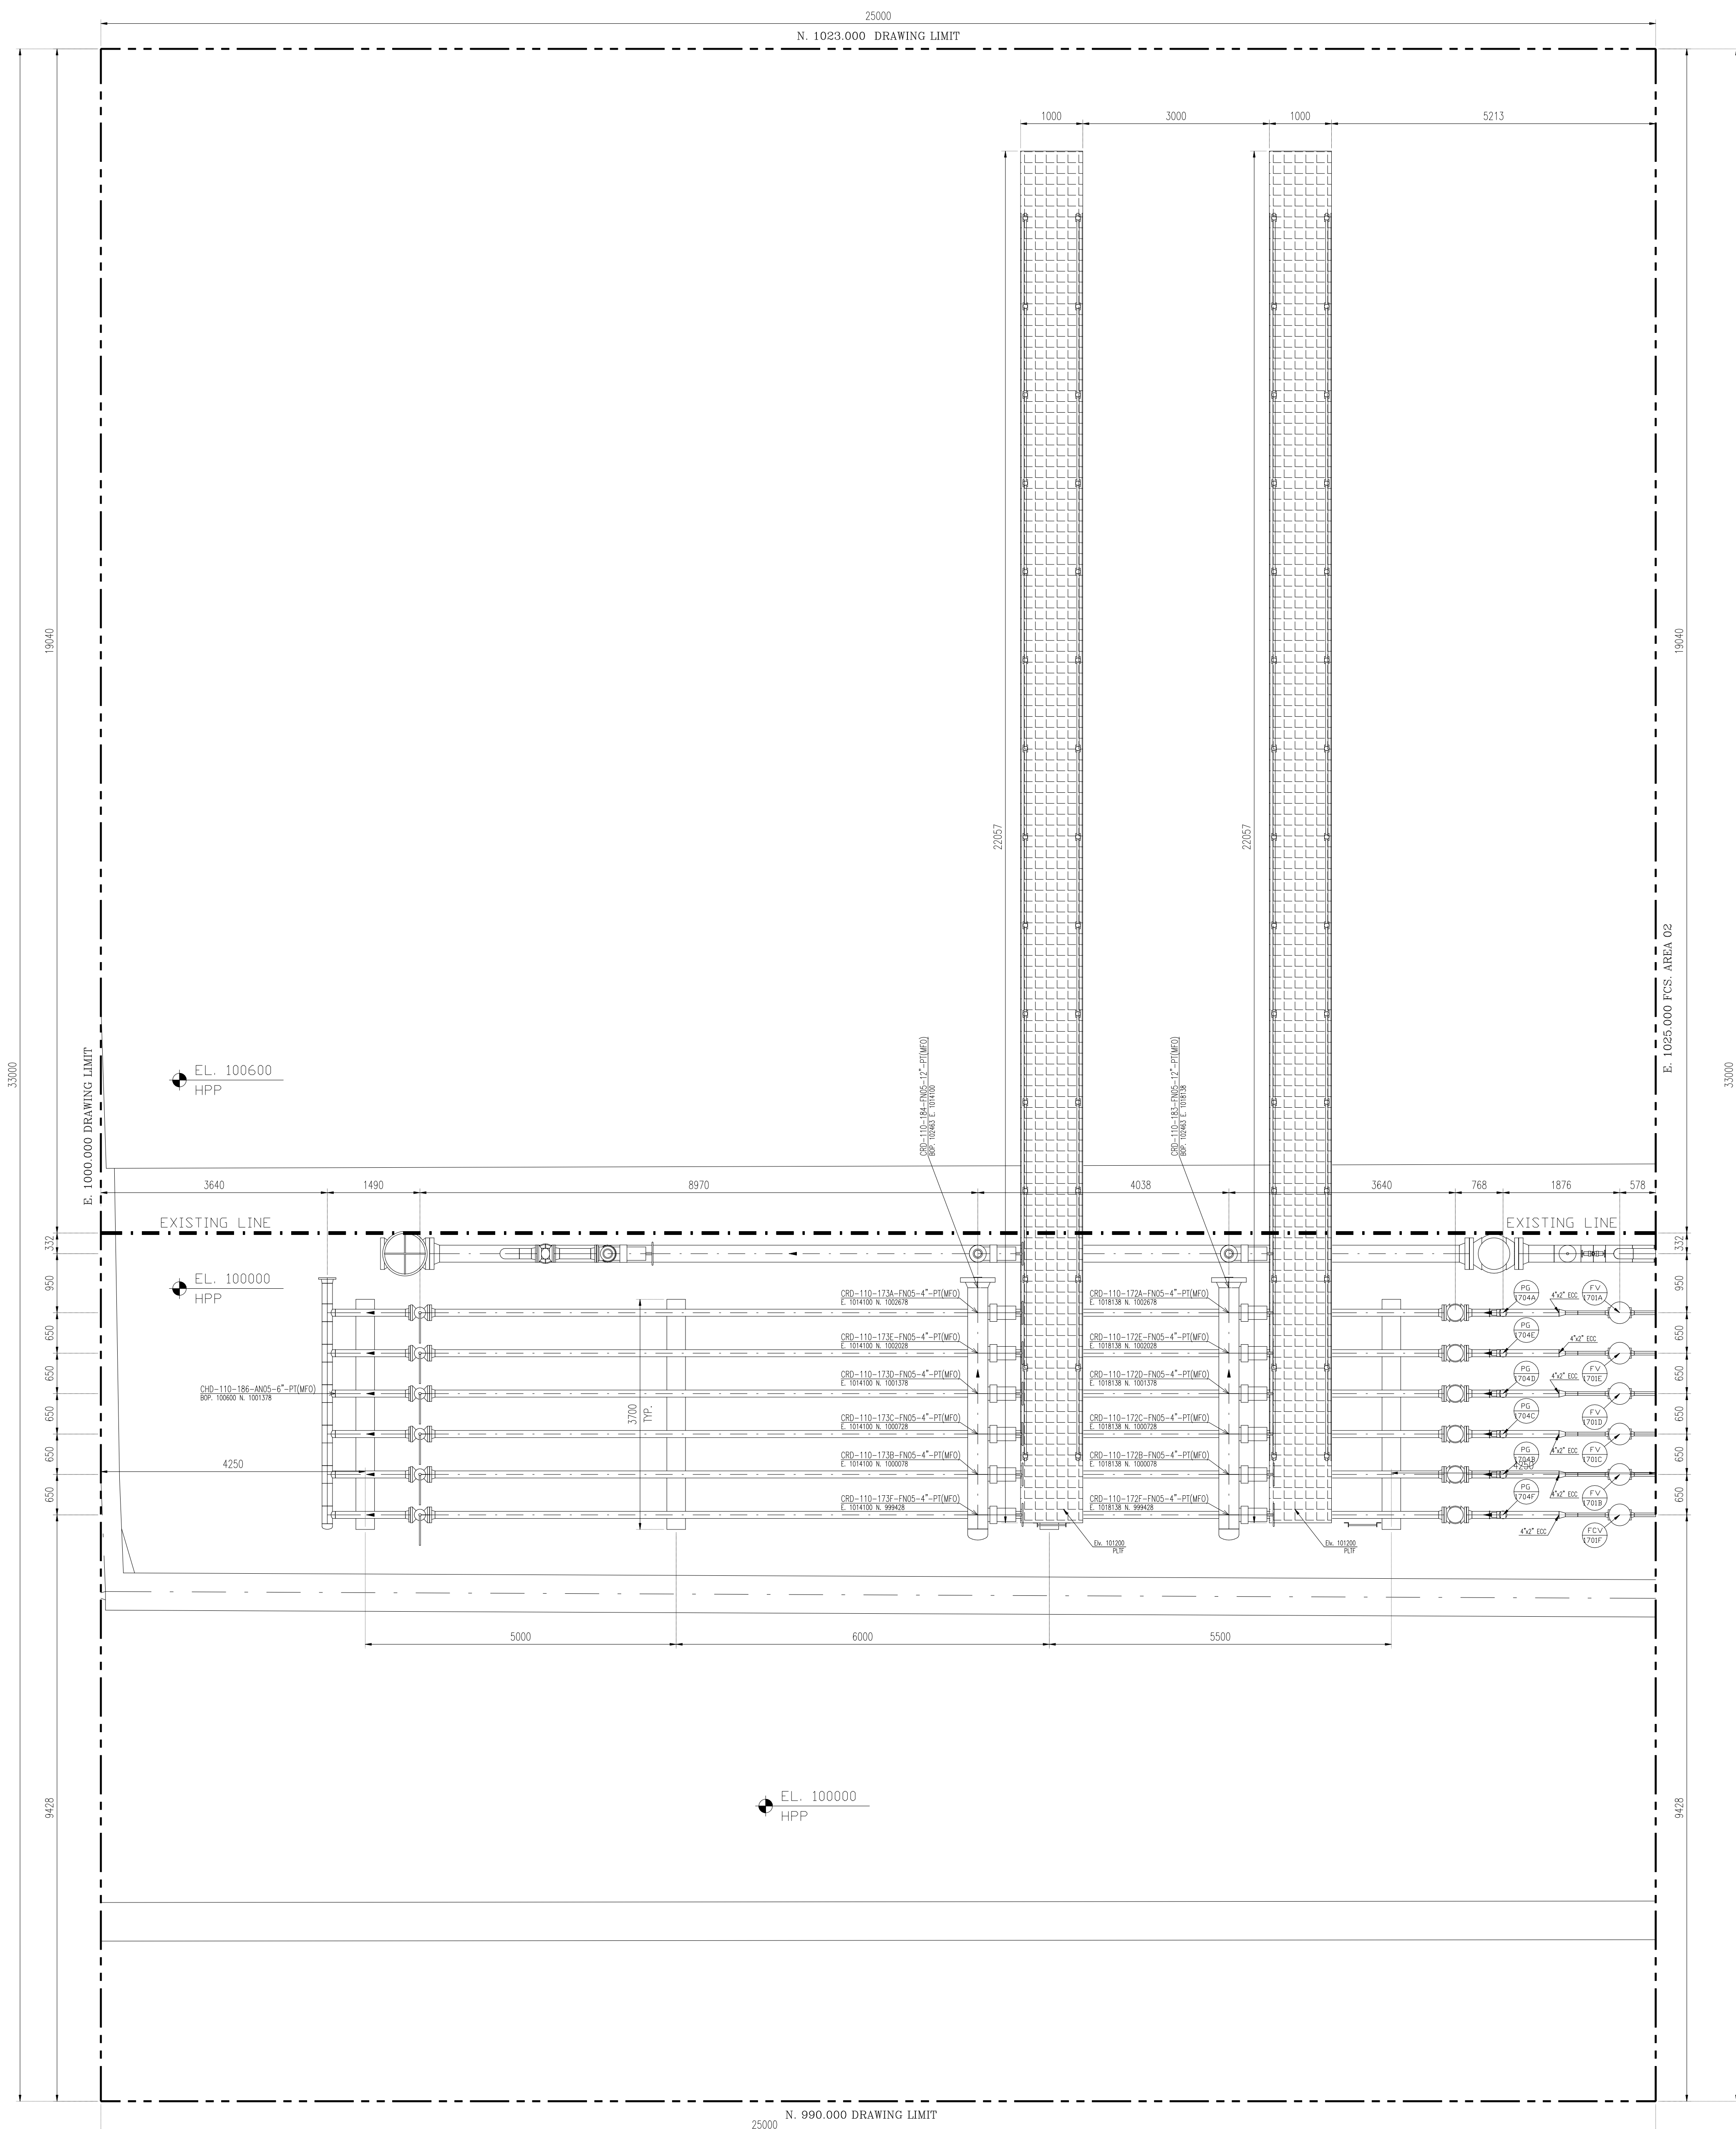

(VENDOR TITLE BLOCK)**

LEGEND	
WP	WORKING POINT ELEVATION (CENTER OF PIPE ELEVATION)
PF	PLATFORM
BOP	BOTTOM OF PIPE ELEVATION
TOS	TOP OF STEEL ELEVATION
FGL	FINISH GRADE LEVEL
HPG	HIGH POINT OF GRAVEL
HPP	HIGH POINT OF PAVEMENT
MSL	MEAN SEA LEVEL
SS	STRUCTURE SUPPORT
PS	PIPE SUPPORT
SPS	SPECIAL PIPE SUPPORT
FCS	FOR CONTINUE SEE
	SLOPE
	MATCH LINE

[illegible][illegible]