
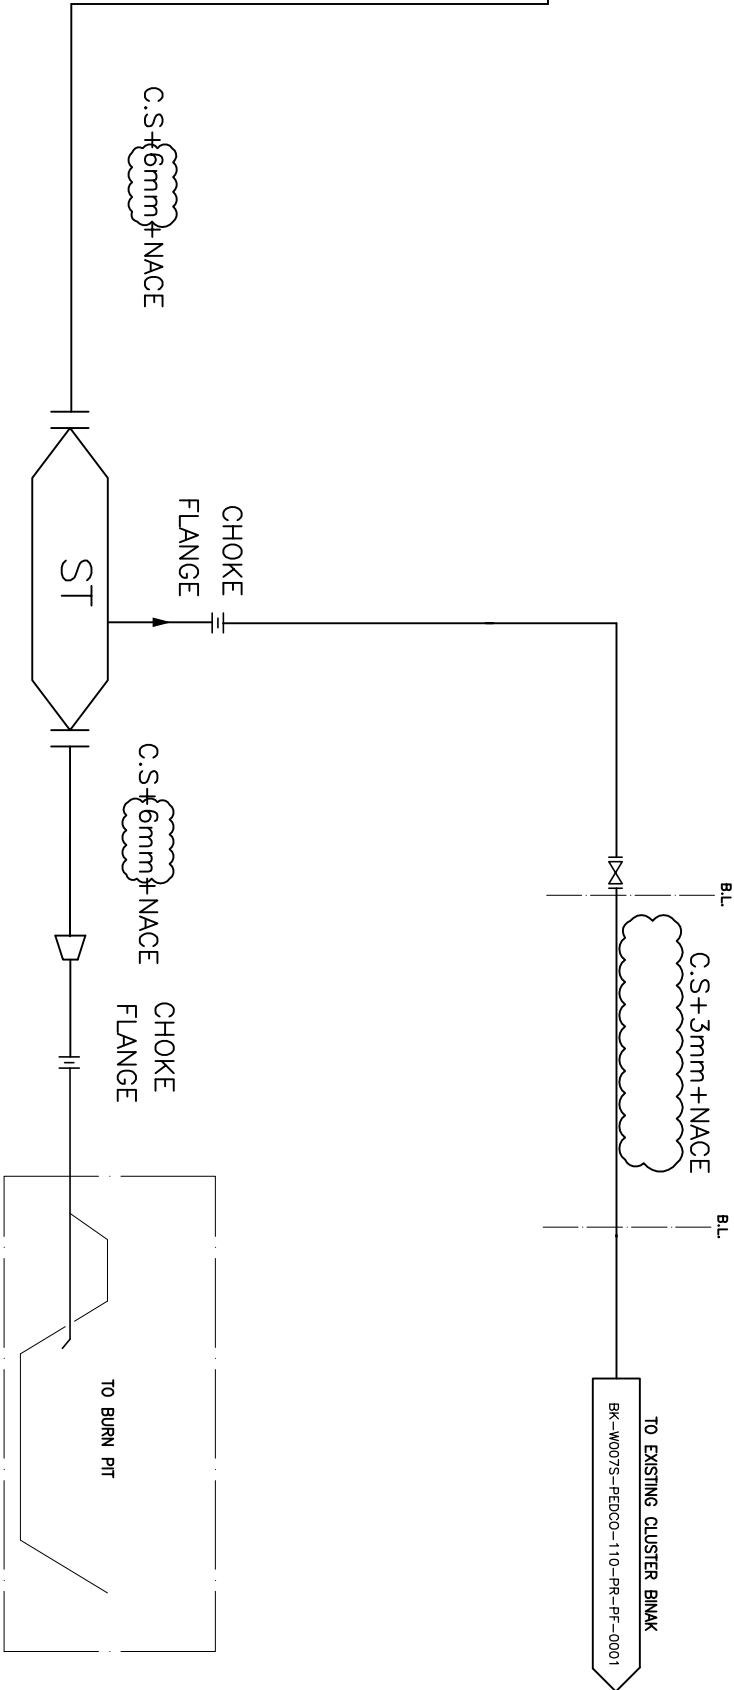


WELL-W007S
BINAK PRODUCTION WELL

ST-1201
STONE TRAP
MATERIAL : CARBON STEEL
NACE MR 0175/ISO15156

IRP-1201
SUCKER ROD PUMP (IRP)
(BY VENDOR)

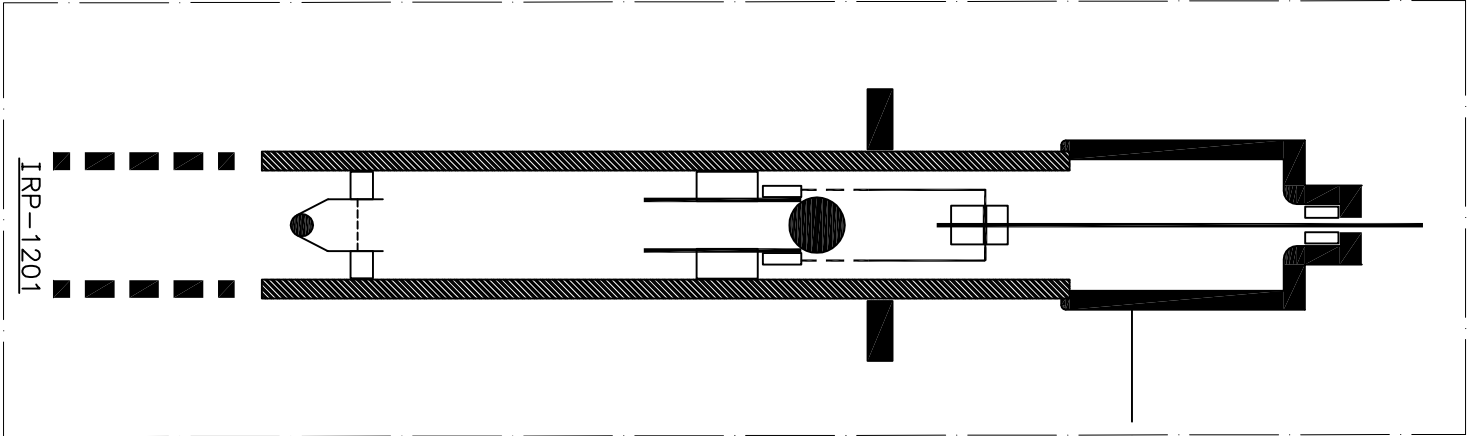

NOTES

GENERAL NOTE

1. WALL THICKNESS SHALL BE IN ACCORDANCE WITH NISOC STANDARD DRAWING.

LEGEND

REFERENCE DRAWING	DRG. No.
Process Flow Diagram - W007S	BK-W007S-PEOCO-110-PS-PT-0002
Pipeline Corrosion Study & Material Selection Report	BK-SRBL-PEOCO-110-PI-PT-0001

KEY PLAN

DO2	OCT 2022	IP/A	REVISION	DATE	BY	DATE	BY	DATE	BY	DATE
DO1	MAY 2022	IP/A	REVISION	DATE	BY	DATE	BY	DATE	BY	DATE
DO0	NOV 2021	IP/C	REVISION	DATE	BY	DATE	BY	DATE	BY	DATE
REV.	DATE	PREP.	CHK.	APP.	DATE	DATE	DATE	DATE	DATE	DATE

PROJECT NAME: BINAK OILFIELD DEVELOPMENT/SUB-SURFACE WORK PACKAGES
W007S WHP & EXTENSION OF BINAK B/C

PROJECT NO.: 971020

EPC CONTRACTOR:

EPC/EPIC CONTRACTOR (GC):

HIRSHAN ENERGY - DESIGN & INSPECTION OPERATIONS

PETROBRAS DEVELOPMENT COMPANY

DRAWING TITLE: MATERIAL FLOW DIAGRAM - W007S									
SCALE	SIZE	DRAWING NO.	SHEET NO.	REV.	DATE				
NS	A3	BK-W007S-PEOCO-110-PI-DG-0001	1 OF 1	DO2					

NO CONSTRUCTION PERMITTED UNLESS DRAWING APPROVED									
APPROVED FOR CONSTRUCTION					DATE:				
BUDGET REV. LOCATION SIZE CLASS					SHEET REVISION				
1 OF 1					2				
707048					1 OF 1				
DO2									

W007S
WELLHEAD
(SUB SURFACE SCOPE OF WORK)

(VENDOR TITLE BLOCK)**