


V-2103
GAS COMPRESSION DISCHARGE DRUM

DIMENSION (ID X TL-TL) : 900 X 3000 mm
DESIGN TEMP. : 130 °C
DESIGN PRESS. : FV/62 barg

TRIM LINE : TRM-V-2103-0511-FN05-PT
TRIM LINE : TRM-V-2103-0513-FS00-NP

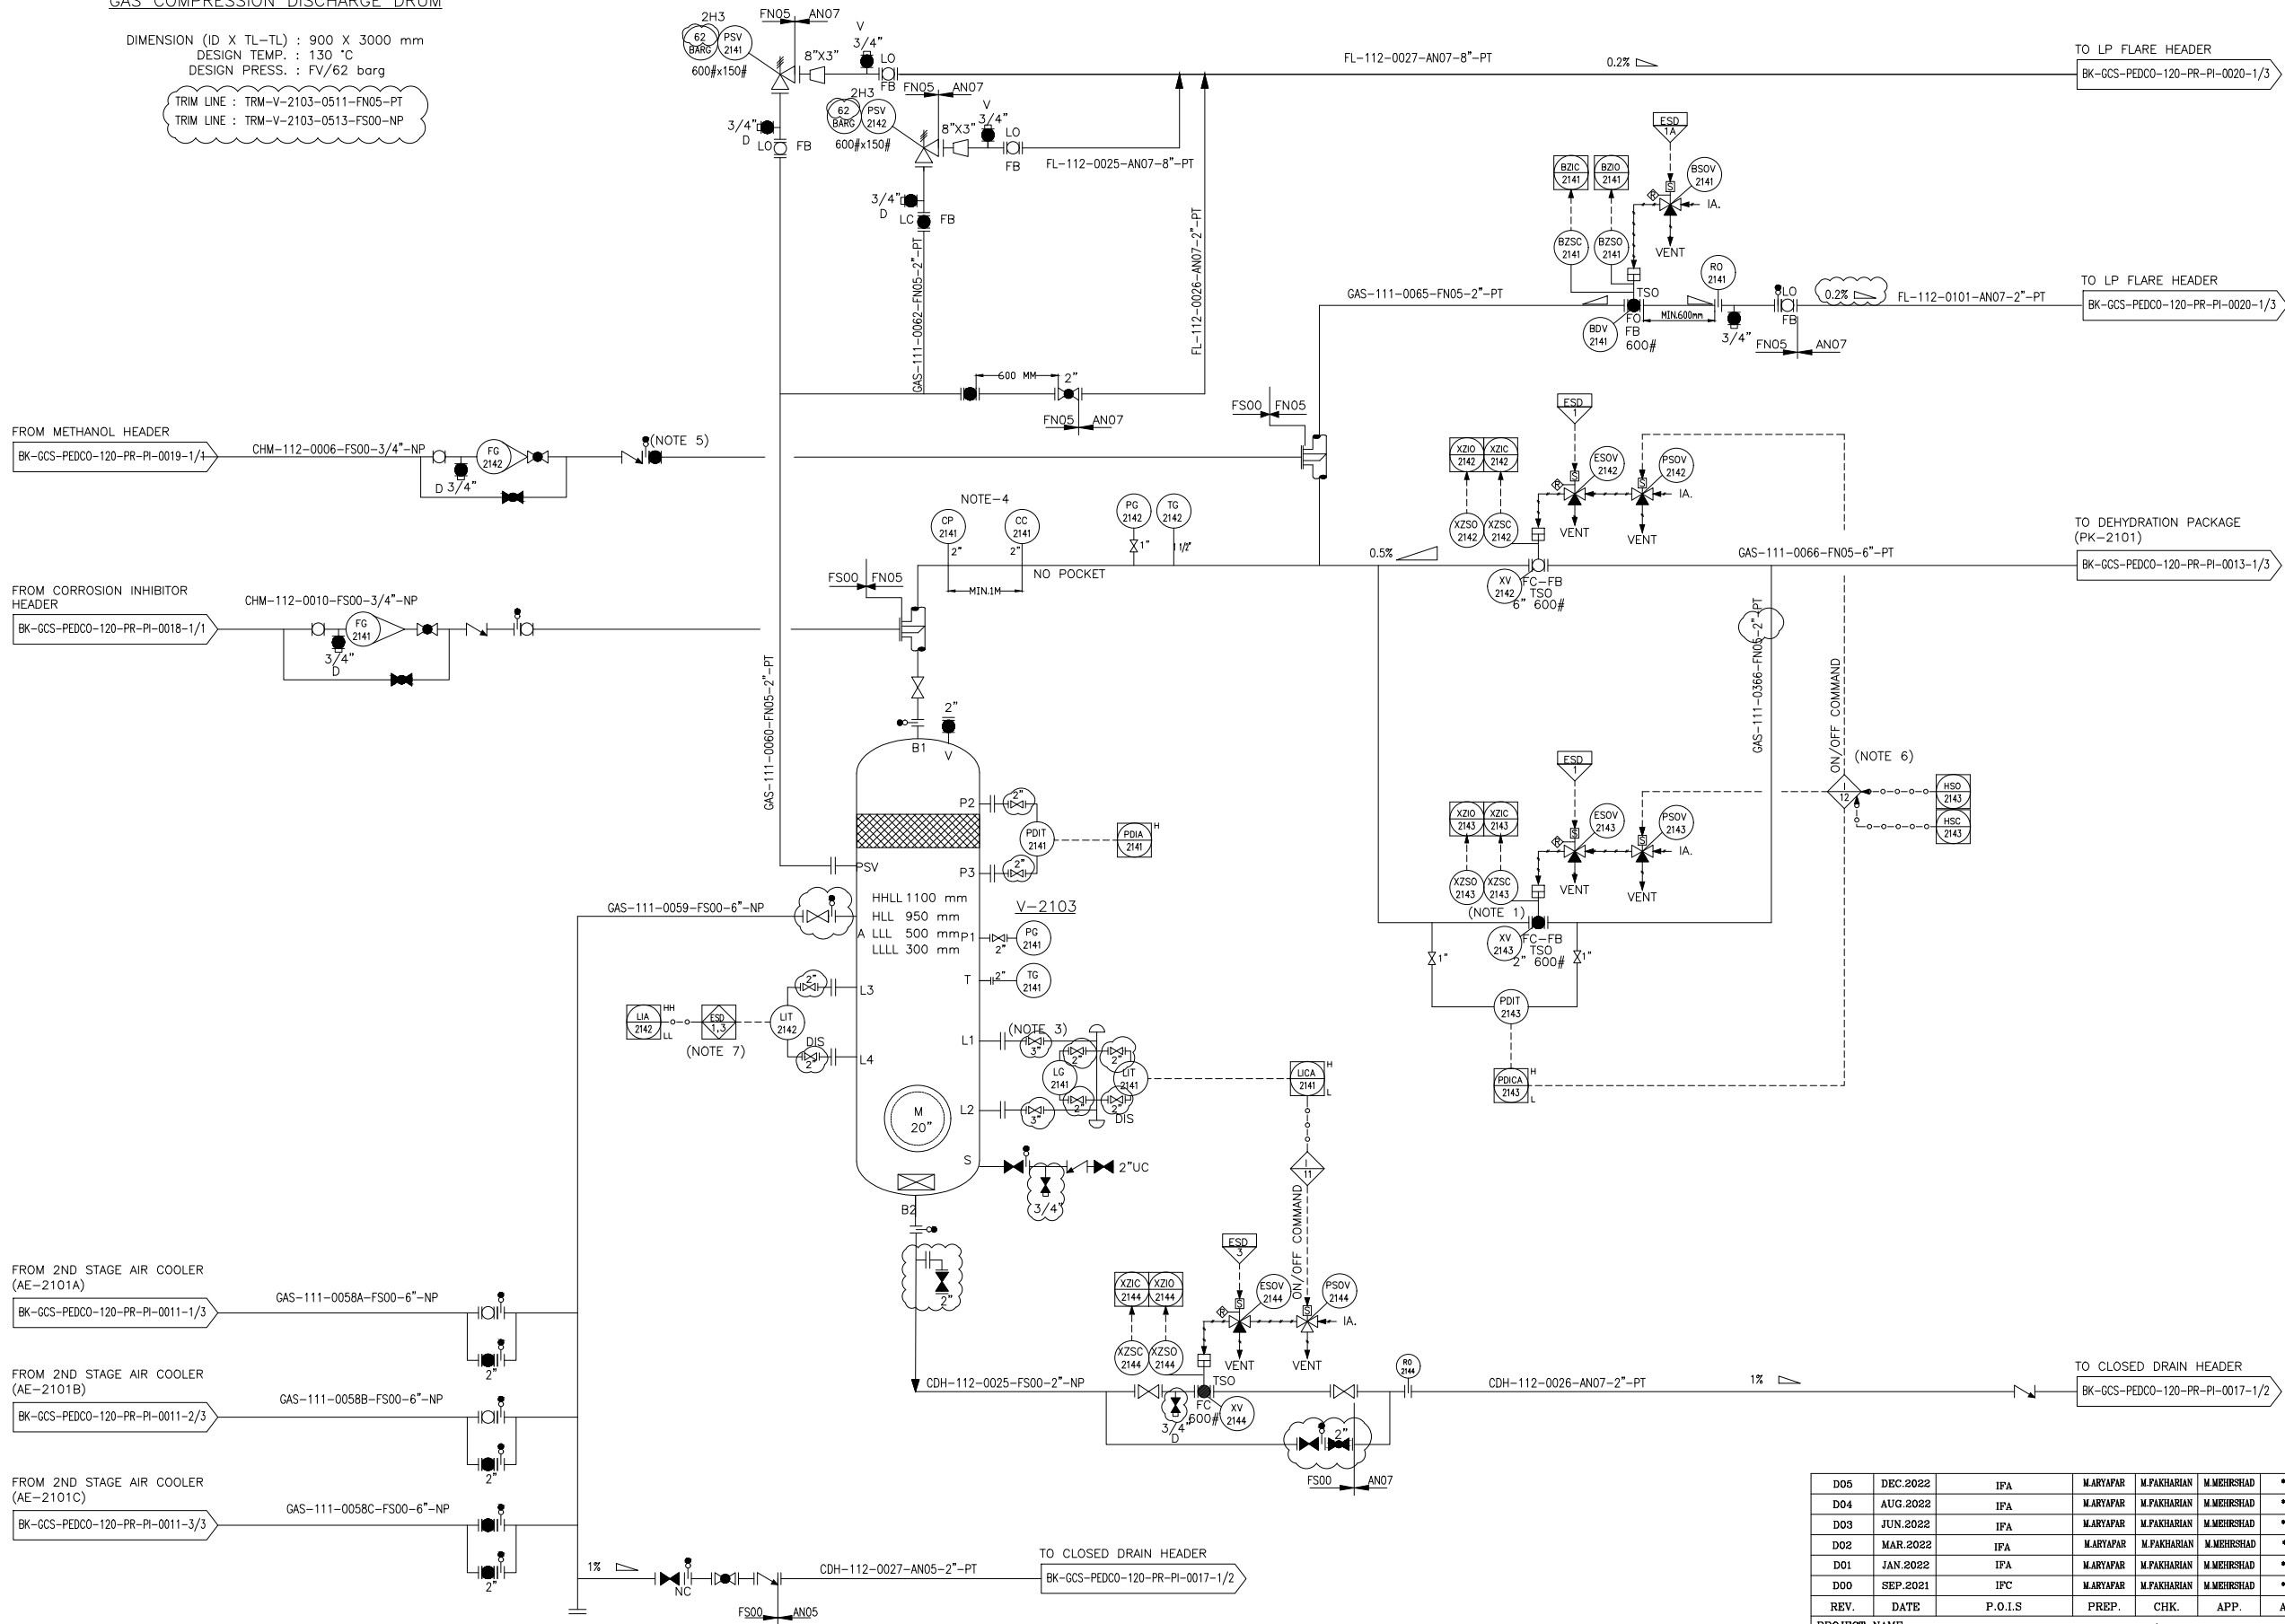

NOTES


- 1- DELETED.
- 2- DELETED.
- 3- DELETED.
- 4- ONE PORTABLE METER FOR CORROSION PROBES TO BE PROVIDE PER SITE TO RECOVERY MONITOR CORROSION DATA.
- 5- BEFORE IN CASE OF COLD DEPRESSURIZING, MANUAL VALVE WILL BE OPEN BY OPERATOR.
- 6- OPEN/CLOSE COMMAND BY OPERATOR WILL BE IMPLEMENTED BY EQUALIZING LOGIC DURING START UP.
- 7- ESD LEVEL 1 FOR HH AND 3 FOR L LIQUID LEVEL
- 8-PARTIAL STROK DEVICE TO BE CONSIDERED FOR ALL ESOV'S ACTIVATED BY ESD 1.0.

LEGEND

REFERENCE DRAWING	DRG. No.
Process Flow Diagram	BK-GCS-PEDCO-120-PR-PF-0001
Symbol & Legend For PFD and P&ID	BK-GCS-PEDCO-120-PR-PI-0001

KEY PLAN

TYPE 1

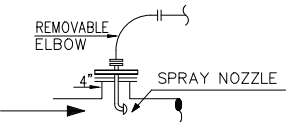

INJECTION DEVICE PERMANENTLY CONNECTED
(GAS SERVICE)

D05	DEC.2022	IPA	M.ARYAPAR	M.PAKHARIAN	M.MEHRSHAD	** **
D04	AUG.2022	IPA	M.ARYAPAR	M.PAKHARIAN	M.MEHRSHAD	** **
D03	JUN.2022	IPA	M.ARYAPAR	M.PAKHARIAN	M.MEHRSHAD	** **
D02	MAR.2022	IPA	M.ARYAPAR	M.PAKHARIAN	M.MEHRSHAD	** **
D01	JAN.2022	IPA	M.ARYAPAR	M.PAKHARIAN	M.MEHRSHAD	** **
D00	SEP.2021	IPC	M.ARYAPAR	M.PAKHARIAN	M.MEHRSHAD	** **

PROJECT NAME: BINAK OILFIELD DEVELOPMENT/SURFACE FACILITIES
GAS COMPRESSOR STATION

PROJECT NO.: 971020

EPC CONTRACTOR:	EPD/EPC CONTRACTOR (GC):
 HIRGAN ENERGY - DESIGN & INSPECTION COMPANIES	 PETROIRAN DEVELOPMENT COMPANY

DRAWING TITLE: P&ID - 2nd Stage Gas Compression Discharge Drum					
SCALE	SIZE	DRAWING NO.	SHEET NO.	REV.	BUDGET REF.
NS	A3	BK-GCS-PEDCO-120-PR-PI-0012	1 OF 1	D05	053-073-9184

BINAK OILFIELD DEVELOPMENT SURFACE FACILITIES GAS COMPRESSOR STATION					
DATE	SCALE	DRAWING BY	CHECKED BY	PROJECT ENG.	
NO CONSTRUCTION PERMITTED UNLESS DRAWING APPROVED					
APPROVED FOR CONSTRUCTION			BY:	DATE:	
BUDGET REF.	LOCATION	SIZE CLASS	SERIAL NO.	SHEET	REVISION
053-073-9184	F	2	A	708790	1 OF 1 D05