


PK-C-2203 A/B
AIR COMPRESSOR PACKAGE

DESIGN CAPACITY (DRY BASIS) : 191 Nm³/hr
DESIGN PRESS. : 12.5 barg

PK-DR-2203 A/B
AIR DRYER PACKAGE

DESIGN CAPACITY (DRY BASIS) : 157.3 Nm³/hr
DESIGN PRESS. : 12.5 barg

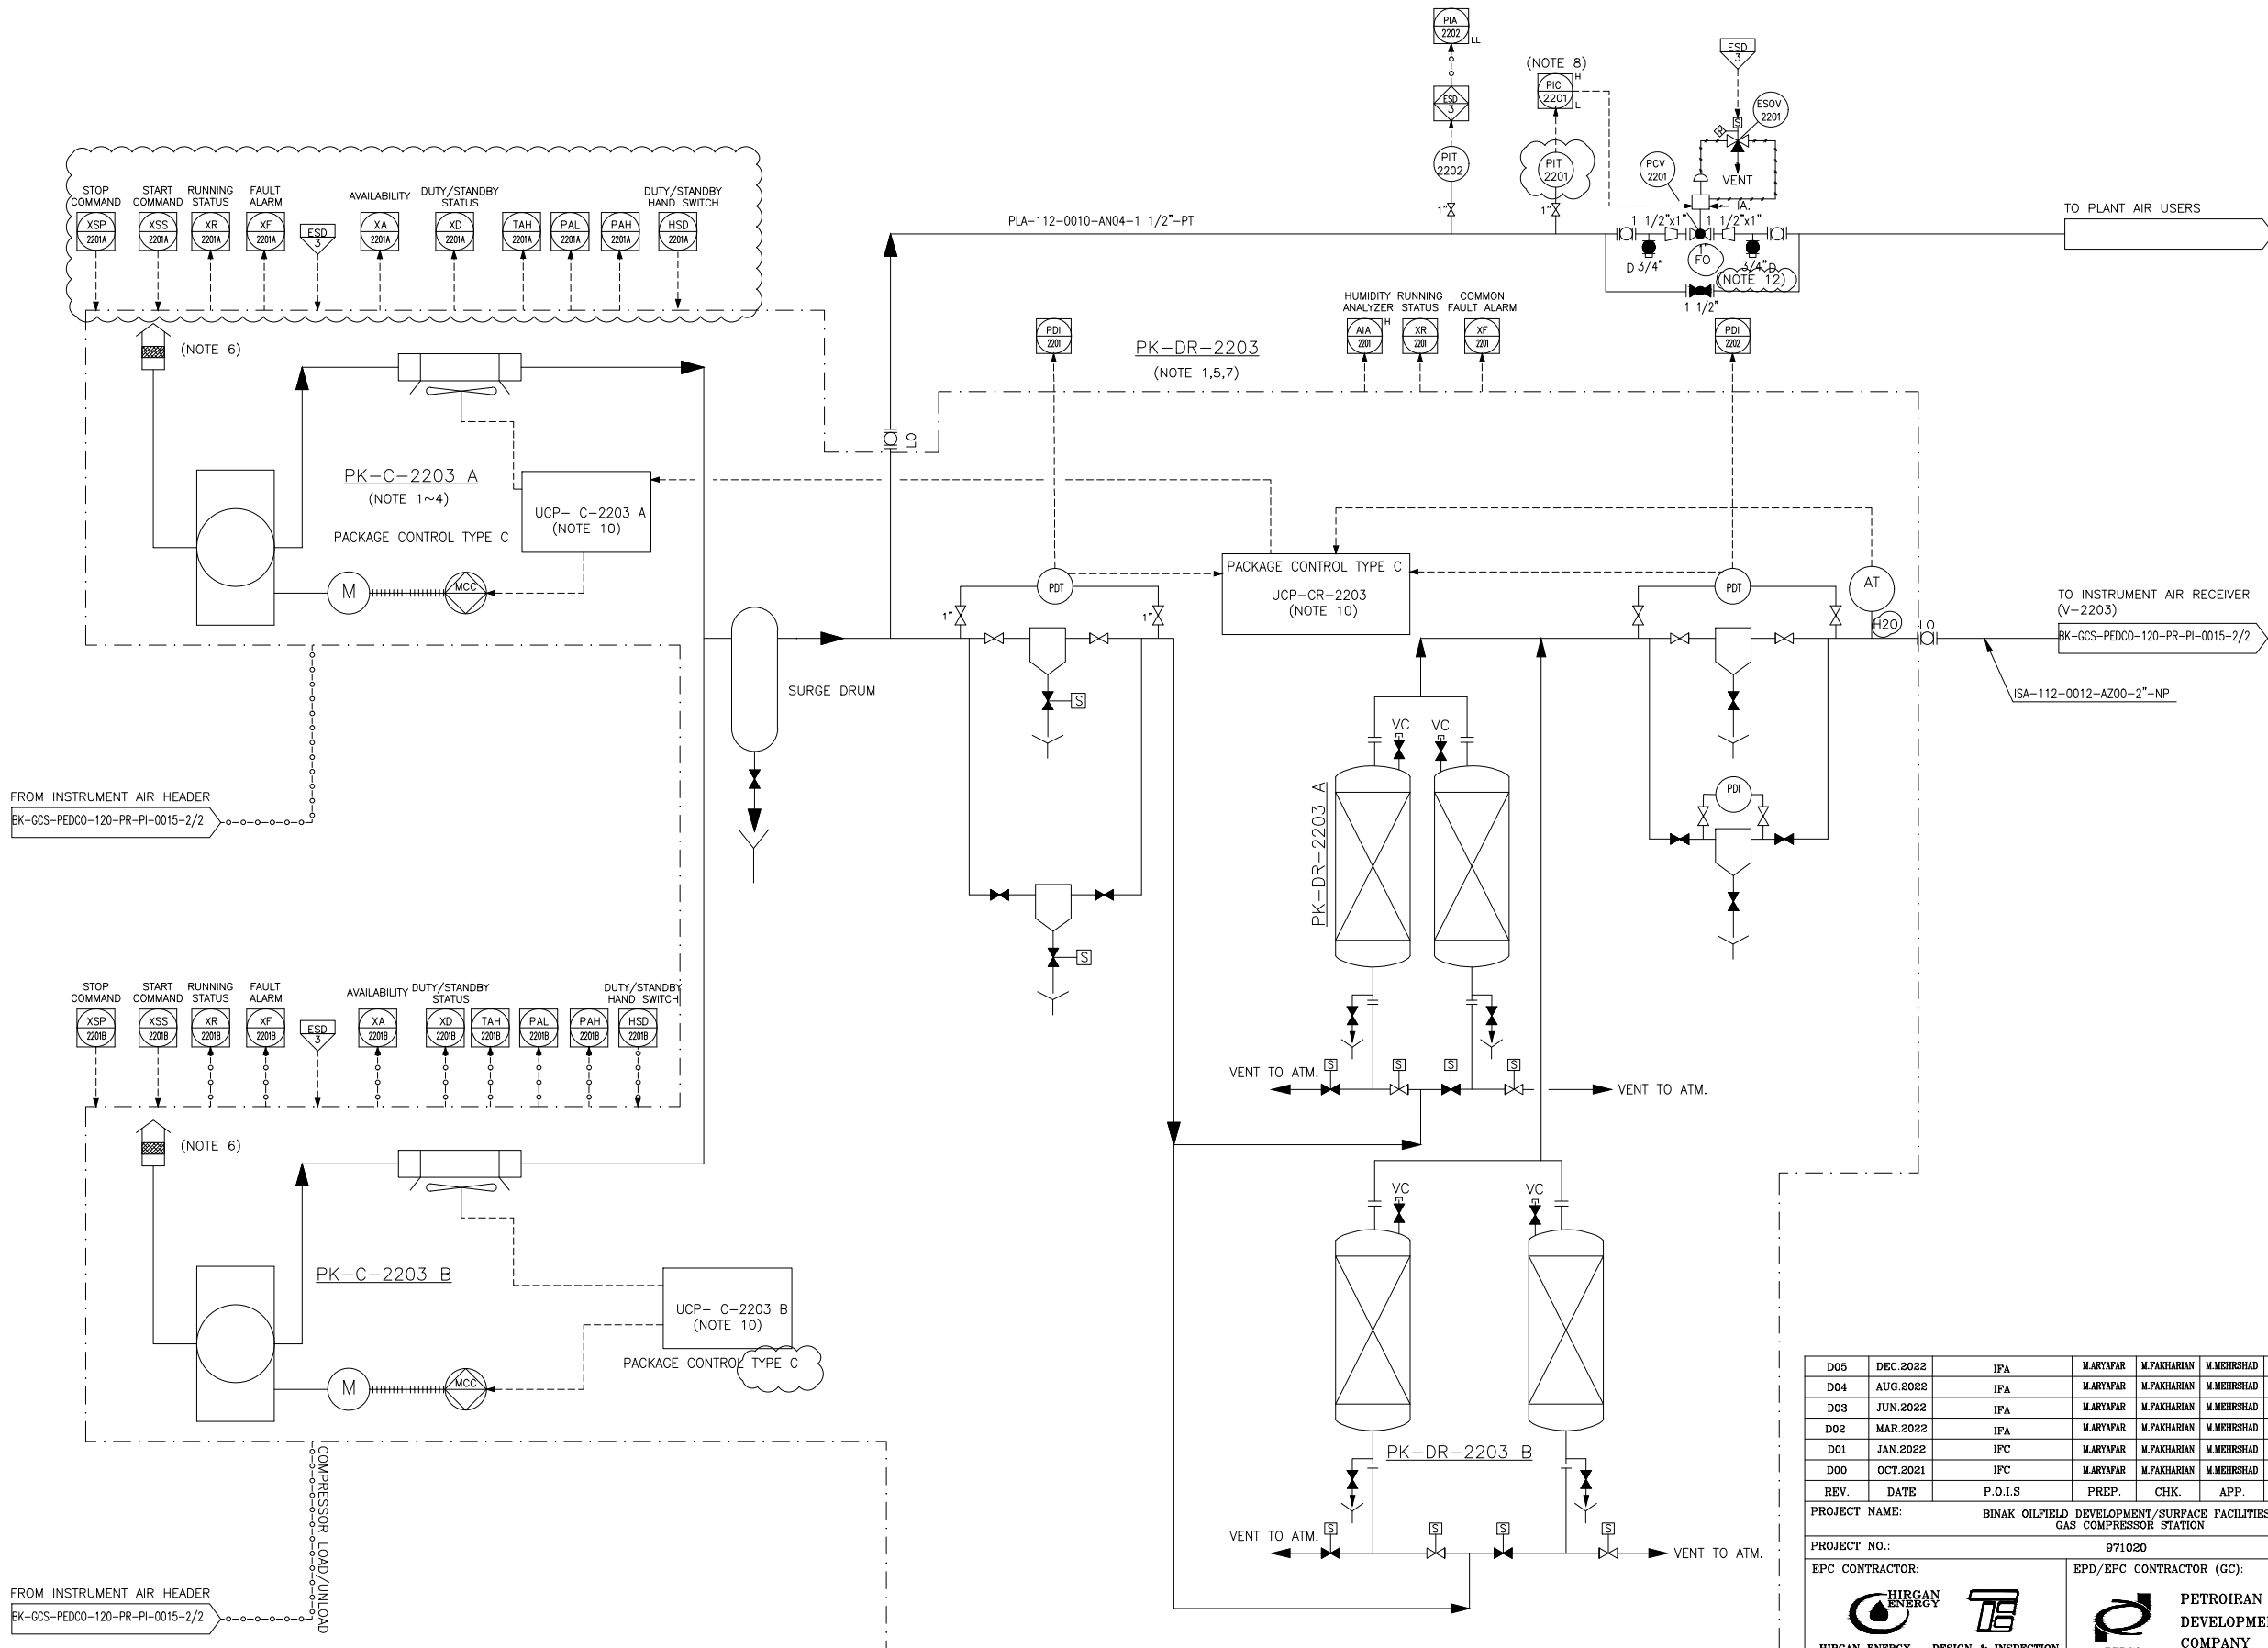

NOTES

- 1- ALL EQUIPMENT AND INSTRUMENTATION INSIDE PACKAGE ARE IN THE VENDOR SCOPE OF WORK. LOCAL CONTROL PANEL FOR EACH TRAIN TO BE CONSIDERED AS PER SPECIFICATION.
- 2- THE STANDBY COMPRESSOR WILL AUTOMATICALLY START BEFORE LOW LOW PRESSURE.
- 3- MOTOR SHALL BE CONTROLLED AND MONITORED BY PACKAGE CONTROL PANEL.
- 4- AIR INTAKE FILTER SHOULD BE SPECIFIED BY VENDOR IN THE AIR COMPRESSOR PACKAGE.
- 5- DETAILS OF AIR DRYER PACKAGE IS ONLY SHOWN INDICATIVELY, SIZE & MATERIAL WILL BE FINALIZED BY VENDOR.
- 6- AIR INTAKE FILTER SHOULD BE SPECIFIED BY VENDOR IN THE AIR COMPRESSOR PACKAGE.
- 7- 20% EXCESS DRY AIR IS CONSIDERED FOR DRYER.
- 8- SET POINT OF PALL-2202 ON THE PLANT AIR LINE IS EQUAL TO THE SET POINT OF PAL-2203 ON THE INSTRUMENT AIR LINE. THEREFORE, IF PALL IS OCCURRED IN THE INSTRUMENT AIR LINE, PCV-2201 ON THE PLANT AIR LINE WILL BE CLOSED.
- 9- EACH COMPRESSOR HAS DEDICATED LOCALLY MONTED UCP FOR EACH TRAIN, DRYER HAS LCP CONNECTED TO PLANT DCS BY HARDWARE.
- 10- TYPE C, (LOCATED IN COMPRESSOR AREA) COMMON FOR COMPRESSORS AND DRYER SHALL BE PROVIDED BY VENDOR FOR COMPLETE ELECTRICALLY/CONTROL ACTION REQUIRED.
- 11- MOTOR STARTER SHALL BE CONSIDERED IN LOCAL CONTROL PANEL ON PACKAGE SKID BY MANUFACTURER.
- 12- CONTROL VALVE SIZING WILL BE FINALIZED BY VENDOR.

GENERAL NOTE

LEGEND

REFERENCE DRAWING	DRG. No.
Utility Flow Diagram	BK-GCS-PEDCO-120-PR-UF-0001
Symbol & Legend For PFD & P&ID	BK-GCS-PEDCO-120-PR-PI-0001

KEY PLAN

D05	DEC.2022	IPA	M.ARYAPAR	M.PAKHARIAN	M.MEHRSHAD	** **						
D04	AUG.2022	IPA	M.ARYAPAR	M.PAKHARIAN	M.MEHRSHAD	** **						
D03	JUN.2022	IPA	M.ARYAPAR	M.PAKHARIAN	M.MEHRSHAD	** **						
D02	MAR.2022	IPA	M.ARYAPAR	M.PAKHARIAN	M.MEHRSHAD	** **						
D01	JAN.2022	IPC	M.ARYAPAR	M.PAKHARIAN	M.MEHRSHAD	** **						
D00	OCT.2021	IPC	M.ARYAPAR	M.PAKHARIAN	M.MEHRSHAD	** **						

REV.	DATE	P.O.I.S	PREP.	CHK.	APP.	AUT.	DESCRIPTION	CHECKED	REV.	APPR.
REV.	DATE	P.O.I.S	PREP.	CHK.	APP.	AUT.	DESCRIPTION	CHECKED	REV.	APPR.
اصل و کلیه نسخ این نقشه و حق اقتباس متعلق به شرکت ملی مناطق نفت خیز جنوب می باشد.
THE ORIGINAL AND ALL COPIES OF THIS DRAWING TOGETHER WITH THE COPYRIGHT THEREIN ARE THE SOLE PROPERTY OF N.I.S.O.C./ FIELDS


DATE	SCALE	DRAWING BY	CHECKED BY	PROJECT ENG.
DATE	SCALE	DRAWING BY	CHECKED BY	PROJECT ENG.
(VENDOR TITLE BLOCK)**

V-2203
INSTRUMENT AIR RECEIVER

DIMENSION (ID X TL-TL) : 1500 X 5000 mm
DESIGN TEMP. : 85 °C
DESIGN PRESS. : 12.5 barg

TRIM LINE : TRM-V-2203-0507-AZ00-NP

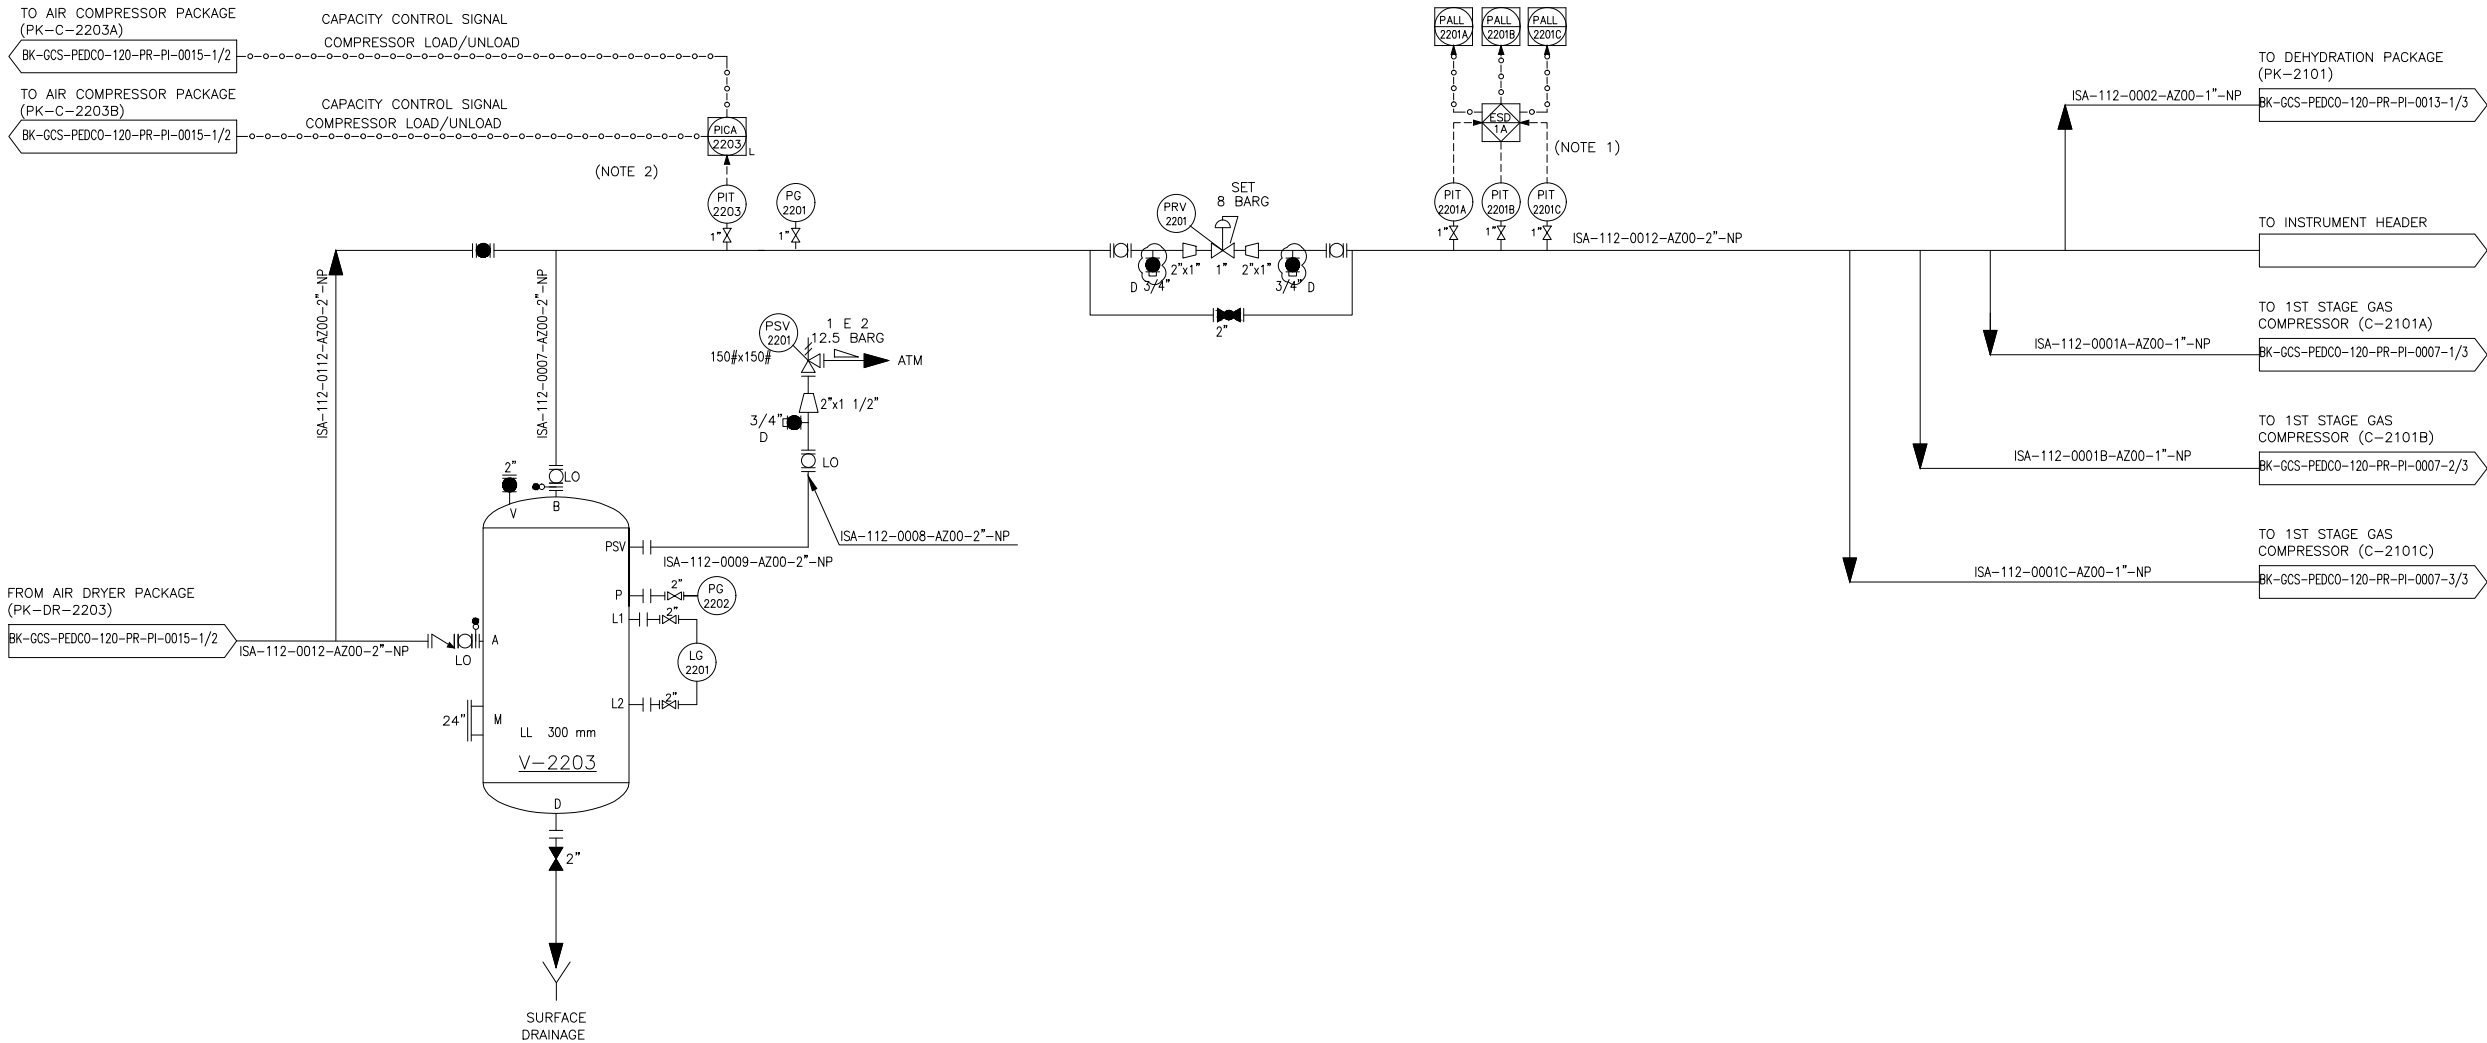

NOTES

- 1- 2 OF 3 VOTING FOR SYSTEM SHUTDOWN.
- 2- PRESSURE TRANSMITTER WILL START STANDBY COMPRESSOR ON LOW PRESSURE OF DUTY COMPRESSOR.
- 3-PARTIAL STROK DEVICE TO BE CONSIDERED FOR ALL ESDV'S ACTIVATED BY ESD 1,0.

GENERAL NOTE

LEGEND

REFERENCE DRAWING	DRG. No.
Utility Flow Diagram	BK-GCS-PEDCO-120-PR-UP-0001
Symbol & Legend For PFD & P&ID	BK-GCS-PEDCO-120-PR-PI-0001

KEY PLAN

D05	DEC.2022	IPA	M.ARYAPAR	M.PAKHARIAN	M.MEHRSHAD	** **							
D04	AUG.2022	IPA	M.ARYAPAR	M.PAKHARIAN	M.MEHRSHAD	** **							
D03	JUN.2022	IPA	M.ARYAPAR	M.PAKHARIAN	M.MEHRSHAD	** **							
D02	MAR.2022	IPA	M.ARYAPAR	M.PAKHARIAN	M.MEHRSHAD	** **							
D01	JAN.2022	IPC	M.ARYAPAR	M.PAKHARIAN	M.MEHRSHAD	** **							
D00	OCT.2021	IPC	M.ARYAPAR	M.PAKHARIAN	M.MEHRSHAD	** **							
REV.	DATE	P.O.I.S	PREP.	CHK.	APP.	AUT.	DESCRIPTION	CHECKED	REV.	APPR.			
PROJECT NAME:							BINAK OILFIELD DEVELOPMENT/SURFACE FACILITIES GAS COMPRESSOR STATION						
PROJECT NO.:							971020						
EPC CONTRACTOR:							EPD/EPC CONTRACTOR (GC):						
 HIRGAN ENERGY - DESIGN & INSPECTION COMPANIES							 PETROIRAN DEVELOPMENT COMPANY						
DRAWING TITLE:							P&ID - INSTRUMENT & PLANT AIR SYSTEM						
SCALE							NO CONSTRUCTION PERMITTED UNLESS DRAWING APPROVED						
BUDGET REF.							APPROVED FOR CONSTRUCTION						
LOCATION							BY:						
SIZE							DATE:						
CLASS							SHEET						
REVISION							REVISION						
NS	A3	BK-GCS-PEDCO-120-PR-PI-0015		2 OF 2	D05	053-073-9184	F	2	A	708793	2 OF 2	D05	