

V-2205
FUEL GAS K.O. DRUM

DIMENSION (ID X TL-TL) : 438 X 2950 mm
DESIGN TEMP. : 85 °C
DESIGN PRESS. : FV/9 barg

TRIM LINE : TRM-V-2205-0504-AN07-PT

FROM CORROSION INHIBITOR PUMPS (P-2207A/B)


BK-GCS-PEDCO-120-PR-PI-0018-1/1

CHM-112-0020-AS00-3/4"-NP

FROM INLET K.O. DRUM (V-2105)

BK-GCS-PEDCO-120-PR-PI-0005-1/1

GAS-111-0004-AN07-3"-PT

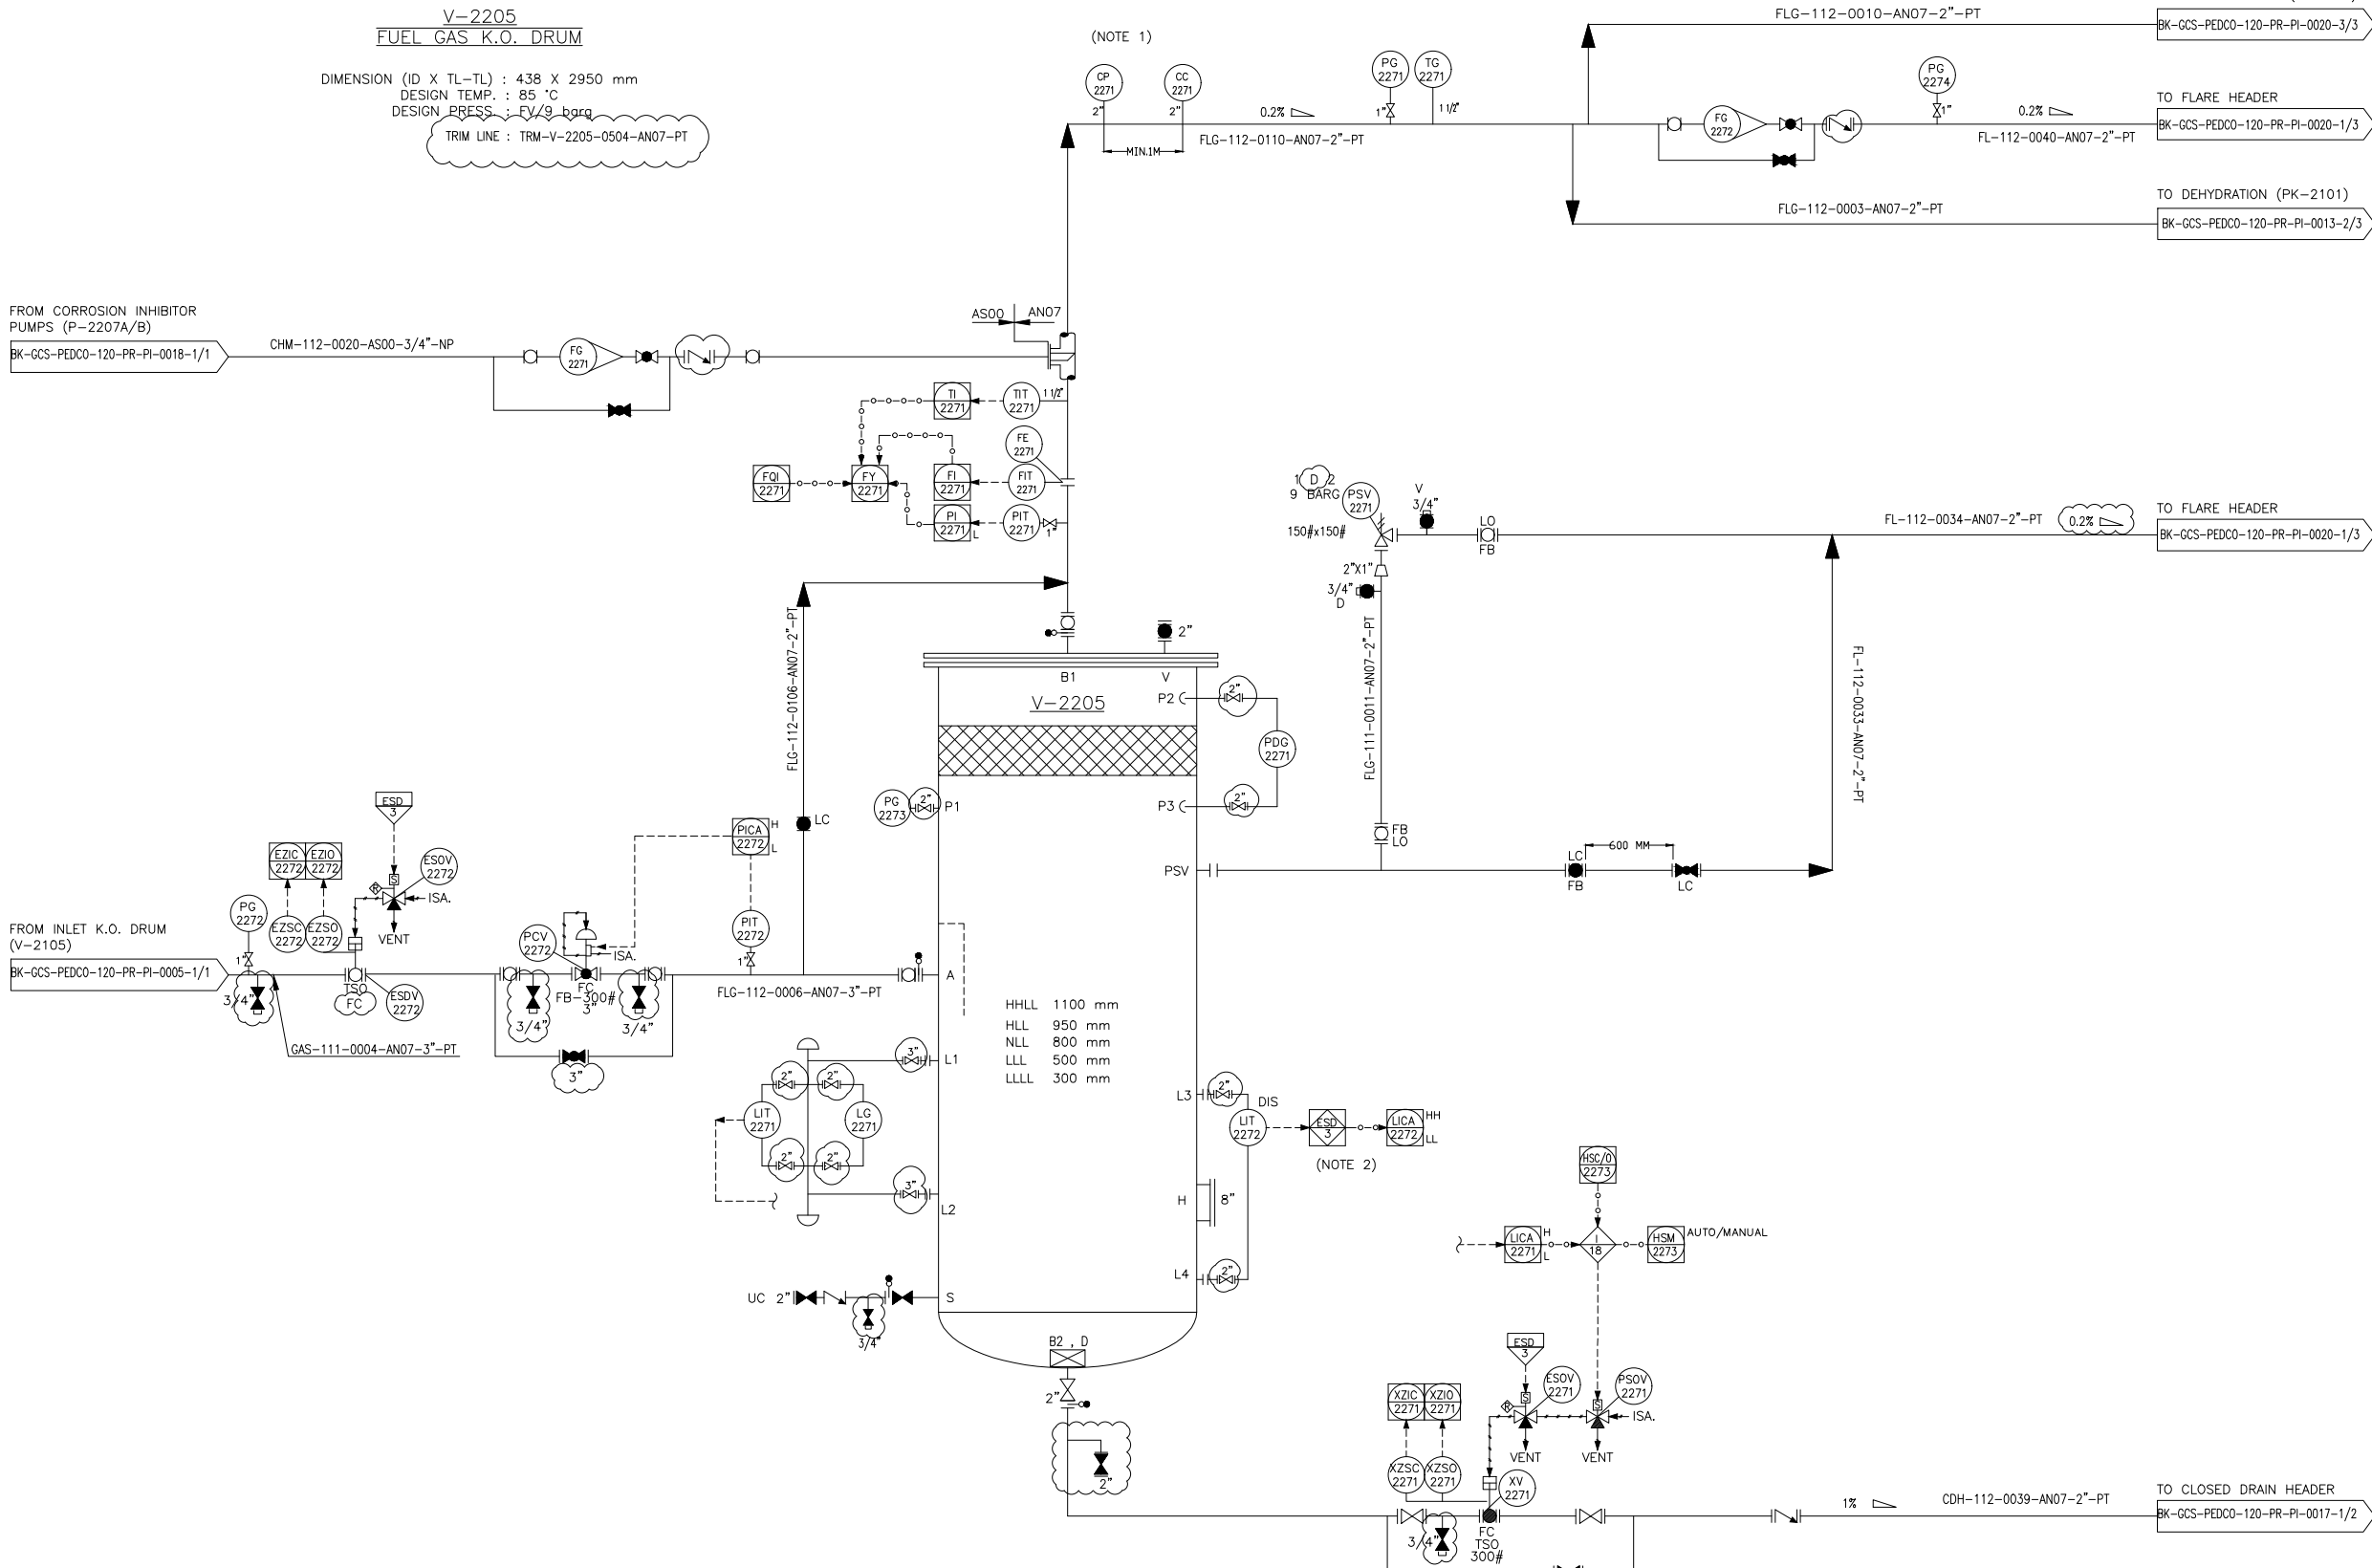

(NOTE 1)

(NOTE 2)

NOTES

- 1-ONE PORTABLE METER FOR CORROSION PROBES TO BE PROVIDED PER SITE TO RECOVERY MONITOR CORROSION DATA.
- 2- ESD LEVEL 3 FOR HH & LL ALARM LIQUID LEVEL.
- 3-CONTROL VALVE SIZING WILL BE FINALIZED BY VENDOR.
- 4-PARTIAL STROK DEVICE TO BE CONSIDERED FOR ALL ESDV'S ACTIVATED BY ESD 1.0.

GENERAL NOTE

LEGEND

REFERENCE DRAWING	DRG. No.
Utility Flow Diagram	BK-GCS-PEDCO-120-PR-UF-0001
Symbol & Legend For PFD & P&ID	BK-GCS-PEDCO-120-PR-PI-0001

KEY PLAN

REV.	DATE	P.O.I.S	PREP.	CHK.	APP.	AUT.
D05	DEC.2022	IFA	M.ARYAPAR	M.PAKHARIAN	M.MBHRSHAD	**
D04	AUG.2022	IFA	M.ARYAPAR	M.PAKHARIAN	M.MBHRSHAD	**
D03	JUN.2022	IFA	M.ARYAPAR	M.PAKHARIAN	M.MBHRSHAD	**
D02	FEB.2022	IFA	M.ARYAPAR	M.PAKHARIAN	M.MBHRSHAD	**
D01	JAN.2022	IFA	M.ARYAPAR	M.PAKHARIAN	M.MBHRSHAD	**
D00	OCT.2021	IFC	M.ARYAPAR	M.PAKHARIAN	M.MBHRSHAD	**

REV.	DATE	DESCRIPTION	BY	DATE	BY	DATE
***	*****	***	*****	**	*****	***
REV.	DESCRIPTION	CHECKED	REV.	APPR.		

اسم و کلیه نسخ این نقشه و حق اقتباس متعلق به شرکت ملی مناطق نفت خیز جنوب میباشد.
THE ORIGINAL AND ALL COPIES OF THIS DRAWING TOGETHER WITH THE COPYRIGHT THEREIN ARE THE SOLE PROPERTY OF N.I.S.O.C./ FIELDS

PROJECT NAME: BINAK OILFIELD DEVELOPMENT/SURFACE FACILITIES GAS COMPRESSOR STATION

PROJECT NO.: 971020

EPC CONTRACTOR: HIRGAN ENERGY

EPD/EPC CONTRACTOR (GC): PETROIRAN DEVELOPMENT COMPANY

DATE	SCALE	DRAWING BY	CHECKED BY	PROJECT ENG.

DRAWING TITLE: P&ID - FUEL GAS SYSTEM

(VENDOR TITLE BLOCK)**

SCALE	SIZE	DRAWING NO.	SHEET NO.	REV.	BUDGET REF.	LOCATION	SIZE CLASS	SERIAL NO.	SHEET	REVISION
NS	A3	BK-GCS-PEDCO-120-PR-PI-0022	1 OF 1	D05	053-073-8194	F	2	A	708800	1 OF 1 D05