


TK-2209
POTABLE WATER TANK

DIMENSION (ID X TL-TL) : 3500 X 2600 mm
NOMINAL CAPACITY : 25 m³
DESIGN TEMP. : 85 °C
DESIGN PRESS. : ATM + FULL OF WATER

TRIM LINE : TRM-TK-2209-0507-AZ00-NP

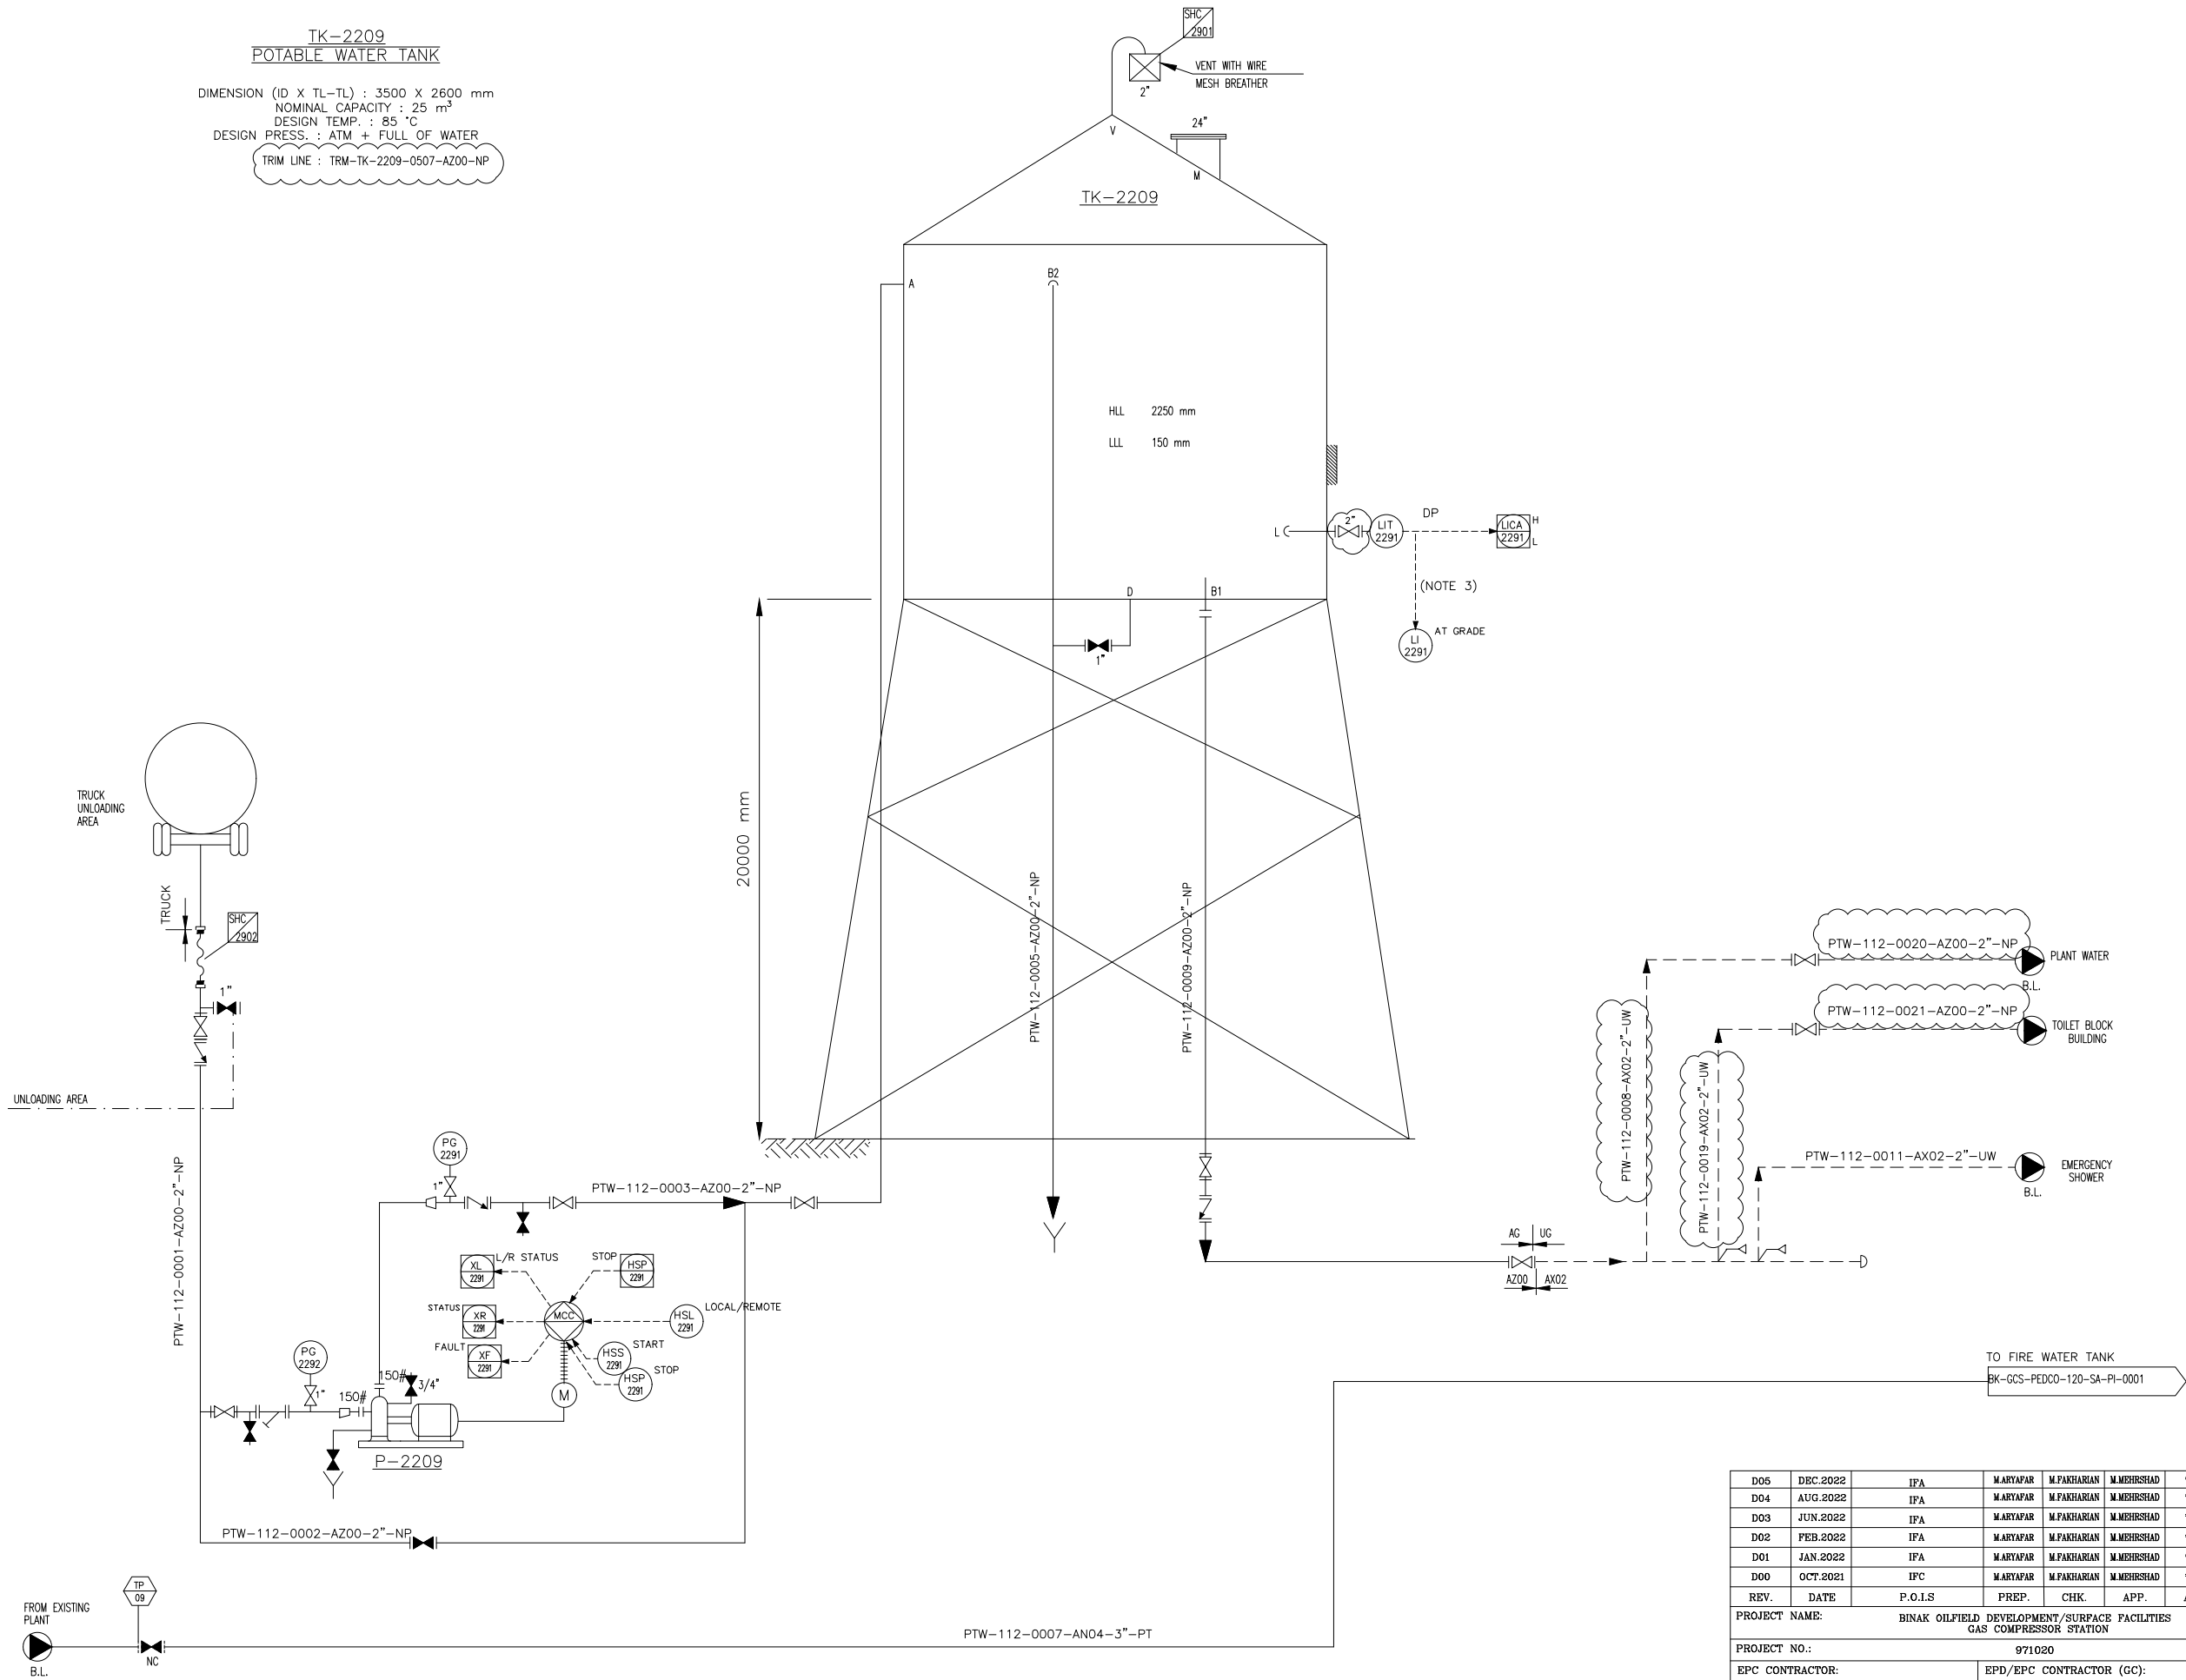

P-2209
POTABLE WATER PUMP

RATED CAPACITY : 5.5 m³/hr
DIFFERENTIAL PRESS. : 3 bar

NOTES

- 1- DELETED.
- 2- DELETED.
- 3- LI SHALL BE READABLE AT GROUND.
- 4-PARTIAL STROK DEVICE TO BE CONSIDERED FOR ALL ESDV'S ACTIVATED BY ESD 1.0.

GENERAL NOTE

LEGEND

REFERENCE DRAWING	DRG. No.
Utility Flow Diagram	BK-GCS-PEDCO-120-PR-UF-0001
Symbol & Legend For PFD & P&ID	BK-GCS-PEDCO-120-PR-PI-0001

KEY PLAN

D05	DEC.2022	IFA	M.ARYAPAR	M.FAKHARIAN	M.MEHRSHAD	** **									
D04	AUG.2022	IFA	M.ARYAPAR	M.FAKHARIAN	M.MEHRSHAD	** **									
D03	JUN.2022	IFA	M.ARYAPAR	M.FAKHARIAN	M.MEHRSHAD	** **									
D02	FEB.2022	IFA	M.ARYAPAR	M.FAKHARIAN	M.MEHRSHAD	** **	***	*****	** **	*** **	** **	*** **	*** **	*** **	*** **
D01	JAN.2022	IFA	M.ARYAPAR	M.FAKHARIAN	M.MEHRSHAD	** **	REV.	DESCRIPTION	BY	DATE	BY	DATE	BY	DATE	BY
D00	OCT.2021	IPC	M.ARYAPAR	M.FAKHARIAN	M.MEHRSHAD	** **									
REV.	DATE	P.O.I.S	PREP.	CHK.	APP.	AUT.	اصل و کلیه نسخ این نقشه و حق اقتباس متعلق به شرکت ملی مناطق نفت خیز جنوب میباشد.								
PROJECT NAME:							THE ORIGINAL AND ALL COPIES OF THIS DRAWING TOGETHER WITH THE COPYRIGHT THEREIN ARE THE SOLE PROPERTY OF N.I.S.O.C./ FIELDS								
PROJECT NO.:							BINAK OILFIELD DEVELOPMENT SURFACE FACILITIES GAS COMPRESSOR STATION								
EPC CONTRACTOR:							DATE								
EPD/EPC CONTRACTOR (GC):							SCALE								
DRAWING TITLE:							DRAWING BY								
NO CONSTRUCTION PERMITTED UNLESS DRAWING APPROVED							CHECKED BY								
APPROVED FOR CONSTRUCTION							PROJECT ENG.								
BY:							DATE:								
SCALE	SIZE	DRAWING NO.			SHEET NO.	REV.	BUDGET REF.	LOCATION	SIZE CLASS	SERIAL NO.	SHEET	REVISION			
NS	A3	BK-GCS-PEDCO-120-PR-PI-0024			1 OF 1	D05	053-073-9184	F	2	A	708802	1 OF 1	D05		