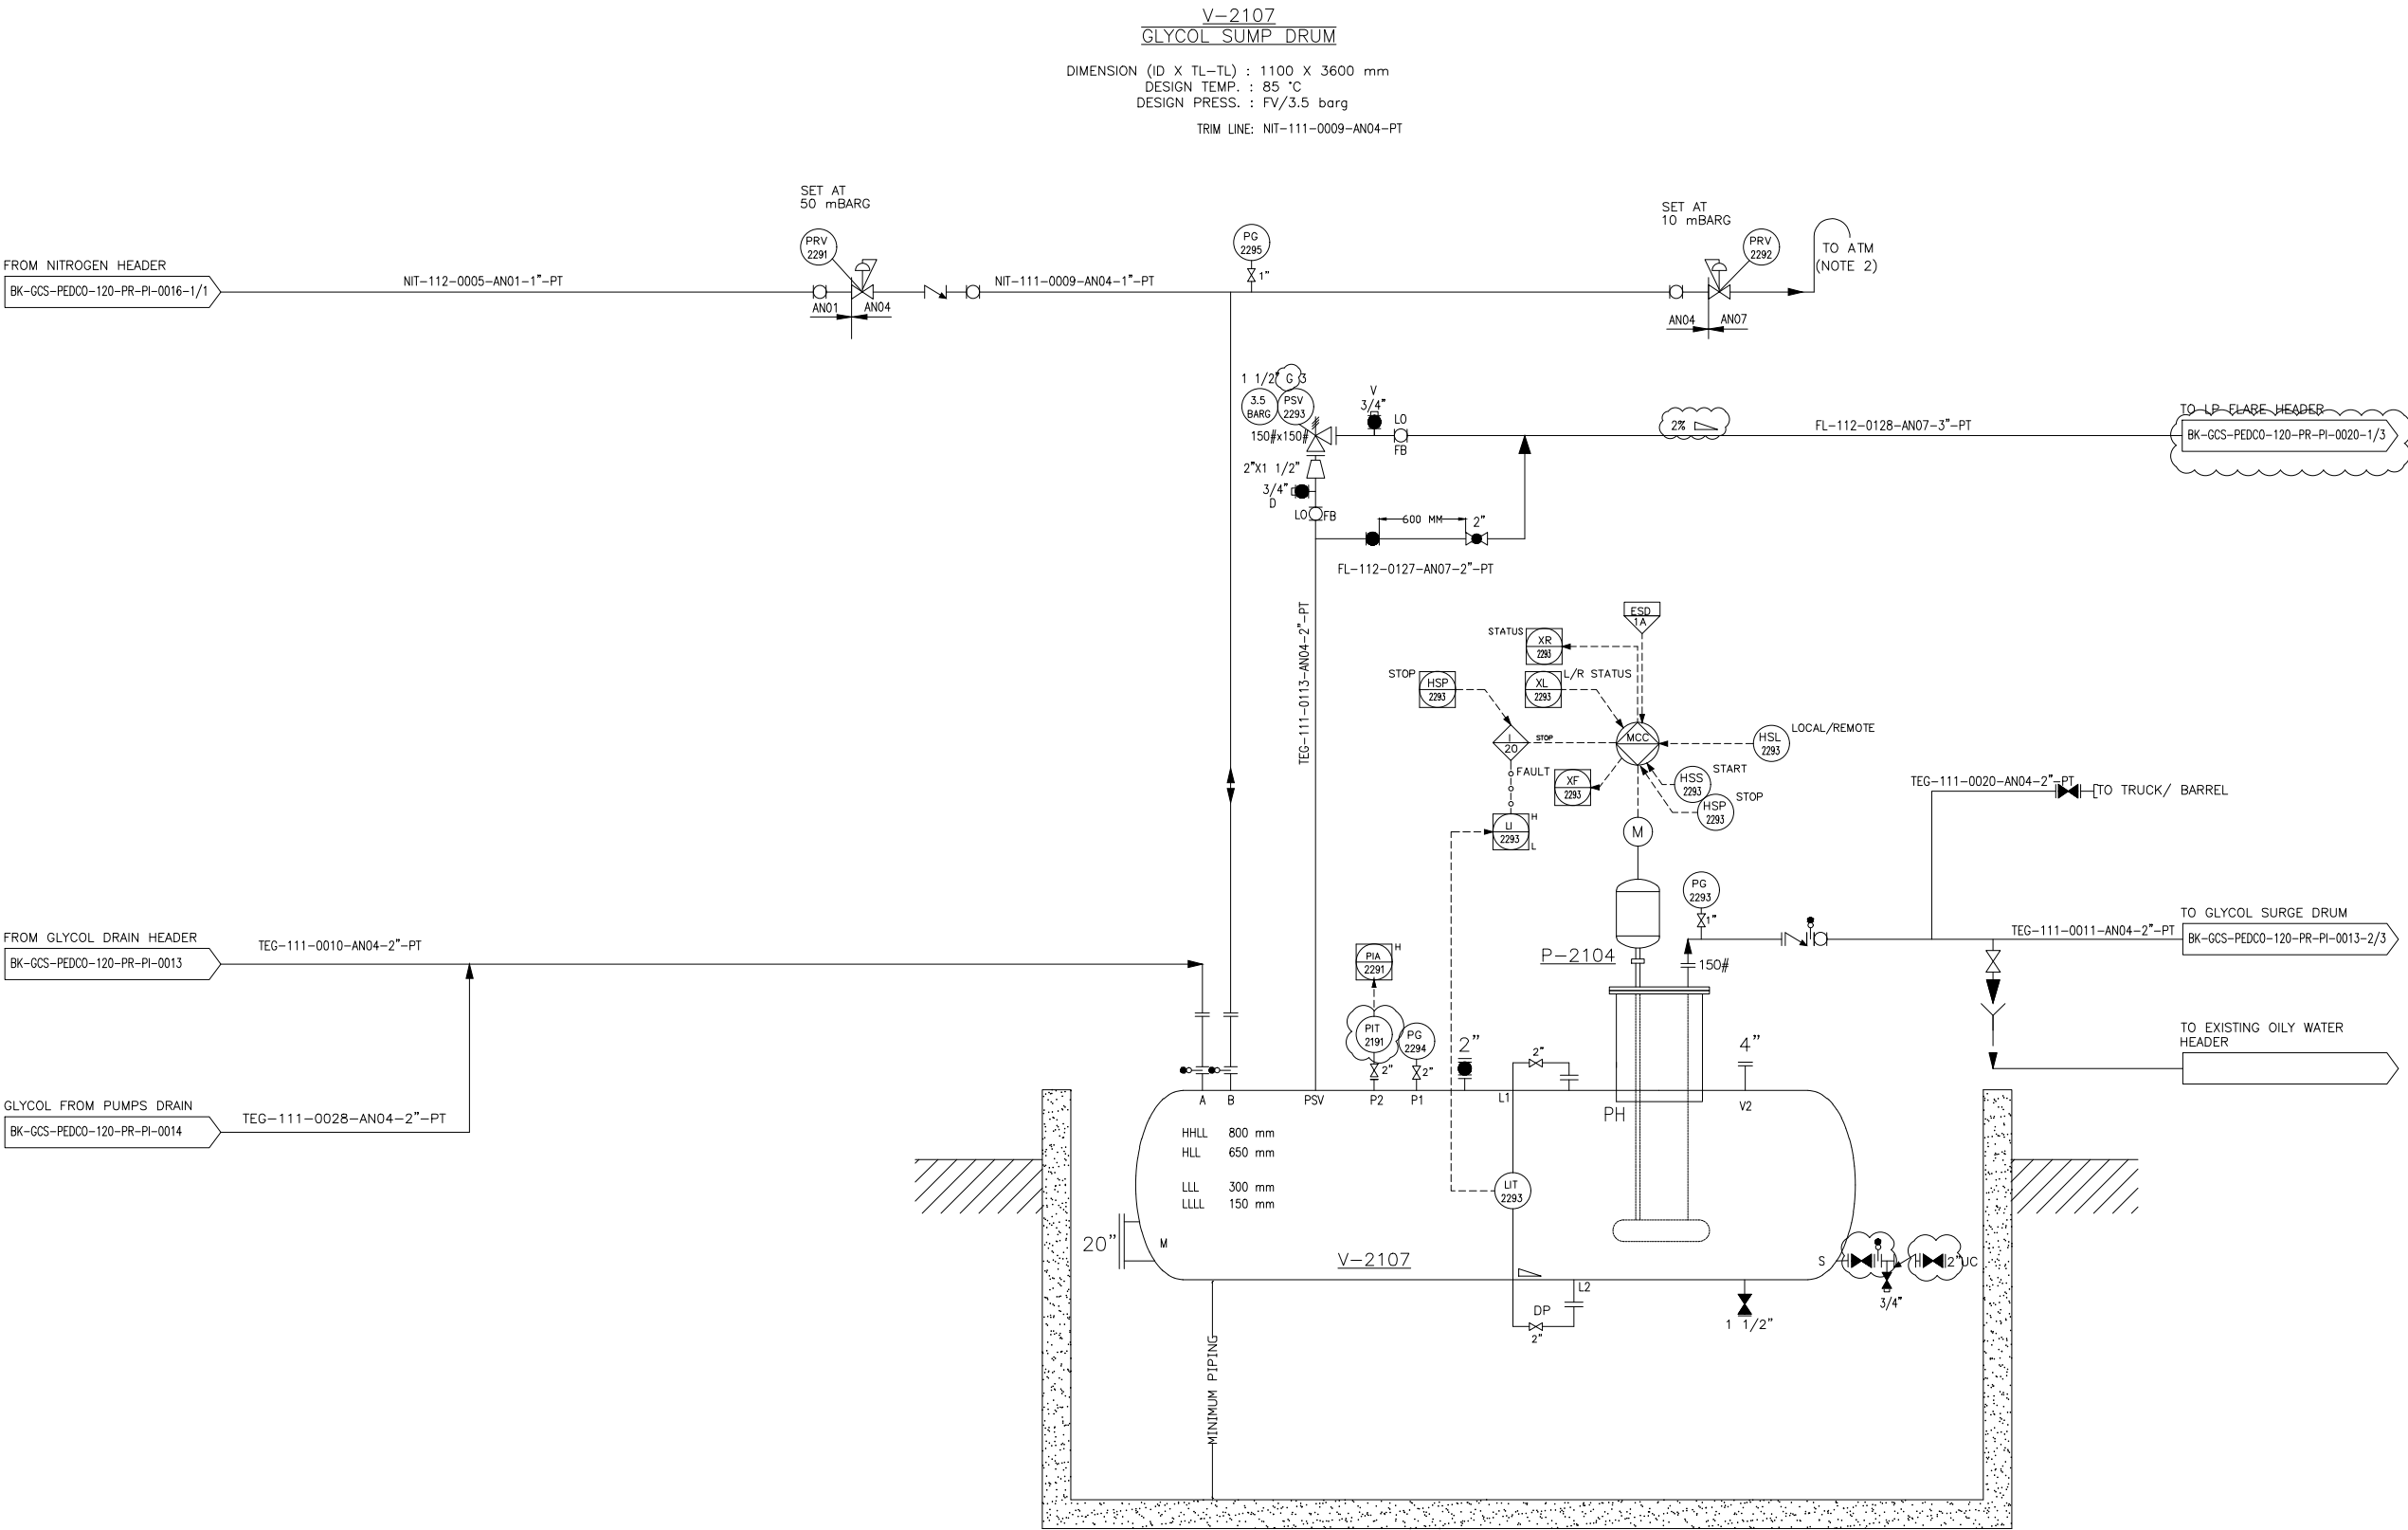


NOTES

1- GLYCOL SUMP DRUM ,FLARE K.O. DRUM, CLOSED DRAIN DRUM AND RELATED PUMPS ARE IN COMMON PIT.

2- DELETED.

3-PARTIAL STROK DEVICE TO BE CONSIDERED FOR ALL ESDV'S ACTIVATED BY ESD 1.0.

LEGEND

REFERENCE DRAWING	DRG. No.
Symbol & Legend For PFD and P&ID	BK-GCS-PEDCO-120-PR-PI-0001

KEY PLAN

D05	DEC.2022	IFA	M.ARYAPAR	M.PAKHARIAN	M.MEHRSHAD	** **									
D04	AUG.2022	IFA	M.ARYAPAR	M.PAKHARIAN	M.MEHRSHAD	** **									
D03	JUN.2022	IFA	M.ARYAPAR	M.PAKHARIAN	M.MEHRSHAD	** **									
D02	MAR.2022	IFA	M.ARYAPAR	M.PAKHARIAN	M.MEHRSHAD	** **									
D01	JAN.2022	IFA	M.ARYAPAR	M.PAKHARIAN	M.MEHRSHAD	** **									
D00	SEP.2021	IPC	M.ARYAPAR	M.PAKHARIAN	M.MEHRSHAD	** **	REV.	DESCRIPTION	BY	DATE	BY	DATE	REV.	APPR.	
REV. DATE P.O.I.S PREP. CHK. APP. AUT.							احل و کلیه نسخ این نقشه و حق اقتباس متعلق به شرکت ملی مناطق نفت خیز جنوب میباشد.								
PROJECT NAME: BINAK OILFIELD DEVELOPMENT/SURFACE FACILITIES GAS COMPRESSOR STATION							 THE ORIGINAL AND ALL COPIES OF THIS DRAWING TOGETHER WITH THE COPYRIGHT THEREIN ARE THE SOLE PROPERTY OF N.I.S.O.C./ FIELDS								
PROJECT NO.: 971020							BINAK OILFIELD DEVELOPMENT SURFACE FACILITIES GAS COMPRESSOR STATION								
EPC CONTRACTOR:  HIRGAN ENERGY - DESIGN & INSPECTION COMPANIES							EPD/EPC CONTRACTOR (GC):  PETROIRAN DEVELOPMENT COMPANY								
DRAWING TITLE: P&ID - GLYCOL SUMP DRUM							NO CONSTRUCTION PERMITTED UNLESS DRAWING APPROVED								
SCALE SIZE DRAWING NO. SHEET NO. REV.							APPROVED FOR CONSTRUCTION BY: DATE:								
NS A3 BK-GCS-PEDCO-120-PR-PI-0025 1 OF 1 D05							BUDGET REP. LOCATION SIZE CLASS SERIAL NO. SHEET REVISION								
							053-073-9184 F 2 A 708803 1 OF 1 D05								