


SU-2202
OILY WATER SUMP

DIMENSION (H X W X L) : 3000 X 4000 X 3000 mm

TRIM LINE : TRM-SU-2202-0501-AN01-PT

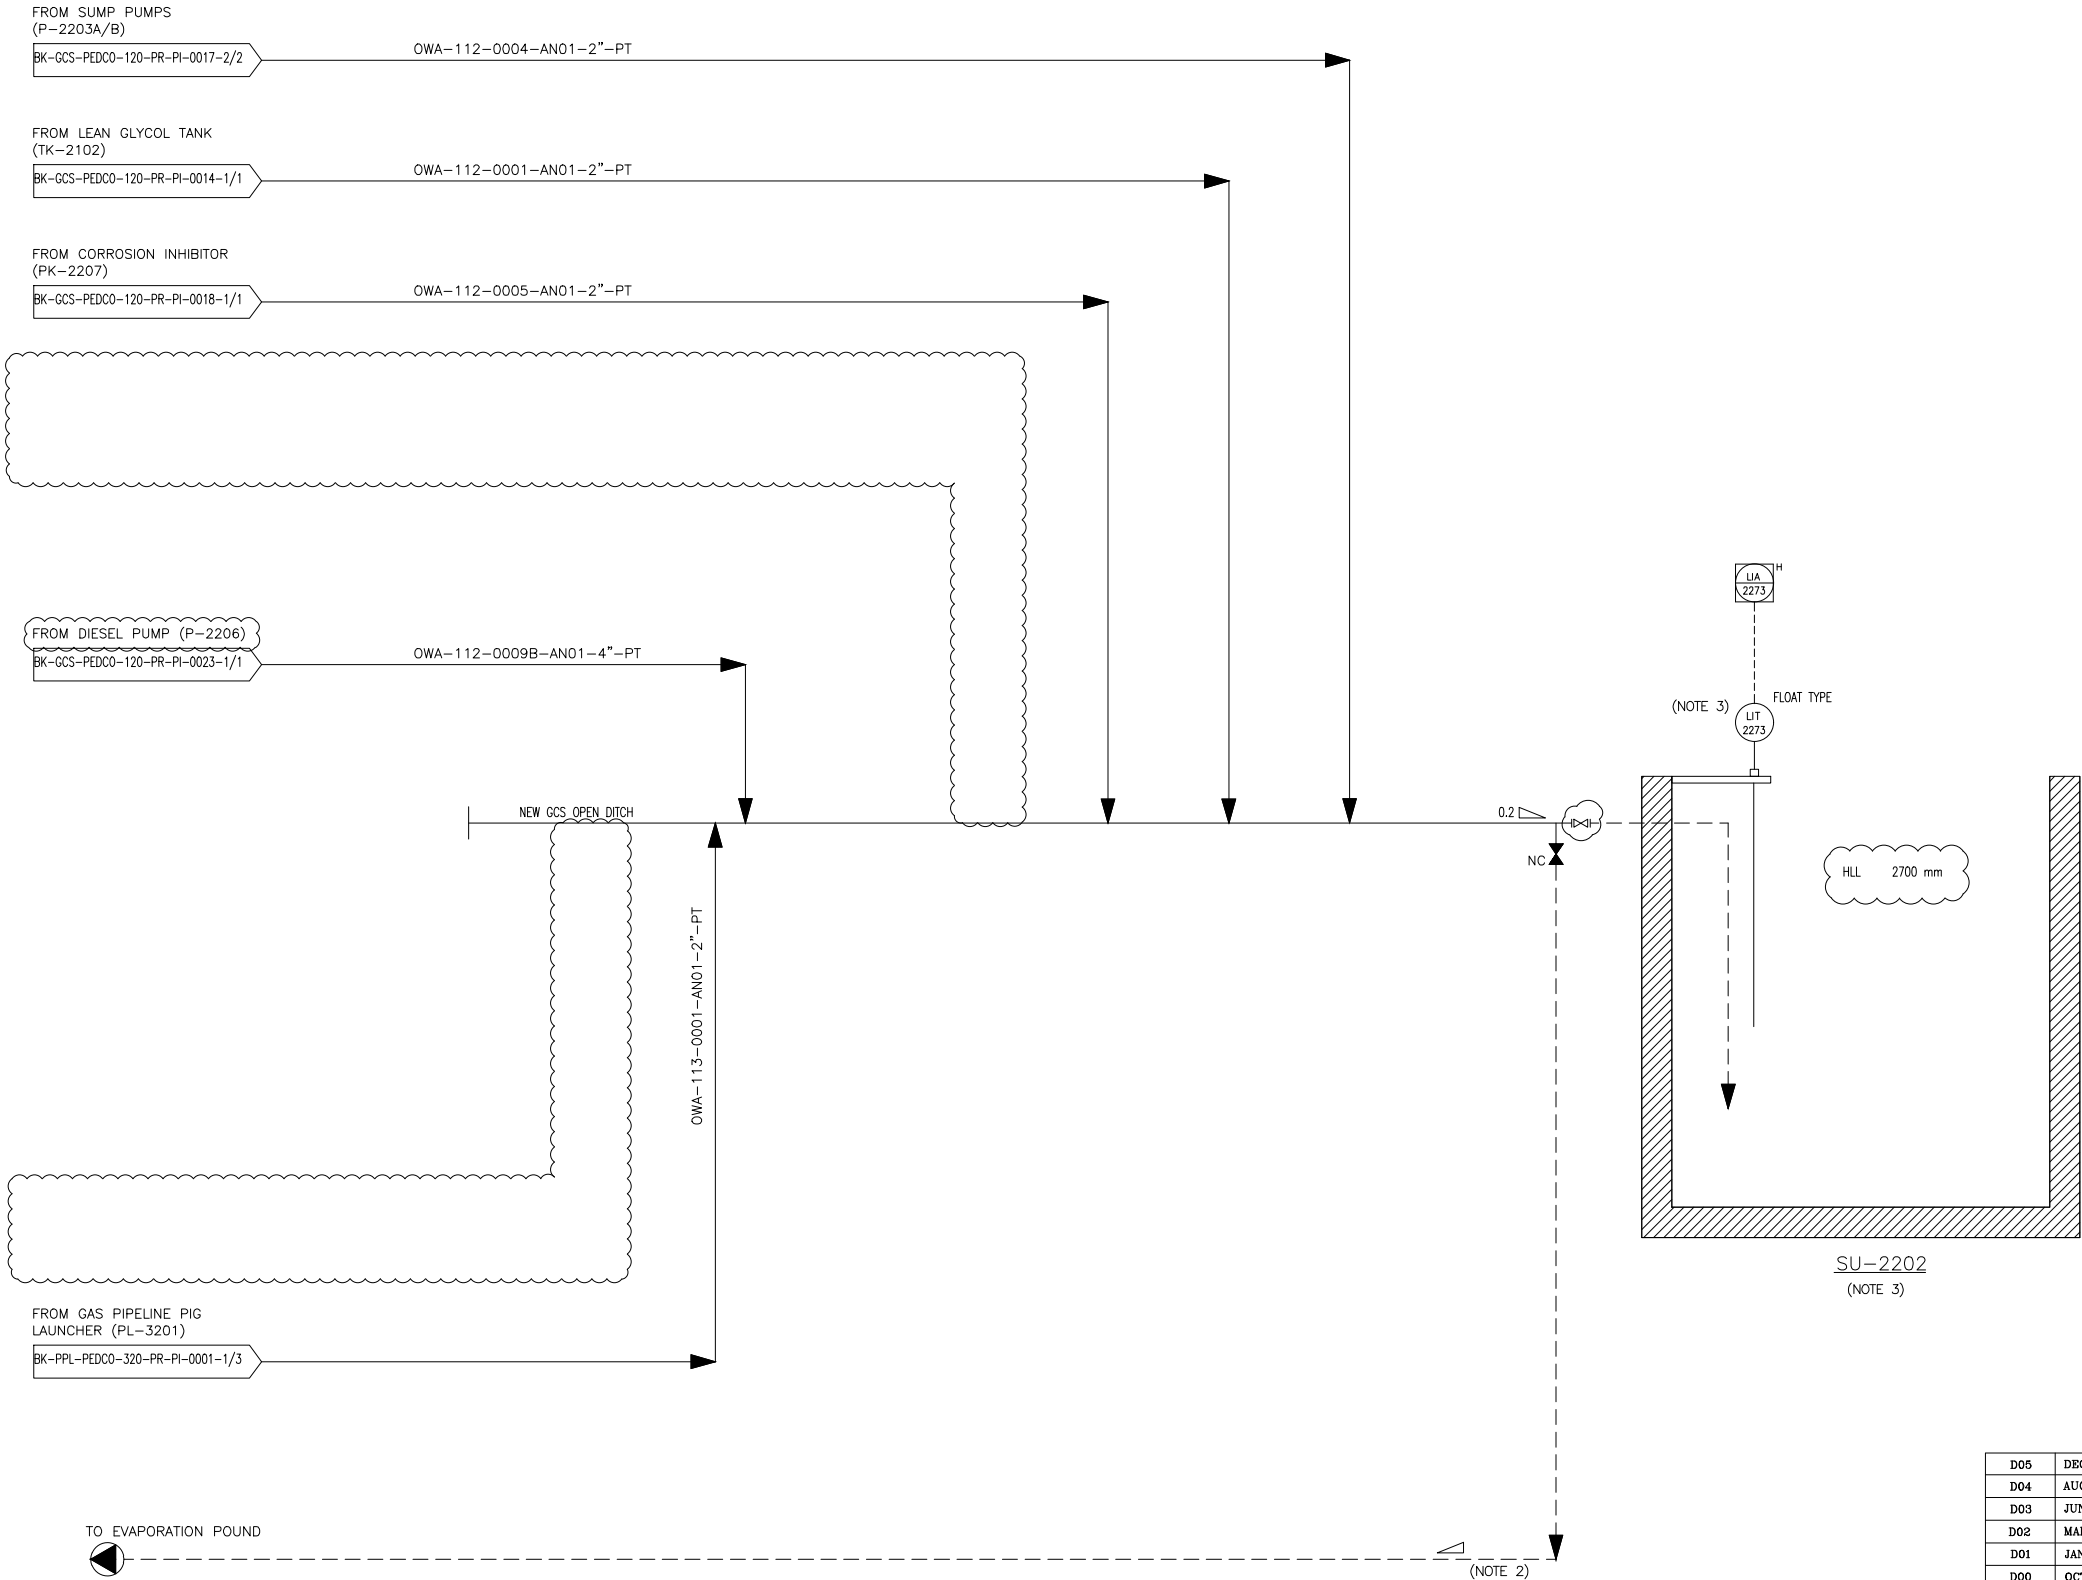

NOTES

- 1-DELETED.
- 2- IT IS ASSUMED THAT OILY WATER FROM PAVING AREA SHALL BE ROUTED TO NON-CONTAMINATED SEWER AFTER 15 MINUTES OF RAIN.
- 3- SU-2202 WILL BE UNLOADED BY PORTABLE PUMP (OUT OF SCOPE).
- 4- TOP MOUNTED FLOAT LEVEL TRANSMITTER WILL BE INSTALLED ON A PLATE AT SUMP GROUND LEVEL)NO PIPING CONNECTION REQUIRED.)
- 5-PARTIAL STROK DEVICE TO BE CONSIDERED FOR ALL ESDV'S ACTIVATED BY ESD 1,0.

GENERAL NOTE

LEGEND

REFERENCE DRAWING	DRG. No.
Utility Flow Diagram	BK-GCS-PEDCO-120-PR-UF-0001
Symbol & Legend For PFD & P&ID	BK-GCS-PEDCO-120-PR-PI-0001

KEY PLAN

D05	DEC.2022	APC	M.ARYAFAR	M.FAKHARIAN	M.MEHRSHAD	***								
D04	AUG.2022	IFA	M.ARYAFAR	M.FAKHARIAN	M.MEHRSHAD	***								
D03	JUN.2022	IFA	M.ARYAFAR	M.FAKHARIAN	M.MEHRSHAD	***								
D02	MAR.2022	IFA	M.ARYAFAR	M.FAKHARIAN	M.MEHRSHAD	***	***	*****	***	***.***	***	***.***		
D01	JAN.2022	IFA	M.ARYAFAR	M.FAKHARIAN	M.MEHRSHAD	***	REV.	DESCRIPTION	BY	DATE	BY	DATE		
D00	OCT.2021	IPC	M.ARYAFAR	M.FAKHARIAN	M.MEHRSHAD	***				CHECKED		REV.	APPR.	
REV.	DATE	P.O.I.S	PREP.	CHK.	APP.	AUT.	اصل و کلیه نسخ این نقشه و حق اقتباس متعلق به حق مناطق نفت خیز جنوب میباشد.							
PROJECT NAME:							BINAK OILFIELD DEVELOPMENT/SURFACE FACILITIES GAS COMPRESSOR STATION							
PROJECT NO.:							971020							
EPC CONTRACTOR:							EPD/EPC CONTRACTOR (GC):							
 HIRGAN ENERGY - DESIGN & INSPECTION COMPANIES							 PETROIRAN DEVELOPMENT COMPANY							
							BINAK OILFIELD DEVELOPMENT SURFACE FACILITIES GAS COMPRESSOR STATION							
							DATE	SCALE	DRAWING BY	CHECKED BY	PROJECT ENG.			
DRAWING TITLE:							NO CONSTRUCTION PERMITTED UNLESS DRAWING APPROVED							
P&ID - OILY WATER SEWER							APPROVED FOR CONSTRUCTION							
							BY:							
							DATE:							
SCALE	SIZE	DRAWING NO.			SHEET NO.	REV.	BUDGET REF.	LOCATION	SIZE	CLASS	SERIAL NO.	SHEET	REVISION	
NS	A3	BK-GCS-PEDCO-120-PR-PI-0021			1 OF 1	D05	053-073-9184	F	2	A	708799	1 OF 1	D05	