


DRAWING—W046S

[illegible]

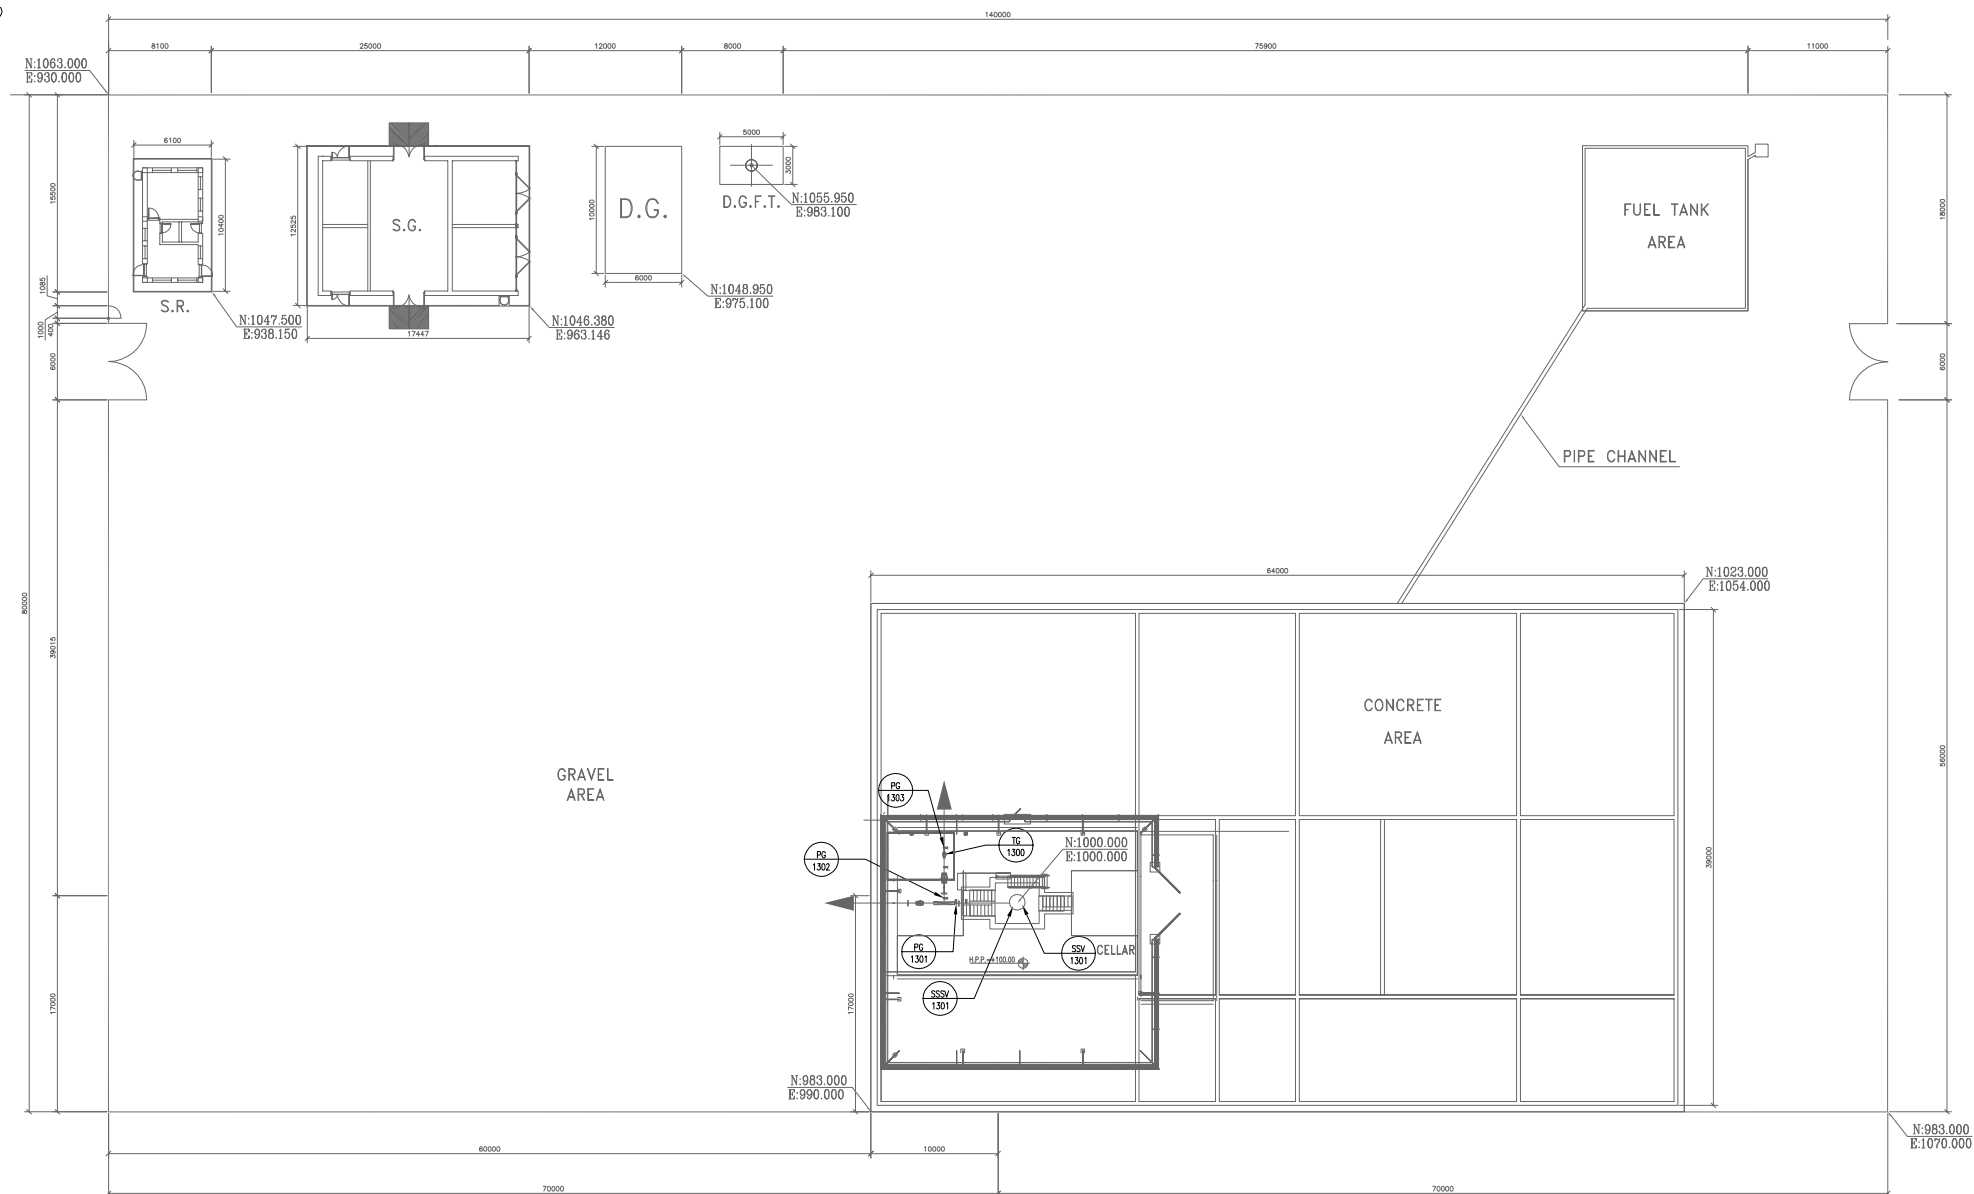

(VENDOR TITLE BLOCK)**

[illegible]

 D02

LEGEND

REFERENCE DRAWING	DRG. No.
P&ID-W046S	BK-W046S-PEDCO-110-PR-0001
PLOT PLAN DRAWING-W046S	BK-W046S-PEDCO-110-PI-PY-0001
PDMS MODEL REVIEW REPORT(60%) -W046	BK-W046-PEDCO-110-PI-RT-0001
DATA SHEETS FOR WHCP/HPU-WELLHEADS	BK-SSGR-PEDCO-110-IN-IT-0001

KEY PLAN

