
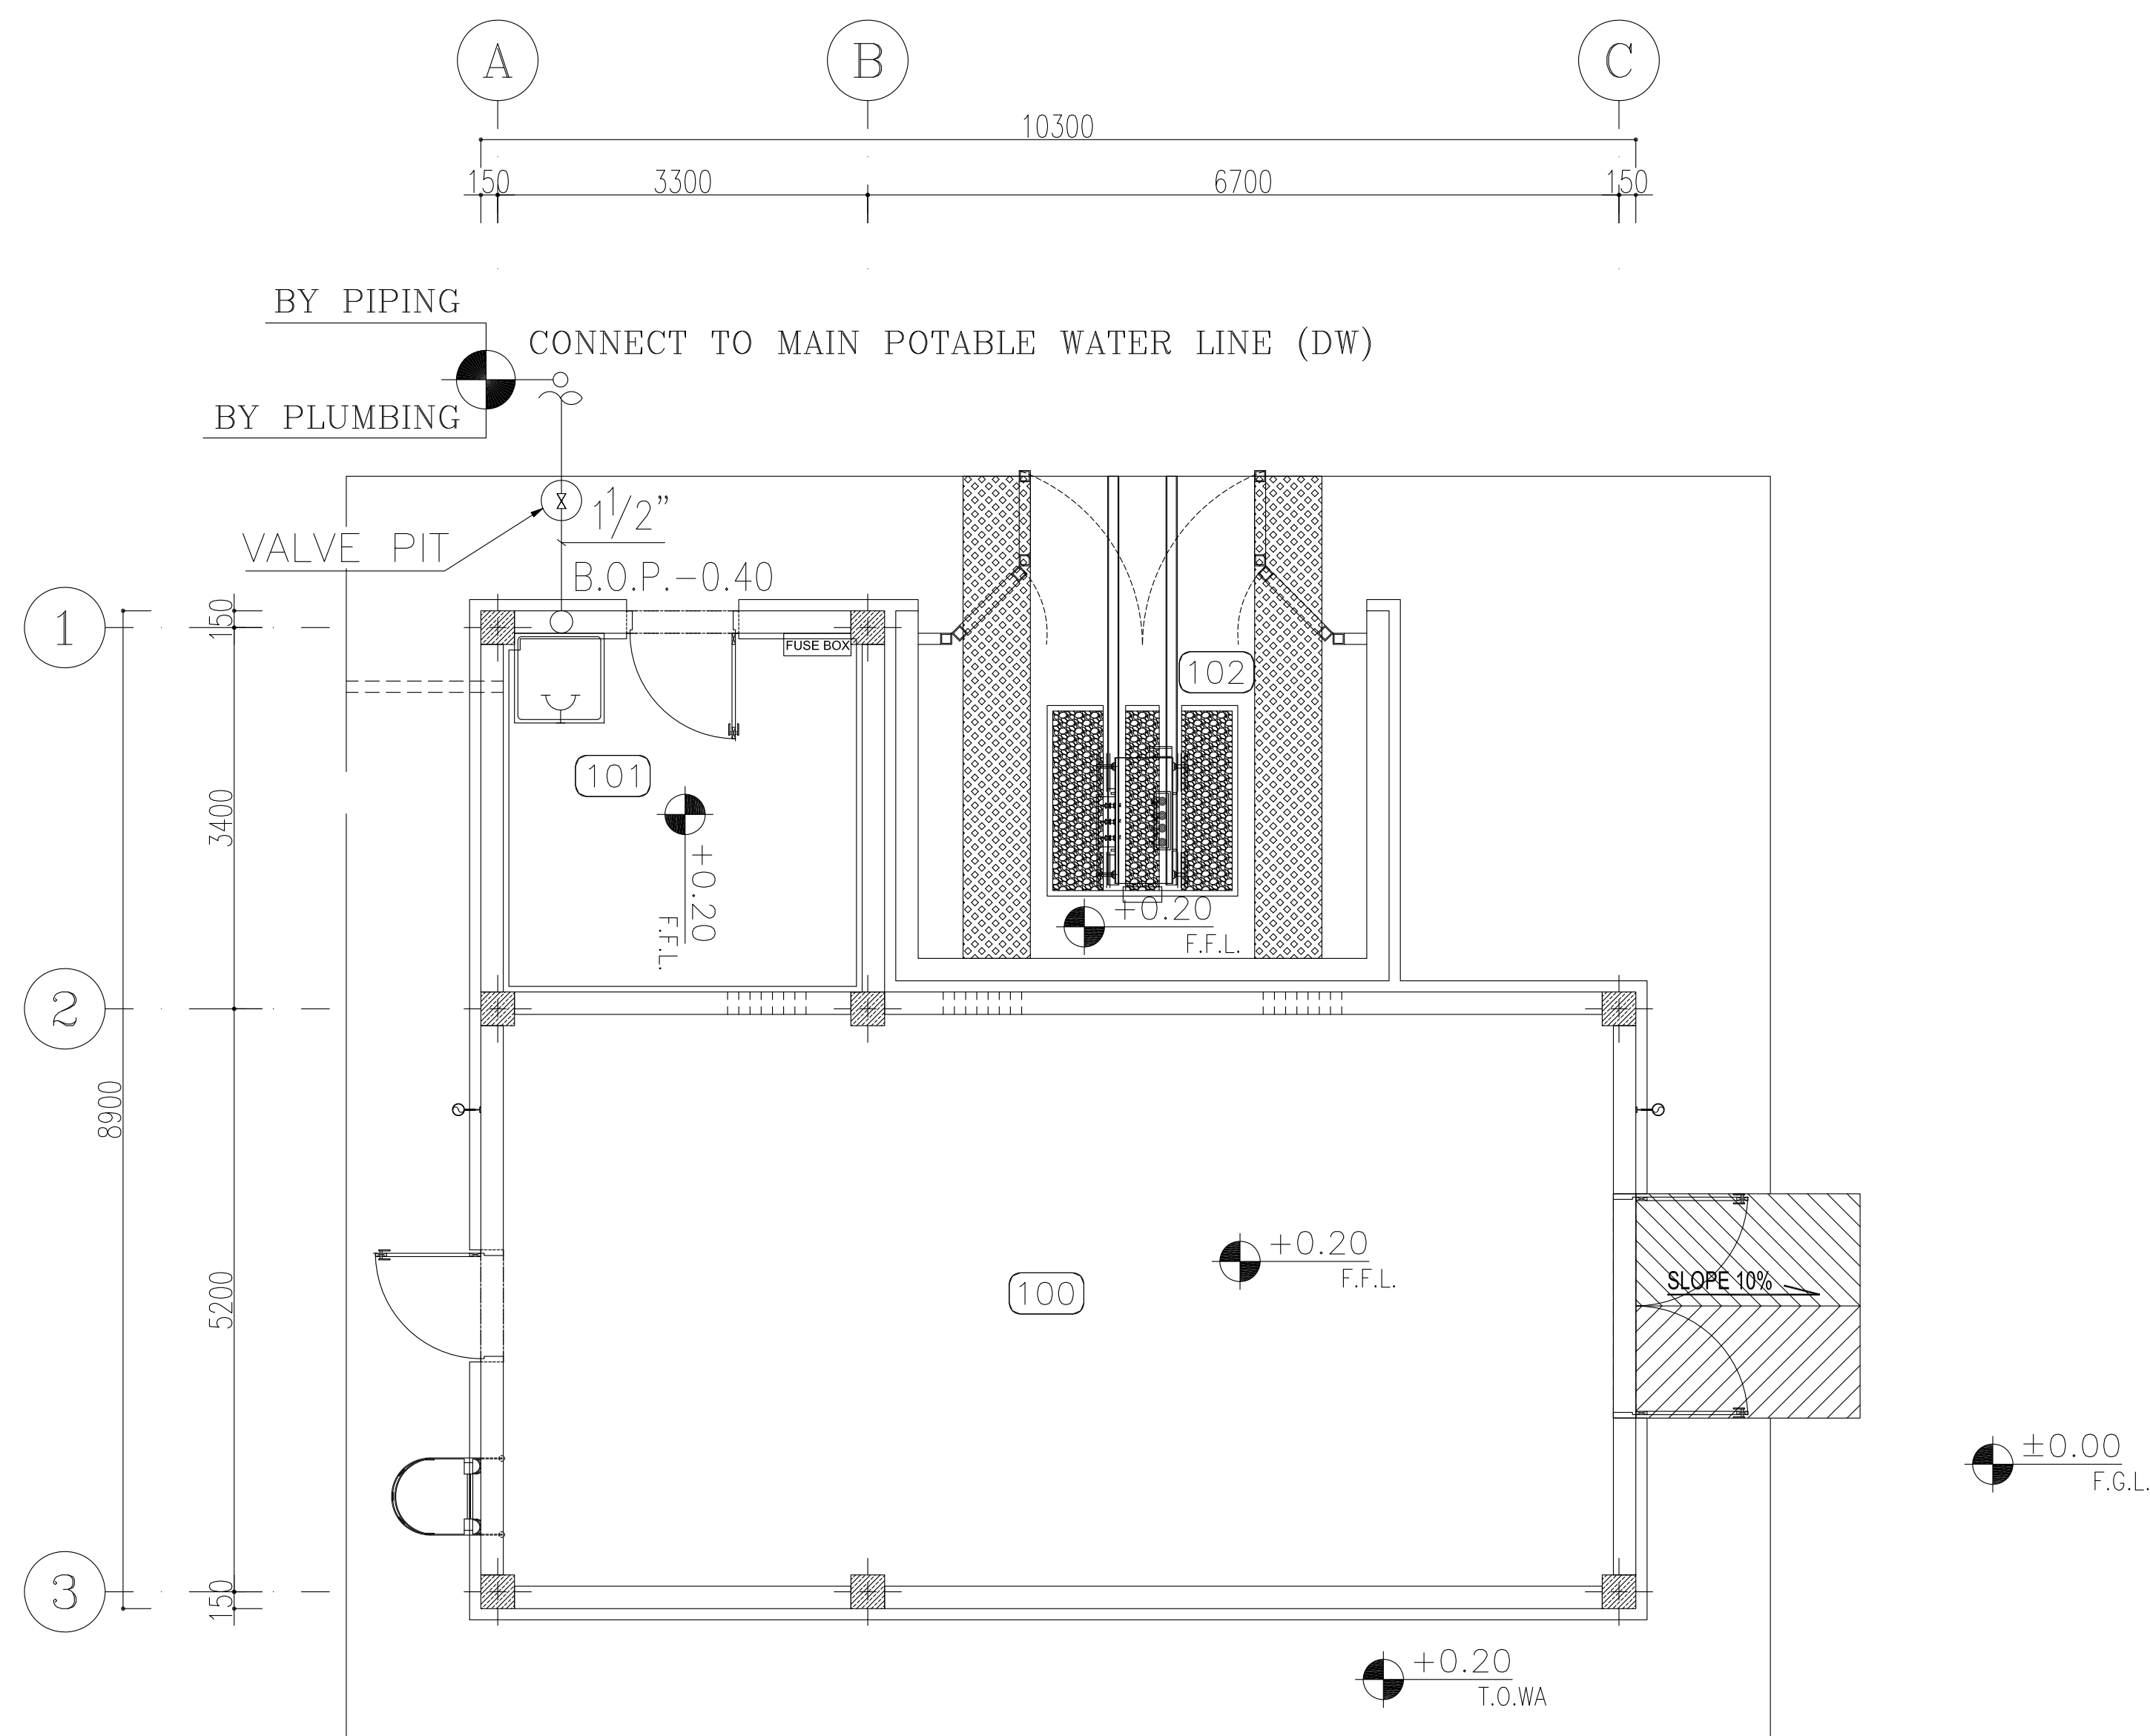


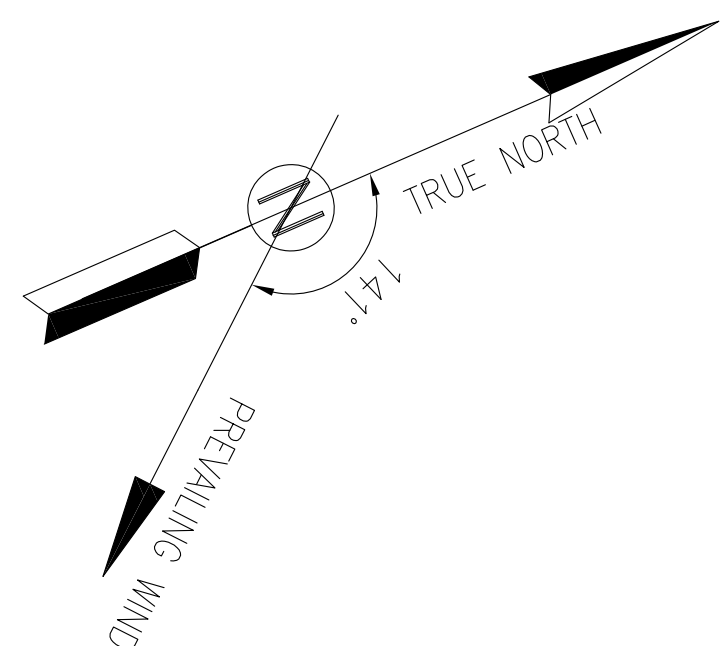

POTABLE PIPING PLAN

SC.1:50

SPACE TAG NUMBER

100 SWITCHGEAR ROOM

101 BATTERY ROOM

102 TRANSFORMER SHELTER

NOTES	
1- DIMENSIONS ARE IN "mm" AND ELEVATIONS IN "m" UNLESS SPECIFIED . 2- ALL DIMENSIONS AND ELEVATIONS SHALL BE CHECKED BY THE CONTRACTOR PRIOR TO CONSTRUCTION. 3- CONTRACTOR SHALL COMPARE ALL ARCHITECTURAL, MECHANICAL, ELECTRICAL, PIPING AND STRUCTURAL DRAWINGS AND IN CASE OF ANY CONFLICTS OR DISCREPANCY, INFORM THE ENGINEER. 4-ALL HVAC WORK SHALL BE DONE IN LINE WITH TECHNICAL SPECIFICATIONS.	
LEGEND	
REFERENCE DRAWING	DRG. No.
STANDARD DRAWING FOR HVAC & PLUMBING	BK-GNRL-PEDCO-000-HV-DW-0001
SYMBOL & LEGEND FOR HVAC & PLUMBING	BK-GNRL-PEDCO-000-HV-DW-0002

[illegible]

