

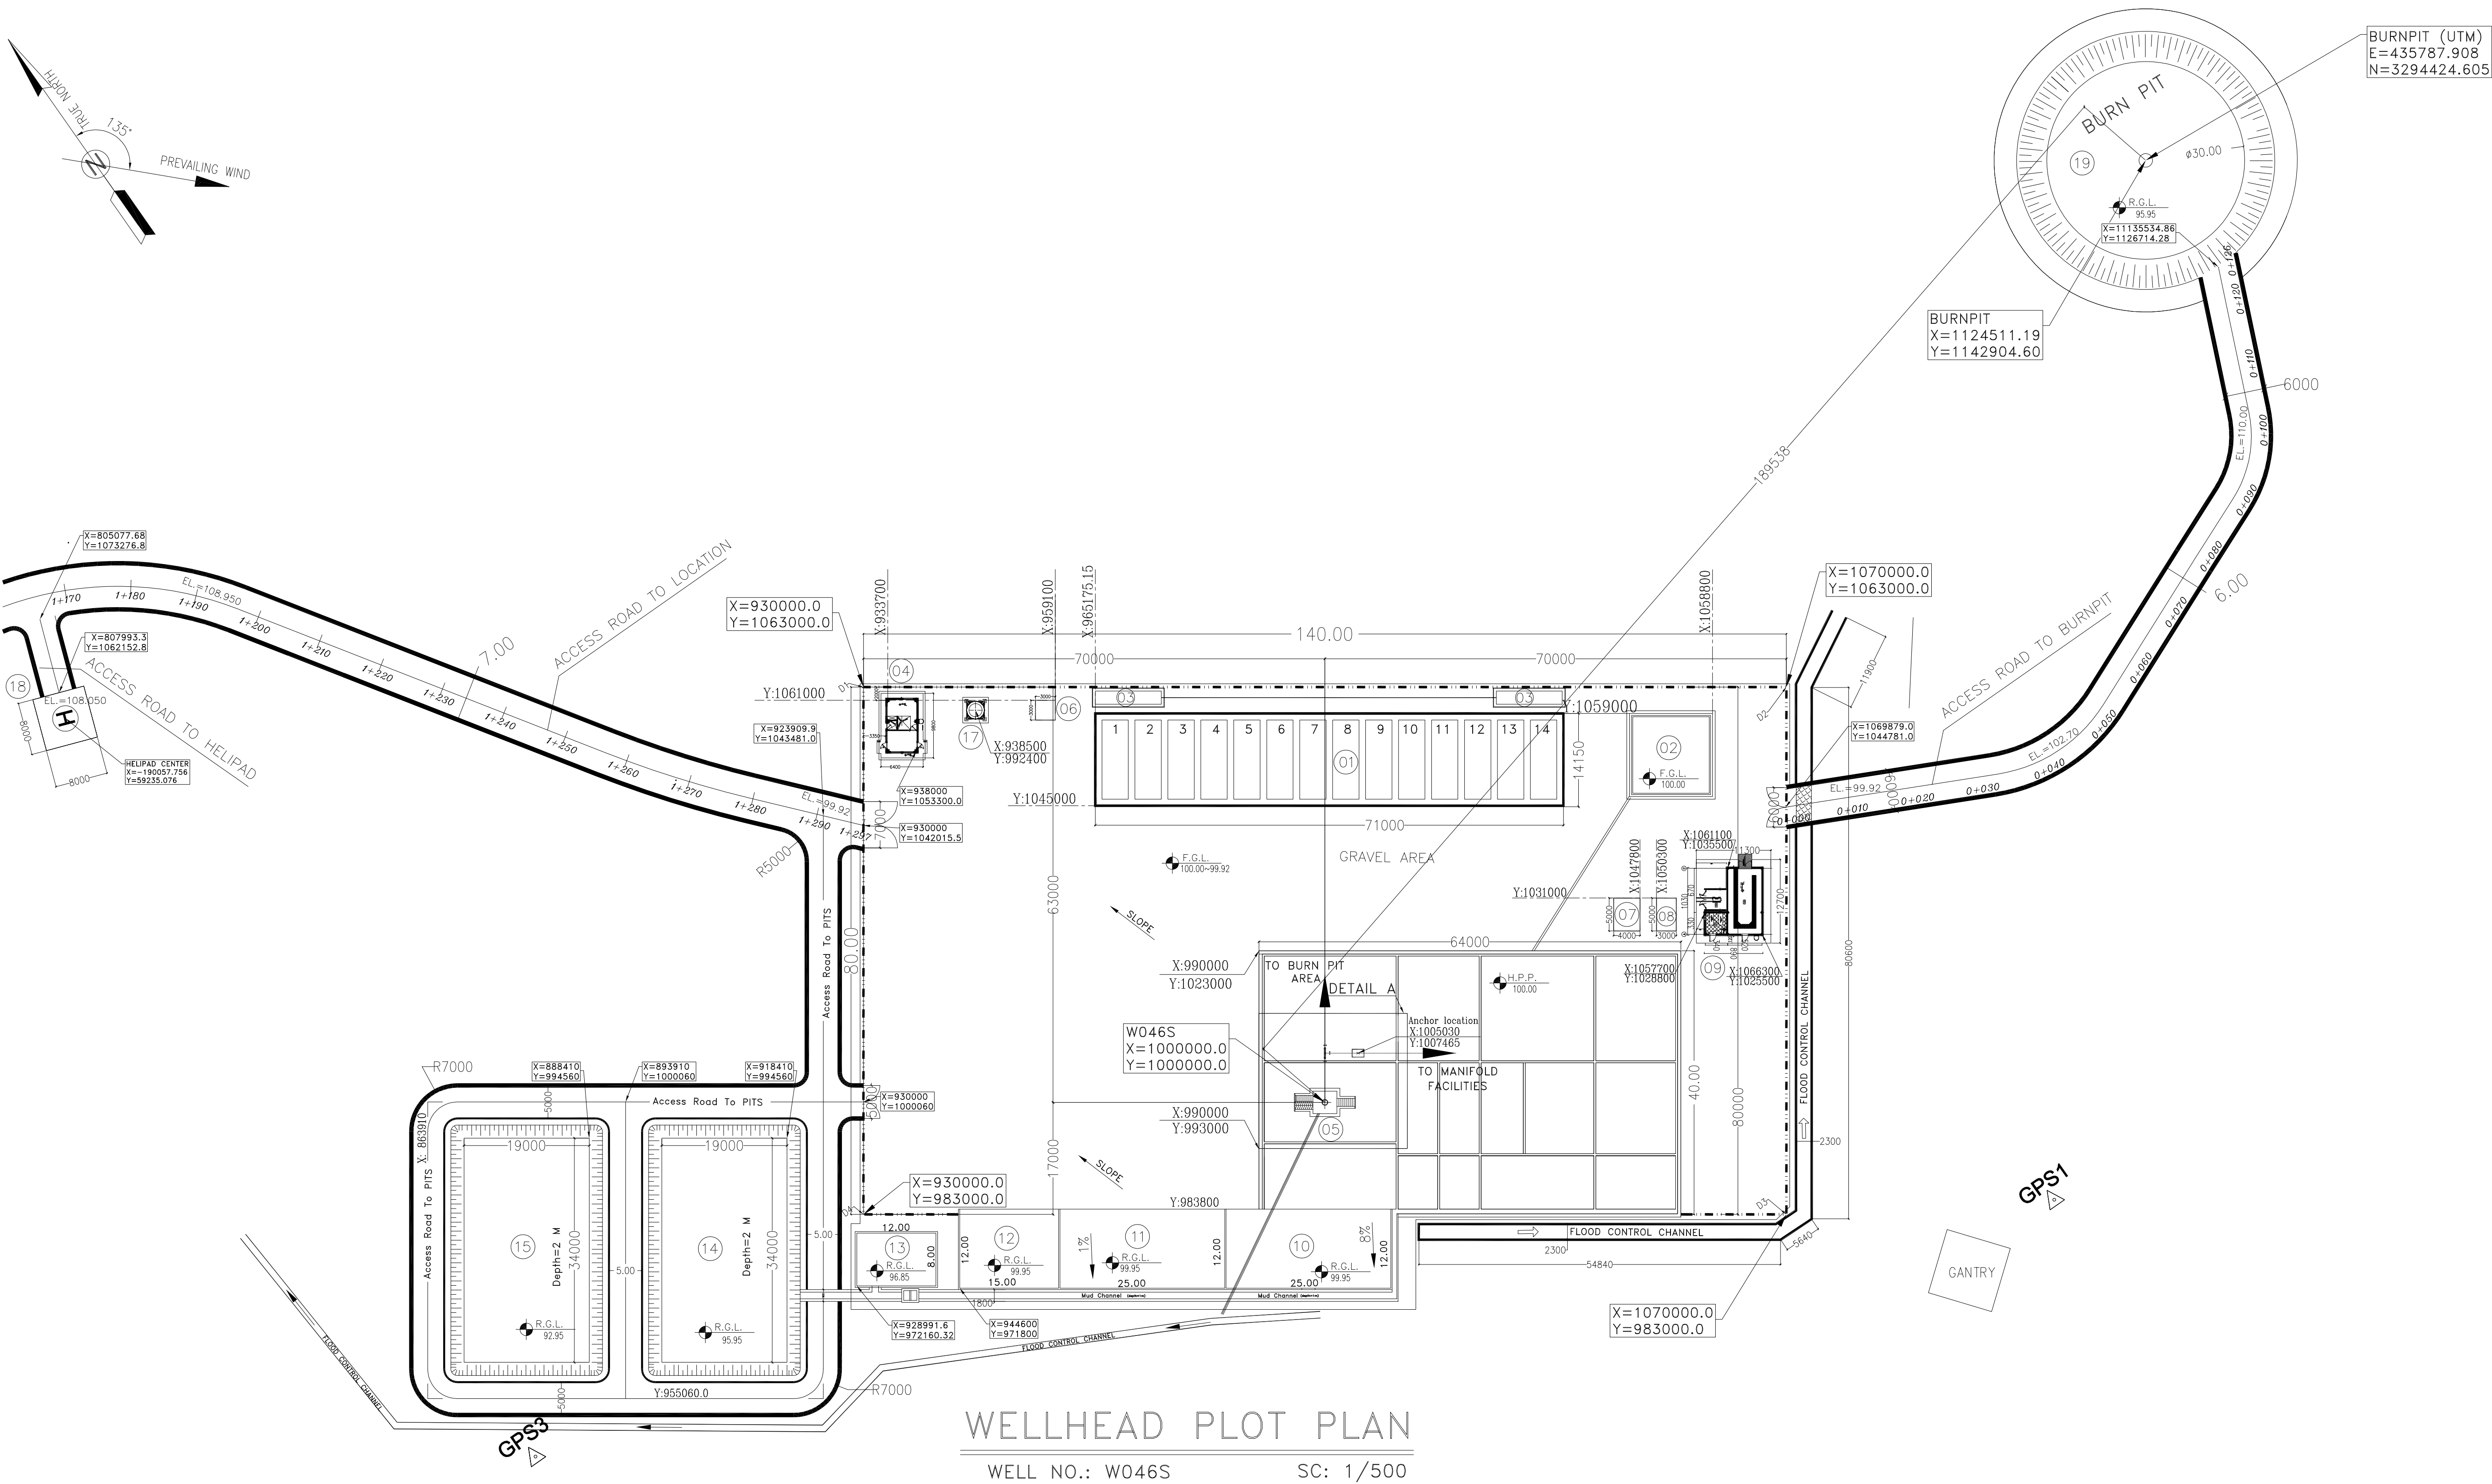


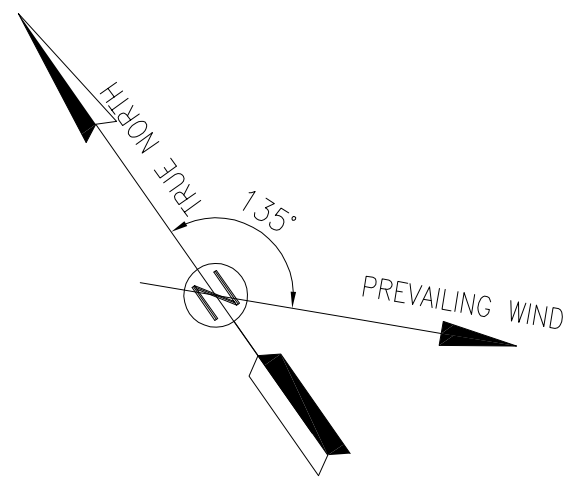

Coordinate of Bench Marks (UTM)			
Points	Northing (m)	Easting (m)	Elevation (m)
BM48	435082.554	3294746.888	41.666
GPS3	435475.560	3294403.536	66.866
GPS1	435686.115	3294303.397	78.025

DETAIL A
SC: 1/100

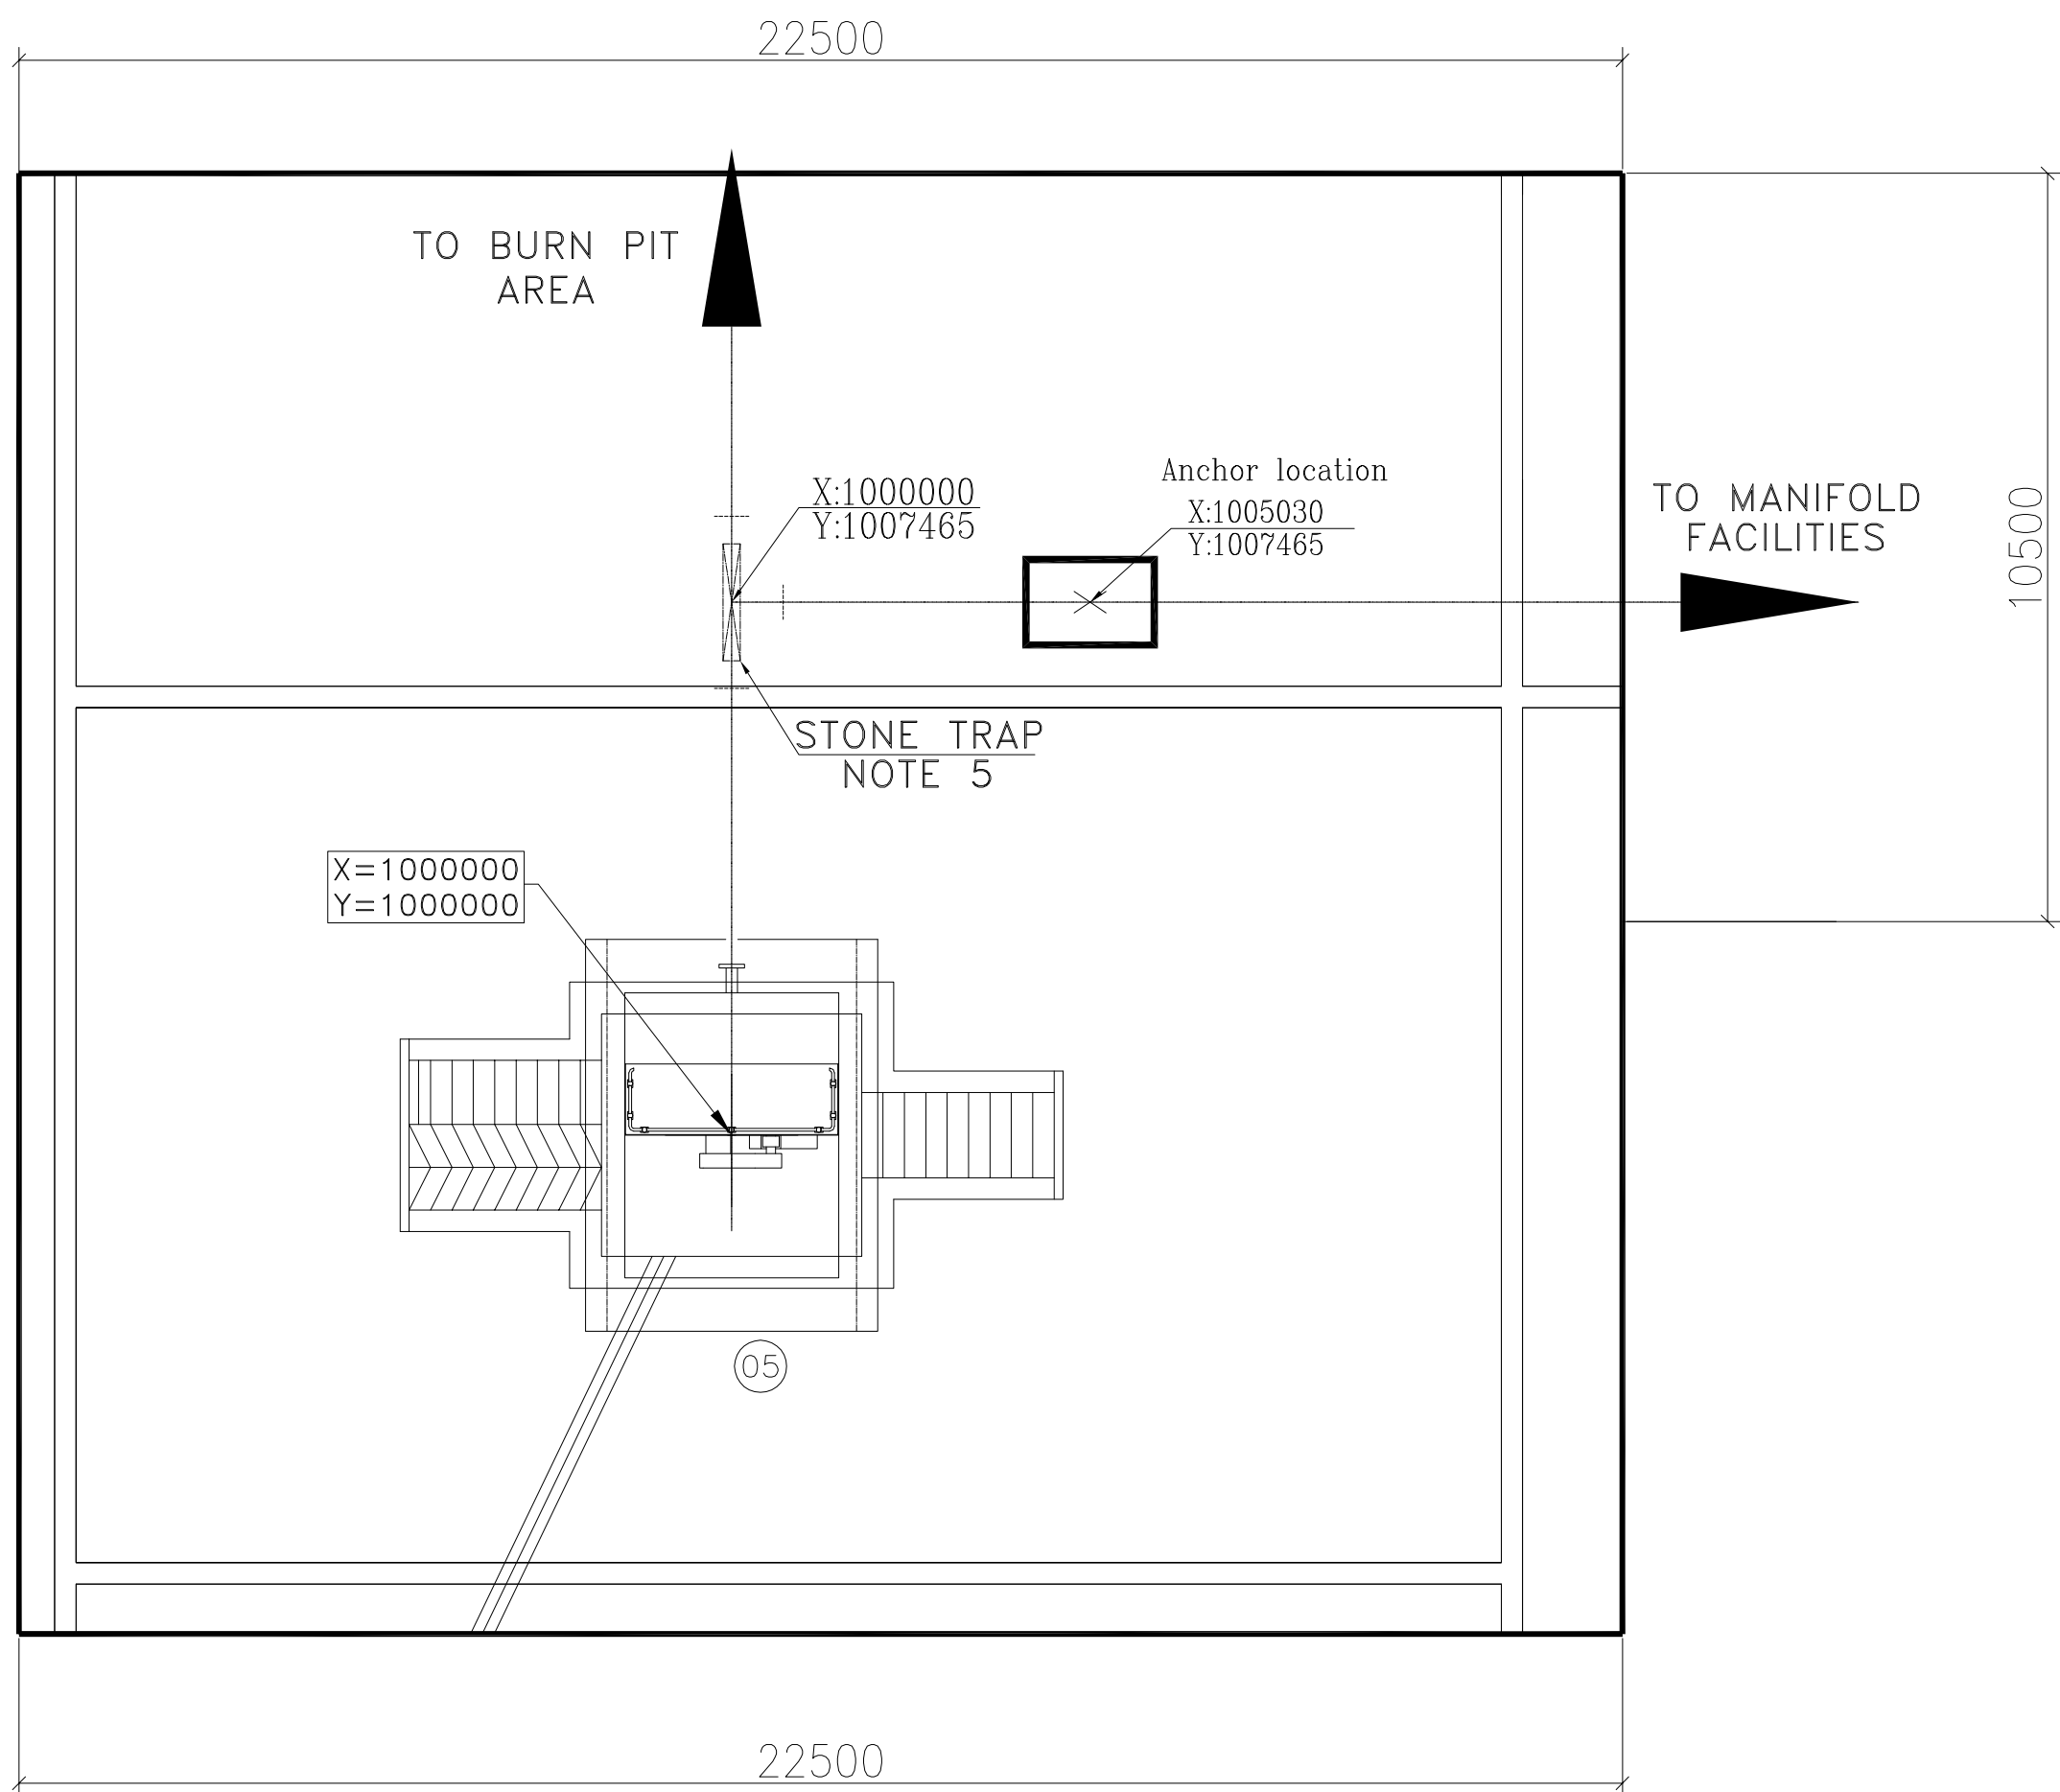


TAG NO.	AREA LIST
(01)	DRILLING CONEX AREA
(02)	FUEL TANK AREA
(03)	SEPTIC
(04)	SECURITY ROOM
(05)	IRP PUMP
(06)	FIREFIGHTING SHELTER
(07)	DIESEL GENERATOR
(08)	DIESEL GENERATOR FUEL TANK
(09)	SWITCHGEAR
(10)	CORAL PIT
(11)	TREATMENT AREA
(12)	DEWATERING AREA
(13)	OBM WASTE PIT
(14)	WASTE PIT
(15)	CUTTING DISPOSAL AREA
(16)	DELETED
(17)	POTABLE WATER TANK
(18)	HELIPAD
(19)	BURN PIT

- NOTES
- 1- ALL DIMENSIONS ARE IN MILLIMETERS, EXCEPT OTHERWISE NOTED.
 - 2- ALL ELEVATIONS ARE IN METERS.
 - 3- ALL COORDINATES OF THIS PLAN ARE LOCAL.
 - 4- H.P.P. 100.00m CORRESPONDING TO 57.05 M.S.L.
 - 5- SHOWED PIPING / PIPELINES AND RELEVANT SUPPORTS, ARE INDICATIVE.
 - 6- DIMENSIONS OF W.H.C.P. AND RELEVANT SHELTER WILL BE FINALIZED.
 - 7- REFERENCE COORDINATES X=1000.000 , Y=1000.000 REFER TO E=435603.952 , N=3294378.945 UTM. WGS84 ZONE 39 - NORTH
 - 8- FOR DETAIL OF BURN PIT & ACCESS ROAD SEE BK-W046S-PEDCO-110-CV-PY-0002

LEGEND & ABBREVIATIONS	
H.P.P.	HIGH POINT PAVING
W.H.C.P.	WELL HEAD CONTROL PANEL
---	FENCE
---	MATCH LINE
○	WELL LOCATION
---	SURFACE WATER TRENCH
---	GRATING
H	HELIPAD

REFERENCE DRAWING	DRG. No.
GENERAL CIVIL LAYOUT - W046S	BK-W046S-PEDCO-110-CV-PY-0001
CIVIL AND STRUCTURAL DRAWINGS - W046S	BK-W046S-PEDCO-110-CV-PY-0002
PAID - W046S	BK-W046S-PEDCO-110-PI-PI-0001
PIPING PLAN - W046S	BK-W046S-PEDCO-110-PI-DW-0002
PLATFORM STRUCTURE DRAWING - W046S	BK-W046S-PEDCO-110-ST-DW-0012
FLOW LINE PLAN & PROFILE DRAWINGS - W046S	BK-W046S-PEDCO-110-SU-DW-0001
CABLE ROUTE LAYOUT FOR ELECTRICAL TOWER (GANTRY) OF WELL PADS	BK-SSSRL-PEDCO-110-EL-PY-0002
ARCHITECTURAL DRAWING FOR SWITCHGEAR BUILDING OF WELL PADS - W046S	BK-W046S-PEDCO-110-AR-DW-0003

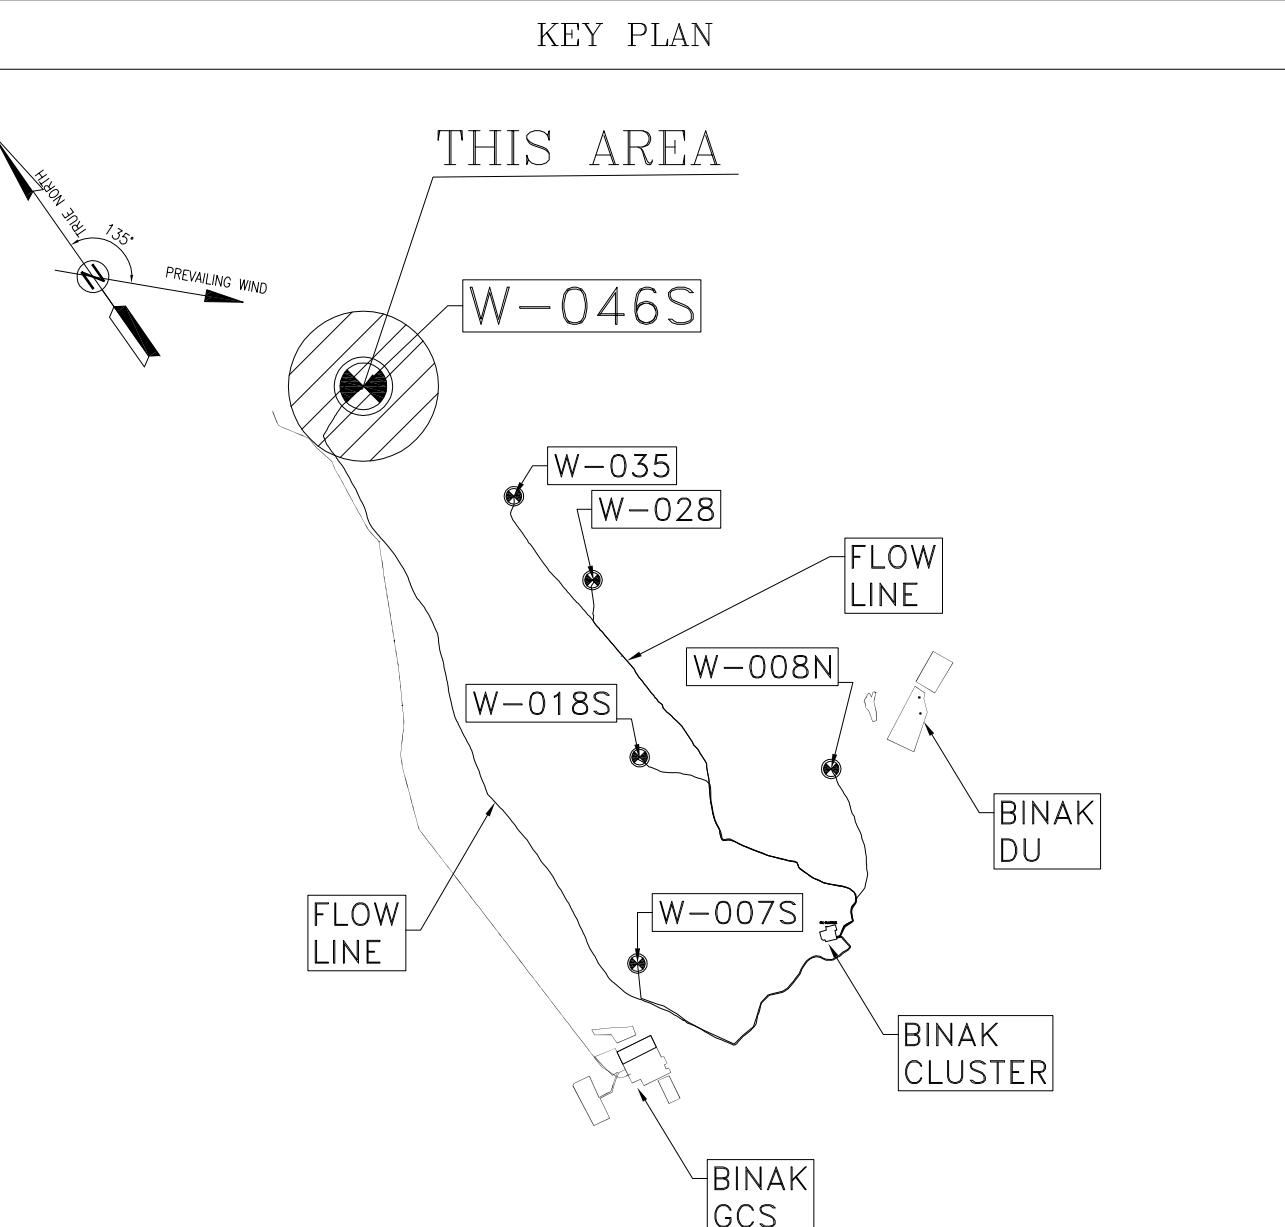

D02	JAN.2023		IFA	M.NOORI	M.PAKHARIAN	M.MEHRSHAD	***	***	*****	***	*****	***	*****		
D01	NOV.2022		IFA	M.NOORI	M.PAKHARIAN	M.MEHRSHAD	***	REV.	DESCRIPTION	BY	DATE	BY	DATE		
D00	MAY.2022		IFC	A.KHOSRAVI	M.PAKHARIAN	M.MEHRSHAD	***			CHECKED		REV. APPR.			
REV.	DATE		P.O.I.S	PREP.	CHK.	APP.	AUT.	واکله نسخ این نقشه و حق اقتباس متعلق به شرکت ملی مناطق نفت خیز جنوب میباشد.							
PROJECT NAME:			BINAK OILFIELD DEVELOPMENT / SUB-SURFACE WORK					THE ORIGINAL AND ALL COPIES OF THIS DRAWING TOGETHER WITH THE COPYRIGHT THEREIN ARE THE SOLE PROPERTY OF N.I.S.O.C./ FIELDS							
PROJECT NO.:			W046S WELLHEAD FACILITIES 971020												
EPC CONTRACTOR:			GENERAL CONTRACTOR:					BINAK OILFIELD DEVELOPMENT SUB-SURFACE WORK			PACKAGES W018S WELLHEAD FACILITIES				
HIRGAN ENERGY – DESIGN & INSPECTION COMPANIES			PETROIRAN DEVELOPMENT COMPANY					DATE			SCALE	DRAWING BY	CHECKED BY	PROJECT ENG.	
DRAWING TITLE:								NO CONSTRUCTION PERMITTED UNLESS DRAWING APPROVED							
PLOT PLAN DRAWING - W046S								APPROVED FOR CONSTRUCTION			BY:		DATE:		
SCALE	SIZE	DRAWING NO.			SHEET NO.	REV.	BUDGET REF.	LOCATION	SIZE	CLASS	SERIAL NO.	SHEET	REVISION		
AS SHOWN	A0	BK-W046S-PEDCO-110-PI-PY-0001			1 OF 1	D02	053-073-9184	F	5	A	707616	1 OF 1	D02		