
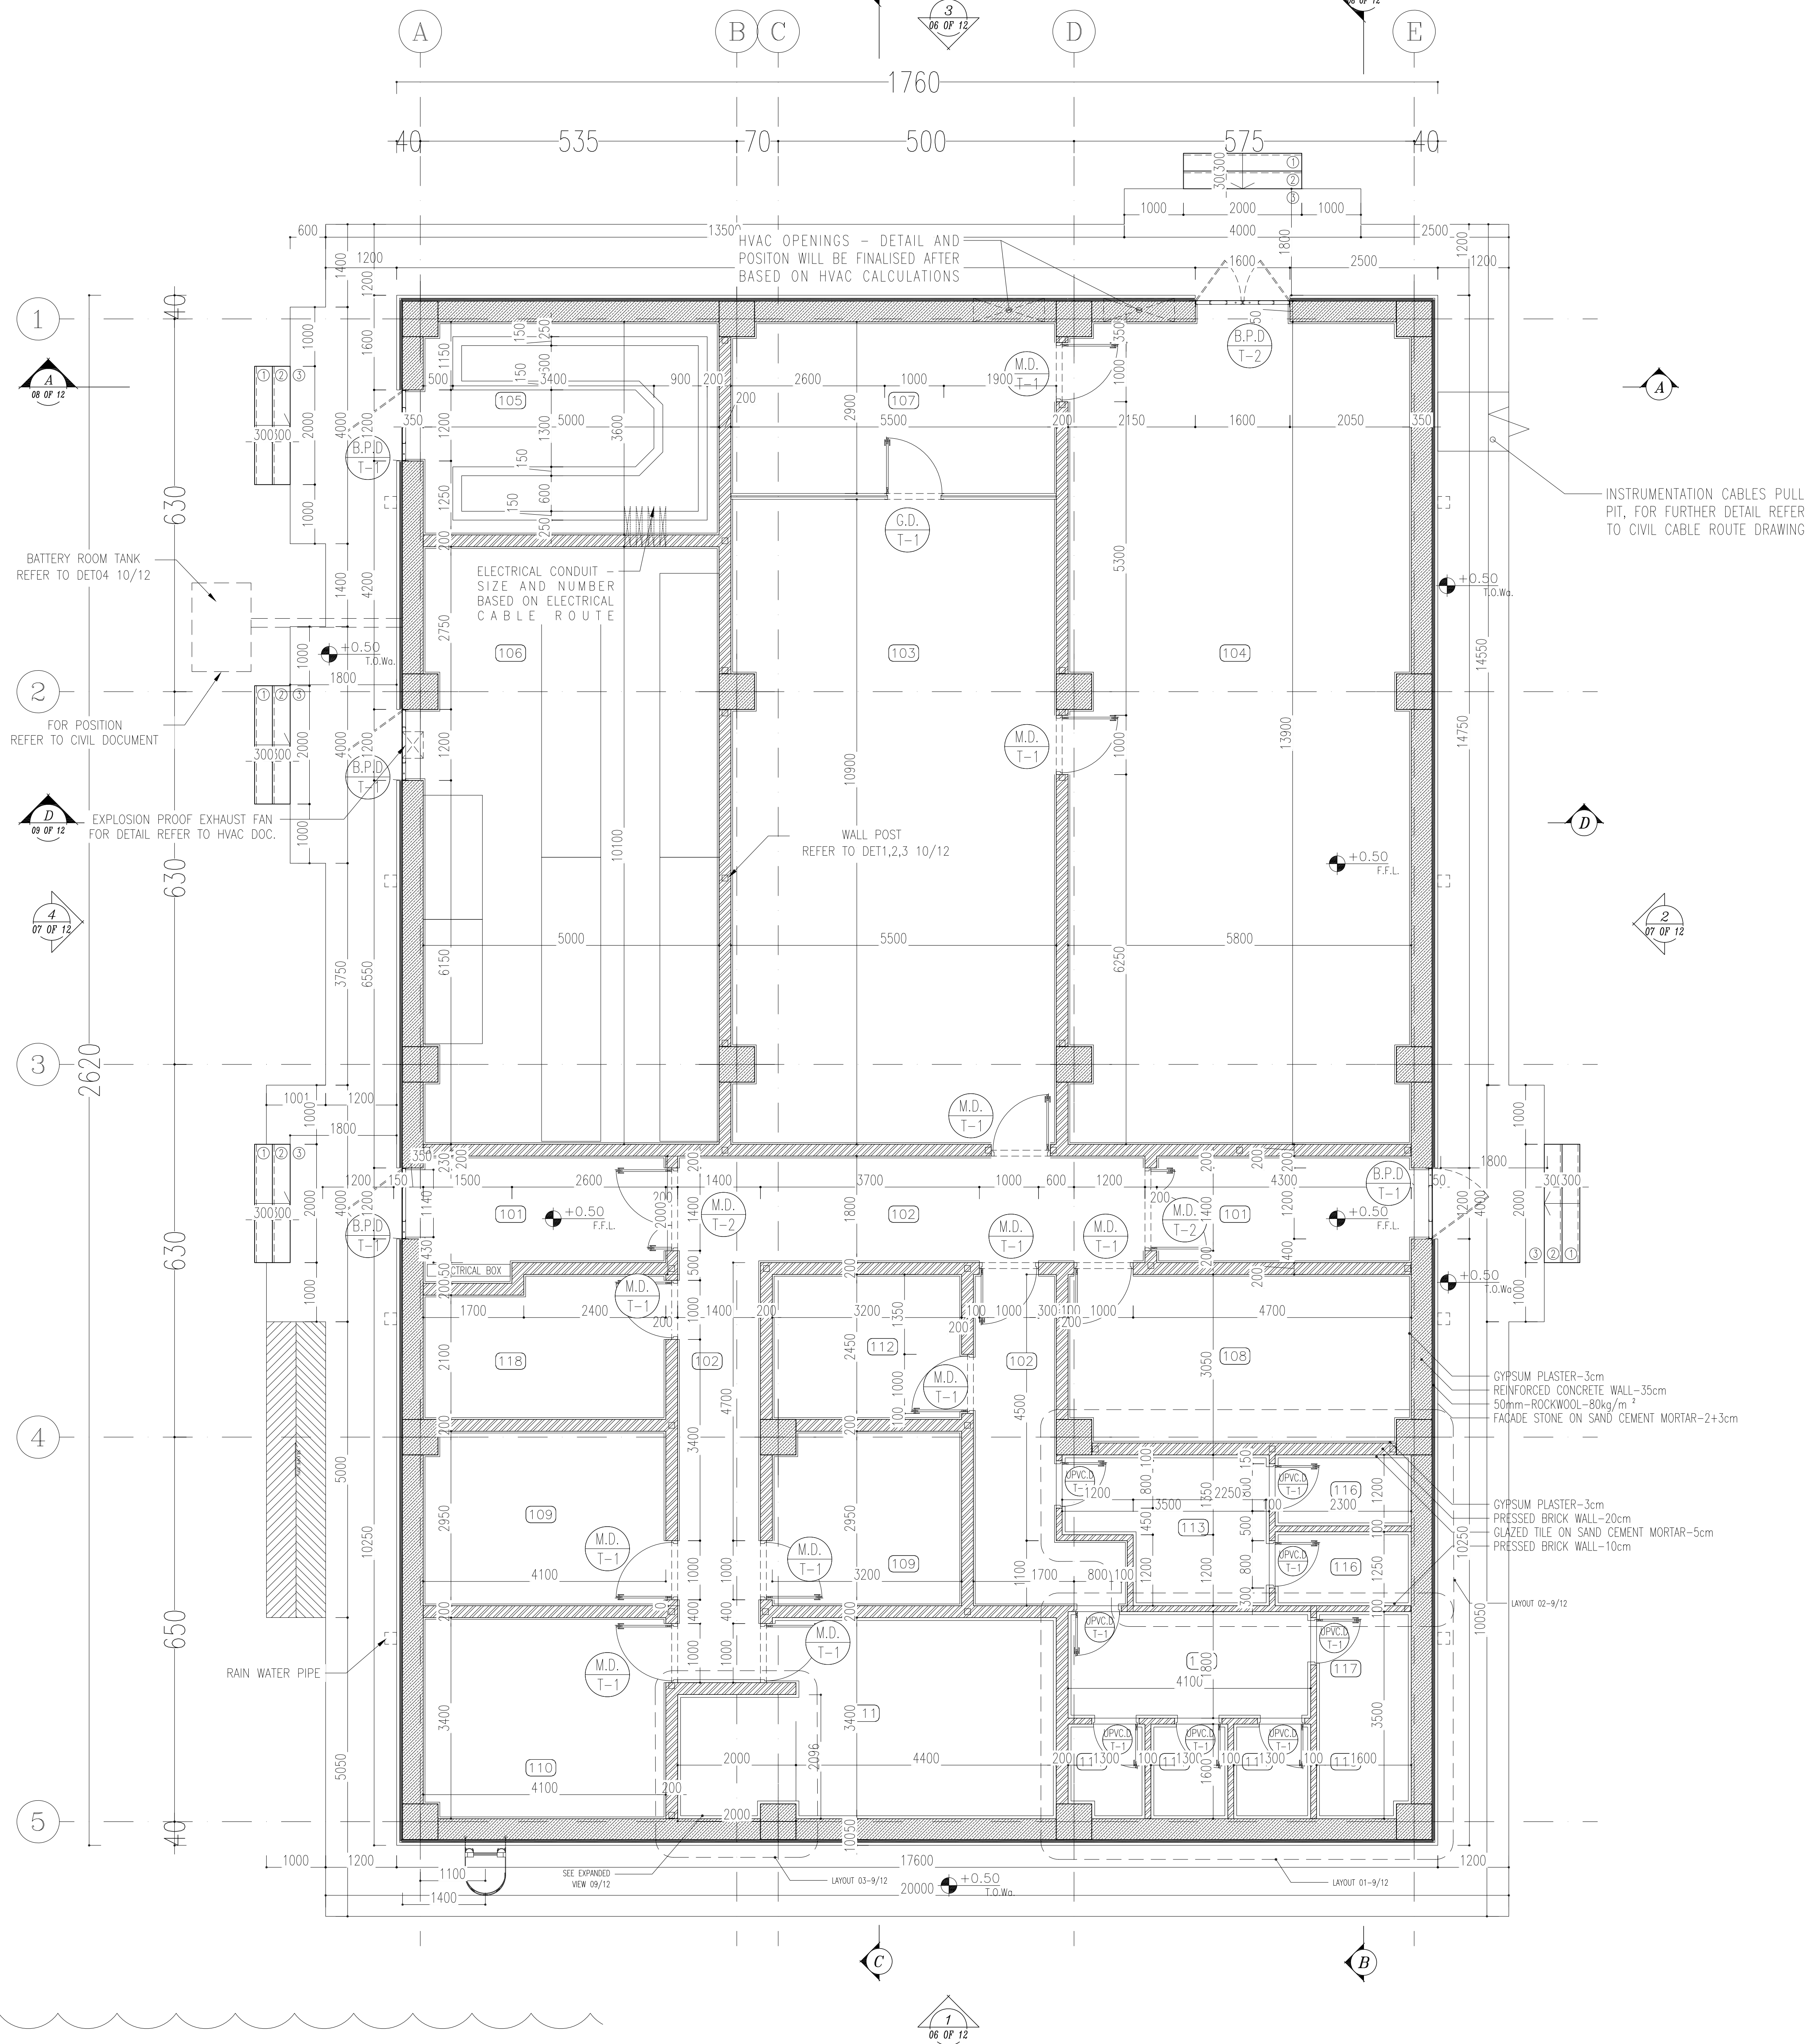


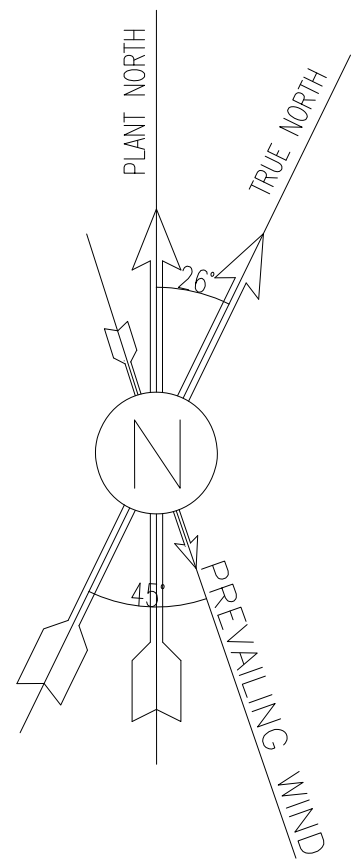

TAG NAME	NET AREA
101 AIR LOCK	16 sq.m
102 CORRIDOR	33 sq.m
103 CONTROL ROOM	59 sq.m
104 AUXILIARY ROOM	80 sq.m
105 UPS ROOM	18 sq.m
106 BATTERY ROOM	50 sq.m
107 ENGINEERING ROOM	16 sq.m
108 INSTRUMENT ROOM	16 sq.m
109 OFFICE	21 sq.m
110 IN-CHARGE + ARCHIVE	14 sq.m
111 PANTRY + DINING ROOM	20 sq.m
112 PRAYER ROOM	8 sq.m
113 LOCKER	8 sq.m
114 WC	13 sq.m
115 BOILERS	4 sq.m
116 BATHROOM	6 sq.m
117 JANITOR CLOSET	2 sq.m
118 HVAC CONTROL ROOM	9 sq.m

D05	JAN. 2023	IFA	R.BERLOUE	M.PAKHARIAN	M.Mehrshad	***
D04	OCT. 2022	IFA	R.BERLOUE	M.PAKHARIAN	M.Mehrshad	***
D03	AUG. 2022	IFA	R.BERLOUE	M.PAKHARIAN	M.Mehrshad	***
D02	MAR. 2022	IPC	R.BERLOUE	M.PAKHARIAN	M.Mehrshad	***
D01	JAN. 2022	IPC	R.BERLOUE	M.PAKHARIAN	M.Mehrshad	***
D00	DEC. 2021	IPC	R.BERLOUE	M.PAKHARIAN	M.Mehrshad	***


PROJECT NAME: BINAK OILFIELD DEVELOPMENT/SURFACE FACILITIES GAS COMPRESSOR STATION					
PROJECT NO.: 971020					
EPC CONTRACTOR:			EPD/EPC CONTRACTOR (GC):		
 HIRGAN ENERGY - DESIGN & INSPECTION COMPANIES			 PETROIRAN DEVELOPMENT COMPANY		

DRAWING TITLE: ARCHITECTURAL DETAIL DRAWING FOR CONTROL BUILDING					
FLOOR PLAN					
SCALE	SIZE	DRAWING NO.	SHEET NO.	REV.	BUDGET REF.
AS SHOWN	A0	BK-GCS-PEDCO-120-AR-DW-0001	01 OF 12	D05	053-073-9184

- NOTES**
1. ALL DIMENSIONS ARE IN CENTIMETER & ALL ELEVATIONS ARE IN METER.
 2. ALL DIMENSIONS AND ELEVATIONS SHALL BE CHECKED BY THE CONTRACTOR PRIOR TO CONSTRUCTION.
 3. CONTRACTOR SHALL COMPLY ALL ARCHITECTURAL, MECHANICAL, ELECTRICAL, PIPING AND STRUCTURAL DRAWINGS AND IN CASE OF ANY CONFLICTS OR DISCREPANCY, INFORM THE ENGINEER.
 4. ALL MATERIALS ARE SELECTED FROM THE HIGHEST QUALITY AND MUST BE APPROVED BY THE CLIENT.
 5. ALL ORDERS FOR PIPING/DRAINING AND HVAC ORDERS SHALL BE CONSIDERED AS PER RELATED DRAWINGS BEFORE CONSTRUCTION.
 6. ALL INTERNAL SLOPES FOR FLOOR DRAINS ARE 1% UNLESS STATED.
 7. KNAUF BOARDS SHALL BE "MR" IN MOST SPACES AND TYP IN HEAT ZONES.
 8. FINISH GRADING LEVEL (T.O.L.) = ±1.20 (W.S.L.) = ±0.00 (LOCAL).
 9. ALL W.S. ARE EQUIPPED WITH HAND-WASH-HOT AIR-BLOWER-ELECTRICAL SOAP DISPENSER WITH ABS DOORS(WITH CLOSER MECHANISM).
 10. ACCORDING TO SPECIFICATION FOR BUILDINGS INTERIOR PAINTING FOR MASONRY, CONCRETE, PLASTER, GYPSUM WALL BOARD SHALL DONE AS FOLLOW : 1st COAT, PRIMER AND SEALER, 2nd AND 3rd COATS, INTERIOR PAINT SEM LUSTRE (WHITE ALKYLID PAINT).
 11. ALL BLASTPROOF DOORS ARE PANIC DOORS - PANIC BARS ARE REQUIRED.
 12. BATTERY ROOM SHALL BE EQUIPPED WITH EXPLOSION-PROOF,FAN,LIGHTING,SWITCHES,OUTLETS AND ETC.

LEGEND			
CONCRETE WALL OR CEILING			
PRESSED BRICK			
F.F.L.	FINISHED FLOOR	W.D	WOOD DOOR
T.O.WA	TOP OF WALKWAY	T.O.D.	TOP OF DOOR
T.O.R.	TOP OF ROOF	F.G.L.	FINISH GRADING LEVEL
T.O.P.	TOP OF PARAPET	B.P.D.	BLAST-PROOF DOOR
T.O.FOU.	TOP OF FOUNDATION	B.O.Ca.	BOTTOM OF LADDER CAGE
AL.D.	ALUMINIUM DOOR	T.O.Ca.	TOP OF LADDER CAGE
M.D.	METAL DOOR		



REFERENCE DRAWING	DRG. No.
Standard Details For Ladder & Safety Cage	BK-GNRL-PEDCO-000-ST-DW-0009
FOUNDATION DRAWING FOR CONTROL BUILDING	BK-GCS-PEDCO-120-ST-DW-0061
STRUCTURAL DRAWING FOR CONTROL BUILDING	BK-GCS-PEDCO-120-ST-DW-0062
ROAD, PAVING AND PLANT FINISH GRADING LAYOUT & SECTIONS	BK-GCS-PEDCO-120-CV-PY-0005
CABLE TRENCH AND DUCT BANK LAYOUT	BK-GCS-PEDCO-120-CV-PY-0002
ELECTRICAL CABLE ROUTE & SECTION LAYOUT FOR BUILDING & SHELTER	BK-GCS-PEDCO-120-EL-PY-0006
CONTROL ROOM LAYOUT & ARRANGEMENT DRAWING	BK-GCS-PEDCO-120-IN-PY-0001
PLUMBING & SEWAGE PIPING LAYOUT FOR CONTROL BUILDING	BK-GCS-PEDCO-120-HV-PY-0001
HVAC ROOM LAYOUT & SECTION FOR CONTROL BUILDING	BK-GCS-PEDCO-120-HV-PY-0002
HVAC SYSTEM DUCT PLAN FOR CONTROL BUILDING	BK-GCS-PEDCO-120-HV-PY-0003
HVAC SYSTEM ROOF LAYOUT FOR CONTROL BUILDING	BK-GCS-PEDCO-120-HV-PY-0004

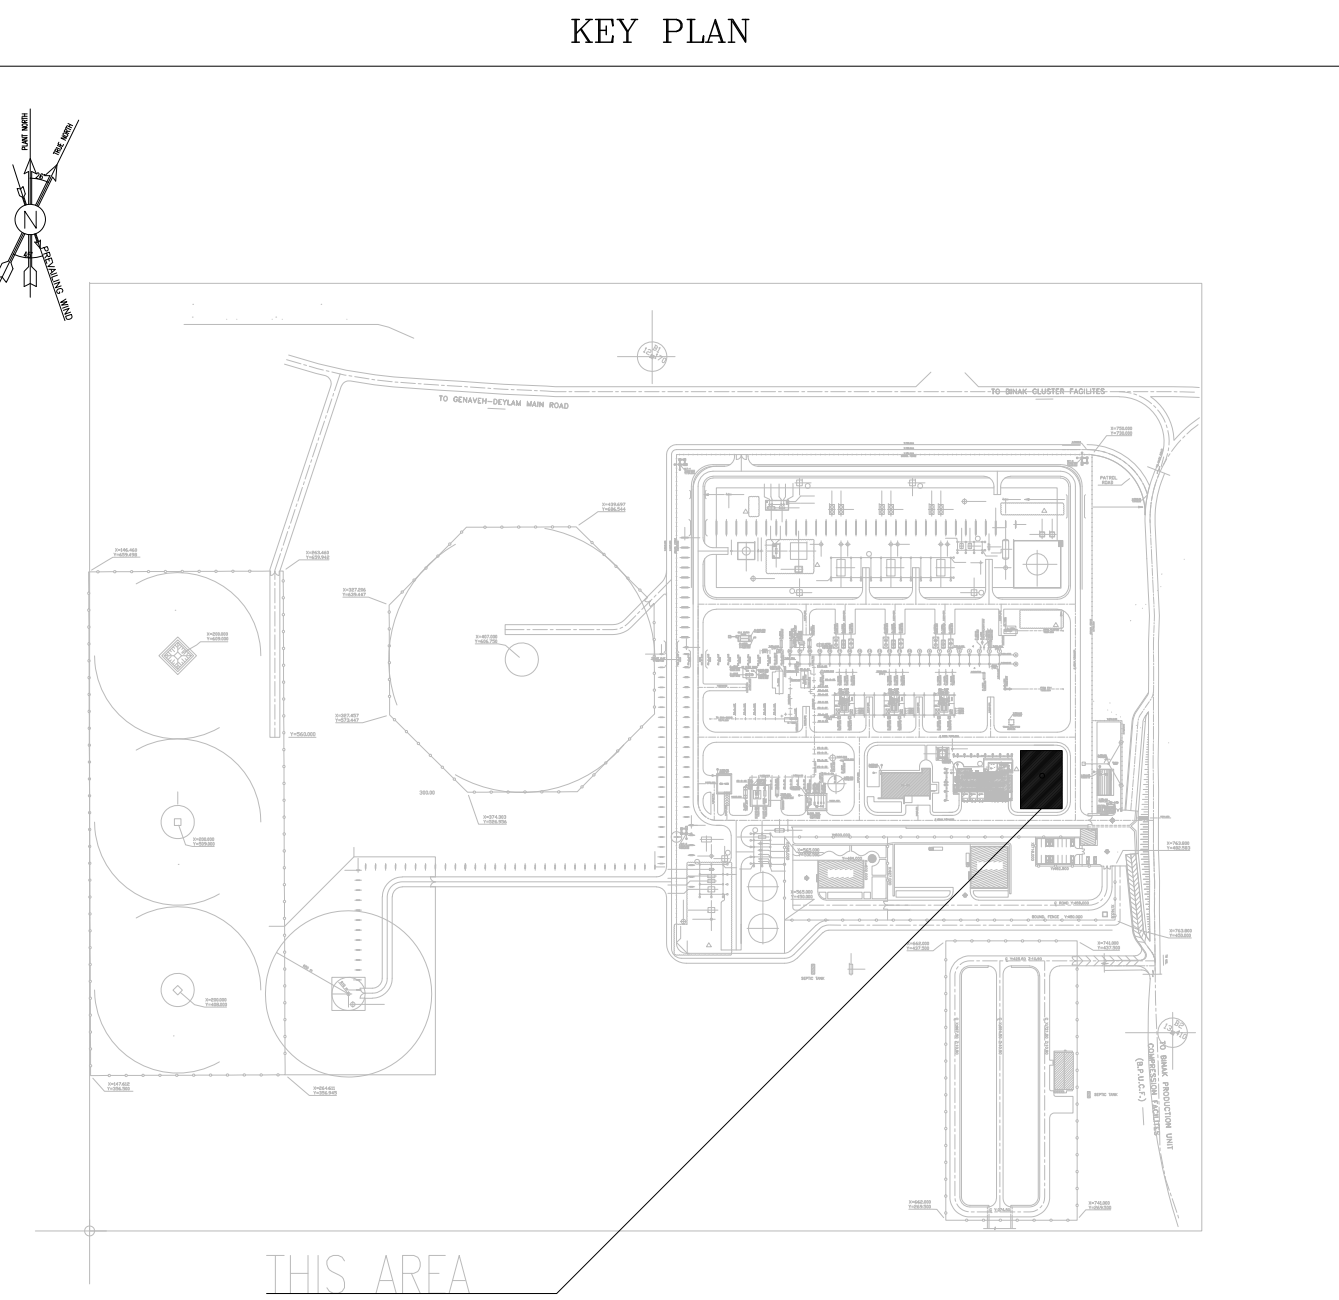

REV.	DESCRIPTION	BY	DATE	BY	DATE
***	*****	***	*****	***	*****

احمل و کلیه نسخ این نقشه و حق اقتباس متعلق به شرکت ملی مناطق نفت خیز جنوب میباشد.
THE ORIGINAL AND ALL COPIES OF THIS DRAWING TOGETHER WITH THE COPYRIGHT THEREIN ARE THE SOLE PROPERTY OF N.I.S.O.C./ FIELDS

BINAK OILFIELD DEVELOPMENT SURFACE FACILITIES GAS COMPRESSOR STATION				
DATE	SCALE	DRAWING BY	CHECKED BY	PROJECT ENG.
NO CONSTRUCTION PERMITTED UNLESS DRAWING APPROVED				
APPROVED FOR CONSTRUCTION			BY:	DATE:
BUDGET REF.	LOCATION	SIZE CLASS	SERIAL NO.	SHEET REVISION
053-073-9184	F	4	B	709099 01 OF 12 D05

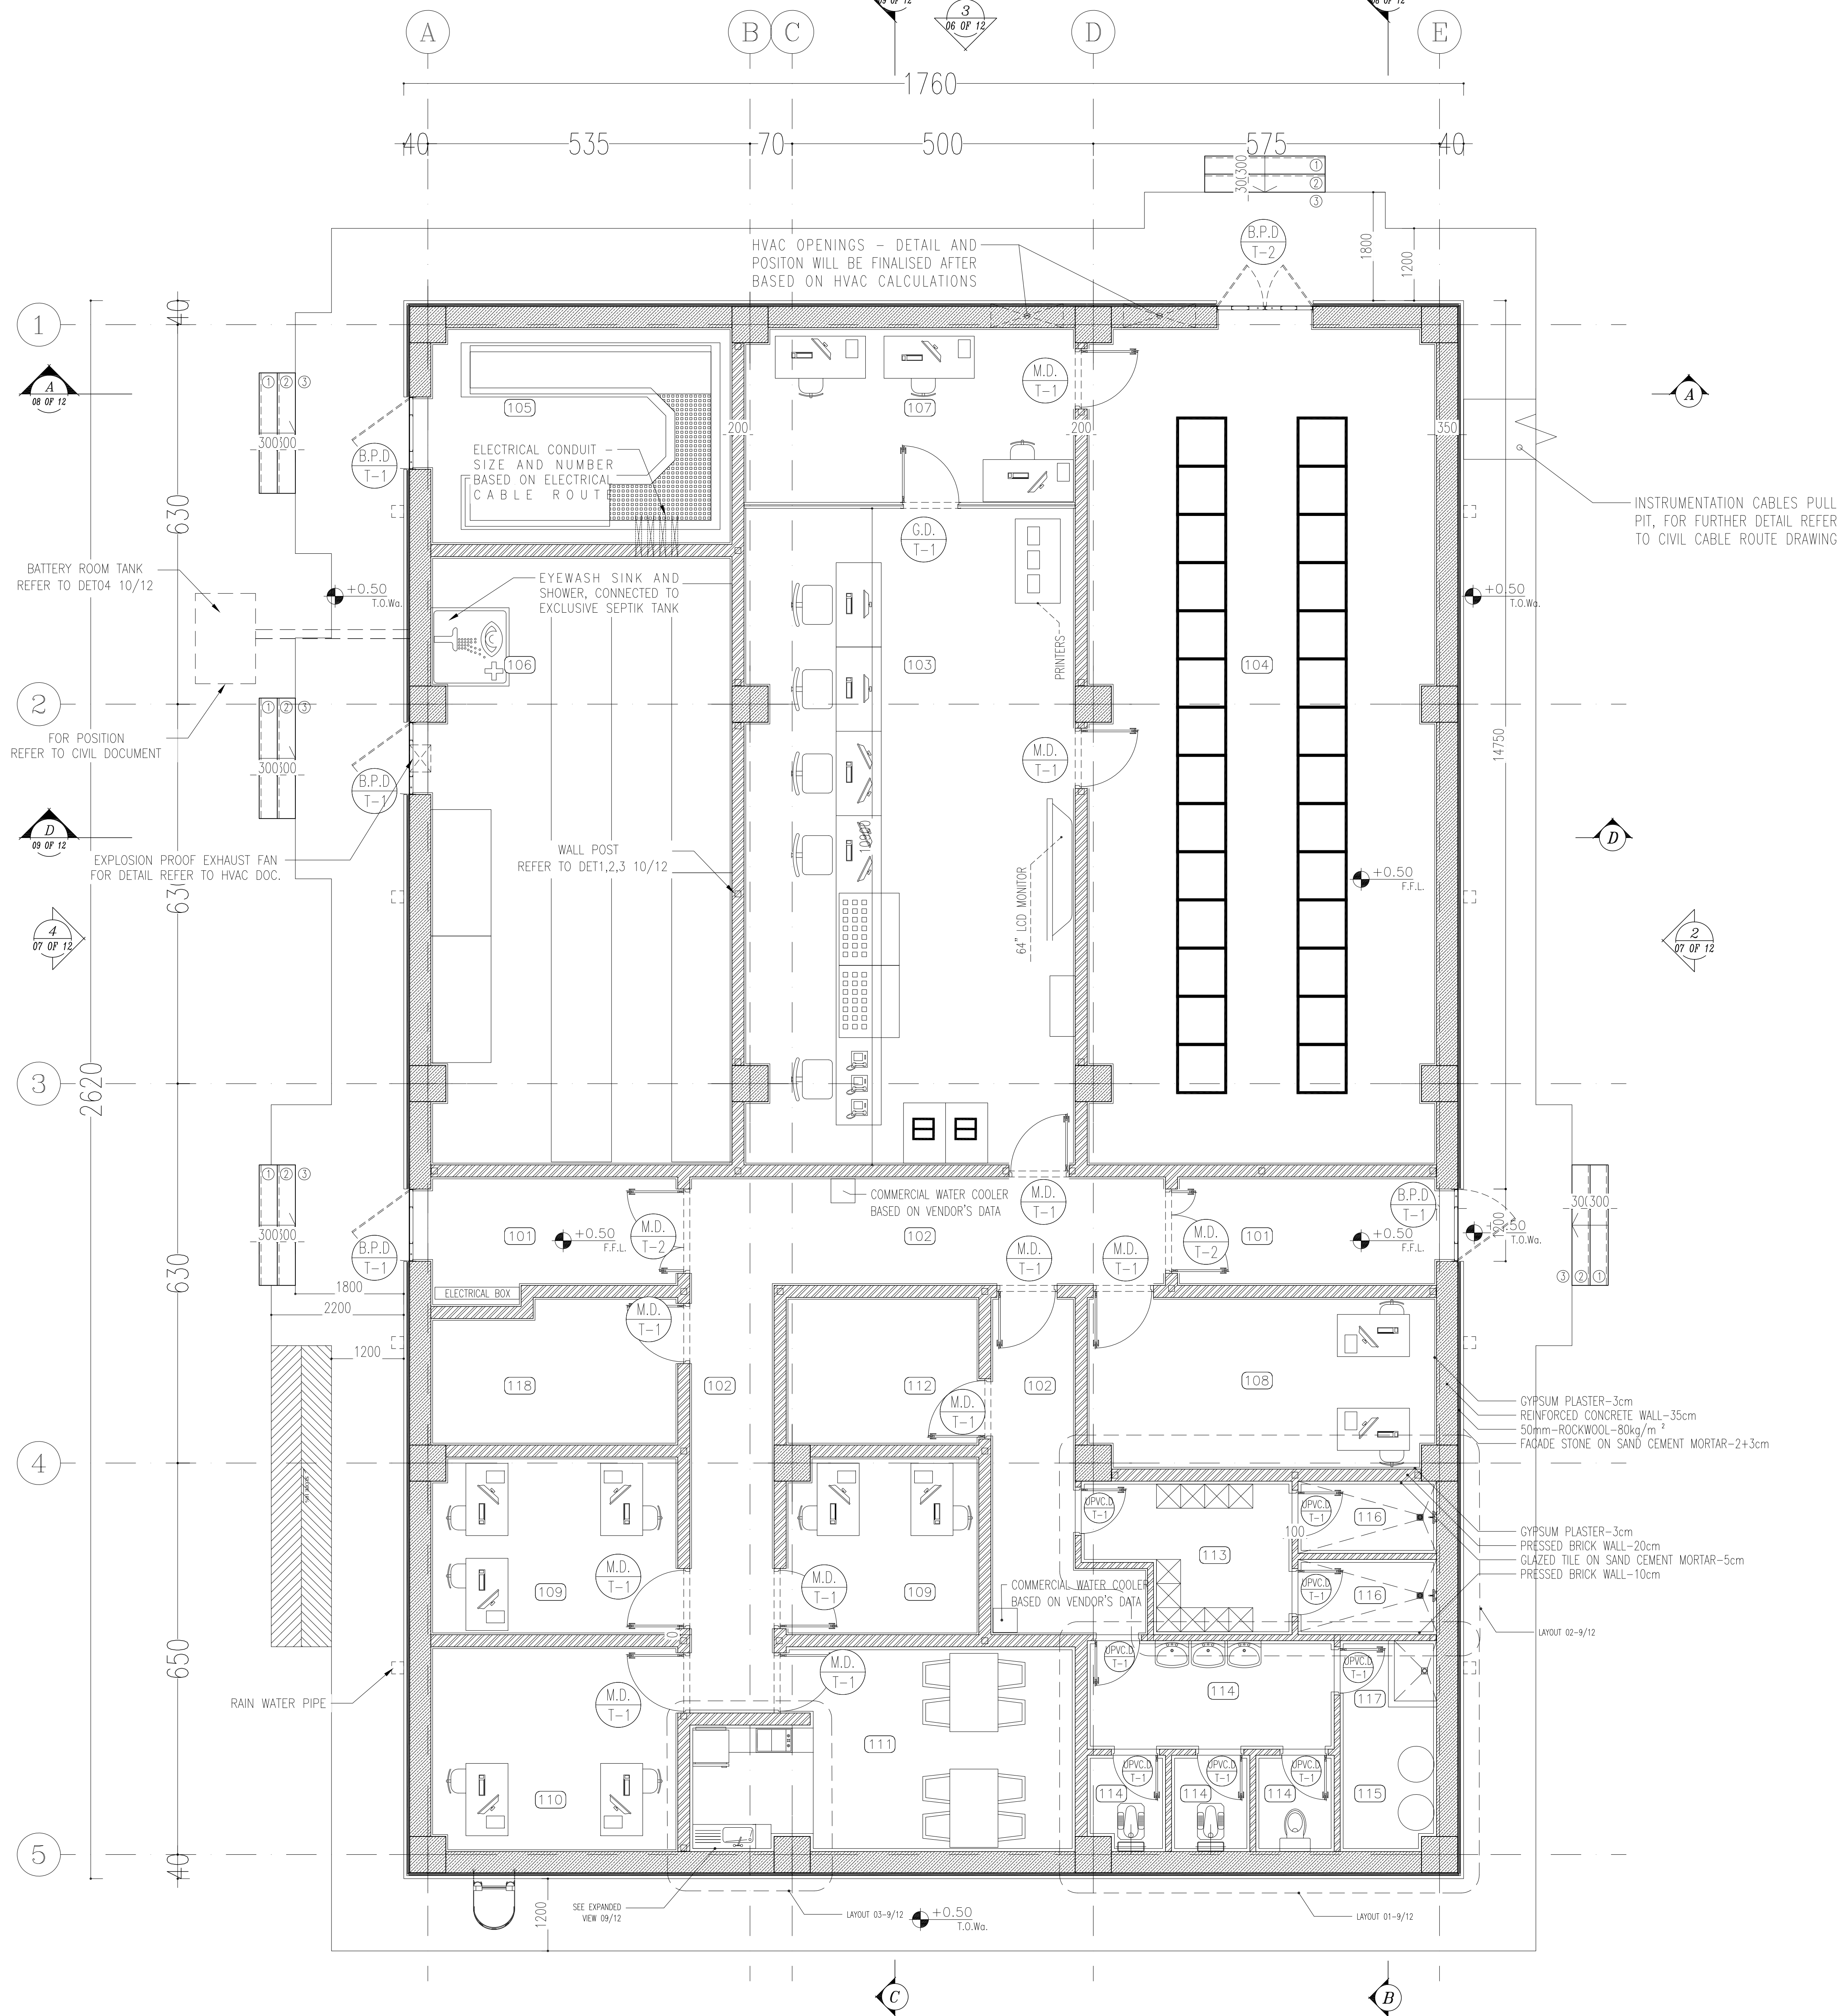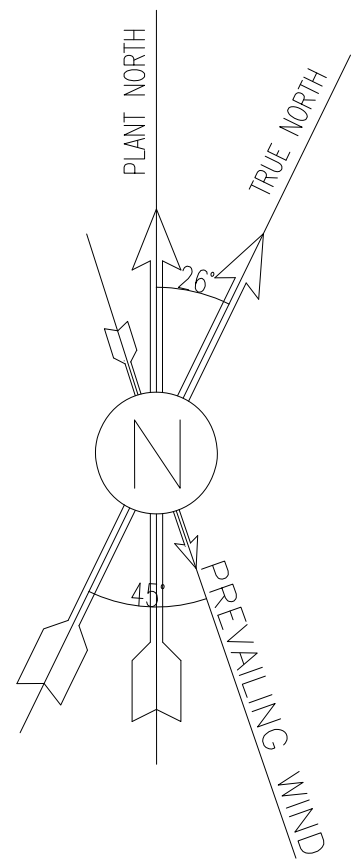


D05

SC:1:50 2 FURNITURE FLOOR PLAN

TAG NAME	NET AREA
101 AIR LOCK	16 sq.m
102 CORRIDOR	33 sq.m
103 CONTROL ROOM	59 sq.m
104 AUXILIARY ROOM	80 sq.m
105 UPS ROOM	18 sq.m
106 BATTERY ROOM	50 sq.m
107 ENGINEERING ROOM	16 sq.m
108 INSTRUMENT ROOM	16 sq.m
109 OFFICE	21 sq.m
110 IN-CHARGE + ARCHIVE	14 sq.m
111 PANTRY + DINING ROOM	20 sq.m
112 PRAYER ROOM	8 sq.m
113 LOCKER	8 sq.m
114 WC	13 sq.m
115 BOILERS	4 sq.m
116 BATHROOM	6 sq.m
117 JANITOR CLOSET	2 sq.m
118 HVAC CONTROL ROOM	9 sq.m

D05	JAN. 2023	IFA	R.BERLOUIE	M.PAKHARIAN	M.Mehrshad	***
D04	OCT. 2022	IFA	R.BERLOUIE	M.PAKHARIAN	M.Mehrshad	***
D03	AUG. 2022	IFA	R.BERLOUIE	M.PAKHARIAN	M.Mehrshad	***
D02	MAR. 2022	IPC	R.BERLOUIE	M.PAKHARIAN	M.Mehrshad	***
D01	JAN. 2022	IPC	R.BERLOUIE	M.PAKHARIAN	M.Mehrshad	***
D00	DEC. 2021	IPC	R.BERLOUIE	M.PAKHARIAN	M.Mehrshad	***

PROJECT NAME:		BINAK OILFIELD DEVELOPMENT/SURFACE FACILITIES GAS COMPRESSOR STATION			
PROJECT NO.:		971020			
EPC CONTRACTOR:		EPD/EPC CONTRACTOR (GC):			
 HIRGAN ENERGY HIRGAN ENERGY - DESIGN & INSPECTION COMPANIES		 PEDCO		 PETROIRAN DEVELOPMENT COMPANY	
DRAWING TITLE:		ARCHITECTURAL DETAIL DRAWING FOR CONTROL BUILDING FLOOR PLAN			
SCALE	SIZE	DRAWING NO.		SHEET NO.	REV.
AS SHOWN	A0	BK-GCS-PEDCO-120-AR-DW-0001		02 OF 12	D05

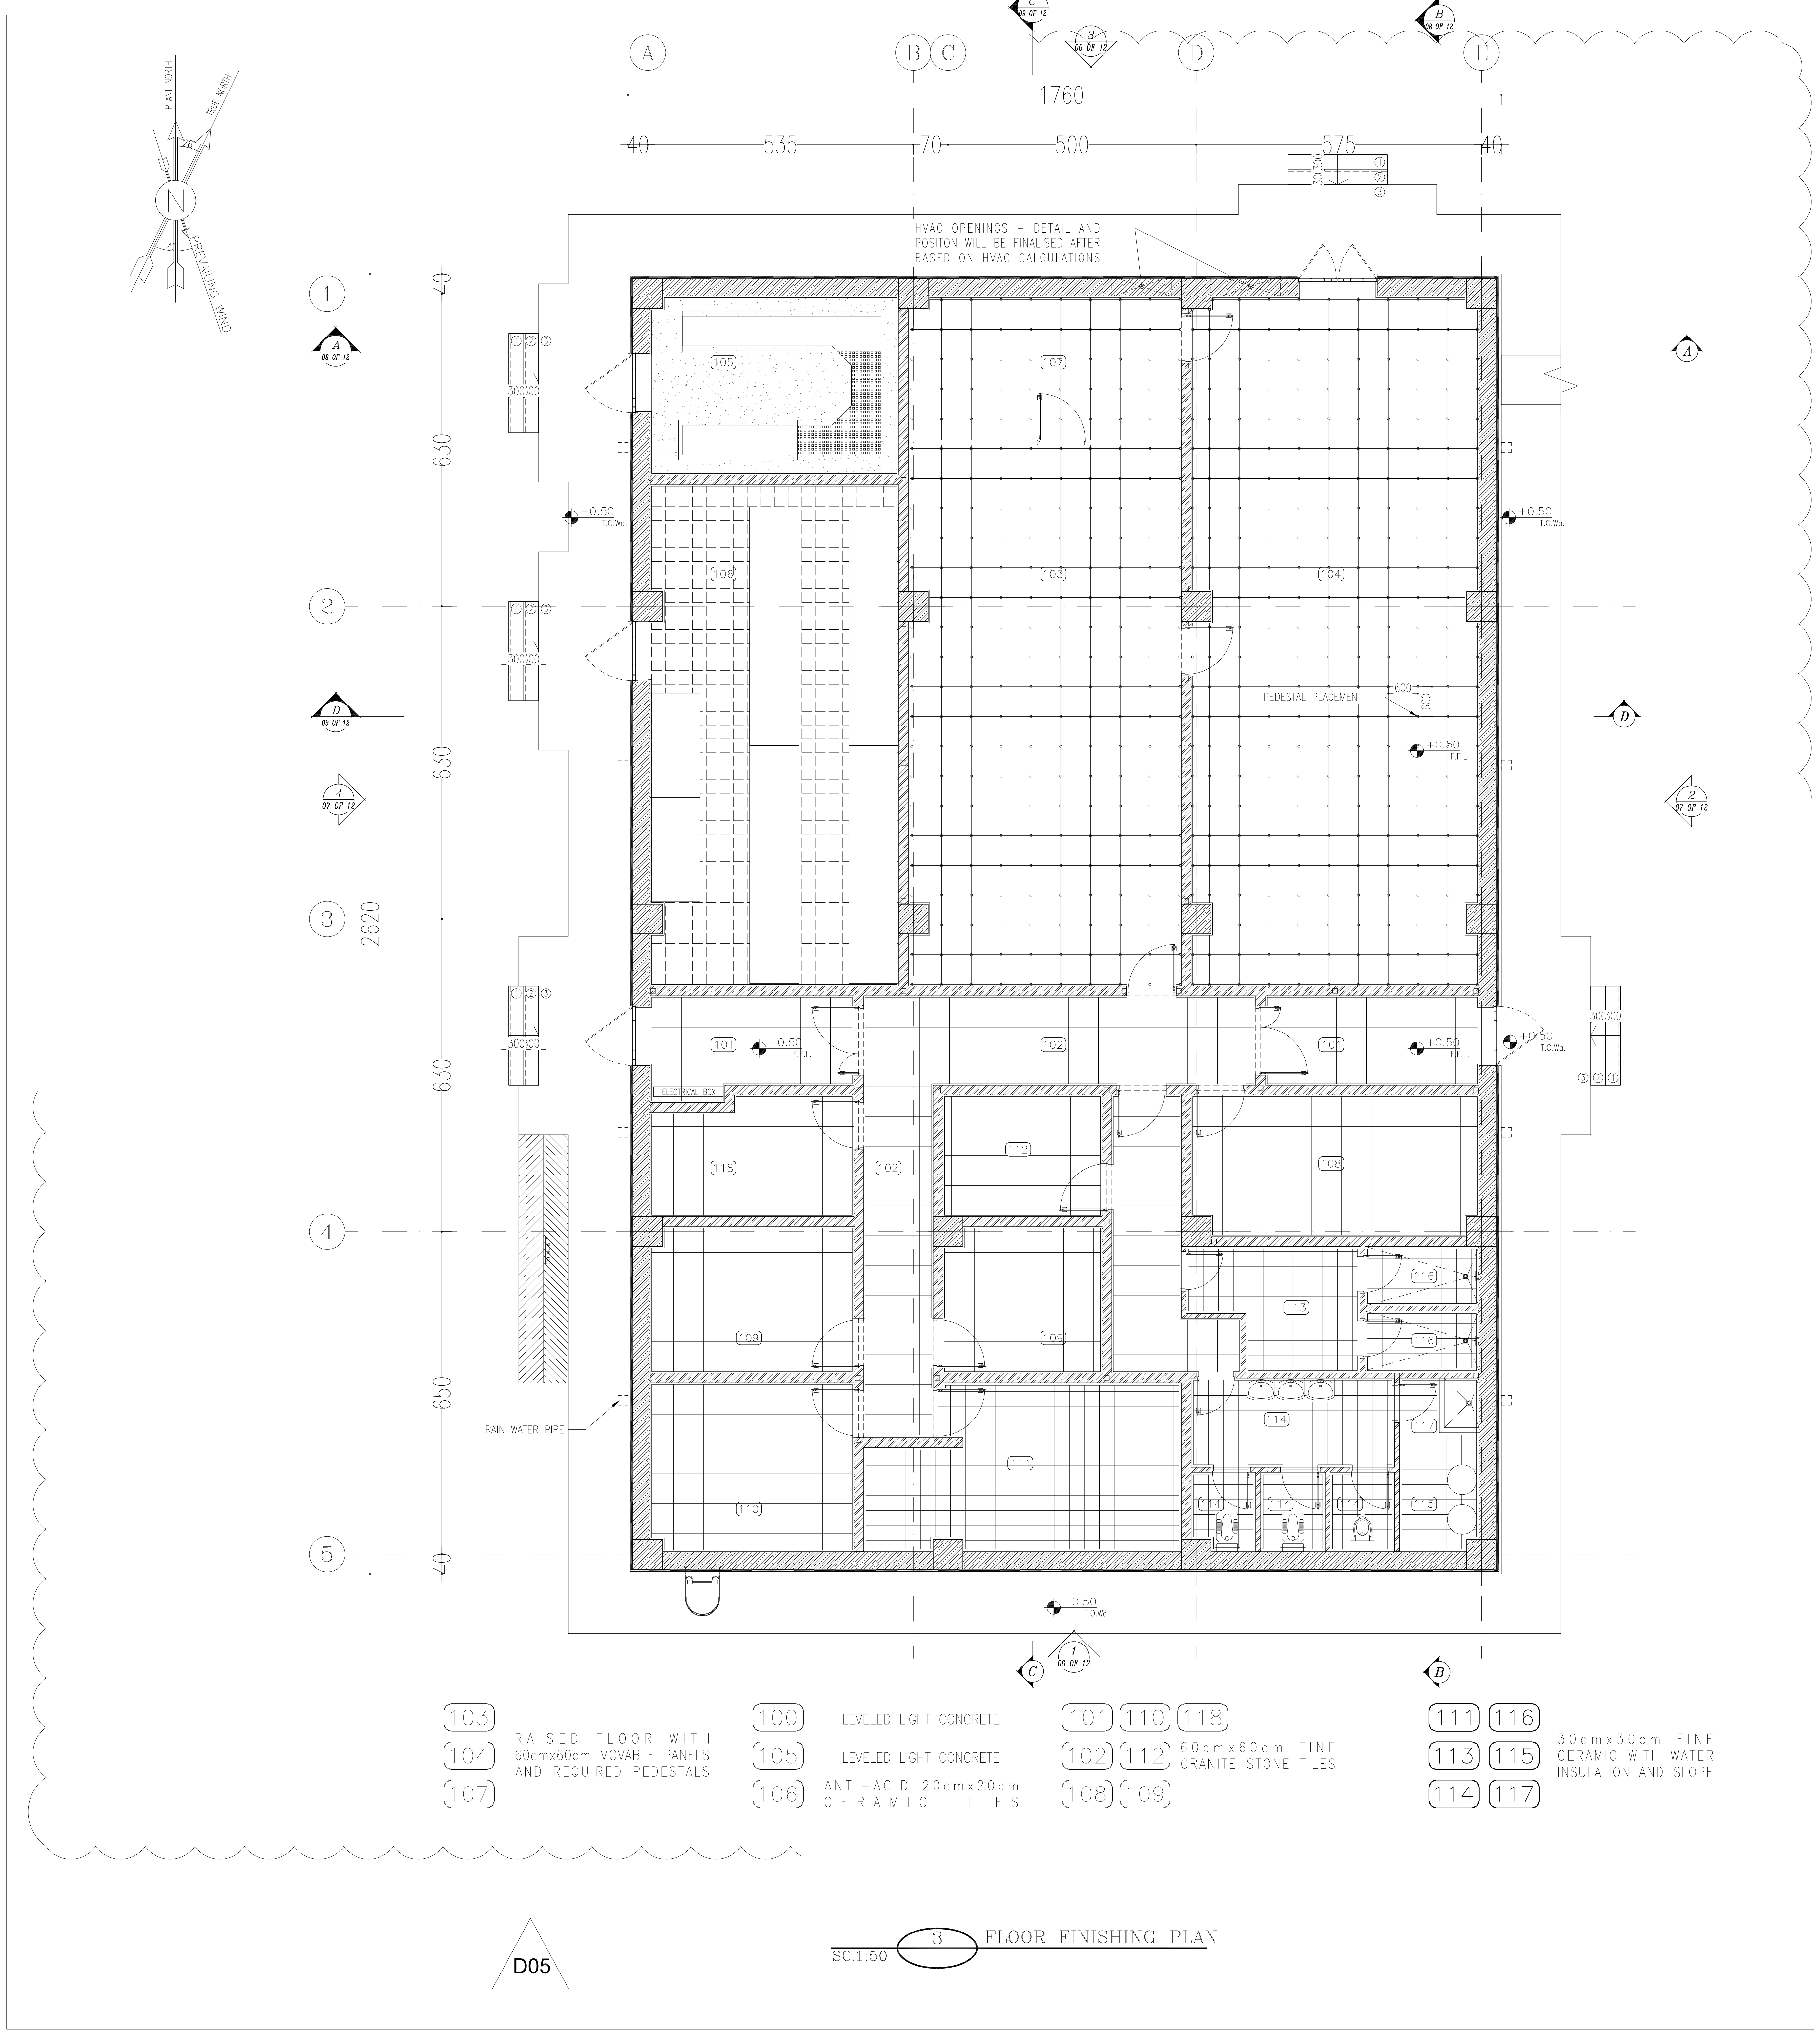

- NOTES**
1. ALL DIMENSIONS ARE IN CENTIMETER & ALL ELEVATIONS ARE IN METER.
 2. ALL DIMENSIONS AND ELEVATIONS SHALL BE CHECKED BY THE CONTRACTOR PRIOR TO CONSTRUCTION.
 3. CONTRACTOR SHALL COMPARE ALL ARCHITECTURAL, MECHANICAL, ELECTRICAL, PIPING AND STRUCTURAL DRAWINGS AND IN CASE OF ANY CONFLICTS OR DISCREPANCY, INFORM THE ENGINEER.
 4. ALL MATERIALS ARE SELECTED FROM THE HIGHEST QUALITY AND MUST BE APPROVED BY THE CLIENT.
 5. ALL OPENINGS FOR PIPING/DRAINING AND HVAC OPENINGS SHALL BE CONSIDERED AS PER RELATED DRAWINGS BEFORE CONSTRUCTION.
 6. ALL INTERNAL SLOPES FOR FLOOR DRAINS ARE 1% UNLESS STATED.
 7. KNAUF BOARDS SHALL BE 'MR' IN MOST SPACES AND TYP IN HEAT ZONES.
 8. FINISH GRADING LEVEL (T.O.S.L.) = +11.20 (M.S.L.) = ±0.00 (LOCAL).
 9. ALL W.S. ARE EQUIPPED WITH HAND-WASH-HOT AIR-BLOWER-ELECTRICAL SOAP DISPENSER WITH ABS DOORS(WITH CLOSER MECHANISM).
 10. ACCORDING TO SPECIFICATION FOR BUILDINGS INTERIOR PAINTING FOR MASONRY, CONCRETE, PLASTER, GYPSUM WALL BOARD SHALL DONE AS FOLLOW : 1st COAT, PRIMER AND SEALER, 2nd AND 3rd COATS, INTERIOR PAINT SEM LUSTRE (WHITE ALKYLID PAINT).
 11. ALL BLASTPROOF DOORS ARE PANIC DOORS - PANIC BARS ARE REQUIRED.
 12. BATTERY ROOM SHALL BE EQUIPPED WITH EXPLOSION-PROOF,FANLIGHTING,SWITCHES,OUTLETS AND ETC.

LEGEND

CONCRETE WALL OR CEILING

PRESSED BRICK

ANTI ACID CERAMIC TILE (200x200mm)

MOVABLE PANELS RAISED FLOOR TILES (AS PER GENERAL F.F.L. - +0.90m)

CHEQUERED PLATE


GRANITE PLAQUE STONE (60x60)

LEVELED LIGHT CONCRETE

CERAMIC TILES(30x30)



F.F.L. FINISHED FLOOR W.D. WOOD DOOR
T.O.WA TOP OF WALKWAY T.O.D. TOP OF DOOR
T.O.R. TOP OF ROOF F.G.L. FINISH GRADING LEVEL
T.O.P. TOP OF PARAPET B.P.D. BLAST-PROOF DOOR
T.O.FOU. TOP OF FOUNDATION B.O.Ca. BOTTOM OF LADDER CAGE
AL.D. ALUMINIUM DOOR T.O.Ca. TOP OF LADDER CAGE
M.D. METAL DOOR

REFERENCE DRAWING	DRG. No.
Standard Details For Ladder & Safety Cage	BK-GNRL-PEDCO-000-ST-DW-0009
FOUNDATION DRAWING FOR CONTROL BUILDING	BK-GCS-PEDCO-120-ST-DW-0061
STRUCTURAL DRAWING FOR CONTROL BUILDING	BK-GCS-PEDCO-120-ST-DW-0062
ROAD, PAVING AND PLANT FINISH GRADING LAYOUT & SECTIONS	BK-GCS-PEDCO-120-CV-PY-0005
CABLE TRENCH AND DUCT BANK LAYOUT	BK-GCS-PEDCO-120-CV-PY-0002
ELECTRICAL CABLE ROUTE & SECTION LAYOUT FOR BUILDING & SHELTER	BK-GCS-PEDCO-120-EL-PY-0006
CONTROL ROOM LAYOUT & ARRANGEMENT DRAWING	BK-GCS-PEDCO-120-IN-PY-0001
PLUMBING & SEWAGE PIPING LAYOUT FOR CONTROL BUILDING	BK-GCS-PEDCO-120-HV-PY-0001
HVAC ROOM LAYOUT & SECTION FOR CONTROL BUILDING	BK-GCS-PEDCO-120-HV-PY-0002
HVAC SYSTEM DUCT PLAN FOR CONTROL BUILDING	BK-GCS-PEDCO-120-HV-PY-0003
HVAC SYSTEM ROOF LAYOUT FOR CONTROL BUILDING	BK-GCS-PEDCO-120-HV-PY-0004

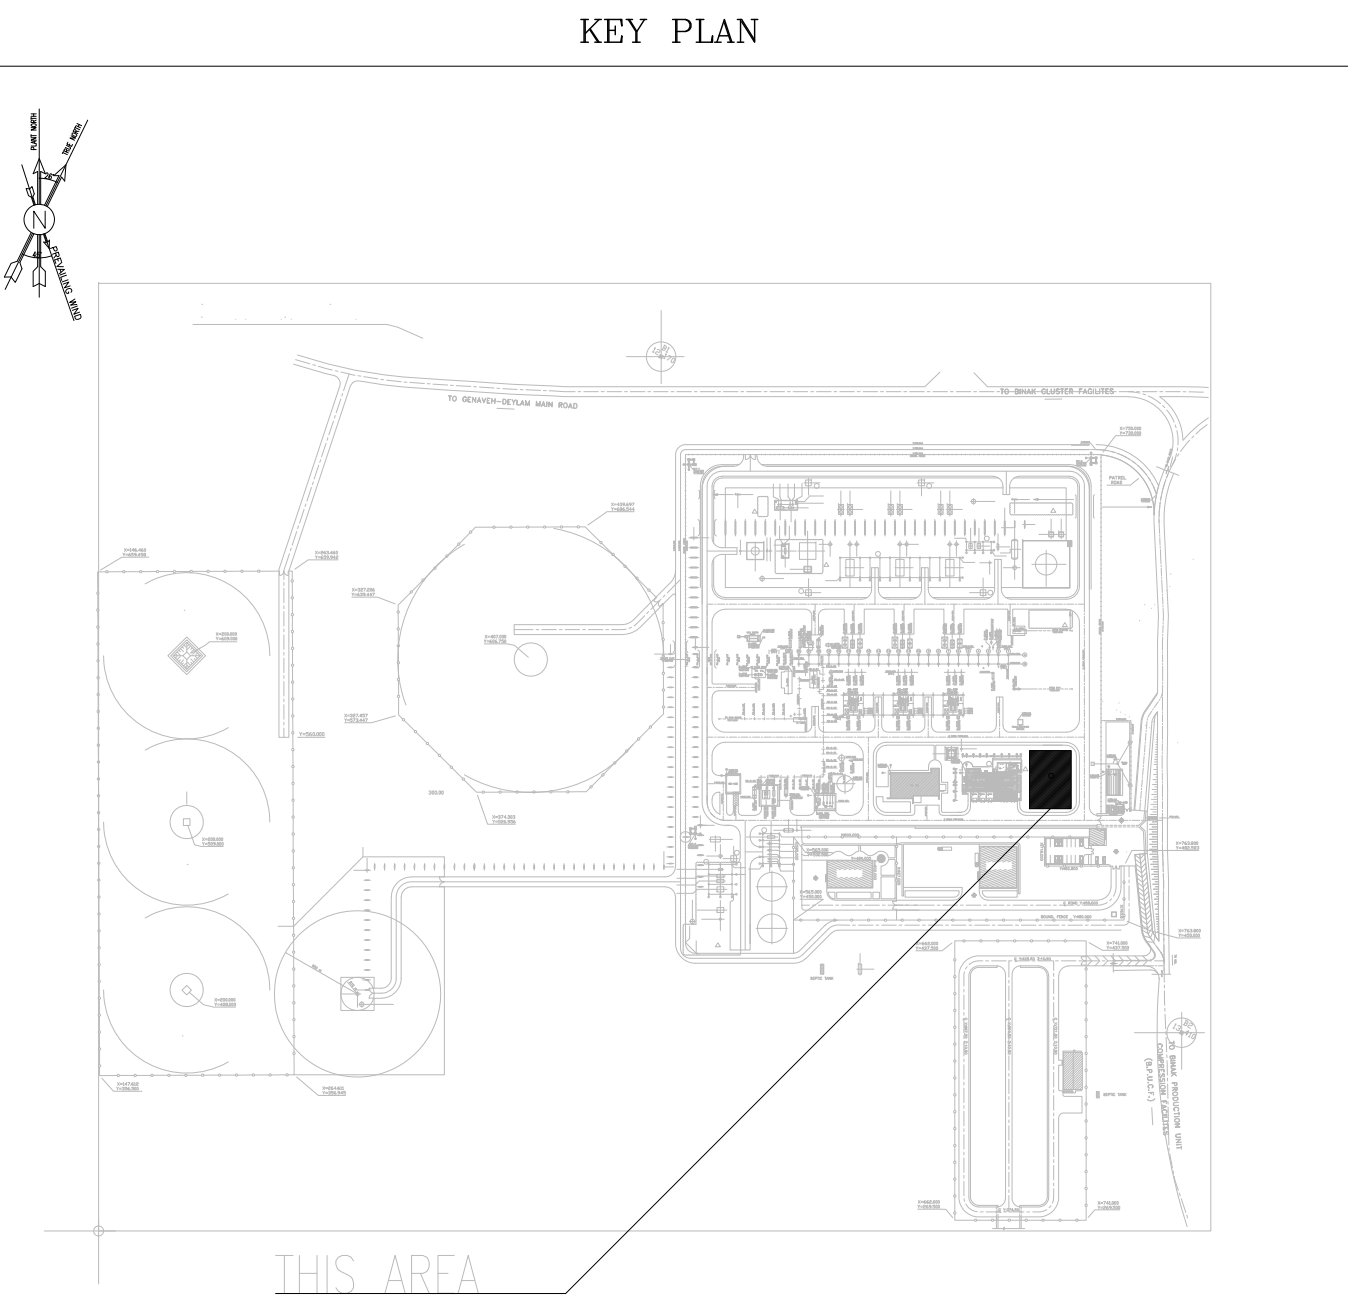

TAG NAME	NET AREA
101 AIR LOCK	16 sq.m
102 CORRIDOR	33 sq.m
103 CONTROL ROOM	59 sq.m
104 AUXILIARY ROOM	80 sq.m
105 UPS ROOM	18 sq.m
106 BATTERY ROOM	50 sq.m
107 ENGINEERING ROOM	16 sq.m
108 INSTRUMENT ROOM	16 sq.m
109 OFFICE	21 sq.m
110 IN-CHARGE + ARCHIVE	14 sq.m
111 PANTRY + DINING ROOM	20 sq.m
112 PRAYER ROOM	8 sq.m
113 LOCKER	8 sq.m
114 WC	13 sq.m
115 BOILERS	4 sq.m
116 BATHROOM	6 sq.m
117 JANITOR CLOSET	2 sq.m
118 HVAC CONTROL ROOM	9 sq.m

D05	JAN.2023	IFA	R.BERLOUIE	M.PAKHARIAN	M.Mehrshad	***																			
D04	OCT.2022	IFA	R.BERLOUIE	M.PAKHARIAN	M.Mehrshad	***																			
D03	AUG.2022	IFA	R.BERLOUIE	M.PAKHARIAN	M.Mehrshad	***																			
D02	MAR.2022	IPC	R.BERLOUIE	M.PAKHARIAN	M.Mehrshad	***	***	*****	***	****	***	****	***	*****											
D01	JAN.2022	IPC	R.BERLOUIE	M.PAKHARIAN	M.Mehrshad	***	REV.	DESCRIPTION	BY	DATE	BY	DATE	REV.	APPR.	اصل و کلیه نسخ این نقشه و حق اقتباس متعلق به شرکت ملی مناطق نفت خیز جنوب میباشد. THE ORIGINAL AND ALL COPIES OF THIS DRAWING TOGETHER WITH THE COPYRIGHT THEREIN ARE THE SOLE PROPERTY OF N.I.S.O.C./ FIELDS										
D00	DEC.2021	IPC	R.BERLOUIE	M.PAKHARIAN	M.Mehrshad	***																			
REV.	DATE	P.O.I.S	PREP.	CHK.	APP.	AUT.																			
PROJECT NAME:							BINAK OILFIELD DEVELOPMENT/SURFACE FACILITIES GAS COMPRESSOR STATION																		
PROJECT NO.:							971020																		
EPC CONTRACTOR:							EPD/EPC CONTRACTOR (GC):																		
 HIRGAN ENERGY - DESIGN & INSPECTION COMPANIES							 PEDCO							 PETROIRAN DEVELOPMENT COMPANY							BINAK OILFIELD DEVELOPMENT SURFACE FACILITIES GAS COMPRESSOR STATION				
														DATE	SCALE	DRAWING BY	CHECKED BY	PROJECT ENG.							
DRAWING TITLE:							ARCHITECTURAL DETAIL DRAWING FOR CONTROL BUILDING							NO CONSTRUCTION PERMITTED UNLESS DRAWING APPROVED											
							FLOOR PLAN							APPROVED FOR CONSTRUCTION							BY:		DATE:		
SCALE	SIZE	DRAWING NO.			SHEET NO.	REV.	BUDGET REF.	LOCATION	SIZE	CLASS	SERIAL NO.		SHEET	REVISION											
AS SHOWN	A0	BK-GCS-PEDCO-120-AR-DW-0001			03 OF 12	D05	053-073-9184	F	4	B	709099		03 OF 12	D05											

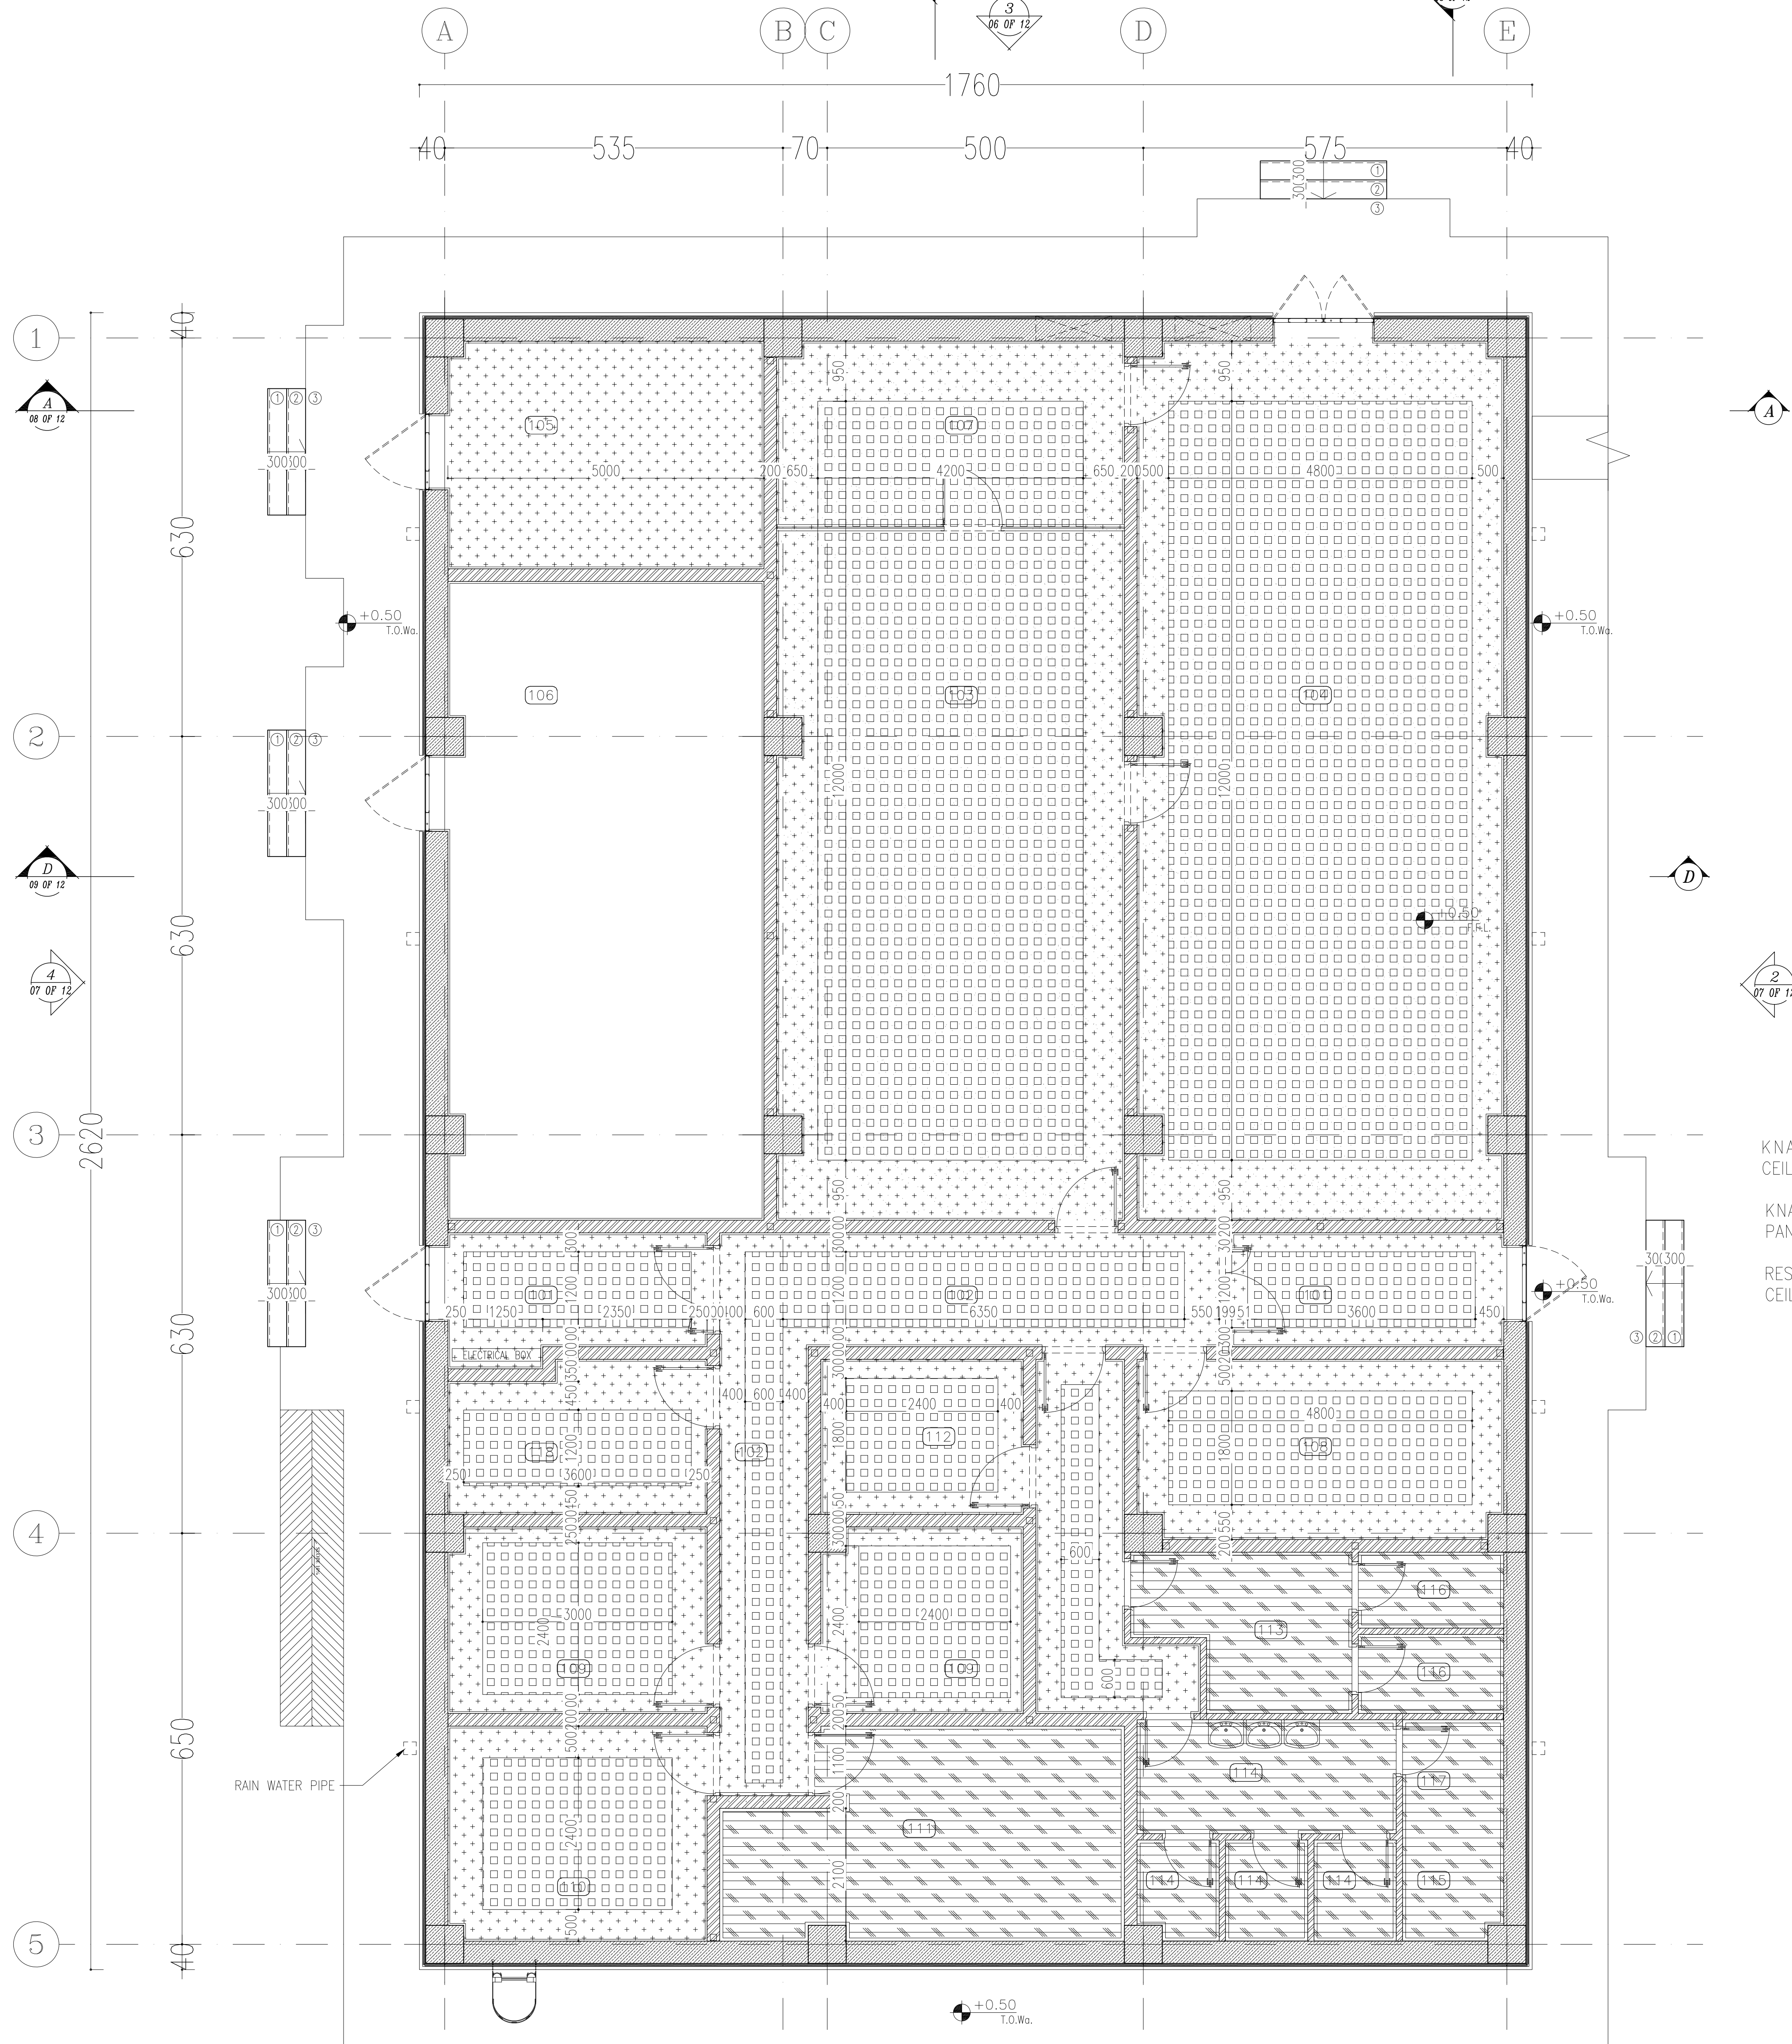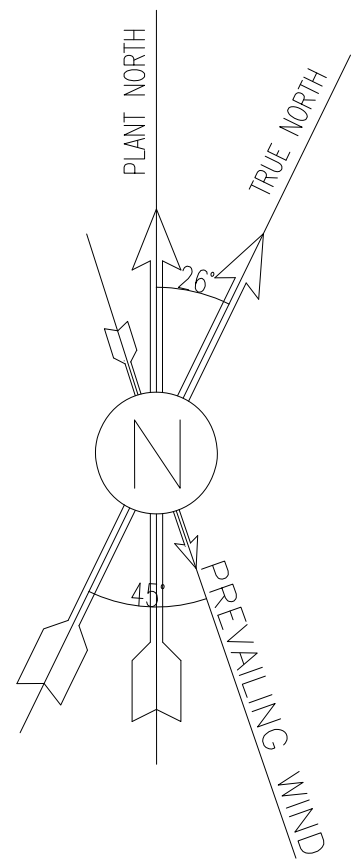

KNAUF REMOVABLE SUSPENDED
CEILING PANELS- +3.00 ABOVE F.F.L.

KNAUF SUSPENDED CEILING
PANELS - 2.80 ABOVE F.F.L.

RESINATED MOVABLE KNAUF SUSPENDED
CEILING- +2.40 ABOVE F.F.L.

KNAUF REMOVABLE SUSPENDED
CEILING PANELS- +2.80 ABOVE F.F.L.

KNAUF SUSPENDED CEILING
PANELS - +2.60 ABOVE F.F.L.

TAG NAME	NET AREA
101 AIR LOCK	16 sq.m
102 CORRIDOR	33 sq.m
103 CONTROL ROOM	59 sq.m
104 AUXILIARY ROOM	80 sq.m
105 UPS ROOM	18 sq.m
106 BATTERY ROOM	50 sq.m
107 ENGINEERING ROOM	16 sq.m
108 INSTRUMENT ROOM	16 sq.m
109 OFFICE	21 sq.m
110 IN-CHARGE + ARCHIVE	14 sq.m
111 PANTRY + DINING ROOM	20 sq.m
112 PRAYER ROOM	8 sq.m
113 LOCKER	8 sq.m
114 WC	13 sq.m
115 BOILERS	4 sq.m
116 BATHROOM	6 sq.m
117 JANITOR CLOSET	2 sq.m
118 HVAC CONTROL ROOM	9 sq.m


D05	JAN. 2023	IFA	R.BERLOUIE	M.PAKHARIAN	M.Mehrshad	***
D04	OCT. 2022	IFA	R.BERLOUIE	M.PAKHARIAN	M.Mehrshad	***
D03	AUG. 2022	IFA	R.BERLOUIE	M.PAKHARIAN	M.Mehrshad	***
D02	MAR. 2022	IPC	R.BERLOUIE	M.PAKHARIAN	M.Mehrshad	***
D01	JAN. 2022	IPC	R.BERLOUIE	M.PAKHARIAN	M.Mehrshad	***
D00	DEC. 2021	IPC	R.BERLOUIE	M.PAKHARIAN	M.Mehrshad	***
REV.	DATE	P.O.I.S	PREP.	CHK.	APP.	AUT.

PROJECT NAME:		BINAK OILFIELD DEVELOPMENT/SURFACE FACILITIES GAS COMPRESSOR STATION			
PROJECT NO.:		971020			
EPC CONTRACTOR:		EPD/EPC CONTRACTOR (GC):			
 HIRGAN ENERGY - DESIGN & INSPECTION COMPANIES		 PEDCO		 PETROIRAN DEVELOPMENT COMPANY	
DRAWING TITLE:		ARCHITECTURAL DETAIL DRAWING FOR CONTROL BUILDING SUSPENDED CEILING PLAN			
SCALE	SIZE	DRAWING NO.		SHEET NO.	REV.
AS SHOWN	A0	BK-GCS-PEDCO-120-AR-DW-0001		04 OF 12	D05


- NOTES
1. ALL DIMENSIONS ARE IN CENTIMETER & ALL ELEVATIONS ARE IN METER.
 2. CONTRACTOR SHALL CHECK ALL DIMENSIONS AND ELEVATIONS PRIOR TO CONSTRUCTION.
 3. CONTRACTOR SHALL CHECK ALL DIMENSIONS AND ELEVATIONS PRIOR TO CONSTRUCTION.
 4. ALL MATERIALS ARE SELECTED FROM THE HIGHEST QUALITY AND MUST BE APPROVED BY THE CLIENT.
 5. ALL CHANGES FOR PIPING/DRAINING AND HVAC DEMANDS SHALL BE CONSIDERED AS PER RELATED DRAWINGS BEFORE CONSTRUCTION.
 6. ALL INTERNAL SLOPES FOR FLOOR DRAINS ARE 1% UNLESS STATED.
 7. KNAUF BOARDS SHALL BE "M" IN MOST SPACES AND "T" IN HEAT ZONES.
 8. FINISH GRADING LEVEL (T.O.L.) = +1.20 (M.S.L.) = +0.00 (LOCAL).
 9. ALL W.S. ARE EQUIPPED WITH HAND-WASH-HOT AIR-BLOWER-ELECTRICAL SOAP DISPENSER WITH ABS DOORS(WITH CLOSER MECHANISM).
 10. ACCORDING TO SPECIFICATION FOR BUILDINGS INTERIOR PAINTING FOR MASONRY, CONCRETE, PLASTER, GYPSUM WALL BOARD SHALL BE DONE AS FOLLOWS: 1st COAT, PRIMER AND SEALER, 2nd AND 3rd COATS, INTERIOR PAINT SEMI LUSTRE (WHITE ALKYLID PAINT).
 11. ALL BLASTPROOF DOORS ARE PANIC DOORS - PANIC BARS ARE REQUIRED.
 12. BATTERY ROOM SHALL BE EQUIPPED WITH EXPLOSION-PROOF,FANLIGHTING,SWITCHES,OUTLETS AND ETC.

LEGEND			
CONCRETE WALL OR CEILING			
PRESSED BRICK			
F.F.L.	FINISHED FLOOR	W.D	WOOD DOOR
T.O.WA	TOP OF WALKWAY	T.O.D.	TOP OF DOOR
T.O.R.	TOP OF ROOF	F.G.L.	FINISH GRADING LEVEL
T.O.P.	TOP OF PARAPET	B.P.D.	BLAST-PROOF DOOR
T.O.FOU.	TOP OF FOUNDATION	B.O.Ca.	BOTTOM OF LADDER CAGE
AL.D.	ALUMINIUM DOOR	T.O.Ca.	TOP OF LADDER CAGE
M.D.	METAL DOOR		

REFERENCE DRAWING	DRG. No.
Standard Details For Ladder & Safety Cage	BK-GNRL-PEDCO-000-ST-DW-0009
FOUNDATION DRAWING FOR CONTROL BUILDING	BK-GCS-PEDCO-120-ST-DW-0061
STRUCTURAL DRAWING FOR CONTROL BUILDING	BK-GCS-PEDCO-120-ST-DW-0062
ROAD, PAVING AND PLANT FINISH GRADING LAYOUT & SECTIONS	BK-GCS-PEDCO-120-CV-PY-0005
CABLE TRENCH AND DUCT BANK LAYOUT	BK-GCS-PEDCO-120-CV-PY-0002
ELECTRICAL CABLE ROUTE & SECTION LAYOUT FOR BUILDING & SHELTER	BK-GCS-PEDCO-120-EL-PY-0006
CONTROL ROOM LAYOUT & ARRANGEMENT DRAWING	BK-GCS-PEDCO-120-IN-PY-0001
PLUMBING & SEWAGE PIPING LAYOUT FOR CONTROL BUILDING	BK-GCS-PEDCO-120-HV-PY-0001
HVAC ROOM LAYOUT & SECTION FOR CONTROL BUILDING	BK-GCS-PEDCO-120-HV-PY-0002
HVAC SYSTEM DUCT PLAN FOR CONTROL BUILDING	BK-GCS-PEDCO-120-HV-PY-0003
HVAC SYSTEM ROOF LAYOUT FOR CONTROL BUILDING	BK-GCS-PEDCO-120-HV-PY-0004

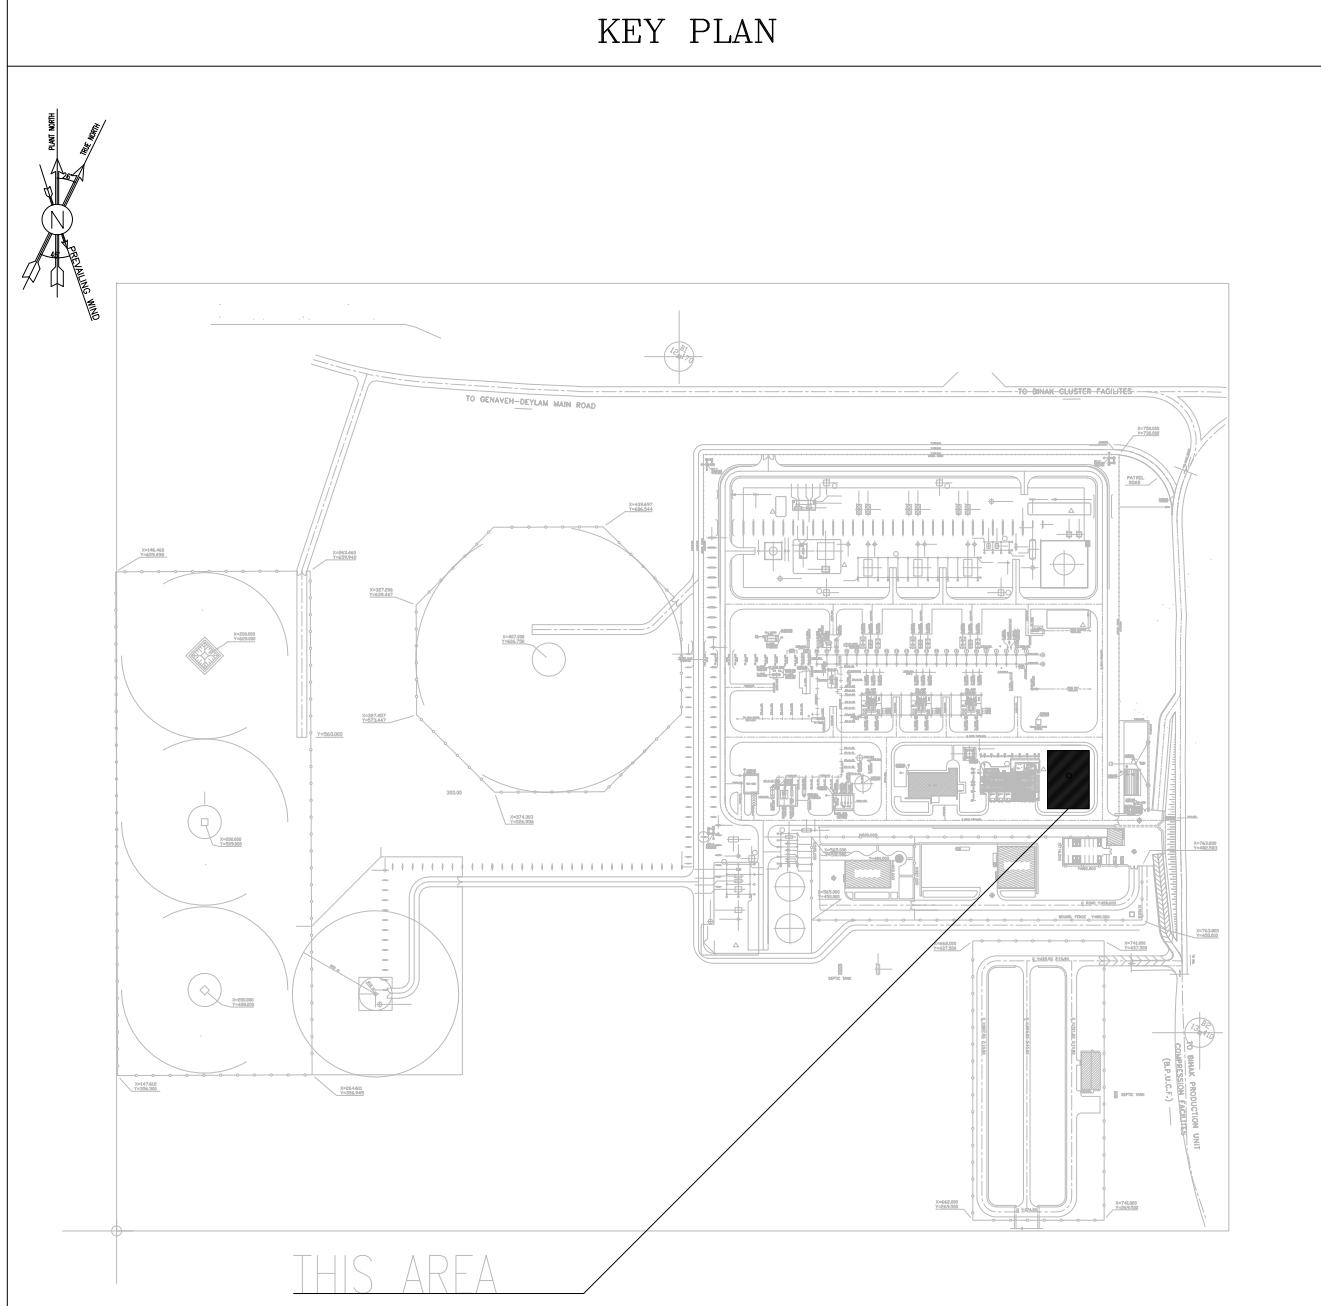

THIS AREA					
DATE	SCALE	DRAWING BY	CHECKED BY	PROJECT ENG.	
NO CONSTRUCTION PERMITTED UNLESS DRAWING APPROVED					
APPROVED FOR CONSTRUCTION			BY:	DATE:	
BUDGET REF.	LOCATION	SIZE CLASS	SERIAL NO.	SHEET	REVISION
053-073-9184	F	4	B	709099	04 OF 12 D05

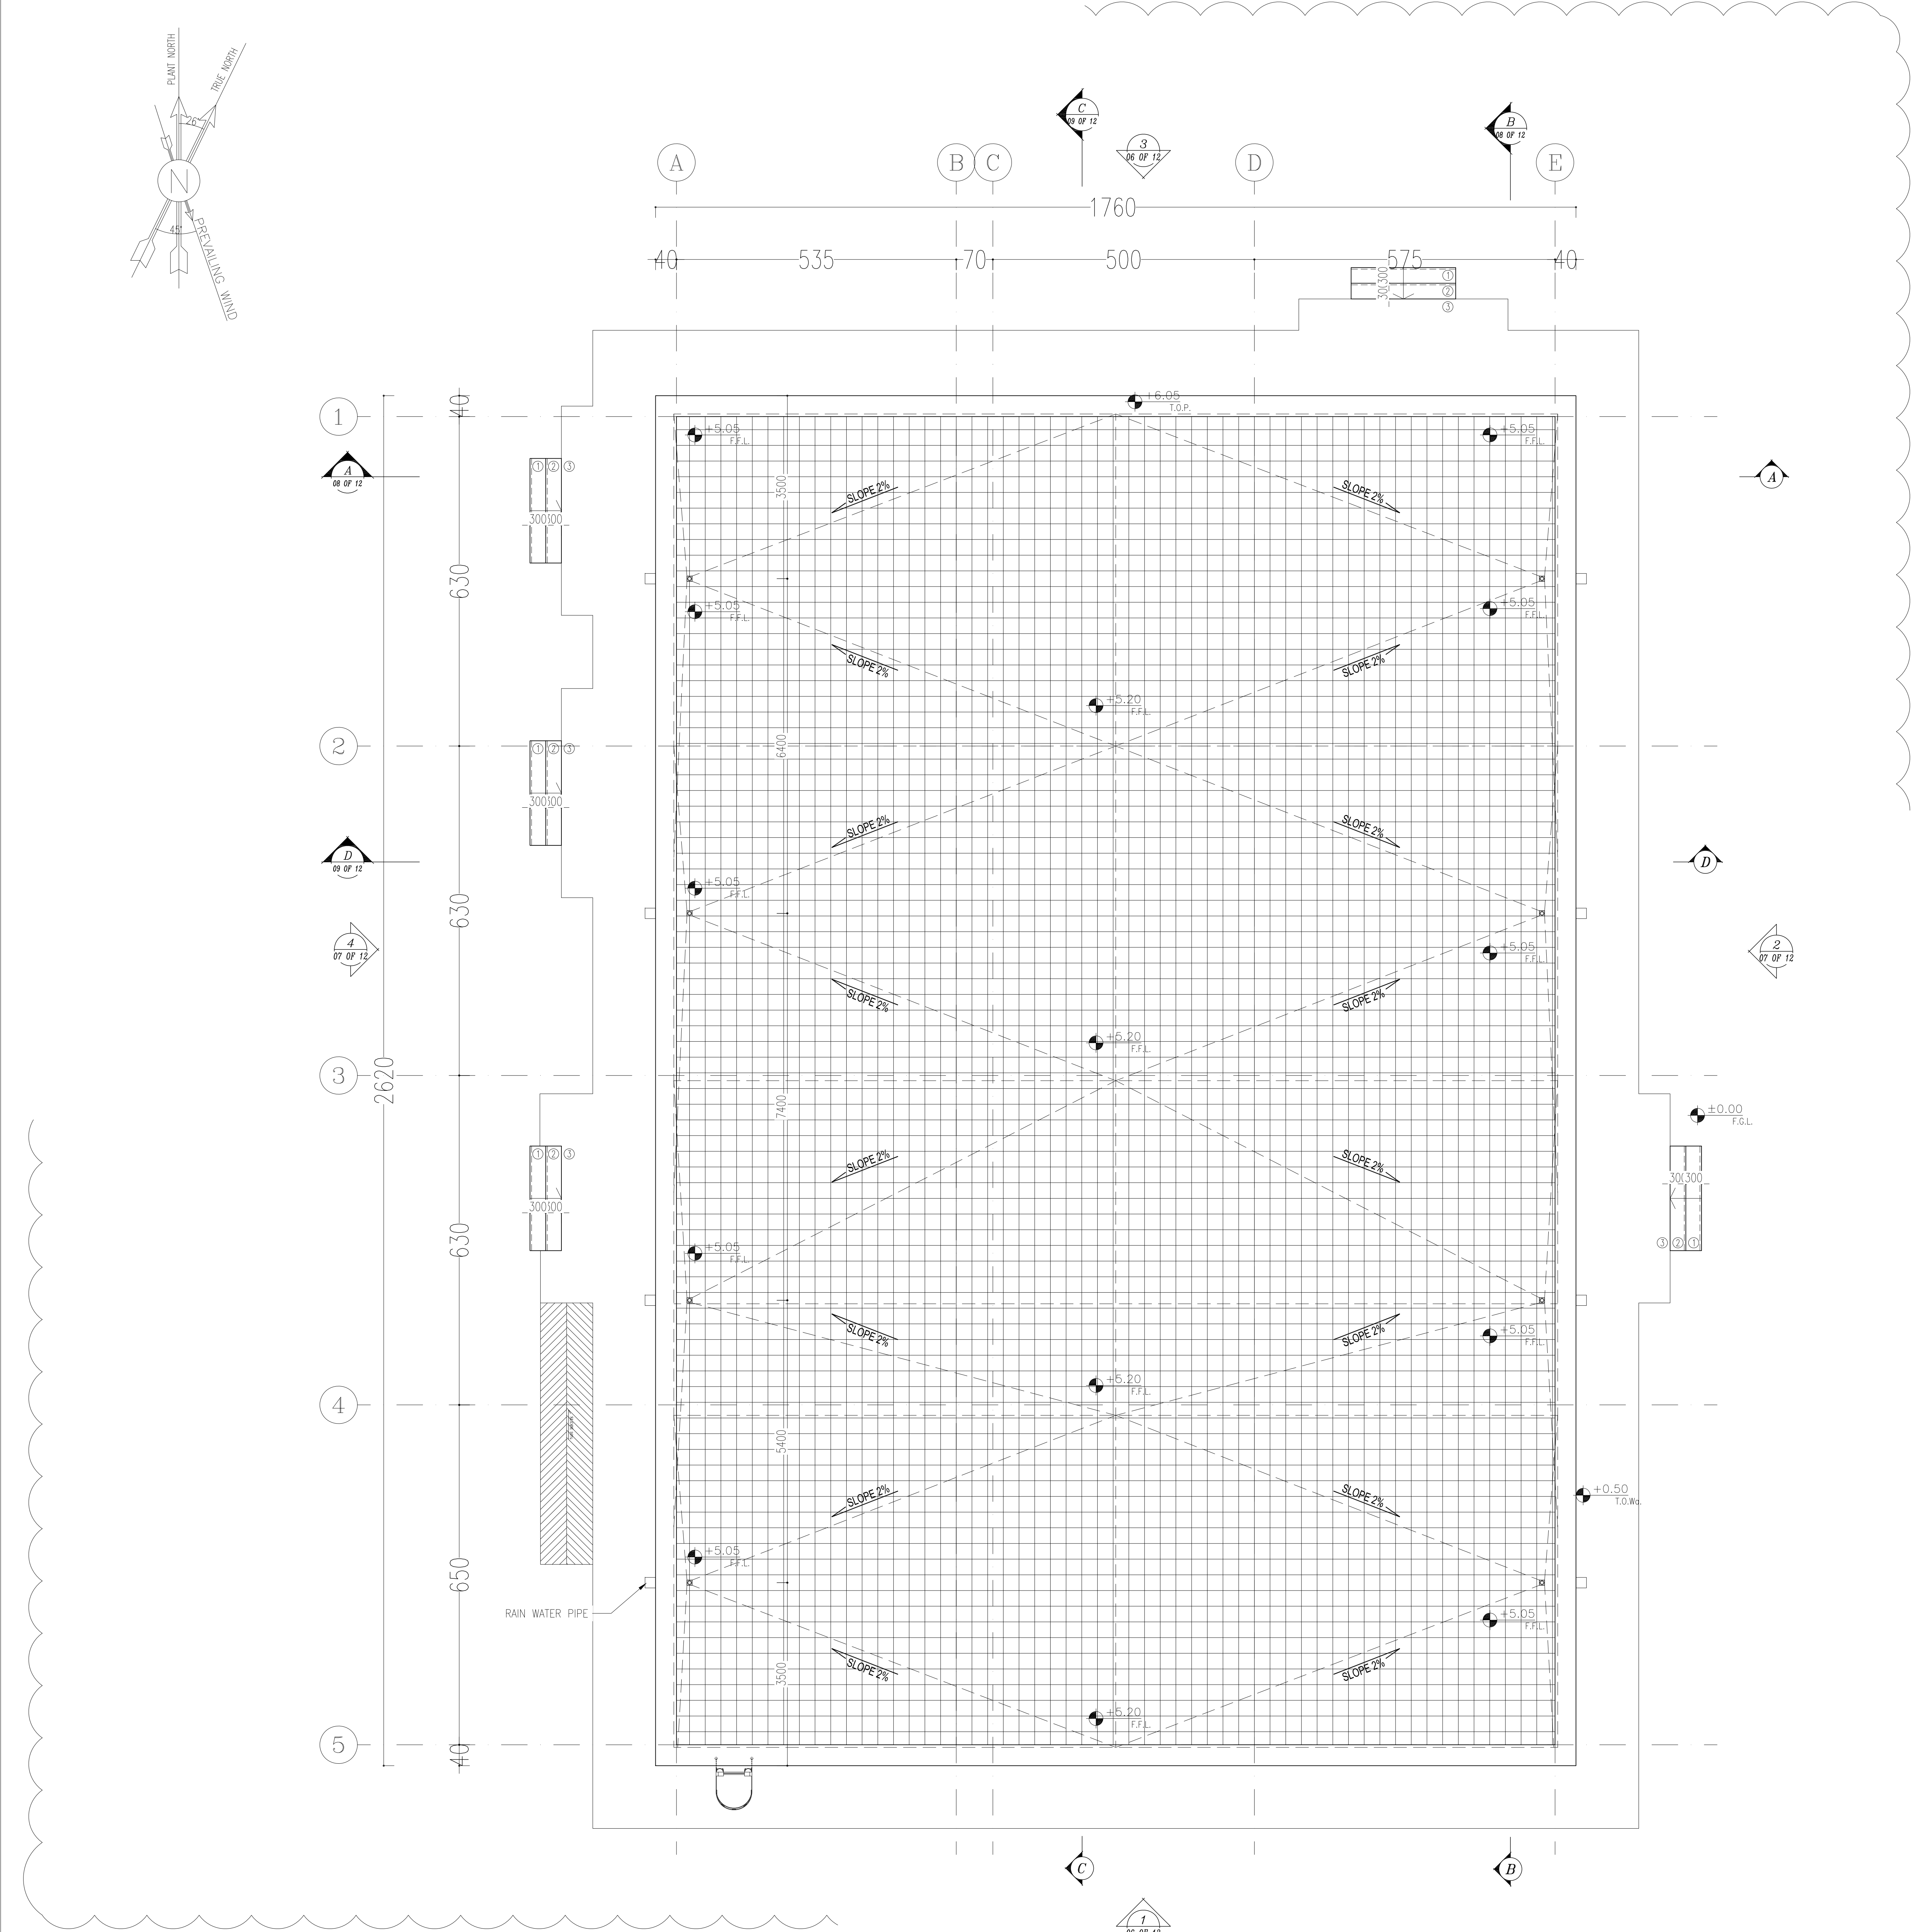

D05

SC.1:50 5 ROOF PLAN


- NOTES
1. ALL DIMENSIONS ARE IN CENTIMETER & ALL ELEVATIONS ARE IN METER.
 2. ALL DIMENSIONS AND ELEVATIONS SHALL BE CHECKED BY THE CONTRACTOR PRIOR TO CONSTRUCTION.
 3. CONTRACTOR SHALL COMPARE ALL ARCHITECTURAL, MECHANICAL, ELECTRICAL, PIPING AND STRUCTURAL DRAWINGS AND IN CASE OF ANY CONFLICTS OR DISCREPANCY, INFORM THE ENGINEER.
 4. ALL MATERIALS ARE SELECTED FROM THE HIGHEST QUALITY AND MUST BE APPROVED BY THE CLIENT.
 5. ALL ORDINERS FOR PIPING/CABLEING AND HVAC ORDERS SHALL BE CONSIDERED AS PER RELATED DRAWINGS BEFORE CONSTRUCTION.
 6. ALL INTERNAL SLOPES FOR FLOOR DRAINS ARE 1% UNLESS STATED.
 7. KNAUF BOARDS SHALL BE "MR" IN MOST SPACES AND TYP IN HEAT ZONES.
 8. FINISH GRADING LEVEL (F.G.L.) = ±1.20 (M.S.L.) = ±0.00 (LOCAL).
 9. ALL WBS ARE EQUIPPED WITH HAND-WASH-HOT AIR-BLOWER/ELECTRICAL SOAP DISPENSER WITH ABS DOORS(WITH CLOSER MECHANISM).
 10. ACCORDING TO SPECIFICATION FOR BUILDINGS INTERIOR PAINTING FOR MASONRY, CONCRETE, PLASTER, GYPSUM WALL BOARD SHALL DONE AS FOLLOW : 1st COAT, PRIMER AND SEALER, 2nd AND 3rd COATS, INTERIOR PAINT SEM LUSTRE (WHITE ALKYD PAINT).
 11. ALL BLASTPROOF DOORS ARE PANIC DOORS – PANIC BARS ARE REQUIRED.
 12. BATTERY ROOM SHALL BE EQUIPPED WITH EXPLOSION-PROOF,FAN,LIGHTING,SWITCHES,OUTLETS AND ETC.

LEGEND



30cmx30cm TERRAZZO MOSAIC TILES WITH INSULATION AND SLOPE

F.F.L. FINISHED FLOOR W.D. WOOD DOOR
T.O.WA. TOP OF WALKWAY T.O.D. TOP OF DOOR
T.O.R. TOP OF ROOF F.G.L. FINISH GRADING LEVEL
T.O.P. TOP OF PARAPET B.P.D. BLAST-PROOF DOOR
T.O.FOU. TOP OF FOUNDATION B.O.Ca. BOTTOM OF LADDER CAGE
AL.D. ALUMINIUM DOOR T.O.Ca. TOP OF LADDER CAGE
M.D. METAL DOOR

REFERENCE DRAWING	DRG. No.
Standard Details For Ladder & Safety Cage	BK-CNRAL-PEDCO-000-ST-DW-0009
FOUNDATION DRAWING FOR CONTROL BUILDING	BK-GCS-PEDCO-120-ST-DW-0061
STRUCTURAL DRAWING FOR CONTROL BUILDING	BK-GCS-PEDCO-120-ST-DW-0062
ROAD, PAVING AND PLANT FINISH GRADING LAYOUT & SECTIONS	BK-GCS-PEDCO-120-CV-PY-0005
CABLE TRENCH AND DUCT BANK LAYOUT	BK-GCS-PEDCO-120-CV-PY-0002
ELECTRICAL CABLE ROUTE & SECTION LAYOUT FOR BUILDING & SHELTER	BK-GCS-PEDCO-120-EL-PY-0006
CONTROL ROOM LAYOUT & ARRANGEMENT DRAWING	BK-GCS-PEDCO-120-IN-PY-0001
PLUMBING & SEWAGE PIPING LAYOUT FOR CONTROL BUILDING	BK-GCS-PEDCO-120-HV-PY-0001
HVAC ROOM LAYOUT & SECTION FOR CONTROL BUILDING	BK-GCS-PEDCO-120-HV-PY-0002
HVAC SYSTEM DUCT PLAN FOR CONTROL BUILDING	BK-GCS-PEDCO-120-HV-PY-0003
HVAC SYSTEM ROOF LAYOUT FOR CONTROL BUILDING	BK-GCS-PEDCO-120-HV-PY-0004

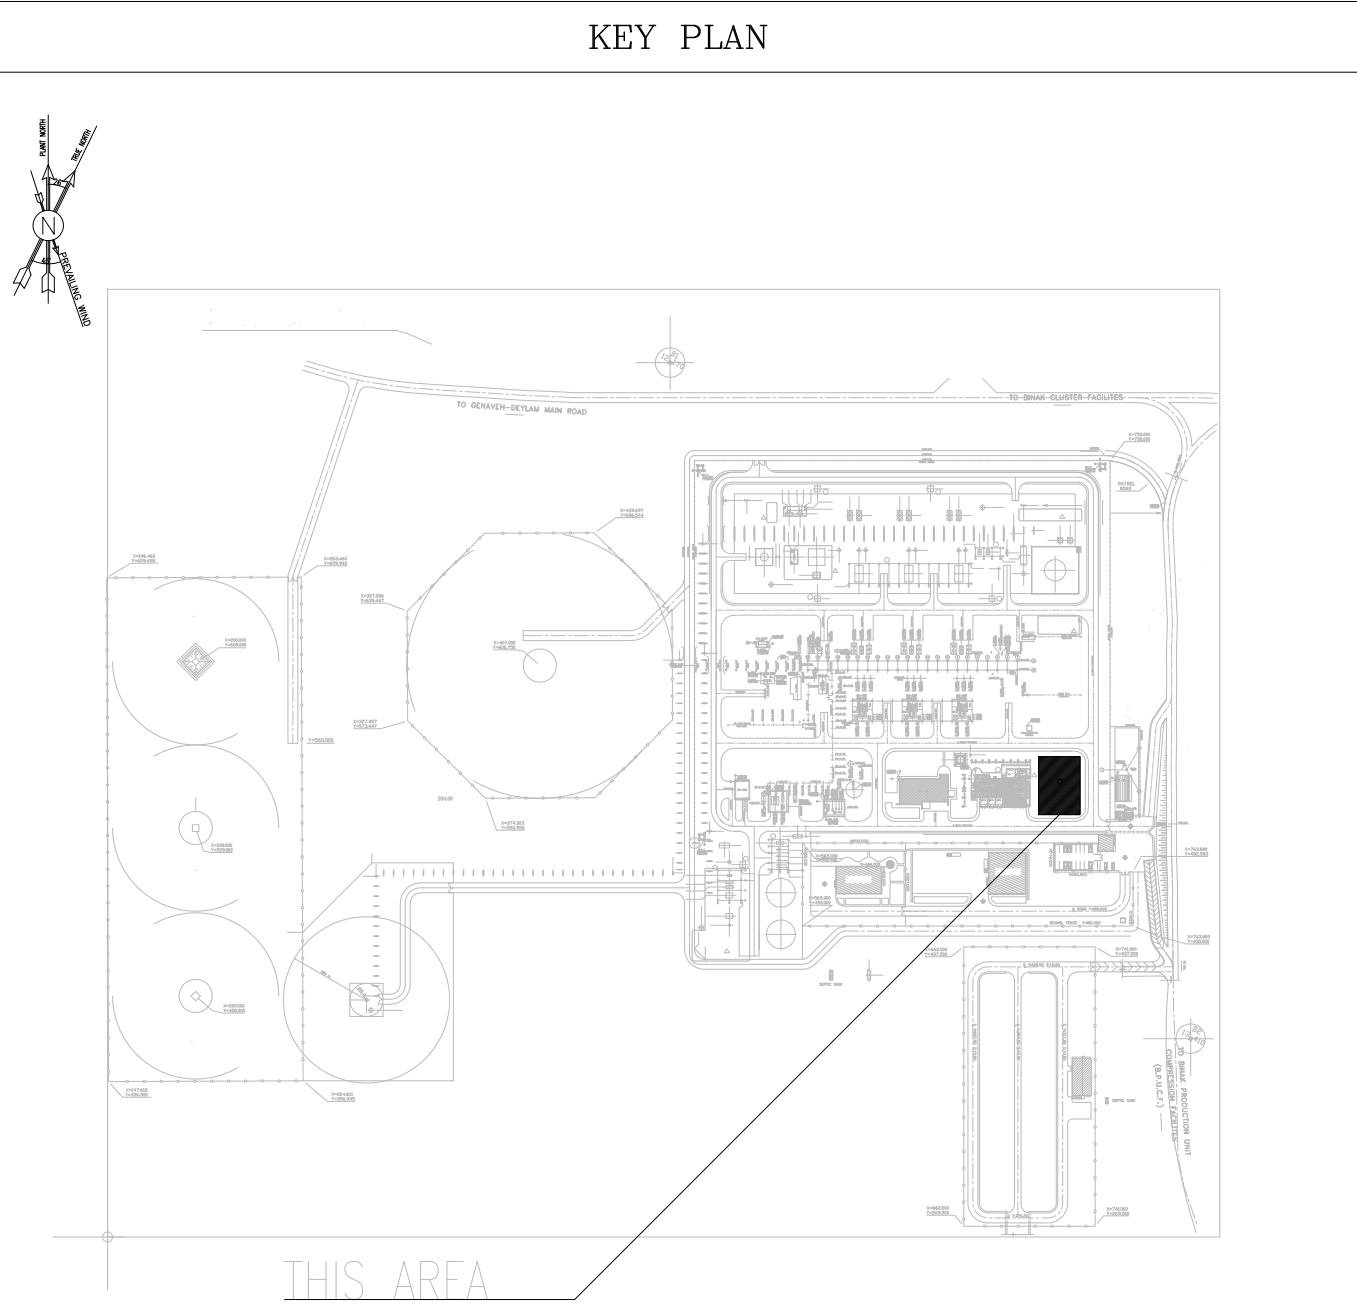


D05	JAN. 2023	IFA	R.BERLOUIE	M.PAKHARIAN	M.Mehrshad	***
D04	OCT. 2022	IFA	R.BERLOUIE	M.PAKHARIAN	M.Mehrshad	***
D03	AUG. 2022	IFA	R.BERLOUIE	M.PAKHARIAN	M.Mehrshad	***
D02	MAR. 2022	IPC	R.BERLOUIE	M.PAKHARIAN	M.Mehrshad	***
D01	JAN. 2022	IPC	R.BERLOUIE	M.PAKHARIAN	M.Mehrshad	***
D00	DEC. 2021	IPC	R.BERLOUIE	M.PAKHARIAN	M.Mehrshad	***
REV.	DATE	P.O.I.S	PREP.	CHK.	APP.	AUT.
PROJECT NAME: BINAK OILFIELD DEVELOPMENT/SURFACE FACILITIES GAS COMPRESSOR STATION						
PROJECT NO.:			971020			
EPC CONTRACTOR:			EPD/EPC CONTRACTOR (GC):			
 HIRGAN ENERGY – DESIGN & INSPECTION COMPANIES			 PETROIRAN DEVELOPMENT COMPANY			
DRAWING TITLE:			ARCHITECTURAL DETAIL DRAWING FOR CONTROL BUILDING			
			NO CONSTRUCTION PERMITTED UNLESS DRAWING APPROVED			
			APPROVED FOR CONSTRUCTION		BY:	DATE:
SCALE	SIZE	DRAWING NO.	SHEET NO.	REV.	BUDGET REF.	LOCATION
AS SHOWN	A0	BK-GCS-PEDCO-120-AR-DW-0001	05 OF 12	D05	053-073-9184	F

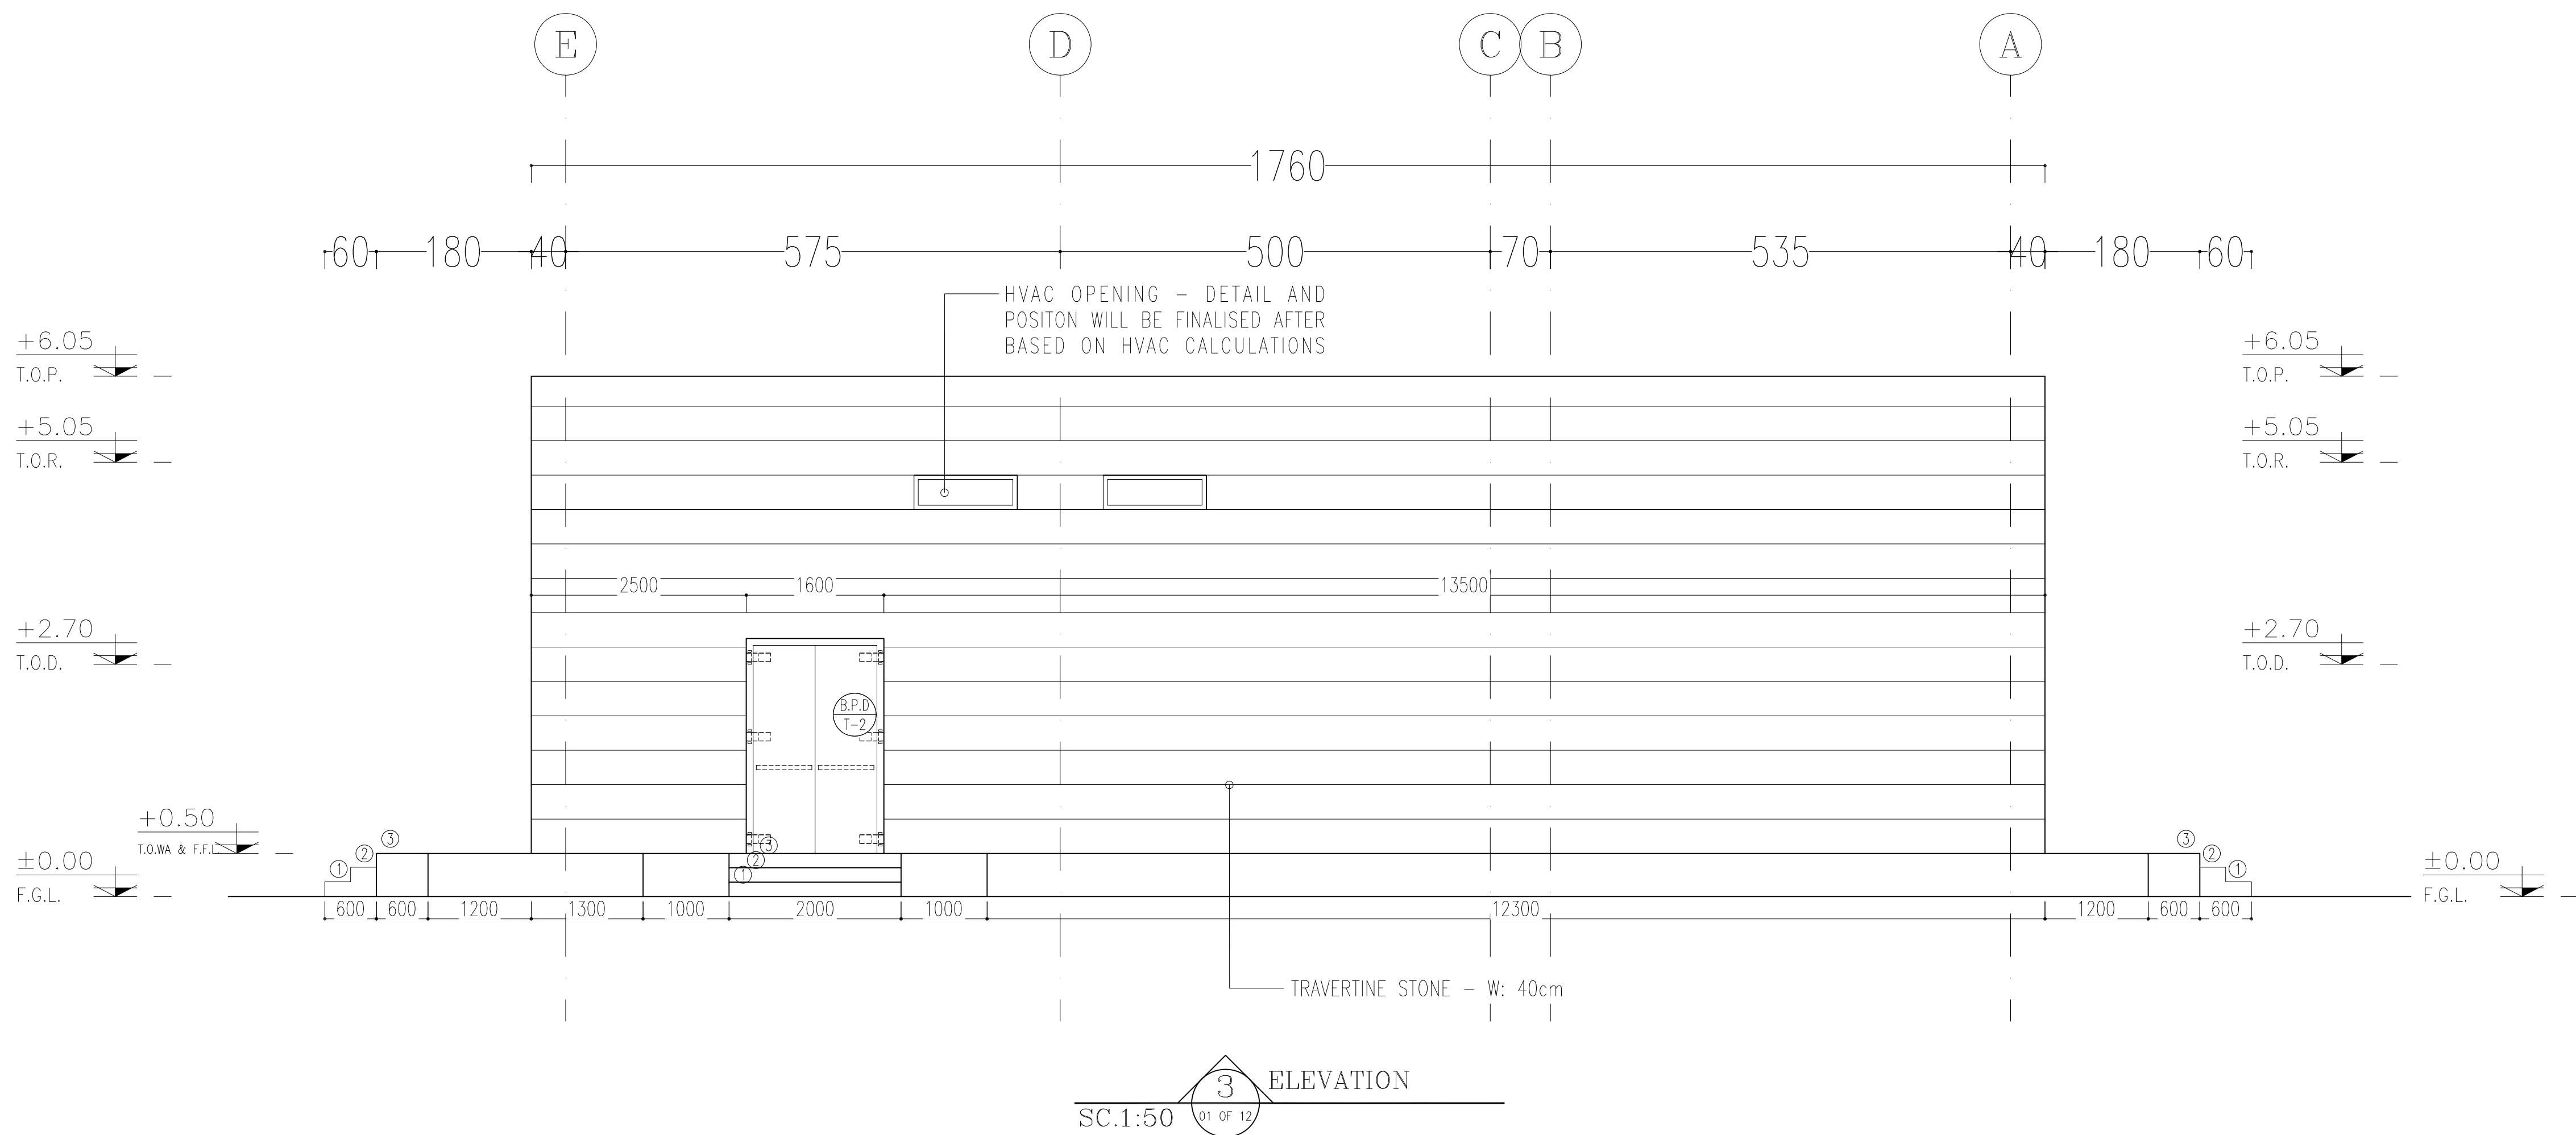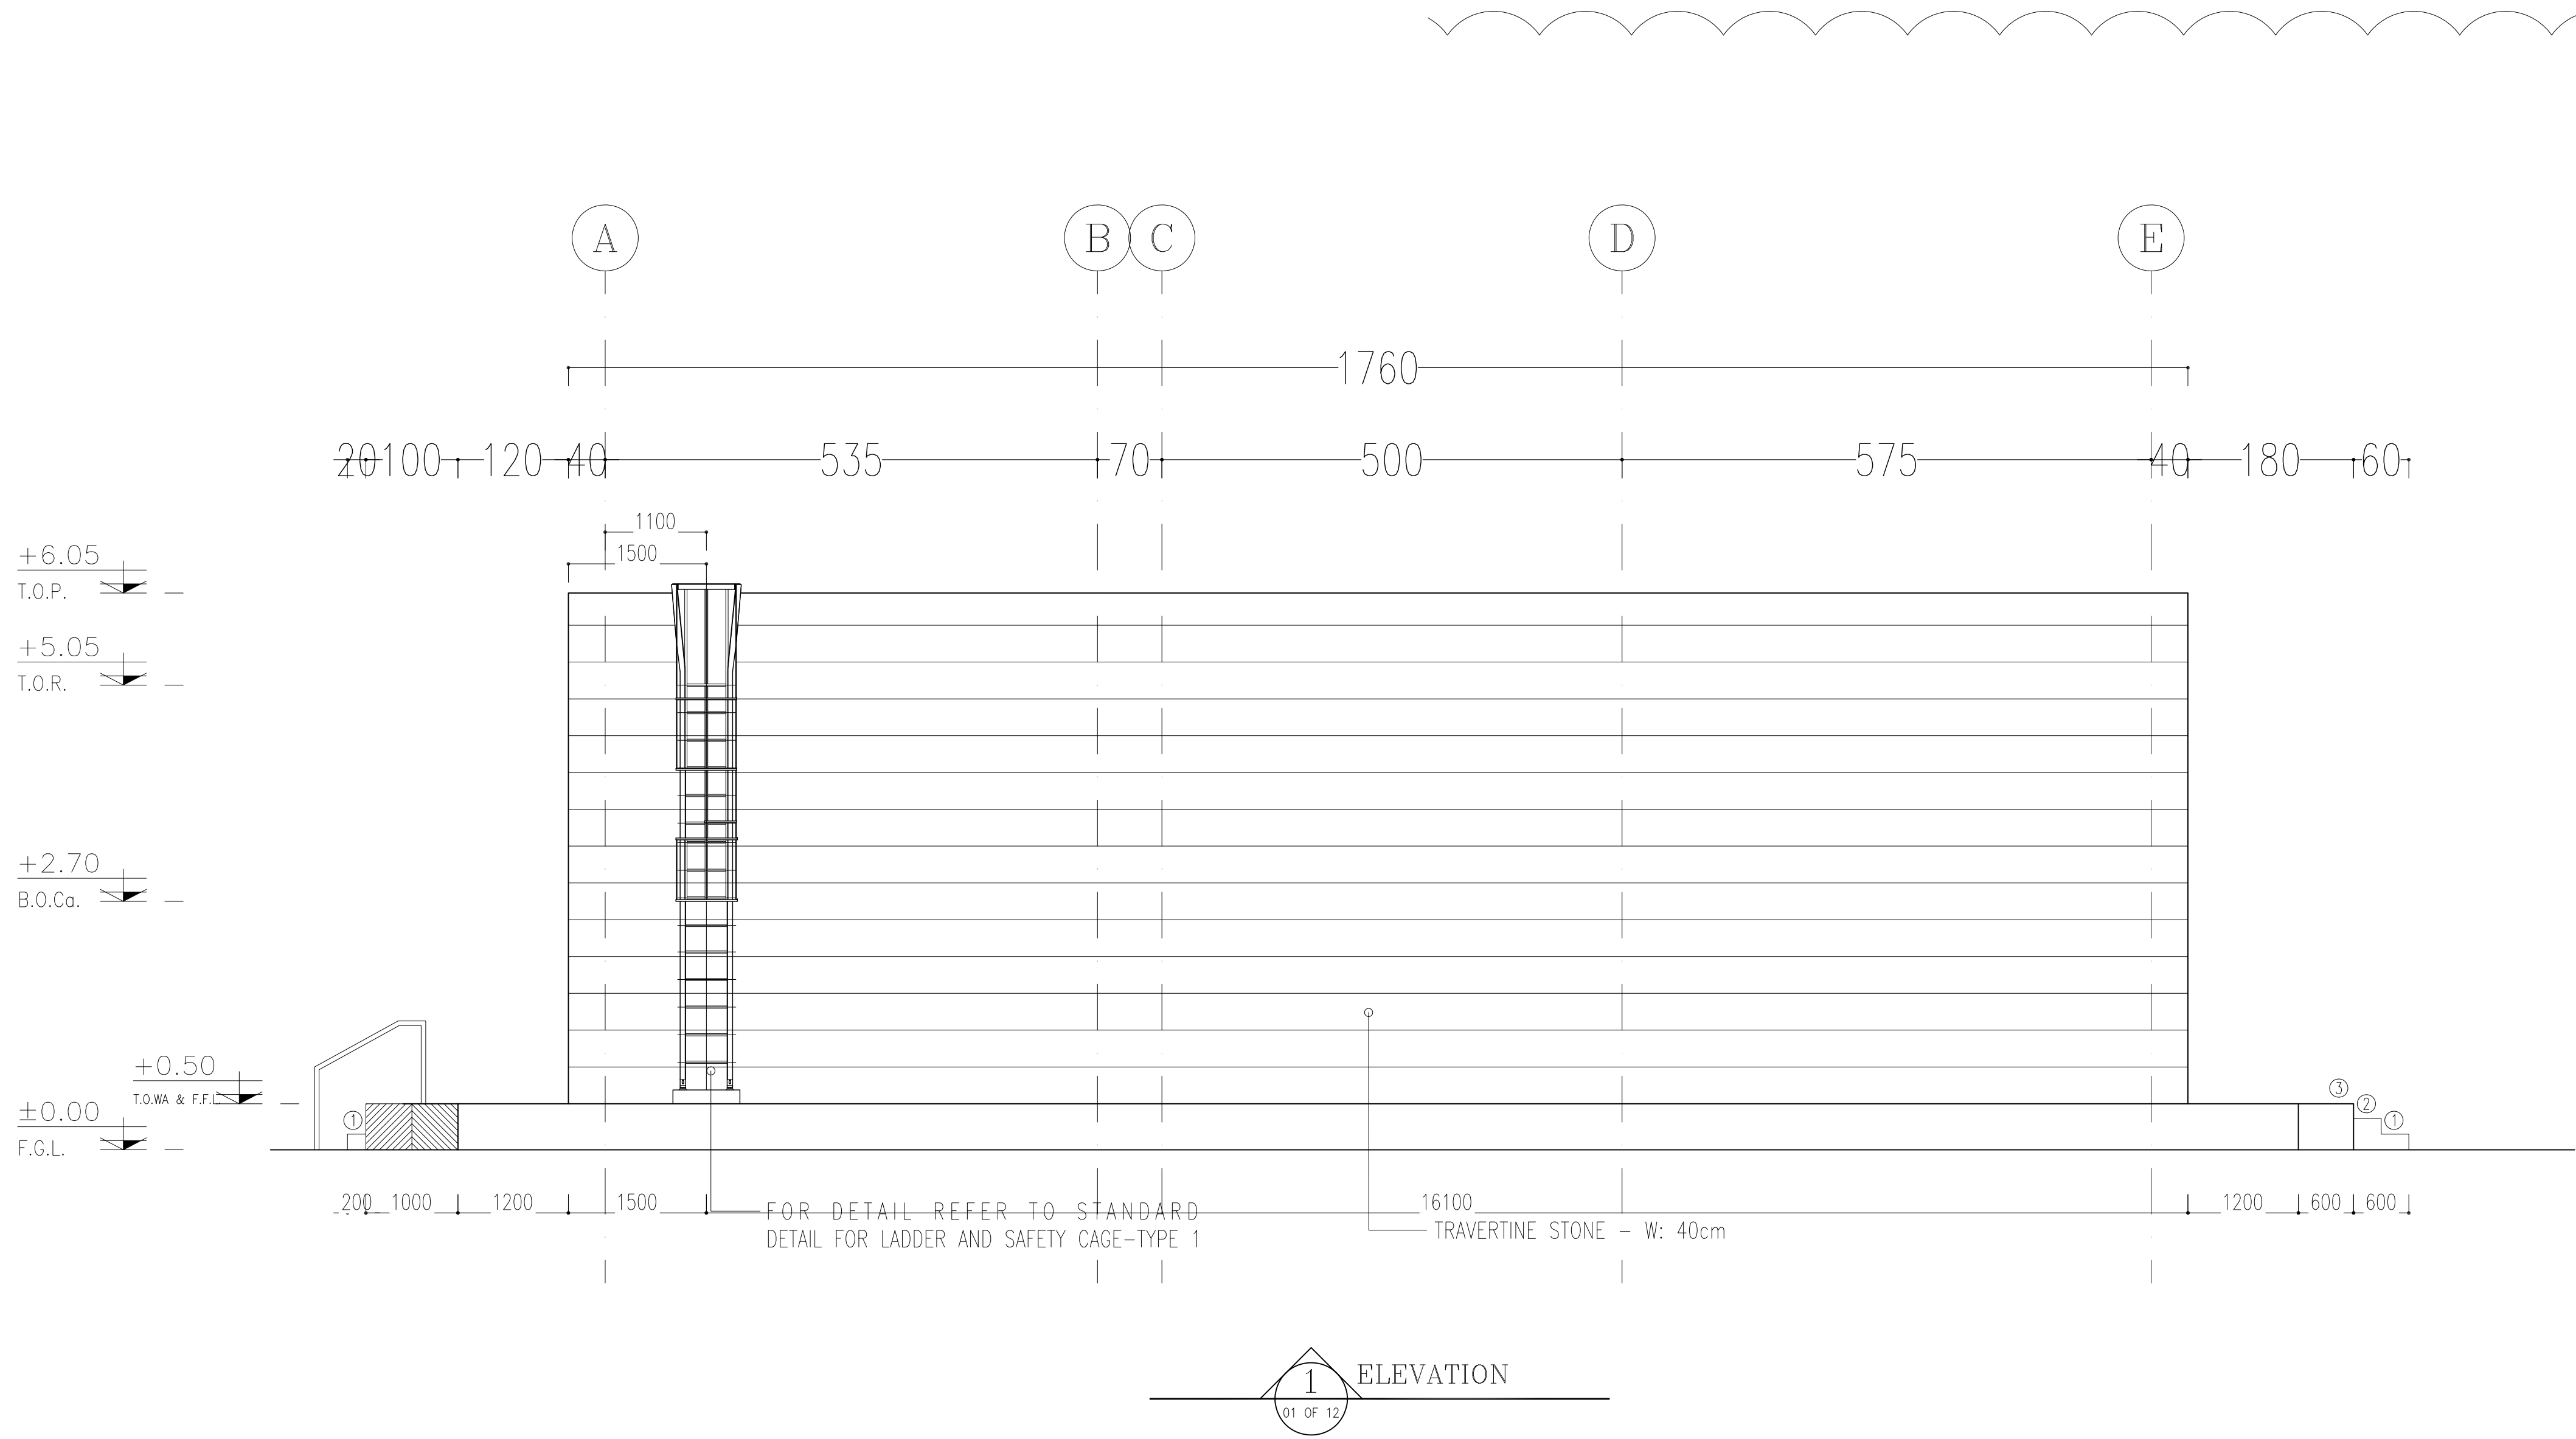


- NOTES
1. ALL DIMENSIONS ARE IN CENTIMETER & ALL ELEVATIONS ARE IN METER.
 2. ALL DIMENSIONS AND ELEVATIONS SHALL BE CHECKED BY THE CONTRACTOR PRIOR TO CONSTRUCTION.
 3. CONTRACTOR SHALL COMPARE ALL ARCHITECTURAL, MECHANICAL, ELECTRICAL, PIPING AND STRUCTURAL DRAWINGS AND IN CASE OF ANY CONFLICTS OR DISCREPANCY, INFORM THE ENGINEER.
 4. ALL MATERIALS ARE SELECTED FROM THE HIGHEST QUALITY AND MUST BE APPROVED BY THE CLIENT.
 5. ALL ORDERS FOR PIPING/DRAINING AND HVAC ORDERS SHALL BE CONSIDERED AS PER RELATED DRAWINGS BEFORE CONSTRUCTION.
 6. ALL INTERNAL SLOPES FOR FLOOR DRAINS ARE 1% UNLESS STATED.
 7. KNAUF BOARDS SHALL BE 'MR' IN MOST SPACES AND 'TP' IN HEAT ZONES.
 8. FINISH GRADING LEVEL (T.O.L.) = ±1.20 (W.S.L.) = ±0.00 (LOCAL).
 9. ALL W.S. ARE EQUIPPED WITH HANDED-WASH-HOT AIR-BLOWER/ELECTRICAL SOAP DISPENSER WITH ABS DOORS(WITH CLOSER MECHANISM).
 10. ACCORDING TO SPECIFICATION FOR BUILDINGS INTERIOR PAINTING FOR MASONRY, CONCRETE, PLASTER, GYPSUM WALL BOARD SHALL DONE AS FOLLOW : 1st COAT, PRIMER AND SEALER, 2nd AND 3rd COATS, INTERIOR PAINT SEM LUSTRE (WHITE ALKYD PAINT).
 11. ALL BLASTPROOF DOORS ARE PANIC DOORS - PANIC BARS ARE REQUIRED.
 12. BATTERY ROOM SHALL BE EQUIPPED WITH EXPLOSION-PROOF,FAN,LIGHTING,SWITCHES,OUTLETS AND ETC.

LEGEND			
TRAVERTINE STONE-w:40cm - THK : ~2.5cm			
F.F.L.	FINISHED FLOOR	W.D	WOOD DOOR
T.O.WA	TOP OF WALKWAY	T.O.D.	TOP OF DOOR
T.O.R.	TOP OF ROOF	F.G.L.	FINISH GRADING LEVEL
T.O.P.	TOP OF PARAPET	B.P.D.	BLAST-PROOF DOOR
T.O.FOU.	TOP OF FOUNDATION	B.O.Cg.	BOTTOM OF LADDER CAGE
AL.D.	ALUMINIUM DOOR	T.O.Cg.	TOP OF LADDER CAGE
M.D.	METAL DOOR		

REFERENCE DRAWING	DRG. No.
Standard Details For Ladder & Safety Cage	BK-GNRL-PEDCO-000-ST-DW-0009
FOUNDATION DRAWING FOR CONTROL BUILDING	BK-GCS-PEDCO-120-ST-DW-0061
STRUCTURAL DRAWING FOR CONTROL BUILDING	BK-GCS-PEDCO-120-ST-DW-0062
ROAD, PAVING AND PLANT FINISH GRADING LAYOUT & SECTIONS	BK-GCS-PEDCO-120-CV-PY-0005
CABLE TRENCH AND DUCT BANK LAYOUT	BK-GCS-PEDCO-120-CV-PY-0002
ELECTRICAL CABLE ROUTE & SECTION LAYOUT FOR BUILDING & SHELTER	BK-GCS-PEDCO-120-EL-PY-0006
CONTROL ROOM LAYOUT & ARRANGEMENT DRAWING	BK-GCS-PEDCO-120-IN-PY-0001
PLUMBING & SEWAGE PIPING LAYOUT FOR CONTROL BUILDING	BK-GCS-PEDCO-120-HV-PY-0001
HVAC ROOM LAYOUT & SECTION FOR CONTROL BUILDING	BK-GCS-PEDCO-120-HV-PY-0002
HVAC SYSTEM DUCT PLAN FOR CONTROL BUILDING	BK-GCS-PEDCO-120-HV-PY-0003
HVAC SYSTEM ROOF LAYOUT FOR CONTROL BUILDING	BK-GCS-PEDCO-120-HV-PY-0004

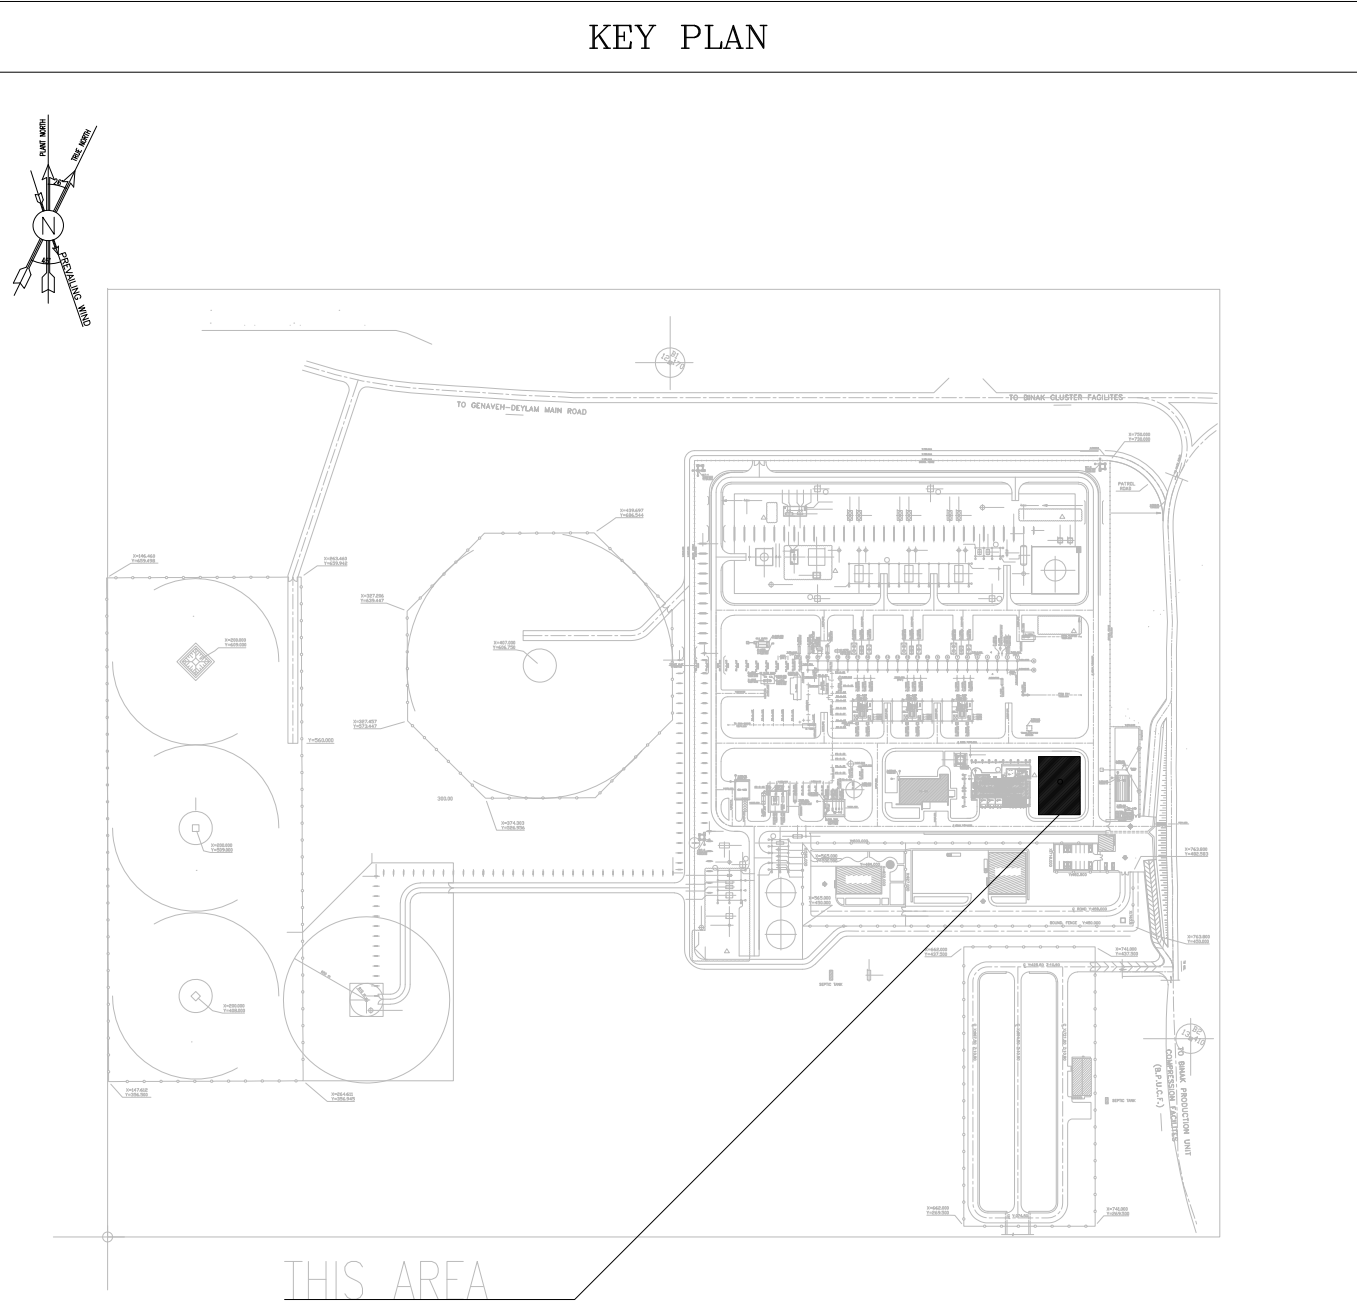



D05	JAN. 2023	IFA	R.BERLOUIE	M.PAKHARIAN	M.Mehrshad	***
D04	OCT. 2022	IFA	R.BERLOUIE	M.PAKHARIAN	M.Mehrshad	***
D03	AUG. 2022	IFA	R.BERLOUIE	M.PAKHARIAN	M.Mehrshad	***
D02	MAR. 2022	IPC	R.BERLOUIE	M.PAKHARIAN	M.Mehrshad	***
D01	JAN. 2022	IPC	R.BERLOUIE	M.PAKHARIAN	M.Mehrshad	***
D00	DEC. 2021	IPC	R.BERLOUIE	M.PAKHARIAN	M.Mehrshad	***
REV.	DATE	P.O.I.S	PREP.	CHK.	APP.	AUT.
PROJECT NAME: BINAK OILFIELD DEVELOPMENT/SURFACE FACILITIES GAS COMPRESSOR STATION						
PROJECT NO.: 971020						
EPC CONTRACTOR:			EPD/EPC CONTRACTOR (GC):			
 HIRGAN ENERGY - DESIGN & INSPECTION COMPANIES			 PETROIRAN DEVELOPMENT COMPANY			
DRAWING TITLE: ARCHITECTURAL DETAIL DRAWING FOR CONTROL BUILDING			NO CONSTRUCTION PERMITTED UNLESS DRAWING APPROVED			
ELEVATIONS			APPROVED FOR CONSTRUCTION			
SCALE	SIZE	DRAWING NO.	SHEET NO.	REV.	DATE:	
AS SHOWN	A0	BK-GCS-PEDCO-120-AR-DW-0001	06 OF 12	D05	053-073-9184	F 4 B 709099 06 OF 12 D05

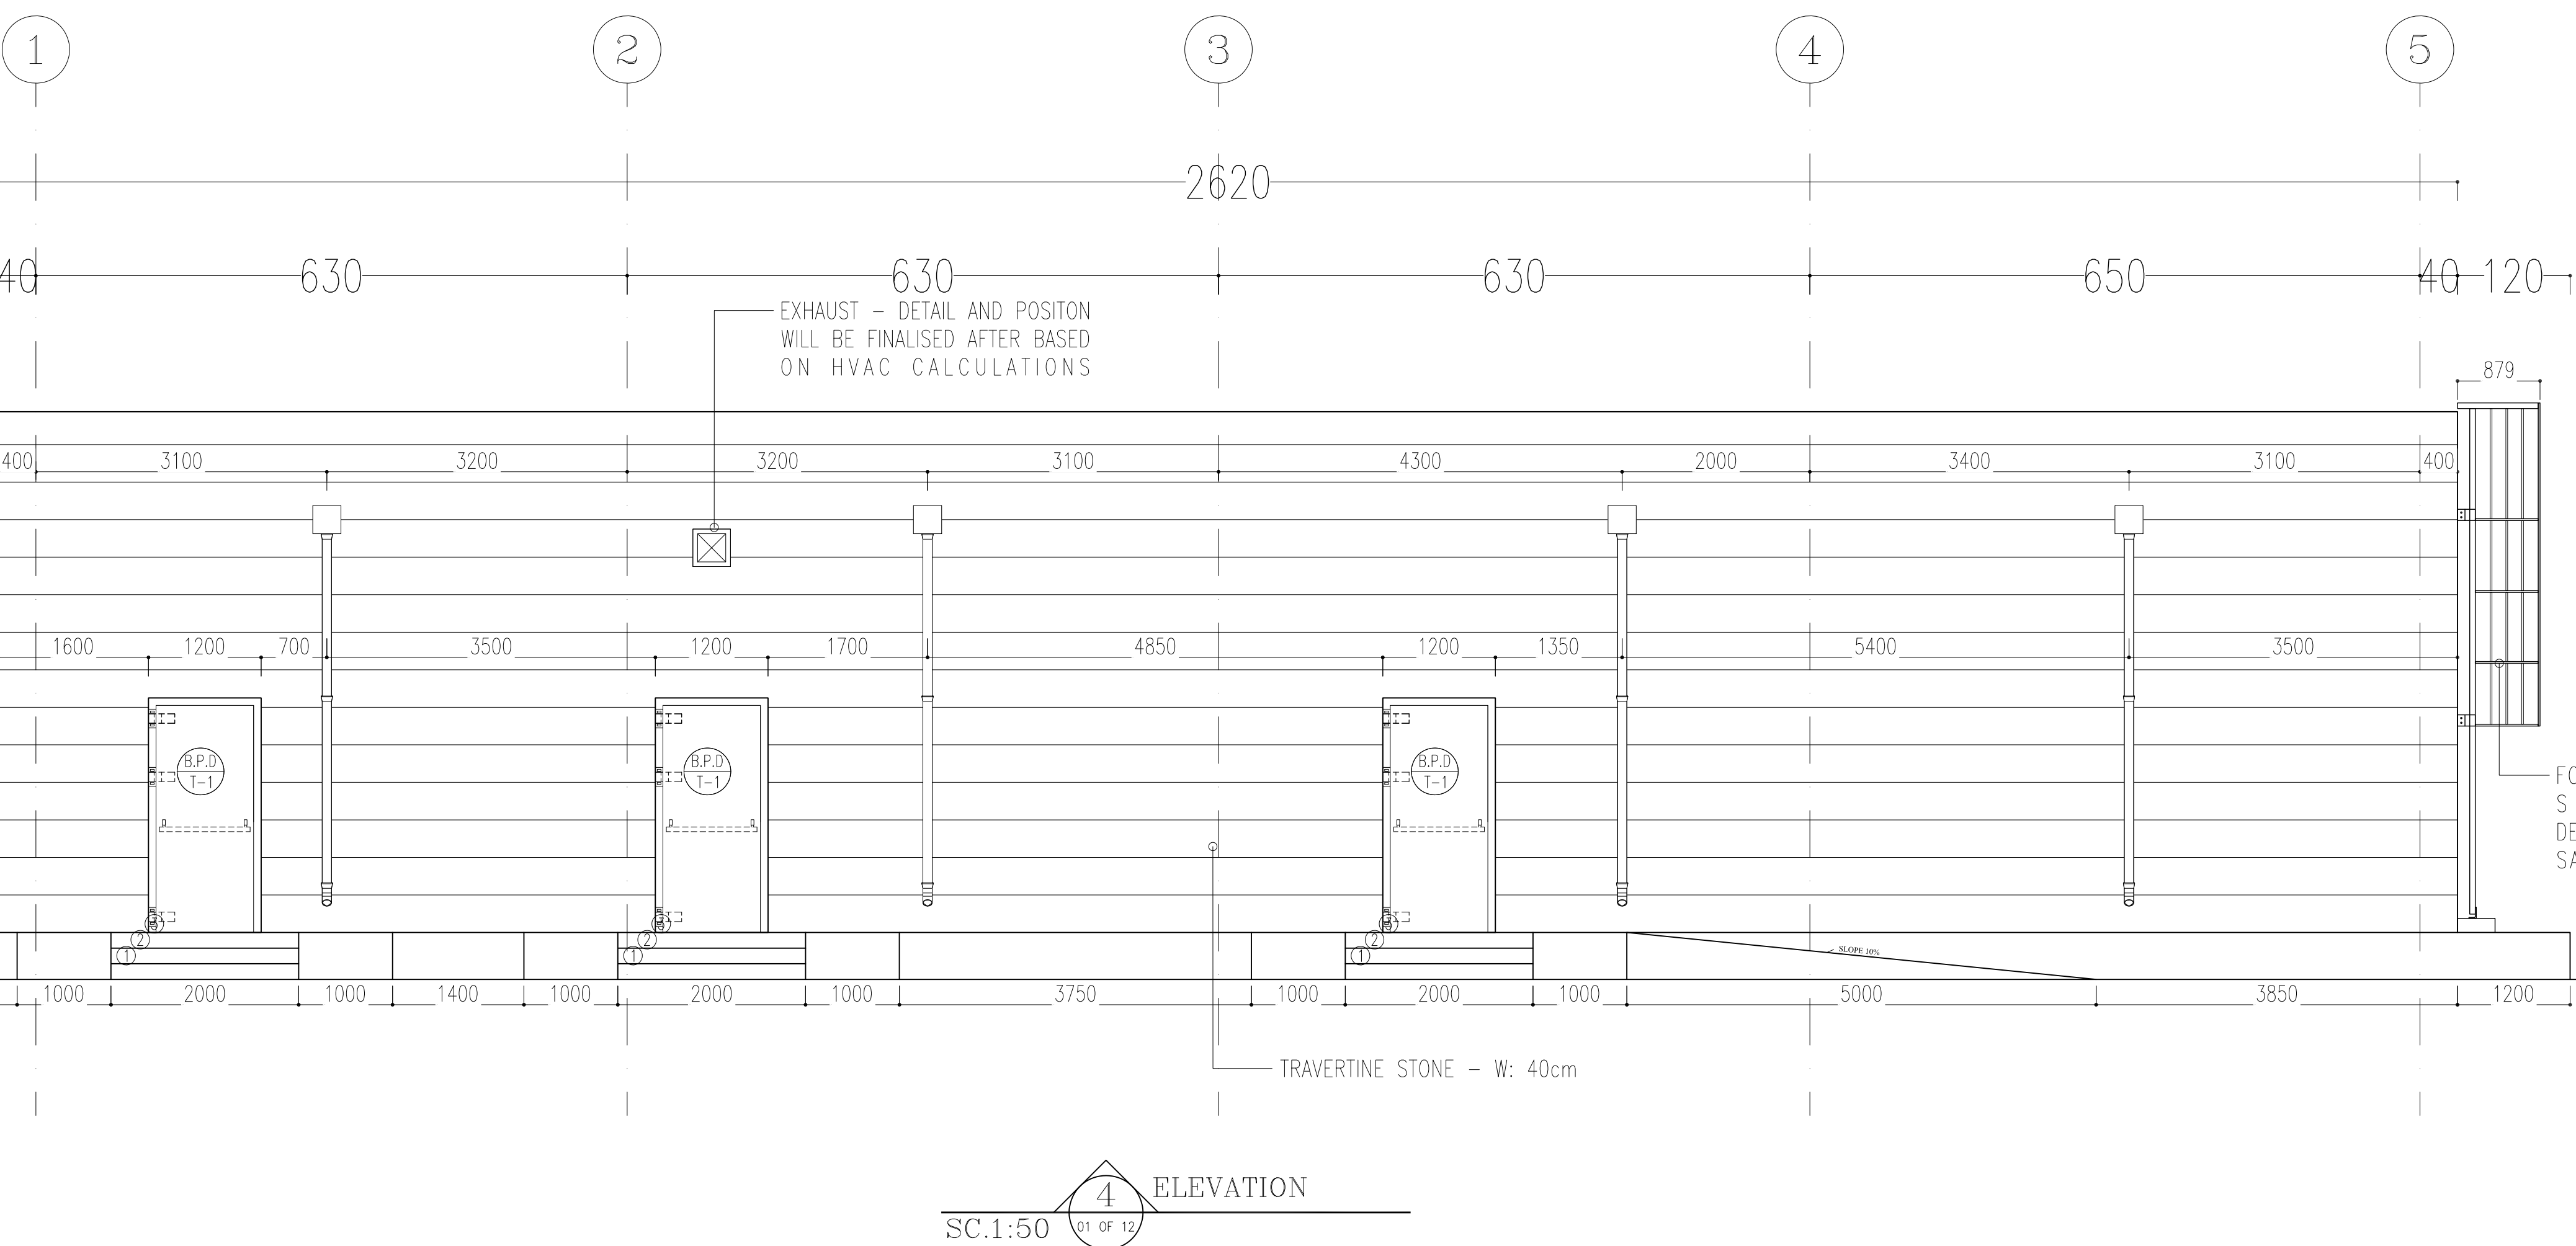

D05	JAN.2023	IFA	R.BERLOUIE	M.PAKHARIAN	M.Mehrshad	**
D02	OCT.2022	IFA	R.BERLOUIE	M.PAKHARIAN	M.Mehrshad	**
D03	AUG.2023	IFA	R.BERLOUIE	M.PAKHARIAN	M.Mehrshad	**
D02	MAR.2022	IFC	R.BERLOUIE	M.PAKHARIAN	M.Mehrshad	**
D01	JAN.2022	IFC	R.BERLOUIE	M.PAKHARIAN	M.Mehrshad	**
D00	DEC.2021	IFC	R.BERLOUIE	M.PAKHARIAN	M.Mehrshad	**
REV.	DATE	P.O.I.S	PREP.	CHK.	APP.	AUT.

PROJECT NAME: BINAK OILFIELD DEVELOPMENT/SURFACE FACILITIES
GAS COMPRESSOR STATION

PROJECT NO.:	971020
--------------	--------

  EPC CONTRACTOR:  HIRGAN ENERGY  HIRGAN ENERGY – DESIGN & INSPECTION COMPANIES	EPD/EPC CONTRACTOR (GC):  PEDCO PETROIRAN DEVELOPMENT COMPANY
--	---

DRAWING TITLE:	ARCHITECTURAL DETAIL DRAWING FOR CONTROL BUILDING
----------------	---

ELEVATIONS

SCALE	SIZE	DRAWING NO.	SHEET NO.	REV.
-------	------	-------------	-----------	------

AS SHOWN	A0	BK-GCS-PEDCO-120-AR-DW-0001	07 OF 12	D05
----------	----	-----------------------------	----------	-----

NOTES

ALL DIMENSIONS ARE IN CENTIMETER & ALL ELEVATIONS ARE IN METER.
ALL DIMENSIONS AND ELEVATIONS SHALL BE CHECKED BY THE CONTRACTOR PRIOR TO CONSTRUCTION.
CONTRACTOR SHALL COMPILE ALL ARCHITECTURAL, STRUCTURAL, MECHANICAL, PIPING AND ELECTRICAL
DRAWINGS AND IN CASE OF ANY CONFLICTS OR DISCREPANCY, INFORM THE ENGINEER.
CONTRACTOR SHALL BE RESPONSIBLE FOR THE SELECTION FROM THE LISTED MATERIALS BY THE CLIENT.
ALL OPTIONS FOR PIPING/CABLEING AND HVAC OPTIONS SHALL BE CONSIDERED AS PER RELATED DRAWINGS BEFORE
CONSTRUCTION.
ALL INTERNAL SLOPE FOR FLOOR DRAINS ARE 1% UNLESS STATED.
WALL/DOOR BARS SHALL BE "M" IN ROOMS AND "L" IN BATHS AND TOILET ZONES
FINISH GRADE LEVEL (F.G.L.) = +11.02 (W.S.L.) - 0.00 (LOCAL).
ALL W.C.S ARE EQUIPPED WITH HAND-WASHING HOT AIR-BLOW/ ELECTRICAL-SPRAY DISPENSER
WITH DISCONNECTING CLOSER MECHANISM.
ALL W.C.S SHALL BE EQUIPPED WITH BUSHING-INTERIOR PAINTING FOR MASONRY, CONCRETE, PLASTER, GLASS/WALL BOARD
AND GLASS/DOOR/SHOWER ENCLOSURE/SCREENING/SLIP-RESISTANT INTERIOR PARTS/SLIP RESISTANT WHITE ALKOAT
PAINT.
GLASS/DOOR DOORS ARE PANAC DOORS - PANAC PROPS, PANAC HINGERS, SWITCHES, OULETS AND ETC.
BATTERY ROOM SHALL BE EQUIPPED WITH EXPLOSION-PROOF, FLASHLIGHTS, CIRCUITS, OULETS AND ETC.


LEGEND

TRAVERTINE STONE-w:40cm - THK : ~2.5cm

F.F.L.	FINISHED FLOOR	W.D	WOOD DOOR
T.O.WA	TOP OF WALKWAY	T.O.D.	TOP OF DOOR
T.O.R.	TOP OF ROOF	F.G.L.	FINISH GRADING LEVEL
T.O.P.	TOP OF PARAPET	B.P.D.	BLAST-PROOF DOOR
T.O.FOU.	TOP OF FOUNDATION	B.O.Co.	BOTTOM OF LADDER CAGE
ALD.	ALUMINUM DOOR	T.O.Co.	TOP OF LADDER CAGE
M.D.	METAL DOOR		

REFERENCE DRAWING	DRG. No.
Standard Details For Ladder & Safety Cage	BK-GNRL-PEDCO-000-ST-DW-0009
FOUNDATION DRAWING FOR CONTROL BUILDING	BK-GCS-PEDCO-120-ST-DW-0061
STRUCTURAL DRAWING FOR CONTROL BUILDING	BK-GCS-PEDCO-120-ST-DW-0062
ROAD, PAVING AND PLANT FINISH GRADING LAYOUT & SECTIONS	BK-GCS-PEDCO-120-CV-PY-0005
CABLE TRENCH AND DUCT BANK LAYOUT	BK-GCS-PEDCO-120-CV-PY-0002
ELECTRICAL CABLE ROUTE & SECTION LAYOUT FOR BUILDING & SHELTER	BK-GCS-PEDCO-120-EL-PY-0006
CONTROL ROOM LAYOUT & ARRANGEMENT DRAWING	BK-GCS-PEDCO-120-IN-PY-0001
PLUMBING & SEWAGE PIPING LAYOUT FOR CONTROL BUILDING	BK-GCS-PEDCO-120-HV-PY-0001
HVAC ROOM LAYOUT & SECTION FOR CONTROL BUILDING	BK-GCS-PEDCO-120-HV-PY-0002
HVAC SYSTEM DUCT PLAN FOR CONTROL BUILDING	BK-GCS-PEDCO-120-HV-PY-0003
HVAC SYSTEM ROOF LAYOUT FOR CONTROL BUILDING	BK-GCS-PEDCO-120-HV-PY-0004

KEY PLAN

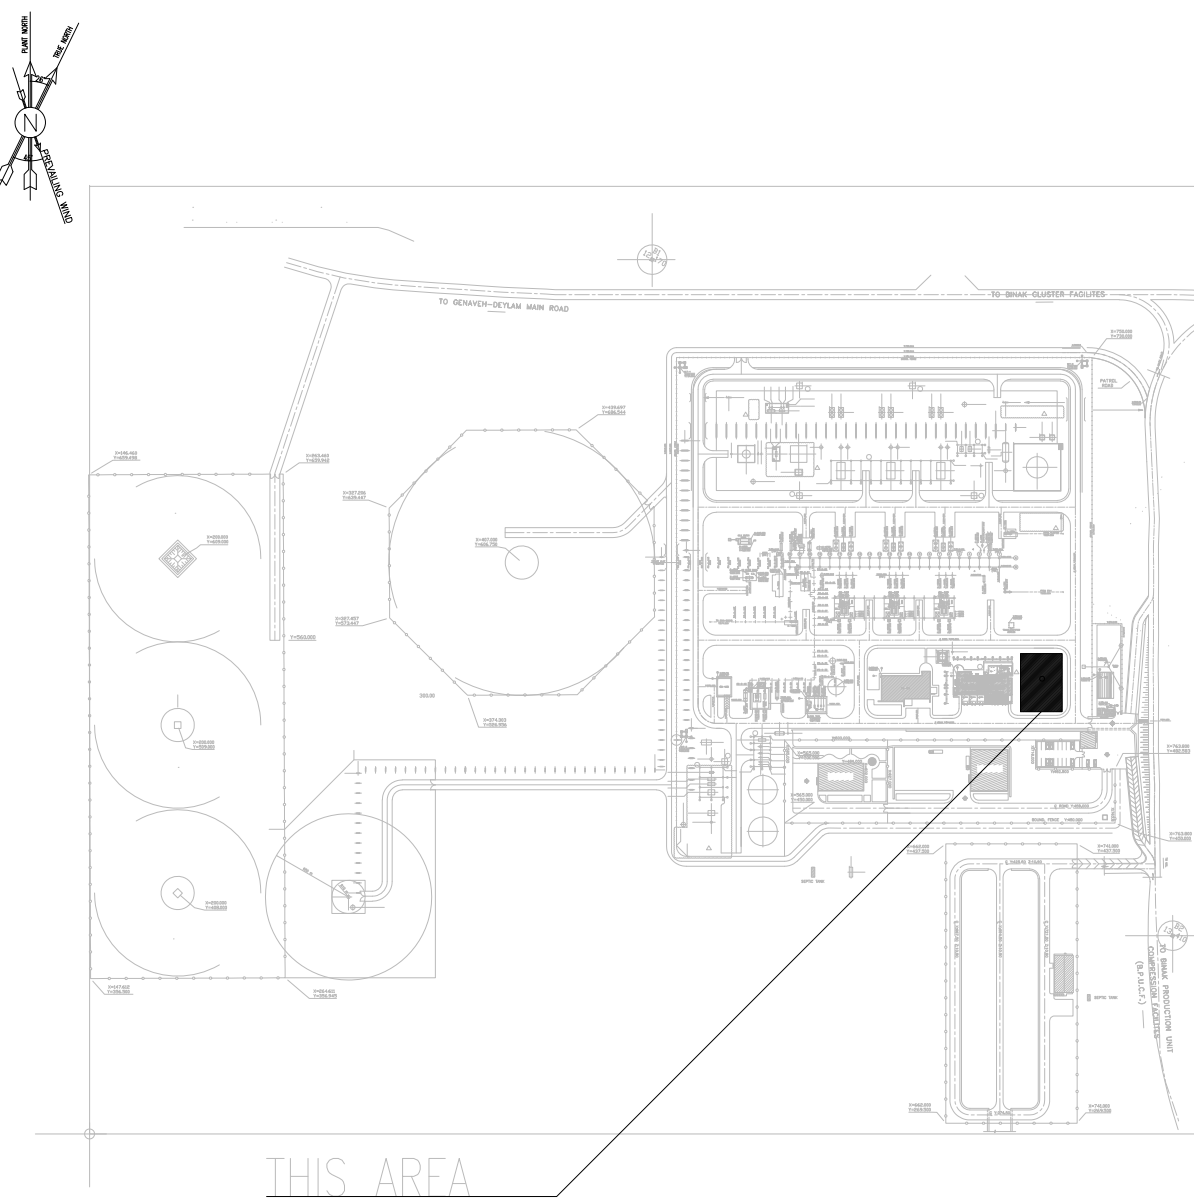

***	*****	***	***	***	***
REV.	DESCRIPTION	BY	DATE	BY	DATE
		CHECKED		REV.	APPR.

اصل و کلیه نسخ این نقشه و حق اقتباس متعلق به شرکت ملی مناطق نفت خیز جنوب می باشد.




THE ORIGINAL AND ALL COPIES OF THIS DRAWING TOGETHER WITH
THE COPYRIGHT THEREIN ARE THE SOLE PROPERTY OF
N.I.S.O.C./ FIELDS

BINAK OILFIELD DEVELOPMENT
SURFACE FACILITIES
GAS COMPRESSOR STATION

DATE	SCALE	DRAWING BY	CHECKED BY	PROJECT ENG.

NO CONSTRUCTION PERMITTED UNLESS DRAWING APPROVED

APPROVED FOR CONSTRUCTION				BY:	DATE:	
BUDGET REF.	LOCATION	SIZE	CLASS	SERIAL NO.	SHEET	REVISION
053-073-9184	F	4	B	709099	07 OF 12	D05

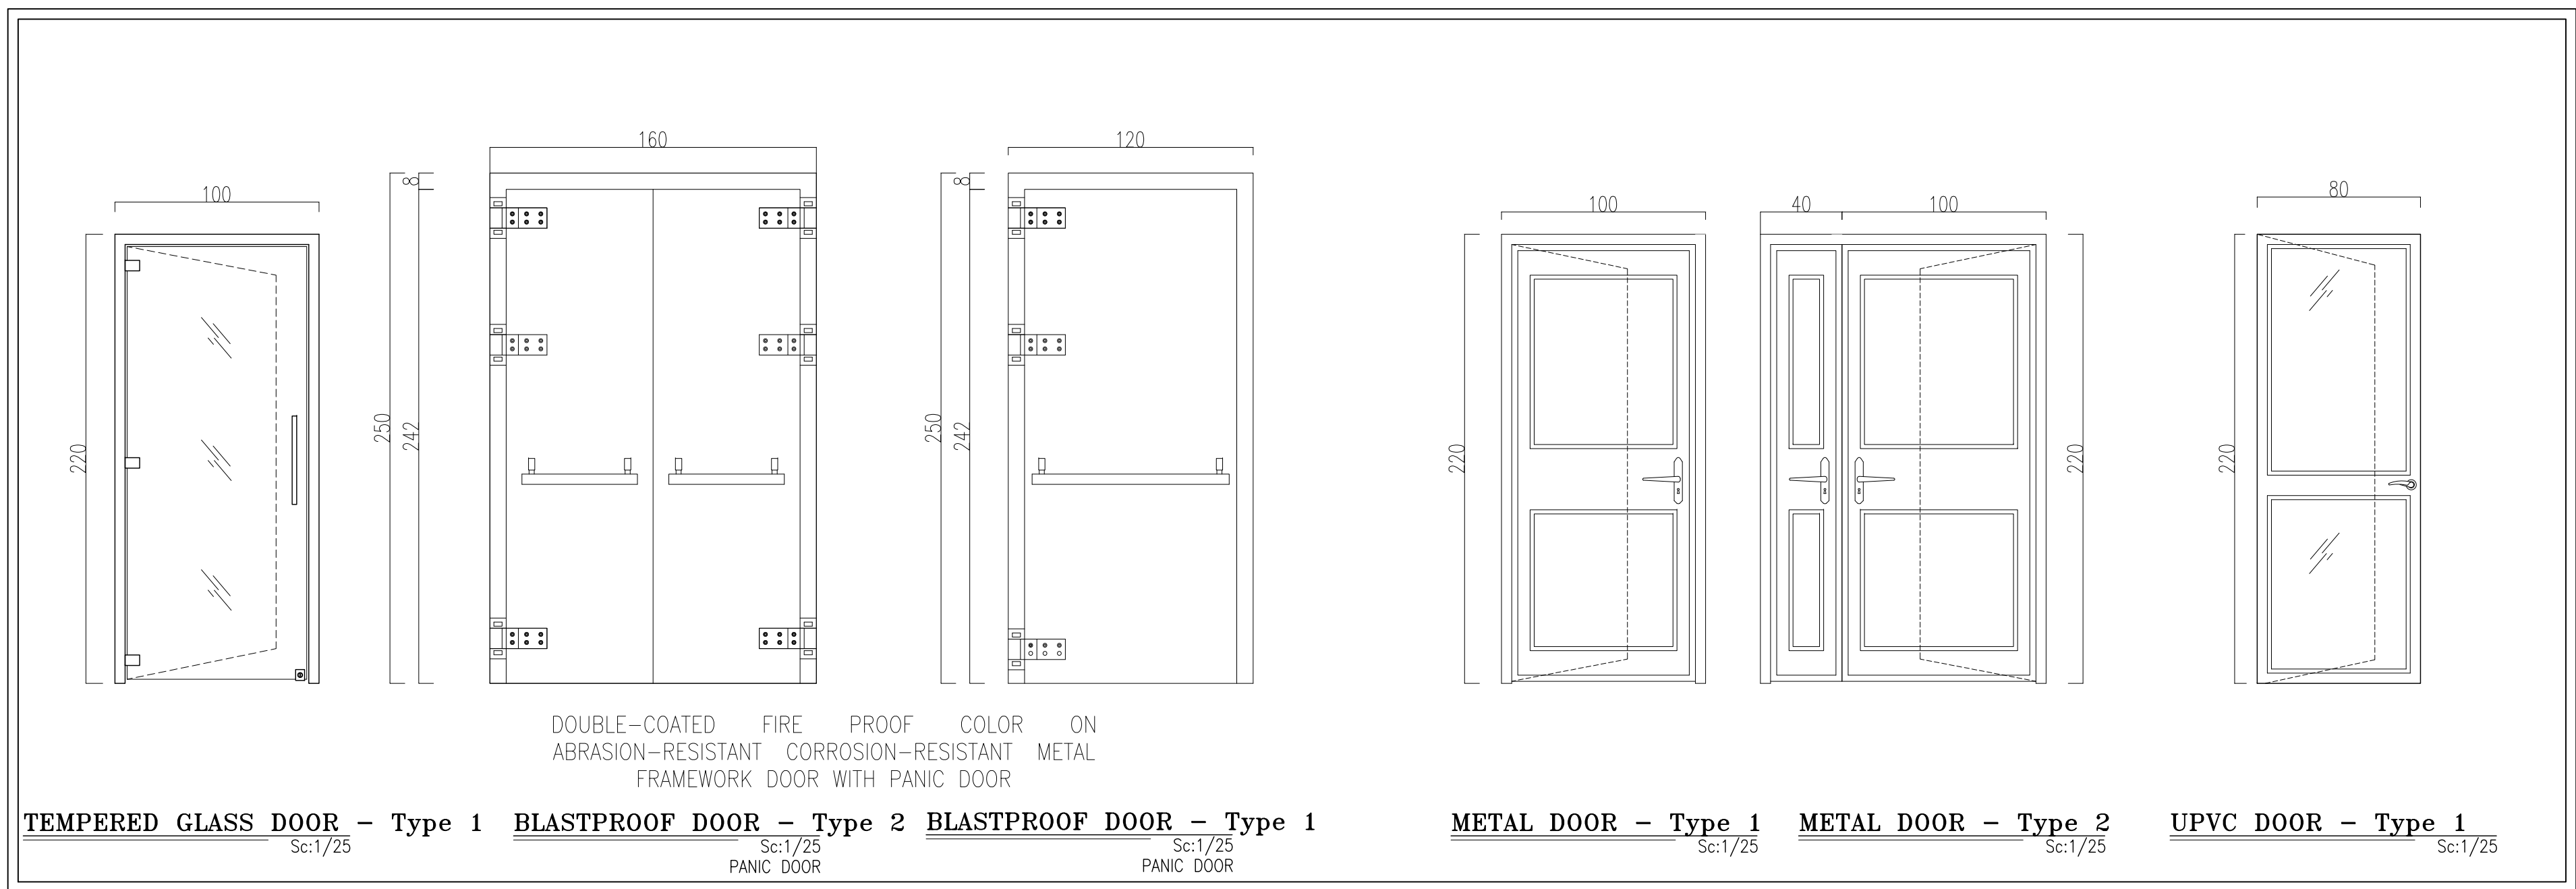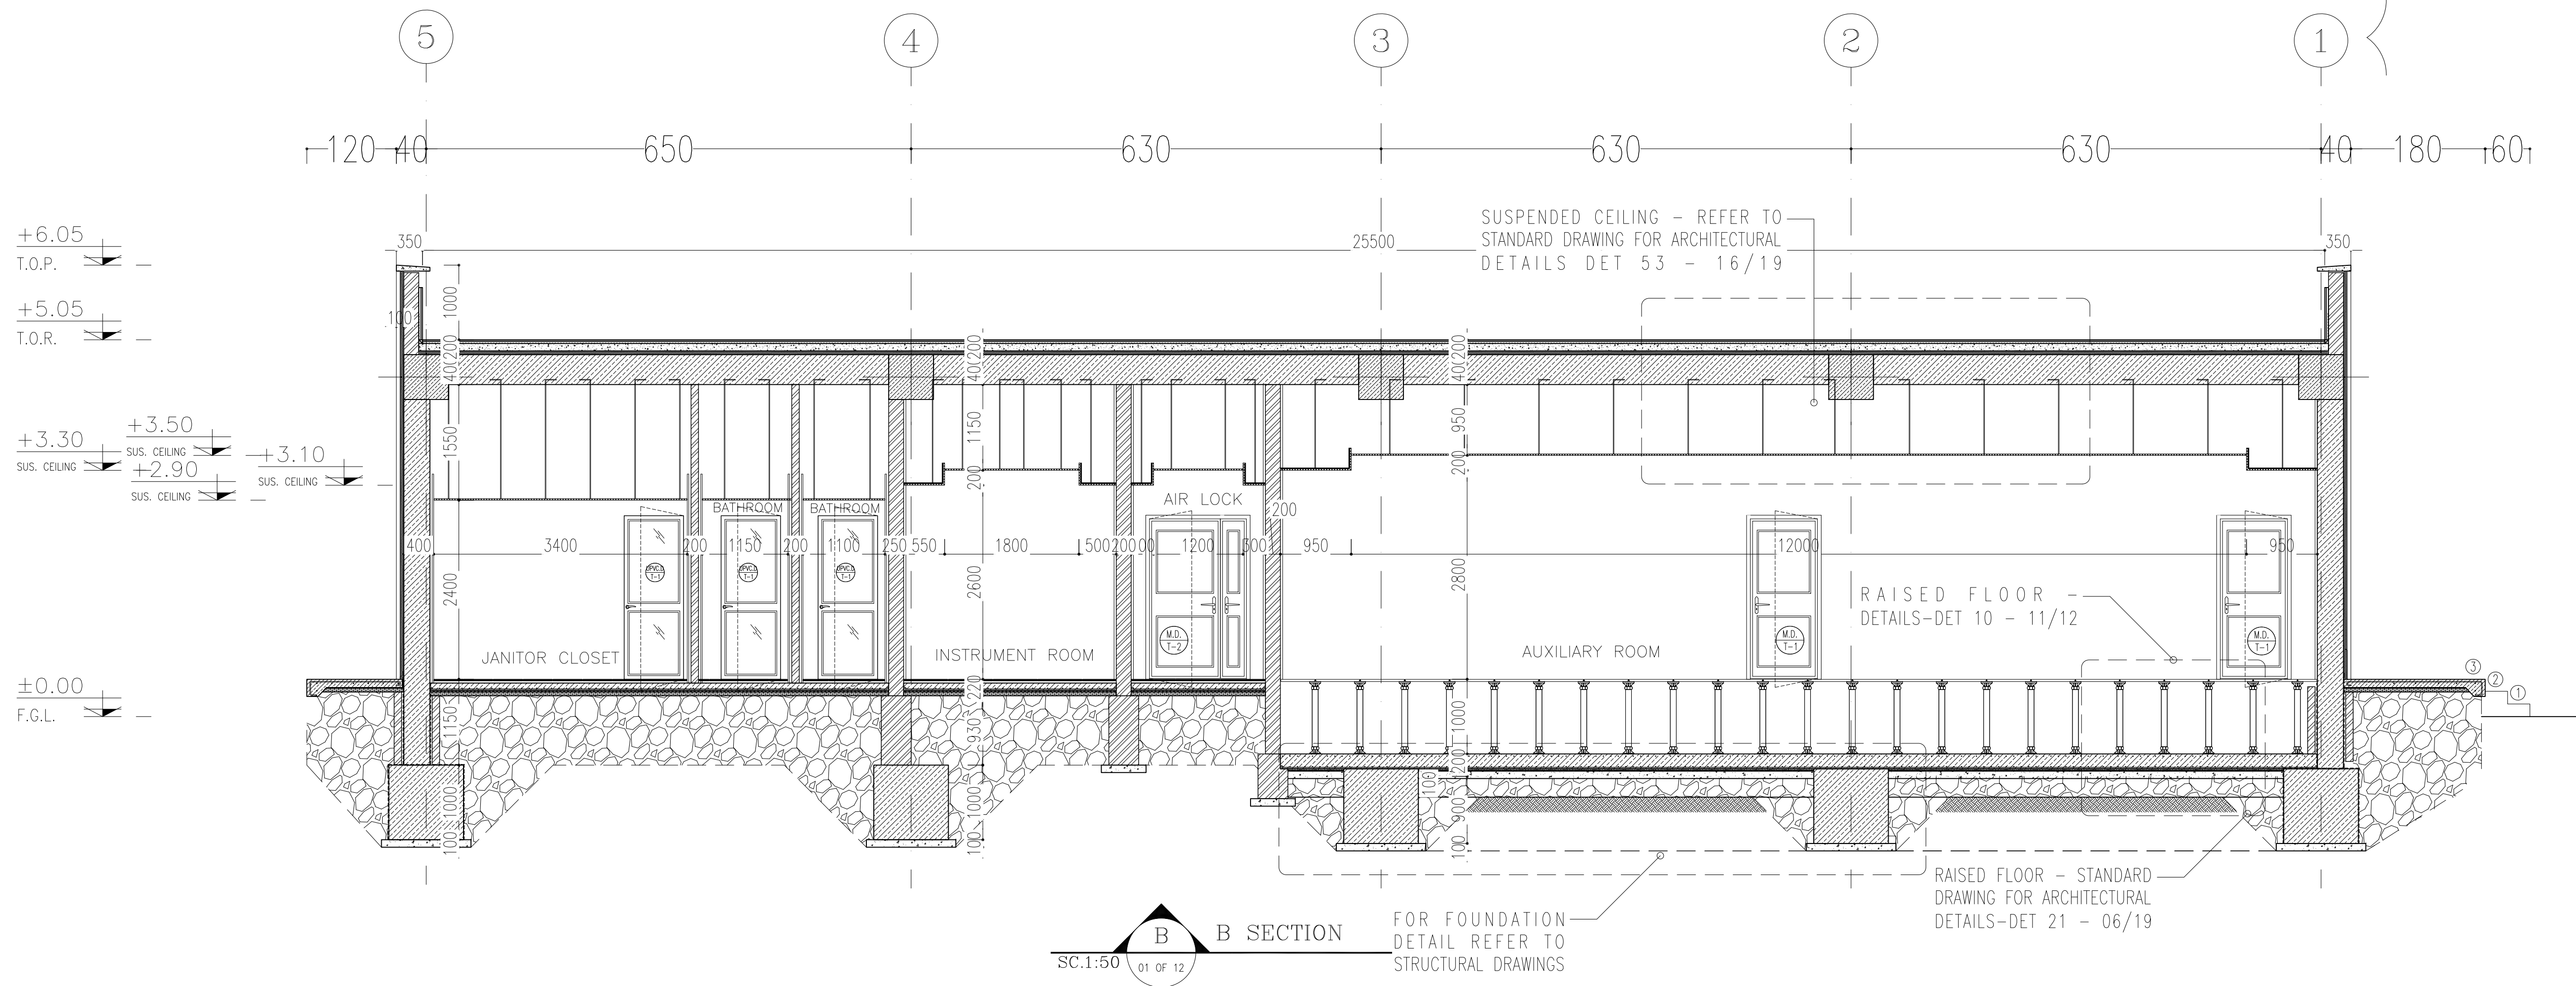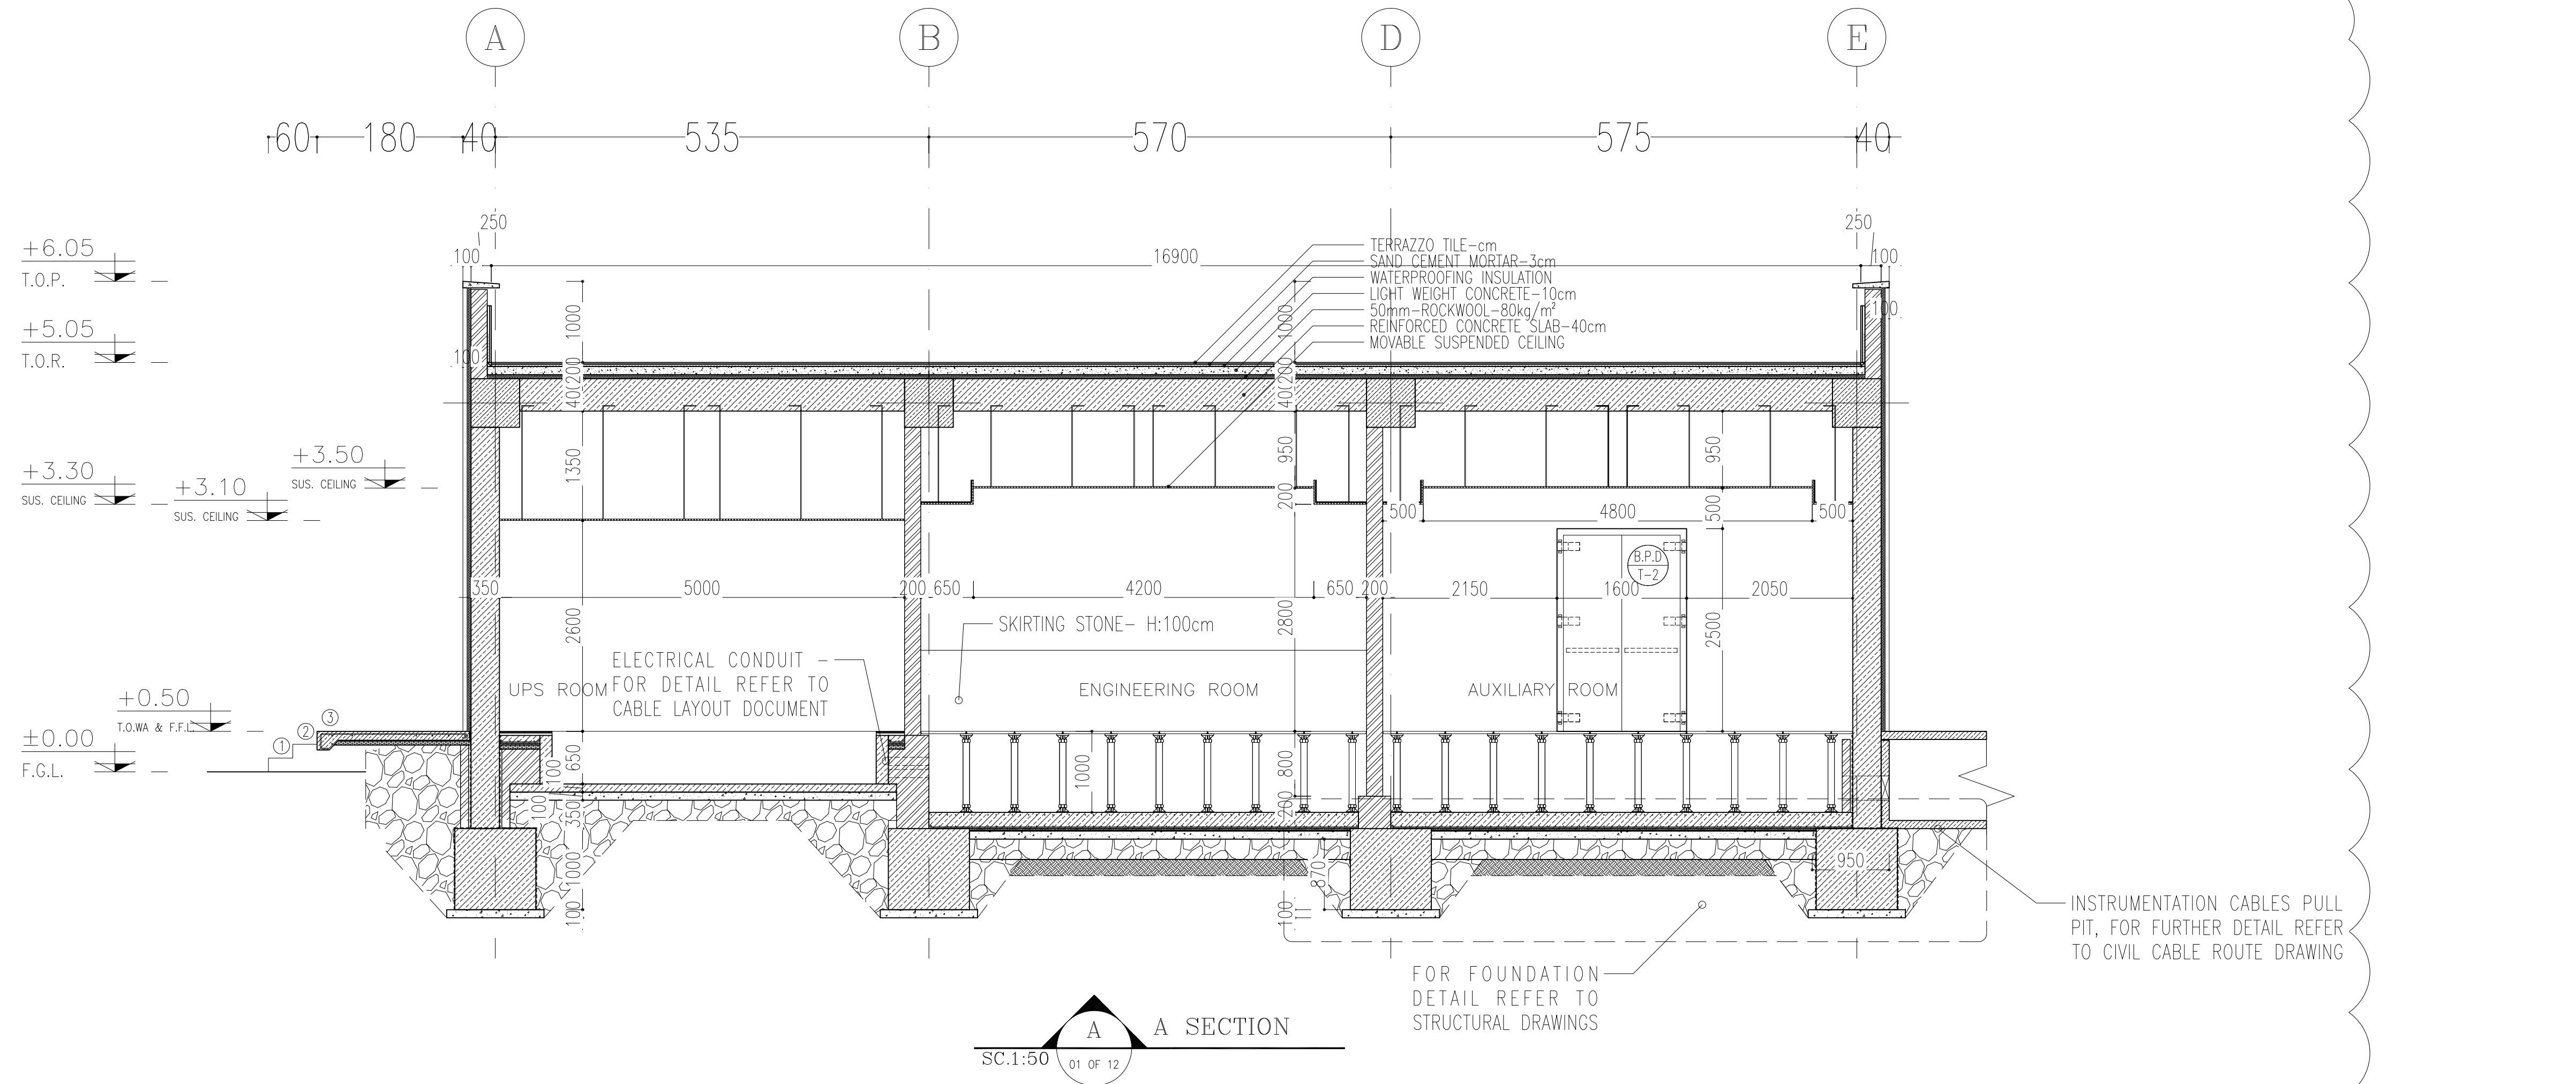

DOOR TYPES

D05

NOTES

1. ALL DIMENSIONS ARE IN CENTIMETER & ALL ELEVATIONS ARE IN METER.
2. ALL DIMENSIONS AND ELEVATIONS SHALL BE CHECKED BY THE CONTRACTOR PRIOR TO CONSTRUCTION.
3. CONTRACTOR SHALL COMPARE ALL ARCHITECTURAL, MECHANICAL, ELECTRICAL, PIPING AND STRUCTURAL DRAWINGS AND IN CASE OF ANY CONFLICTS OR DISCREPANCY, INFORM THE ENGINEER.
4. ALL MATERIALS ARE SELECTED FROM THE HIGHEST QUALITY AND MUST BE APPROVED BY THE CLIENT.
5. ALL ORDERS FOR PIPING/DRAINING AND HVAC ORDERS SHALL BE CONSIDERED AS PER RELATED DRAWINGS BEFORE CONSTRUCTION.
6. ALL INTERNAL SLOPES FOR FLOOR DRAINS ARE 1% UNLESS STATED.
7. KNAUF BOARDS SHALL BE "MR" IN MOST SPACES AND "TF" IN HEAT ZONES.
8. FINISH GRADING LEVEL (T.O.L.) = ±1.20 (W.S.L.) = ±0.00 (LOCAL).
9. ALL WBS ARE EQUIPPED WITH HAND-WASH-HOT AIR-BLOWER/ELECTRICAL SOAP DISPENSER WITH ABS DOORS(WITH CLOSER MECHANISM).
10. ACCORDING TO SPECIFICATION FOR BUILDINGS INTERIOR PAINTING FOR MASONRY, CONCRETE, PLASTER, GYPSUM WALL BOARD SHALL DONE AS FOLLOW : 1st COAT, PRIMER AND SEALER, 2nd AND 3rd COATS, INTERIOR PAINT SEM LUSTRE (WHITE ALKYLID PAINT).
11. ALL BLASTPROOF DOORS ARE PANIC DOORS - PANIC BARS ARE REQUIRED.
12. BATTERY ROOM SHALL BE EQUIPPED WITH EXPLOSION-PROOF,FANLIGHTING,SWITCHES,OUTLETS AND ETC.

LEGEND


CONCRETE WALL OR CEILING

PRESSED BRICK

LIGHT WEIGHT CONCRETE

HARD CORE


COMPACT SOIL

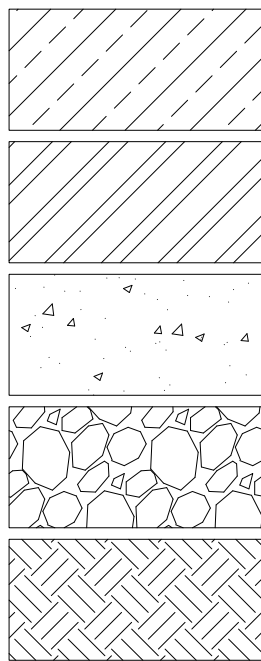

F.F.L.	FINISHED FLOOR	W.D	WOOD DOOR
T.O.WA	TOP OF WALKWAY	T.O.D.	TOP OF DOOR
T.O.R.	TOP OF ROOF	F.G.L.	FINISH GRADING LEVEL
T.O.P.	TOP OF PARAPET	B.P.D.	BLAST-PROOF DOOR
T.O.FOU.	TOP OF FOUNDATION	B.O.Ca.	BOTTOM OF LADDER CAGE
AL.D.	ALUMINIUM DOOR	T.O.Ca.	TOP OF LADDER CAGE
M.D.	METAL DOOR		

REFERENCE DRAWING	DRG. No.
Standard Details For Ladder & Safety Cage	BK-GNRL-PEDCO-000-ST-DW-0009
FOUNDATION DRAWING FOR CONTROL BUILDING	BK-GCS-PEDCO-120-ST-DW-0061
STRUCTURAL DRAWING FOR CONTROL BUILDING	BK-GCS-PEDCO-120-ST-DW-0062
ROAD, PAVING AND PLANT FINISH GRADING LAYOUT & SECTIONS	BK-GCS-PEDCO-120-CV-PY-0005
CABLE TRENCH AND DUCT BANK LAYOUT	BK-GCS-PEDCO-120-CV-PY-0002
ELECTRICAL CABLE ROUTE & SECTION LAYOUT FOR BUILDING & SHELTER	BK-GCS-PEDCO-120-EL-PY-0006
CONTROL ROOM LAYOUT & ARRANGEMENT DRAWING	BK-GCS-PEDCO-120-IN-PY-0001
PLUMBING & SEWAGE PIPING LAYOUT FOR CONTROL BUILDING	BK-GCS-PEDCO-120-HV-PY-0001
HVAC ROOM LAYOUT & SECTION FOR CONTROL BUILDING	BK-GCS-PEDCO-120-HV-PY-0002
HVAC SYSTEM DUCT PLAN FOR CONTROL BUILDING	BK-GCS-PEDCO-120-HV-PY-0003
HVAC SYSTEM ROOF LAYOUT FOR CONTROL BUILDING	BK-GCS-PEDCO-120-HV-PY-0004

KEY PLAN

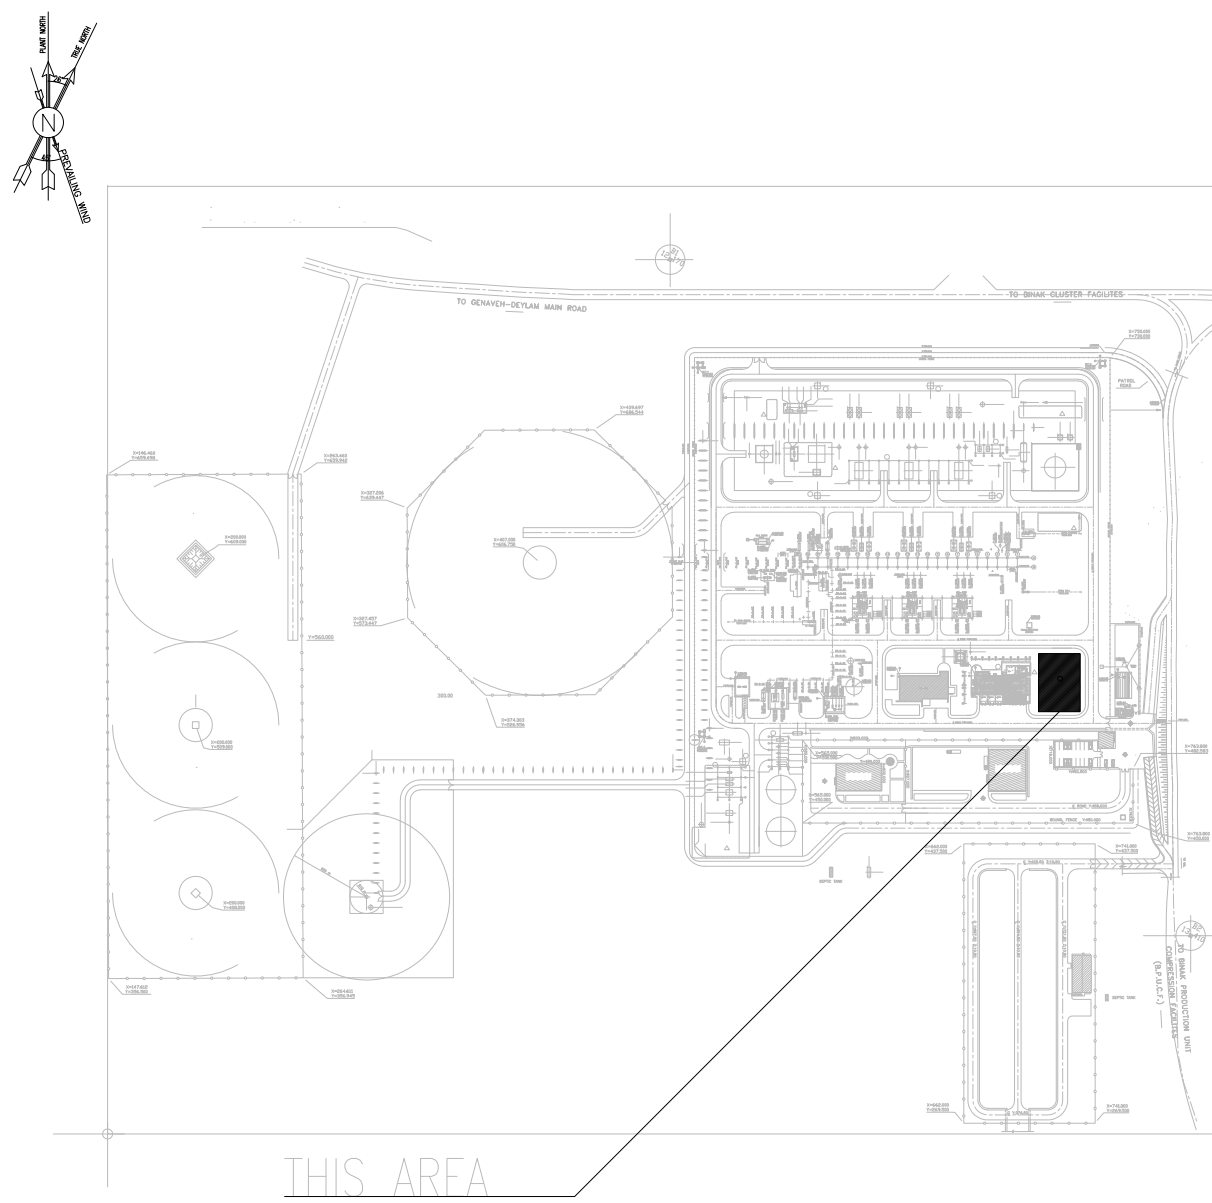

D05	JAN.2023	IFA	R.BERLOUIE	M.PAKHARIAN	M.Mehrshad	***
D04	OCT.2022	IFA	R.BERLOUIE	M.PAKHARIAN	M.Mehrshad	***
D03	AUG.2022	IFA	R.BERLOUIE	M.PAKHARIAN	M.Mehrshad	***
D02	MAR.2022	IPC	R.BERLOUIE	M.PAKHARIAN	M.Mehrshad	***
D01	JAN.2022	IPC	R.BERLOUIE	M.PAKHARIAN	M.Mehrshad	***
D00	DEC.2021	IPC	R.BERLOUIE	M.PAKHARIAN	M.Mehrshad	***
REV.	DATE	P.O.I.S	PREP.	CHK.	APP.	AUT.

PROJECT NAME: BINAK OILFIELD DEVELOPMENT/SURFACE FACILITIES GAS COMPRESSOR STATION

PROJECT NO.: 971020

EPC CONTRACTOR:	EPD/EPC CONTRACTOR (GC):
 HIRGAN ENERGY - DESIGN & INSPECTION COMPANIES	 PETROIRAN DEVELOPMENT COMPANY








DRAWING TITLE: ARCHITECTURAL DETAIL DRAWING FOR CONTROL BUILDING SECTION, DETAILS AND DOOR TYPES

SCALE	SIZE	DRAWING NO.	SHEET NO.	REV.
AS SHOWN	A0	BK-GCS-PEDCO-120-AR-DW-0001	08 OF 12	D05

NO CONSTRUCTION PERMITTED UNLESS DRAWING APPROVED







APPROVED FOR CONSTRUCTION	BY:	DATE:
BUDGET REF. LOCATION SIZE CLASS	SERIAL NO.	SHEET REVISION

053-073-9184	F	4	B	709099	08 OF 12	D05
--------------	---	---	---	--------	----------	-----

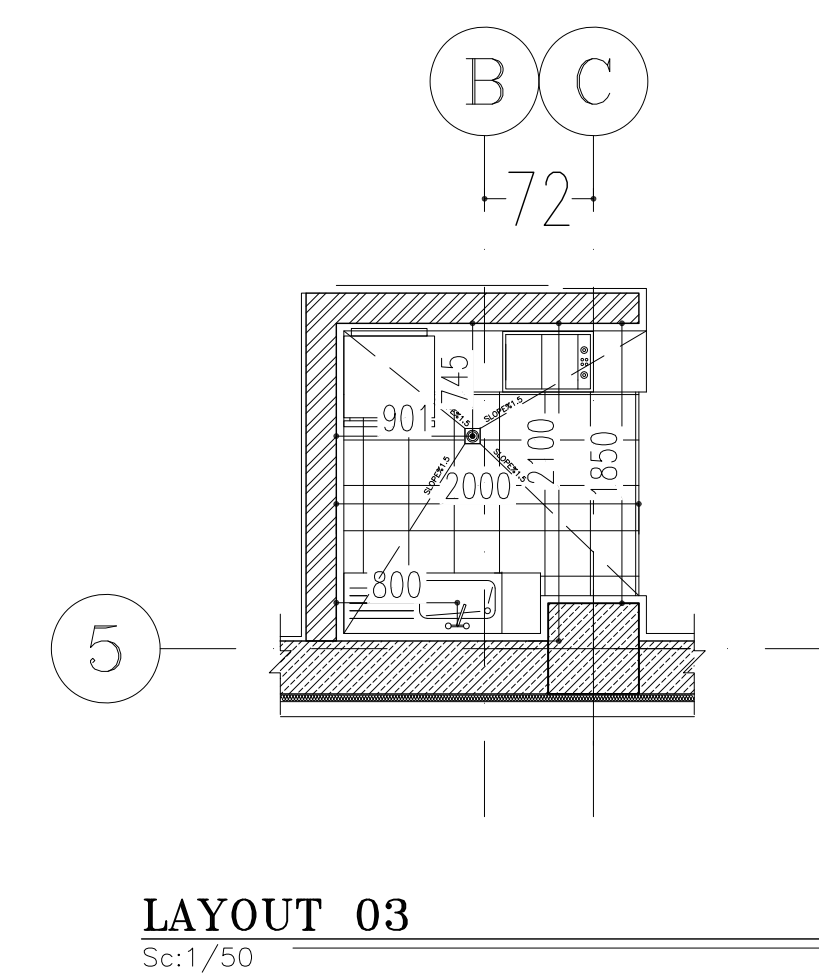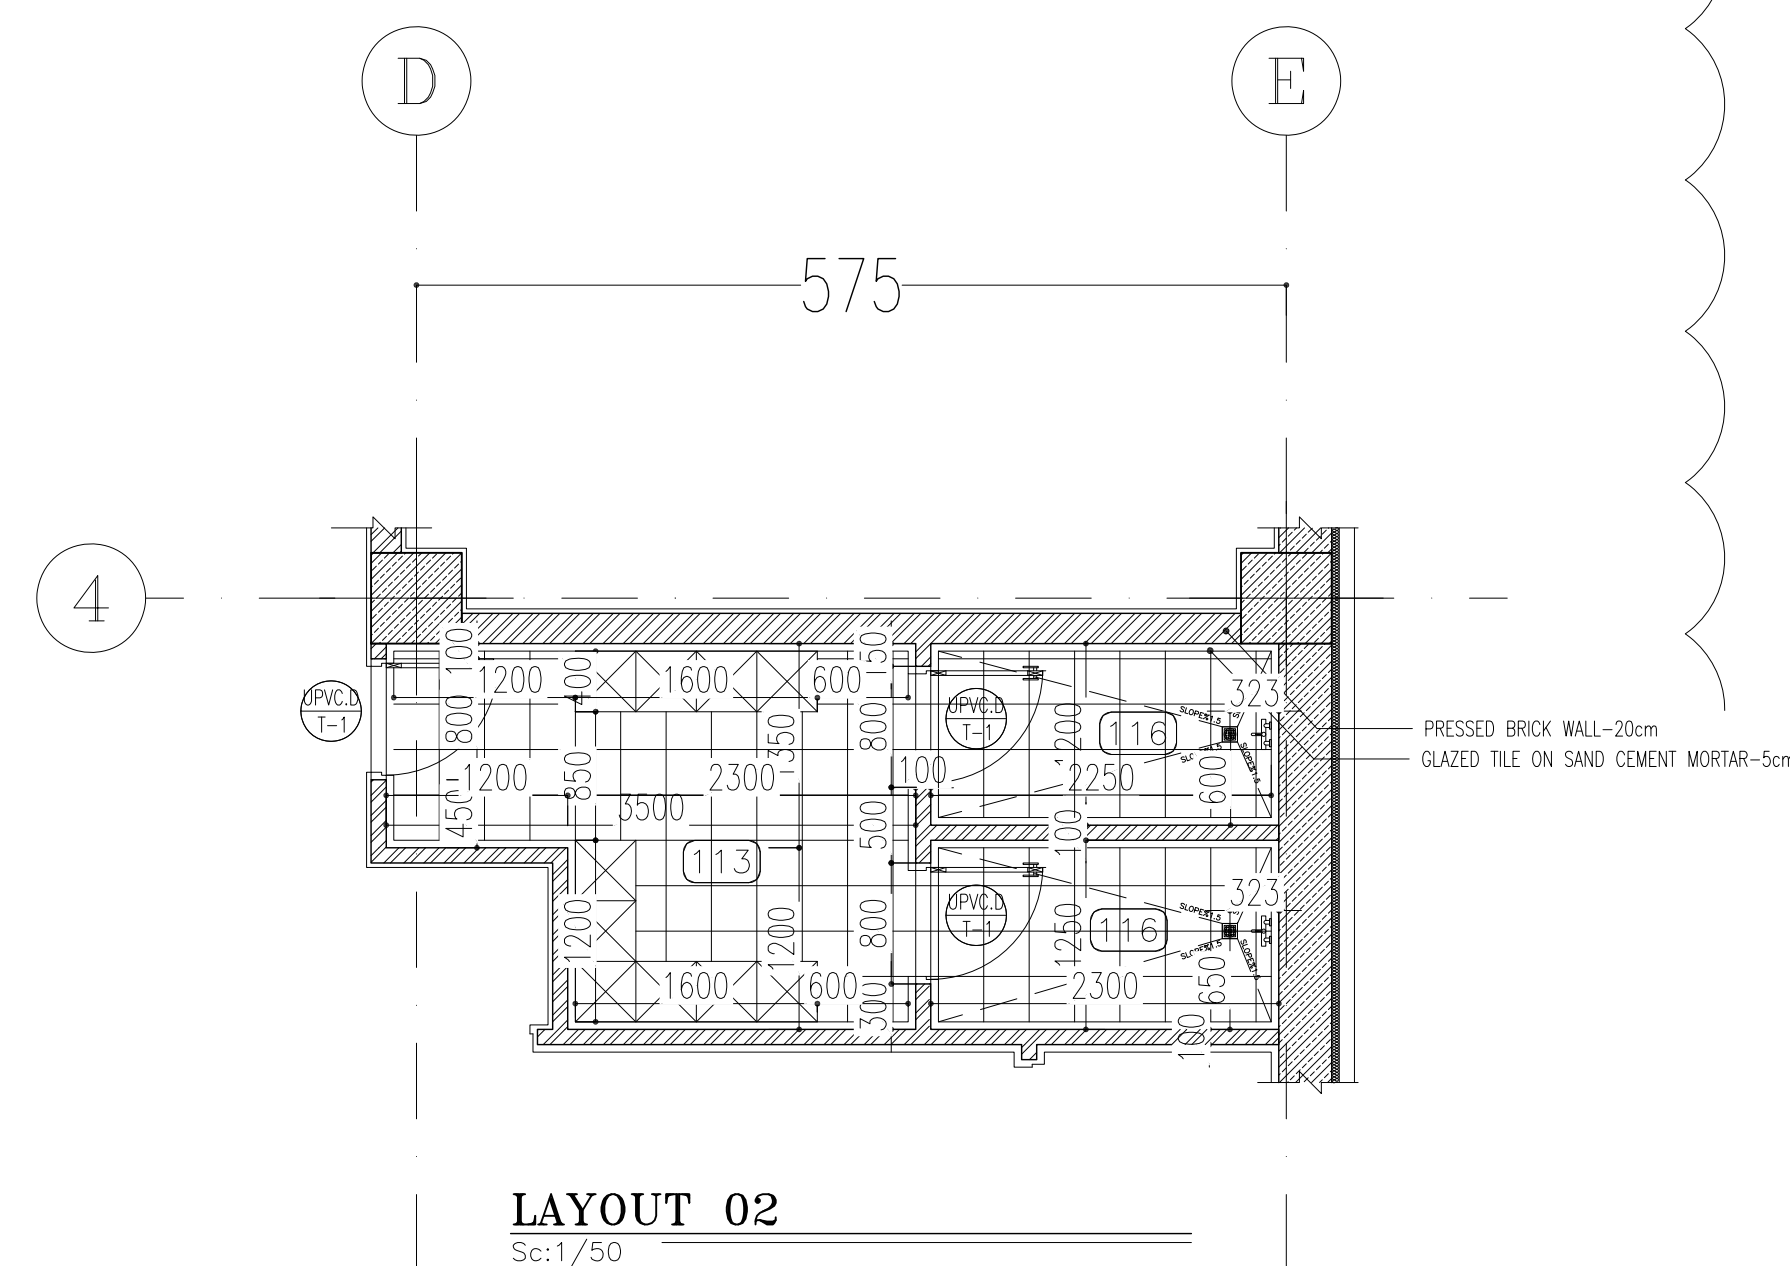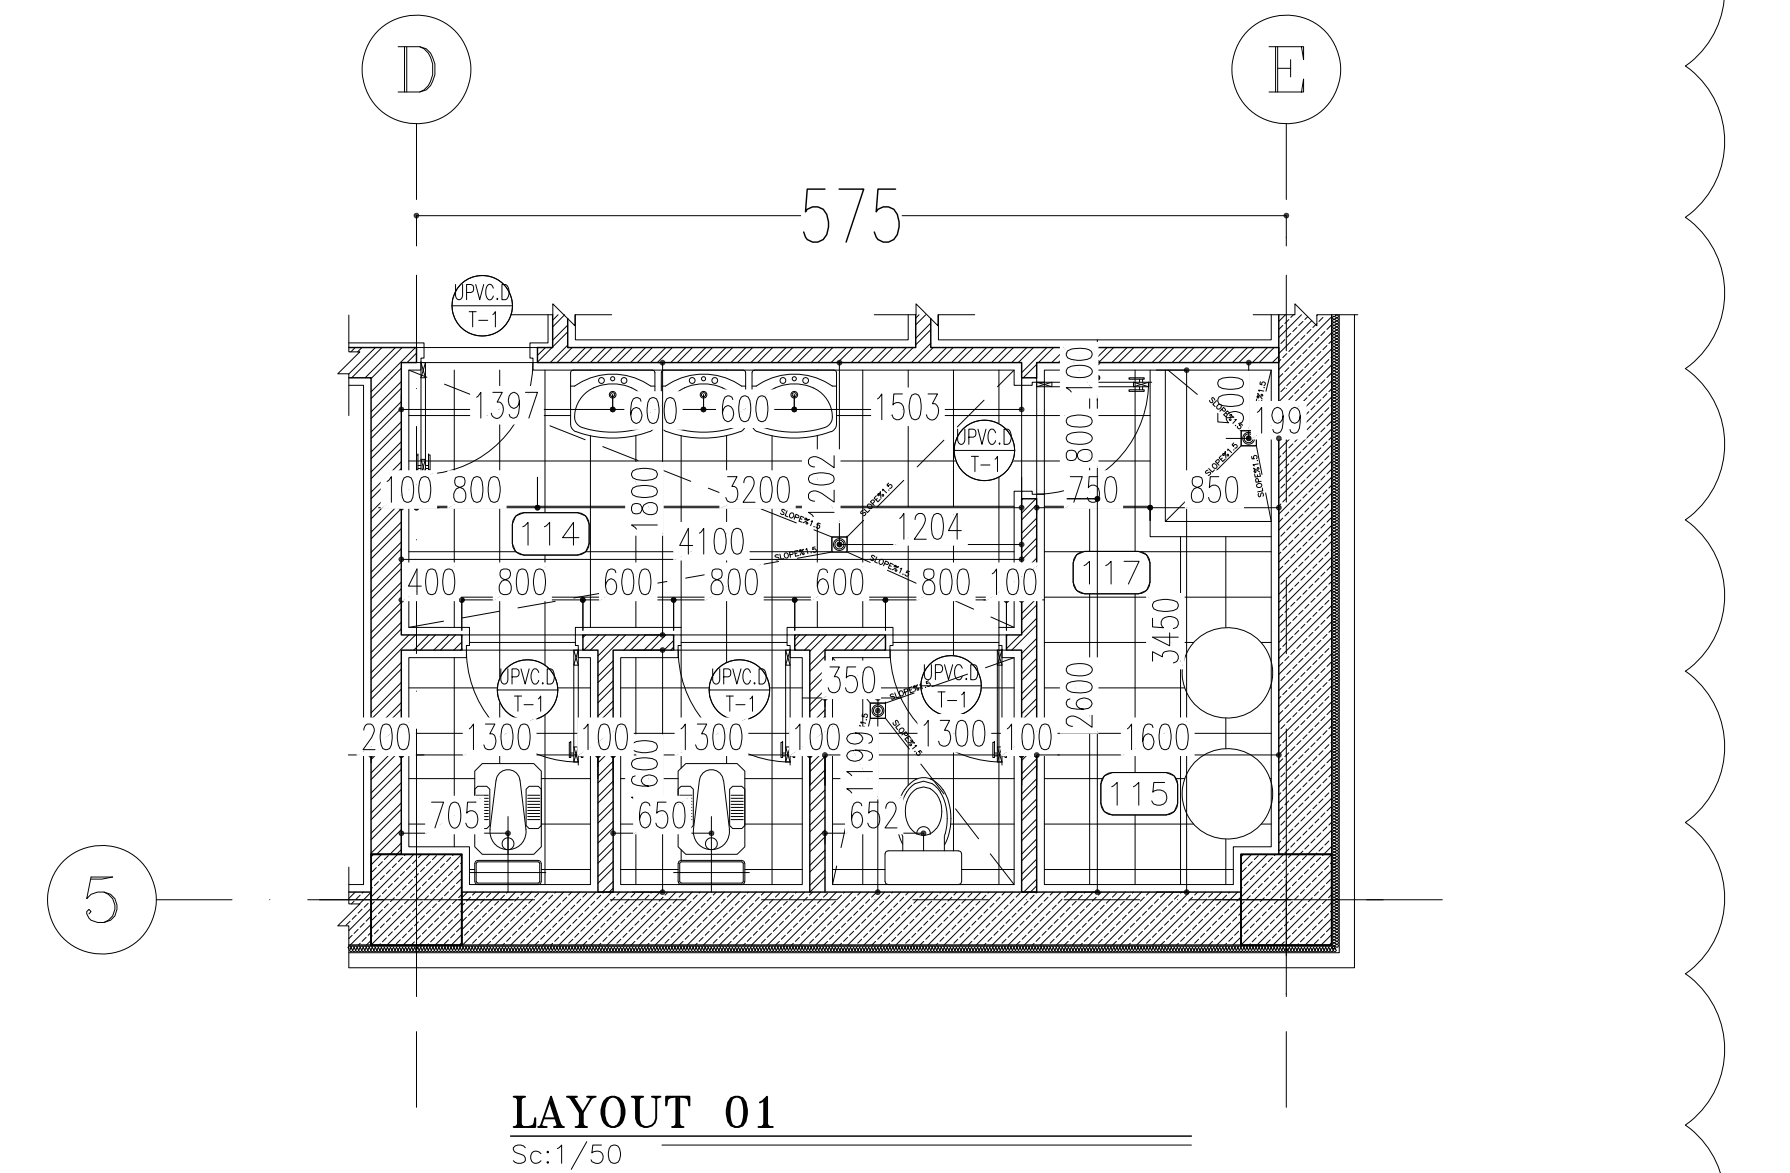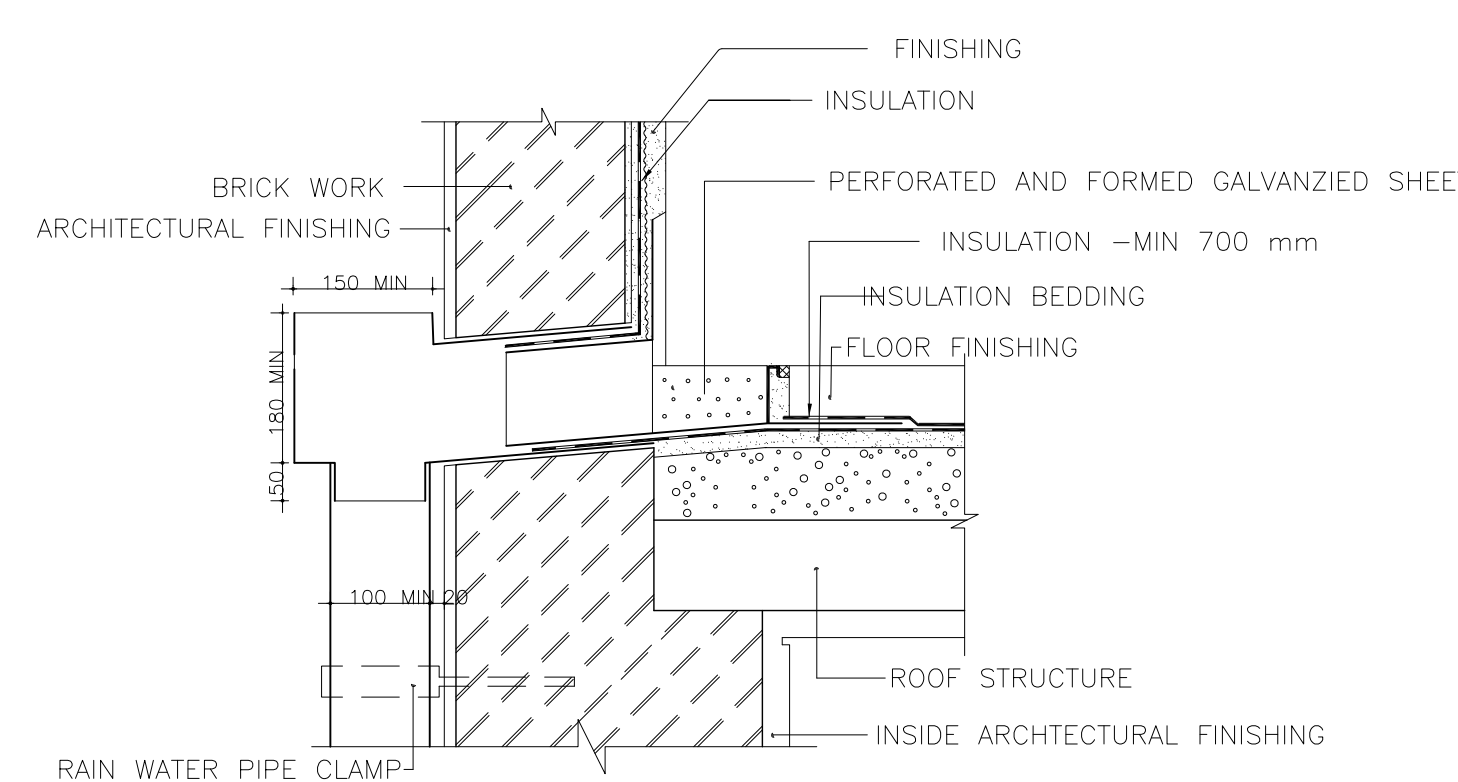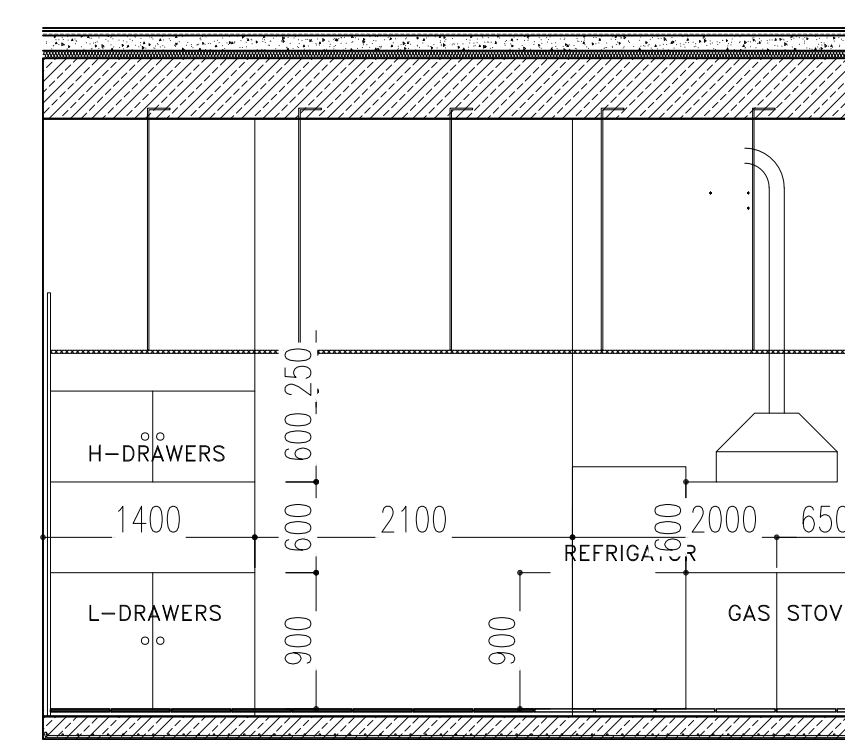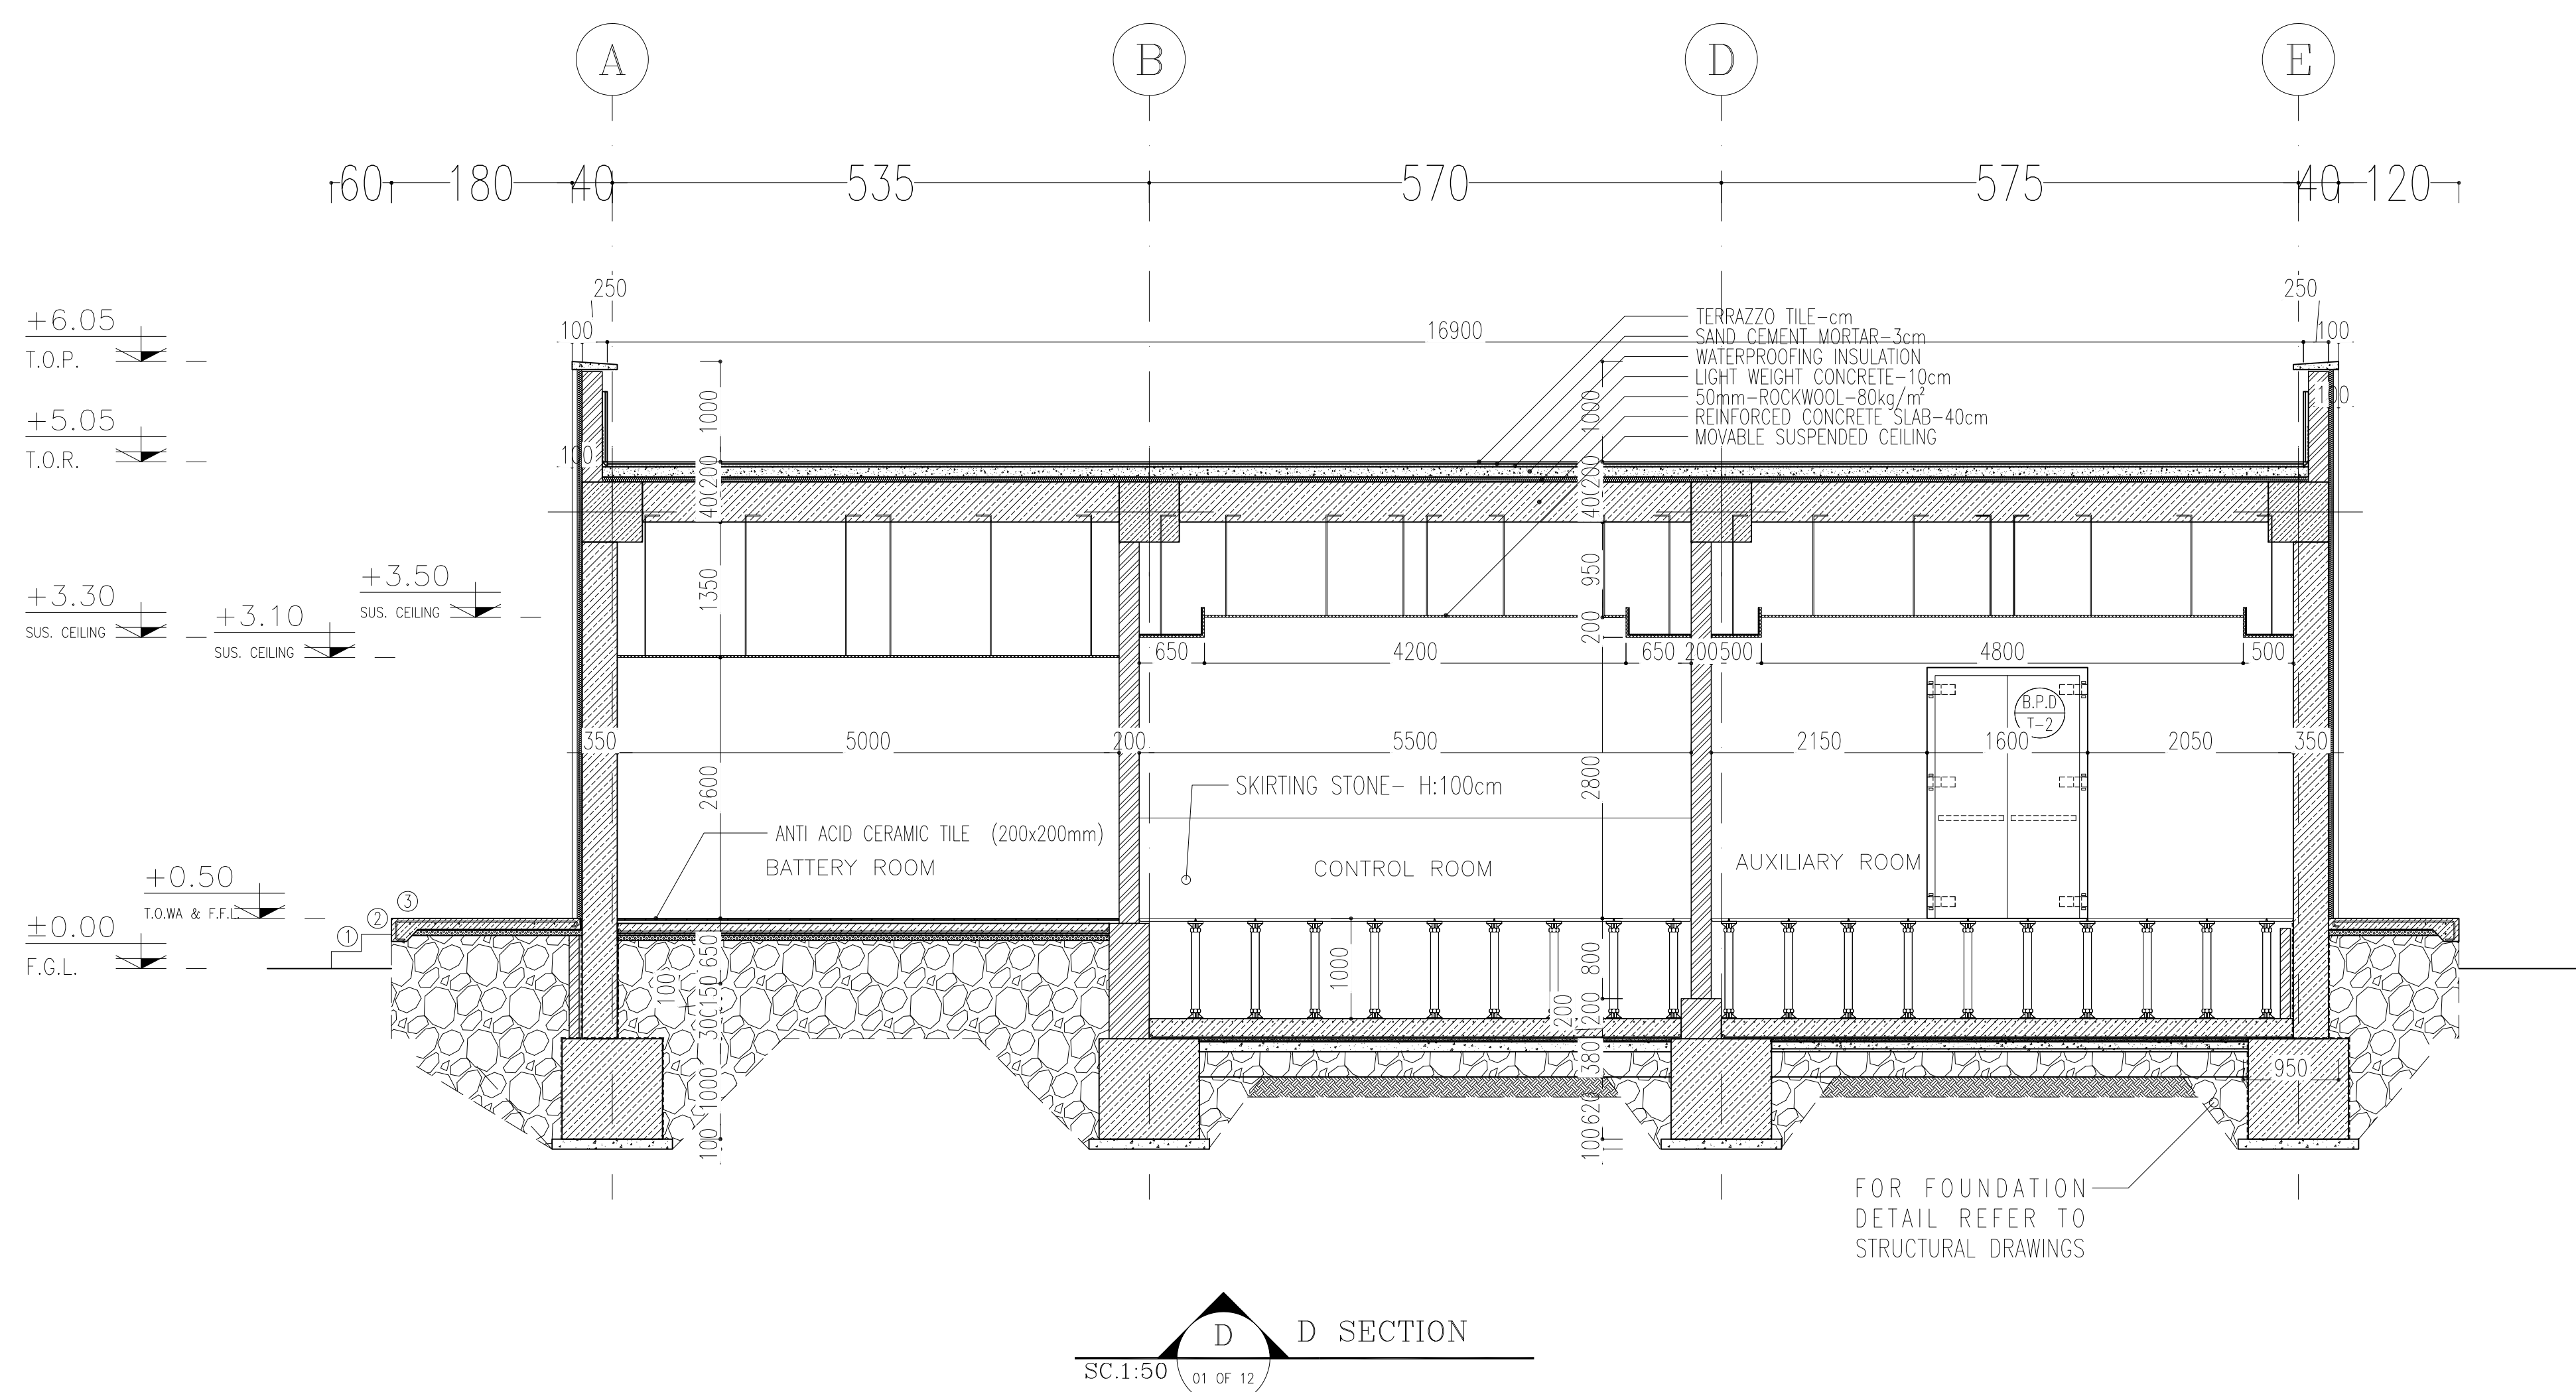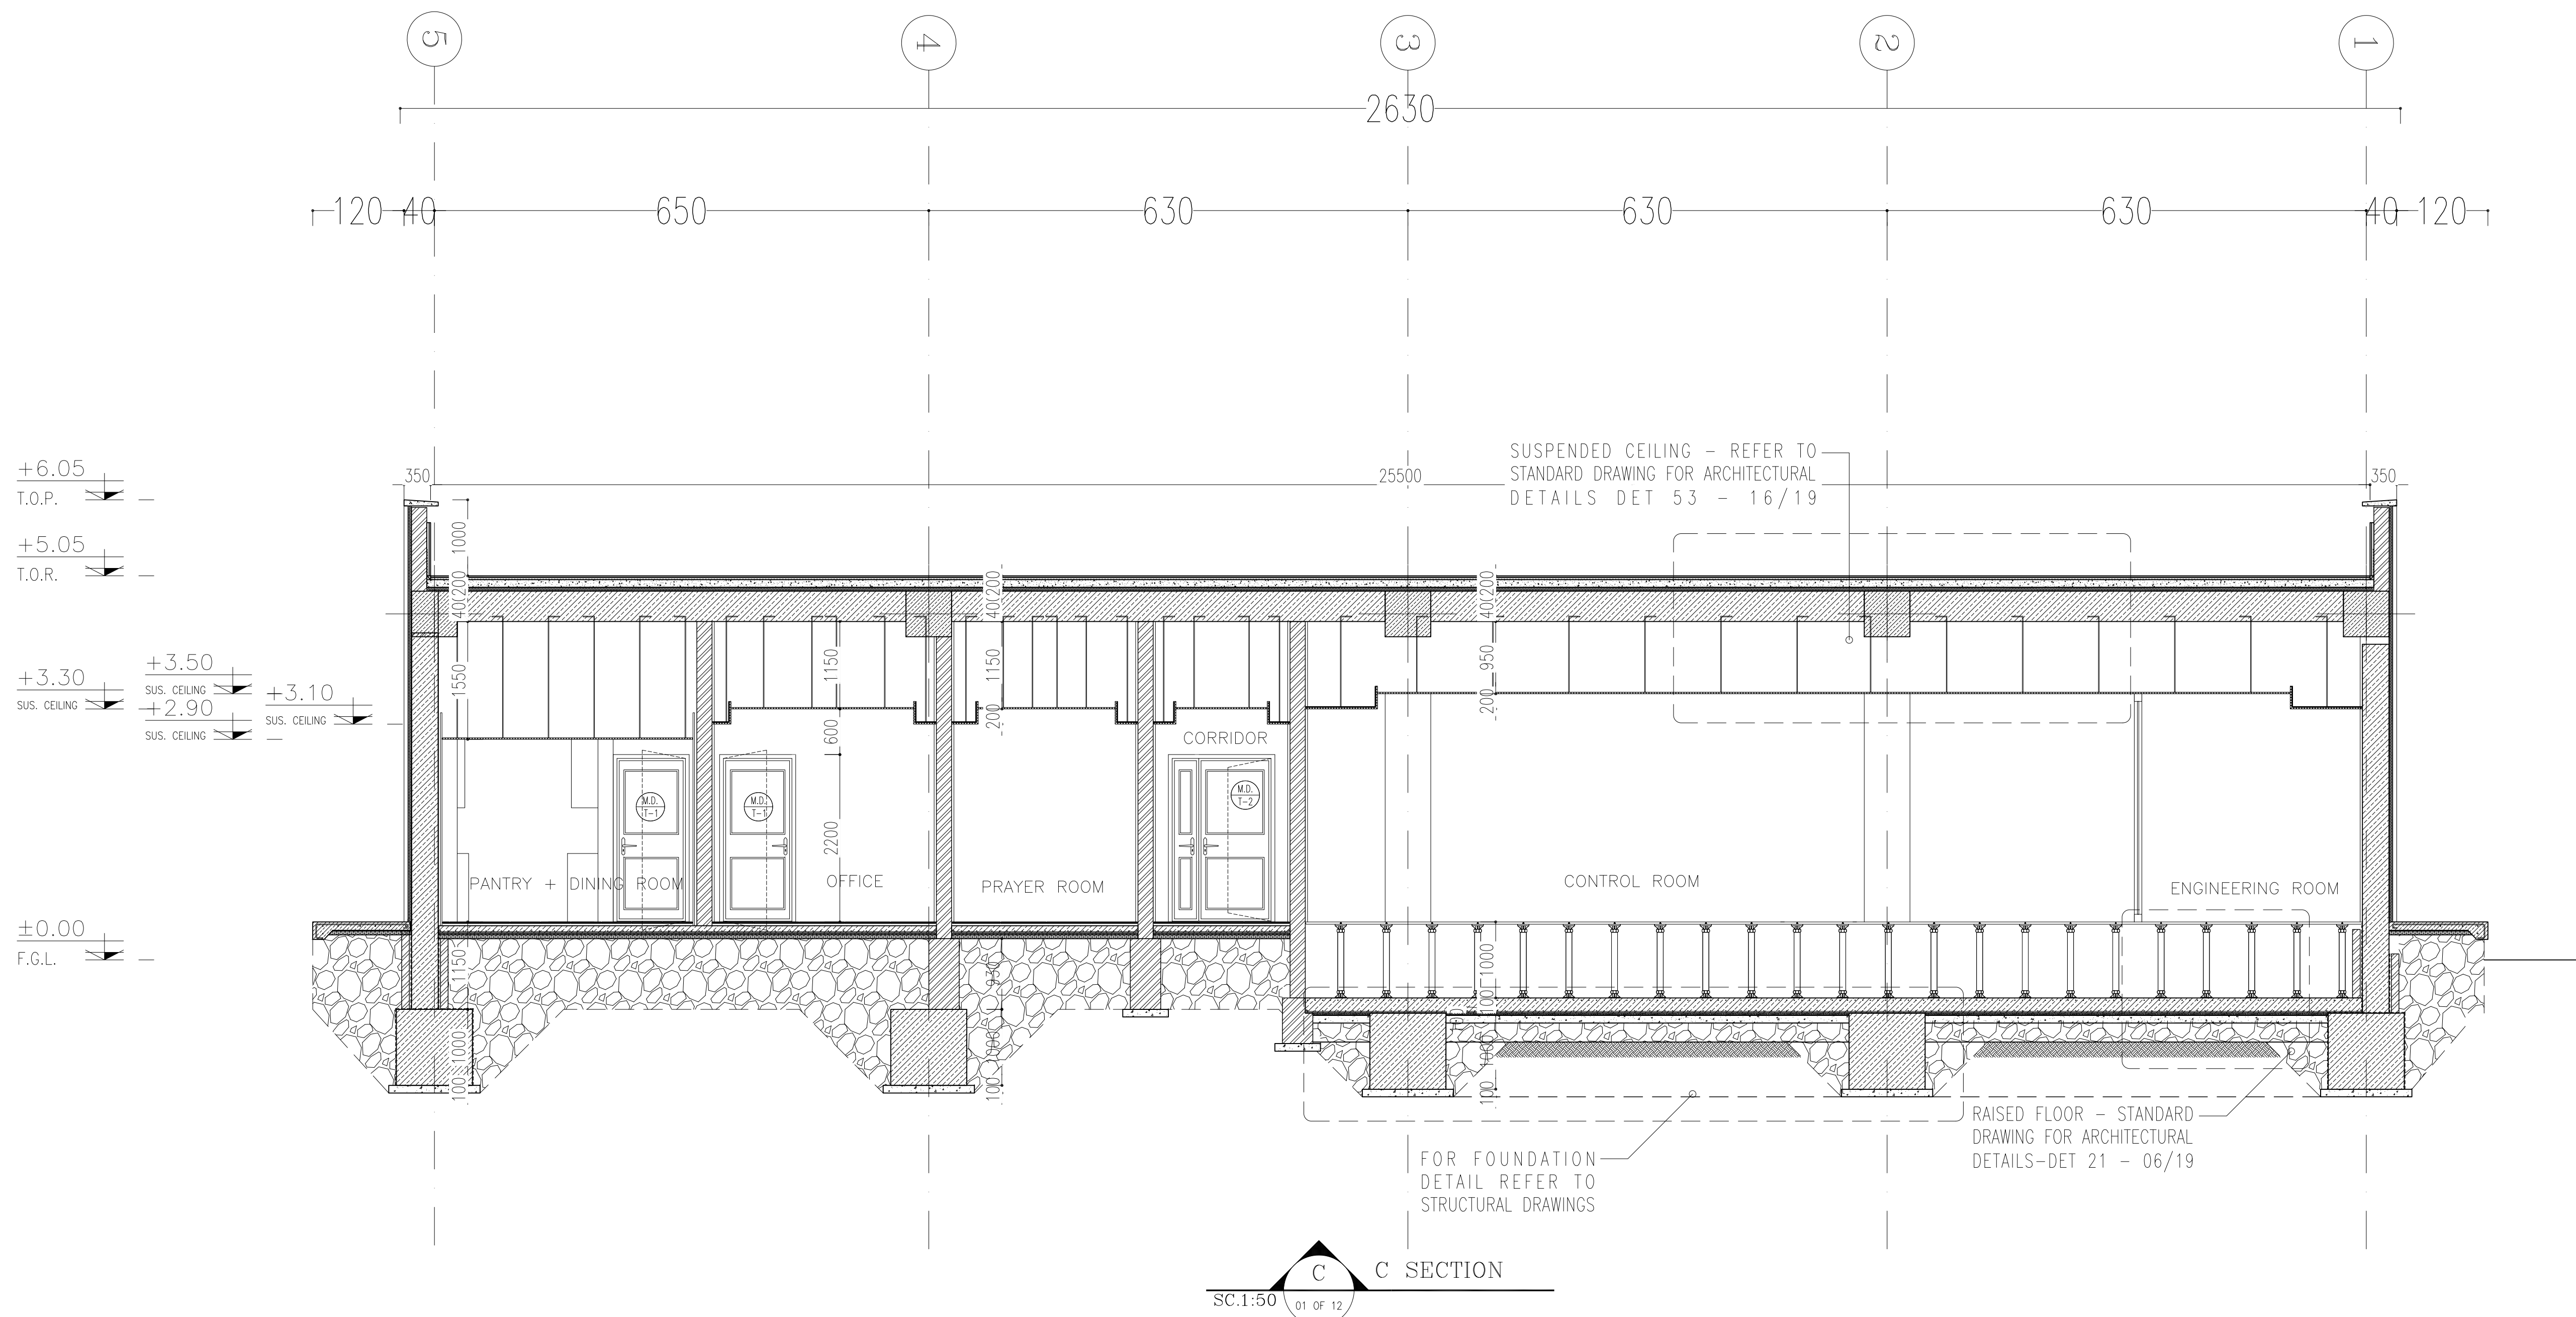


NOTES

1. ALL DIMENSIONS ARE IN CENTIMETER & ALL ELEVATIONS ARE IN METER.
2. ALL DIMENSIONS AND ELEVATIONS SHALL BE CHECKED BY THE CONTRACTOR PRIOR TO CONSTRUCTION.
3. CONTRACTOR SHALL COMPLY ALL ARCHITECTURAL, MECHANICAL, ELECTRICAL, PIPING AND STRUCTURAL DRAWINGS AND IN CASE OF ANY CONFLICTS OR DISCREPANCY, INFORM THE ENGINEER.
4. ALL MATERIALS TO BE USED ARE SELECTED FROM THE LIST AND SHALL BE APPROVED BY THE CLIENT.
5. ALL OPENINGS FOR PIPING/CABLEING AND W/HS OPENINGS SHALL BE CONSIDERED AS PER RELATED DRAWINGS BEFORE CONSTRUCTION.
6. ALL INTERNAL STAIRS FOR FLOOR DECKS ARE 1% UNLESS STATED.
7. HALLWAY BRANDES SHALL BE 90° IN MOST SPACES AND 120° IN CORNERS AND ZONES.
8. FINISH GRADE LEVEL (F.G.L.) = +1.10 M.S.L. ± 0.00 (LOCAL).
9. ALL W/CS ARE EQUIPPED WITH HAND-HOLDING AIR-BLOWER/ELECTRIC SOAP DISPENSER.
10. HALLWAYS DOORS WITH GLASS GLAZING MECHANISM.
11. ACCORDING TO SPECIFICATION FOR BUILDINGS INTERIOR PAINTING FOR MASONRY, CONCRETE, PLASTER, GYPSUM WALL BOARD AND PLASTER, INTERIOR PAINT SHALL BE APPLIED IN INTERIOR PAINT COLOR LUSTRE (WHITE) AND 10%.
12. ALL BLASTPROOF DOORS ARE PAINTED DOUBLE – PAINTS ARE REQUIRED.
13. BATTERY ROOM SHALL BE EQUIPPED WITH EXPLOSION-PROOF FAN/LIGHTING, SWITCHES, OUTLETS AND ETC.

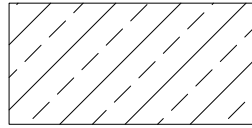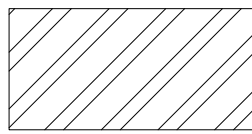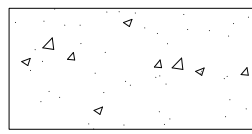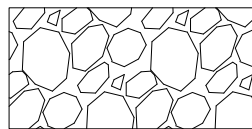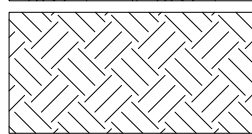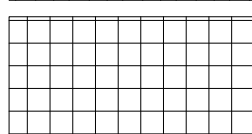LEGEND			
CONCRETE WALL OR CEILING			
PRESSED BRICK			
LIGHT WEIGHT CONCRETE			
HARD CORE			
COMPACT SOIL			
CERAMIC TILES(30x30)			
F.F.L.	FINISHED FLOOR	W.D	WOOD DOOR
T.O.WA	TOP OF WALKWAY	T.O.D.	TOP OF DOOR
T.O.R.	TOP OF ROOF	F.G.L.	FINISH GRADING LEVEL
T.O.P.	TOP OF PARAPET	B.P.D.	BLAST-PROOF DOOR
T.O.FOU.	TOP OF FOUNDATION	B.O.Ca.	BOTTOM OF LADDER CAGE
AL.D.	ALUMINIUM DOOR	T.O.Ca.	TOP OF LADDER CAGE
M.D.	METAL DOOR		

REFERENCE DRAWING	DRG. No.
Standard Details For Ladder & Safety Cage	BK-GNRL-PEDCO-000-ST-DW-0009
FOUNDATION DRAWING FOR CONTROL BUILDING	BK-GCS-PEDCO-120-ST-DW-0061
STRUCTURAL DRAWING FOR CONTROL BUILDING	BK-GCS-PEDCO-120-ST-DW-0062
ROAD, PAVING AND PLANT FINISH GRADING LAYOUT & SECTIONS	BK-GCS-PEDCO-120-CV-PY-0005
CABLE TRENCH AND DUCT BANK LAYOUT	BK-GCS-PEDCO-120-CV-PY-0002
ELECTRICAL CABLE ROUTE & SECTION LAYOUT FOR BUILDING & SHELTER	BK-GCS-PEDCO-120-EL-PY-0006
CONTROL ROOM LAYOUT & ARRANGEMENT DRAWING	BK-GCS-PEDCO-120-HV-PY-0001
PLUMBING & SEWAGE PIPING LAYOUT FOR CONTROL BUILDING	BK-GCS-PEDCO-120-HV-PY-0001
HVAC ROOM LAYOUT & SECTION FOR CONTROL BUILDING	BK-GCS-PEDCO-120-HV-PY-0002
HVAC SYSTEM DUCT PLAN FOR CONTROL BUILDING	BK-GCS-PEDCO-120-HV-PY-0003
HVAC SYSTEM ROOF LAYOUT FOR CONTROL BUILDING	BK-GCS-PEDCO-120-HV-PY-0004



KEY PLAN

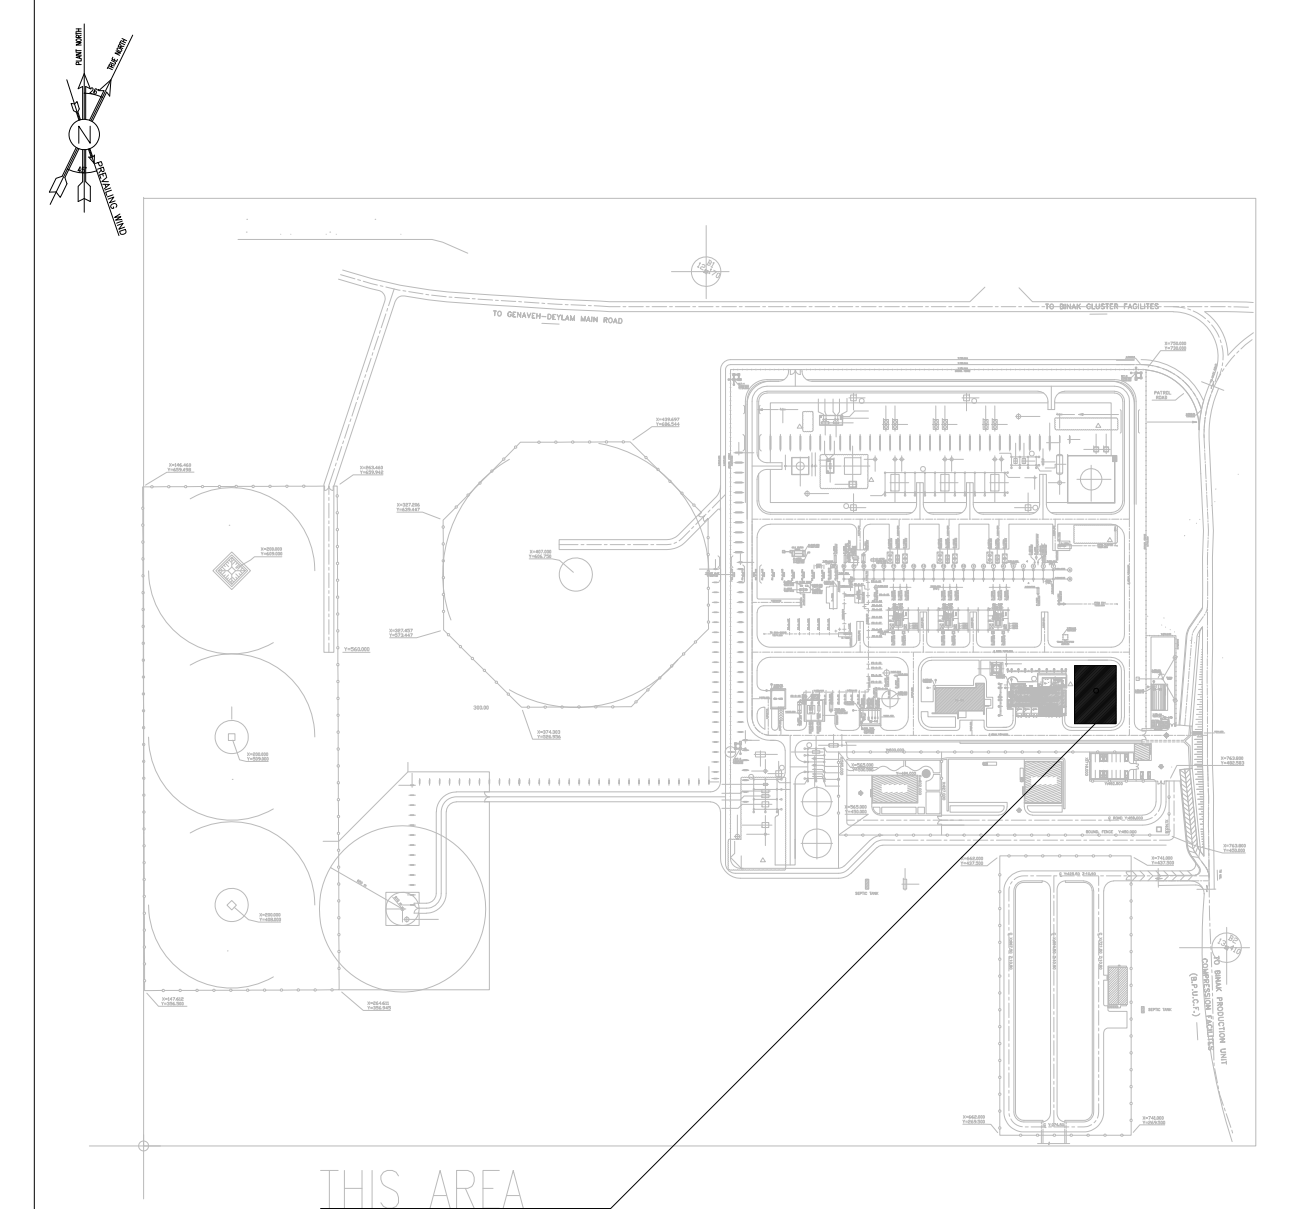

D05	JAN.2022	IFA	R.BERLOUJE	M.FAKHARIAN	M.Mehrshad	**							
D04	OCT.2022	IFA	R.BERLOUJE	M.FAKHARIAN	M.Mehrshad	**							
D03	AUG.2022	IFA	R.BERLOUJE	M.FAKHARIAN	M.Mehrshad	**							
D02	MAR.2022	IPC	R.BERLOUJE	M.FAKHARIAN	M.Mehrshad	**	***	*****	***	****	**	*****	
D01	JAN.2022	IPC	R.BERLOUJE	M.FAKHARIAN	M.Mehrshad	**	REV.	DESCRIPTION	BY	DATE	BY	DATE	
D00	DEC.2021	IPC	R.BERLOUJE	M.FAKHARIAN	M.Mehrshad	**				CHECKED		REV.	APPR.
REV.	DATE	P.O.I.S	PREP.	CHK.	APP.	AUT.	احمل و کلیه نسخ این نقشه و حق اقتباس متعلق به شرکت مازی ماتالی نفت خیز جنوب میباشد.						
PROJECT NAME:			BINAK OILFIELD DEVELOPMENT/SURFACE FACILITIES GAS COMPRESSOR STATION				 THE ORIGINAL AND ALL COPIES OF THIS DRAWING TOGETHER WITH THE COPYRIGHT THEREON ARE THE SOLE PROPERTY OF N.I.S.O.C./ FIELDS						
PROJECT NO.:			971020										
EPC CONTRACTOR:			EPD/EPC CONTRACTOR (GC):			BINAK OILFIELD DEVELOPMENT SURFACE FACILITIES GAS COMPRESSOR STATION							
 HIRGAN ENERGY – DESIGN & INSPECTION COMPANIES			 PEDCO			PETROIRAN DEVELOPMENT COMPANY							
						DATE		SCALE	DRAWING BY	CHECKED BY	PROJECT ENG.		
DRAWING TITLE:						ARCHITECTURAL DETAIL DRAWING FOR CONTROL BUILDING SECTION, DETAILS AND DOOR TYPES							
						NO CONSTRUCTION PERMITTED UNLESS DRAWING APPROVED							
SCALE		SIZE	DRAWING NO.		SHEET NO.	REV.	APPROVED REF.		LOCATION	SIZE CLASS	SERIAL NO.	SHEET	REVISION
AS SHOWN		A0	BK-GCS-PEDCO-120-A-R-DW-0001		09 OF 12	D05	053-073-9184		F'	4 B	7090999	09 OF 12	D05

FINISHING SCHEDULE																	
SPACE TAG NUMBER	FLOOR				SKIRTING	WALL		CEILING			REMARK						
	GRANITE PLAQUE STONE (60x60)	LEVELED LIGHT CONCRETE	FIRST CLASS LOCAL CERAMIC TILES (30x30)	ANTI-STATIC RAISED FLOOR TILES (60x60)	ANTI ACID CERAMIC TILES (20x20)	STONE (H=100cm) - THK : 10mm	STONE (H=10cm) - THK : 10mm	GYPSUM PLASTER + OIL PAINT	GLAZED TILE 25x30 UP TO +2.60	ANTI ACID CERAMIC TILES (20x20)	TRAVERTINE STONE-w/40cm - THK : ~ 2.5cm	KNAUF SUSPENDED CEILING+MOVABLE PANELS SUSPENDED CEILING (600x600mm)	KNAUF SUSPENDED CEILING	RESINATED KNAUF SUSPENDED CEILING	WHITE CEMENT PLASTER+OIL PAINT	CEMENT PLASTER	
100	WALKWAY (FACADE)		●								●						
101	AIR LOCK	●				●		●				●					
102	CORRIDOR	●				●		●					●				
103	AUXILIARY ROOM				●	●		●					●				
104	CONTROL ROOM				●	●		●					●				
105	UPS ROOM		●			●		●					●				
106	BATTERY ROOM					●			●						●		
107	ENGINEERING ROOM				●	●		●					●				
108	INSTRUMENT ROOM	●				●		●					●				
109	OFFICE	●				●		●					●				
110	IN-CHARGE + ARCHIVE	●					●	●					●				
111	PANTRY + DINING ROOM			●					●				●				
112	PRAYER ROOM	●					●	●					●				
113	LOCKER ROOM			●					●				●				
114	WC			●					●				●				
115	BOILER			●					●				●				
116	BATHROOM			●					●				●				
117	JANITOR CLOSET			●					●				●				
118	HVAC CONTROL ROOM	●					●	●					●				

LINTEL SCHEDULE			
WIDTH a	SPAN b mm	PROFILE mm	
		a>200	a<200
VARIES-- IT DEPENDS ON WALL THICKNESS AND IT'S FINISHING. REFER TO ARCHITECTURAL DWGS.	b<1100	2L-60x60x6	UNP 100
	1100<b<1500	2L-80x80x8	UNP 100
	1600<b<2100	2L-100x100x10	2UNP 80
	2100<b<3000	2IPE 160	2UNP 100
	3000<b<3600	2IPE 180	2UNP 100

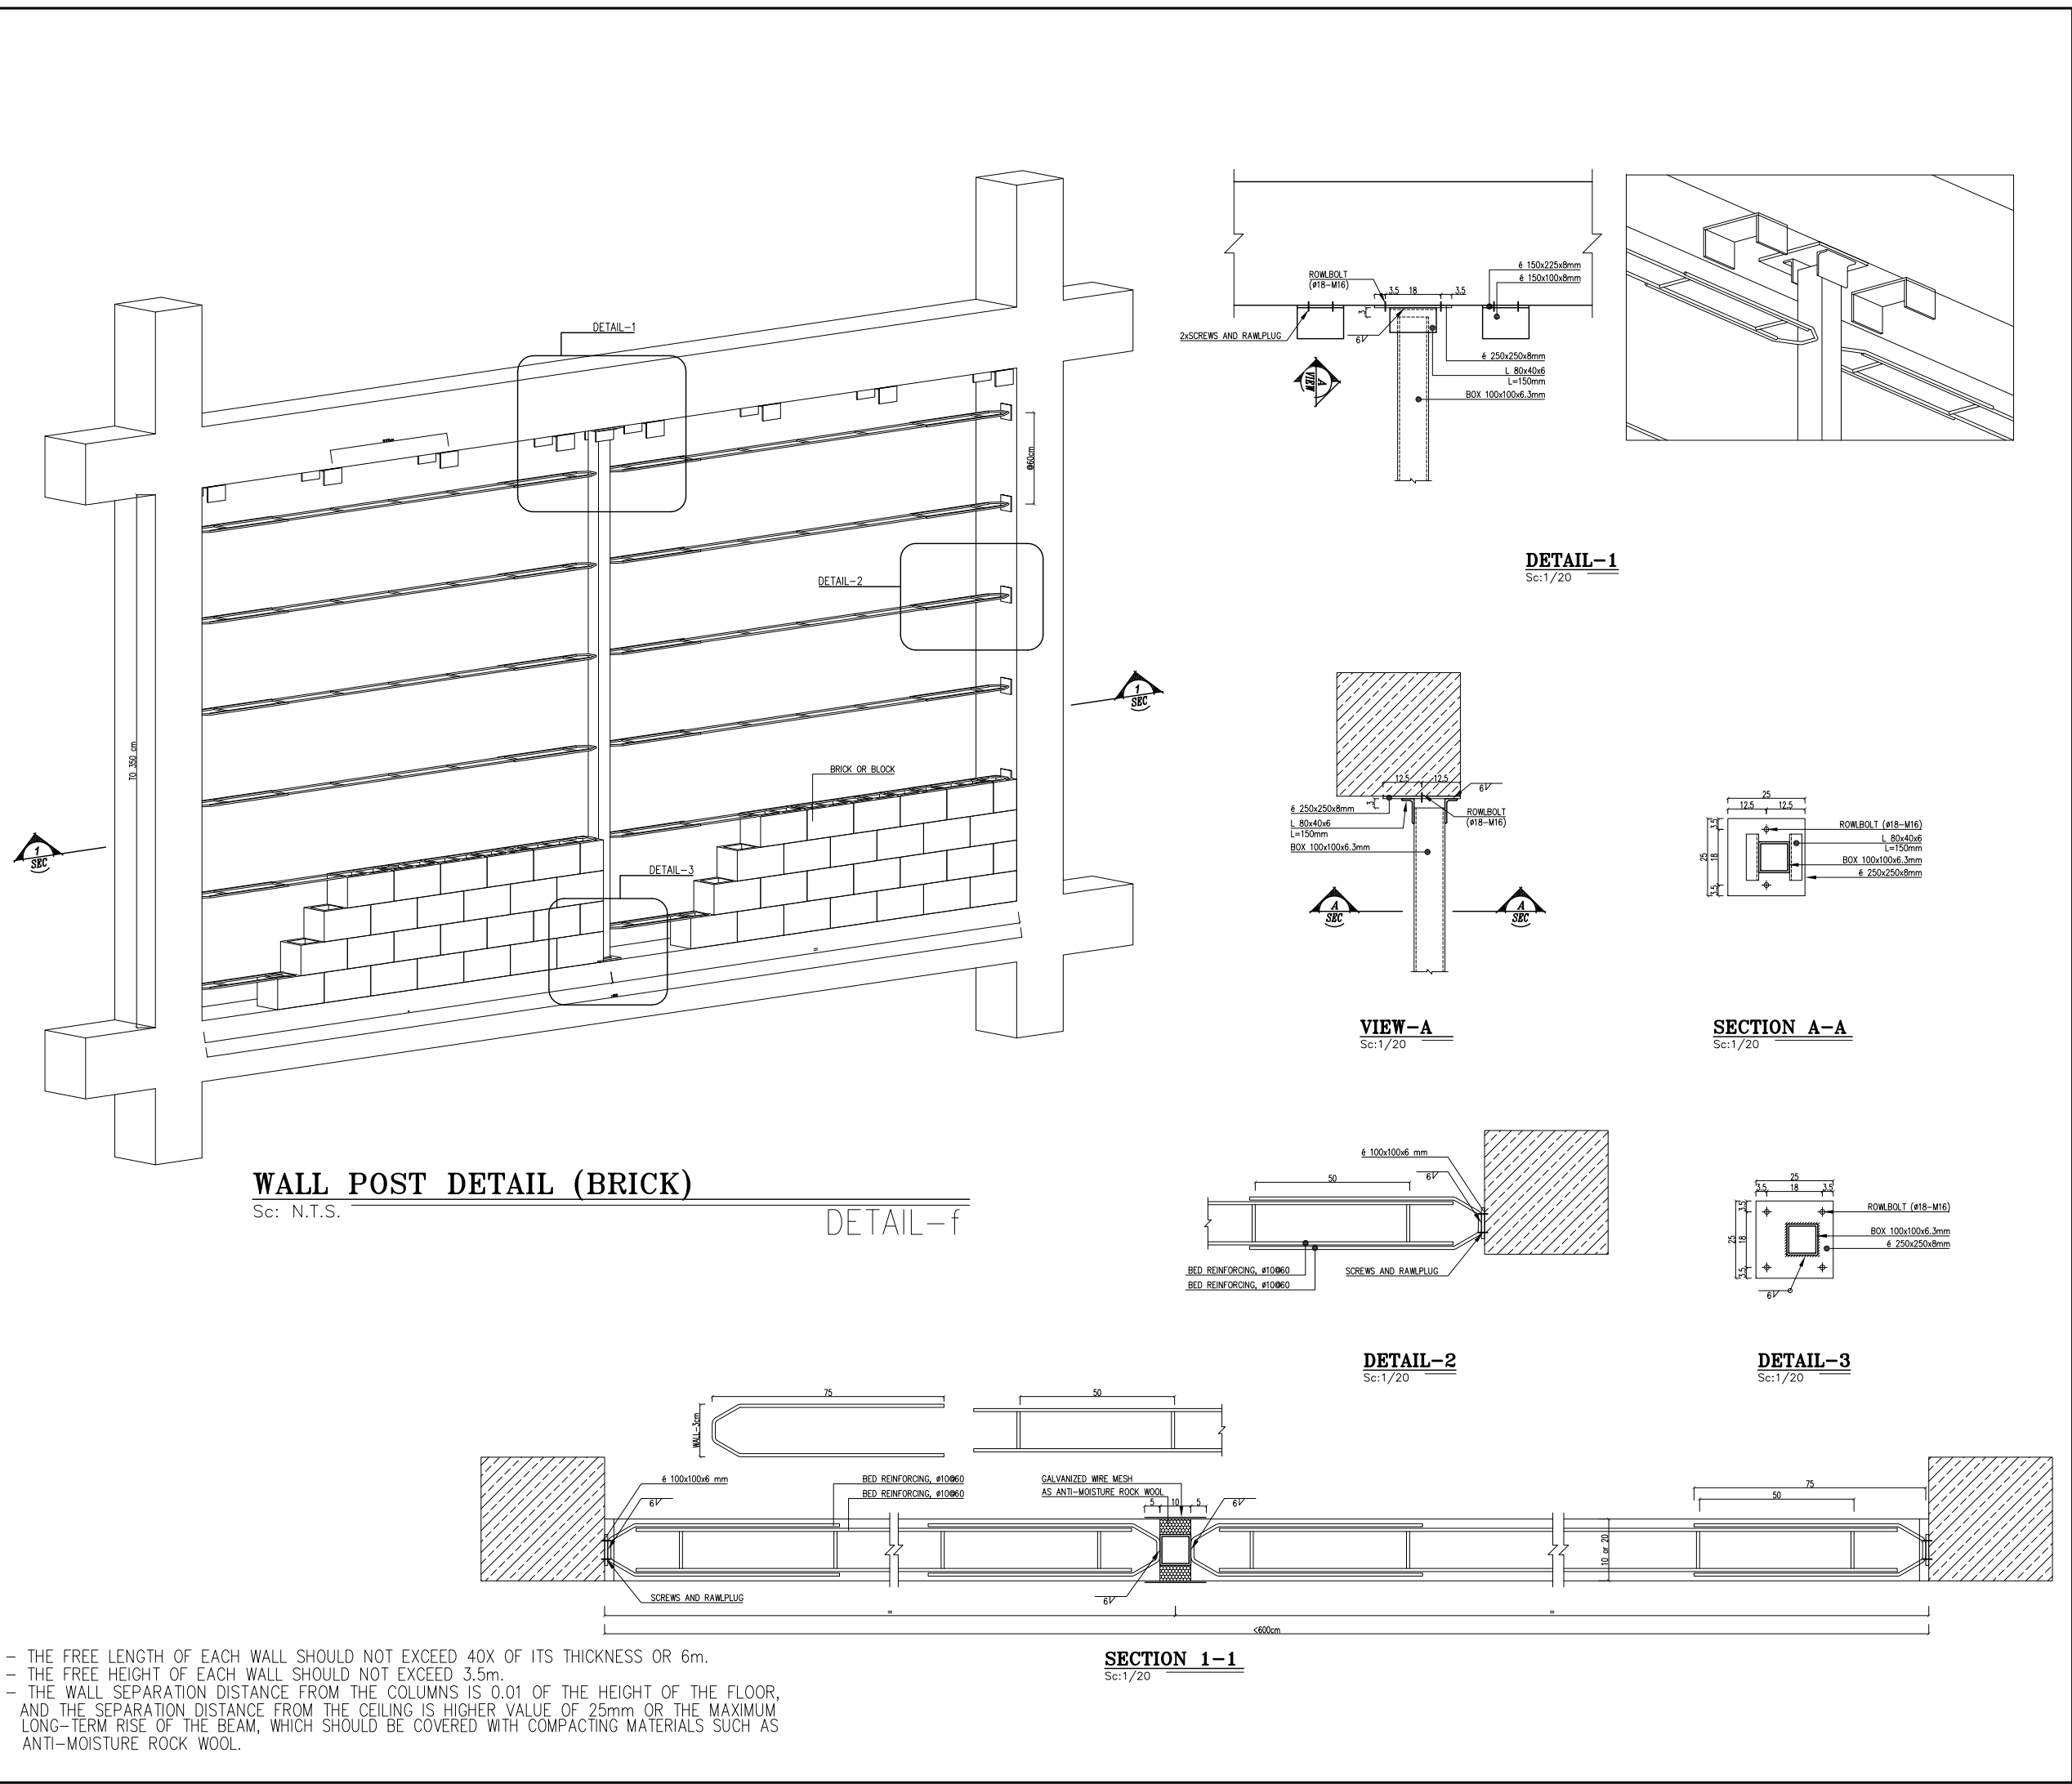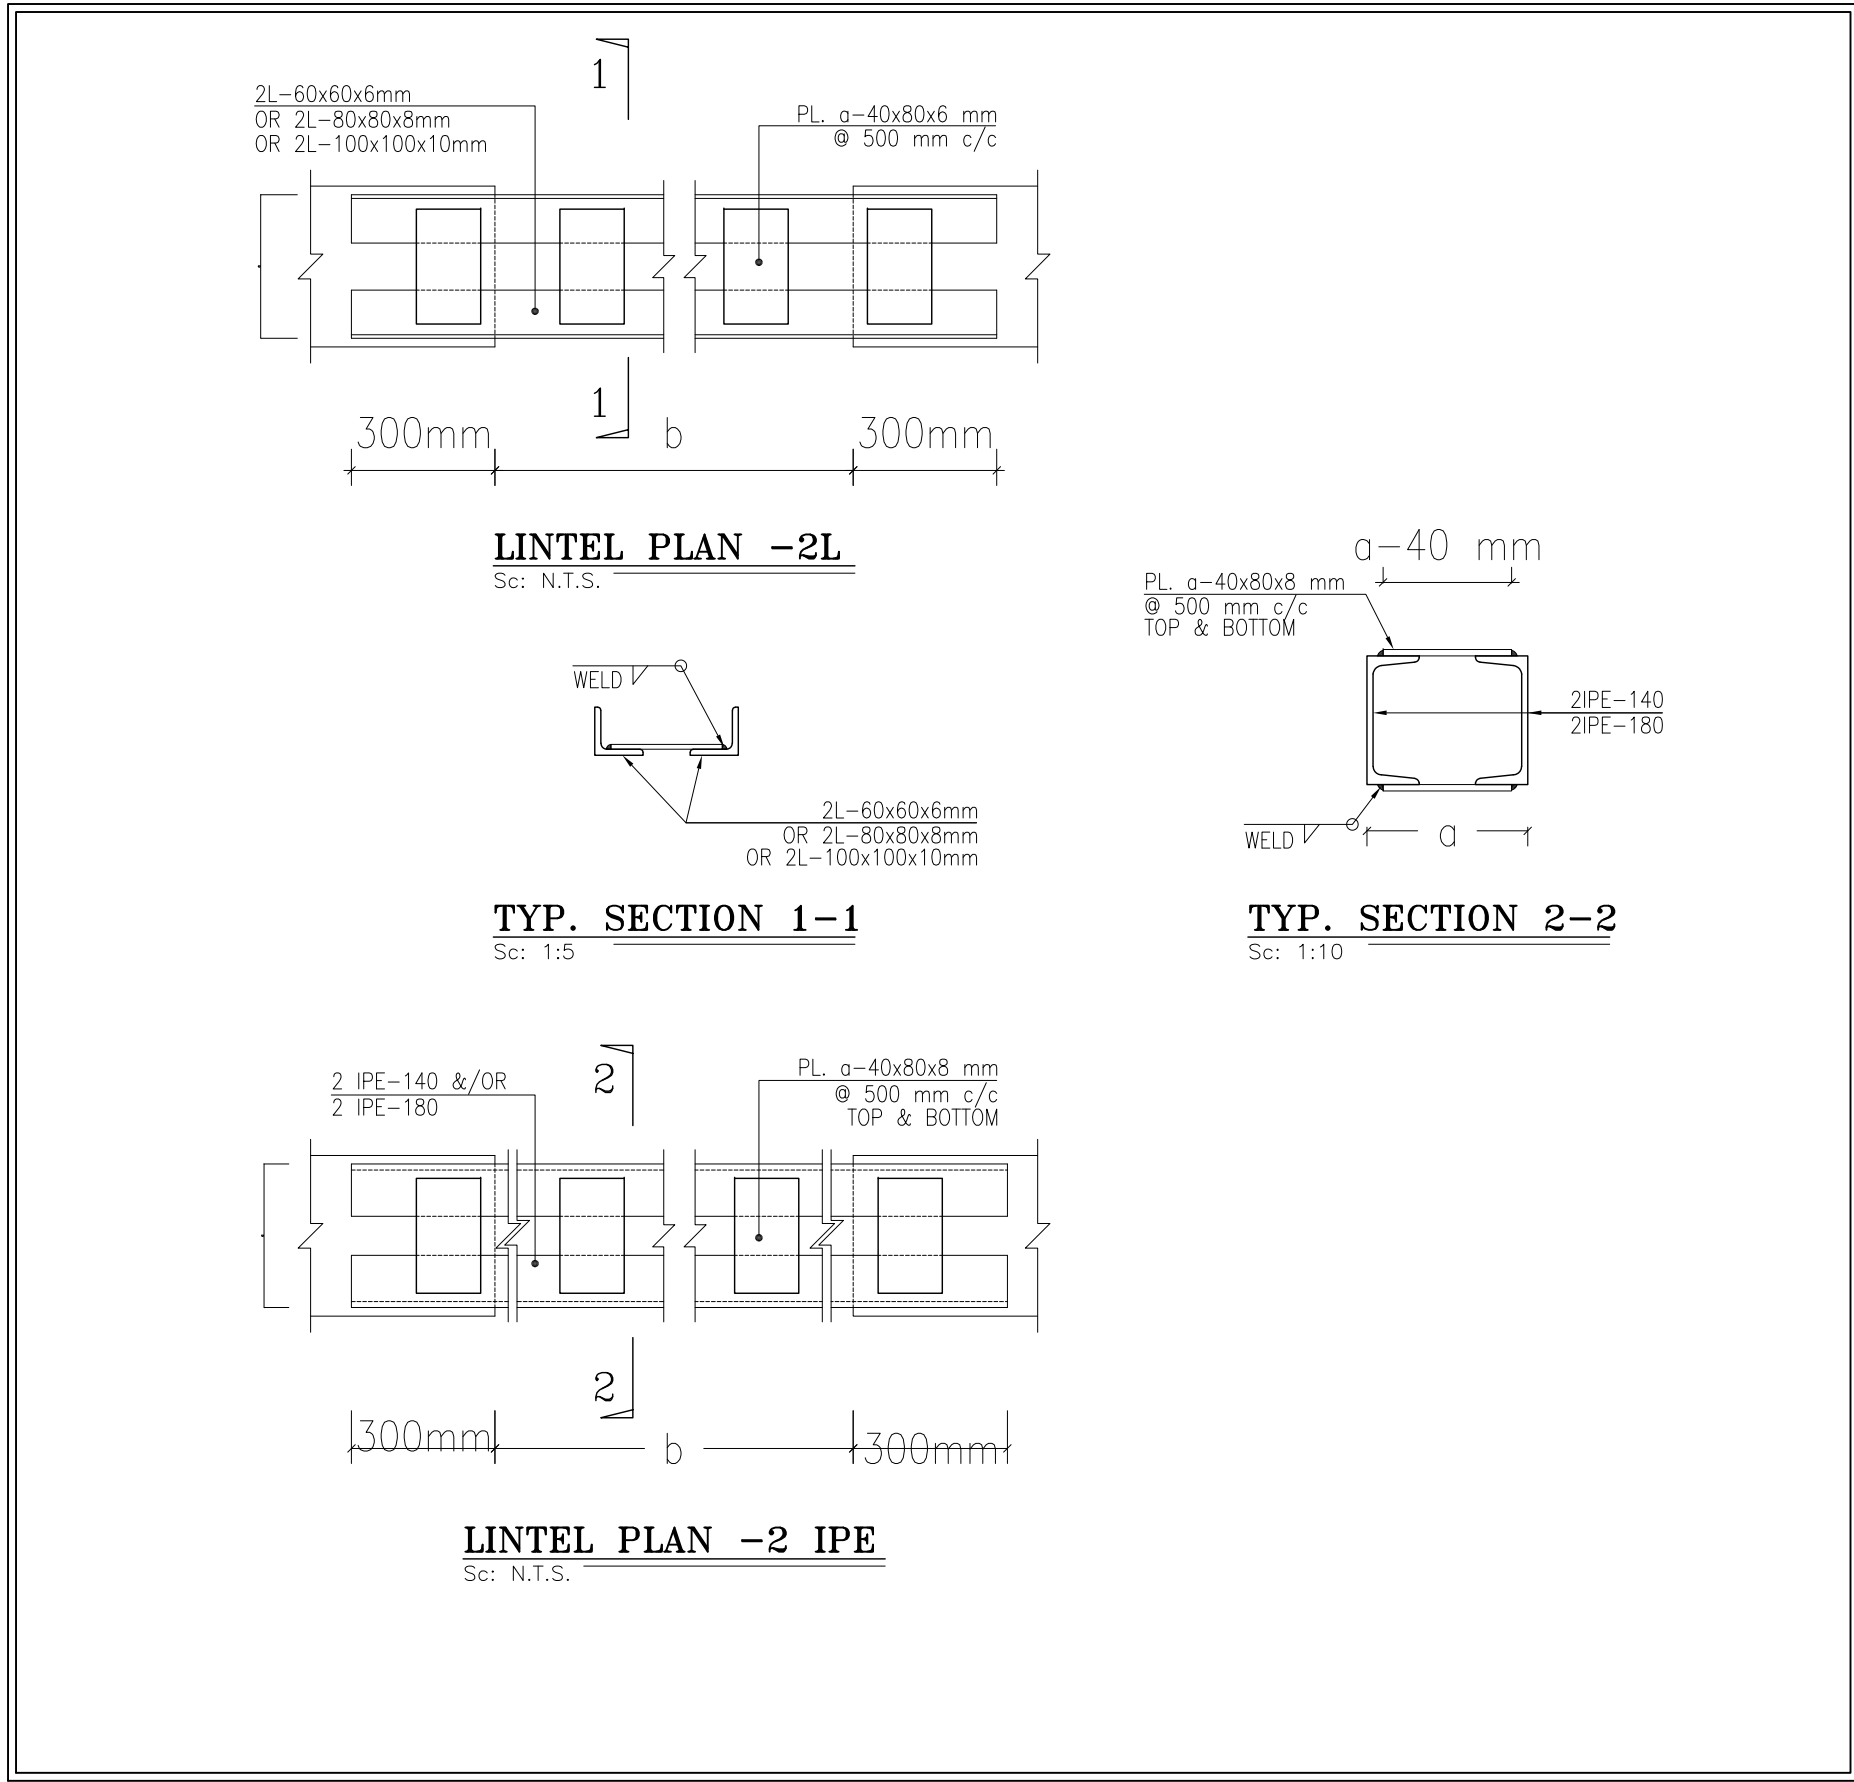



- NOTES
1. ALL DIMENSIONS ARE IN CENTIMETER & ALL ELEVATIONS ARE IN METER.
 2. ALL DIMENSIONS AND ELEVATIONS SHALL BE CHECKED BY THE CONTRACTOR PRIOR TO CONSTRUCTION.
 3. CONTRACTOR SHALL COMPLY ALL ARCHITECTURAL, MECHANICAL, ELECTRICAL, PIPING AND STRUCTURAL DRAWINGS AND IN CASE OF ANY CONFLICTS OR DISCREPANCY, INFORM THE ENGINEER.
 4. ALL MATERIALS ARE SELECTED FROM THE HIGHEST QUALITY AND MUST BE APPROVED BY THE CLIENT.
 5. ALL CRACKS FOR PIPING/DRAINING AND HVAC DRAINAGE SHALL BE CONSIDERED AS PER RELATED DRAWINGS BEFORE CONSTRUCTION.
 6. ALL INTERNAL SLOPES FOR FLOOR DRAINS ARE 1% UNLESS STATED.
 7. KNAUF BOARDS SHALL BE "M" IN MOST SPACES AND TYP IN HEAT ZONES.
 8. FINISH GRADING LEVEL (T.G.L.) = ±1.20 (W.S.L.) = ±0.00 (LOCAL).
 9. ALL WBS ARE EQUIPPED WITH HAND-WASH-HOT AIR-BLOWER/ELECTRICAL SOAP DISPENSER WITH ABS DOORS(WITH CLOSER MECHANISM).
 10. ACCORDING TO SPECIFICATION FOR BUILDINGS INTERIOR PAINTING FOR MASONRY, CONCRETE, PLASTER, GYPSUM WALL BOARD (PAINT).
 11. ALL BLASTPROOF DOORS ARE PANIC DOORS -- PANIC BARS ARE REQUIRED.
 12. BATTERY ROOM SHALL BE EQUIPPED WITH EXPLOSION-PROOF,FAN,LIGHTING,SWITCHES,OUTLETS ETC.

LEGEND

F.F.L.	FINISHED FLOOR	W.D	WOOD DOOR
T.O.WA	TOP OF WALKWAY	T.O.D.	TOP OF DOOR
T.O.R.	TOP OF ROOF	F.G.L.	FINISH GRADING LEVEL
T.O.P.	TOP OF PARAPET	B.P.D.	BLAST-PROOF DOOR
T.O.FOU.	TOP OF FOUNDATION	B.O.Cg.	BOTTOM OF LADDER CAGE
AL.D.	ALUMINIUM DOOR	T.O.Cg.	TOP OF LADDER CAGE
M.D.	METAL DOOR		

REFERENCE DRAWING	DRG. No.
Standard Details For Ladder & Safety Cage	BK-GNRL-PEDCO-000-ST-DW-0009
FOUNDATION DRAWING FOR CONTROL BUILDING	BK-GCS-PEDCO-120-ST-DW-0061
STRUCTURAL DRAWING FOR CONTROL BUILDING	BK-GCS-PEDCO-120-ST-DW-0062
ROAD, PAVING AND PLANT FINISH GRADING LAYOUT & SECTIONS	BK-GCS-PEDCO-120-CV-PY-0005
CABLE TRENCH AND DUCT BANK LAYOUT	BK-GCS-PEDCO-120-CV-PY-0002
ELECTRICAL CABLE ROUTE & SECTION LAYOUT FOR BUILDING & SHELTER	BK-GCS-PEDCO-120-EL-PY-0006
CONTROL ROOM LAYOUT & ARRANGEMENT DRAWING	BK-GCS-PEDCO-120-IN-PY-0001
PLUMBING & SEWAGE PIPING LAYOUT FOR CONTROL BUILDING	BK-GCS-PEDCO-120-HV-PY-0001
HVAC ROOM LAYOUT & SECTION FOR CONTROL BUILDING	BK-GCS-PEDCO-120-HV-PY-0002
HVAC SYSTEM DUCT PLAN FOR CONTROL BUILDING	BK-GCS-PEDCO-120-HV-PY-0003
HVAC SYSTEM ROOF LAYOUT FOR CONTROL BUILDING	BK-GCS-PEDCO-120-HV-PY-0004

KEY PLAN

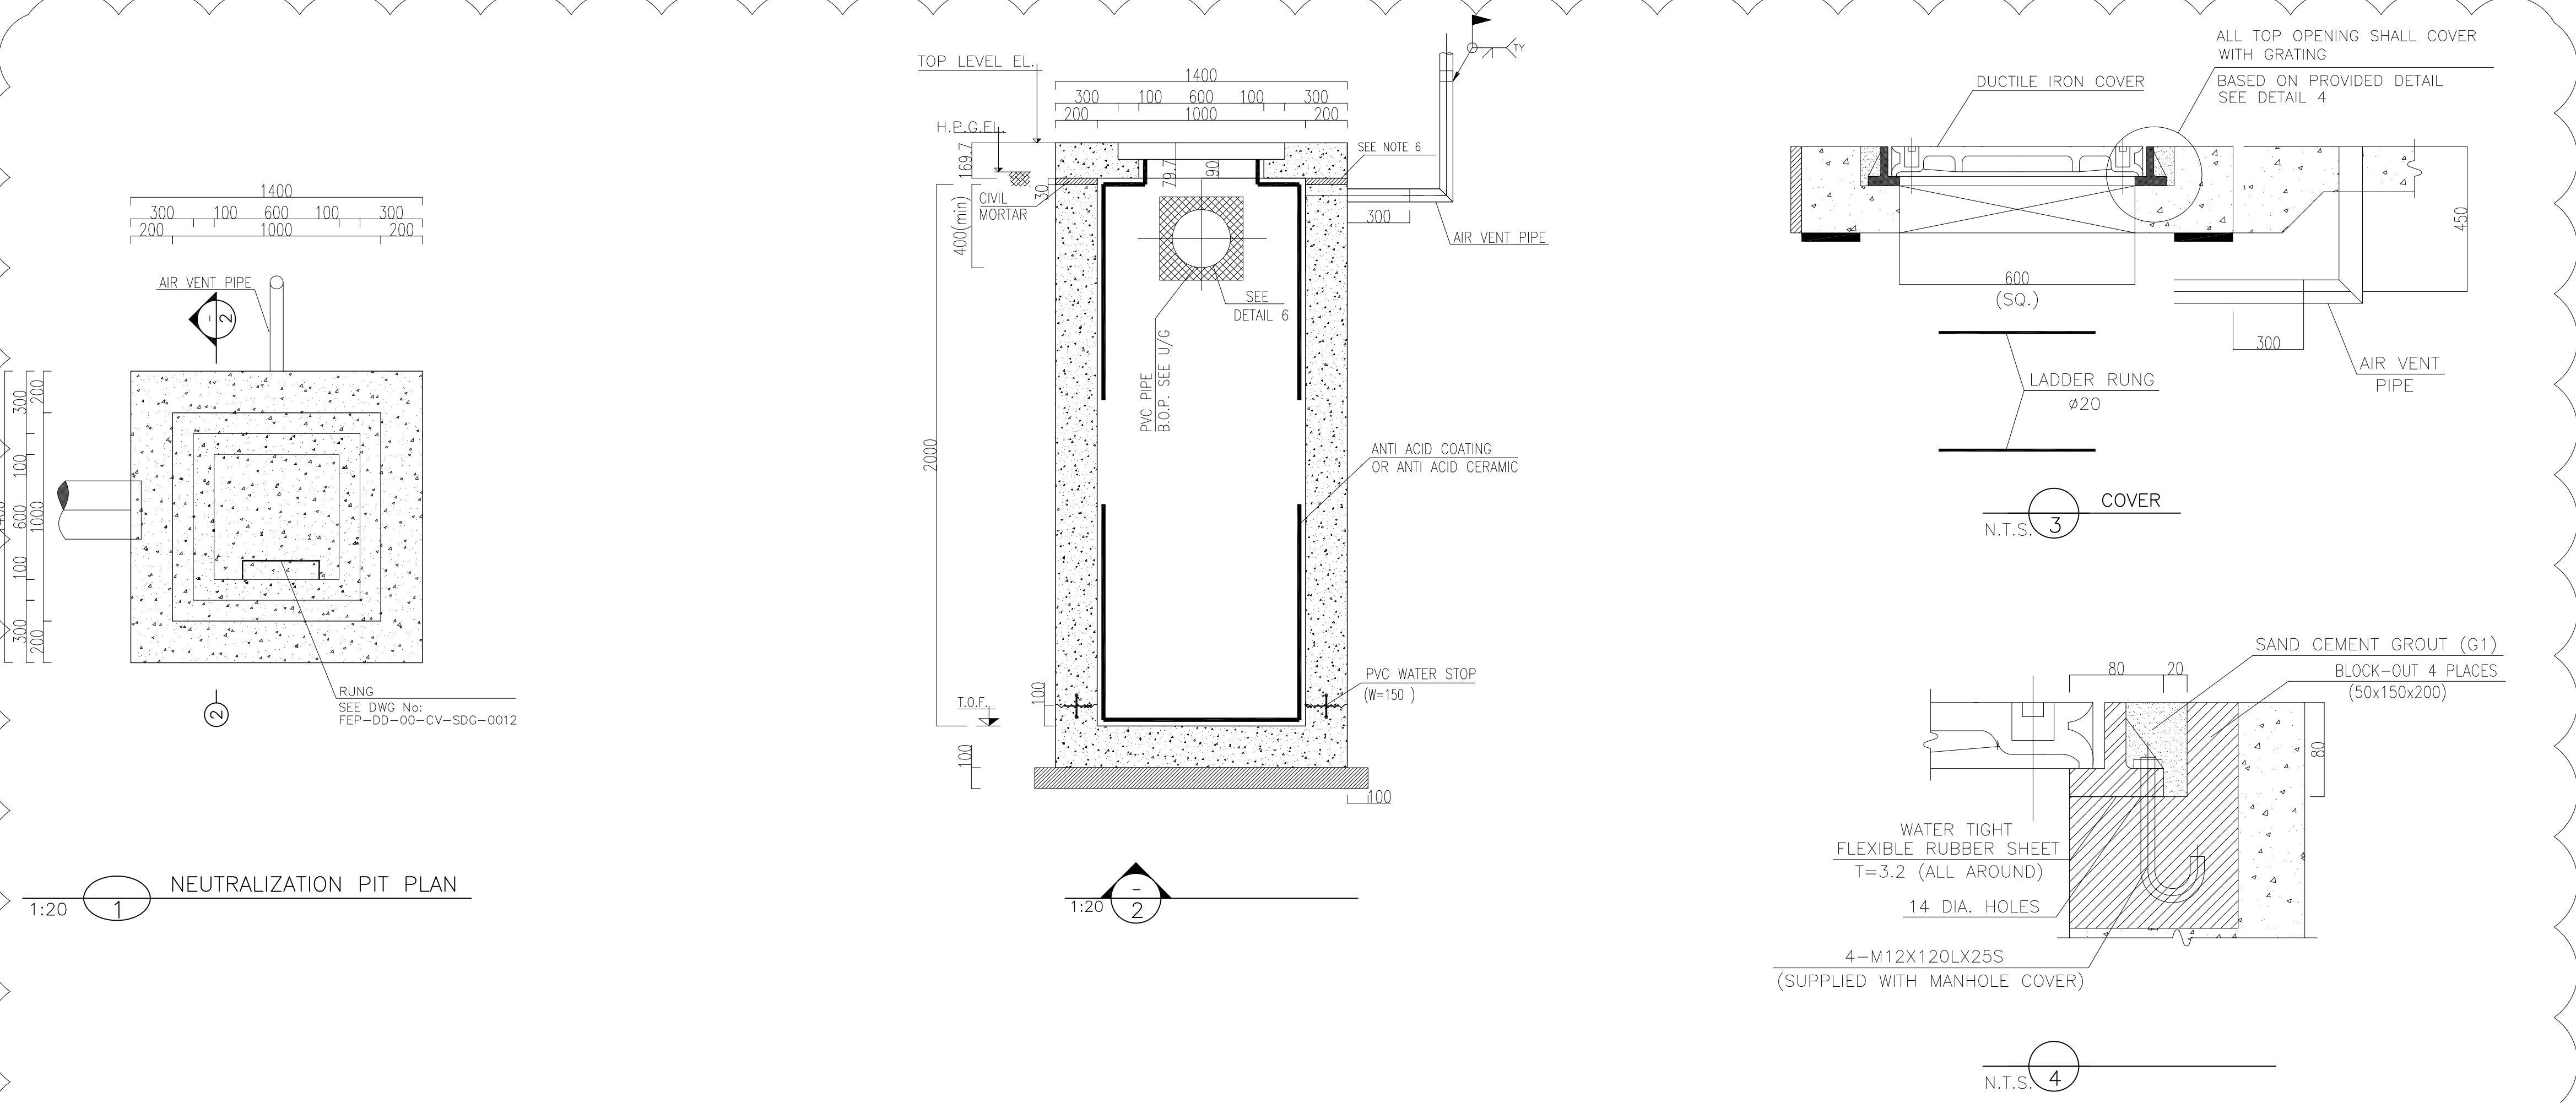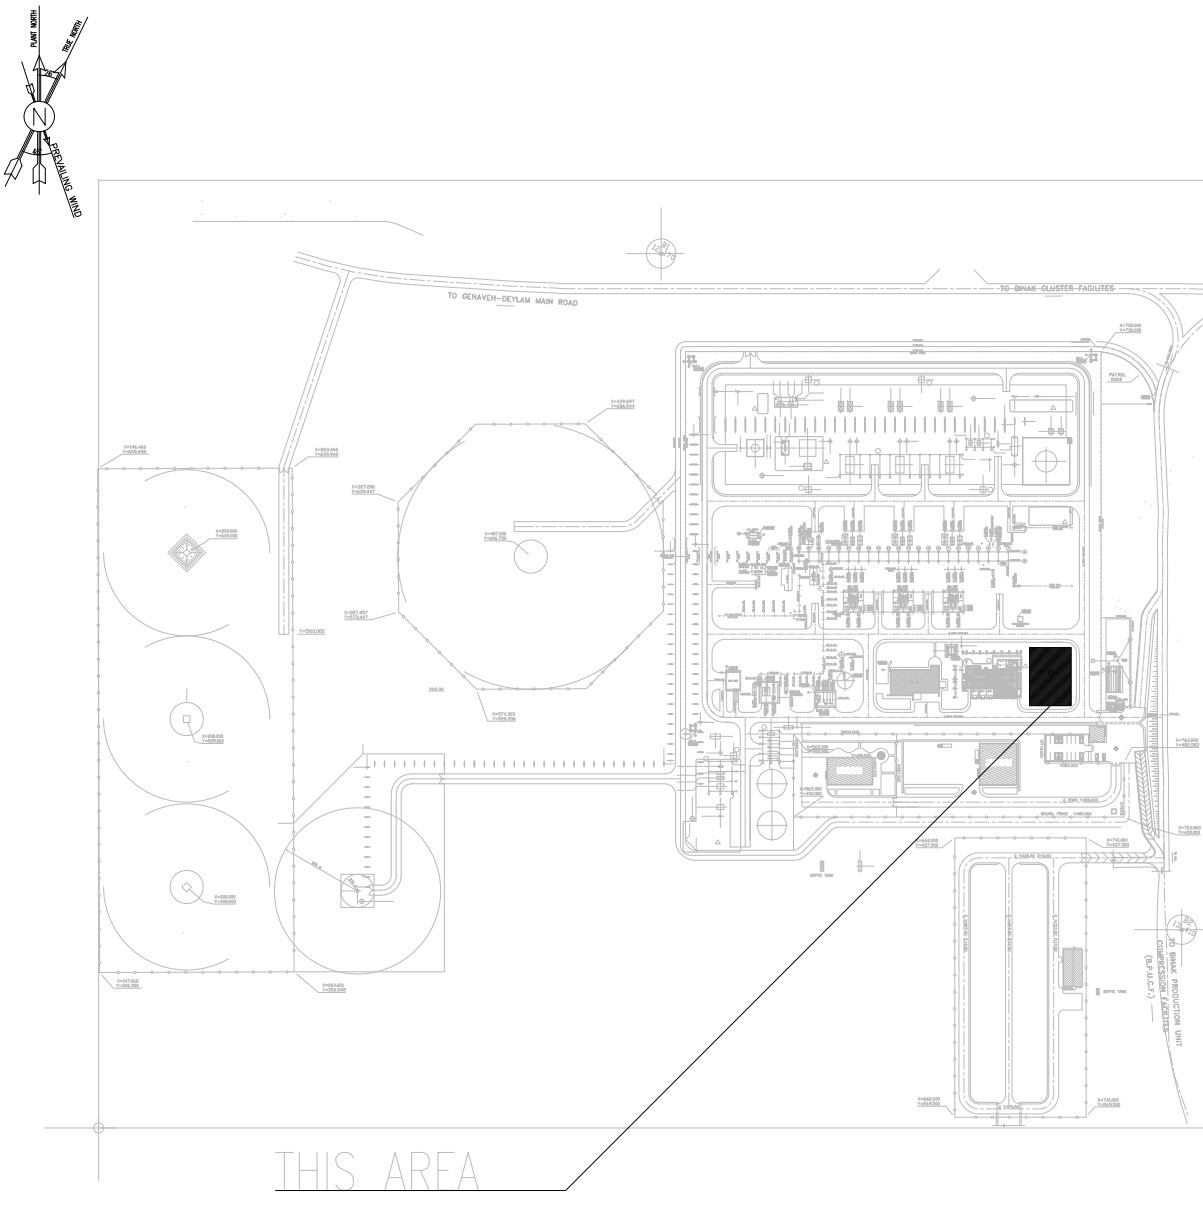

BATTERY ROOM TANK DETAIL

Sc:1/20

DETAIL-4

D05	JAN. 2023	IFA	R.BERLOUIE	M.PAKHARIAN	M.Mehrshad	***
D04	OCT. 2022	IFA	R.BERLOUIE	M.PAKHARIAN	M.Mehrshad	***
D03	AUG. 2022	IFA	R.BERLOUIE	M.PAKHARIAN	M.Mehrshad	***
D02	MAR. 2022	IPC	R.BERLOUIE	M.PAKHARIAN	M.Mehrshad	***
D01	JAN. 2022	IPC	R.BERLOUIE	M.PAKHARIAN	M.Mehrshad	***
D00	DEC. 2021	IPC	R.BERLOUIE	M.PAKHARIAN	M.Mehrshad	***
REV.	DATE	P.O.I.S	PREP.	CHK.	APP.	AUT.

PROJECT NAME: BINAK OILFIELD DEVELOPMENT/SURFACE FACILITIES GAS COMPRESSOR STATION

PROJECT NO.: 971020

EPC CONTRACTOR:	EPD/EPC CONTRACTOR (GC):
 HIRGAN ENERGY - DESIGN & INSPECTION COMPANIES	 PETROIRAN DEVELOPMENT COMPANY

DRAWING TITLE: ARCHITECTURAL DETAIL DRAWING FOR CONTROL BUILDING DETAILS AND FINISHING SCHEDULE


SCALE	SIZE	DRAWING NO.	SHEET NO.	REV.
AS SHOWN	A0	BK-GCS-PEDCO-120-AR-DW-0001	10 OF 12	D05

THE ORIGINAL AND ALL COPIES OF THIS DRAWING TOGETHER WITH THE COPYRIGHT THEREIN ARE THE SOLE PROPERTY OF N.I.S.O.C./ FIELDS


DATE	SCALE	DRAWING BY	CHECKED BY	PROJECT ENG.

NO CONSTRUCTION PERMITTED UNLESS DRAWING APPROVED


APPROVED FOR CONSTRUCTION	BY:	DATE:
BUDGET REF.	LOCATION	SIZE CLASS
SERIAL NO.	SHEET	REVISION
053-073-9184	F	4
B	709099	10 OF 12
D05		

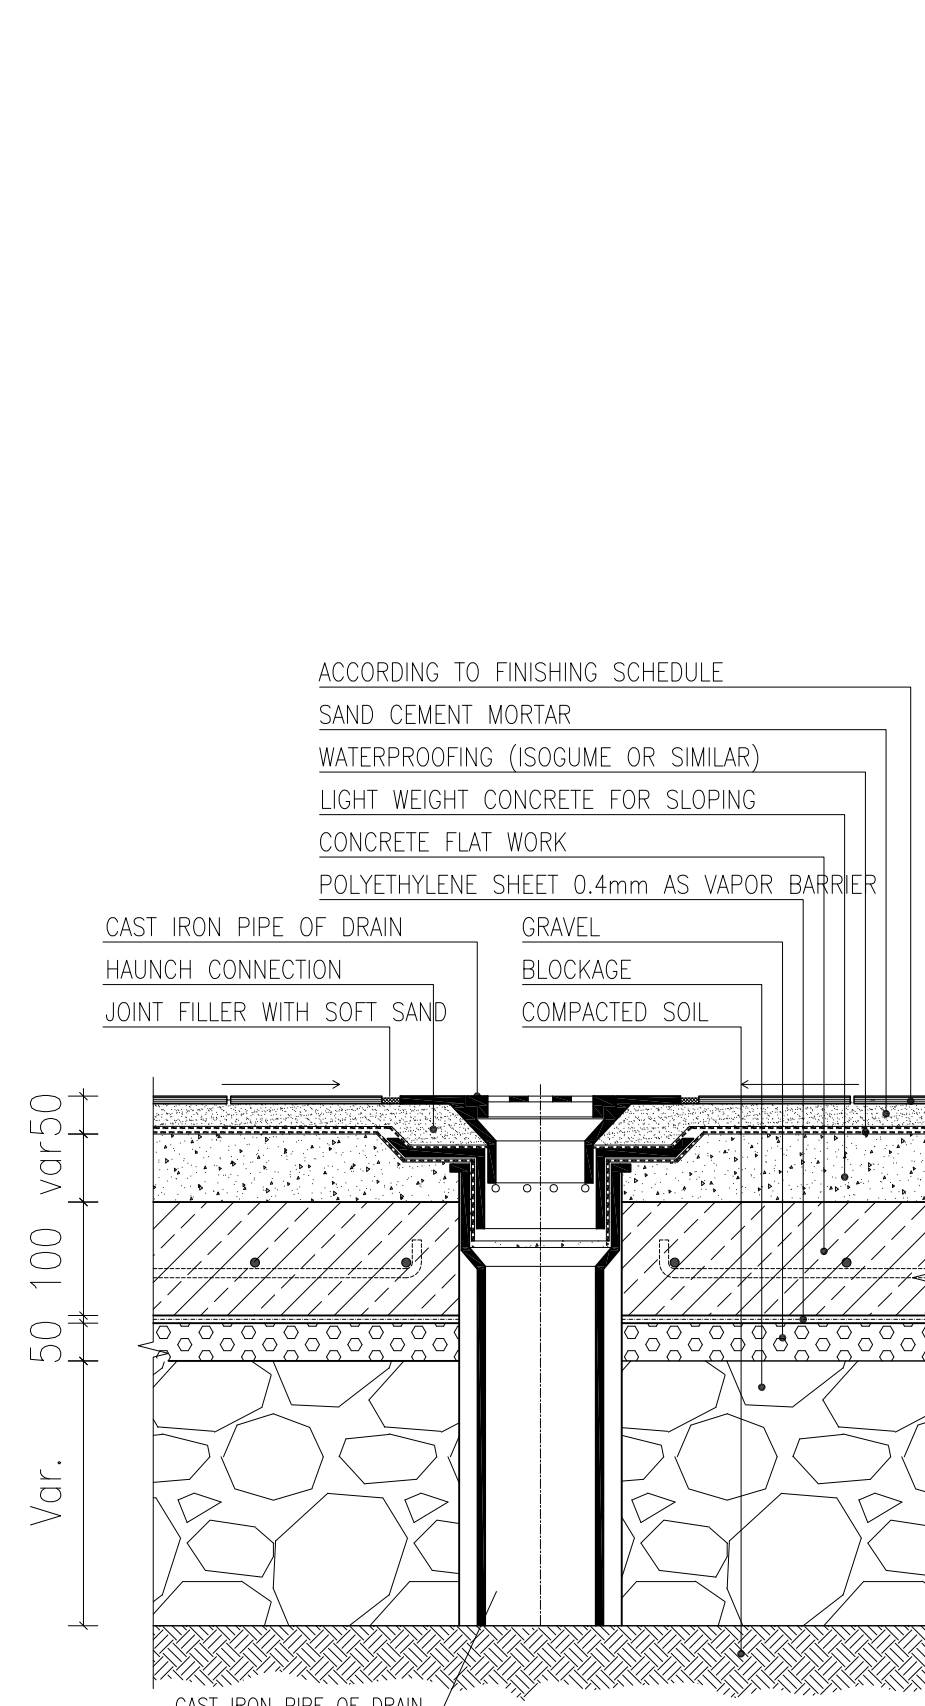


DRAIN DETAIL (GROUND FLOORS)
Sc:1/20 DETAIL-5

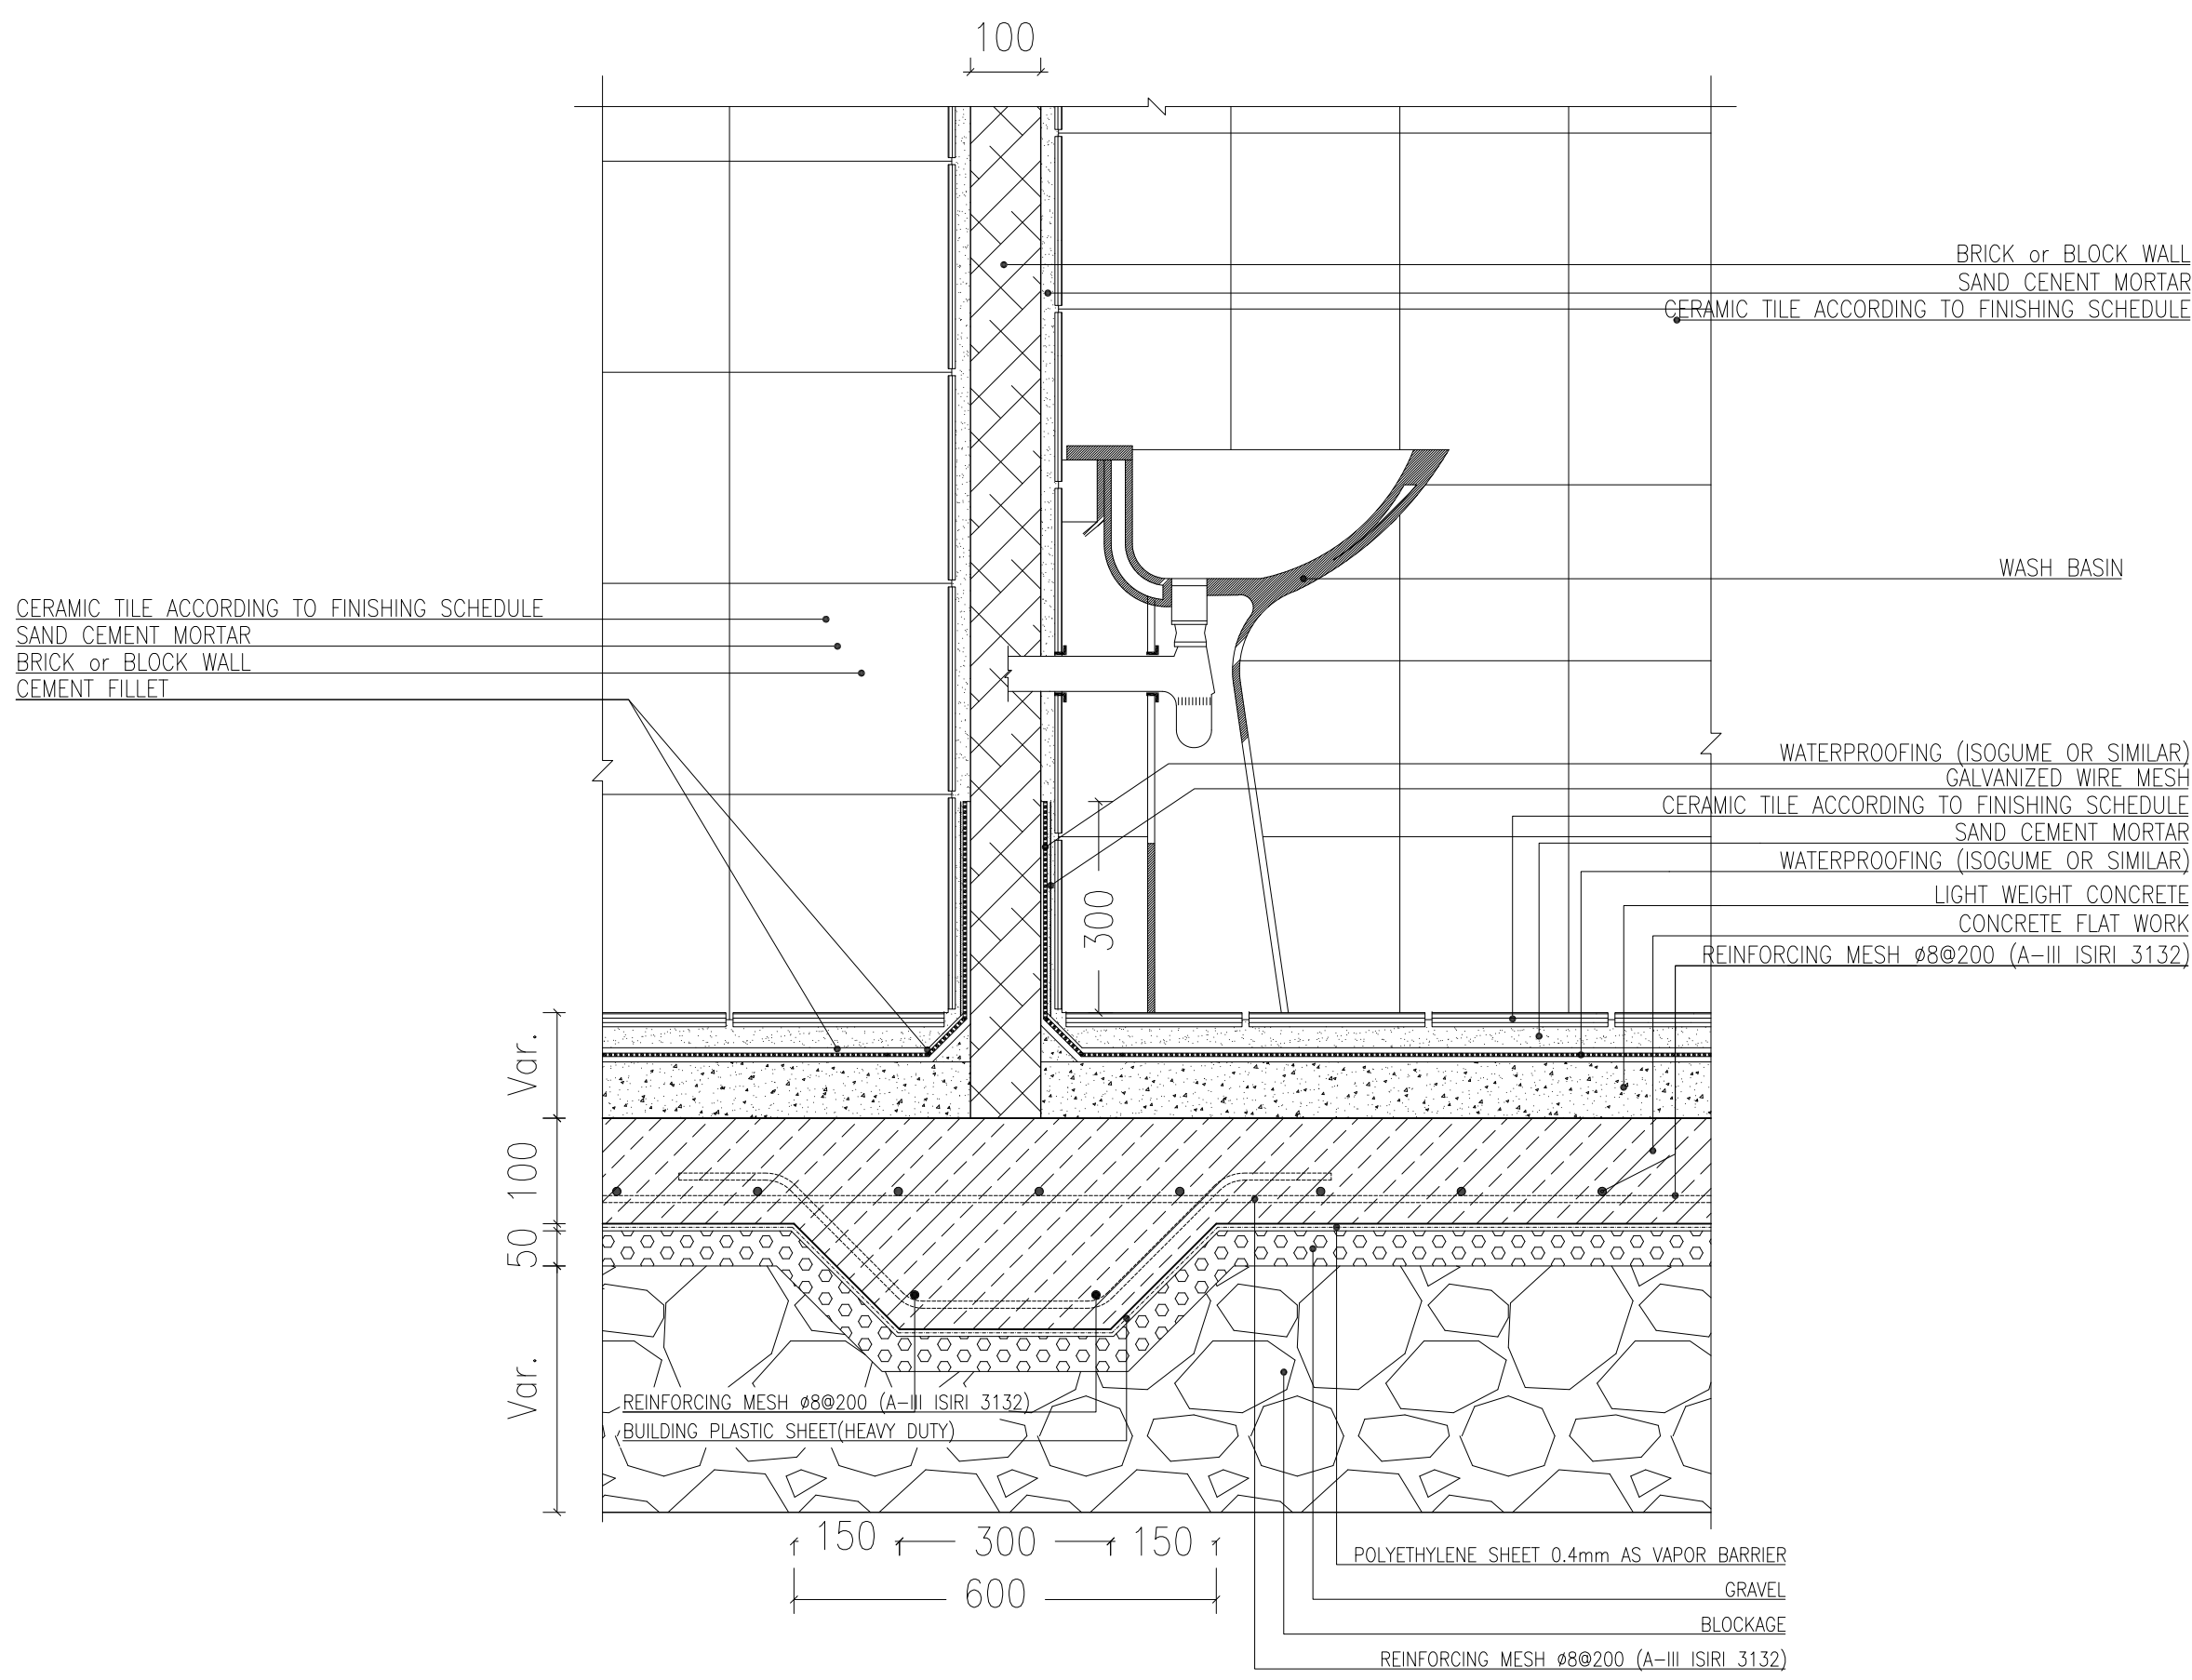


BASIN INSTALATION DETAIL
Sc:1/20 DETAIL-6

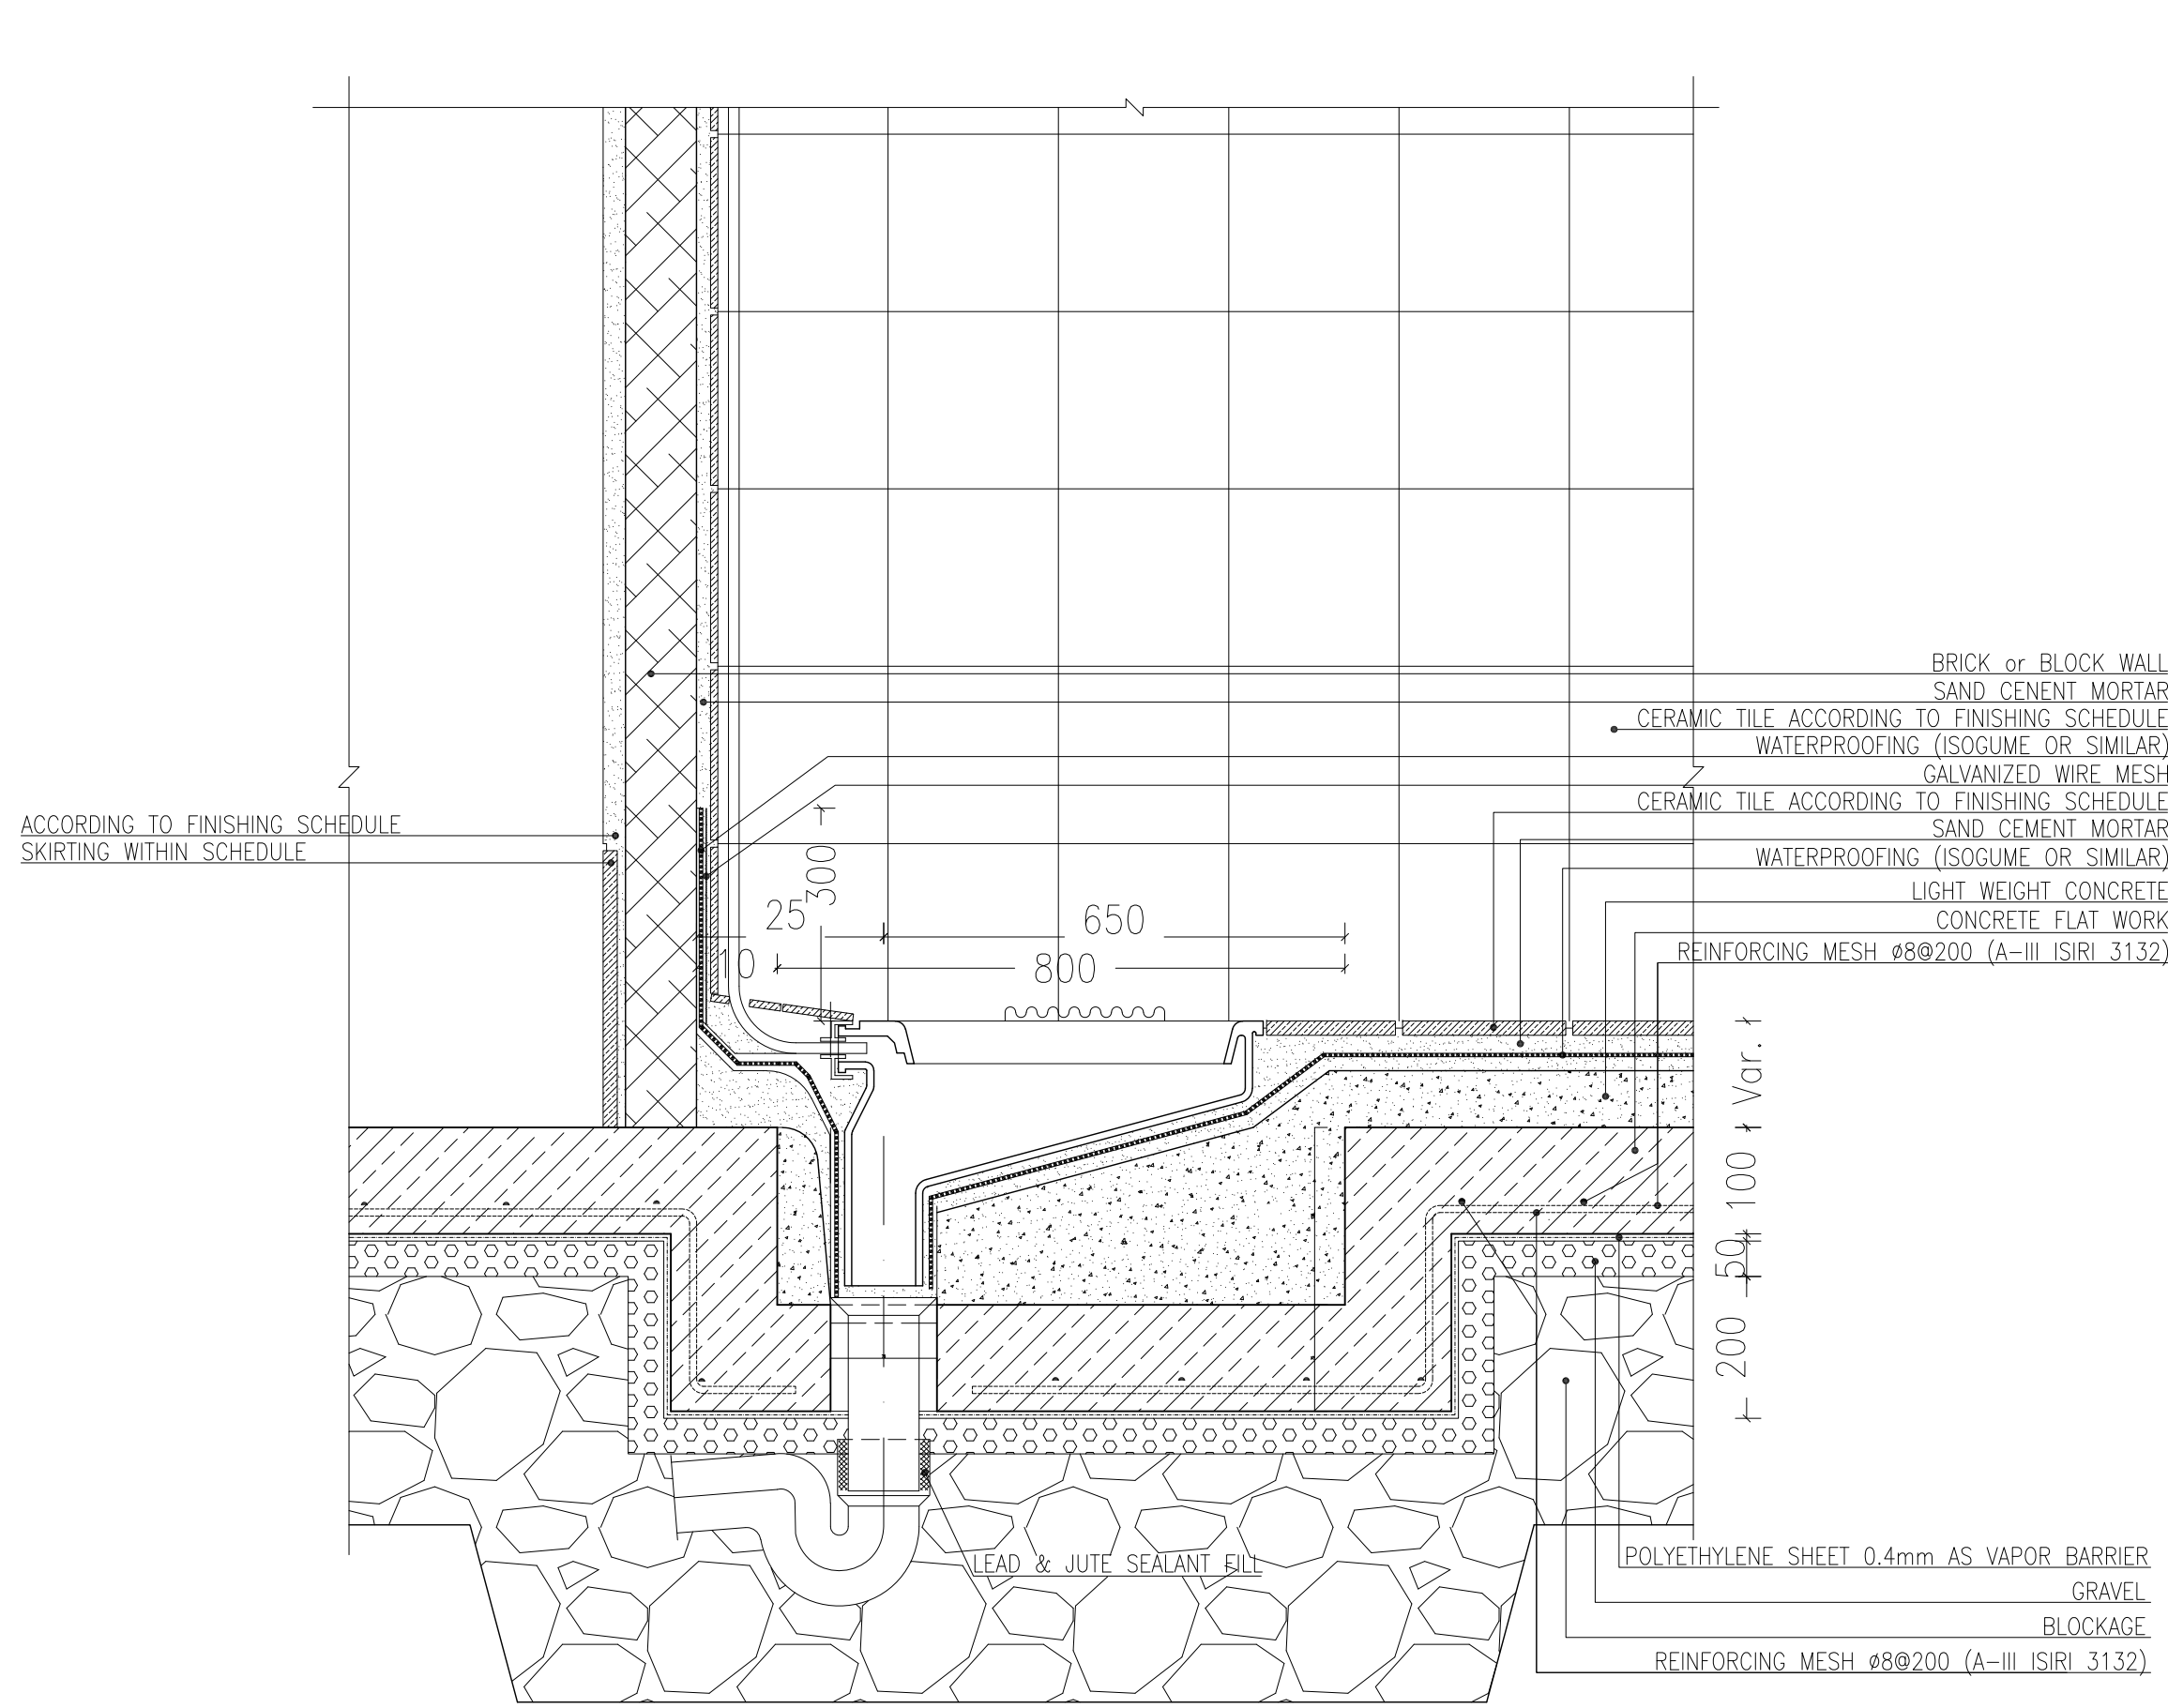


TOILET BOWL INSTALATION DETAIL
Sc:1/20 DETAIL-7

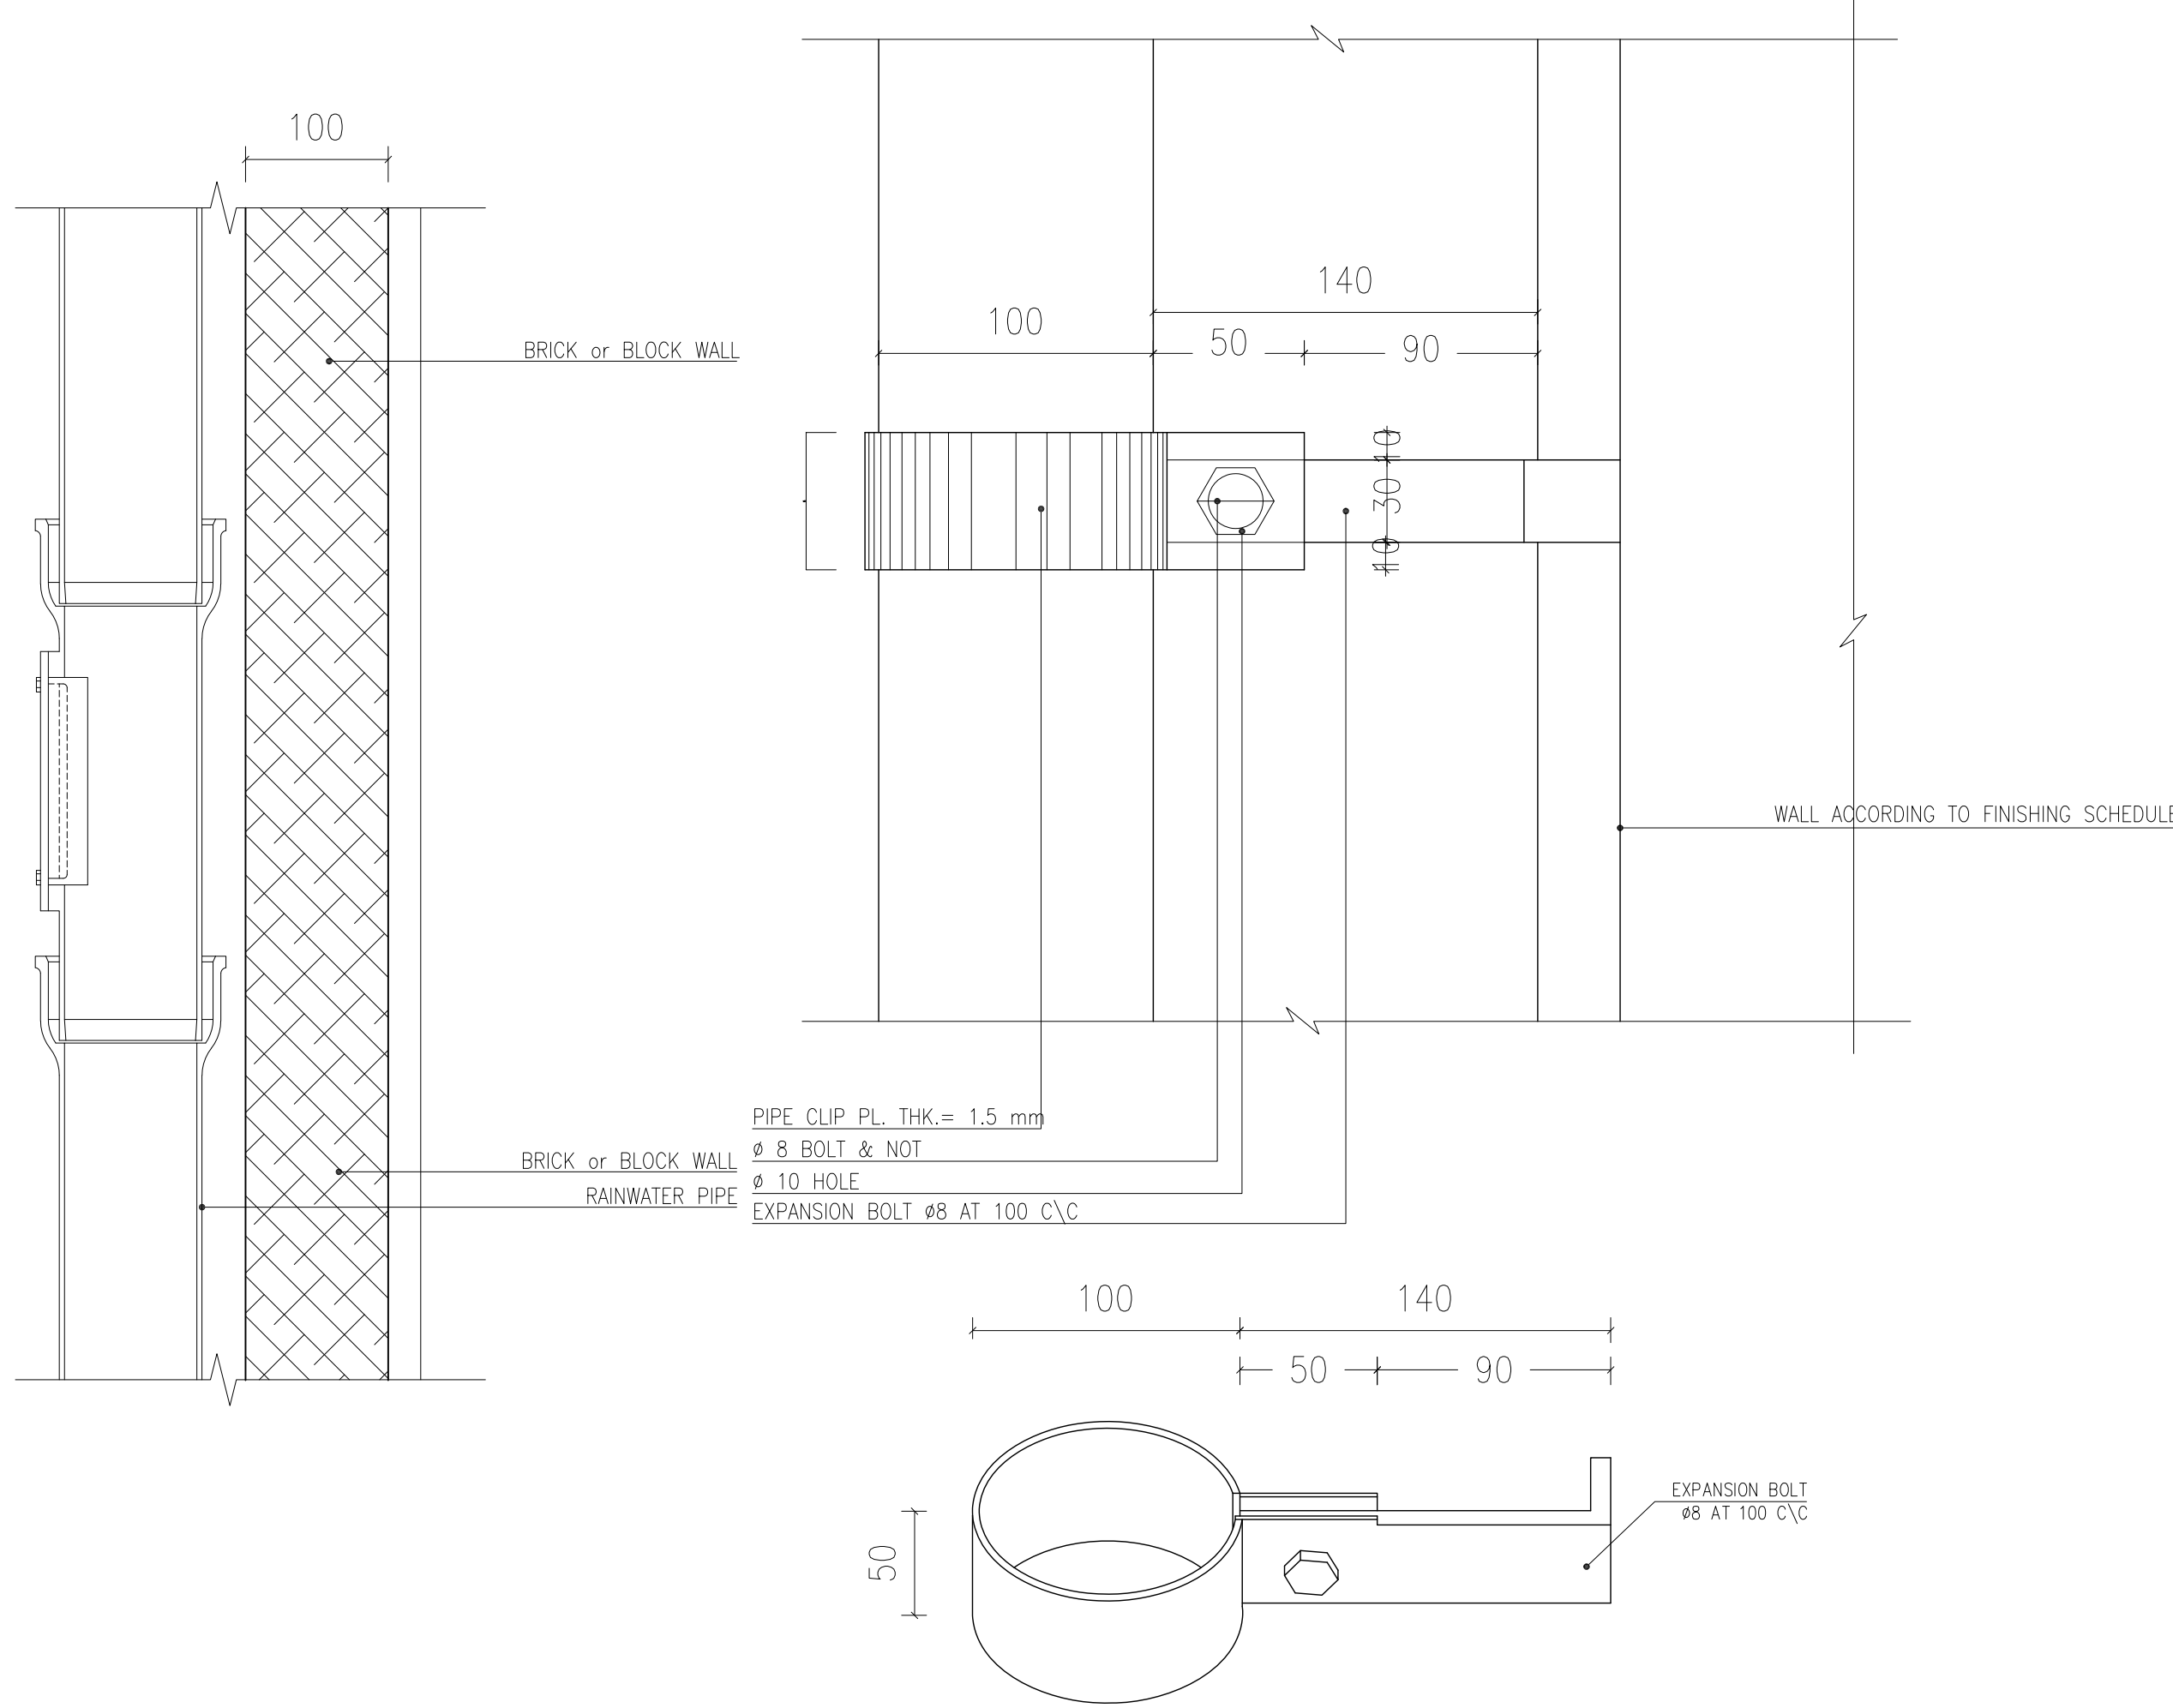

RAINWATER PIPE DETAIL
Sc:1/20 DETAIL-8

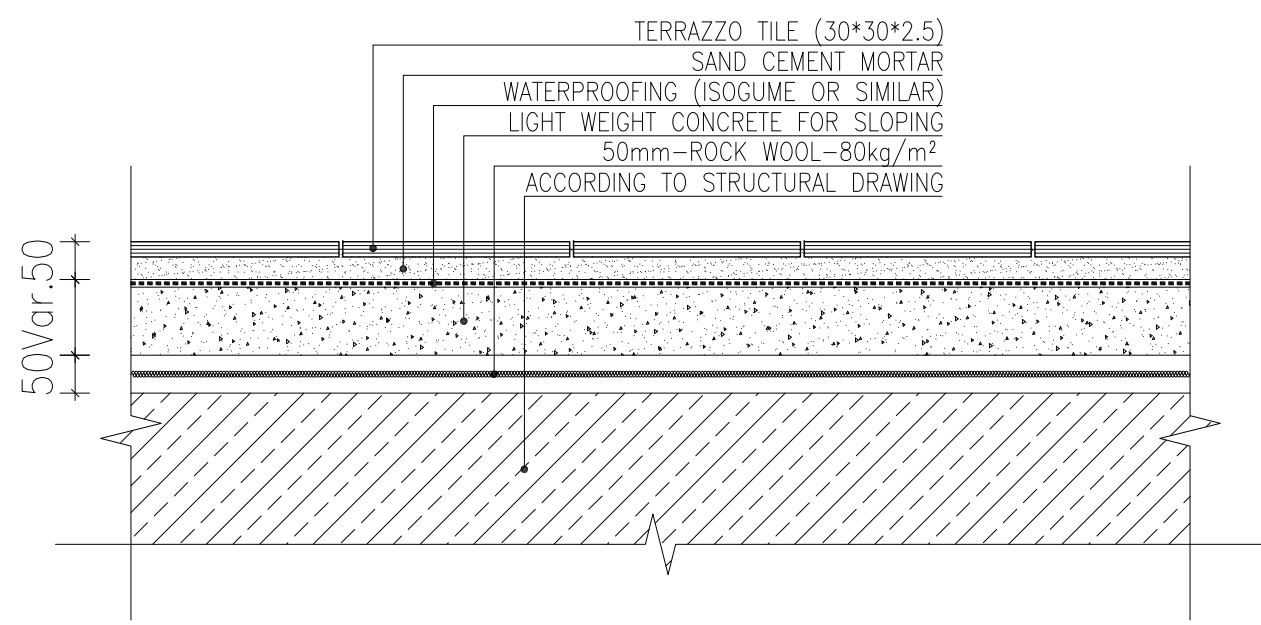

ROOF FLOOR DETAIL
Sc:1/20 DETAIL-9

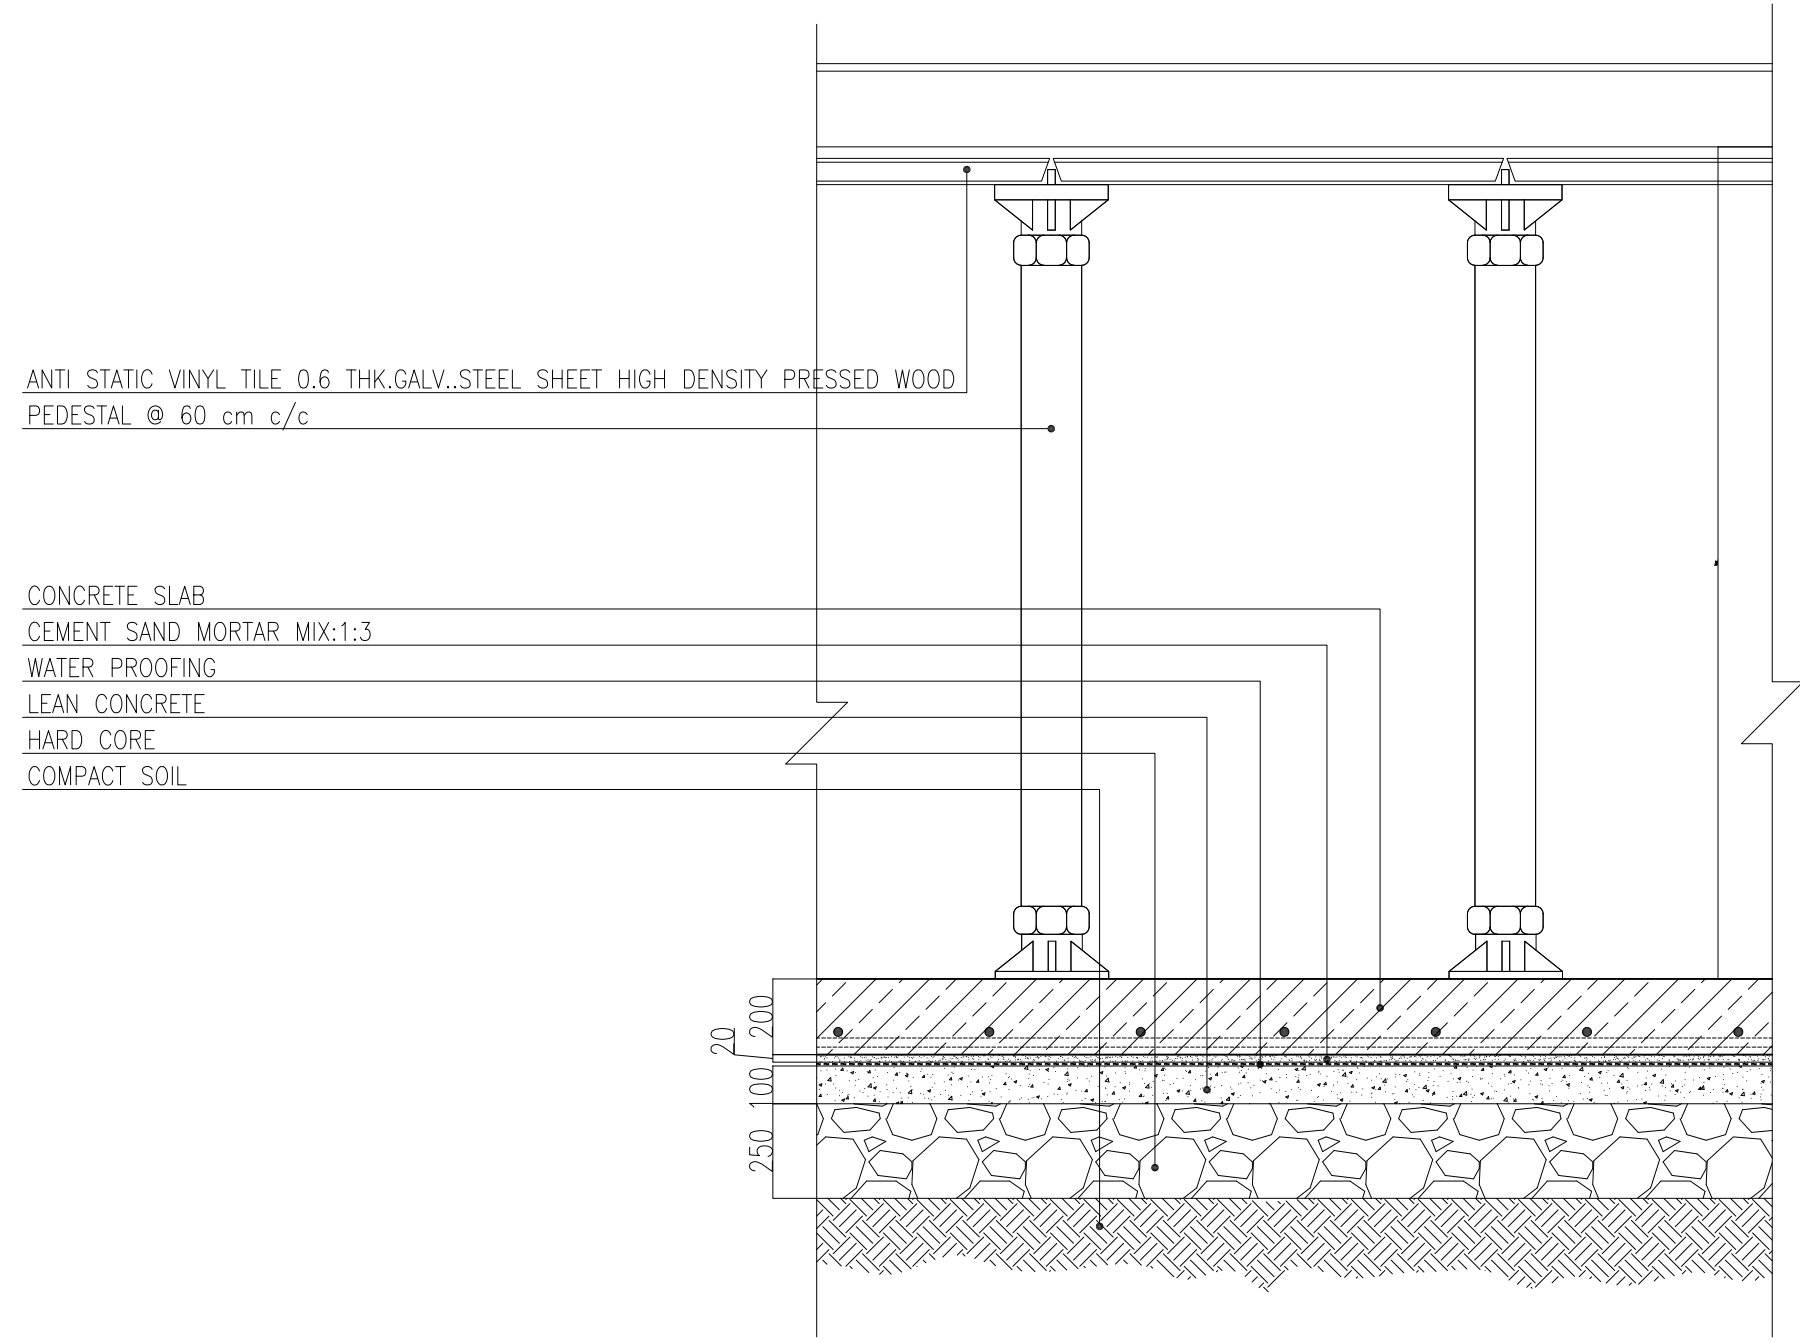

RAISED FLOOR DETAIL
Sc:1/20 DETAIL-10


- NOTES
1. ALL DIMENSIONS ARE IN CENTIMETER & ALL ELEVATIONS ARE IN METER
 2. ALL DIMENSIONS AND ELEVATIONS SHALL BE CHECKED BY THE CONTRACTOR PRIOR TO CONSTRUCTION.
 3. CONTRACTOR SHALL COMPAE ALL ARCHITECTURAL, MECHANICAL, ELECTRICAL, PIPING AND STRUCTURAL DRAWINGS AND IN CASE OF ANY CONFLICTS OR DISCREPANCY, INFORM THE ENGINEER.
 4. ALL MATERIALS ARE SELECTED FROM THE HIGHEST QUALITY AND MUST BE APPROVED BY THE CLIENT
 5. ALL CHANGES FOR PIPING/DRAINING AND HVAC DRAINAGE SHALL BE CONSIDERED AS PER RELATED DRAWINGS BEFORE CONSTRUCTION.
 6. ALL INTERNAL SLOPES FOR FLOOR DRAINS ARE 1% UNLESS STATED.
 7. KNAUF BOARDS SHALL BE "MR" IN MOST SPACES AND TYP IN HEAT ZONES
 8. FINISH GRADING LEVEL (F.G.L.) = ±11.20 (W.S.L.) = ±0.00 (LOCAL)
 9. ALL WBS ARE EQUIPPED WITH HAND-WASH-HOT AIR-BLOWER/ELECTRICAL SOAP DISPENSER WITH ABS DOORS(WITH CLOSER MECHANISM)
 10. ACCORDING TO SPECIFICATION FOR BUILDINGS INTERIOR PAINTING FOR MASONRY, CONCRETE, PLASTER, GYPSUM WALL BOARD SHALL DONE AS FOLLOW : 1st COAT, PRIMER AND SEALER, 2nd and 3rd COATS, INTERIOR PAINT SEM LUSTRE (WHITE ALKYD PAINT).
 11. ALL BLASTPROOF DOORS ARE PANIC DOORS – PANIC BARS ARE REQUIRED
 12. BATTERY ROOM SHALL BE EQUIPPED WITH EXPLOSION-PROOF,FAN,LIGHTING,SWITCHES,OUTLETS AND ETC.

LEGEND

F.F.L.	FINISHED FLOOR	W.D	WOOD DOOR
T.O.WA	TOP OF WALKWAY	T.O.D.	TOP OF DOOR
T.O.R.	TOP OF ROOF	F.G.L.	FINISH GRADING LEVEL
T.O.P.	TOP OF PARAPET	B.P.D.	BLAST-PROOF DOOR
T.O.FOU.	TOP OF FOUNDATION	B.O.Cg.	BOTTOM OF LADDER CAGE
AL.D.	ALUMINIUM DOOR	T.O.Cg.	TOP OF LADDER CAGE
M.D.	METAL DOOR		

REFERENCE DRAWING	DRG. No.
Standard Details For Ladder & Safety Cage	BK-GNRL-PEDCO-000-ST-DW-0009
FOUNDATION DRAWING FOR CONTROL BUILDING	BK-GCS-PEDCO-120-ST-DW-0061
STRUCTURAL DRAWING FOR CONTROL BUILDING	BK-GCS-PEDCO-120-ST-DW-0062
ROAD, PAVING AND PLANT FINSH GRADING LAYOUT & SECTIONS	BK-GCS-PEDCO-120-CV-PY-0005
CABLE TRENCH AND DUCT BANK LAYOUT	BK-GCS-PEDCO-120-CV-PY-0002
ELECTRICAL CABLE ROUTE & SECTION LAYOUT FOR BUILDING & SHELTER	BK-GCS-PEDCO-120-EL-PY-0006
CONTROL ROOM LAYOUT & ARRANGEMENT DRAWING	BK-GCS-PEDCO-120-IN-PY-0001
PLUMBING & SEWAGE PIPING LAYOUT FOR CONTROL BUILDING	BK-GCS-PEDCO-120-HV-PY-0001
HVAC ROOM LAYOUT & SECTION FOR CONTROL BUILDING	BK-GCS-PEDCO-120-HV-PY-0002
HVAC SYSTEM DUCT PLAN FOR CONTROL BUILDING	BK-GCS-PEDCO-120-HV-PY-0003
HVAC SYSTEM ROOF LAYOUT FOR CONTROL BUILDING	BK-GCS-PEDCO-120-HV-PY-0004

KEY PLAN

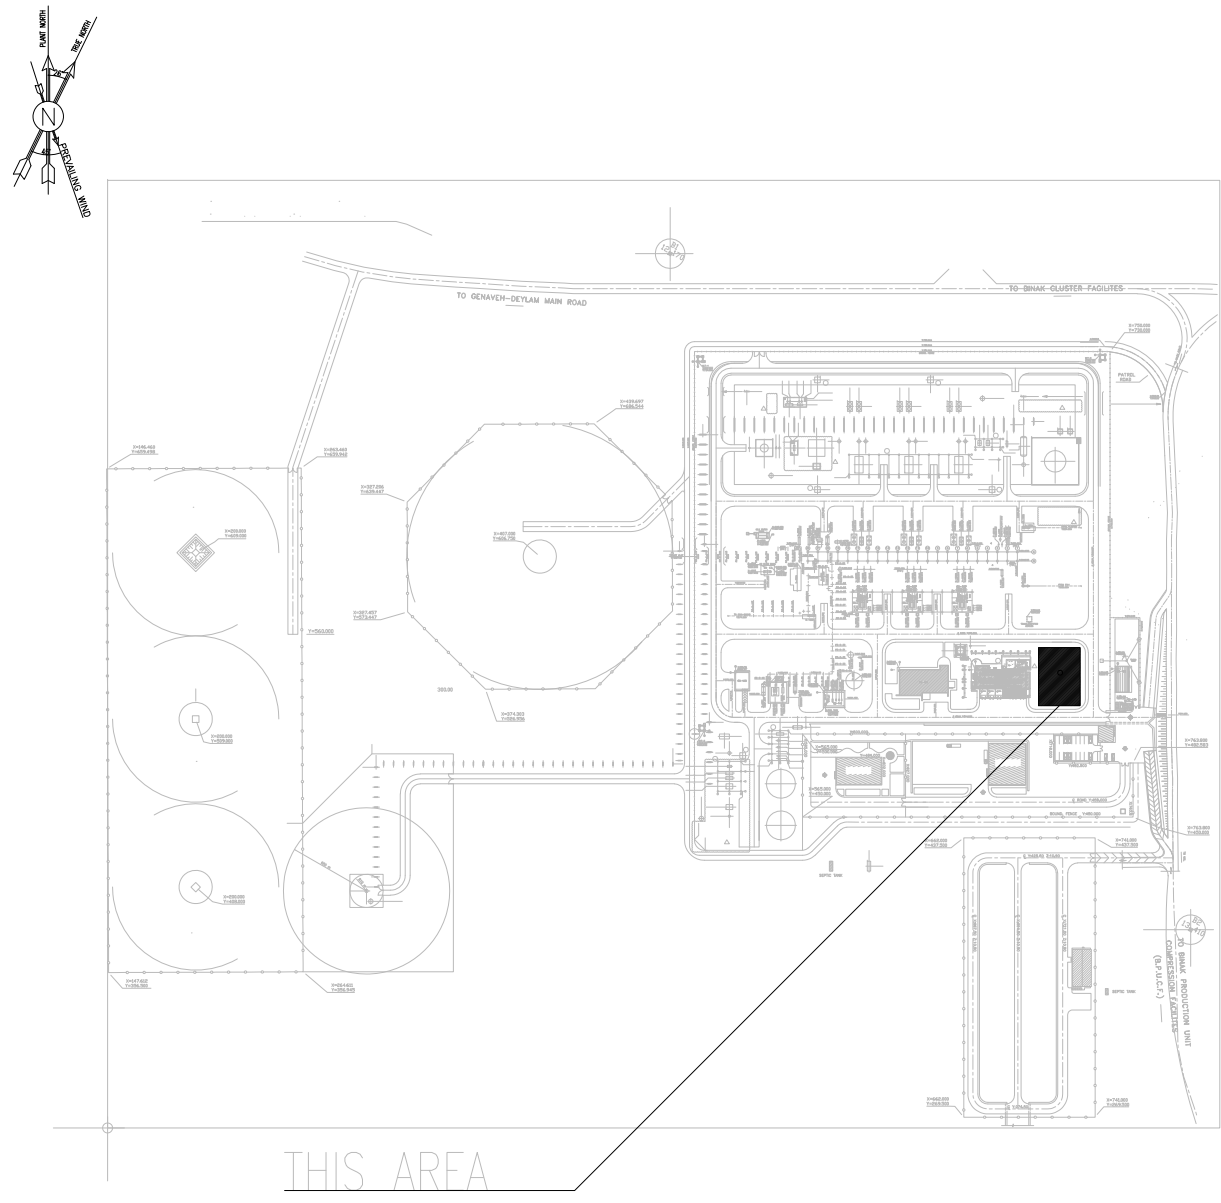

D05	JAN.2023	IFA	R.BERLOUIE	M.PAKHARIAN	M.Mehrshad	***								
D04	OCT.2022	IFA	R.BERLOUIE	M.PAKHARIAN	M.Mehrshad	***								
D03	AUG.2022	IFA	R.BERLOUIE	M.PAKHARIAN	M.Mehrshad	***								
D02	MAR.2022	IPC	R.BERLOUIE	M.PAKHARIAN	M.Mehrshad	***	***	*****	***	*****	***	*****		
D01	JAN.2022	IPC	R.BERLOUIE	M.PAKHARIAN	M.Mehrshad	***	REV.	DESCRIPTION	BY	DATE	BY	DATE		
D00	DEC.2021	IPC	R.BERLOUIE	M.PAKHARIAN	M.Mehrshad	***			CHECKED				REV.	APPR.
REV.	DATE	P.O.I.S	PREP.	CHK.	APP.	AUT.			امل و کلیه نسخ این نقشه و حق اقتباس متعلق به شرکت ملی مناطق نفت خیز جنوب میباشند.					
PROJECT NAME:							BINAK OILFIELD DEVELOPMENT/SURFACE FACILITIES GAS COMPRESSOR STATION							
PROJECT NO.:							971020							
EPC CONTRACTOR:							EPD/EPC CONTRACTOR (GC):							
 HIRGAN ENERGY – DESIGN & INSPECTION COMPANIES							 PETROIRAN DEVELOPMENT COMPANY							
							BINAK OILFIELD DEVELOPMENT SURFACE FACILITIES GAS COMPRESSOR STATION							
							DATE	SCALE	DRAWING BY	CHECKED BY	PROJECT ENG.			
DRAWING TITLE:							NO CONSTRUCTION PERMITTED UNLESS DRAWING APPROVED							
ARCHITECTURAL DETAIL DRAWING FOR CONTROL BUILDING														
DETAILS							APPROVED FOR CONSTRUCTION							
							BY:		DATE:					
SCALE	SIZE	DRAWING NO.			SHEET NO.	REV.	BUDGET REF.	LOCATION	SIZE	CLASS	SERIAL NO.	SHEET	REVISION	
AS SHOWN	A0	BK-GCS-PEDCO-120-AR-DW-0001			11 OF 12	D05	053-073-9184	F	4	B	709099	11 OF 12	D05	

