



- NOTES**
- 1- ALL DIMENSIONS ARE IN MILLIMETERS, EXCEPT OTHERWISE NOTED.
 - 2- ALL ELEVATIONS ARE IN METERS.
 - 3- ALL COORDINATES OF THIS PLAN ARE LOCAL.
 - 4- H.P.P. 100.00m CORRESPONDING TO 26.236 M.S.L.
 - 5- SHOWED PIPING / PIPELINES AND RELEVANT SUPPORTS, ARE INDICATIVE.
 - 6- ELEVATION & COORDINATION OF ACCESS ROADS WILL BE ILLUSTRATED IN NEXT REV.
 - 7- REFERENCE COORDINATES X=1000.000 , Y=1000.000 REFER TO E=437424.723 , N=3290543.013 UTM, WGS84 ZONE 39 - NORTH
 - 8- FOR DETAIL OF BURN PIT & ACCESS ROAD SEE BK-W007S-PEDCO-110-CV-PY-0002

- LEGEND & ABBREVIATIONS**
- H.P.P. HIGH POINT PAVING
 - W.H.C.P. WELL HEAD CONTROL PANEL
 - FENCE
 - MATCH LINE
 - WELL LOCATION
 - SURFACE WATER TRENCH
 - GRATING
 - HELIPAD

REFERENCE DRAWING	DRG. No.
GENERAL CIVIL LAYOUT - W007S	BK-W007S-PEDCO-110-CV-PY-0001
CIVIL AND STRUCTURAL DRAWINGS - W007S	BK-W007S-PEDCO-110-CV-PY-0002
PAID - W007S	BK-W007S-PEDCO-110-PR-PI-0002
PIPING PLAN - W007S	BK-W007S-PEDCO-110-PI-DW-0003
FLOW LINE PLAN & PROFILE DRAWINGS - W007S	BK-W007S-PEDCO-110-SU-DW-0001
CABLE ROUTE LAYOUT FOR ELECTRICAL TOWER (GANTRY) OF WELL PADS	BK-SSGR-L-PEDCO-110-EL-PY-0002
ARCHITECTURAL DRAWING FOR SWITCHGEAR BUILDING OF WELL PADS - W007S	BK-W007S-PEDCO-110-AR-DW-0003

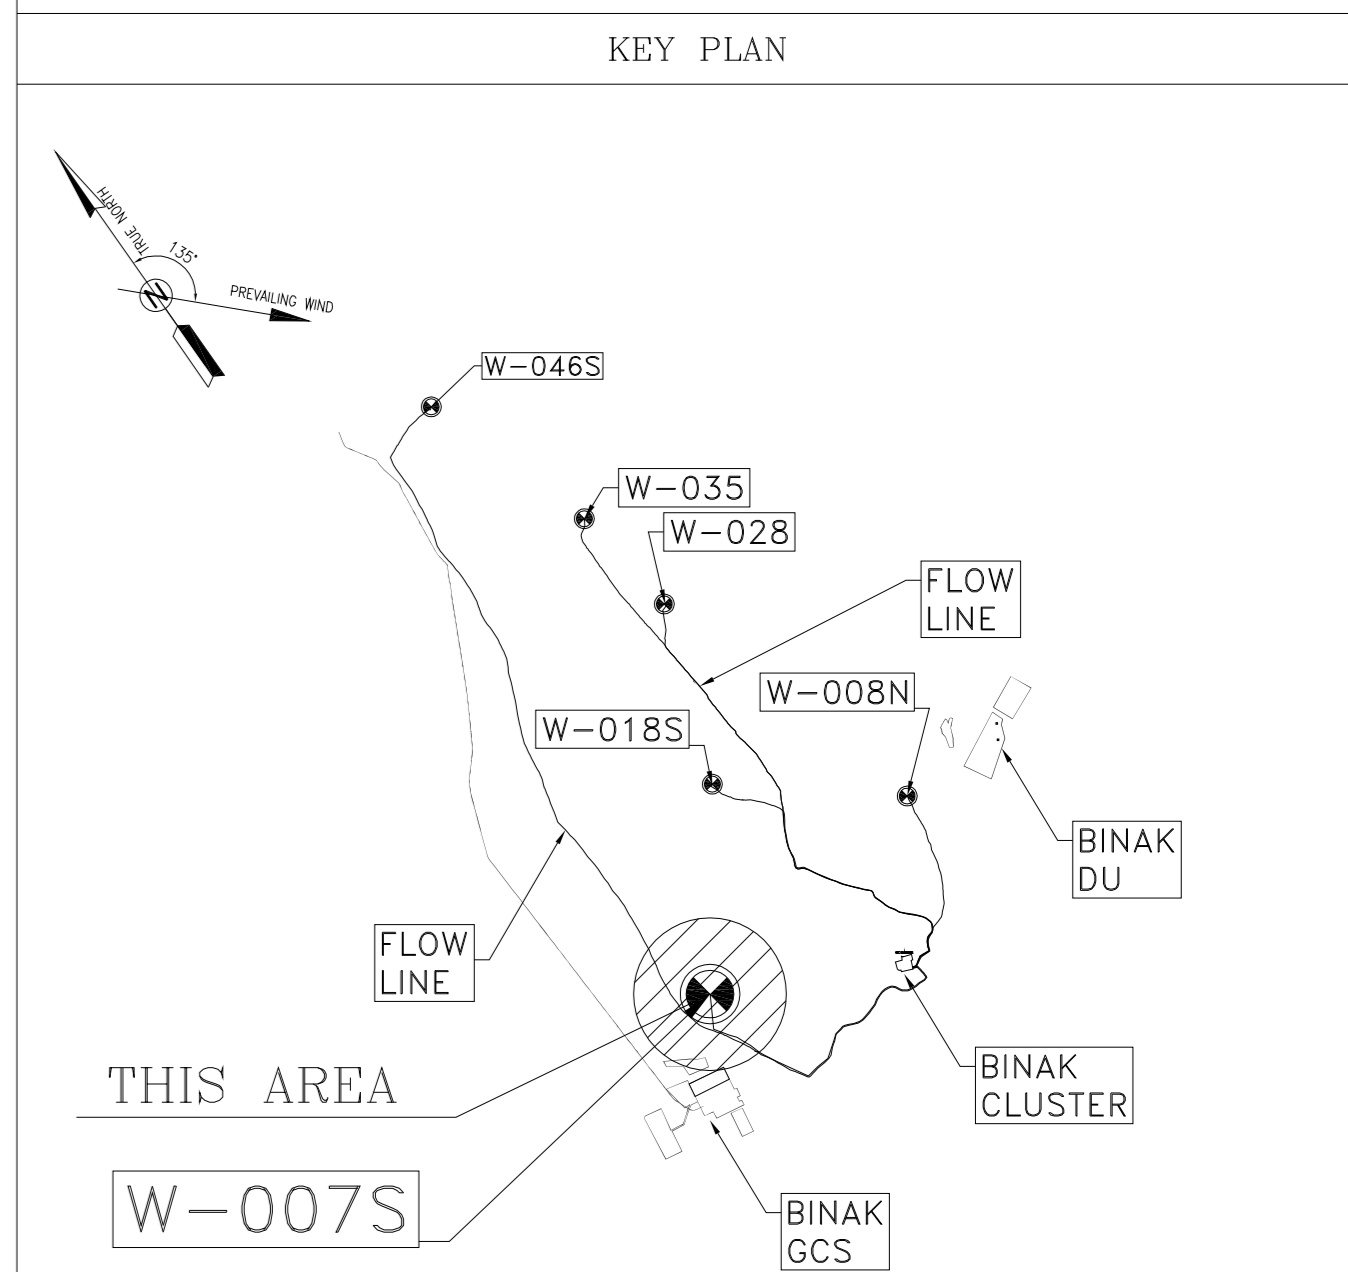

TAG NO.	AREA LIST
01	DRILLING CONEX AREA
02	FUEL TANK AREA
03	SEPTIC
04	SECURITY ROOM
05	IRP PUMP
06	FIREFIGHTING SHELTER
07	DIESEL GENERATOR
08	DIESEL GENERATOR FUEL TANK
09	SWITCHGEAR
10	WASTE PIT
11	BURN PIT
12	POTABLE WATER TANK
13	HELIPAD

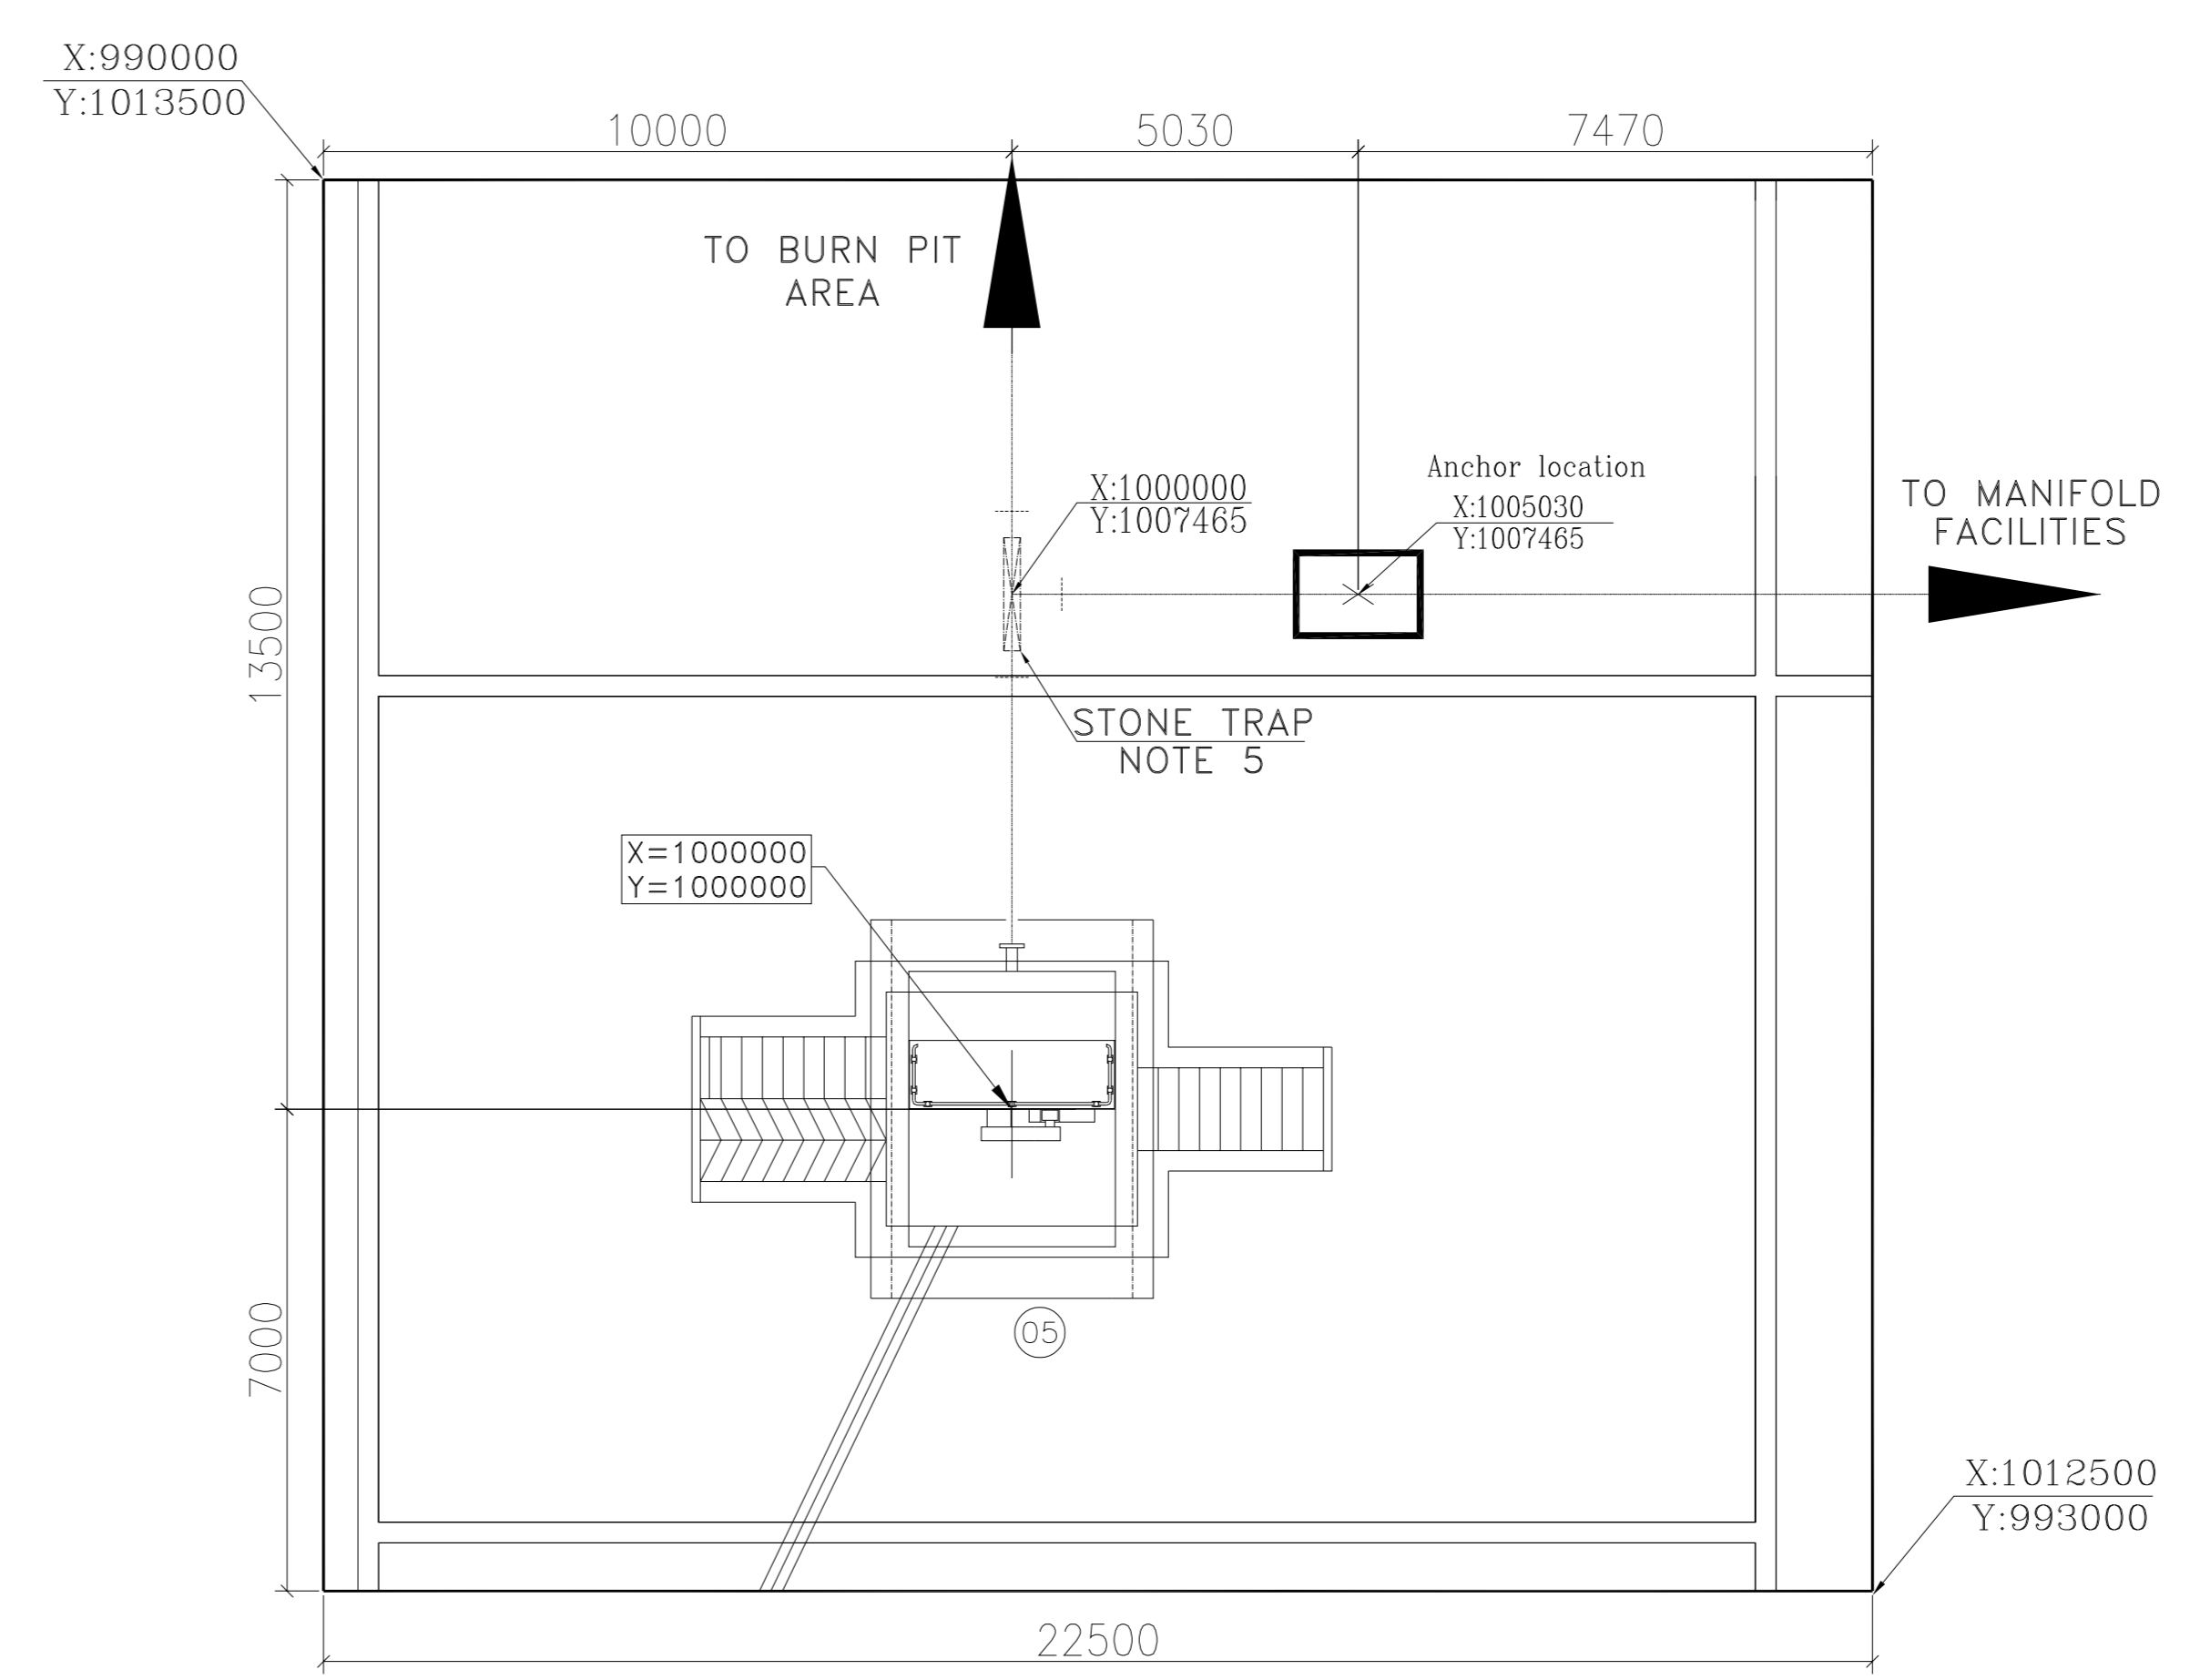

REV.	DESCRIPTION	BY	DATE	BY	DATE				
DOO	JAN.2023	IFC	M.NOORI	M.FAKHARIAN	M.MEHRSHAD				
REV.	DATE	P.O.I.S	PREP.	CHK.	APP.	AUT.			
PROJECT NAME: BINAK OILFIELD DEVELOPMENT/SUB-SURFACE WORK PACKAGES W007S WELLHEAD FACILITIES									
PROJECT NO.: 971020									
EPC CONTRACTOR:			GENERAL CONTRACTOR:						
HIRGAN ENERGY - DESIGN & INSPECTION COMPANIES			PEDCO						
DRAWING TITLE:			PLOT PLAN DRAWING - W007S						
NO CONSTRUCTION PERMITTED UNLESS DRAWING APPROVED									
APPROVED FOR CONSTRUCTION			BY:		DATE:				
SCALE	SIZE	DRAWING NO.	SHEET NO.	REV.	BUDGET REF.	LOCATION SIZE CLASS	SERIAL NO.	SHEET	REVISION
AS SHOWN	A0	BK-W007S-PEDCO-110-PI-PY-0002	1 OF 1	DOO	053-073-9184	F 5 A	707945	1 OF 1	DOO