
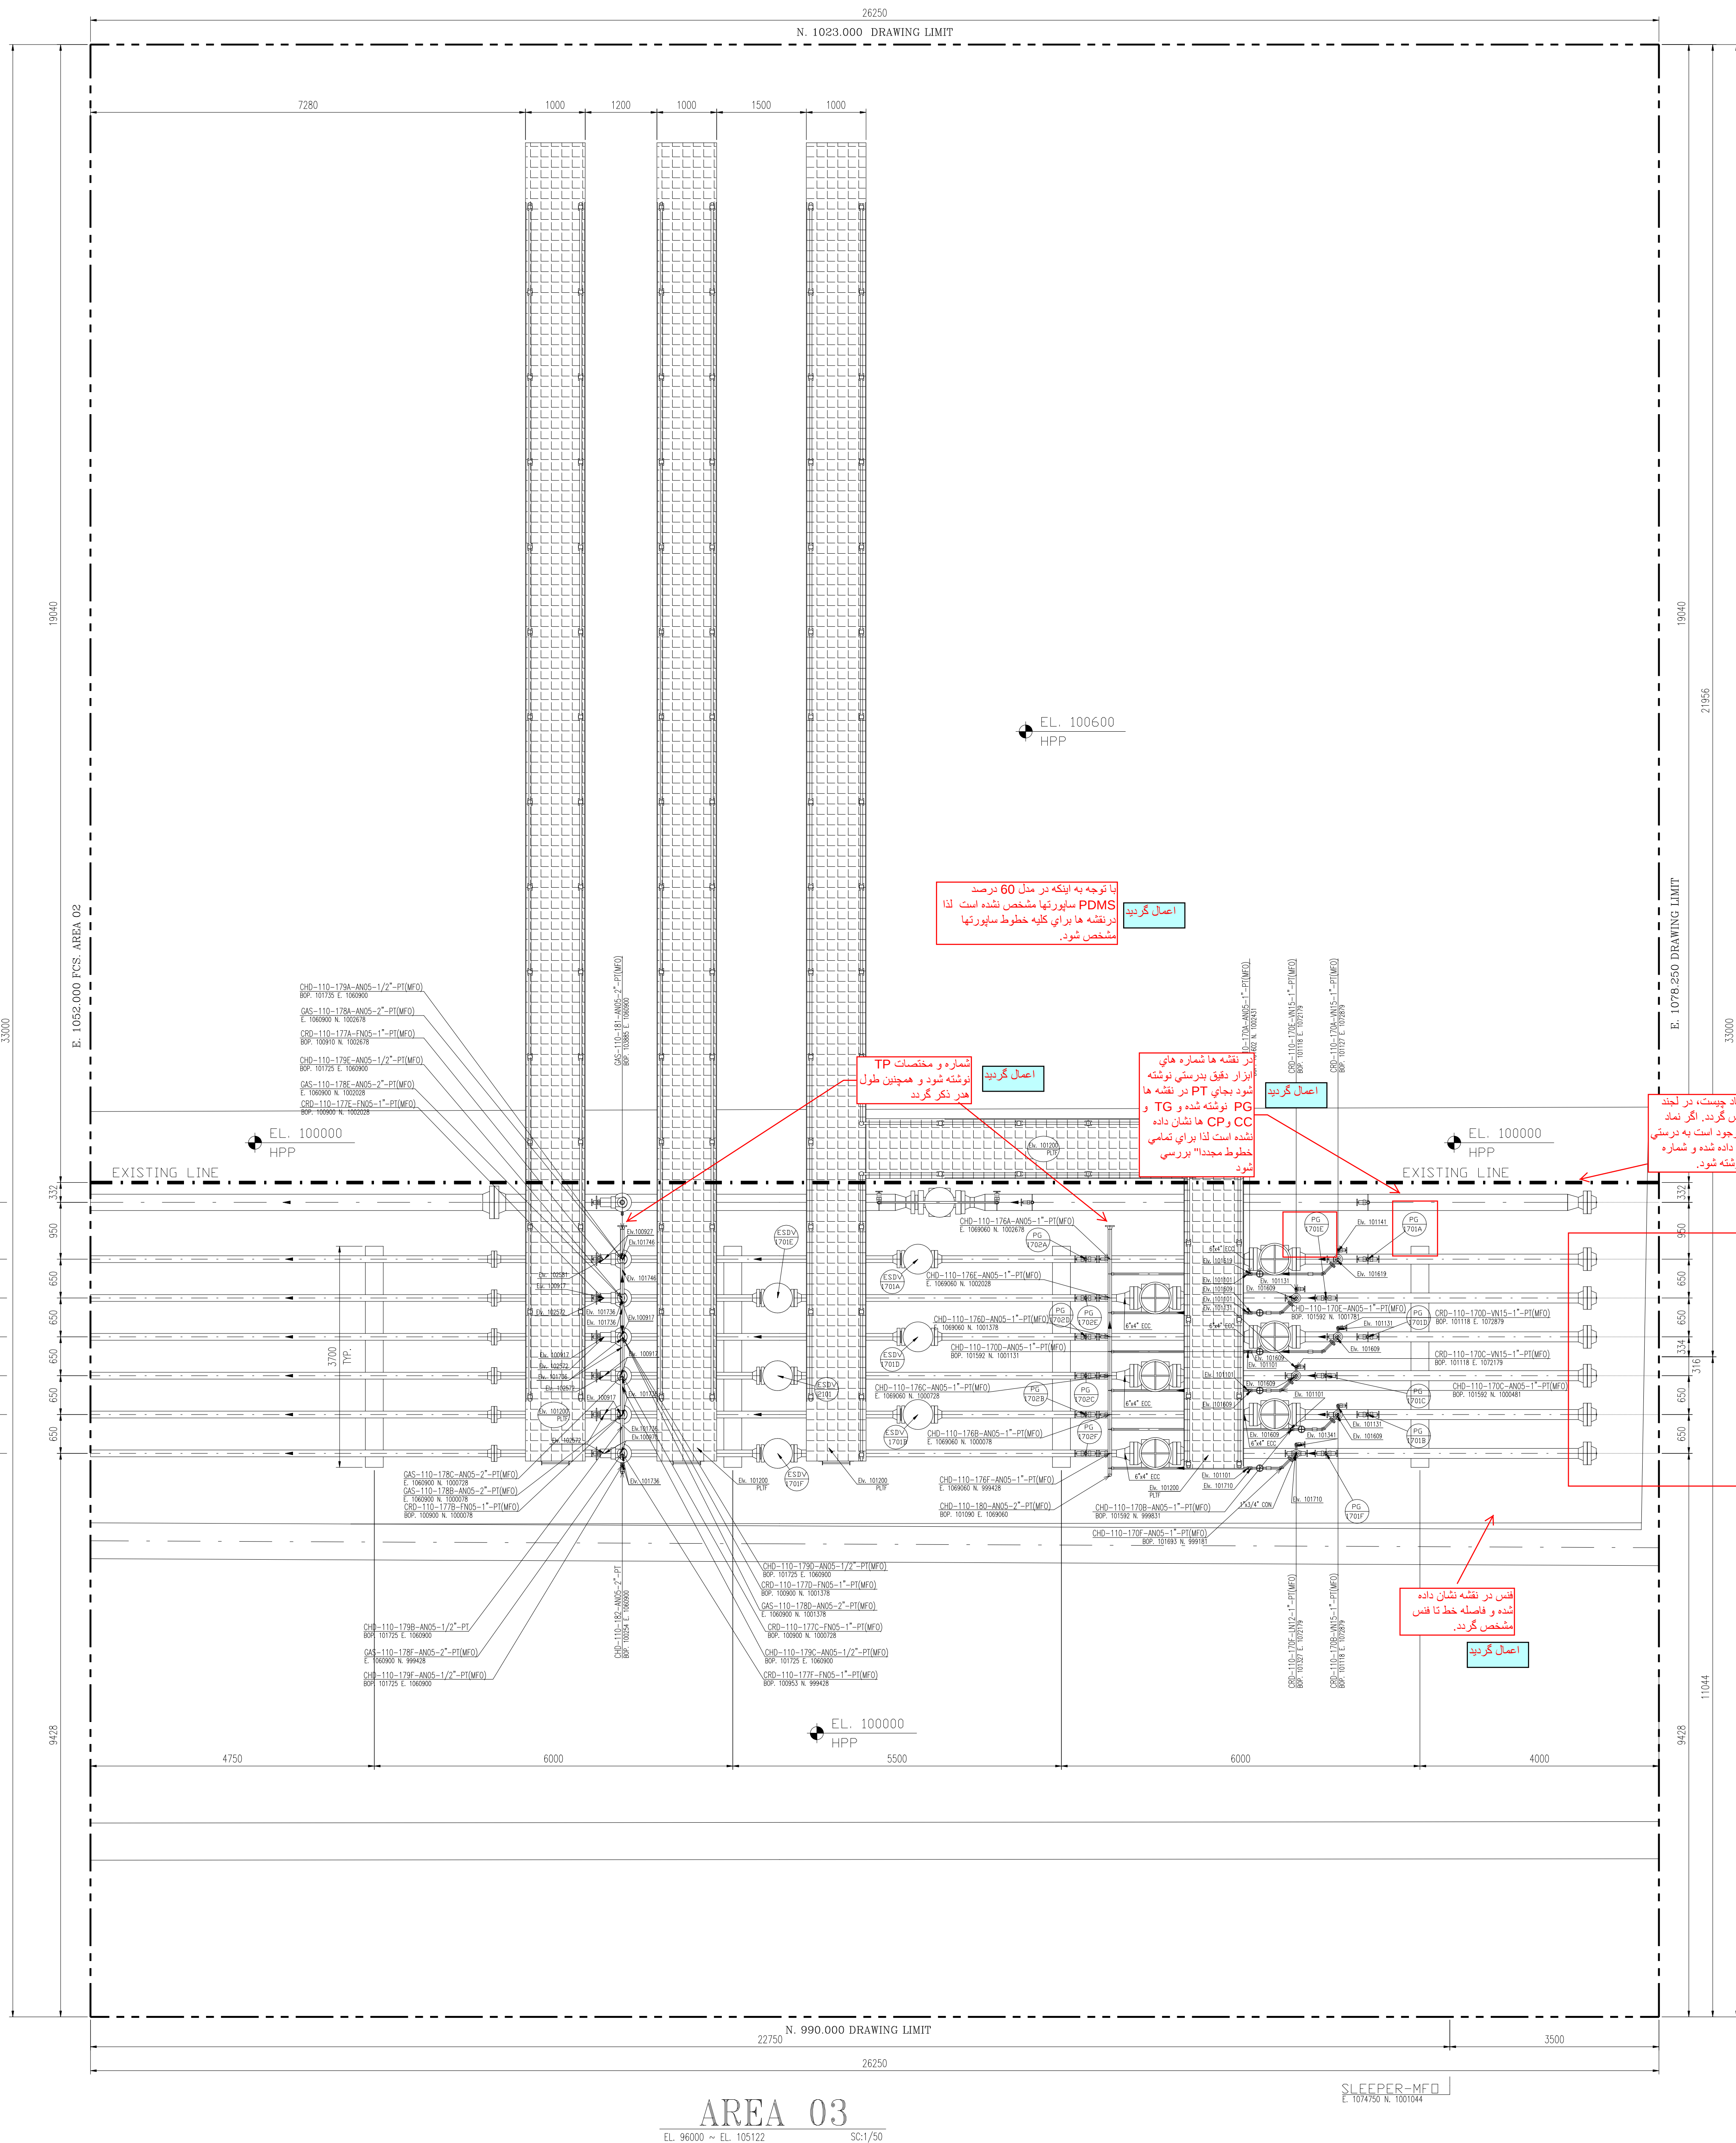
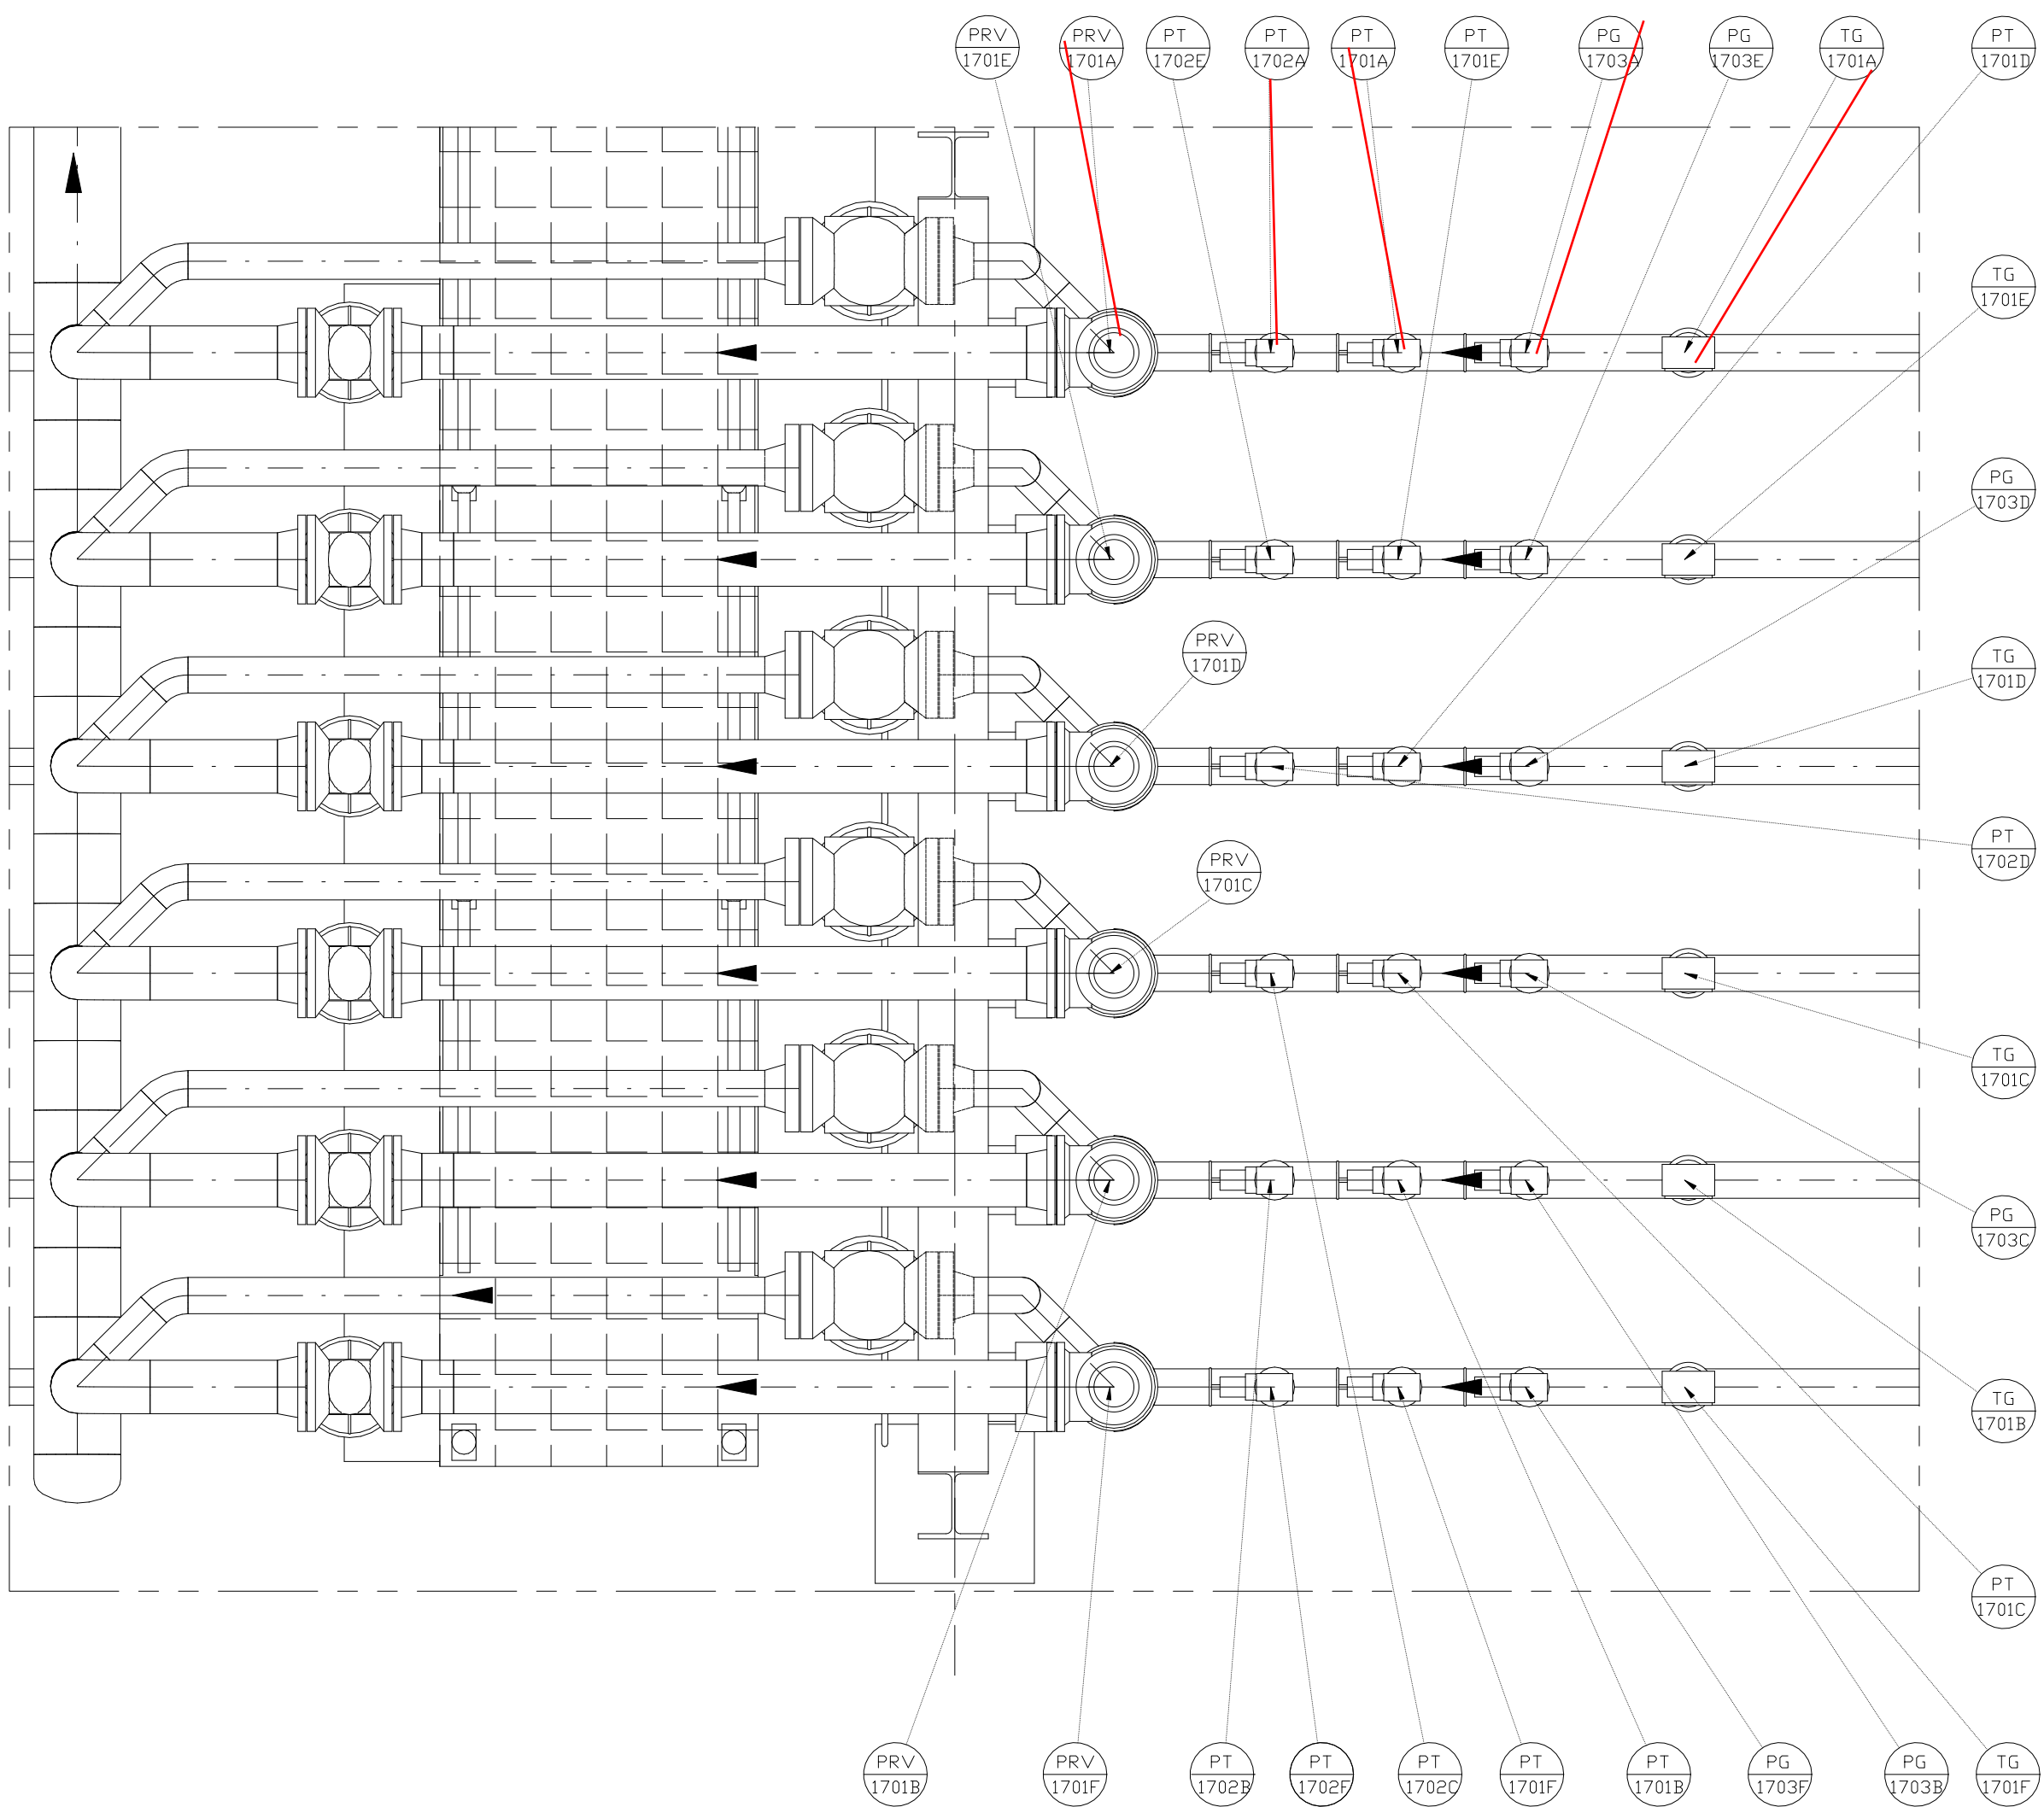
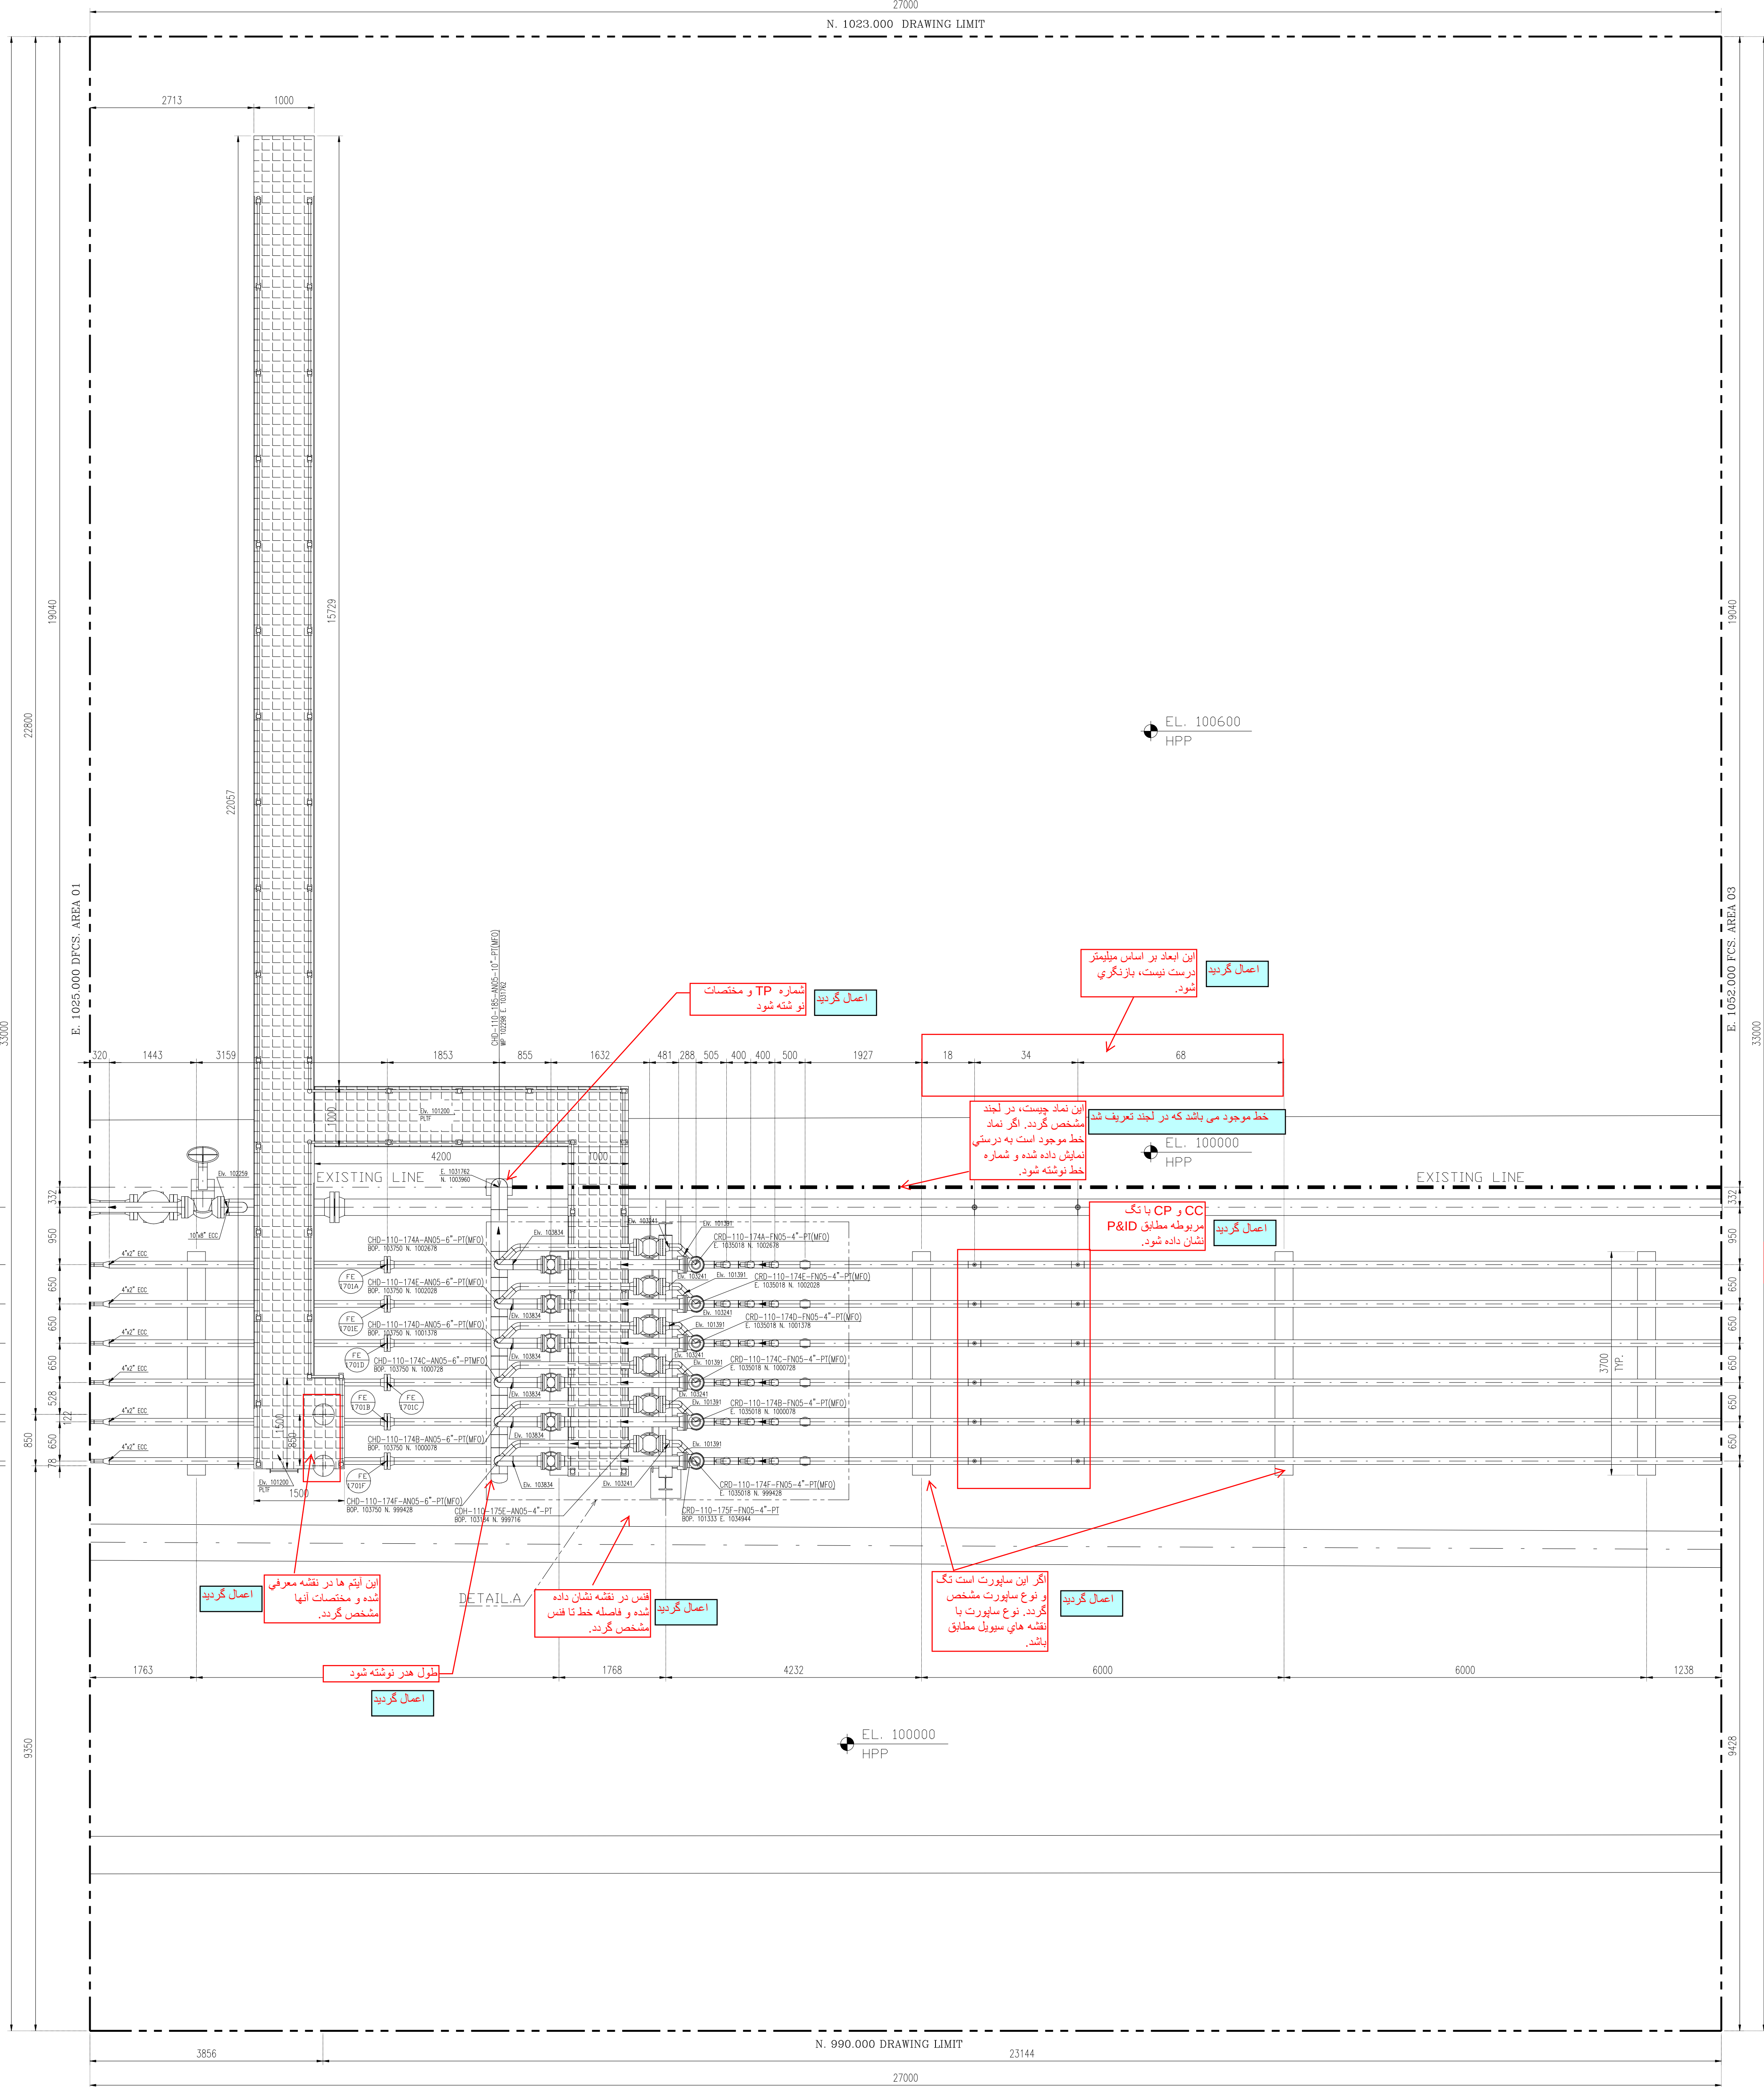


[illegible]

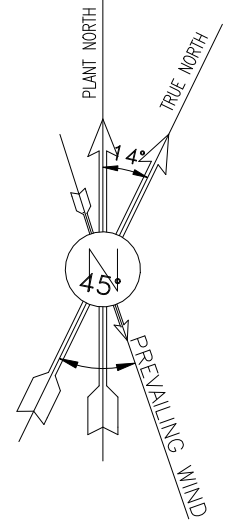


DETAIL A

- NOTES
- 1- ALL DIMENSIONS AND ELEVATIONS ARE IN MILLIMETERS.
 - 2- ALL COORDINATES ARE IN METERS.
 - 3- H.P.P. ELEVATION +100.00 CORRESPOND TO +55.0 UTM.
 - 4- ALL COORDINATES = PLANT COORDINATES


LEGEND	
WP	WORKING POINT ELEVATION (CENTER OF PIPE ELEVATION)
PF	PLATFORM
BOP	BOTTOM OF PIPE ELEVATION
TOS	TOP OF STEEL ELEVATION
FGL	FINISH GRADE LEVEL
HPG	HIGH POINT OF GRAVEL
HPP	HIGH POINT OF PAVEMENT
MSL	MEAN SEA LEVEL
SS	STRUCTURE SUPPORT
PS	PIPE SUPPORT
SPS	SPECIAL PIPE SUPPORT
FCS	FOR CONTINUE SEE
∇	SLOPE
---	MATCH LINE

REFERENCE DRAWING	DRG. No.
Plot Plan Drawing - Extension of Binak B/C Manifold	BK-W007S-PEDCO-110-PI-PY-0001
P&ID - Extension of Binak B/C Manifold	BK-W007S-PEDCO-110-PR-PI-0001

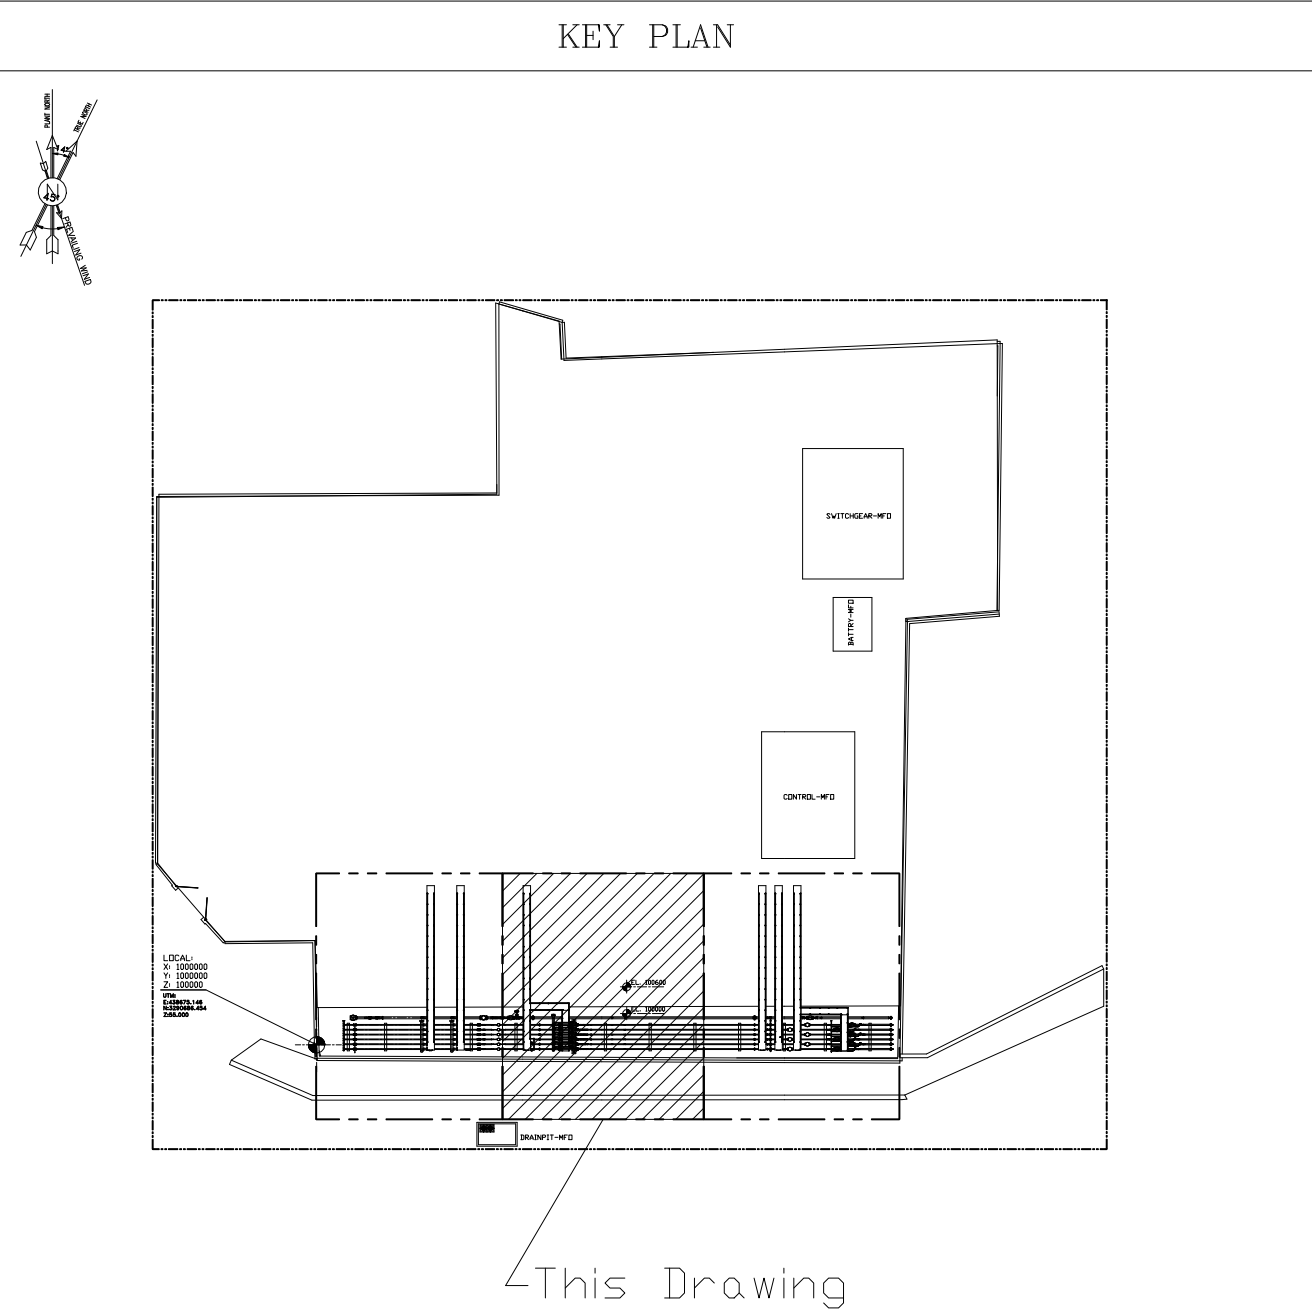

REV.						BY					
DESCRIPTION						CHECKED					
PROJECT NAME:						THE ORIGINAL AND ALL COPIES OF THIS DRAWING TOGETHER WITH THE COPYRIGHT THEREIN ARE THE SOLE PROPERTY OF N.I.S.O.C./ FIELDS					
PROJECT NO.:						BINAK OILFIELD DEVELOPMENT SUB-SURFACE WORK PACKAGES W007S WHF & EXTENSION OF BINAK B/C					
EPC CONTRACTOR:						PETROIRAN DEVELOPMENT COMPANY					
DRAWING TITLE:						NO CONSTRUCTION PERMITTED UNLESS DRAWING APPROVED					
SCALE						APPROVED FOR CONSTRUCTION					
1 : 50						DATE					
A0						BY:					
BK-W007S-PEDCO-110-PI-DW-0001						DATE:					
2 OF 3						SHEET					
D00						REVISION					
0-53-073-9184						F2J-707999					
F						2 OF 3					
2						D00					
J											
F2J-707999											
2 OF 3											
D00											

(VENDOR TITLE BLOCK)**

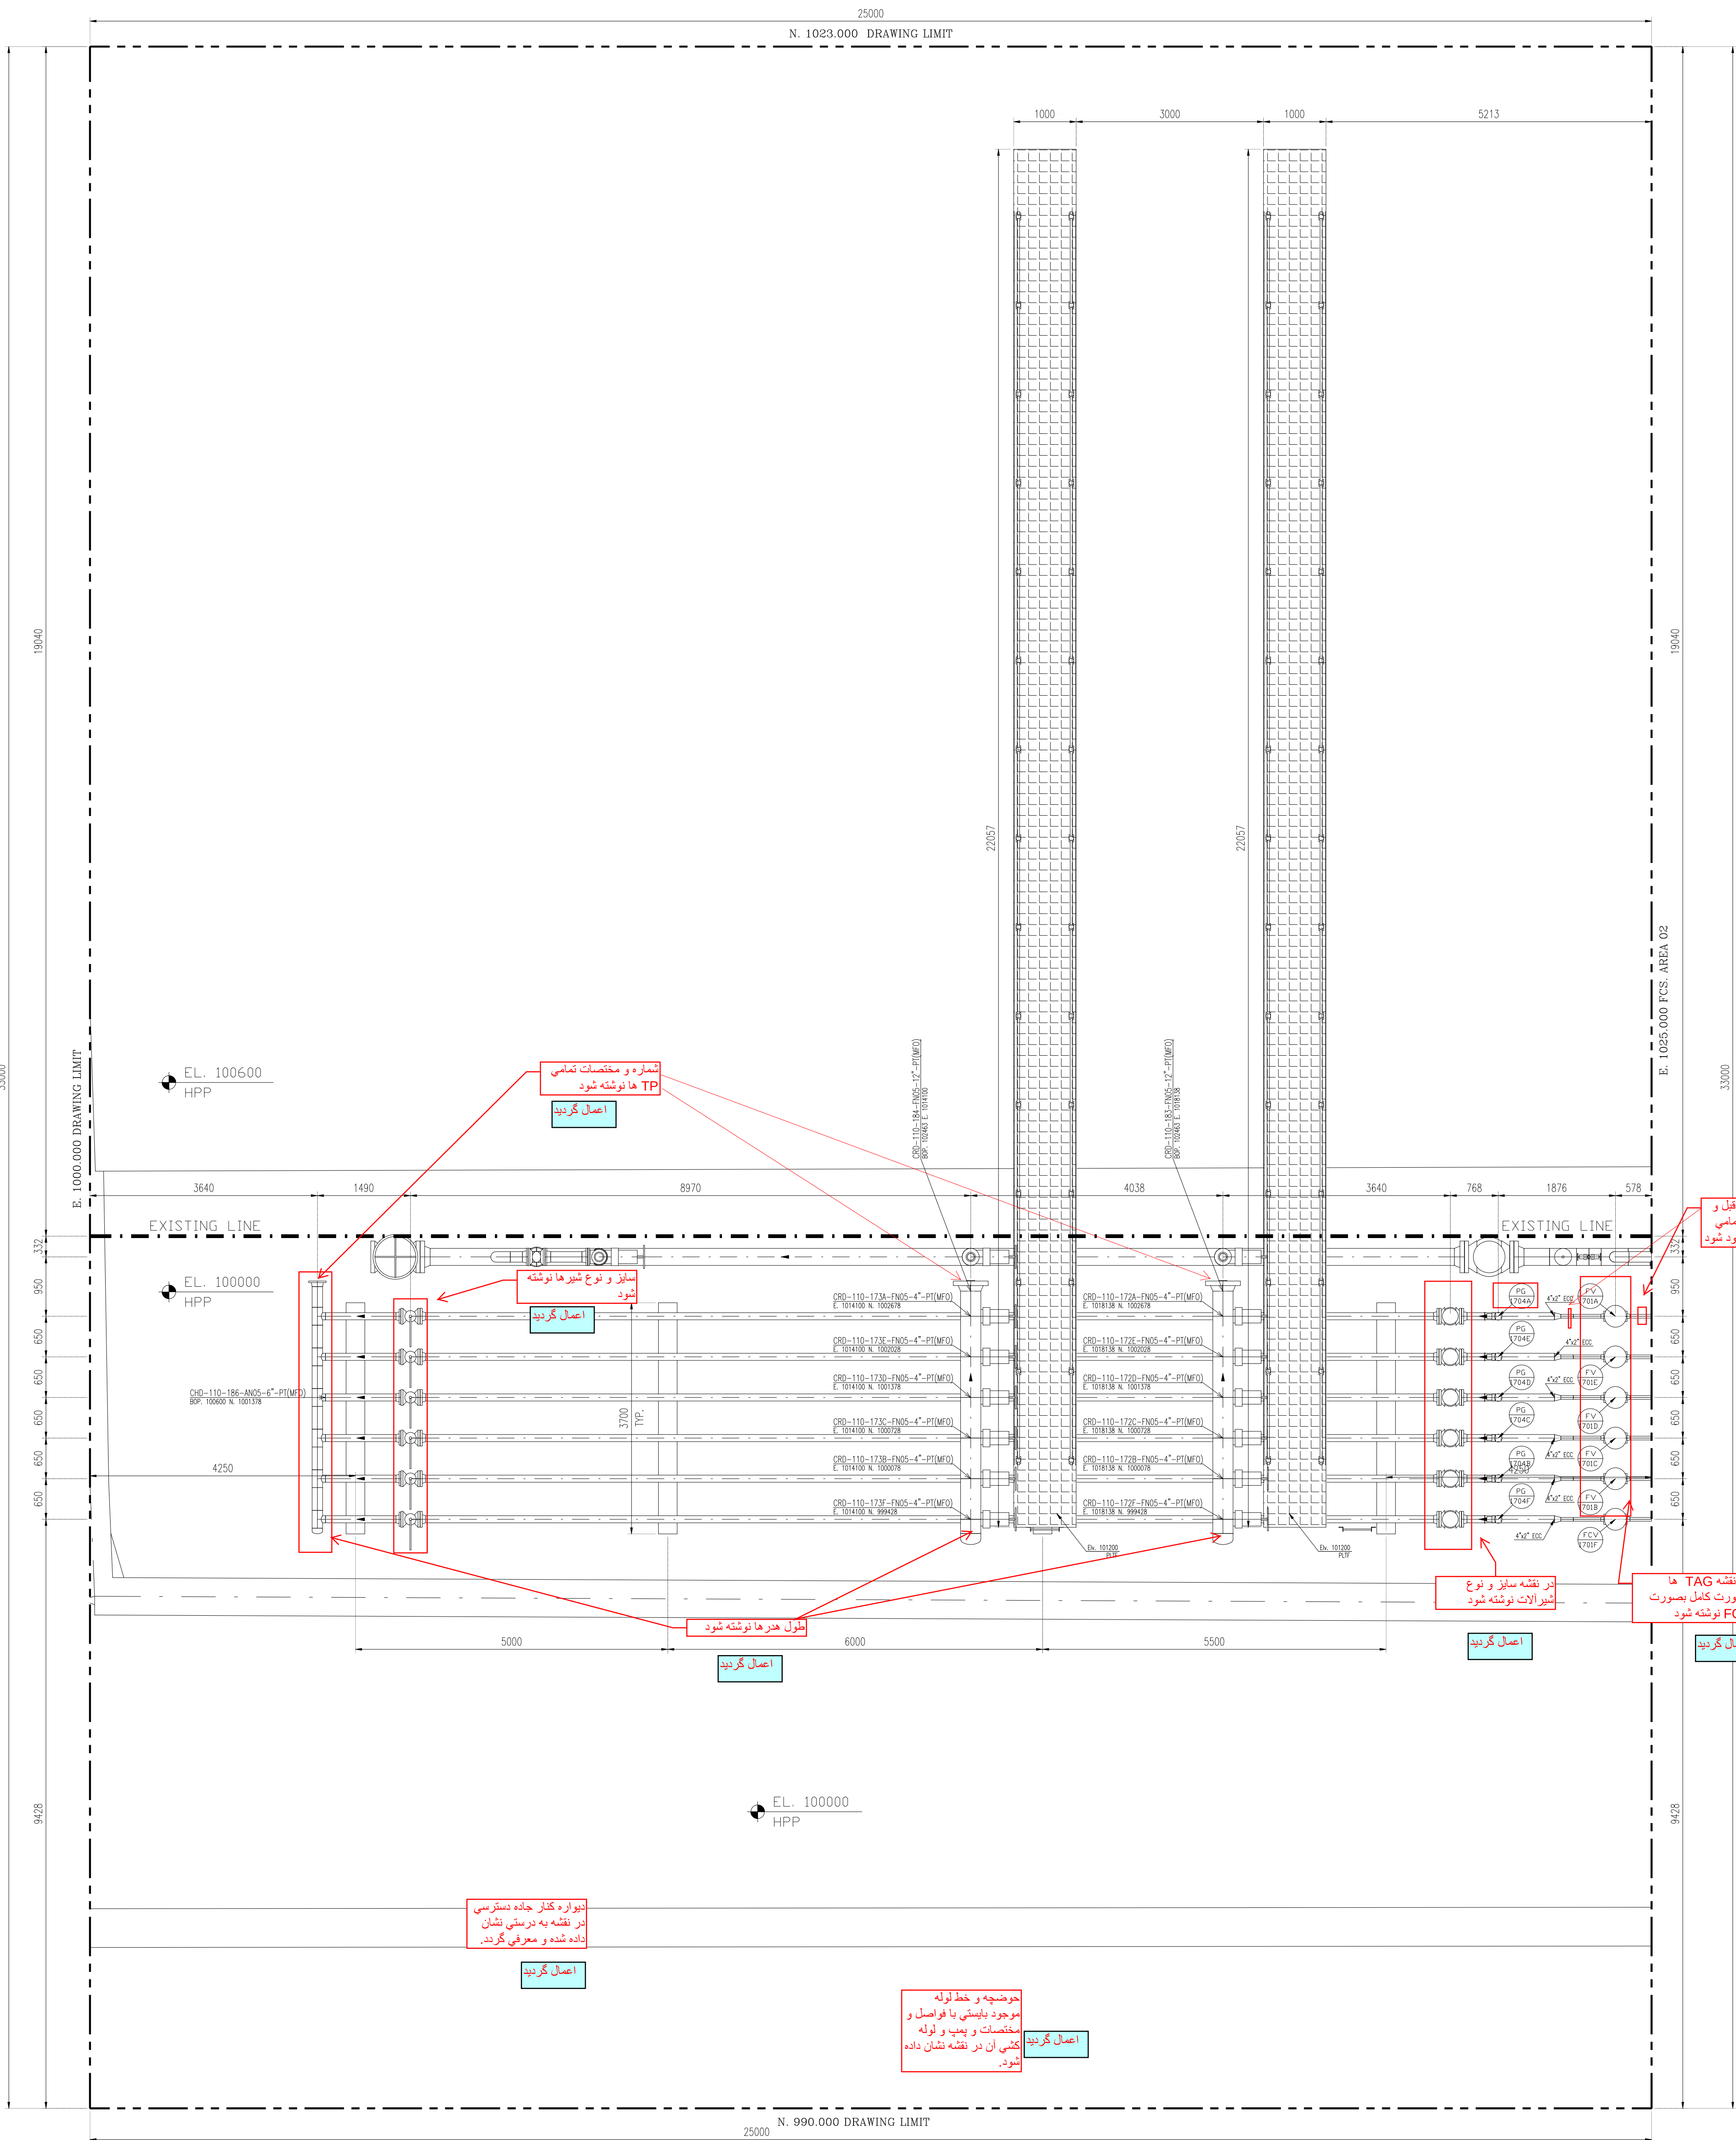

نقطه نظر مدنظر قرار خواهد گرفت. و در صورت تغییر مدارک پایه این مدرک نیز به روز رسانی خواهد شد.

CRD-110-171A-FW05-4'-PT(MED)
CRD-110-173E-FW05-4'-PT
RDP, 100601

در نقشه سبایز و نوع

AREA 01

EL. 96000 ~ EL. 105122 SC:1/50

دیواره کنار جاده
در نقشه به دریا
داده شده و معر

 
مسابره و نوع شیوه‌ها نوشته شود

مسابره و نوع شیوه‌ها نوشته شود

ما نوشتنه شود


اعمال گردید

اعمال گردید

LEGEND	
WP	WORKING POINT ELEVATION (CENTER OF PIPE ELEVATION)
PF	PLATFORM
BOP	BOTTOM OF PIPE ELEVATION
TOS	TOP OF STEEL ELEVATION
FGL	FINISH GRADE LEVEL
HPG	HIGH POINT OF GRAVEL
HPP	HIGH POINT OF PAVEMENT
MSL	MEAN SEA LEVEL
SS	STRUCTURE SUPPORT
PS	PIPE SUPPORT
SPS	SPECIAL PIPE SUPPORT
FCS	FOR CONTINUE SEE
	SLOPE
	MATCH LINE

REFERENCE DRAWING	DRG. No.
Plot Plan Drawing – Extension of Binak B/C Manifold	BK-W007S-PEDCO-110-PI-PY-0001
P&ID – Extension of Binak B/C Manifold	BK-W007S-PEDCO-110-PR-PI-0001

KEY PLAN

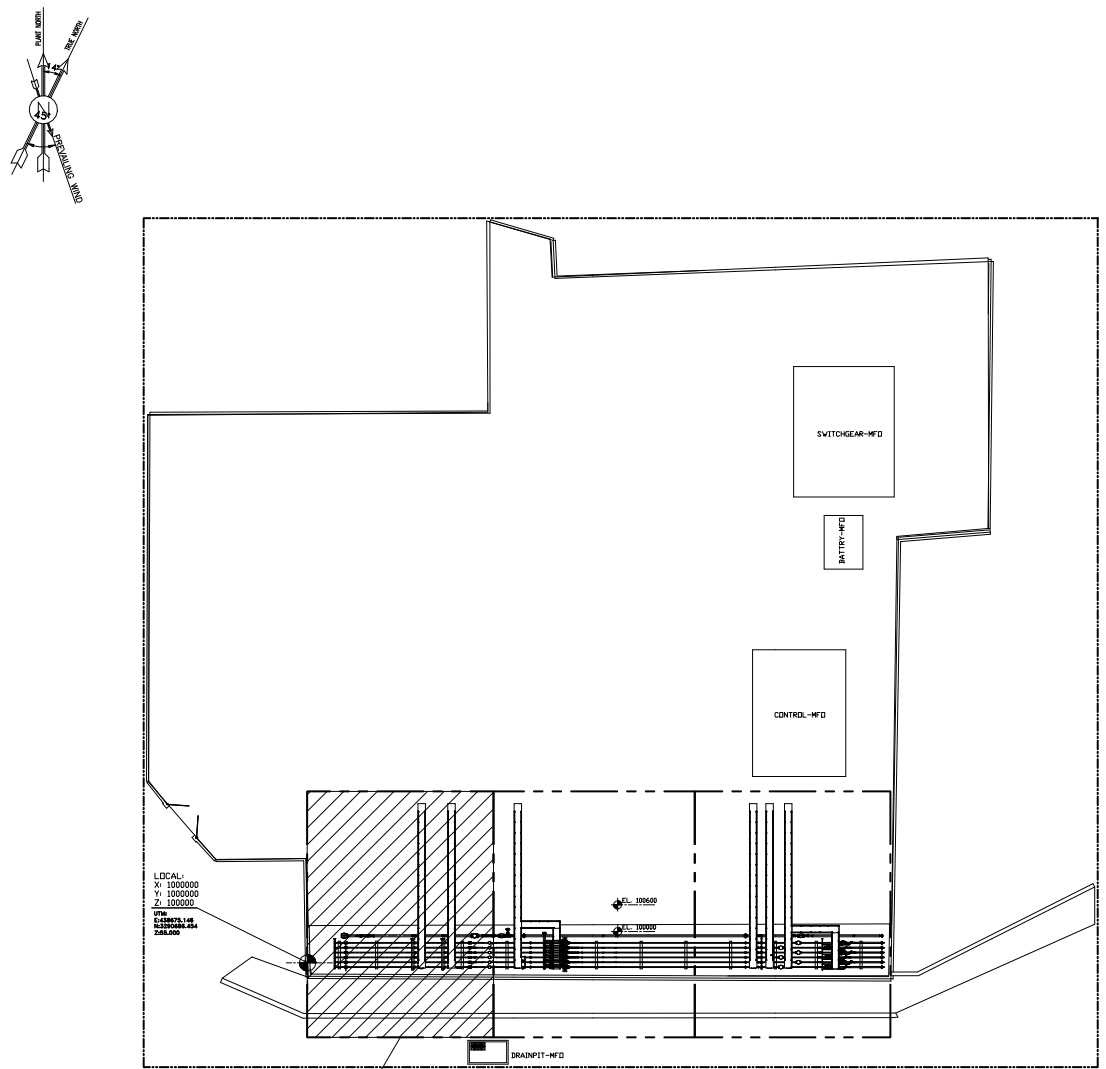

↳ This Drawing

[illegible]