



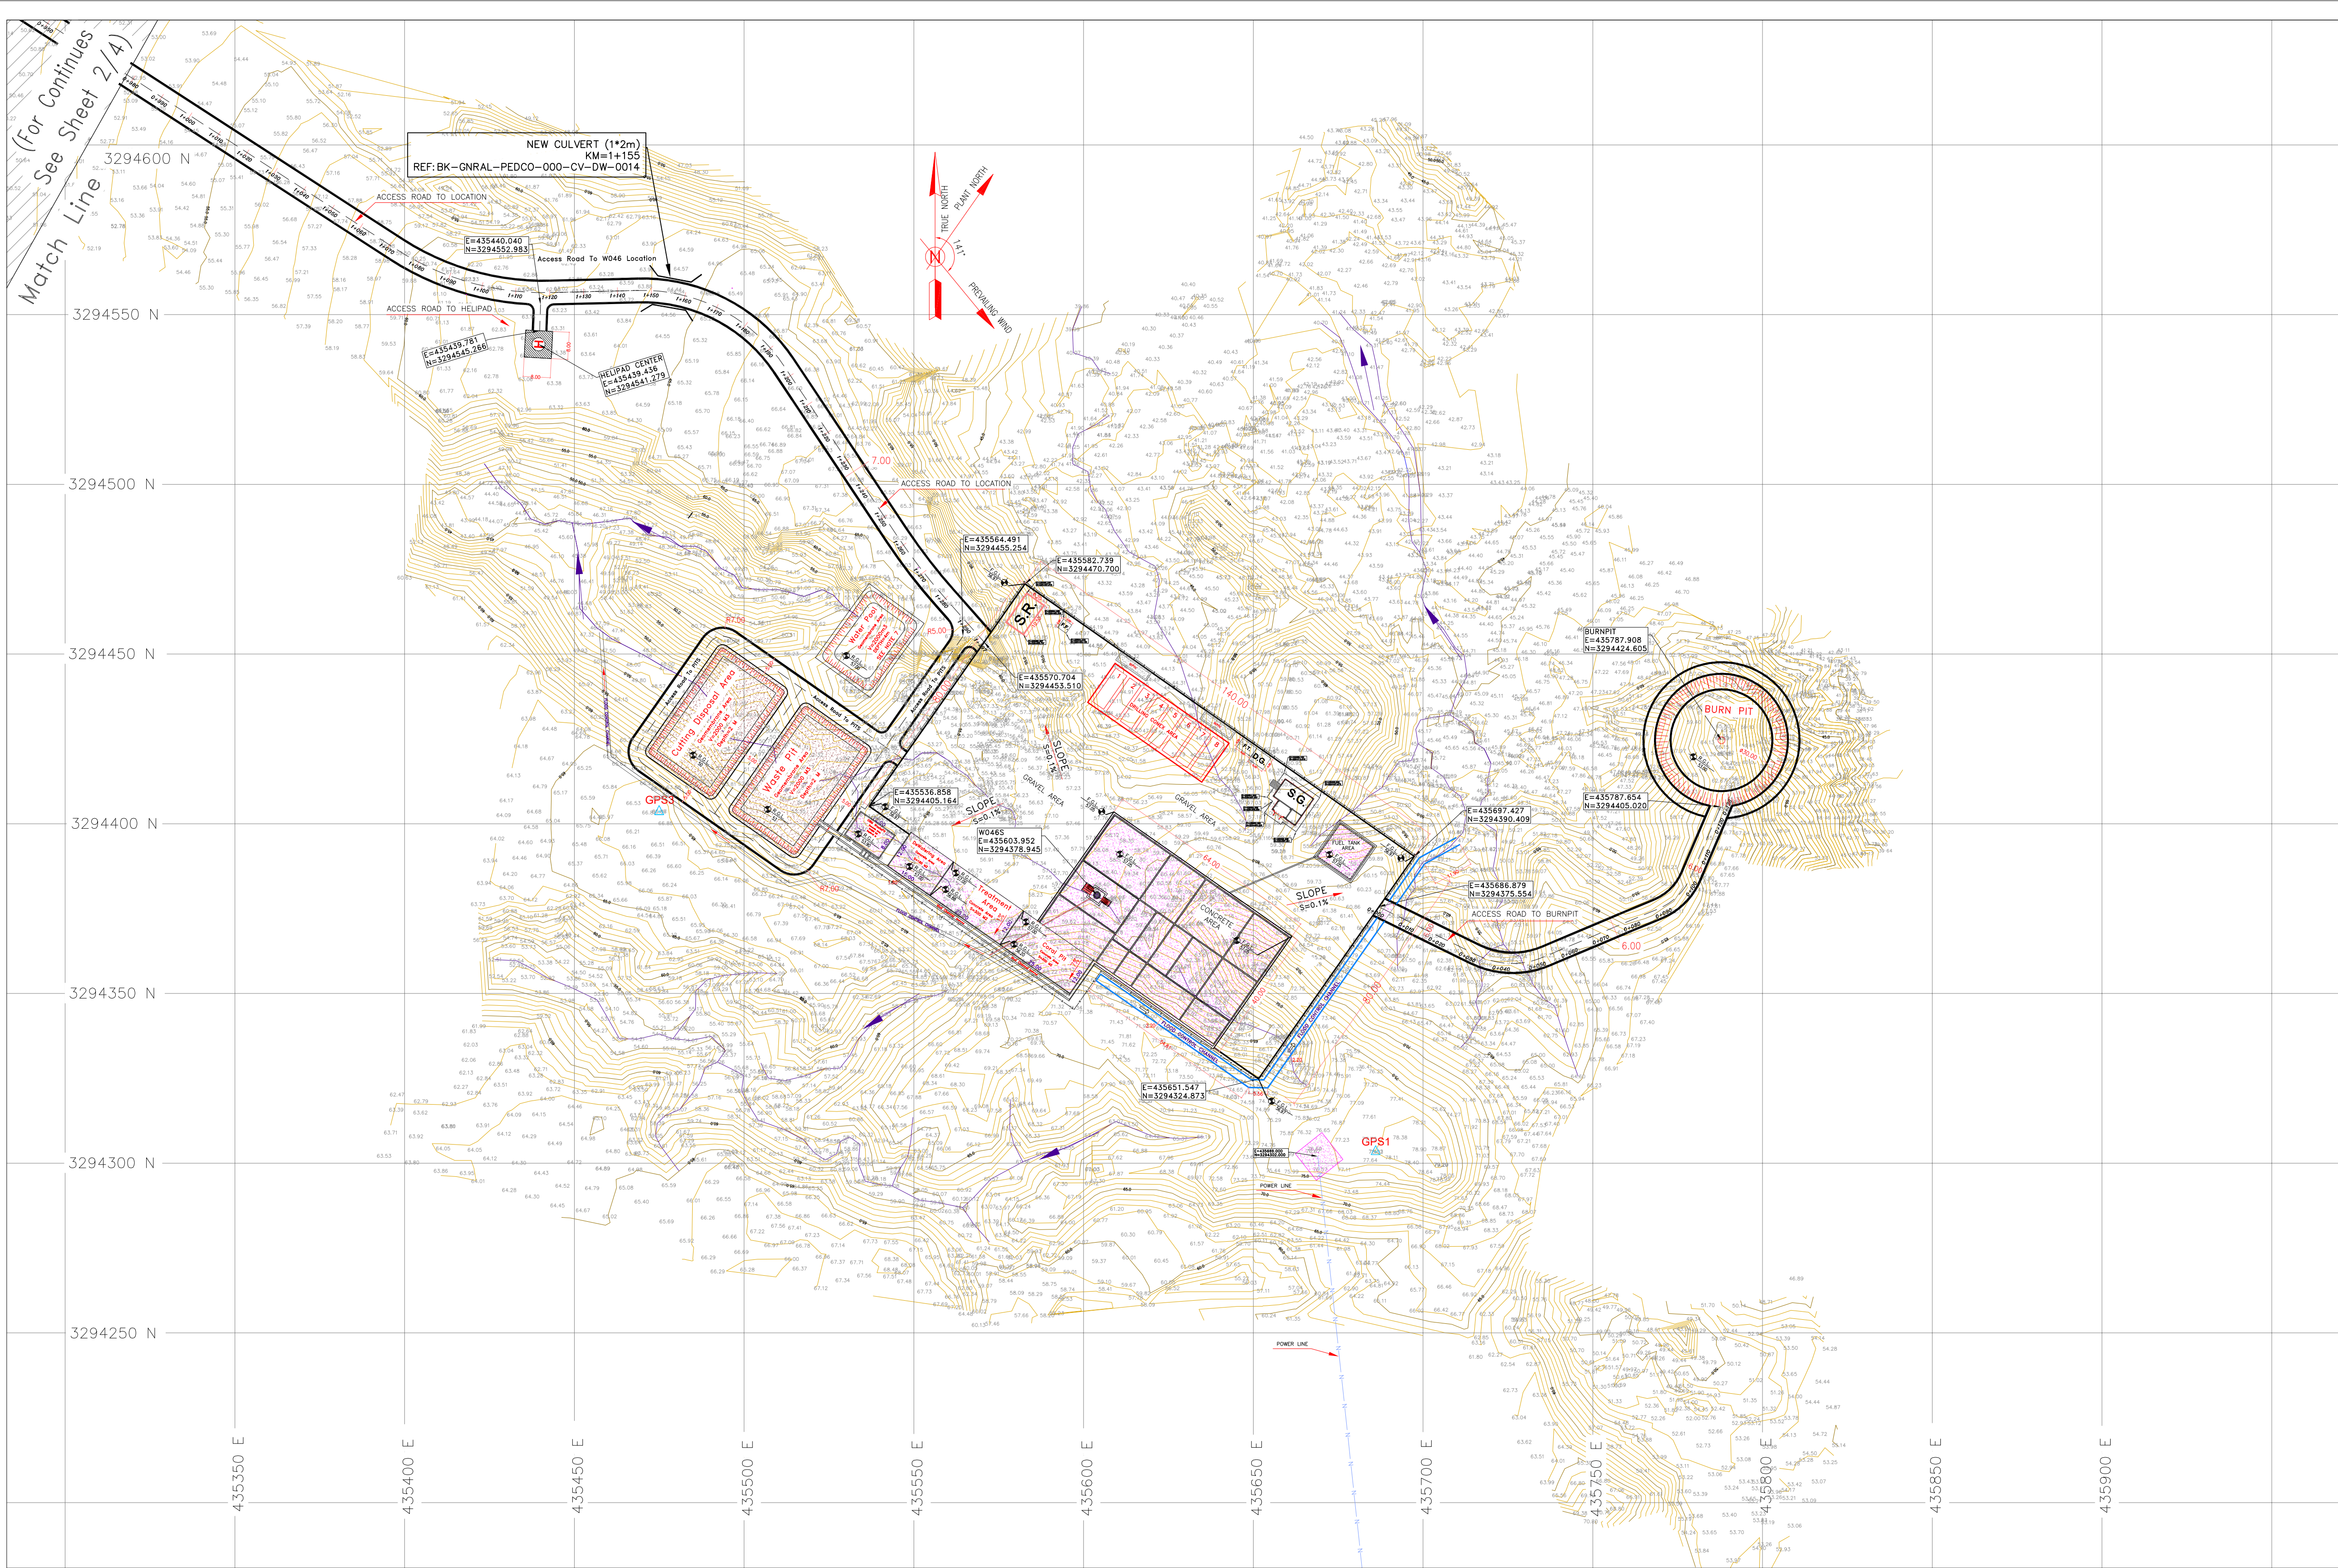

- NOTES
- 1- ALL COORDINATES AND ELEVATIONS ARE IN METER.
 - 2- ALL DRAWINGS SHALL BE CHECKED BY CONTRACTOR WITH RELATIVE DRAWINGS BEFORE CONSTRUCTION.
 - 3-GEOETIC PARAMETERS FOR COORDINATES ARE AS BELOW:
HORIZONTAL COORDINATE SYSTEM: WGS84/UTM ZONE 39
ELLIPSOID : WORLD GEOETIC SYSTEM 1984 (WGS84)
MAP PROJECTION: UNIVERSAL TRANSVERSE MERCATOR (UTM)
VERTICAL DATUM: MEAN SEA LEVEL
 - 4-THE SUITABLE MATERIAL FOR FILLING SHALL BE COLLECTED BASED ON TO THE BELOW RULES:
 - PROJECT GEOTECHNICAL INVESTIGATION REPORT, BORROW MATERIALS AND SPECIFICATION STUDY PART.
 - "GENERAL SPECIFICATION FOR ROAD" NO. 101, SECTION 207, IRAN PLANNING AND BUDGET ORGANIZATION.
 - PROJECT GENERAL SPECIFICATION "SPECIFICATION FOR EARTH WORK" DOCUMENT NUMBER "BK-GNRL-PEDCO-000-CV-SP-0004".
 - GEOTECHNICAL REPORTS AND CLIENT'S SITE SUPERVISORY BODY RECOMMENDATIONS AND APPROVALS.
 - 5-BEFORE ANY EARTH WORK ACTIVITIES (CUT OR FILL), TOP AND UNSUITABLE SOIL (MARN,...) SHALL BE REMOVED AS GEOTECHNICAL RECOMMENDATION AND SUPERVISOR'S REQUIREMENTS.
 - 6-THE WASTE PIT SHALL BE COVERED WITH A LAYER OF GEOTEXTILE(ONE LAYER, MIN 600 KG/M2) AND GEOMEMBRANE (MIN 1.5 MM THICKNESS, 7 M WIDTH) BASED ON CIVIL DESIGN SPECIFICATION DOCUMENTS. THE COVER SHALL EXTEND BEYOND THE OUTER EDGES OF THE PIT TO COVER AND ENTIRELY ENCAPSULATE THE PIT AND SHALL BE SLOPED TO PROVIDE SURFACE DRAINAGE AWAY FROM THE PIT.
 - 7-THE WATER POOL IS NOT CLIENT REQUIREMENT.

LEGEND			
	Existing GRAVEL ROAD		CHANNEL
	New GRAVEL ROAD		RIVER
	ASPHALT ROAD		WATER COURSE
	STAIR		CONTOURS
	TRENCH		CONTOURS
	FENCE	99,27	SPOT HEIGHT
	BURNING PIT LINE		BENCH MARK
	WATER LINE		CULVERT
	BUILDING		WELL LOCATION
	CONCRETE AREA		WELL
	SEPTIC		BURNPIT
	MANHOLE		SITE (LOCATION)
	POLE		DRILLING CONEX AREA
	HELIPAD		POWER LINE
	GEOMEMBRANE AREA		


REFERENCE DRAWING		DRG. No.
Civil and Structural drawings - W046S		BK-W046S-PEDCO-110-CV-PY-0002
Rough Grading Plans - W046S		BK-W046S-PEDCO-110-CV-DW-0001
Plot Plan Drawing - W046S		BK-W046S-PEDCO-110-PH-DW-0001
Standard Drawing For Fence & Gate Details		BK-GNRL-PEDCO-000-CV-DW-0009
ARCHITECTURAL DRAWING FOR DIESEL GENERATOR SHELTER OF WELL PADS - W046S		BK-W046S-PEDCO-110-AR-DW-0001
ARCHITECTURAL DRAWING FOR WHOP/PHU SHELTER SHELTER OF WELL PADS - W046S		BK-W046S-PEDCO-110-AR-DW-0002
ARCHITECTURAL DRAWING FOR SWITCHGEAR BUILDING OF WELL PADS - W046S		BK-W046S-PEDCO-110-AR-DW-0003
ARCHITECTURAL DRAWING FOR SECURITY BUILDING OF WELL PADS - W046S		BK-W046S-PEDCO-110-AR-DW-0004
ABBREVIATIONS		
F.T.	FUEL TANK	
S.R.	SECURITY ROOM	
S.G.	SWITCH GEAR	
F.F.	FIRE FIGHTING SHELTER	
D.G	DIESEL GENERATOR SHELTER	

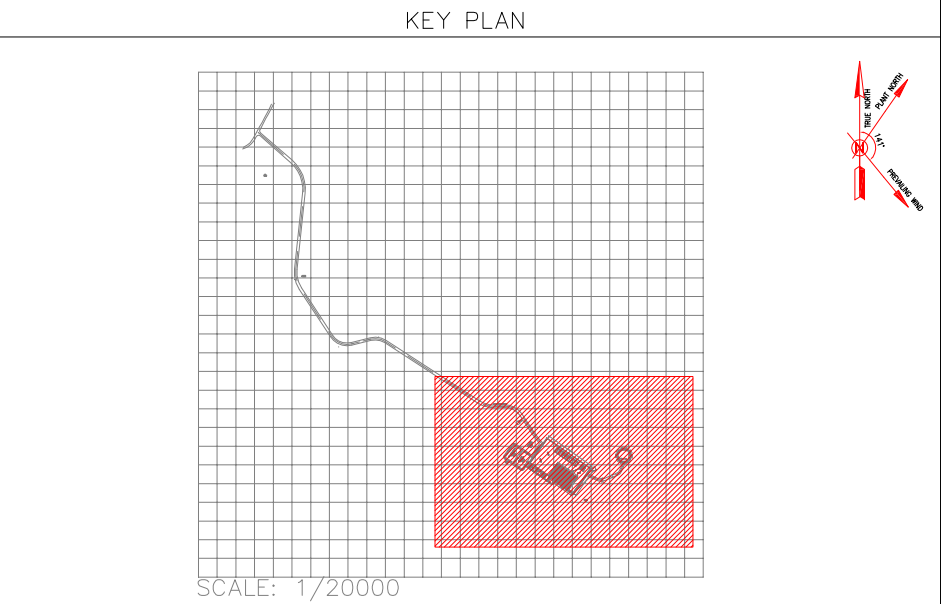

Coordinate of Bench Marks (UTM)			
Points	Northing (m)	Easting (m)	Elevation (m)
BM48	435082.354	3294748.888	41.668
GPS3	435475.560	3294403.536	66.866
GPS1	435686.115	3294303.397	78.025

D03 TOTALLY REVISED


D03	FEB.2023	IFA	R.BERLOUE	M.FAKHARIAN	M.MEHRSHAD	***								
D02	NOV.2022	IFA	R.BERLOUE	M.FAKHARIAN	M.MEHRSHAD	***	***	*****	***	*****	***	*****		
D01	SEP.2022	IFA	R.BERLOUE	M.FAKHARIAN	M.MEHRSHAD	***	REV.	DESCRIPTION	BY	DATE	BY	DATE		
D00	MAY.2022	IFC	R.BERLOUE	M.FAKHARIAN	M.MEHRSHAD	***			CHECKED				REV. APPR.	
REV.	DATE	P.O.I.S	PREP.	CHK.	APP.	AUT.			اصل و کلیه نسخ این نقشه و حق اقتباس متعلق به شرکت ملی مناطق نفت خیز جنوب می باشد.					
PROJECT NAME:							BINAK OILFIELD DEVELOPMENT/SUB-SURFACE WORK PACKAGES W046S WELLHEAD FACILITIES							
PROJECT NO.:							971020							
EPC CONTRACTOR:							EPD/EPC CONTRACTOR (GC):							
 HIRGAN ENERGY - DESIGN & INSPECTION COMPANIES							 PETROIRAN DEVELOPMENT COMPANY							
 							BINAK OILFIELD DEVELOPMENT SUB-SURFACE WORK PACKAGES W046S WELLHEAD FACILITIES							
							DATE	SCALE	DRAWING BY	CHECKED BY	PROJECT ENG.			
DRAWING TITLE:							NO CONSTRUCTION PERMITTED UNLESS DRAWING APPROVED							
General Civil Layout – W046 (Location Map)							APPROVED FOR CONSTRUCTION							
SCALE	SIZE	DRAWING NO.			SHEET NO.	REV.	BUDGET REF.	LOCATION	SIZE	CLASS	SERIAL NO.	SHEET	REVISION	
1:1000	A1	BK-W046S-PEDCO-110-CV-PY-0001			1 OF 4	D03	053-073-9184	F	4	A	707653	1	D03	
							BY:							DATE:

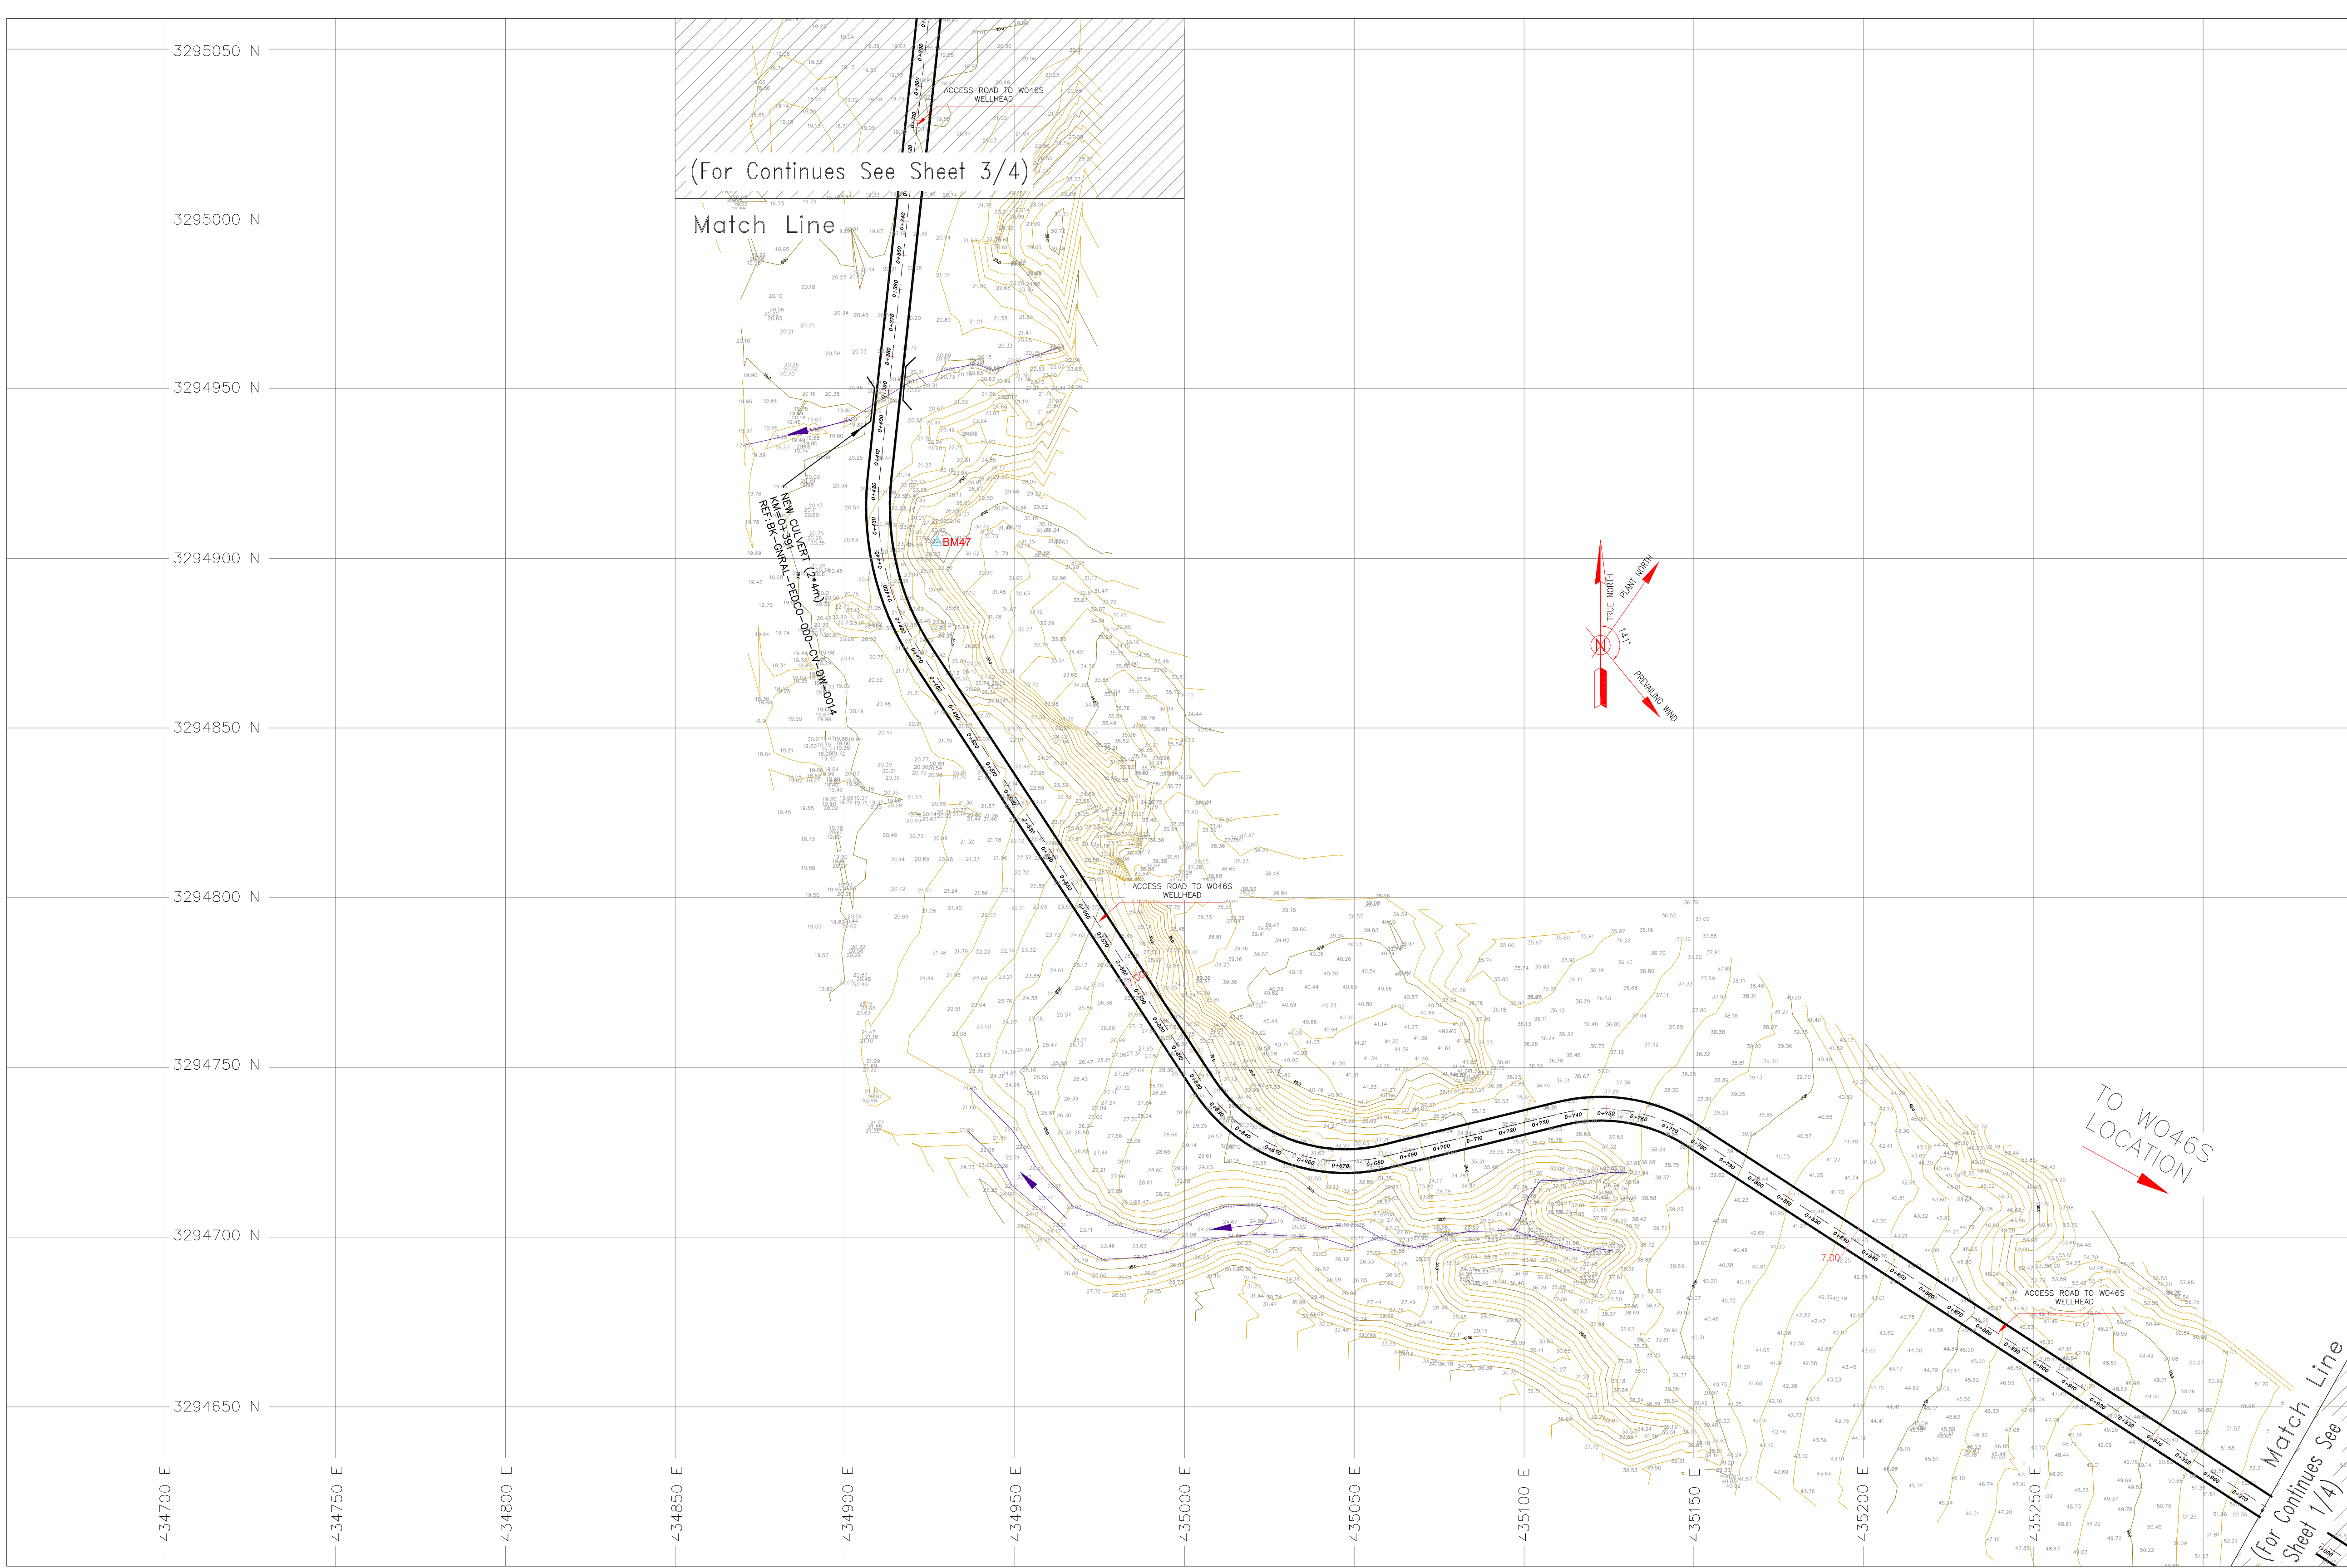

- NOTES
- 1- ALL COORDINATES AND ELEVATIONS ARE IN METER.
 - 2- ALL DRAWINGS SHALL BE CHECKED BY CONTRACTOR WITH RELATIVE DRAWINGS BEFORE CONSTRUCTION.
 - 3-GEODETIC PARAMETERS FOR COORDINATES ARE AS BELOW:
HORIZONTAL COORDINATE SYSTEM: WGS84/UTM ZONE 39
ELLIPSOID : WORLD GEODETIC SYSTEM 1984 (WGS84)
MAP PROJECTION: UNIVERSAL TRANSVERSE MERCATOR (UTM)
VERTICAL DATUM: MEAN SEA LEVEL
 - 4-THE SUITABLE MATERIAL FOR FILLING SHALL BE COLLECTED BASED ON TO THE BELOW RULES:
 - PROJECT GEOTECHNICAL INVESTIGATION REPORT, BORROW MATERIALS AND SPECIFICATION STUDY PART.
 - "GENERAL SPECIFICATION FOR ROAD" NO. 101, SECTION 207, IRAN PLANNING AND BUDGET ORGANIZATION.
 - PROJECT GENERAL SPECIFICATION "SPECIFICATION FOR EARTH WORK" DOCUMENT NUMBER "BK-GNRL-PEDCO-000-CV-SP-0004".
 - GEOTECHNICAL REPORTS AND CLIENT'S SITE SUPERVISORY BODY RECOMMENDATIONS AND APPROVALS
 - 5-BEFORE ANY EARTH WORK ACTIVITIES (CUT OR FILL), TOP AND UNSUITABLE SOIL (MARN,...) SHALL BE REMOVED AS GEOTECHNICAL RECOMMENDATION AND SUPERVISOR'S REQUIREMENTS.
 - 6-THE WASTE PIT SHALL BE COVERED WITH A LAYER OF GEOTEXTILE(ONE LAYER, MIN 600 KG/M2/) AND GEOMEMBRANE (MIN 1.5 MM THICKNESS, 7 M WIDTH) BASED ON CIVIL DESIGN SPECIFICATION DOCUMENTS. THE COVER SHALL EXTEND BEYOND THE OUTER EDGES OF THE PIT TO COVER AND ENTIRELY ENCAPSULATE THE PIT AND SHALL BE SLOPED TO PROVIDE SURFACE DRAINAGE AWAY FROM THE PIT.
 - 7-THE WATER POOL IS NOT CLIENT REQUIREMENT.

LEGEND			
	Existing GRAVEL ROAD		CHANNEL
	New GRAVEL ROAD		RIVER
	ASPHALT ROAD		WATER COURSE
	STAIR		CONTOURS
	TRENCH		SPOT HEIGHT
	FENCE	99.27	SPOT HEIGHT
	BURNING PIT LINE		BENCH MARK
	WATER LINE		
	BUILDING		CULVERT
	CONCRETE AREA		WELL LOCATION
	SEPTIC		WELL
	MANHOLE		BURNPIT
	POLE		SITE (LOCATION)
	HELIPAD		DRILLING CONEX AREA
	GEOMEMBRANE AREA		POWER LINE


REFERENCE DRAWING		DRG. No.
Civil and Structural drawings - W046S		BK-W046S-PEDCO-110-CV-PY-0002
Rough Grading Plans - W046S		BK-W046S-PEDCO-110-CV-DW-0001
Plot Plan Drawing - W046S		BK-W046S-PEDCO-110-PH-DW-0001
Standard Drawing For Fence & Gate Details		BK-GNRL-PEDCO-000-CV-DW-0009
ARCHITECTURAL DRAWING FOR DIESEL GENERATOR SHELTER OF WELL PADS - W046S		BK-W046S-PEDCO-110-AR-DW-0001
ARCHITECTURAL DRAWING FOR WHOP/HPU SHELTER OF WELL PADS - W046S		BK-W046S-PEDCO-110-AR-DW-0002
ARCHITECTURAL DRAWING FOR SECURITY BUILDING OF WELL PADS - W046S		BK-W046S-PEDCO-110-AR-DW-0003
ARCHITECTURAL DRAWING FOR SECURITY BUILDING OF WELL PADS - W046S		BK-W046S-PEDCO-110-AR-DW-0004
ABBREVIATIONS		
F.T.	FUEL TANK	
S.R.	SECURITY ROOM	
S.G.	SWITCH GEAR	
F.F.	FIRE FIGHTING SHELTER	
D.G	DIESEL GENERATOR SHELTER	

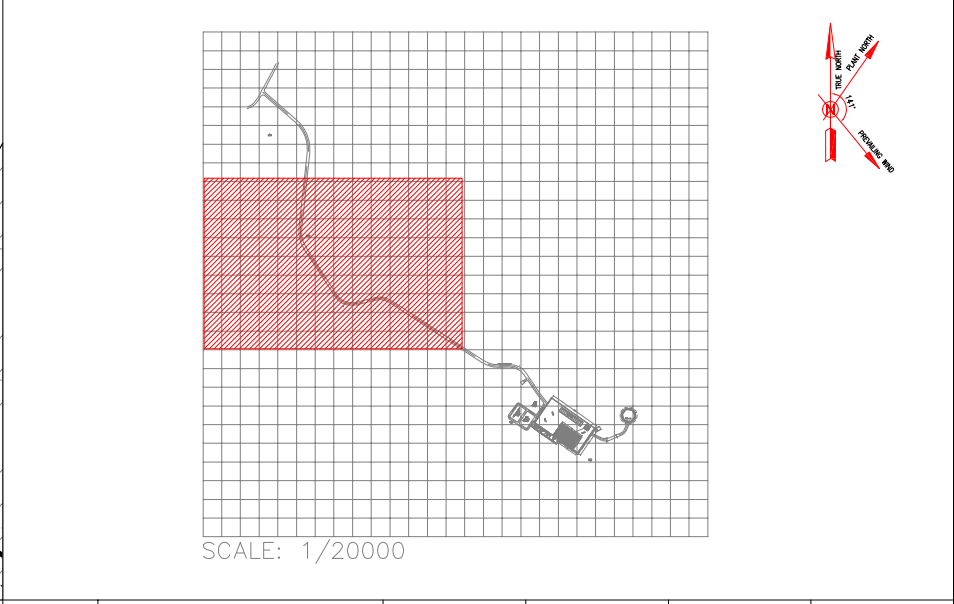



Coordinate of Bench Marks (UTM)			
Points	Northing (m)	Easting (m)	Elevation (m)
BM48	435082.354	3294748.888	41.668
GPS3	435475.560	3294403.536	66.866
GPS1	435686.115	3294303.397	78.025

D03 TOTALLY REVISED

D03	FEB.2023	IFA	R.BERLOUE	M.FAKHARIAN	M.MEHRSHAD	***							
D02	NOV.2022	IFA	R.BERLOUE	M.FAKHARIAN	M.MEHRSHAD	***	***	*****	***	*****	***	*****	
D01	SEP.2022	IFA	R.BERLOUE	M.FAKHARIAN	M.MEHRSHAD	***							
D00	MAY.2022	IFC	R.BERLOUE	M.FAKHARIAN	M.MEHRSHAD	***							
REV.	DATE	P.O.I.S	PREP.	CHK.	APP.	AUT.	REV.	DESCRIPTION	BY	DATE	BY	DATE	
									CHECKED	REV. APPR.			
PROJECT NAME:							اسم و کلیه نسخ این نقشه و حق اقتباس متعلق به شرکت ملی مناطق نفت خیز جنوب میباشد.						
PROJECT NO.:							THE ORIGINAL AND ALL COPIES OF THIS DRAWING TOGETHER WITH THE COPYRIGHT THEREIN ARE THE SOLE PROPERTY OF N.I.S.O.C./ FIELDS						
EPC CONTRACTOR:							BINAK OILFIELD DEVELOPMENT SUB-SURFACE WORK PACKAGES W046S WELLHEAD FACILITIES						
 HIRGAN ENERGY - DESIGN & INSPECTION COMPANIES							 PETROIRAN DEVELOPMENT COMPANY						
							DATE	SCALE	DRAWING BY	CHECKED BY	PROJECT ENG.		
DRAWING TITLE:							NO CONSTRUCTION PERMITTED UNLESS DRAWING APPROVED						
General Civil Layout - W046 (Location Map)							APPROVED FOR CONSTRUCTION		BY:		DATE:		
SCALE	SIZE	DRAWING NO.			SHEET NO.	REV.	BUDGET REF.	LOCATION	SIZE	CLASS	SERIAL NO.	SHEET	REVISION
1:1000	A1	BK-W046S-PEDCO-110-CV-PY-0001			2 OF 4	D03	053-073-9184	F	4	A	707653	2	D03

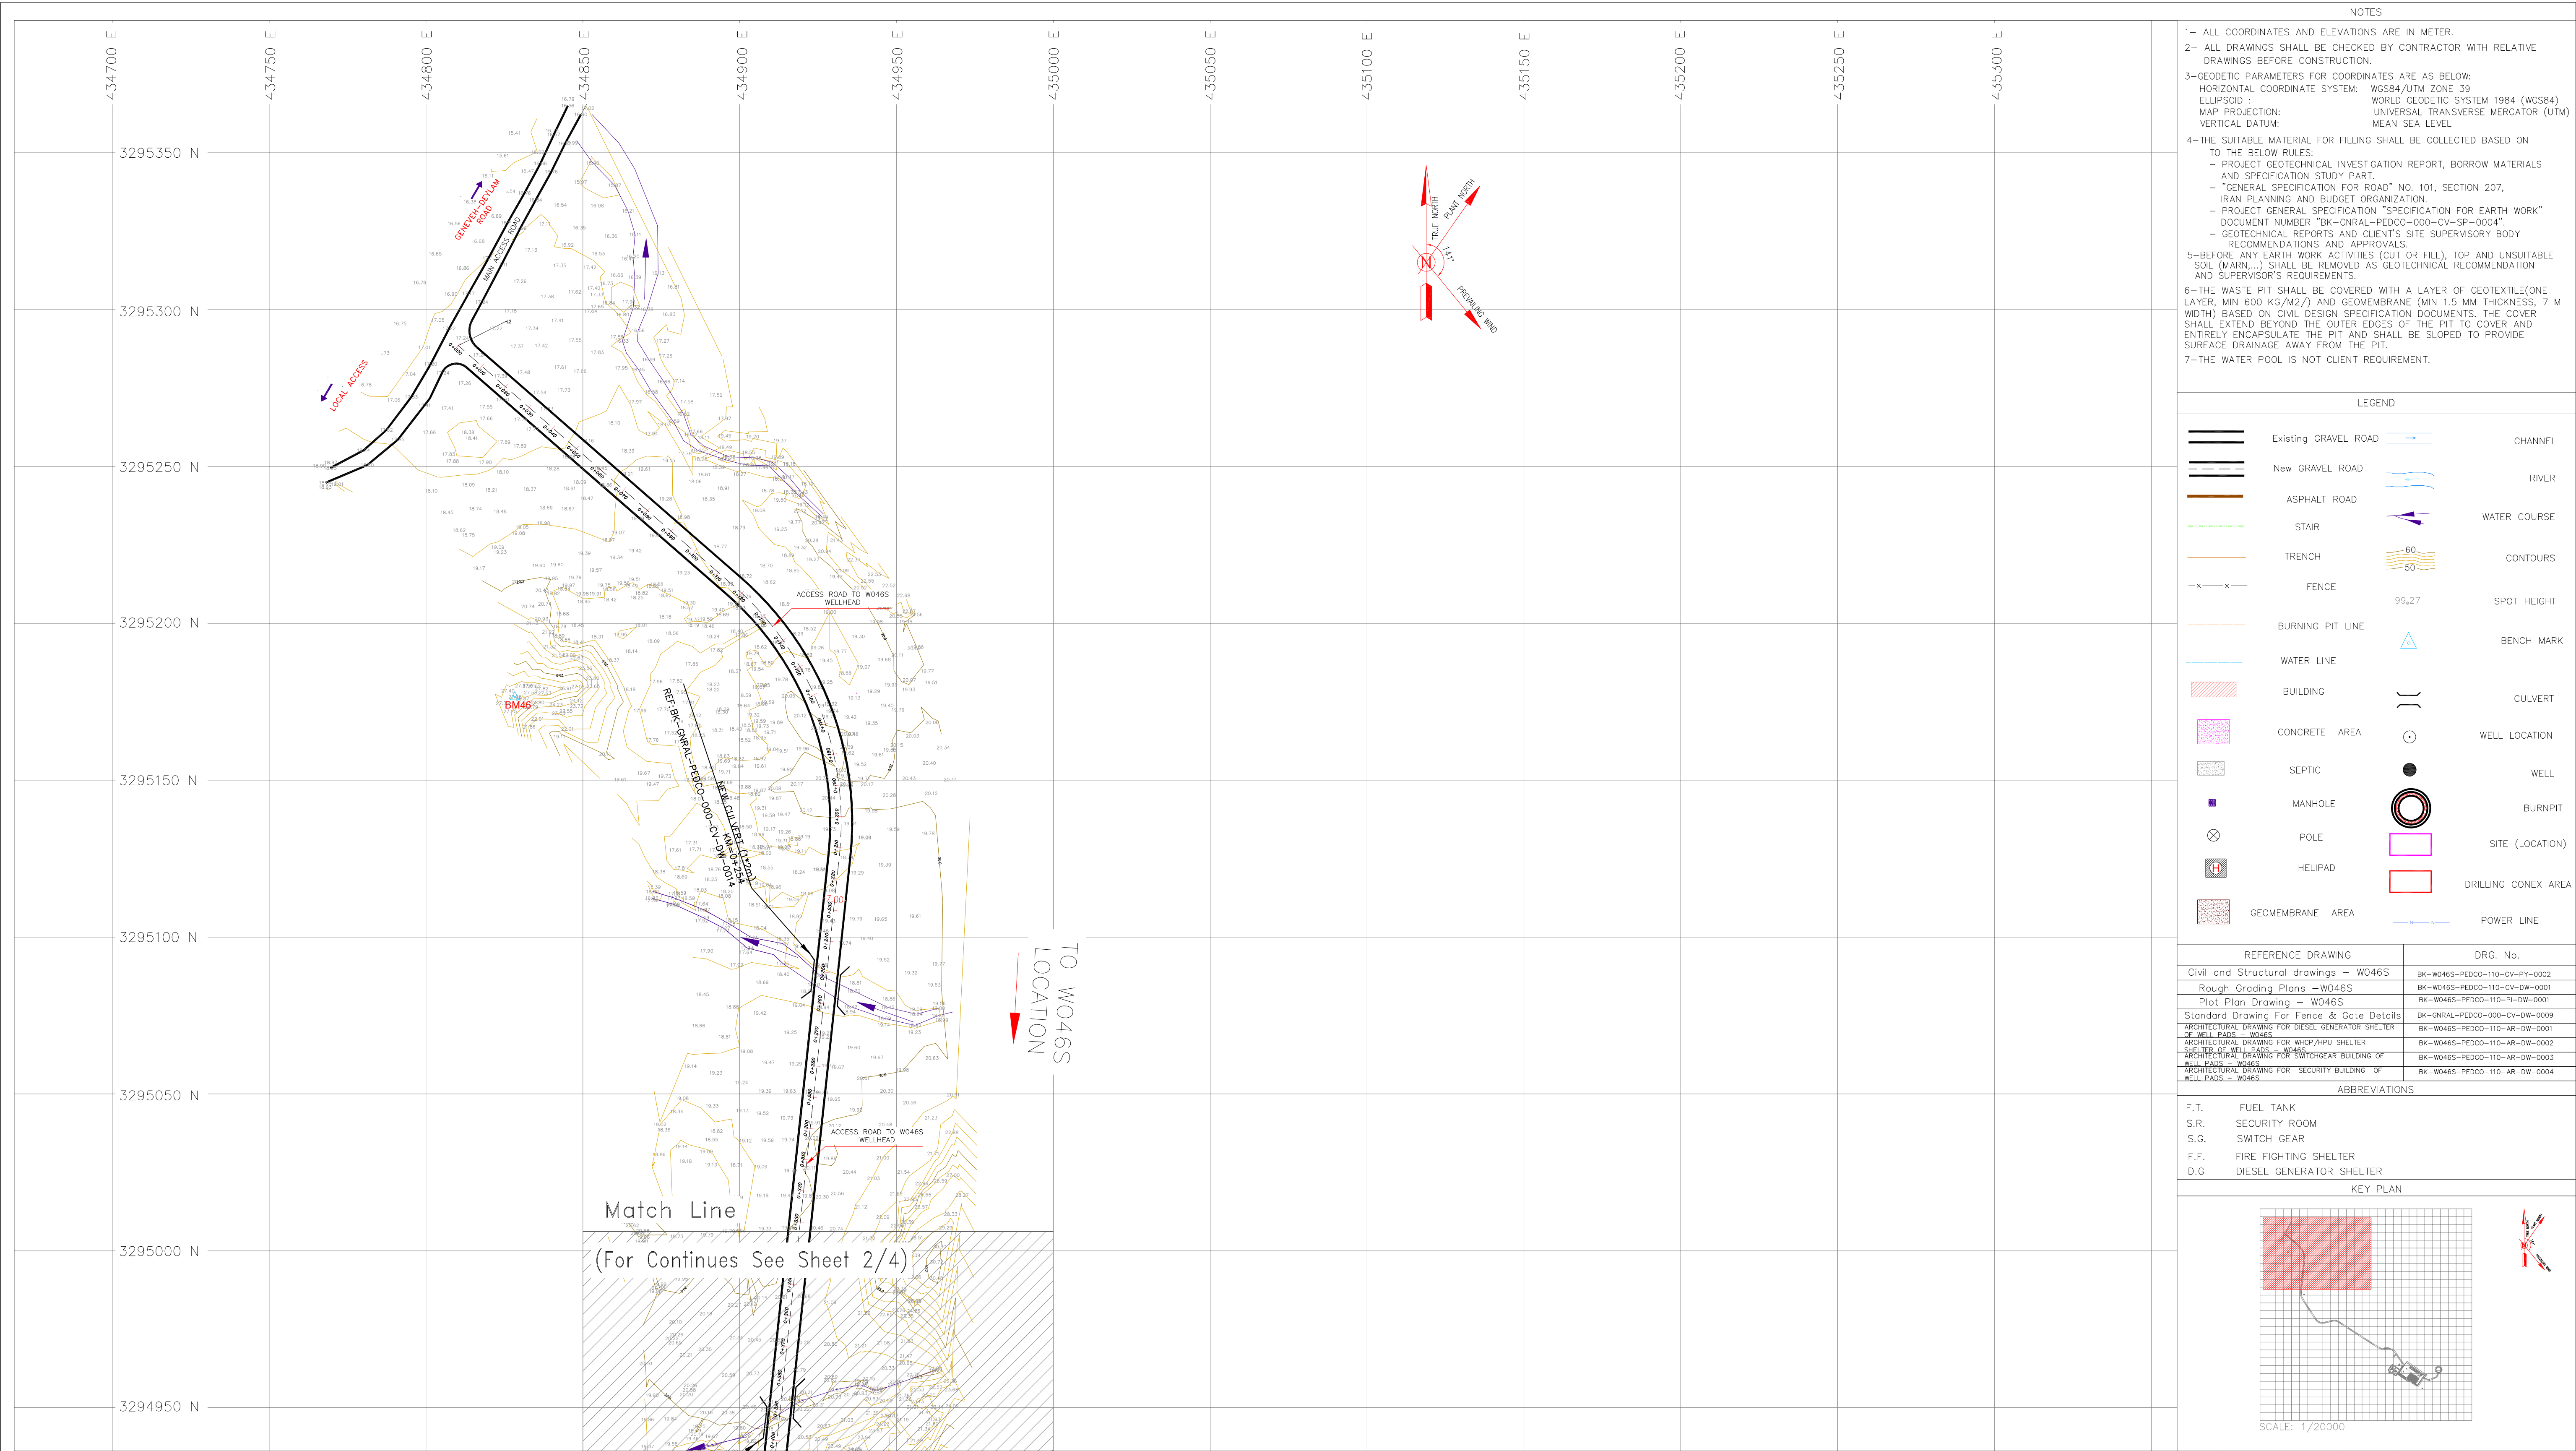


- NOTES
- 1- ALL COORDINATES AND ELEVATIONS ARE IN METER.
 - 2- ALL DRAWINGS SHALL BE CHECKED BY CONTRACTOR WITH RELATIVE DRAWINGS BEFORE CONSTRUCTION.
 - 3-GEODETIC PARAMETERS FOR COORDINATES ARE AS BELOW:
HORIZONTAL COORDINATE SYSTEM: WGS84/UTM ZONE 39
ELLIPSOID : WORLD GEODETIC SYSTEM 1984 (WGS84)
MAP PROJECTION: UNIVERSAL TRANSVERSE MERCATOR (UTM)
VERTICAL DATUM: MEAN SEA LEVEL
 - 4-THE SUITABLE MATERIAL FOR FILLING SHALL BE COLLECTED BASED ON TO THE BELOW RULES:
 - PROJECT GEOTECHNICAL INVESTIGATION REPORT, BORROW MATERIALS AND SPECIFICATION STUDY PART.
 - "GENERAL SPECIFICATION FOR ROAD" NO. 101, SECTION 207, IRAN PLANNING AND BUDGET ORGANIZATION.
 - PROJECT GENERAL SPECIFICATION "SPECIFICATION FOR EARTH WORK" DOCUMENT NUMBER "BK-GNRL-PEDCO-000-CV-SP-0004".
 - GEOTECHNICAL REPORTS AND CLIENT'S SITE SUPERVISORY BODY RECOMMENDATIONS AND APPROVALS.
 - 5-BEFORE ANY EARTH WORK ACTIVITIES (CUT OR FILL), TOP AND UNSUITABLE SOIL (MARN,...) SHALL BE REMOVED AS GEOTECHNICAL RECOMMENDATION AND SUPERVISOR'S REQUIREMENTS.
 - 6-THE WASTE PIT SHALL BE COVERED WITH A LAYER OF GEOTEXTILE(ONE LAYER, MIN 600 KG/M2/) AND GEOMEMBRANE (MIN 1.5 MM THICKNESS, 7 M WIDTH) BASED ON CIVIL DESIGN SPECIFICATION DOCUMENTS. THE COVER SHALL EXTEND BEYOND THE OUTER EDGES OF THE PIT TO COVER AND ENTIRELY ENCAPSULATE THE PIT AND SHALL BE SLOPED TO PROVIDE SURFACE DRAINAGE AWAY FROM THE PIT.
 - 7-THE WATER POOL IS NOT CLIENT REQUIREMENT.

  LEGEND			
	Existing GRAVEL ROAD		CHANNEL
	New GRAVEL ROAD		RIVER
	ASPHALT ROAD		
	STAIR		WATER COURSE
	TRENCH		CONTOURS
	FENCE	99,27	SPOT HEIGHT
	BURNING PIT LINE		BENCH MARK
	WATER LINE		
	BUILDING		CULVERT
	CONCRETE AREA		WELL LOCATION
	SEPTIC		WELL
	MANHOLE		BURNPIT
	POLE		SITE (LOCATION)
	HELIPAD		DRILLING CONEX AREA
	GEOMEMBRANE AREA		POWER LINE

REFERENCE DRAWING		DRG. No.
Civil and Structural drawings - W046S		BK-W046S-PEDCO-110-CV-PY-0002
Rough Grading Plans - W046S		BK-W046S-PEDCO-110-CV-DW-0001
Plot Plan Drawing - W046S		BK-W046S-PEDCO-110-PI-DW-0001
Standard Drawing For Fence & Gate Details		BK-GNRL-PEDCO-000-CV-DW-0009
ARCHITECTURAL DRAWING FOR DIESEL GENERATOR SHELTER OF WELL PADS - W046S		BK-W046S-PEDCO-110-AR-DW-0001
ARCHITECTURAL DRAWING FOR WHOP/HPU SHELTER OF WELL PADS - W046S		BK-W046S-PEDCO-110-AR-DW-0002
ARCHITECTURAL DRAWING FOR SW SHELTER OF WELL PADS - W046S		BK-W046S-PEDCO-110-AR-DW-0003
ARCHITECTURAL DRAWING FOR SECURITY BUILDING OF WELL PADS - W046S		BK-W046S-PEDCO-110-AR-DW-0004


ABBREVIATIONS	
F.T.	FUEL TANK
S.R.	SECURITY ROOM
S.G.	SWITCH GEAR
F.F.	FIRE FIGHTING SHELTER
D.G.	DIESEL GENERATOR SHELTER

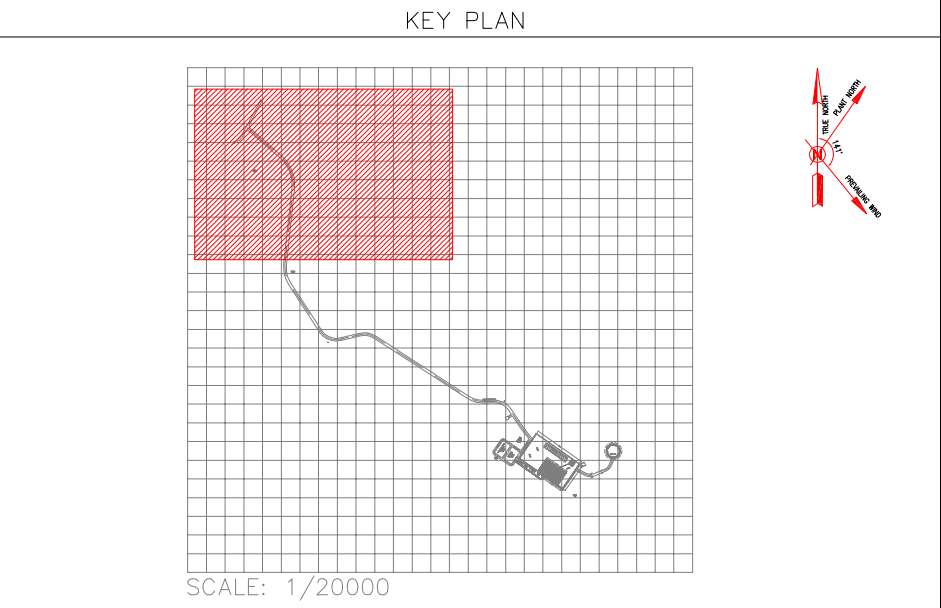

Coordinate of Bench Marks (UTM)			
Points	Northing (m)	Easting (m)	Elevation (m)
BM48	435082.354	3294748.888	41.668
GPS3	435475.560	3294403.536	66.866
GPS1	435686.115	3294303.397	78.025

TOTALLY REVISED


D03	FEB.2023	IFA	R.BERLOUE	M.FAKHARIAN	M.MEHRSHAD	***							
D02	NOV.2022	IFA	R.BERLOUE	M.FAKHARIAN	M.MEHRSHAD	***	***	*****	***	*****	***	*****	
D01	SEP.2022	IFA	R.BERLOUE	M.FAKHARIAN	M.MEHRSHAD	***	REV.	DESCRIPTION	BY	DATE	BY	DATE	
D00	MAY.2022	IFC	R.BERLOUE	M.FAKHARIAN	M.MEHRSHAD	***			CHECKED		REV.	APPR.	
REV.	DATE	P.O.I.S	PREP.	CHK.	APP.	AUT.	اصل و کلیه نسخ این نقشه و حق اقتباس متعلق به شرکت ملای مناطق نفت خیز جنوب میباشد.						
PROJECT NAME:							BINAK OILFIELD DEVELOPMENT/SUB-SURFACE WORK PACKAGES W046S WELLHEAD FACILITIES						
PROJECT NO.:							971020						
EPC CONTRACTOR:							EPD/EPC CONTRACTOR (GC):						
 HIRGAN ENERGY - DESIGN & INSPECTION COMPANIES							 PETROIRAN DEVELOPMENT COMPANY						
 <													

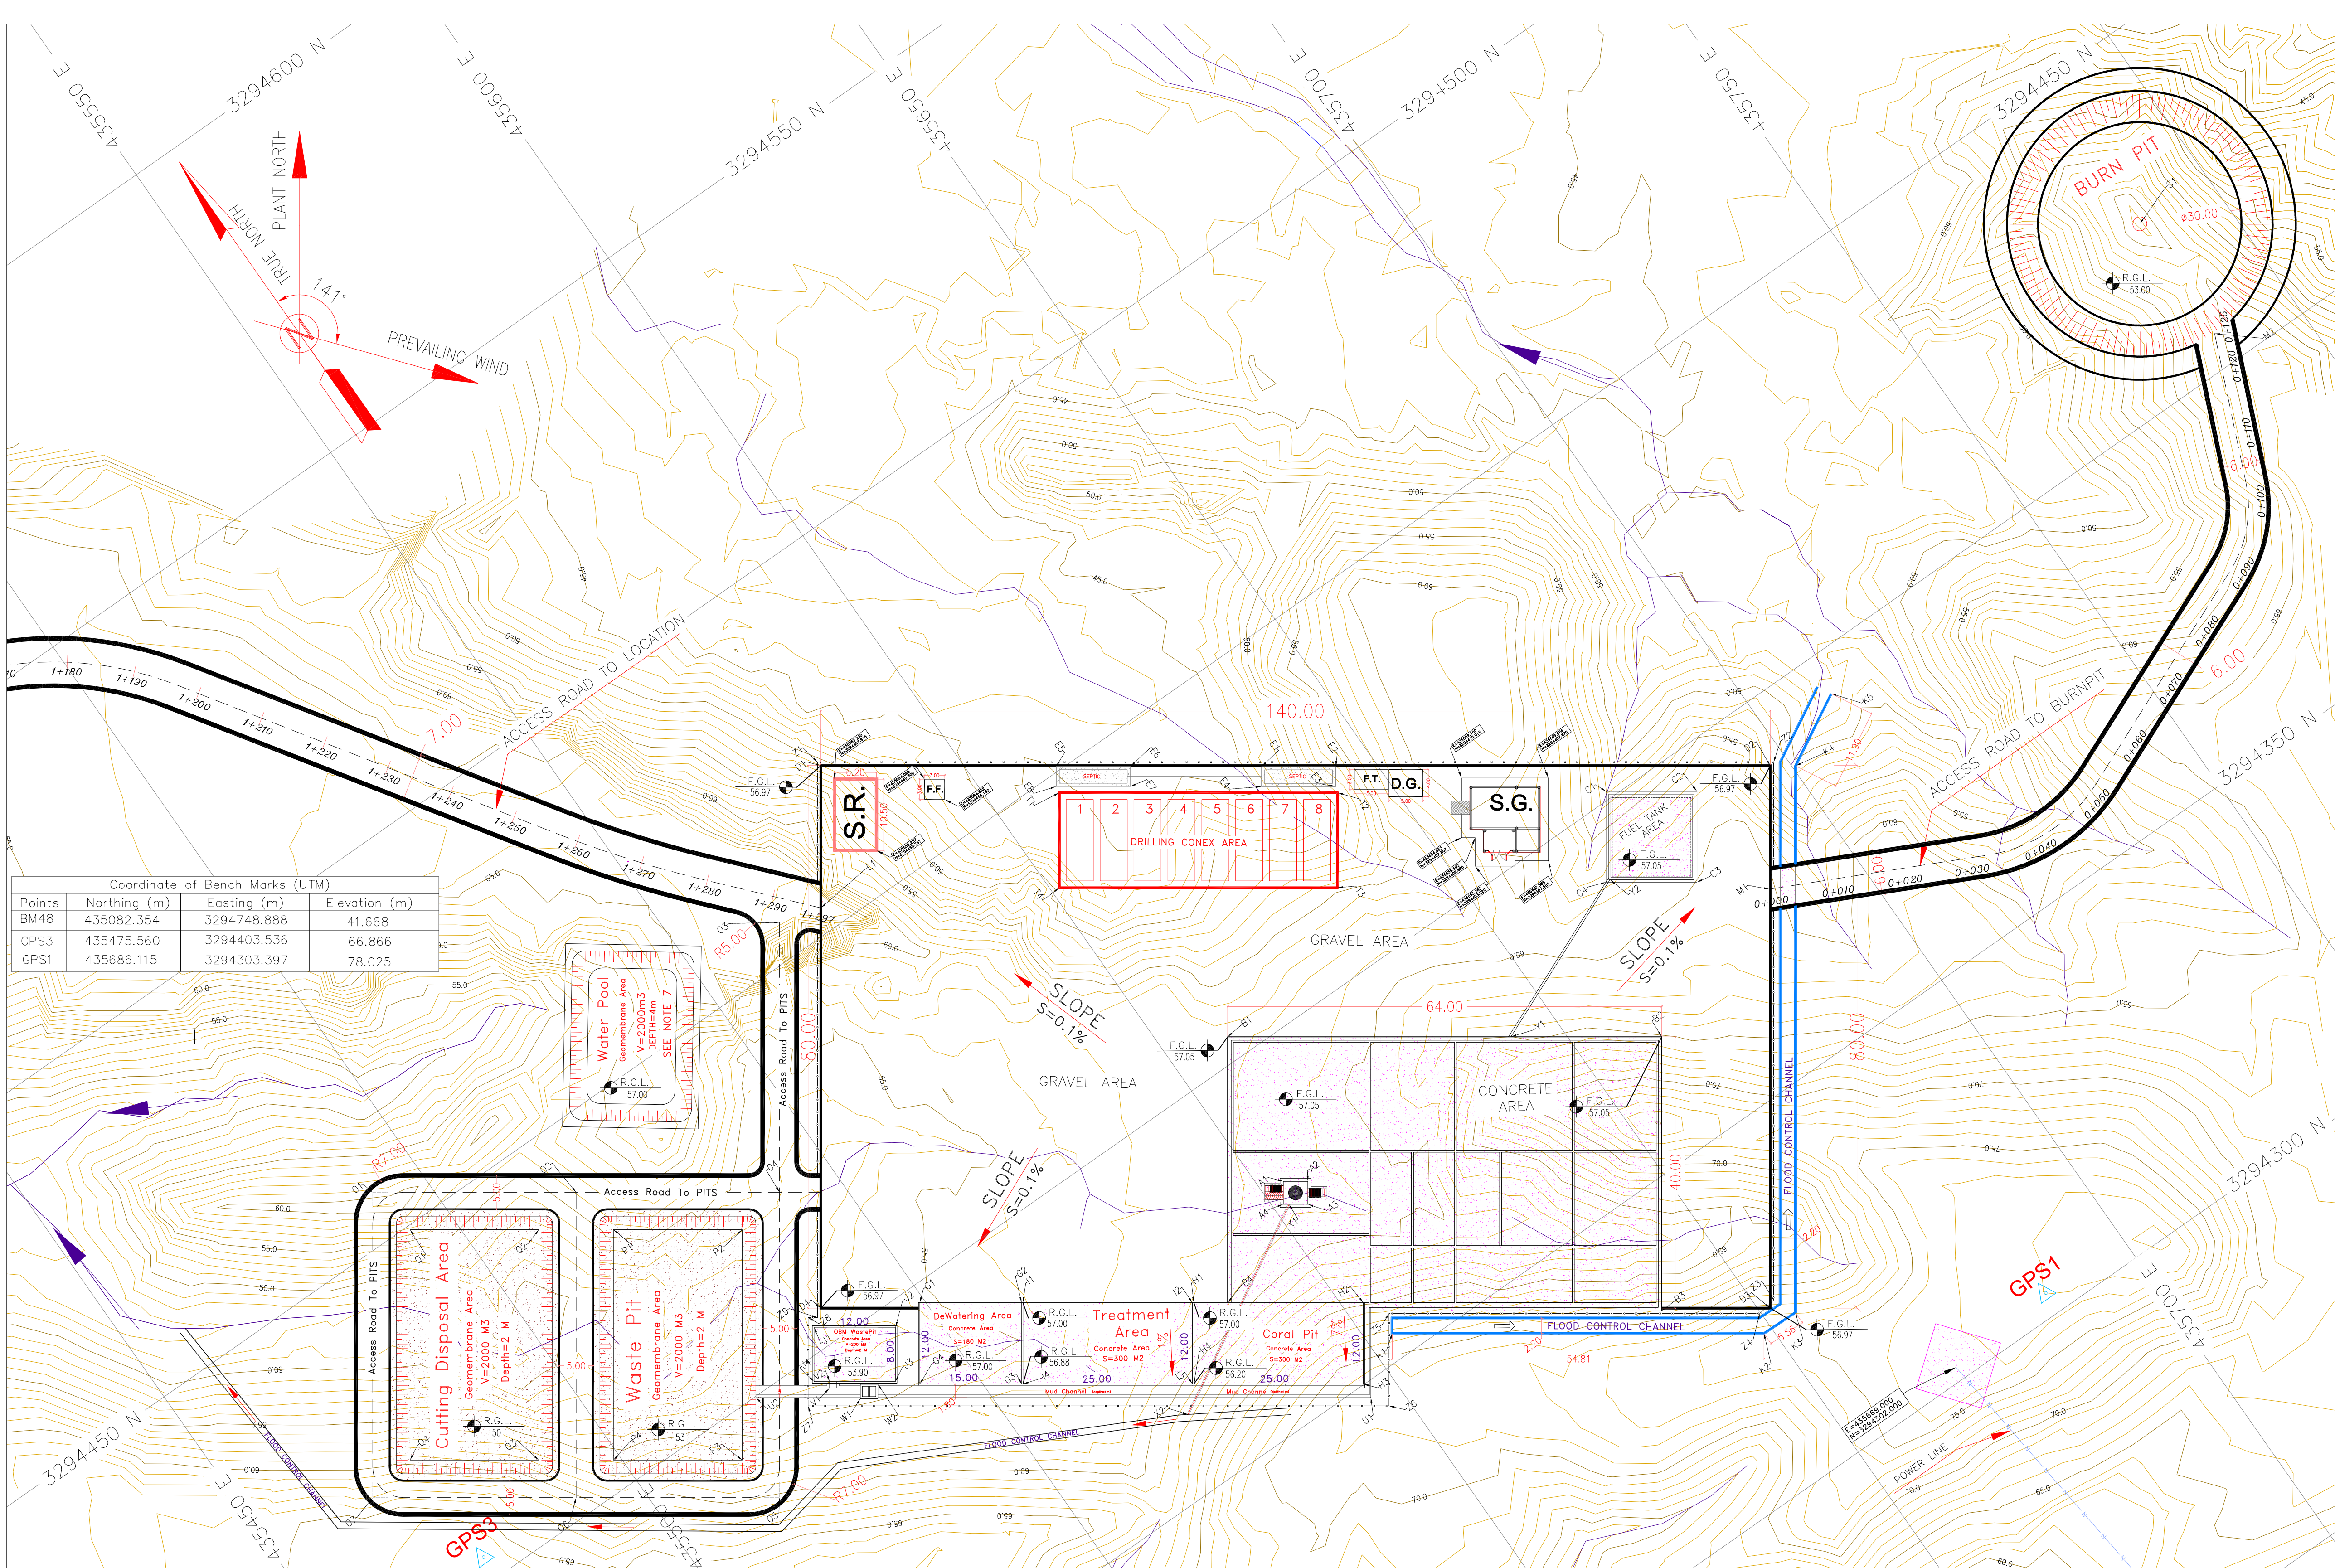

- NOTES
- 1- ALL COORDINATES AND ELEVATIONS ARE IN METER.
 - 2- ALL DRAWINGS SHALL BE CHECKED BY CONTRACTOR WITH RELATIVE DRAWINGS BEFORE CONSTRUCTION.
 - 3-GEODETIC PARAMETERS FOR COORDINATES ARE AS BELOW:
HORIZONTAL COORDINATE SYSTEM: WGS84/UTM ZONE 39
ELLIPSOID : WORLD GEODETIC SYSTEM 1984 (WGS84)
MAP PROJECTION: UNIVERSAL TRANSVERSE MERCATOR (UTM)
VERTICAL DATUM: MEAN SEA LEVEL
 - 4-THE SUITABLE MATERIAL FOR FILLING SHALL BE COLLECTED BASED ON TO THE BELOW RULES:
 - PROJECT GEOTECHNICAL INVESTIGATION REPORT, BORROW MATERIALS AND SPECIFICATION STUDY PART.
 - "GENERAL SPECIFICATION FOR ROAD" NO. 101, SECTION 207, IRAN PLANNING AND BUDGET ORGANIZATION.
 - PROJECT GENERAL SPECIFICATION "SPECIFICATION FOR EARTH WORK" DOCUMENT NUMBER "BK-GNARL-PEDCO-000-CV-SP-0004".
 - GEOTECHNICAL REPORTS AND CLIENT'S SITE SUPERVISORY BODY RECOMMENDATIONS AND APPROVALS.
 - 5-BEFORE ANY EARTH WORK ACTIVITIES (CUT OR FILL), TOP AND UNSUITABLE SOIL (MARL,...) SHALL BE REMOVED AS GEOTECHNICAL RECOMMENDATION AND SUPERVISOR'S REQUIREMENTS.
 - 6-THE WASTE PIT SHALL BE COVERED WITH A LAYER OF GEOTEXTILE(ONE LAYER, MIN 600 KG/M2/) AND GEOMEMBRANE (MIN 1.5 MM THICKNESS, 7 M WIDTH) BASED ON CIVIL DESIGN SPECIFICATION DOCUMENTS. THE COVER SHALL EXTEND BEYOND THE OUTER EDGES OF THE PIT TO COVER AND ENTIRELY ENCAPSULATE THE PIT AND SHALL BE SLOPED TO PROVIDE SURFACE DRAINAGE AWAY FROM THE PIT.
 - 7-THE WATER POOL IS NOT CLIENT REQUIREMENT.

LEGEND			
	Existing GRAVEL ROAD		CHANNEL
	New GRAVEL ROAD		RIVER
	ASPHALT ROAD		WATER COURSE
	STAIR		
	TRENCH		CONTOURS
	FENCE	99.27	SPOT HEIGHT
	BURNING PIT LINE		BENCH MARK
	WATER LINE		
	BUILDING		CULVERT
	CONCRETE AREA		WELL LOCATION
	SEPTIC		WELL
	MANHOLE		BURNPIT
	POLE		SITE (LOCATION)
	HELIPAD		DRILLING CONEX AREA
	GEOMEMBRANE AREA		POWER LINE

REFERENCE DRAWING		DRG. No.
Civil and Structural drawings - W046S		BK-W046S-PEDCO-110-CV-PY-0002
Rough Grading Plans - W046S		BK-W046S-PEDCO-110-CV-DW-0001
Plot Plan Drawing - W046S		BK-W046S-PEDCO-110-PH-DW-0001
Standard Drawing For Fence & Gate Details		BK-GNARL-PEDCO-000-CV-DW-0009
ARCHITECTURAL DRAWING FOR DIESEL GENERATOR SHELTER OF WELL PADS - W046S		BK-W046S-PEDCO-110-AR-DW-0001
ARCHITECTURAL DRAWING FOR WHOP/HPU SHELTER OF WELL PADS - W046S		BK-W046S-PEDCO-110-AR-DW-0002
SHELTER OF WELL PADS - W046S		BK-W046S-PEDCO-110-AR-DW-0003
ARCHITECTURAL DRAWING FOR SECURITY BUILDING OF WELL PADS - W046S		BK-W046S-PEDCO-110-AR-DW-0004
ABBREVIATIONS		
F.T.	FUEL TANK	
S.R.	SECURITY ROOM	
S.G.	SWITCH GEAR	
F.F.	FIRE FIGHTING SHELTER	
D.G.	DIESEL GENERATOR SHELTER	

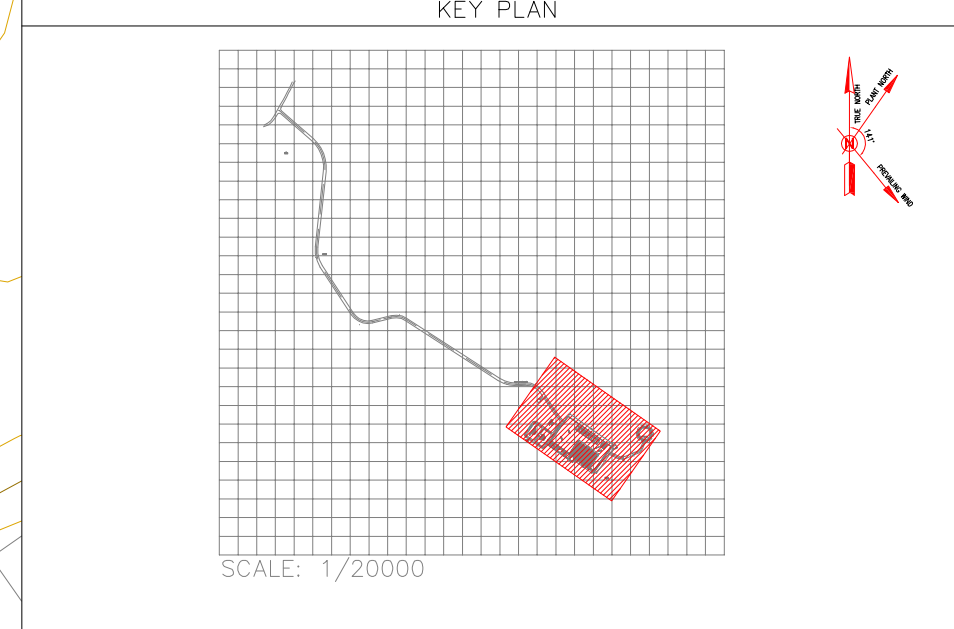

AREA NAME	DESCRIPTION	UTM--COORDINATE (ZONE 39N)	REMARKS & Reference Drawing	AREA NAME	DESCRIPTION	UTM--COORDINATE (ZONE 39N)	REMARKS & Reference Drawing	AREA NAME	DESCRIPTION	UTM--COORDINATE (ZONE 39N)	REMARKS & Reference Drawing	AREA NAME	DESCRIPTION	UTM--COORDINATE (ZONE 39N)	REMARKS & Reference Drawing	
AREA-A	CELLAR	NAME	EASTING(m)	NORTHING(m)	AREA-F	HELIPAD AREA	NAME	EASTING(m)	NORTHING(m)	AREA-L	ACCESS ROAD TO WELL	NAME	EASTING(m)	NORTHING(m)	AREA-S	BURN PIT
		A1	435603.432	3294381.584			F1	435435.661	3294545.491			L1	435570.704	3294453.510		
		A2	435606.422	3294379.291			F2	435443.619	3294537.066			L2	434810.281	3295285.523		
		A3	435604.472	3294376.506			F3	435443.212	3294537.066			M1	435686.879	3294375.554		
		A4	435601.482	3294378.599			F4	435435.224	3294537.503			M2	435787.654	3294405.020		
		B1	435608.951	3294403.522			G1	435549.277	3294397.446			N1	435440.040	3294552.983		
		B2	435661.380	3294366.817			G2	435561.565	3294388.844			N2	435439.781	3294545.266		
		B3	435638.210	3294333.722			G3	435554.683	3294379.013			O1	435492.501	3294457.042		
AREA-B	CONCRETE PAD	B4	435586.469	3294371.409	AREA-G	DEWATERING AREA	G4	435542.395	3294387.616	AREA-O	ACCESS ROAD TO PIT AREA	O2	435517.077	3294439.837	AREA-U	MUD CHANNEL (CONCRETE AREA)
		C1	435675.423	3294401.175			H1	435582.373	3294374.277			O3	435564.491	3294455.254		
		C2	435686.400	3294393.490			H2	435602.853	3294359.939			O4	435541.653	3294422.632		
		C3	435678.715	3294382.513			H3	435595.971	3294350.108			O5	435515.845	3294385.768		
AREA-C	FUEL TANK	C4	435667.738	3294390.198	AREA-H	CORAL PIT (CONCRETE AREA)	H4	435575.491	3294364.446	AREA-I	TREATMENT AREA (CONCRETE AREA)	O6	435491.269	3294402.973	AREA-W	OIL TRAP (CONCRETE AREA)
		D1	435582.739	3294470.700			I1	435561.729	3294388.729			P1	435466.693	3294420.178		
		D2	435697.427	3294390.409	AREA-J	OBM WASTE PIT (CONCRETE AREA)	I2	435582.209	3294374.391			P2	435518.428	3294432.177		
		D3	435651.547	3294324.873			I3	435575.327	3294364.561			P3	435533.993	3294421.281		
AREA-D	GRAVEL AREA OF WELL PAD	D4	435536.858	3294405.164	AREA-K	FLOOD CONTROL CHANNEL	I4	435554.847	3294378.898			P4	435498.929	3294404.324	AREA-Y	PIPE CHANNEL (CONCRETE AREA)
		E1	435635.891	3294433.324			J1	435534.204	3294403.416	AREA-Q	CUTTING DISPOSAL (GEOMEMBRANE AREA)	Q1	435493.852	3294449.382		
		E2	435644.869	3294427.038			J2	435544.234	3294396.534			Q2	435509.417	3294438.486		
		E3	435643.171	3294424.613			J3	435539.686	3294389.980			Q3	435489.918	3294410.633		
AREA-E	SEPTIC AREA 1 (CONCRETE AREA)	E4	435634.191	3294430.900	AREA-K	FLOOD CONTROL CHANNEL	K1	435502.771	3294353.803	AREA-Q	CUTTING DISPOSAL (GEOMEMBRANE AREA)	Q4	435474.353	3294421.530	AREA-Z	FENCE AREA
		E5	435611.093	3294450.704			K2	435648.670	3294322.370			Q5	435489.918	3294410.633		
		E6	435620.071	3294444.417			K3	435654.224	3294322.246			Q6	435474.353	3294421.530		
		E7	435618.372	3294441.994			K4	435700.435	3294388.255			Q7	435474.353	3294421.530		
AREA-E	SEPTIC AREA 2 (CONCRETE AREA)	E8	435609.394	3294448.280			K5	435710.869	3294393.970			Q8	435474.353	3294421.530		

DO NOT TOTALLY REVISED

D03	FEB.2023	IFA	R.BERLOUE	M.FAKHARIAN	M.MEHRSHAD	**.**																				
D02	NOV.2022	IFA	R.BERLOUE	M.FAKHARIAN	M.MEHRSHAD	**.**	***	*****	** **	***.***	** **	***.***														
D01	SEP.2022	IFA	R.BERLOUE	M.FAKHARIAN	M.MEHRSHAD	**.**	REV.	DESCRIPTION	BY	DATE	BY	DATE														
D00	MAY.2022	IFC	R.BERLOUE	M.FAKHARIAN	M.MEHRSHAD	**.**					CHECKED		REV.	APPR.												
REV.	DATE	P.O.I.S	PREP.	CHK.	APP.	AUT.	 THE ORIGINAL AND ALL COPIES OF THIS DRAWING TOGETHER WITH THE COPYRIGHT THEREIN ARE THE SOLE PROPERTY OF N.I.S.O.C. / FIELDS اصل و کلیه نسخ این نقشه و حق اقتباس متعلق به شرکت ملی مناطق نفت خیز جنوب میباشد.																			
PROJECT NAME:																	BINAK OILFIELD DEVELOPMENT/SUB-SURFACE WORK PACKAGES W046S WELLHEAD FACILITIES									
PROJECT NO.:			971020																							
EPC CONTRACTOR:			EPD/EPC CONTRACTOR (GC):				BINAK OILFIELD DEVELOPMENT SUB-SURFACE WORK PACKAGES W046S WELLHEAD FACILITIES																			
 HIRGAN ENERGY – DESIGN & INSPECTION COMPANIES																										
DRAWING TITLE:							NO CONSTRUCTION PERMITTED UNLESS DRAWING APPROVED																			
General Civil Layout – W046 (Site Plan)							APPROVED FOR CONSTRUCTION BY: DATE:																			
SCALE	SIZE	DRAWING NO.			SHEET NO.	REV.	BUDGET REF.	LOCATION	SIZE	CLASS	SERIAL NO.	SHEET	REVISION													
1:500	A1	BK-W046S-PEDCO-110-CV-PY-0001			4 OF 4	D03	053-073-9184	F	4	A	707653	2	D03													