



DOCUMENT TITLE:  
INSTRUMENT LOCATION LAYOUT  
DRAWING—W046S




NOTES											
LEGEND											
REFERENCE DRAWING						DRG. No.					
P&ID-W046S						BK-W046S-PEDCO-110-PR-0001					
PLOT PLAN DRAWING-W046S						BK-W046S-PEDCO-110-PI-PY-0001					
PDMS MODEL REVIEW REPORT(60%)-W046						BK-W046-PEDCO-110-PI-RT-0001					
DATA SHEETS FOR WHCP/HPU-WELLHEADS						BK-SSORL-PEDCO-110-IN-DT-0001					
KEY PLAN											
D03	MAR.2023	IFA	P.HAJIBADDEHI	M.PAKHARIAN	SH.GHALIKAR	** **					
D02	JAN.2023	IFA	P.HAJIBADDEHI	M.PAKHARIAN	SH.GHALIKAR	** **	***	*****	** **	***,****	** **
D01	SEP.2022	IFA	P.HAJIBADDEHI	M.PAKHARIAN	SH.GHALIKAR	** **	REV.	DESCRIPTION	BY	DATE	BY
D00	MAY.2022	IPC	P.HAJIBADDEHI	M.PAKHARIAN	SH.GHALIKAR	** **		CHECKED			REV. APPR.
REV.	DATE	P.O.I.S	PREP.	CHK.	APP.	AUT.	ا عمل و کلیه نسخ این نقشه و حق اقتباس متعلق به شرکت ملی مناطق نفت خیز جنوب میباشد.				
PROJECT NAME:							THE ORIGINAL AND ALL COPIES OF THIS DRAWING TOGETHER WITH THE COPYRIGHT THEREIN ARE THE SOLE PROPERTY OF N.I.S.O.C./ FIELDS				
PROJECT NO.:							971020				
EPC CONTRACTOR:				EPC/EPD CONTRACTOR:				BINAK OILFIELD DEVELOPMENT SURFACE WORK PACKAGES WELL PADS, WELLHEAD FACILITIES, FLOW LINES & MANIFOLD			
DATE				SCALE				DRAWING BY			
CHECKED BY				PROJECT ENG.							
DRAWING TITLE:							NO CONSTRUCTION PERMITTED UNLESS DRAWING APPROVED				
INSTRUMENT LOCATION LAYOUT DRAWING - W046S							APPROVED FOR CONSTRUCTION BY: DATE:				
SCALE	SIZE	DRAWING NO.			SHEET NO.	REV.	BUDGET REF.	LOCATION	SIZE	CLASS	SERIAL NO.
1/250	A0	BK-W046S-PEDCO-110-IN-PY-0001			01 OF 02	D03	0-63-073-9184	F	2	J	


(VENDOR TITLE BLOCK)\*\*

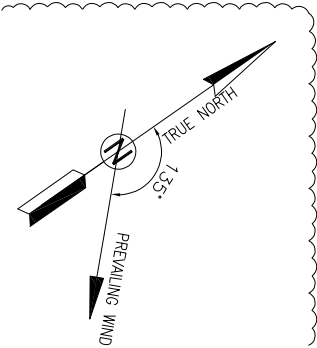



 D03  
 DIGITALLY REVISED

- 1- EACH T/1/G SHALL BE SUPPLIED WITH ADEQUATE THERMOWELL BY VENDOR.
- 2- IRP LOCATION IS ON WELHEAD (OUT OF CONTRACTOR SCORE).
- 3- IRP CONTROL PANEL WILL BE LOCATED IN SWITCH GEAR BUILDING.
- 4- LEVEL GAUGE SHALL BE PROVIDED BY DIESEL OIL DRUM VENDOR.
- 5- LEVEL GAUGE SHALL BE PROVIDED BY PORTABLE WATER TANK VENDOR.

LEGEND	
H.P.P.	HIGH POINT PAVING
----	FENCE
=====	MATCH LINE
○	WELL LOCATION
	TRENCH
	TEMPERATURE GAUGE
	PRESSURE GAUGE
REFERENCE DRAWING	DWG. No.
PAD-WAYS	BK-W04S-PBDC-110-PR-0001
PLOT PLAN DRAWING-W04S	BK-W04S-PBDC-110-PI-PY-0001
PUMP MODEL, BENTON REPORT(604) W046	BK-W046-PBDC-110-PI-PT-0001
DATA SHEETS FOR WHP/HPV-WELLSHEADS BK-S004L-PBDC-110-IN-DT-0001	

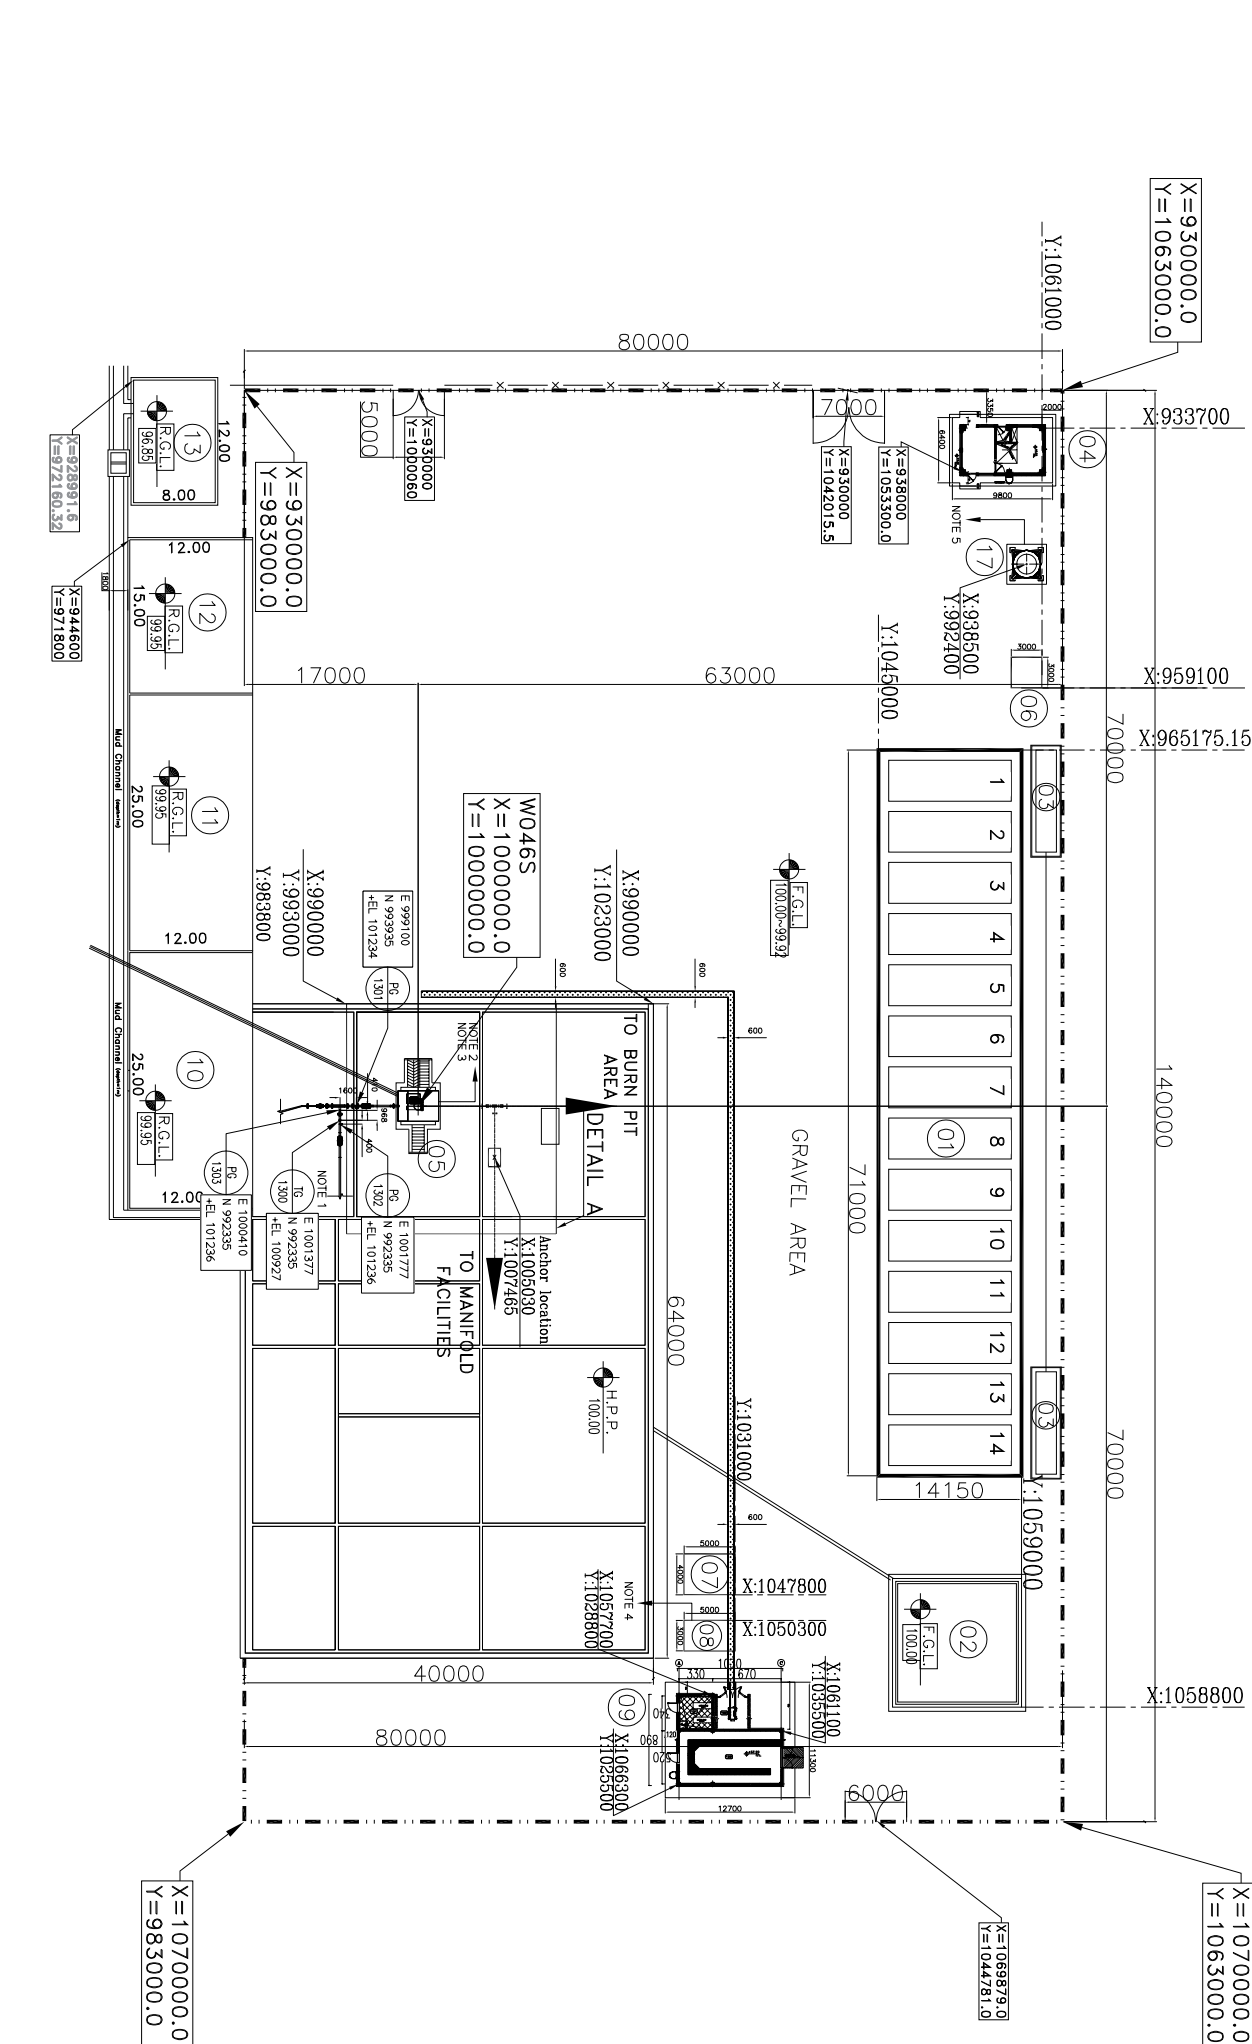

TAG NO.	AREA LIST
01	DRINKING CONEX AREA
02	FUEL TANK AREA
03	SEPTIC
04	SECURITY ROOM
05	IPP PUMP
06	FREIGHTING SHUTTER
07	DIESEL GENERATOR
08	DIESEL GENERATOR FUEL TANK
09	SWITCHGEAR
10	CORAL PIT
11	TREATMENT AREA
12	DRAINING AREA
13	OBH WASTEWATER
14	WASTE PIT
15	CUTTING DISPOSAL AREA
16	DELTED
17	POTABLE WATER TANK
18	HELIPAD
19	BURN PIT

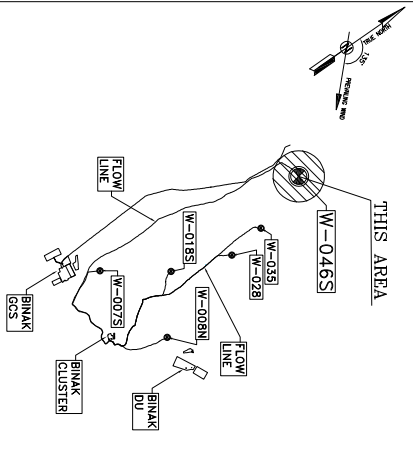[illegible]