

DOCUMENT TITLE:


MENT LOCATION LAYOUT

DRAWING—W028

NOTES	
LEGEND	
REFERENCE DRAWING	DRG. No.
P&ID- W028	BK-W028-PEDCO-110-PR-0001
PLOT PLAN DRAWING-W028	BK-W028-PEDCO-110-PI-PY-0001
PDMS MODEL REVIEW REPORT(80%)-W028	BK-W028-PEDCO-110-PI-RT-0001
DATA SHEETS FOR WHCF/HPU-WELLHEADS	BK-SSGRL-PEDCO-110-IN-DT-0001

KEY PLAN

[illegible]

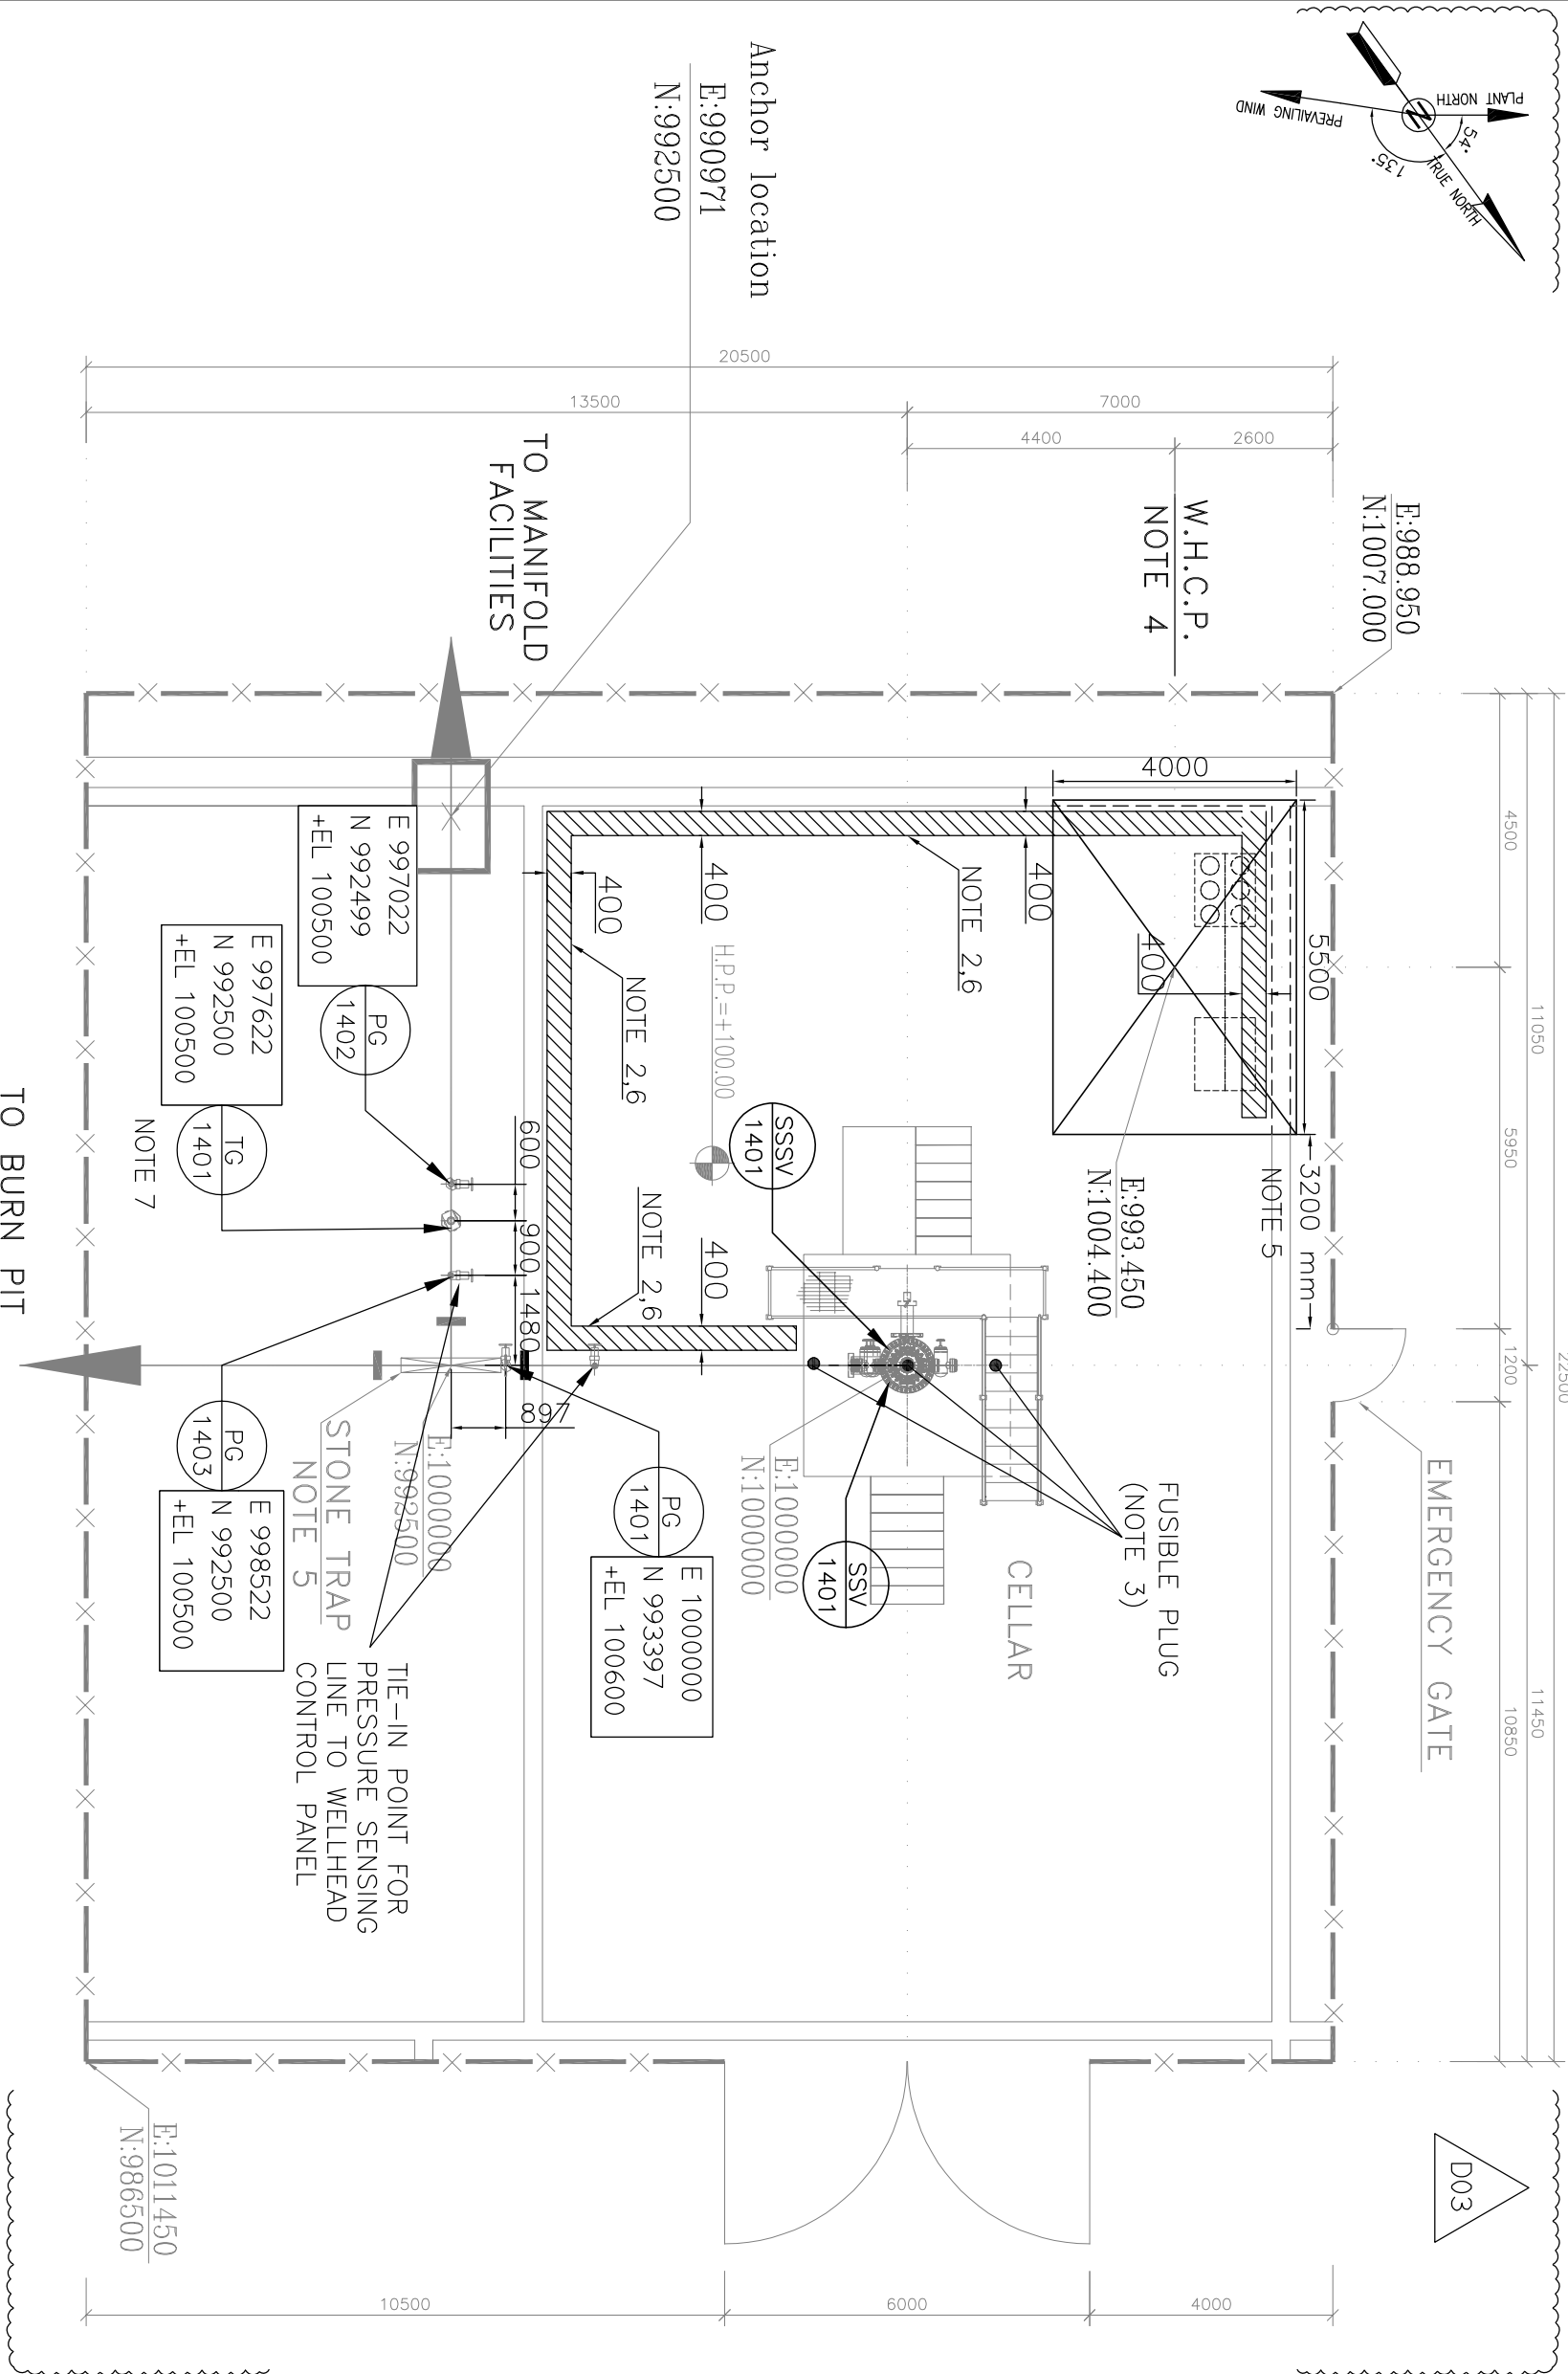

- | LEGEND | |
|--------|------------------------------|
| H.P.P. | HIGH POINT PAVING |
| WHCP | WELL HEAD CONTROL PANEL |
| — X — | FENCE |
| — - - | MATCH LINE |
| ● | WELL LOCATION |
| — — | SURFACE WATER TRENCH |
| | GRATING |
| | TUBE TRAY |
| | TWO RACK OF NITROGEN BOTTLES |
| | WHCP |
| | TEMPERATURE GAUGE |
| | PRESSURE GAUGE |

INSTRUMENT LOCATION LAYOUT DRAWING - W 028

SC: 1/100