
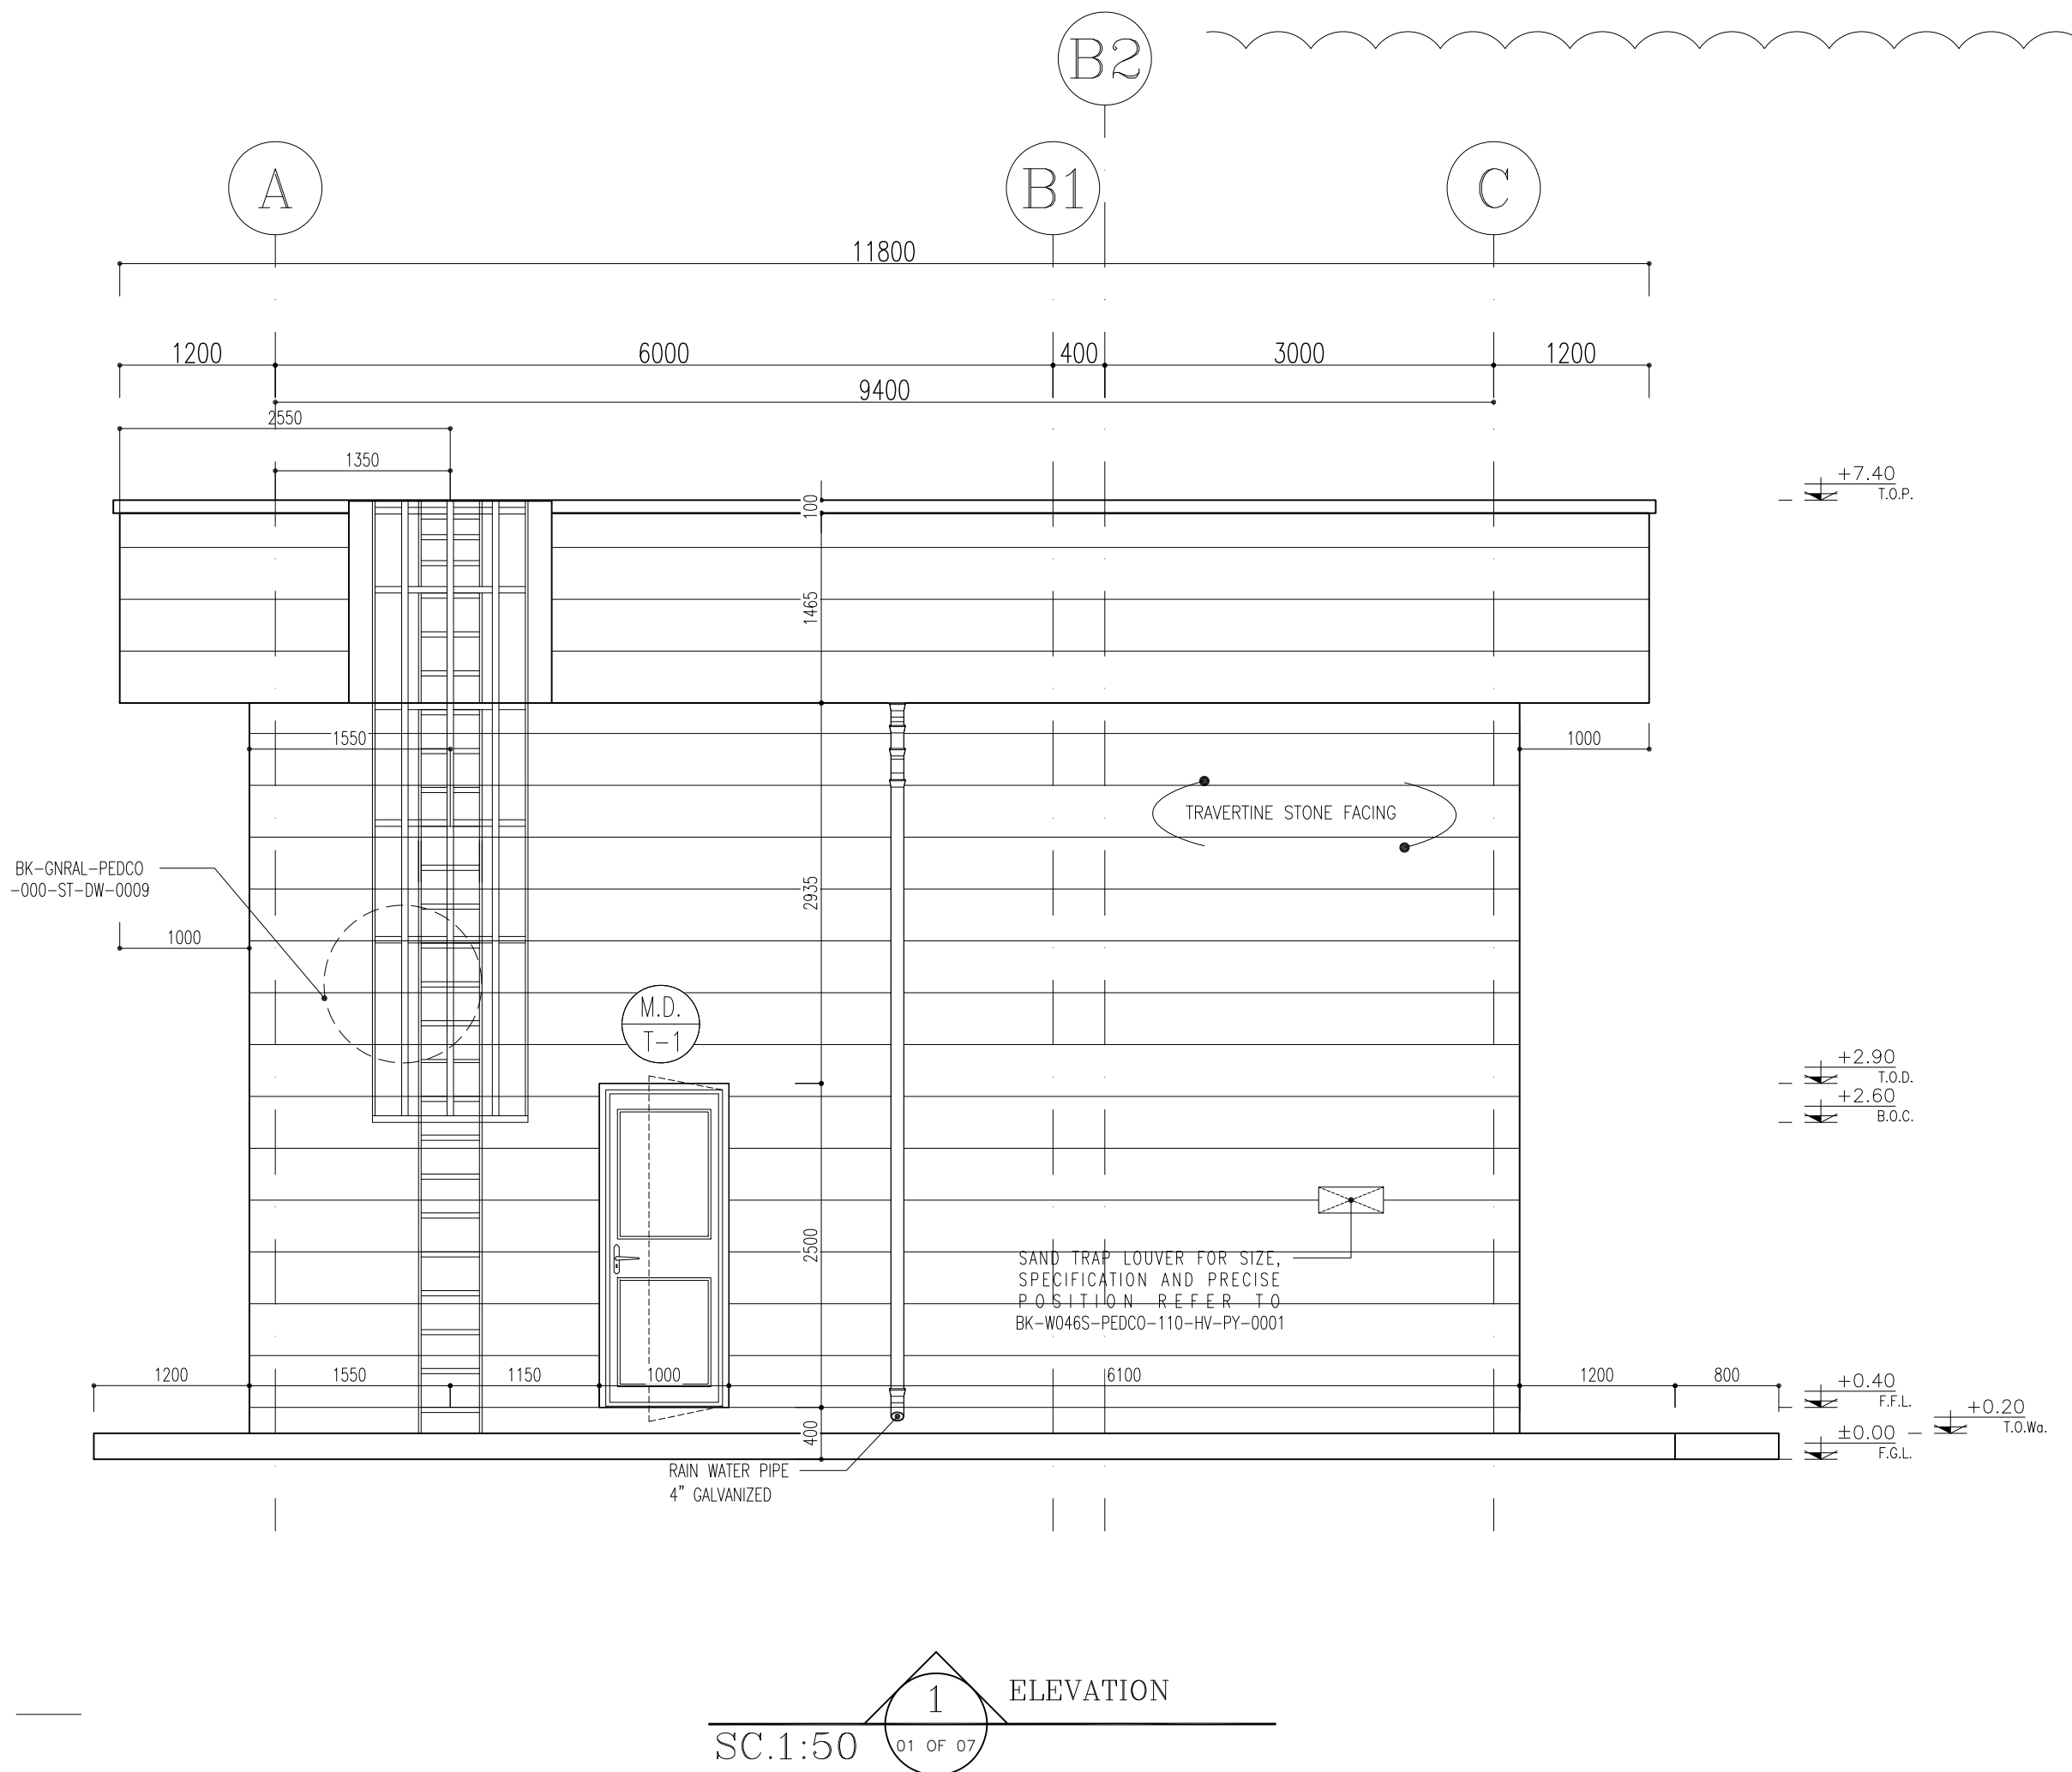
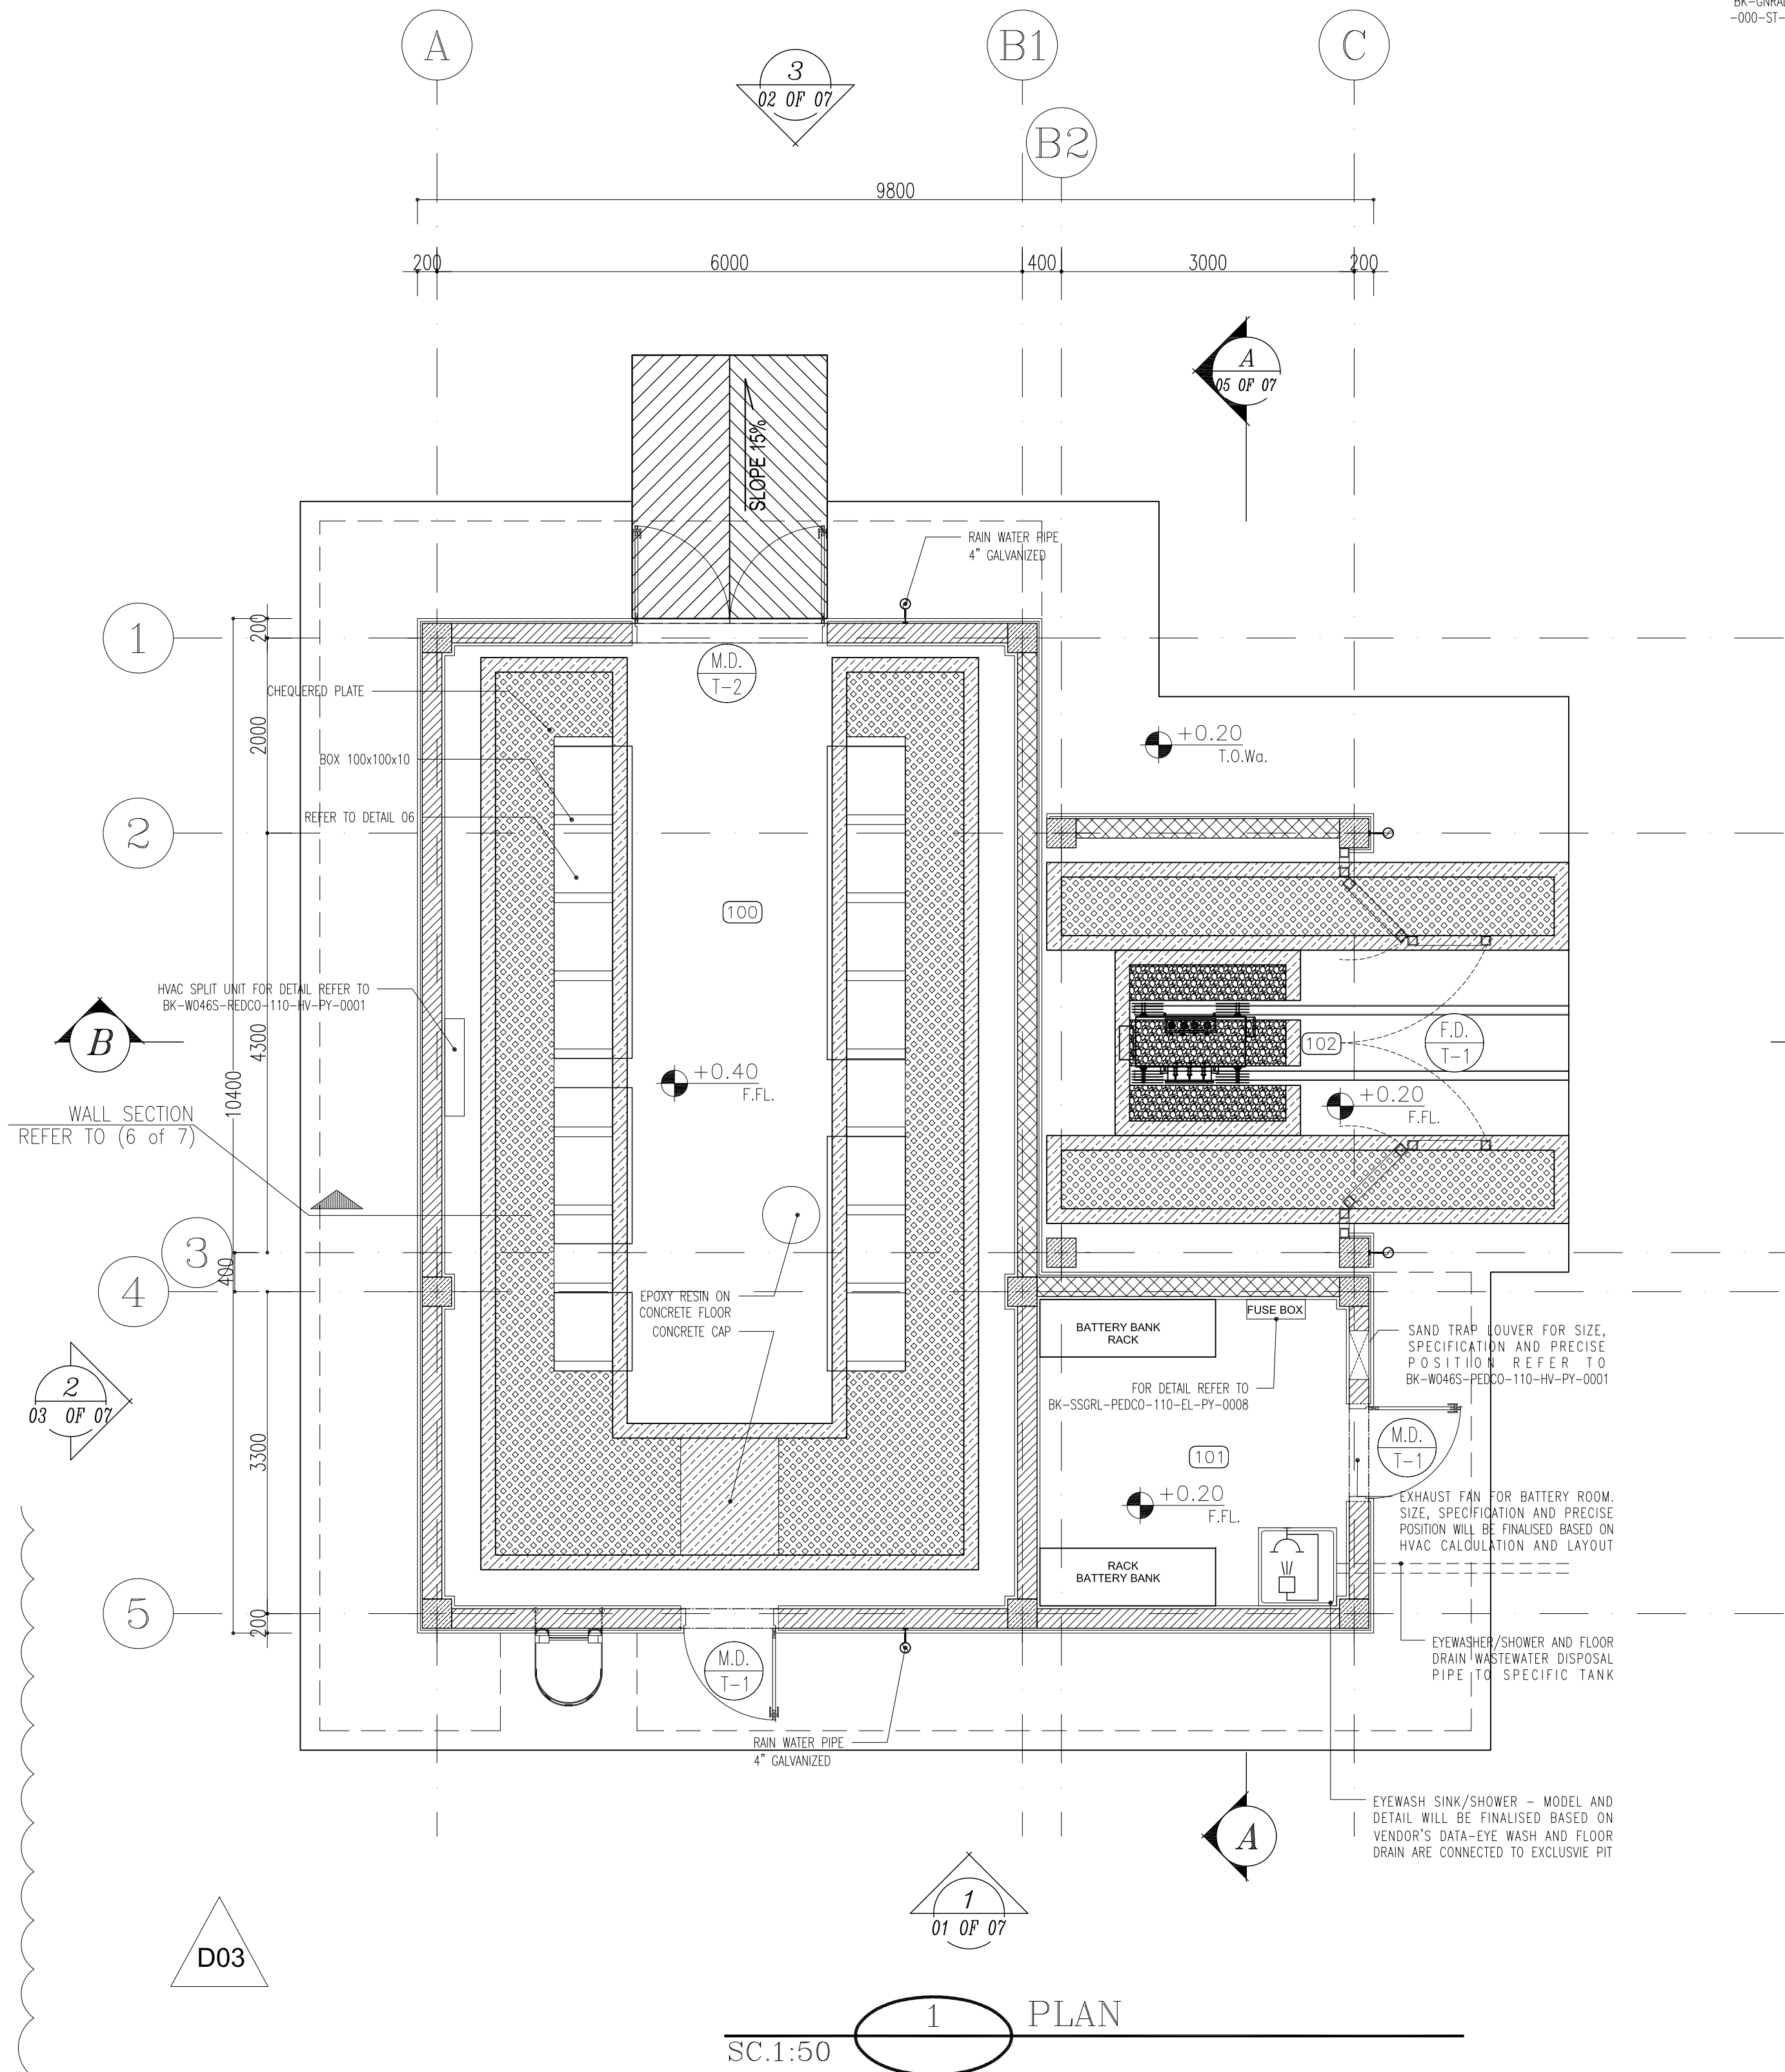


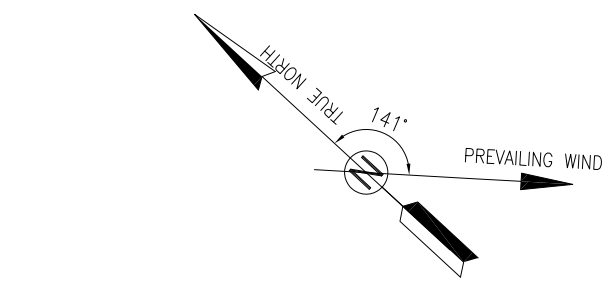


- NOTES
- 1- DIMENSIONS ARE IN "mm" AND ELEVATIONS IN "m" UNLESS SPECIFIED .
 - 2- ALL DIMENSIONS AND ELEVATIONS SHALL BE CHECKED BY THE CONTRACTOR PRIOR TO CONSTRUCTION.
 - 3- CONTRACTOR SHALL COMPARE ALL ARCHITECTURAL, MECHANICAL, ELECTRICAL, PIPING AND STRUCTURAL DRAWINGS AND IN CASE OF ANY CONFLICTS OR DISCREPANCY, INFORM THE ENGINEER.
 - 4- SLAB ON GRADE SHALL BE CONSTRUCTED AFTER EXECUTION OF CABLE TRENCH & EQUIPMENTS FOUNDATION.
 - 5- ALL MATERIALS ARE SELECTED FROM THE HIGHEST QUALITY AND SHALL BE APPROVED BY THE CLIENT.
 - 6- FOR COORDINATE REFER TO FINISH GRADING DOCUMENTS.
 - 7) REFERENCE COORDINATES E=1000.000 , N=1000.000 REFER TO X=441693 , Y=3286498 UTM.
 - 8) FINISH GRADING LEVEL (BK05) ELEVATION :
+50 m (GLOBAL) = ±0.00 (LOCAL)
 - 9) ALL HVAC OPENINGS SIZE, SPECS, AND POSITION WILL BE FINALISED BASED ON HVAC SYSTEM DESIGN.
 - 10) BATTERY ROOM EQUIPMENT SHALL BE BLAST-PROOF (EXP)
 - 11) DRAWINGS MUST BE IN CONJUNCTION WITH STRUCTURAL, ELECTRICAL, INSTRUMENT AND OTHER DRAWINGS.
 - 12) ALL DOORS SHALL BE THERMAL BREAK AND FIRE RESISTANT.
 - 13) RAINWATER MUST BE CONNECTED TO THE SURFACE WATER NETWORK.
 - 14) BATTERY ROOM EQUIPMENT MUST BE BLAST -PROOF.(ACCORDING TO SCOPE OF WORK)

LEGEND

	BRICK WALL
	REINFORCED CONCRETE ACCORDING TO STR. DWG
	CHEQUERED PLATE TRENCH CAP
	GRAVEL/HARDCORE
	FIRE RESISTANT BRICK


F.F.L.	FINISHED FLOOR	B.O.C.	BOTTOM OF CAGE
F.G.L.	TOP OF WALL	T.O.C.	TOP OF CAGE
T.O.Wa.	TOP OF WALKWAY	R.H.P.	ROOF HIGH POINT
T.O.P.	TOP OF PARAPET	R.L.P.	ROOF LOW POINT
T.O.Fou.	TOP OF FOUNDATION		
B.O.Pit	BOTTOM OF PIT		
B.O.O.	BOTTOM OF OPENING		
T.O.D.	TOP OF DOOR		
T.O.R.	TOP OF ROOF		
T.O.W.	FINISHED GRADING LEVEL		
B.O.O.	BOTTOM OF OPENING		

REFERENCE DRAWING	DRG. No.
STANDARD DRAWING FOR ARCHITECTURAL DETAILS	BK-GNRL-PEDCO-000-AR-DW-0001
STANDARD DETAILS FOR LADDER & SAFETY CAGE	BK-GNRL-PEDCO-000-ST-DW-0009
FOUNDATION DRAWING FOR SWITCHGEAR BUILDING FOR WELL PADS - BK-05	BK-BK05-PEDCO-110-ST-DW-0004
STRUCTURAL DRAWING FOR SWITCHGEAR BUILDING FOR WELL PADS - BK-05	BK-BK05-PEDCO-110-ST-DW-0005
GENERAL CIVIL LAYOUT - BK05	BK-BK05-PEDCO-110-CV-PY-0001
HVAC SYSTEM LAYOUT FOR SWITCHGEAR BUILDING - BK05	BK-BK05-PEDCO-110-HV-PY-0001
PLUMBING & SEWAGE PIPING LAYOUT FOR SWITCHGEAR BUILDING - BK05	BK-BK05-PEDCO-110-HV-PY-0003


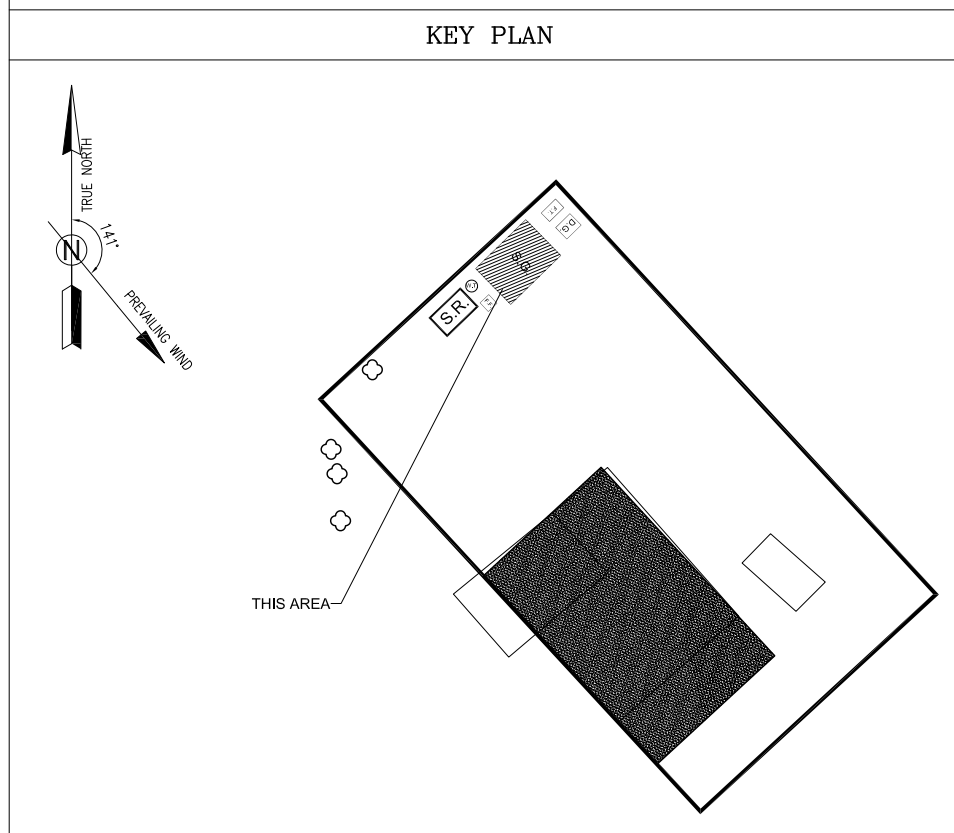


SPACE TAG NUMBER

 
- 100 SWITCHGEAR ROOM
- 101 BATTERY ROOM
- 102 TRANSFORMER SHELTER

D03	MAR.2023	IFA	R.BERLOUIE	M.PAKHARIAN	M.Mehrshad	***
D02	SEP.2022	IFC	R.BERLOUIE	M.PAKHARIAN	M.Mehrshad	***
D01	MAY.2022	IFC	R.BERLOUIE	M.PAKHARIAN	M.Mehrshad	***
D00	MAR.2022	IFC	R.BERLOUIE	M.PAKHARIAN	M.Mehrshad	***
REV.	DATE	P.O.I.S	PREP.	CHK.	APP.	AUT.
PROJECT NAME: BINAK OILFIELD DEVELOPMENT/SUB-SURFACE WORK PACKAGES BK05 WHF MODIFICATIONS						
PROJECT NO.:			971020			
EPC CONTRACTOR:			EPD/EPC CONTRACTOR (GC):			
 HIRGAN ENERGY - DESIGN & INSPECTION COMPANIES			 PEDCO			
DRAWING TITLE: ARCHITECTURAL DRAWING FOR SWITCHGEAR BUILDING OF WELL PADS - BK-05 PLAN AND ELEVATION						
SCALE	SIZE	DRAWING NO.			SHEET NO.	REV
AS SHOWN	A1	BK-BK05-PEDCO-110-AR-DW-0002			01 OF 07	D03


DATE	SCALE	DRAWING BY	CHECKED BY	PROJECT ENG.
NO CONSTRUCTION PERMITTED UNLESS DRAWING APPROVED				
APPROVED FOR CONSTRUCTION		BY:	DATE:	
SHEET	CLASS	SERIAL NO.	SHEET	REVISION
053-073-9184	F	4	B	708456
01 OF 07	D03			

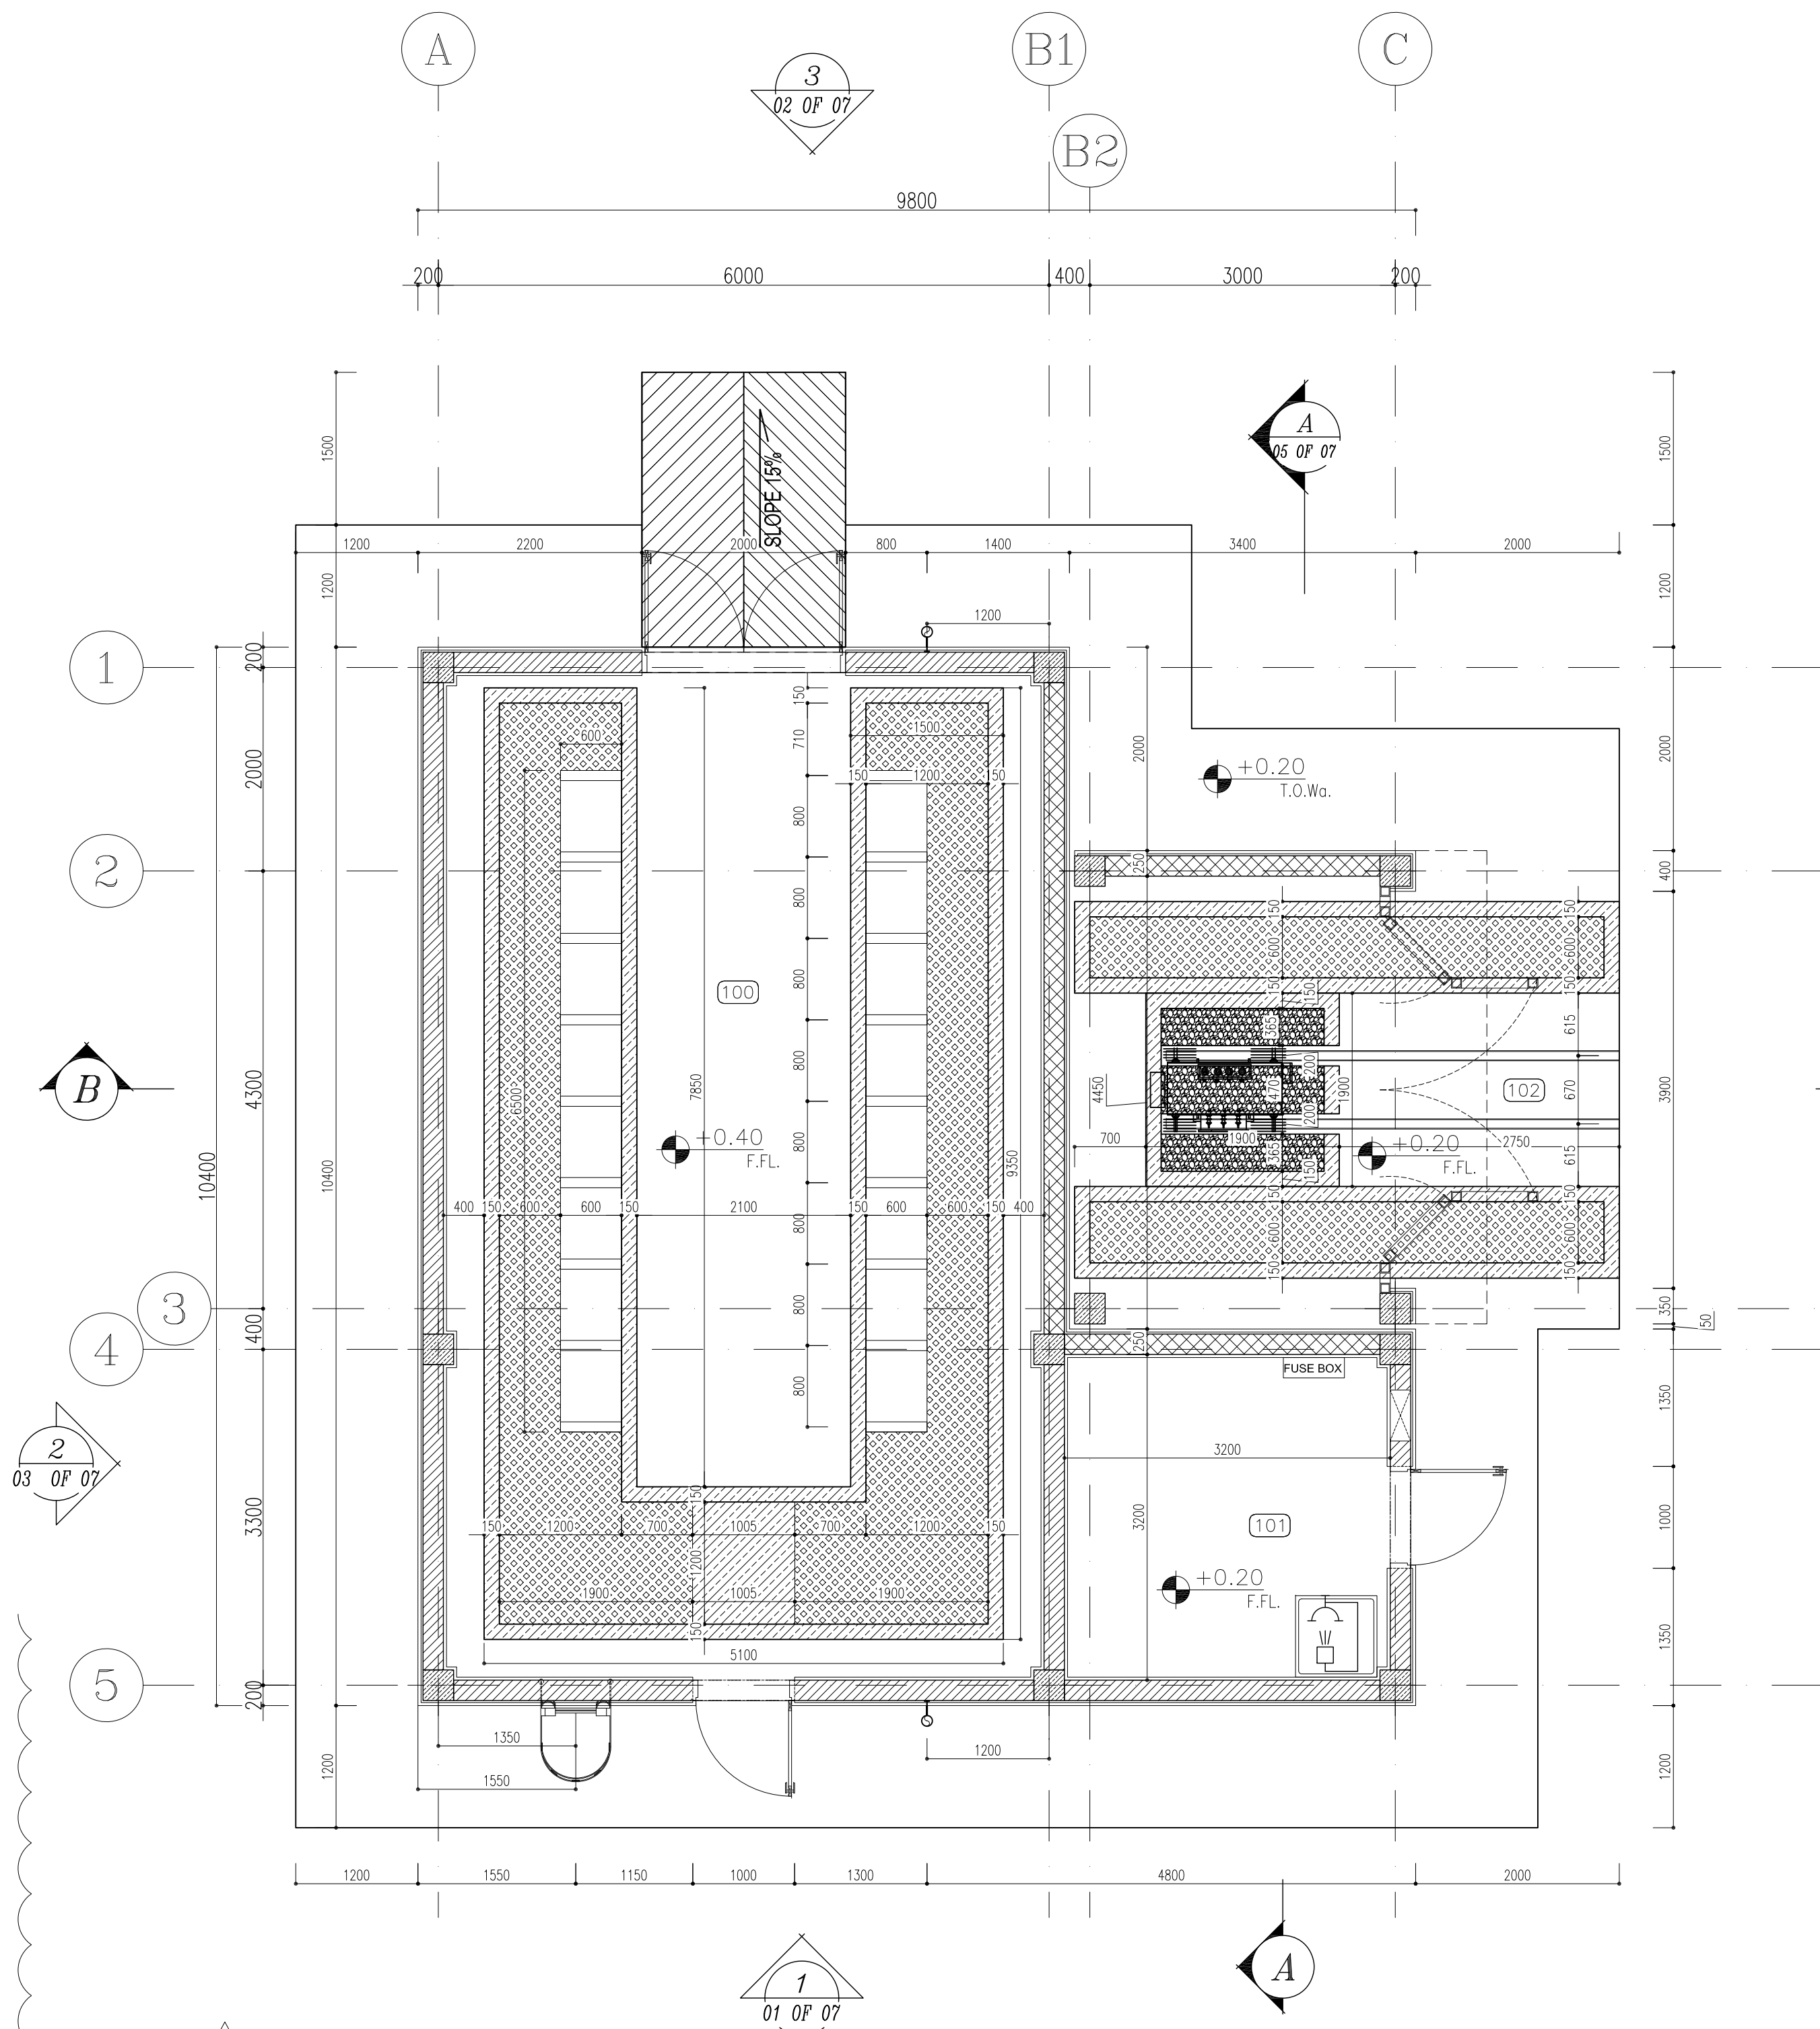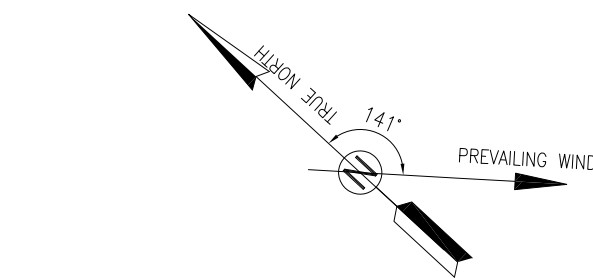

SC.1:50 2 DIMENSION PLAN

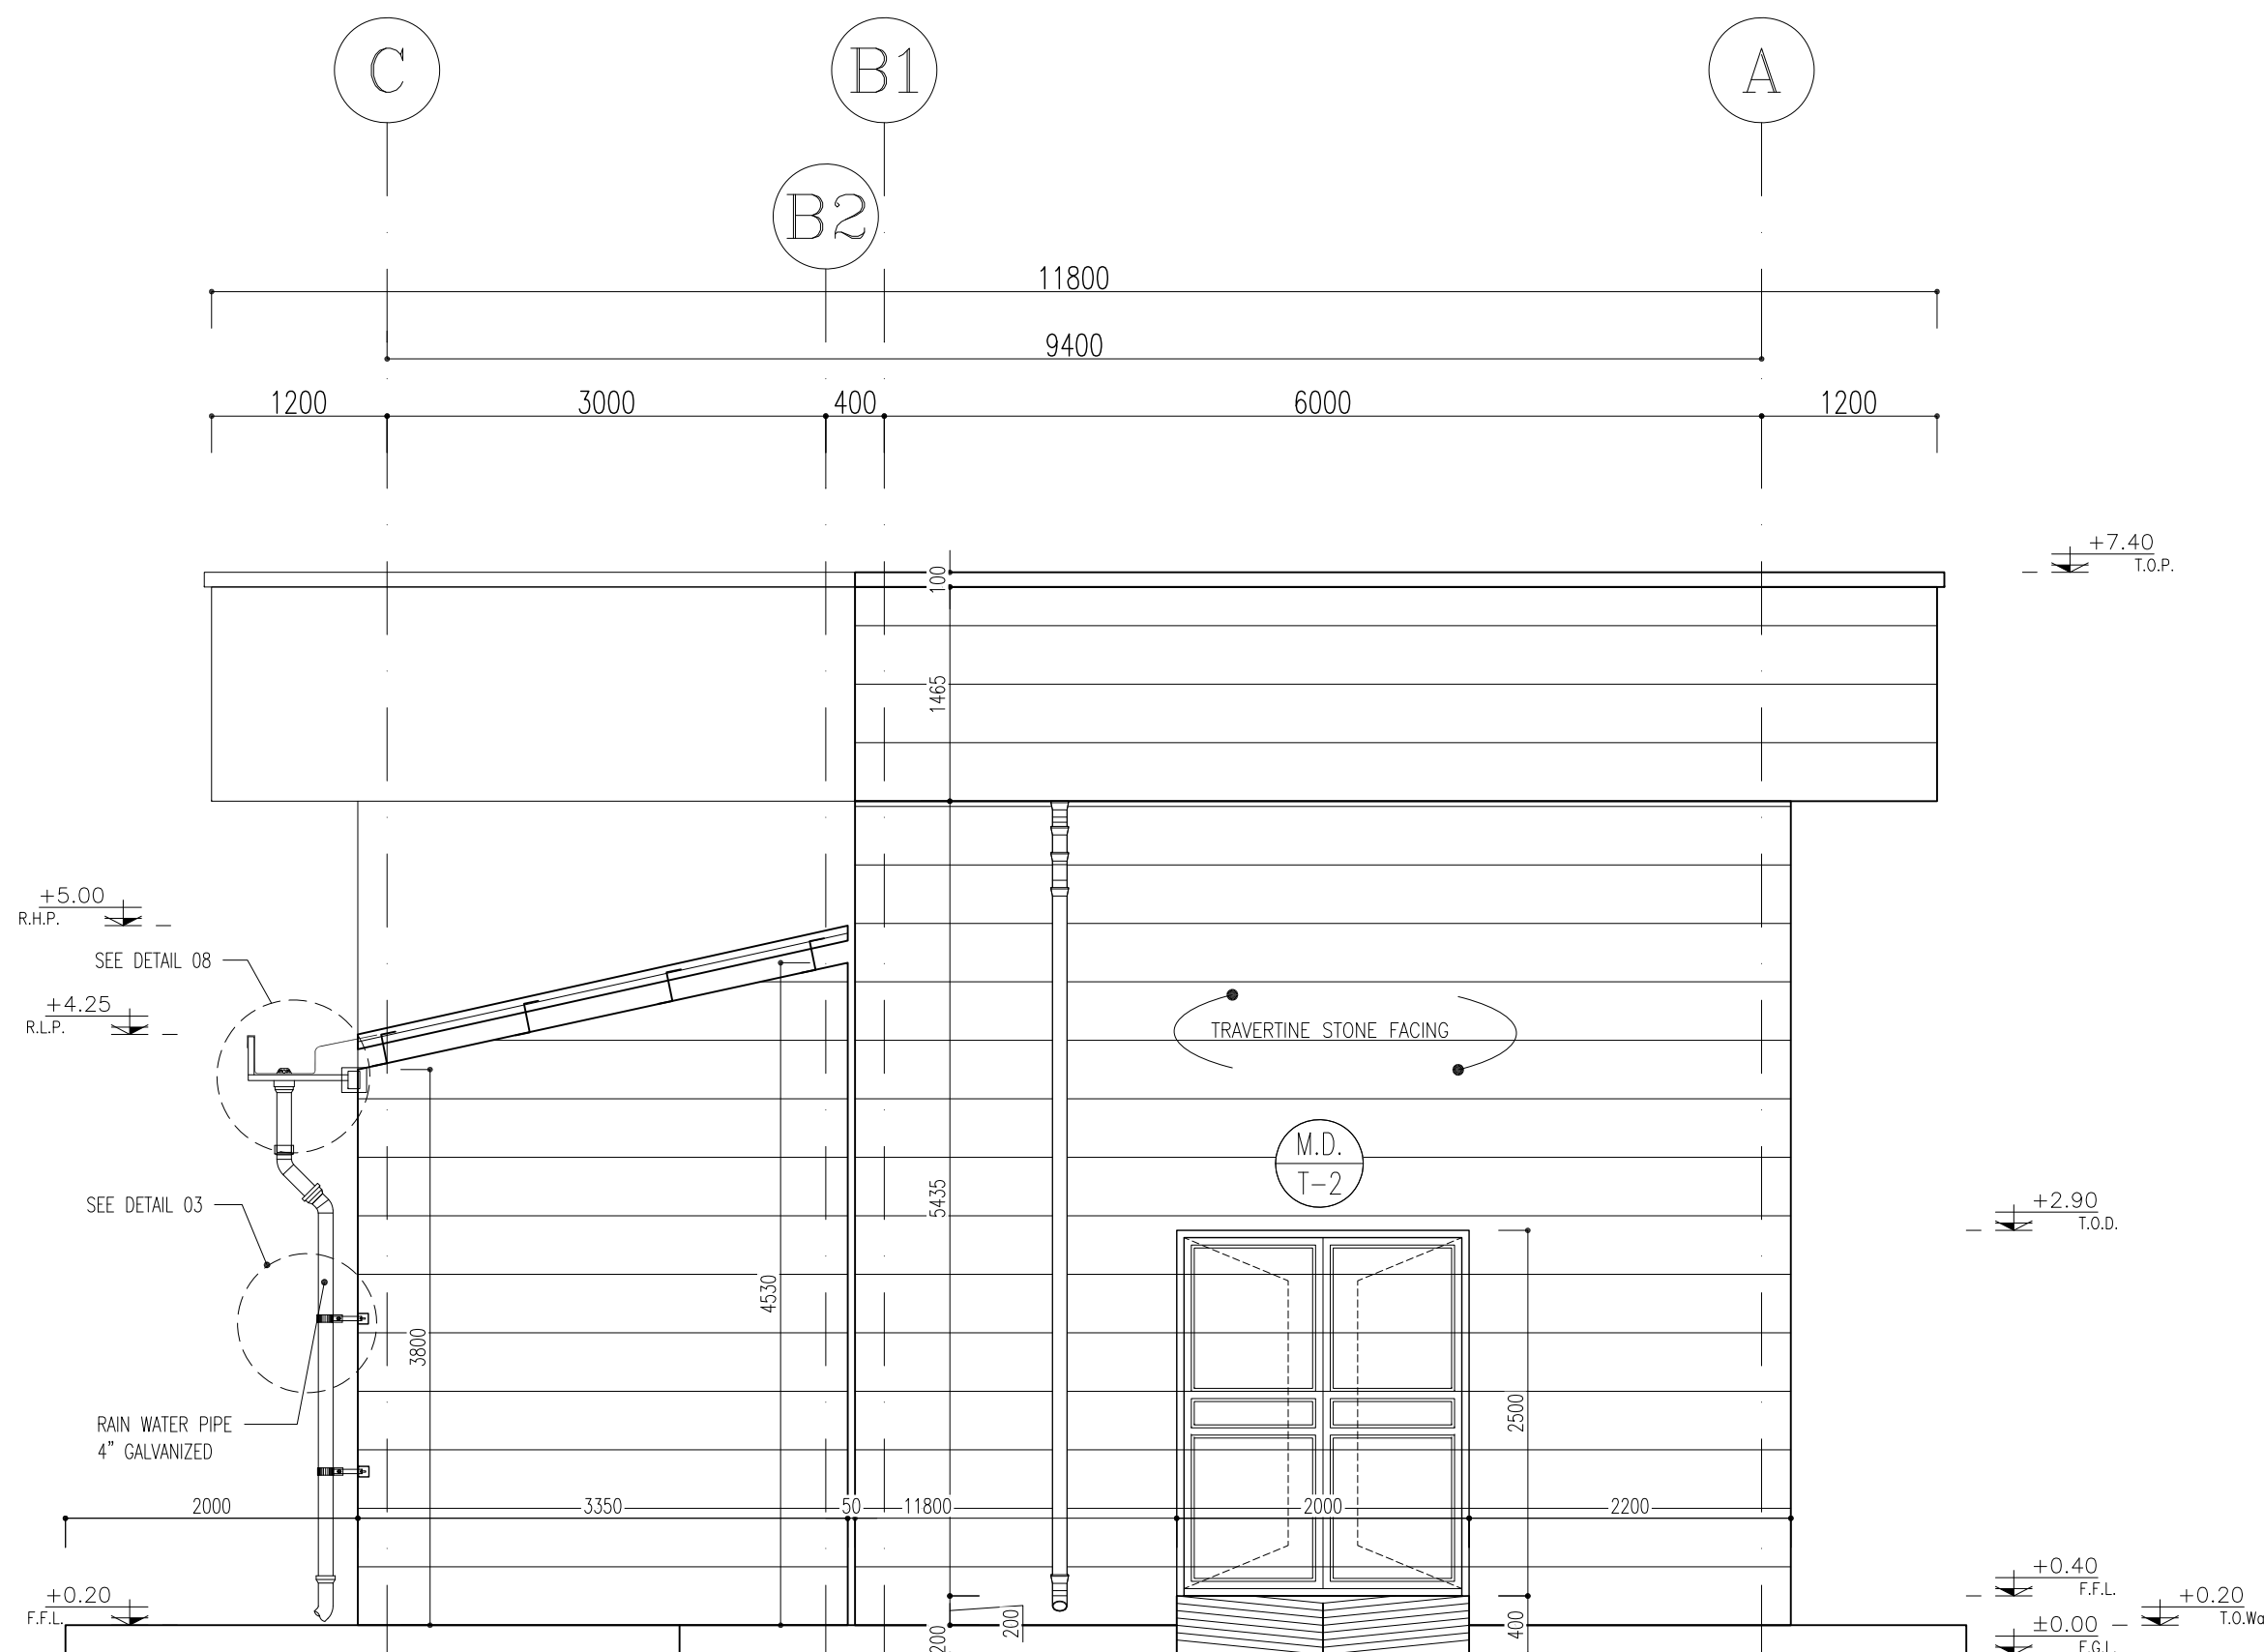

SC.1:50 3 ELEVATION

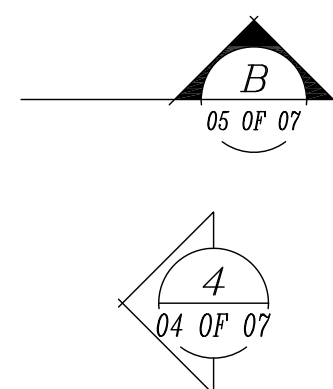

SPACE TAG NUMBER


- 100 SWITCHGEAR ROOM
- 101 BATTERY ROOM
- 102 TRANSFORMER SHELTER


- NOTES
- 1- DIMENSIONS ARE IN "mm" AND ELEVATIONS IN "m" UNLESS SPECIFIED .
 - 2- ALL DIMENSIONS AND ELEVATIONS SHALL BE CHECKED BY THE CONTRACTOR PRIOR TO CONSTRUCTION.
 - 3- CONTRACTOR SHALL COMPARE ALL ARCHITECTURAL, MECHANICAL, ELECTRICAL, PIPING AND STRUCTURAL DRAWINGS AND IN CASE OF ANY CONFLICTS OR DISCREPANCY, INFORM THE ENGINEER.
 - 4- SLAB ON GRADE SHALL BE CONSTRUCTED AFTER EXECUTION OF CABLE TRENCH & EQUIPMENTS FOUNDATION.
 - 5- ALL MATERIALS ARE SELECTED FROM THE HIGHEST QUALITY AND SHALL BE APPROVED BY THE CLIENT.
 - 6- FOR COORDINATE REFER TO FINISH GRADING DOCUMENTS.
 - 7) REFERENCE COORDINATES E=1000.000 , N=1000.000 REFER TO X=441693 , Y=3286498 UTM.
 - 8) FINISH GRADING LEVEL (BK05) ELEVATION :
+50 m (GLOBAL) = ±0.00 (LOCAL)
 - 9) ALL HVAC OPENINGS SIZE, SPECS, AND POSITION WILL BE FINALISED BASED ON HVAC SYSTEM DESIGN.
 - 10) BATTERY ROOM EQUIPMENT SHALL BE BLAST-PROOF (EXP)
 - 11) DRAWINGS MUST BE IN CONJUNCTION WITH STRUCTURAL, ELECTRICAL, INSTRUMENT AND OTHER DRAWINGS.
 - 12) ALL DOORS SHALL BE THERMAL BREAK AND FIRE RESISTANT.
 - 13) RAINWATER MUST BE CONNECTED TO THE SURFACE WATER NETWORK.
 - 14) BATTERY ROOM EQUIPMENT MUST BE BLAST -PROOF.(ACCORDING TO SCOPE OF WORK)



- LEGEND
- BRICK WALL
 - REINFORCED CONCRETE ACCORDING TO STR. DWG
 - CHEQUERED PLATE TRENCH CAP
 - GRAVEL/HARDCORE
 - FIRE RESISTANT BRICK

- F.F.L. FINISHED FLOOR B.O.C. BOTTOM OF CAGE
F.G.L. TOP OF WALL T.O.C. TOP OF CAGE
T.O.Wa. TOP OF WALKWAY R.H.P. ROOF HIGH POINT
T.O.P. TOP OF PARAPET R.L.P. ROOF LOW POINT
T.O.Fou. TOP OF FOUNDATION
B.O.Pit BOTTOM OF PIT
B.O.O. BOTTOM OF OPENING
T.O.D. TOP OF DOOR
T.O.R. TOP OF ROOF
T.O.W. FINISHED GRADING LEVEL
B.O.O. BOTTOM OF OPENING


REFERENCE DRAWING	DRG. No.
STANDARD DRAWING FOR ARCHITECTURAL DETAILS	BK-GNRL-PEDCO-000-AR-DW-0001
STANDARD DETAILS FOR LADDER & SAFETY CAGE	BK-GNRL-PEDCO-000-ST-DW-0009
FOUNDATION DRAWING FOR SWITCHGEAR BUILDING FOR WELL PADS - BK-05	BK-BK05-PEDCO-110-ST-DW-0004
STRUCTURAL DRAWING FOR SWITCHGEAR BUILDING FOR WELL PADS - BK-05	BK-BK05-PEDCO-110-ST-DW-0005
GENERAL CIVIL LAYOUT - BK05	BK-BK05-PEDCO-110-CV-PY-0001
HVAC SYSTEM LAYOUT FOR SWITCHGEAR BUILDING - BK05	BK-BK05-PEDCO-110-HV-PY-0001
PLUMBING & SEWAGE PIPING LAYOUT FOR SWITCHGEAR BUILDING - BK05	BK-BK05-PEDCO-110-HV-PY-0003

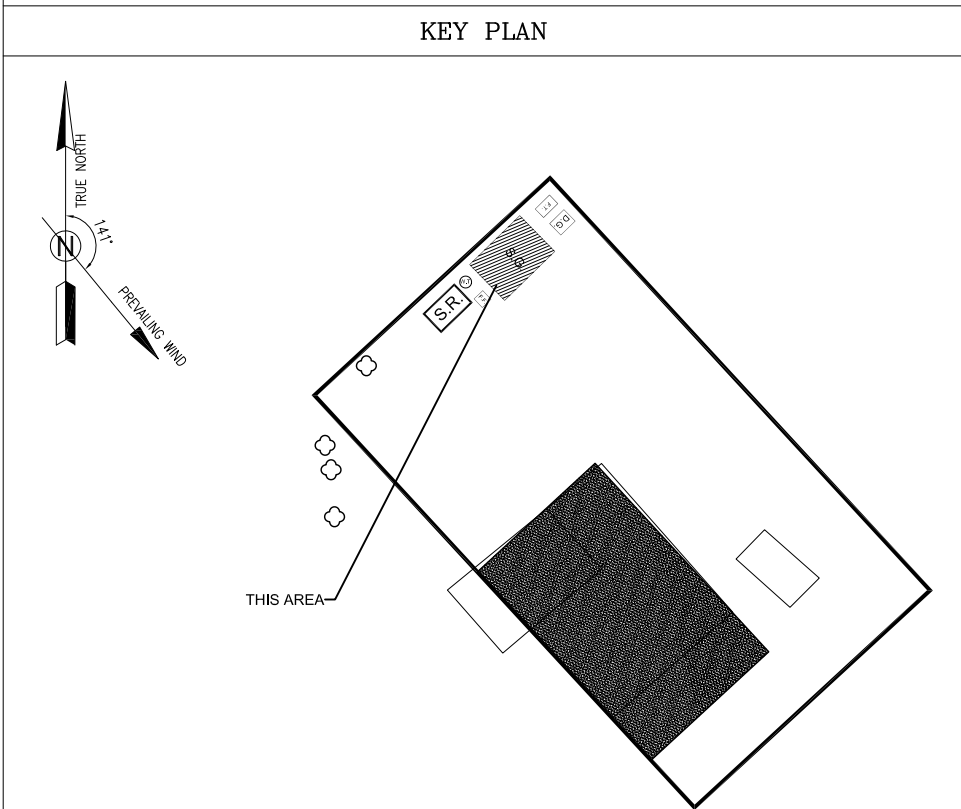

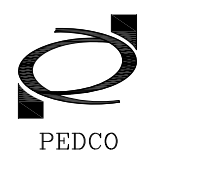D03	MAR.2023	IPA	R.BERLOUIE	M.PAKHARIAN	M.Mehrshad	***							
D02	SEP.2022	IPC	R.BERLOUIE	M.PAKHARIAN	M.Mehrshad	***	***	*****	***	***	***		
D01	MAY.2022	IPC	R.BERLOUIE	M.PAKHARIAN	M.Mehrshad	***	REV.	DESCRIPTION	BY	DATE	BY	DATE	
D00	MAR.2022	IPC	R.BERLOUIE	M.PAKHARIAN	M.Mehrshad	***			CHECKED		REV. APPR.		
REV.	DATE	P.O.I.S	PREP.	CHK.	APP.	AUT.	اصل و کليه نسخ اين نقشه و حق آفسياس متعلق به شرکت ملي مناطق نفت خيز جنوب ميباشد.						
PROJECT NAME:							BINAK OILFIELD DEVELOPMENT/SUB-SURFACE WORK PACKAGES BK05 WHF MODIFICATIONS						
PROJECT NO.:							971020						
EPC CONTRACTOR:							EPD/EPC CONTRACTOR (GC):						
 HIRGAN ENERGY - DESIGN & INSPECTION COMPANIES							 PETROIRAN DEVELOPMENT COMPANY						
							BINAK OILFIELD DEVELOPMENT SUB-SURFACE WORK PACKAGES BK05 WHF MODIFICATIONS						
							DATE		SCALE	DRAWING BY	CHECKED BY	PROJECT ENG.	
DRAWING TITLE:							NO CONSTRUCTION PERMITTED UNLESS DRAWING APPROVED						
ARCHITECTURAL DRAWING FOR SWITCHGEAR BUILDING OF WELL PADS - BK-05							APPROVED FOR CONSTRUCTION						
PLAN AND ELEVATION							BY:		DATE:				
SCALE	SIZE	DRAWING NO.			SHEET NO.	REV.	BUDGET REF.	LOCATION	SIZE	CLASS	SERIAL NO.	SHEET	REVISION
AS SHOWN	A1	BK-BK05-PEDCO-110-AR-DW-0002			02 OF 07	D03	053-073-9184	F	4	B	708456	02 OF 07	D03

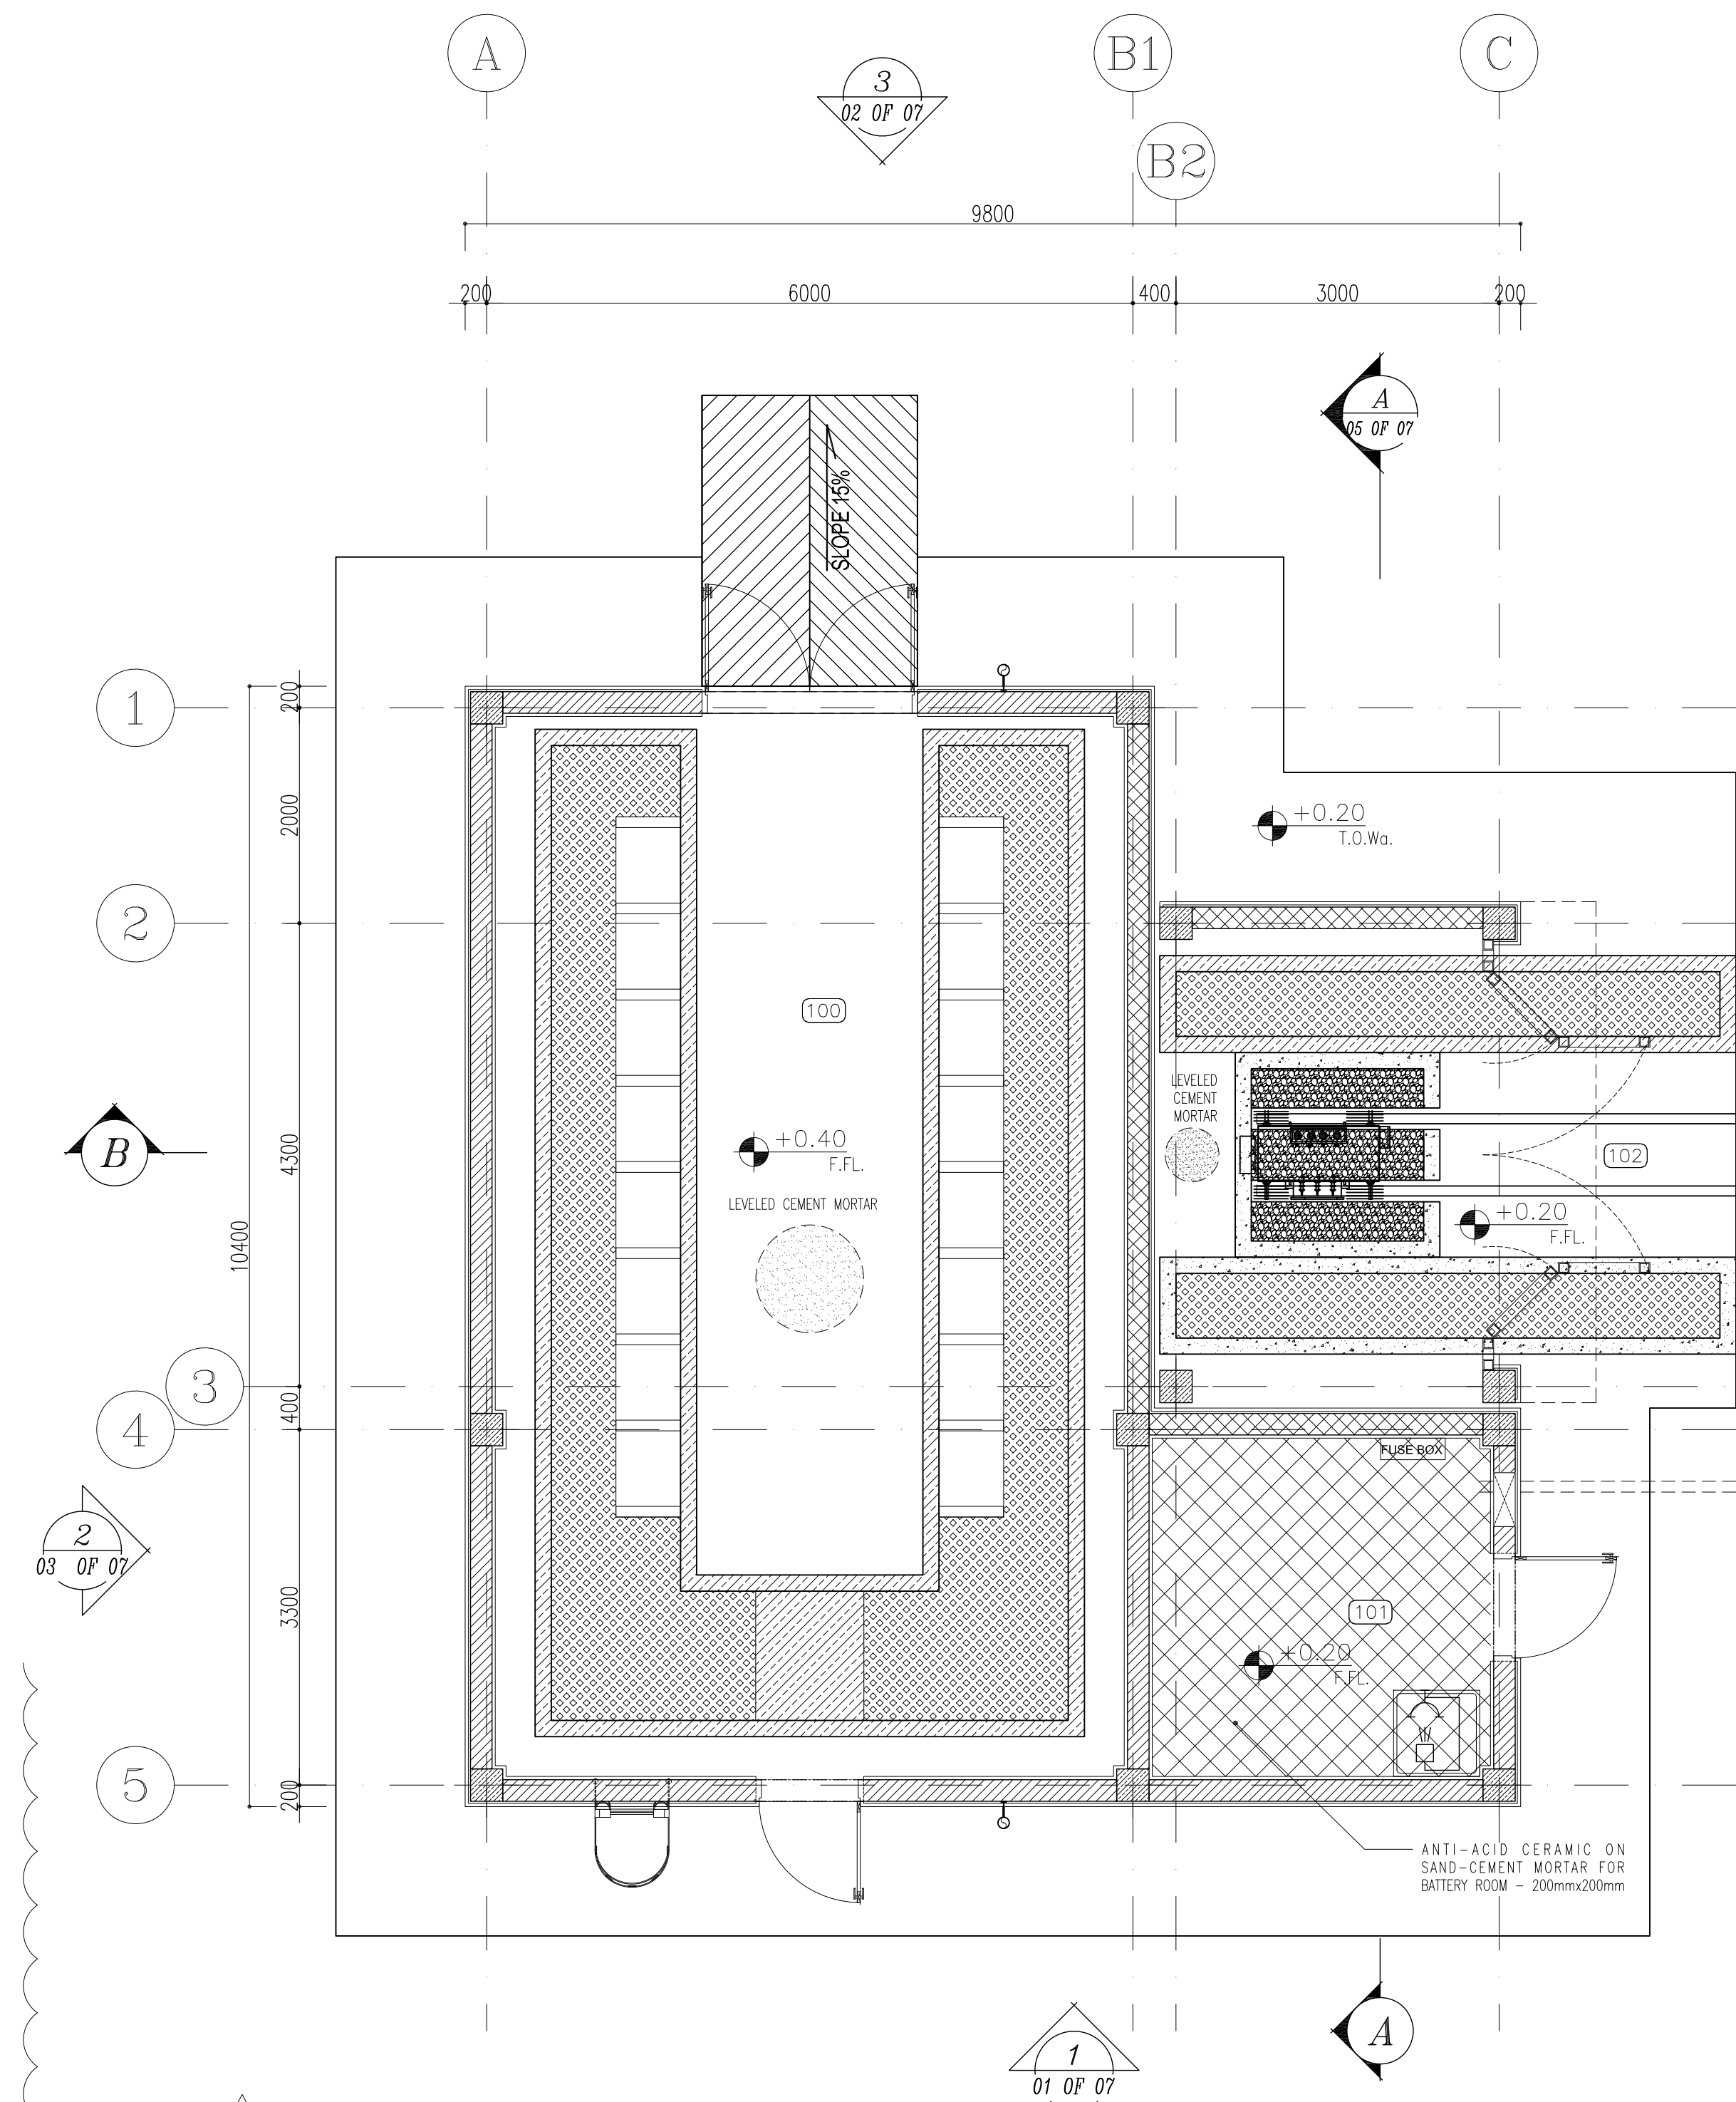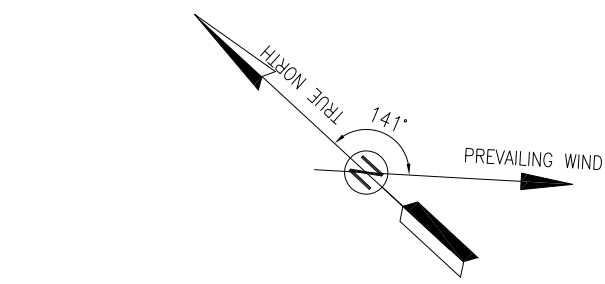

SC.1:50 **3** FLOOR FINISHING PLAN

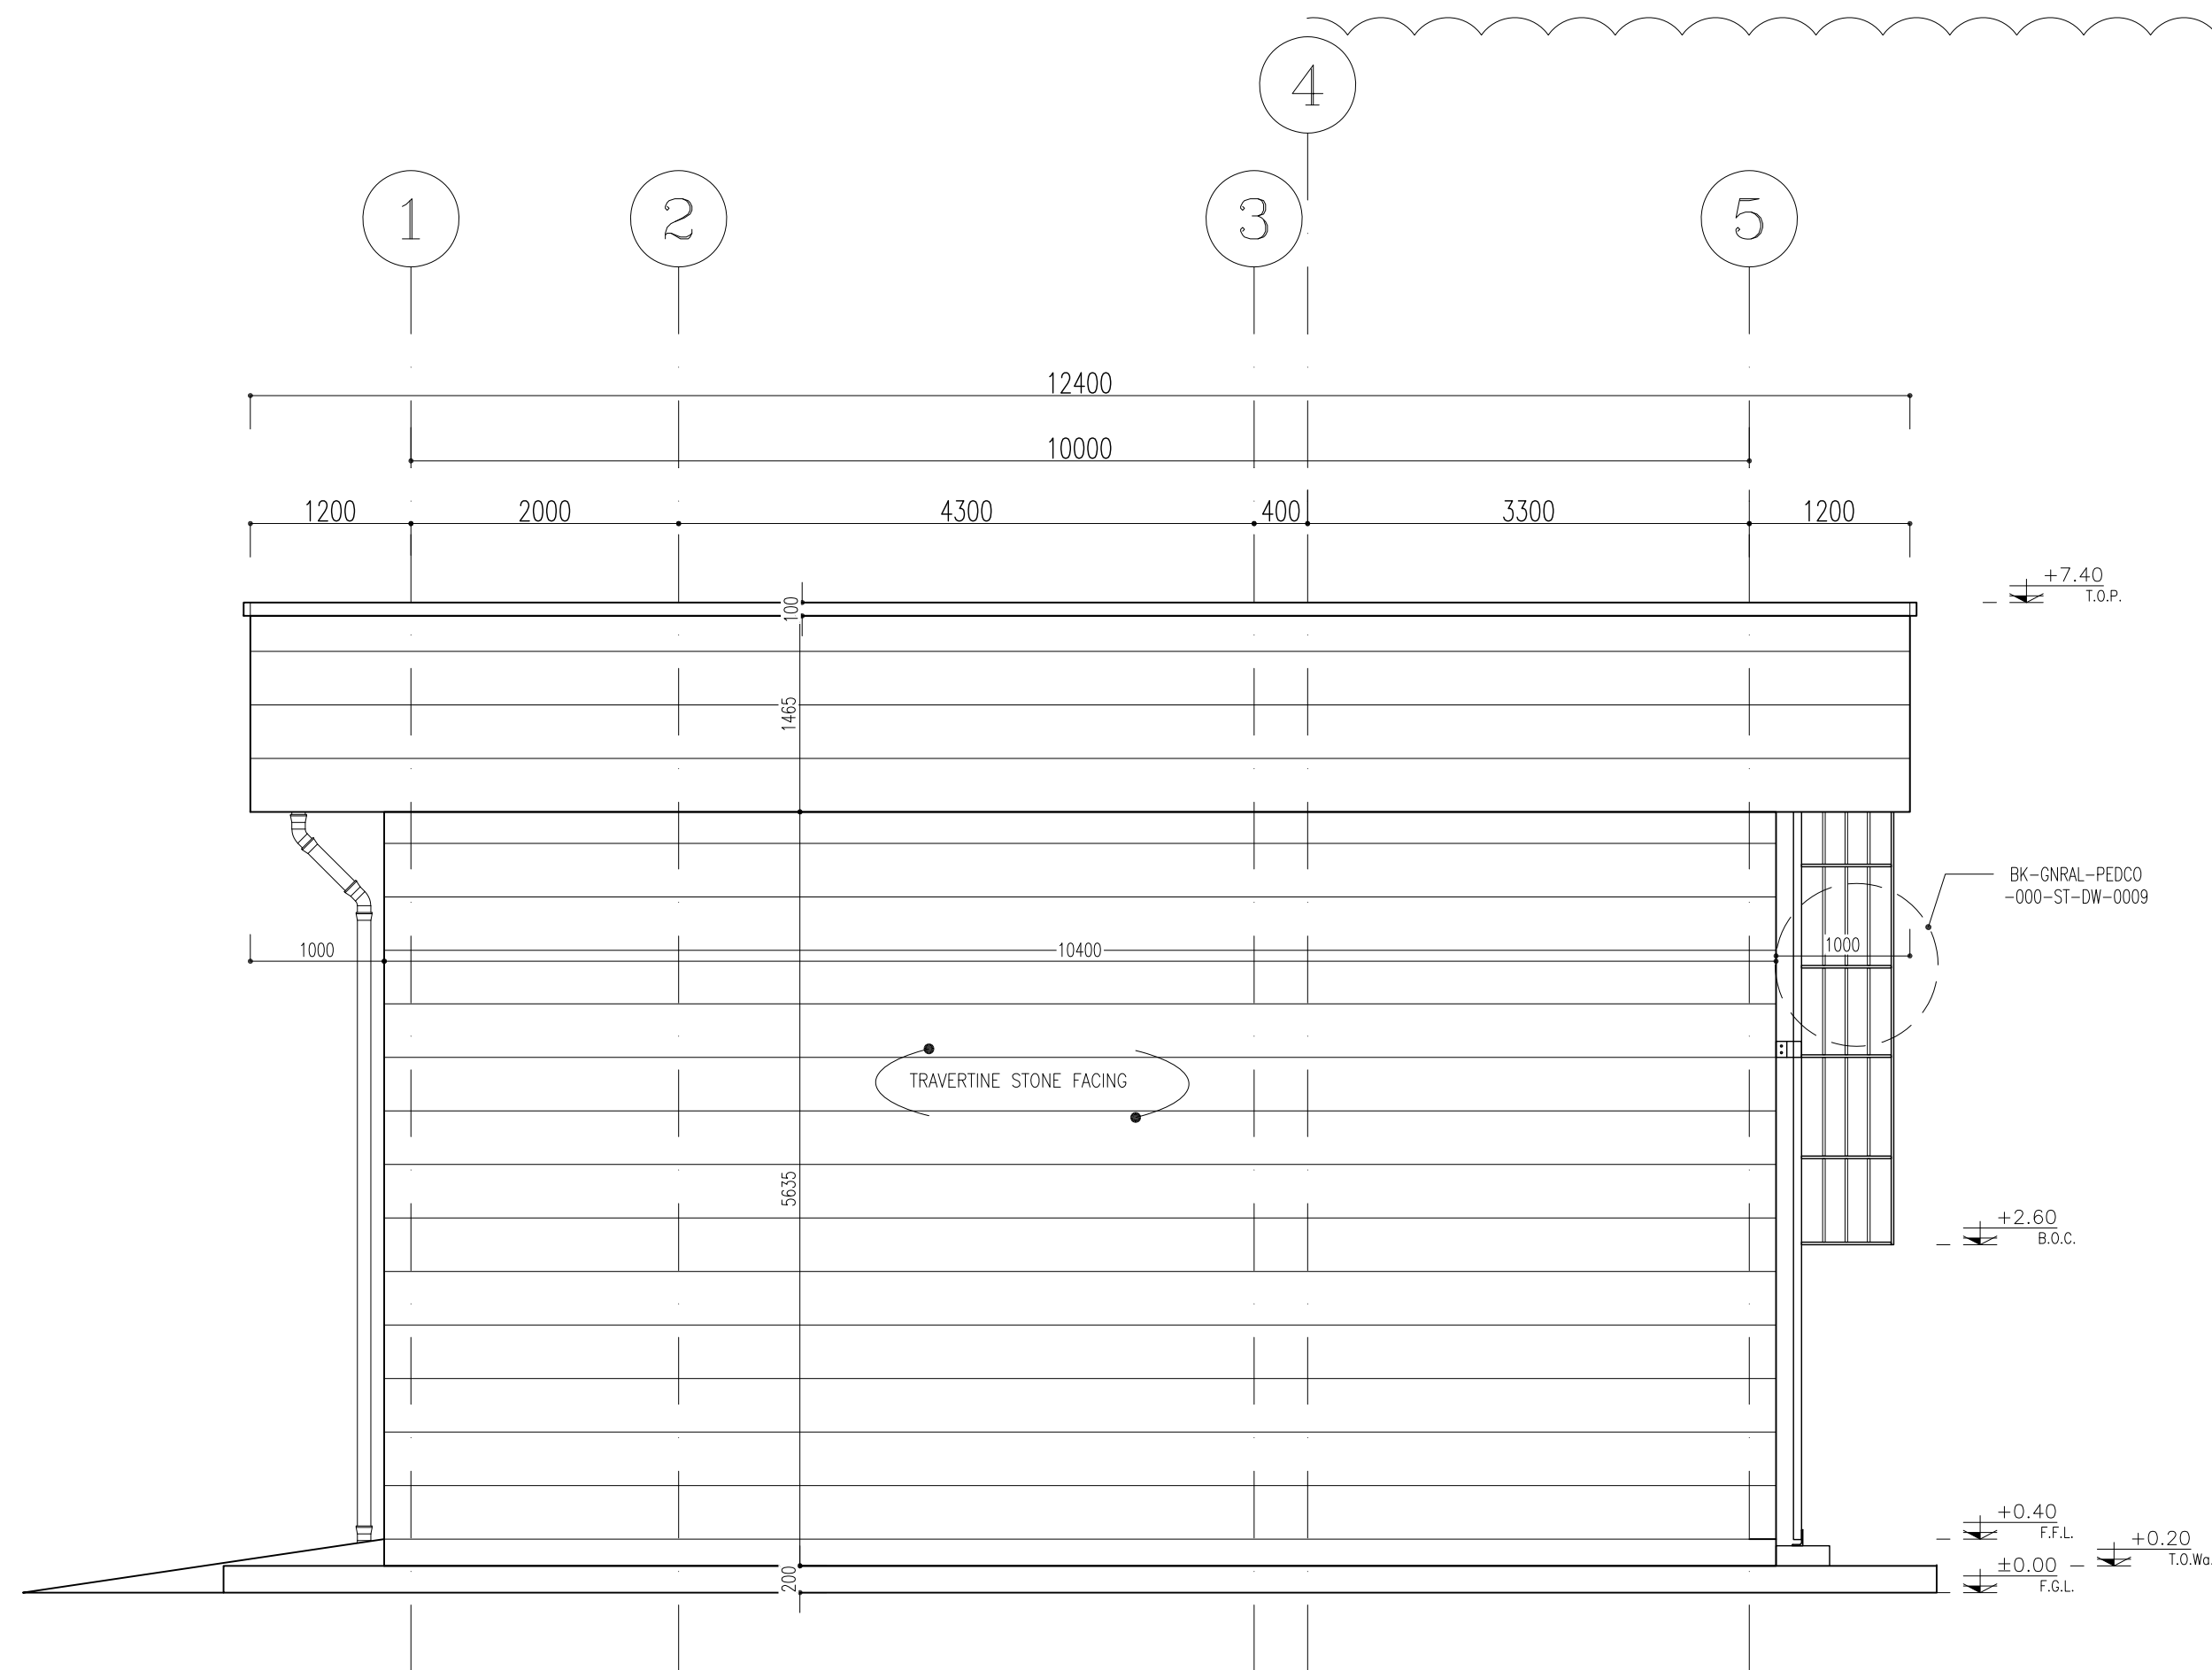

SC.1:50 **2** ELEVATION


SPACE TAG NUMBER

- 100 SWITCHGEAR ROOM
- 101 BATTERY ROOM
- 102 TRANSFORMER SHELTER



- NOTES**
- 1- DIMENSIONS ARE IN "mm" AND ELEVATIONS IN "m" UNLESS SPECIFIED .
 - 2- ALL DIMENSIONS AND ELEVATIONS SHALL BE CHECKED BY THE CONTRACTOR PRIOR TO CONSTRUCTION.
 - 3- CONTRACTOR SHALL COMPARE ALL ARCHITECTURAL, MECHANICAL, ELECTRICAL, PIPING AND STRUCTURAL DRAWINGS AND IN CASE OF ANY CONFLICTS OR DISCREPANCY, INFORM THE ENGINEER.
 - 4- SLAB ON GRADE SHALL BE CONSTRUCTED AFTER EXECUTION OF CABLE TRENCH & EQUIPMENTS FOUNDATION.
 - 5- ALL MATERIALS ARE SELECTED FROM THE HIGHEST QUALITY AND SHALL BE APPROVED BY THE CLIENT.
 - 6- FOR COORDINATE REFER TO FINISH GRADING DOCUMENTS.
 - 7) REFERENCE COORDINATES E=1000.000 , N=1000.000 REFER TO X=441693 , Y=3286498 UTM.
 - 8) FINISH GRADING LEVEL (BK05) ELEVATION :
+50 m (GLOBAL) = ±0.00 (LOCAL)
 - 9) ALL HVAC OPENINGS SIZE, SPECS, AND POSITION WILL BE FINALISED BASED ON HVAC SYSTEM DESIGN.
 - 10) BATTERY ROOM EQUIPMENT SHALL BE BLAST-PROOF (EXP)
 - 11) DRAWINGS MUST BE IN CONJUNCTION WITH STRUCTURAL, ELECTRICAL, INSTRUMENT AND OTHER DRAWINGS.
 - 12) ALL DOORS SHALL BE THERMAL BREAK AND FIRE RESISTANT.
 - 13) RAINWATER MUST BE CONNECTED TO THE SURFACE WATER NETWORK.
 - 14) BATTERY ROOM EQUIPMENT MUST BE BLAST -PROOF.(ACCORDING TO SCOPE OF WORK)

- LEGEND**
- BRICK WALL
 - REINFORCED CONCRETE ACCORDING TO STR. DWG
 - CHEQUERED PLATE TRENCH CAP
 - LEAN CONCRETE
 - ANTI-ACID CERAMIC
 - FIRE RESISTANT BRICK WALL
 - CEMENT MORTAR
- F.F.L. FINISHED FLOOR T.O.C. TOP OF CAGE
T.O.Wa. TOP OF WALKWAY R.H.P. ROOF HIGH POINT
T.O.P. TOP OF PARAPET R.L.P. ROOF LOW POINT
T.O.Fou. TOP OF FOUNDATION T.O.D. TOP OF DOOR
B.O.Pit BOTTOM OF PIT T.O.R. TOP OF ROOF
B.O.O. BOTTOM OF OPENING T.O.W. TOP OF WALL
B.O.C. BOTTOM OF CAGE
F.G.L. FINISHED GRADING LEVEL


REFERENCE DRAWING	DRG. No.
STANDARD DRAWING FOR ARCHITECTURAL DETAILS	BK-GNRL-PEDCO-000-AR-DW-0001
STANDARD DETAILS FOR LADDER & SAFETY CAGE	BK-GNRL-PEDCO-000-ST-DW-0009
FOUNDATION DRAWING FOR SWITCHGEAR BUILDING FOR WELL PADS - BK-05	BK-BK05-PEDCO-110-ST-DW-0004
STRUCTURAL DRAWING FOR SWITCHGEAR BUILDING FOR WELL PADS - BK-05	BK-BK05-PEDCO-110-ST-DW-0005
GENERAL CIVIL LAYOUT - BK05	BK-BK05-PEDCO-110-CV-PY-0001
HVAC SYSTEM LAYOUT FOR SWITCHGEAR BUILDING - BK05	BK-BK05-PEDCO-110-HV-PY-0001
PLUMBING & SEWAGE PIPING LAYOUT FOR SWITCHGEAR BUILDING - BK05	BK-BK05-PEDCO-110-HV-PY-0003

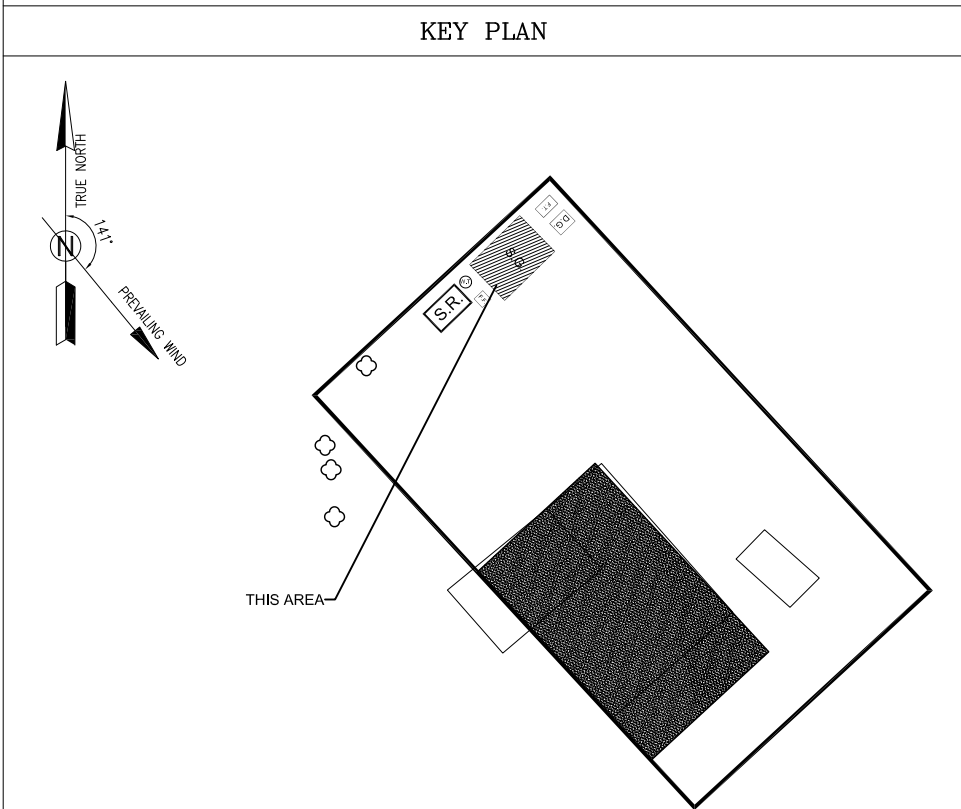


D03	MAR.2023	IPA	R.BERLOUIE	M.PAKHARIAN	M.Mehrshad	***								
D02	SEP.2022	IPC	R.BERLOUIE	M.PAKHARIAN	M.Mehrshad	***	***	*****	***	***	***			
D01	MAY.2022	IPC	R.BERLOUIE	M.PAKHARIAN	M.Mehrshad	***	REV.	DESCRIPTION	BY	DATE	BY	DATE		
D00	MAR.2022	IPC	R.BERLOUIE	M.PAKHARIAN	M.Mehrshad	***			CHECKED		REV. APPR.			
REV.	DATE	P.O.I.S	PREP.	CHK.	APP.	AUT.	اصل و کليه نسخ اين نقشه و حق آفسياس متعلق به شرکت ملي مناطق نفت خيز جنوب ميباشد.							
PROJECT NAME:							BINAK OILFIELD DEVELOPMENT/SUB-SURFACE WORK PACKAGES BK05 WHF MODIFICATIONS							
PROJECT NO.:							971020							
EPC CONTRACTOR:			EPD/EPC CONTRACTOR (GC):				THE ORIGINAL AND ALL COPIES OF THIS DRAWING TOGETHER WITH THE COPYRIGHT THEREIN ARE THE SOLE PROPERTY OF N.I.S.O.C./ FIELDS							
 HIRGAN ENERGY - DESIGN & INSPECTION COMPANIES			 PETROIRAN DEVELOPMENT COMPANY				BINAK OILFIELD DEVELOPMENT SUB-SURFACE WORK PACKAGES BK05 WHF MODIFICATIONS							
							DATE	SCALE	DRAWING BY	CHECKED BY	PROJECT ENG.			
DRAWING TITLE:							NO CONSTRUCTION PERMITTED UNLESS DRAWING APPROVED							
ARCHITECTURAL DRAWING FOR SWITCHGEAR BUILDING OF WELL PADS - BK-05 PLAN AND ELEVATION							APPROVED FOR CONSTRUCTION						BY:	DATE:
SCALE	SIZE	DRAWING NO.			SHEET NO.	REV.	BUDGET REF.	LOCATION	SIZE	CLASS	SERIAL NO.	SHEET	REVISION	
AS SHOWN	A1	BK-BK05-PEDCO-110-AR-DW-0002			03 OF 07	D03	053-073-9184	F	4	B	708456	03 OF 07	D03	

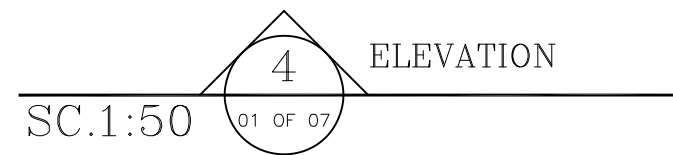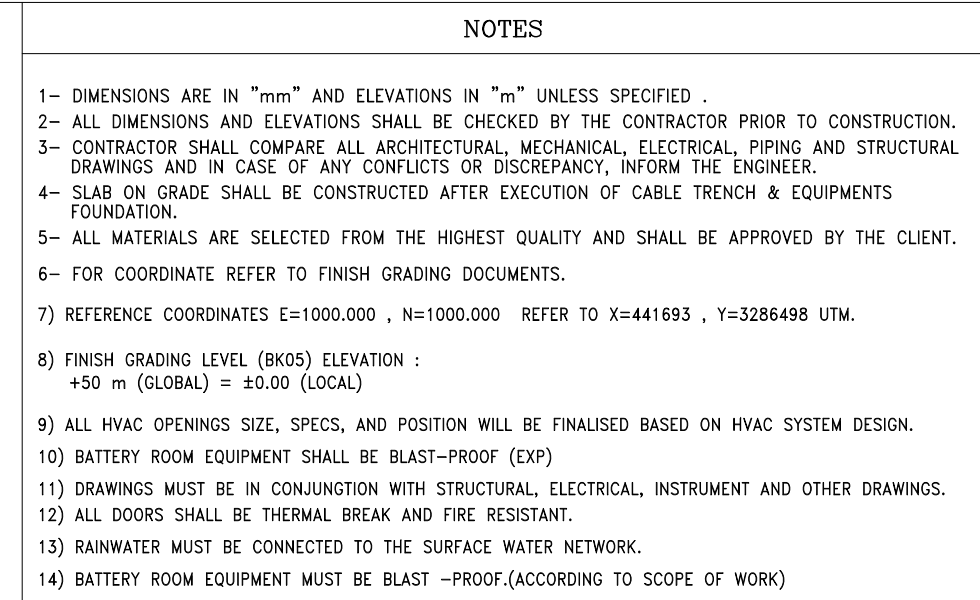

REFERENCE DRAWING	DRG. No.
STANDARD DRAWING FOR ARCHITECTURAL DETAILS	BK-GNRAI-PEDCO-000-AR-DW-0001
STANDARD DETAILS FOR LADDER & SAFETY CAGE	BK-GNRAI-PEDCO-000-ST-DW-0009
FOUNDATION DRAWING FOR SWITCHGEAR BUILDING FOR WELL PADS - BK-05	BK-BK05-PEDCO-110-ST-DW-0004
STRUCTURAL DRAWING FOR SWITCHGEAR BUILDING FOR WELL PADS - BK-05	BK-BK05-PEDCO-110-ST-DW-0005
GENERAL CIVIL LAYOUT - BK05	BK-BK05-PEDCO-110-CV-PY-0001
HVAC SYSTEM LAYOUT FOR SWITCHGEAR BUILDING - BK05	BK-BK05-PEDCO-110-HV-PY-0001
PLUMBING & SEWAGE PIPE LAYOUT FOR SWITCHGEAR BUILDING - BK05	BK-BK05-PEDCO-110-HV-PY-0003

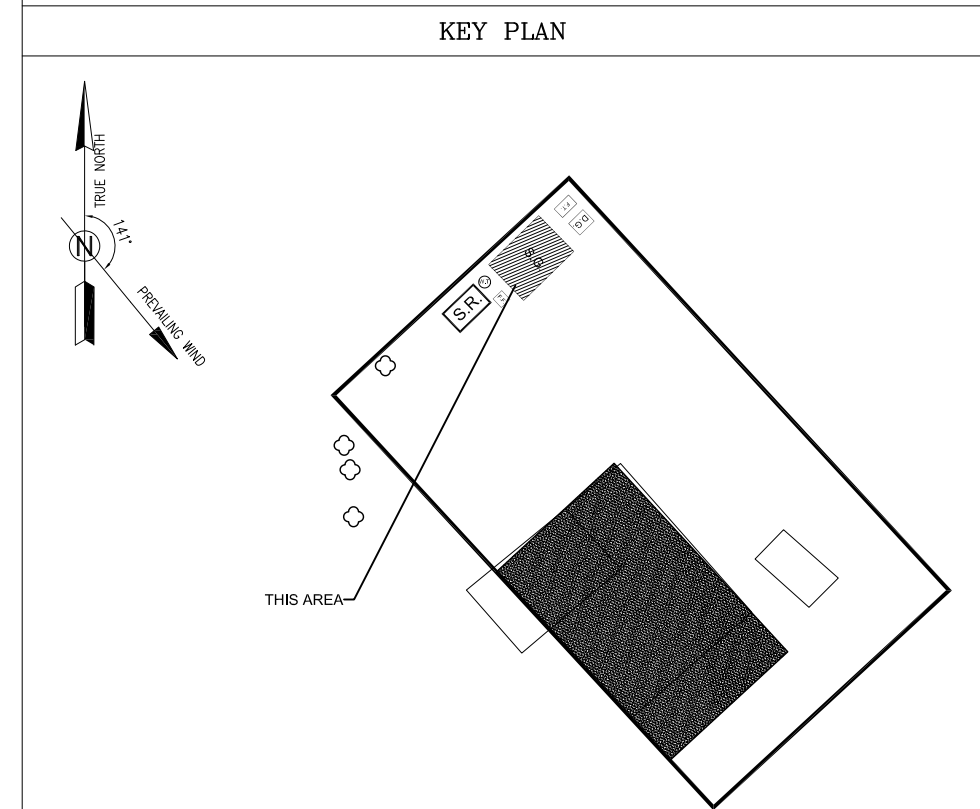[illegible]

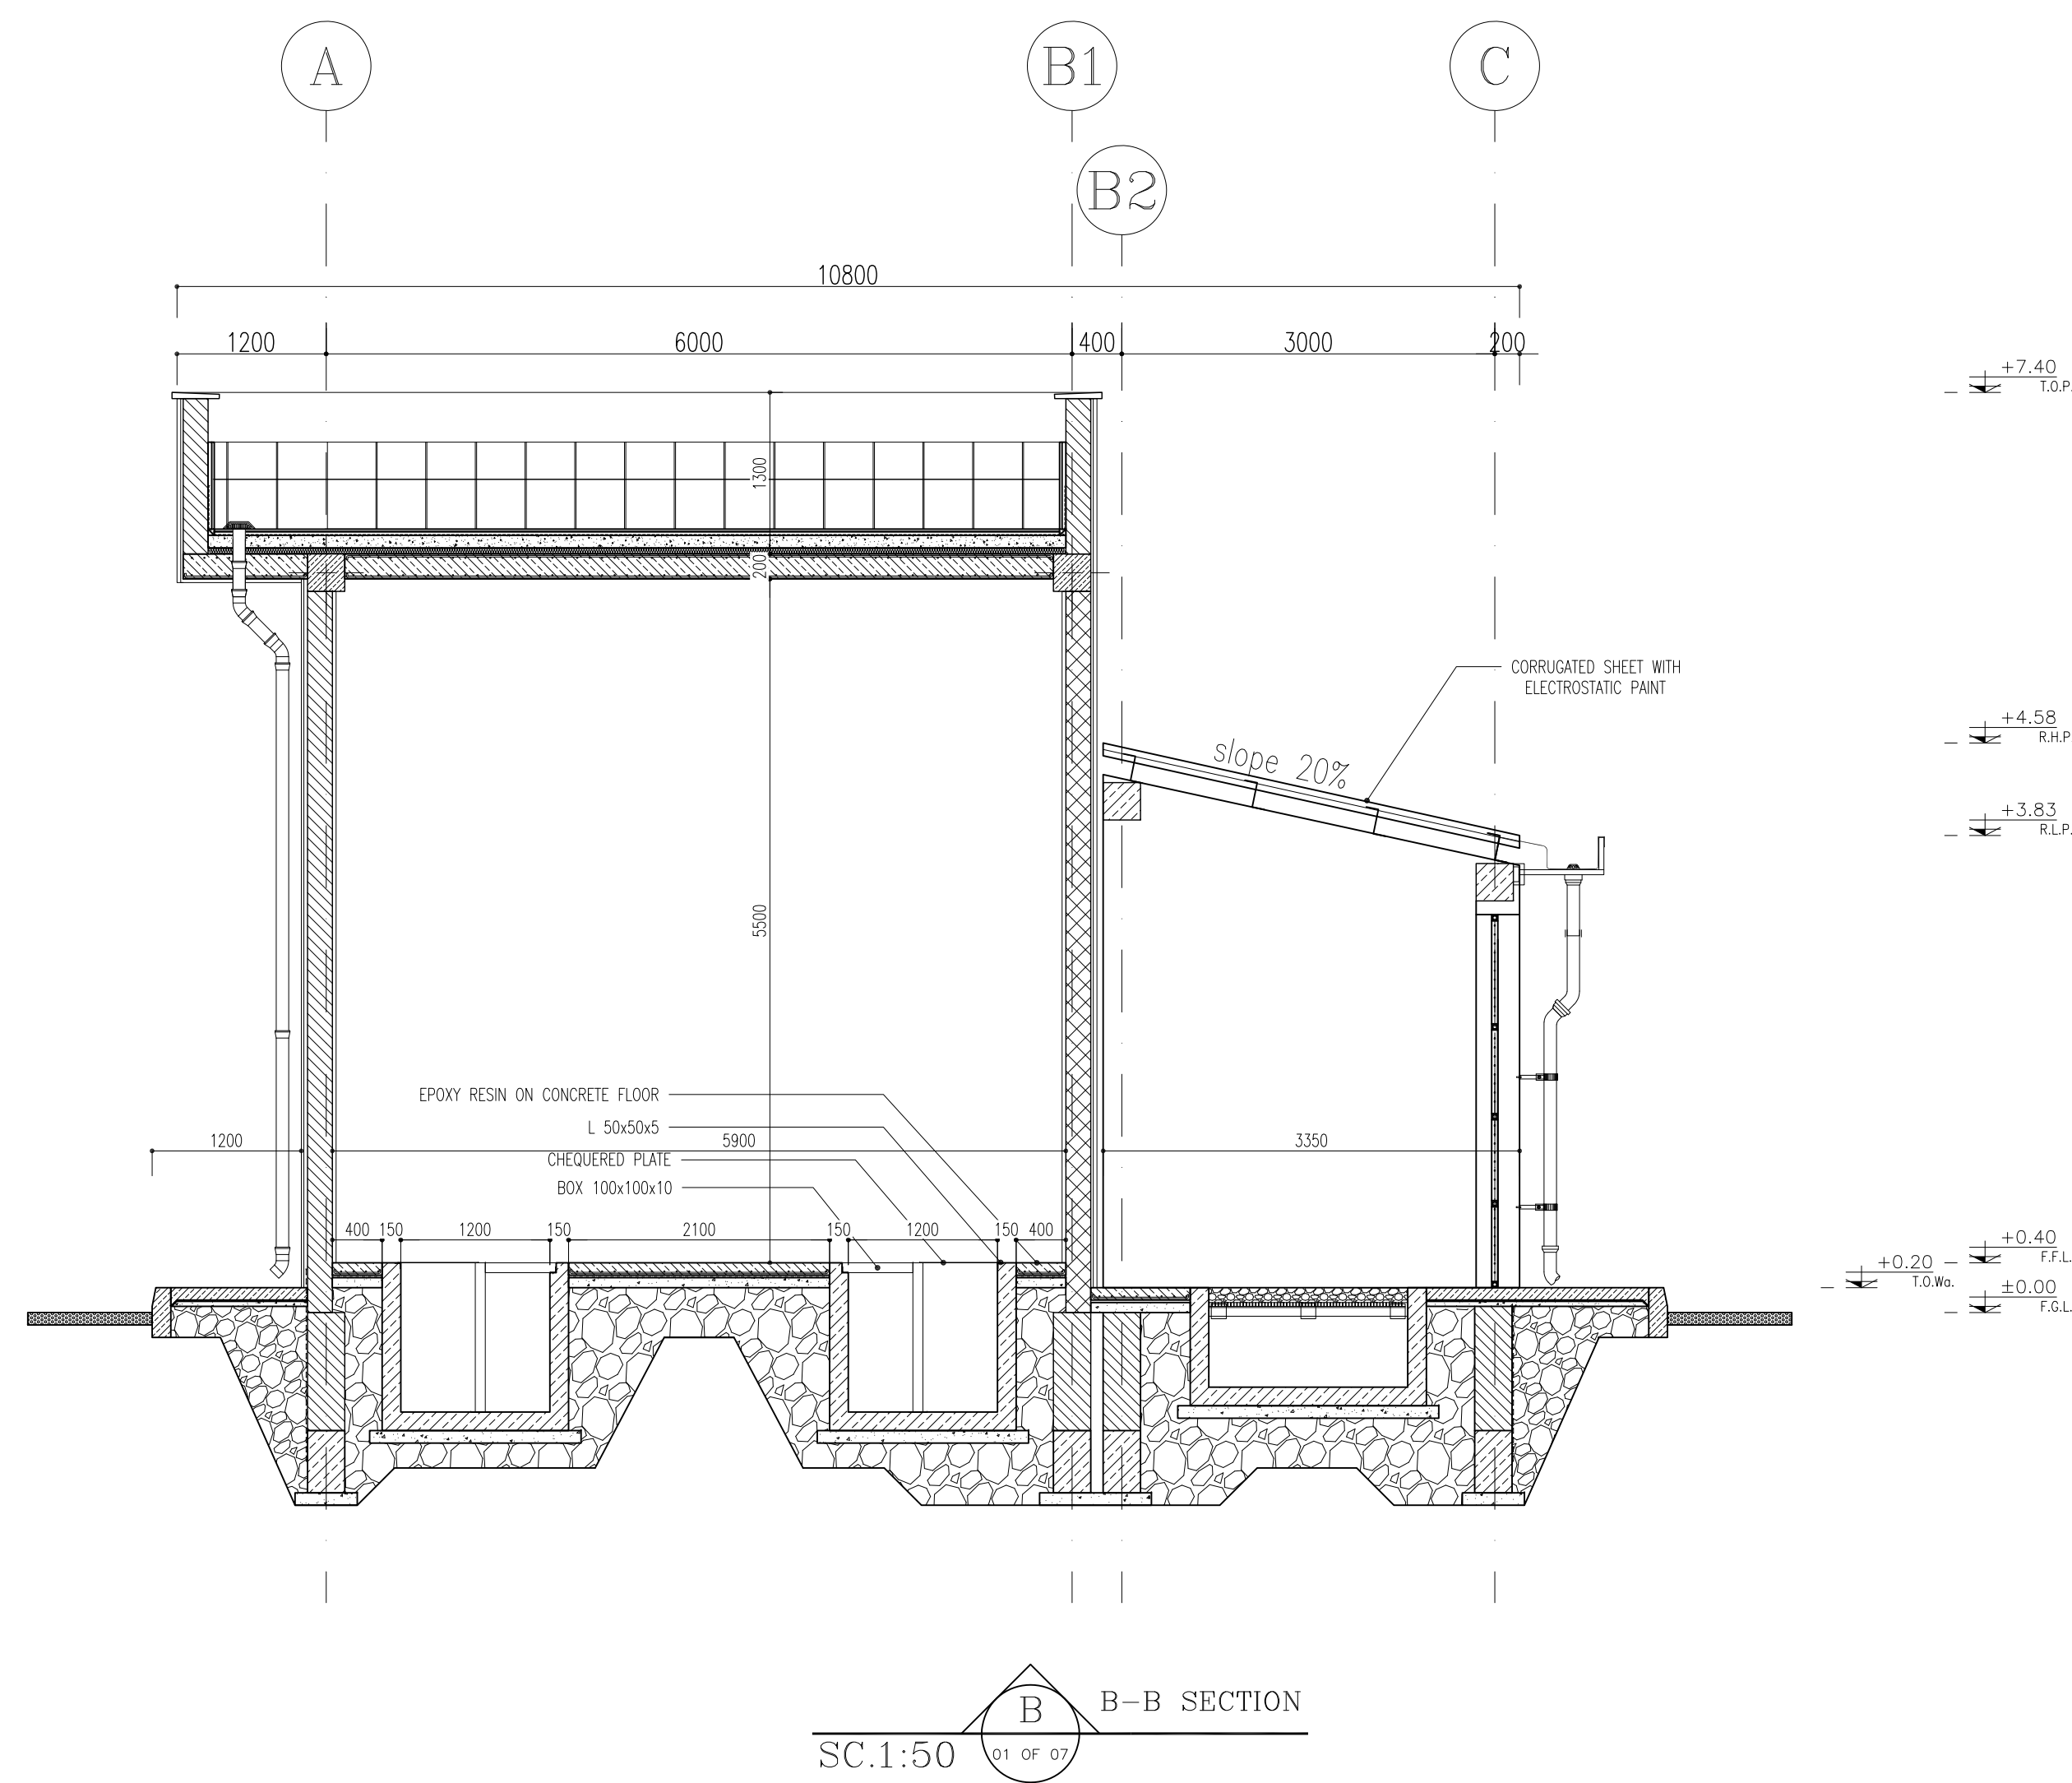

NOTES

- 1- DIMENSIONS ARE IN "MM" AND ELEVATIONS IN "M" UNLESS SPECIFIED .
- 2- ALL DIMENSIONS AND ELEVATIONS SHALL BE CHECKED BY THE CONTRACTOR PRIOR TO CONSTRUCTION
- 3- CONTRACTOR SHALL COMPARE ALL ARCHITECTURAL, MECHANICAL, ELECTRICAL, PIPING, AND STRUCTURAL DRAWINGS AND IN CASE OF ANY CONFLICTS OR DISCREPANCY, INFORM THE ENGINEER.
- 4- SLAB ON GRADE SHALL BE CONSTRUCTED AFTER EXECUTION OF CABLE TRENCH & EQUIPMENTS FOUNDATION.
- 5- ALL MATERIALS ARE SELECTED FROM THE HIGHEST QUALITY AND SHALL BE APPROVED BY THE CLIENT.
- 6- FOR COORDINATE REFER TO FINISH GRADING DOCUMENTS.
- 7- REFERENCE COORDINATES E=1000,000M N=1000,000M REFER TO X=441693, Y=3286498 UTM.
- 8- FINISH GRADING LEVEL (8K05) ELEVATION :
+5.0 m (GLOBAL) ± 0.00 (LOCAL)
- 9) ALL HVAC OPENINGS SIZE, SPECS, AND POSITION WILL BE FINALISED BASED ON HVAC SYSTEM DESIGN.
- 10) BATTERY ROOM EQUIPMENT SHALL BE BLAST-PROOF (EXP)
- 11) DRAWINGS MUST BE IN CONJUNCTION WITH STRUCTURAL, ELECTRICAL, INSTRUMENT AND OTHER DRAWINGS.
- 12) ALL DOORS SHALL BE THERMAL BREAK AND FIRE RESISTANT.
- 13) RAINWATER MUST BE CONNECTED TO THE SURFACE WATER NETWORK.
- 14) BATTERY ROOM EQUIPMENT MUST BE BLAST -PROOF (ACCORDING TO SCOPE OF WORK)

LEGEND			
	BRICK WALL		
	REINFORCED CONCRETE ACCORDING TO STR. DWG		
	BLOCKAGE		
	LEAN CONCRETE		
	FIRE RESISTANT BRICK WALL		
F.F.L.	FINISHED FLOOR	B.O.C.	BOTTOM OF CAGE
F.G.L.	TOP OF WALL	T.O.C.	TOP OF CAGE
T.O.Wa.	TOP OF WALKWAY	R.H.P.	ROOF HIGH POINT
T.O.P.	TOP OF PARAPET	R.L.P.	ROOF LOW POINT
T.O.Fou.	TOP OF FOUNDATION		
B.O.Pit	BOTTOM OF PIT		
B.O.O.	BOTTOM OF OPENING		
T.O.D.	TOP OF DOOR		
T.O.R.	TOP OF ROOF		
T.O.W.	FINISHED GRADING LEVEL		
B.O.O.	BOTTOM OF OPENING		

REFERENCE DRAWING	DRG. No.
STANDARD DRAWING FOR ARCHITECTURAL DETAILS	BK-CNRL-PEDCO-000-AR-DW-0001
STANDARD DETAILS FOR LADDER & SAFETY CAGE	BK-CNRL-PEDCO-000-ST-DW-0004
FOUNDATION DRAWING FOR SWITCHGEAR BUILDING FOR WELL PADS - BK-05	BK-BK05-PEDCO-110-ST-DW-0009
STRUCTURAL DRAWING FOR SWITCHGEAR BUILDING FOR WELL PADS - BK-05	BK-BK05-PEDCO-110-ST-DW-0005
GENERAL CIVIL LAYOUT - BK05	BK-BK05-PEDCO-110-CV-PY-0001
HVAC SYSTEM LAYOUT FOR SWITCHGEAR BUILDING - BK05	BK-BK05-PEDCO-110-HV-PY-0001
PLUMBING & SEWAGE PIPING LAYOUT FOR SWITCHGEAR BUILDING - BK05	BK-BK05-PEDCO-110-HV-PY-0003

FINISHING SCHEDULE						
	AREA	FLOOR	MATERIAL DIMENSION	SKIRTING	WALL	CEILING
(100)	SWITCHGEAR ROOM	EPOXY RESIN ON CONCRETE	—	—	GYPSUM PLASTER WITH WHITE PLASTIC PAINT	WHITE CEMENT PLASTER+OIL PAINT
(101)	BATTERY ROOM	ANTI ACID CERAMIC TILES	(60x60)	—	ANTI ACID CERAMIC TILES	WHITE CEMENT PLASTER+OIL PAINT
(102)	TRANSFORMER SHELTER	SMOOTH LEVELED CONCRETE FINISHING	—	—	SMOOTH LEVELED CONCRETE FINISHING	CURROGATED METAL SHEET 0.75mm — ELECTROSTATIC PAINT
(103)	WALK WAY	SMOOTH LEVELED CONCRETE FINISHING	—	—	WHITE TRAVERTINE W:0.40m GRADE 1	—
(104)	ROOF	TERRAZZO TILE	(40x40)	—	TERRAZZO TILE	TERRAZZO TILE

[illegible]


5cm STONE PARAPET CAP
WATERPROOFING (ISOGUME OR SIMILAR)
WIRE MESH
TERRAZZO TILE (30*30*2.5)
TERRAZZO TILE (30*30*2.5)
SAND CEMENT MORTAR
WATERPROOFING (ISOGUME OR SIMILAR)
LIGHT WEIGHT CONCRETE FOR SLOPING
HIGH DENSITY WOOL STONE INSULATION (100KG/M2)
ACCORDING TO STRUCTURAL DRAWING

PRESSED BRICK
TRAVERTINE STONE
60x60mm±@500cm
EMBEDDED PLATE (100x100x8mm @500cm)
ACCORDING TO STRUCTURAL DRAWING
CEMENT PLASTER
RAINWATER PIPE AND RACK-
SEE DET 01 06/06


RAIN WATER PIPE WITH CLAMP AND JOINTS
ACCORDING TO FINISHING SCHEDULE
ACCORDING TO FINISHING SCHEDULE

WATERPROOFING (ISOGUME OR SIMILAR)
+0.40 F.F.L.
+0.20 T.O.Wa.
±0.00 F.G.L.


WALL SECTION
Sc:1/25

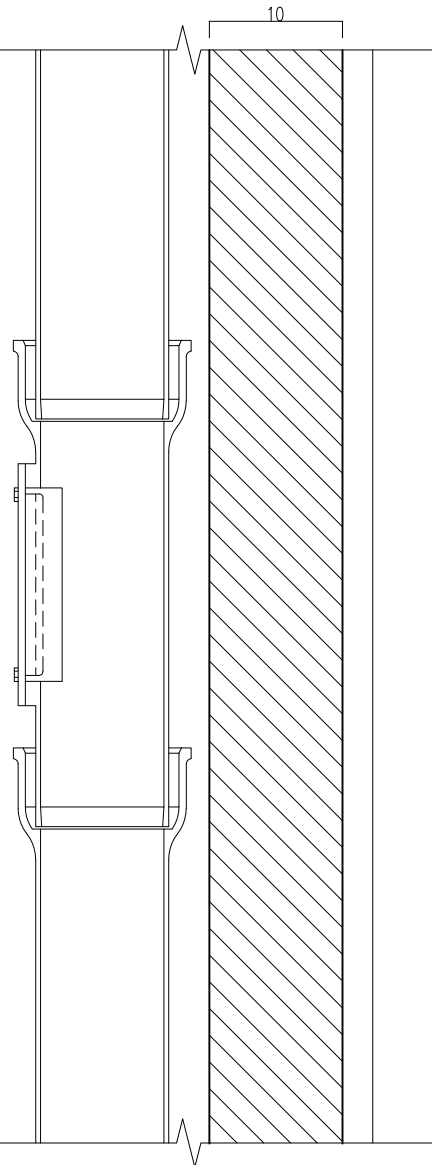


RAINWATER PIPE VALVE DETAIL
Sc:1/25 DETAIL-01

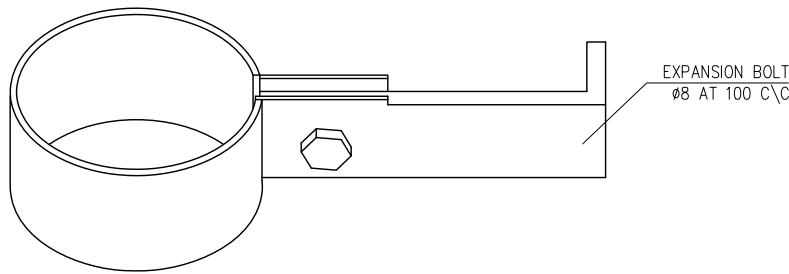

TYPICAL PIPE CLIP ON TRAPEZOIDAL SHEET
Sc:1/10 DETAIL-03

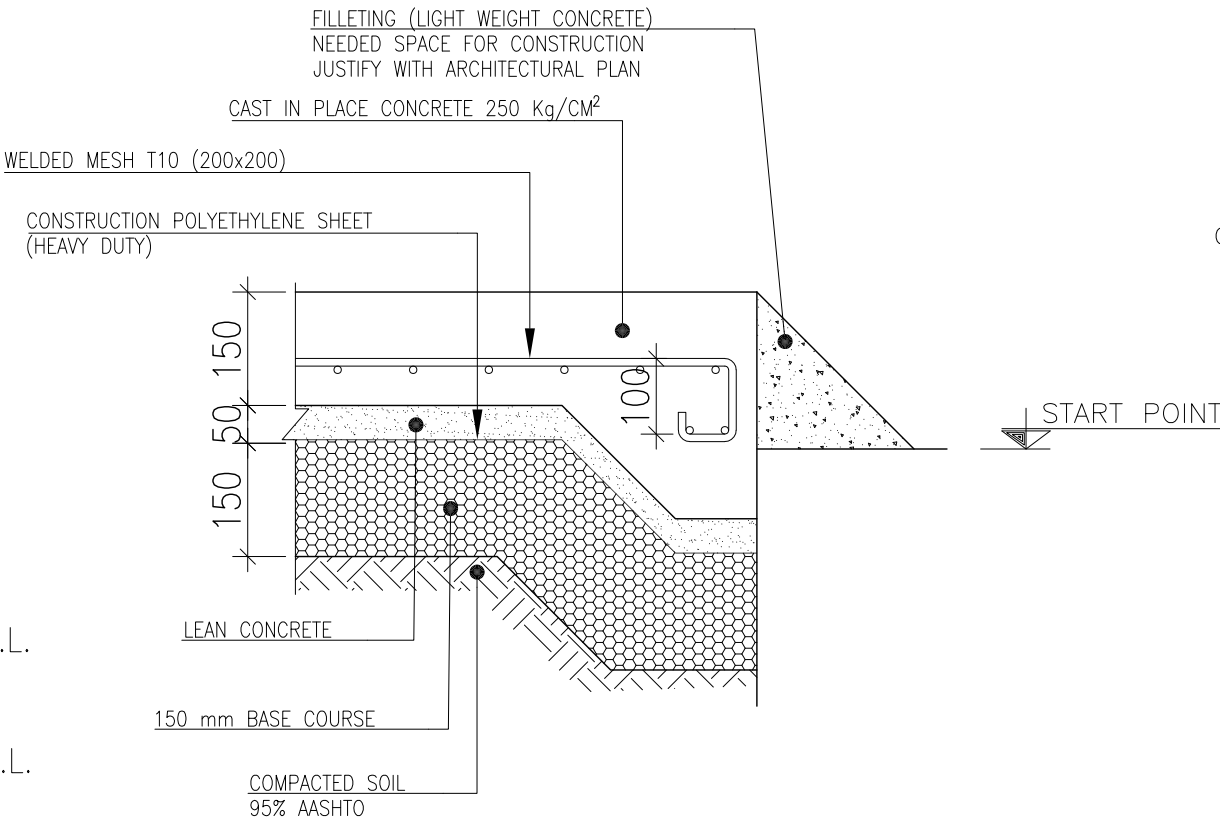


SECTION 7-7
Sc:1/25

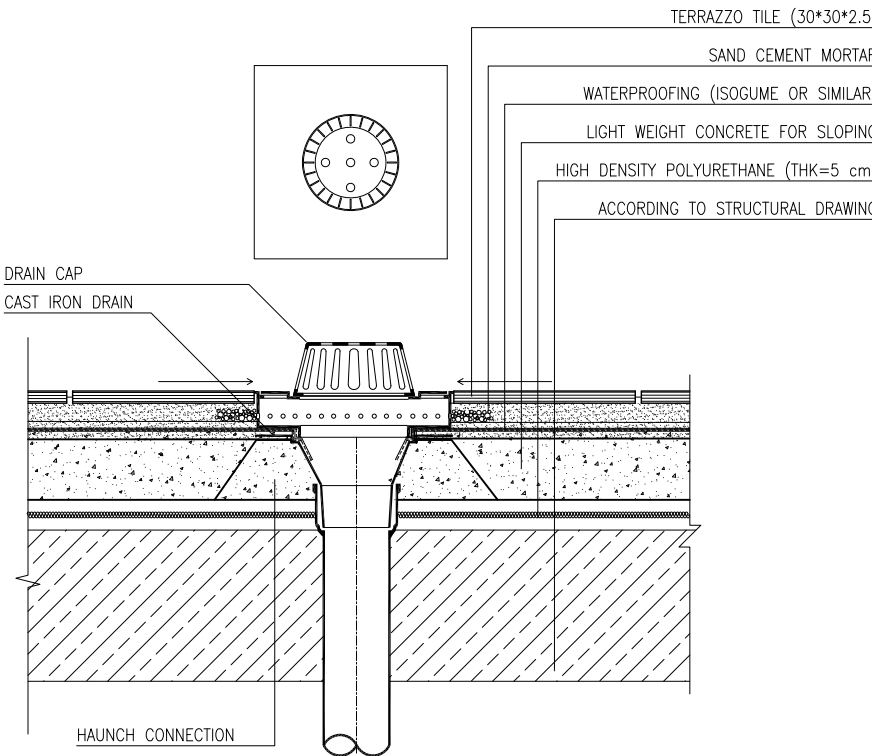


DRAIN DETAIL (ROOF)
Sc:1/25 DETAIL-05

PIPE CLIP PL. THK.= 1.5 mm
Ø 8 BOLT & NUT
Ø 10 HOLE
EXPANSION BOLT #8 AT 100 C/C

TYPICAL PIPE CLIP ON TRAPEZOIDAL SHEET
Sc:1/10 DETAIL-02

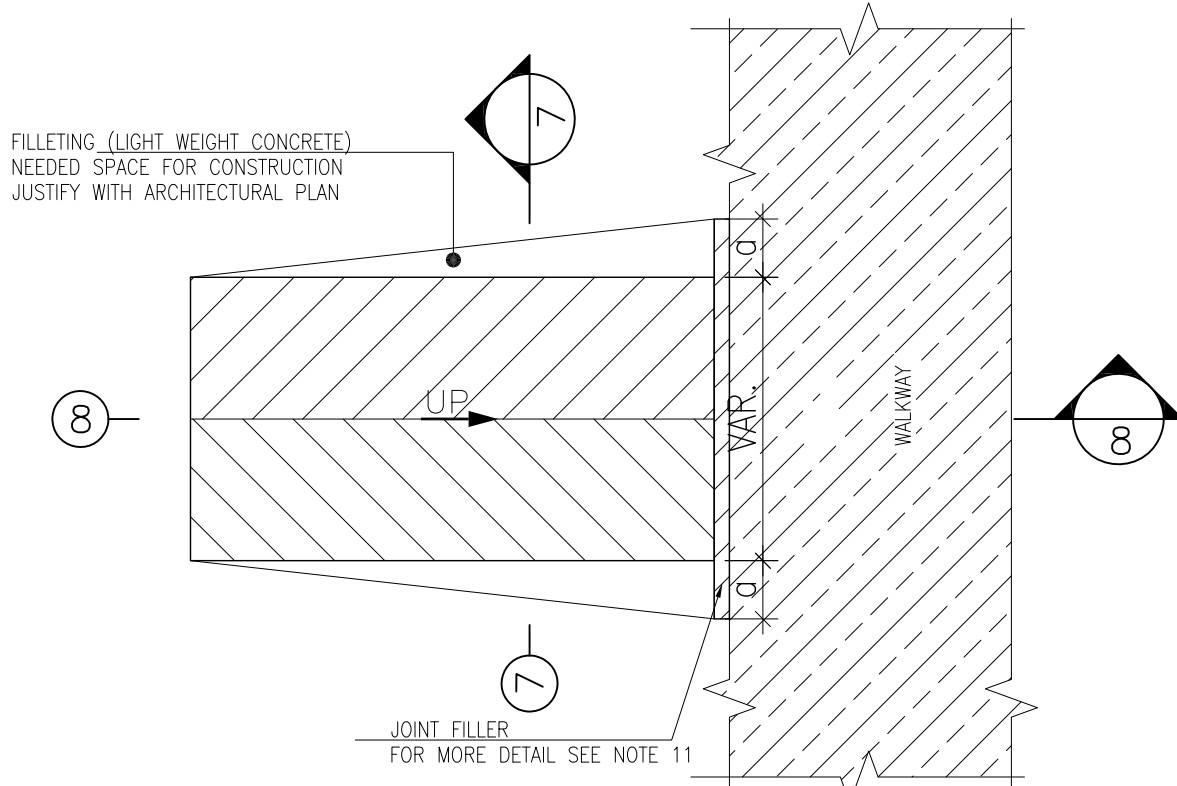

TYPICAL RAMP PLAN
N.T.S DETAIL-04

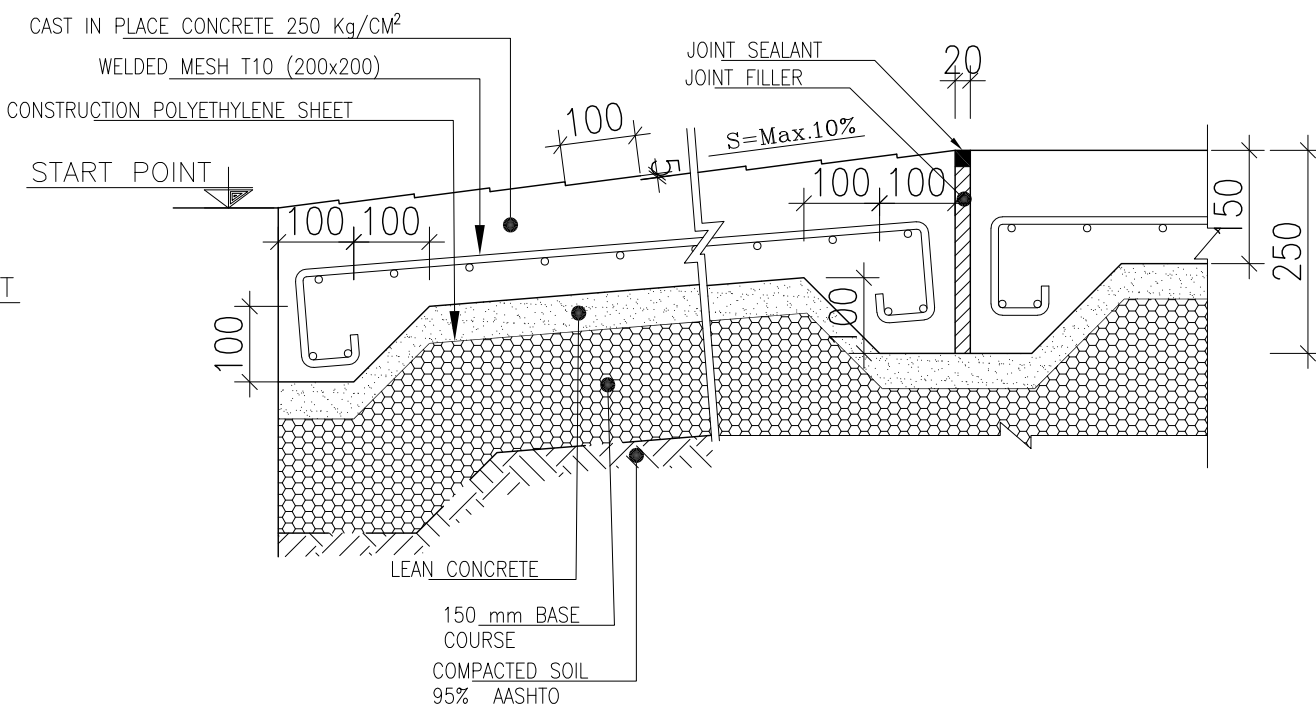


SECTION 8-8
Sc:1/25

- NOTES
- 1- DIMENSIONS ARE IN "mm" AND ELEVATIONS IN "m" UNLESS SPECIFIED .
 - 2- ALL DIMENSIONS AND ELEVATIONS SHALL BE CHECKED BY THE CONTRACTOR PRIOR TO CONSTRUCTION.
 - 3- CONTRACTOR SHALL COMPARE ALL ARCHITECTURAL, MECHANICAL, ELECTRICAL, PIPING AND STRUCTURAL DRAWINGS AND IN CASE OF ANY CONFLICTS OR DISCREPANCY, INFORM THE ENGINEER.
 - 4- SLAB ON GRADE SHALL BE CONSTRUCTED AFTER EXECUTION OF CABLE TRENCH & EQUIPMENTS FOUNDATION.
 - 5- ALL MATERIALS ARE SELECTED FROM THE HIGHEST QUALITY AND SHALL BE APPROVED BY THE CLIENT.
 - 6- FOR COORDINATE REFER TO FINISH GRADING DOCUMENTS.
 - 7) REFERENCE COORDINATES E=1000.000 , N=1000.000 REFER TO X=441693 , Y=3286498 UTM.
 - 8) FINISH GRADING LEVEL (BK05) ELEVATION :
+50 m (GLOBAL) = ±0.00 (LOCAL)
 - 9) ALL HVAC OPENINGS SIZE, SPECS, AND POSITION WILL BE FINALISED BASED ON HVAC SYSTEM DESIGN.
 - 10) BATTERY ROOM EQUIPMENT SHALL BE BLAST-PROOF (EXP)
 - 11) DRAWINGS MUST BE IN CONJUNCTION WITH STRUCTURAL, ELECTRICAL, INSTRUMENT AND OTHER DRAWINGS.
 - 12) ALL DOORS SHALL BE THERMAL BREAK AND FIRE RESISTANT.
 - 13) RAINWATER MUST BE CONNECTED TO THE SURFACE WATER NETWORK.
 - 14) BATTERY ROOM EQUIPMENT MUST BE BLAST -PROOF.(ACCORDING TO SCOPE OF WORK)

- LEGEND
- BRICK WALL
 - REINFORCED CONCRETE
ACCORDING TO STR. DWG
 - BLOCKAGE
 - LEAN CONCRETE
 - FIRE RESISTANT BRICK WALL
- F.F.L. FINISHED FLOOR B.O.C. BOTTOM OF CAGE
P.G.L. TOP OF WALL T.O.C. TOP OF CAGE
T.O.Wa. TOP OF WALKWAY R.H.P. ROOF HIGH POINT
T.O.P. TOP OF PARAPET R.L.P. ROOF LOW POINT
T.O.Fou. TOP OF FOUNDATION
B.O.Pit BOTTOM OF PIT
B.O.O. BOTTOM OF OPENING
T.O.D. TOP OF DOOR
T.O.R. TOP OF ROOF
T.O.W. FINISHED GRADING LEVEL
B.O.O. BOTTOM OF OPENING






REFERENCE DRAWING	DRG. No.
STANDARD DRAWING FOR ARCHITECTURAL DETAILS	BK-GNRL-PEDCO-000-AR-DW-0001
STANDARD DETAILS FOR LADDER & SAFETY CAGE	BK-GNRL-PEDCO-000-ST-DW-0009
FOUNDATION DRAWING FOR SWITCHGEAR BUILDING FOR WELL PADS - BK-05	BK-BK05-PEDCO-110-ST-DW-0004
STRUCTURAL DRAWING FOR SWITCHGEAR BUILDING FOR WELL PADS - BK-05	BK-BK05-PEDCO-110-ST-DW-0005
GENERAL CIVIL LAYOUT - BK05	BK-BK05-PEDCO-110-CV-PY-0001
HVAC SYSTEM LAYOUT FOR SWITCHGEAR BUILDING - BK05	BK-BK05-PEDCO-110-HV-PY-0001
PLUMBING & SEWAGE PIPING LAYOUT FOR SWITCHGEAR BUILDING - BK05	BK-BK05-PEDCO-110-HV-PY-0003

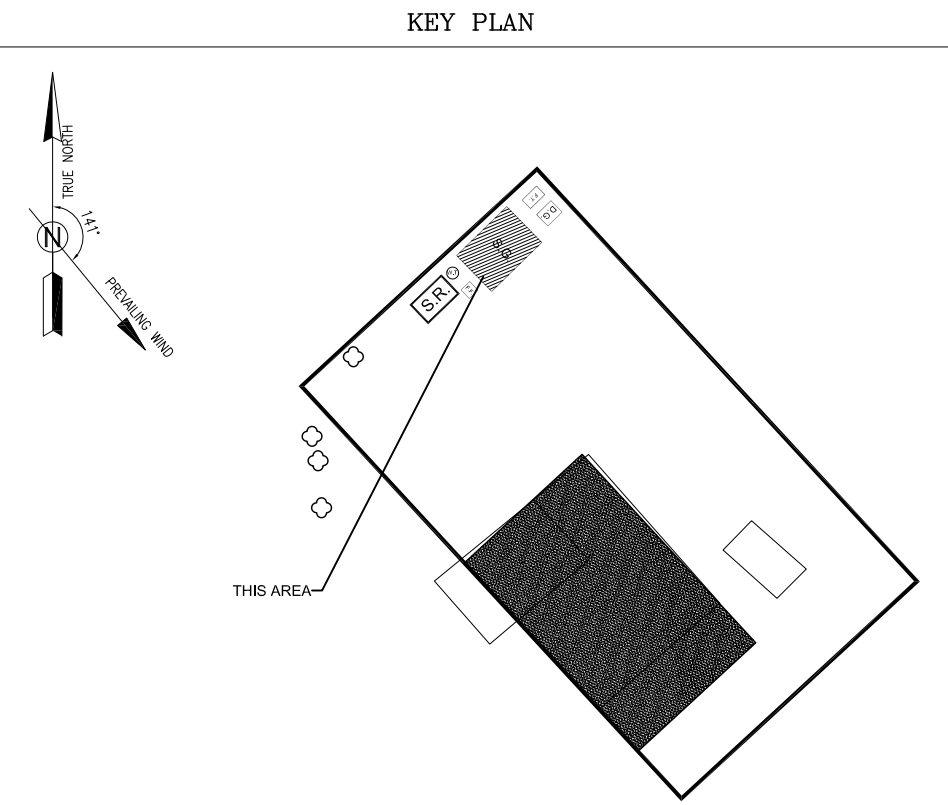



REV.	DATE	DESCRIPTION	BY	DATE	BY	DATE
D03	MAR.2023	IPA	R.BERLOUIE	M.PAKHARIAN	M.Mehrshad	***
D02	SEP.2022	IPC	R.BERLOUIE	M.PAKHARIAN	M.Mehrshad	***
D01	MAY.2022	IPC	R.BERLOUIE	M.PAKHARIAN	M.Mehrshad	***
D00	MAR.2022	IPC	R.BERLOUIE	M.PAKHARIAN	M.Mehrshad	***

PROJECT NAME:		BINAK OILFIELD DEVELOPMENT/SUB-SURFACE WORK PACKAGES BK05 WHF MODIFICATIONS			
PROJECT NO.:		971020			
EPC CONTRACTOR:		EPD/EPC CONTRACTOR (GC):			
 HIRGAN ENERGY - DESIGN & INSPECTION COMPANIES		 PEDCO		 PETROIRAN DEVELOPMENT COMPANY	
DRAWING TITLE: ARCHITECTURAL DRAWING FOR SWITCHGEAR BUILDING OF WELL PADS – BK-05 WALL SECTION AND DETAILS					
SCALE	SIZE	DRAWING NO.		SHEET NO.	REV
AS SHOWN	A1	BK-BK05-PEDCO-110-AR-DW-0002		06 OF 07	D03

DATE	SCALE	DRAWING BY	CHECKED BY	PROJECT ENG.
NO CONSTRUCTION PERMITTED UNLESS DRAWING APPROVED				
APPROVED FOR CONSTRUCTION		BY:		DATE:
BUDGET REP	LOCATION	SIZE CLASS	SERIAL NO.	SHEET REVISION
AS SHOWN	A1	BK-BK05-PEDCO-110-AR-DW-0002	06 OF 07	D03

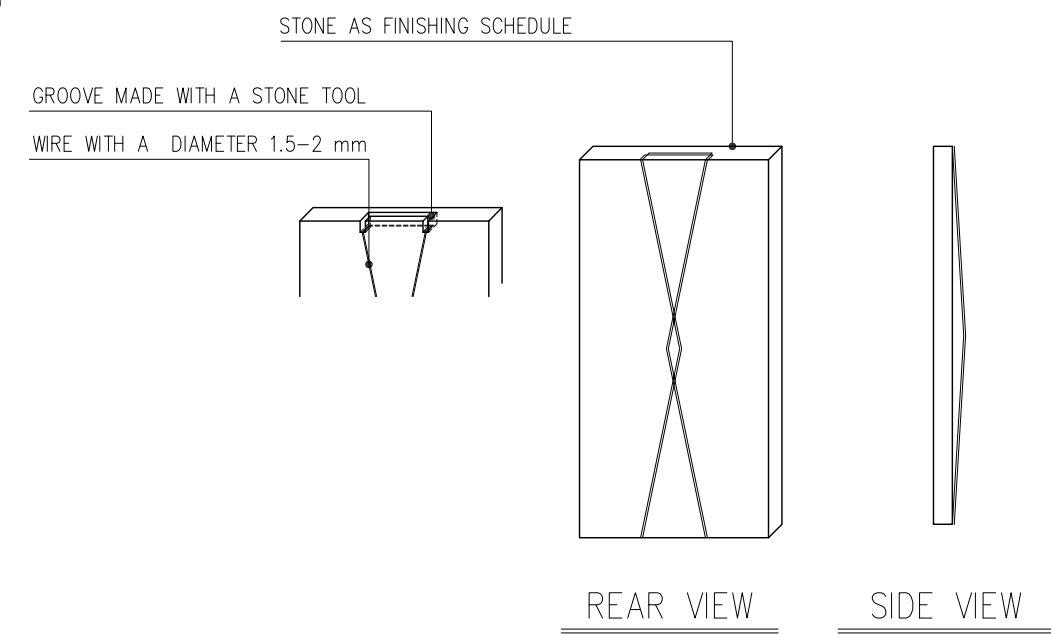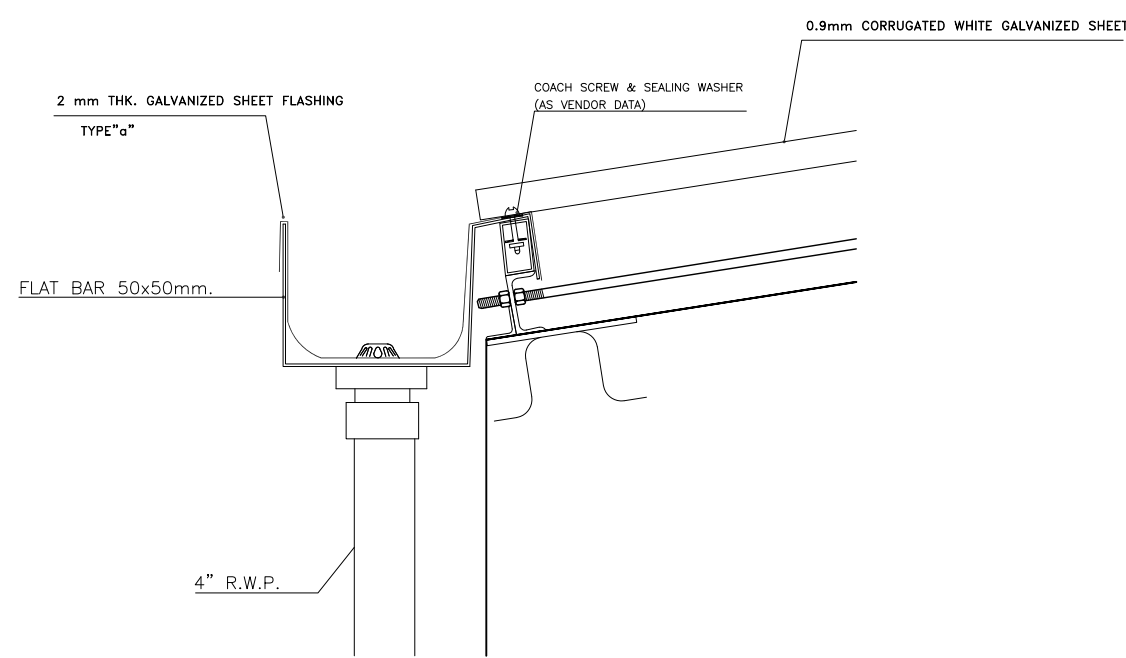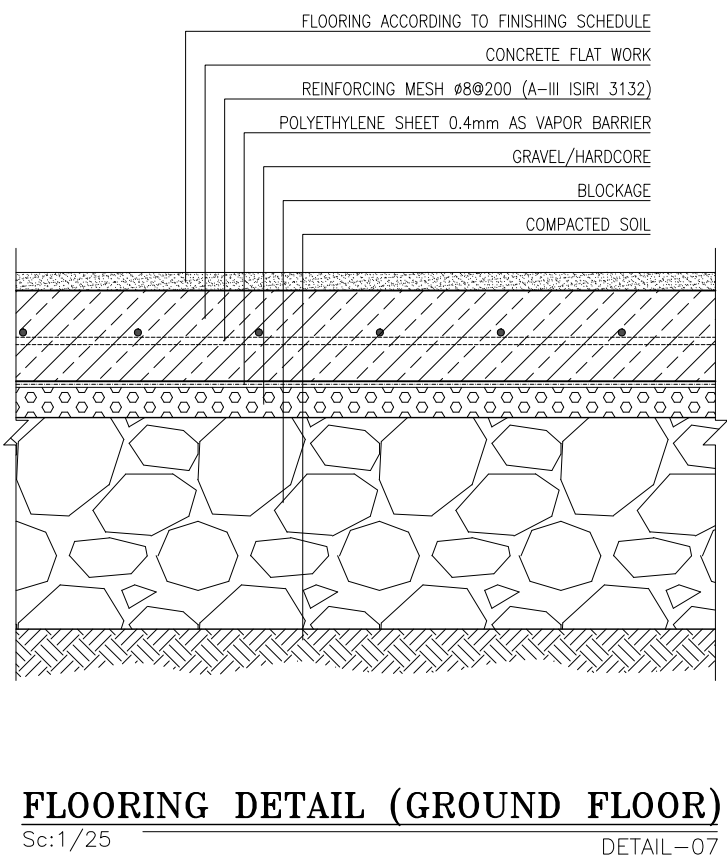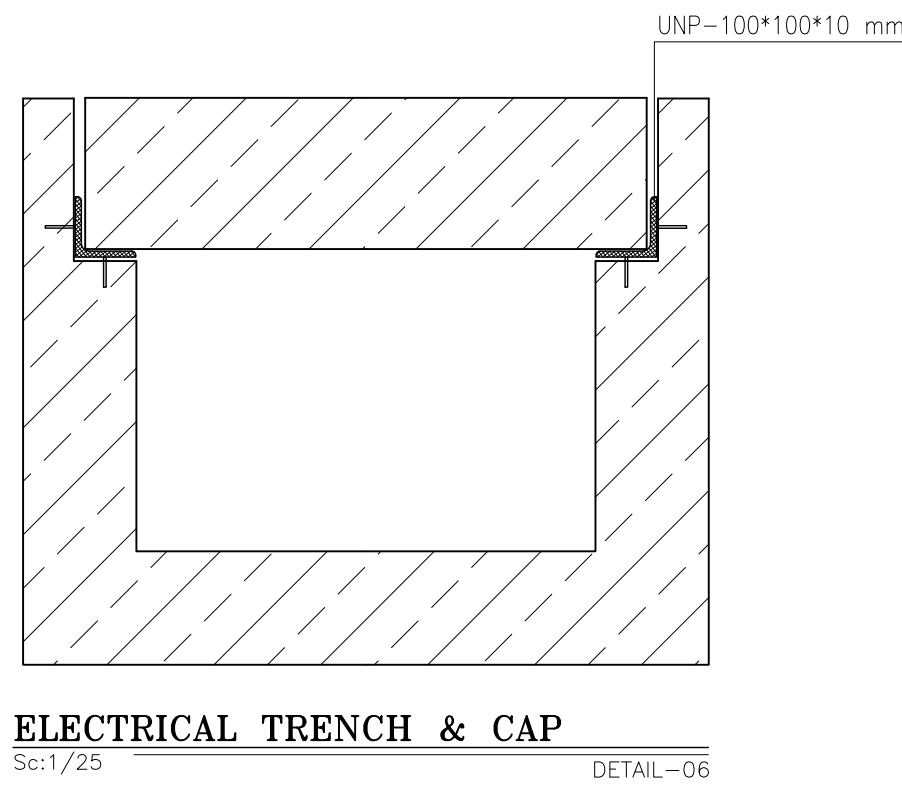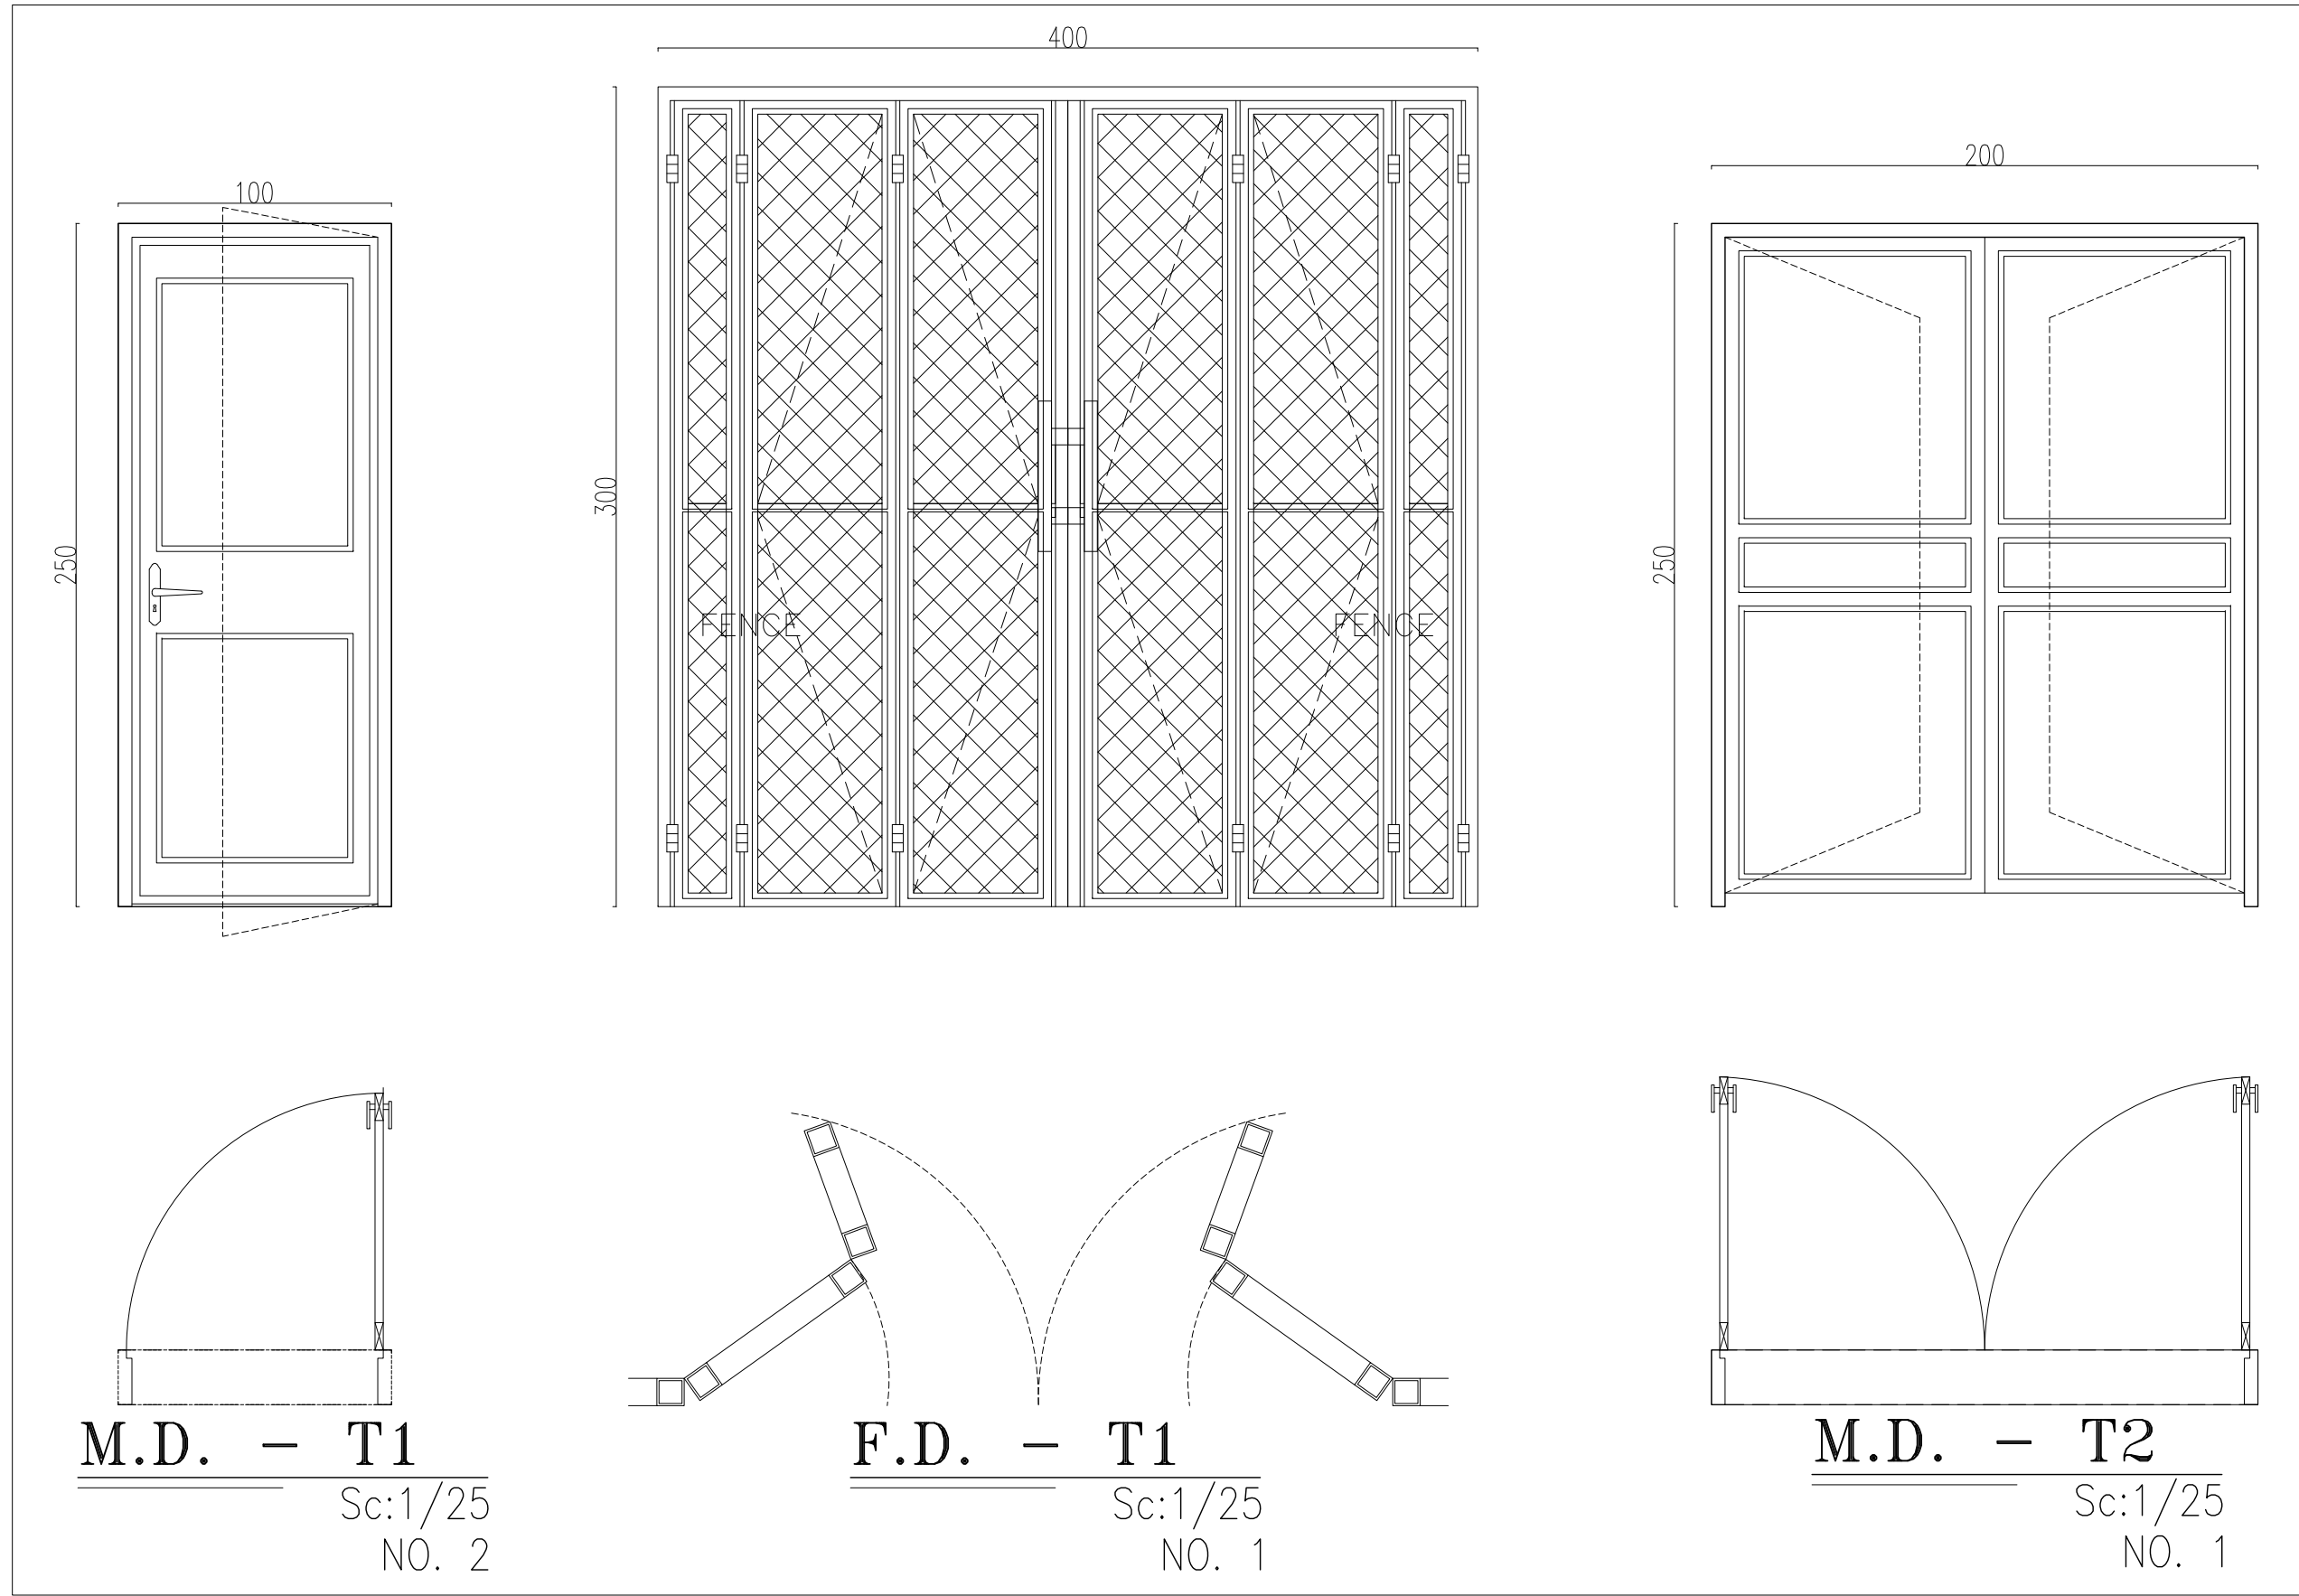

DOOR TYPES

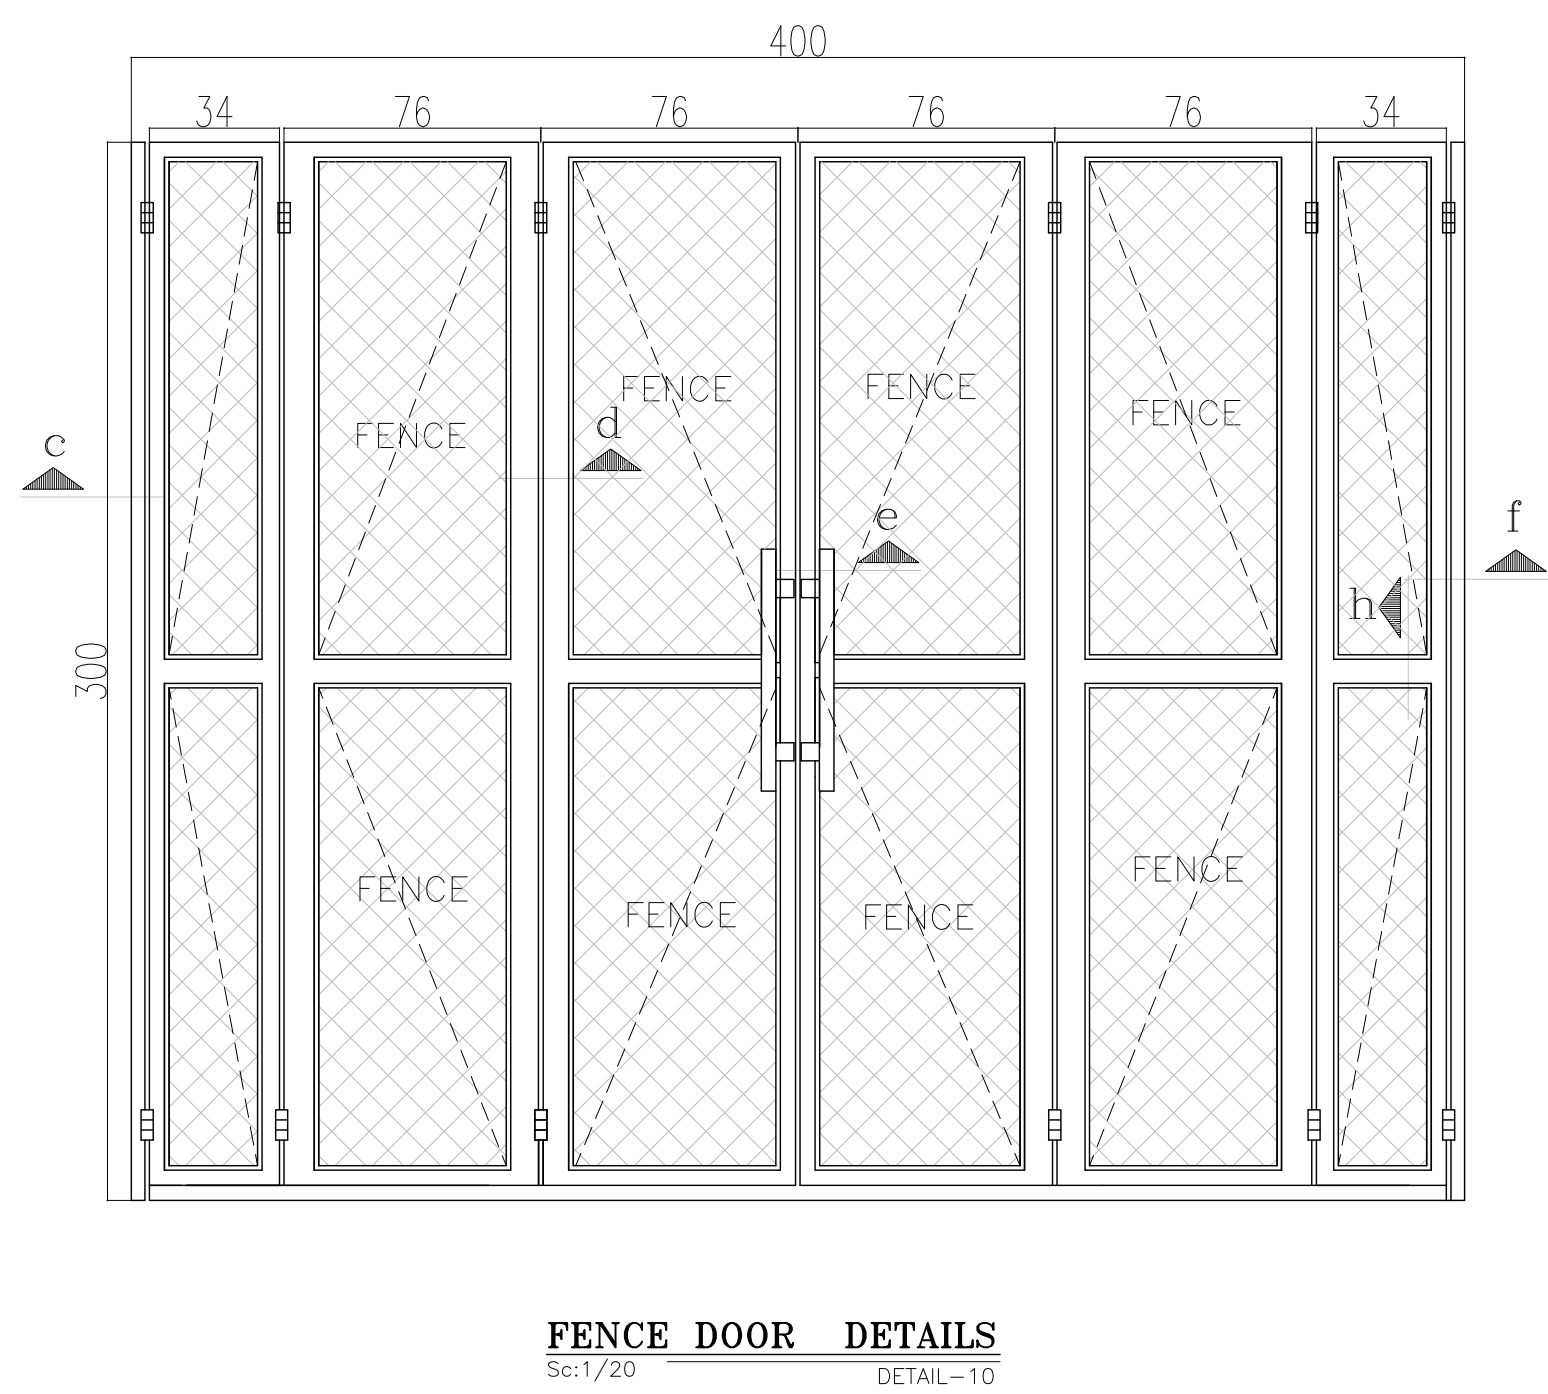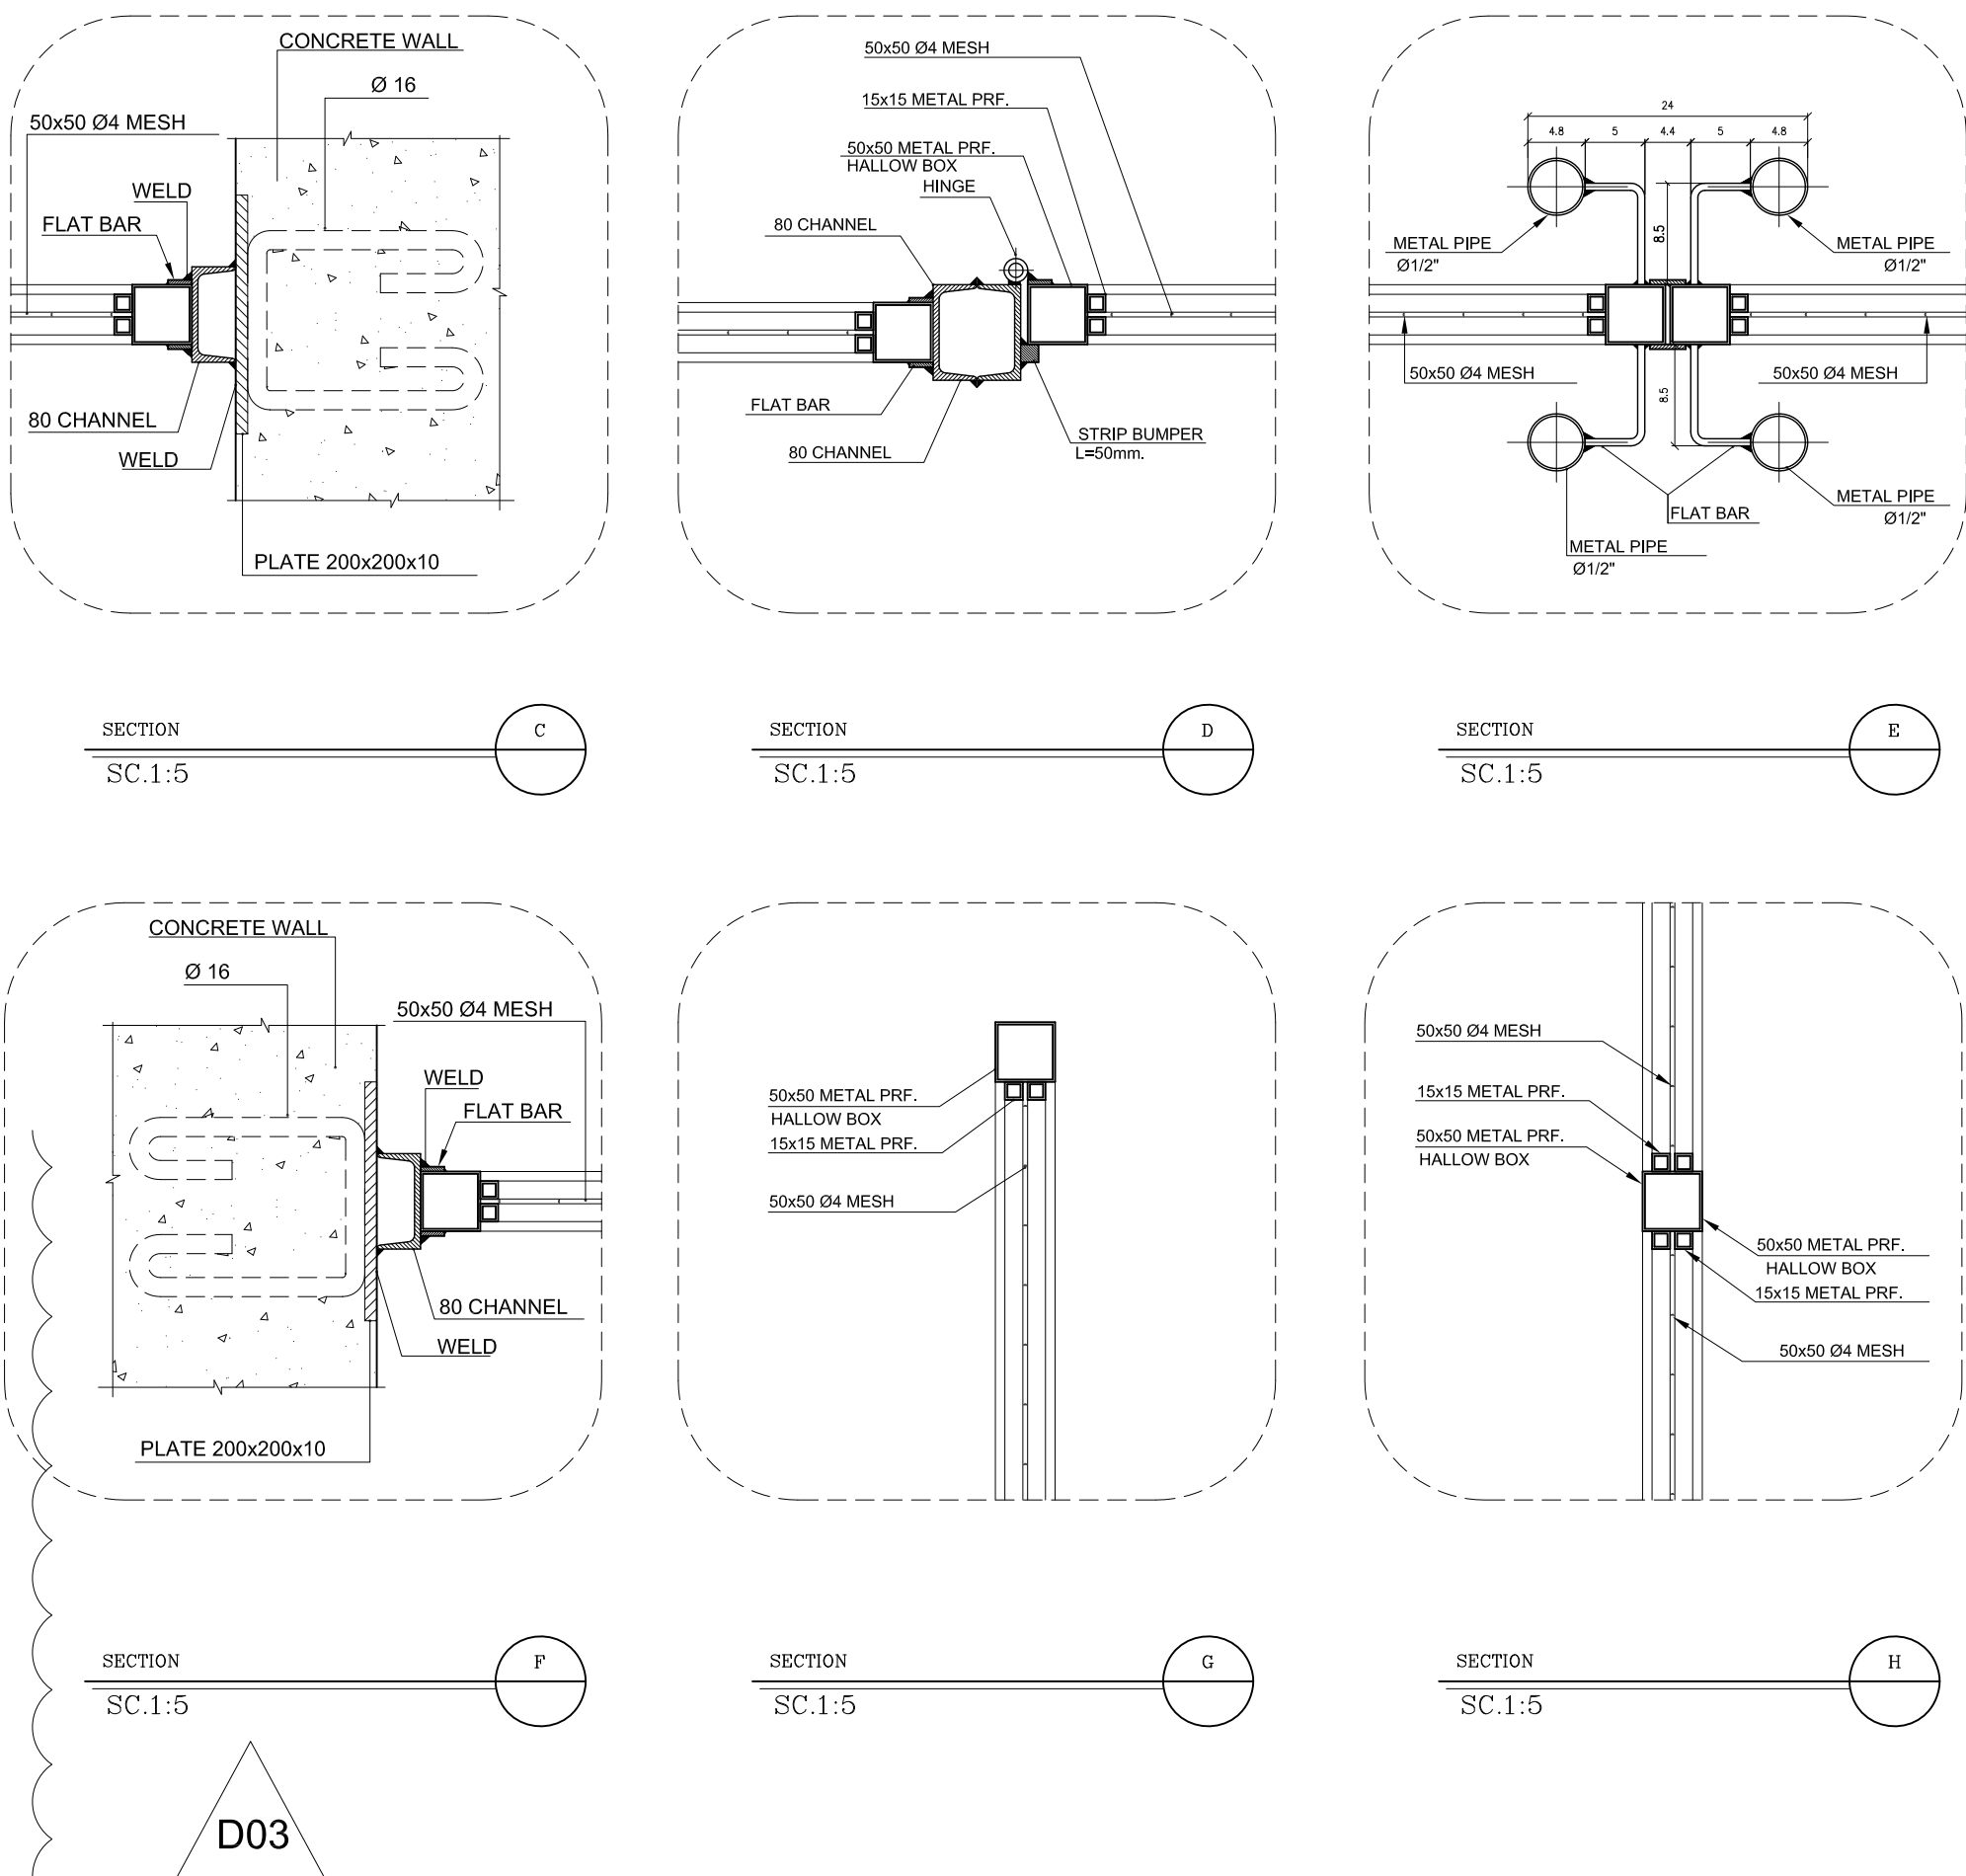


- NOTES
- 1- DIMENSIONS ARE IN "mm" AND ELEVATIONS IN "m" UNLESS SPECIFIED .
 - 2- ALL DIMENSIONS AND ELEVATIONS SHALL BE CHECKED BY THE CONTRACTOR PRIOR TO CONSTRUCTION.
 - 3- CONTRACTOR SHALL COMPARE ALL ARCHITECTURAL, MECHANICAL, ELECTRICAL, PIPING AND STRUCTURAL DRAWINGS AND IN CASE OF ANY CONFLICTS OR DISCREPANCY, INFORM THE ENGINEER.
 - 4- SLAB ON GRADE SHALL BE CONSTRUCTED AFTER EXECUTION OF CABLE TRENCH & EQUIPMENTS FOUNDATION.
 - 5- ALL MATERIALS ARE SELECTED FROM THE HIGHEST QUALITY AND SHALL BE APPROVED BY THE CLIENT.
 - 6- FOR COORDINATE REFER TO FINISH GRADING DOCUMENTS.
 - 7) REFERENCE COORDINATES E=1000.000 , N=1000.000 REFER TO X=441693 , Y=3286498 UTM.
 - 8) FINISH GRADING LEVEL (BK05) ELEVATION :
+50 m (GLOBAL) = ±0.00 (LOCAL)
 - 9) ALL HVAC OPENINGS SIZE, SPECS, AND POSITION WILL BE FINALISED BASED ON HVAC SYSTEM DESIGN.
 - 10) BATTERY ROOM EQUIPMENT SHALL BE BLAST-PROOF (EXP)
 - 11) DRAWINGS MUST BE IN CONJUNCTION WITH STRUCTURAL, ELECTRICAL, INSTRUMENT AND OTHER DRAWINGS.
 - 12) ALL DOORS SHALL BE THERMAL BREAK AND FIRE RESISTANT.
 - 13) RAINWATER MUST BE CONNECTED TO THE SURFACE WATER NETWORK.
 - 14) BATTERY ROOM EQUIPMENT MUST BE BLAST -PROOF.(ACCORDING TO SCOPE OF WORK)

- LEGEND
- BRICK WALL
 - REINFORCED CONCRETE ACCORDING TO STR. DWG
 - BLOCKAGE
 - LEAN CONCRETE

- F.F.L. FINISHED FLOOR B.O.C. BOTTOM OF CAGE
F.G.L. TOP OF WALL T.O.C. TOP OF CAGE
T.O.Wa. TOP OF WALKWAY R.H.P. ROOF HIGH POINT
T.O.P. TOP OF PARAPET R.L.P. ROOF LOW POINT
T.O.Fou. TOP OF FOUNDATION
B.O.Pit. BOTTOM OF PIT
B.O.O. BOTTOM OF OPENING
T.O.D. TOP OF DOOR
T.O.R. TOP OF ROOF
T.O.W. FINISHED GRADING LEVEL
B.O.O. BOTTOM OF OPENING

REFERENCE DRAWING	DRG. No.
STANDARD DRAWING FOR ARCHITECTURAL DETAILS	BK-GNRL-PEDCO-000-AR-DW-0001
STANDARD DETAILS FOR LADDER & SAFETY CAGE	BK-GNRL-PEDCO-000-ST-DW-0009
FOUNDATION DRAWING FOR SWITCHGEAR BUILDING FOR WELL PADS - BK-05	BK-BK05-PEDCO-110-ST-DW-0004
STRUCTURAL DRAWING FOR SWITCHGEAR BUILDING FOR WELL PADS - BK-05	BK-BK05-PEDCO-110-ST-DW-0005
GENERAL CIVIL LAYOUT - BK05	BK-BK05-PEDCO-110-CV-PY-0001
HVAC SYSTEM LAYOUT FOR SWITCHGEAR BUILDING - BK05	BK-BK05-PEDCO-110-HV-PY-0001
PLUMBING & SEWAGE PIPING LAYOUT FOR SWITCHGEAR BUILDING - BK05	BK-BK05-PEDCO-110-HV-PY-0003

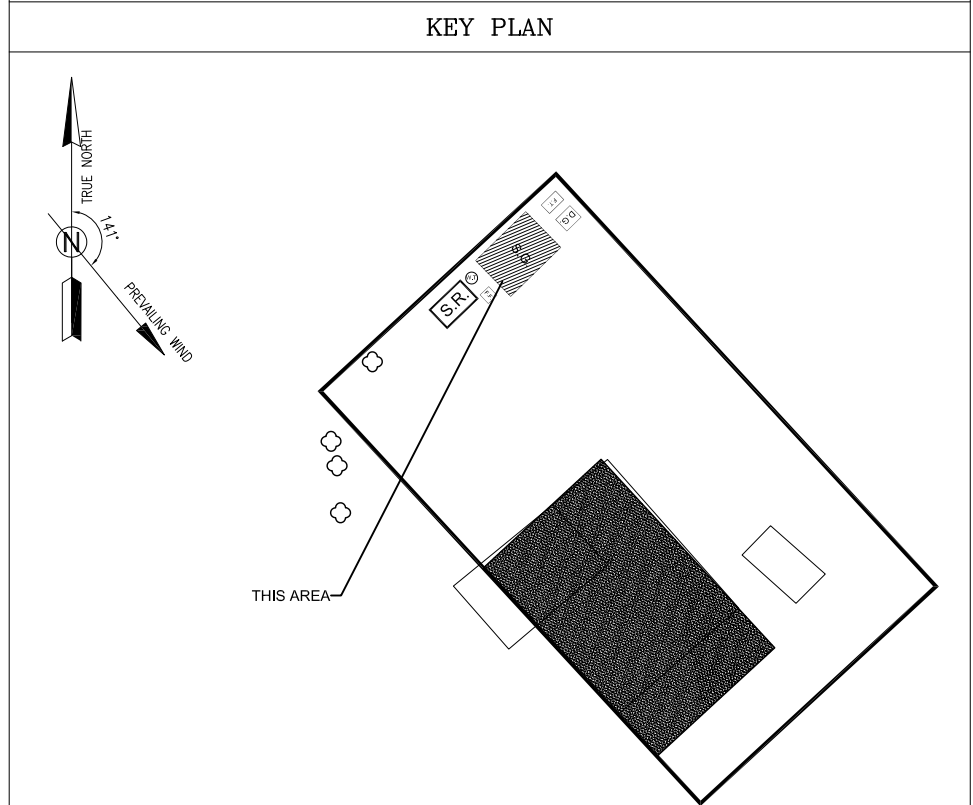

D03	MAR.2023	IPA	R.BERLOUIE	M.PAKHARIAN	M.Mehrshad	***							
D02	SEP.2022	IFC	R.BERLOUIE	M.PAKHARIAN	M.Mehrshad	***	***	*****	***	*****	*** 07 *****		
D01	MAY.2022	IFC	R.BERLOUIE	M.PAKHARIAN	M.Mehrshad	***	REV.	DESCRIPTION	BY	DATE	BY	DATE	
D00	MAR.2022	IFC	R.BERLOUIE	M.PAKHARIAN	M.Mehrshad	***			CHECKED		REV. APPR.		
REV.	DATE	P.O.I.S	PREP.	CHK.	APP.	AUT.	اصل و کلیه نسخ این نقشه و حق آفتابش متعلق به شرکت ملی مناطق نفت خیز جنوب میباشند.						
PROJECT NAME: BINAK OILFIELD DEVELOPMENT/SUB-SURFACE WORK PACKAGES BK05 WHF MODIFICATIONS								THE ORIGINAL AND ALL COPIES OF THIS DRAWING TOGETHER WITH THE COPYRIGHT THEREIN ARE THE SOLE PROPERTY OF N.I.S.O.C./ FIELDS					
PROJECT NO.: 971020													
EPC CONTRACTOR:			EPD/EPC CONTRACTOR (GC):				BINAK OILFIELD DEVELOPMENT SUB-SURFACE WORK PACKAGES BK05 WHF MODIFICATIONS						
 HIRGAN ENERGY - DESIGN & INSPECTION COMPANIES			 PETROIRAN DEVELOPMENT COMPANY										
							DATE	SCALE	DRAWING BY	CHECKED BY	PROJECT ENG.		
DRAWING TITLE: ARCHITECTURAL DRAWING FOR SWITCHGEAR BUILDING OF WELL PADS - BK-05 DETAILS							NO CONSTRUCTION PERMITTED UNLESS DRAWING APPROVED						
							APPROVED FOR CONSTRUCTION			BY:	DATE:		
SCALE	SIZE	DRAWING NO.			SHEET NO.	REV.	BUDGET REF.	LOCATION	SIZE	CLASS	SERIAL NO.	SHEET	REVISION
AS SHOWN	A1	BK-BK05-PEDCO-110-AR-DW-0002			07 OF 07	D03	053-073-9184	F	4	B	708456	07 OF 07	D03