


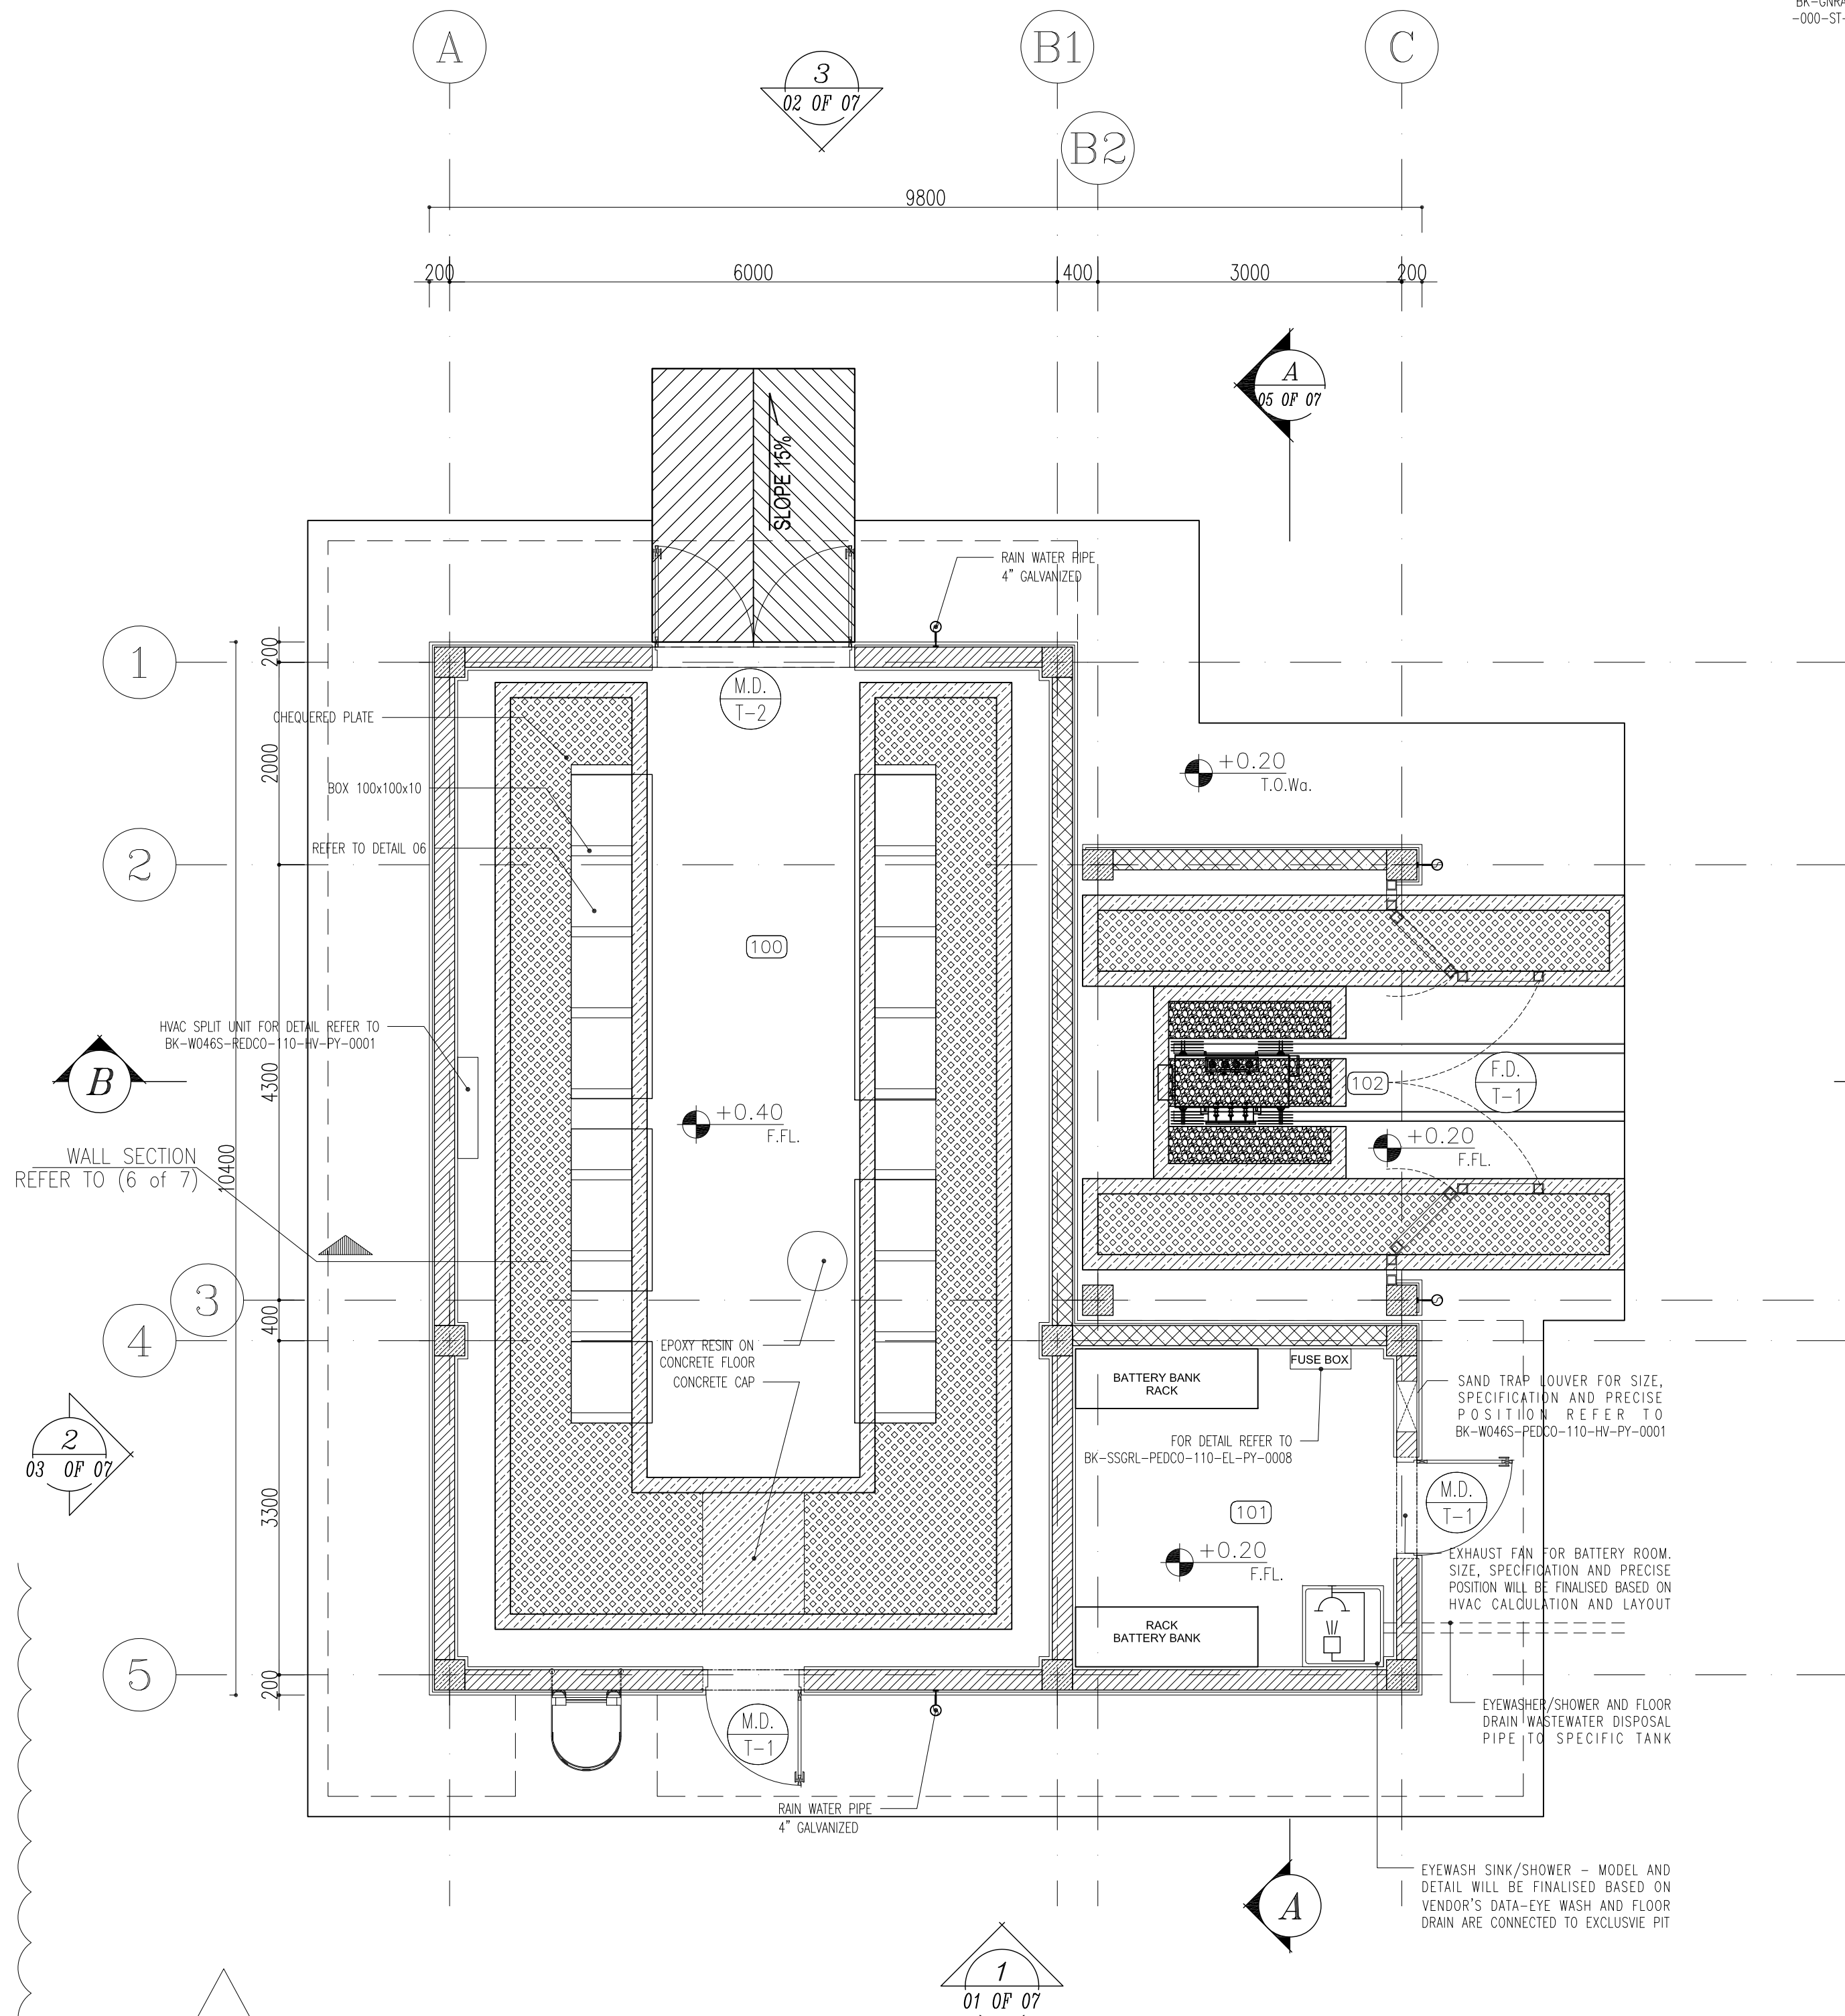


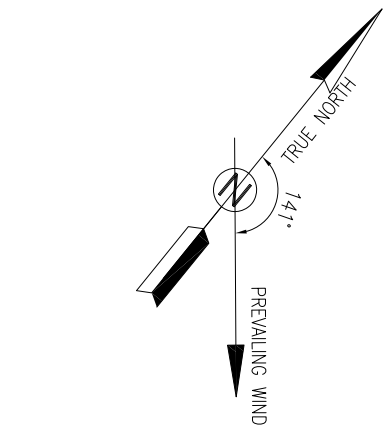

SC.1:50 1 PLAN

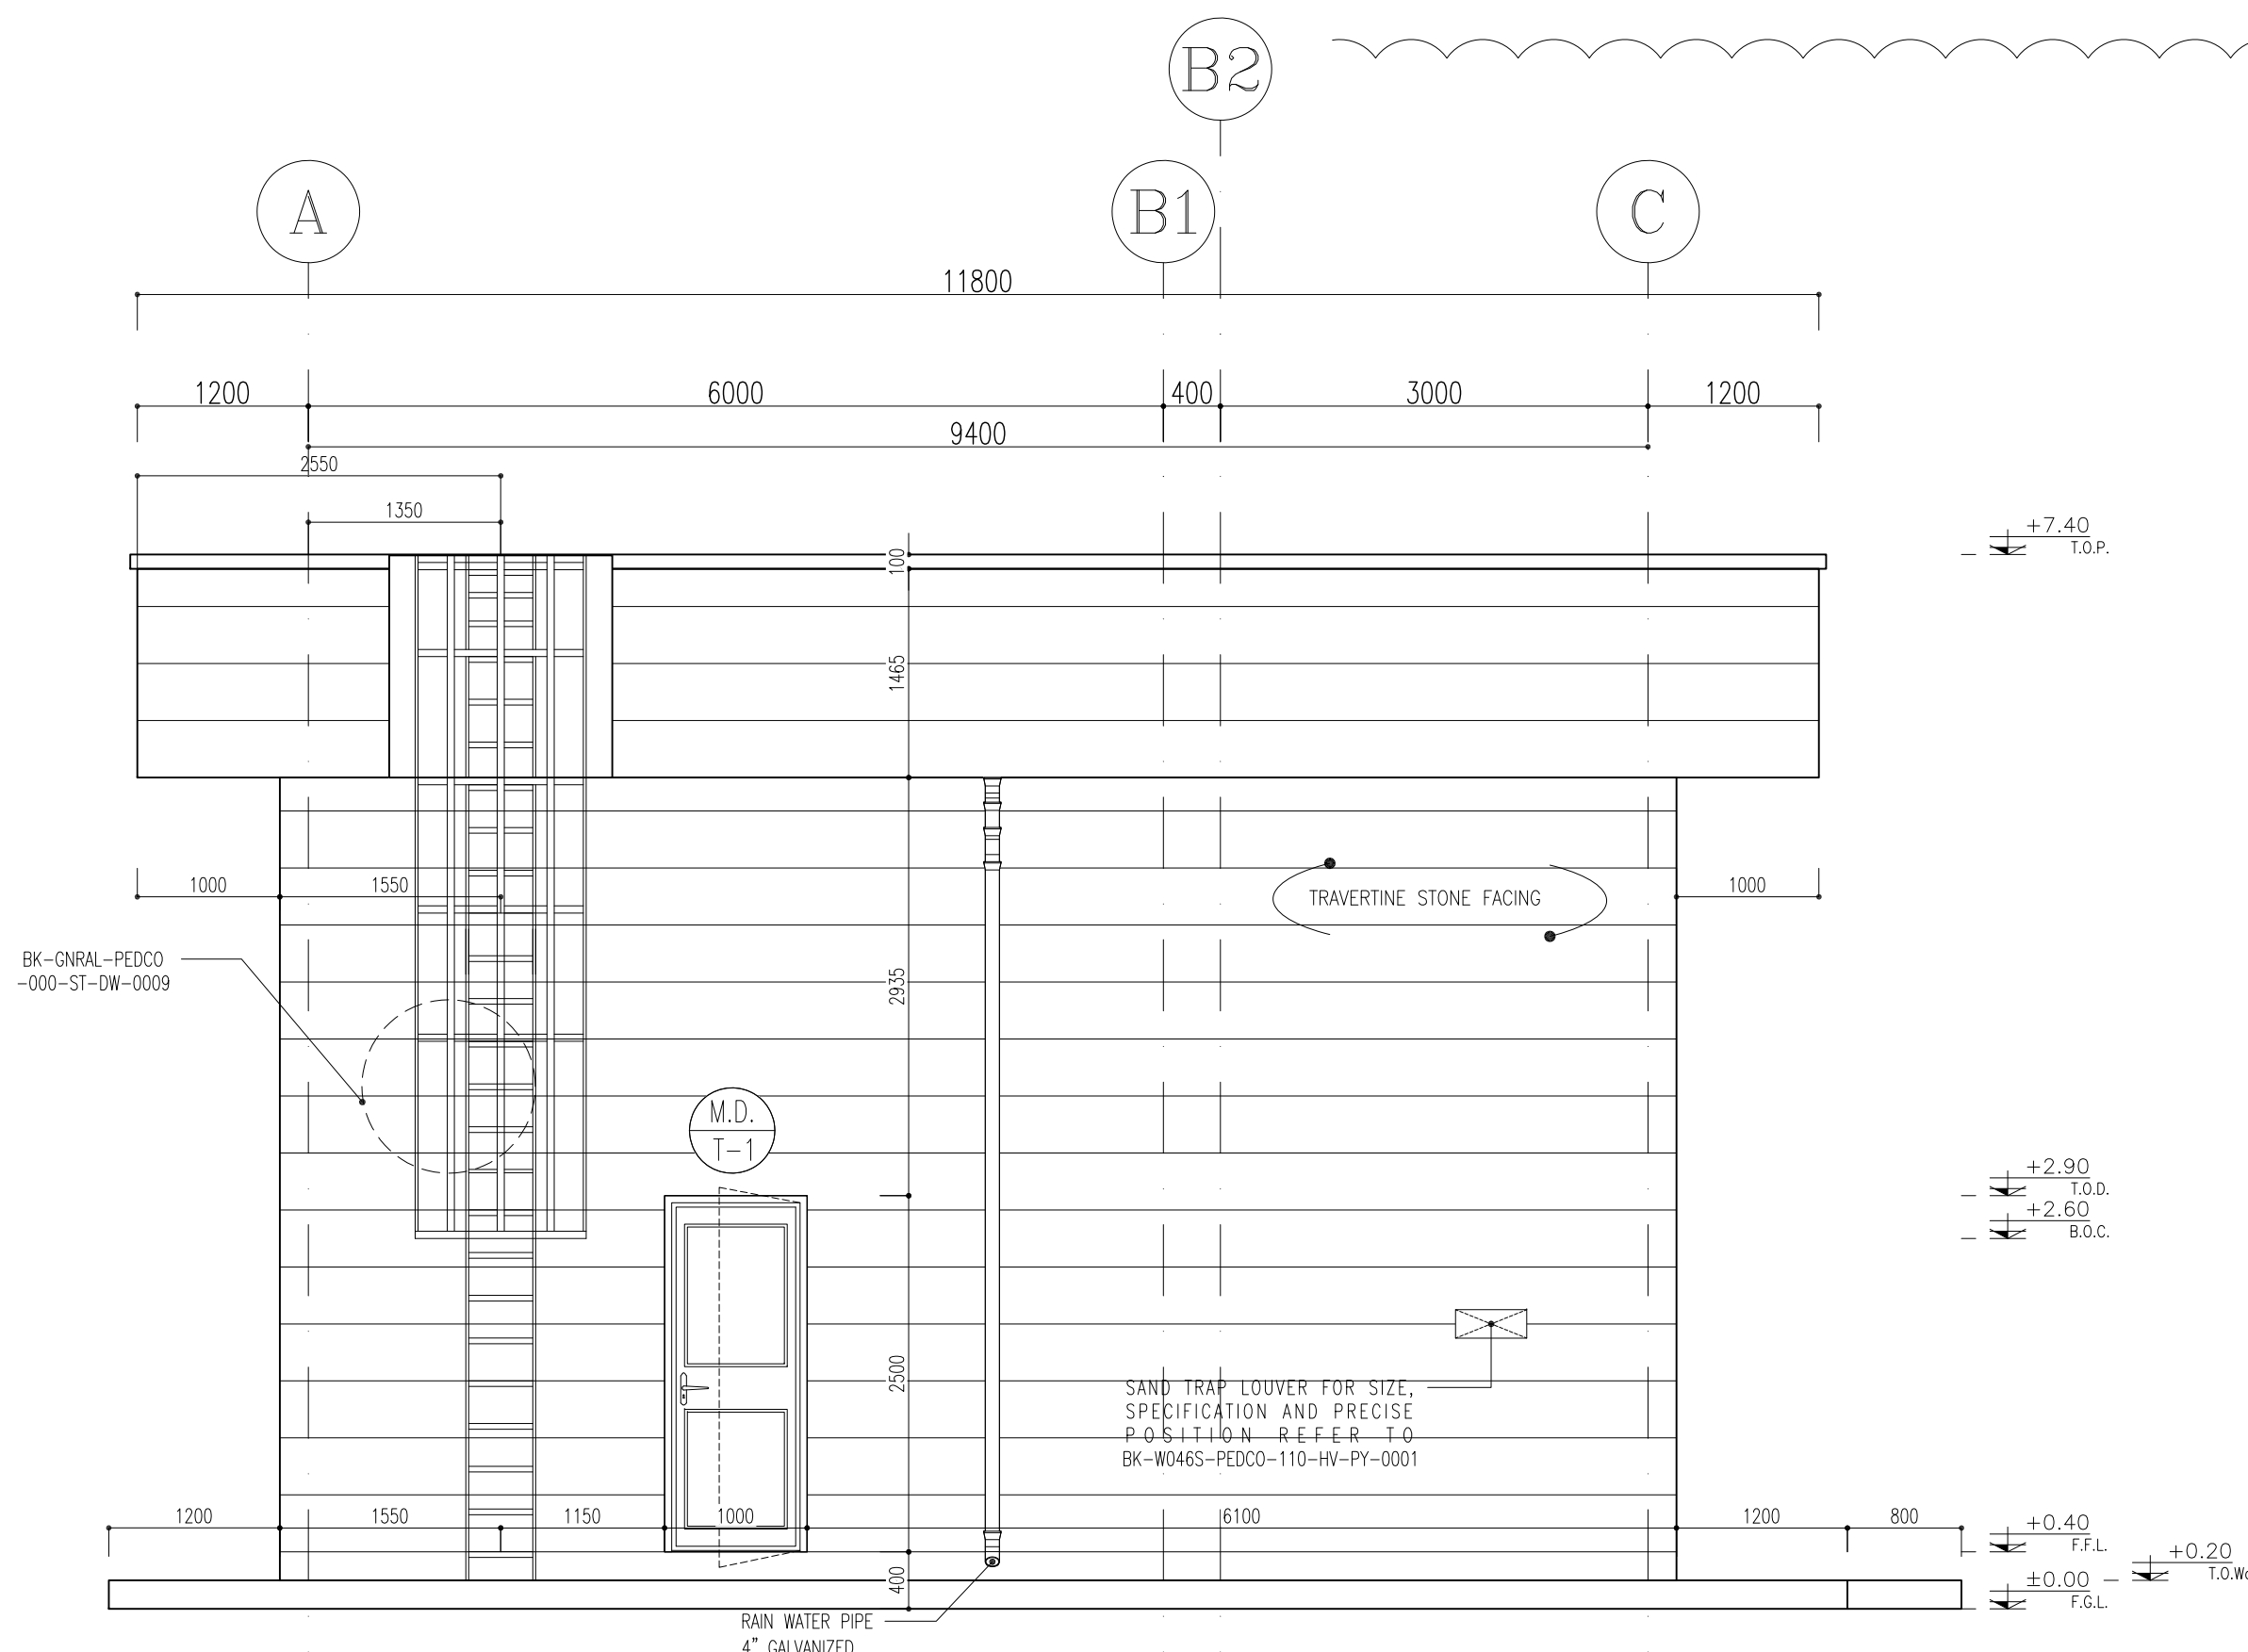

SC.1:50 1 ELEVATION

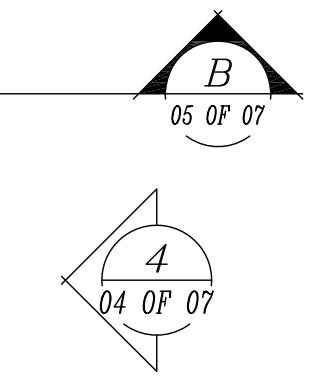


SPACE TAG NUMBER

- 100 SWITCHGEAR ROOM
- 101 BATTERY ROOM
- 102 TRANSFORMER SHELTER






- NOTES
- 1- DIMENSIONS ARE IN "mm" AND ELEVATIONS IN "m" UNLESS SPECIFIED .
 - 2- ALL DIMENSIONS AND ELEVATIONS SHALL BE CHECKED BY THE CONTRACTOR PRIOR TO CONSTRUCTION.
 - 3- CONTRACTOR SHALL COMPARE ALL ARCHITECTURAL, MECHANICAL, ELECTRICAL, PIPING AND STRUCTURAL DRAWINGS AND IN CASE OF ANY CONFLICTS OR DISCREPANCY, INFORM THE ENGINEER.
 - 4- SLAB ON GRADE SHALL BE CONSTRUCTED AFTER EXECUTION OF CABLE TRENCH & EQUIPMENTS FOUNDATION.
 - 5- ALL MATERIALS ARE SELECTED FROM THE HIGHEST QUALITY AND SHALL BE APPROVED BY THE CLIENT.
 - 6- FOR COORDINATE REFER TO FINISH GRADING DOCUMENTS.
 - 7) REFERENCE COORDINATES E=1000.000 , N=1000.000 REFER TO X=437425 , Y=3290543 UTM.
 - 8) FINISH GRADING LEVEL (W007S) ELEVATION :
+26 m (GLOBAL) = ±0.00 (LOCAL)
 - 9) ALL HVAC OPENINGS SIZE, SPECS, AND POSITION WILL BE FINALISED BASED ON HVAC SYSTEM DESIGN.
 - 10) BATTERY ROOM EQUIPMENT SHALL BE BLAST-PROOF (EXP)
 - 11) DRAWINGS MUST BE IN CONJUNCTION WITH STRUCTURAL, ELECTRICAL, INSTRUMENT AND OTHER DRAWINGS.
 - 12) ALL DOORS SHALL BE THERMAL BREAK AND FIRE RESISTANT.
 - 13) RAINWATER MUST BE CONNECTED TO THE SURFACE WATER NETWORK.
 - 14) BATTERY ROOM EQUIPMENT MUST BE BLAST-PROOF.(ACCORDING TO SCOPE OF WORK)

- LEGEND
- BRICK WALL
 - REINFORCED CONCRETE ACCORDING TO STR. DWG
 - CHEQUERED PLATE TRENCH CAP
 - GRAVEL/HARDCORE
 - FIRE RESISTANT BRICK
- F.F.L. FINISHED FLOOR B.O.C. BOTTOM OF CAGE
F.G.L. TOP OF WALL T.O.C. TOP OF CAGE
T.O.Wa. TOP OF WALKWAY R.H.P. ROOF HIGH POINT
T.O.P. TOP OF PARAPET R.L.P. ROOF LOW POINT
T.O.Fou. TOP OF FOUNDATION
B.O.Pit. BOTTOM OF PIT
B.O.O. BOTTOM OF OPENING
T.O.D. TOP OF DOOR
T.O.R. TOP OF ROOF
T.O.W. FINISHED GRADING LEVEL
B.O.O. BOTTOM OF OPENING

REFERENCE DRAWING	DRG. No.
STANDARD DRAWING FOR ARCHITECTURAL DETAILS	BK-GNRL-PEDCO-000-AR-DW-0001
STANDARD DETAILS FOR LADDER & SAFETY CAGE	BK-GNRL-PEDCO-000-ST-DW-0009
PLOT PLAN DRAWING - W007S	BK-W007S-PEDCO-110-P1-PY-0002
FOUNDATION DRAWING FOR SWITCHGEAR BUILDING FOR WELL PADS - W007S	BK-W007S-PEDCO-110-ST-DW-0010
STRUCTURAL DRAWING FOR SWITCHGEAR BUILDING FOR WELL PADS - W007S	BK-W007S-PEDCO-110-ST-DW-0011
GENERAL CIVIL LAYOUT - W007S	BK-W007S-PEDCO-110-CV-PY-0001
HVAC SYSTEM LAYOUT FOR SWITCHGEAR BUILDING - W007S	BK-W007S-PEDCO-110-HV-PY-0001
PLUMBING & SEWAGE PIPING LAYOUT FOR SWITCHGEAR BUILDING - W007S	BK-W007S-PEDCO-110-HV-PY-0003

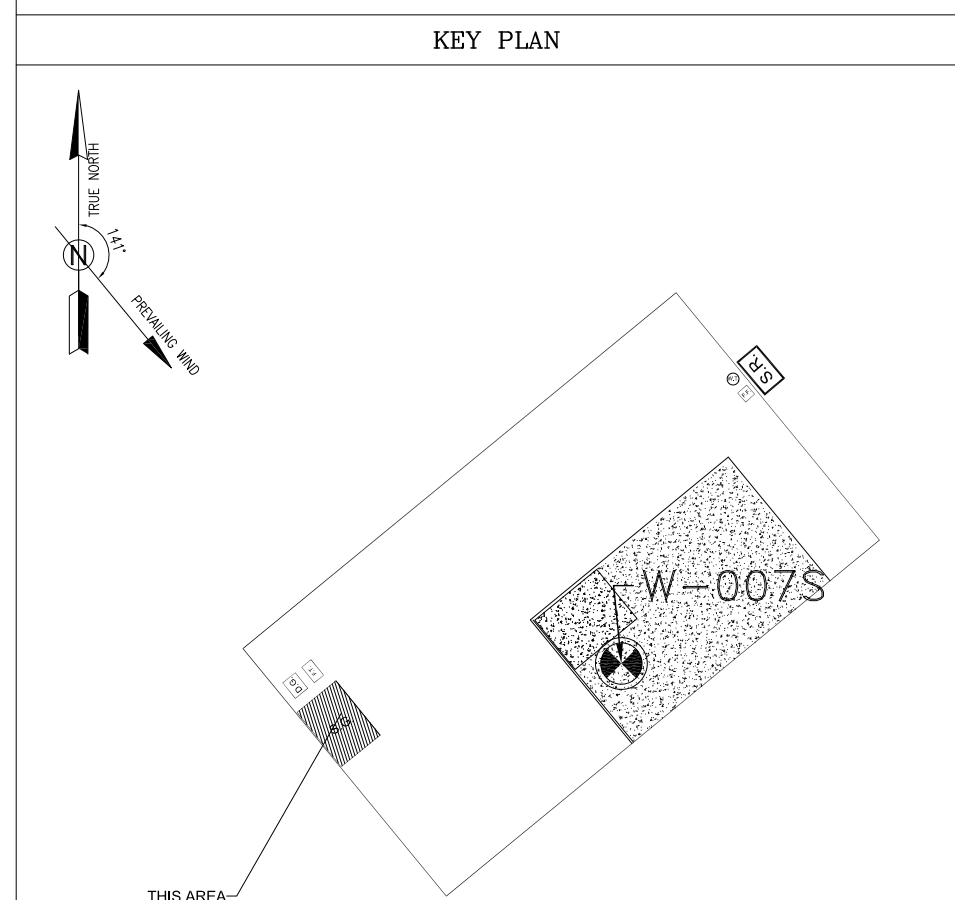

D03	MAR.2023	IPA	R.BERLOUIE	M.PAKHARIAN	M.Mehrshad	***								
D02	SEP.2022	IFC	R.BERLOUIE	M.PAKHARIAN	M.Mehrshad	***	***	*****	**	*****	**	*****		
D01	MAY.2022	IFC	R.BERLOUIE	M.PAKHARIAN	M.Mehrshad	**	REV.	DESCRIPTION	BY	DATE	BY	DATE		
D00	MAR.2022	IFC	R.BERLOUIE	M.PAKHARIAN	M.Mehrshad	***			CHECKED		REV. APPR.			
REV.	DATE	P.O.I.S	PREP.	CHK.	APP.	AUT.	اسم و کلیه نسخ این نقشه و حق اقتباس متعلق به شرکت ملی مناطق نفت خیز جنوب میباشد.							
PROJECT NAME: BINAK OILFIELD DEVELOPMENT/SUB-SURFACE WORK PACKAGES W007S WHF & EXTENSION OF BINAK B/C								THE ORIGINAL AND ALL COPIES OF THIS DRAWING TOGETHER WITH THE COPYRIGHT THEREIN ARE THE SOLE PROPERTY OF N.I.S.O.C./ FIELDS						
PROJECT NO.:		971020												
EPC CONTRACTOR:			EPD/EPC CONTRACTOR (GC):					BINAK OILFIELD DEVELOPMENT SUB-SURFACE WORK PACKAGES W007S WHF & EXTENSION OF BINAK B/C						
 HIRGAN ENERGY – DESIGN & INSPECTION COMPANIES			 PETROIRAN DEVELOPMENT COMPANY											
							DATE	SCALE	DRAWING BY	CHECKED BY	PROJECT ENG			
DRAWING TITLE: ARCHITECTURAL DRAWING FOR SWITCHGEAR BUILDING OF WELL PADS – W007S PLAN AND ELEVATION							NO CONSTRUCTION PERMITTED UNLESS DRAWING APPROVED							
SCALE			SIZE	DRAWING NO.		SHEET NO.	REV.	BUDGET REF.	LOCATION	SIZE	CLASS	SERIAL NO.	SHEET	REVISIO
AS SHOWN			A1	BK–W007S–PEDCO–110–AR–DW–0003		01 OF 07	D03	053–073–9184	F	4	B	708044	01 OF 07	D03

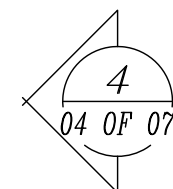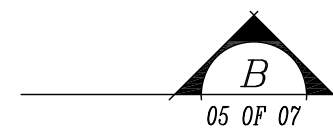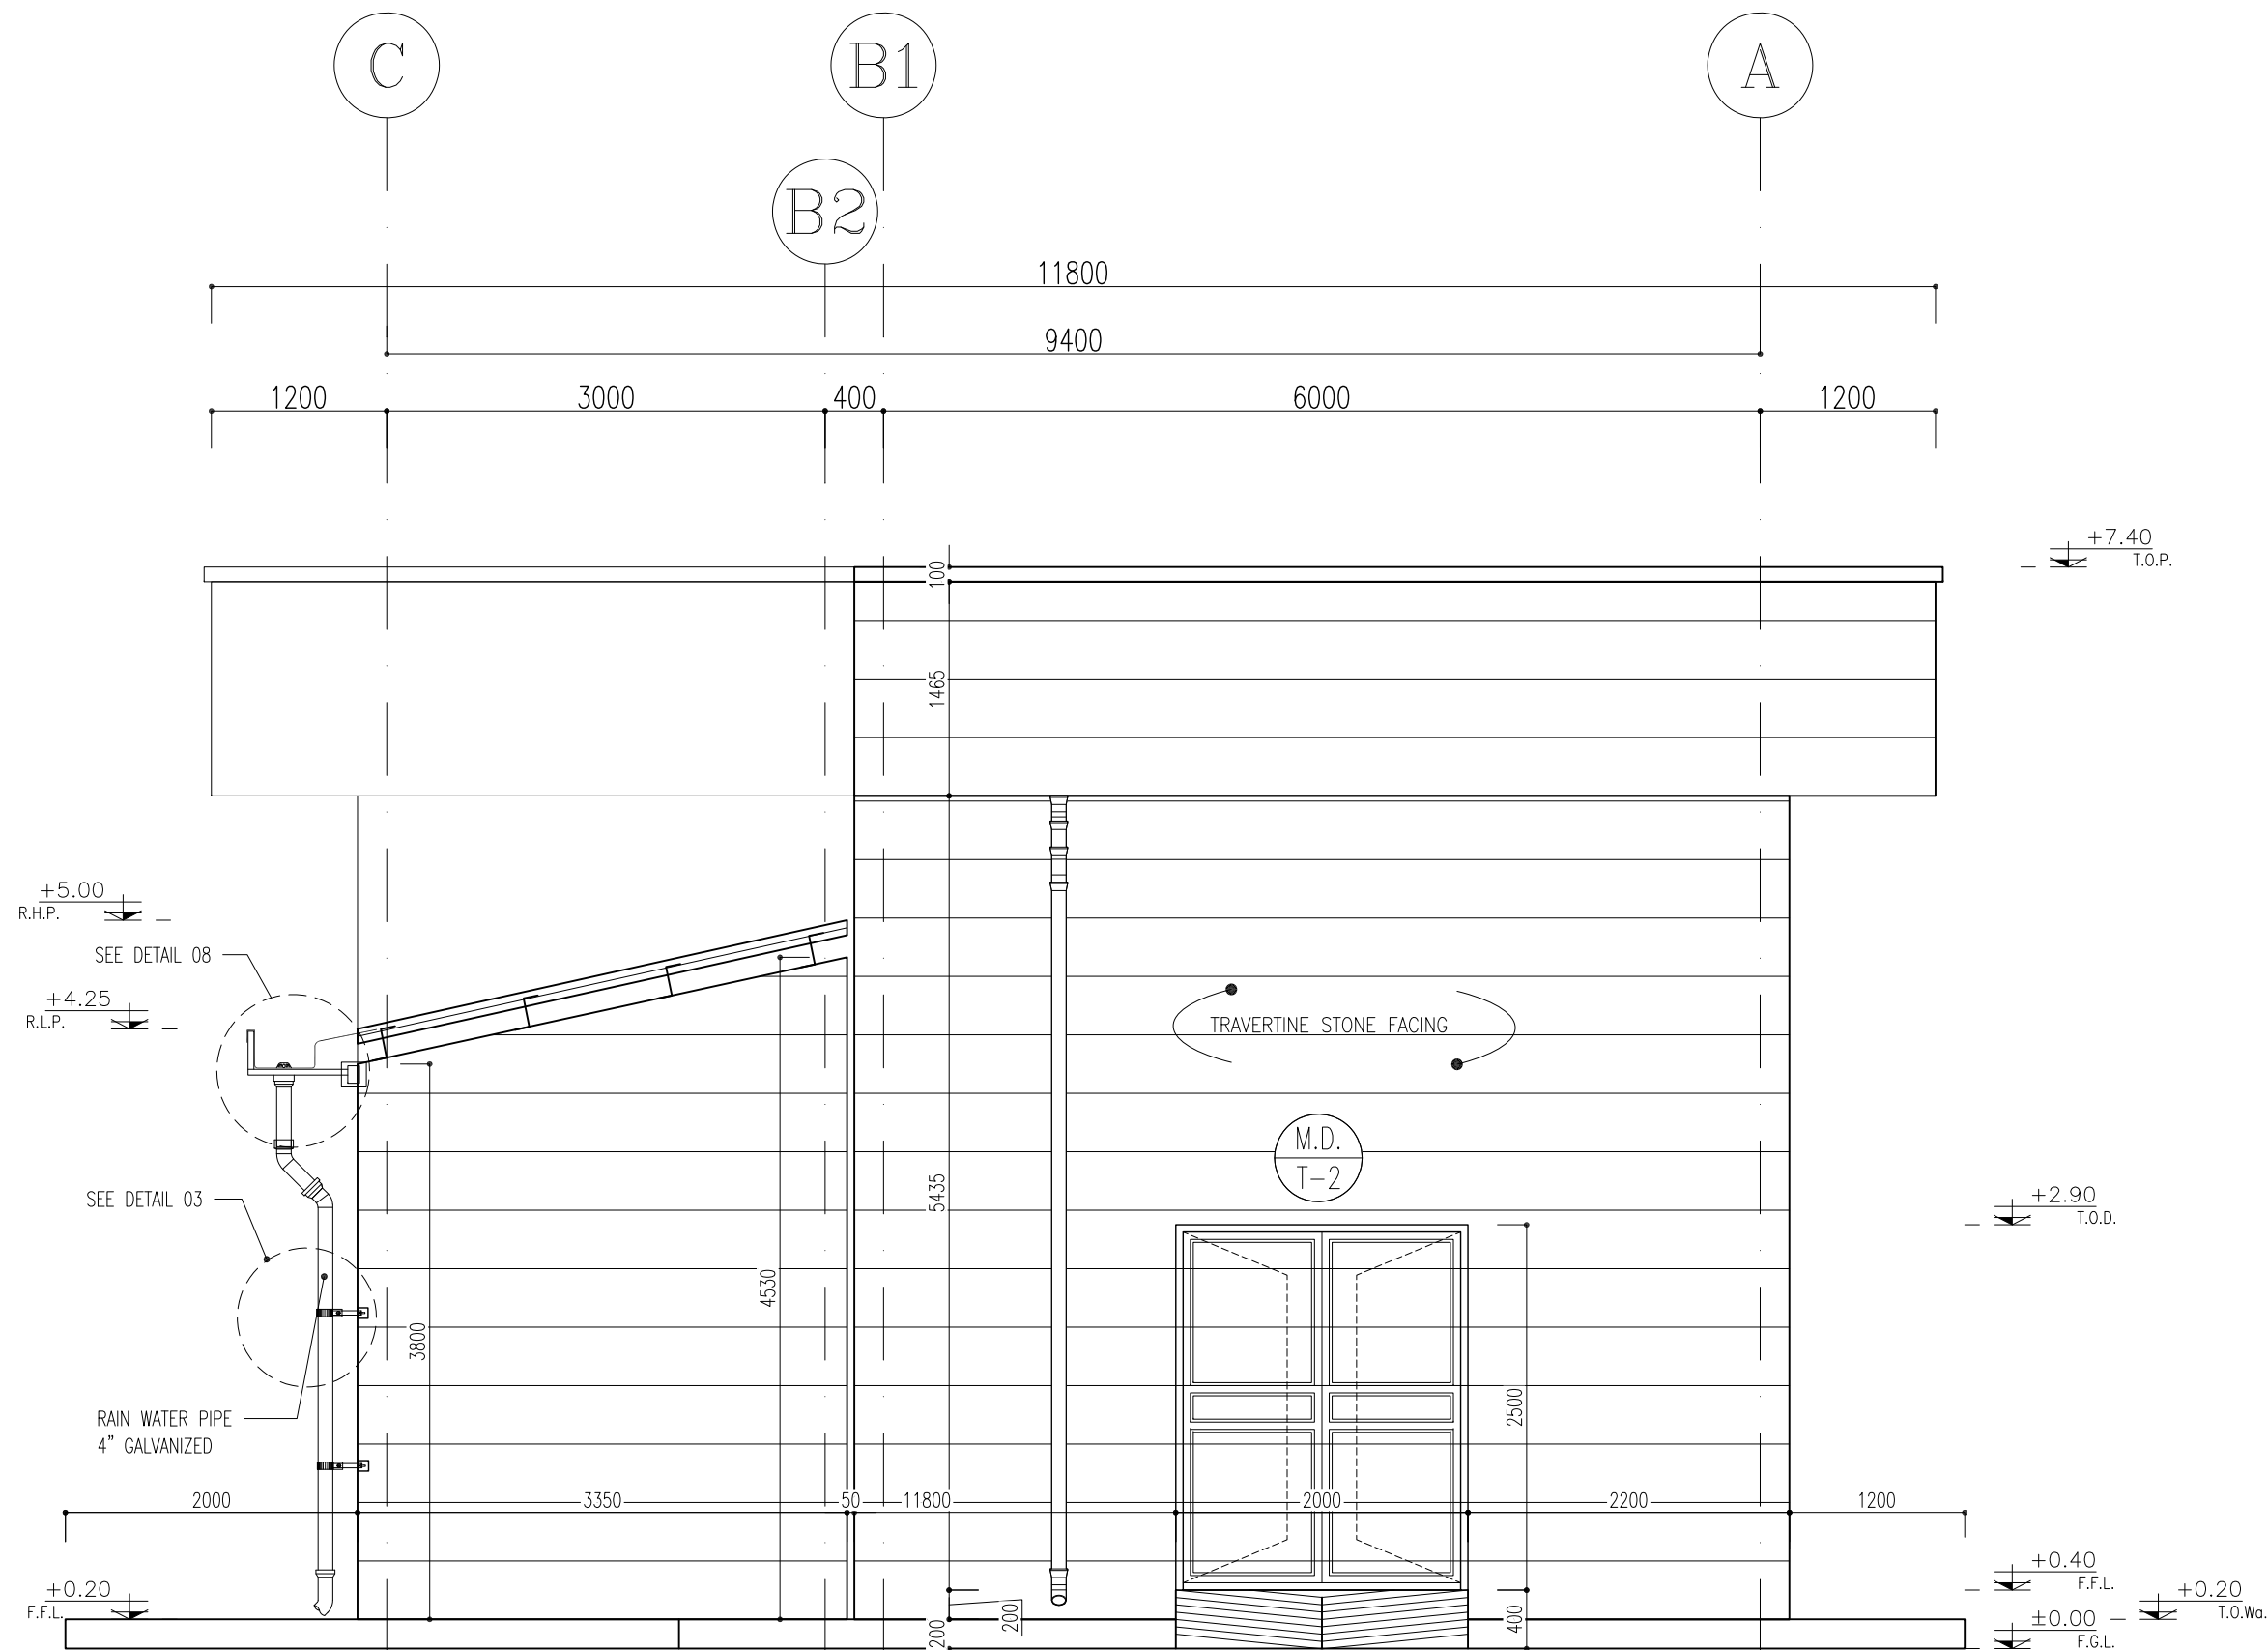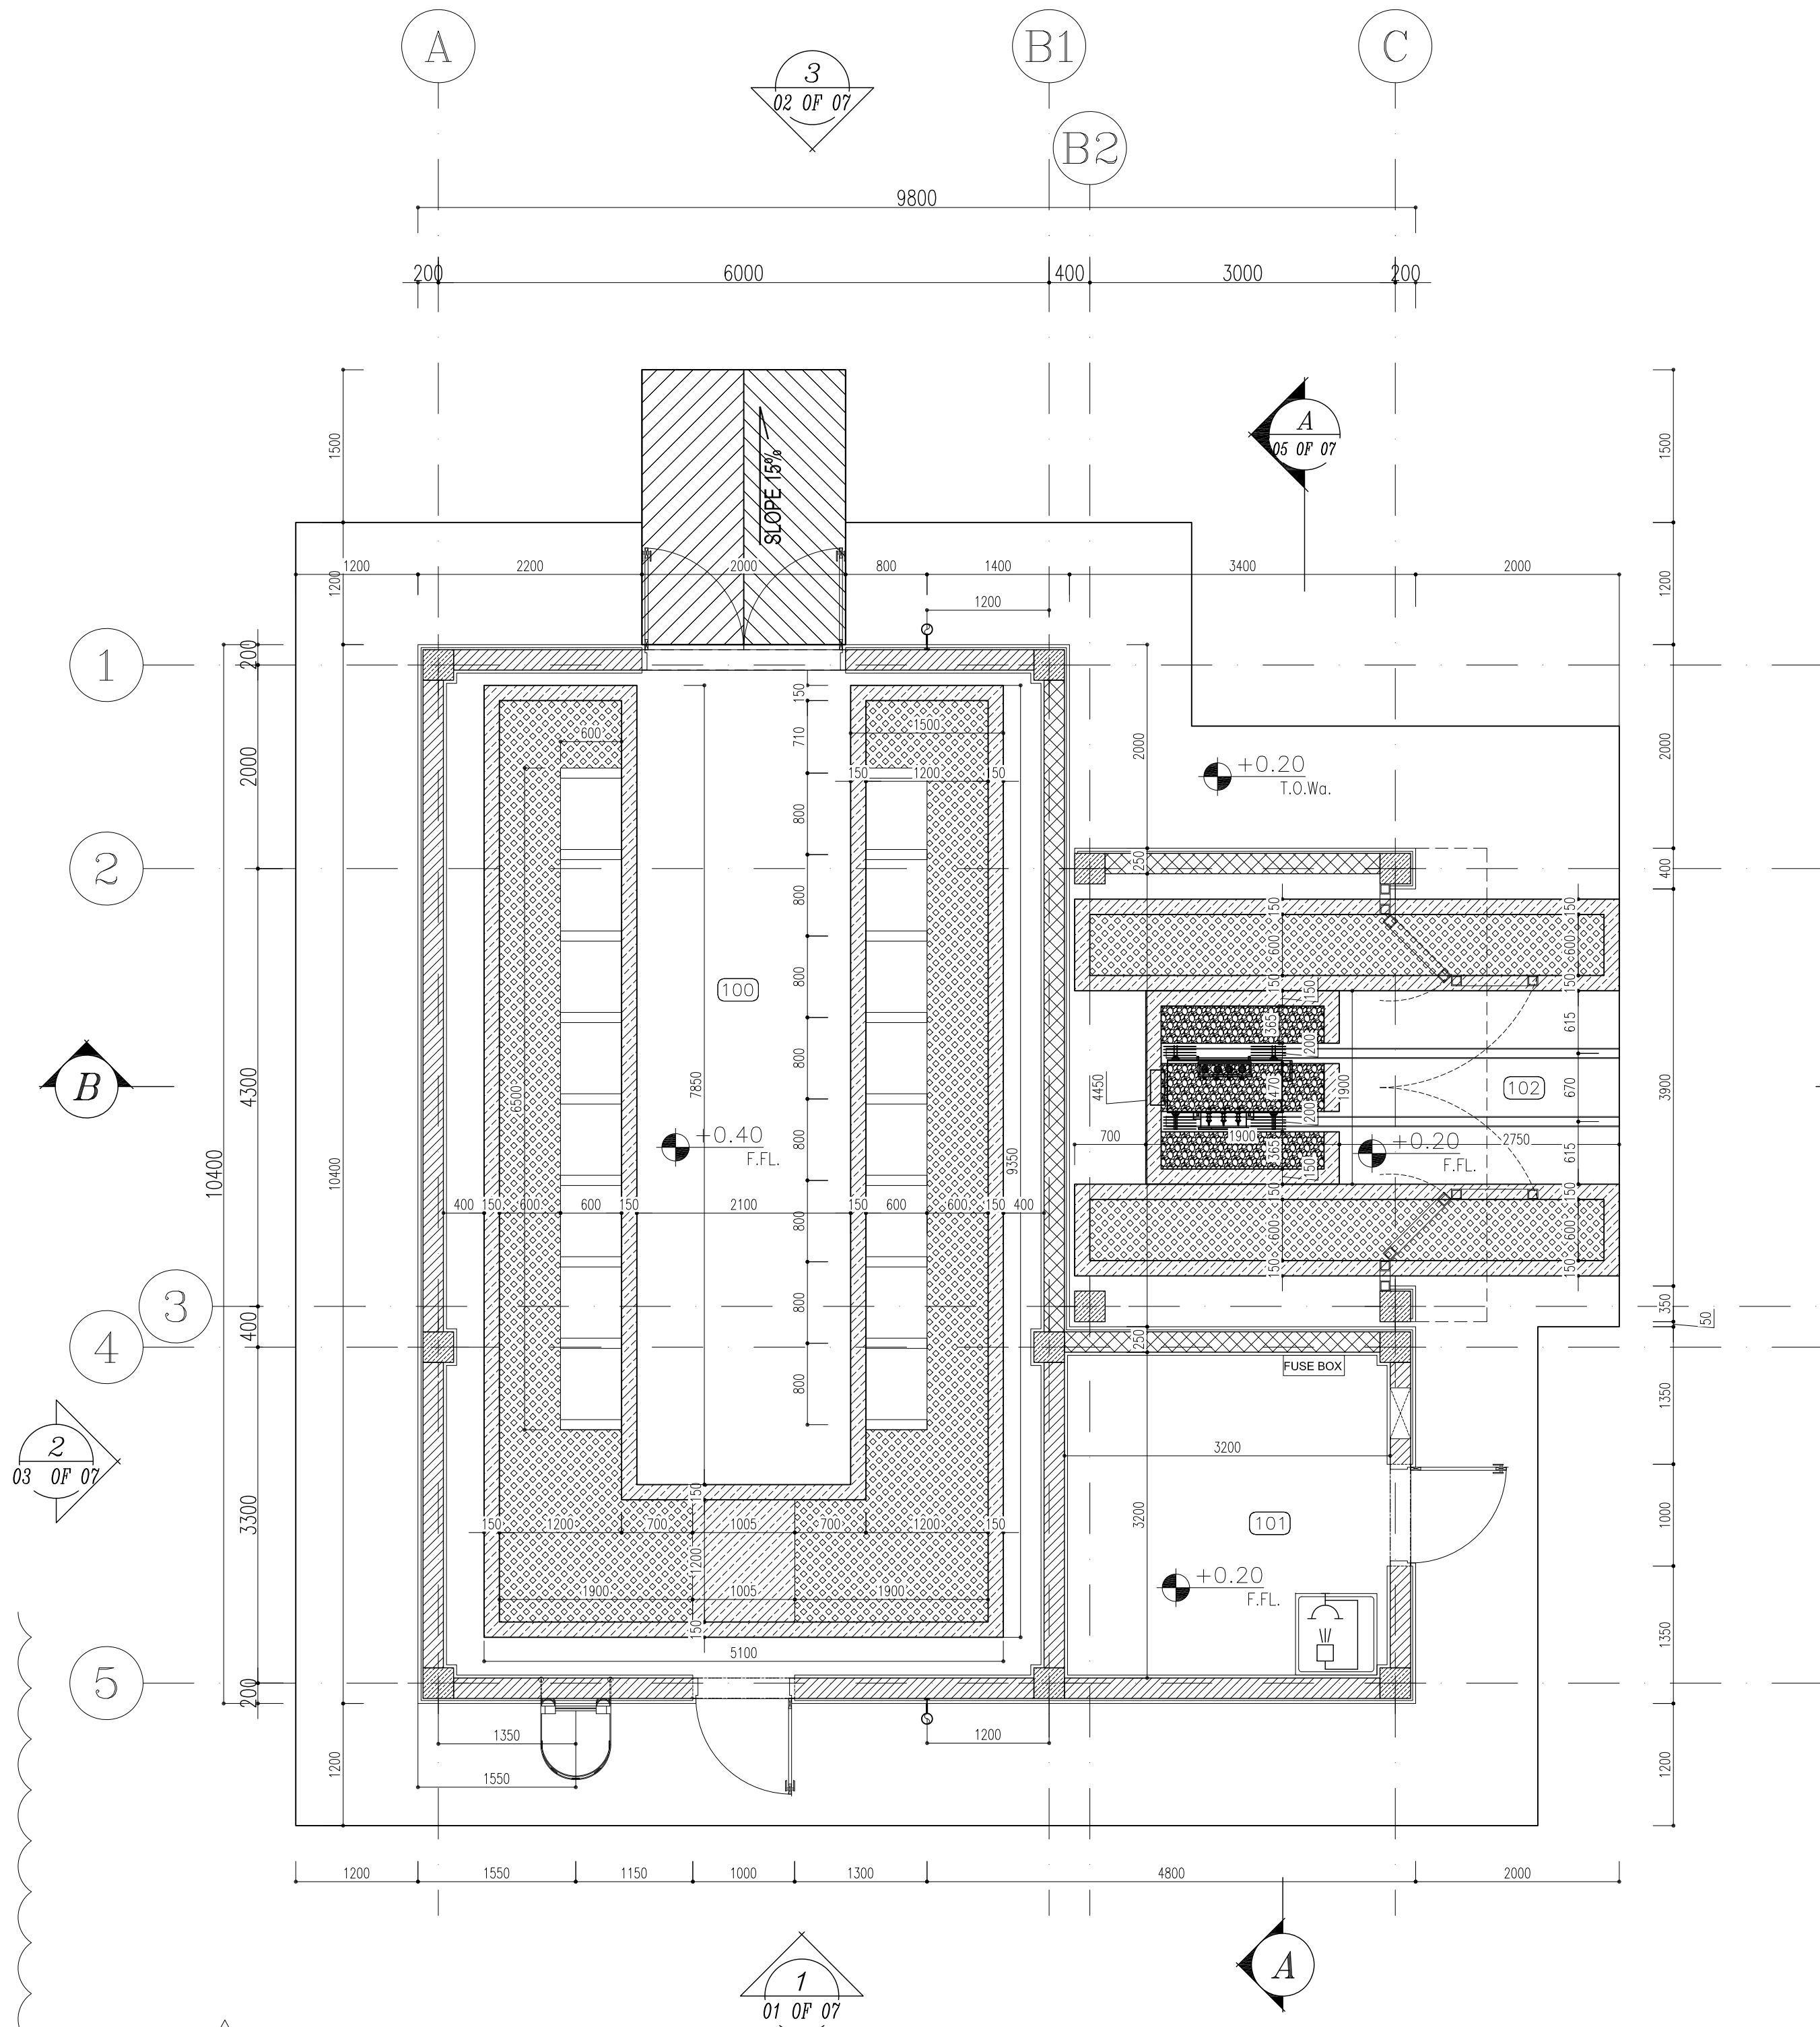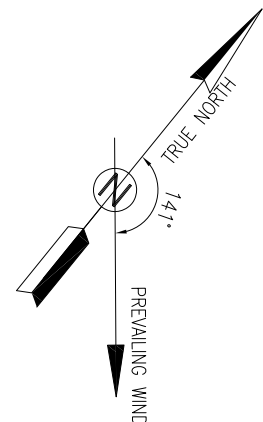

SPACE TAG NUMBER


- 100 SWITCHGEAR ROOM
101 BATTERY ROOM
102 TRANSFORMER SHELTER

- NOTES
- 1- DIMENSIONS ARE IN "mm" AND ELEVATIONS IN "m" UNLESS SPECIFIED .
 - 2- ALL DIMENSIONS AND ELEVATIONS SHALL BE CHECKED BY THE CONTRACTOR PRIOR TO CONSTRUCTION.
 - 3- CONTRACTOR SHALL COMPARE ALL ARCHITECTURAL, MECHANICAL, ELECTRICAL, PIPING AND STRUCTURAL DRAWINGS AND IN CASE OF ANY CONFLICTS OR DISCREPANCY, INFORM THE ENGINEER.
 - 4- SLAB ON GRADE SHALL BE CONSTRUCTED AFTER EXECUTION OF CABLE TRENCH & EQUIPMENTS FOUNDATION.
 - 5- ALL MATERIALS ARE SELECTED FROM THE HIGHEST QUALITY AND SHALL BE APPROVED BY THE CLIENT.
 - 6- FOR COORDINATE REFER TO FINISH GRADING DOCUMENTS.
 - 7) REFERENCE COORDINATES E=1000.000 , N=1000.000 REFER TO X=437425 , Y=3290543 UTM.
 - 8) FINISH GRADING LEVEL (W007S) ELEVATION :
+26 m (GLOBAL) = ±0.00 (LOCAL)
 - 9) ALL HVAC OPENINGS SIZE, SPECS, AND POSITION WILL BE FINALISED BASED ON HVAC SYSTEM DESIGN.
 - 10) BATTERY ROOM EQUIPMENT SHALL BE BLAST-PROOF (EXP)
 - 11) DRAWINGS MUST BE IN CONJUNCTION WITH STRUCTURAL, ELECTRICAL, INSTRUMENT AND OTHER DRAWINGS.
 - 12) ALL DOORS SHALL BE THERMAL BREAK AND FIRE RESISTANT.
 - 13) RAINWATER MUST BE CONNECTED TO THE SURFACE WATER NETWORK.
 - 14) BATTERY ROOM EQUIPMENT MUST BE BLAST-PROOF.(ACCORDING TO SCOPE OF WORK)



- LEGEND
- BRICK WALL
 - REINFORCED CONCRETE
ACCORDING TO STR. DWG
 - CHEQUERED PLATE TRENCH CAP
 - GRAVEL/HARDCORE
 - FIRE RESISTANT BRICK

- F.F.L. FINISHED FLOOR B.O.C. BOTTOM OF CAGE
F.G.L. TOP OF WALL T.O.C. TOP OF CAGE
T.O.Wa. TOP OF WALKWAY R.H.P. ROOF HIGH POINT
T.O.P. TOP OF PARAPET R.L.P. ROOF LOW POINT
T.O.Fou. TOP OF FOUNDATION
B.O.Pit BOTTOM OF PIT
B.O.O. BOTTOM OF OPENING
T.O.D. TOP OF DOOR
T.O.R. TOP OF ROOF
T.O.W. FINISHED GRADING LEVEL
B.O.O. BOTTOM OF OPENING


REFERENCE DRAWING	DRG. No.
STANDARD DRAWING FOR ARCHITECTURAL DETAILS	BK-GNRL-PEDCO-000-AR-DW-0001
STANDARD DETAILS FOR LADDER & SAFETY CAGE	BK-GNRL-PEDCO-000-ST-DW-0009
PLOT PLAN DRAWING - W007S	BK-W007S-PEDCO-110-PI-PY-0002
FOUNDATION DRAWING FOR SWITCHGEAR BUILDING FOR WELL PADS - W007S	BK-W007S-PEDCO-110-ST-DW-0010
STRUCTURAL DRAWING FOR SWITCHGEAR BUILDING FOR WELL PADS - W007S	BK-W007S-PEDCO-110-ST-DW-0011
GENERAL CIVIL LAYOUT - W007S	BK-W007S-PEDCO-110-CV-PY-0001
HVAC SYSTEM LAYOUT FOR SWITCHGEAR BUILDING - W007S	BK-W007S-PEDCO-110-HV-PY-0001
PLUMBING & SEWAGE PIPING LAYOUT FOR SWITCHGEAR BUILDING - W007S	BK-W007S-PEDCO-110-HV-PY-0003

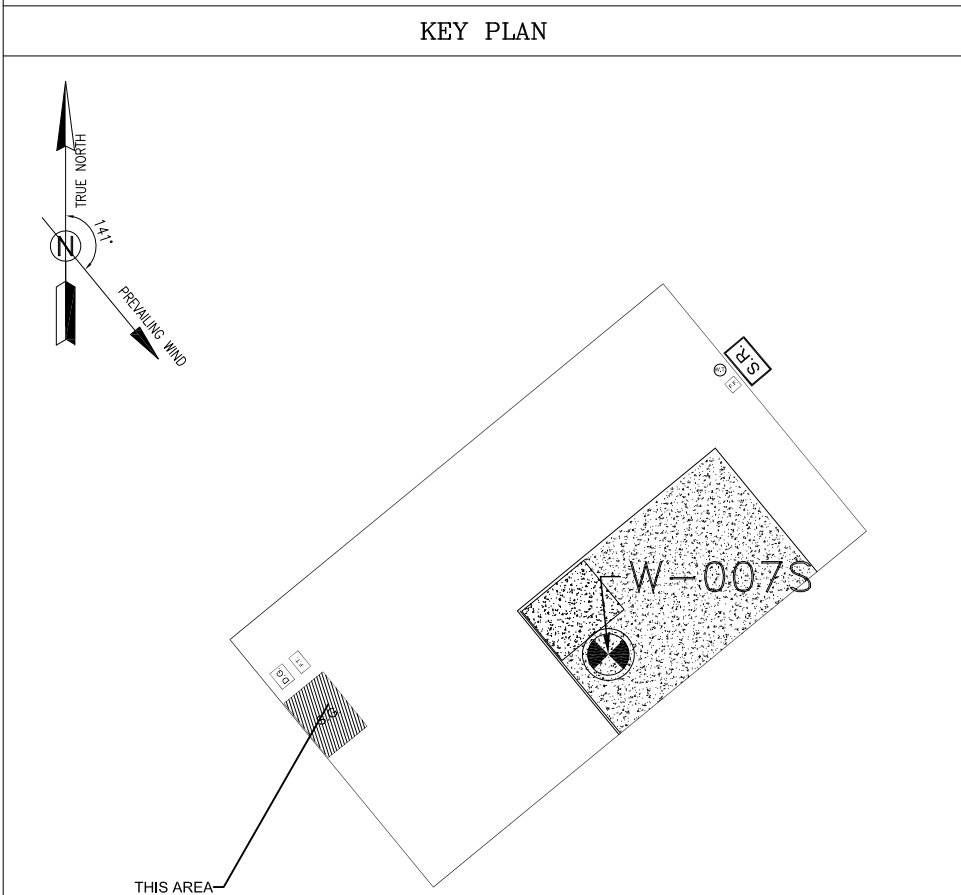

D03	MAR.2023	IFA	R.BERLOUIE	M.PAKHARIAN	M.Mehrshad	***													
D02	SEP.2022	IFC	R.BERLOUIE	M.PAKHARIAN	M.Mehrshad	***	***	*****	***	***	***	***	***	***	***				
D01	MAY.2022	IFC	R.BERLOUIE	M.PAKHARIAN	M.Mehrshad	***	REV.	DESCRIPTION	BY	DATE	BY	DATE							
D00	MAR.2022	IFC	R.BERLOUIE	M.PAKHARIAN	M.Mehrshad	***			CHECKED		REV. APPR.								
REV.	DATE	P.O.I.S	PREP.	CHK.	APP.	AUT.	اصل و کليه نسخ اين نقشه و حق آقياسى متعلق به شرکت ملى مناطق نفت خيز جنوب ميباشد.												
PROJECT NAME:							BINAK OILFIELD DEVELOPMENT/SUB-SURFACE WORK PACKAGES W007S WHF & EXTENSION OF BINAK B/C												
PROJECT NO.:							971020												
EPC CONTRACTOR:							EPD/EPC CONTRACTOR (GC):												
 HIRGAN ENERGY - DESIGN & INSPECTION COMPANIES							 PETROIRAN DEVELOPMENT COMPANY							BINAK OILFIELD DEVELOPMENT SUB-SURFACE WORK PACKAGES W007S WHF & EXTENSION OF BINAK B/C					
							DATE		SCALE		DRAWING BY		CHECKED BY		PROJECT ENG.				
DRAWING TITLE:							NO CONSTRUCTION PERMITTED UNLESS DRAWING APPROVED												
ARCHITECTURAL DRAWING FOR SWITCHGEAR BUILDING OF WELL PADS - W007S							APPROVED FOR CONSTRUCTION									BY:		DATE:	
PLAN AND ELEVATION																SHEET		REVISION	
SCALE	SIZE	DRAWING NO.			SHEET NO.	REV.	BUDGET REF.	LOCATION	SIZE	CLASS	SERIAL NO.	SHEET		REVISION					
AS SHOWN	A1	BK-W007S-PEDCO-110-AR-DW-0003			02 OF 07	D03	053-073-9184	F	4	B	708044	02 OF 07		D03					

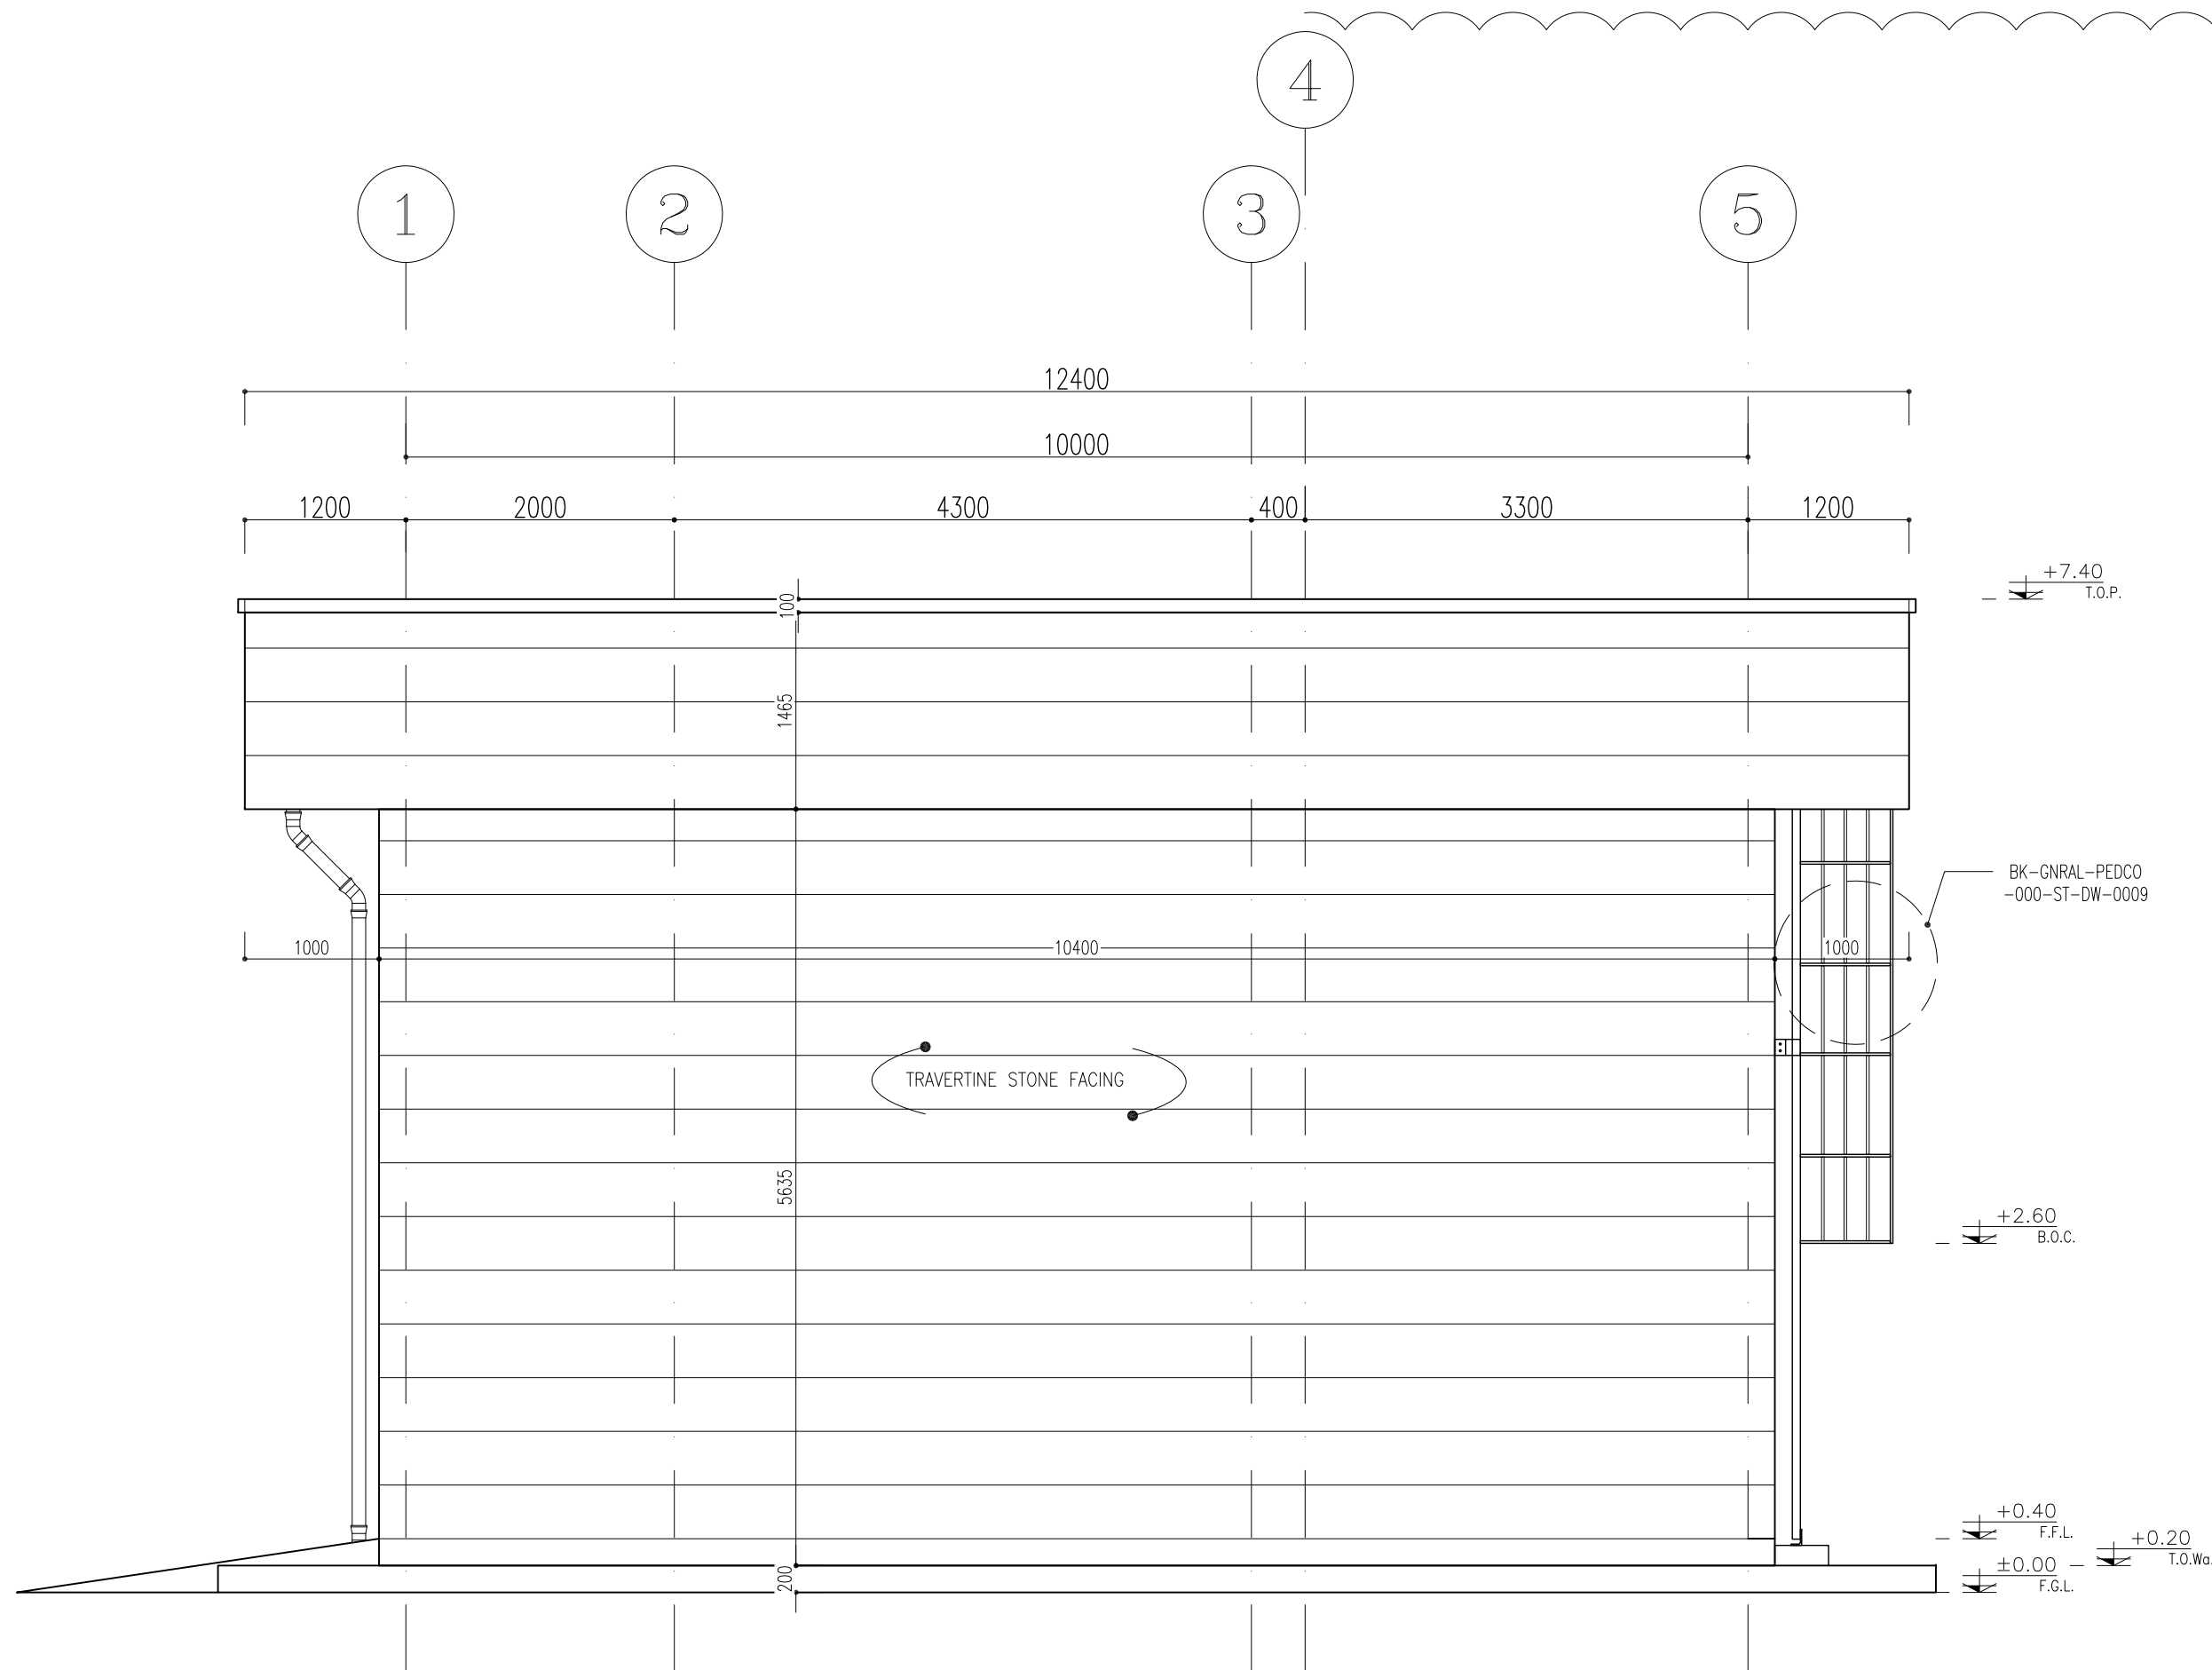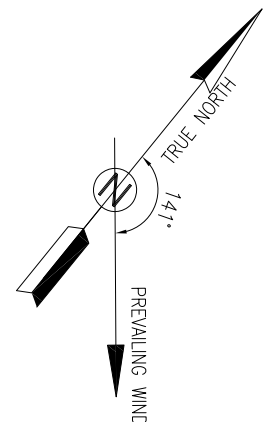

SC.1:50
2
01 OF 07
ELEVATION

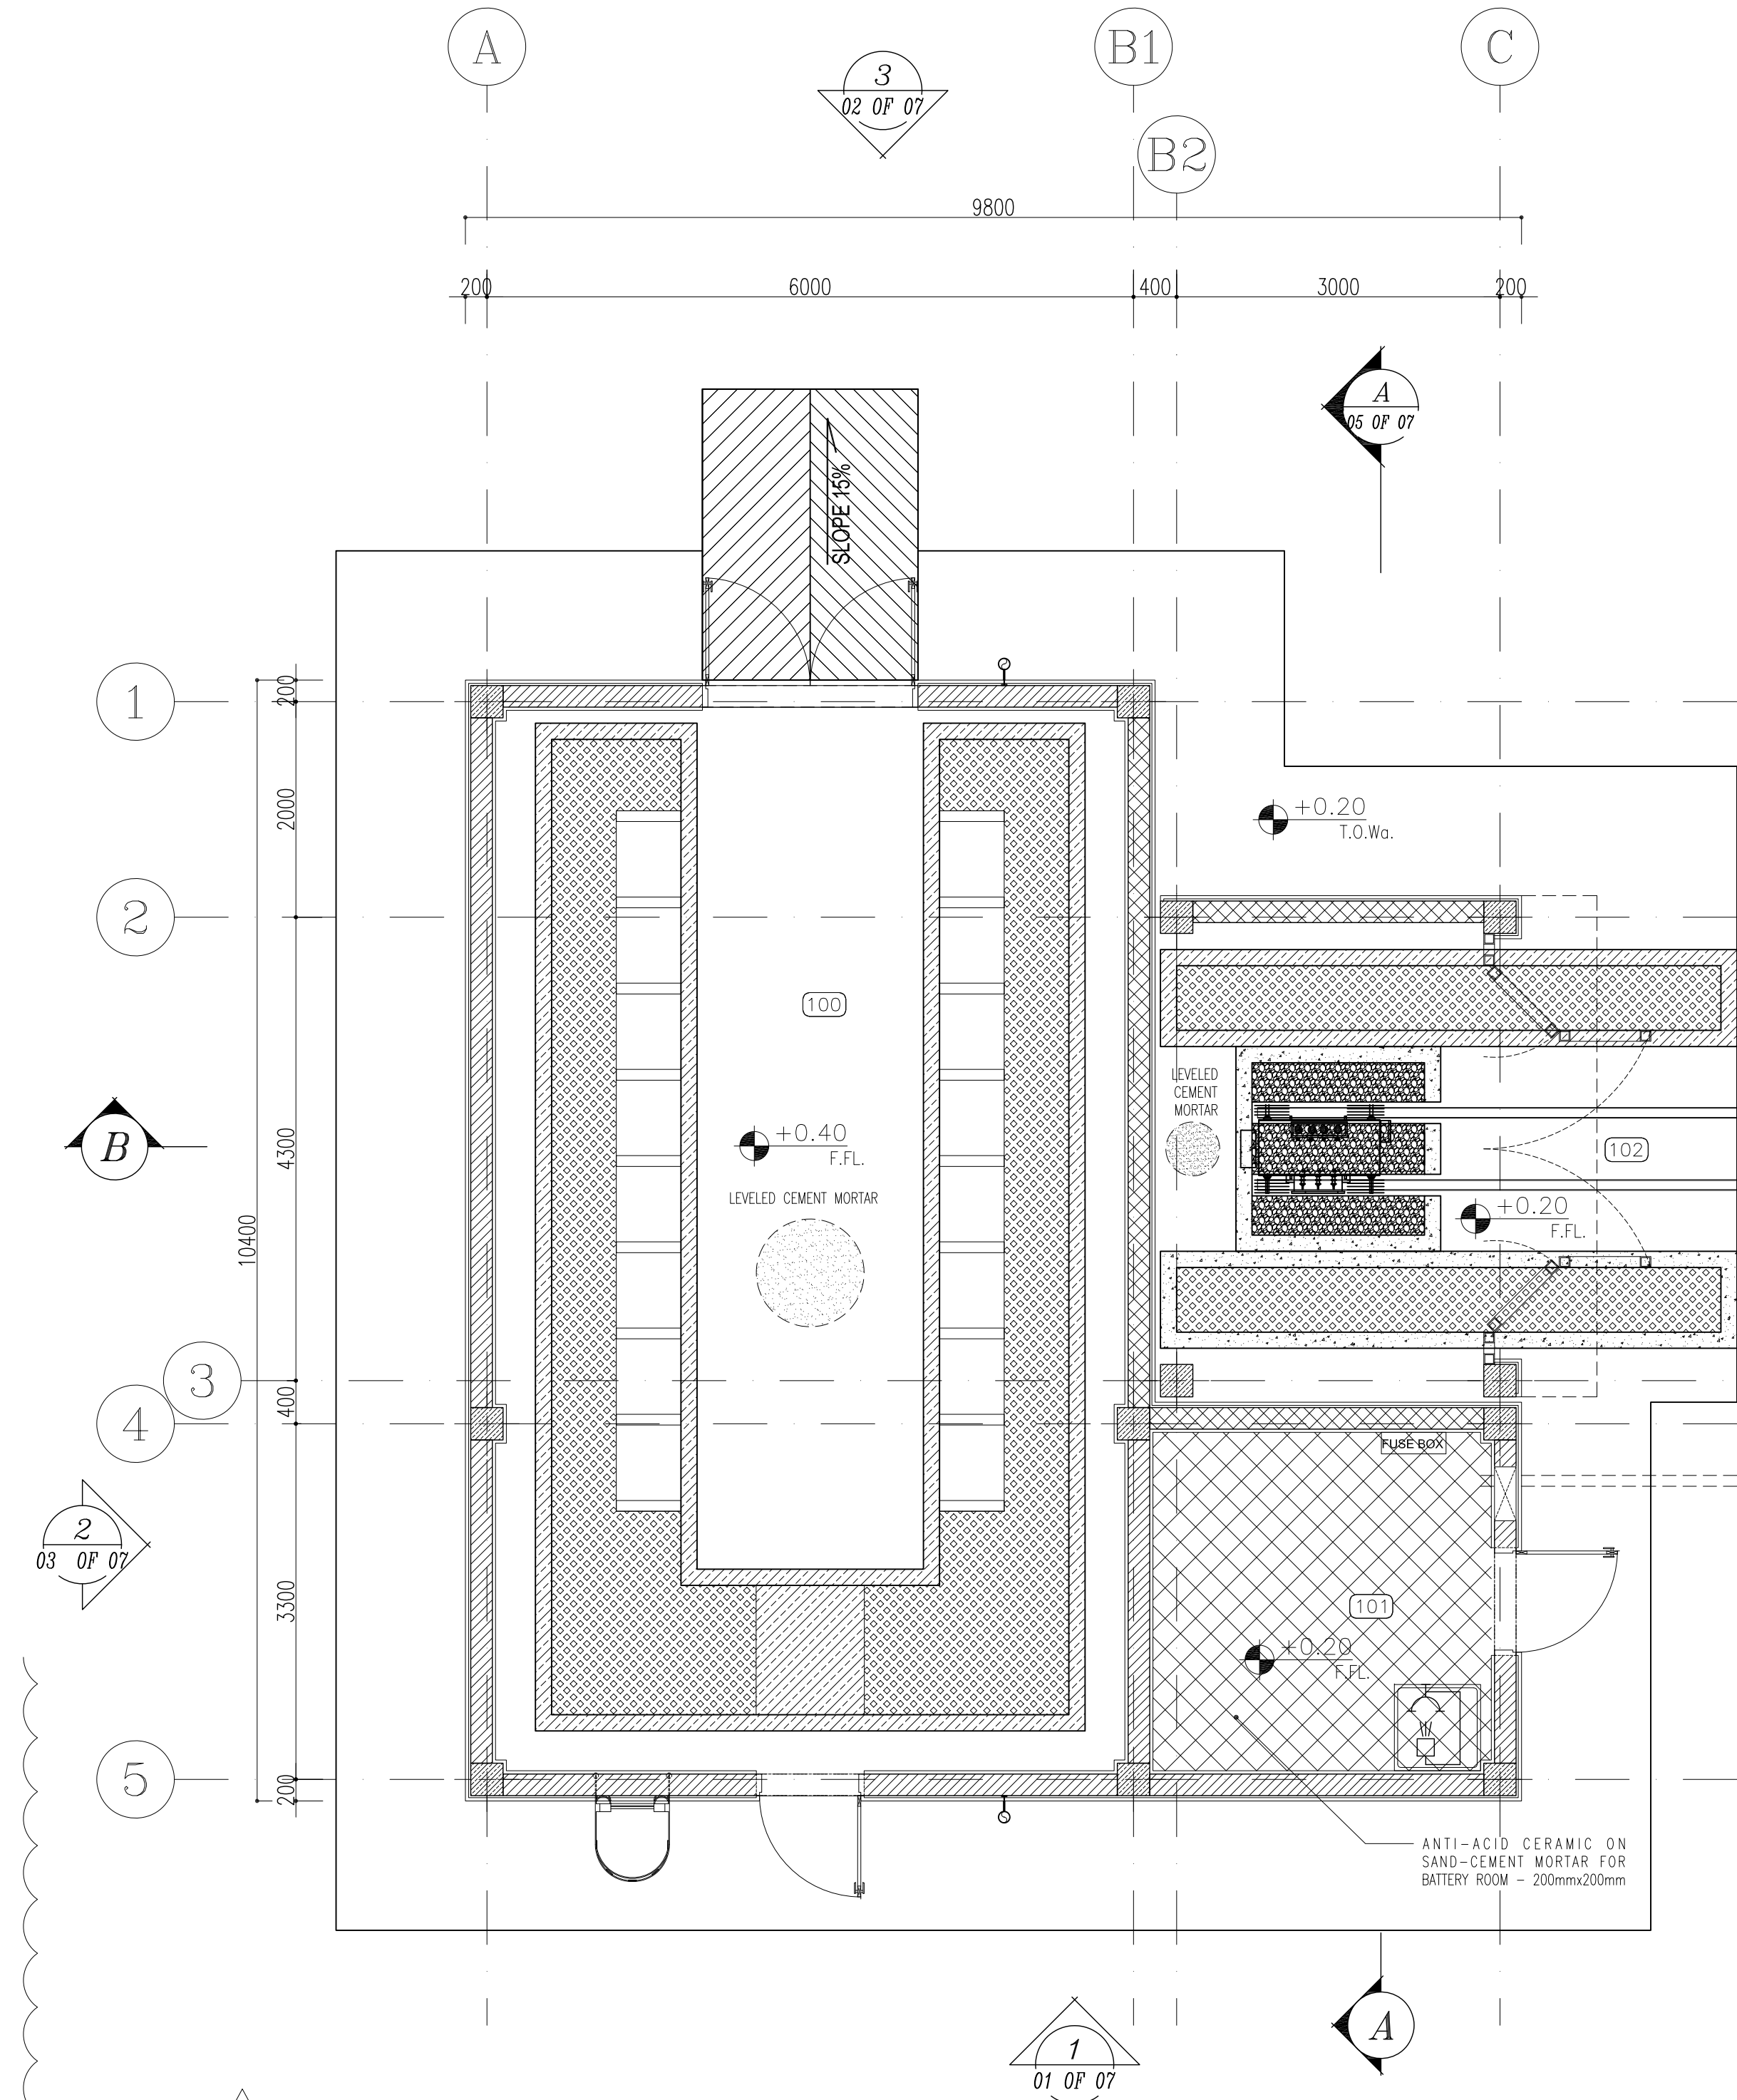


SC.1:50
3
FLOOR FINISHING PLAN







- NOTES
- 1- DIMENSIONS ARE IN "mm" AND ELEVATIONS IN "m" UNLESS SPECIFIED .
 - 2- ALL DIMENSIONS AND ELEVATIONS SHALL BE CHECKED BY THE CONTRACTOR PRIOR TO CONSTRUCTION.
 - 3- CONTRACTOR SHALL COMPARE ALL ARCHITECTURAL, MECHANICAL, ELECTRICAL, PIPING AND STRUCTURAL DRAWINGS AND IN CASE OF ANY CONFLICTS OR DISCREPANCY, INFORM THE ENGINEER.
 - 4- SLAB ON GRADE SHALL BE CONSTRUCTED AFTER EXECUTION OF CABLE TRENCH & EQUIPMENTS FOUNDATION.
 - 5- ALL MATERIALS ARE SELECTED FROM THE HIGHEST QUALITY AND SHALL BE APPROVED BY THE CLIENT.
 - 6- FOR COORDINATE REFER TO FINISH GRADING DOCUMENTS.
 - 7) REFERENCE COORDINATES E=1000.000 , N=1000.000 REFER TO X=437425 , Y=3290543 UTM.
 - 8) FINISH GRADING LEVEL (W007S) ELEVATION :
+26 m (GLOBAL) = ±0.00 (LOCAL)
 - 9) ALL HVAC OPENINGS SIZE, SPECS, AND POSITION WILL BE FINALISED BASED ON HVAC SYSTEM DESIGN.
 - 10) BATTERY ROOM EQUIPMENT SHALL BE BLAST-PROOF (EXP)
 - 11) DRAWINGS MUST BE IN CONJUNCTION WITH STRUCTURAL, ELECTRICAL, INSTRUMENT AND OTHER DRAWINGS.
 - 12) ALL DOORS SHALL BE THERMAL BREAK AND FIRE RESISTANT.
 - 13) RAINWATER MUST BE CONNECTED TO THE SURFACE WATER NETWORK.
 - 14) BATTERY ROOM EQUIPMENT MUST BE BLAST-PROOF.(ACCORDING TO SCOPE OF WORK)


- LEGEND
- BRICK WALL
 - REINFORCED CONCRETE
ACCORDING TO STR. DWG
 - CHEQUERED PLATE TRENCH CAP
 - LEAN CONCRETE
 - ANTI-ACID CERAMIC
 - FIRE RESISTANT BRICK WALL
 - CEMENT MORTAR
- F.F.L. FINISHED FLOOR T.O.C. TOP OF CAGE
T.O.Wa. TOP OF WALKWAY R.H.P. ROOF HIGH POINT
T.O.P. TOP OF PARAPET R.L.P. ROOF LOW POINT
T.O.Fou. TOP OF FOUNDATION T.O.D. TOP OF DOOR
B.O.Pit BOTTOM OF PIT T.O.R. TOP OF ROOF
B.O.O. BOTTOM OF OPENING T.O.W. TOP OF WALL
B.O.C. BOTTOM OF CAGE
F.G.L. FINISHED GRADING LEVEL

REFERENCE DRAWING	DRG. No.
STANDARD DRAWING FOR ARCHITECTURAL DETAILS	BK-GNRAL-PEDCO-000-AR-DW-0001
STANDARD DETAILS FOR LADDER & SAFETY CAGE	BK-GNRAL-PEDCO-000-ST-DW-0009
PLOT PLAN DRAWING - W007S	BK-W007S-PEDCO-110-PI-PY-0002
FOUNDATION DRAWING FOR SWITCHGEAR BUILDING FOR WELL PADS - W007S	BK-W007S-PEDCO-110-ST-DW-0010
STRUCTURAL DRAWING FOR SWITCHGEAR BUILDING FOR WELL PADS - W007S	BK-W007S-PEDCO-110-ST-DW-0011
GENERAL CIVIL LAYOUT - W007S	BK-W007S-PEDCO-110-CV-PY-0001
HVAC SYSTEM LAYOUT FOR SWITCHGEAR BUILDING - W007S	BK-W007S-PEDCO-110-HV-PY-0001
PLUMBING & SEWAGE PIPING LAYOUT FOR SWITCHGEAR BUILDING - W007S	BK-W007S-PEDCO-110-HV-PY-0003

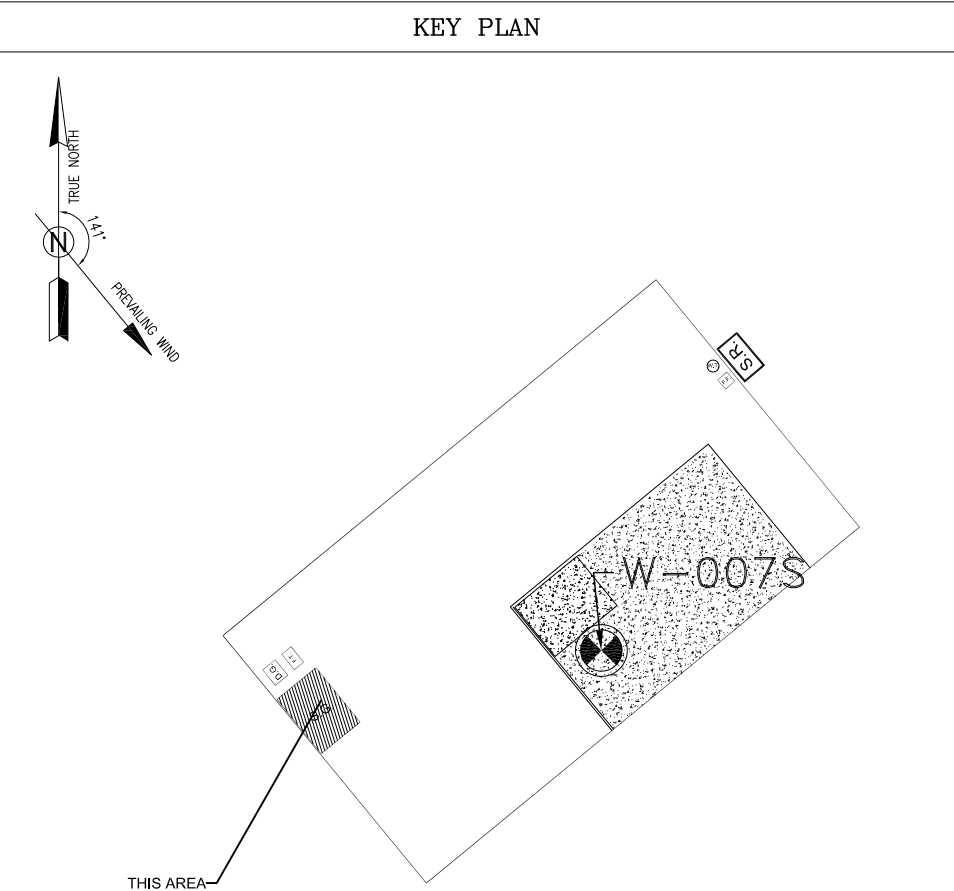

D03	MAR.2023	IPA	R.BERLOUIE	M.PAKHARIAN	M.Mehrshad	***					
D02	SEP.2022	IPC	R.BERLOUIE	M.PAKHARIAN	M.Mehrshad	***	***	*****	***	****	***
D01	MAY.2022	IPC	R.BERLOUIE	M.PAKHARIAN	M.Mehrshad	***	REV.	DESCRIPTION	BY	DATE	BY
D00	MAR.2022	IPC	R.BERLOUIE	M.PAKHARIAN	M.Mehrshad	***			CHECKED		REV. APPR.
REV.	DATE	P.O.I.S	PREP.	CHK.	APP.	AUT.	اصل و کلیه نسخ این نقشه و حق اقتباس متعلق به شرکت ملی مناطق نفت خیز جنوب می باشد.				
PROJECT NAME: BINAK OILFIELD DEVELOPMENT/SUB-SURFACE WORK PACKAGES W007S WHF & EXTENSION OF BINAK B/C								THE ORIGINAL AND ALL COPIES OF THIS DRAWING TOGETHER WITH THE COPYRIGHT THEREIN ARE THE SOLE PROPERTY OF N.I.S.O.C./ FIELDS			
PROJECT NO.: 971020											
EPC CONTRACTOR:			EPD/EPC CONTRACTOR (GC):				BINAK OILFIELD DEVELOPMENT SUB-SURFACE WORK PACKAGES W007S WHF & EXTENSION OF BINAK B/C				
 HIRGAN ENERGY – DESIGN & INSPECTION COMPANIES			 PETROIRAN DEVELOPMENT COMPANY								
							DATE	SCALE	DRAWING BY	CHECKED BY	PROJECT ENG.
DRAWING TITLE: ARCHITECTURAL DRAWING FOR SWITCHGEAR BUILDING OF WELL PADS – W007S PLAN AND ELEVATION							NO CONSTRUCTION PERMITTED UNLESS DRAWING APPROVED				
							APPROVED FOR CONSTRUCTION			BY:	DATE:
SCALE	SIZE	DRAWING NO.			SHEET NO.	REV.	BUDGET REF.	LOCATION	SIZE	CLASS	SERIAL NO.
AS SHOWN	A1	BK-W007S-PEDCO-110-AR-DW-0003			03 OF 07	D03	053-073-9184	F	4	B	708044
										03 OF 07	D03

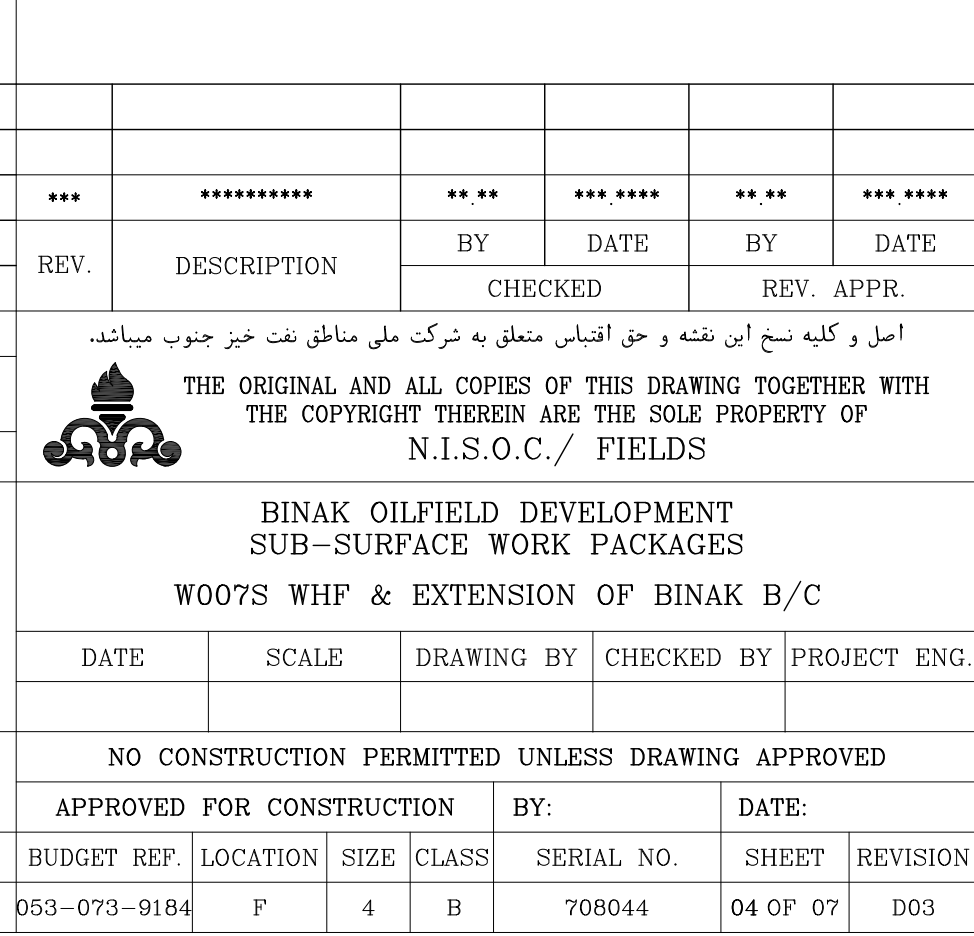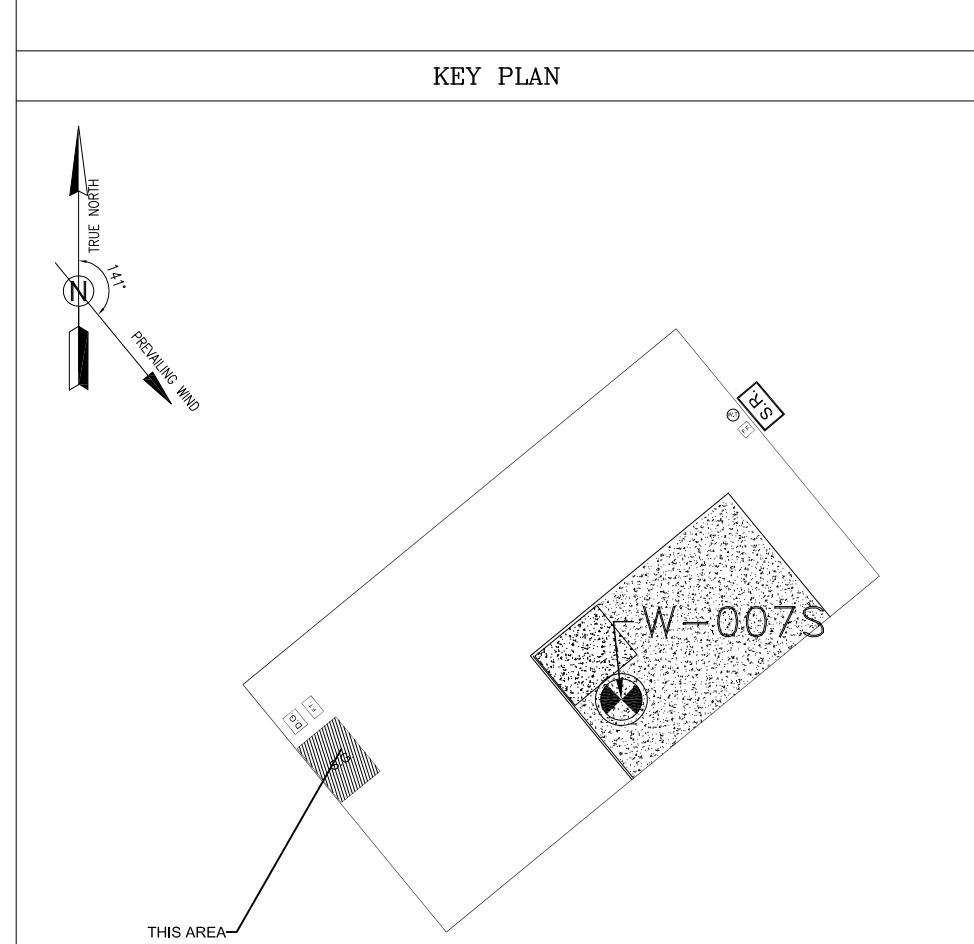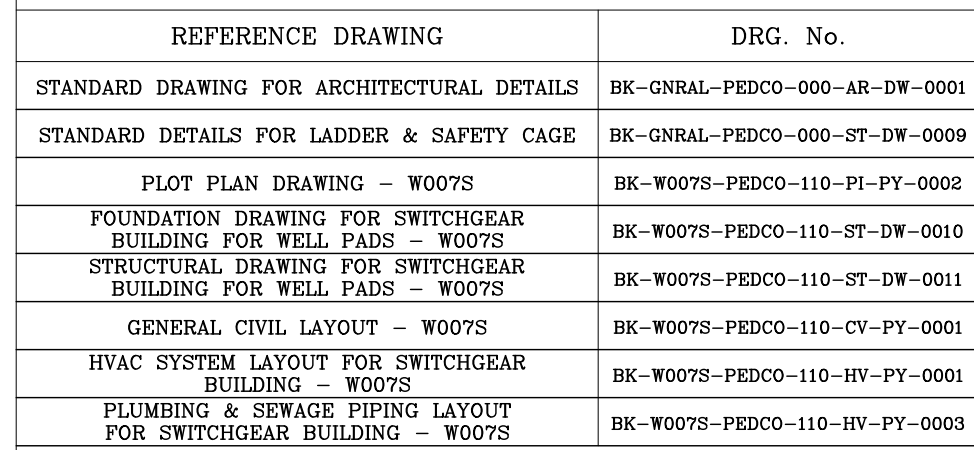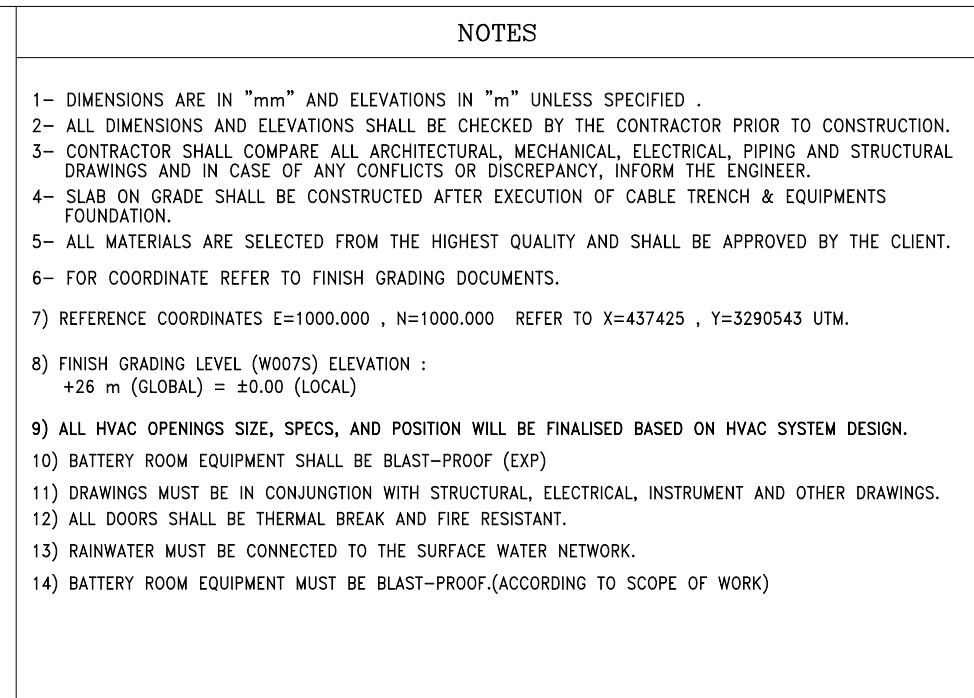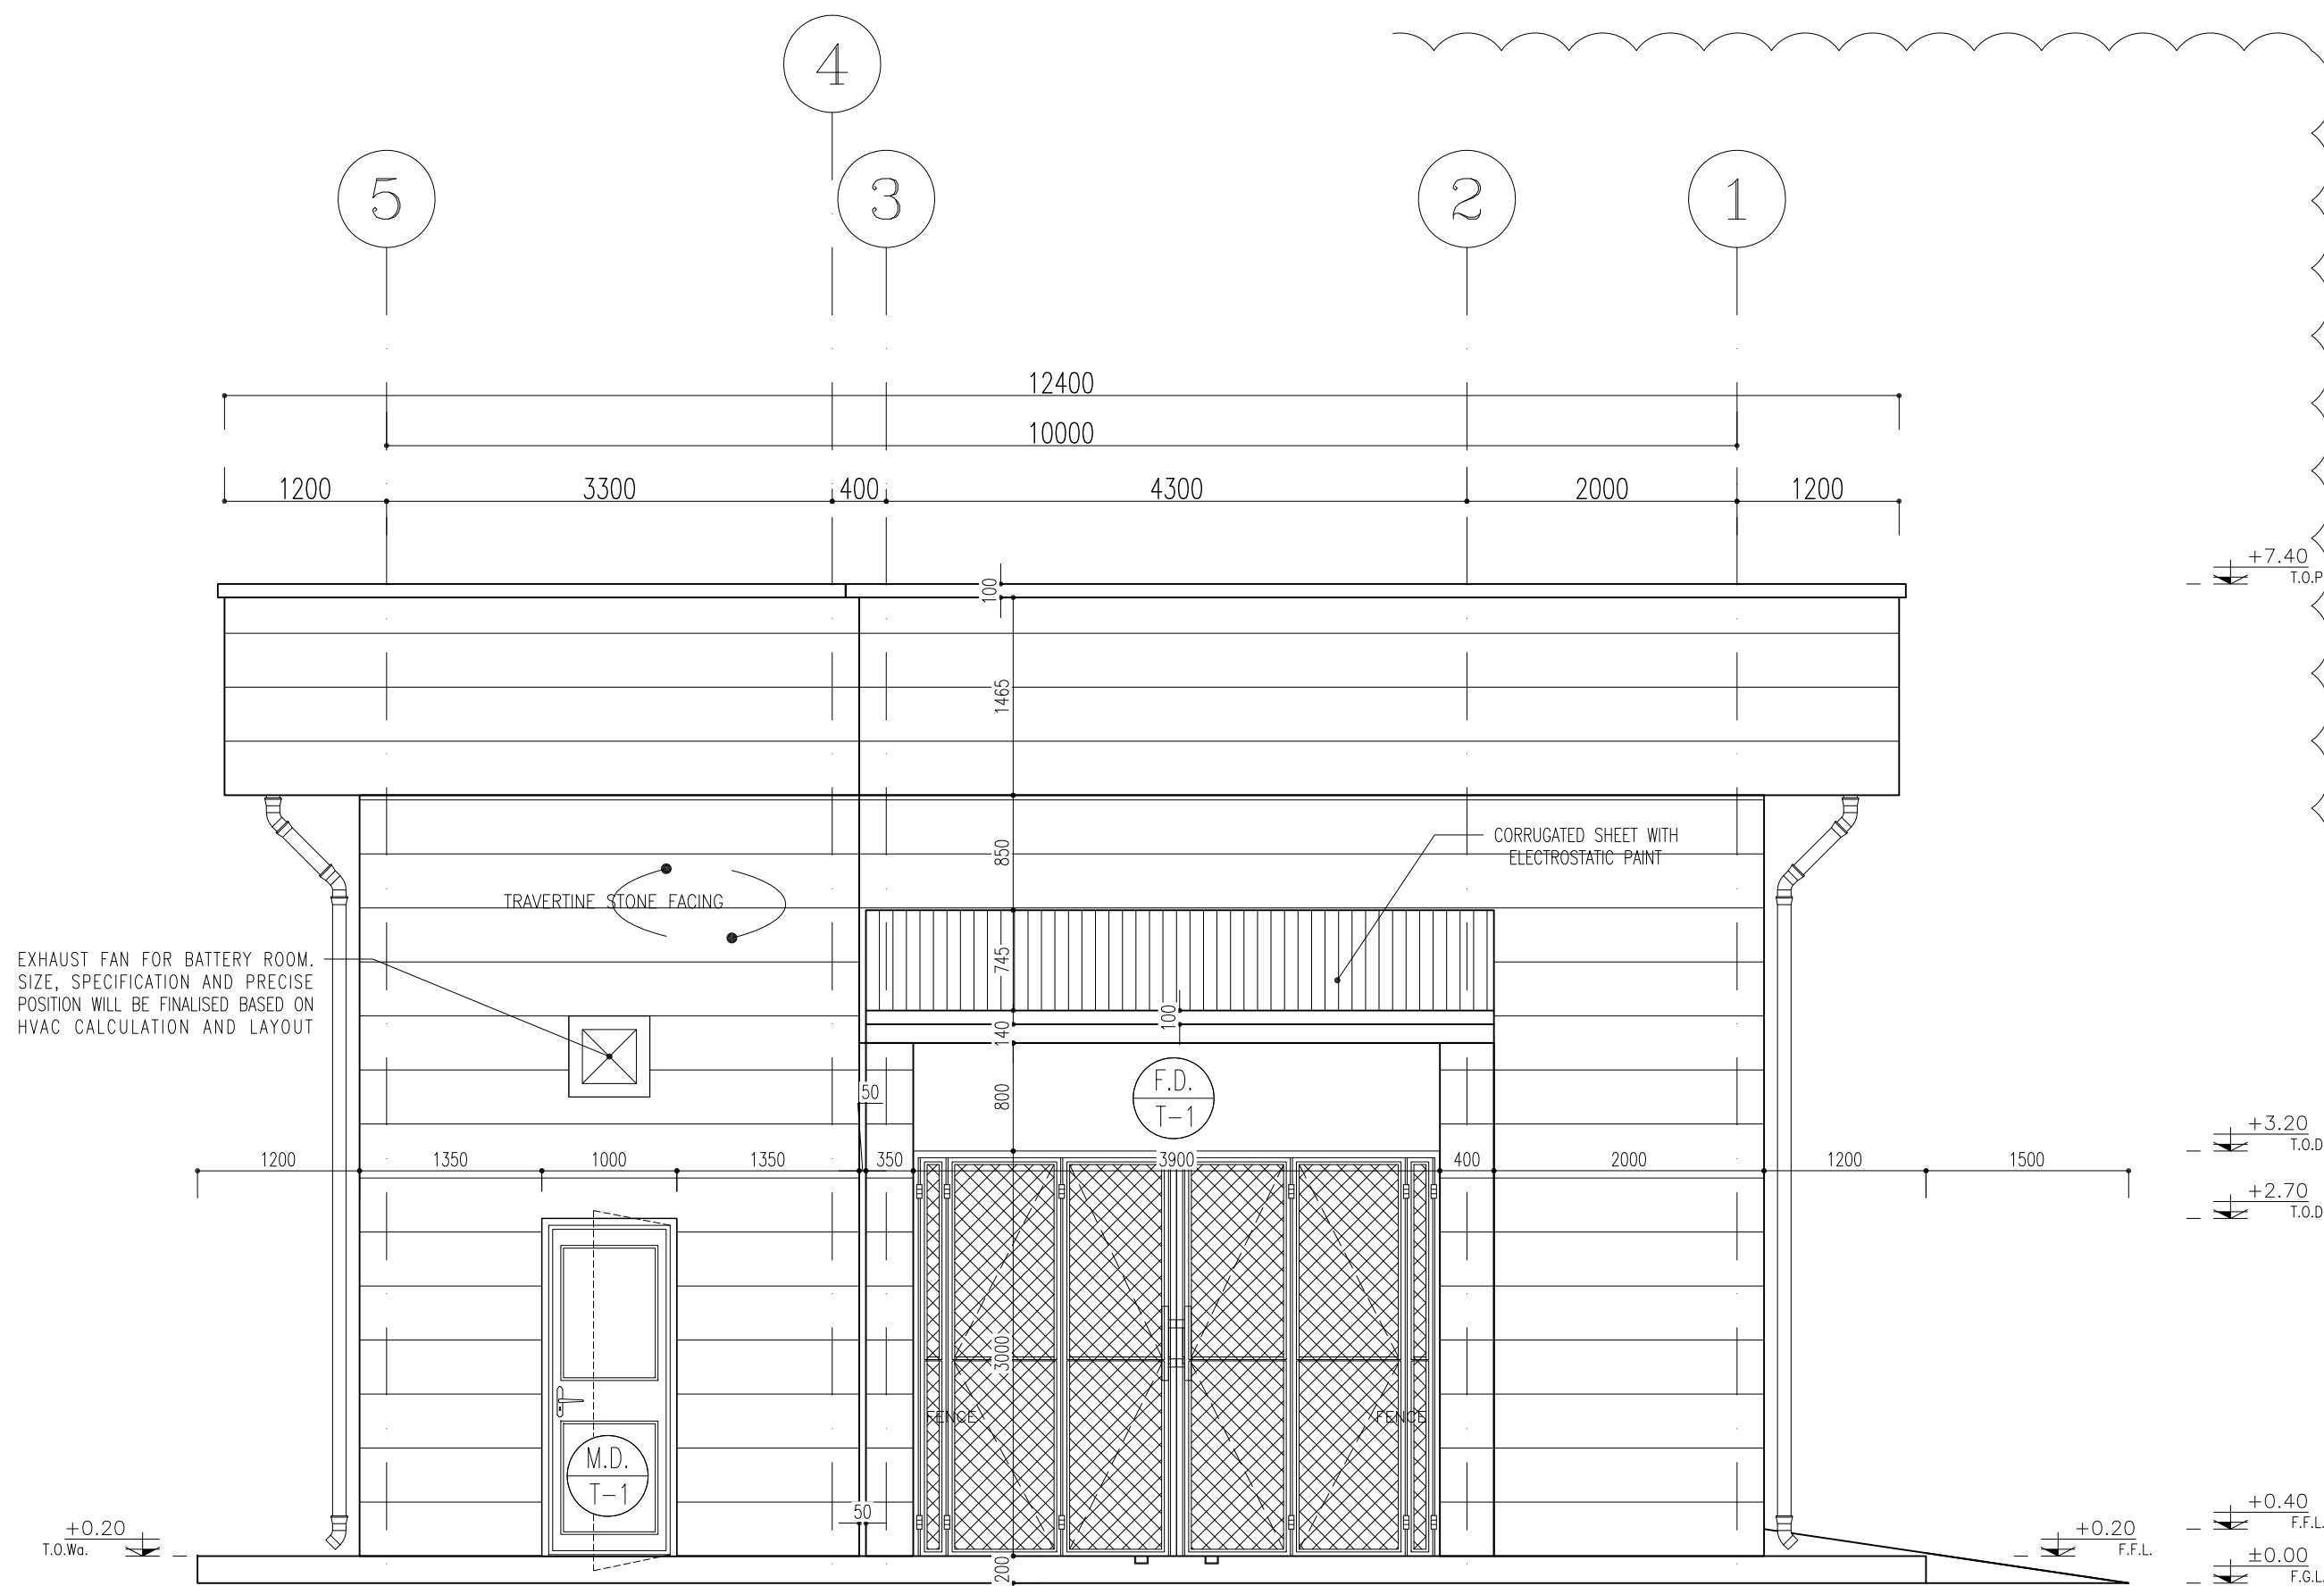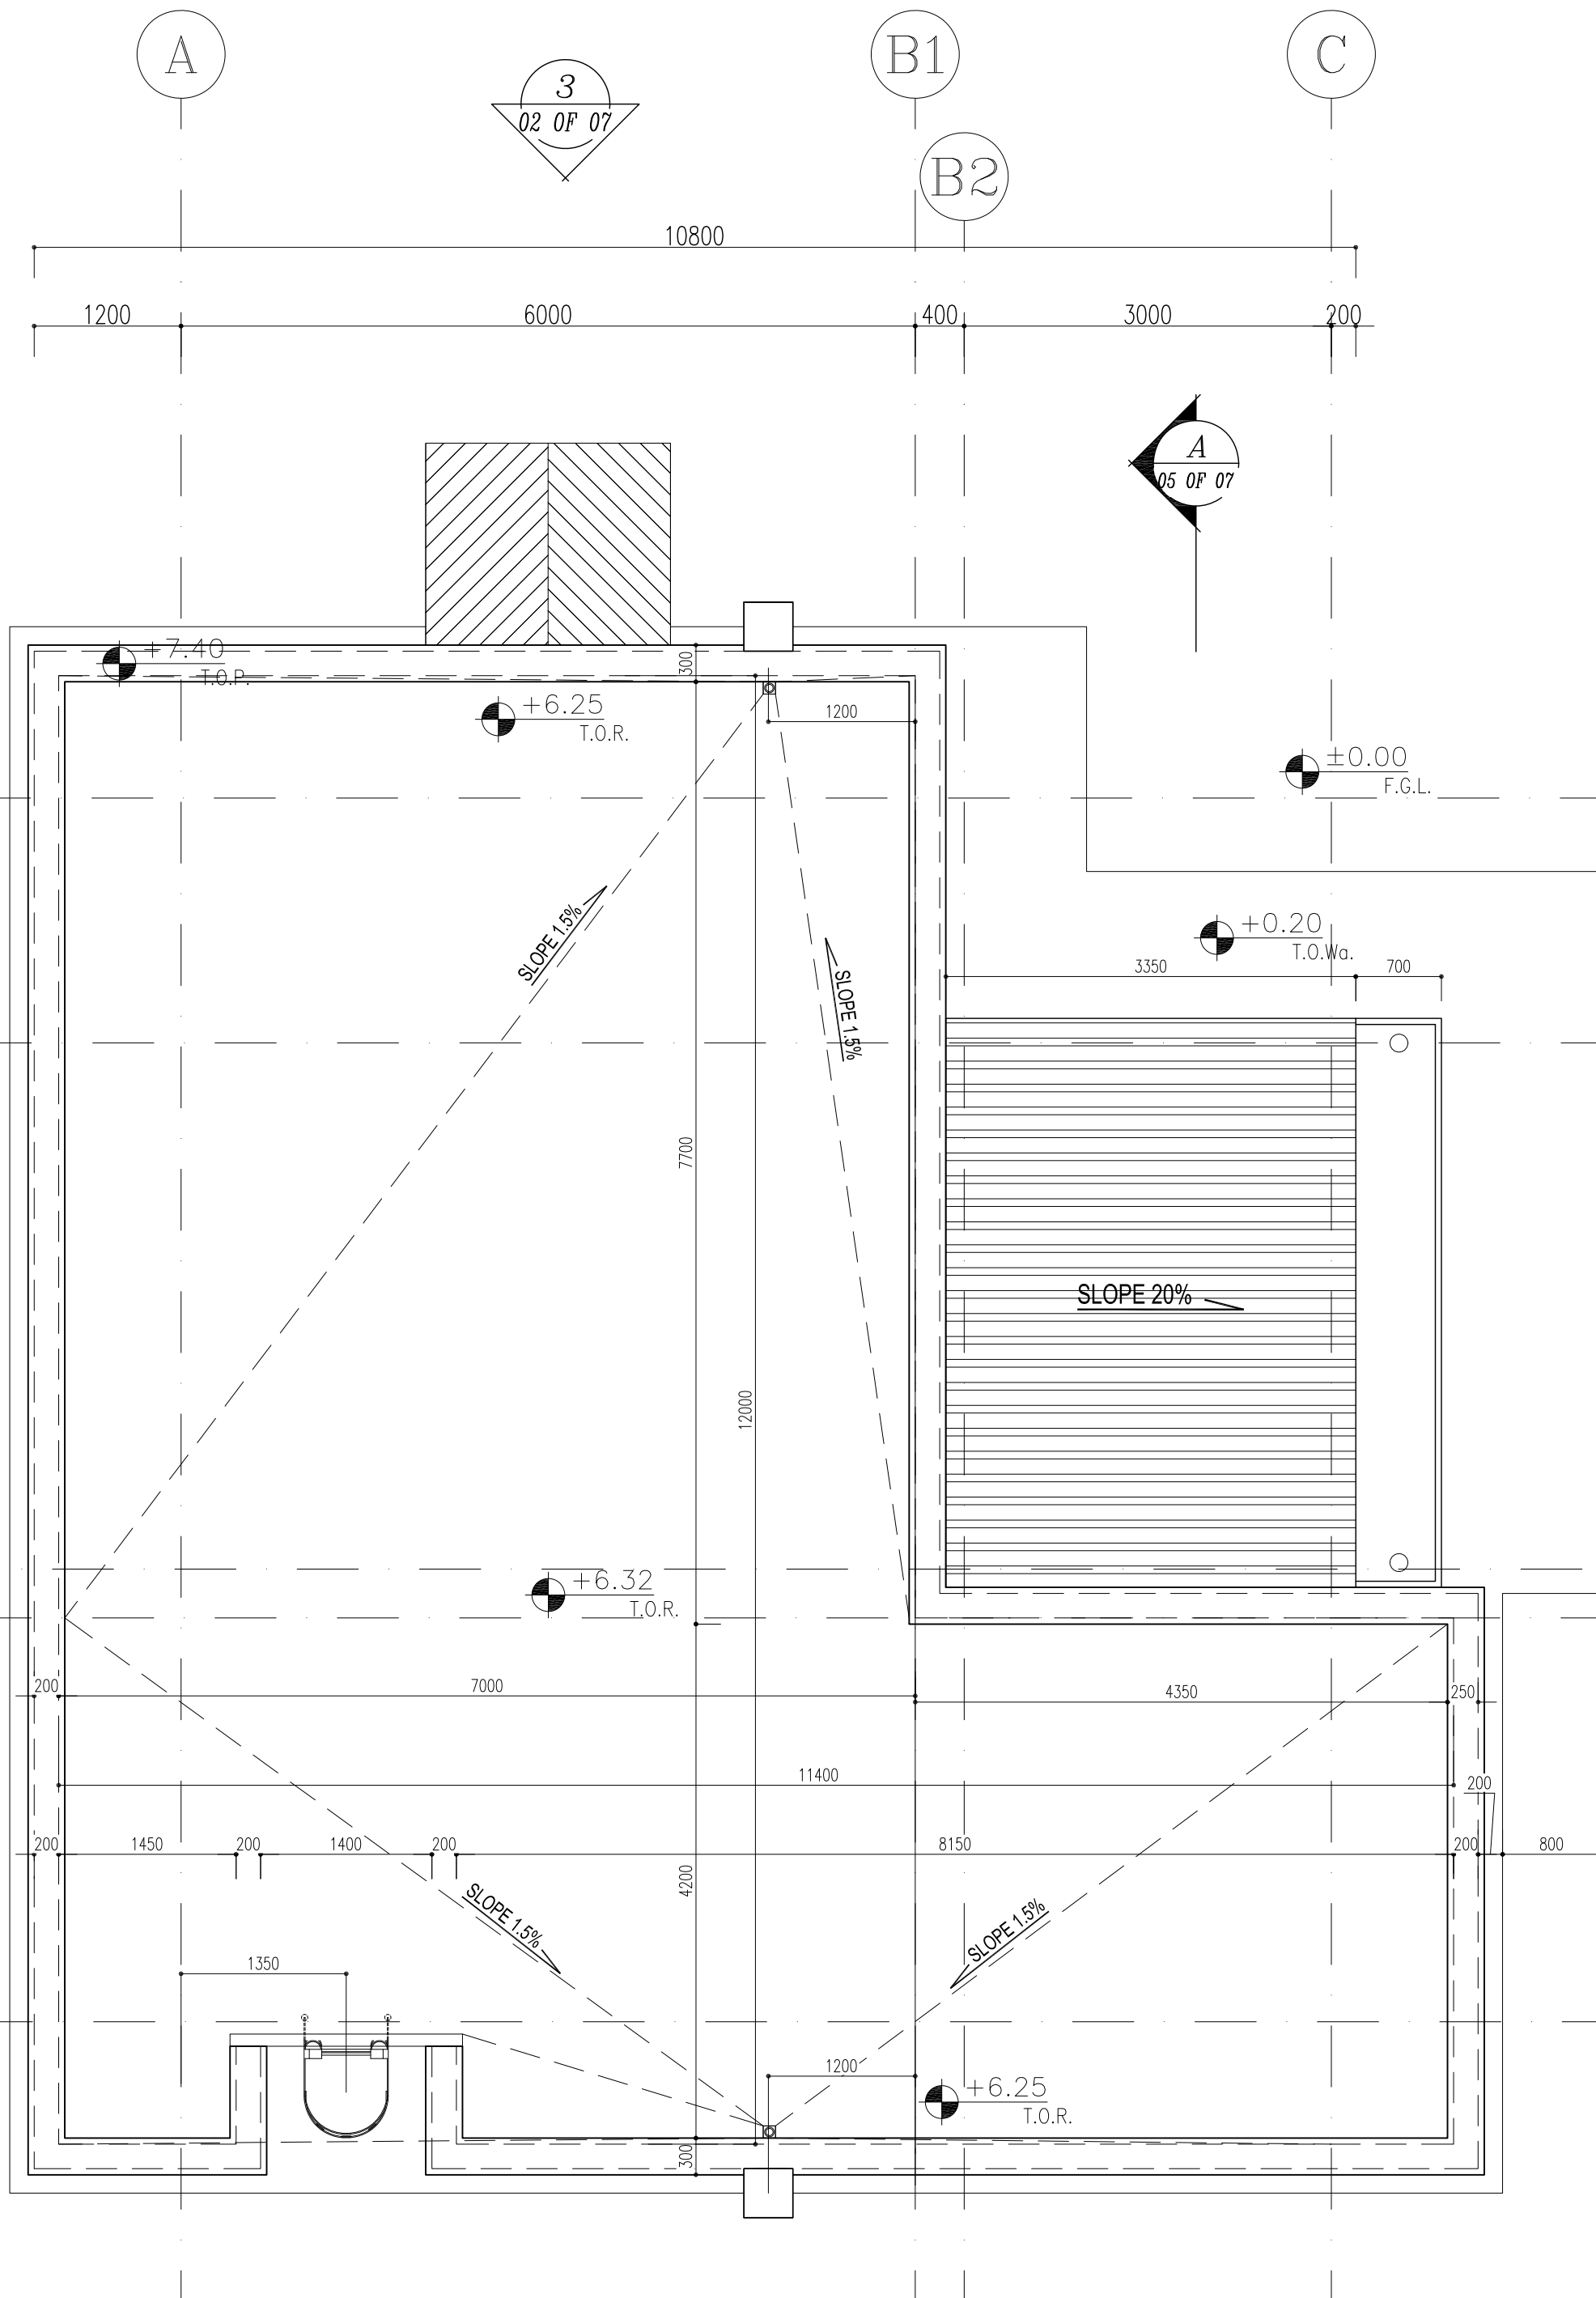

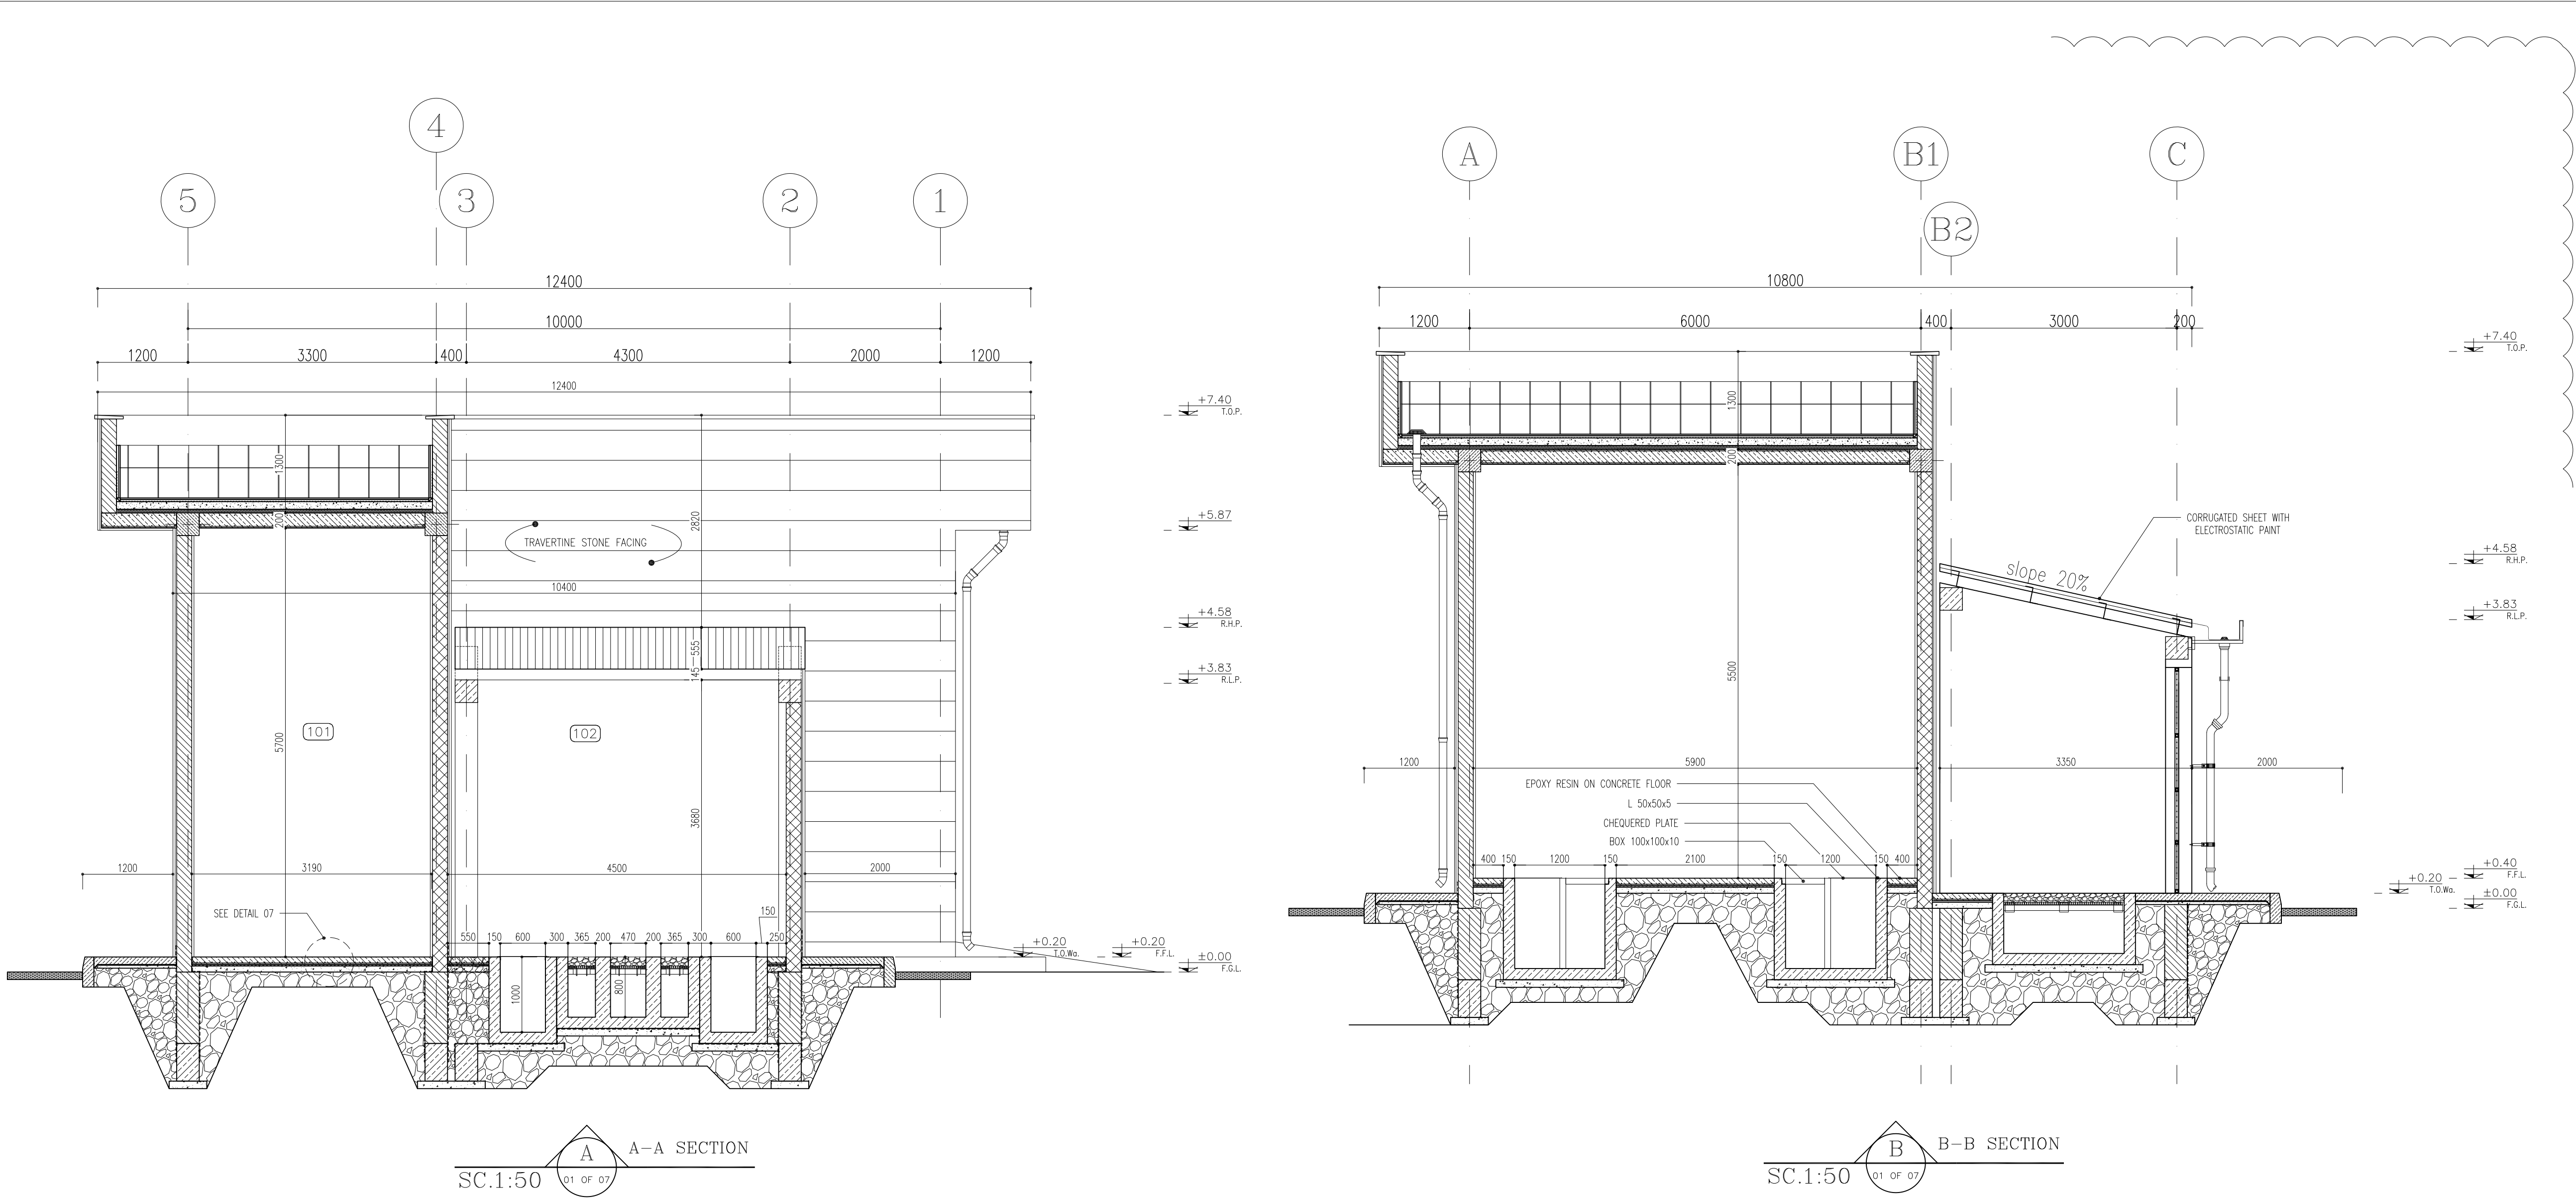

A-A SECTION
SC.1:50
01 OF 07

B-B SECTION
SC.1:50
01 OF 07

FINISHING SCHEDULE


	AREA	FLOOR	MATERIAL DIMENSION	SKIRTING	WALL	CEILING
100	SWITCHGEAR ROOM	EPOXY RESIN ON CONCRETE	—	—	GYPSUM PLASTER WITH WHITE PLASTIC PAINT	WHITE CEMENT PLASTER+OIL PAINT
101	BATTERY ROOM	ANTI ACID CERAMIC TILES	(60×60)	—	ANTI ACID CERAMIC TILES	WHITE CEMENT PLASTER+OIL PAINT
102	TRANSFORMER SHELTER	SMOOTH LEVELED CONCRETE FINISHING	—	—	SMOOTH LEVELED CONCRETE FINISHING	CURROGATED METAL SHEET 0.75mm — ELECTROSTATIC PAINT
103	WALK WAY	SMOOTH LEVELED CONCRETE FINISHING	—	—	WHITE TRAVERTINE W:0.40m GRADE 1	—
104	ROOF	TERRAZZO TILE	(40×40)	—	TERRAZZO TILE	TERRAZZO TILE

D03



5 FINISHING SCHEDULE

NOTES	
1- DIMENSIONS ARE IN "mm" AND ELEVATIONS IN "m" UNLESS SPECIFIED . 2- ALL DIMENSIONS AND ELEVATIONS SHALL BE CHECKED BY THE CONTRACTOR PRIOR TO CONSTRUCTION. 3- CONTRACTOR SHALL COMPARE ALL ARCHITECTURAL, MECHANICAL, ELECTRICAL, PIPING AND STRUCTURAL DRAWINGS AND IN CASE OF ANY CONFLICTS OR DISCREPANCY, INFORM THE ENGINEER. 4- SLAB ON GRADE SHALL BE CONSTRUCTED AFTER EXECUTION OF CABLE TRENCH & EQUIPMENTS FOUNDATION. 5- ALL MATERIALS ARE SELECTED FROM THE HIGHEST QUALITY AND SHALL BE APPROVED BY THE CLIENT. 6- FOR COORDINATE REFER TO FINISH GRADING DOCUMENTS. 7) REFERENCE COORDINATES E=1000.000 , N=1000.000 REFER TO X=437425 , Y=3290543 UTM. 8) FINISH GRADING LEVEL (W007S) ELEVATION : +26 m (GLOBAL) = ±0.00 (LOCAL) 9) ALL HVAC OPENINGS SIZE, SPECS, AND POSITION WILL BE FINALISED BASED ON HVAC SYSTEM DESIGN. 10) BATTERY ROOM EQUIPMENT SHALL BE BLAST-PROOF (EXP) 11) DRAWINGS MUST BE IN CONJUNCTION WITH STRUCTURAL, ELECTRICAL, INSTRUMENT AND OTHER DRAWINGS. 12) ALL DOORS SHALL BE THERMAL BREAK AND FIRE RESISTANT. 13) RAINWATER MUST BE CONNECTED TO THE SURFACE WATER NETWORK. 14) BATTERY ROOM EQUIPMENT MUST BE BLAST-PROOF.(ACCORDING TO SCOPE OF WORK)	
LEGEND	
	BRICK WALL
	REINFORCED CONCRETE ACCORDING TO STR. DWG
	BLOCKAGE
	LEAN CONCRETE
	FIRE RESISTANT BRICK WALL
F.F.L.	FINISHED FLOOR
F.G.L.	TOP OF WALL
T.O.Wa.	TOP OF WALKWAY
T.O.P.	TOP OF PARAPET
T.O.Fou.	TOP OF FOUNDATION
B.O.Pit	BOTTOM OF PIT
B.O.O.	BOTTOM OF OPENING
T.O.D.	TOP OF DOOR
T.O.R.	TOP OF ROOF
T.O.W.	FINISHED GRADING LEVEL
B.O.O.	BOTTOM OF OPENING


REFERENCE DRAWING	DRG. No.
STANDARD DRAWING FOR ARCHITECTURAL DETAILS	BK-GNRL-PEDCO-000-AR-DW-0001
STANDARD DETAILS FOR LADDER & SAFETY CAGE	BK-GNRL-PEDCO-000-ST-DW-0009
PLOT PLAN DRAWING - W007S	BK-W007S-PEDCO-110-PI-PY-0002
FOUNDATION DRAWING FOR SWITCHGEAR BUILDING FOR WELL PADS - W007S	BK-W007S-PEDCO-110-ST-DW-0010
STRUCTURAL DRAWING FOR SWITCHGEAR BUILDING FOR WELL PADS - W007S	BK-W007S-PEDCO-110-ST-DW-0011
GENERAL CIVIL LAYOUT - W007S	BK-W007S-PEDCO-110-CV-PY-0001
HVAC SYSTEM LAYOUT FOR SWITCHGEAR BUILDING - W007S	BK-W007S-PEDCO-110-HV-PY-0001
PLUMBING & SEWAGE PIPING LAYOUT FOR SWITCHGEAR BUILDING - W007S	BK-W007S-PEDCO-110-HV-PY-0003

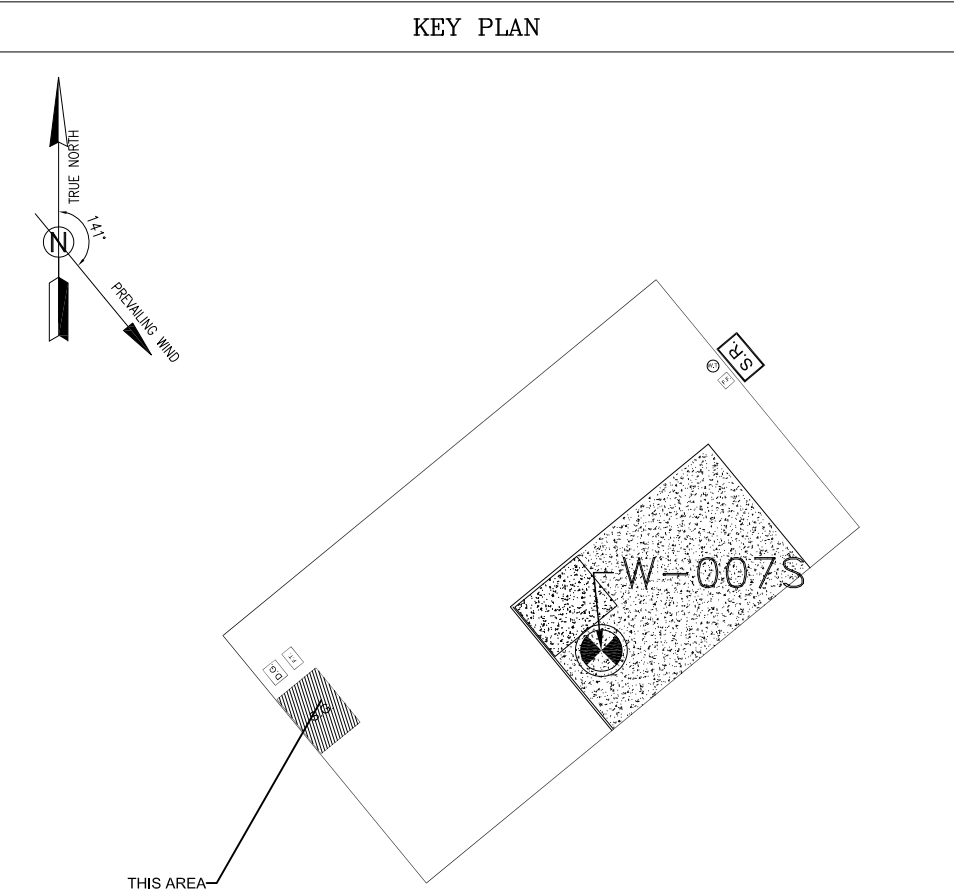


D03	MAR.2023	IPA	R.BERLOUIE	M.PAKHARIAN	M.Mehrshad	***						
D02	SEP.2022	IPC	R.BERLOUIE	M.PAKHARIAN	M.Mehrshad	***	***	*****	***	*****		
D01	MAY.2022	IPC	R.BERLOUIE	M.PAKHARIAN	M.Mehrshad	***	REV.	DESCRIPTION	BY	DATE		
D00	MAR.2022	IPC	R.BERLOUIE	M.PAKHARIAN	M.Mehrshad	***			CHECKED		REV. APPR.	
REV.	DATE	P.O.I.S	PREP.	CHK.	APP.	AUT.	اصل و کلیه نسخ این نقشه و حق آفتابى متعلق به شرکت ملی مناطق نفت خیز جنوب میباشد.					
PROJECT NAME: BINAK OILFIELD DEVELOPMENT/SUB-SURFACE WORK PACKAGES W007S WHF & EXTENSION OF BINAK B/C								THE ORIGINAL AND ALL COPIES OF THIS DRAWING TOGETHER WITH THE COPYRIGHT THEREIN ARE THE SOLE PROPERTY OF N.I.S.O.C./ FIELDS				
PROJECT NO.: 971020												
EPC CONTRACTOR:			EPD/EPC CONTRACTOR (GC):				BINAK OILFIELD DEVELOPMENT SUB-SURFACE WORK PACKAGES W007S WHF & EXTENSION OF BINAK B/C					
 HIRGAN ENERGY – DESIGN & INSPECTION COMPANIES			 PETROIRAN DEVELOPMENT COMPANY									
							DATE	SCALE	DRAWING BY	CHECKED BY	PROJECT ENG.	
DRAWING TITLE: ARCHITECTURAL DRAWING FOR SWITCHGEAR BUILDING OF WELL PADS – W007S SECTIONS AND FINISHING SCHEDULE							NO CONSTRUCTION PERMITTED UNLESS DRAWING APPROVED					
							APPROVED FOR CONSTRUCTION			BY:	DATE:	
SCALE	SIZE	DRAWING NO.		SHEET NO.	REV.	BUDGET REF.	LOCATION	SIZE	CLASS	SERIAL NO.	SHEET	REVISION
AS SHOWN	A1	BK-W007S-PEDCO-110-AR-DW-0003		05 OF 07	D03	053-073-9184	F	4	B	708044	05 OF 07	D03

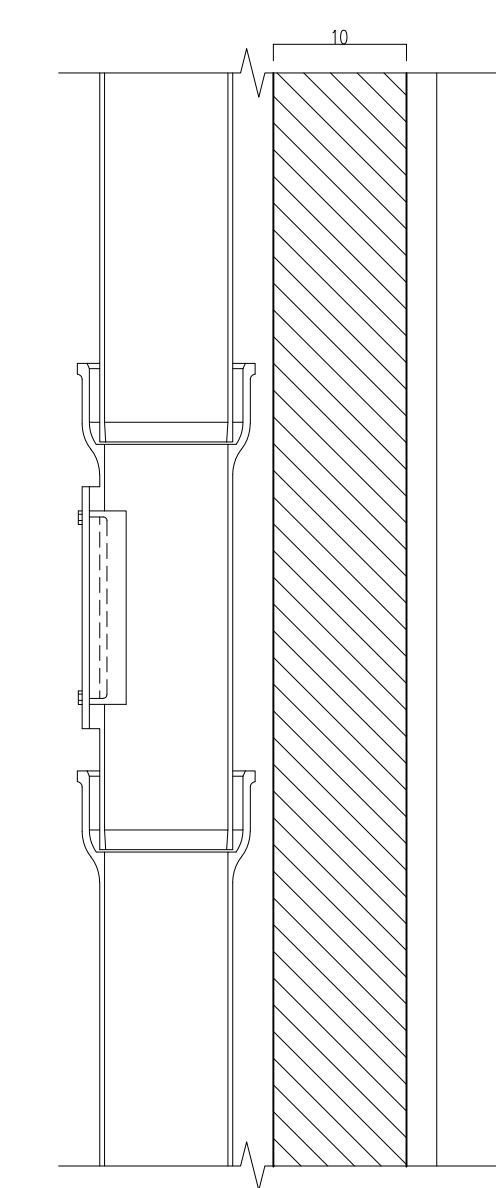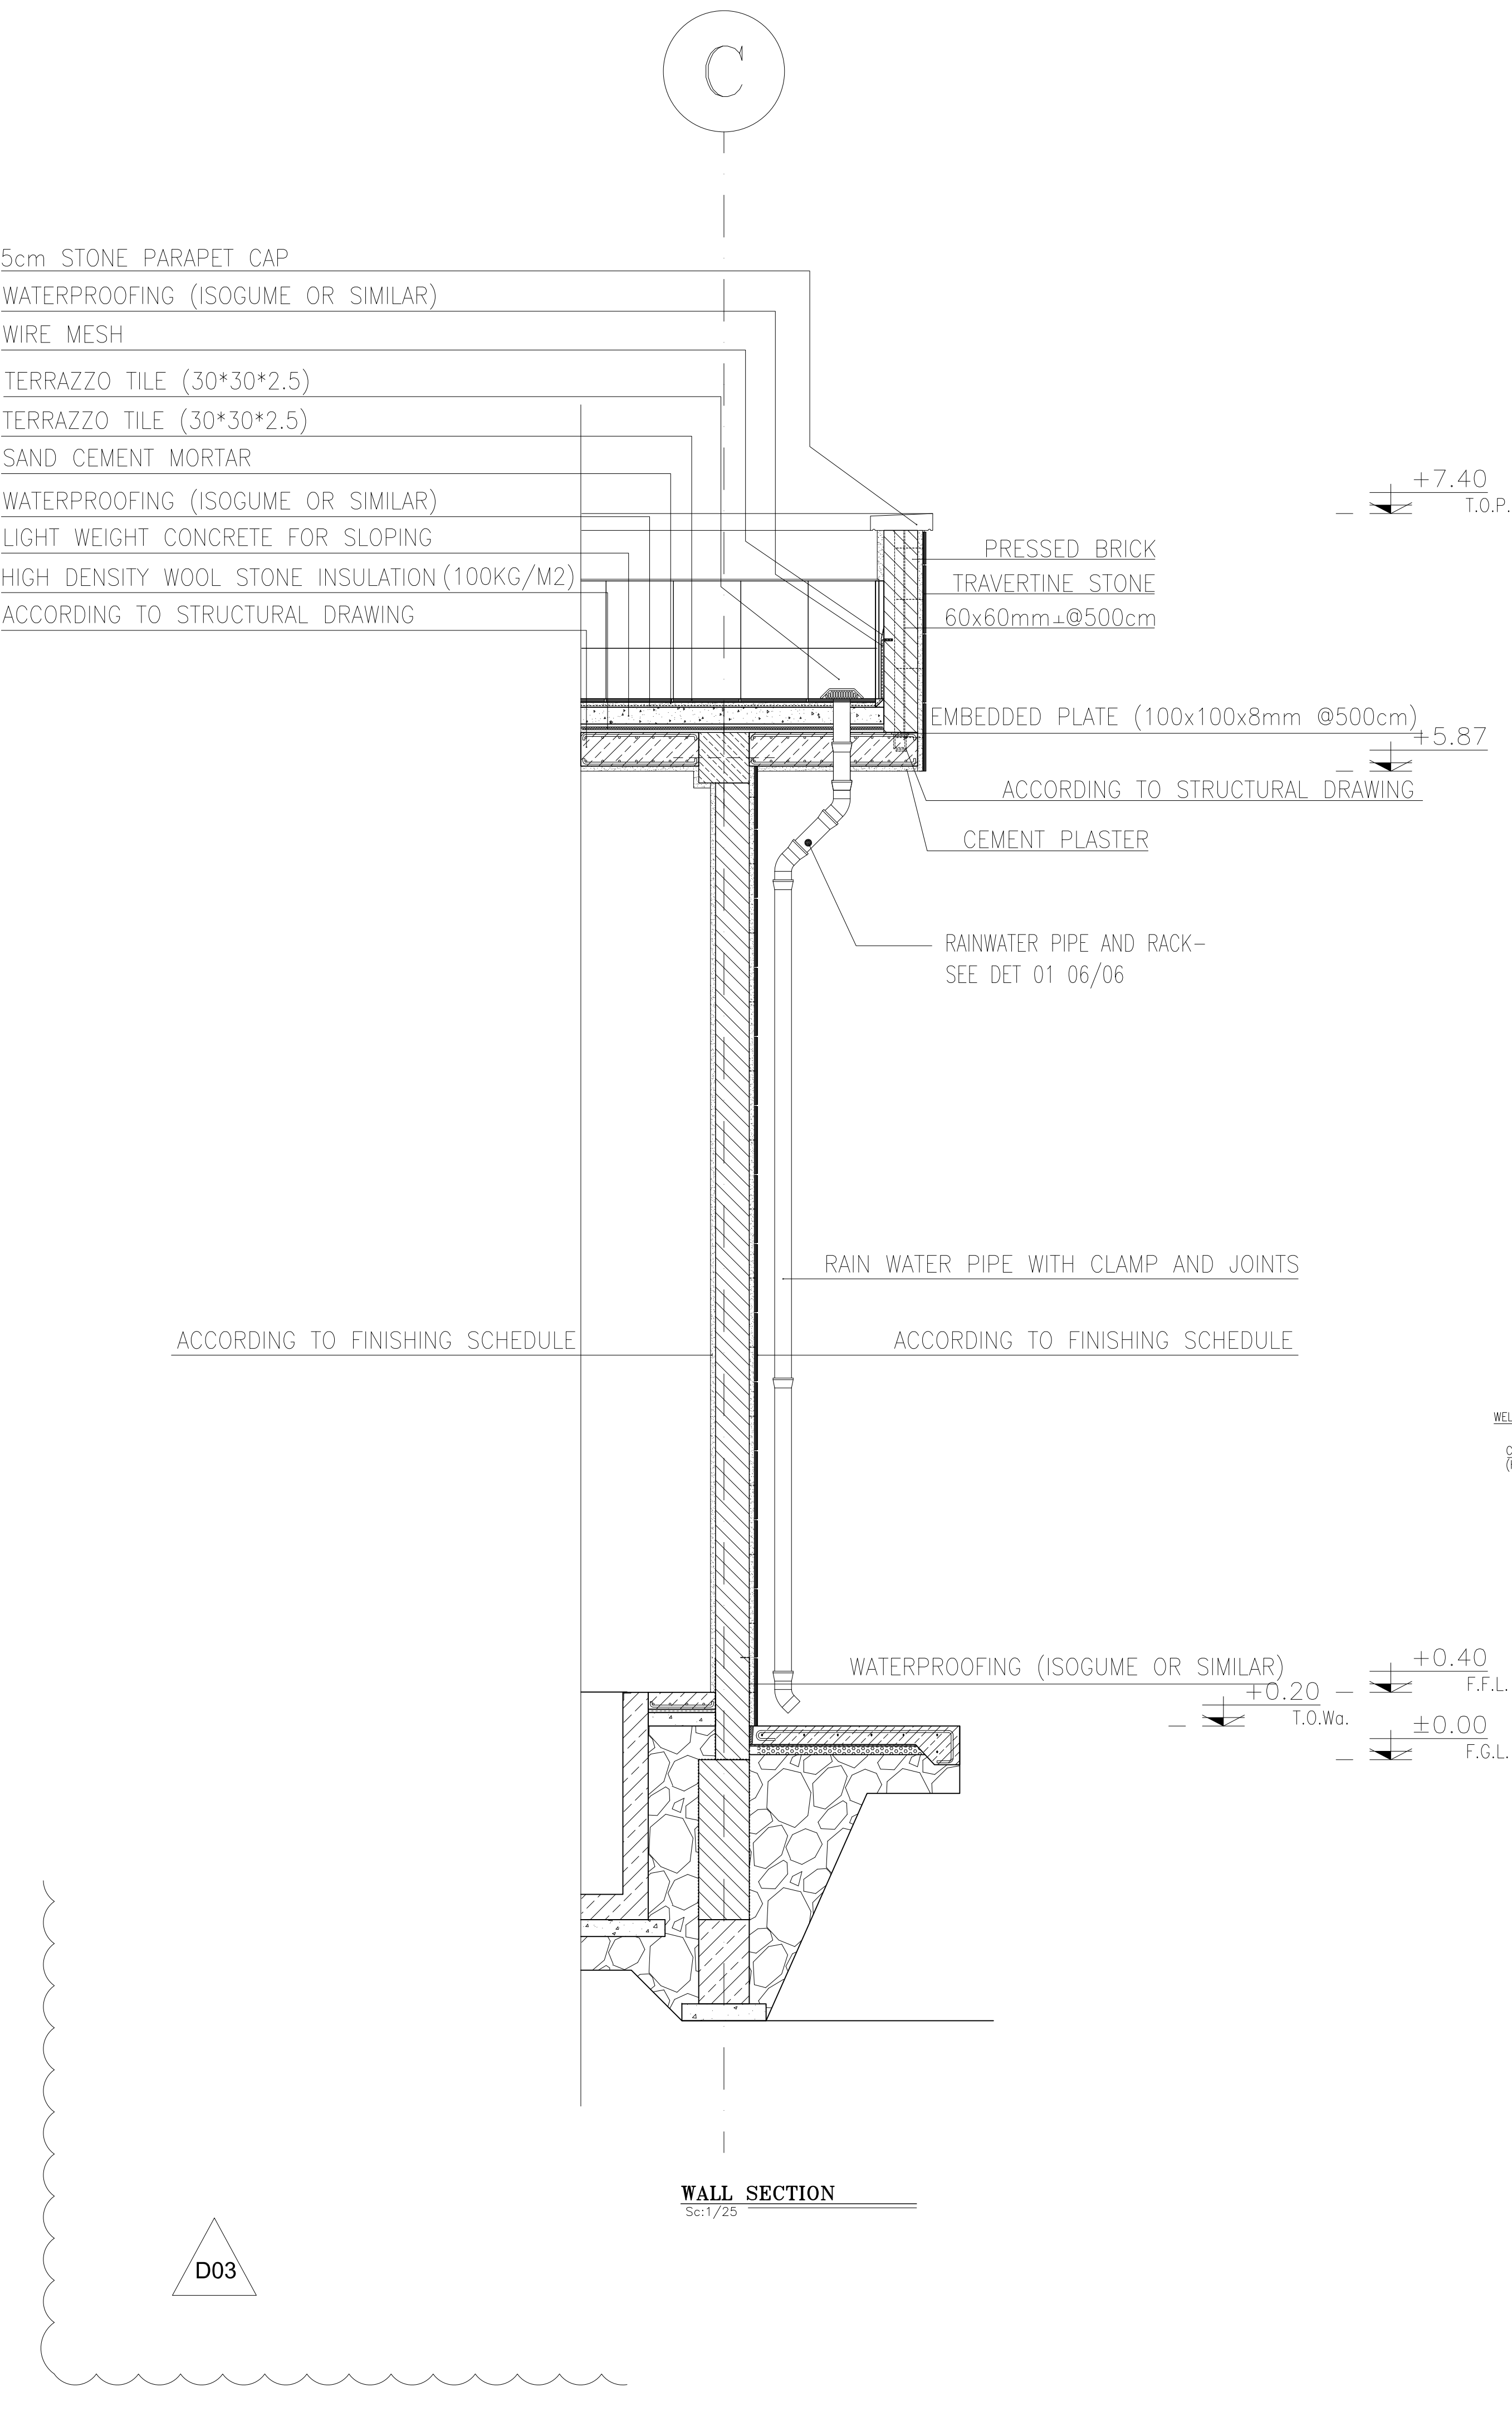


RAINWATER PIPE VALVE DETAIL
Sc:1/25
DETAIL-01

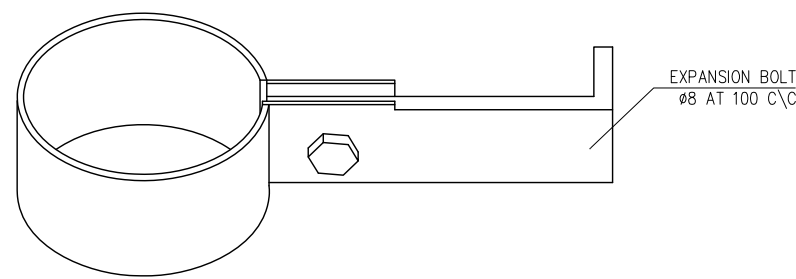


TYPICAL PIPE CLIP ON TRAPEZOIDAL SHEET
Sc:1/10
DETAIL-03

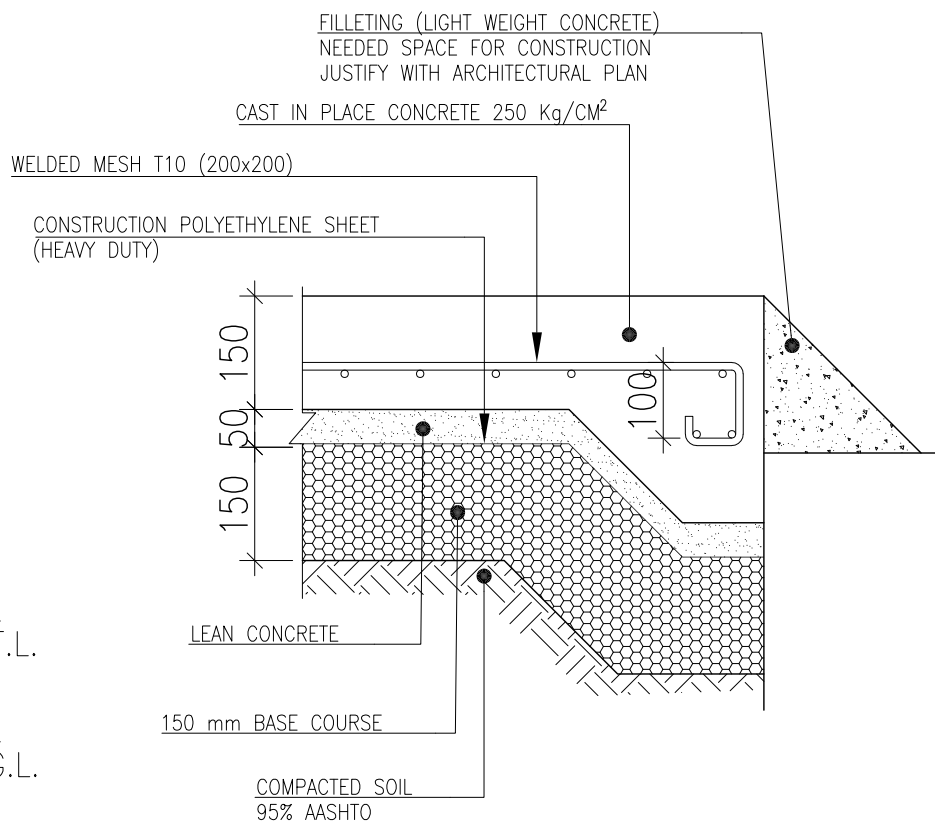


SECTION 7-7
Sc:1/25

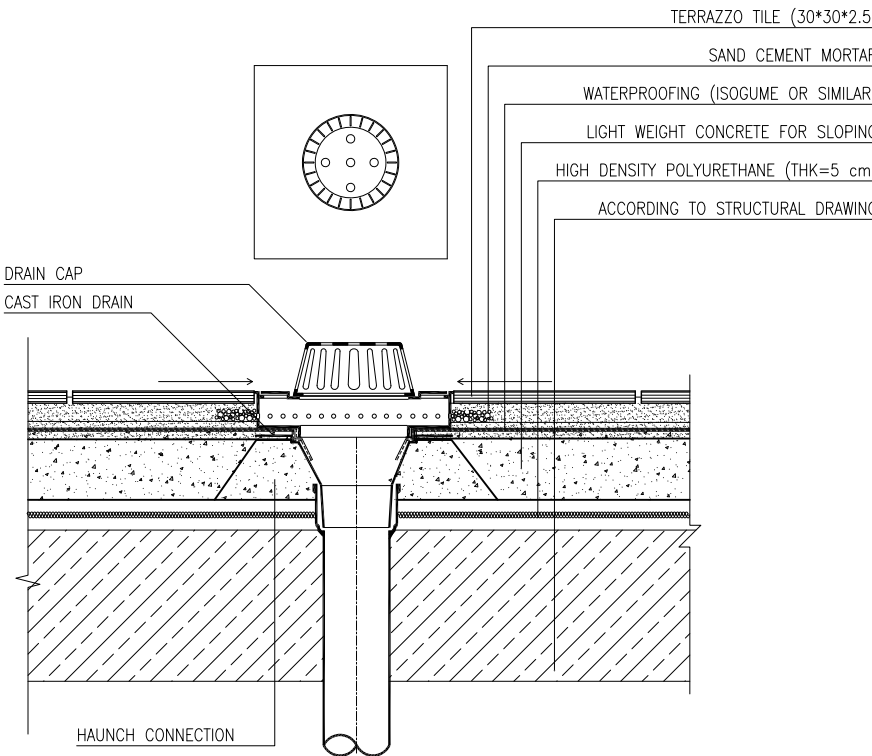


DRAIN DETAIL (ROOF)
Sc:1/25
DETAIL-05

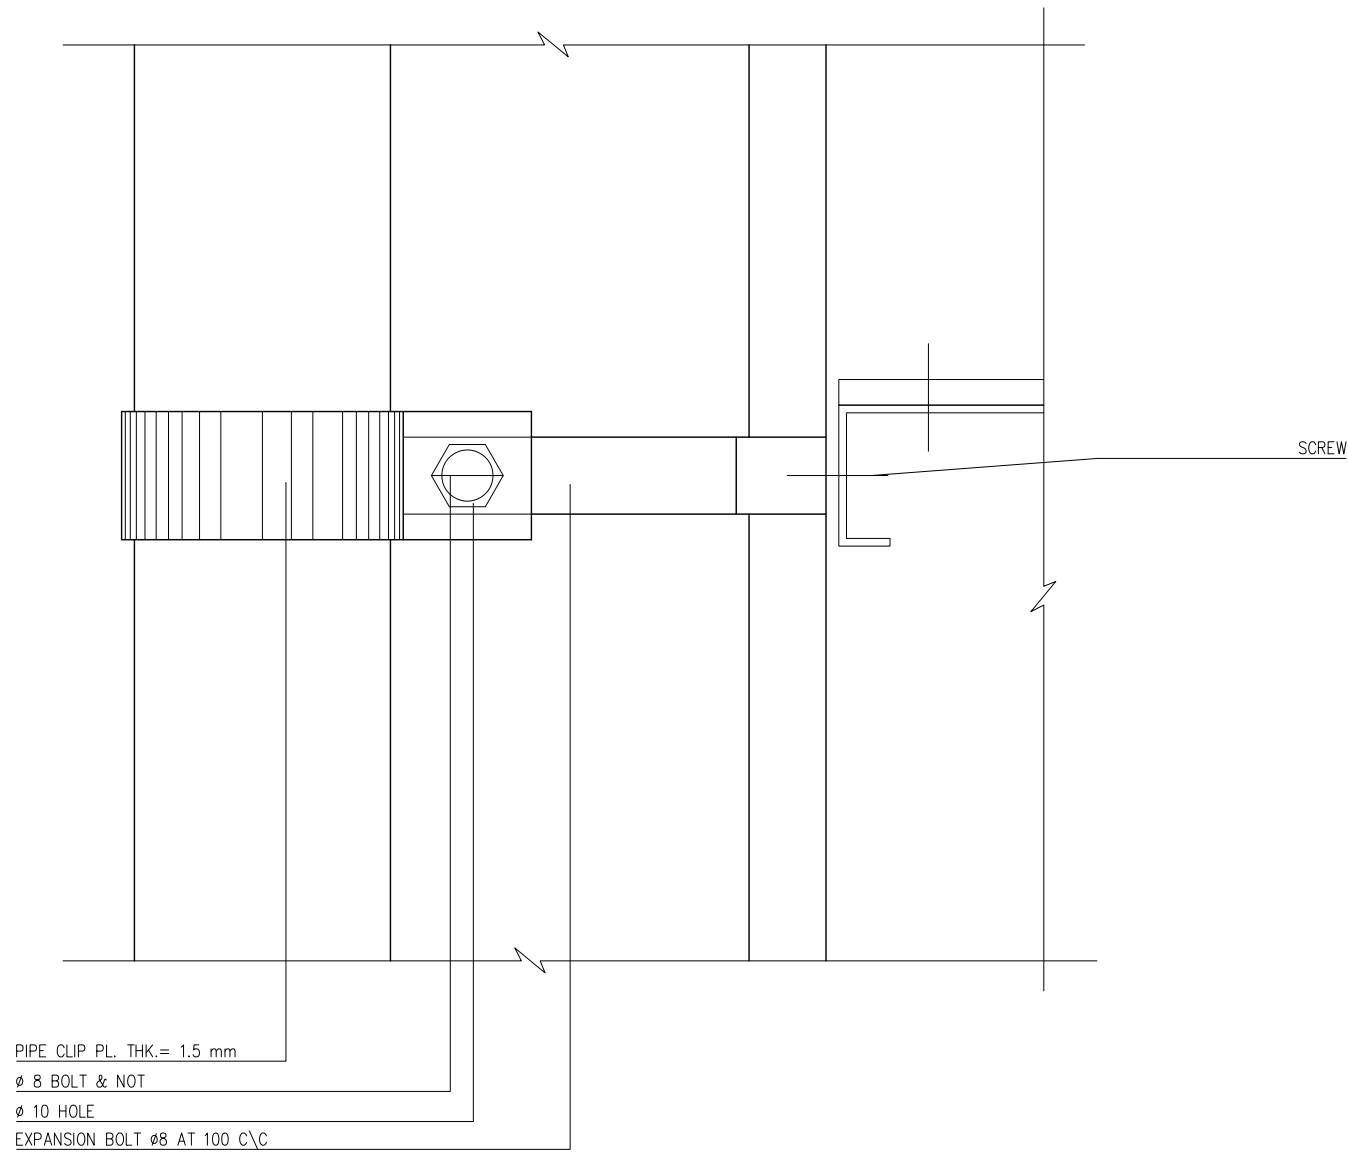

TYPICAL PIPE CLIP ON TRAPEZOIDAL SHEET
Sc:1/10
DETAIL-02

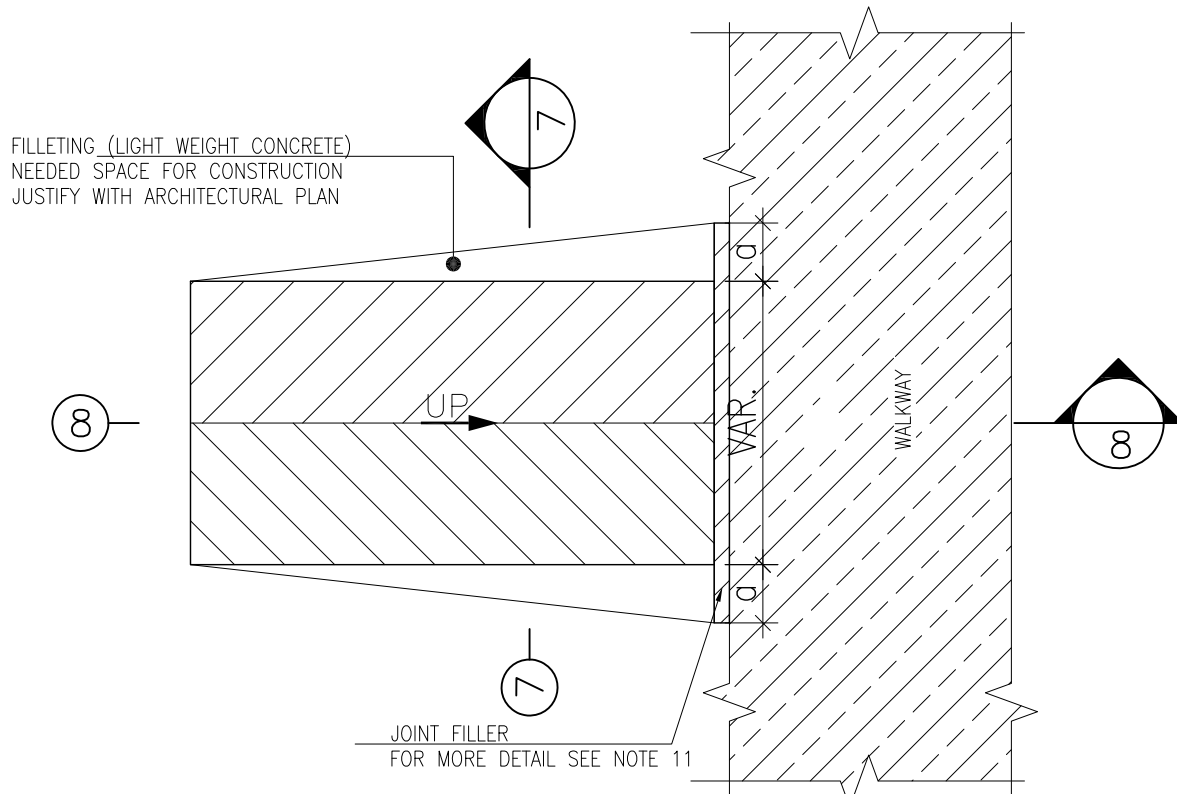

TYPICAL RAMP PLAN
N.T.S.
DETAIL-04

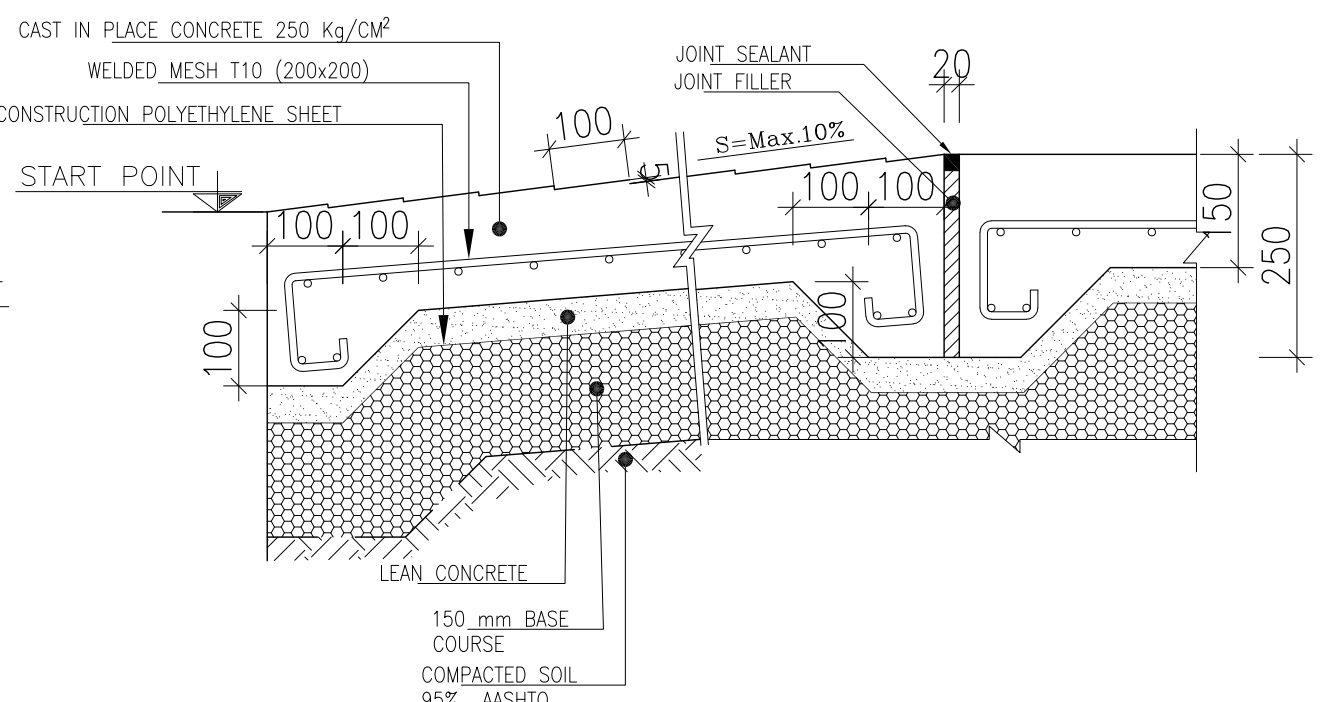


SECTION 8-8
Sc:1/25

- NOTES
- 1- DIMENSIONS ARE IN "mm" AND ELEVATIONS IN "m" UNLESS SPECIFIED .
 - 2- ALL DIMENSIONS AND ELEVATIONS SHALL BE CHECKED BY THE CONTRACTOR PRIOR TO CONSTRUCTION.
 - 3- CONTRACTOR SHALL COMPARE ALL ARCHITECTURAL, MECHANICAL, ELECTRICAL, PIPING AND STRUCTURAL DRAWINGS AND IN CASE OF ANY CONFLICTS OR DISCREPANCY, INFORM THE ENGINEER.
 - 4- SLAB ON GRADE SHALL BE CONSTRUCTED AFTER EXECUTION OF CABLE TRENCH & EQUIPMENTS FOUNDATION.
 - 5- ALL MATERIALS ARE SELECTED FROM THE HIGHEST QUALITY AND SHALL BE APPROVED BY THE CLIENT.
 - 6- FOR COORDINATE REFER TO FINISH GRADING DOCUMENTS.
 - 7) REFERENCE COORDINATES E=1000.000 , N=1000.000 REFER TO X=437425 , Y=3290543 UTM.
 - 8) FINISH GRADING LEVEL (W007S) ELEVATION :
+26 m (GLOBAL) = ±0.00 (LOCAL)
 - 9) ALL HVAC OPENINGS SIZE, SPECS, AND POSITION WILL BE FINALISED BASED ON HVAC SYSTEM DESIGN.
 - 10) BATTERY ROOM EQUIPMENT SHALL BE BLAST-PROOF (EXP)
 - 11) DRAWINGS MUST BE IN CONJUNCTION WITH STRUCTURAL, ELECTRICAL, INSTRUMENT AND OTHER DRAWINGS.
 - 12) ALL DOORS SHALL BE THERMAL BREAK AND FIRE RESISTANT.
 - 13) RAINWATER MUST BE CONNECTED TO THE SURFACE WATER NETWORK.
 - 14) BATTERY ROOM EQUIPMENT MUST BE BLAST-PROOF.(ACCORDING TO SCOPE OF WORK)

- LEGEND
- BRICK WALL
 - REINFORCED CONCRETE
ACCORDING TO STR. DWG
 - BLOCKAGE
 - LEAN CONCRETE
 - FIRE RESISTANT BRICK WALL

- F.F.L. FINISHED FLOOR B.O.C. BOTTOM OF CAGE
P.G.L. TOP OF WALL T.O.C. TOP OF CAGE
T.O.Wa. TOP OF WALKWAY R.H.P. ROOF HIGH POINT
T.O.P. TOP OF PARAPET R.L.P. ROOF LOW POINT
T.O.Fou. TOP OF FOUNDATION
B.O.Pit BOTTOM OF PIT
B.O.O. BOTTOM OF OPENING
T.O.D. TOP OF DOOR
T.O.R. TOP OF ROOF
T.O.W. FINISHED GRADING LEVEL
B.O.O. BOTTOM OF OPENING






REFERENCE DRAWING	DRG. No.
STANDARD DRAWING FOR ARCHITECTURAL DETAILS	BK-GNRL-PEDCO-000-AR-DW-0001
STANDARD DETAILS FOR LADDER & SAFETY CAGE	BK-GNRL-PEDCO-000-ST-DW-0009
PLOT PLAN DRAWING - W007S	BK-W007S-PEDCO-110-P1-PY-0002
FOUNDATION DRAWING FOR SWITCHGEAR BUILDING FOR WELL PADS - W007S	BK-W007S-PEDCO-110-ST-DW-0010
STRUCTURAL DRAWING FOR SWITCHGEAR BUILDING FOR WELL PADS - W007S	BK-W007S-PEDCO-110-ST-DW-0011
GENERAL CIVIL LAYOUT - W007S	BK-W007S-PEDCO-110-CV-PY-0001
HVAC SYSTEM LAYOUT FOR SWITCHGEAR BUILDING - W007S	BK-W007S-PEDCO-110-HV-PY-0001
PLUMBING & SEWAGE PIPING LAYOUT FOR SWITCHGEAR BUILDING - W007S	BK-W007S-PEDCO-110-HV-PY-0003

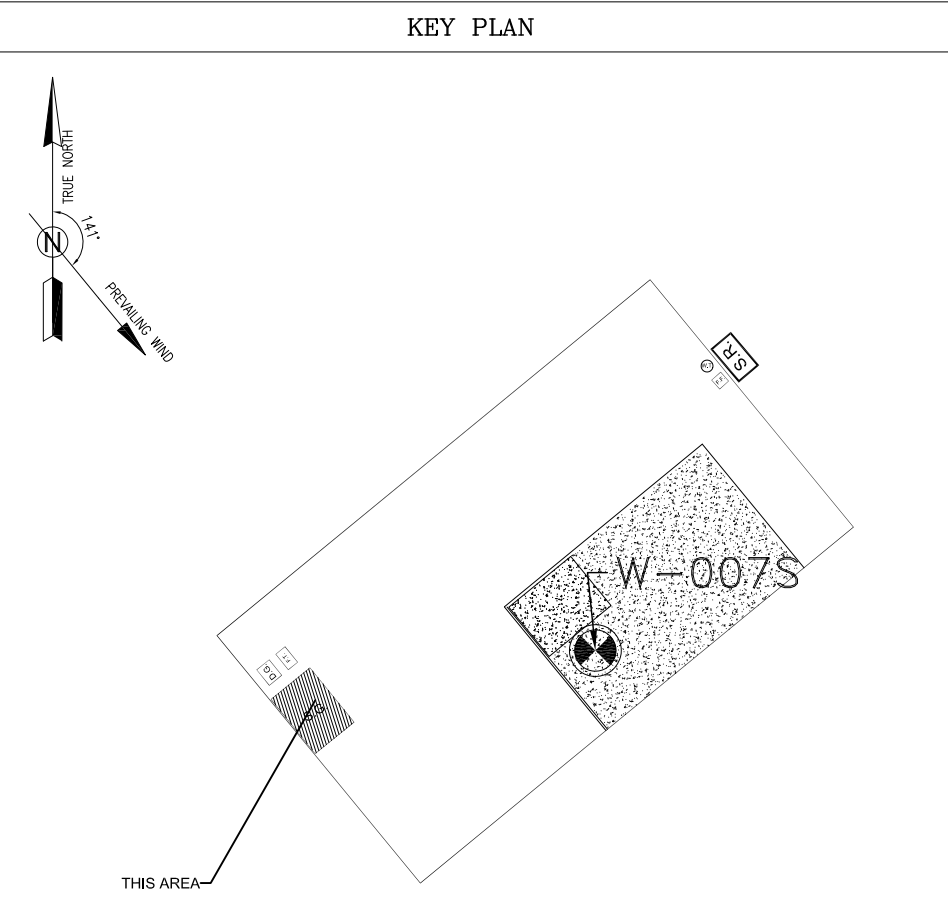


REV.	DESCRIPTION	BY	DATE	BY	DATE
D03	MAR.2023	IPA	R.BERLOUIE	M.PAKHARIAN	M.Mehrshad
D02	SEP.2022	IPC	R.BERLOUIE	M.PAKHARIAN	M.Mehrshad
D01	MAY.2022	IPC	R.BERLOUIE	M.PAKHARIAN	M.Mehrshad
D00	MAR.2022	IPC	R.BERLOUIE	M.PAKHARIAN	M.Mehrshad

PROJECT NAME:		BINAK OILFIELD DEVELOPMENT/SUB-SURFACE WORK PACKAGES W007S WHF & EXTENSION OF BINAK B/C			
PROJECT NO.:		971020			
EPC CONTRACTOR:		EPD/EPC CONTRACTOR (GC):			
 HIRGAN ENERGY - DESIGN & INSPECTION COMPANIES				 PETROIRAN DEVELOPMENT COMPANY	
DRAWING TITLE:					
ARCHITECTURAL DRAWING FOR SWITCHGEAR BUILDING OF WELL PADS - W007S WALL SECTION AND DETAILS					
SCALE	SIZE	DRAWING NO.		SHEET NO.	REV.
AS SHOWN	A1	BK-W007S-PEDCO-110-AR-DW-0003		06 OF 07	D03

DATE	SCALE	DRAWING BY	CHECKED BY	PROJECT ENG.
NO CONSTRUCTION PERMITTED UNLESS DRAWING APPROVED				
APPROVED FOR CONSTRUCTION		BY:	DATE:	
BUDGET REP	LOCATION	SIZE CLASS	SERIAL NO.	SHEET REVISION
AS SHOWN	A1	BK-W007S-PEDCO-110-AR-DW-0003	06 OF 07	D03

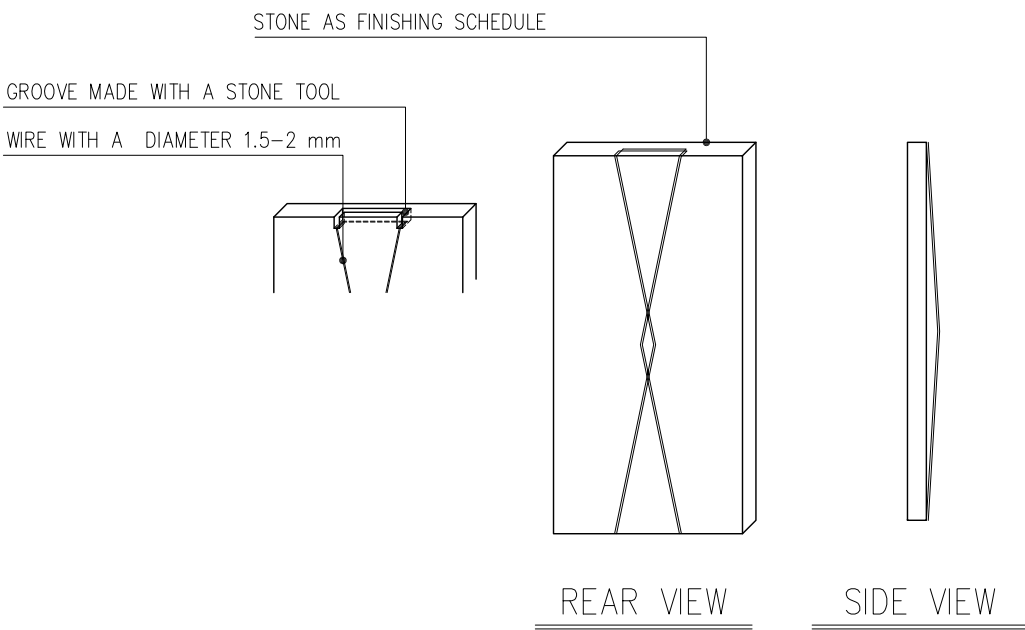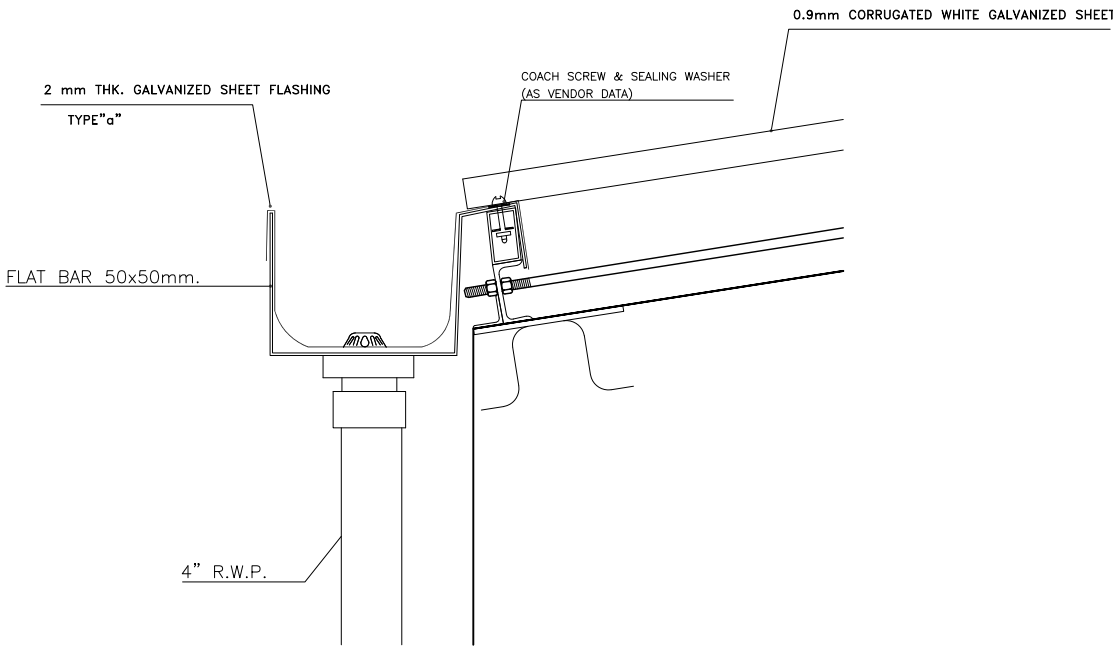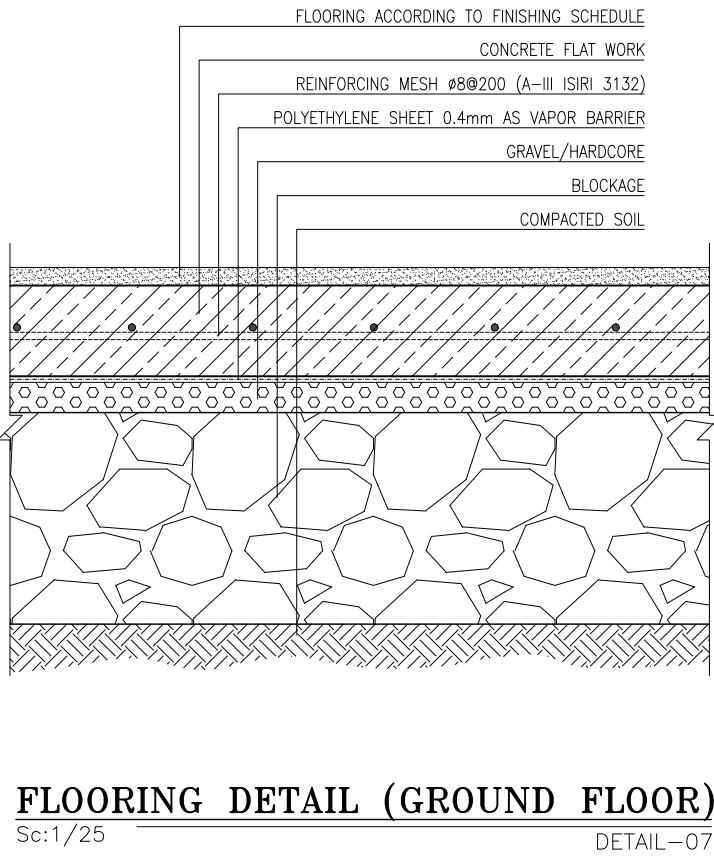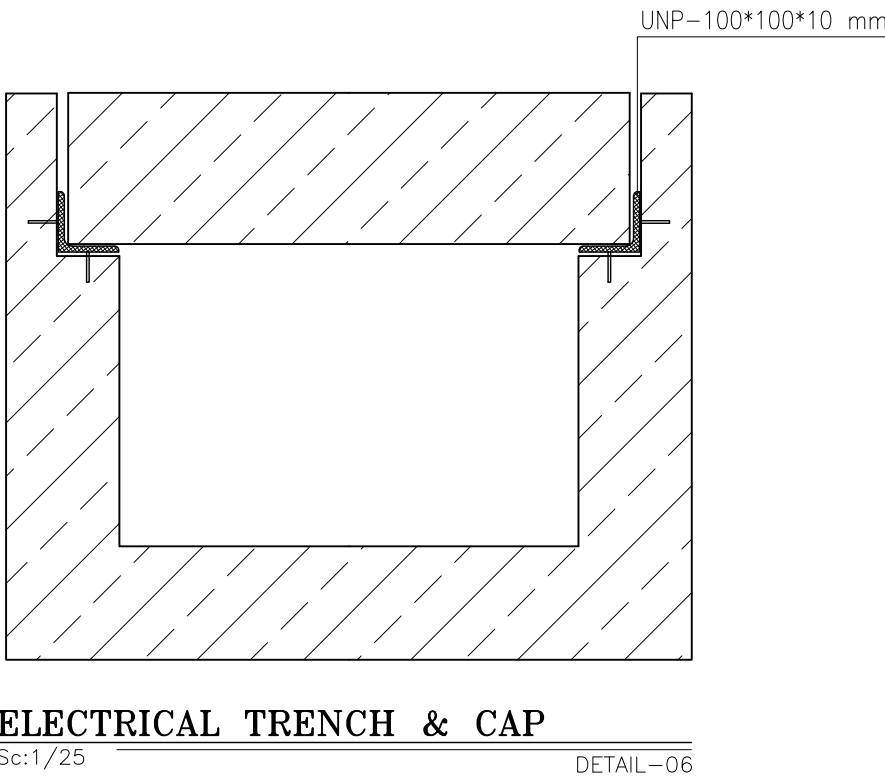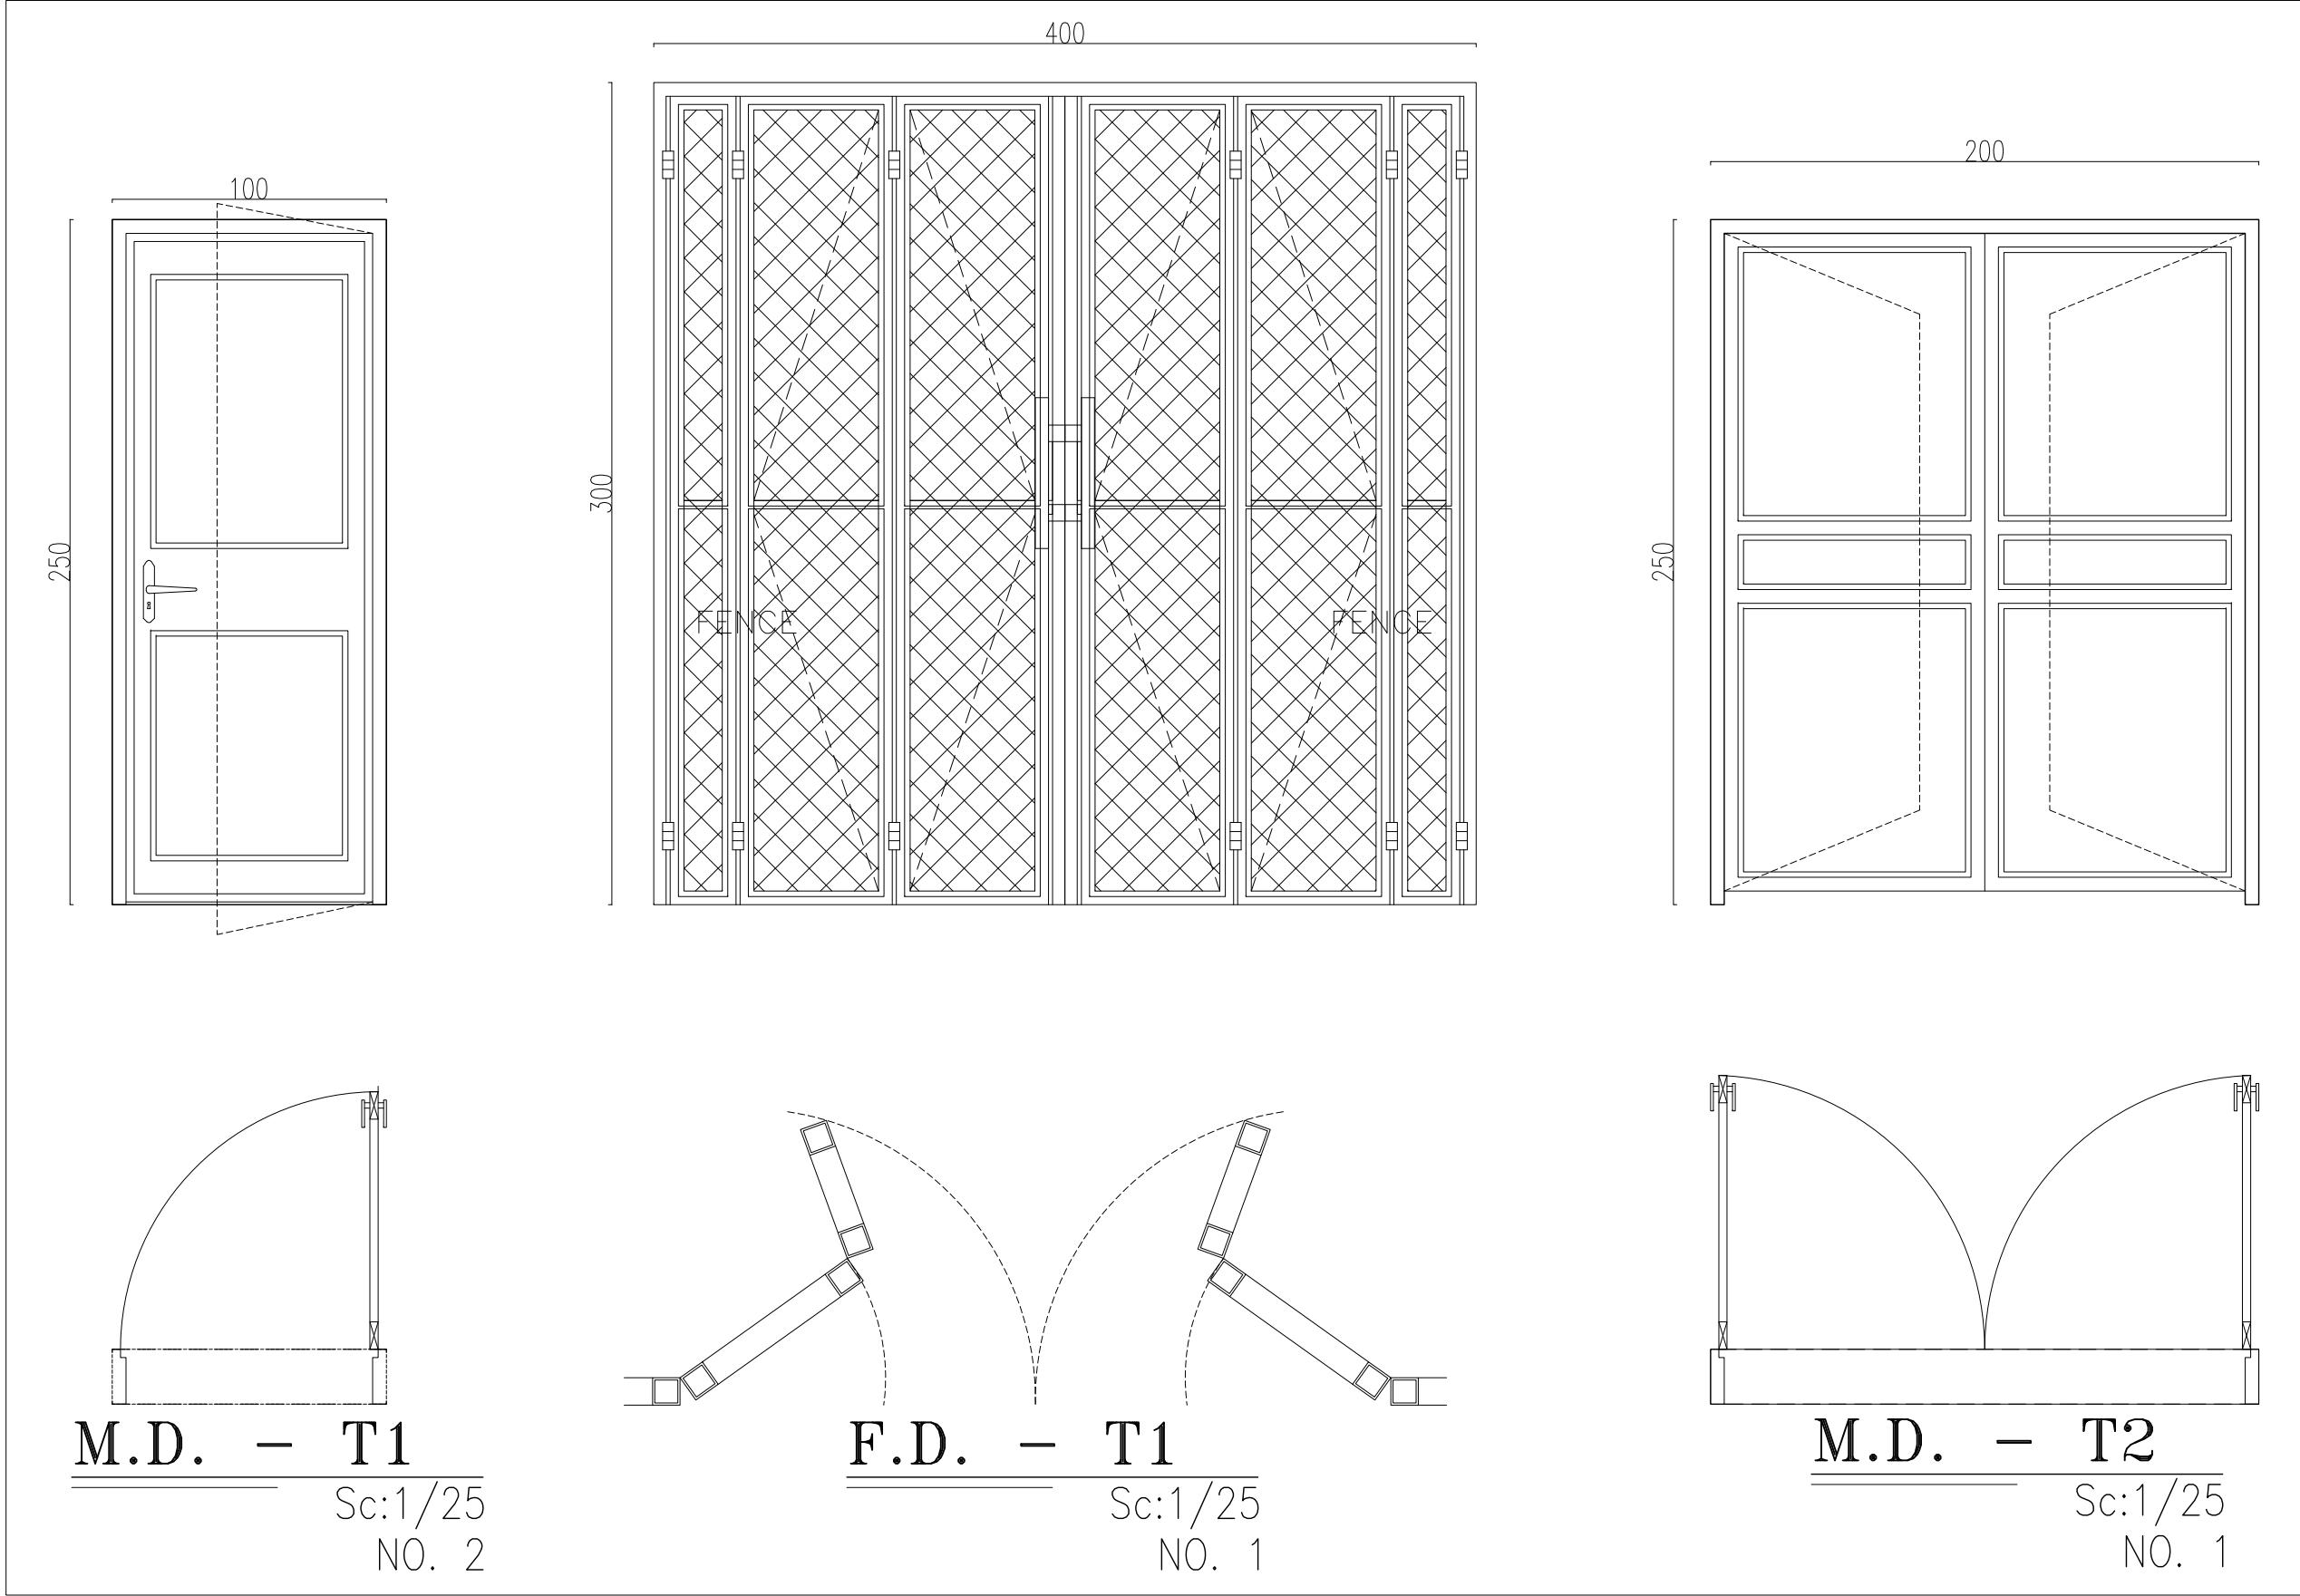

DOOR TYPES

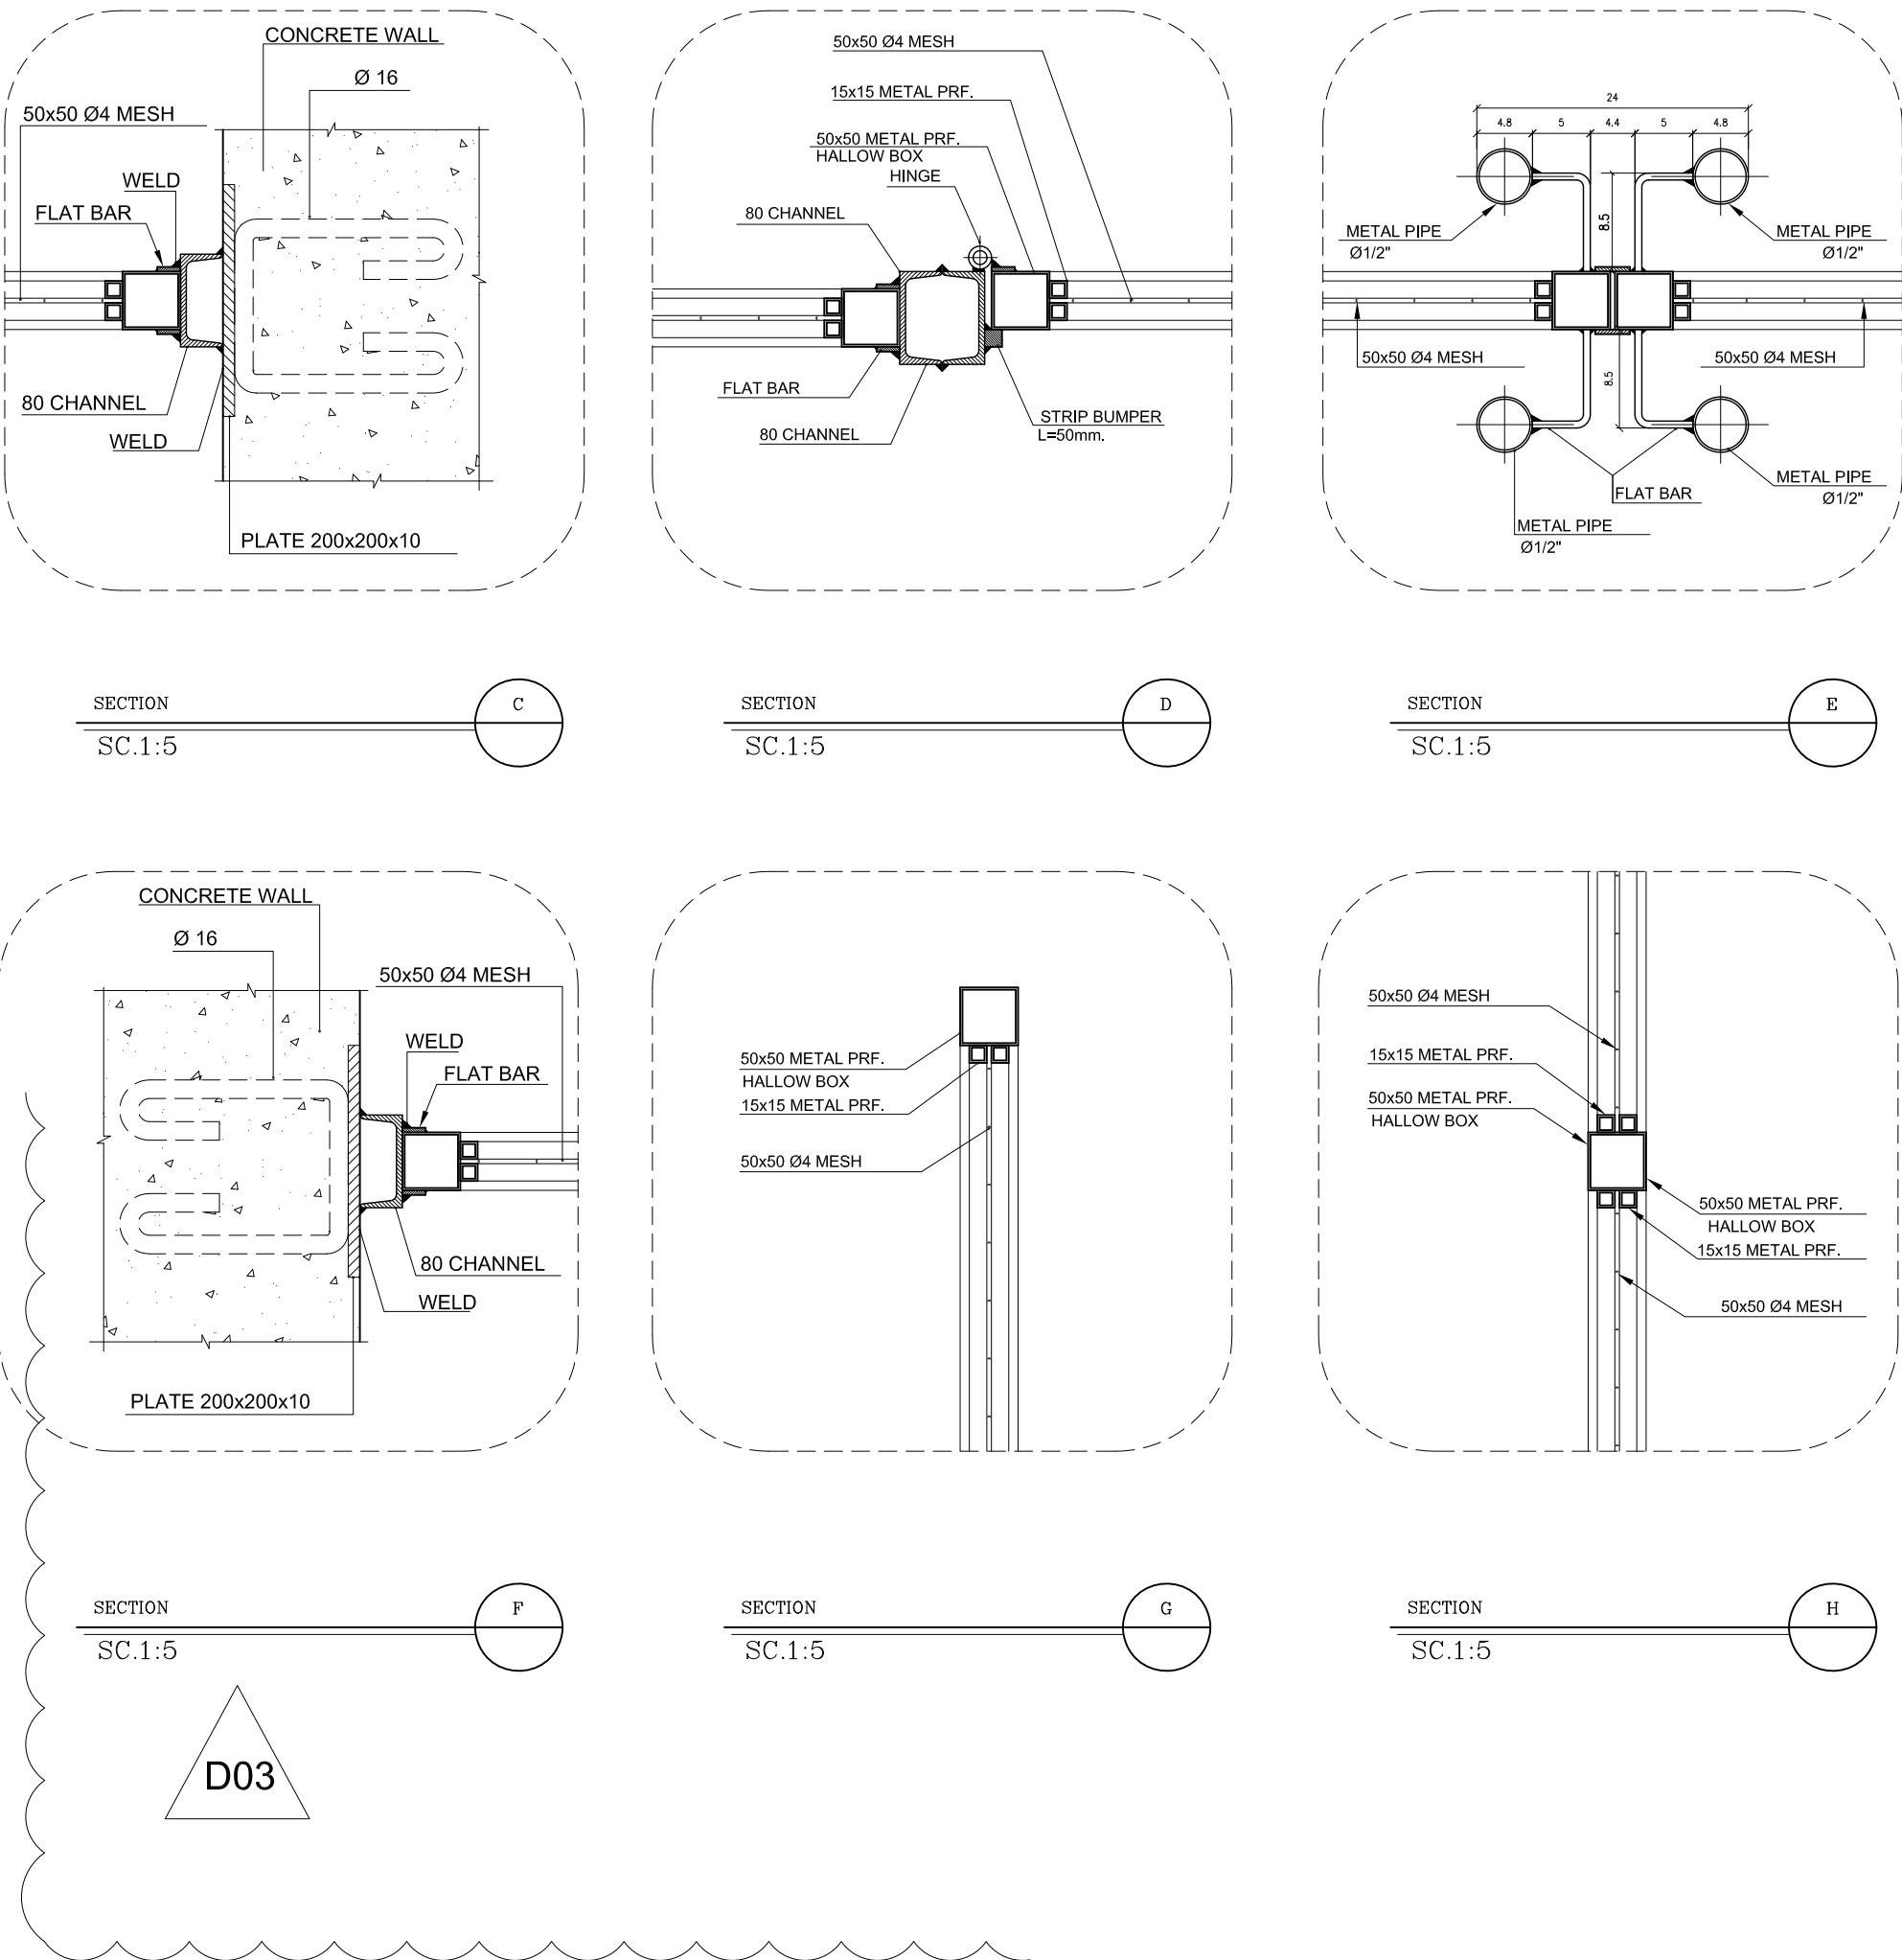


- NOTES**
- 1- DIMENSIONS ARE IN "mm" AND ELEVATIONS IN "m" UNLESS SPECIFIED .
 - 2- ALL DIMENSIONS AND ELEVATIONS SHALL BE CHECKED BY THE CONTRACTOR PRIOR TO CONSTRUCTION.
 - 3- CONTRACTOR SHALL COMPARE ALL ARCHITECTURAL, MECHANICAL, ELECTRICAL, PIPING AND STRUCTURAL DRAWINGS AND IN CASE OF ANY CONFLICTS OR DISCREPANCY, INFORM THE ENGINEER.
 - 4- SLAB ON GRADE SHALL BE CONSTRUCTED AFTER EXECUTION OF CABLE TRENCH & EQUIPMENTS FOUNDATION.
 - 5- ALL MATERIALS ARE SELECTED FROM THE HIGHEST QUALITY AND SHALL BE APPROVED BY THE CLIENT.
 - 6- FOR COORDINATE REFER TO FINISH GRADING DOCUMENTS.
 - 7) REFERENCE COORDINATES E=1000.000 , N=1000.000 REFER TO X=437425 , Y=3290543 UTM.
 - 8) FINISH GRADING LEVEL (W007S) ELEVATION :
+26 m (GLOBAL) = ±0.00 (LOCAL)
 - 9) ALL HVAC OPENINGS SIZE, SPECS, AND POSITION WILL BE FINALISED BASED ON HVAC SYSTEM DESIGN.
 - 10) BATTERY ROOM EQUIPMENT SHALL BE BLAST-PROOF (EXP)
 - 11) DRAWINGS MUST BE IN CONJUNCTION WITH STRUCTURAL, ELECTRICAL, INSTRUMENT AND OTHER DRAWINGS.
 - 12) ALL DOORS SHALL BE THERMAL BREAK AND FIRE RESISTANT.
 - 13) RAINWATER MUST BE CONNECTED TO THE SURFACE WATER NETWORK.
 - 14) BATTERY ROOM EQUIPMENT MUST BE BLAST-PROOF.(ACCORDING TO SCOPE OF WORK)

- LEGEND**
- BRICK WALL
 - REINFORCED CONCRETE
ACCORDING TO STR. DWG
 - BLOCKAGE
 - LEAN CONCRETE

- F.F.L. FINISHED FLOOR B.O.C. BOTTOM OF CAGE
F.G.L. TOP OF WALL T.O.C. TOP OF CAGE
T.O.Wa. TOP OF WALKWAY R.H.P. ROOF HIGH POINT
T.O.P. TOP OF PARAPET R.L.P. ROOF LOW POINT
T.O.Fou. TOP OF FOUNDATION
B.O.Pit. BOTTOM OF PIT
B.O.O. BOTTOM OF OPENING
T.O.D. TOP OF DOOR
T.O.R. TOP OF ROOF
T.O.W. FINISHED GRADING LEVEL
B.O.O. BOTTOM OF OPENING

REFERENCE DRAWING	DRG. No.
STANDARD DRAWING FOR ARCHITECTURAL DETAILS	BK-GNRL-PEDCO-000-AR-DW-0001
STANDARD DETAILS FOR LADDER & SAFETY CAGE	BK-GNRL-PEDCO-000-ST-DW-0009
PLOT PLAN DRAWING - W007S	BK-W007S-PEDCO-110-P1-PY-0002
FOUNDATION DRAWING FOR SWITCHGEAR BUILDING FOR WELL PADS - W007S	BK-W007S-PEDCO-110-ST-DW-0010
STRUCTURAL DRAWING FOR SWITCHGEAR BUILDING FOR WELL PADS - W007S	BK-W007S-PEDCO-110-ST-DW-0011
GENERAL CIVIL LAYOUT - W007S	BK-W007S-PEDCO-110-CV-PY-0001
HVAC SYSTEM LAYOUT FOR SWITCHGEAR BUILDING - W007S	BK-W007S-PEDCO-110-HV-PY-0001
PLUMBING & SEWAGE PIPING LAYOUT FOR SWITCHGEAR BUILDING - W007S	BK-W007S-PEDCO-110-HV-PY-0003

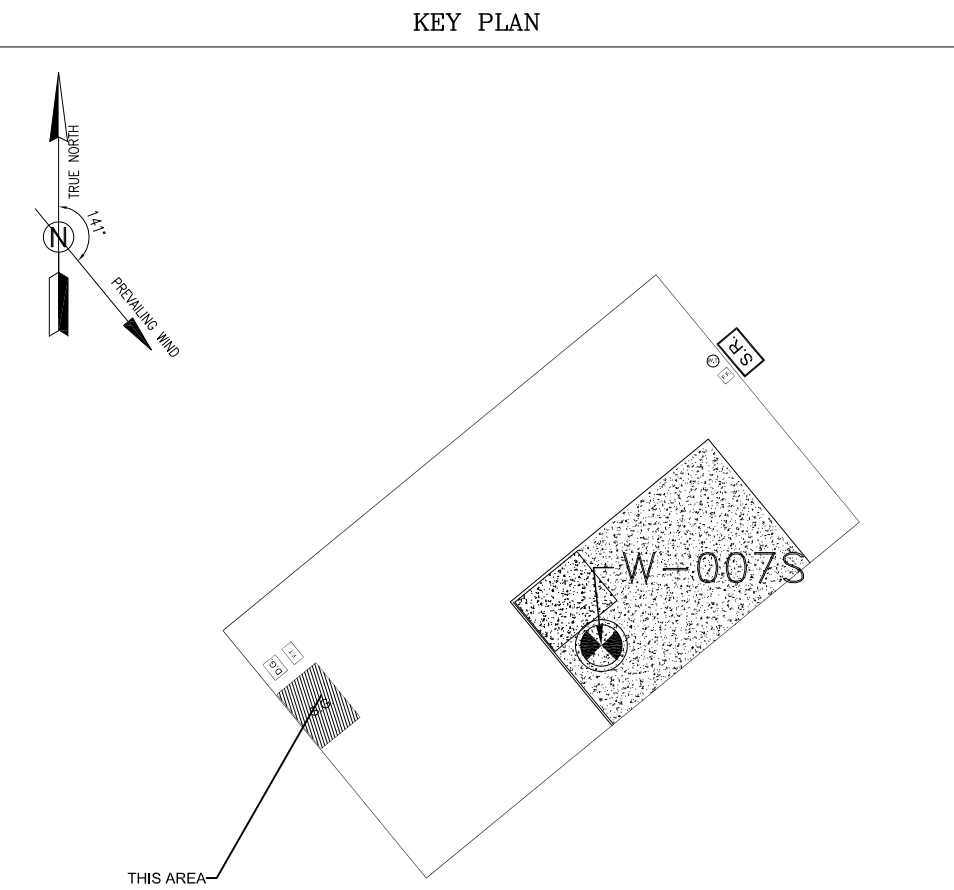

D03	MAR.2023	IPA	R.BERLOUIE	M.PAKHARIAN	M.Mehrshad	***									
D02	SEP.2022	IFC	R.BERLOUIE	M.PAKHARIAN	M.Mehrshad	***	***	*****	***	*****	***	07	*****		
D01	MAY.2022	IFC	R.BERLOUIE	M.PAKHARIAN	M.Mehrshad	***	REV.	DESCRIPTION	BY	DATE	BY	DATE			
D00	MAR.2022	IFC	R.BERLOUIE	M.PAKHARIAN	M.Mehrshad	***			CHECKED		REV. APPR.				
REV.	DATE	P.O.I.S	PREP.	CHK.	APP.	AUT.	اصل و کلیه نسخ این نقشه و حق امتیاز متعلق به شرکت ملی مناطق نفت خیز جنوب میباشند.								
PROJECT NAME:								THE ORIGINAL AND ALL COPIES OF THIS DRAWING TOGETHER WITH THE COPYRIGHT THEREIN ARE THE SOLE PROPERTY OF N.I.S.O.C./ FIELDS							
PROJECT NO.:								971020							
EPC CONTRACTOR:			EPD/EPC CONTRACTOR (GC):					BINAK OILFIELD DEVELOPMENT SUB-SURFACE WORK PACKAGES							
							W007S WHF & EXTENSION OF BINAK B/C								
							DATE	SCALE	DRAWING BY	CHECKED BY	PROJECT ENG.				
DRAWING TITLE:							NO CONSTRUCTION PERMITTED UNLESS DRAWING APPROVED								
ARCHITECTURAL DRAWING FOR SWITCHGEAR BUILDING OF WELL PADS - W007S							APPROVED FOR CONSTRUCTION								
DETAILS							BY:		DATE:						
SCALE	SIZE	DRAWING NO.			SHEET NO.	REV.	BUDGET REF.	LOCATION	SIZE	CLASS	SERIAL NO.	SHEET	REVISION		
AS SHOWN	A1	BK-W007S-PEDCO-110-AR-DW-0003			07 OF 07	D03	053-073-9184	F	4	B	708044	07 OF 07	D03		