


V-2103

GAS COMPRESSION DISCHARGE DRUM

DIMENSION (ID X TL-TL): 900 X 3000 mm
DESIGN TEMP. : 130 °C
DESIGN PRESS. : PV/62 barg
TRM LINE : TRM-V-2103-051-FN05-P1
TRM LINE : TRM-V-2103-0513-FS00-NP

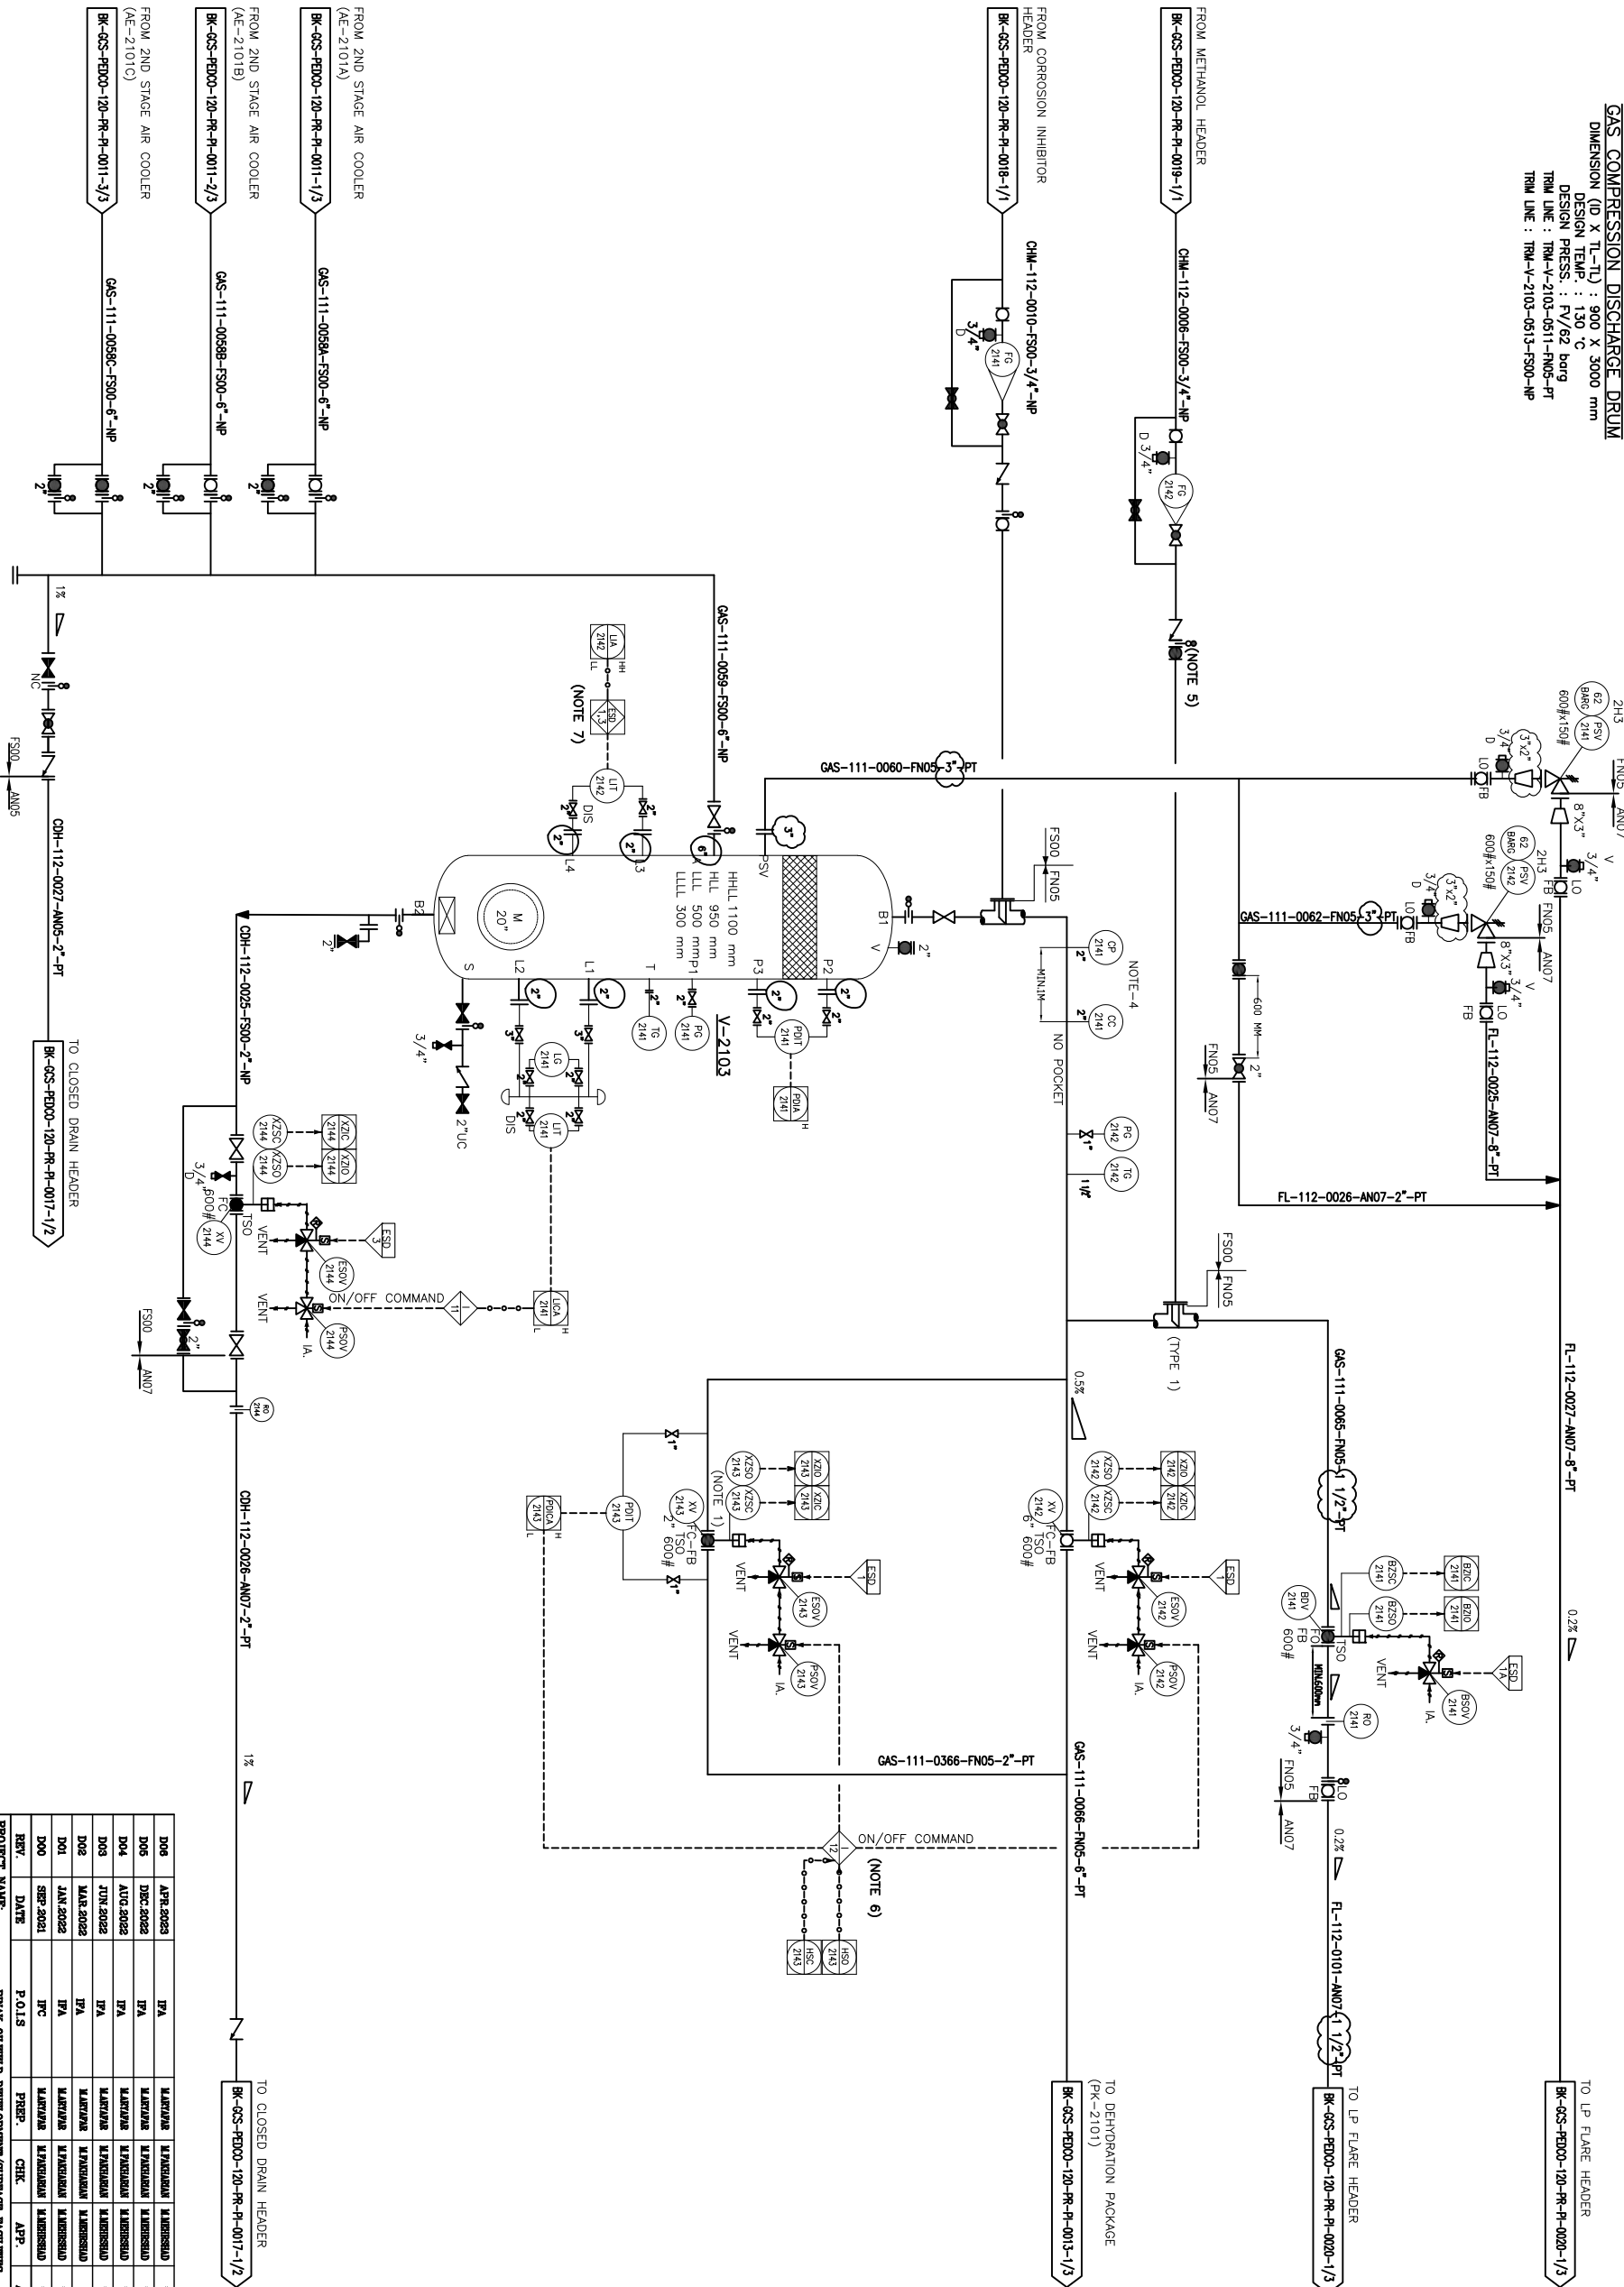


NOTES

- 1- DELETED.
- 2- DELETED.
- 3- DELETED.
- 4- ONE PORTABLE WATER FOR CORROSION PROGES TO BE PROVIDE PER SITE TO RECOVER MONITOR CORROSION DATA.
- 5- BEFORE IN CASE OF COLD DEPRESSURIZING, MANUAL VALVE WILL BE OPEN BY OPERATOR.
- 6- OPEN/CLOSE COMMAND BY OPERATOR WILL BE IMPLEMENTED BY EQUALIZING LOGIC DURING START UP.
- 7- ESD LEVEL 1 FOR HH AND 3 FOR LL LIQUID LEVEL.
- 8- PARTIAL STROK DENCE TO BE CONSIDERED FOR ALL ESDV'S ACTIVATED BY ESD 1/0.

LEGEND


V: BY COOLER VENDOR

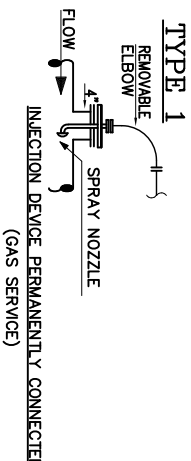

REFERENCE DRAWING	DRG. No.
Process Flow Diagram	BK-GCS-FED00-120-PR-P1-0001
Symbol & Legend For PFD and P&ID	BK-GCS-FED00-120-PR-P1-0001

KEY PLAN

TYPE 1

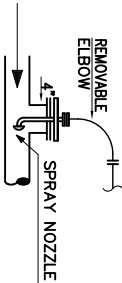

INJECTION DEVICE PERMANENTLY CONNECTED (GAS SERVICE)

REV.	DESCRIPTION	BY	DATE	REV.	DESCRIPTION	BY	DATE
001	INITIAL DESIGN	001	001	001	INITIAL DESIGN	001	001
002	REVISION	002	002	002	REVISION	002	002
003	REVISION	003	003	003	REVISION	003	003
004	REVISION	004	004	004	REVISION	004	004
100	REVISION	100	100	100	REVISION	100	100

THE ORIGINAL AND ALL COPIES OF THIS DRAWING TOGETHER WITH THE COPYRIGHT THEREIN ARE THE SOLE PROPERTY OF N.I.S.O.C./ FIELDS

DATE	SCALE	DRAWING BY	CHECKED BY	PROJECT ENG.

NO CONSTRUCTION PERMITTED UNLESS DRAWING APPROVED						
APPROVED FOR CONSTRUCTION			BY:		DATE:	
BUDGET REF.	LOCATION	SIZE	CLASS	SERIAL NO.	SHEET	REVISION
068-073-0104	F	2	A	708790	1 OF 1	006