


V=2205
FUEL GAS K.O. DRUM
DIMENSION (D X TL-TL) : 438 X 2950 mm
DESIGN TEMP. : 85 °C
DESIGN PRESS. : FV/9 barg
TRM UNE : TRM-V-2205-0504-AN07-PT

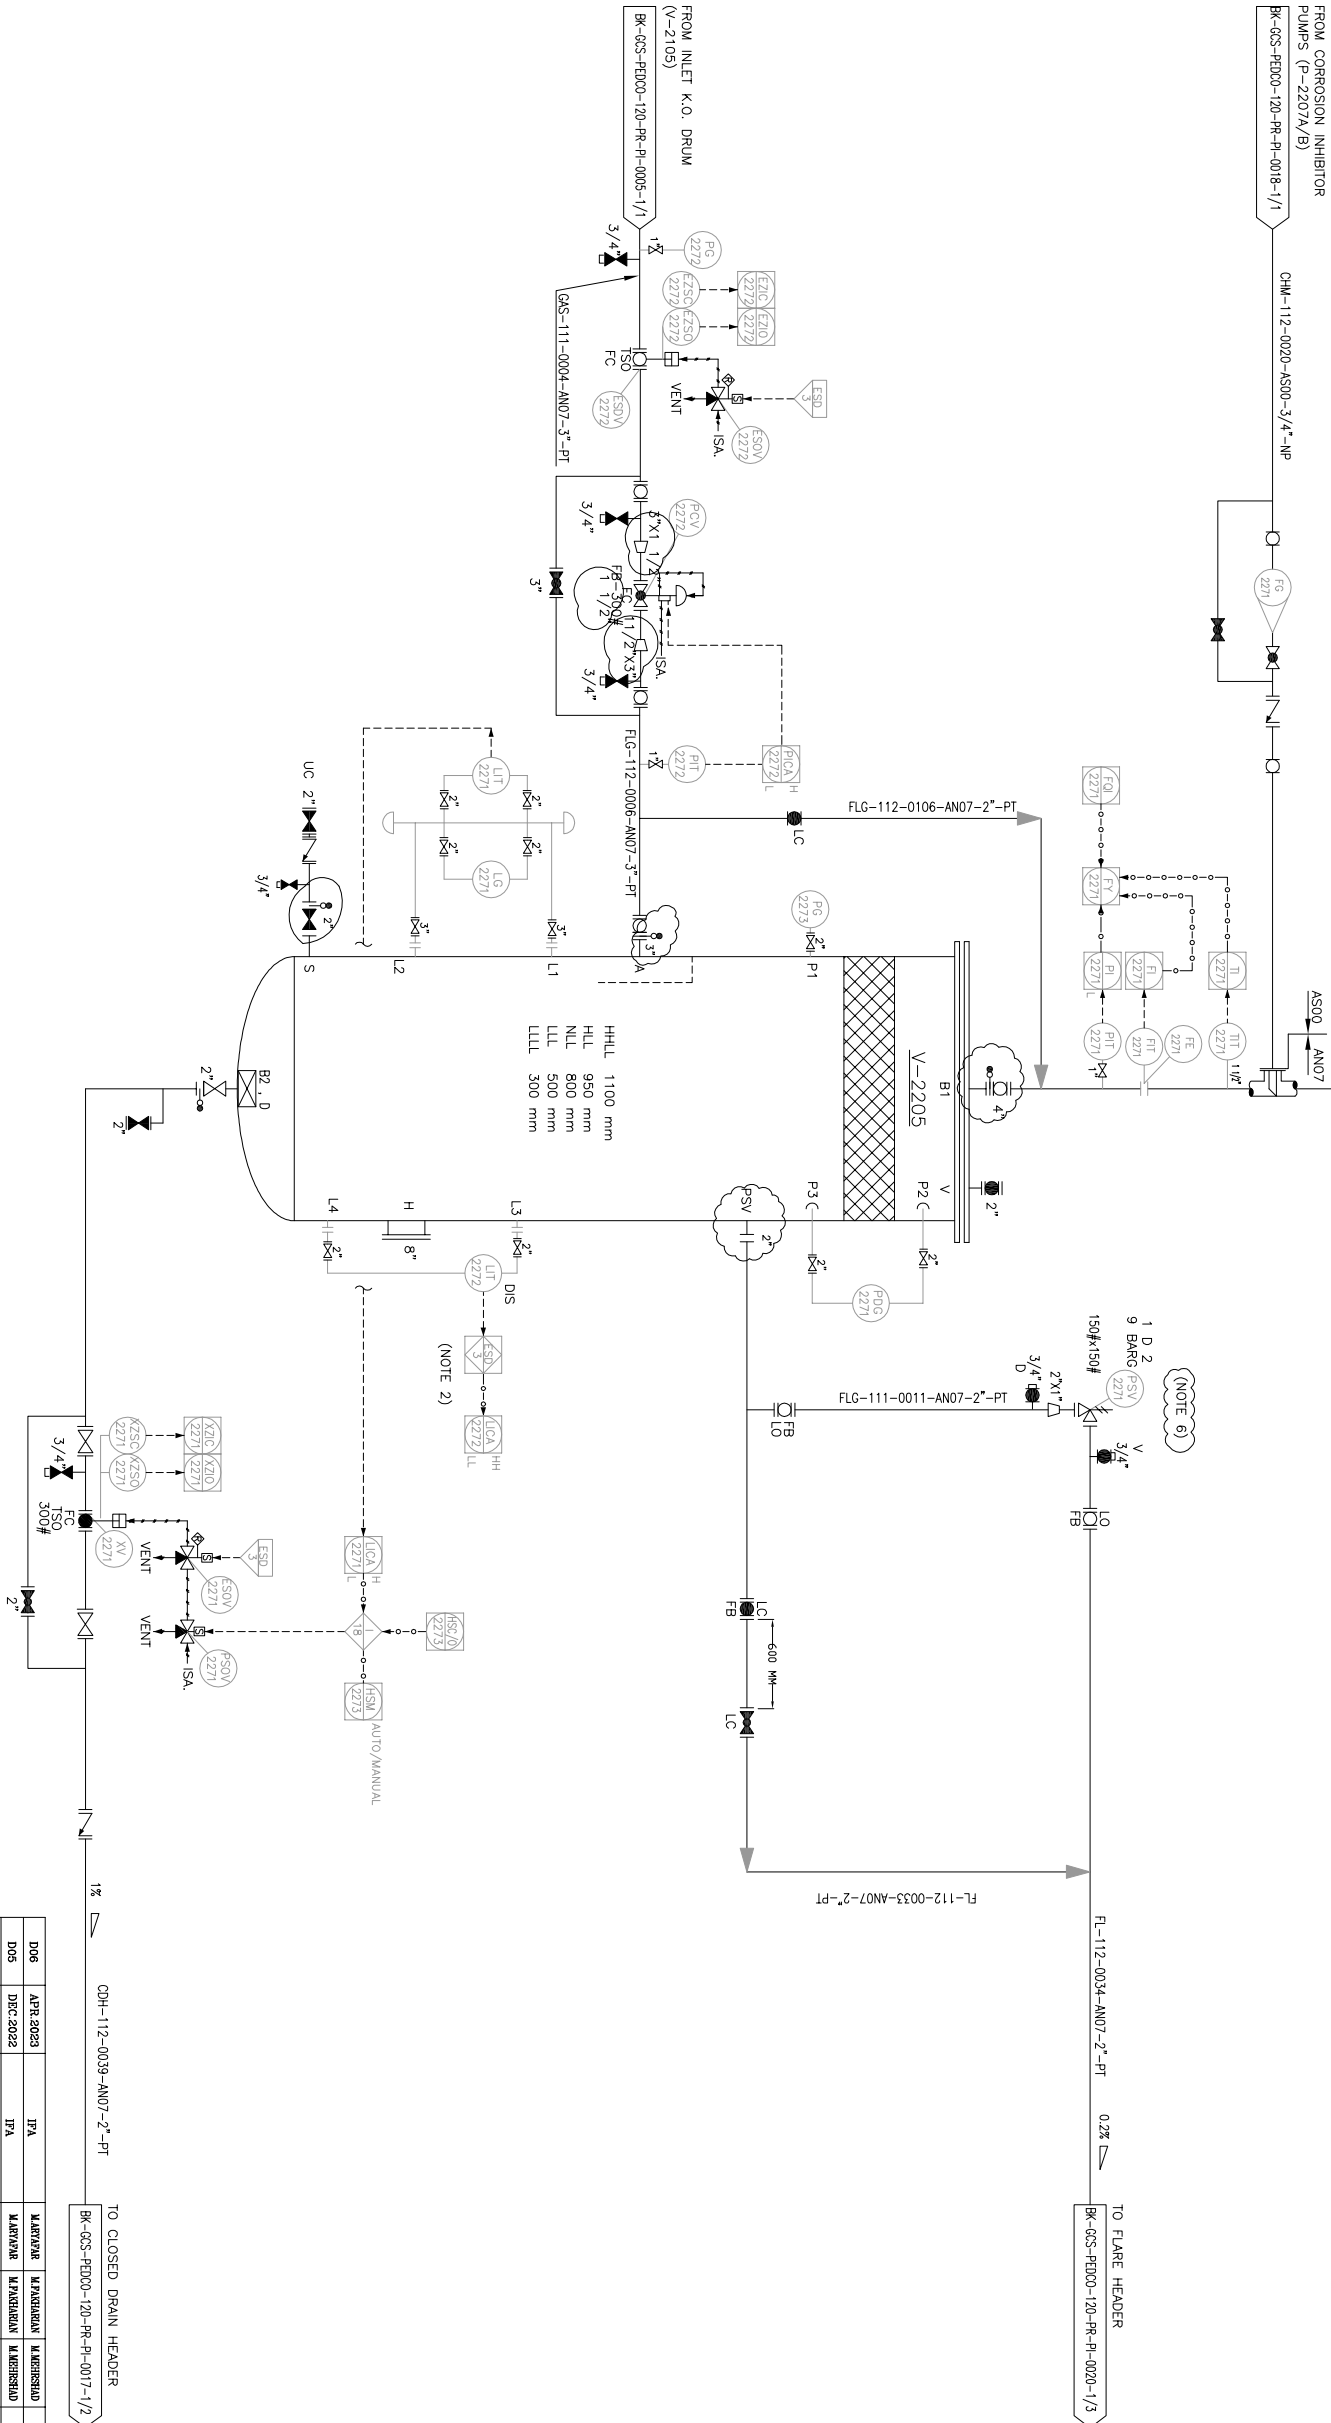

- NOTES
- 1-ONE PORTABLE METER FOR CORROSION PROBES TO BE PROVIDE PER SITE TO RECOVERY MONITOR CORROSION DATA.
 - 2- ESD LEVEL 3 FOR HH & LL ALARM LIQUID LEVEL.
 - 3-CONTROL VALVE SIZING WILL BE FINALIZED BY VENDOR.
 - 4-PARTIAL STROKE DEVICE TO BE CONSIDERED FOR ALL ESDV'S ACTIVATED BY ESD LEVEL 3.
 - 5-LINE SHALL BE EXPANDED TO MINIMUM 4" FOE CC INSTALLATION.
 - 6-2*100% PSV'S ONE DUTY AND ONE STANDBY.

GENERAL NOTE

LEGEND

REFERENCE DRAWING	DRG. No.
Utility Flow Diagram	BK-GCS-PEDCO-120-PR-PI-UT-0001
Symbol & Legend for PFD & P&ID	BK-GCS-PEDCO-120-PR-PI-0001

KEY PLAN

REV.	DESCRIPTION	BY	DATE	CHECKED	REV.	DATE
006	DATE					
005	DATE					
004	DATE					
003	DATE					
002	DATE					
001	DATE					
000	DATE					

این سند و کلیه محتوای آن به عنوان سند فنی و حقوقی محسوب می شود و هر گونه کپی برداری از آن بدون مجوز کتبی شرکت نایس.ا.ج. ممنوع است.

THE ORIGINAL AND ALL COPIES OF THIS DRAWING TOGETHER WITH THE COPYRIGHT THEREIN ARE THE SOLE PROPERTY OF N.I.S.O.C./ FIELDS

EPC CONTRACTOR:		EPC CONTRACTOR (GC):		BINAK OILFIELD DEVELOPMENT SURFACE FACILITIES GAS COMPRESSOR STATION						
										
HIRGAN ENERGY - DESIGN & INSPECTION COMPANIES		PEDCO								
DRAWING TITLE:				NO CONSTRUCTION PERMITTED UNLESS DRAWING APPROVED						
P&ID - FUEL GAS SYSTEM				BY: DATE:						
SCALE	SIZE	DRAWING NO.	SHEET NO.	BUDGET REF	LOCATION	SIZE CLASS	SERIAL NO.	SHEET REVISION		
NS	A3	BK-GCS-PEDCO-120-PR-PI-0022	1 OF 1	006	P	2	A	708800	1 OF 1	008

(VENDOR TITLE BLOCK)**