


PR-1002
EXISTING GAS PIG RECEIVER


TRIM LINE : TRM-PR-1002-0004-AN07-PT

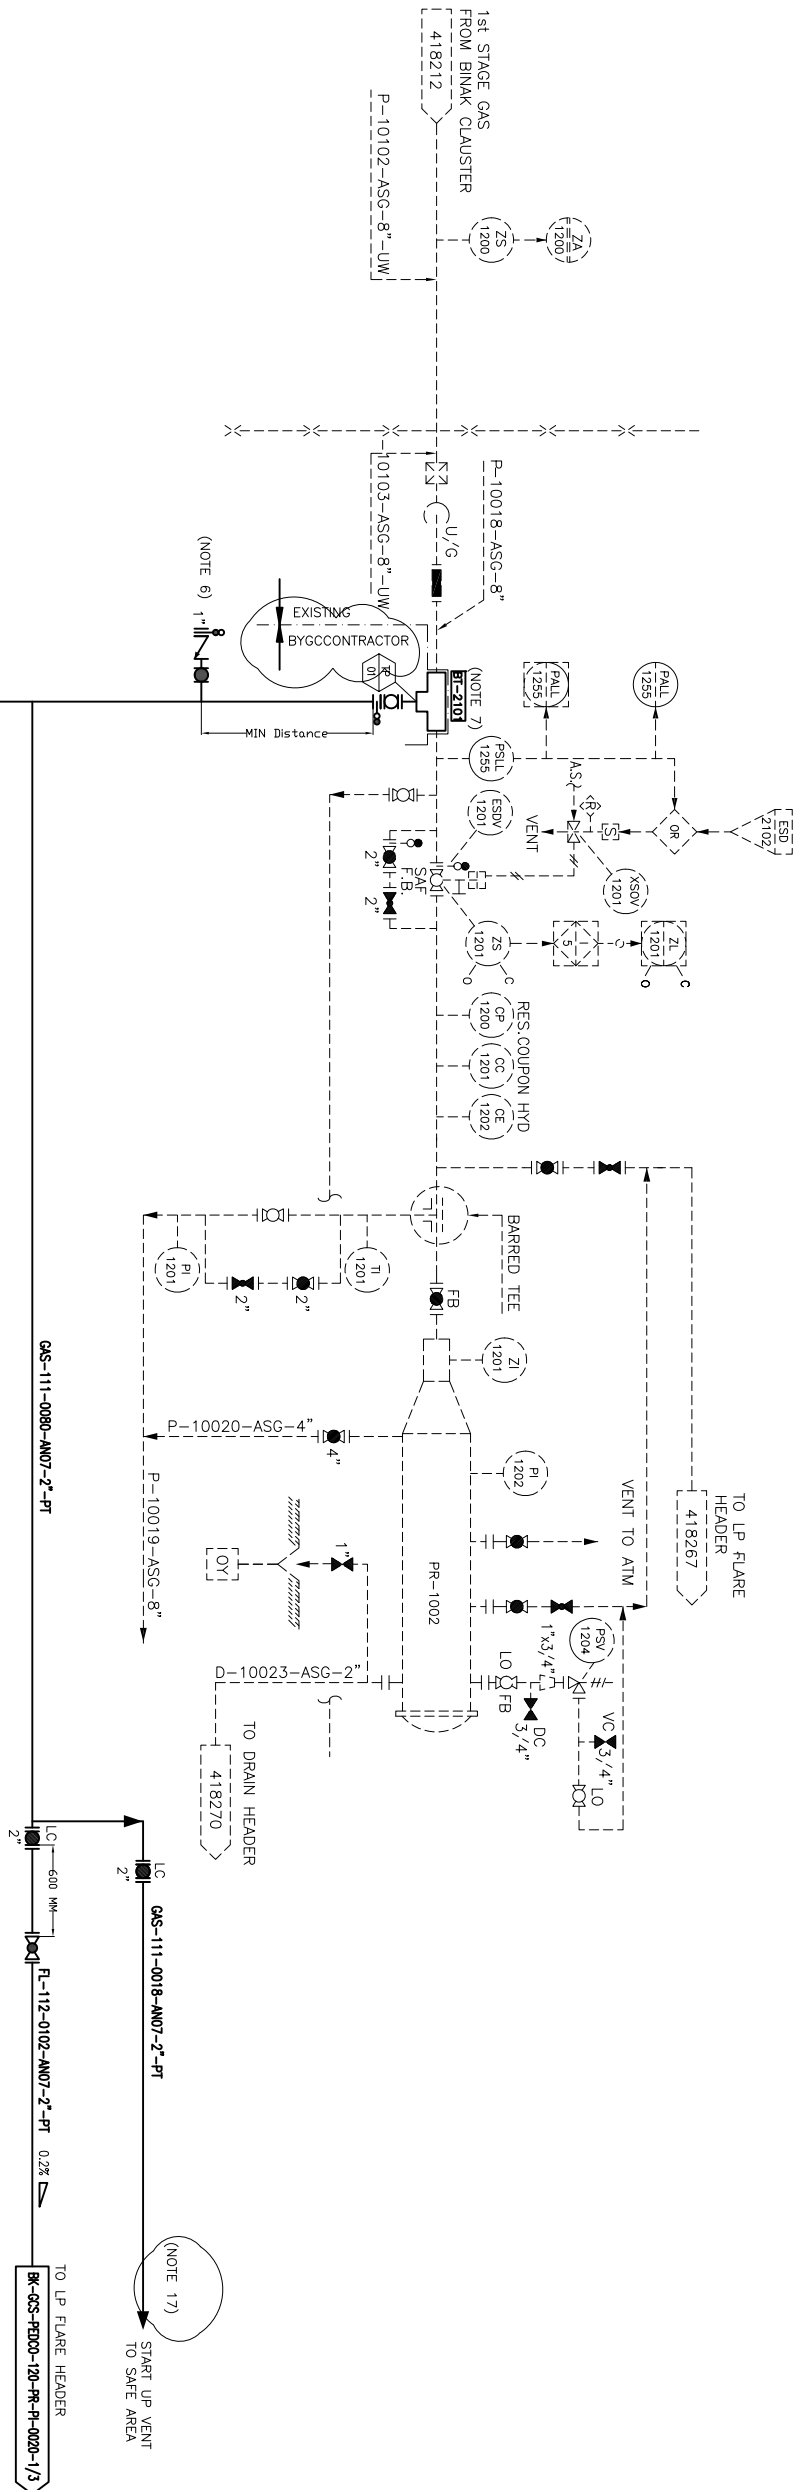

NOTES

- 1- THE ESD VALVE SHOULD WORK AS FIRE ZONE ISOLATION DURING EMERGENCY CONDITION.
- 2- DELETED.
- 3- DELETED.
- 4- DELETED.
- 5- DELETED.
- 6- PURGE CONNECTION.
- 7- TE IN IS TAKEN FROM EXISTING BINAQ PIPELINE.
- 8- DELETED.
- 9- DELETED.
- 10- DELETED.
- 11- DELETED.
- 12- FLOW QUANTITY WILL BE COMPENSATED BY TT AND PT.
- 13- ONE PORTABLE METER FOR CORROSION PROBES TO BE PROVIDE PER SITE TO RECOVERY MONITOR CORROSION DATA.
- 14- PARTIAL STROK DEVICE TO BE CONSIDERED FOR ALL ESD0'S ACTIVATED BY ESD 1,0.
- 15- DEFINE IN OPERATING PROCEDURE THAT OPERATOR SHOULD CHANGE CAPACITY OF COMPRESSORS ACCORDING TO INLET FLOW OF GAS FROM BINAQ AND GOLAHARI CLUSTERS
- 16- CONTROL VALVE SIZING WILL BE FINALLIZED BY VENDOR.
- 17- THIS LINE IS CONSIDERED FOR PURGE GOLAHARI FLOW LINE AND IF PURGING DONE WITH INERT GAS THIS LINE IS USED.

LEGEND

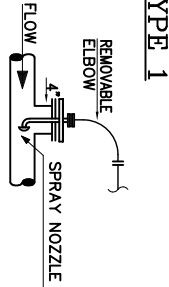

INJECTION DEVICE PERMANENTLY CONNECTED
(GAS SERVICE)

REFERENCE DRAWING	DRG. No.
Process Flow Diagram	BK-GCS-PBDO-120-PR-PP-0001
Symbol & Legend For PFD and P&ID	BK-GCS-PBDO-120-PR-PI-0001

KEY PLAN

DO6	APR.2023	APC	MAHDIYAR	MAHDIYAR	MAHDIYAR	***
DO6	DEC.2022	TPA	MAHDIYAR	MAHDIYAR	MAHDIYAR	***
DO4	AUG.2022	TPA	MAHDIYAR	MAHDIYAR	MAHDIYAR	***
DO3	JUN.2022	TPA	MAHDIYAR	MAHDIYAR	MAHDIYAR	***
DO2	MAR.2022	TPA	MAHDIYAR	MAHDIYAR	MAHDIYAR	***
DO1	JAN.2022	TPA	MAHDIYAR	MAHDIYAR	MAHDIYAR	***
DO0	SEP.2021	TPC	MAHDIYAR	MAHDIYAR	MAHDIYAR	***
REV.	DATE	P.O.I.S	PREP.	CHK.	APP.	AUT.
PROJECT NAME: BINAQ OUTFIELD DEVELOPMENT/SURFACE FACILITIES						
PROJECT NO.: 971020						
EPC CONTRACTOR:			EPC/EPC CONTRACTOR (GC):			
BINAQ ENERGY - DESIGN & INSPECTION COMPANIES			PETROLIAN DEVELOPMENT COMPANY			

این و کلیه نسخ این خط و حق انحصاری مندرج به شرکت ملی مناطق نفت خیز جنوب می باشد
THE ORIGINAL AND ALL COPIES OF THIS DRAWING TOGETHER WITH THE COPYRIGHT THEREIN ARE THE SOLE PROPERTY OF N.I.S.O.C./ FIELDS

B.P. CONTRACTOR:		BINAQ OUTFIELD DEVELOPMENT SURFACE FACILITIES GAS COMPRESSOR STATION									
BINAQ ENERGY - DESIGN & INSPECTION COMPANIES		BINAQ OUTFIELD DEVELOPMENT SURFACE FACILITIES GAS COMPRESSOR STATION									
DRAWING TITLE:		NO CONSTRUCTION PERMITTED UNLESS DRAWING APPROVED									
P&ID - GAS COMPRESSION INLET GAS PIPELINE (BINAQ)		APPROVED FOR CONSTRUCTION BY: DATE:									
SCALE	SIZE	DRAWING NO.	SHEET NO.	REV.	BUDGET REF.	LOCATION	SIZE	CLASS	SERIAL NO.	SHEET	REVISION
NS	AS	BK-003-TRDCC-120-PR-FI-0003	1 OF 1	D06	BKS-073-0104	F	2	A	706780	1 OF 1	D06

(VENDOR TITLE BLOCK)**

FROM CORROSION INHIBITOR
HEADER

BK-GCS-PBDO-120-PR-PI-0016-1/1

CHM-112-0001-AS00-3/4"-NP

