


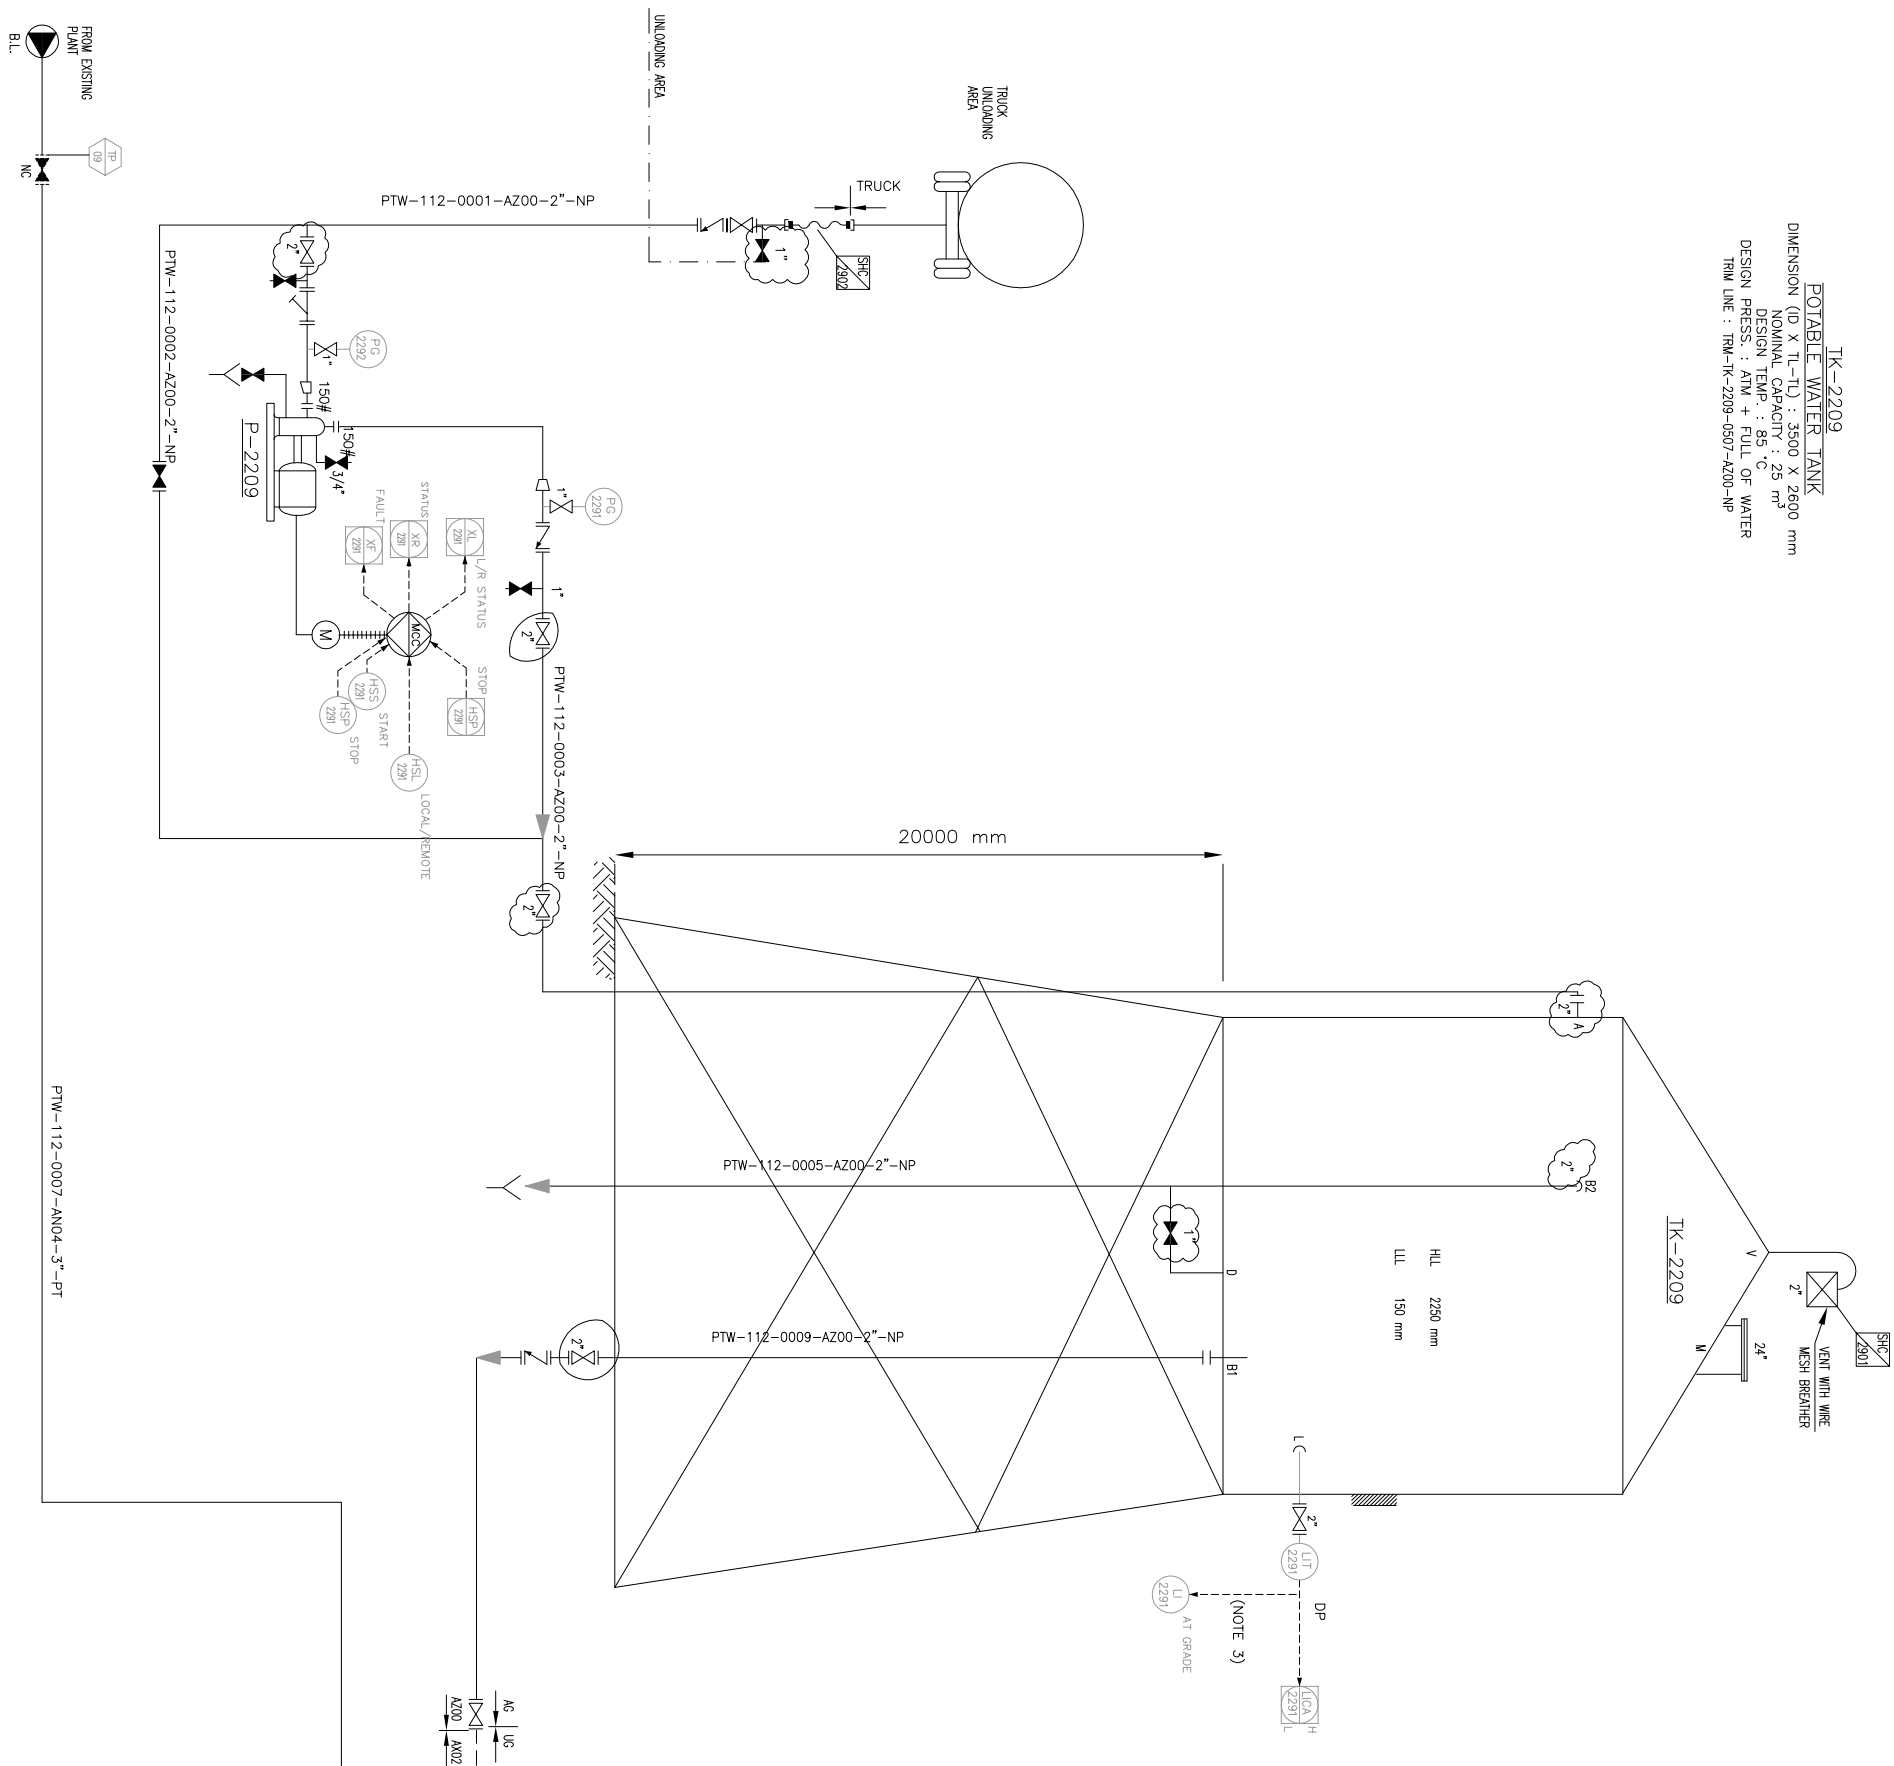

PFC CONTRACTOR:										BPD/PFC CONTRACTOR (GC):																																																	
 HIRAN ENERGY - DESIGN & INSPECTION COMPANIES										 PETROBRAN DEVELOPMENT COMPANY																																																	
DRAWING TITLE: P&ID - POTABLE WATER SYSTEM										NO CONSTRUCTION PERMITTED UNLESS DRAWING APPROVED																																																	
SCALE					SIZE					DRAWING NO.					SHEET NO.					REV					BUDGET REF.					LOCATION					SIZE CLASS					SERIAL NO.					DATE:														
NS					A3					BK-GCS-PEBCO-120-PR-P-0024					1 OF 1					D06					D03-073-9164					F					2					A					708862					1 OF 1					D06				
(VENDOR TITLE BLOCK)**																																																											

NOTES	
1- DELETED. 2- DELETED. 3- U SHALL BE READABLE AT GROUND. 4-PARTIAL STROK DEVICE TO BE CONSIDERED FOR ALL ESDY'S ACTIVATED BY ESD 1.0.	
GENERAL NOTE	
REFERENCE DRAWING Utility Flow Diagram Symbol & Legend For FPD & PAID DRG. No. BK-GCS-PEDCO-120-PR-UP-0001 BK-GCS-PEDCO-120-PR-PI-0001	
LEGEND	