


MENT LOCATION LAYOUT

DRAWING W018S

[illegible]

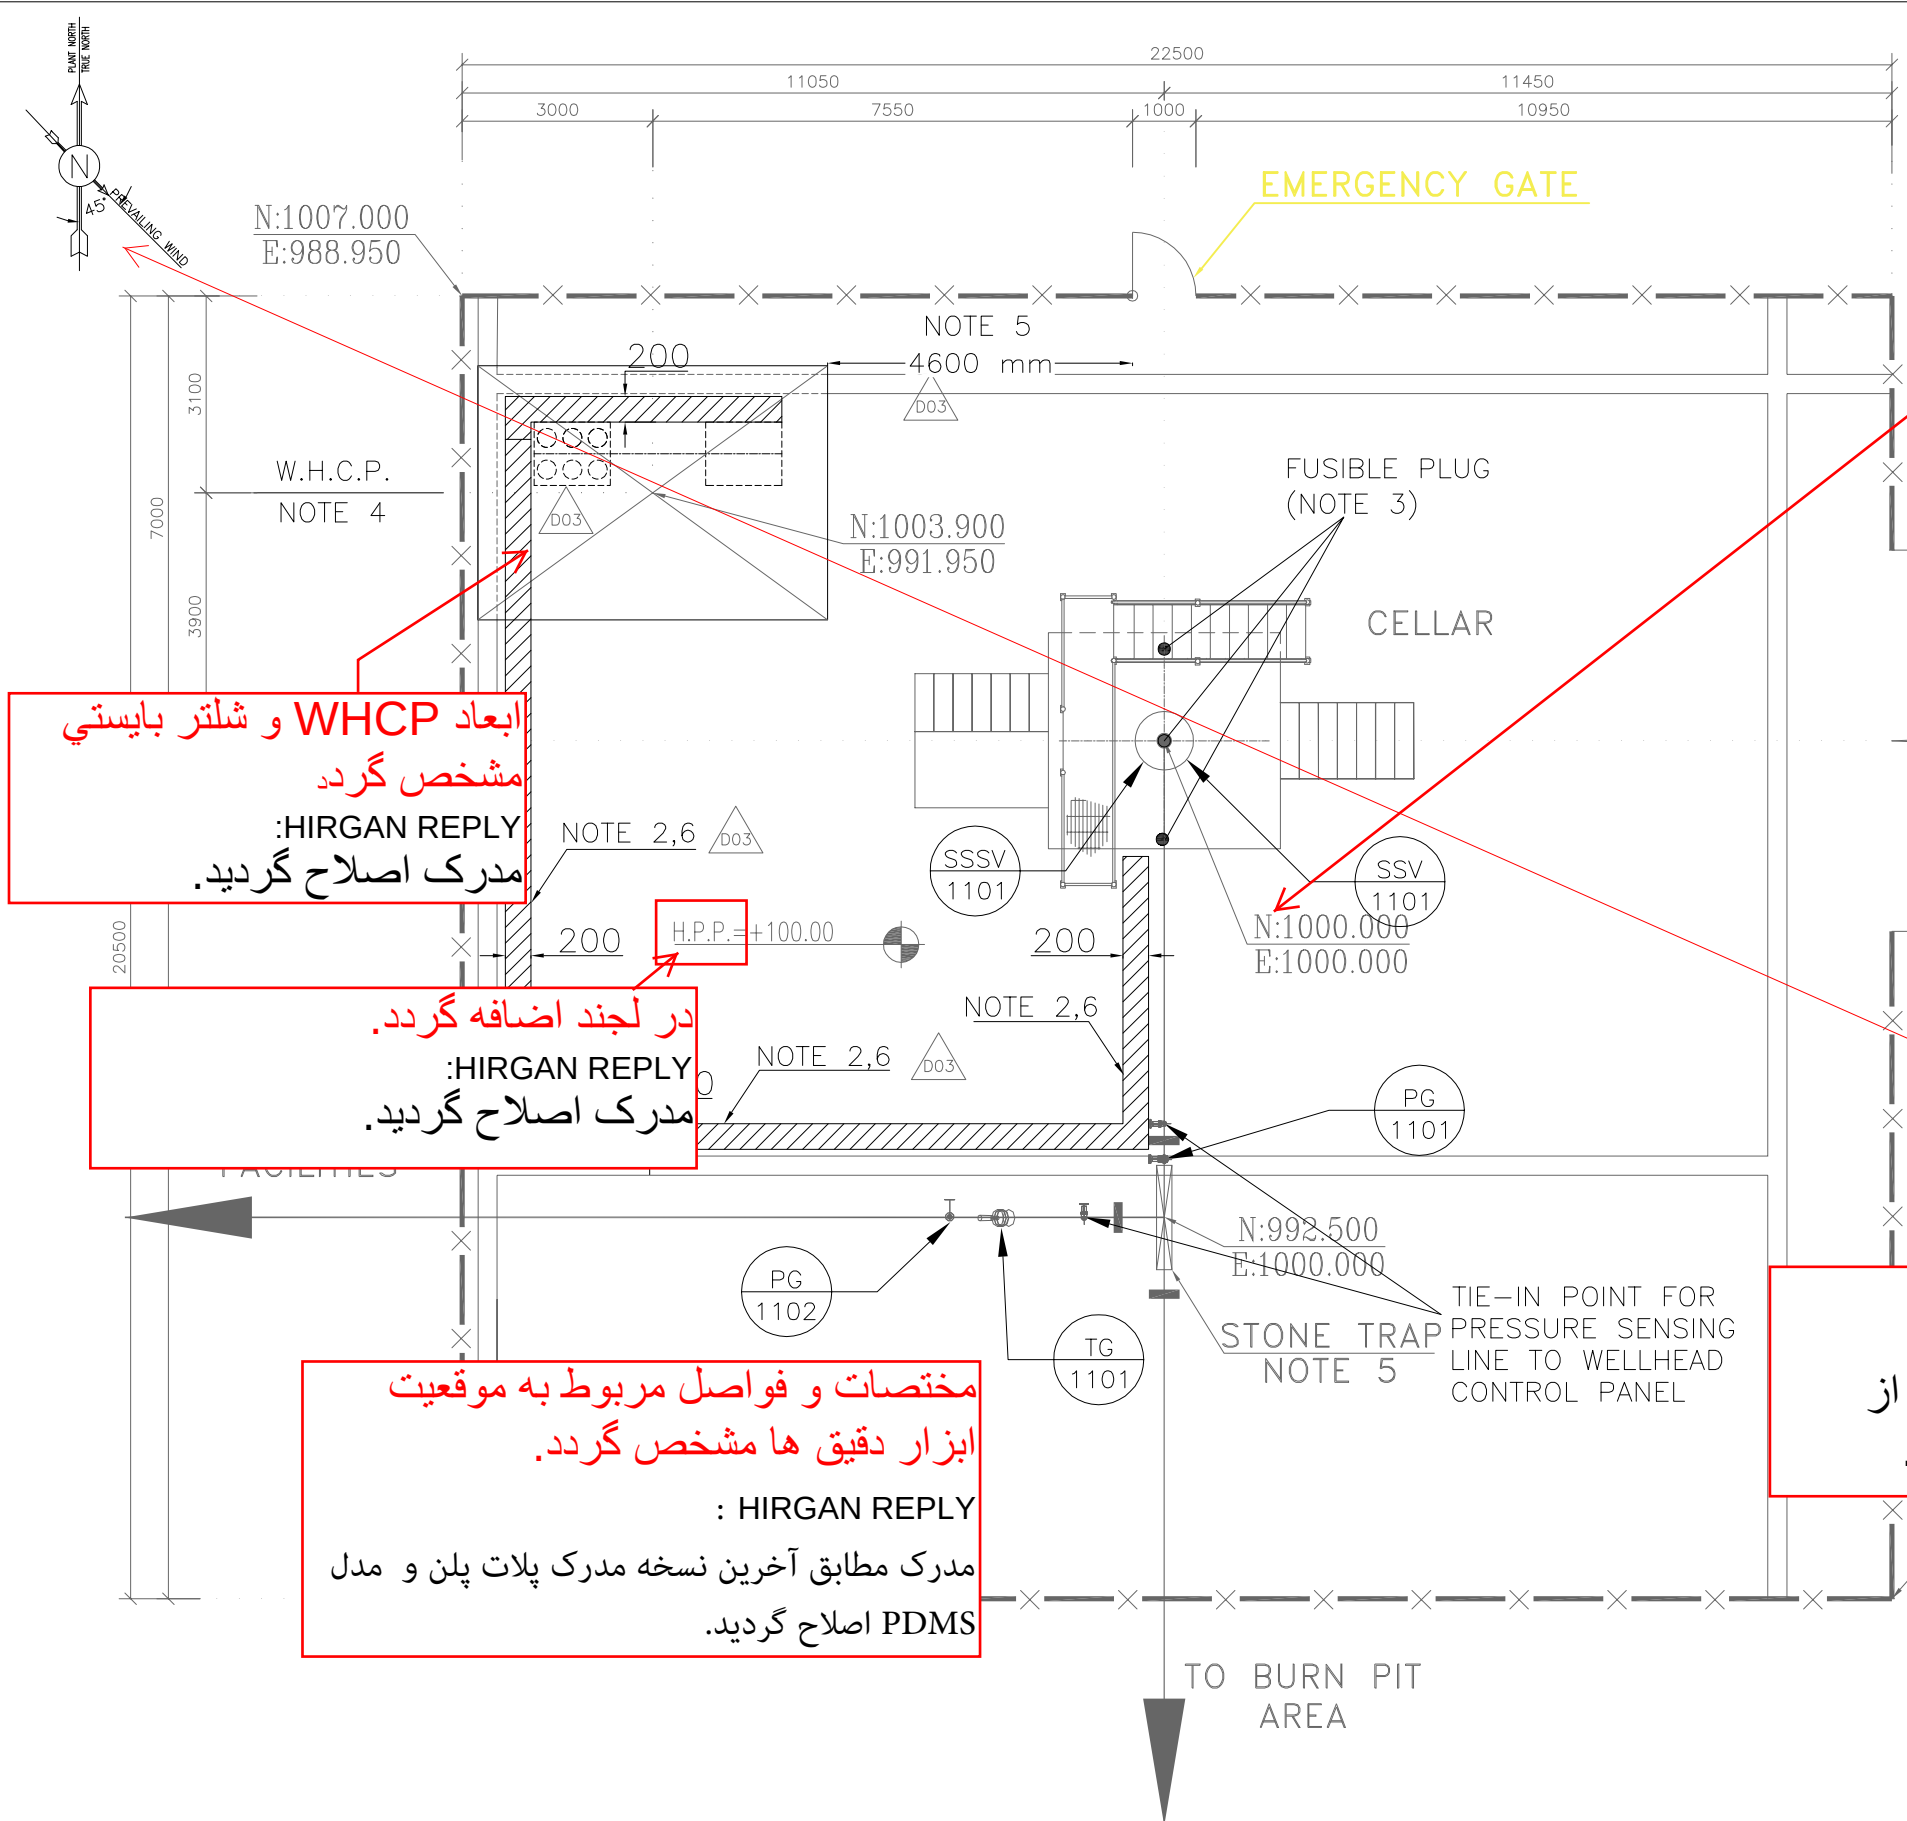

- NOTES
- 1: SHELTER OF WHCP AND NITROGEN BOTTLES.
 - 2: TUBE TRAY SHALL BE INSTALLED AT HEIGHT 100MM ABOVE GROUND, 1/2" TUBE & 1/4" TUBE FOR SSV & SSSV SHALL BE LAID ON THIS CABLE TRAY.
 - 3: 3 NO.S FUSIBLE PLUG WILL BE PREPARED BY WHCP VENDOR WHICH WILL BE INSTALLED ON NITROGEN LINE TWISTED AROUND WELLHEAD.
 - 4: DIMENSIONS OF W.H.C.P. AND RELEVANT SHELTER WILL BE FINALIZED.
 - 5: THE DISTANCE BETWEEN EMERGENCY GATE AND WHCP.
 - 6: TRAY LENGTH BETWEEN CHRISTMAS TREE AND WHCP TO BE CONSIDERED 30m.

در نقشه ها مختصات نقطه مرجع نسبت به مختصات UTS ذکر گردد.
: HIRGAN REPLY
این مدرک مطابق مدرک پلات پلن تهیه شده است و لذا برای مختصات لازم به مدارک مرجع رجوع شود.

ابعاد WHCP و شلتر بایستی مشخص گردد.
:HIRGAN REPLY
مدرک اصلاح گردید.

در لجنه اضافه گردد.
:HIRGAN REPLY
مدرک اصلاح گردید.


مختصات و فواصل مربوط به موقعیت ابزار دقیق ها مشخص گردد.
: HIRGAN REPLY
مدرک مطابق آخرین مدرک پلات پلن و مدل PDMS اصلاح گردید.

زاویه باد غالب؟
: HIRGAN REPLY
تمامی اطلاعات مطابق آخرین نسخه از مدارک پیش نیاز ارائه گردیده است .

LEGEND

	TUBE TRAY
	TWO RACK OF NITROGEN BOTTLES
	WHCP
	FUSIBLE PLUG

REFERENCE DRAWING	DRG. No.
P&ID-W018S	BK-W018S-PEDCO-110-PR-PI-0001
PLOT PLAN DRAWING-W018S	BK-W018S-PEDCO-110-PI-PY-0001
PDMS MODEL REVIEW REPORT(60%)-W018S	BK-W018S-PEDCO-110-PI-RT-0001
DATA SHEETS FOR WHCP/HPU-WELLHEADS	BK-SSGRL-PEDCO-110-IN-DT-0001

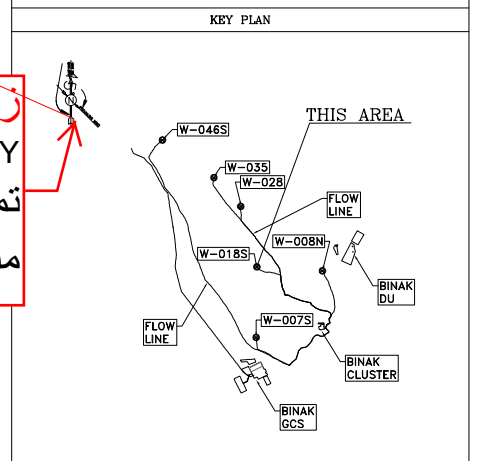

D03	JAN. 2023	APC	P.HAJISADROHI	M.PAKHARIAN	M.Mehrshad	** **													
D02	JUL. 2022	IPA	P.HAJISADROHI	M.PAKHARIAN	M.Mehrshad	** **													
D01	Apr. 2022	IPA	P.HAJISADROHI	M.PAKHARIAN	M.Mehrshad	** **													
D00	Apr. 2022	IPC	P.HAJISADROHI	M.PAKHARIAN	M.Mehrshad	** **													
REV.	DATE	P.O.I.S	PREP.	CHK.	APP.	AUT.													
PROJECT NAME: BINAK OILFIELD DEVELOPMENT/SUB-SURFACE WORK PACKAGES W018S WELLHEAD FACILITIES							THE ORIGINAL AND ALL COPIES OF THIS DRAWING TOGETHER WITH THE COPYRIGHT THEREIN ARE THE SOLE PROPERTY OF N.I.S.O.C./ FIELDS												
PROJECT NO.: 971020							BINAK OILFIELD DEVELOPMENT SUB-SURFACE WORK PACKAGES W018S WELLHEAD FACILITIES												
EPC CONTRACTOR: HIRGAN ENERGY - DESIGN & INSPECTION COMPANIES							EPD/EPC CONTRACTOR (GC): PETROIRAN DEVELOPMENT COMPANY												
DRAWING TITLE: INSTRUMENT LOCATION LAYOUT DRAWING - W018S							NO CONSTRUCTION PERMITTED UNLESS DRAWING APPROVED												
							APPROVED FOR CONSTRUCTION BY: DATE:												
SCALE	SIZE	DRAWING NO.			SHEET NO.	REV.	BUDGET REF.	LOCATION SIZE/CLASS	SERIAL NO.	SHEET	REVISION								
AS SHOWN	A0	BK-W018S-PEDCO-110-IN-PY-0001			2 OF 2	D03	0-53-073-9184	F	2	J	707450	2	D03						

W018S
SC: 1/100

(VENDOR TITLE BLOCK)**