


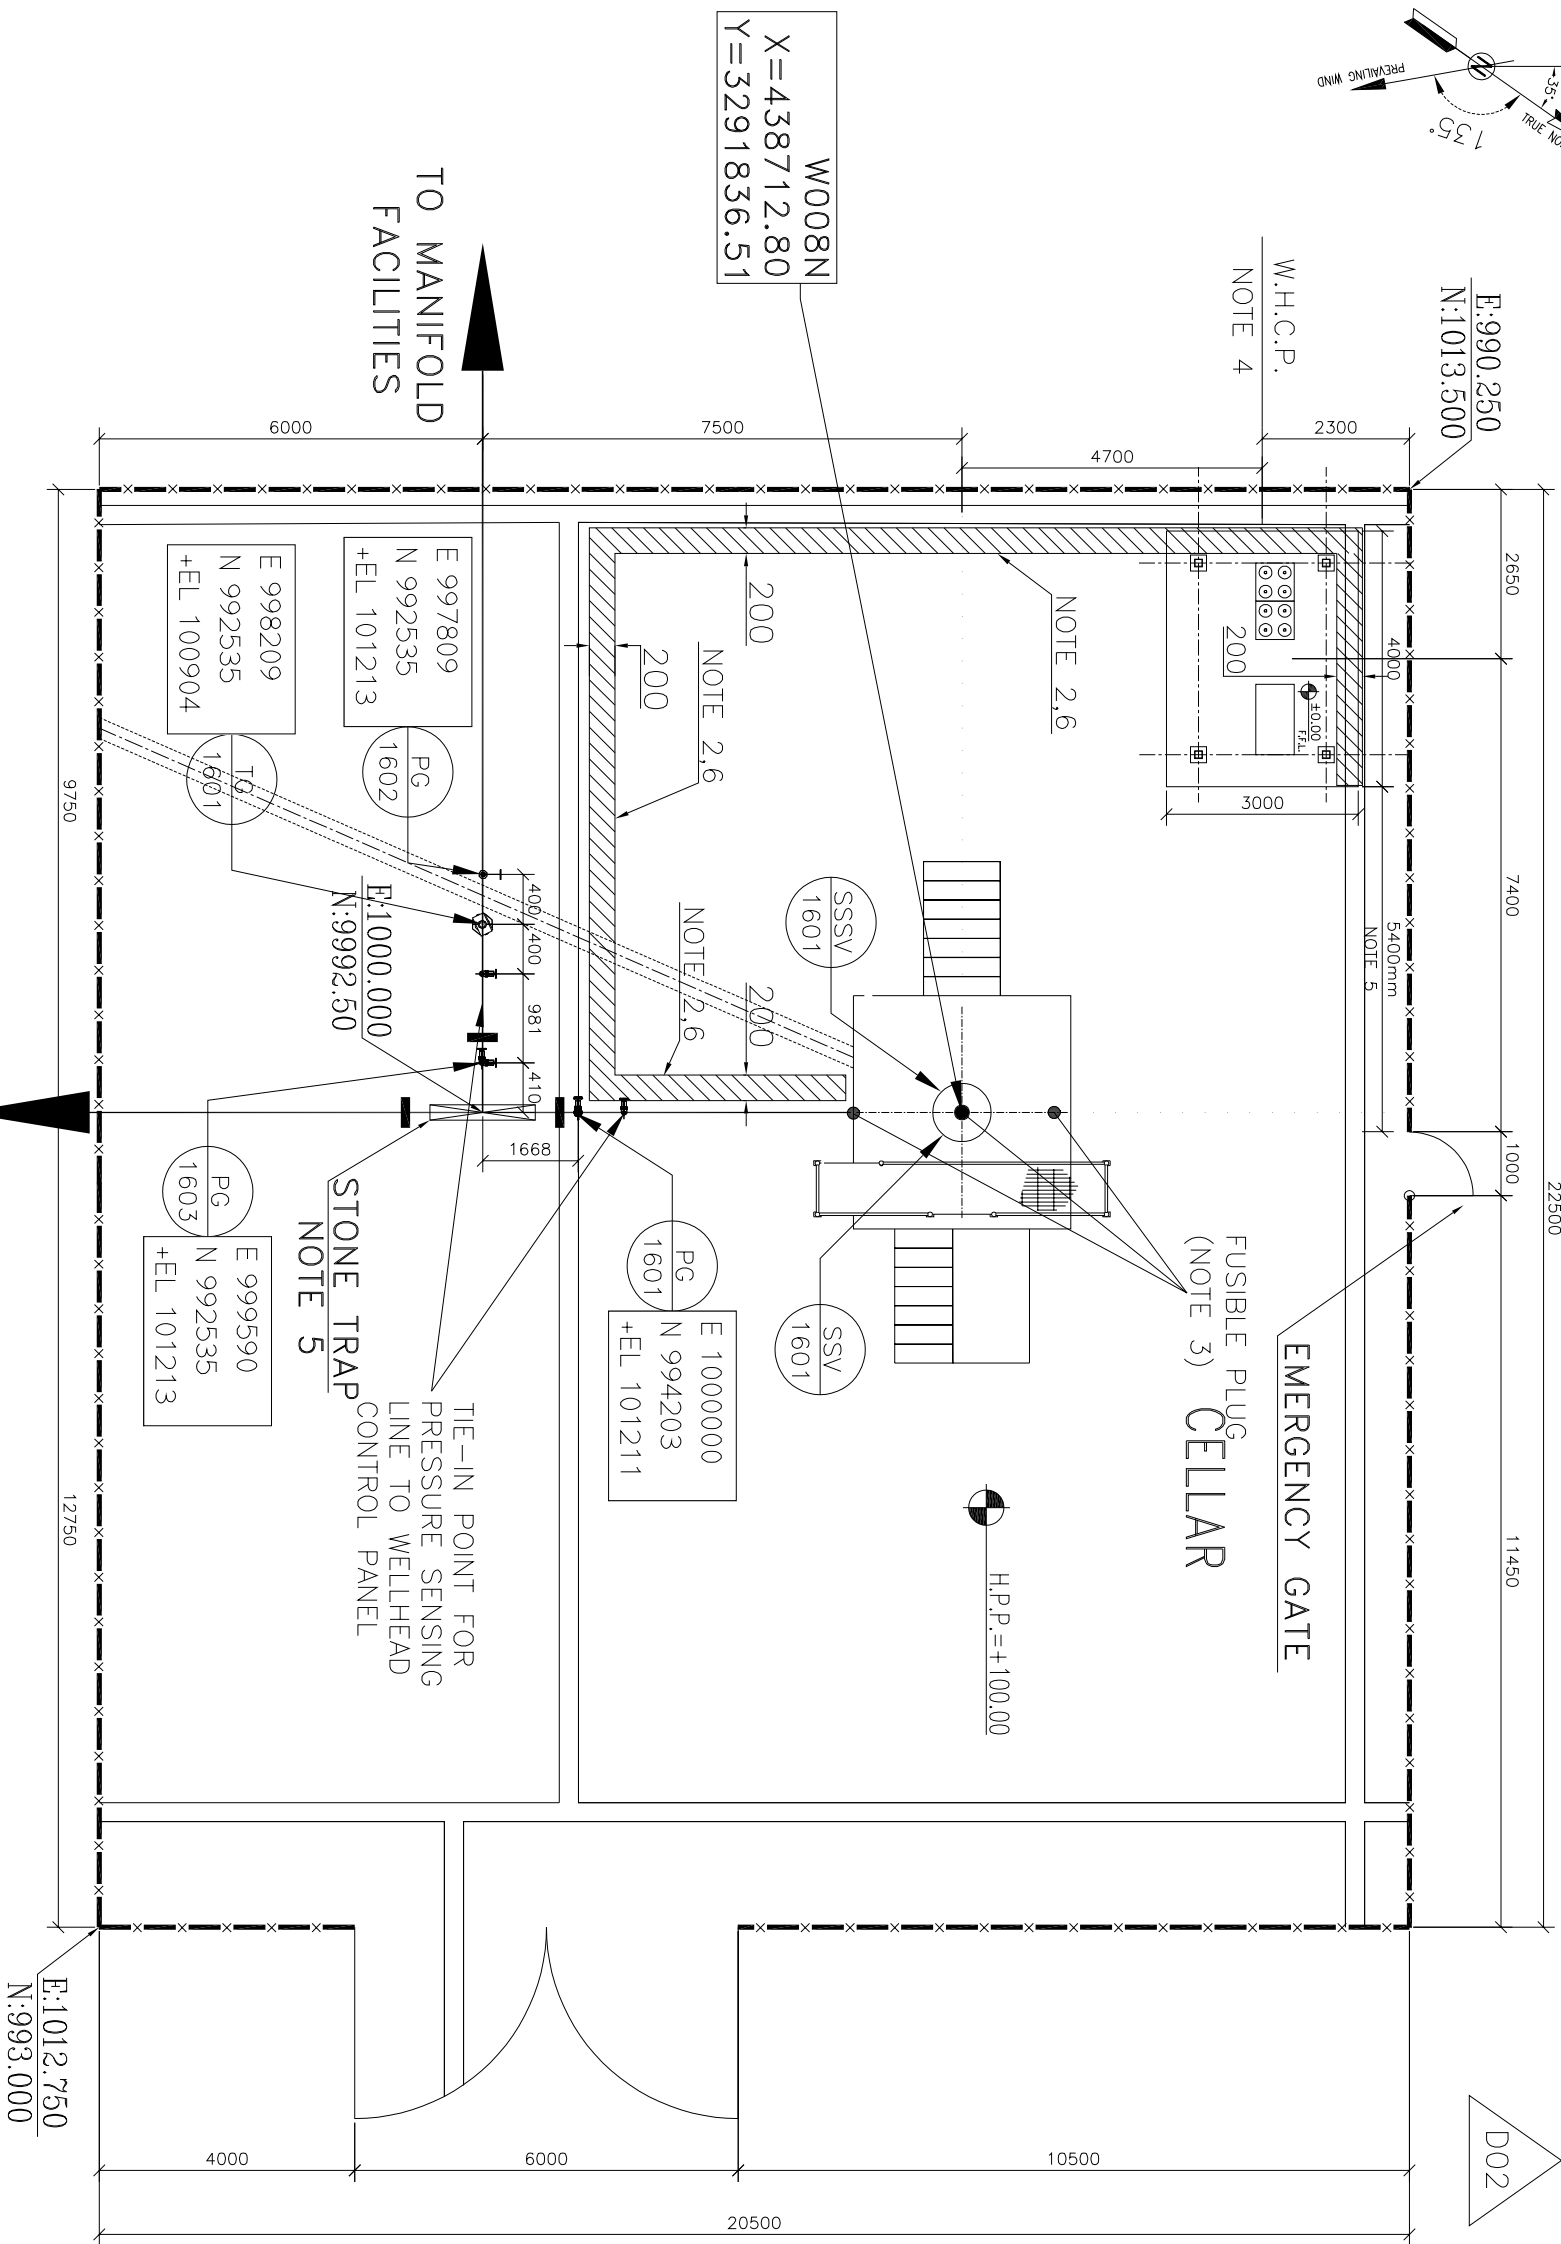












INSTRUMENT LOCATION LAYOUT  
DRAWING W008N

NOTES	
LEGEND	
REFERENCE DRAWING	DRG. No.
P&ID-W008N	BK-W008N-PEDCO-110-PR-P1-0001
PLOT PLAN DRAWING-W008N	BK-W008N-PEDCO-110-PI-P1-0001
PDMS MODEL REVIEW REPORT(60%)-W008N	BK-W008N-PEDCO-110-PI-RT-0001
DATA SHEETS FOR WHCP/HPU-WELLHEADS	BK-SSGRL-PEDCO-110-IN-DT-0001
KEY PLAN	

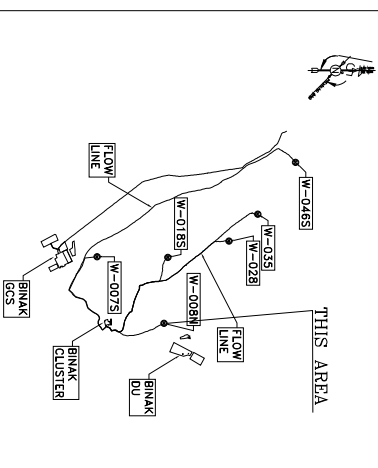
DO2	APR.2023	APC	P.HAJISADGHI	M.FAKHARIAN	A.M.MOHSEN	** **	***	*****	** **	***.****	** **	***.****			
DO1	NOV.2022	IFA	P.HAJISADGHI	M.FAKHARIAN	M.MEHRSHAD	** **	REV.	DESCRIPTION	BY	DATE	BY	DATE			
DO0	AUG.2022	IPC	P.HAJISADGHI	M.FAKHARIAN	M.MEHRSHAD	** **			CHECKED		REV. APPR.				
REV.	DATE	P.O.I.S	PREP.	CHK.	APP.	AUT.	اصل و کلیه نسخ این نقشه و حق اقتباس متعلق به شرکت ملی مناطق نفت خیز جنوب میباشد.								
PROJECT NAME: BINAK OILFIELD DEVELOPMENT/SUB-SURFACE WORK PACKAGES W008N WELLHEAD FACILITIES							 THE ORIGINAL AND ALL COPIES OF THIS DRAWING TOGETHER WITH THE COPYRIGHT THEREIN ARE THE SOLE PROPERTY OF N.I.S.O.C./ FIELDS								
PROJECT NO.: 971020															
EPC CONTRACTOR:			EPD/EPC CONTRACTOR (GC):				BINAK OILFIELD DEVELOPMENT SUB-SURFACE WORK PACKAGES W008N WELLHEAD FACILITIES								
 HIRGAN ENERGY - DESIGN & INSPECTION COMPANIES			 PEDCO				PETROIRAN DEVELOPMENT COMPANY								
							DATE		SCALE	DRAWING BY	CHECKED BY	PROJECT ENG.			
DRAWING TITLE: Instrument Location Layout Drawing - W008N							NO CONSTRUCTION PERMITTED UNLESS DRAWING APPROVED								
APPROVED FOR CONSTRUCTION							BY:		DATE:						
SCALE	SIZE	DRAWING NO.			SHEET NO.	REV.	BUDGET REF.	LOCATION	SIZE	CLASS	SERIAL NO.	SHEET	REVISION		
AS SHOWN	A3	BK-W008N-PEDCO-110-IN-PY-0001			1 OF 2	DO2	0-63-073-9184	F	2	J	707853	1 OF 2	DO2		

(VENDOR TITLE BLOCK)\*\*



- | LEGEND  |                              |
|---|------------------------------|
| H.P.P.  | HIGH POINT PAVING            |
| W.H.C.P.  | WELL HEAD CONTROL PANEL      |
|  | FENCE                        |
|  | MATCH LINE                   |
|  | WELL LOCATION                |
|  | SURFACE WATER TRENCH         |
|  | GRATING                      |
|  | TUBE TRAY                    |
|  | TWO RACK OF NITROGEN BOTTLES |
|  | WHCP                         |
|  | TEMPERATURE GAUGE            |
|  | PRESSURE GAUGE               |

	DRC. No.
REFERENCE DRAWING	
PALID - WOODEN	BK - W008N - PEDCO - 110 - PR - PT - 0001
PLOT PLAN DRAINING - WOODEN	BK - W008N - PEDCO - 110 - PI - PT - 0001
PDMIS MODEL REVIEW REPORT(60%) - WOODEN	BK - W008N - PEDCO - 110 - PI - RT - 0001
DATA SHEETS FOR WHCP/HPL-METHODS BK-SSTRB-PEDCO-110-IN-DT-0001	
KEY PLAN	

[illegible]

THE ORIGINAL AND ALL COPIES OF THIS DRAWING TOGETHER WITH  
THE COPYRIGHT THEREIN ARE THE SOLE PROPERTY OF  
N.I.S.O.C./ FIELDS

SC: 1/5

DRAWING TITLE:		NO CONSTRUCTION PERMITTED UNLESS DRAWING APPROVED	
INSTRUMENT LOCATION LAYOUT DRAWING - WOODB		APPROVED FOR CONSTRUCTION BY:	DATE:
SCALE	DRAWING NO.	BUDGET REF	SHEET
SIZE	SHEET NO.	CLASS	REVISION
AS SHOWN	2 OF 2	F	2 OF 2
AK-WOODB-PED00-110-IN-PY-0001	D002	707863	D002