

WELL-W046S

BINAK PRODUCTION WELL

NORMAL OPERATING WELLHEAD PRESSURE(FWHP) : 43.8 BARG

NORMAL WELLHEAD TEMPERATURE (WHT) : (80 °C)

ST-1301

STONE TRAP

NORMAL OPERATING PRESS : 43.8 BARG

NORMAL OPERATING : 80 °C

IRP-1301

SUCKER ROD PUMP (IRP)

(BY VENDOR)

NOTES

- 1-DICTATED.
- 2-DRAWN.

LEGEND


REFERENCE DRAWING	DRG. No.
SYMBOL & LEGEND FOR PFD AND PAID	BK-S99L-PD00-10-PR-PF-0001
PROCESS BASIS OF DESIGN	BK-G09L-PD00-00-PR-DB-0001

KEY PLAN

این و کلیه متعلق به شرکت ملی نفت ایران می باشد. هرگونه کپی برداری بدون مجوز میسر نمیگردد.

THE ORIGINAL AND ALL COPIES OF THIS DRAWING TOGETHER WITH THE COPYRIGHT THEREON ARE THE SOLE PROPERTY OF N.I.S.O.C./ FIELDS

D06	MAY 2023	AFC	LAHVIARE	LAHVIARE	LAHVIARE	***							
D06	DEC 2022	AFC	LAHVIARE	LAHVIARE	LAHVIARE	***							
D04	AUG 2022	AFC	LAHVIARE	LAHVIARE	LAHVIARE	***							
D03	MAR 2022	AFC	LAHVIARE	LAHVIARE	LAHVIARE	***							
D02	DEC 2021	TPA	LAHVIARE	LAHVIARE	LAHVIARE	***							
D01	OCT 2021	IPC	LAHVIARE	LAHVIARE	LAHVIARE	***							
D00	AUG 2021	IPC	LAHVIARE	LAHVIARE	LAHVIARE	***							
REV.	DATE	P.O.I.S	PREP.	CHK.	APP.	AUT.							
PROJECT NAME: BINAK OILFIELD DEVELOPMENT/SUB-SURFACE WORK PACKAGES							PROJECT NO.: 971020						
PROJECT NO.: 971020							EPC CONTRACTOR (GC): PETROBRAN DEVELOPMENT COMPANY						
EPC CONTRACTOR: HIRSHAN ENERGY - DESIGN & INSPECTION OPERATIONS							NO CONSTRUCTION PERMITTED UNLESS DRAWING APPROVED						
DRAWING TITLE: PROCESS FLOW DIAGRAM - W046S							APPROVED FOR CONSTRUCTION						
SCALE	SIZE	DRAWING NO.			SHEET NO.	REV.	BUDGET REV.	LOCATION	SIZE	CLASS	SERIAL NO.	SHEET	REVISION
NS	A3	BK-W046S-PD00-110-PR-PF-0001			1 OF 2	D06	003-075-016	F	2	A	707001	1 OF 2	D06

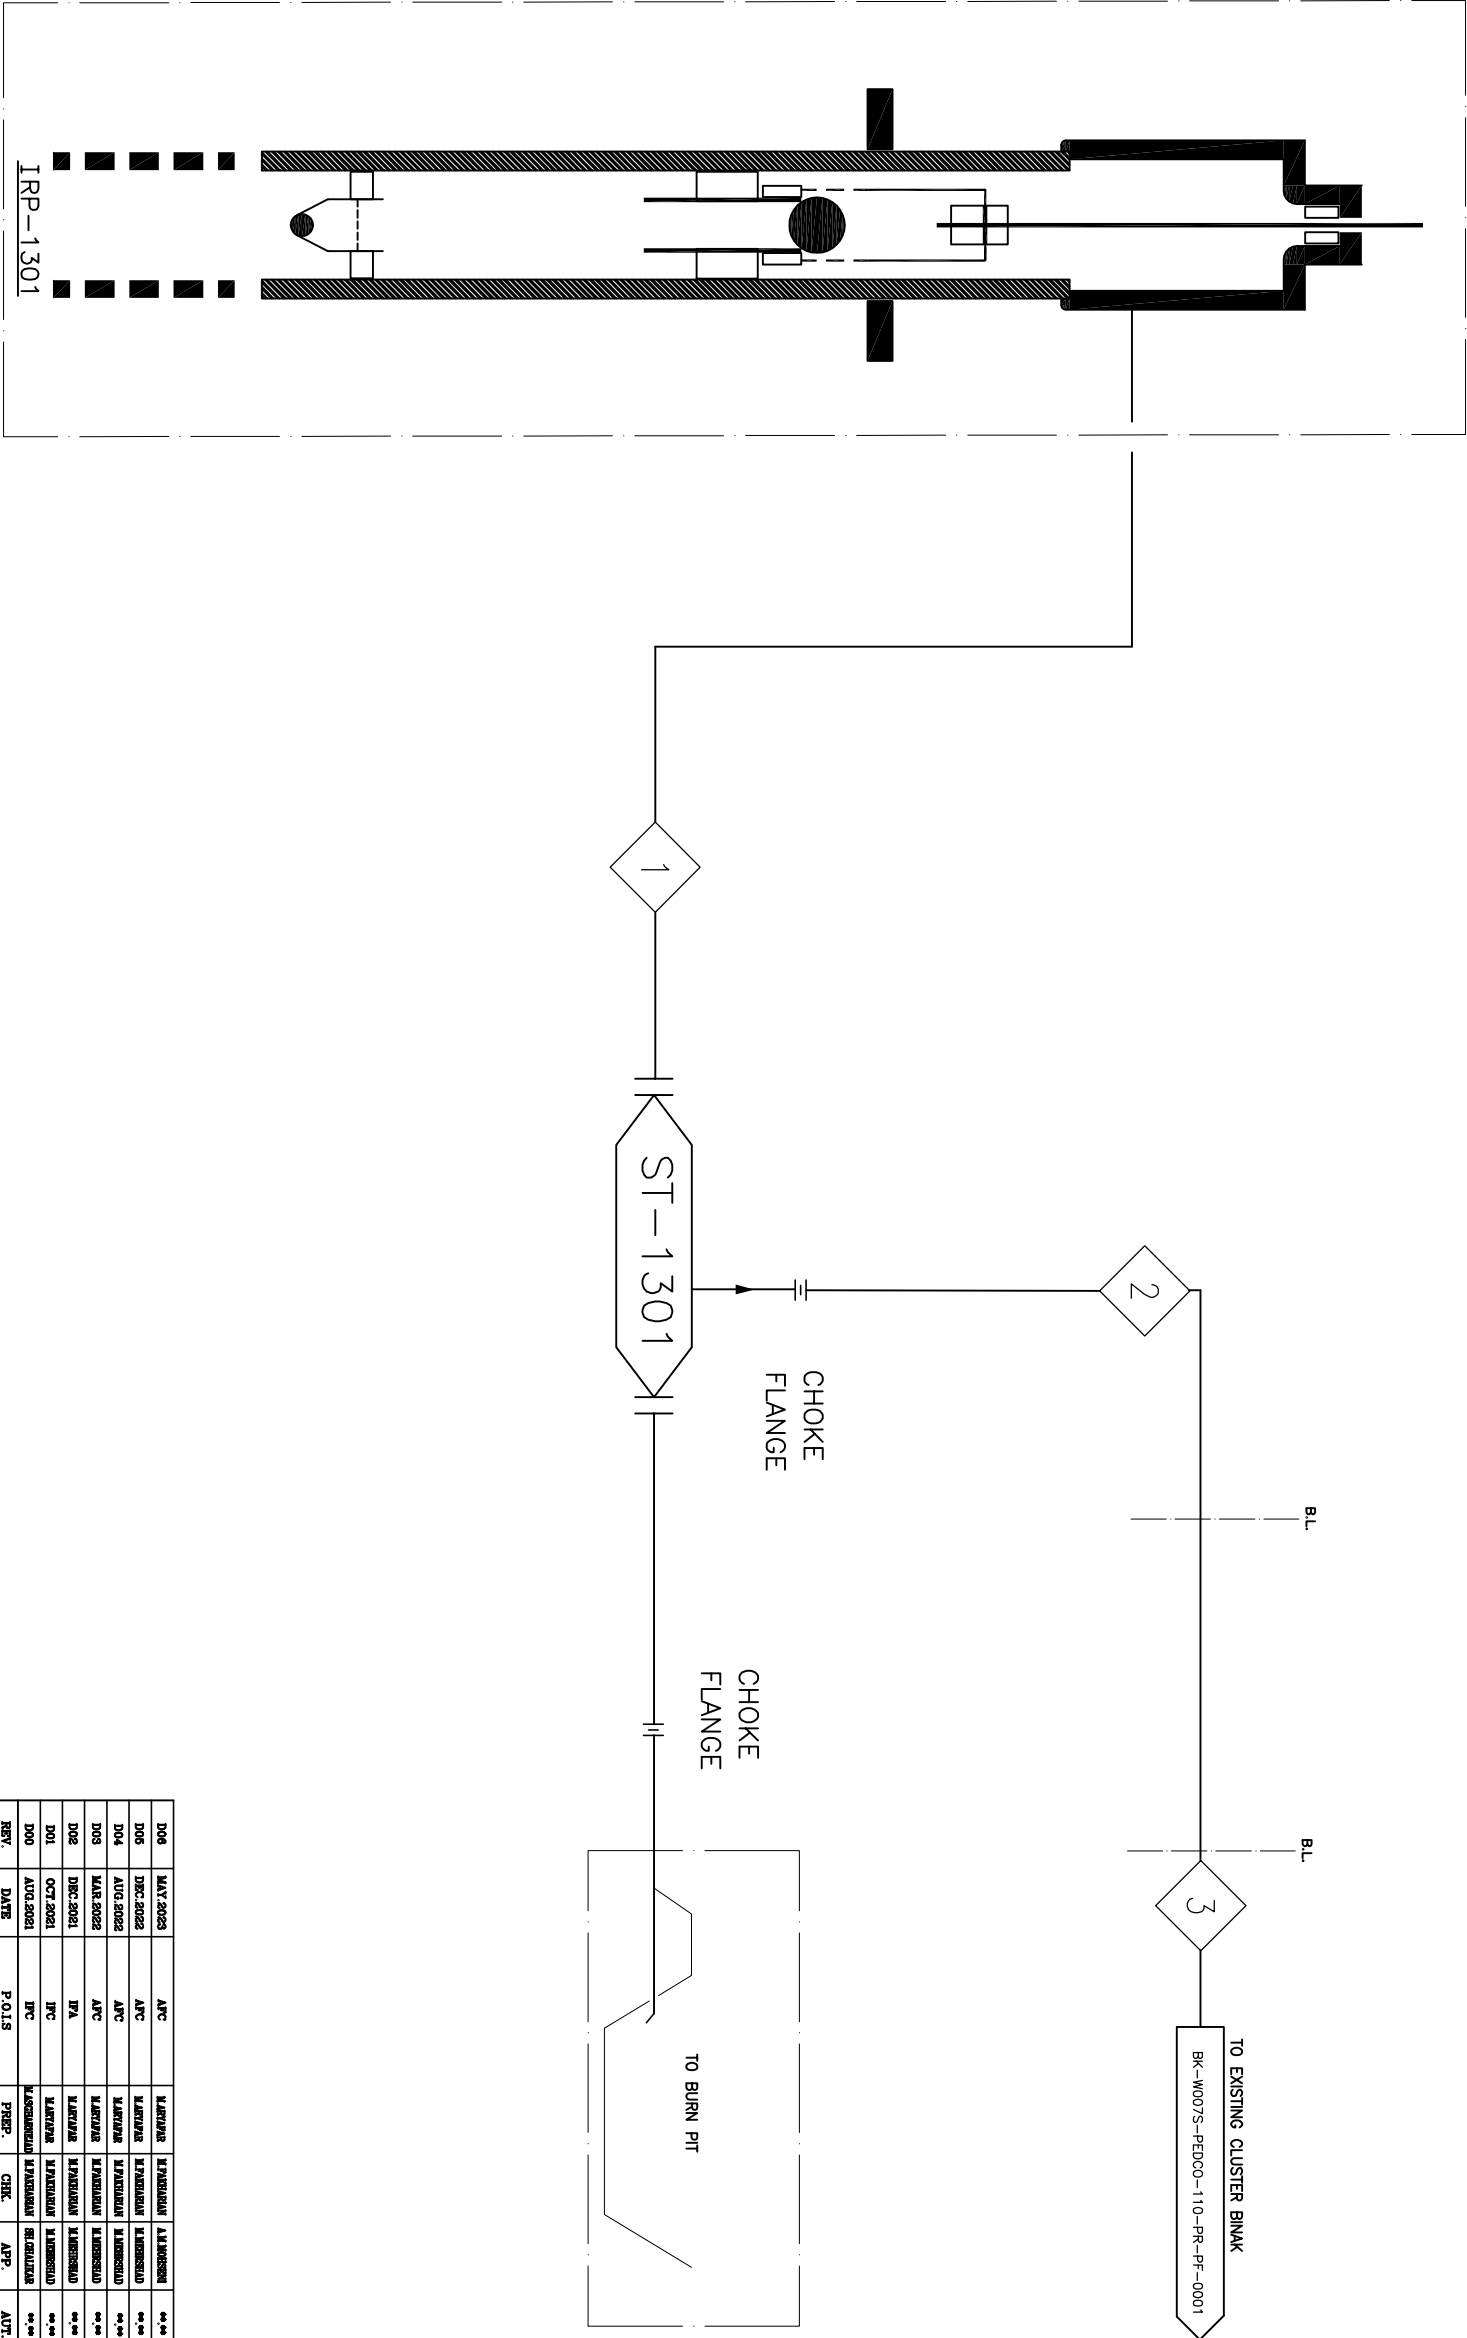

W046S

WELLHEAD

(SUB SURFACE SCOPE OF WORK)

(VENDOR TITLE BLOCK)**

