

NOTES


- 1- ALL DIMENSIONS ARE IN MILLIMETERS, EXCEPT OTHERWISE NOTED.
- 2- ALL ELEVATIONS ARE IN METERS.
- 3- ALL COORDINATES OF THIS PLAN ARE LOCAL.
- 4- H.P.P. 100.00m CORRESPONDING TO 57.05 M.S.L.
- 5- SHOWED PIPING / PIPELINES AND RELEVANT SUPPORTS, ARE INDICATIVE.
- 6- DIMENSIONS OF W.H.C.P. AND RELEVANT SHELTER WILL BE FINALIZED.
- 7- REFERENCE COORDINATES X=1000000, Y=1000000 REFER TO E=43503.952, N=3294378.945 UTM, WGS84, ZONE 39 - NORTH
- 8- FOR DETAIL OF BURN PIT & ACCESS ROAD SITE
- BK-W035-PEDCO-110-CV-P1-0002

LEGEND & ABBREVIATIONS

- WP WORKING POINT ELEVATION (CENTER OF PIPE ELEVATION)
- PF PLATFORM
- BOP BOTTOM OF PIPE ELEVATION
- TOS TOP OF STEEL ELEVATION
- FGL FINISH GRADE LEVEL
- HFG HIGH POINT OF GRAVEL
- HPP HIGH POINT OF PAVEMENT
- MSL MEAN SEA LEVEL
- SS STRUCTURE SUPPORT
- PS PIPE SUPPORT
- SPS SPECIAL PIPE SUPPORT
- FCS FOR CONTINUE SEE
- SLOPE
- H.P.P. HIGH POINT PAVING
- W.H.C.P. WELL HEAD CONTROL PANEL
- FENCE
- MATCH LINE
- WELL LOCATION
- SURFACE WATER TRENCH
- GRATING

REFERENCE DRAWING		DRG. No.
GENERAL CIVIL LAYOUT - W035		BK-W035-PEDCO-110-CV-P1-0001
CIVIL AND STRUCTURAL DRAWINGS - W035		BK-W035-PEDCO-110-CV-P1-0002
P&ID - W035		BK-W035-PEDCO-110-PS-P1-0001
ROOF PLAN DRAWING - W035		BK-W035-PEDCO-110-P1-P1-0001
BUILDING SHADING PLANS - W035		BK-W035-PEDCO-110-CV-DW-0001
FLOW LINE PLAN & PROFILE DRAWINGS - W035		BK-W035-PEDCO-110-SI-DW-0001
Standard Pipe Support Drawings		BK-SSSBL-PEDCO-110-P1-DW-0001



KEY PLAN

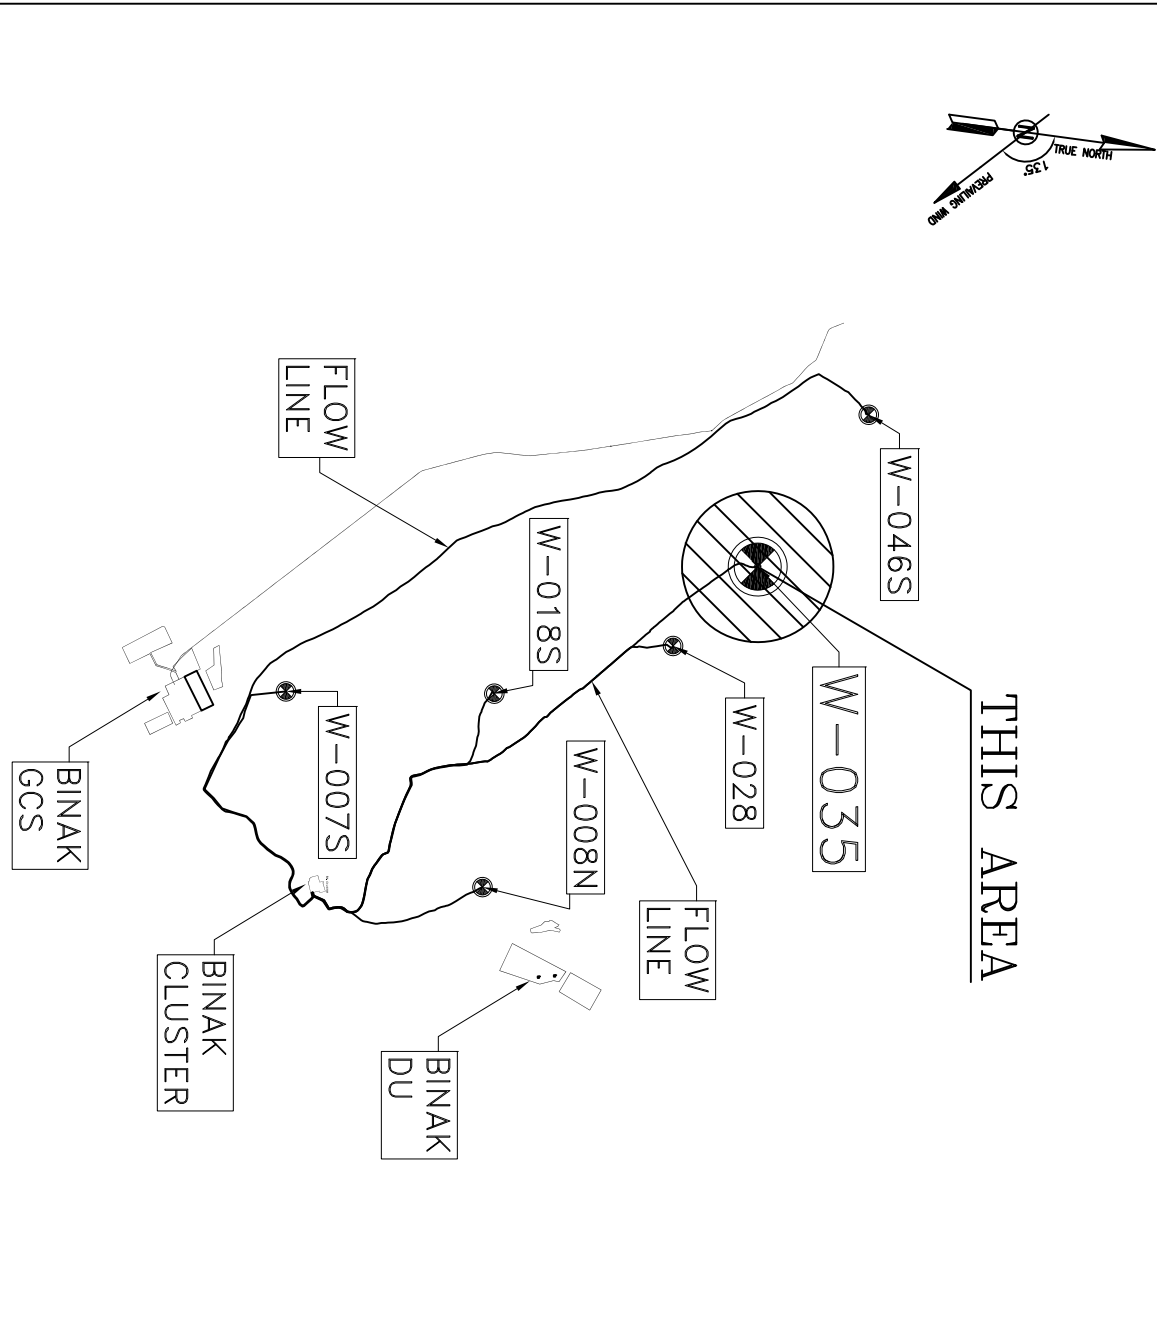

REV.	DESCRIPTION	BY	DATE	REV.	DATE
***	*****	***	****	***	****
REV.	CHECKED	BY	DATE	REV.	DATE
اسم و تلمیح سنج این نقشه و حق انحصاری متعلق به شرکت ملی مناطق نفت خیز جنوب میباشد					
THE ORIGINAL AND ALL COPIES OF THIS DRAWING TOGETHER WITH THE COPYRIGHT THEREIN ARE THE SOLE PROPERTY OF N.I.S.O.C./ FIELDS					

BINAIK OUTFIELD DEVELOPMENT SUB-SURFACE WORK PACKAGES W035 WELLHEAD FACILITIES	
DATE	SCALE
	DRAWING BY
	CHECKED BY
	PROJECT ENG.



NO CONSTRUCTION PERMITTED UNLESS DRAWING APPROVED	
APPROVED FOR CONSTRUCTION	BY:
	DATE:
BUDGET REF.	LOCATION
SIZE	CLASS
SERIAL NO.	SHEET
REVISION	REVISION
063-079-9194	P
4	L
707751	1 OF 4
D00	D00

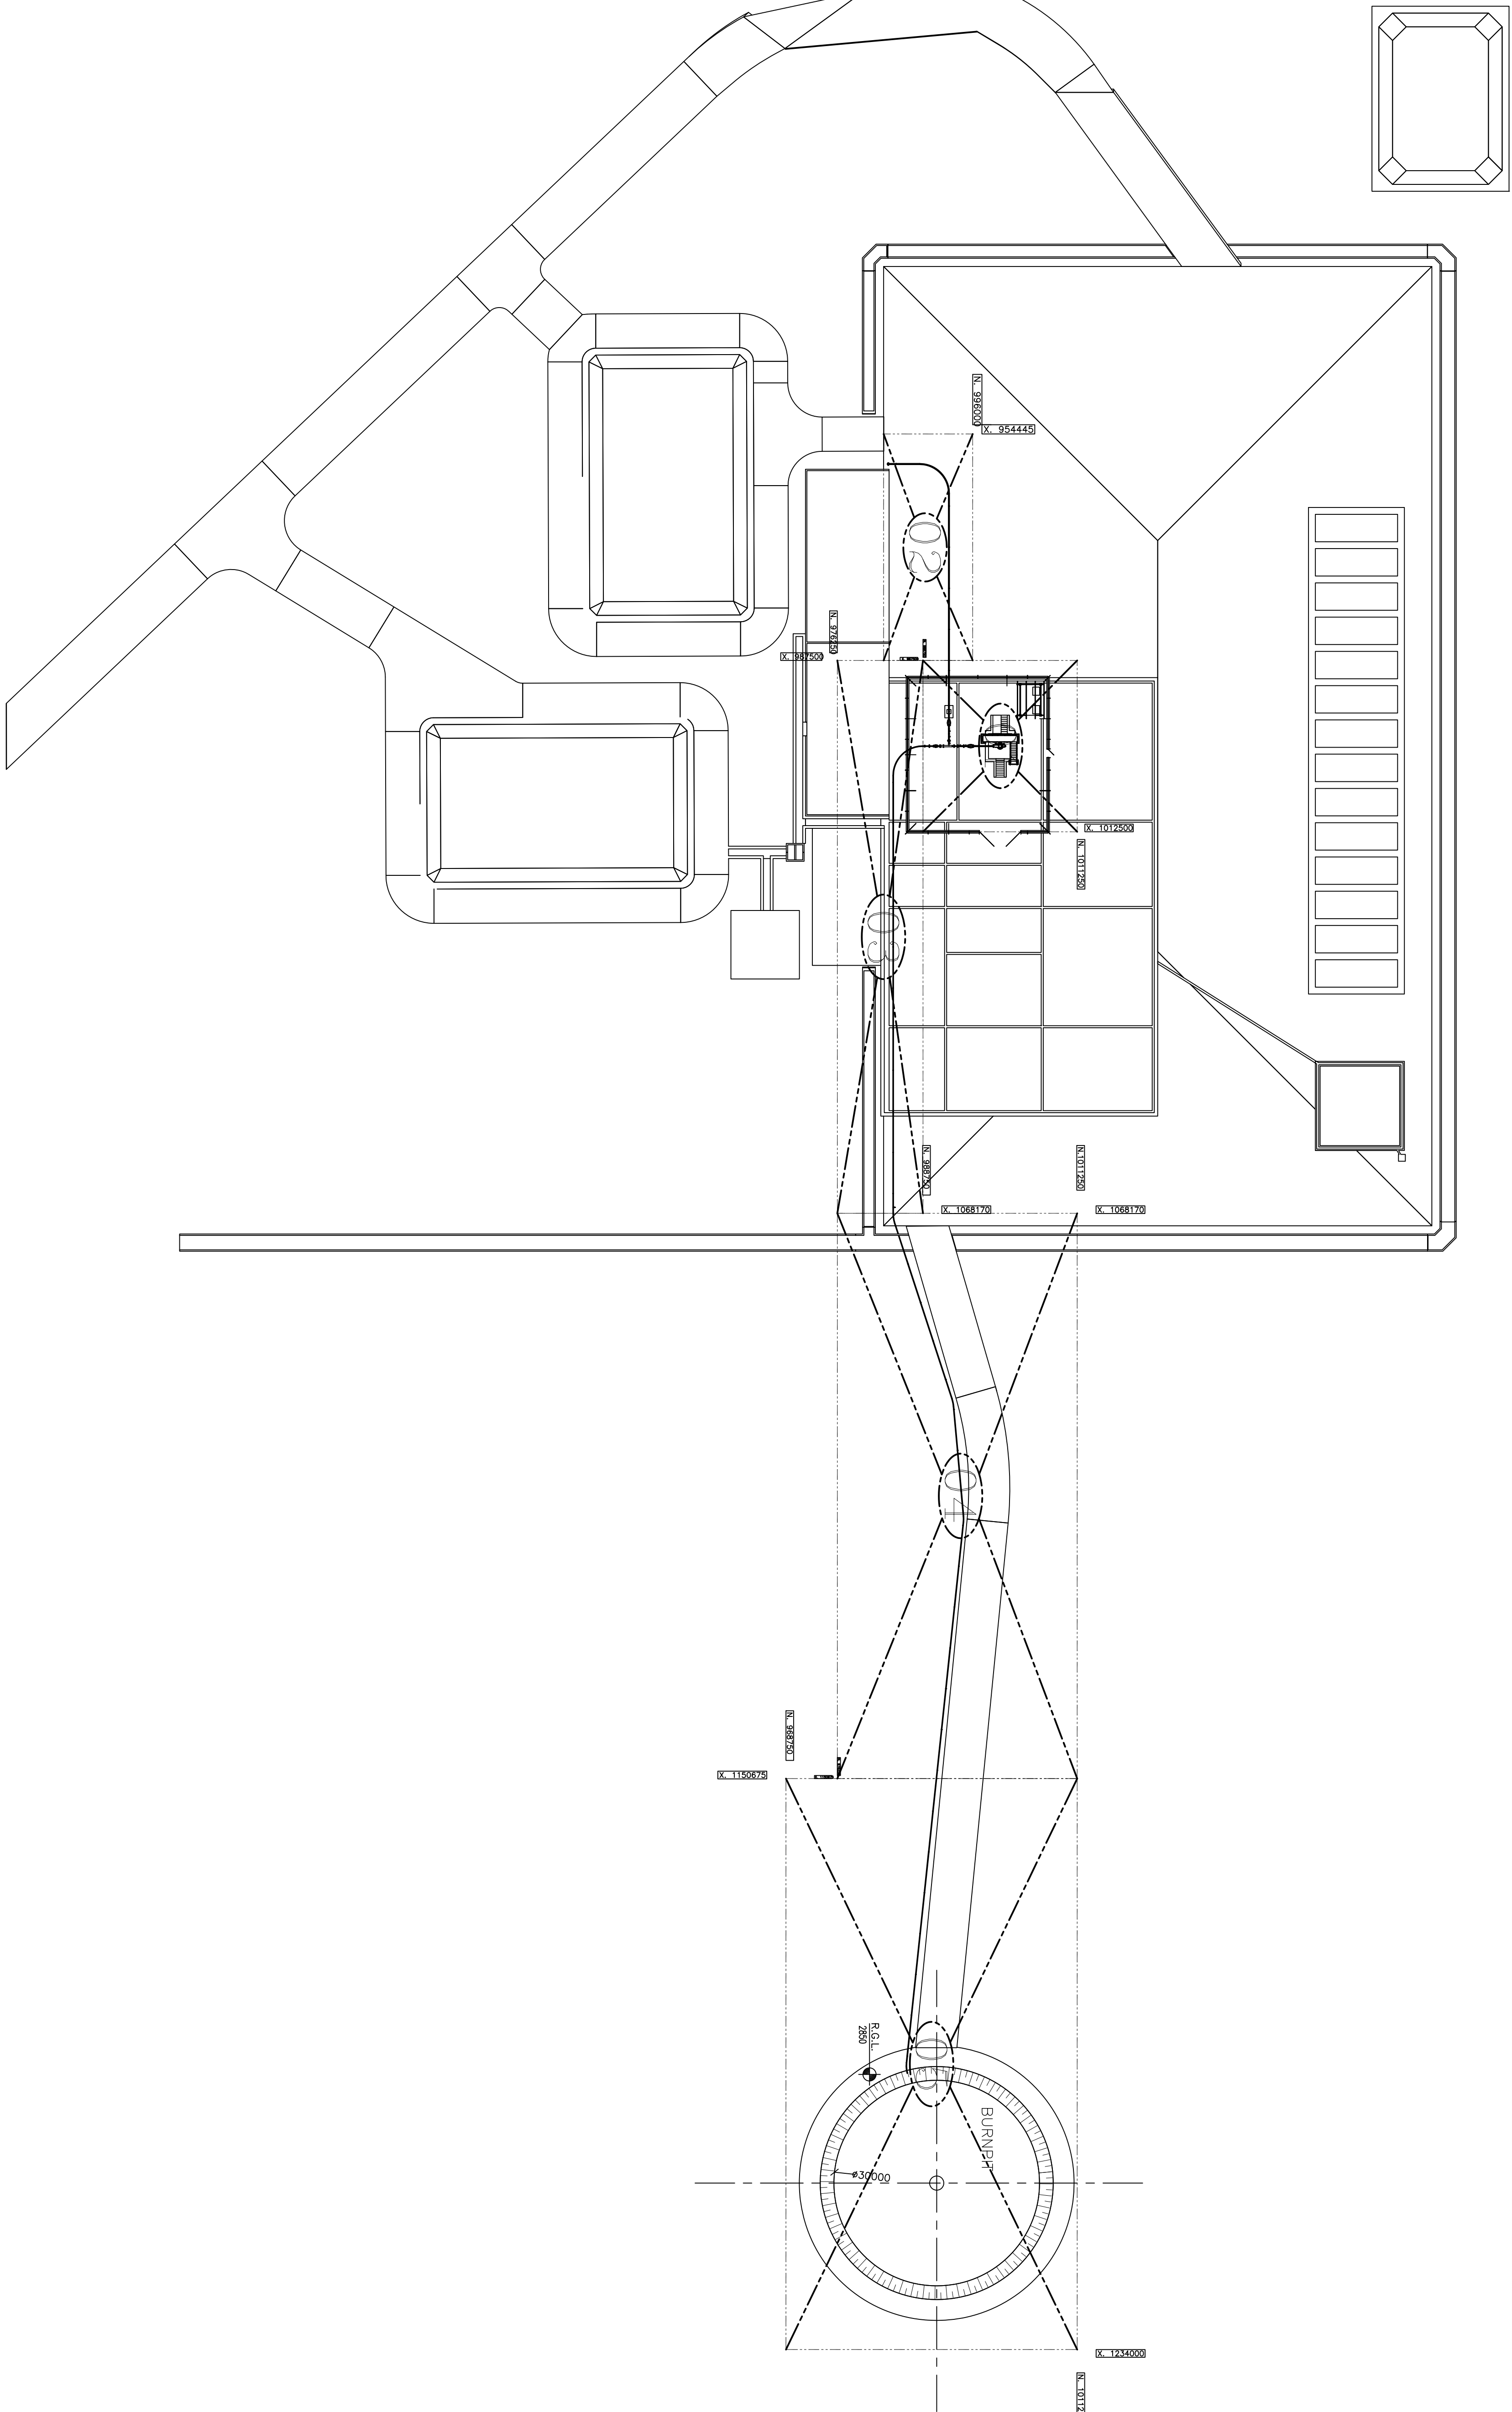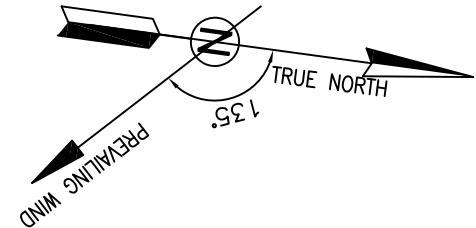

OVERALL PIPING PLAN

WELLHEAD.: W035

SC: 1/500

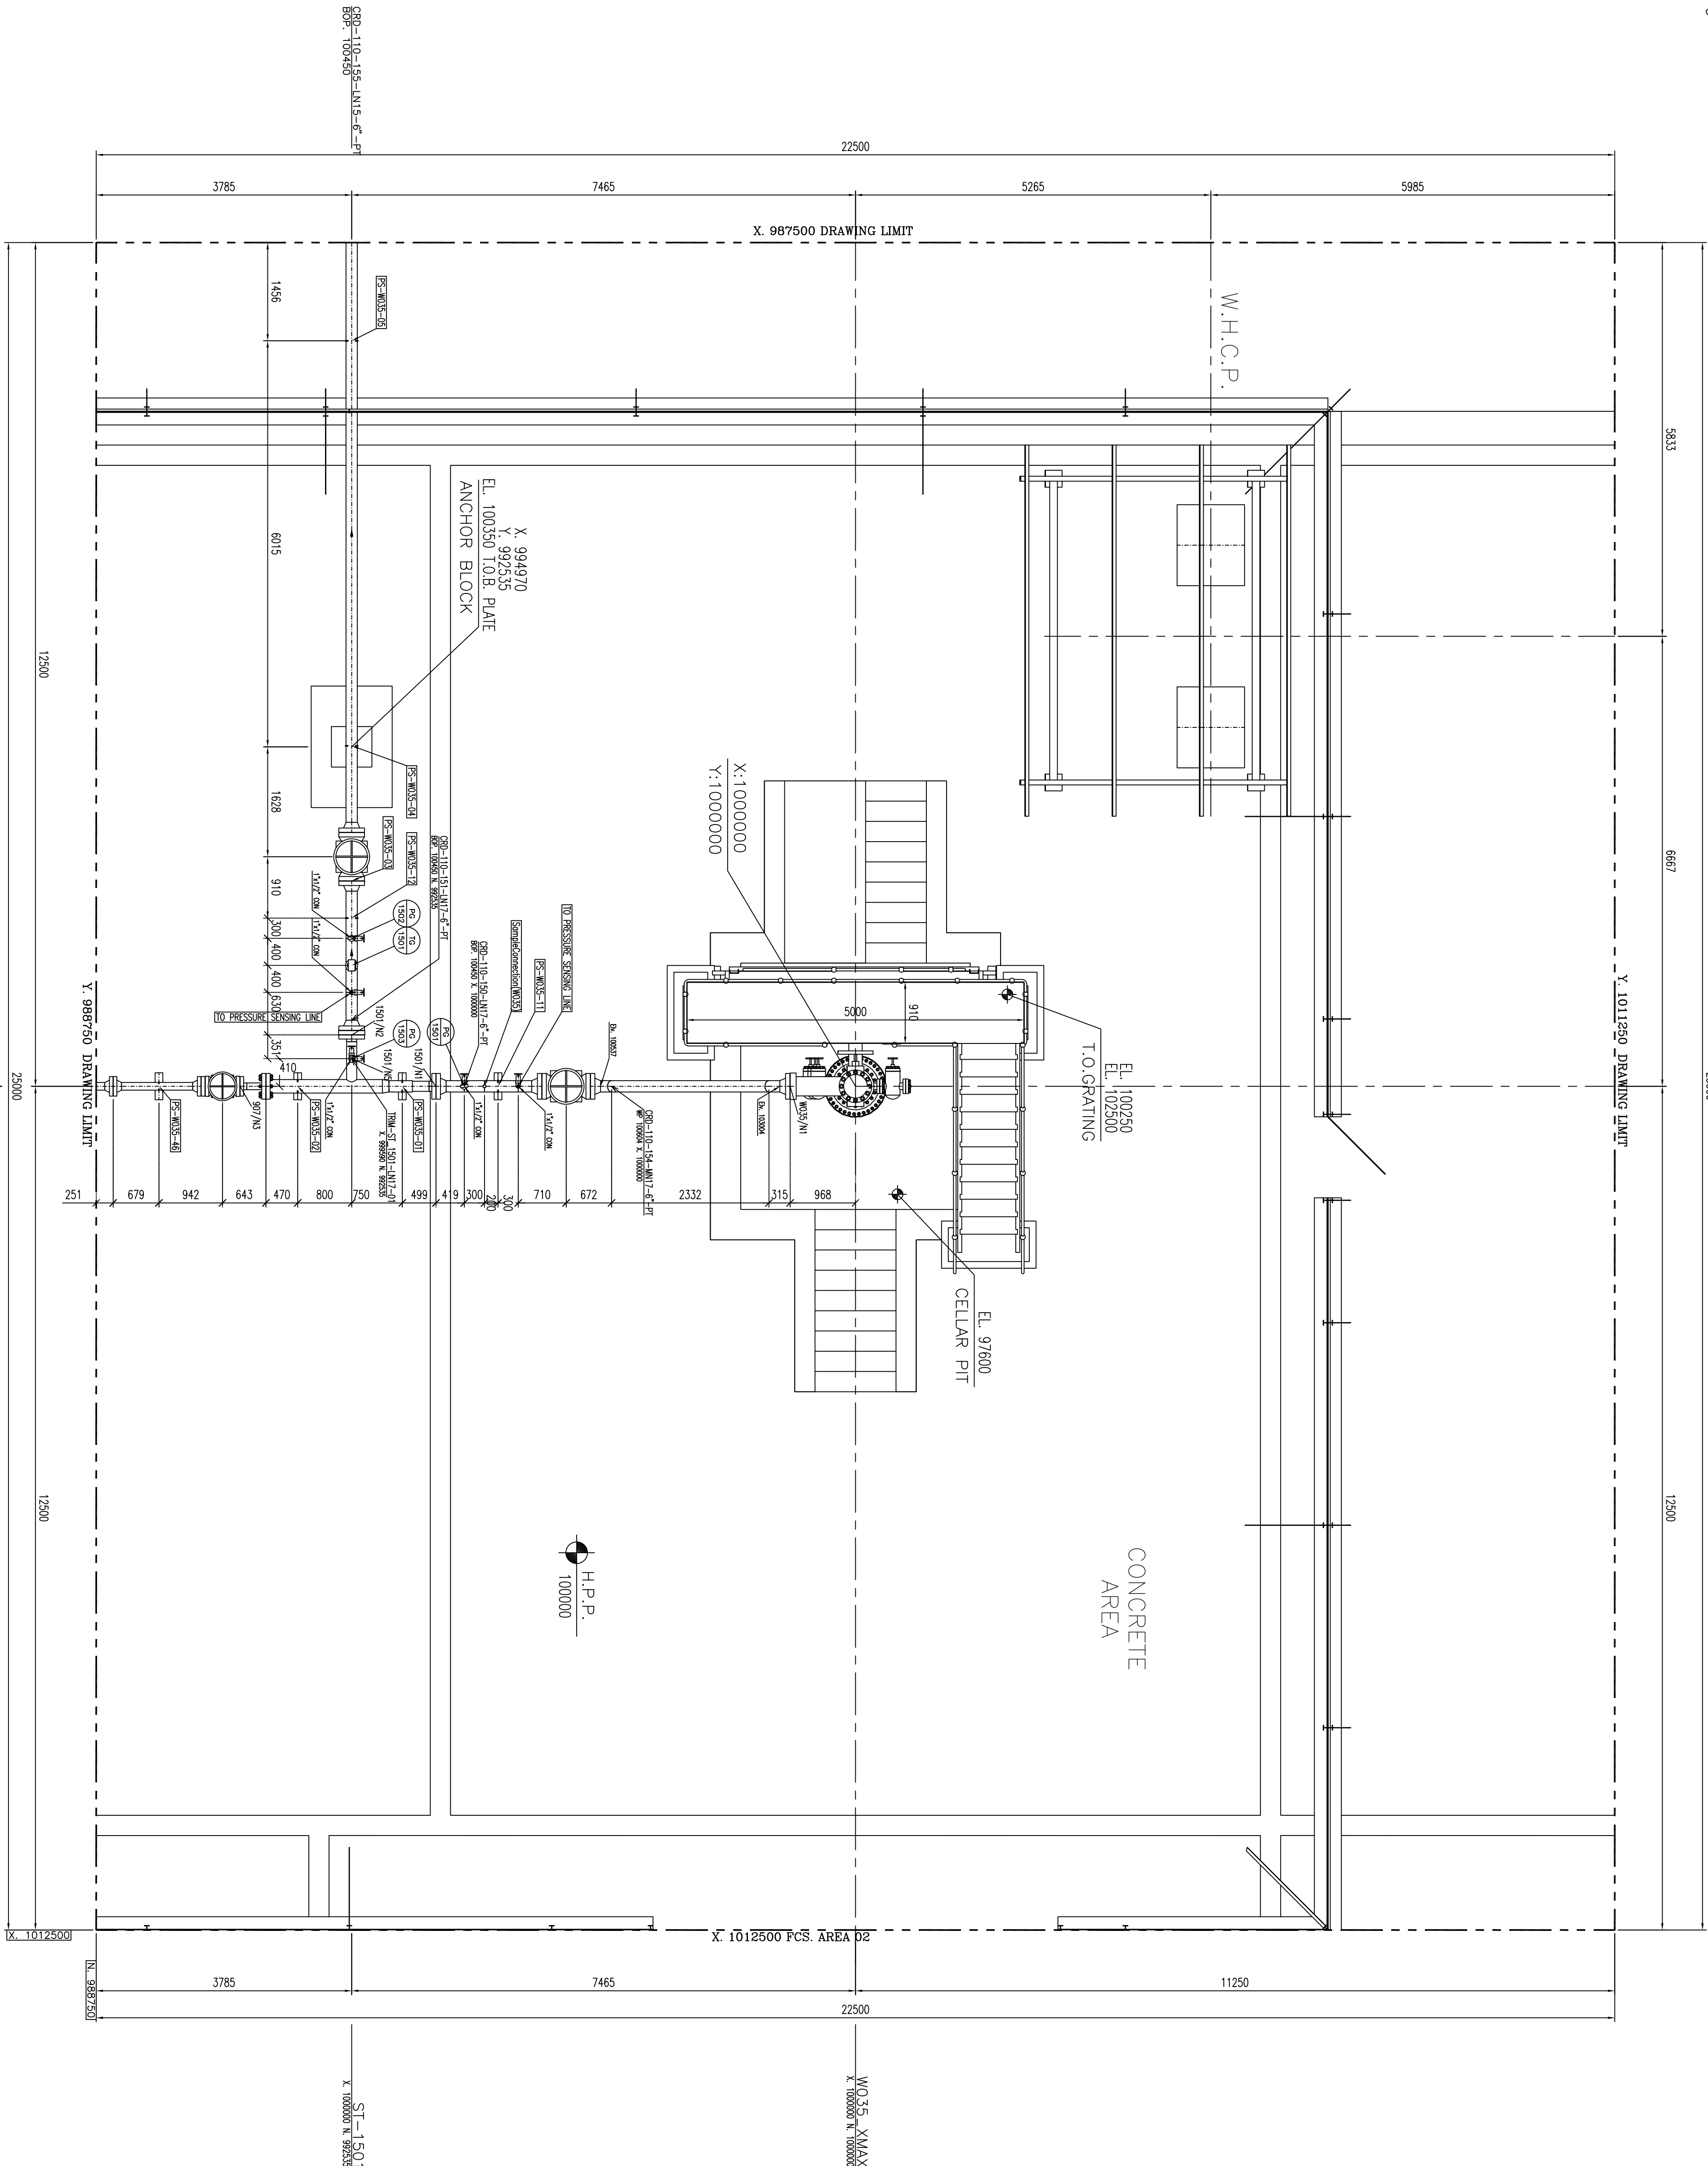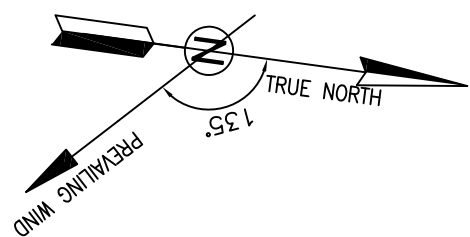

AREA 01
EL. 8500 - EL. 12000
S.S. / 50

NO.	SITE	ORIENT	PLANT	CORE	LEV.	RELU.
W035/N1	6"	180	Q. 1500	RT. ANG. B165	10354	-
S1-1501						
S1-1501/N2	6"	0	Q. 1500	-	10354	-
S1-1501/N2	6"	270	Q. 1500	-	10354	-
S1-1501/N3	4"	180	Q. 1500	-	10354	-
S1-1501/N3	1"	80700	-	-	100629	-

NOTES


- 1- ALL DIMENSIONS ARE IN MILLIMETERS, EXCEPT OTHERWISE NOTED.
- 2- ALL ELEVATIONS ARE IN METERS.
- 3- ALL COORDINATES OF THIS PLAN ARE LOCAL.
- 4- H.P.P. 100.00m CORRESPONDING TO 57.05 M.S.L.
- 5- SHOWED PIPING / PIPELINES AND RELEVANT SUPPORTS, ARE INDICATIVE.
- 6- DIMENSIONS OF W.H.C.P. AND RELEVANT SHELTER WILL BE FINALIZED.
- 7- REFERENCE COORDINATES X=1000000, Y=1000000 REFER TO E=43503.952, N=3294378.945, UTM, WGS84, ZONE 39 - NORTH
- 8- FOR DETAIL OF BURN PIT & ACCESS ROAD SITE
- BK-W035-PEDCO-110-CV-P1-0002

LEGEND & ABBREVIATIONS

- WP WORKING POINT ELEVATION (CENTER OF PIPE ELEVATION)
- PF PLATFORM
- BOP BOTTOM OF PIPE ELEVATION
- TOS TOP OF STEEL ELEVATION
- FGL FINISH GRADE LEVEL
- HFG HIGH POINT OF GRAVEL
- HPP HIGH POINT OF PAVEMENT
- MSL MEAN SEA LEVEL
- SS STRUCTURE SUPPORT
- PS PIPE SUPPORT
- SPS SPECIAL PIPE SUPPORT
- FCS FOR CONTINUE SEE
- SLOPE
- H.P.P. HIGH POINT PAVING
- W.H.C.P. WELL HEAD CONTROL PANEL
- FENCE
- MATCH LINE
- WELL LOCATION
- SURFACE WATER TRENCH
- GRATING

REFERENCE DRAWING	DRG. No.
GENERAL CIVIL LAYOUT - W035	BK-W035-PEDCO-110-CV-P1-0001
CIVIL AND STRUCTURAL DRAWINGS - W035	BK-W035-PEDCO-110-CV-P1-0002
ROAD - W035	BK-W035-PEDCO-110-PS-P1-0001
ROAD PLAN DRAWING - W035	BK-W035-PEDCO-110-PS-P1-0001
ROAD GRADING PLANS - W035	BK-W035-PEDCO-110-CV-DW-0001
ROAD LINE PLAN & PROFILE DRAWINGS - W035	BK-W035-PEDCO-110-SI-DW-0001
Standard Pipe Support Drawings	BK-SSBIL-PEDCO-110-PI-DW-0001



KEY PLAN

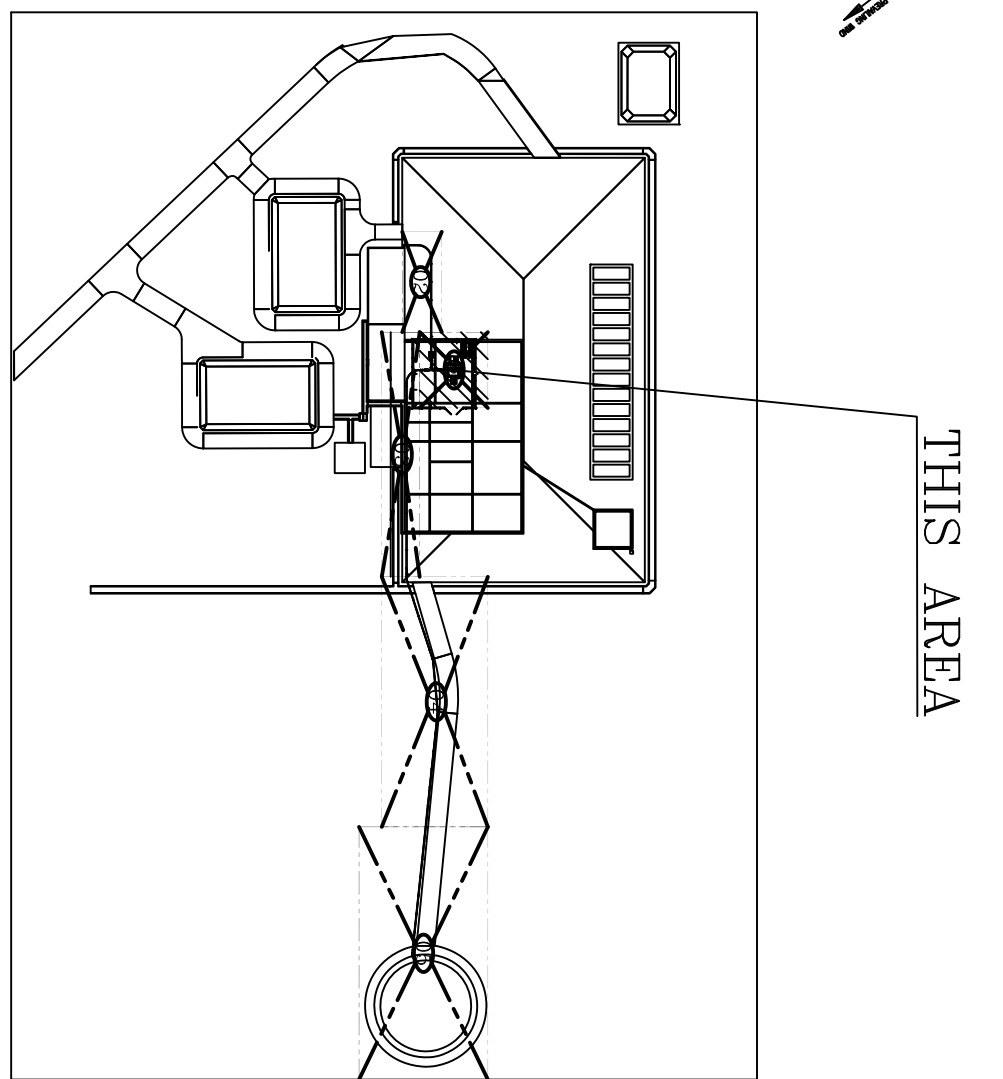

REV.	DESCRIPTION	BY	DATE	REV.	DATE
***	*****	***	****	***	****
DOO	MAY 2023	IPC	UNMOBI	MARABANI	ALMORSHINI
REV.	DATE	P.O.I.S	PREP.	CHK.	APP.
PROJECT NAME:	BINAK OUTFIELD DEVELOPMENT/SUB-SURFACE WORK PACKAGES				
PROJECT NO.:	971020				
EPC CONTRACTOR:	GENERAL CONTRACTOR:				

IRISGAN ENERGY - DESIGN & INSPECTION COMPANIES	PEDCO	PETROBRAN DEVELOPMENT COMPANY
DRAWING TITLE:	PINGING PLAN - W035	
SCALE	SIZE	DRAWING NO.
AS SHOWN	A0	BK-W035-PEDCO-110-PI-DW-0002

NO CONSTRUCTION PERMITTED UNLESS DRAWING APPROVED	BUDGET REF.	LOCATION	SIZE CLASS	SERIAL NO.	SHEET	REVISION
APPROVED FOR CONSTRUCTION	BY:	DATE:				
063-073-9194	P	4	L	707751	2 OF 4	DOO

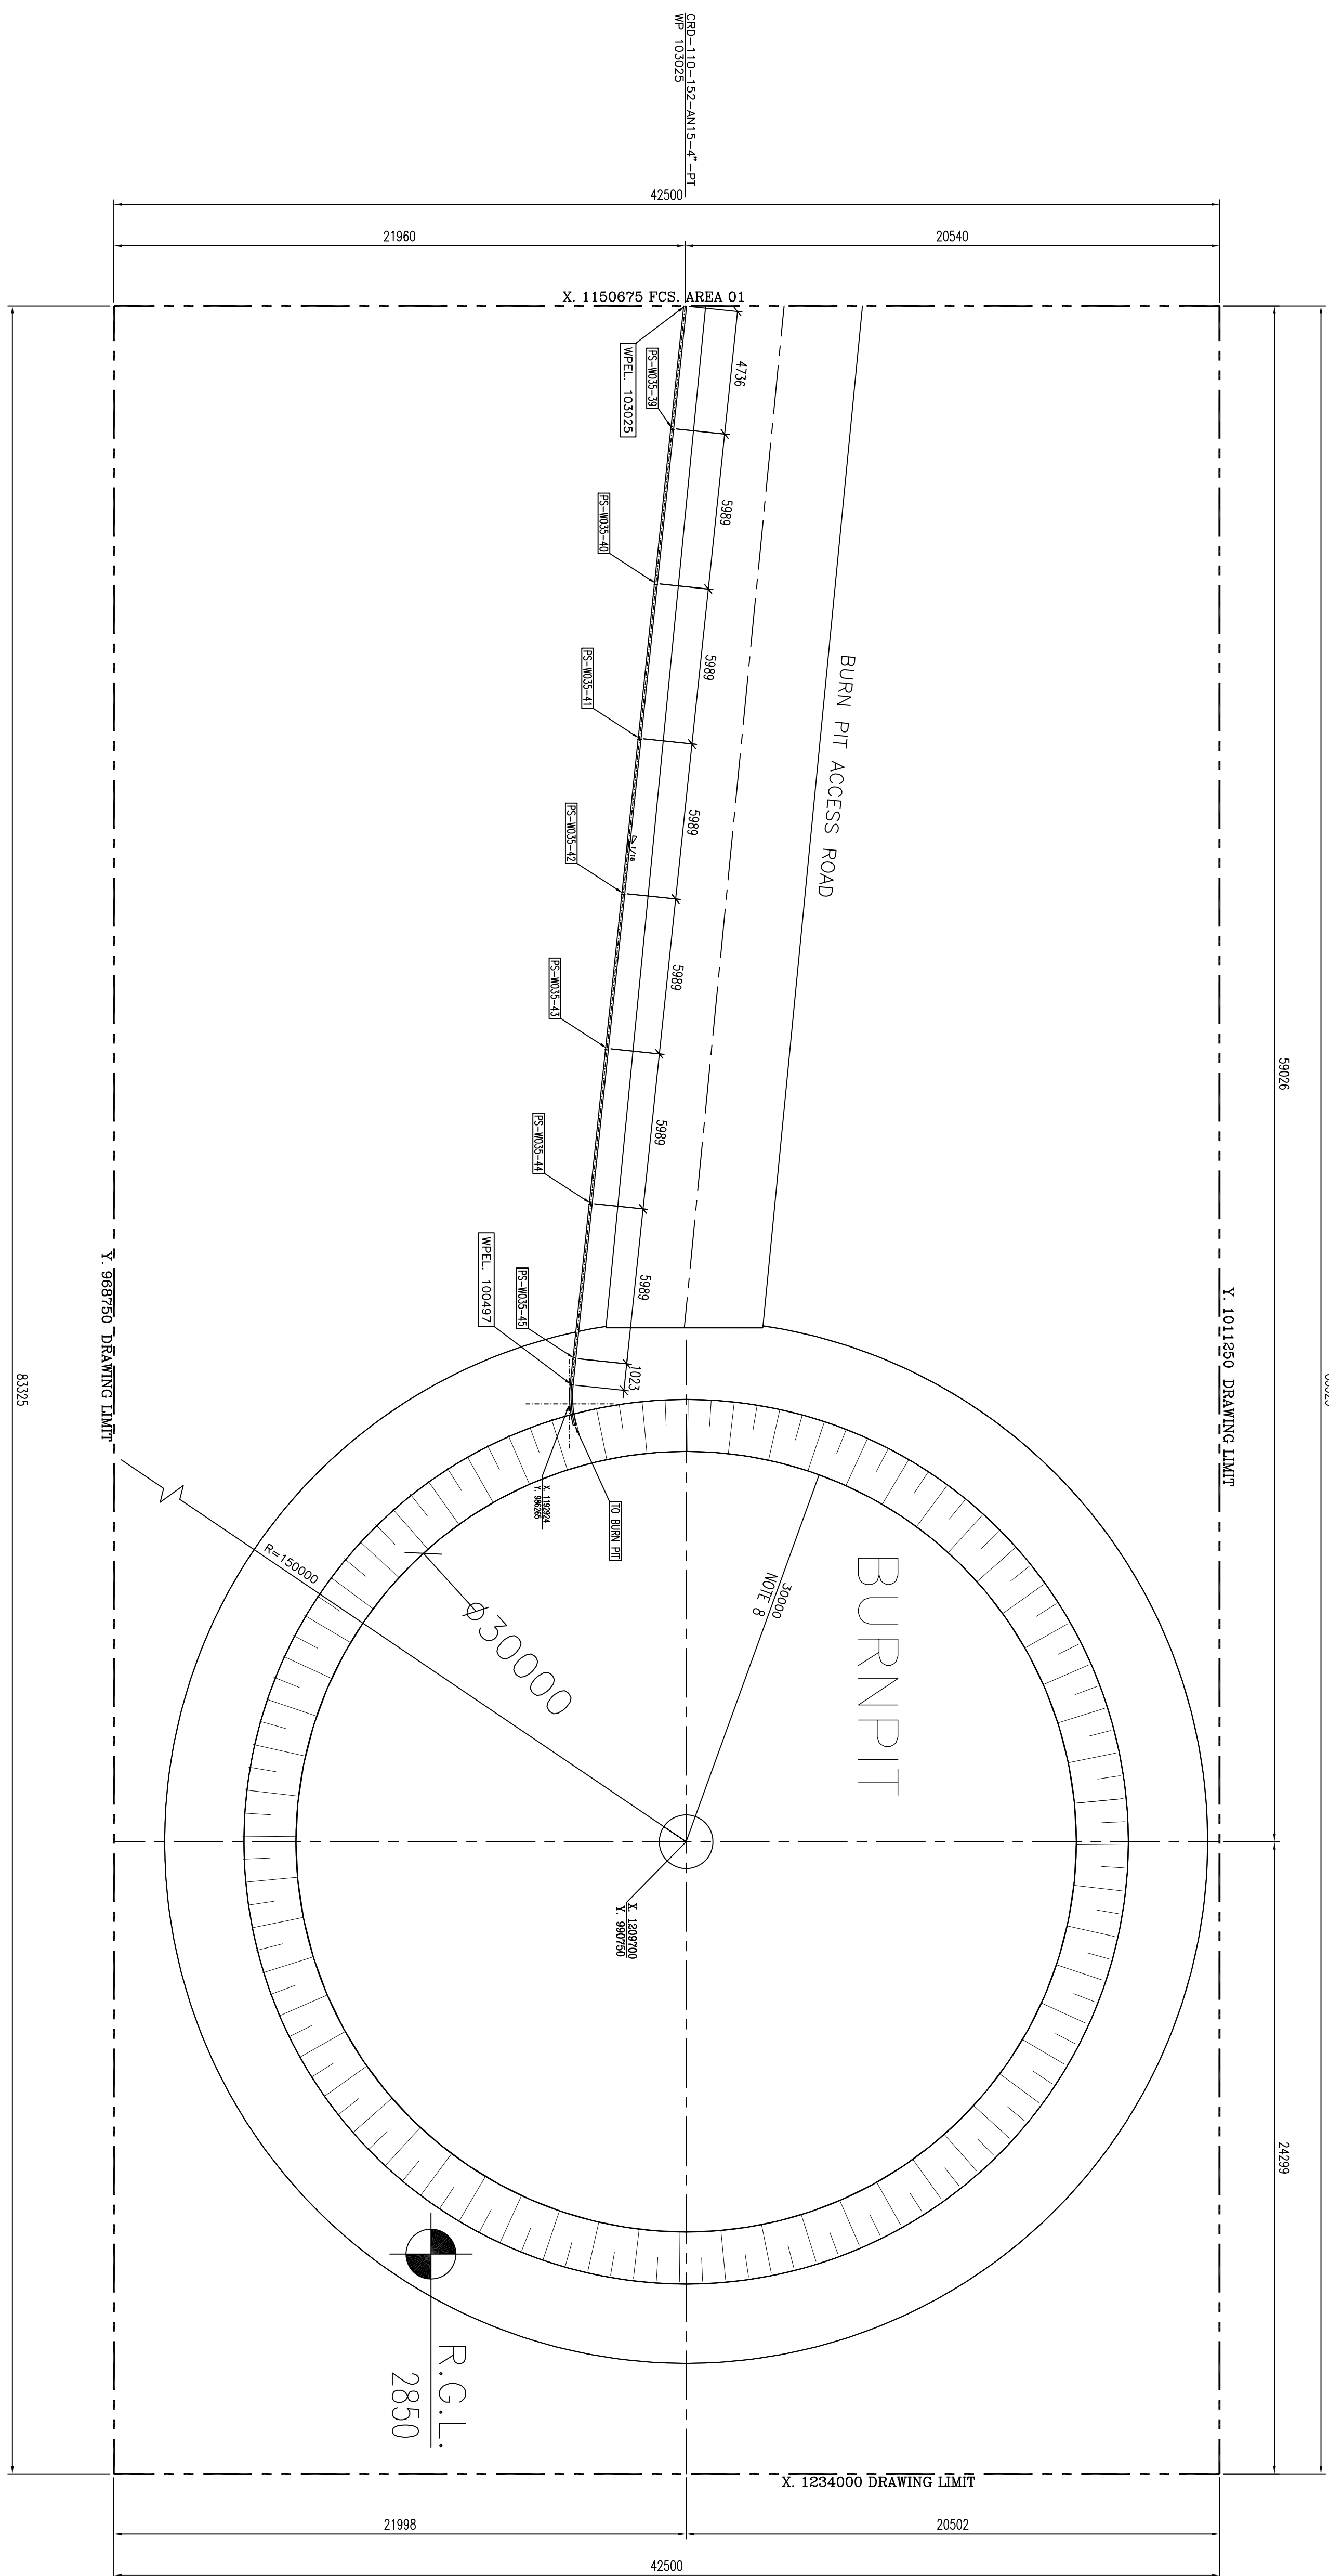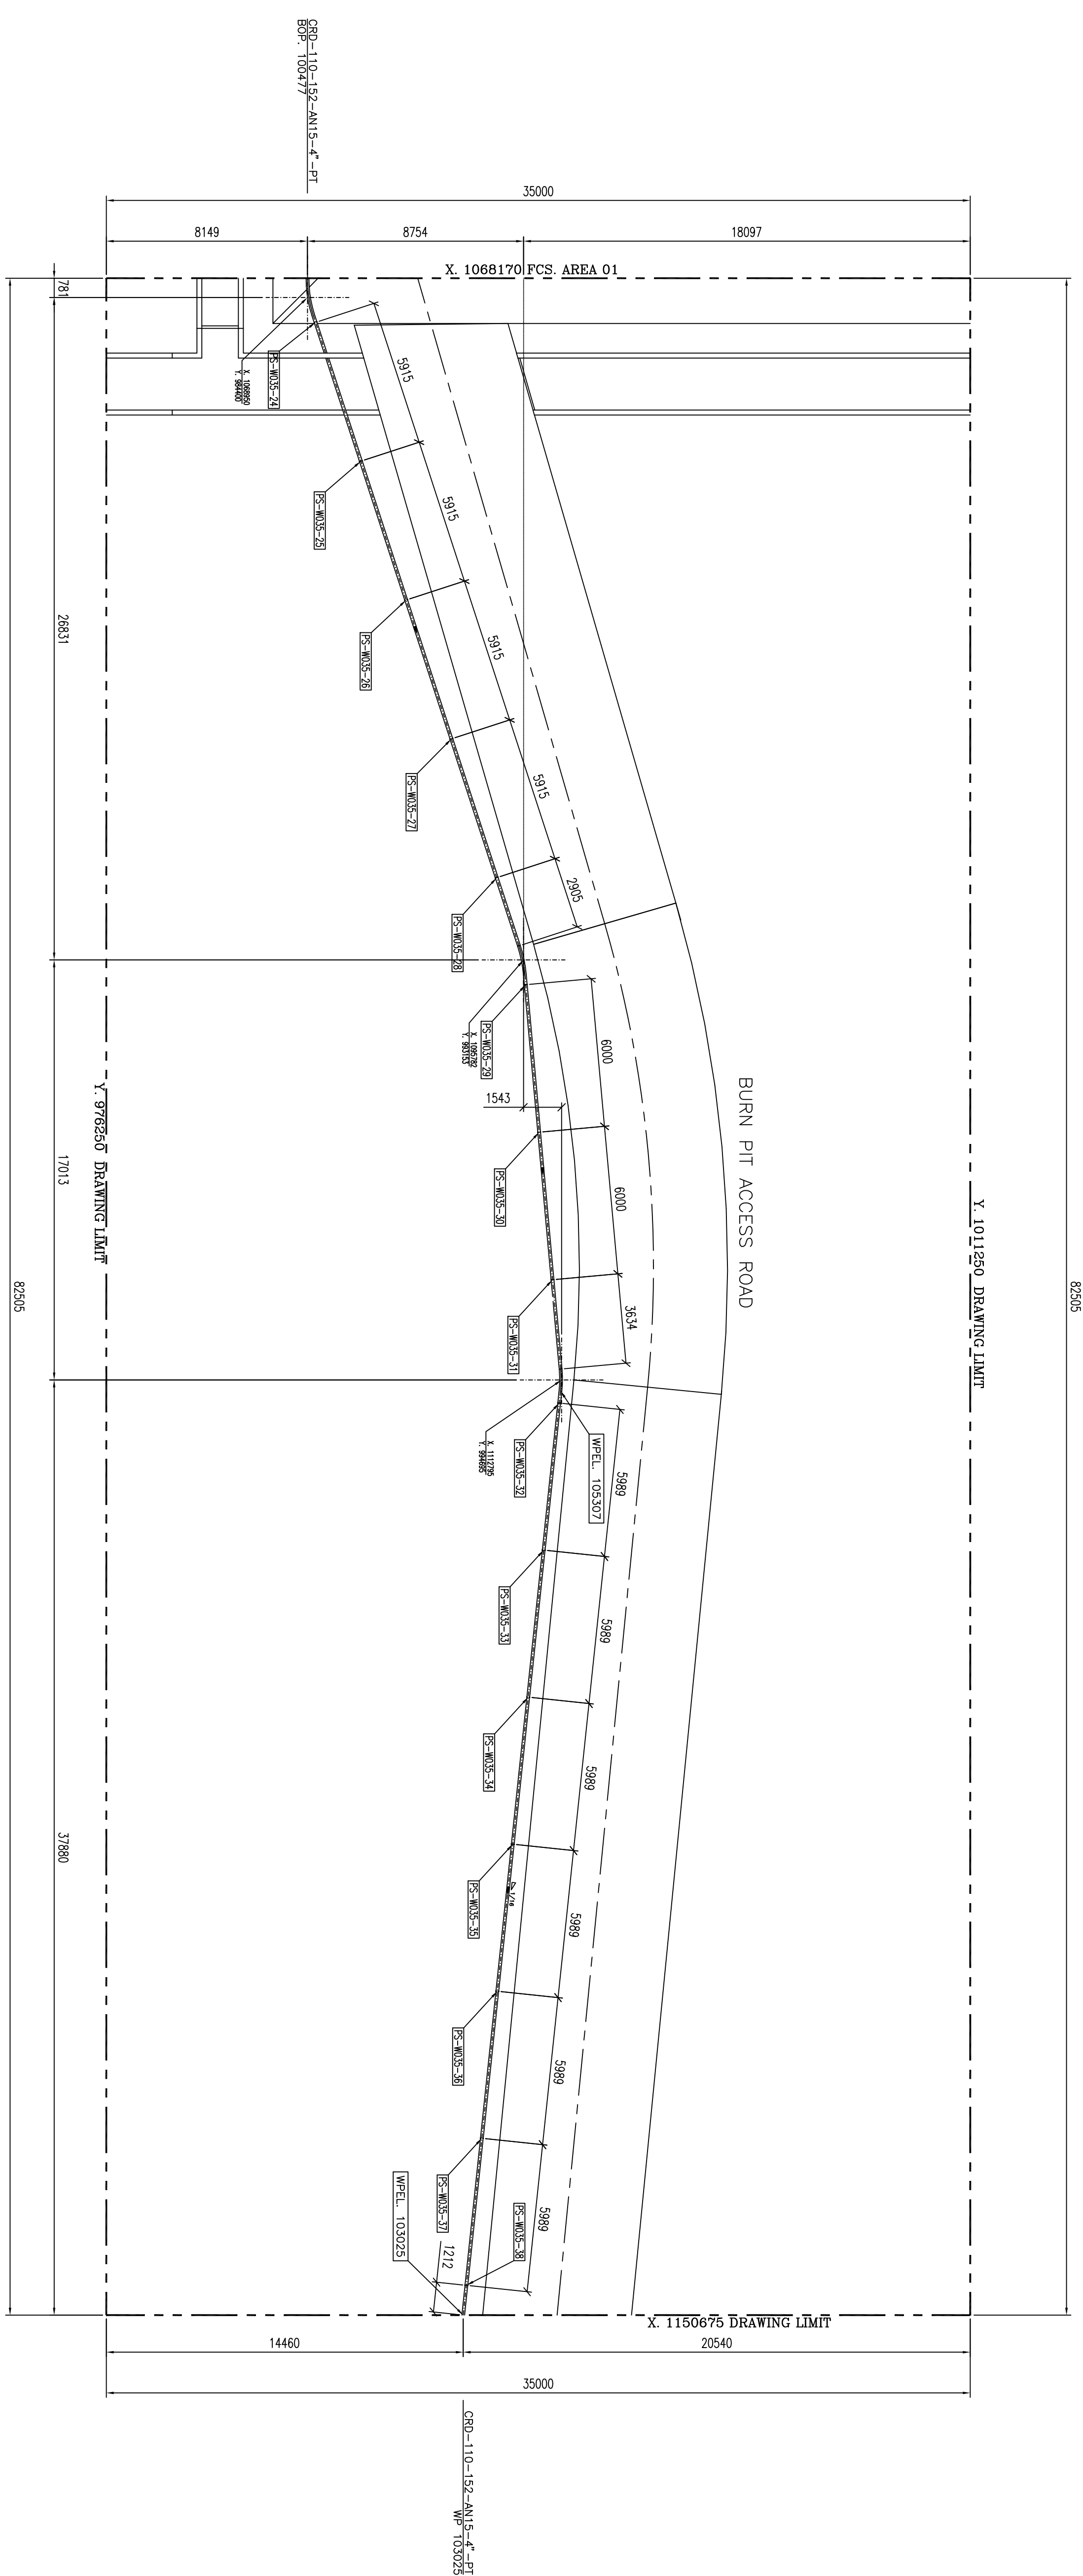

- 1.- ALL DIMENSIONS ARE IN MILLIMETERS, EXCEPT OTHERWISE NOTED.
- 2.- ALL ELEVATIONS ARE IN METERS.
- 3.- ALL COORDINATES OF THIS PLAN ARE 57.05 N.E.L.
- 4.- H.P. 100.00M CORRESPONDING TO 57.05 N.E.L.
- 5.- SHOWED PILING / PRELIMS AND RELEVANT SUPPORTS, ARE INDICATIVE.
- 6.- DIMENSIONS OF W.H.C.P. AND RELEVANT SHELTER WILL BE FINALIZED.
- 7.- REFERENCE COORDINATES X=1000000, Y=1000000 REFER TO E=4356603.9452, N=3294378.9145 UTM, WGS84 ZONE 39 - NORTH
- 8.- FOR DETAIL OF BURN PIT & ACCESS ROAD SEE BK-W035-PEOCO-110-CV-PY-00002