


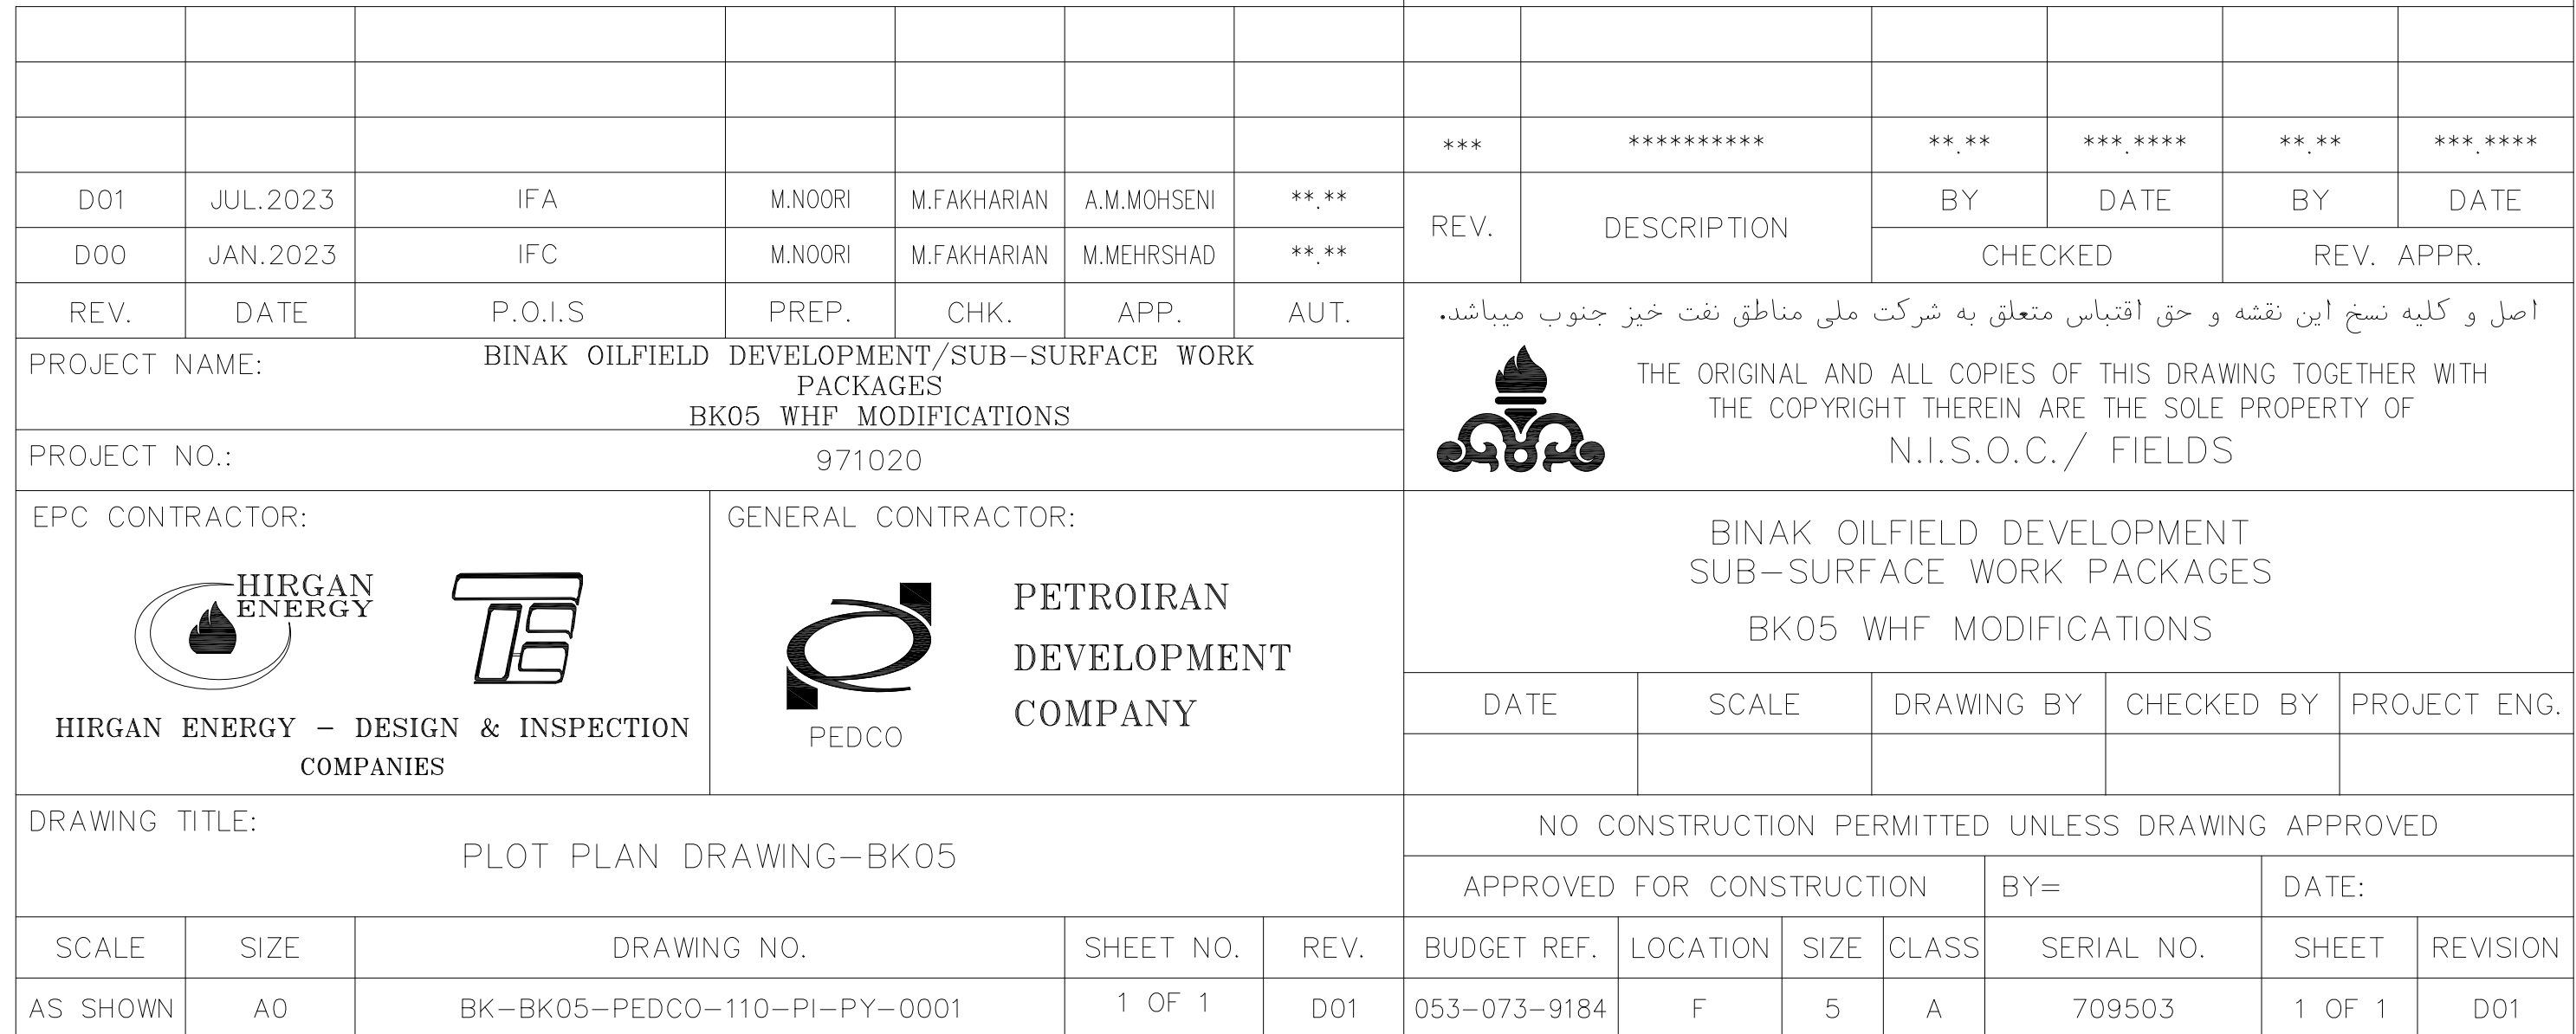

TAG NO.	AREA LIST
(01)	FUEL TANK
(02)	SECURITY ROOM
(03)	SWITCHGEAR
(04)	WATER TANK
(05)	FIRE FIGHTING SHELTER
(06)	DIESEL GENERATOR SHELTER
(07)	IRP PUMP

NOTES

1-	ALL DIMENSIONS ARE IN MILLIMETERS, EXCEPT OTHERWISE NOTED.
2-	ALL ELEVATIONS ARE IN METERS.
3-	ALL COORDINATES OF THIS PLAN ARE LOCAL.
4-	H.P.P. 100.00m CORRESPONDING TO 58.77 M.S.L.
5-	SHOWED PIPING / PIPELINES AND RELEVANT SUPPORTS, ARE INDICATIVE.
6-	PLEASE SEE BK-BK05-PEDCO-110-CV-PY-0001 FOR DETAIL OF CIVIL WORKS AND ROADS
7-	REFERENCE COORDINATES X=1000.00, Y=1000.00 REFER TO E=441692.205, N=3286503.797 UTM. WGS84 ZONE 39 - NORTH

LEGEND & ABBREVIATIONS	
H.P.P.	HIGH POINT PAVING
W.H.C.P.	WELL HEAD CONTROL PANEL
	FENCE
	MATCH LINE
	WELL LOCATION
	SURFACE WATER TRENCH
	GRATING
	ELECTRICAL OVERHEAD LINE

REFERENCE	DRAWING	DRG. No.
GENERAL CIVIL LAYOUT	~ BK05	BK-BK05-PEDCO-110-CV-PY-0001
CIVIL AND STRUCTURAL DRAWINGS	~ BK05	BK-BK05-PEDCO-110-CV-DW-0001
OVER HEAD LINE PLAN AND PROFILE	~ BK05	BK-BK05-PEDCO-110-SU-DW-0001
ARCHITECTURAL DRAWING FOR SWITCHGEAR BUILDING OF WELL PADS	~ BK-05	BK-BK05-PEDCO-110-AR-DW-0002
ARCHITECTURAL DRAWING FOR SECURITY BUILDING OF WELL PADS	~ BK-05	BK-BK05-PEDCO-110-AR-DW-0003

