


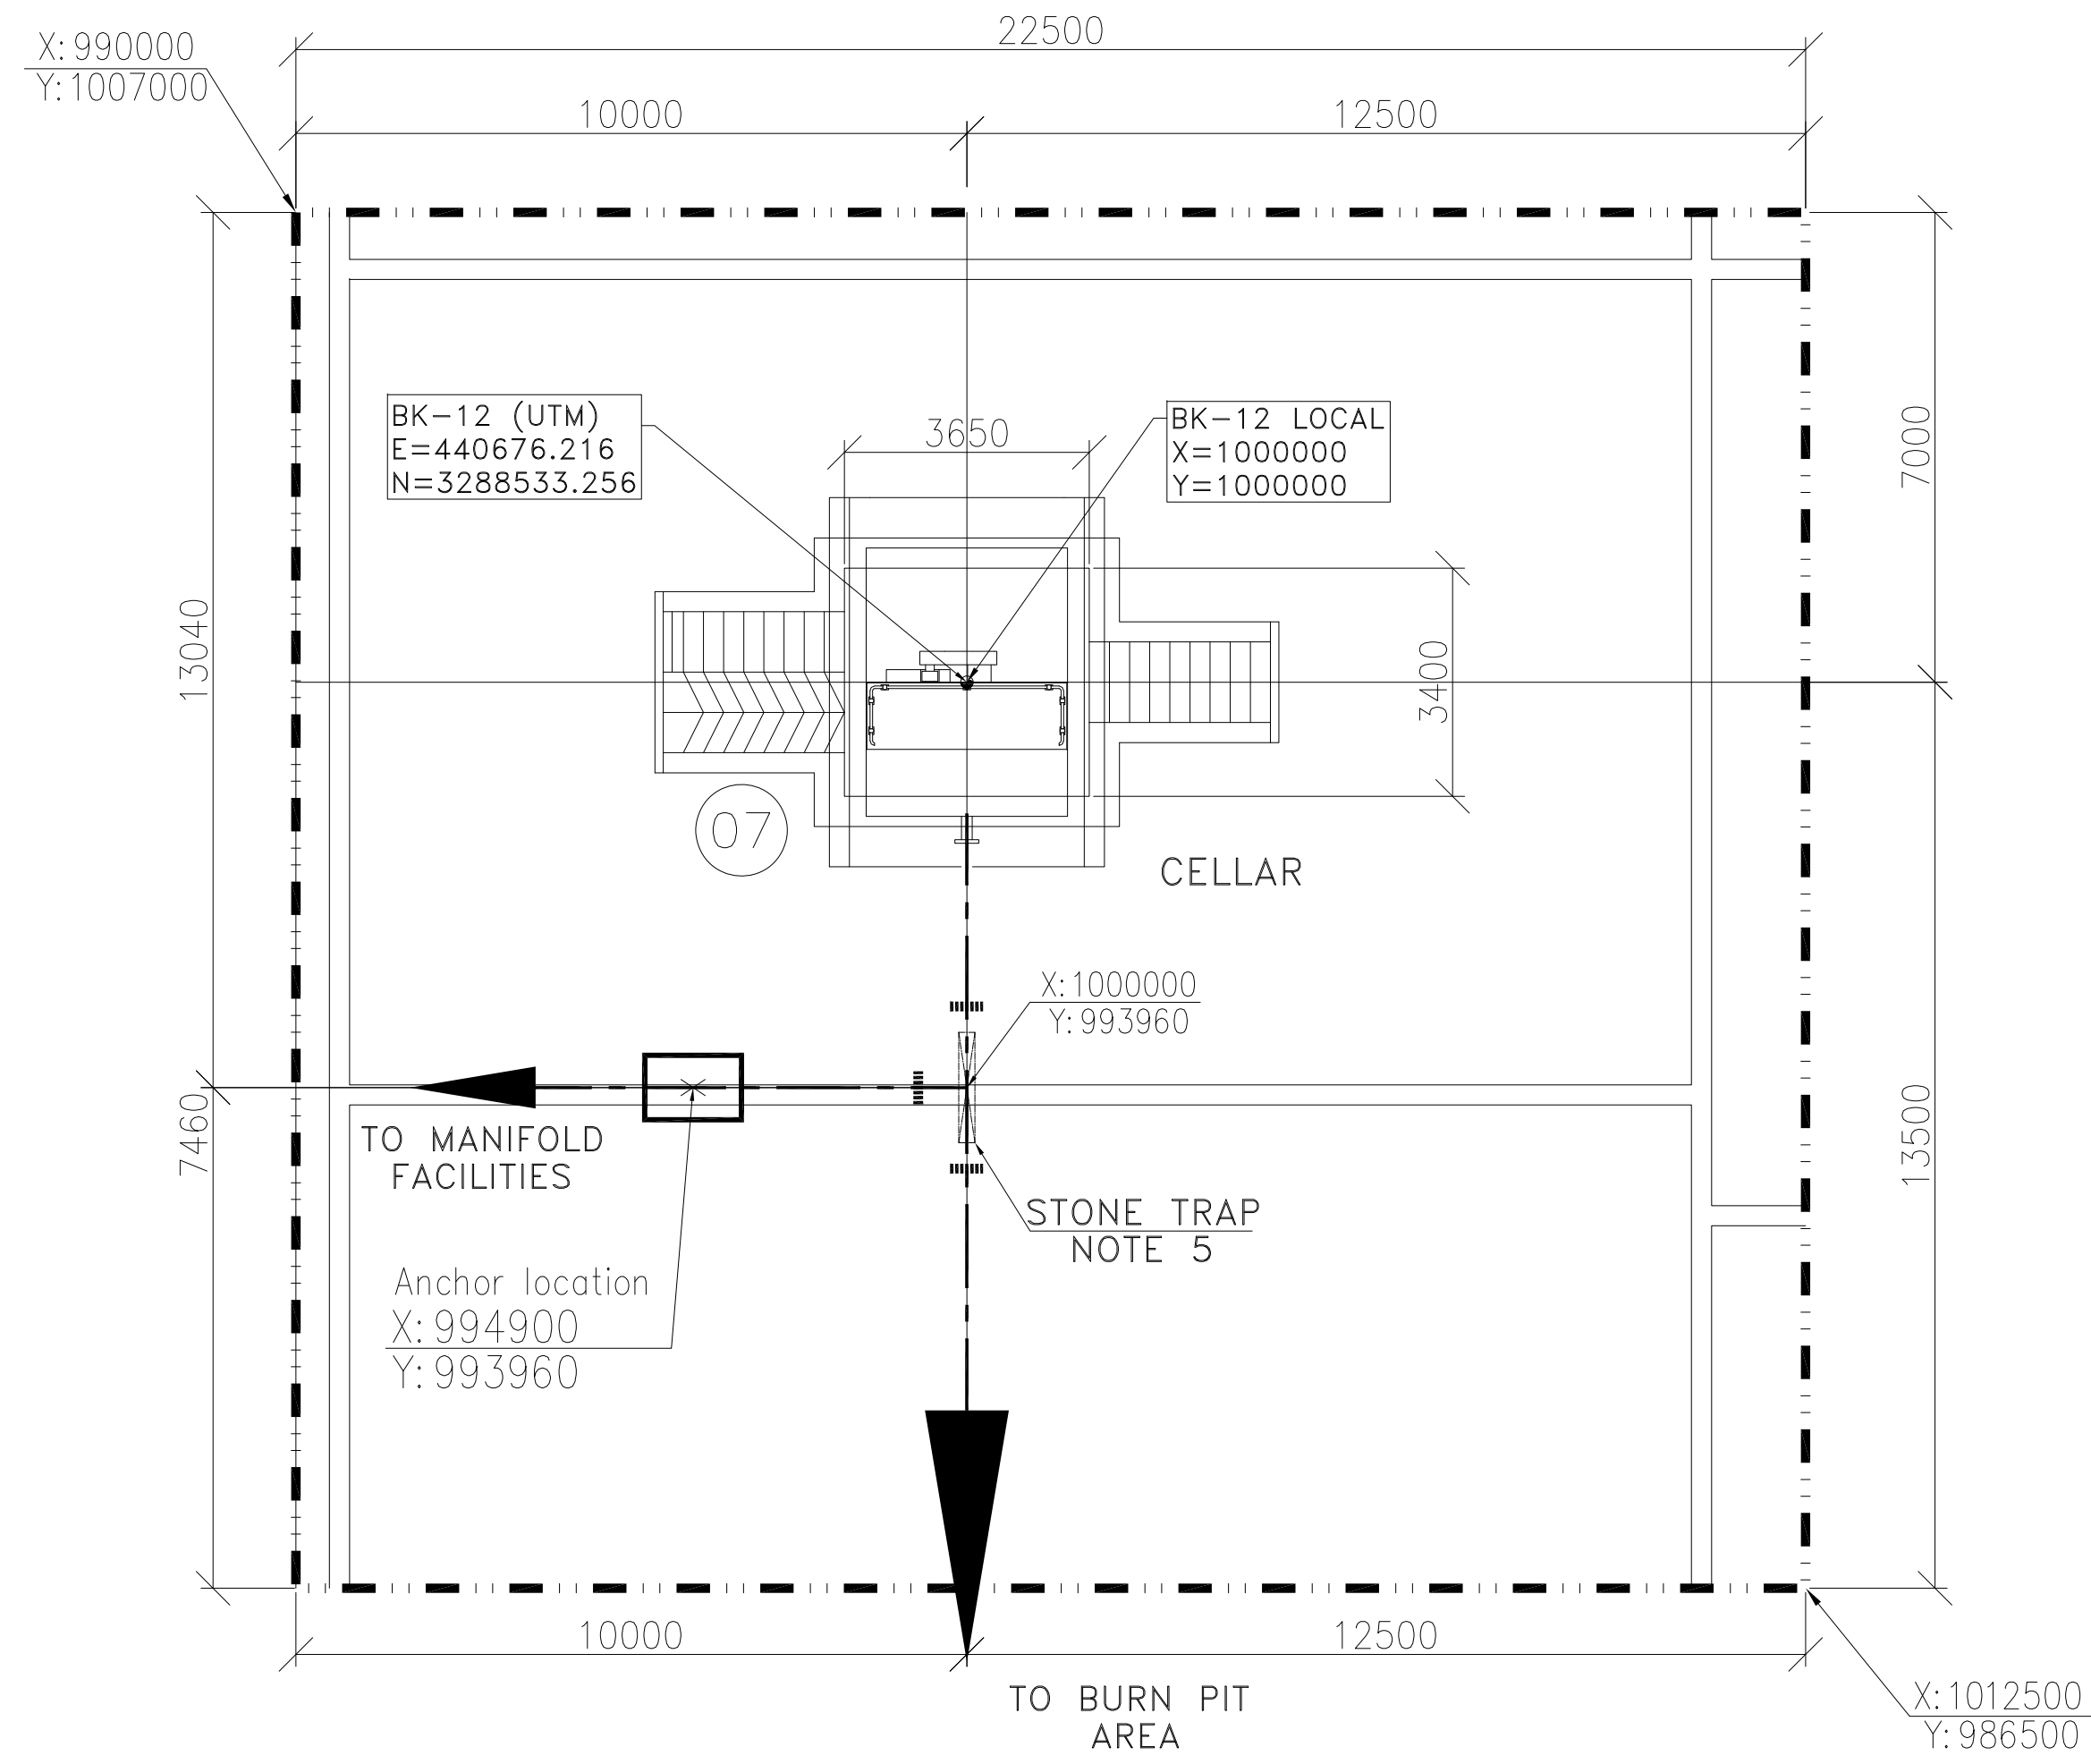

DETAIL A

SC: 1/100

TAG NO.	AREA LIST
01	FUEL TANK
02	SECURITY ROOM
03	SWITCHGEAR
04	WATER TANK
05	FIRE FIGHTING SHELTER
06	DIESEL GENERATOR SHELTER
07	IRP PUMP


[illegible]

NOTES	
1 -	ALL DIMENSIONS ARE IN MILLIMETERS, EXCEPT OTHERWISE NOTED.
2 -	ALL ELEVATIONS ARE IN METERS.
3 -	ALL COORDINATES OF THIS PLAN ARE LOCAL.
4 -	H.P.P. 100.00M CORRESPONDING TO 75.40 M.S.L.
5 -	SHOWED PIPING / PIPELINES AND RELEVANT SUPPORTS, ARE INDICATIVE.
6 -	PLEASE SEE BK-BK05-PDC0-110-CV-PY-0001 FOR DETAIL OF CIVIL WORKS AND ROADS
7 -	REFERENCE COORDINATES = E=1000.00, N=1000.00 REFER TO X=440676.216 , Y=328853.256 UTM. WGS84 ZONE 39 - NORTH

LEGEND & ABBREVIATIONS	
H.P.P.	HIGH POINT PAVING
F.G.L.	FINAL GRADING LEVEL
W.H.C.P.	WELL HEAD CONTROL PANEL
	FENCE
	MATCH LINE
	WELL LOCATION
	SURFACE WATER TRENCH
	GRATING
	BURN PIT LINE

REFERENCE DRAWING	DRG. No.
GENERAL CIVIL LAYOUT - BK12	BK-BK12-PEDCO-110-CV-PY-0001
CIVIL AND STRUCTURAL DRAWINGS - BK12	BK-BK12-PEDCO-110-CV-DW-0001
OVER HEAD LINE PLAN AND PROFILE - BK12	BK-BK12-PEDCO-110-SU-DW-0001
ARCHITECTURAL DRAWING FOR SECURITY BUILDING OF WELL PADS - BK-12	BK-BK12-PEDCO-110-AR-DW-0003
ARCHITECTURAL DRAWING FOR SWITCHGEAR BUILDING OF WELL PADS - BK-12	BK-BK12-PEDCO-110-SU-DW-0001

KEY PLAN

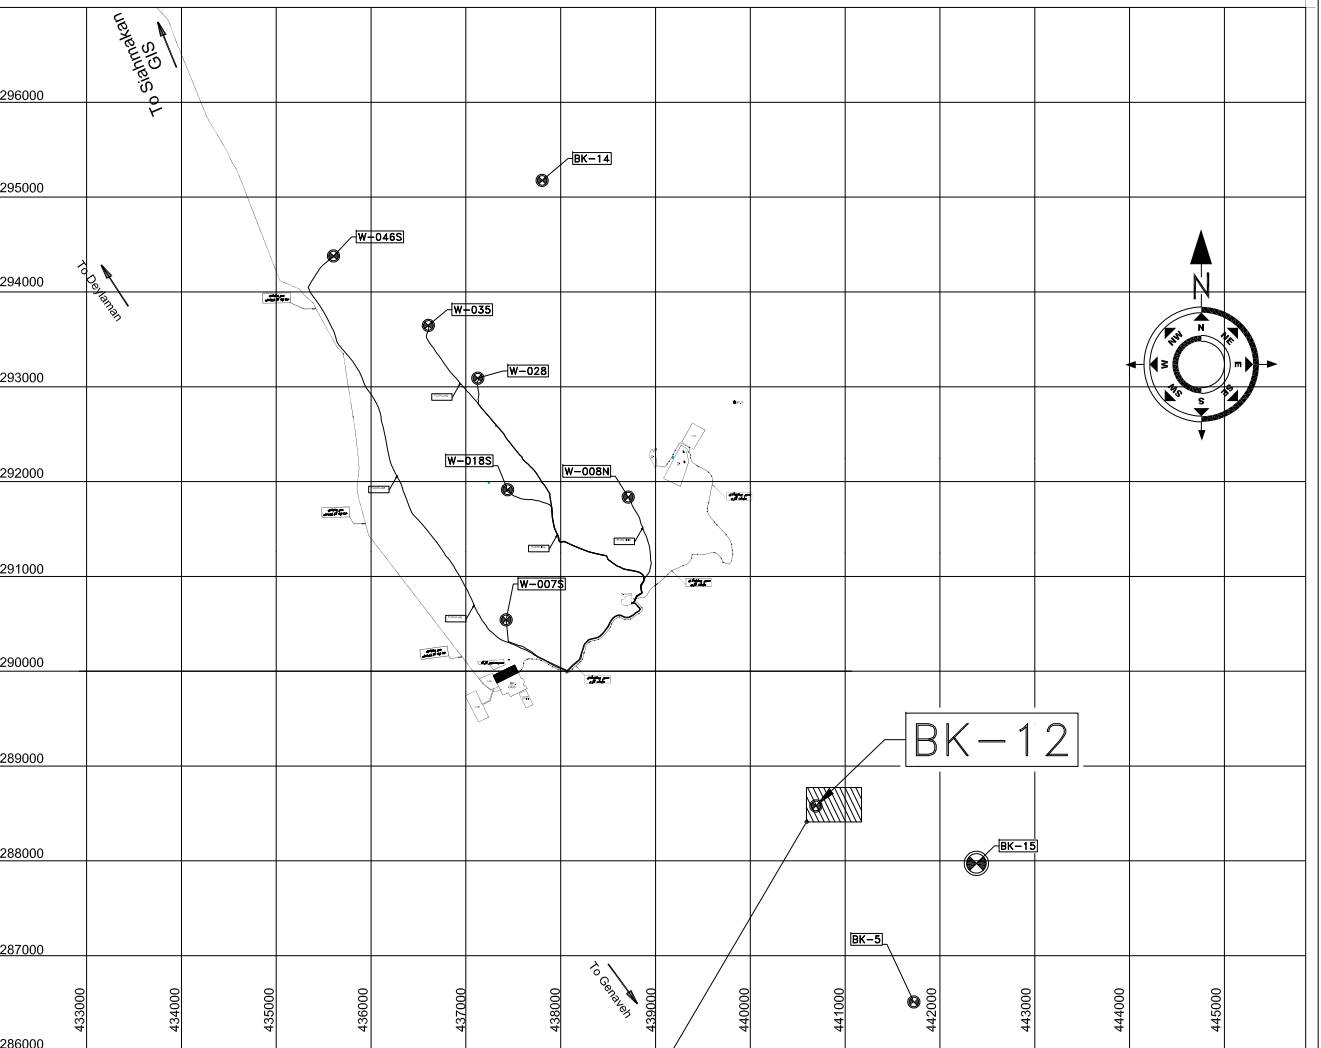

THIS AREA