


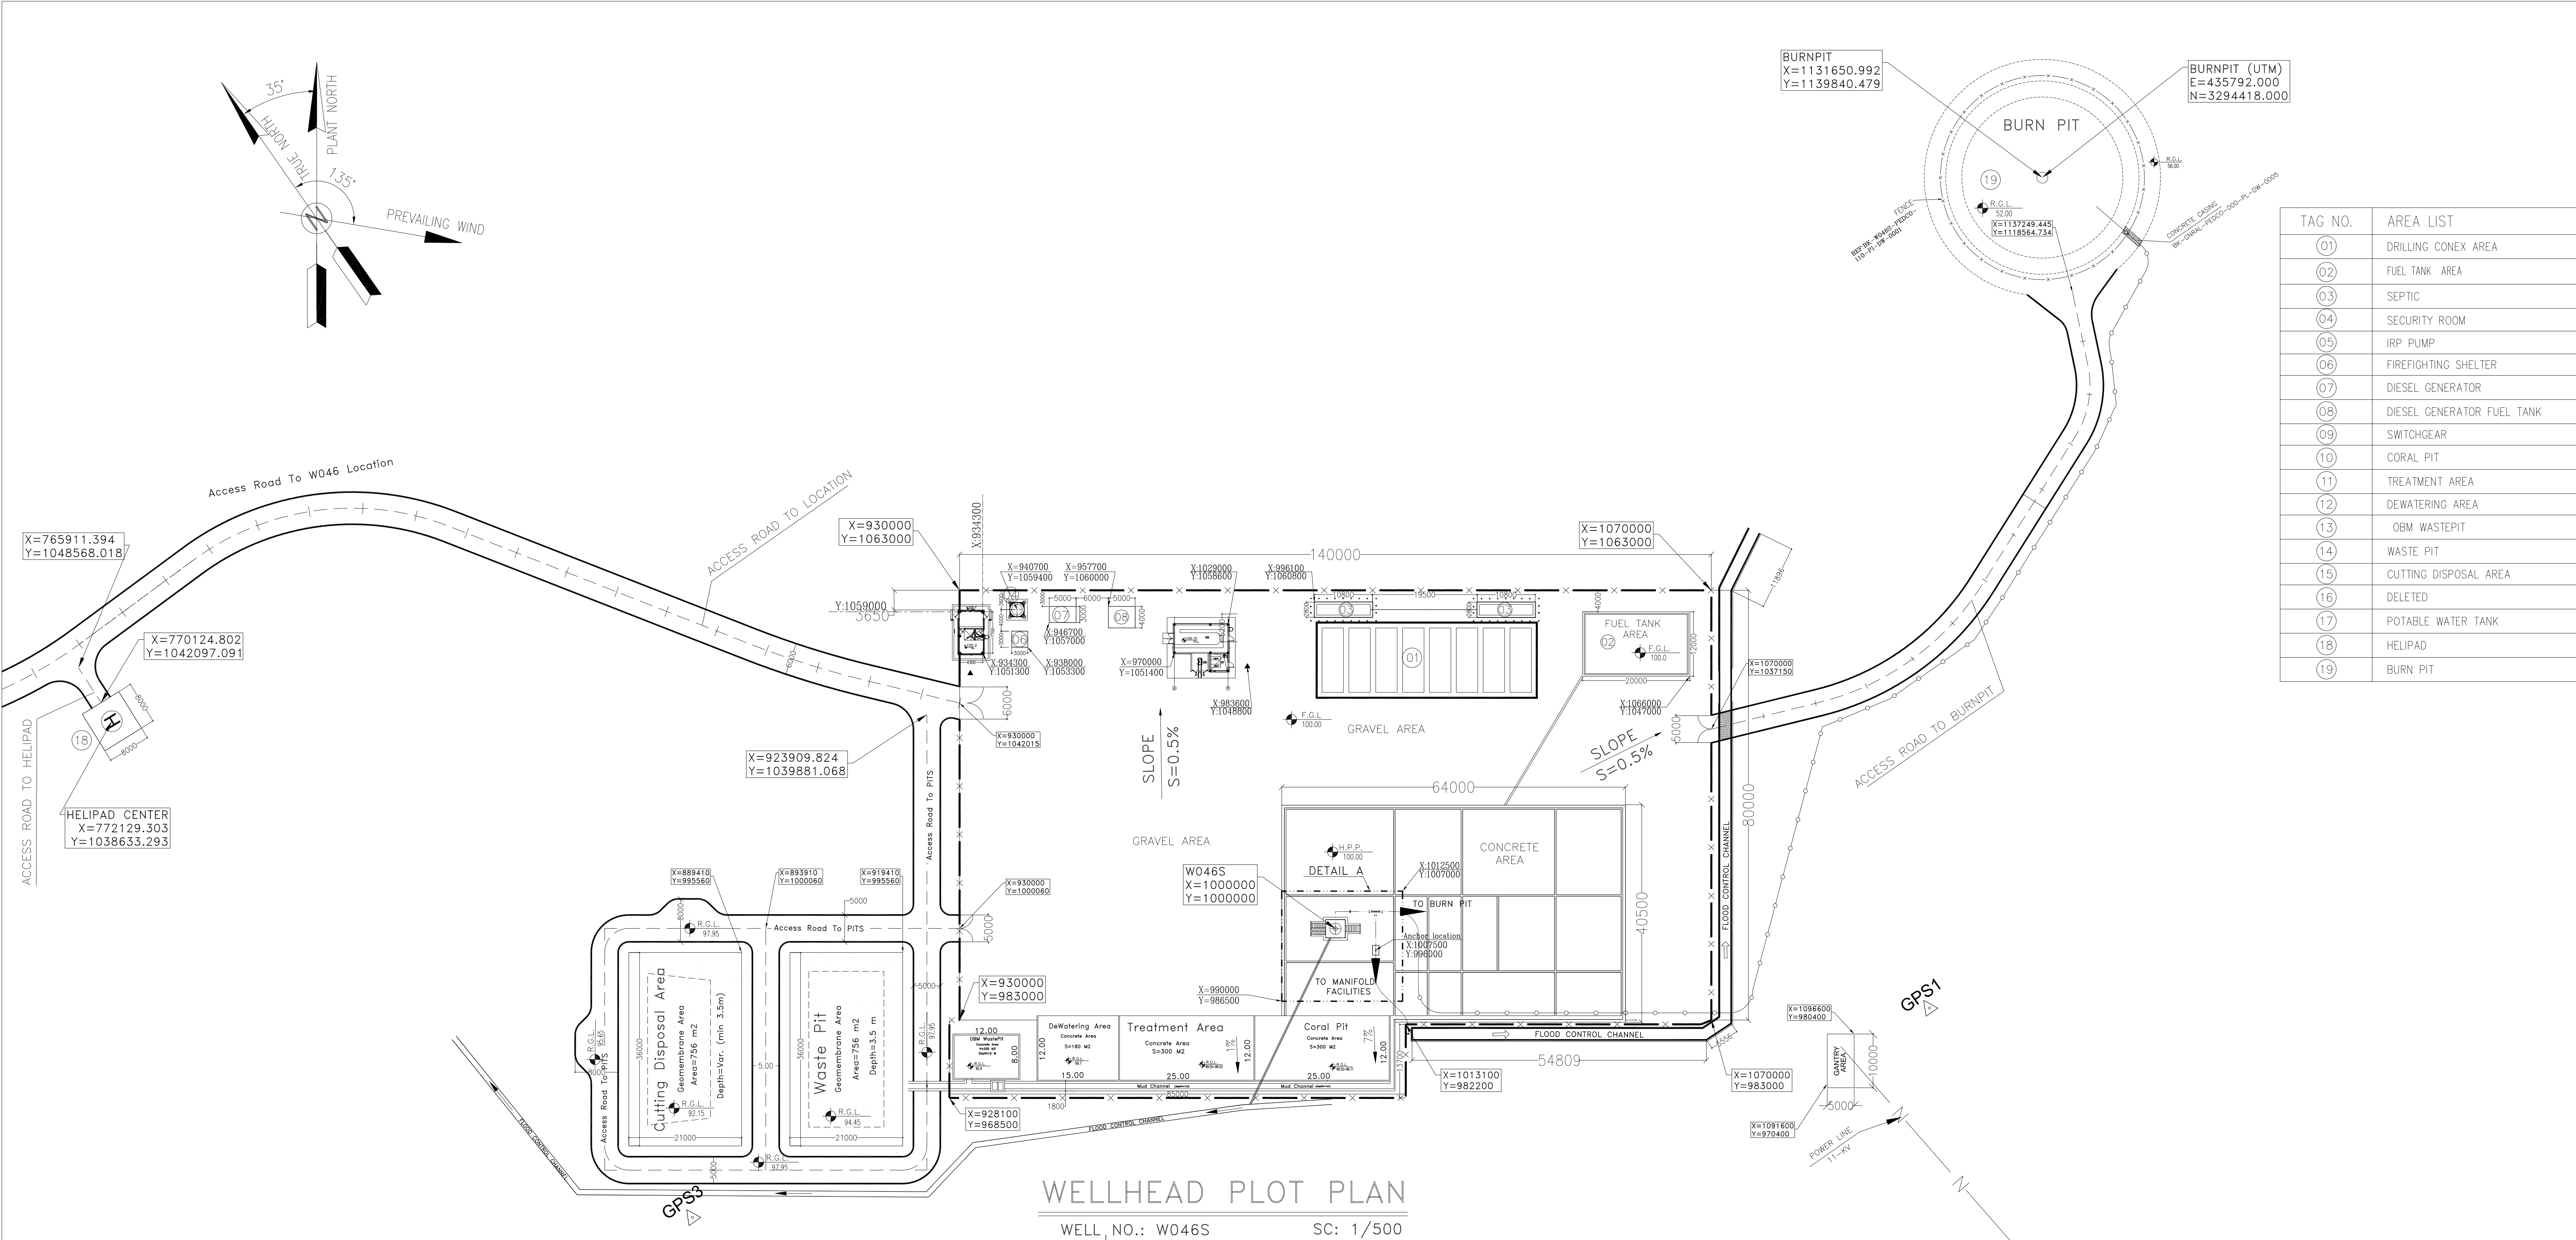


TAG NO.	AREA LIST
01	DRILLING CONEX AREA
02	FUEL TANK AREA
03	SEPTIC
04	SECURITY ROOM
05	IRP PUMP
06	FIREFIGHTING SHELTER
07	DIESEL GENERATOR
08	DIESEL GENERATOR FUEL TANK
09	SWITCHGEAR
10	CORAL PIT
11	TREATMENT AREA
12	DEWATERING AREA
13	OBM WASTE PIT
14	WASTE PIT
15	CUTTING DISPOSAL AREA
16	DELETED
17	POTABLE WATER TANK
18	HELIPAD
19	BURN PIT

- NOTES
- 1- ALL DIMENSIONS ARE IN MILLIMETERS, EXCEPT OTHERWISE NOTED.
 - 2- ALL ELEVATIONS ARE IN METERS.
 - 3- ALL COORDINATES OF THIS PLAN ARE LOCAL.
 - 4- H.P.P. 100.00m CORRESPONDING TO 57.05 M.S.L.
 - 5- SHOWED PIPING / PIPELINES AND RELEVANT SUPPORTS, ARE INDICATIVE.
 - 6- DIMENSIONS OF W.H.C.P. AND RELEVANT SHELTER WILL BE FINALIZED.
 - 7- REFERENCE COORDINATES X=1000.000 , Y=1000.000 REFER TO E=435603.952 , N=3294378.945 UTM. WGS84 ZONE 39 - NORTH
 - 8- FOR DETAIL OF BURN PIT & ACCESS ROAD SEE BK-W046S-PEDCO-110-CV-PY-0002


LEGEND & ABBREVIATIONS	
H.P.P.	HIGH POINT PAVING
W.H.C.P.	WELL HEAD CONTROL PANEL
---	FENCE
---	MATCH LINE
○	WELL LOCATION
---	SURFACE WATER TRENCH
---	GRATING
H	HELIPAD
—N—	ELECTRICAL OVERHEAD LINE
○—○	BURN PIT LINE
▲	LIGHTING POLE

REFERENCE DRAWING	DRG. No.
GENERAL CIVIL LAYOUT - W046S	BK-W046S-PEDCO-110-CV-PY-0001
CIVIL AND STRUCTURAL DRAWINGS - W046S	BK-W046S-PEDCO-110-CV-PY-0002
PRID - W046S	BK-W046S-PEDCO-110-PR-PY-0001
PIPING PLAN - W046S	BK-W046S-PEDCO-110-PI-DW-0002
PLATFORM STRUCTURE DRAWING - W046S	BK-W046S-PEDCO-110-ST-DW-0012
FLOW LINE PLAN & PROFILE DRAWINGS - W046S	BK-W046S-PEDCO-110-SU-DW-0001
CABLE ROUTE LAYOUT FOR ELECTRICAL TOWER (GANTRY) OF WELL PAIRS	BK-SSGRU-PEDCO-110-EL-PY-0002
ARCHITECTURAL DRAWING FOR SWITCHGEAR BUILDING OF WELL PAIRS - W046S	BK-W046S-PEDCO-110-AR-DW-0003

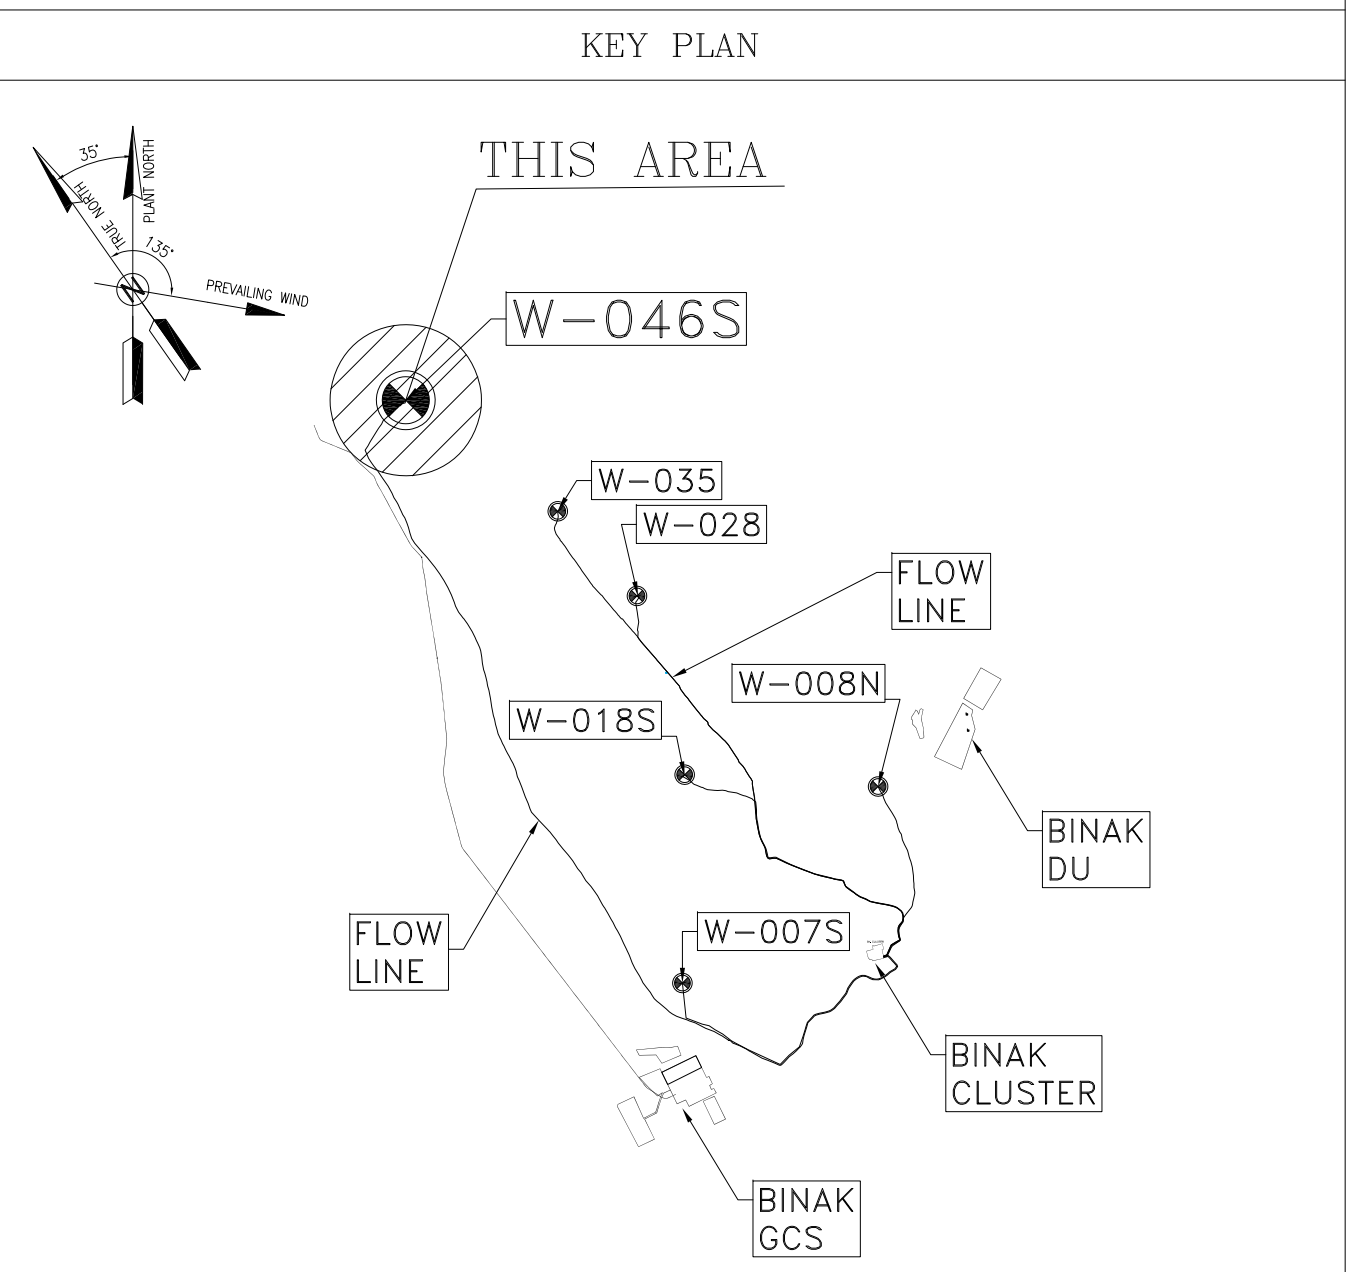

Coordinate of Bench Marks (UTM)			
Points	Northing (m)	Easting (m)	Elevation (m)
BM48	435082.354	3294748.888	41.668
GPS3	435475.560	3294403.536	66.866
GPS1	435686.115	3294303.397	76.025

WELLHEAD PLOT PLAN
WELL, NO.: W046S SC: 1/500

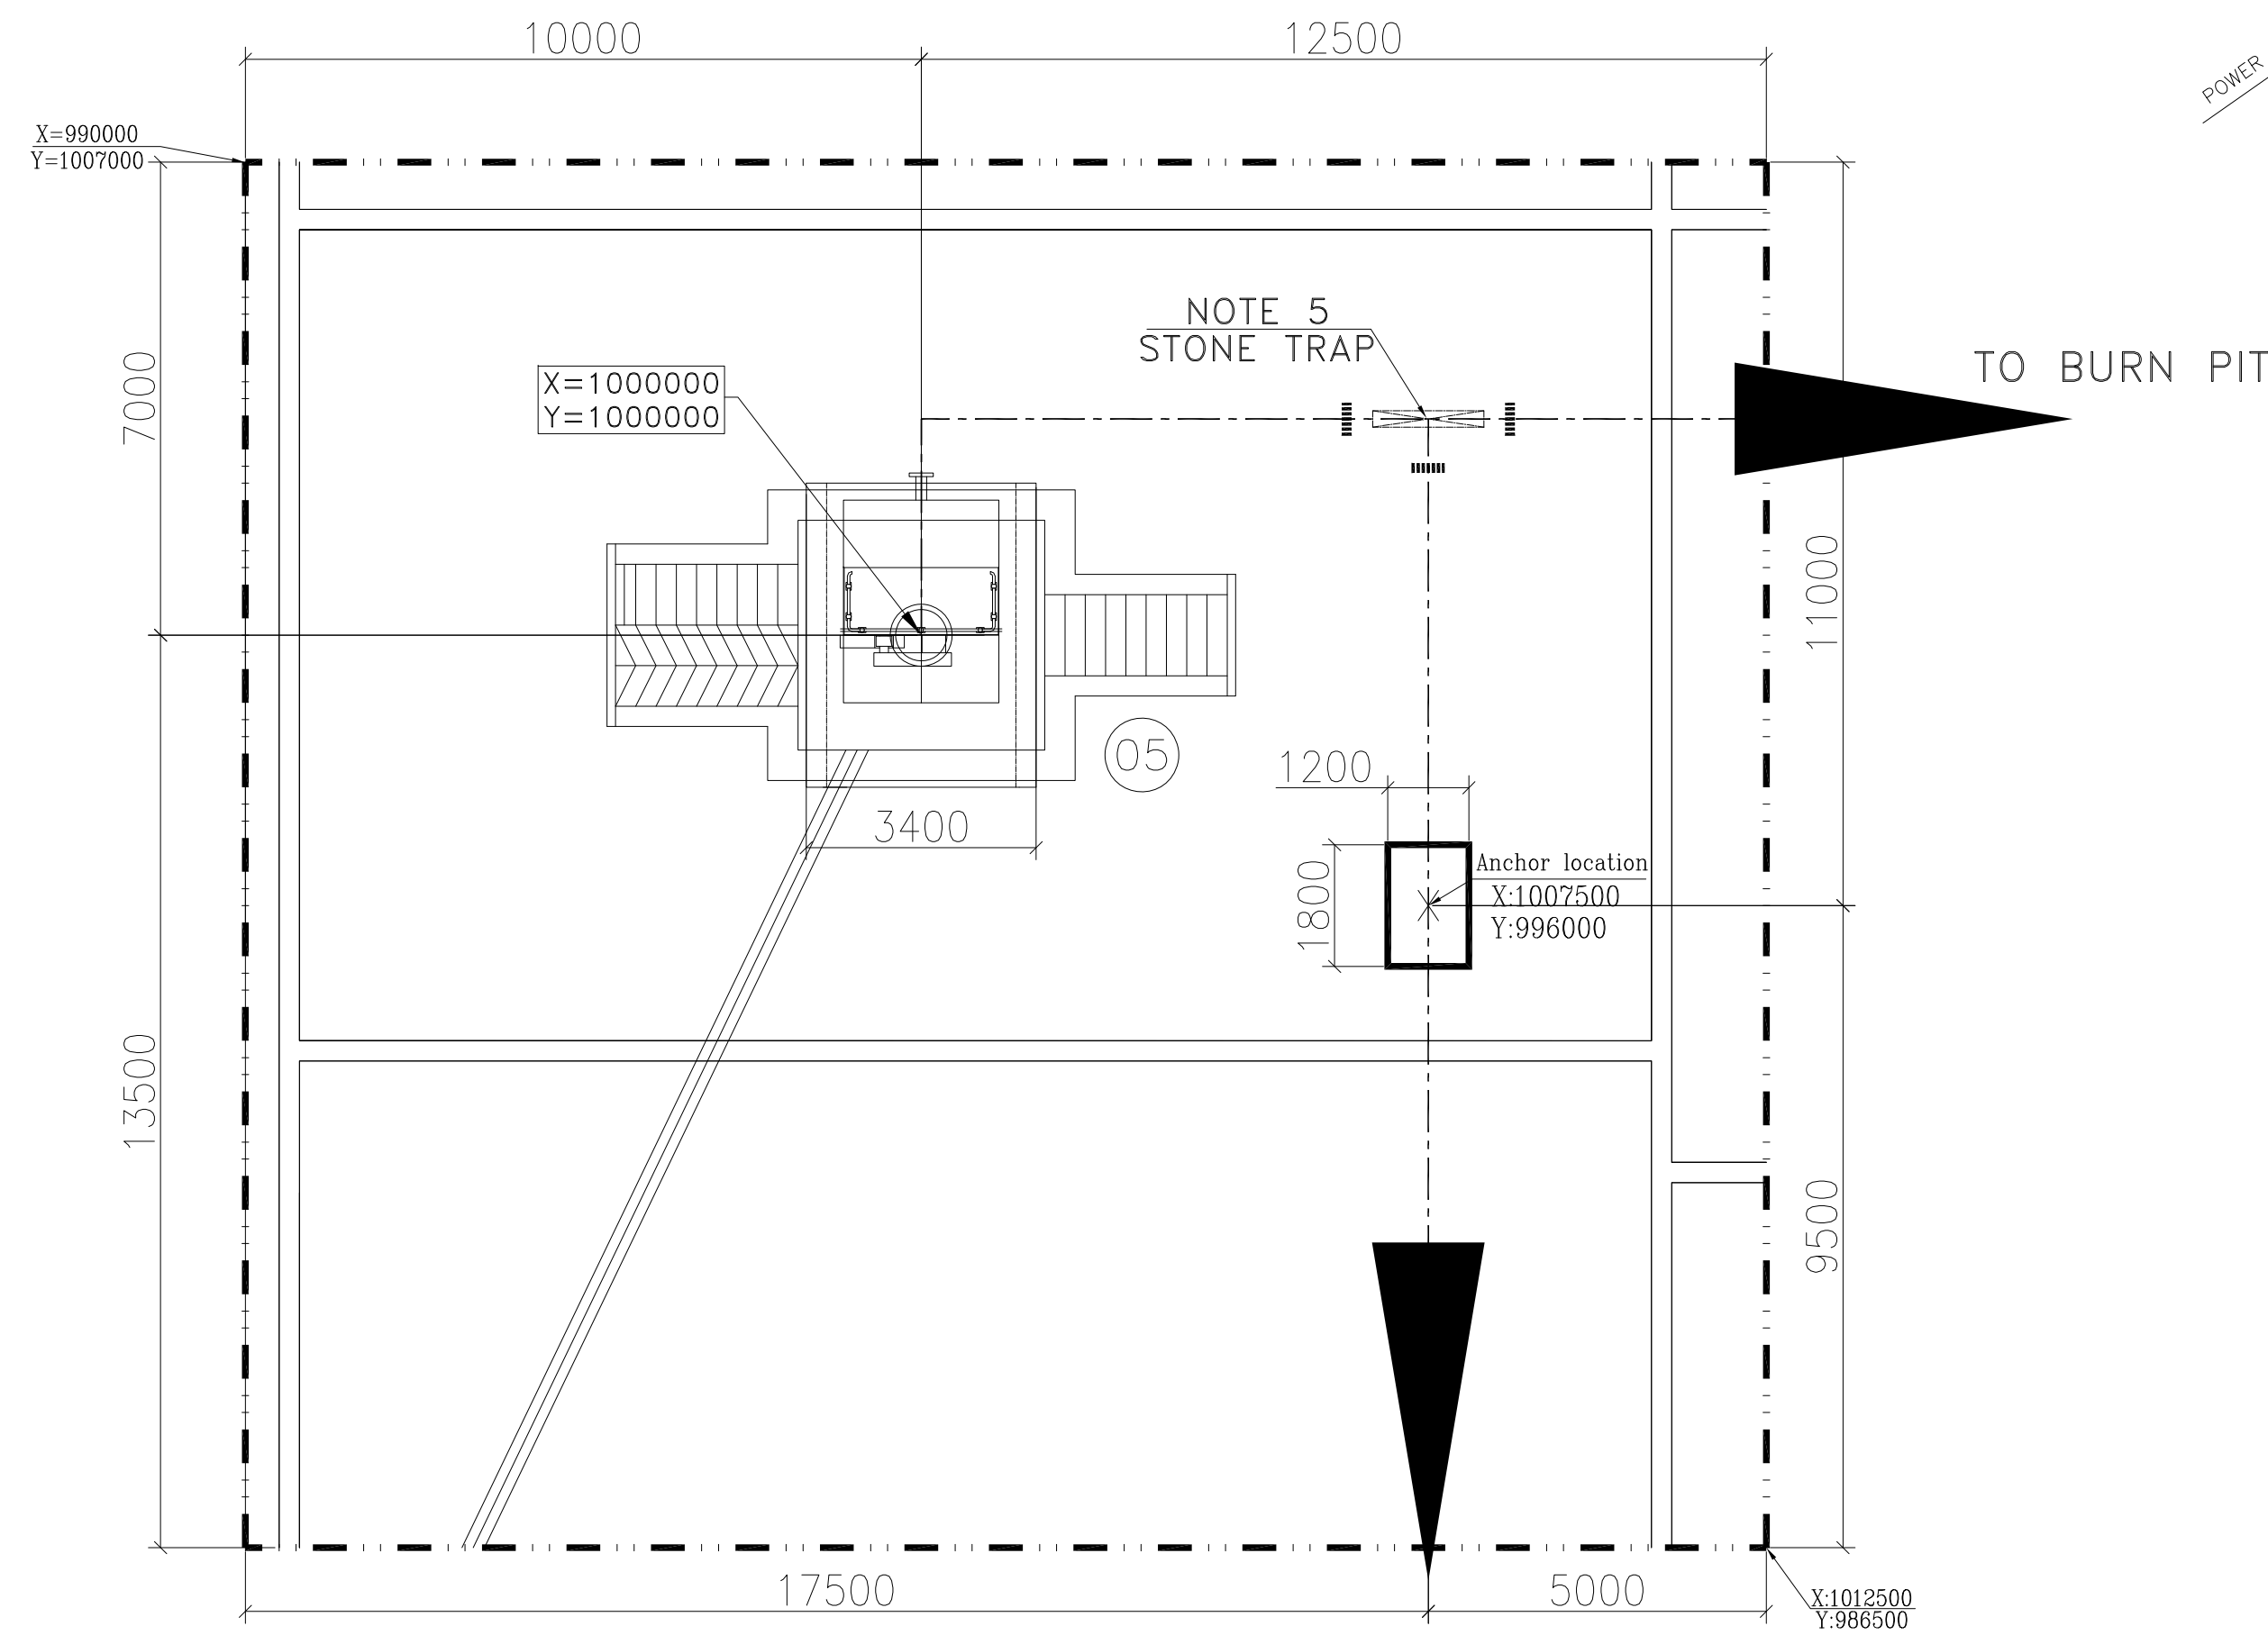

DETAIL A
SC: 1/100

DO3	JUL.2023	IFA	M.NOORI	M.FAKHARIAN	A.M.MOHSENI	***
DO2	JAN.2023	IFA	M.NOORI	M.FAKHARIAN	M.MEHRSHAD	***
DO1	NOV.2022	IFA	M.NOORI	M.FAKHARIAN	M.MEHRSHAD	***
DO0	MAY.2022	IFC	A.KHOSRAVI	M.FAKHARIAN	M.MEHRSHAD	***
REV.	DATE	P.O.I.S	PREP	CHK	APP.	AUT.
PROJECT NAME: BINAK OILFIELD DEVELOPMENT/SUB-SURFACE WORK PACKAGES W046S WELLHEAD FACILITIES 971020						
EPC CONTRACTOR:			GENERAL CONTRACTOR:			
HIRGAN ENERGY - DESIGN & INSPECTION COMPANIES			PETROIRAN DEVELOPMENT COMPANY			

THE ORIGINAL AND ALL COPIES OF THIS DRAWING TOGETHER WITH THE COPYRIGHT THEREIN ARE THE SOLE PROPERTY OF N.I.S.O.C./ FIELDS

DRAWING TITLE: PLOT PLAN DRAWING - W046S						NO CONSTRUCTION PERMITTED UNLESS DRAWING APPROVED							
						APPROVED FOR CONSTRUCTION				BY:		DATE:	
SCALE	SIZE	DRAWING NO.			SHEET NO.	REV.	BUDGET REF.	LOCATION	SIZE	CLASS	SERIAL NO.	SHEET	REVISION
AS SHOWN	A0	BK-W046S-PEDCO-110-PI-PY-0001			1 OF 1	D03	053-073-9184	F	5	A	707616	1 OF 1	D03