


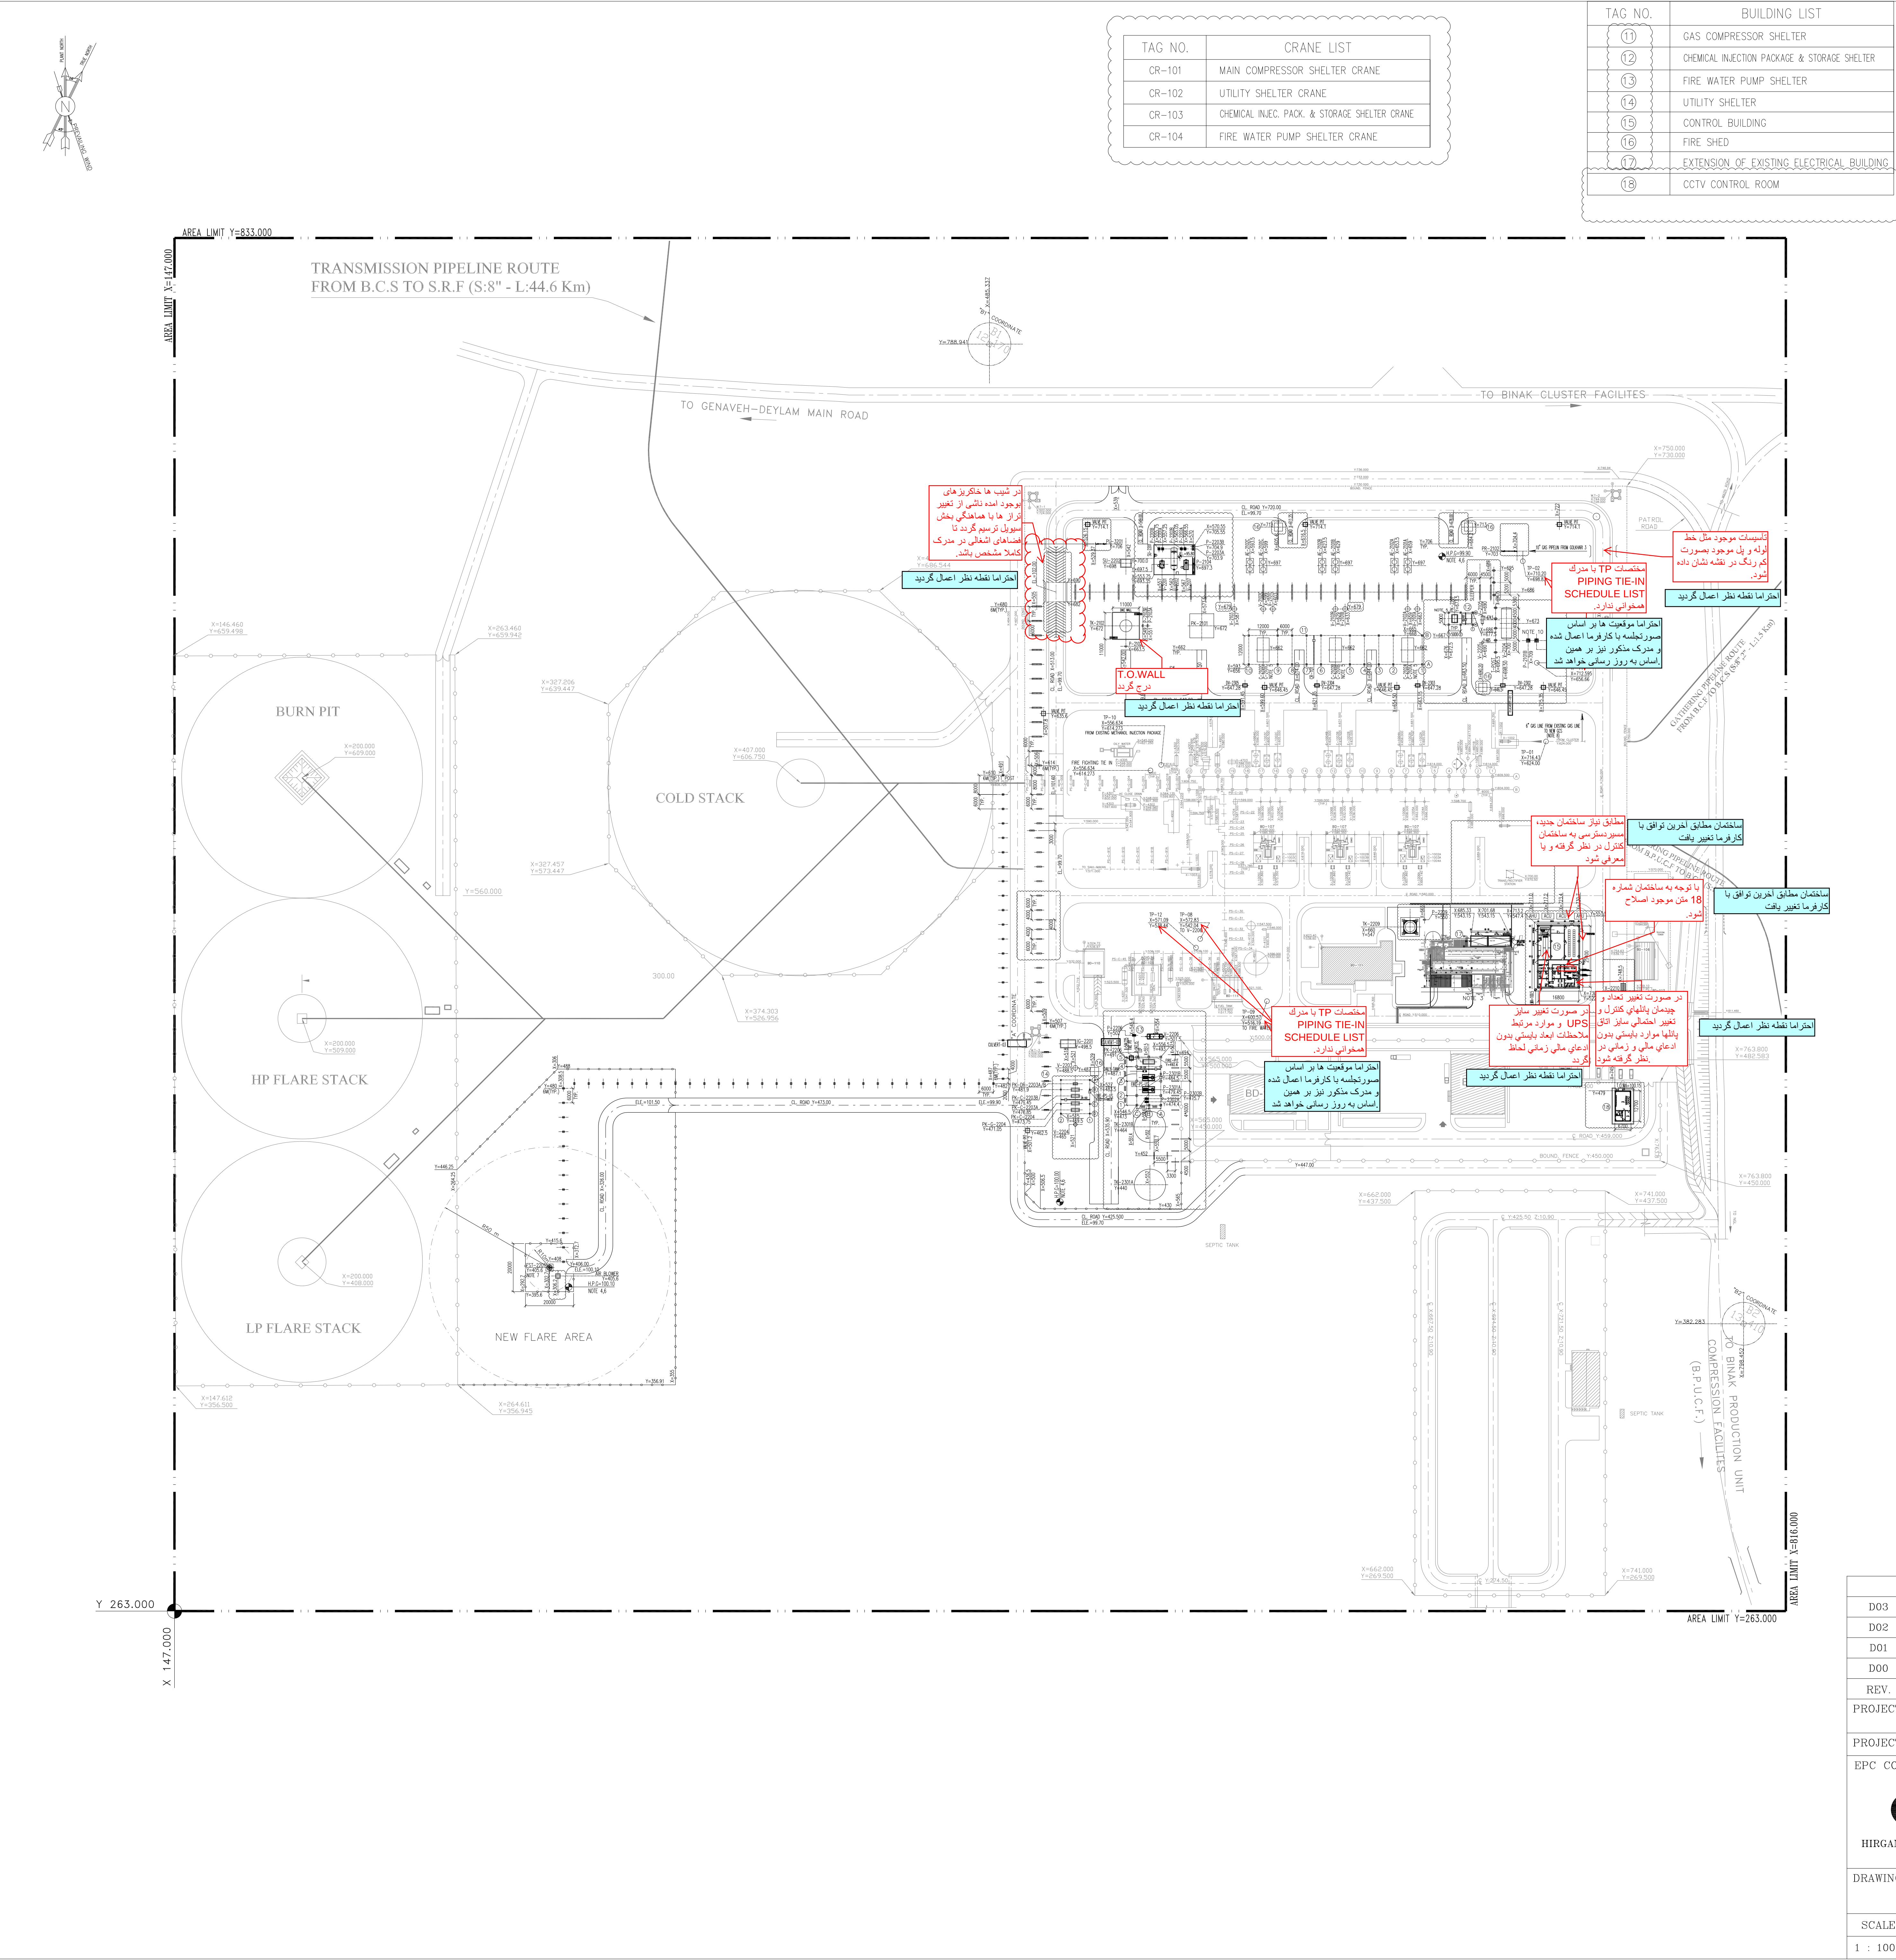

TAG NO.	BUILDING LIST
11	GAS COMPRESSOR SHELTER
12	CHEMICAL INJECTION PACKAGE & STORAGE SHELTER
13	FIRE WATER PUMP SHELTER
14	UTILITY SHELTER
15	CONTROL BUILDING
16	FIRE SHED
17	EXTENSION OF EXISTING ELECTRICAL BUILDING
18	CCTV CONTROL ROOM

TAG NO.	CRANE LIST
CR-101	MAIN COMPRESSOR SHELTER CRANE
CR-102	UTILITY SHELTER CRANE
CR-103	CHEMICAL INJEC. PACK. & STORAGE SHELTER CRANE
CR-104	FIRE WATER PUMP SHELTER CRANE

TAG NO.	EQUIPMENT LIST
AE-2101 A/B/C	1ST STAGE GAS AIR COOLER
AE-2102 A/B/C	2ND STAGE GAS AIR COOLER
C-2101 A/B/C	1ST STAGE GAS COMPRESSORS
C-2102 A/B/C	2ND STAGE GAS COMPRESSORS
FST-2201	LP FLARE STACK
IG-2201	LP FLARE IGNITION PACKAGE
P-2101 A/B	SLUG PUMPS
P-2102	GLYCOL MANUAL PUMP
P-2103 A/B	GLYCOL TRANSFER PUMPS
P-2104	GLYCOL DRAIN PUMP
DELETED	DELETED
P-2201 A/B	FLARE K.O. DRUM PUMPS
P-2202 A/B	CLOSED DRAIN PUMPS
P-2203 A/B	SUMP PUMPS
P-2206	FUEL OIL PUMP
P-2209	POTABLE WATER PUMP
P-2301 A	FIRE WATER PUMP - ELECTRICAL MOTOR DRIVEN
P-2301 B	FIRE WATER PUMP - DIESEL ENGINE DRIVEN
P-2302 A/B	FIRE WATER JOCKEY PUMPS
PK-2101	GAS DEHYDRATION PACKAGE
PK-C-2203 A/B	AIR COMPRESSOR PACKAGES
PK-DR-2203A/B	AIR DRYER PACKAGE
PK-C-2204	NITROGEN COMPRESSOR PACKAGE
PK-G-2204	NITROGEN GENERATION PACKAGE
PK-2206	DIESEL GENERATOR PACKAGE
PK-2207	CORROSION INHIBITOR INJECTION PACKAGE
DELETED	DELETED
PLC-3201	PIG LAUNCHER
PR-2102	GOLKHARI-3 PIG RECEIVER (BY OTHERS)
DELETED	DELETED
SU-2201	CLOSED DRAIN AND FLARE DRUM SUMP
SU-2202	OLY WATER SUMP
DELETED	DELETED
TK-2102	LEAN GLYCOL STORAGE TANK
TK-2209	POTABLE WATER TANK
TK-2301 A/B	FIRE WATER STORAGE TANKS
V-2101 A/B/C	1ST STAGE GAS SUCTION DRUM
V-2102 A/B/C	2ND STAGE GAS SUCTION DRUM
V-2103	2ND STAGE GAS DISCHARGE DRUM
V-2105	SLUG CATCHER DRUM
DELETED	INLET KNOCK OUT DRUM
V-2107	GLYCOL SUMP DRUM
V-2109	FLARE K.O. DRUM
V-2201	CLOSED DRAIN DRUM
V-2203	INSTRUMENT AIR RECEIVER
V-2204	NITROGEN RECEIVER
V-2205	FUEL GAS K.O. DRUM
V-2206	FUEL OIL STORAGE DRUM
DELETED	DELETED
X-2210	NEW SEPTIC PACKAGE

- NOTES
- 1- ALL ELEVATIONS AND COORDINATES ARE IN METER UNLESS OTHERWISE NOTED. DIMENSIONS ARE IN MILLIMETER.

2- ALL COORDINATES ARE IN METERS WITH REFERENCE TO SITE LOCAL DATUM POINT.

3- HATCHED AREAS ARE OUT OF SCOPE OF THIS PROJECT.

4- COORDINATE (UTM COORDINATES OF SITE):
- LOCAL

UTM

A

B1

B2

X=500.000

Y=500.000

X=485.337

Y=788.941

Z=12.170

E=437384.709

N=3289737.469

E=437245.830

N=3289991.269

ELEV.=12.17

X=798.452

Y=382.283

Z=13.410

E=437704.660

N=3289761.280

ELEV.=13.41
- H.P.G AND H.P.P. ELEVATION +100.00 CORRESPOND TO +11.20 M.S.L.
- 5- DIMENSION WILL BE FINALIZED IN NEXT REVISIONS.
- 6- DELETED
- 7- DIMENSION AREA AND LOCATION FOR FLARE WILL BE FINALIZED SUBSEQUENTLY.
- 8- TIE-IN POINT LOCATION WILL BE FINALIZED AT SITE LATER.
- 9- DIMENSION AND LOCATION OF SU-2202 WILL BE FINALIZED SUBSEQUENTLY.
- 10- CONDENSATE PUMP IS PROTECTED BY SUN SHADE

- LEGEND
- NEW FENCE

OLD FENCE

ROAD CENTER LINE

EQUIPMENTS CENTER LINE

AREA LIMIT

HIGH POINT OF PAVING

HIGH POINT OF GRAVEL

TOP OF WALKWAY

REVISION CLOUD

EXISTING ROADS

NEW ROADS

GREEN AREA

SHELTER

H.P.P.

H.P.G.

T.O.WA

NEW FENCE

OLD FENCE

ROAD CENTER LINE

EQUIPMENTS CENTER LINE

AREA LIMIT

HIGH POINT OF PAVING

HIGH POINT OF GRAVEL

TOP OF WALKWAY

REVISION CLOUD

EXISTING ROADS


NEW ROADS

GREEN AREA

SHELTER
- حداکثر ارتفاع نظر اصل گردید

REFERENCE DRAWING	DRG. No.
BNK NEW COMPRESSOR GAS STATION PLOT PLAN (BASIC PACKAGE)	1560-BK-NCS-PI-DWG-0001
PROCESS MAIN EQUIPMENT LIST	BK-GCS-PEDCO-120-PR-LI-0001
COMPRESSOR GAS STATION P&IDs	BK-GCS-PEDCO-120-PR-PI-0001-0025
CONSEQUENCE MODELING REPORT	BK-GCS-PEDCO-120-SA-RT-0003
FLARE RADIATION & DISPERSION STUDY REPORT	BK-GCS-PEDCO-120-PR-RT-0002
HAZARDOUS AREA CLASSIFICATION LAYOUT	BK-GCS-PEDCO-120-SA-PY-0002
ROAD, PAVING AND PLANT FINISH GRADING LAYOUT & SECTIONS	BK-GCS-PEDCO-120-CV-PY-0005

KEY PLAN

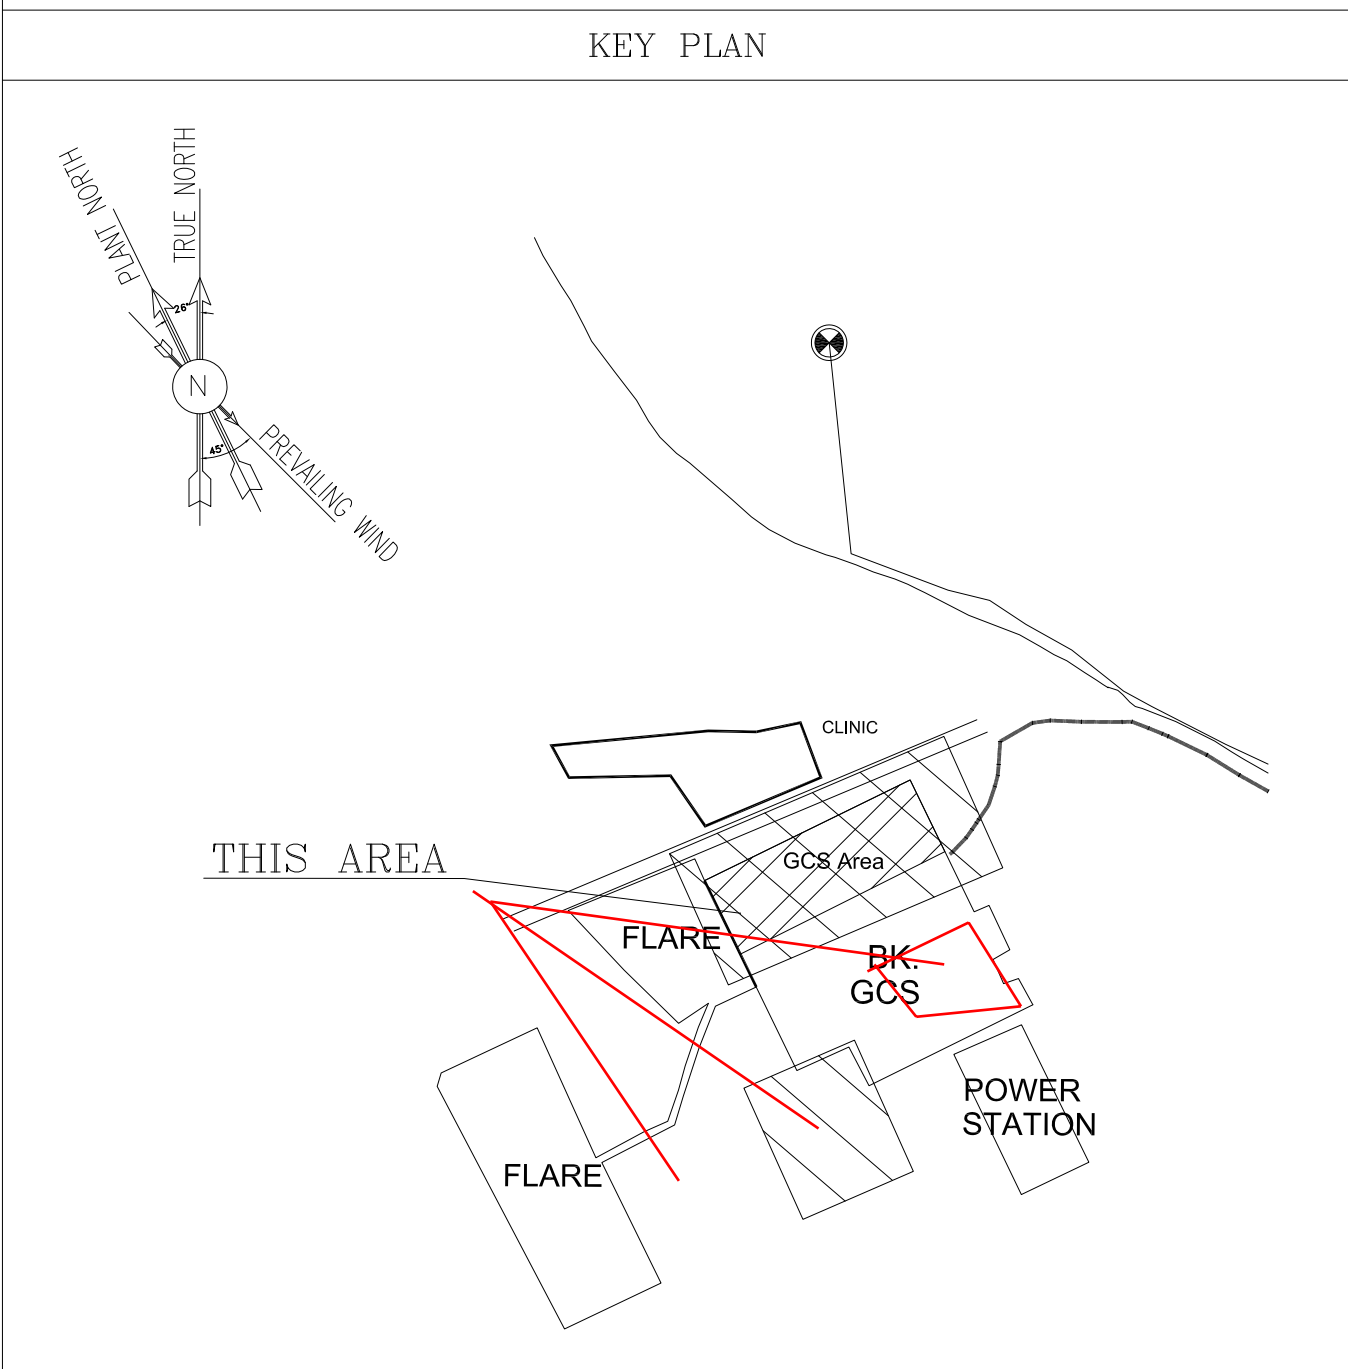

D03	OCT.2022	APC	M.NOORI	M.PAKHARIAN	M.MEHRSHAD	***
D02	JAN.2022	IFA	A.KHOSRAVI	M.PAKHARIAN	M.MEHRSHAD	***
D01	NOV.2021	IFA	H.SHARROKHI	M.PAKHARIAN	M.MEHRSHAD	***
D00	SEP.2021	IFC	M.ASGHARNEJAD	M.PAKHARIAN	SH.GHALIKAR	***
REV.	DATE	P.O.I.S	PREP.	CHK.	APP.	AUT.
PROJECT NAME: BINAK OILFIELD DEVELOPMENT/SURFACE FACILITIES GAS COMPRESSOR STATION						
PROJECT NO.: 971020						
EPC CONTRACTOR:			EPD/EPC CONTRACTOR (GC):			
 HIRGAN ENERGY - DESIGN & INSPECTION COMPANIES			 PETROIRAN DEVELOPMENT COMPANY			
DRAWING TITLE: UNIT PLOT PLAN DRAWING						
SCALE	SIZE	DRAWING NO.			SHEET NO.	REV.
1 : 1000	A0	BK-GCS-PEDCO-120-PI-PY-0001			1 OF 1	D03

***	*****	** **	*** ****	** **	*** ****
REV.	DESCRIPTION	BY	DATE	BY	DATE
		CHECKED		REV. APPR.	
اصل و کاپیه نسخ این نقشه و حق اقتباس متعلق به شرکت ملی مناطق نفت خیز جنوب میباشد.					
					
THE ORIGINAL AND ALL COPIES OF THIS DRAWING TOGETHER WITH THE COPYRIGHT THEREIN ARE THE SOLE PROPERTY OF N.I.S.O.C./ FIELDS					
BINAK OILFIELD DEVELOPMENT SURFACE FACILITIES GAS COMPRESSOR STATION					
DATE	SCALE	DRAWING BY	CHECKED BY	PROJECT ENG.	
NO CONSTRUCTION PERMITTED UNLESS DRAWING APPROVED					
APPROVED FOR CONSTRUCTION			BY:	DATE:	
BUDGET REF	LOCATION	SIZE CLASS	SERIAL NO.	SHEET	REVISION
053-073-9184	F	5 A	708890	1 OF 1	D03

اصل و کلیه نسخ این نقشه و حق اقتباس متعلق به شرکت ملی مناطق نفت خیز جنوب می باشد.

THE ORIGINAL AND ALL COPIES OF THIS DRAWING TOGETHER WITH THE COPYRIGHT THEREIN ARE THE SOLE PROPERTY OF N.I.S.O.C./ FIELDS

DATE	SCALE	DRAWING BY	CHECKED BY	PROJECT ENG.
NO CONSTRUCTION PERMITTED UNLESS DRAWING APPROVED				
APPROVED FOR CONSTRUCTION			BY:	
SCALE	SIZE	DRAWING NO.	SHEET NO.	REV.
1 : 1000	A0	BK-GCS-PEDCO-120-PI-PY-0001	1 OF 1	D03