
 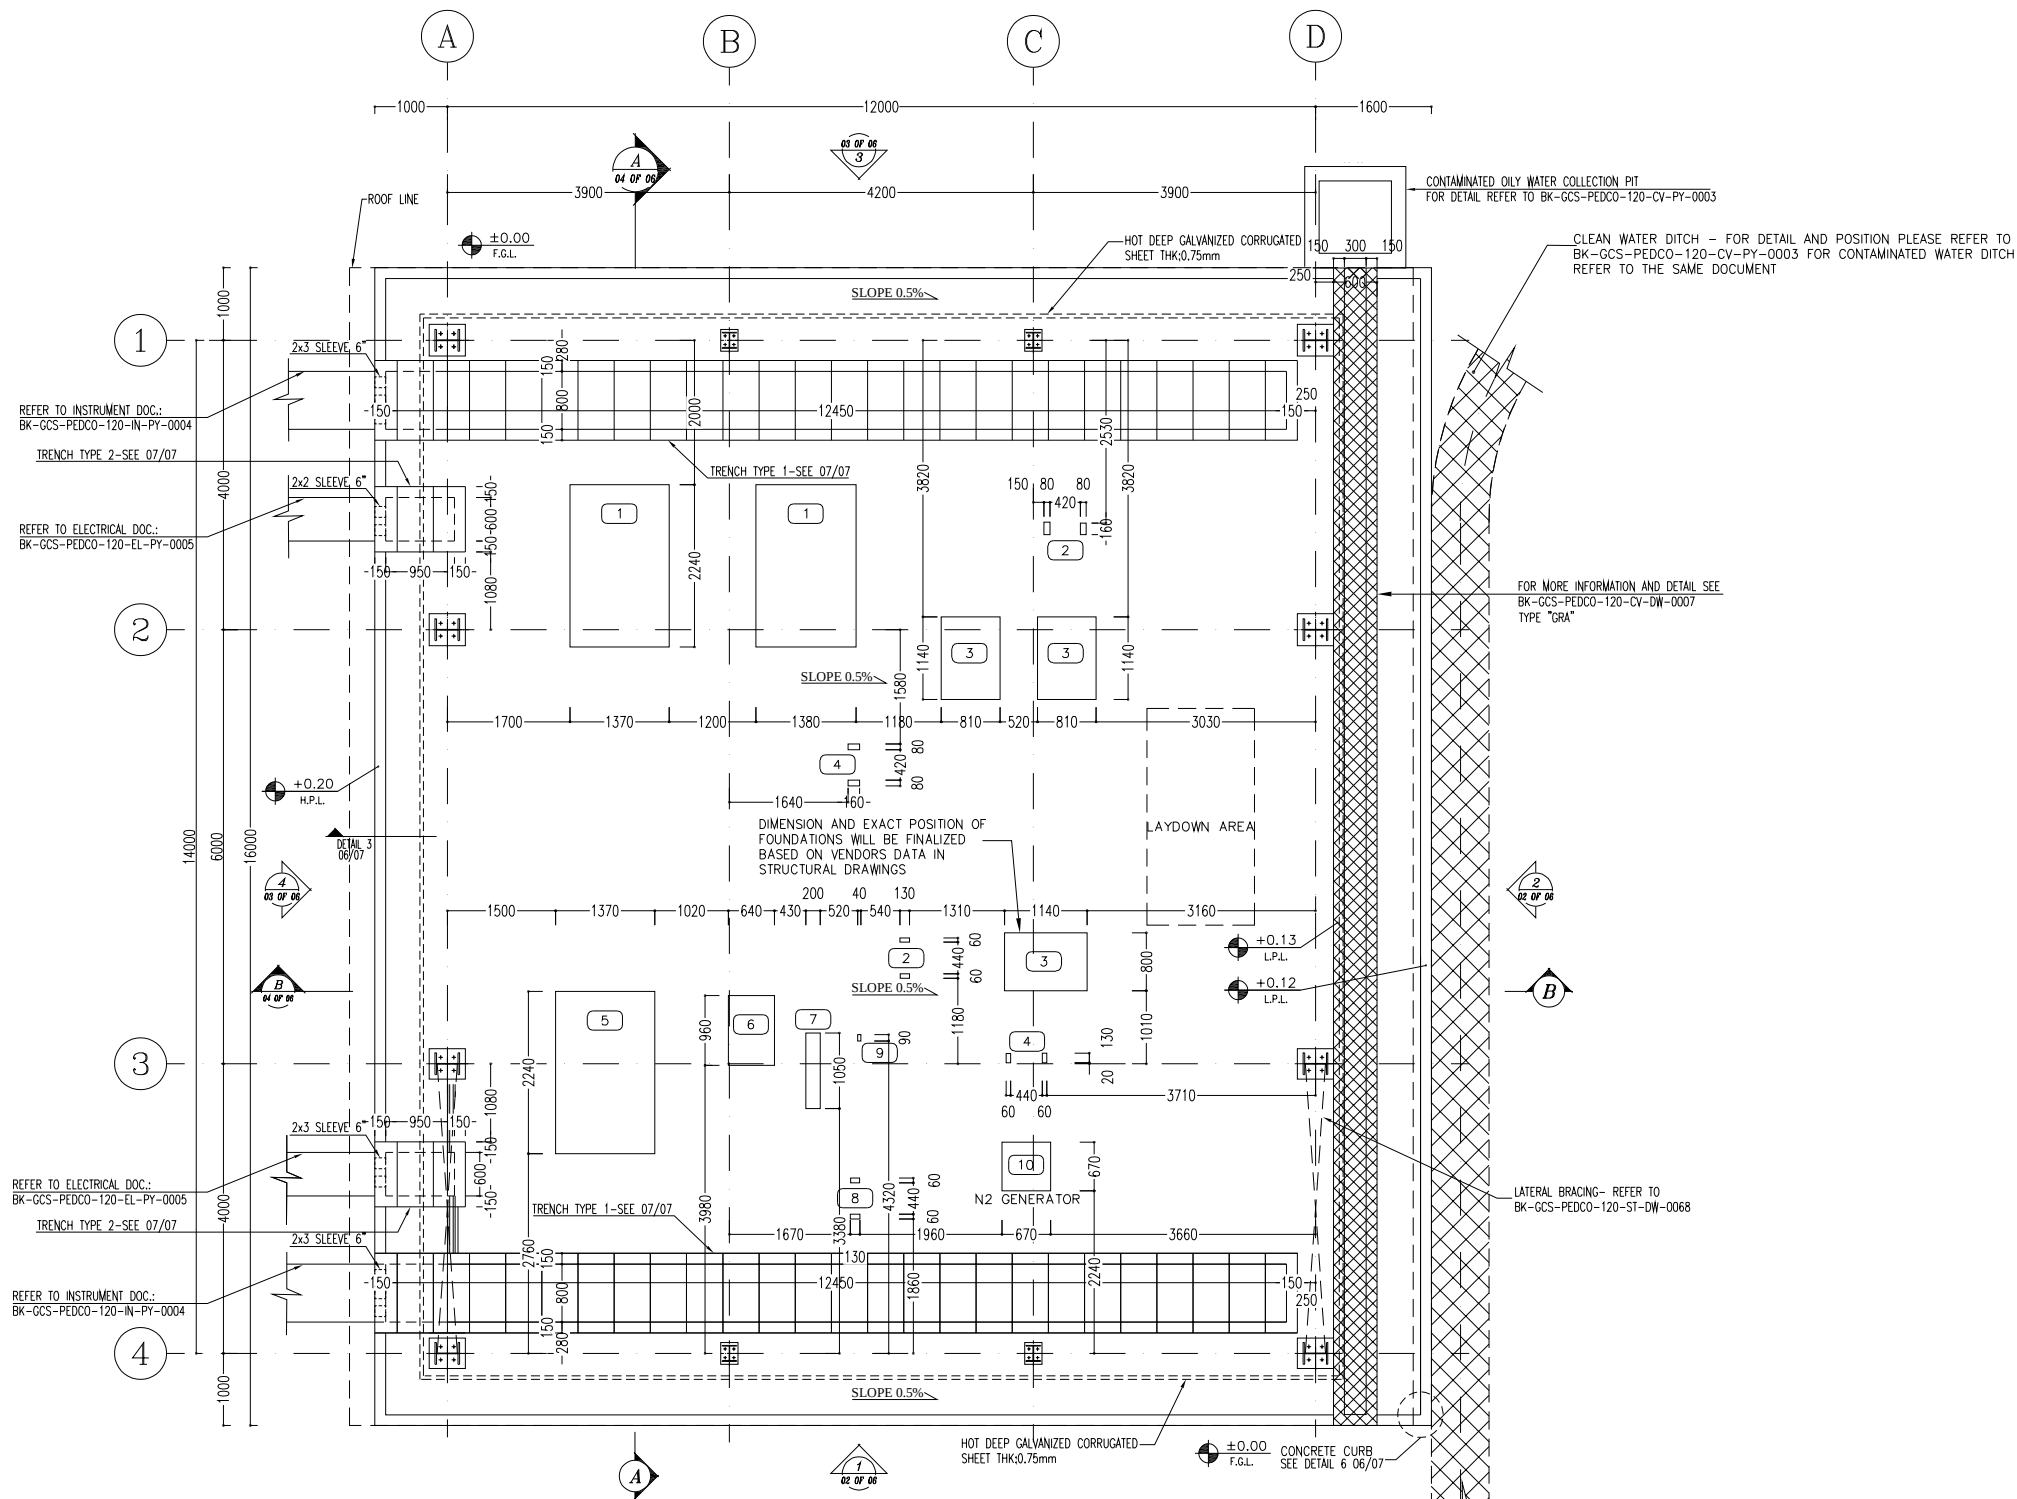




SC.1:50 1 FLOOR PLAN

NOTES

1. ALL DIMENSIONS ARE IN MILLIMETER & ALL ELEVATIONS ARE IN METER.
2. ALL DIMENSIONS AND ELEVATIONS SHALL BE CHECKED BY THE CONTRACTOR PRIOR TO CONSTRUCTION.
3. CONTRACTOR SHALL COMPLY ALL ARCHITECTURAL, MECHANICAL, ELECTRICAL, PIPING AND STRUCTURAL DRAWINGS AND IN CASE OF ANY CONFLICTS OR DISCREPANCY, INFORM THE ENGINEER.
4. ALL MATERIALS ARE SELECTED FROM THE HIGHEST QUALITY AND MUST BE APPROVED BY THE CLIENT.
5. ALL OPENINGS FOR PIPING/CABLES SHALL BE CONSIDERED AS PER RELATED DRAWINGS BEFORE CONSTRUCTION.
6. FINISH GRADING LEVEL IS EQUIVALENT ± 0.00 LOCAL ± 11.00 GLOBAL (M.S.L.)

LEGEND


CORRUGATED GALVANIZED METAL SHEET THK. = 0.75mm

1	AIR COMPRESSOR
2	PRE FILTER
3	AIR DRYER
4	AFTER FILTER
5	NITROGEN COMPRESSOR
6	HEAT CHANGER
7	CHILLER
8	DUST FILTER
9	WATER TRAP
10	N2 GENERATOR

F.G.L. FINISH GRADING LEVEL
T.O.F. TOP OF FOUNDATION
T.O.B. TOP OF BRACKET
B.O.G. BOTTOM OF GIRT
T.O.PED. TOP OF PEDESTAL
T.O.S. TOP OF SHELTER
B.O.GU. BOTTOM OF GUTTER
L.P.L. LOWEST POINT LEVEL
H.P.L. HIGHEST POINT LEVEL
T.O.D. TOP OF DITCH



REFERENCE DRAWING	DRG. No.
STANDARD DRAWING FOR ARCHITECTURAL DETAILS	BK-GNRL-PEDCO-000-AR-DW-0001
SITE SEWAGE SYSTEM LAYOUT & DETAILS	BK-GCS-PEDCO-120-CV-PY-0001
CABLE TRENCH AND DUCT BANK LAYOUT	BK-GCS-PEDCO-120-CV-PY-0002
ROAD, PAVING AND PLANT FINISH GRADING LAYOUT & SECTIONS	BK-GCS-PEDCO-120-CV-PY-0005
ELECTRICAL CABLE ROUTE & SECTION LAYOUT FOR BUILDING & SHELTER	BK-GCS-PEDCO-120-EL-PY-0006
FOUNDATION DRAWING FOR UTILITY SHELTER	BK-GCS-PEDCO-120-ST-DW-0007
STRUCTURAL DRAWING FOR UTILITY SHELTER	BK-GCS-PEDCO-120-ST-DW-0008
UNIT PLANT PLAN DRAWING	BK-GCS-PEDCO-120-PI-PY-0001
FOUNDATION DRAWING FOR AIR DRYER PACKAGE	BK-GCS-PEDCO-120-ST-DW-69
FOUNDATION DRAWING FOR INSTRUMENT PLANT SR PACKAGE	BK-GCS-PEDCO-120-ST-DW-28
FOUNDATION DRAWING FOR NITROGEN PACKAGE	BK-GCS-PEDCO-120-ST-DW-32
FOUNDATION DRAWINGS FOR NITROGEN RECEIVER DRUM	BK-GCS-PEDCO-120-ST-DW-20
SPECIFICATION FOR CONCRETE WORK	BK-GNRL-PEDCO-000-ST-SP-0001

KEY PLAN

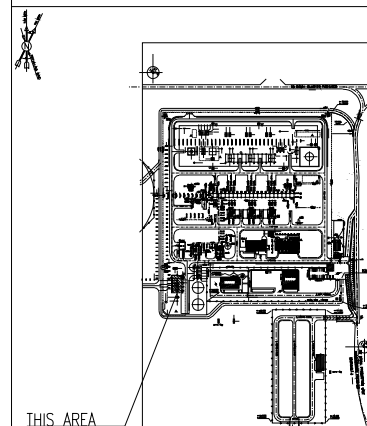


D04	AUG.2023	IFA	R.BERLOUJE	M.FAKHARIAN	A.M.MOHESEN	**
D03	MAY.2023	IFA	R.BERLOUJE	M.FAKHARIAN	M.MEHRSHAD	**
D02	JAN.2023	IFA	R.BERLOUJE	M.FAKHARIAN	M.MEHRSHAD	**
D01	OCT.2022	IPC	R.BERLOUJE	M.FAKHARIAN	M.MEHRSHAD	**
D00	SEP.2022	IPC	R.BERLOUJE	M.FAKHARIAN	M.MEHRSHAD	**
REV.	DATE	P.O.I.S	PREP.	CHK.	APP.	AUT.
PROJECT NAME: BINAK OILFIELD DEVELOPMENT/SURFACE FACILITIES GAS COMPRESSOR STATION						
PROJECT NO.: 971020						
EPC CONTRACTOR:			EPD/EPC CONTRACTOR (GC):			
 HIRGAN ENERGY - DESIGN & INSPECTION COMPANIES			 PETROIRAN DEVELOPMENT COMPANY			
DRAWING TITLE: ARCHITECTURAL DRAWING FOR UTILITY SHELTER						
PLAN						
NO CONSTRUCTION PERMITTED UNLESS DRAWING APPROVED			NO CONSTRUCTION PERMITTED UNLESS DRAWING APPROVED			
APPROVED FOR CONSTRUCTION			BY:		DATE:	
SCALE	SIZE	DRAWING NO.			SHEET NO.	REV.
AS SHOWN	A1	BK-GCS-PEDCO-120-AR-DW-0005			01 OF 07	D04

DATE	SCALE	DRAWING BY	CHECKED BY	PROJECT ENG.
THE ORIGINAL AND ALL COPIES OF THIS DRAWING TOGETHER WITH THE COPYRIGHT THEREIN ARE THE SOLE PROPERTY OF N.I.S.O.C./ FIELDS				
امل و کلیه نسخ این نقشه و حق اقتباس متعلق به شرکت ملی مناطق نفت خیز جنوب می باشد				
THE ORIGINAL AND ALL COPIES OF THIS DRAWING TOGETHER WITH THE COPYRIGHT THEREIN ARE THE SOLE PROPERTY OF N.I.S.O.C./ FIELDS				
DATE	SCALE	DRAWING BY	CHECKED BY	PROJECT ENG.
NO CONSTRUCTION PERMITTED UNLESS DRAWING APPROVED				
APPROVED FOR CONSTRUCTION			BY:	
DATE:				
SCALE	SIZE	DRAWING NO.	SHEET NO.	REV.
AS SHOWN	A1	BK-GCS-PEDCO-120-AR-DW-0005	01 OF 07	D04

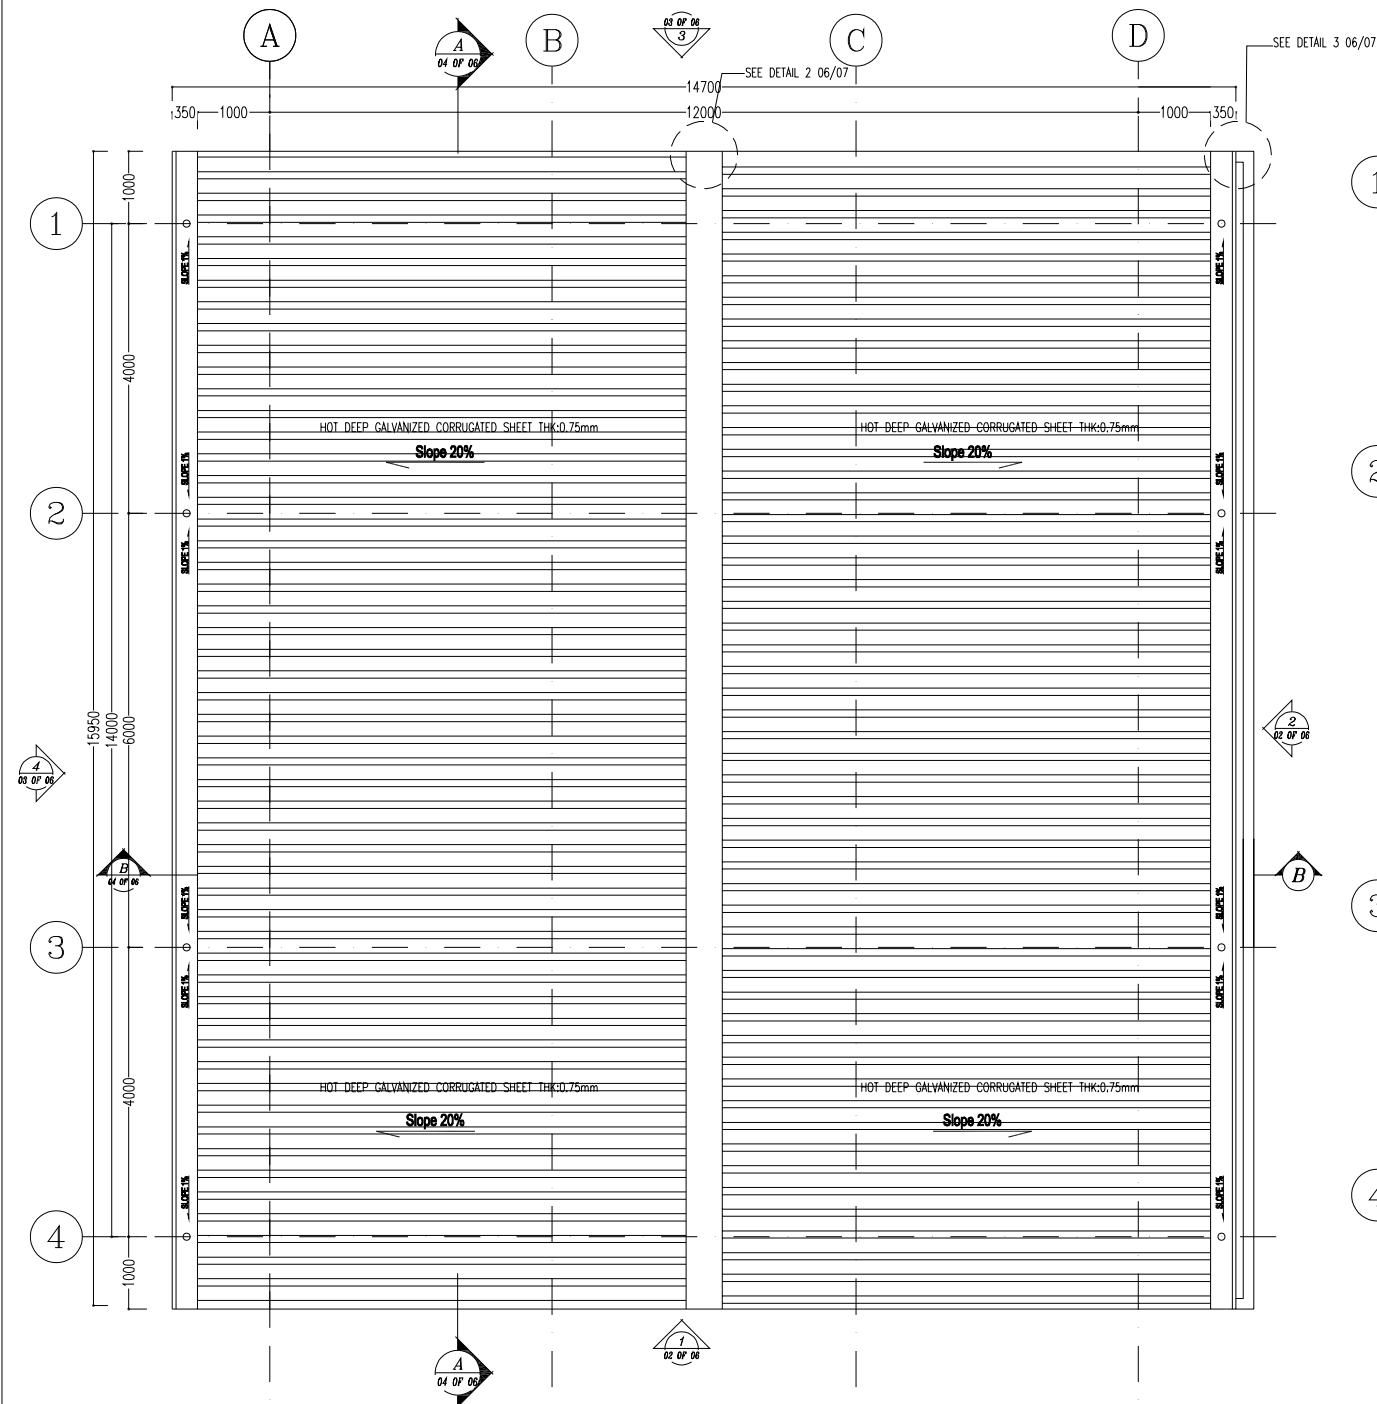 

SC.1:50 2 ROOF PLAN

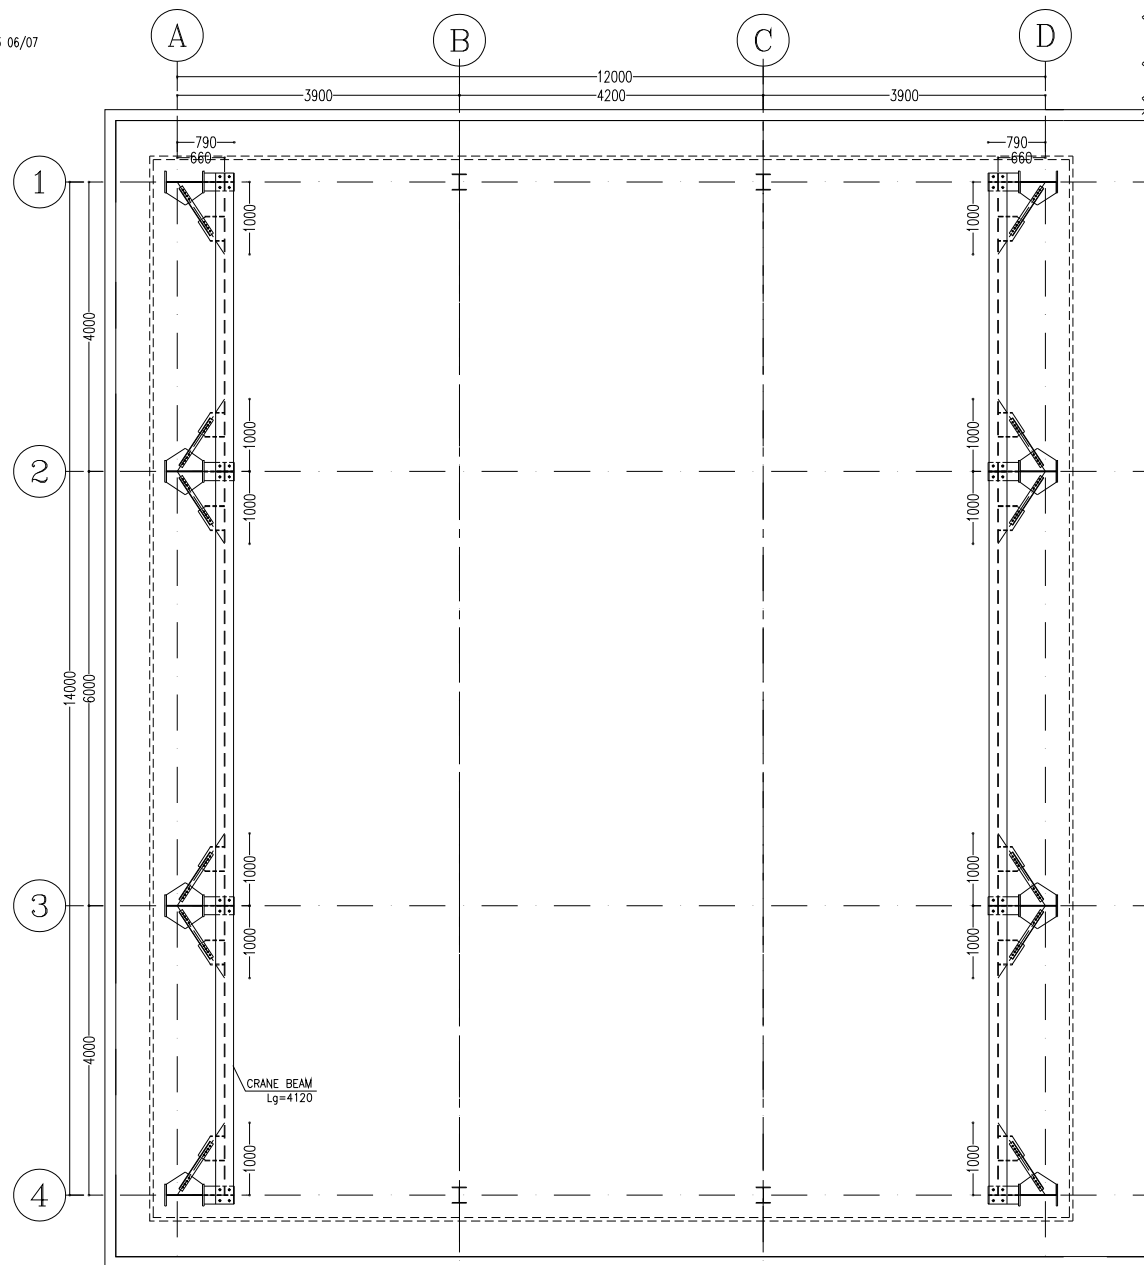

SC.1:50 3 RUNWAY BEAM LAYOUT PLAN

NOTES

1. ALL DIMENSIONS ARE IN MILLIMETER & ALL ELEVATIONS ARE IN METER.
2. ALL DIMENSIONS AND ELEVATIONS SHALL BE CHECKED BY THE CONTRACTOR PRIOR TO CONSTRUCTION.
3. CONTRACTOR SHALL COMPLY ALL ARCHITECTURAL, MECHANICAL, ELECTRICAL, PIPING AND STRUCTURAL DRAWINGS AND IN CASE OF ANY CONFLICTS OR DISCREPANCY, INFORM THE ENGINEER.
4. ALL MATERIALS ARE SELECTED FROM THE HIGHEST QUALITY AND MUST BE APPROVED BY THE CLIENT.
5. ALL SPENCING FOR PIPING/CABLEING SHALL BE CONSIDERED AS PER RELATED DRAWINGS BEFORE CONSTRUCTION.
6. FINISH GRADING LEVEL IS EQUIVALENT ± 0.00 LOCAL ± 11.00 GLOBAL (M.S.L.).

LEGEND

CORRUGATED GALVANIZED METAL SHEET THK. = 0.75mm




F.G.L. FINISH GRADING LEVEL
T.O.F. TOP OF FOUNDATION
T.O.B. TOP OF BRACKET
B.O.G. BOTTOM OF GIRT
T.O.PED. TOP OF PEDESTAL
T.O.S. TOP OF SHELTER
B.O.GU. BOTTOM OF GUTTER
L.P.L. LOWEST POINT LEVEL
H.P.L. HIGHEST POINT LEVEL

REFERENCE DRAWING

REFERENCE DRAWING	DRG. No.
STANDARD DRAWING FOR ARCHITECTURAL DETAILS	BK-GNRL-PEDCO-000-AR-DW-0001
SITE SEWAGE SYSTEM LAYOUT & DETAILS	BK-GCS-PEDCO-120-CV-PY-0001
CABLE TRENCH AND DUCT BANK LAYOUT	BK-GCS-PEDCO-120-CV-PY-0002
ROAD, PAVING AND PLANT FINISH GRADING LAYOUT & SECTIONS	BK-GCS-PEDCO-120-CV-PY-0005
ELECTRICAL CABLE ROUTE & SECTION LAYOUT FOR BUILDING & SHEDS	BK-GCS-PEDCO-120-EL-PY-0006
FOUNDATION DRAWING FOR UTILITY SHELTER	BK-GCS-PEDCO-120-ST-DW-0007
STRUCTURAL DRAWING FOR UTILITY SHELTER	BK-GCS-PEDCO-120-ST-DW-0008
UNIT PLANT PLAN DRAWING	BK-GCS-PEDCO-120-PI-PY-0001
FOUNDATION DRAWING FOR AIR DRYER PACKAGE	BK-GCS-PEDCO-120-ST-DW-69
FOUNDATION DRAWING FOR INSTRUMENT PLANT SR PACKAGE	BK-GCS-PEDCO-120-ST-DW-28
FOUNDATION DRAWING FOR NITROGEN PACKAGE	BK-GCS-PEDCO-120-ST-DW-32
FOUNDATION DRAWINGS FOR NITROGEN RECEIVER DRUM	BK-GCS-PEDCO-120-ST-DW-20
SPECIFICATION FOR CONCRETE WORK	BK-GNRL-PEDCO-000-ST-SP-0001

KEY PLAN

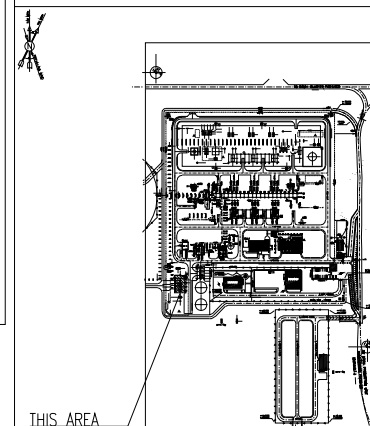

REV.	DATE	P.O.I.S	PREP.	CHK.	APP.	AUT.
D04	AUG.2023	IFA	R.BERLOUJE	M.FAKHARIAN	A.M.MOHESEN	**
D03	MAY.2023	IFA	R.BERLOUJE	M.FAKHARIAN	M.MEHRSHAD	**
D02	JAN.2023	IFA	R.BERLOUJE	M.FAKHARIAN	M.MEHRSHAD	**
D01	OCT.2022	IPC	R.BERLOUJE	M.FAKHARIAN	M.MEHRSHAD	**
D00	SEP.2022	IPC	R.BERLOUJE	M.FAKHARIAN	M.MEHRSHAD	**

PROJECT NAME: BINAK OILFIELD DEVELOPMENT/SURFACE FACILITIES GAS COMPRESSOR STATION

PROJECT NO.: 971020

EPC CONTRACTOR:	EPD/EPC CONTRACTOR (GC):
 HIRGAN ENERGY - DESIGN & INSPECTION COMPANIES	 PETROIRAN DEVELOPMENT COMPANY

DRAWING TITLE: ARCHITECTURAL DRAWING FOR UTILITY SHELTER PLAN

SCALE	SIZE	DRAWING NO.	SHEET NO.	REV.
AS SHOWN	A1	BK-GCS-PEDCO-120-AR-DW-0006	02 OF 07	D04


امثل و کلیه نسخ این نقشه و حق اقتباس متعلق به شرکت ملی مناطق نفت خیز جنوب می باشد.
THE ORIGINAL AND ALL COPIES OF THIS DRAWING TOGETHER WITH THE COPYRIGHT THEREIN ARE THE SOLE PROPERTY OF N.I.S.O.C./ FIELDS

BINAK OILFIELD DEVELOPMENT SURFACE FACILITIES GAS COMPRESSOR STATION				
DATB	SCALE	DRAWING BY	CHECKED BY	PROJECT ENG.


NO CONSTRUCTION PERMITTED UNLESS DRAWING APPROVED

APPROVED FOR CONSTRUCTION		BY:	DATE:	

BUDGET REF.	LOCATION	SIZE	CLASS	SERIAL NO.	SHEET	REVISION
053-073-9104	F	4	B	709103	02 OF 07	D04

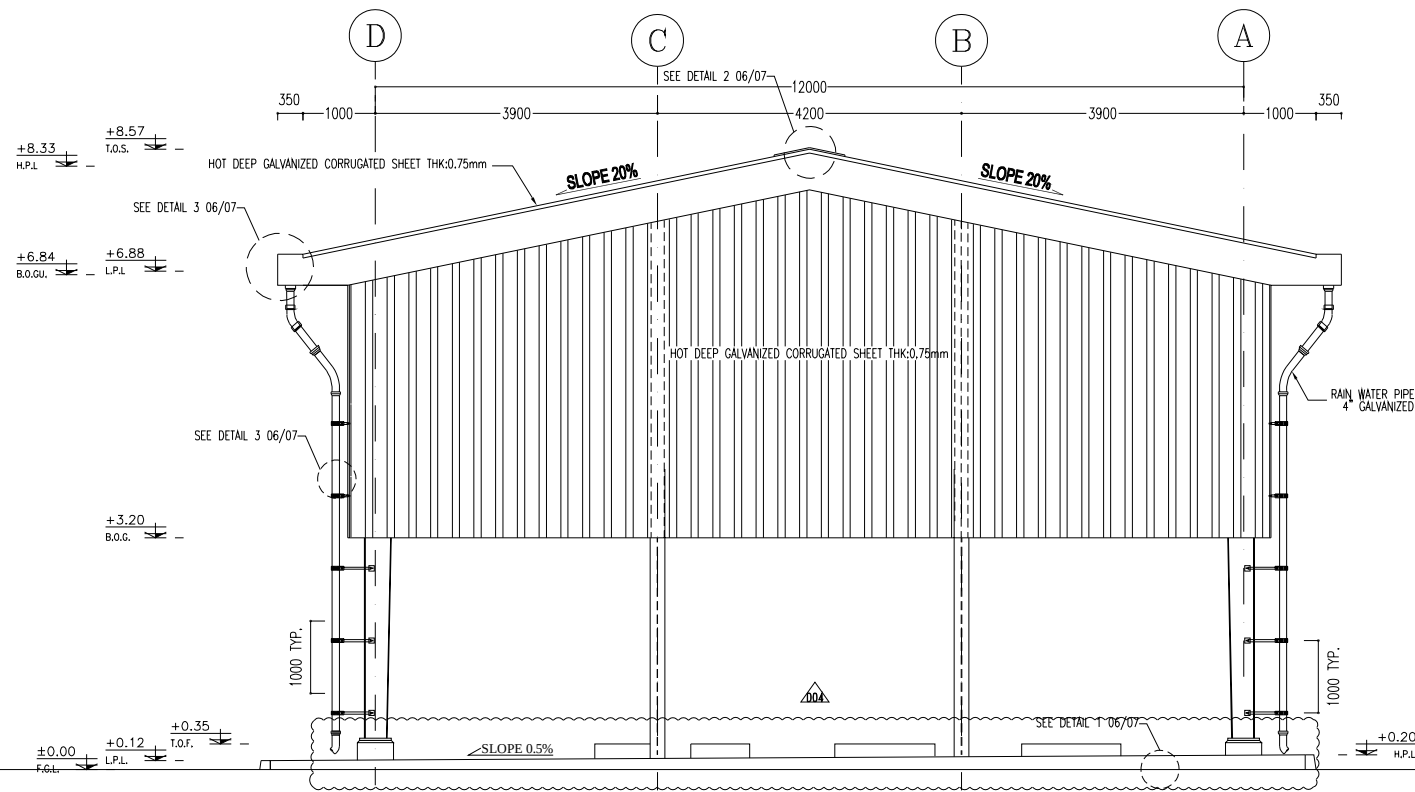


3 ELEVATION
SC:1:50
01 OF 06

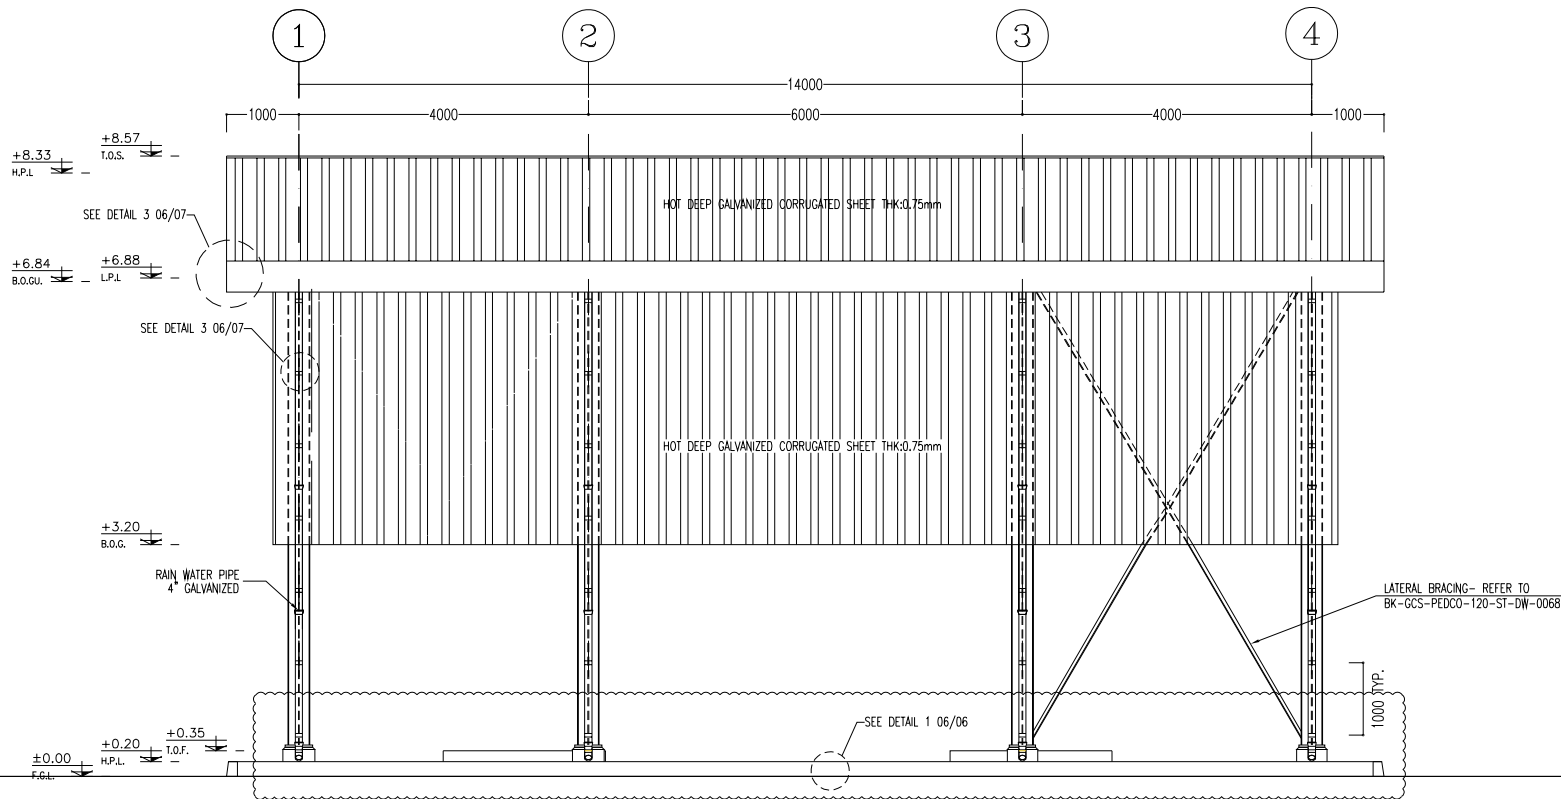

4 ELEVATION
SC:1:50
01 OF 06


NOTES	
1. ALL DIMENSIONS ARE IN MILLIMETER & ALL ELEVATIONS ARE IN METER. 2. ALL DIMENSIONS AND ELEVATIONS SHALL BE CHECKED BY THE CONTRACTOR PRIOR TO CONSTRUCTION. 3. CONTRACTOR SHALL COMPARE ALL ARCHITECTURAL, MECHANICAL, ELECTRICAL, PIPING AND STRUCTURAL DRAWINGS AND IN CASE OF ANY CONFLICTS OR DISCREPANCY, INFORM THE ENGINEER. 4. ALL MATERIALS ARE SELECTED FROM THE HIGHEST QUALITY AND MUST BE APPROVED BY THE CLIENT. 5. ALL OPENINGS FOR PIPING/CABLEING SHALL BE CONSIDERED AS PER RELATED DRAWINGS BEFORE CONSTRUCTION. 6. FINISH GRADING LEVEL IS EQUIVALENT=±0.00 LOCAL=+11.00 QLOBA(M.S.L.)	
LEGEND	
CORRUGATED GALVANIZED METAL SHEET THK. = 0.75mm	
F.G.L. FINISH GRADING LEVEL T.O.F. TOP OF FOUNDATION T.O.B. TOP OF BRACKET B.O.G. BOTTOM OF GIRT T.O.PED. TOP OF PEDESTAL T.O.S. TOP OF SHELTER B.O.GU. BOTTOM OF GUTTER L.P.L. LOWEST POINT LEVEL H.P.L. HIGHEST POINT LEVEL	

REFERENCE DRAWING	DRG. No.
STANDARD DRAWING FOR ARCHITECTURAL DETAILS	BK-GNRL-PEDCO-000-AR-DW-0001
SITE SEWAGE SYSTEM LAYOUT & DETAILS	BK-GCS-PEDCO-120-CV-PY-0001
CABLE TRENCH AND DUCT BANK LAYOUT	BK-GCS-PEDCO-120-CV-PY-0002
ROAD, PAVING AND PLANT FINISH GRADING LAYOUT & SECTIONS	BK-GCS-PEDCO-120-CV-PY-0005
ELECTRICAL CABLE ROUTE & SECTION LAYOUT FOR BUILDING & SHED	BK-GCS-PEDCO-120-EL-PY-0006
FOUNDATION DRAWING FOR UTILITY SHED	BK-GCS-PEDCO-120-ST-DW-0007
STRUCTURAL DRAWING FOR UTILITY SHED	BK-GCS-PEDCO-120-ST-DW-0008
UNIT PLANT PLAN DRAWING	BK-GCS-PEDCO-120-PI-PY-0001
FOUNDATION DRAWING FOR AIR DRYER PACKAGE	BK-GCS-PEDCO-120-ST-DW-69
FOUNDATION DRAWING FOR INSTRUMENT PLANT SR PACKAGE	BK-GCS-PEDCO-120-ST-DW-28
FOUNDATION DRAWING FOR NITROGEN PACKAGE	BK-GCS-PEDCO-120-ST-DW-32
FOUNDATION DRAWINGS FOR NITROGEN RECEIVER DRUM	BK-GCS-PEDCO-120-ST-DW-20
SPECIFICATION FOR CONCRETE WORK	BK-GNRL-PEDCO-000-ST-EP-0001



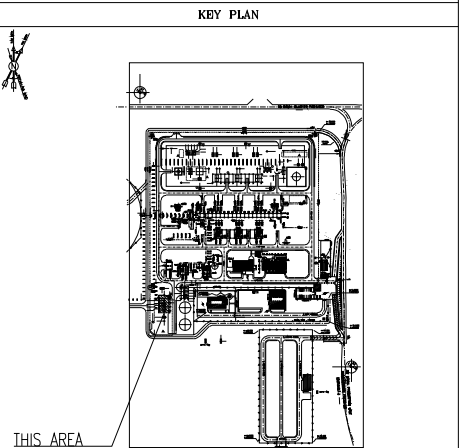


D04	AUG.2023	IFA	R.BERLOUE	M.FAKHARIAN	A.M.MOHESEN	** **
D03	MAY.2023	IFA	R.BERLOUE	M.FAKHARIAN	M.MEHRSHAD	** **
D02	JAN.2023	IFA	R.BERLOUE	M.FAKHARIAN	M.MEHRSHAD	** **
D01	OCT.2022	IPC	R.BERLOUE	M.FAKHARIAN	M.MEHRSHAD	** **
D00	SEP.2022	IPC	R.BERLOUE	M.FAKHARIAN	M.MEHRSHAD	** **
REV.	DATE	P.O.I.S	PREP.	CHK.	APP.	AUT.
PROJECT NAME: BINAK OILFIELD DEVELOPMENT/SURFACE FACILITIES GAS COMPRESSOR STATION						
PROJECT NO.: 971020						
EPC CONTRACTOR:			EPD/EPC CONTRACTOR (GC):			
 HIRGAN ENERGY - DESIGN & INSPECTION COMPANIES			 PETROIRAN DEVELOPMENT COMPANY			
DRAWING TITLE: ARCHITECTURAL DRAWING FOR UTILITY SHELTER ELEVATIONS						
APPROVED FOR CONSTRUCTION			BY:		DATE:	
SCALE	SIZE	DRAWING NO.			SHEET NO.	REV
AS SHOWN	A1	BK-GCS-PEDCO-120-AR-DW-0006			04 OF 07	D04





BINAK OILFIELD DEVELOPMENT SURFACE FACILITIES GAS COMPRESSOR STATION					
DATE	SCALE	DRAWING BY	CHECKED BY	PROJECT ENG.	
NO CONSTRUCTION PERMITTED UNLESS DRAWING APPROVED					
APPROVED FOR CONSTRUCTION			BY:	DATE:	
BUDGET REF.	LOCATION	SIZE	CLASS	SERIAL NO.	SHEET
063-073-9184	F	4	B	708103	04 OF 07
					D04

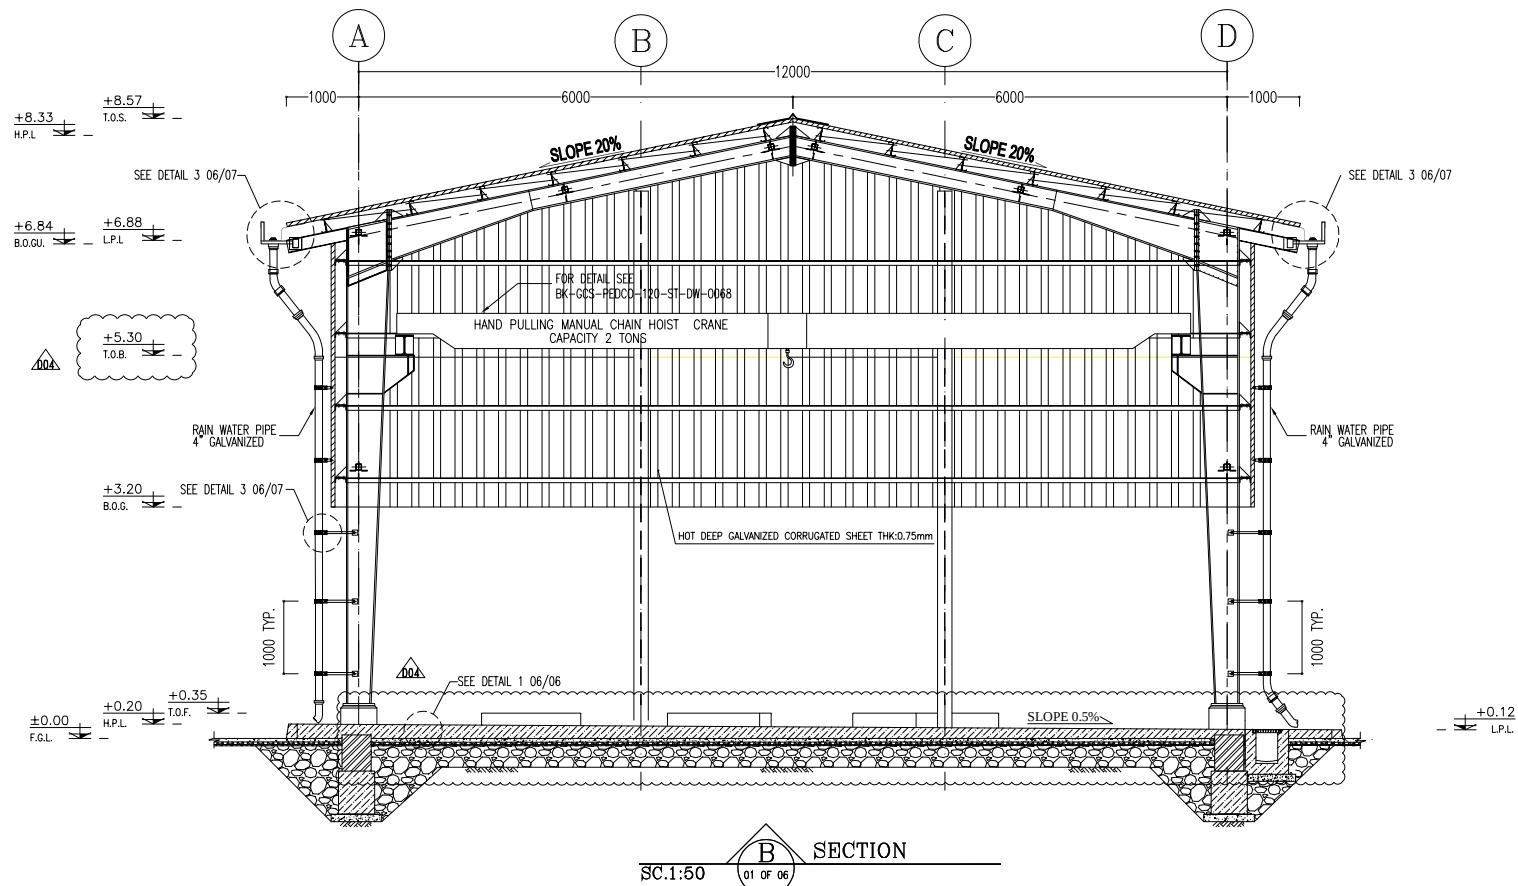

NOTES					
1. ALL DIMENSIONS ARE IN MILLIMETER & ALL ELEVATIONS ARE IN METER. 2. ALL DIMENSIONS AND ELEVATIONS SHALL BE CHECKED BY THE CONTRACTOR PRIOR TO CONSTRUCTION. 3. CONTRACTOR SHALL COMBARE ALL ARCHITECTURAL, MECHANICAL, ELECTRICAL, PIPING AND STRUCTURAL DRAWINGS AND IN CASE OF ANY CONFLICTS OR DISCREPANCY, INFORM THE ENGINEER. 4. ALL MATERIALS ARE SELECTED FROM THE HIGHEST QUALITY AND MUST BE APPROVED BY THE CLIENT. 5. ALL OPENINGS FOR PIPING/CABLEING SHALL BE CONSIDERED AS PER RELATED DRAWINGS BEFORE CONSTRUCTION. 6. FINISH GRADING LEVEL IS EQUIVALENT=+0.00 (LOCAL=+11.00 GDAH(M.S.L.))					
LEGEND					
CORRUGATED GALVANIZED METAL SHEET THK. = 0.75mm					
REINFORCED CONCRETE					
BLOCKAGE					
PRESSED BRICK					
LEAN CONCRETE					
F.G.L.	FINISH GRADING LEVEL				
T.O.F.	TOP OF FOUNDATION				
T.O.B.	TOP OF BRACKET				
B.O.G.	BOTTOM OF GIRT				
T.O.PED.	TOP OF PEDESTAL				
T.O.S.	TOP OF SHELTER				
B.O.GU.	BOTTOM OF GUTTER				
L.P.L.	LOWEST POINT LEVEL				
H.P.L.	HIGHEST POINT LEVEL				
REFERENCE DRAWING			DRG. No.		
STANDARD DRAWING FOR ARCHITECTURAL DETAILS			BK-GNRL-PEDCO-000-AR-DW-0001		
SITE SEWAGE SYSTEM LAYOUT & DETAILS			BK-GCS-PEDCO-120-CV-PY-0001		
CABLE TRENCH AND DUCT BANK LAYOUT			BK-GCS-PEDCO-120-CV-PY-0002		
ROAD, PAVING AND PLANT FINISH GRADING LAYOUT & SECTIONS			BK-GCS-PEDCO-120-CV-PY-0006		
ELECTRICAL CABLE ROUTE & SECTION LAYOUT FOR BUILDING & SHELTER			BK-GCS-PEDCO-120-EL-PY-0006		
FOUNDATION DRAWING FOR UTILITY SHELTER			BK-GCS-PEDCO-120-ST-DW-0067		
STRUCTURAL DRAWING FOR UTILITY SHELTER			BK-GCS-PEDCO-120-ST-DW-0068		
UNIT PLOT PLANT DRAWING			BK-GCS-PEDCO-120-PI-PY-0001		
FOUNDATION DRAWING FOR AIR DRYER PACKAGES			BK-GCS-PEDCO-120-ST-DW-00		
FOUNDATION DRAWING FOR INSTRUMENT PLANT AIR PACKAGES			BK-GCS-PEDCO-120-ST-DW-28		
FOUNDATION DRAWING FOR NITROGEN PACKAGES			BK-GCS-PEDCO-120-ST-DW-32		
FOUNDATION DRAWINGS FOR NITROGEN RECEIVER DRUM			BK-GCS-PEDCO-120-ST-DW-20		
SPECIFICATION FOR CONCRETE WORK			BK-GNRL-PEDCO-000-ST-SP-0001		
KEY PLAN					
***	*****	** **	*** ****	** **	*** ****
REV.	DESCRIPTION	BY	DATE	BY	DATE
		CHECKED		REV. APPR.	
اصل و کاپیه نسخ این نقشه و حق اقتباس متعلق به شرکت ملی مناطق نفت خیز جنوب میباشد. THE ORIGINAL AND ALL COPIES OF THIS DRAWING TOGETHER WITH THE COPYRIGHT THEREIN ARE THE SOLE PROPERTY OF N.I.S.O.C./ FIELDS					
BINAK OILFIELD DEVELOPMENT					
SURFACE FACILITIES					
GAS COMPRESSOR STATION					
DATE	SCALE	DRAWING BY	CHECKED BY	PROJECT ENG.	
NO CONSTRUCTION PERMITTED UNLESS DRAWING APPROVED					
APPROVED FOR CONSTRUCTION			BY:		DATE:
BUDGET REF.	LOCATION	SIZE CLASS	SERIAL NO.	SHEET	REVISION
063-073-9184	F	4	B	709103	06 OF 07
				D04	

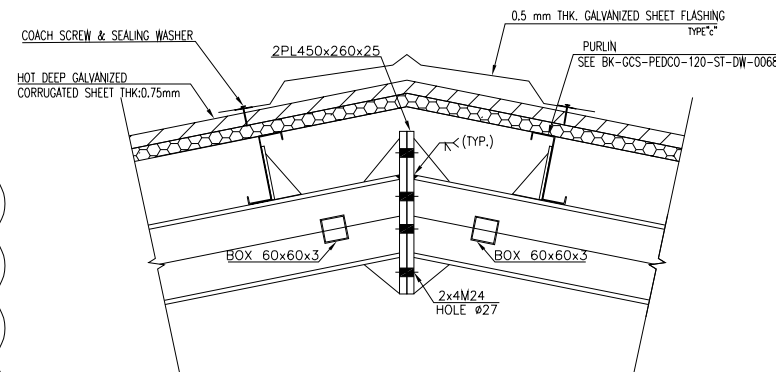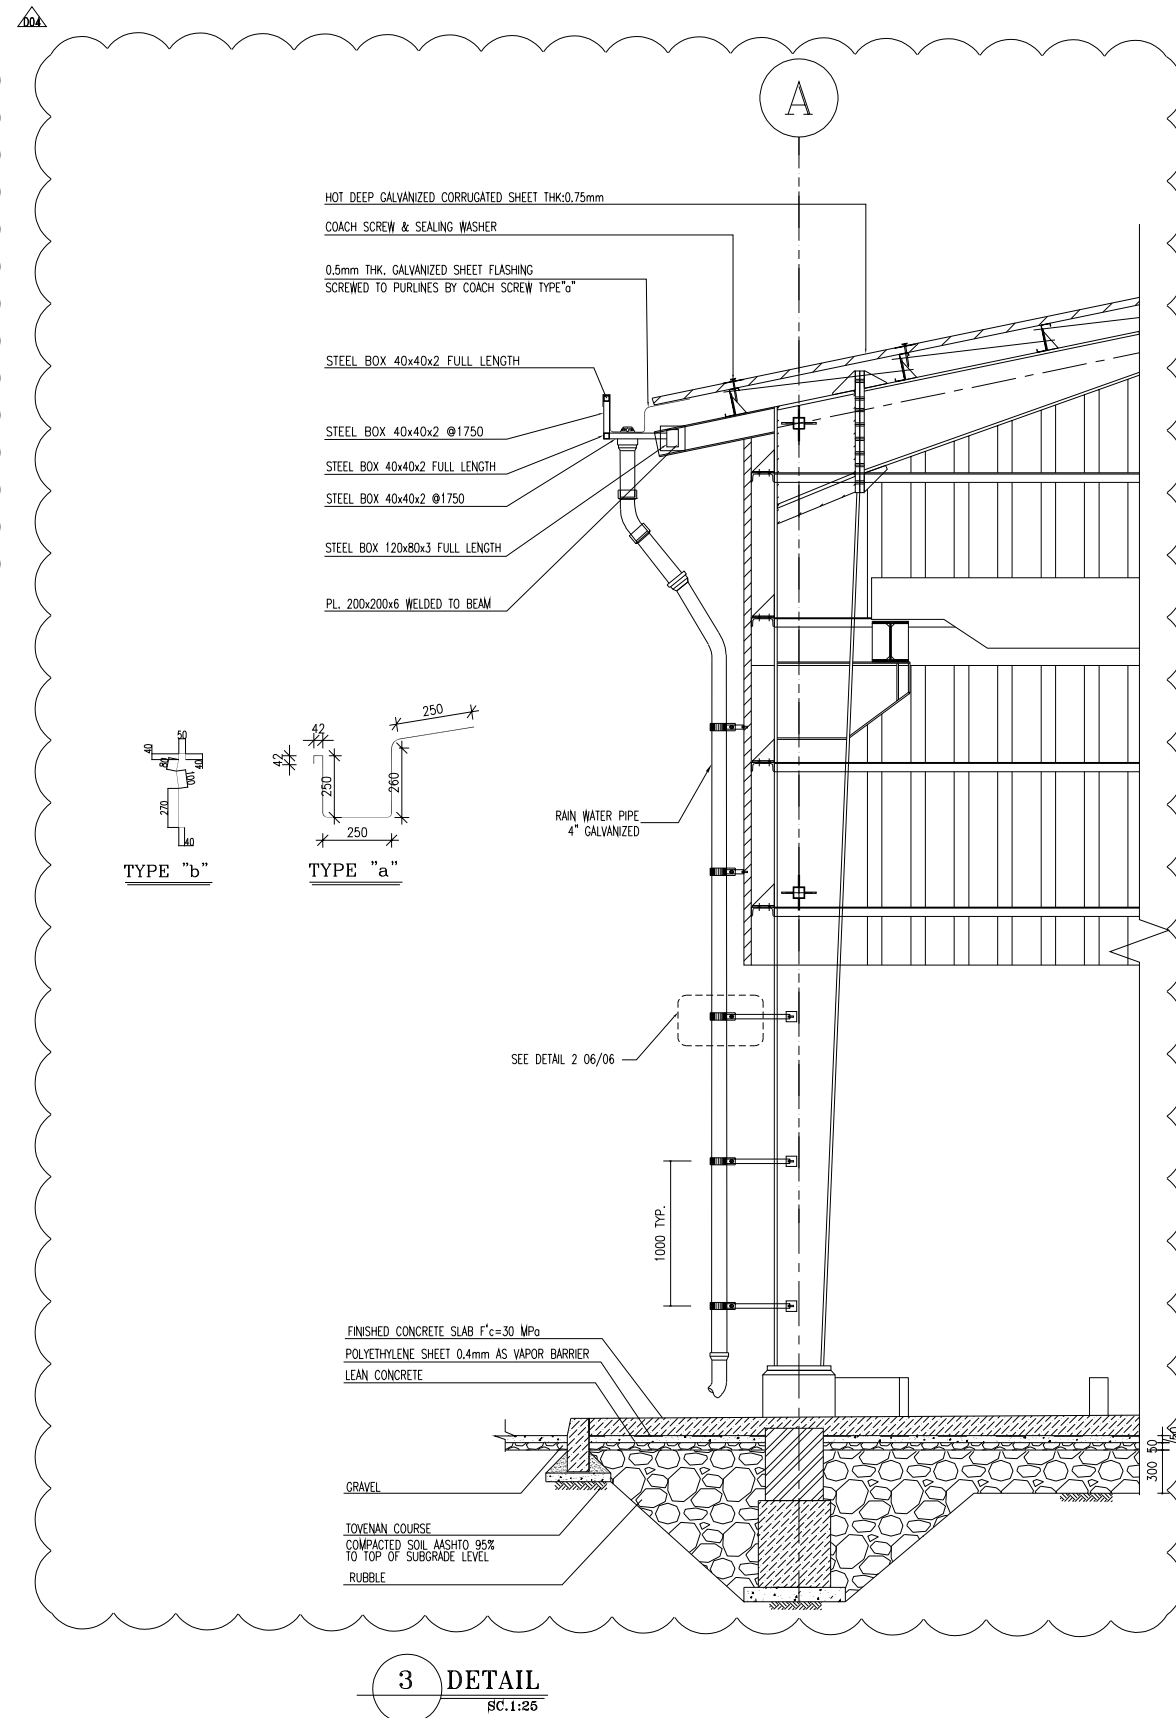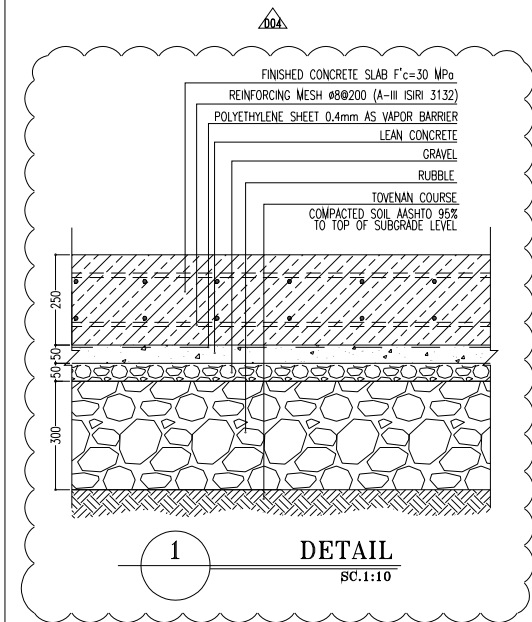

TYPE "c"
SC.1:5

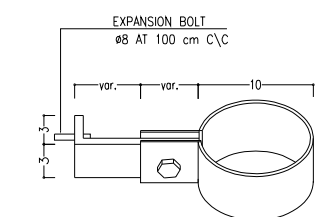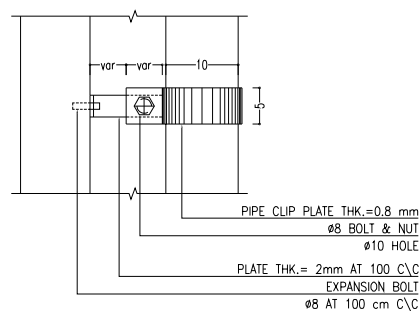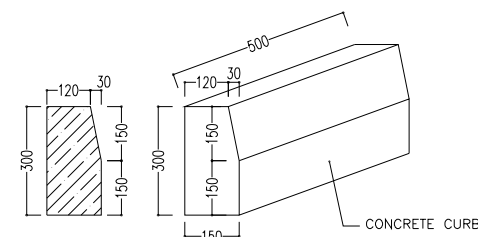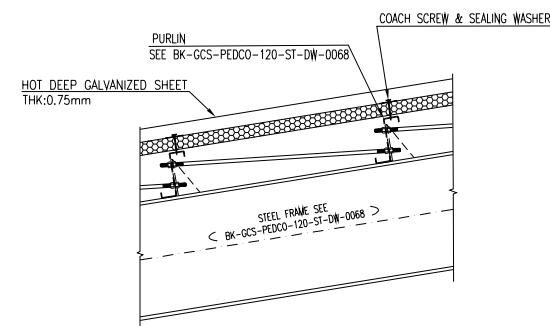

NOTES

1. ALL DIMENSIONS ARE IN MILLIMETER & ALL ELEVATIONS ARE IN METER.

2. ALL DIMENSIONS AND ELEVATIONS SHALL BE CHECKED BY THE CONTRACTOR PRIOR TO CONSTRUCTION.

3. CONTRACTOR SHALL COMPLY ALL ARCHITECTURAL, MECHANICAL, ELECTRICAL, PIPING AND STRUCTURAL DRAWINGS AND IN CASE OF ANY CONFLICTS OR DISCREPANCY, INFORM THE ENGINEER.

4. ALL MATERIALS ARE SELECTED FROM THE HIGHEST QUALITY AND MUST BE APPROVED BY THE CLIENT.

5. ALL OPENINGS FOR PIPING/CABLEING SHALL BE CONSIDERED AS PER RELATED DRAWINGS BEFORE CONSTRUCTION.

6. FINISH GRADING LEVEL IS EQUIVALENT+0.00 LOCAL+11.00 GLOBAL(M.S.L.)

LEGEND

CORRUGATED GALVANIZED METAL SHEET THK. = 0.75mm

REINFORCED CONCRETE

BLOCKAGE

PRESSED BRICK

LEAN CONCRETE

F.G.L. FINISH GRADING LEVEL

T.O.F. TOP OF FOUNDATION

T.O.B. TOP OF BRACKET

B.O.G. BOTTOM OF GIRT

T.O.PED. TOP OF PEDESTAL

T.O.S. TOP OF SHELTER

B.O.GU. BOTTOM OF GUTTER

L.P.L. LOWEST POINT LEVEL

H.P.L. HIGHEST POINT LEVEL

REFERENCE DRAWING

DRG. No.

STANDARD DRAWING FOR ARCHITECTURAL DETAILS

BK-GNRL-PEDCO-000-AR-DW-0001

SITE SEWAGE SYSTEM LAYOUT & DETAILS

BK-GCS-PEDCO-120-CV-PY-0001

CABLE TRENCH AND DUCT BANK LAYOUT

BK-GCS-PEDCO-120-CV-PY-0002

ROAD, PAVING AND PLANT FINISH GRADING LAYOUT & SECTIONS

BK-GCS-PEDCO-120-CV-PY-0006

ELECTRICAL CABLE ROUTE & SECTION LAYOUT FOR BUILDING & SHED

BK-GCS-PEDCO-120-EL-PY-0006

FOUNDATION DRAWING FOR UTILITY SHED

BK-GCS-PEDCO-120-ST-DW-0007

STRUCTURAL DRAWING FOR UTILITY SHED

BK-GCS-PEDCO-120-ST-DW-0008

UNIT PLANT PLAN DRAWING

BK-GCS-PEDCO-120-PI-PY-0001

FOUNDATION DRAWING FOR AIR DRYER PACKAGE

BK-GCS-PEDCO-120-ST-DW-69

FOUNDATION DRAWING FOR INSTRUMENT PLANT SR PACKAGE

BK-GCS-PEDCO-120-ST-DW-28

FOUNDATION DRAWING FOR NITROGEN PACKAGE

BK-GCS-PEDCO-120-ST-DW-32

FOUNDATION DRAWINGS FOR NITROGEN RECEIVER DRUM

BK-GCS-PEDCO-120-ST-DW-20

SPECIFICATION FOR CONCRETE WORK

BK-GNRL-PEDCO-000-ST-EP-0001

KEY PLAN

THIS AREA

REV.

DESCRIPTION

BY

DATE

CHECKED

REV. APPR.

THE ORIGINAL AND ALL COPIES OF THIS DRAWING TOGETHER WITH THE COPYRIGHT THEREIN ARE THE SOLE PROPERTY OF N.I.S.O.C./ FIELDS

BINAK OILFIELD DEVELOPMENT

SURFACE FACILITIES

GAS COMPRESSOR STATION

DATE

SCALE

DRAWING BY

CHECKED BY

PROJECT ENG.

NO CONSTRUCTION PERMITTED UNLESS DRAWING APPROVED

APPROVED FOR CONSTRUCTION

BY:

DATE:

BUDGET REF.

LOCATION

SIZE CLASS

SERIAL NO.

SHEET

REVISION

063-073-9184

F



4

B


709103

06 OF 07


D04

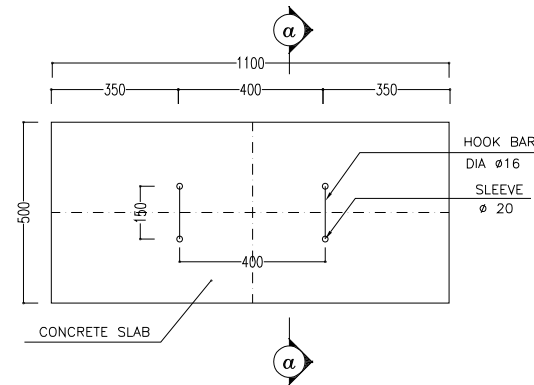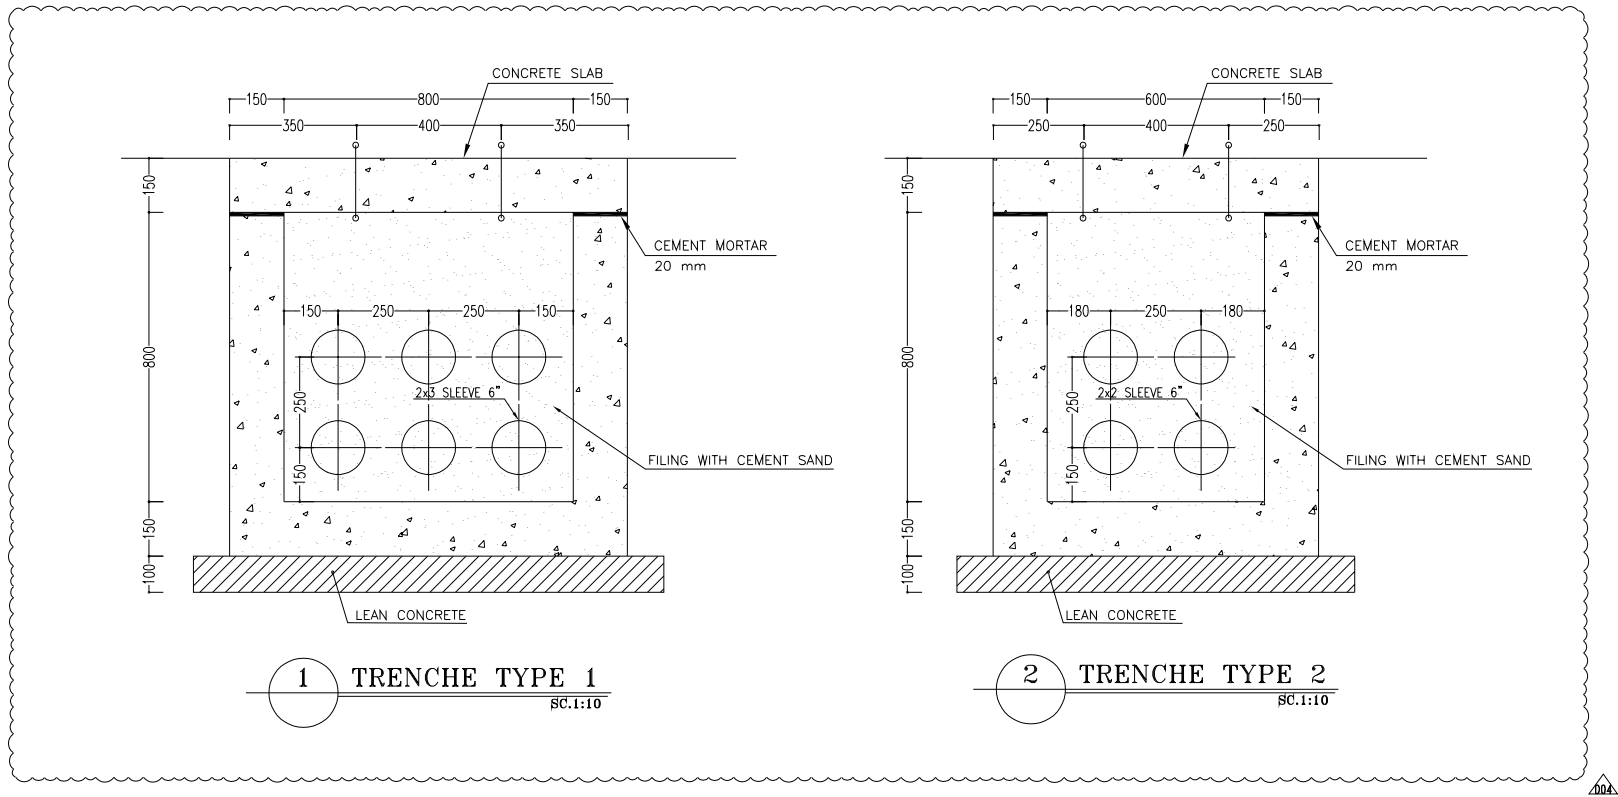


5 CONCRETE SLAB PLAN
TRENCH TYPE 1 SC.1:10

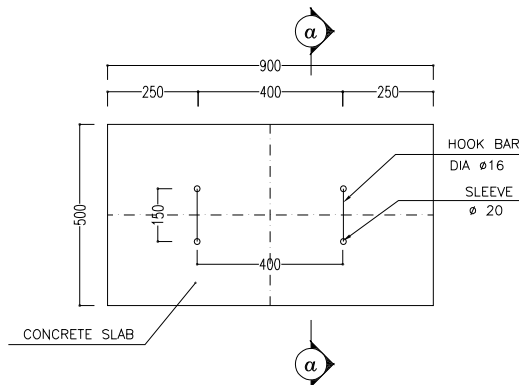


6 CONCRETE SLAB PLAN
TRENCH TYPE 2 SC.1:10

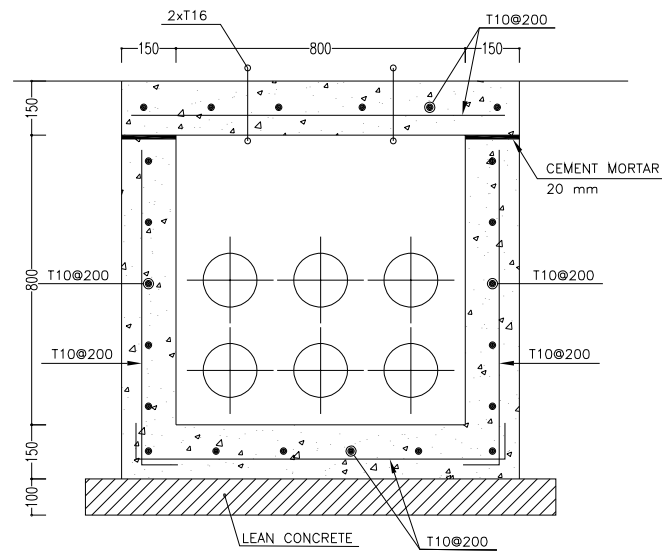

3 TRENCH TYPE 1 (REINFORCEMENT)
SC.1:10

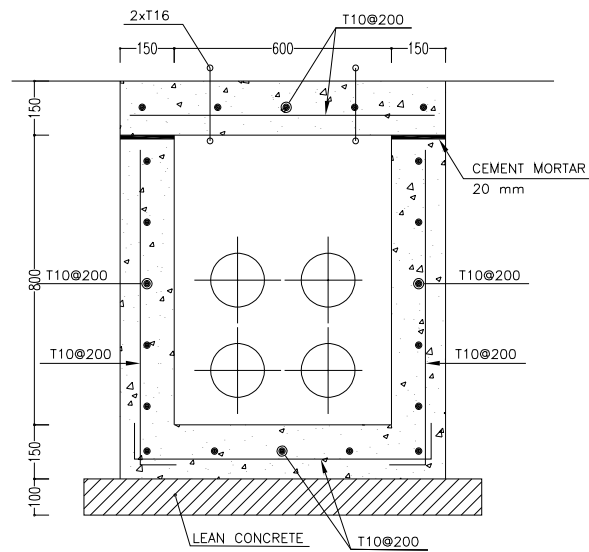


4 TRENCH TYPE 2 (REINFORCEMENT)
SC.1:10

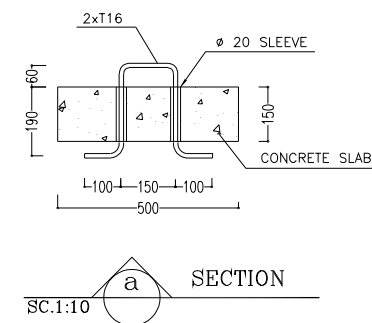

NOTES	
1. ALL DIMENSIONS ARE IN MILLIMETER & ALL ELEVATIONS ARE IN METER. 2. ALL DIMENSIONS AND ELEVATIONS SHALL BE CHECKED BY THE CONTRACTOR PRIOR TO CONSTRUCTION. 3. CONTRACTOR SHALL COMPLY ALL ARCHITECTURAL, MECHANICAL, ELECTRICAL, PIPING AND STRUCTURAL DRAWINGS AND IN CASE OF ANY CONFLICTS OR DISCREPANCY, INFORM THE ENGINEER. 4. ALL MATERIALS ARE SELECTED FROM THE HIGHEST QUALITY AND MUST BE APPROVED BY THE CLIENT. 5. ALL OPENINGS FOR PIPING/CABLEING SHALL BE CONSIDERED AS PER RELATED DRAWINGS BEFORE CONSTRUCTION. 6. FINISH GRADING LEVEL IS EQUIVALENT+0.00 LOCAL=+11.00 GLOBAL(M.S.L.)	
LEGEND	
CORRUGATED GALVANIZED METAL SHEET THK. = 0.75mm	
REINFORCED CONCRETE	
BLOCKAGE	
PRESSED BRICK	
LEAN CONCRETE	
F.G.L.	FINISH GRADING LEVEL
T.O.F.	TOP OF FOUNDATION
T.O.B.	TOP OF BRACKET
B.O.G.	BOTTOM OF GIRT
T.O.PED.	TOP OF PEDESTAL
T.O.S.	TOP OF SHELTER
B.O.GU.	BOTTOM OF GUTTER
L.P.L.	LOWEST POINT LEVEL
H.P.L.	HIGHEST POINT LEVEL

REFERENCE DRAWING	DRG. No.
STANDARD DRAWING FOR ARCHITECTURAL DETAILS	BK-GNRL-PEDCO-000-AR-DW-0001
SITE SEWAGE SYSTEM LAYOUT & DETAILS	BK-GCS-PEDCO-120-CV-PY-0001
CABLE TRENCH AND DUCT BANK LAYOUT	BK-GCS-PEDCO-120-CV-PY-0002
ROAD, PAVING AND PLANT FINISH GRADING LAYOUT & SECTIONS	BK-GCS-PEDCO-120-CV-PY-0005
ELECTRICAL CABLE ROUTE & SECTION LAYOUT FOR BUILDING & SHEDS	BK-GCS-PEDCO-120-EL-PY-0006
FOUNDATION DRAWING FOR UTILITY SHEDS	BK-GCS-PEDCO-120-ST-DW-0007
STRUCTURAL DRAWING FOR UTILITY SHEDS	BK-GCS-PEDCO-120-ST-DW-0008
UNIT PLANT PLAN DRAWING	BK-GCS-PEDCO-120-PI-PY-0001
FOUNDATION DRAWING FOR AIR DRYER PACKAGES	BK-GCS-PEDCO-120-ST-DW-0009
FOUNDATION DRAWING FOR INSTRUMENT PLANT SR PACKAGES	BK-GCS-PEDCO-120-ST-DW-0028
FOUNDATION DRAWING FOR NITROGEN PACKAGES	BK-GCS-PEDCO-120-ST-DW-0032
FOUNDATION DRAWINGS FOR NITROGEN RECEIVER DRUM	BK-GCS-PEDCO-120-ST-DW-0020
SPECIFICATION FOR CONCRETE WORK	BK-GNRL-PEDCO-000-ST-SP-0001

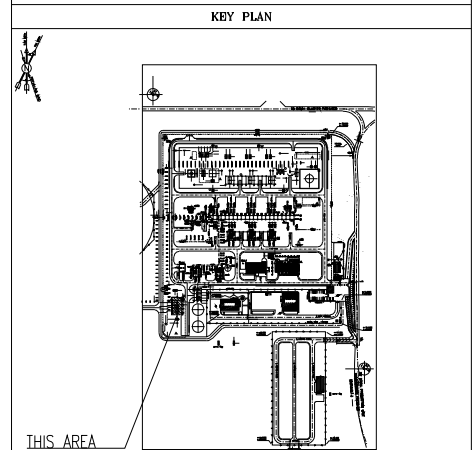

D04	AUG.2023	IFA	R.BERLOUE	M.FAKHARIAN	A.M.MOHESEN	**													
D03	MAY.2023	IFA	R.BERLOUE	M.FAKHARIAN	M.MEHRSHAD	**													
D02	JAN.2023	IFA	R.BERLOUE	M.FAKHARIAN	M.MEHRSHAD	**	***	*****		**	***.****		**		***.****				
D01	OCT.2022	IPC	R.BERLOUE	M.FAKHARIAN	M.MEHRSHAD	**													
D00	SEP.2022	IPC	R.BERLOUE	M.FAKHARIAN	M.MEHRSHAD	**													
REV.	DATE	P.O.I.S	PREP.	CHK.	APP.	AUT.	REV.	DESCRIPTION		BY	DATE		BY	DATE		CHECKED		REV. APPR.	
							احمل و کلیه نسخ این نقشه و حق اقتباس متعلق به شرکت ملی مناطق نفت خیز جنوب می باشد.												
PROJECT NAME:							THE ORIGINAL AND ALL COPIES OF THIS DRAWING TOGETHER WITH THE COPYRIGHT THEREIN ARE THE SOLE PROPERTY OF N.I.S.O.C./ FIELDS												
PROJECT NO.:							971020												
EPC CONTRACTOR:			EPD/EPC CONTRACTOR (GC):				BINAK OILFIELD DEVELOPMENT SURFACE FACILITIES GAS COMPRESSOR STATION												
																			
HIRGAN ENERGY - DESIGN & INSPECTION COMPANIES			PEDCO																
DRAWING TITLE:							NO CONSTRUCTION PERMITTED UNLESS DRAWING APPROVED												
ARCHITECTURAL DRAWING FOR UTILITY SHELTER DETAILS							APPROVED FOR CONSTRUCTION												
SCALE		SIZE		DRAWING NO.		SHEET NO.	REV.	BUDGET REF.	LOCATION	SIZE	CLASS	SERIAL NO.	BY:	DATE:					
AS SHOWN		A1		BK-GCS-PEDCO-120-AR-DW-0006		07 OF 07	D04	063-073-9184	F	4	B	709103		07 OF 07		D04			