


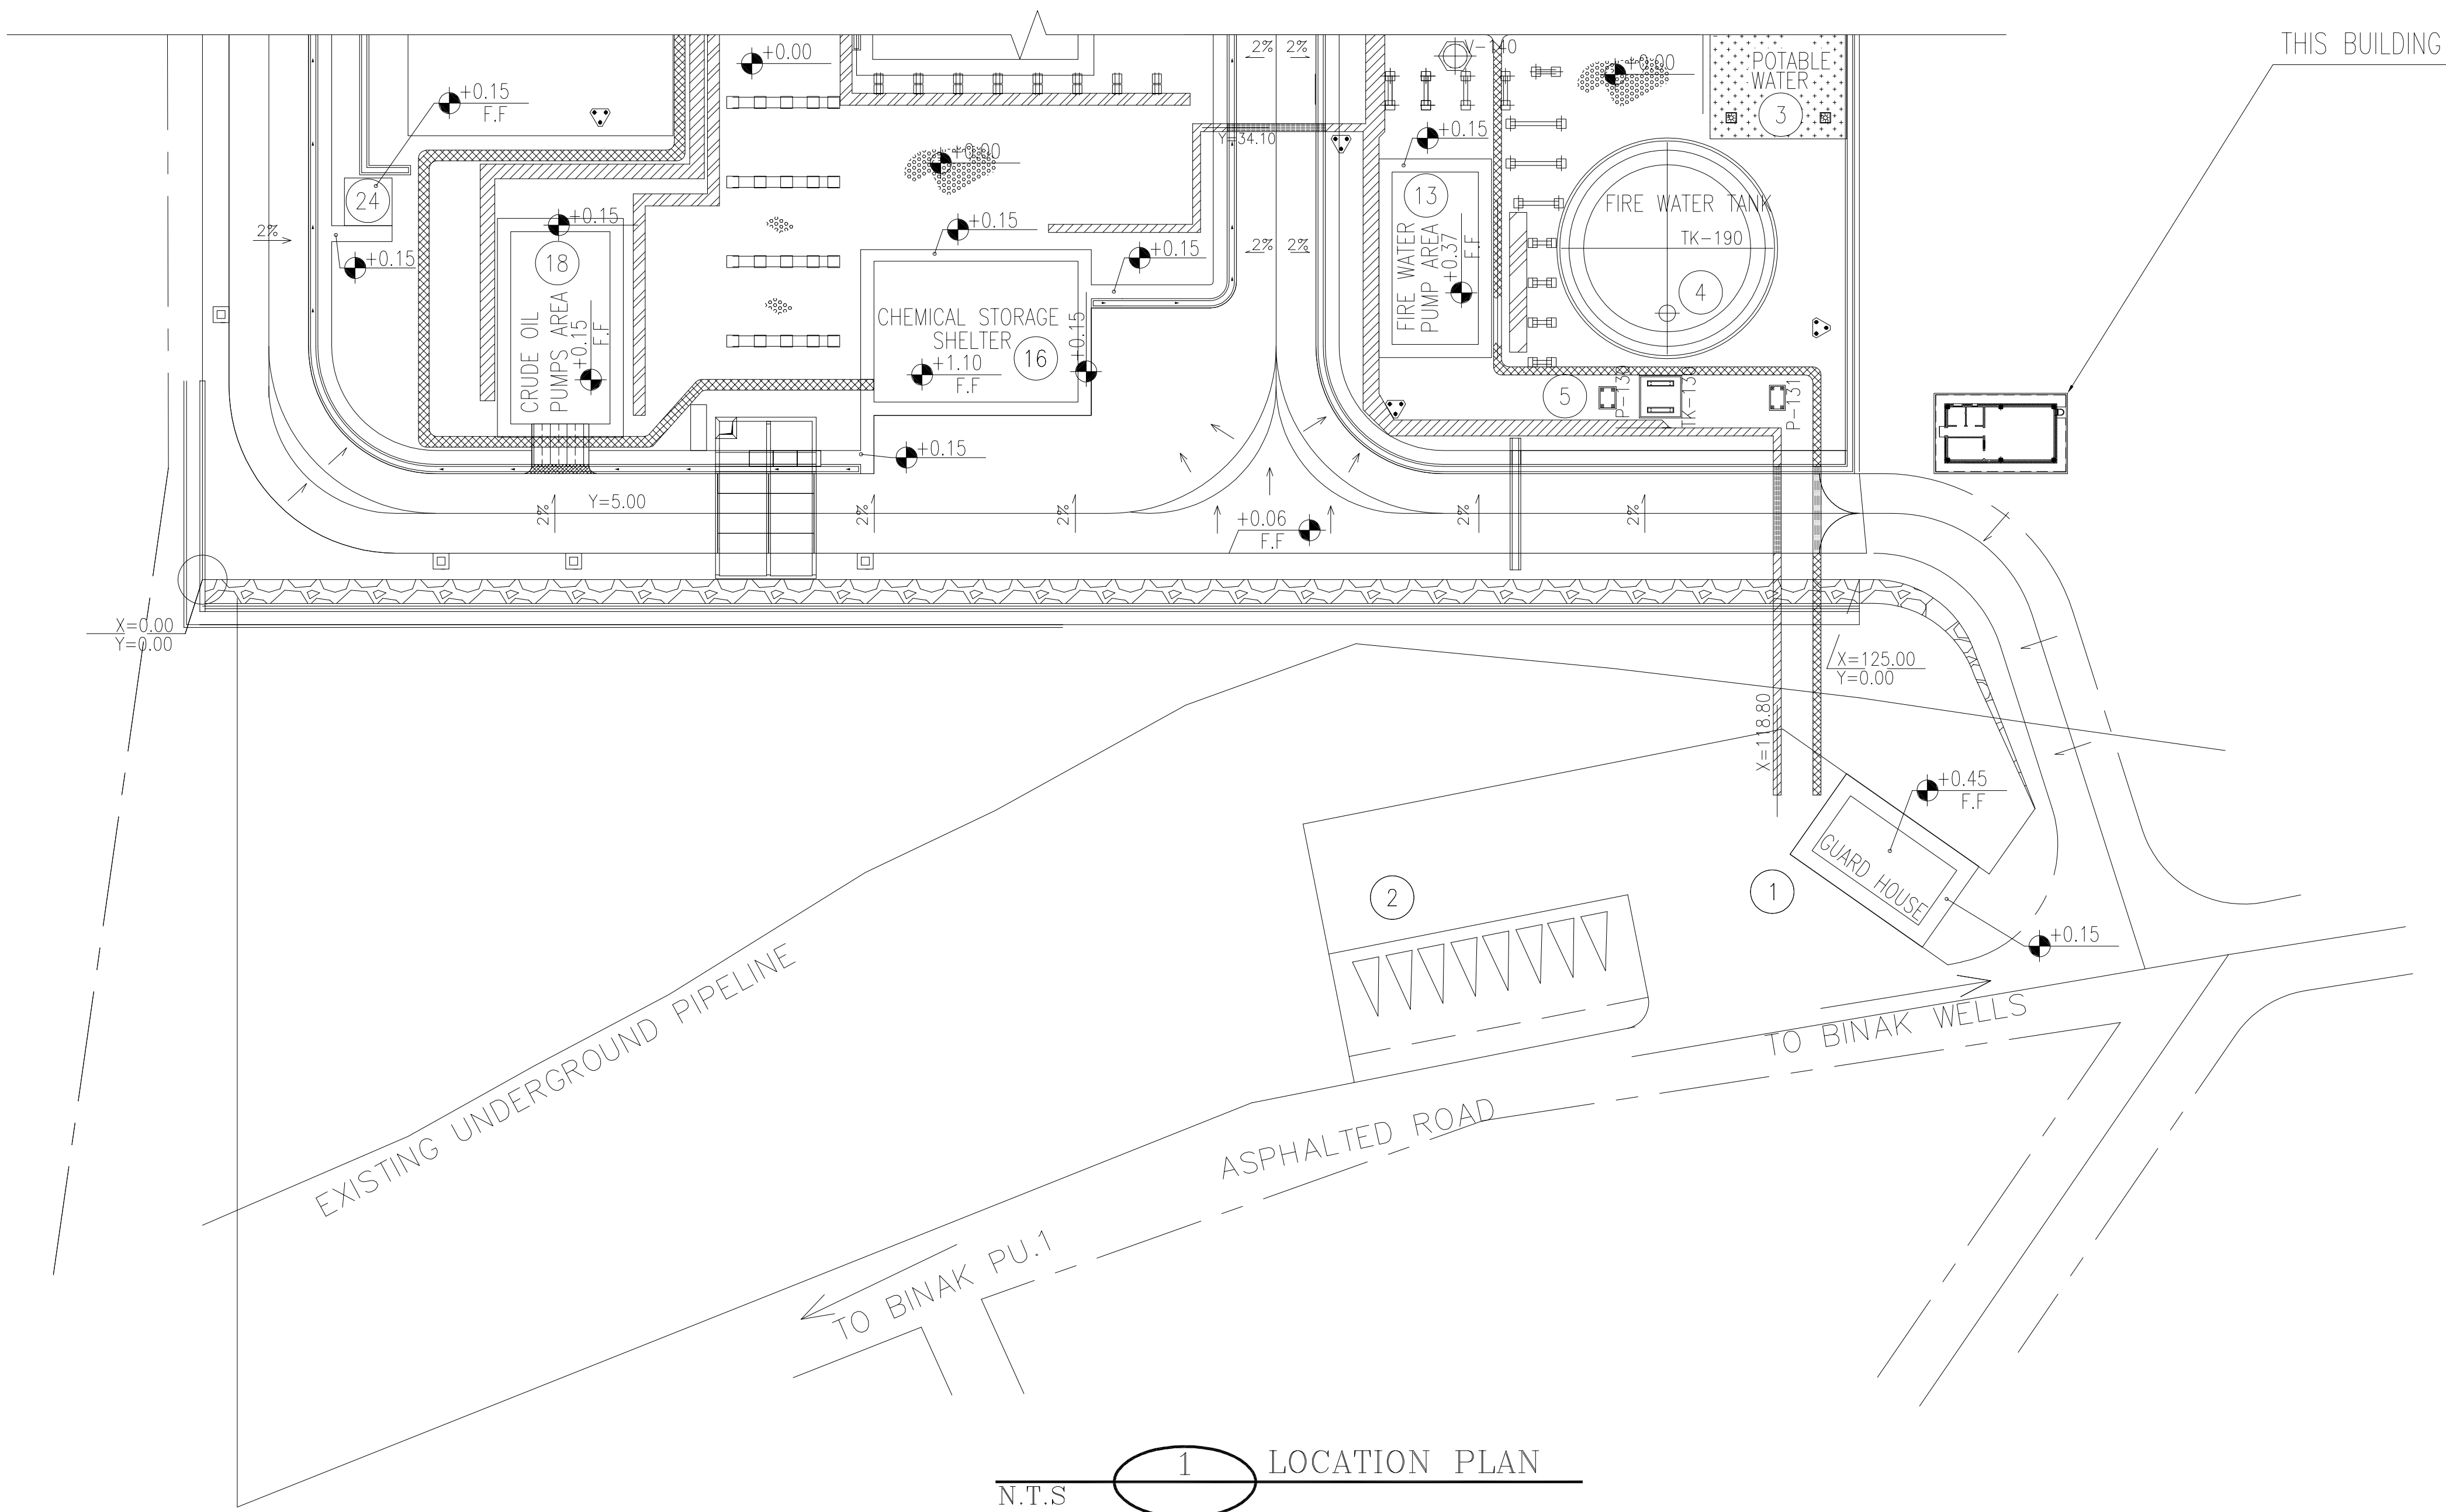

1. ALL DIMENSIONS ARE IN CENTIMETER & ALL ELEVATIONS ARE IN METER.
2. ALL DIMENSIONS AND ELEVATIONS SHALL BE CHECKED BY THE CONTRACTOR PRIOR TO CONSTRUCTION.
3. CONTRACTOR SHALL COMPARE ALL ARCHITECTURAL, MECHANICAL, ELECTRICAL, PIPING AND STRUCTURAL DRAWINGS AND IN CASE OF ANY CONFLICTS OR DISCREPANCY, INFORM THE ENGINEER IMMEDIATELY.
4. ALL MATERIALS SUPPLIED FOR THE PROJECT SHALL BE APPROVED BY THE CLIENT.
5. ALL OPENINGS FOR PIPING/CABLE/HVAC OPENINGS SHALL BE CONSIDERED AS PER RELATED DRAWINGS BEFORE CONSTRUCTION.
6. FINISH GRADING LEVEL IS/EQUALING=+0.00 LOCAL=+243.00 GLOBAL(M.S.L.).
7. POINT OT: EL:3485/6880 , N:4415/3406 (UTM-ZONE 39). THIS COORDINATION IS PRELIMINARY AND WILL BE FINALIZED IN THE NEXT REVISION.

F.F.L.	FINISHED FLOOR LEVEL
T.O.W.A.	TOP OF WALKWAY
T.O.P.	TOP OF PARAPET
T.O.S.	TOP OF SLAB
T.O.D.	TOP OF DOOR
T.O.W.	TOP OF WINDOW
B.O.W.	BOTTOM OF WINDOW
T.O.C.	TOP OF CAGE
B.O.C.	BOTTOM OF CAGE
B.O.F.	BOTTOM OF FALSE FLOOR
B.O.S.U.	BOTTOM OF SUSPENDED
B.O.S.	BOTTOM OF SLEEVE
F.G.L.	FINISH GRADING LEVEL

REFERENCE DRAWING	DRG. No.
STANDARD DRAWING FOR ARCHITECTURAL DETAILS	BK-GNRL-PEDCO-000-AR-DW-0001
SITE SEWAGEAGE SYSTEM LAYOUT & DETAILS	BK-GCS-PEDCO-120-CV-PY-0001
CABLE TRENCH AND DUCT BANK LAYOUT	BK-GCS-PEDCO-120-CV-PY-0002
ROAD, PAVING AND PLANT FINISH GRADING LAYOUT & SECTIONS	BK-GCS-PEDCO-120-CV-PY-0003
ELECTRICAL CABLE ROUTE & SECTION LAYOUT FOR BUILDING & SHELFER	BK-GCS-PEDCO-120-EL-PY-0005
FOUNDATION DRAWING FOR CITY CONTROL ROOM - INSAK DU	BK-GCS-PEDCO-120-ST-DW-0077
STRUCTURAL DRAWING FOR CCY CONTROL ROOM - INSAK DU	BK-GCS-PEDCO-120-ST-DW-0078
STANDARD DETAILS FOR LADDER & SAFETY CAGE	BK-GNRL-PEDCO-000-ST-DW-0009

THIS DRAWING




[illegible]



[illegible]



SC.1:50 3 FURNITURE PLAN

 
[illegible]

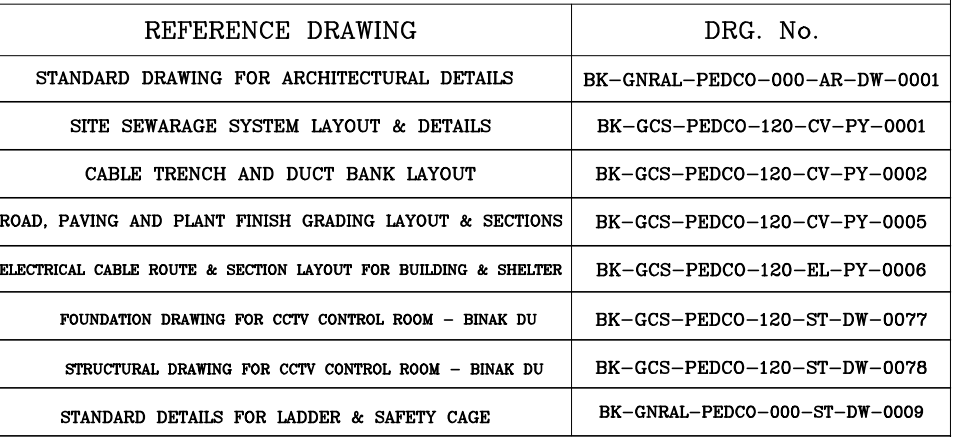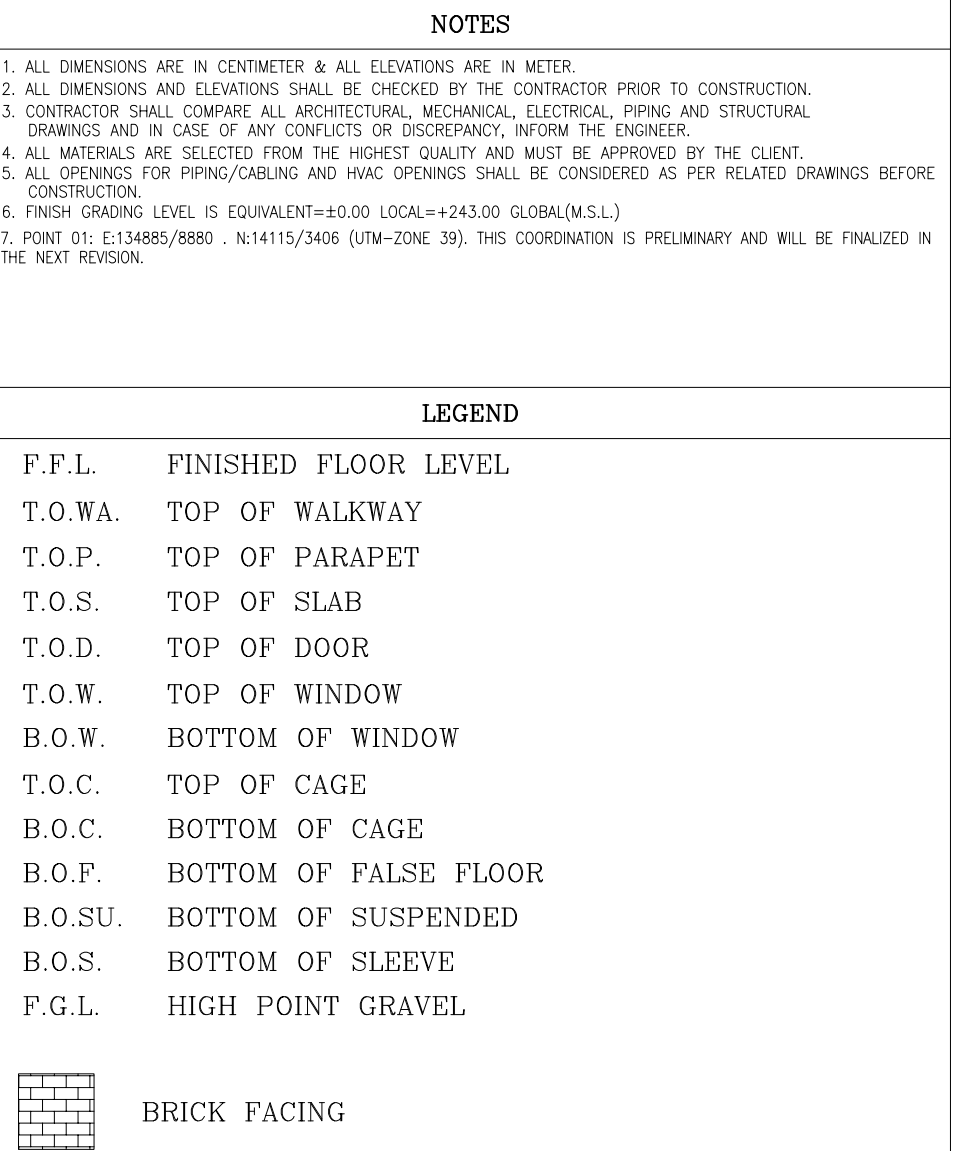[illegible]

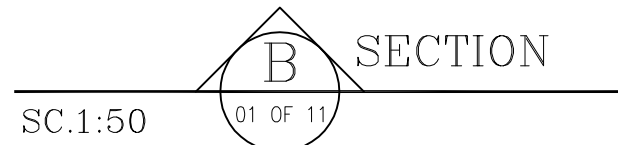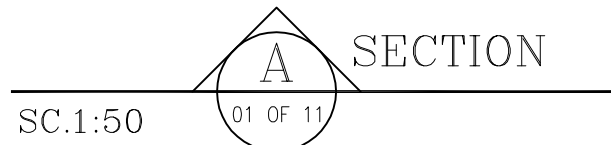


3 FINISHING SCHEDULE


[illegible]

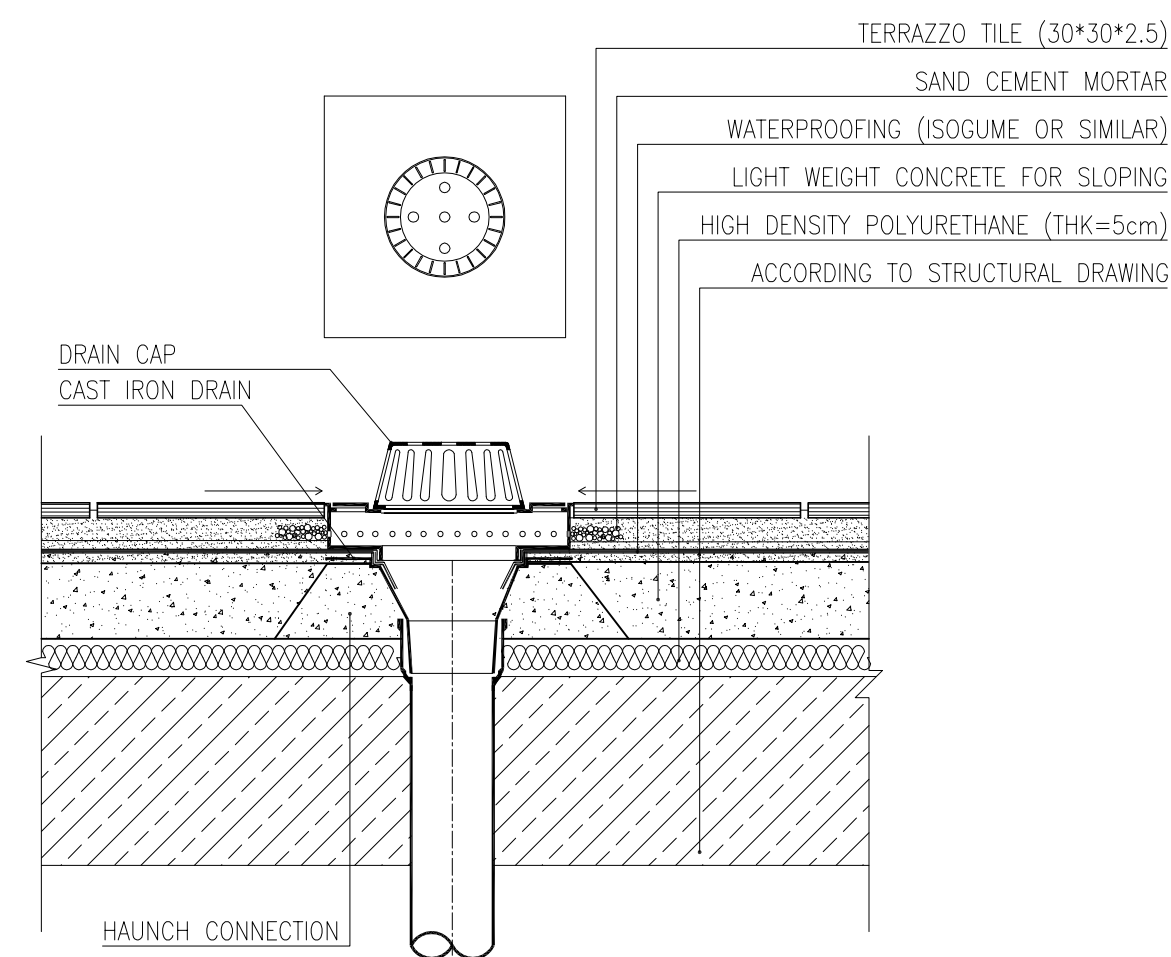


DETAIL 04
Sc:1/10

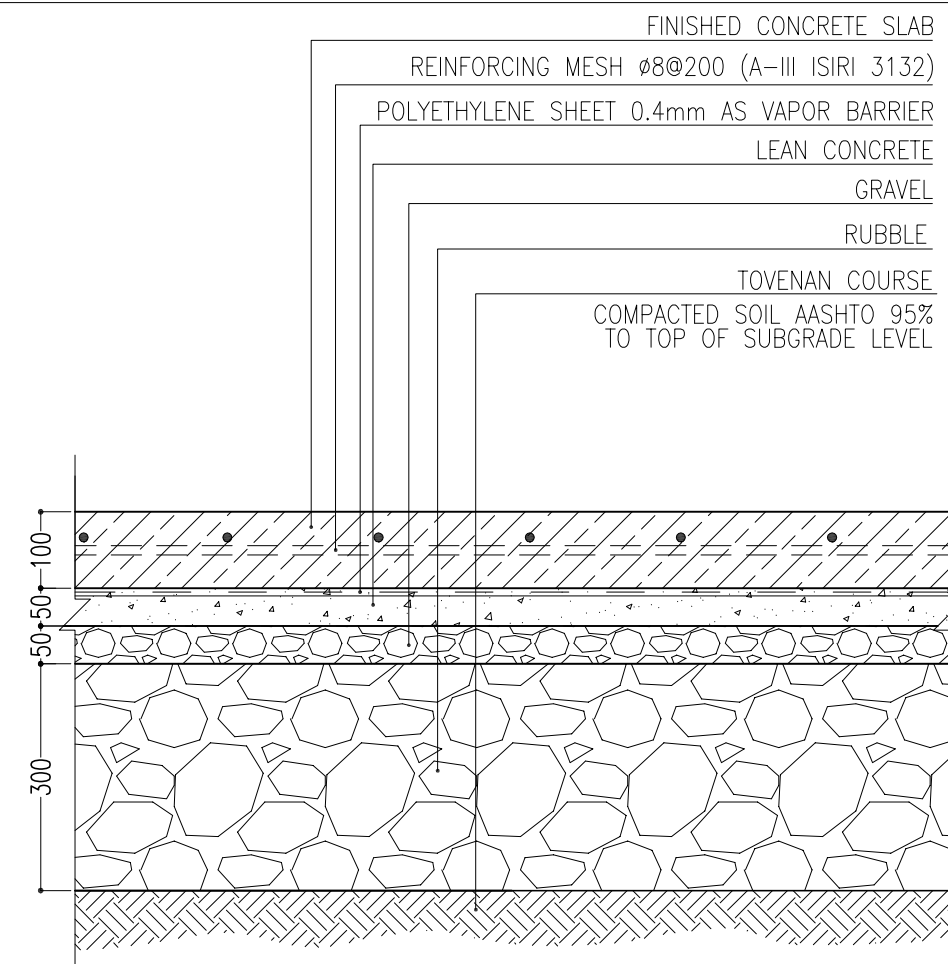


DETAIL 08
Sc:1/10

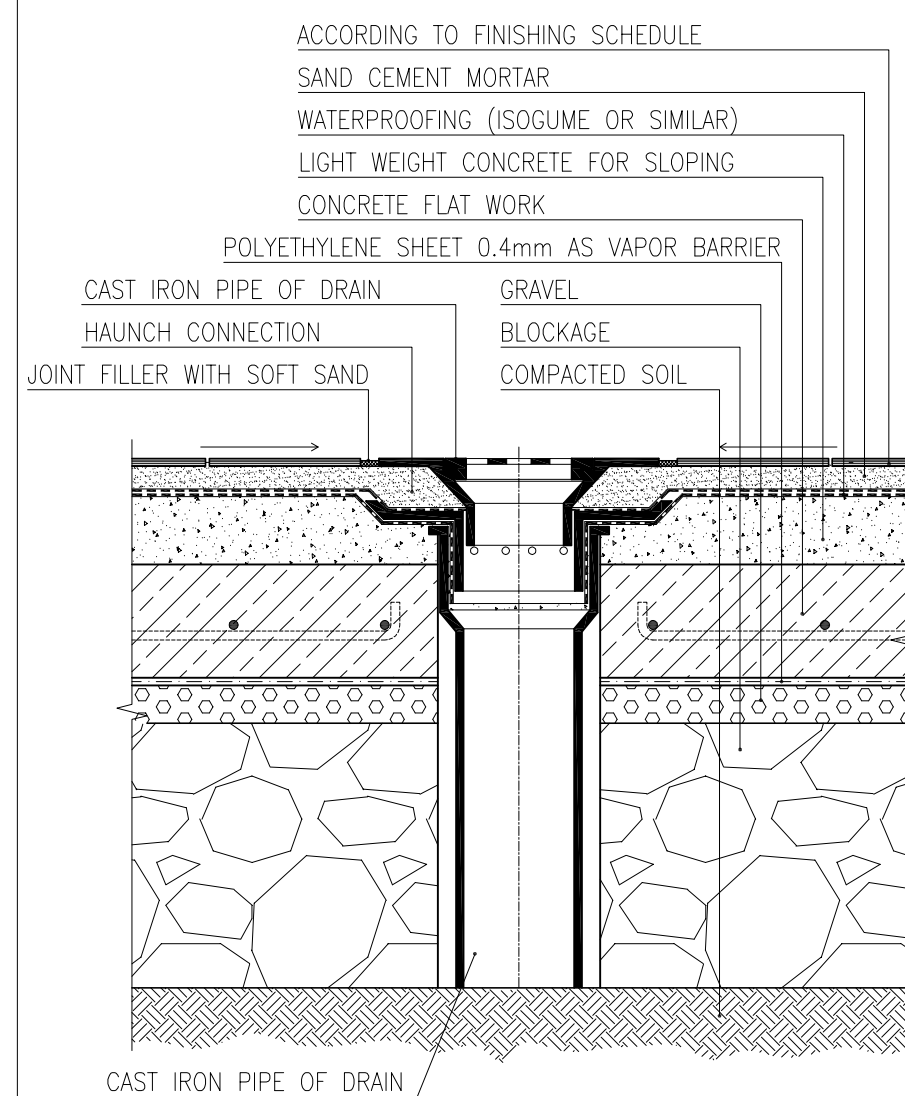


DETAIL 05
Sc:1/10

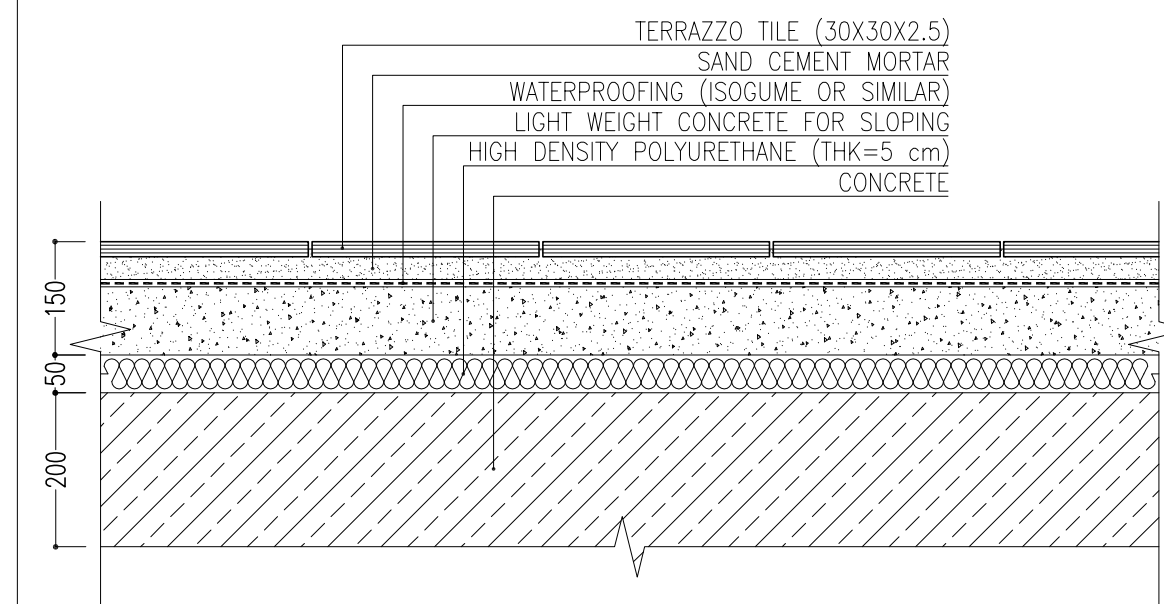


DETAIL 06
Sc:1/10

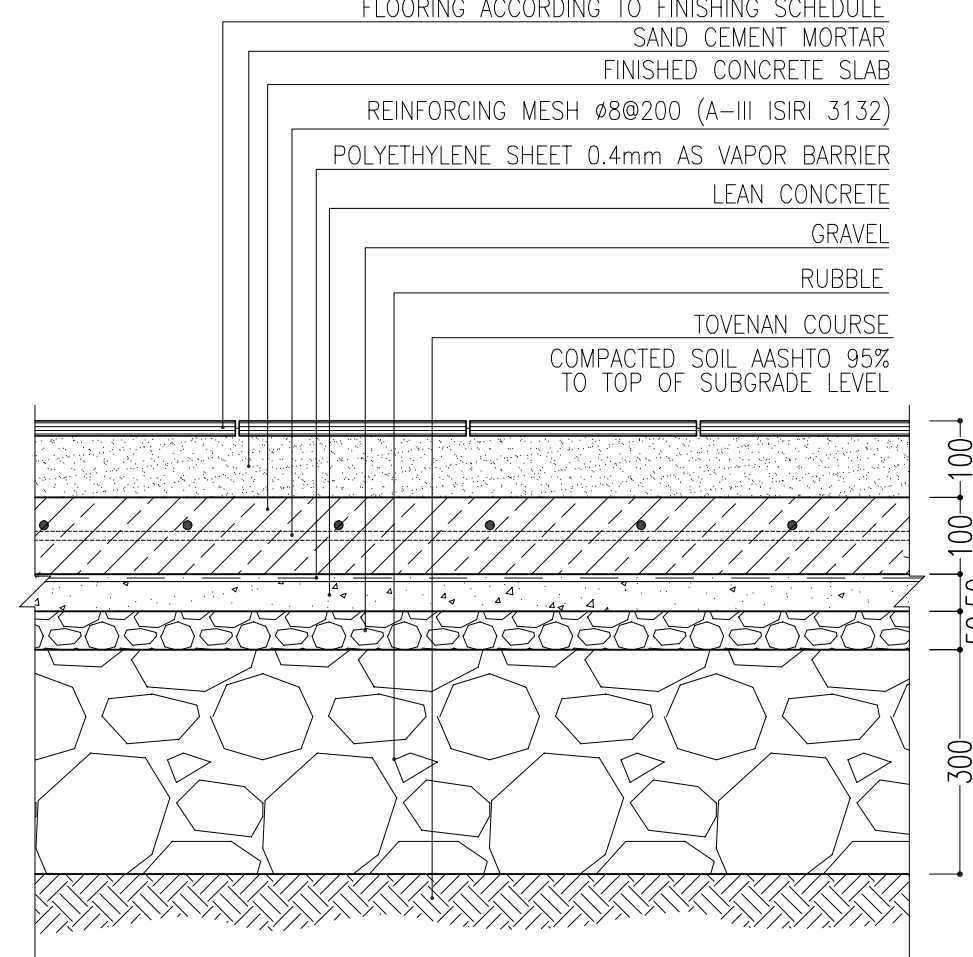


DETAIL 07
Sc:1/10

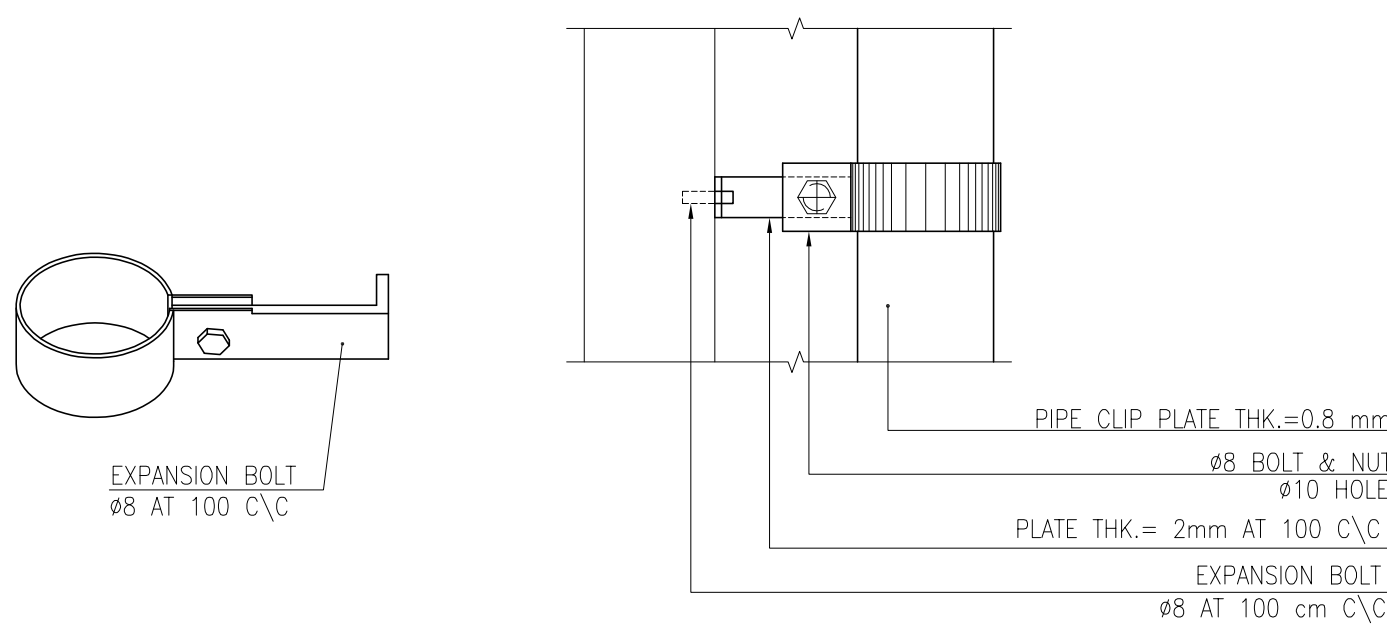


DETAIL 10
Sc:1/5

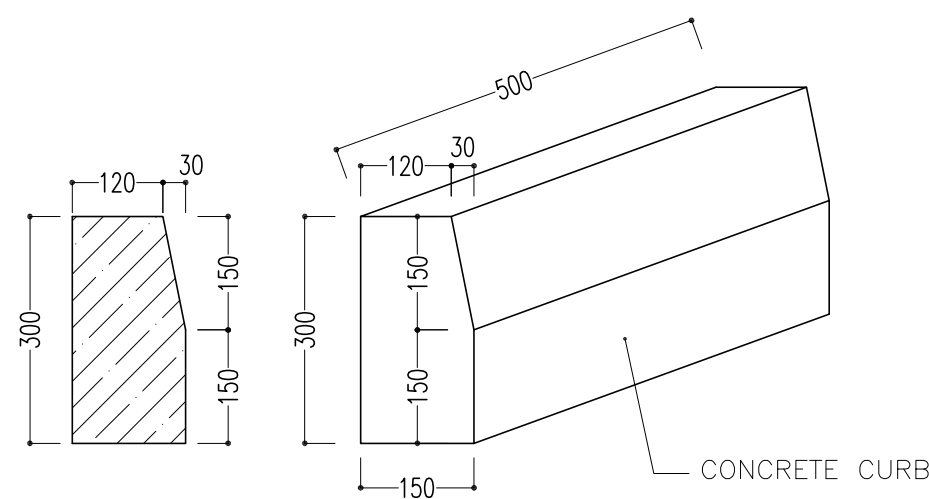

DETAIL 11
Sc:1/10

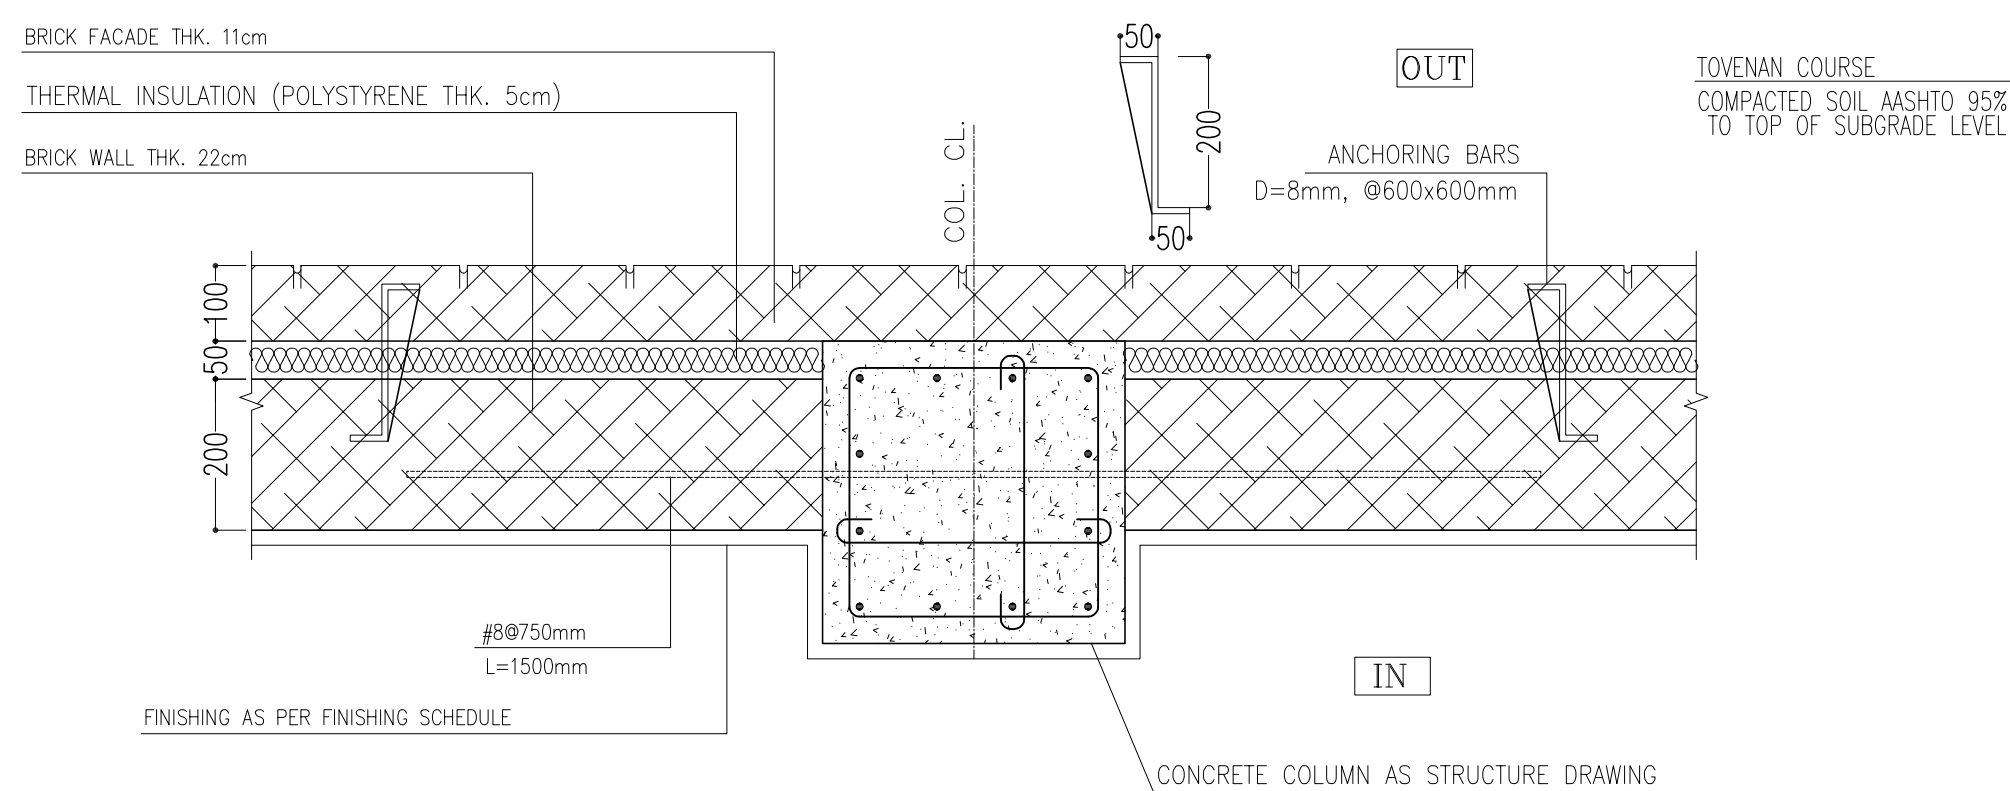

DETAIL 12
Sc:1/10

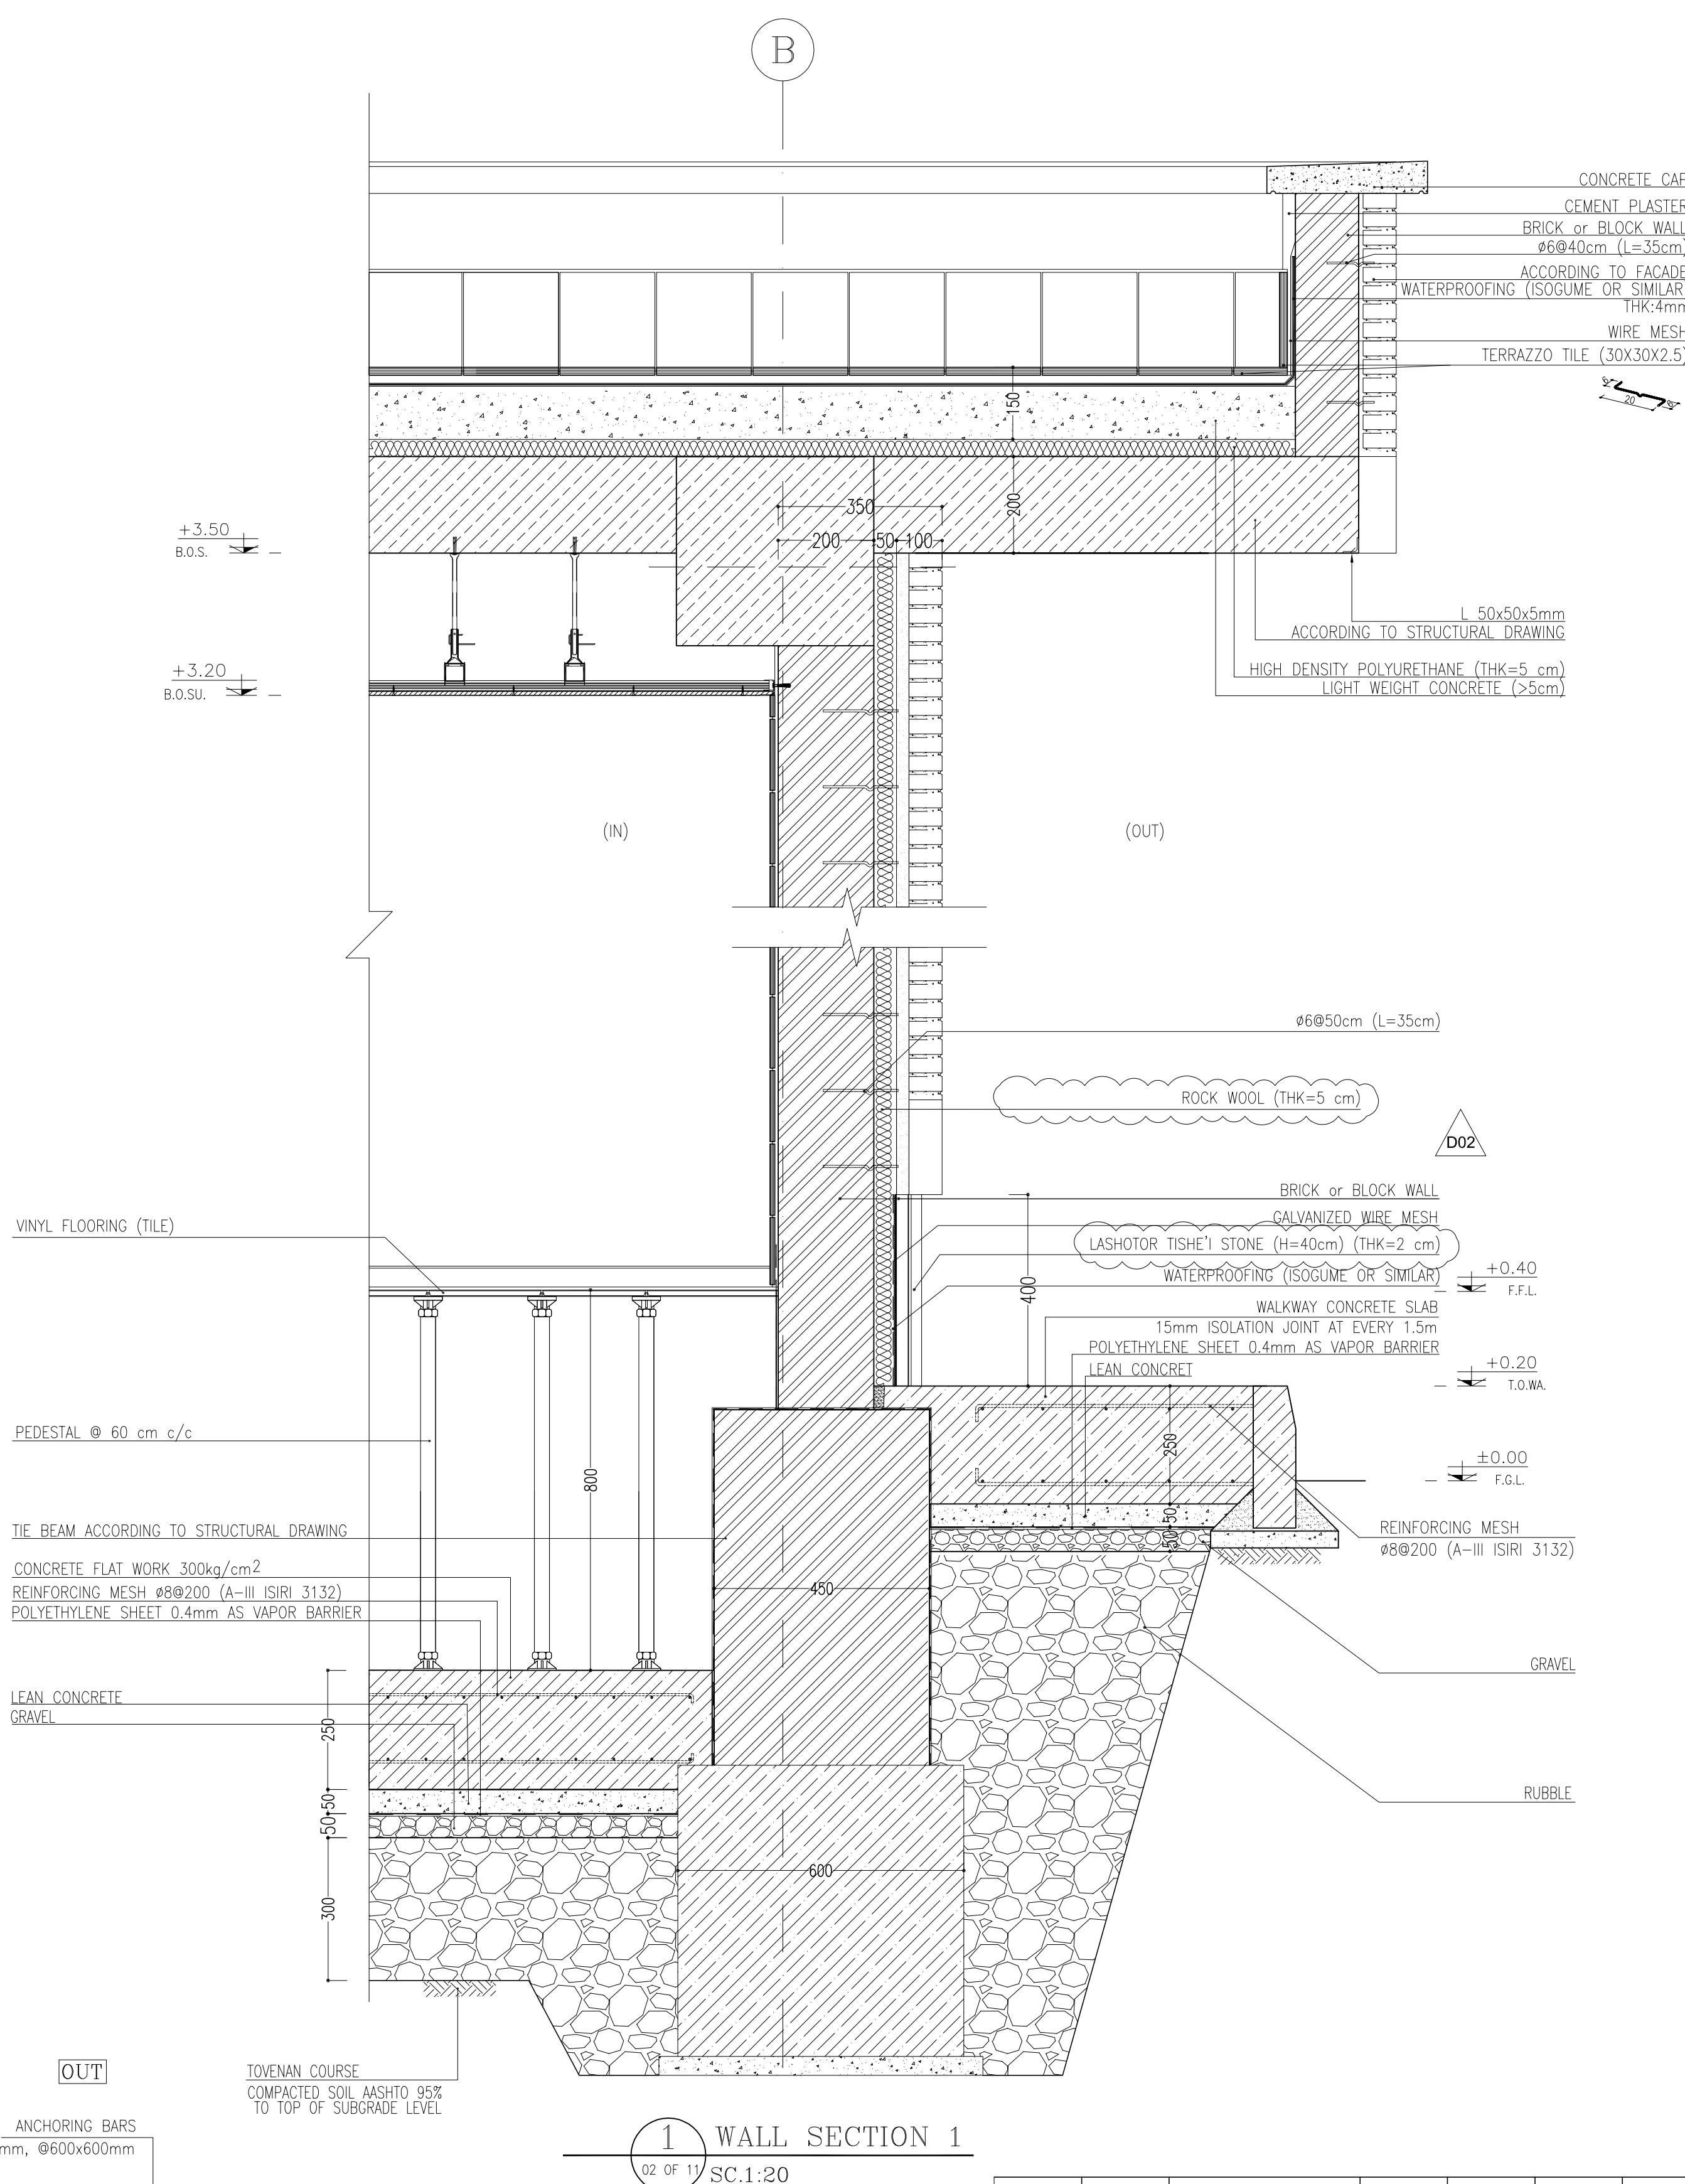

1 WALL SECTION 1
02 OF 11 SC.1:20

[illegible]

NOTES	
1.	ALL DIMENSIONS ARE IN CENTIMETER & ALL ELEVATIONS ARE IN METER.
2.	ALL DIMENSIONS AND ELEVATIONS SHALL BE CHECKED BY THE CONTRACTOR PRIOR TO CONSTRUCTION. CONTRACTOR SHALL COMPARE ALL ARCHITECTURAL, MECHANICAL, ELECTRICAL, PIPING AND STRUCTURAL DRAWINGS AND IN CASE OF ANY CONFLICTS OR DISCREPANCIES, THE CONTRACTOR SHALL CONSULT THE ENGINEER.
3.	ALL MATERIALS ARE SELECTED FROM THE HIGHEST QUALITY AND MUST BE APPROVED BY THE CLIENT.
4.	ALL OPENINGS FOR PIPING/CABLEING AND HVAC OPENINGS SHALL BE CONSIDERED AS PER RELATED DRAWINGS BEFORE THE CONSTRUCTION.
5.	FINISH GRADING LEVEL: EQUIVALENT=+0.00 (LOCAL)+243.00 GLOBAL (M.S.L.).
6.	POINT 01: E116485/8860, N 1411515+00 (UTM-ZONE 35). THIS COORDINATION IS PRELIMINARY AND WILL BE FINALIZED IN THE FUTURE.

LEGEND	
F.F.L.	FINISHED FLOOR LEVEL
T.O.W.A.	TOP OF WALKWAY
T.O.P.	TOP OF PARAPET
T.O.S.	TOP OF SLAB
T.O.D.	TOP OF DOOR
T.O.W.	TOP OF WINDOW
B.O.W.	BOTTOM OF WINDOW
T.O.C.	TOP OF CAGE
B.O.C.	BOTTOM OF CAGE
B.O.F.	BOTTOM OF FALSE FLOOR
B.O.S.U.	BOTTOM OF SUSPENDED
B.O.S.	BOTTOM OF SLEEVE
F.G.L.	HIGH POINT GRAVEL

	BRICK WORK		BRICK FACING
	REINFORCED CONCRETE		
	LEAN CONCRETE		
	BLOCKAGE		
	GRAVEL		
	GYPSUM BOARD		
	PAINTED ALUMINUM STRIP (DUMPA)		
	FALSE FLOOR		

REFERENCE DRAWING	DRG. No.
STANDARD DRAWING FOR ARCHITECTURAL DETAILS	BK-GNRL-PEDCO-000-AR-DW-0001
SITE SEWAGE SYSTEM LAYOUT & DETAILS	BK-GCS-PEDCO-120-CV-PY-0001
CABLE TRENCH AND DUCT BANK LAYOUT	BK-GCS-PEDCO-120-CV-PY-0002
ROAD, PAVING AND PLANT FINISH GRADING LAYOUT & SECTIONS	BK-GCS-PEDCO-120-CV-PY-0003
ELECTRICAL CABLE ROUTE & SECTION LAYOUT FOR BUILDING & SHEETER	BK-GCS-PEDCO-120-EL-PY-0005
FOUNDATION DRAWING FOR CCTV CONTROL ROOM - HINAK DU	BK-GCS-PEDCO-120-ST-DW-0077
STRUCTURAL DRAWING FOR CCTV CONTROL ROOM - HINAK DU	BK-GCS-PEDCO-120-ST-DW-0078
STANDARD DETAILS FOR LADDER & SAFETY CAGE	BK-GNRL-PEDCO-000-ST-DW-0009

KEY PLAN

[illegible]

--	--	--	--	--	--

REV	DESCRIPTION	BY	DATE	BY	DATE
-----	-------------	----	------	----	------

اصل و کليه نسخ این نقشه و حق اقتباس متعلق به شرکت ملی مناطق نفت خیز جنوب میباشد.

THE ORIGINAL AND ALL COPIES OF THIS DRAWING TOGETHER WITH
THE COPYRIGHT THEREIN ARE THE SOLE PROPERTY OF

	RINAK OILFIELD DEVELOPMENT
--	----------------------------


GAS COMPRESSOR STATION

DATE	SCALE	DRAWING BY	CHECKED BY	PROJECT ENG.

NO CONSTRUCTION PERMITTED UNLESS DRAWING APPROVED


APPROVED FOR CONSTRUCTION					BY:	DATE:	
BUDGET REF	LOCATION	SIZE	CLASS	SERIAL NO.	SHEET	REVISION	

053-073-9184	F	4	B	709397	06 OF 11	D02
--------------	---	---	---	--------	----------	-----


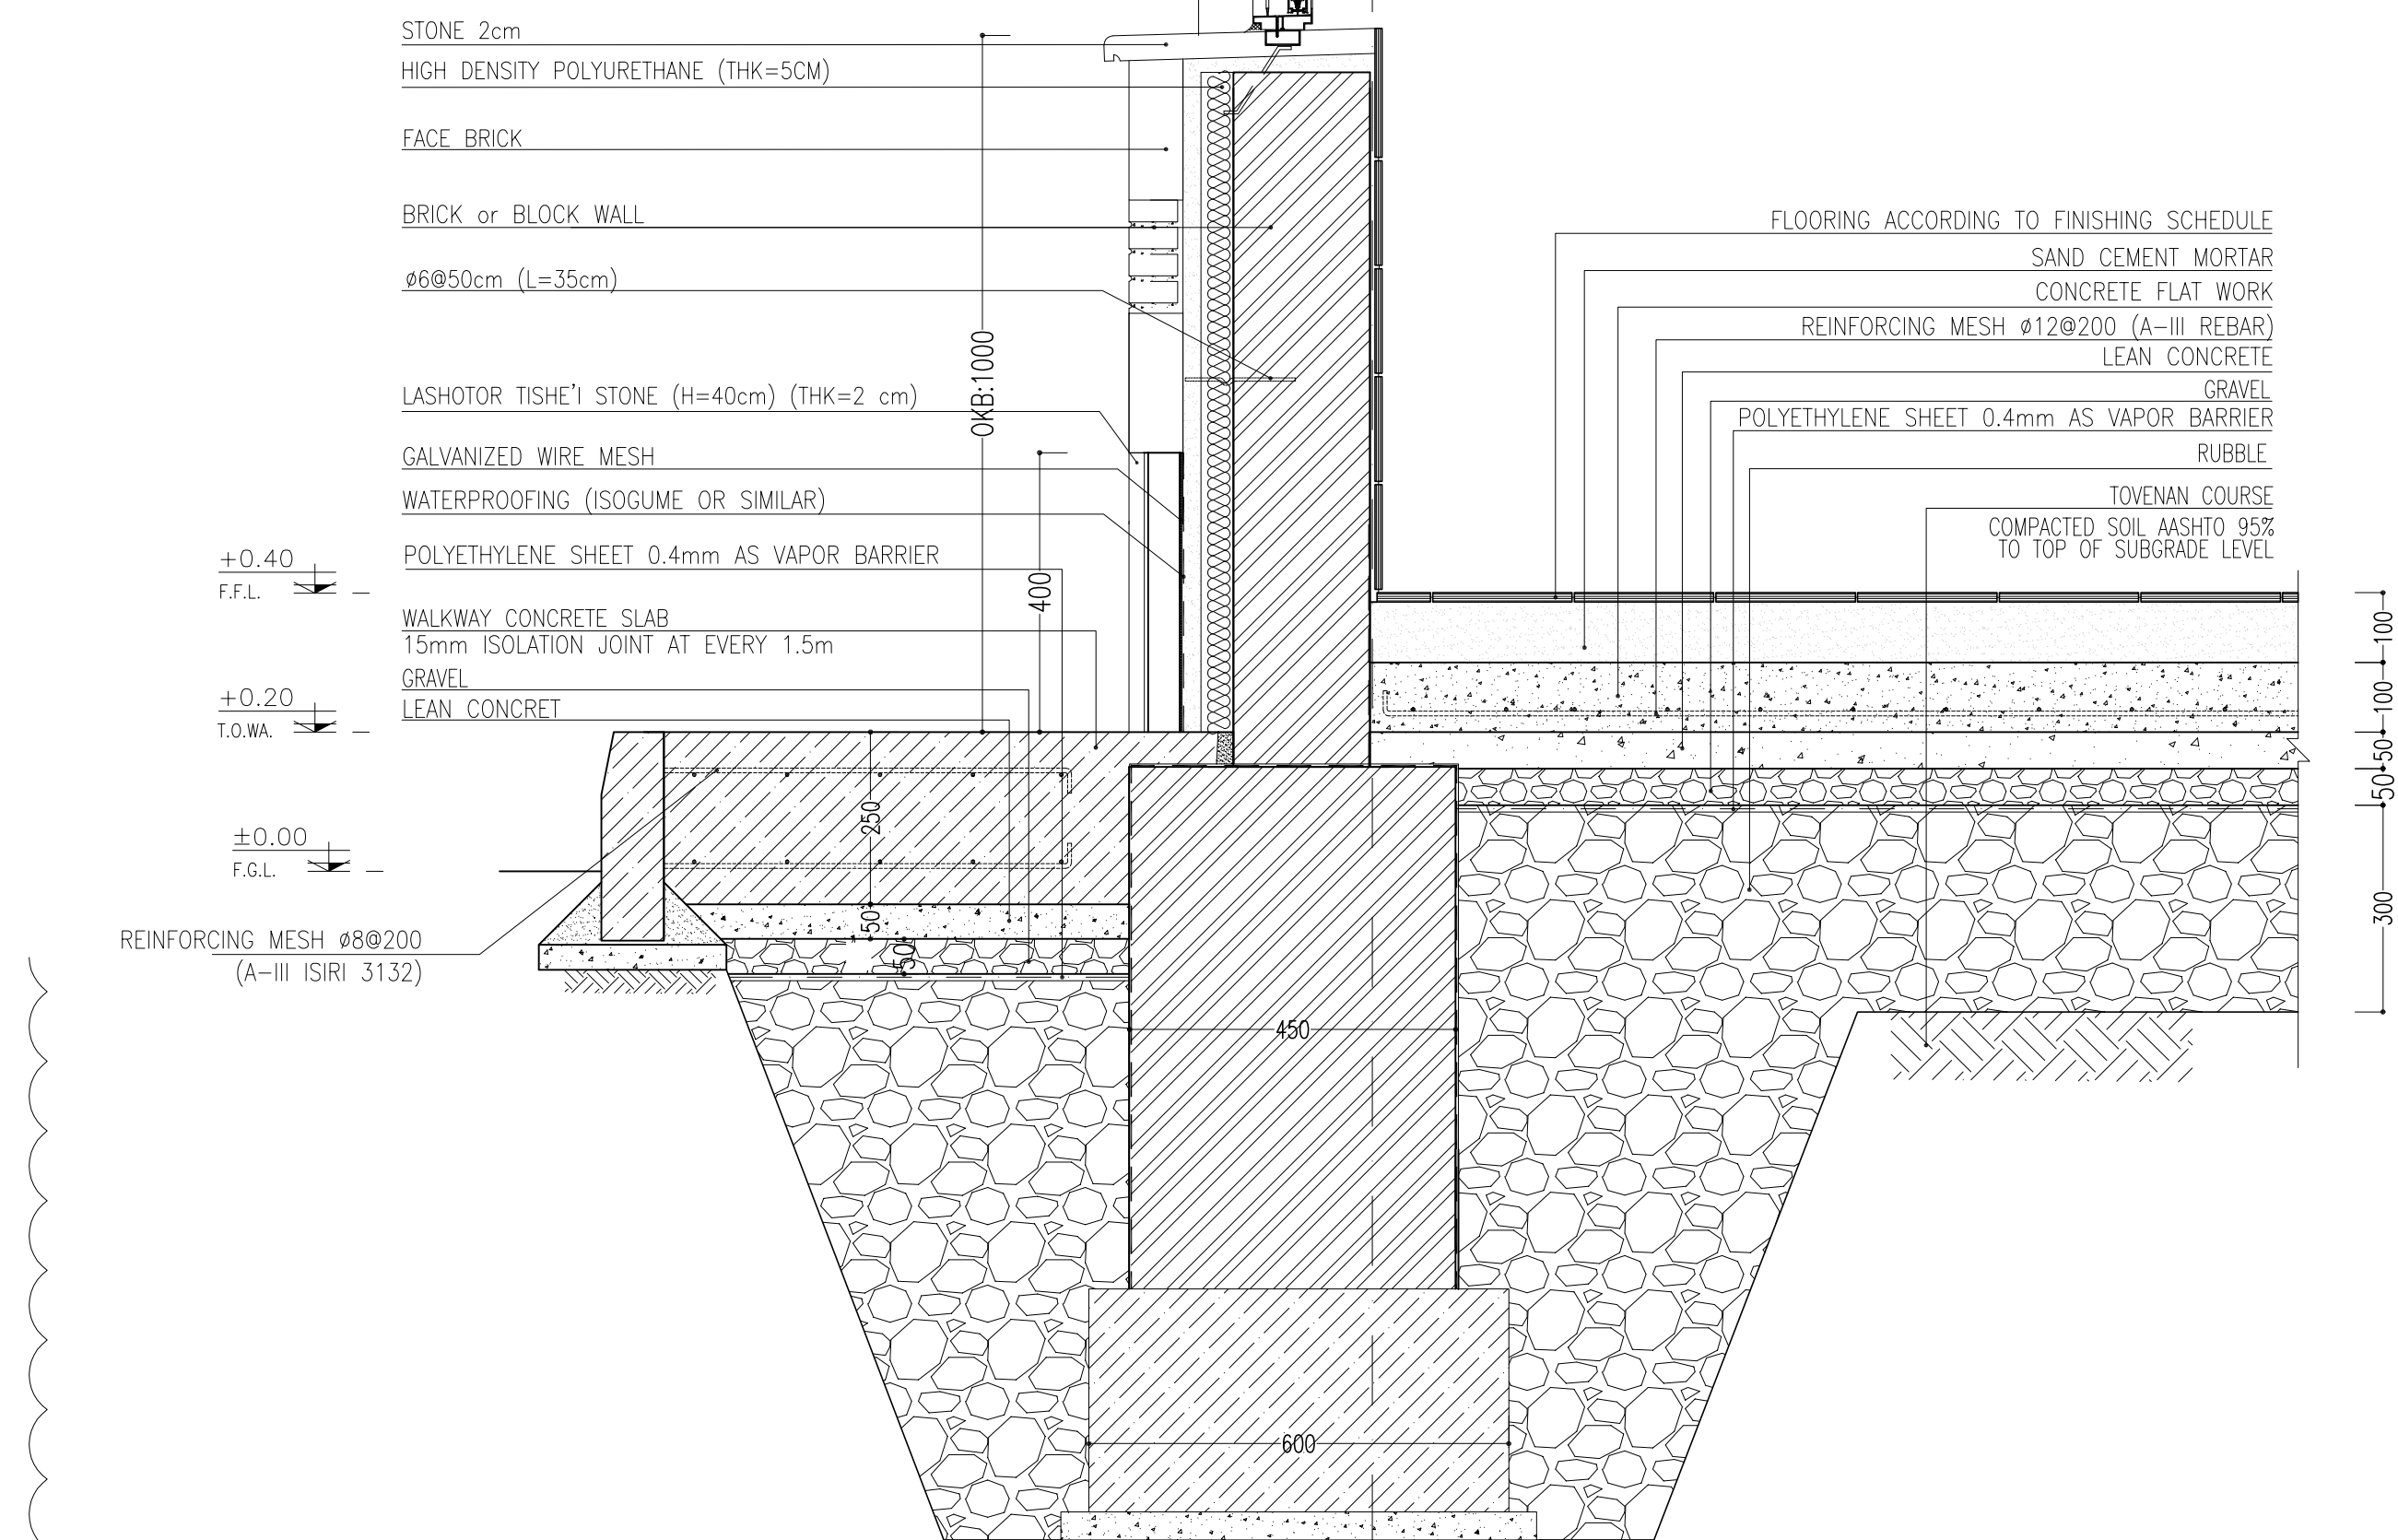


2
02 OF 11


[illegible]

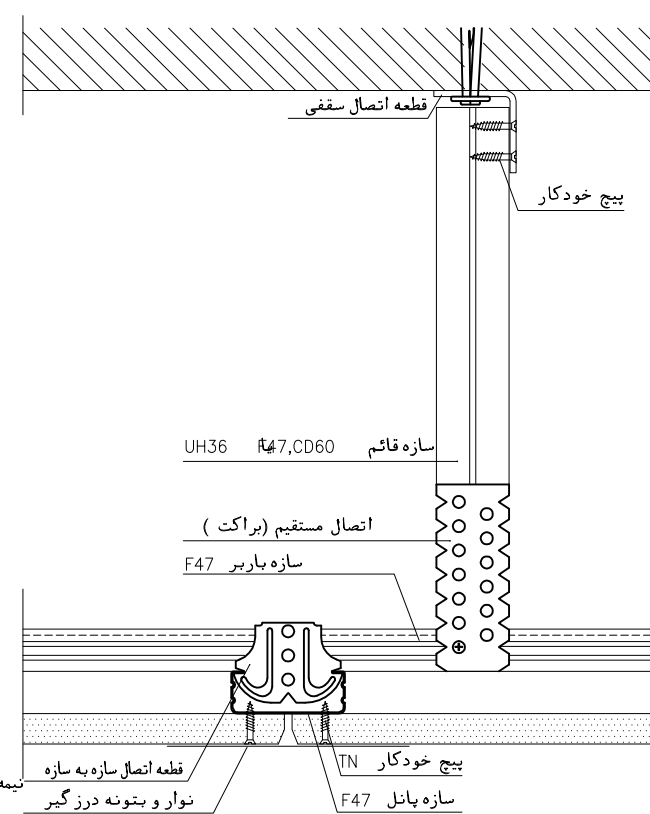


فواصل در زیرسازی نظری		
حد اکثر درجهان $\left(\frac{1}{2} \text{ مایل مینتر}\right)$		
بار سطحی $P \left(\frac{\text{KN}}{\text{M}^2}\right)$		
$0.30 < p \leq 0.50$	$0.15 < p \leq 0.30$	$p \leq 0.15$
600	750	900
فاصله اویزها -a-		
750	1000	فاصله مرکز تا مرکز برودها های باربر -c-

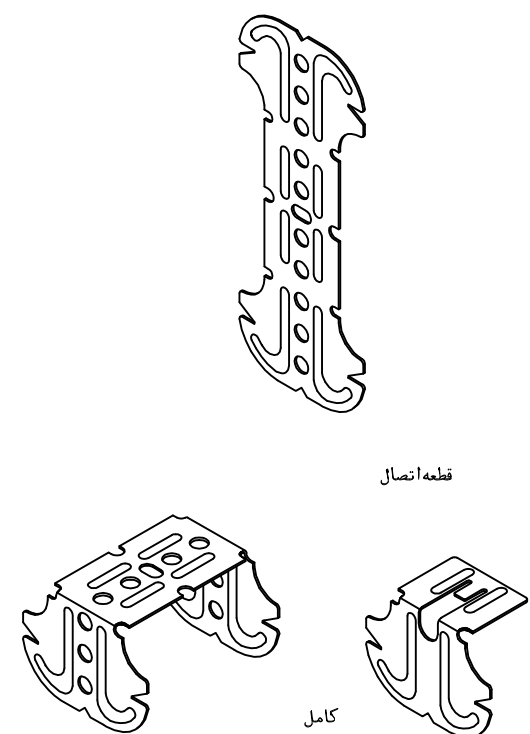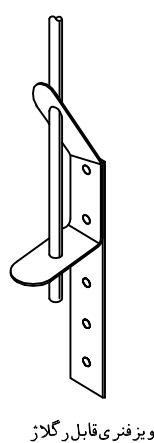

اوپن فٹری قابل درگلاز



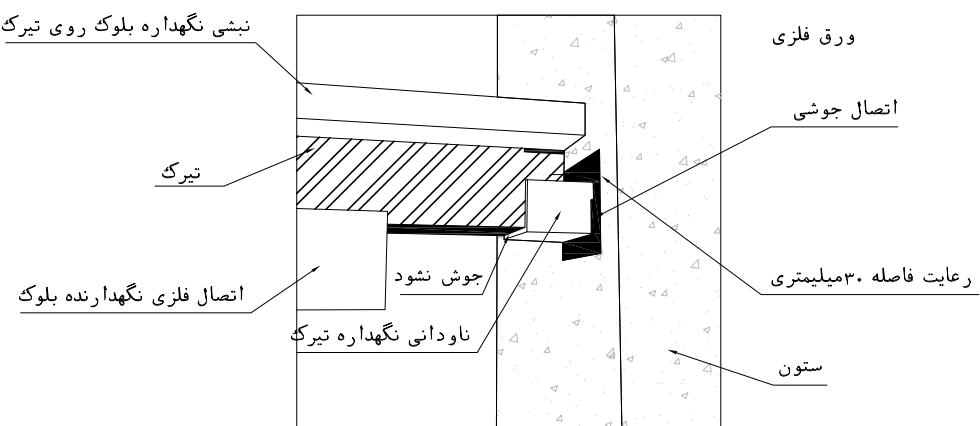


det.4

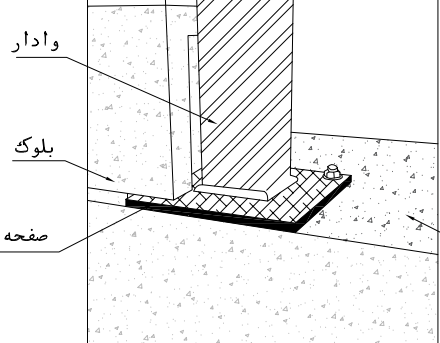

det.2

 
det.3

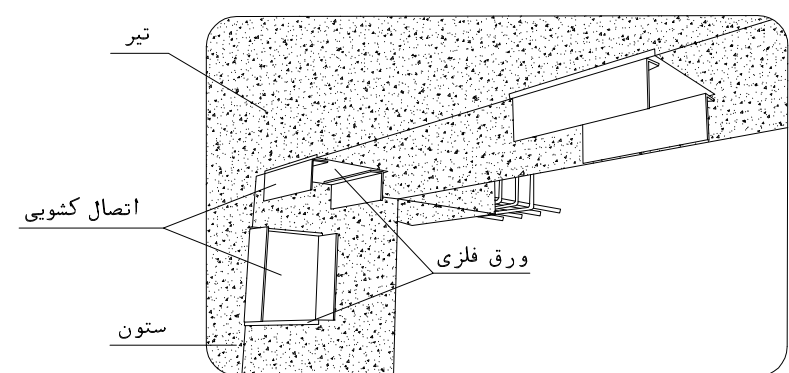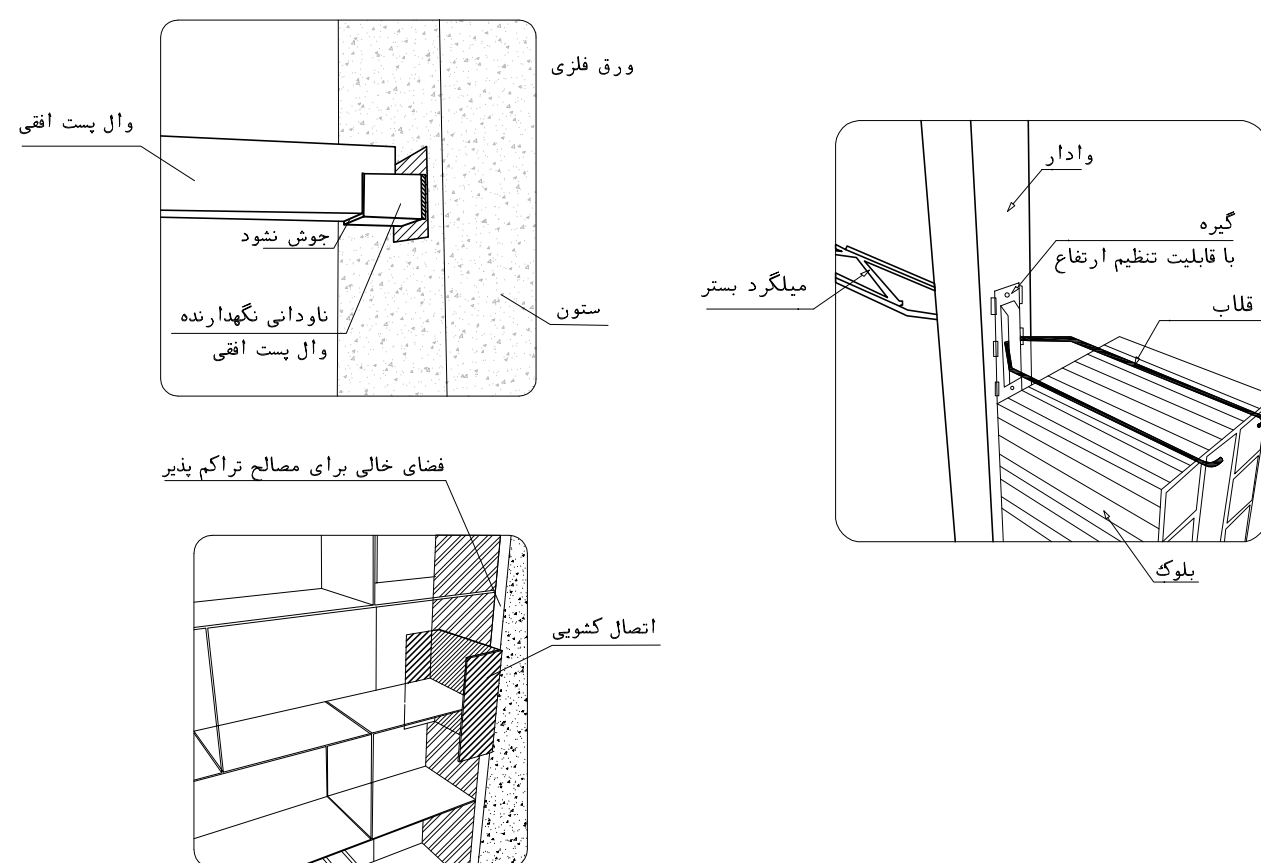


LEGEND

REFERENCE DRAWING	DRG. No.
STANDARD DRAWING FOR ARCHITECTURAL DETAILS	BK-GNRL-PEDCO-000-AR-DW-0001
SITE SEWAGE SYSTEM LAYOUT & DETAILS	BK-GCS-PEDCO-120-CV-PY-0001
CABLE TRENCH AND DUCT BANK LAYOUT	BK-GCS-PEDCO-120-CV-PY-0002
ROAD, PAVING AND PLANT FINISH GRADING LAYOUT & SECTIONS	BK-GCS-PEDCO-120-CV-PY-0005
ELECTRICAL CABLE ROUTE & SECTION LAYOUT FOR BUILDING & SHEETER	BK-GCS-PEDCO-120-EL-PY-0006
FOUNDATION DRAWING FOR CCTV CONTROL ROOM - BINAQ DU	BK-GCS-PEDCO-120-ST-DW-0077
STRUCTURAL DRAWING FOR CCTV CONTROL ROOM - BINAQ DU	BK-GCS-PEDCO-120-ST-DW-0078
STANDARD DETAILS FOR LADDER & SAFETY CAGE	BK-GNRL-PEDCO-000-ST-DW-0009


KEY PLAN

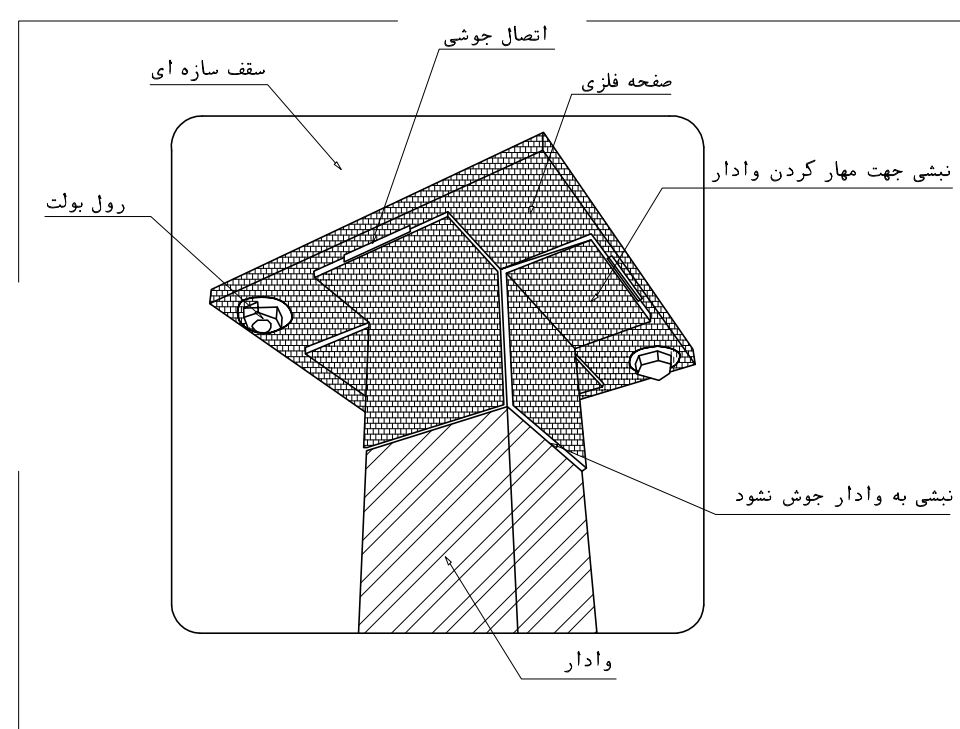

اتصال وادار انتهایی در دیوارهای خارج از قاب به صورت تلسکوپی




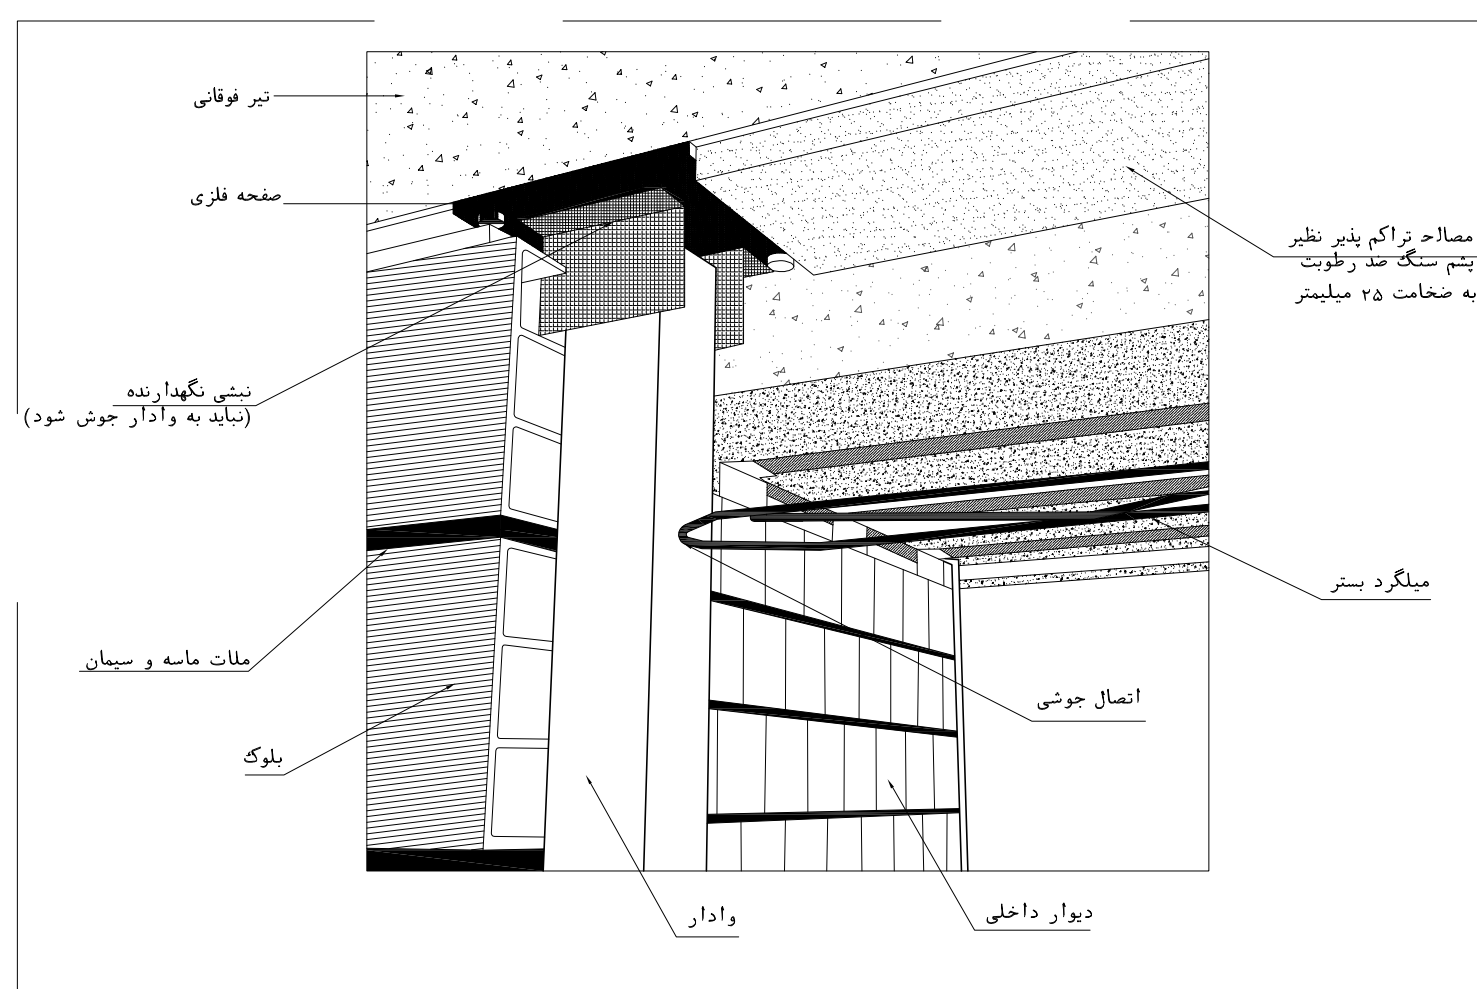






الف-به صورت اتصال کشویی با استفاده از نبشی

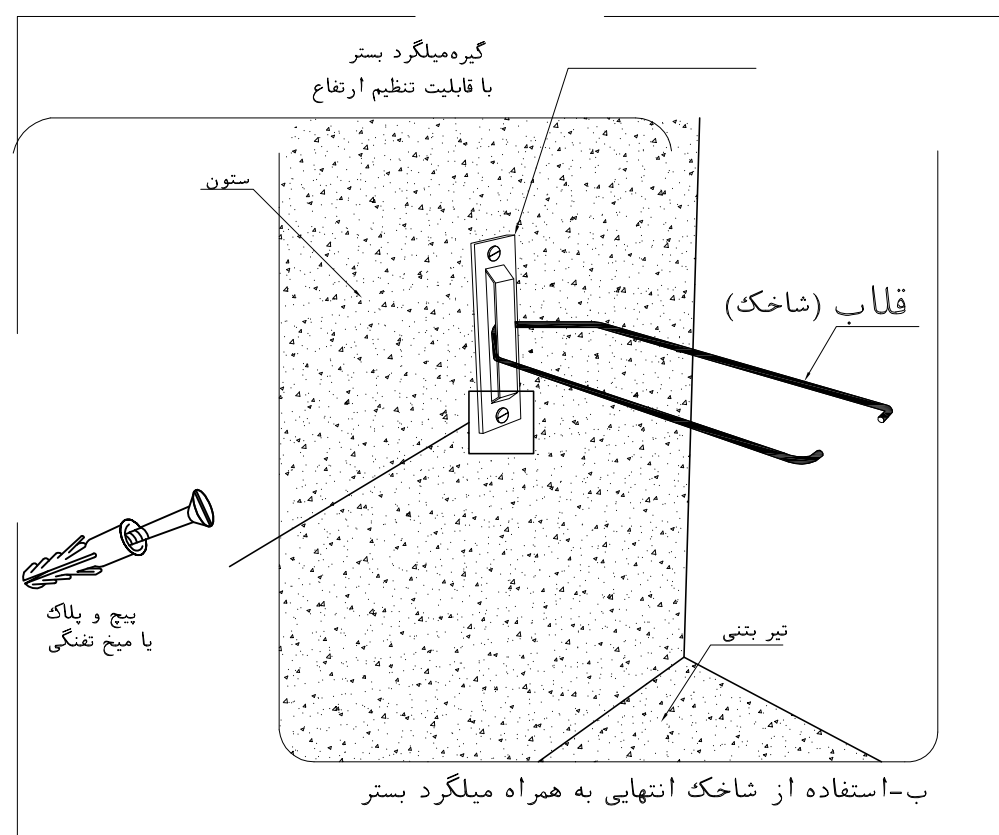




روش های مهار دیوار به ستون جهت نیروی خارج از صفحه

[illegible]

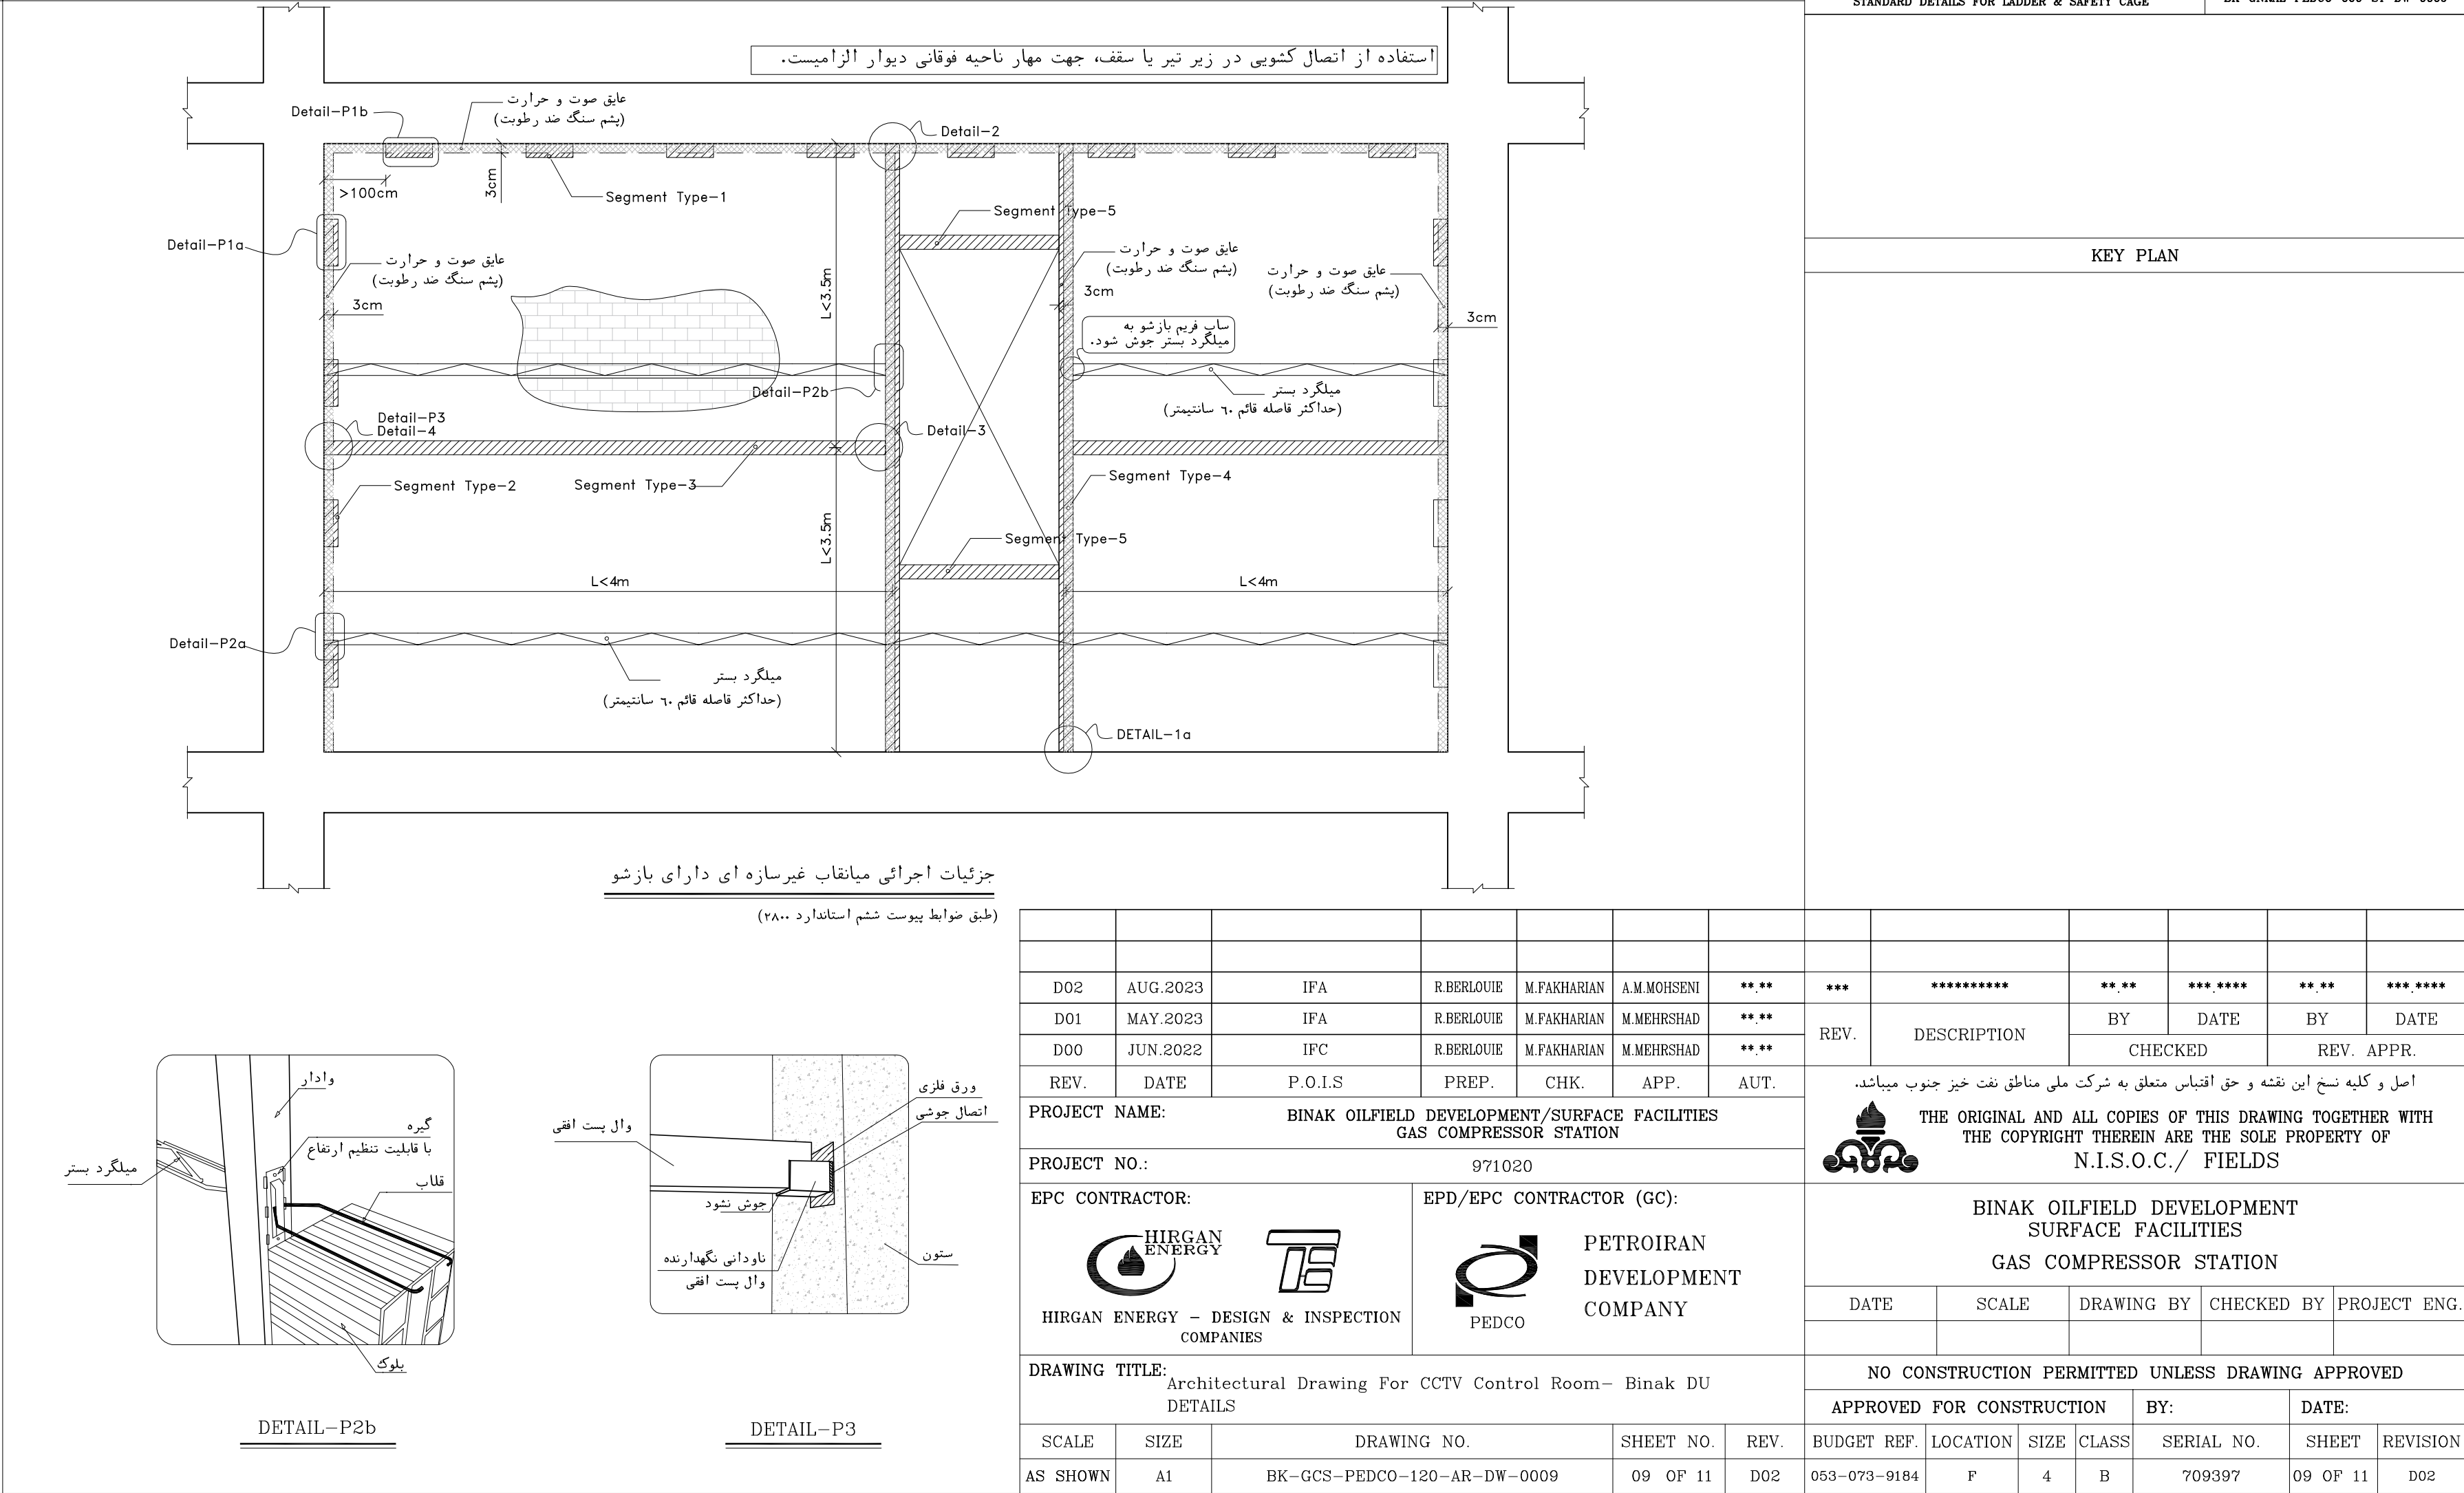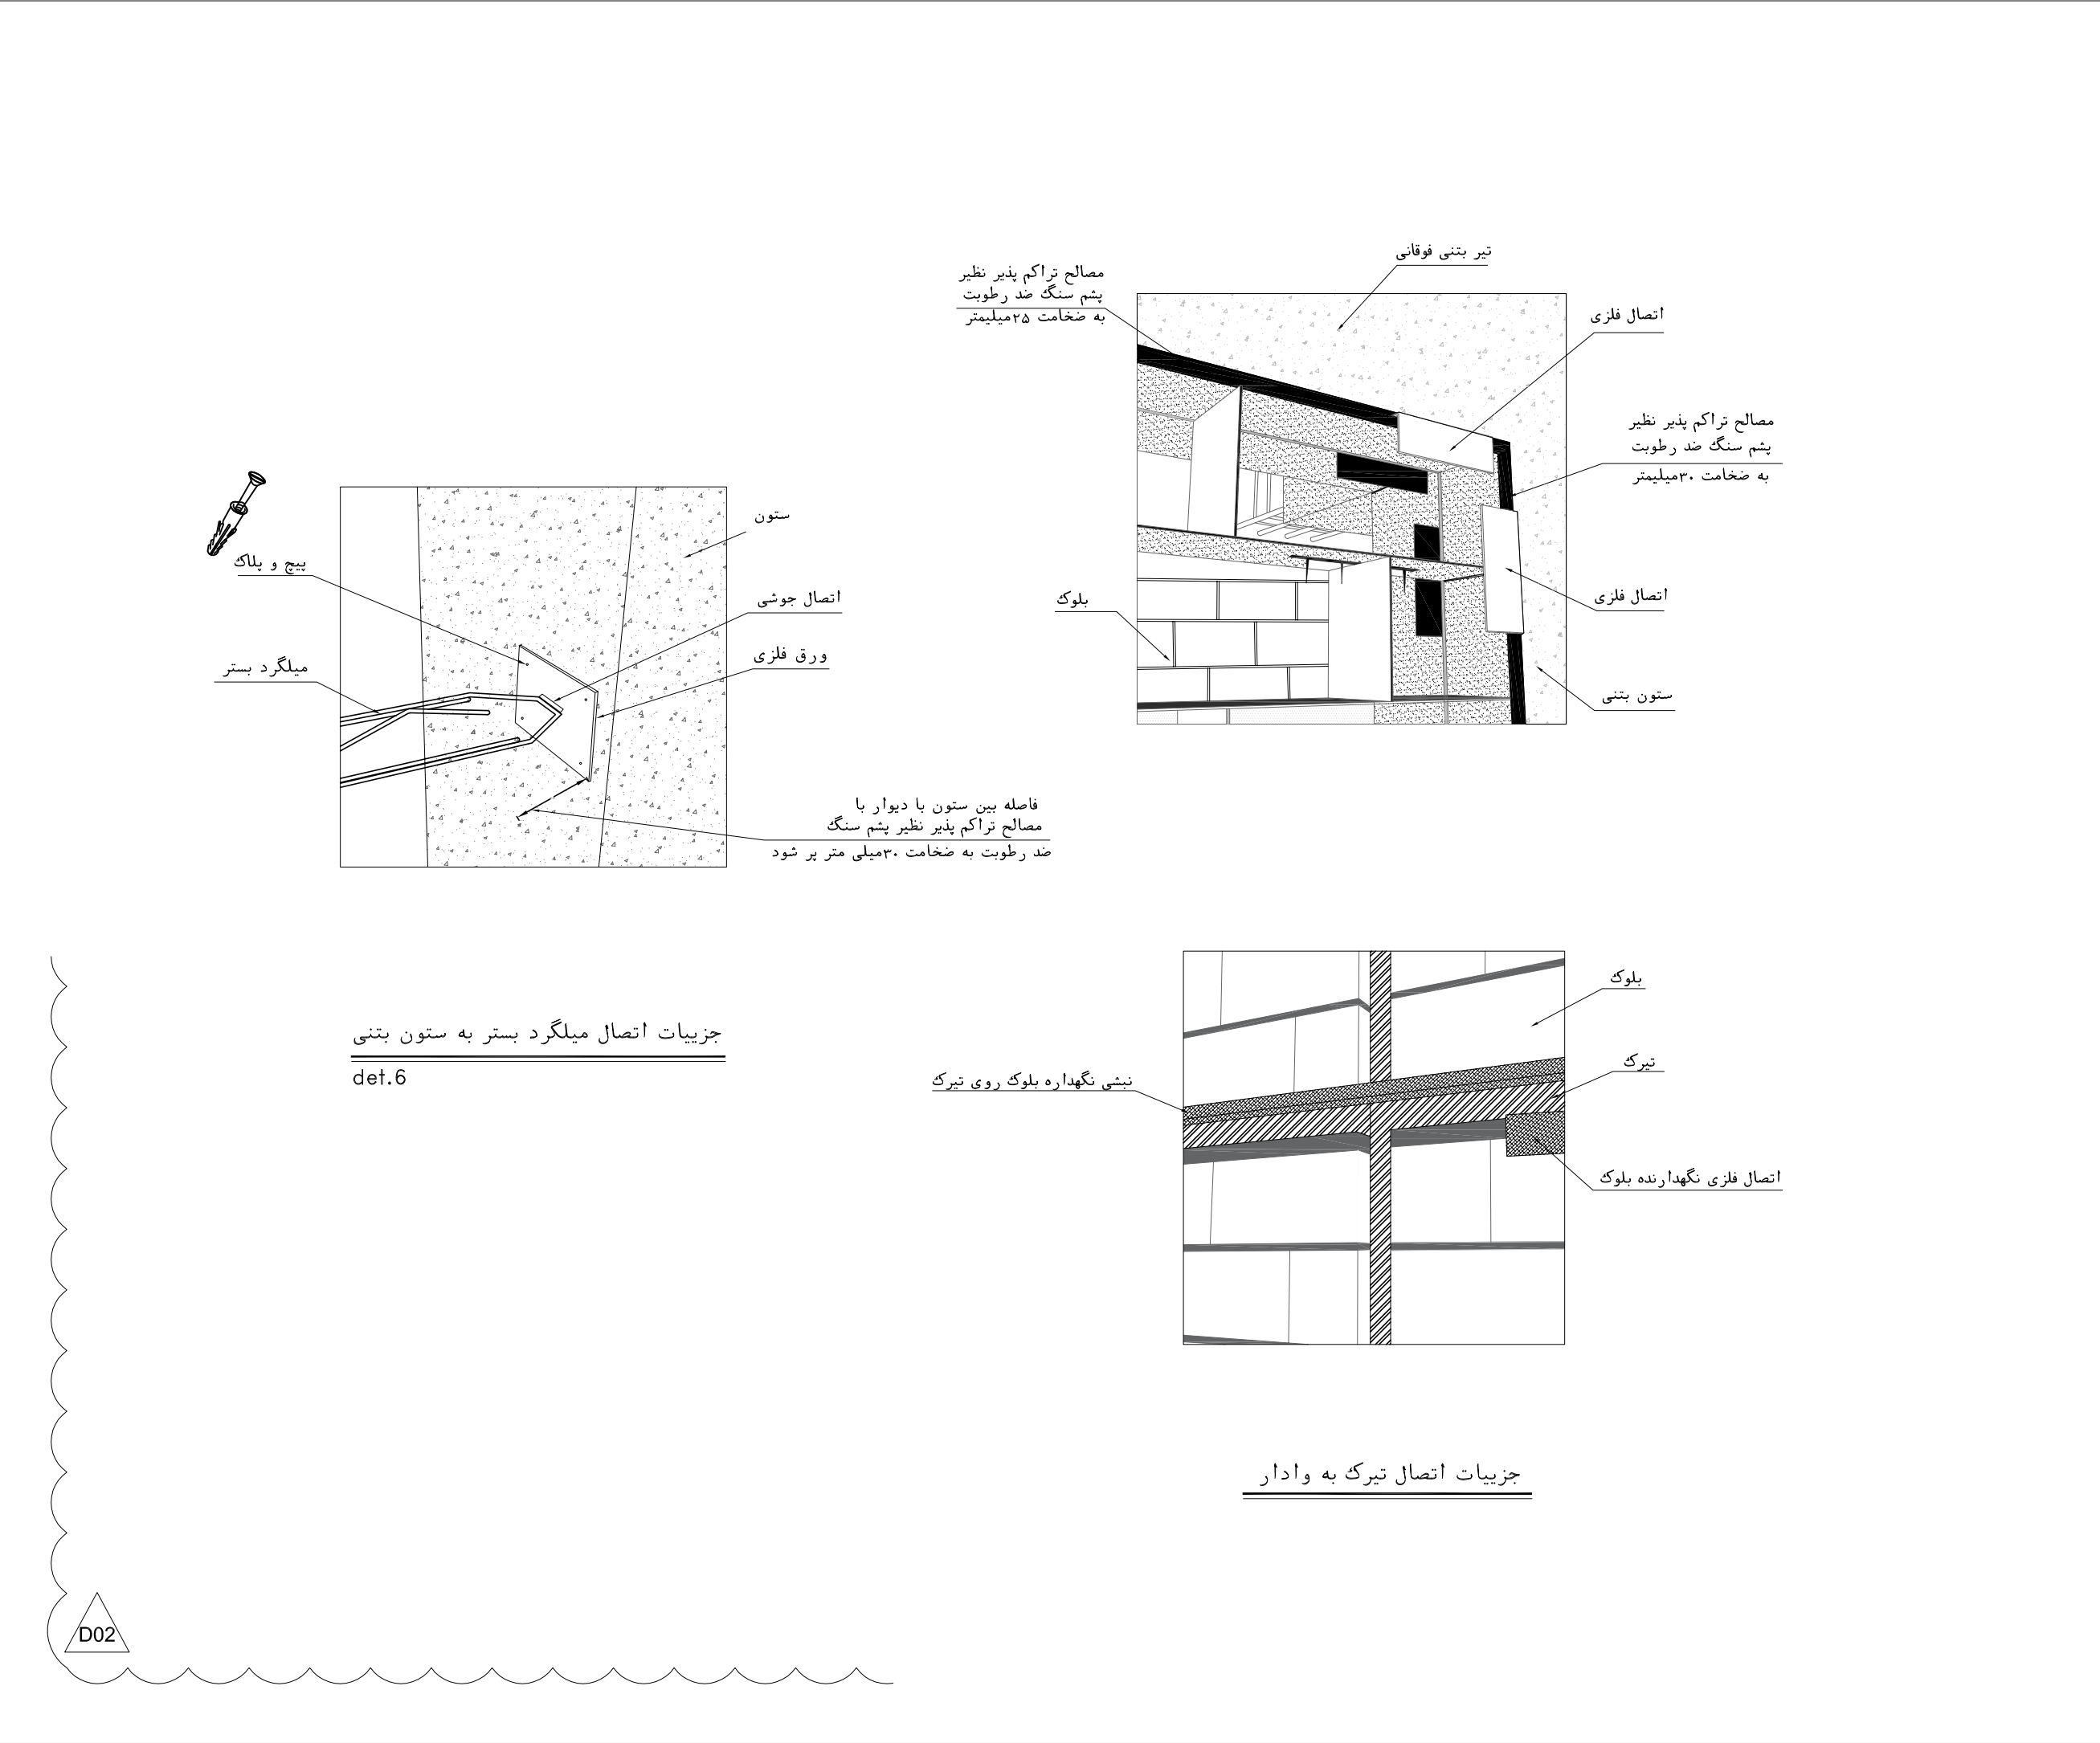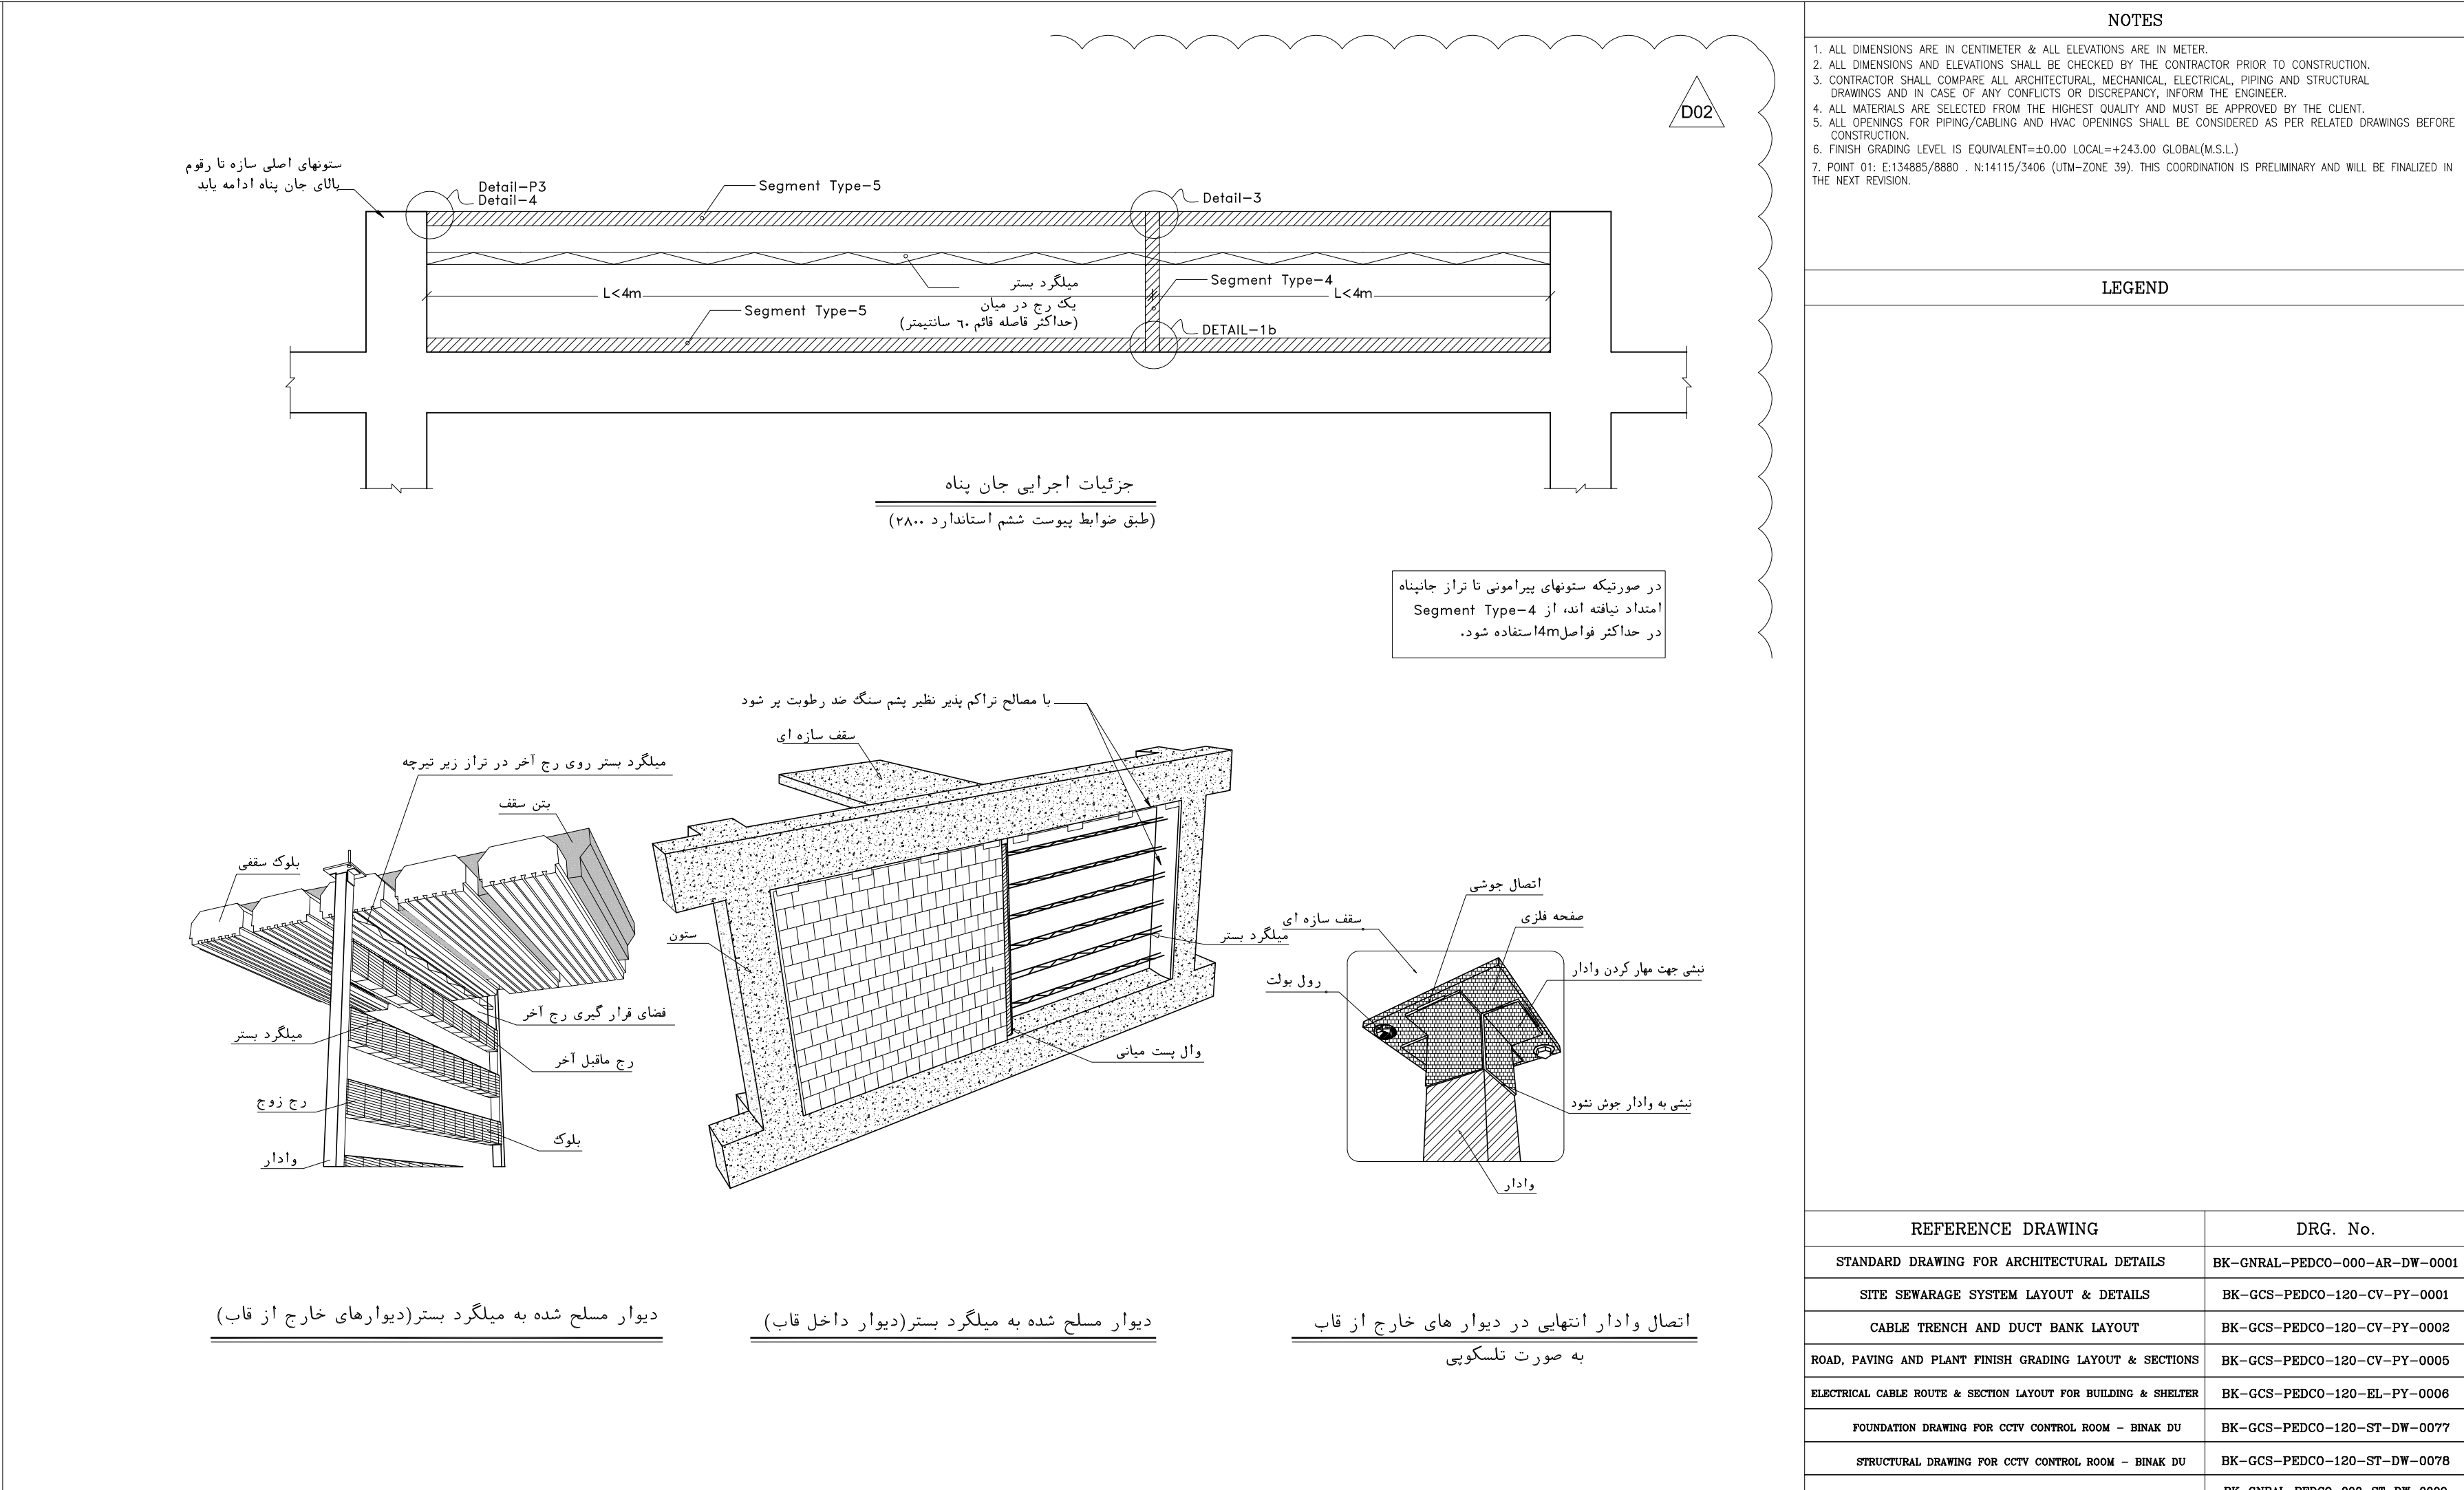
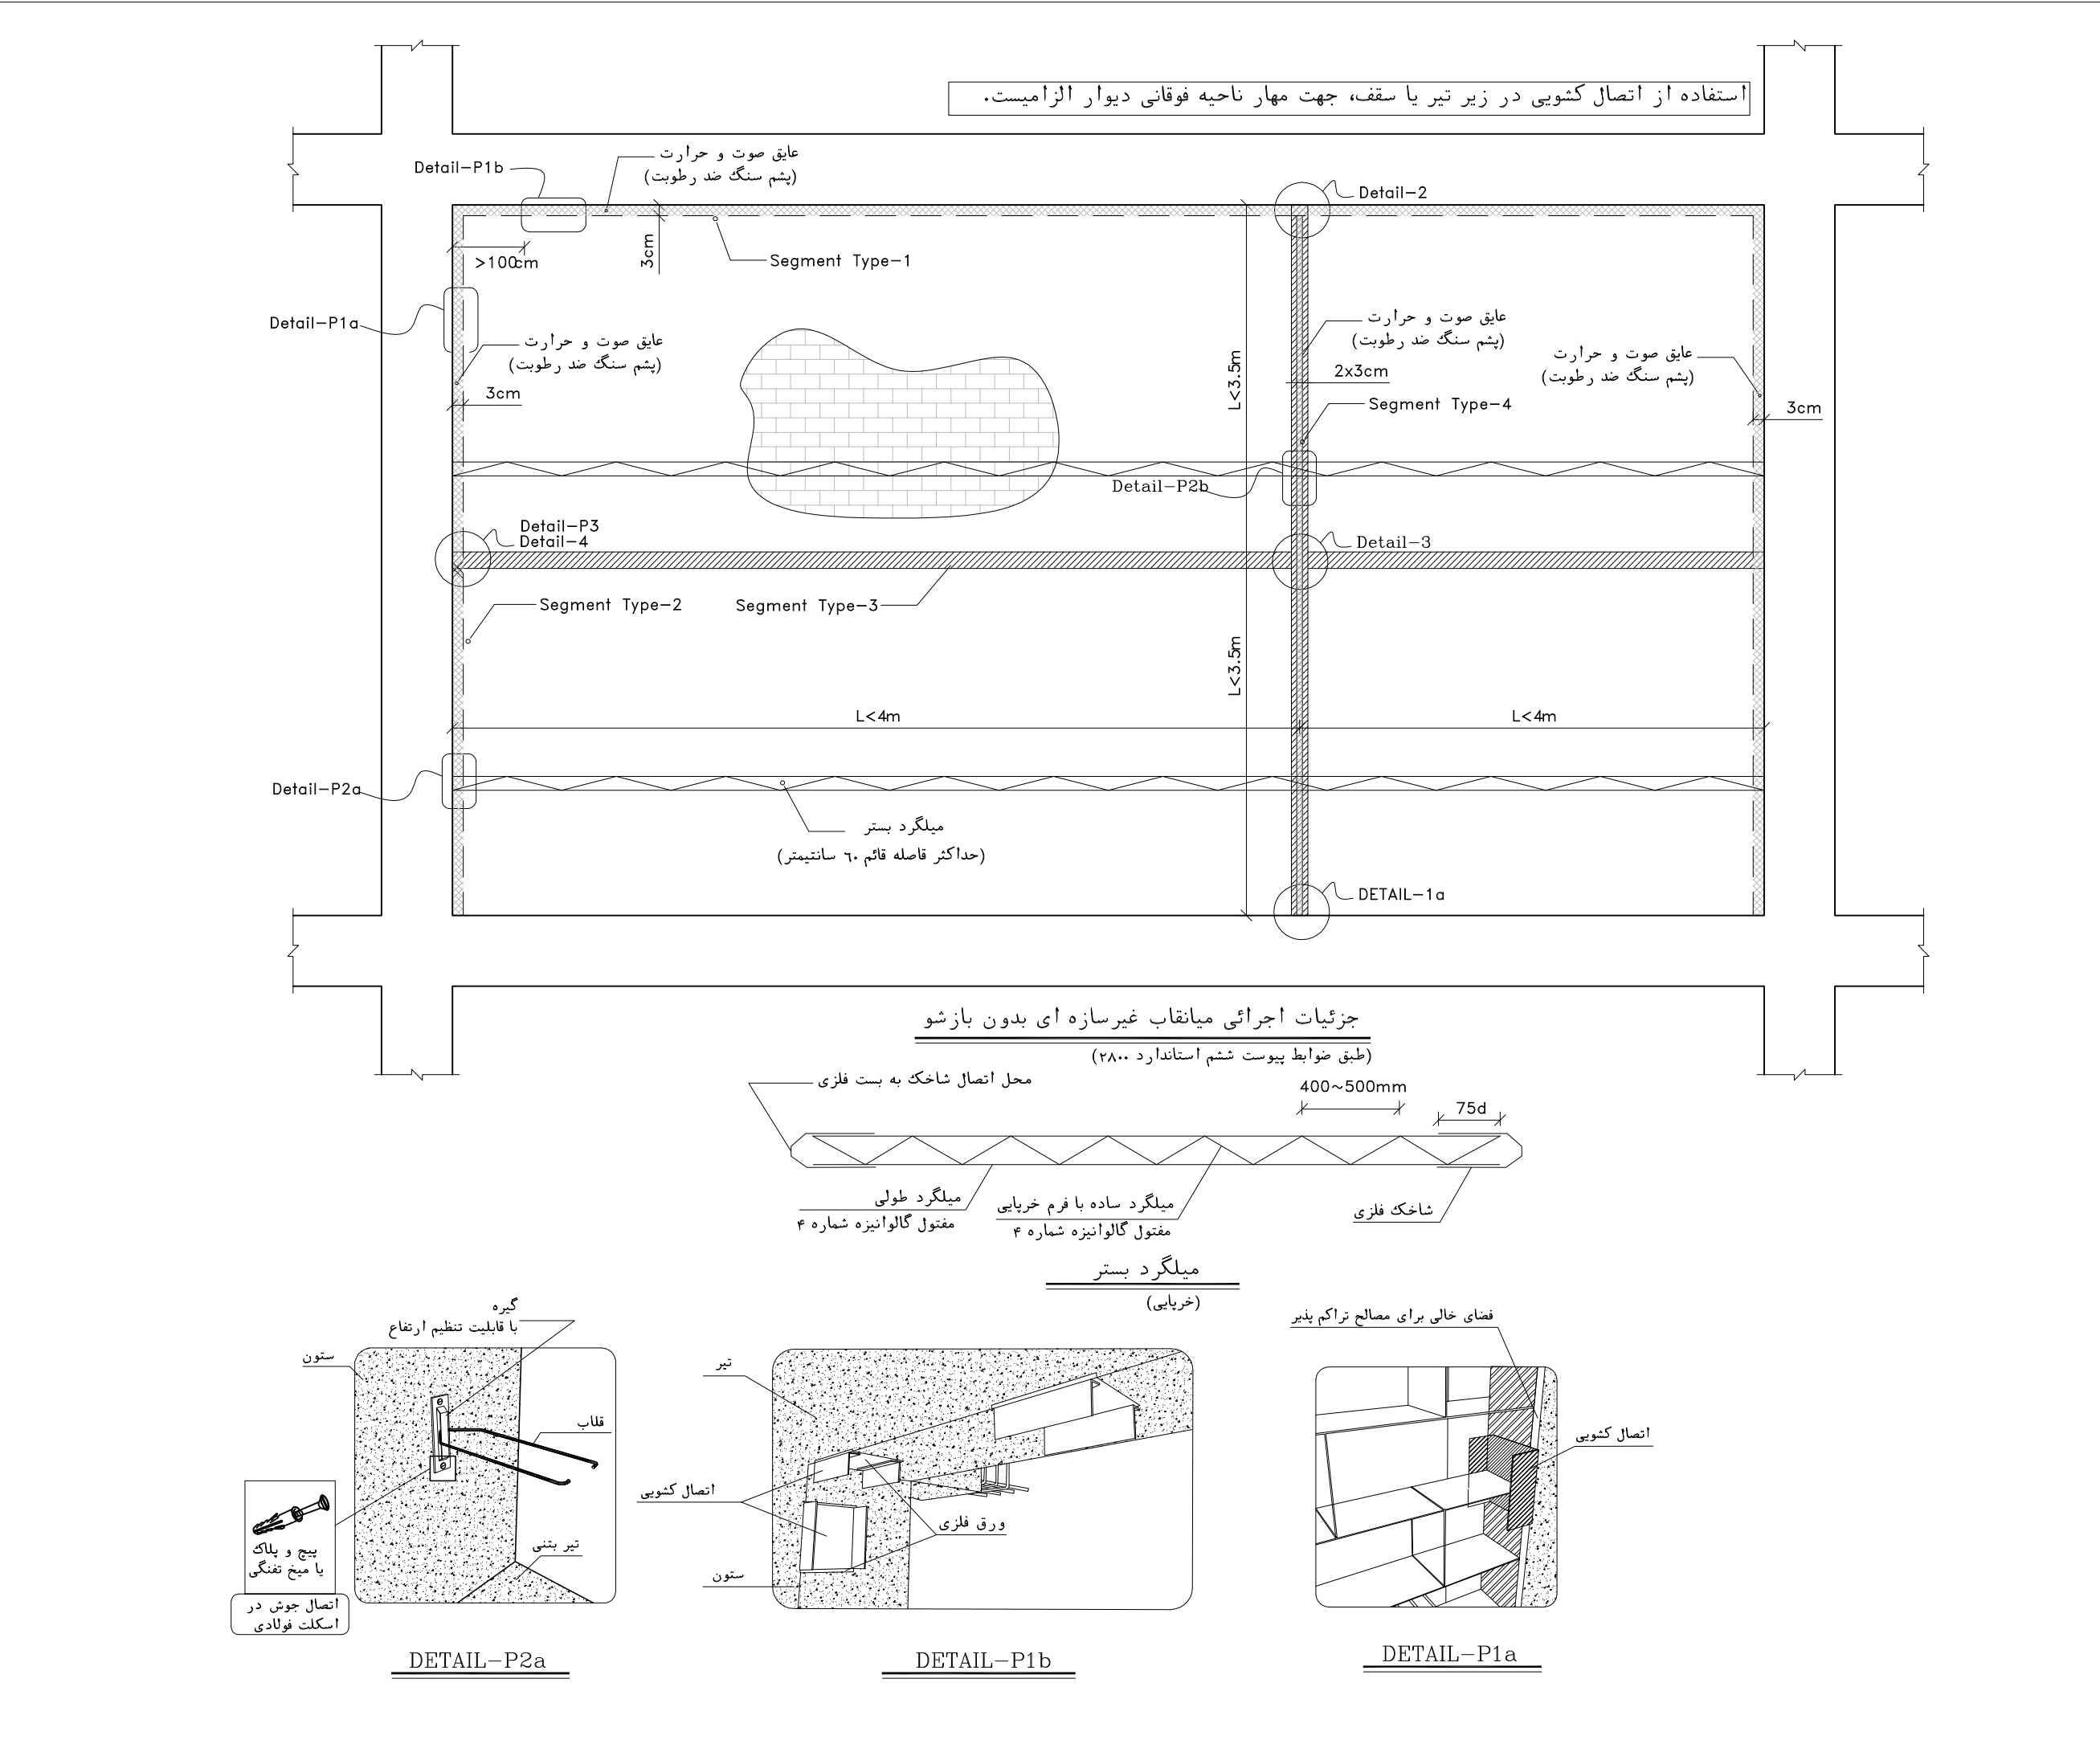


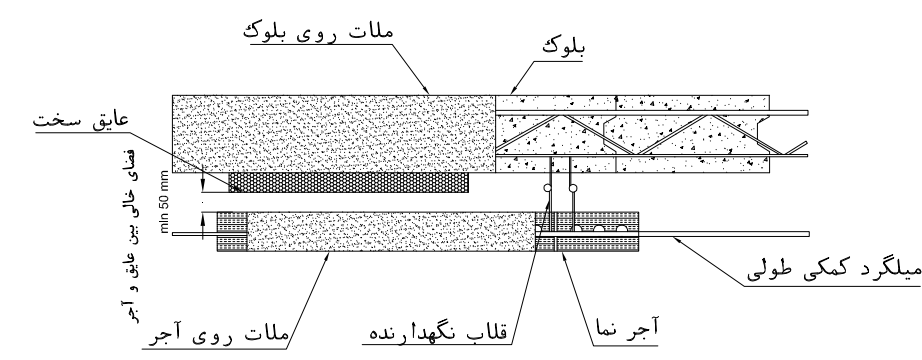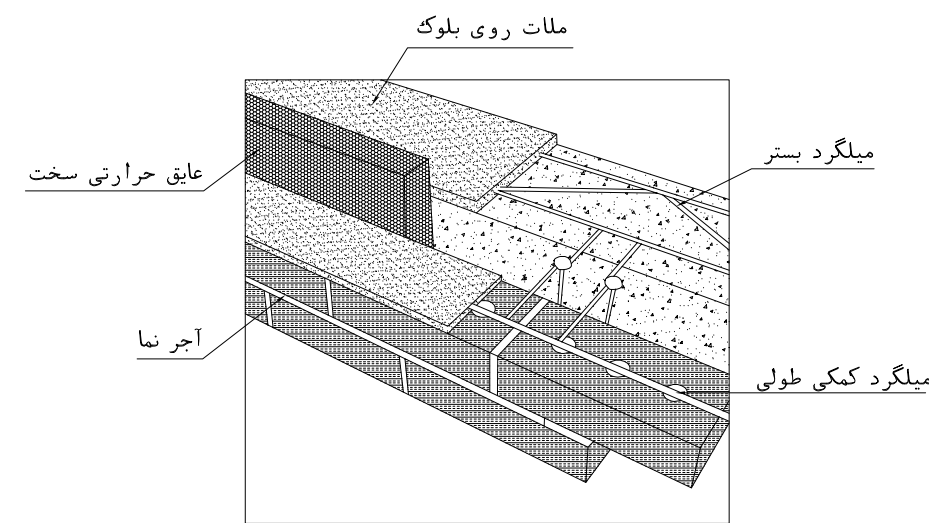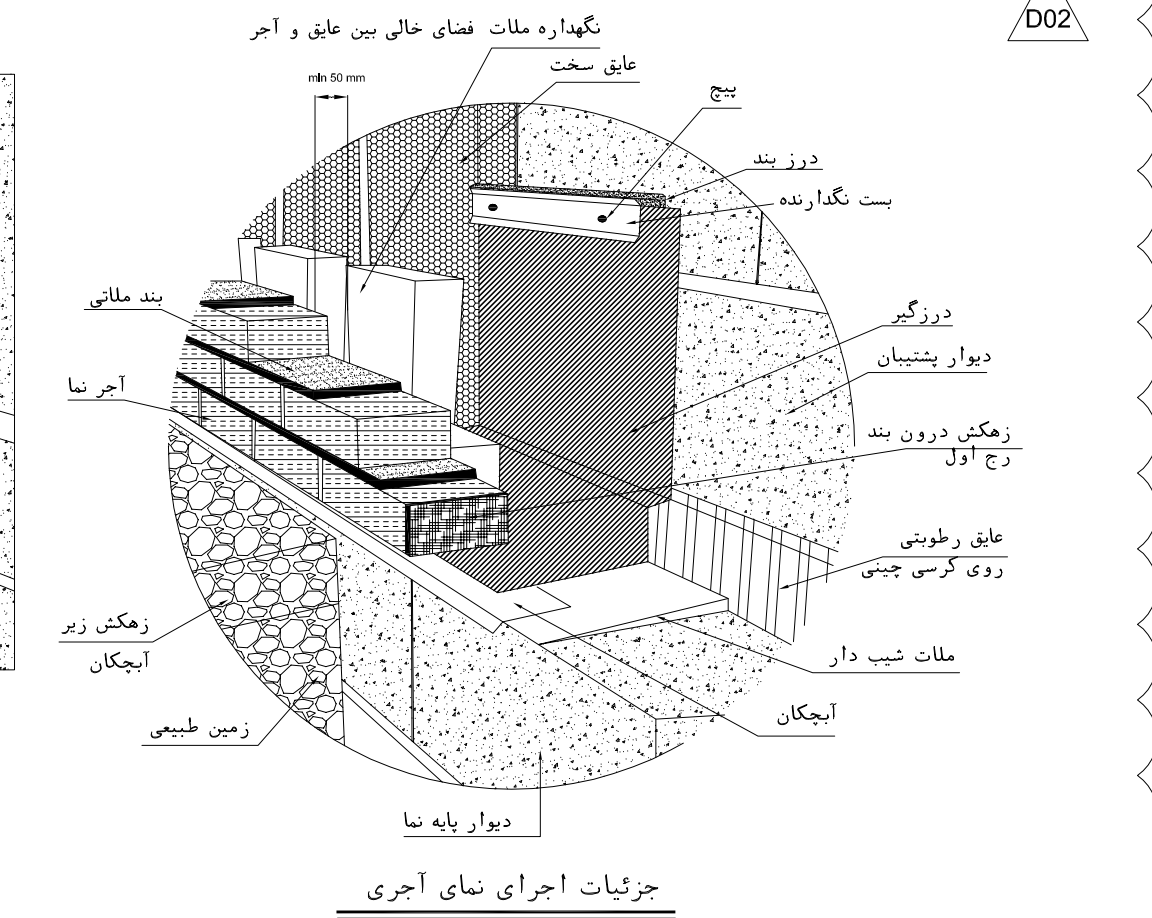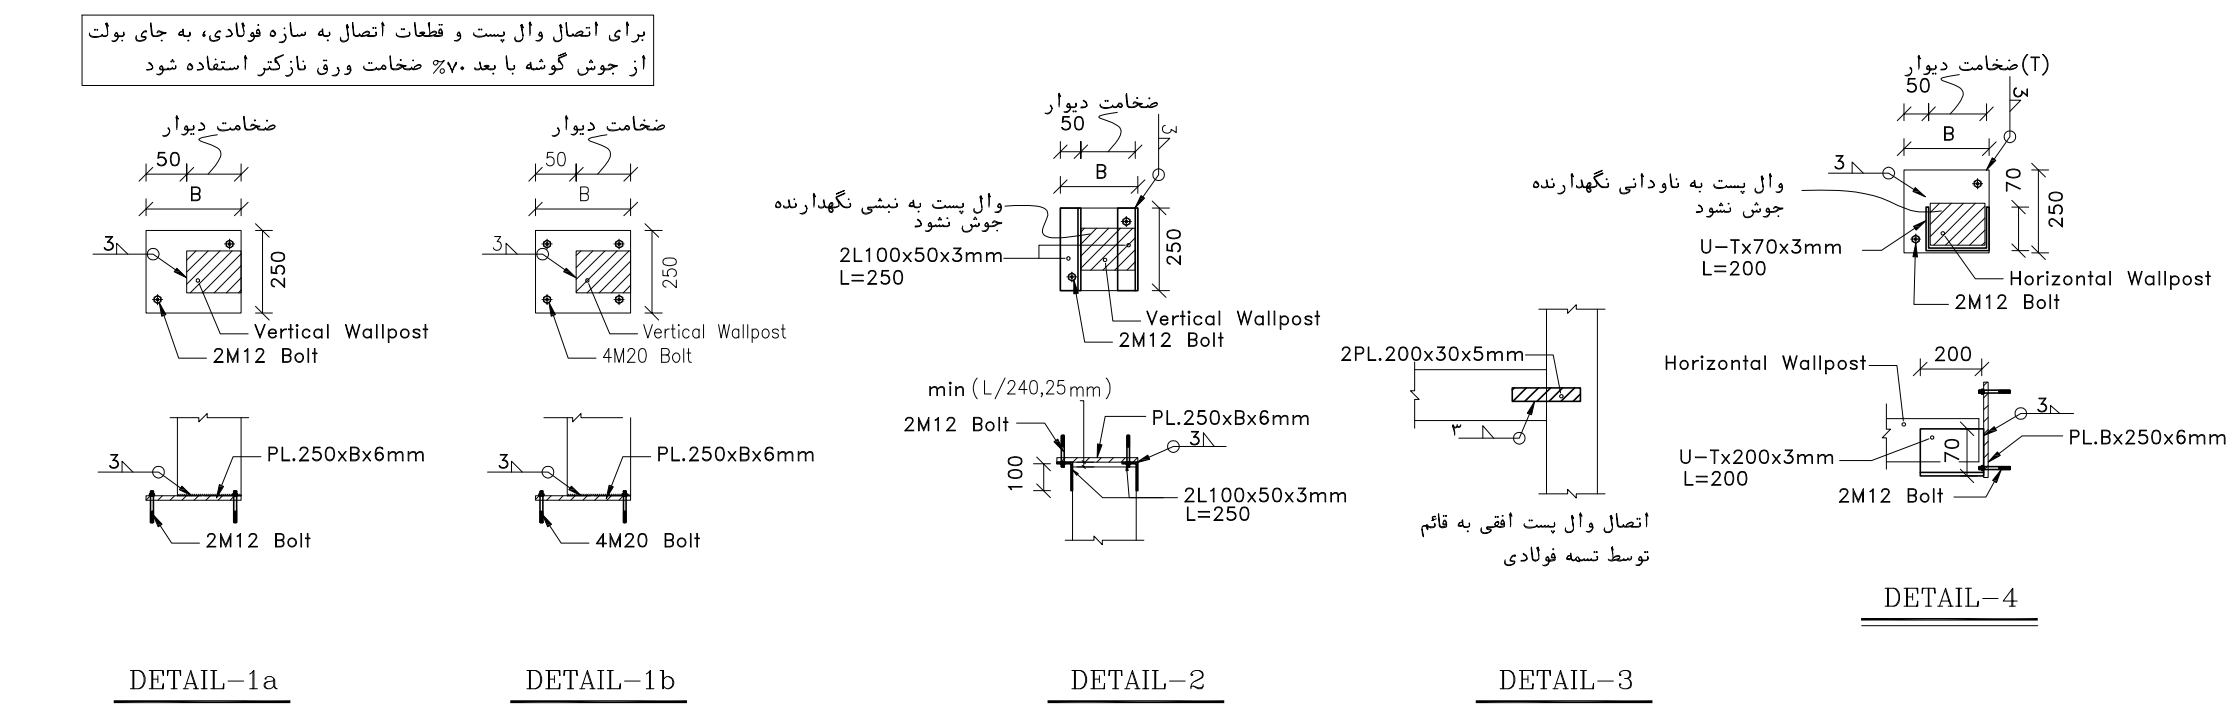

نحوه مهار نمای آجری به دیوار پشت

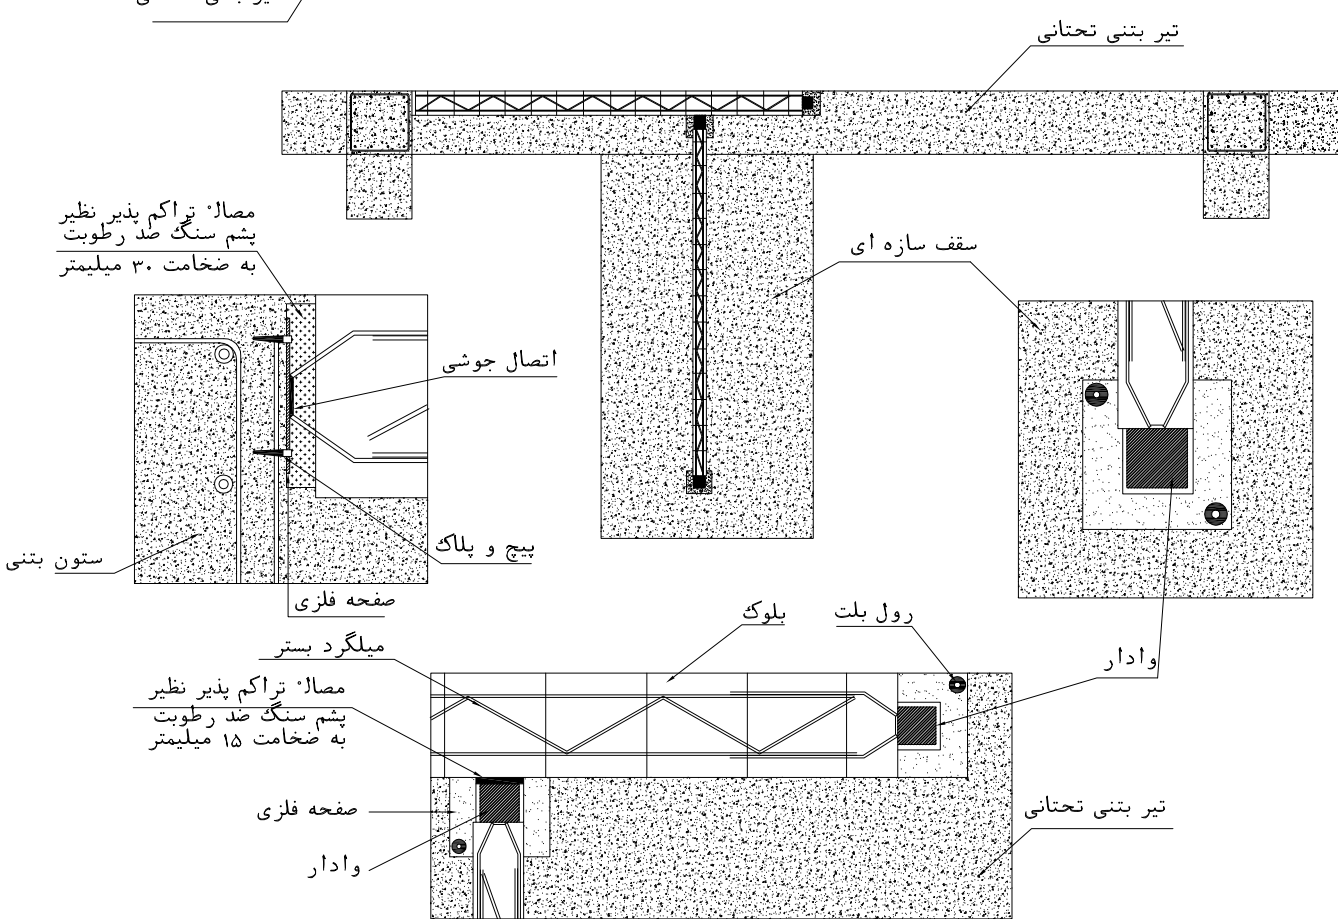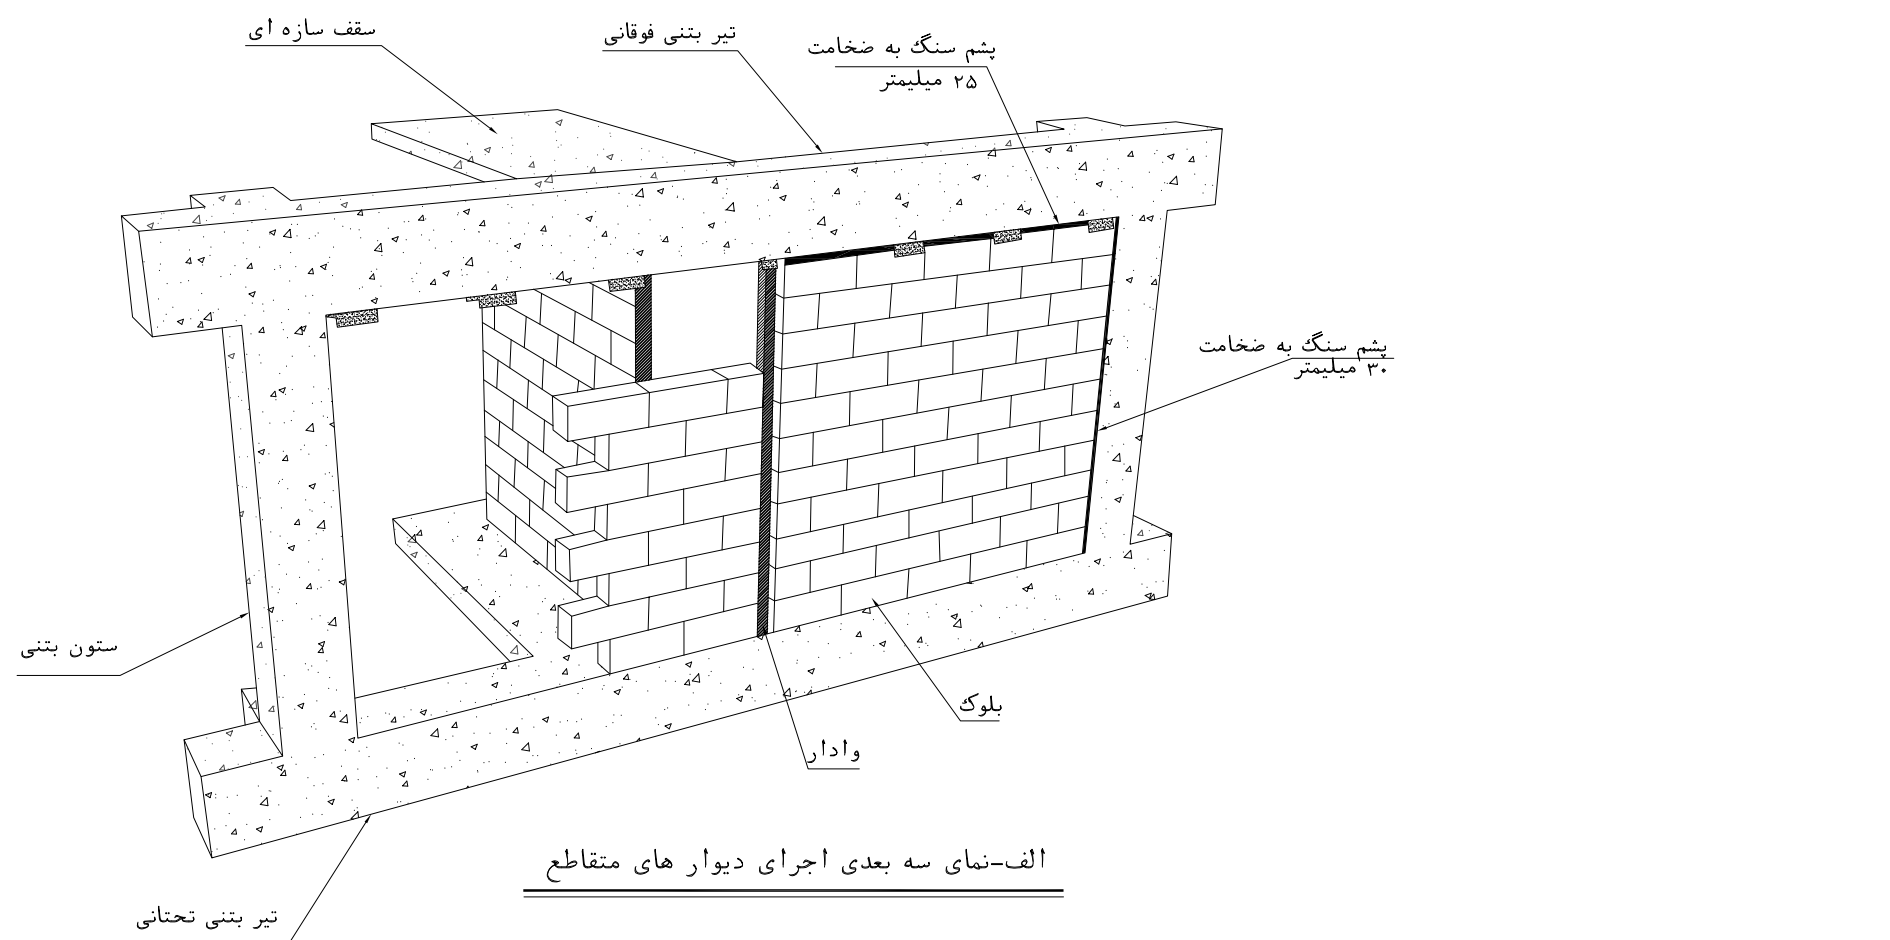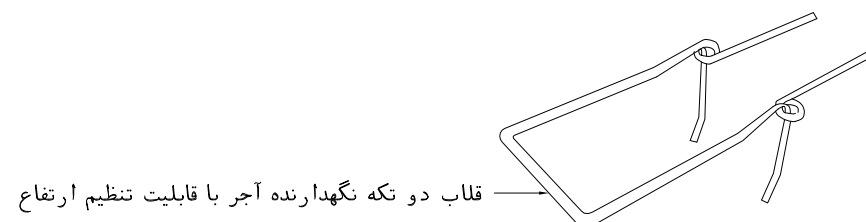

ب - اجرای دیوار متقاطع از بلان
اجرای دیوار های متقاطع و نحوه اجرای وادار در محل اتصال دو دیوار

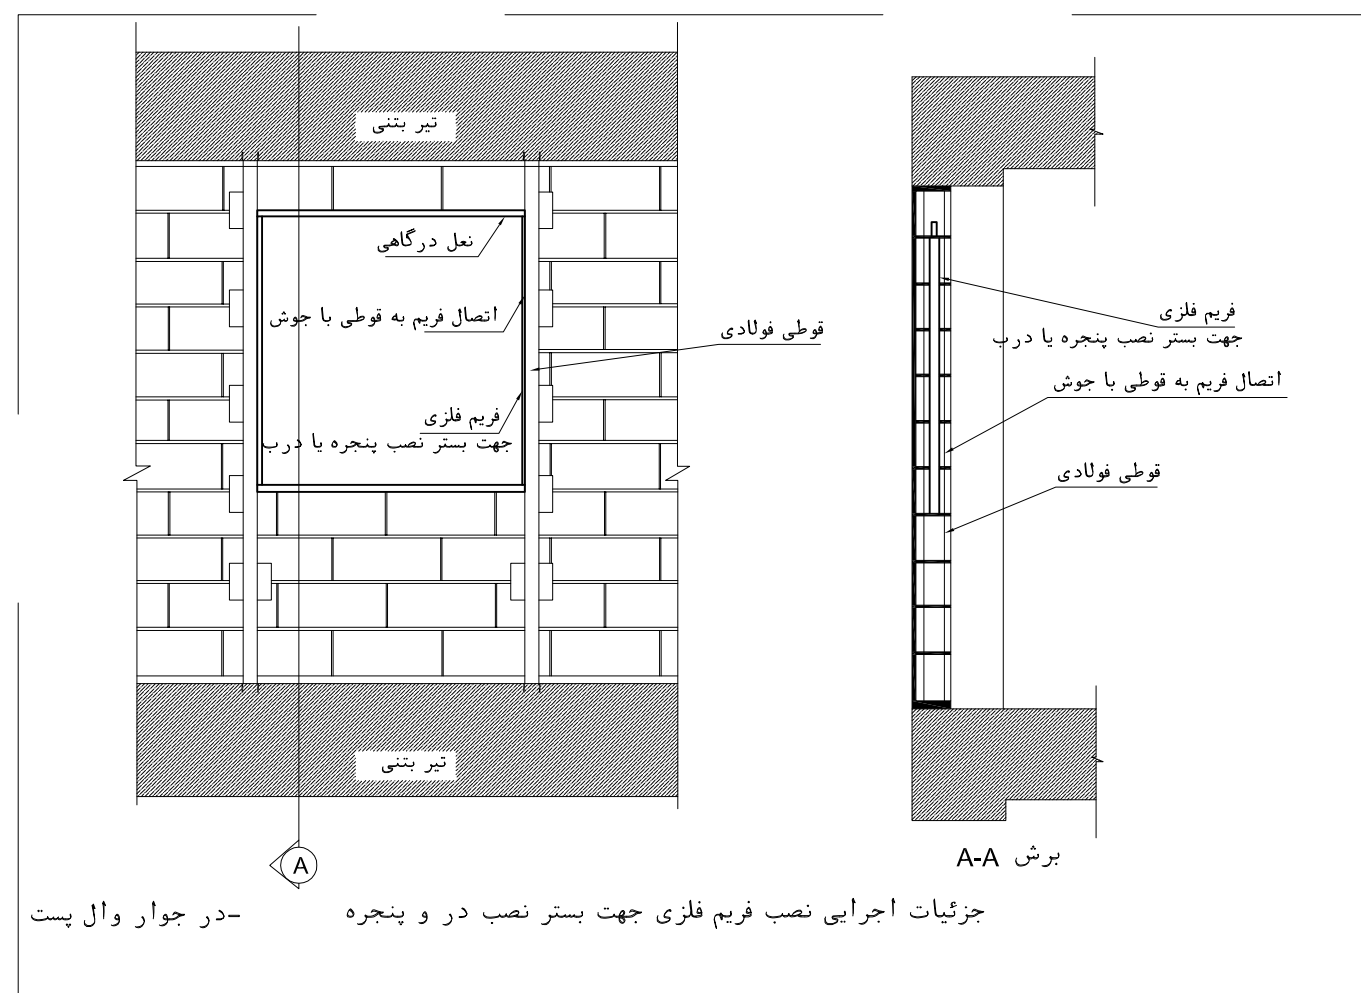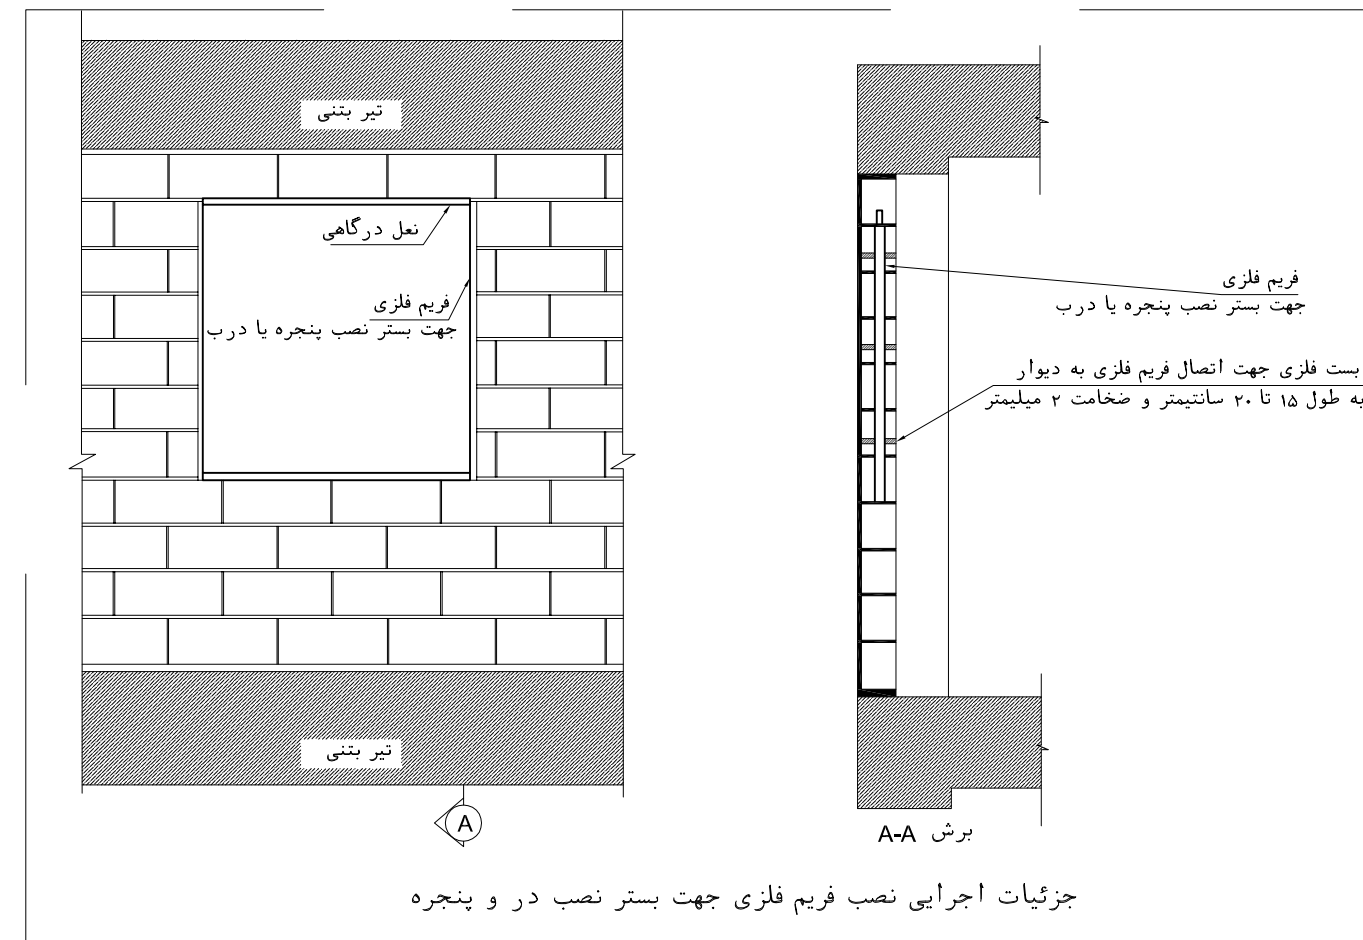


نحوه اجرای وادار در دو طرف باز شو در صورت نیاز

NOTES	
1. ALL DIMENSIONS ARE IN CENTIMETER & ALL ELEVATIONS ARE IN METER. 2. ALL DIMENSIONS AND ELEVATIONS SHALL BE CHECKED BY THE CONTRACTOR PRIOR TO CONSTRUCTION. 3. CONTRACTOR SHALL COMPARE ALL ARCHITECTURAL, MECHANICAL, ELECTRICAL, PIPING AND STRUCTURAL DRAWINGS AND IN CASE OF ANY CONFLICTS OR DISCREPANCY, INFORM THE ENGINEER. 4. ALL MATERIALS ARE SELECTED FROM THE HIGHEST QUALITY AND MUST BE APPROVED BY THE CLIENT. 5. ALL OPENINGS FOR PIPING/CABLING AND HVAC OPENINGS SHALL BE CONSIDERED AS PER RELATED DRAWINGS BEFORE CONSTRUCTION. 6. FINISH GRADING LEVEL IS EQUIVALENT=±0.00 LOCAL=+243.00 GLOBAL(M.S.L.) 7. POINT DL E134885/8880 - N:14115/3406 (UTM-ZONE 39). THIS COORDINATION IS PRELIMINARY AND WILL BE FINALIZED IN THE NEXT REVISION.	
LEGEND	
REFERENCE DRAWING	DRG. No.
STANDARD DRAWING FOR ARCHITECTURAL DETAILS	BK-GNRL-PEDCO-000-AR-DW-0001
SITE SEWAGE SYSTEM LAYOUT & DETAILS	BK-GCS-PEDCO-120-CV-PY-0001
CABLE TRENCH AND DUCT BANK LAYOUT	BK-GCS-PEDCO-120-CV-PY-0002
ROAD, PAVING AND PLANT FINISH GRADING LAYOUT & SECTIONS	BK-GCS-PEDCO-120-CV-PY-0005
ELECTRICAL CABLE ROUTE & SECTION LAYOUT FOR BUILDING & SHELTER	BK-GCS-PEDCO-120-EL-PY-0006
FOUNDATION DRAWING FOR CCTV CONTROL ROOM - BINAK DU	BK-GCS-PEDCO-120-ST-DW-0077
STRUCTURAL DRAWING FOR CCTV CONTROL ROOM - BINAK DU	BK-GCS-PEDCO-120-ST-DW-0078
STANDARD DETAILS FOR LADDER & SAFETY CAGE	BK-GNRL-PEDCO-000-ST-DW-0000

KEY PLAN

[illegible]

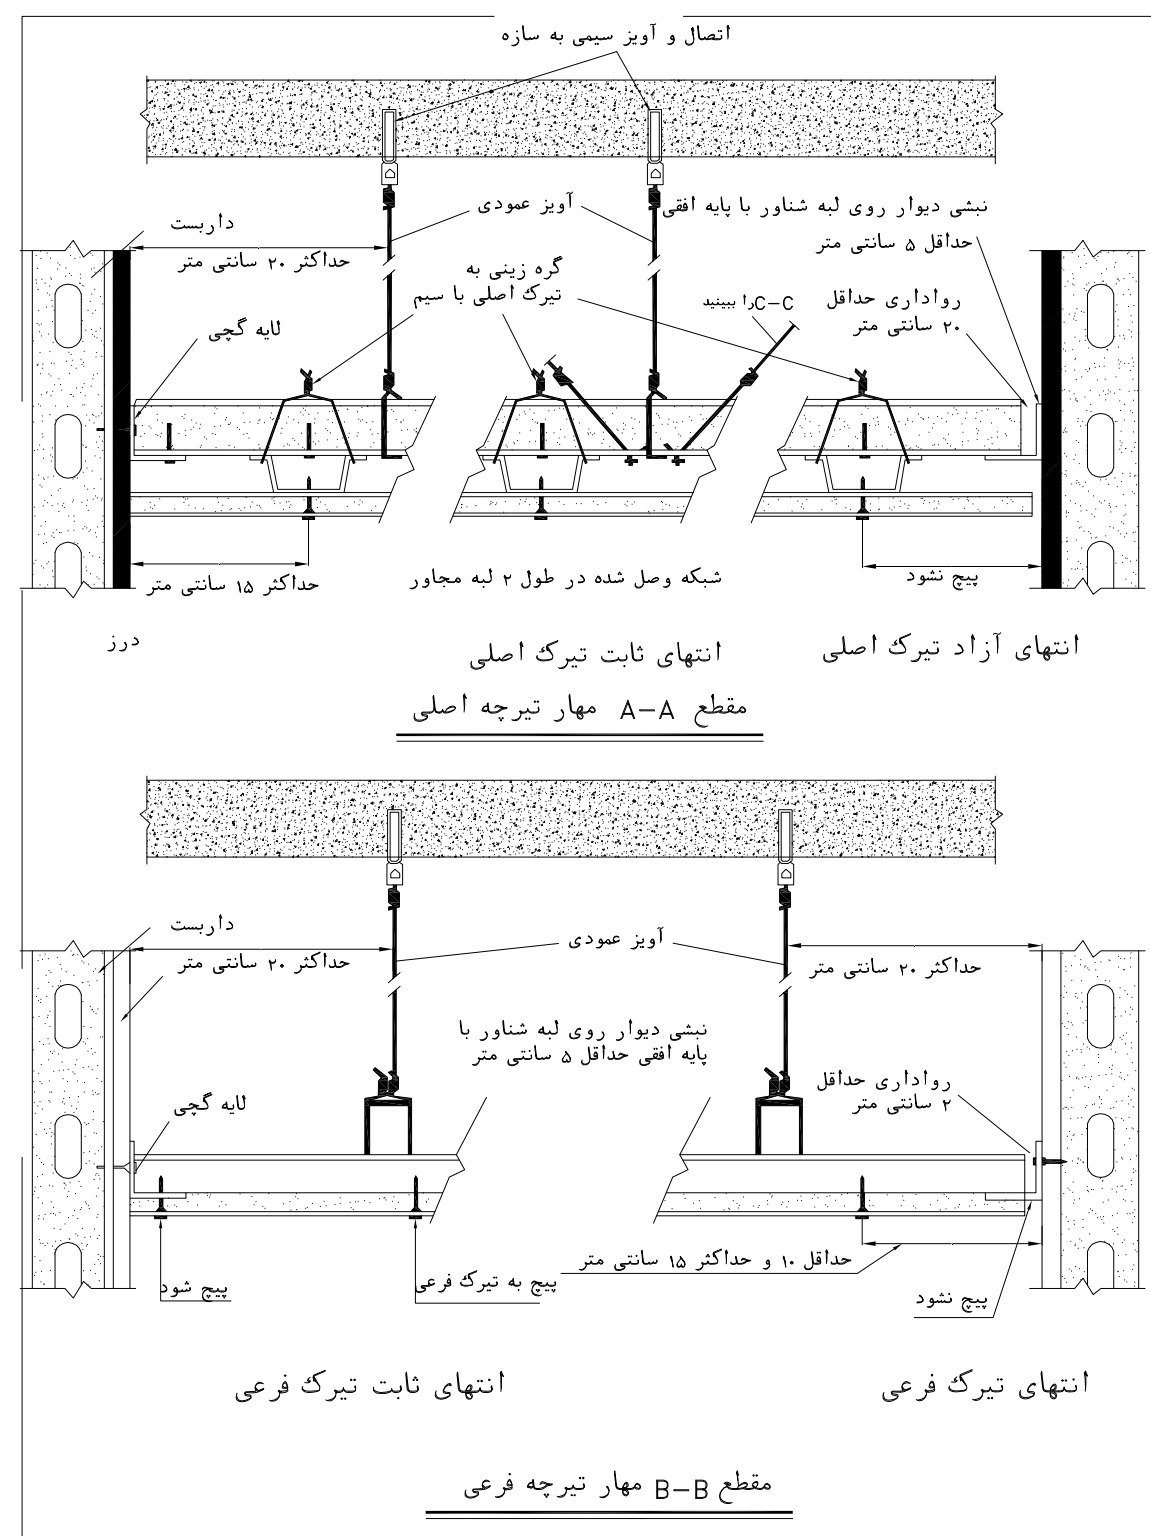

REFERENCE DRAWING	DRG. No.
STANDARD DRAWING FOR ARCHITECTURAL DETAILS	BK-GNRL-PEDCO-000-AR-DW-0001
SITE SEWAGE SYSTEM LAYOUT & DETAILS	BK-GCS-PEDCO-120-CV-PY-0001
CABLE TRENCH AND DUCT BANK LAYOUT	BK-GCS-PEDCO-120-CV-PY-0002
ROAD, PAVING AND PLANT FINISH GRADING LAYOUT & SECTIONS	BK-GCS-PEDCO-120-CV-PL-PY-0003
ELECTRICAL CABLE ROUTE & SECTION LAYOUT FOR BUILDING & SHELF	BK-GCS-PEDCO-120-EY-PY-0005
FOUNDATION DRAWING FOR CCTV CONTROL ROOM - SINAK DU	BK-GCS-PEDCO-120-ST-DW-0077
STRUCTURAL DRAWING FOR CCTV CONTROL ROOM - SINAK DU	BK-GCS-PEDCO-120-ST-DW-0078
STANDARD DETAILS FOR LADDER & SAFETY CAGE	BK-GNRL-PEDCO-000-ST-DW-0009

KEY PLAN

[illegible]