


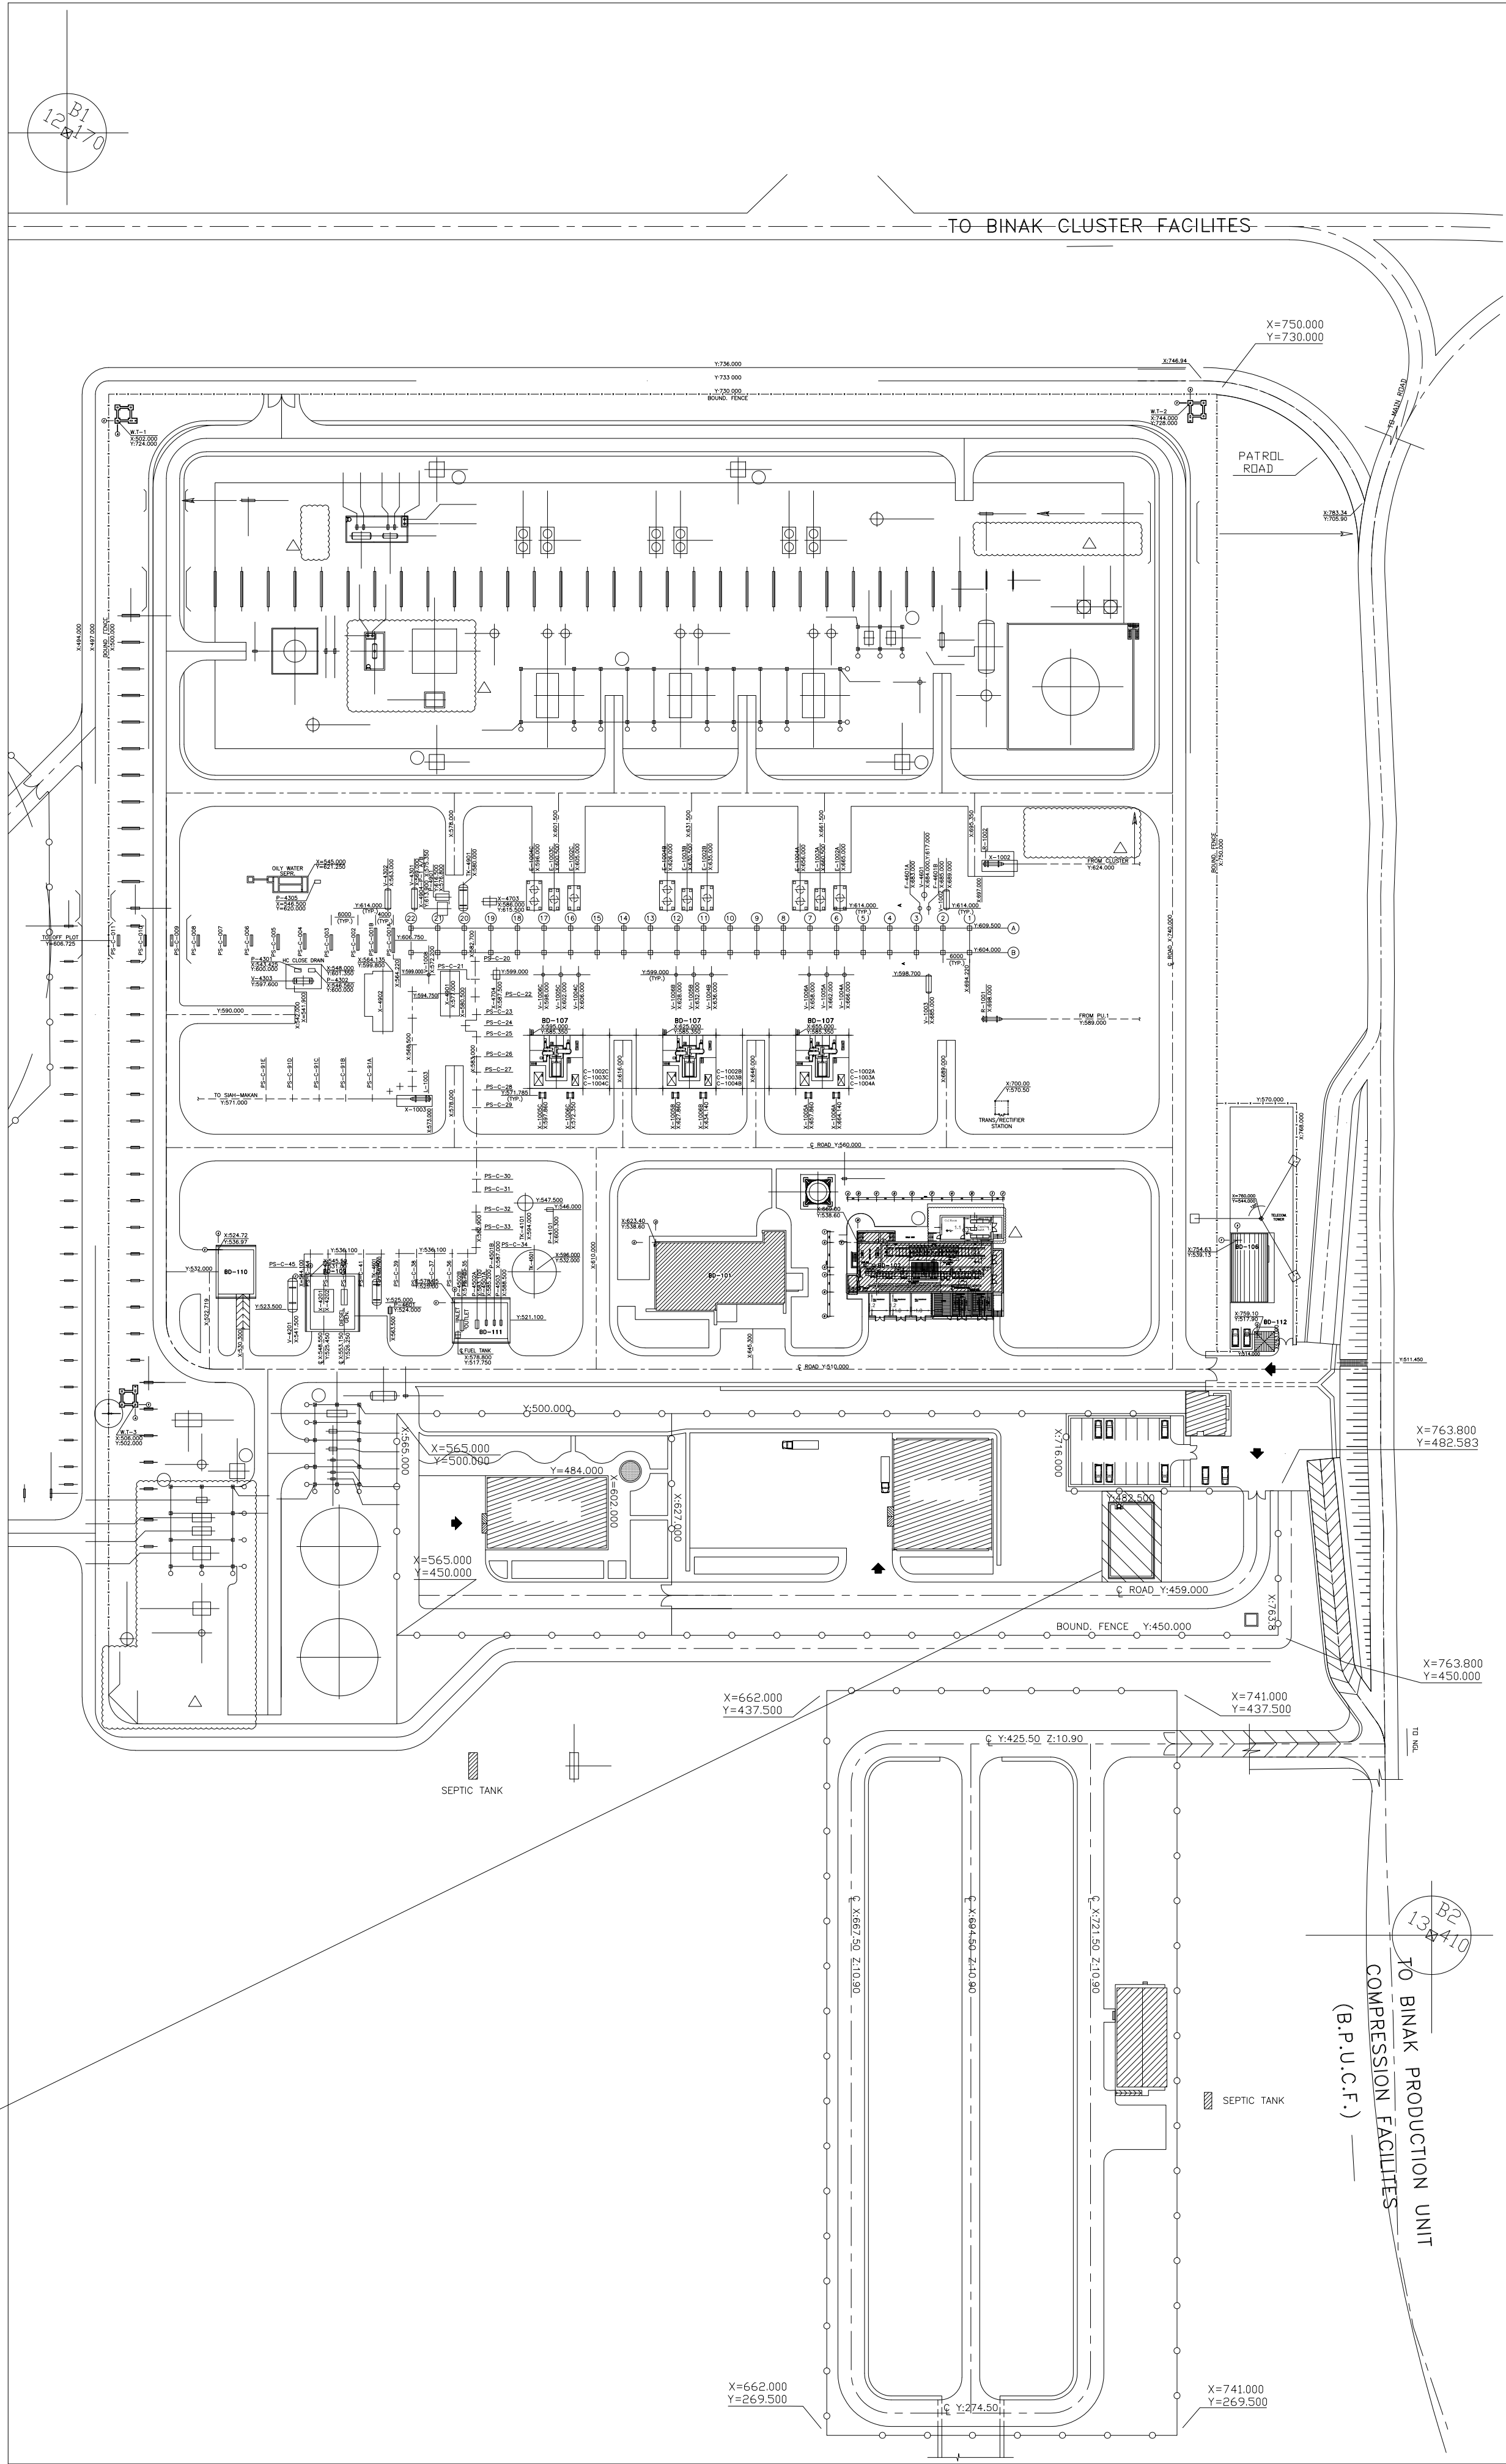

TO BINAK PRODUCTION UNIT
COMPRESSION FACILITIES
(B.P.U.C.F.) —

N.T.S

1. ALL DIMENSIONS ARE IN METERS & ALL ELEVATIONS ARE IN METER.
2. ALL DIMENSIONS AND ELEVATIONS SHALL BE CHECKED BY THE CONTRACTOR PRIOR TO CONSTRUCTION.
3. CONTRACTOR SHALL COMPARE ALL ARCHITECTURAL, MECHANICAL, ELECTRICAL, PIPING AND STRUCTURAL DRAWINGS AND IN CASE OF ANY CONFLICTS OR DISCREPANCY, INFORM THE ENGINEER.
4. ALL MATERIALS ARE SELECTED FROM THE HIGHEST QUALITY AND MUST BE APPROVED BY THE CLIENT.
5. ALL OPENINGS FOR PIPING/CABLING AND HVAC OPENINGS SHALL BE CONSIDERED AS PER RELATED DRAWINGS BEFORE CONSTRUCTION.
6. FINISH GRADING LEVEL (F.G.L.) : +11.20 (M.S.L.) = ±0.00 (LOCAL)

D04

THIS AREA

D04	SEP 2023	AFK	R.BERLOUE	M.PAKHARIAN	A.M.MOHSSENI	***
D03	AUG 2023	IFA	R.BERLOUE	M.PAKHARIAN	A.M.MOHSSENI	***
D02	MAY 2023	IFA	R.BERLOUE	M.PAKHARIAN	M.MEHRSHAD	***
D01	OCT 2022	IFA	R.BERLOUE	M.PAKHARIAN	M.MEHRSHAD	***
D00	JUN 2022	IFC	R.BERLOUE	M.PAKHARIAN	M.MEHRSHAD	***
REV.	DATE	P.O.I.S	PREP.	CHK.	APP.	AUT.

اصل و کلیه نسخ این نقشه و حق اقتباس متعلق به شرکت ملی مناطق نفت خیز جنوب می باشد.




ORIGINAL AND ALL COPIES OF THIS DRAWING TOGETHER WITH
THE COPYRIGHT THEREIN ARE THE SOLE PROPERTY OF
N.I.S.O.C./ FIELDS

N.I.S.O.C./ FIELDS

BINAK OILFIELD DEVELOPMENT
SURFACE FACILITIES
GAS COMPRESSOR STATION

HIGAN ENERGY - DESIGN & INSPECTION COMPANIES				PEDCO COMPANY				DATE		SCALE		DRAWING BY		CHECKED BY		PROJECT ENG.	
DRAWING TITLE Architectural Drawing For CCTV Control Room- Binak GCS PLAN								NO CONSTRUCTION PERMITTED UNLESS DRAWING APPROVED									
								APPROVED FOR CONSTRUCTION						BY:		DATE:	
SCALE	SIZE	DRAWING NO.				SHEET NO.	REV.	BUDGET REF.	LOCATION	SIZE	CLASS	SERIAL NO.	SHEET	REVISION			
AS SHOWN	A1	BK-GCS-PEDCO-120-AR-DW-0008				01 OF 11	D04	053-073-9184	F	4	B	709396	01 OF 11	D04			

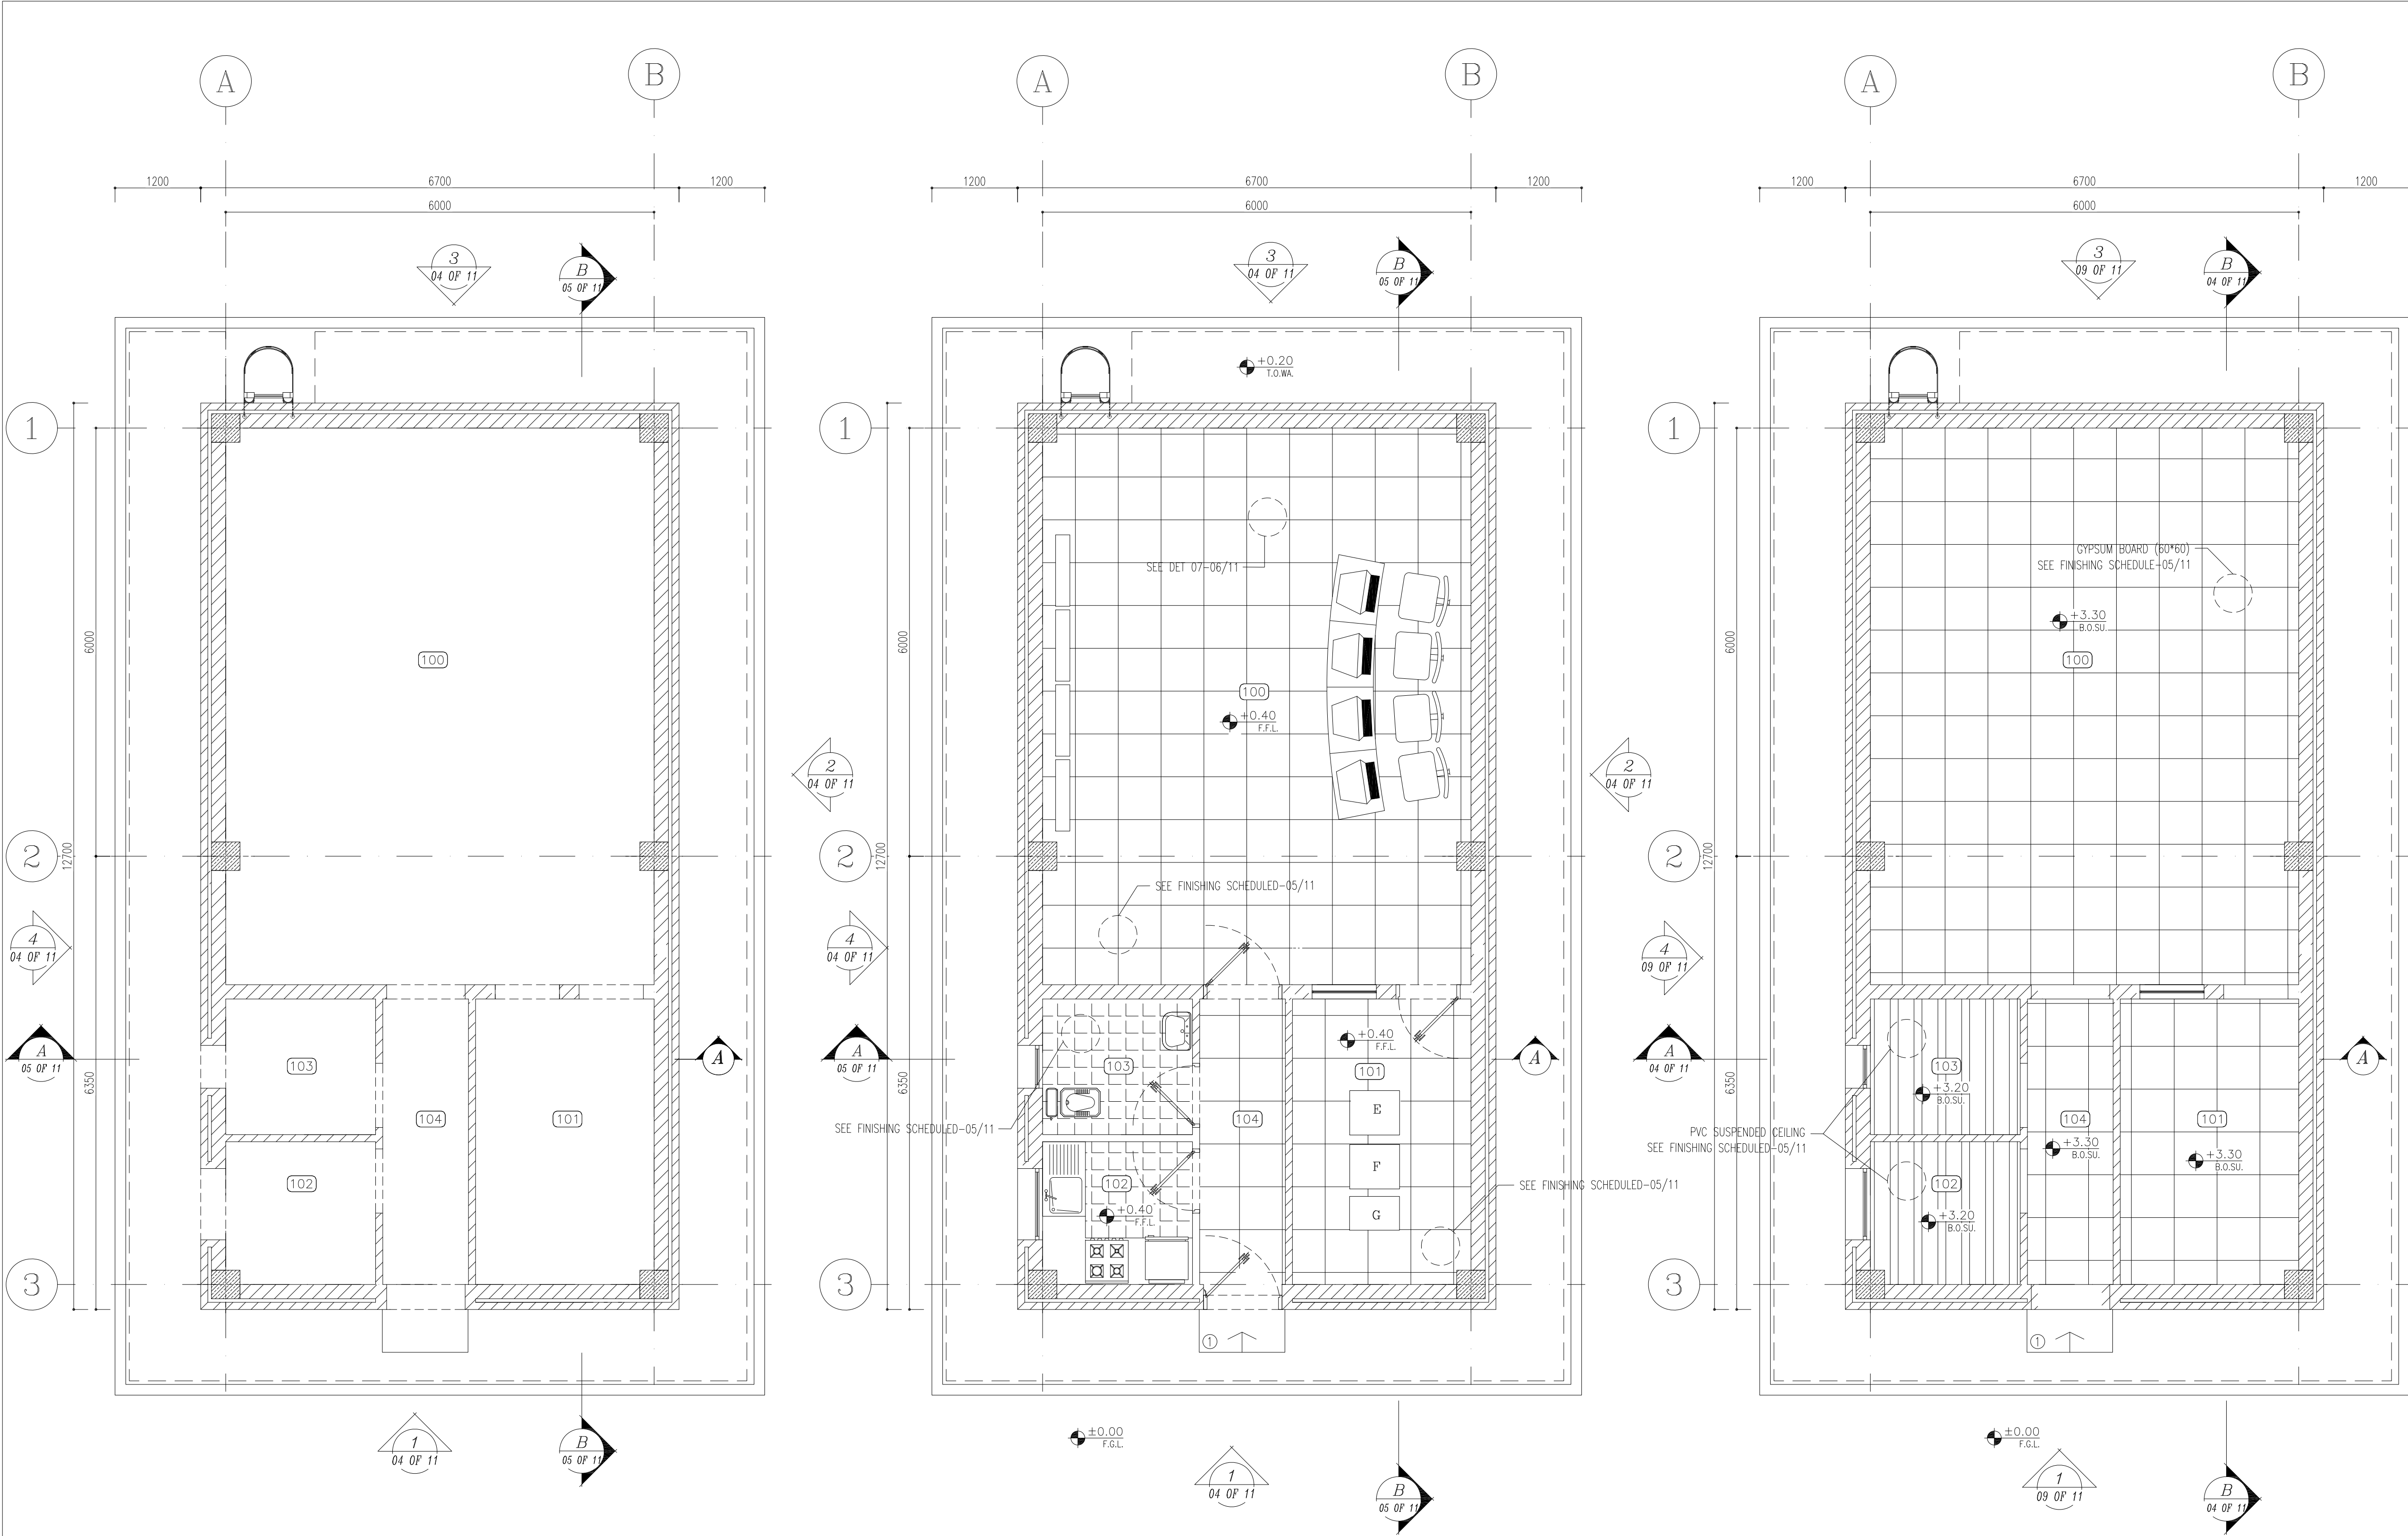

SC.1:50 4 LINTEL PLAN

SC.1:50 3 FURNITURE PLAN

SC.1:50 4 SUSPENDED CEILING PLAN

100	CONTROL ROOM
101	RACK ROOM
102	PANTRY
103	WC
104	ENTRANCE

D04	SEP. 2023	APC	R.BERLOUIE	M.PAKHARIAN	A.M.MOHSSENI	***
D03	AUG. 2023	IPA	R.BERLOUIE	M.PAKHARIAN	A.M.MOHSSENI	***
D02	MAY. 2023	IPA	R.BERLOUIE	M.PAKHARIAN	M.MEHRSHAD	***
D01	OCT. 2022	IPA	R.BERLOUIE	M.PAKHARIAN	M.MEHRSHAD	***
D00	JUN. 2022	IPC	R.BERLOUIE	M.PAKHARIAN	M.MEHRSHAD	***
REV.	DATE	P.O.I.S	PREP.	CHK.	APP.	AUT.

PROJECT NAME:		BINAK OILFIELD DEVELOPMENT/SURFACE FACILITIES GAS COMPRESSOR STATION	
PROJECT NO.:		971020	
EPC CONTRACTOR:		EPD/EPC CONTRACTOR (GC):	
 HIRGAN ENERGY – DESIGN & INSPECTION COMPANIES		 PETROIRAN DEVELOPMENT COMPANY	
DRAWING TITLE: Architectural Drawing For CCTV Control Room– Binak GCS PLAN			
SCALE	SIZE	DRAWING NO.	SHEET NO. REV
AS SHOWN	A1	BK-GCS-PEDCO-120-AR-DW-0008	03 OF 11 D04

- NOTES
1. ALL DIMENSIONS ARE IN MILLIMETER & ALL ELEVATIONS ARE IN METER.
 2. ALL DIMENSIONS AND ELEVATIONS SHALL BE CHECKED BY THE CONTRACTOR PRIOR TO CONSTRUCTION.
 3. CONTRACTOR SHALL COMPARE ALL ARCHITECTURAL, MECHANICAL, ELECTRICAL, PIPING AND STRUCTURAL DRAWINGS AND IN CASE OF ANY CONFLICTS OR DISCREPANCY, INFORM THE ENGINEER.
 4. ALL MATERIALS ARE SELECTED FROM THE HIGHEST QUALITY AND MUST BE APPROVED BY THE CLIENT.
 5. ALL OPENINGS FOR PIPING/CABLING AND HVAC OPENINGS SHALL BE CONSIDERED AS PER RELATED DRAWINGS BEFORE CONSTRUCTION.
 6. FINISH GRADING LEVEL (F.G.L.) : +11.20 (M.S.L.) = ±0.00 (LOCAL)

LEGEND	
F.F.L.	FINISHED FLOOR LEVEL
T.O.WA.	TOP OF WALKWAY
T.O.P.	TOP OF PARAPET
T.O.S.	TOP OF SLAB
T.O.D.	TOP OF DOOR
T.O.W.	TOP OF WINDOW
B.O.W.	BOTTOM OF WINDOW
T.O.C.	TOP OF CAGE
B.O.C.	BOTTOM OF CAGE
B.O.F.	BOTTOM OF FALSE FLOOR
B.O.SU.	BOTTOM OF SUSPENDED
B.O.S.	BOTTOM OF SLEEVE
F.G.L.	FINISH GROUND LEVEL



	BRICK WORK
	REINFORCED CONCRETE
	GYPSON BOARD
	PVC SUSPENDED CEILING
	BRICK FACING



REFERENCE DRAWING	DRG. No.
STANDARD DRAWING FOR ARCHITECTURAL DETAILS	BK-GNRL-PEDCO-000-AR-DW-0001
SITE SEWORAGE SYSTEM LAYOUT & DETAILS	BK-GCS-PEDCO-120-CV-PY-0001
CABLE TRENCH AND DUCT BANK LAYOUT	BK-GCS-PEDCO-120-CV-PY-0002
ROAD, PAVING AND PLANT FINISH GRADING LAYOUT & SECTIONS	BK-GCS-PEDCO-120-CV-PY-0005
ELECTRICAL CABLE ROUTE & SECTION LAYOUT FOR BUILDING & SHELTER	BK-GCS-PEDCO-120-EL-PY-0006
FOUNDATION DRAWING FOR CCTV CONTROL ROOM - BINAK GCS	BK-GCS-PEDCO-120-ST-DW-0075
STRUCTURAL DRAWING FOR CCTV CONTROL ROOM - BINAK GCS	BK-GCS-PEDCO-120-ST-DW-0076
STANDARD DETAILS FOR LADDER & SAFETY CAGE	BK-GNRL-PEDCO-000-ST-DW-0009
HVAC SYSTEM LAYOUT AND PLUMBING FOR CCTV CONTROL ROOM	BK-GCS-PEDCO-120-HV-PY-0009
PLUMBING & SEWAGE PIPING LAYOUT FOR CCTV CONTROL ROOM	BK-GCS-PEDCO-120-HV-PY-0013
UNIT PLOT PLAN DRAWING	BK-GCS-PEDCO-120-PI-PY-0001

KEY PLAN

اصل و کلیه نسخ این نقشه و حق اقتباس متعلق به شرکت ملی مناطق نفت خیز جنوب میباشد.
THE ORIGINAL AND ALL COPIES OF THIS DRAWING TOGETHER WITH THE COPYRIGHT THEREIN ARE THE SOLE PROPERTY OF N.I.S.O.C./ FIELDS

BINAK OILFIELD DEVELOPMENT SURFACE FACILITIES GAS COMPRESSOR STATION					
DATE	SCALE	DRAWING BY	CHECKED BY	PROJECT ENG.	
NO CONSTRUCTION PERMITTED UNLESS DRAWING APPROVED					
APPROVED FOR CONSTRUCTION			BY:	DATE:	
BUDGET REF.	LOCATION	SIZE CLASS	SERIAL NO.	SHEET	REVISION
AS SHOWN	053-073-9184	F	4	B	709396 03 OF 11 D04

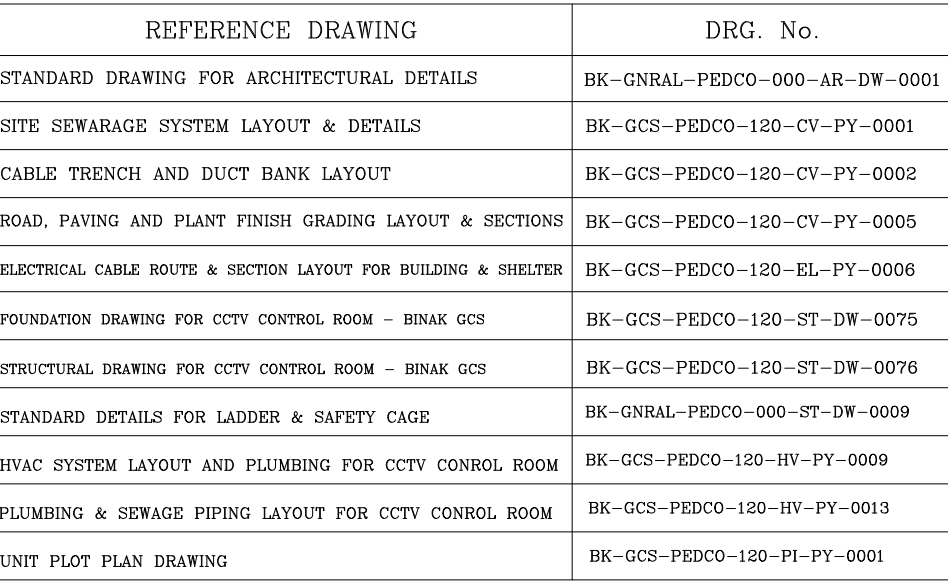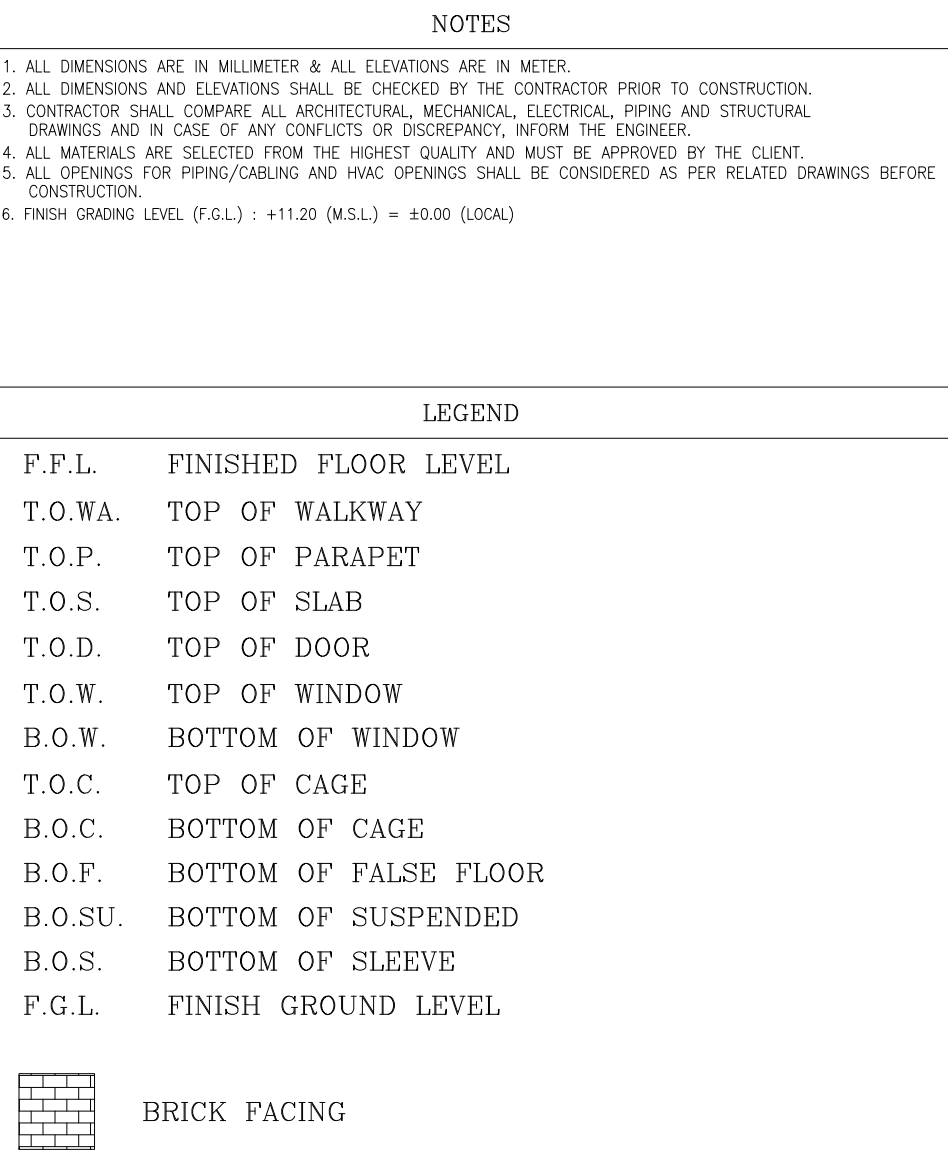[illegible]

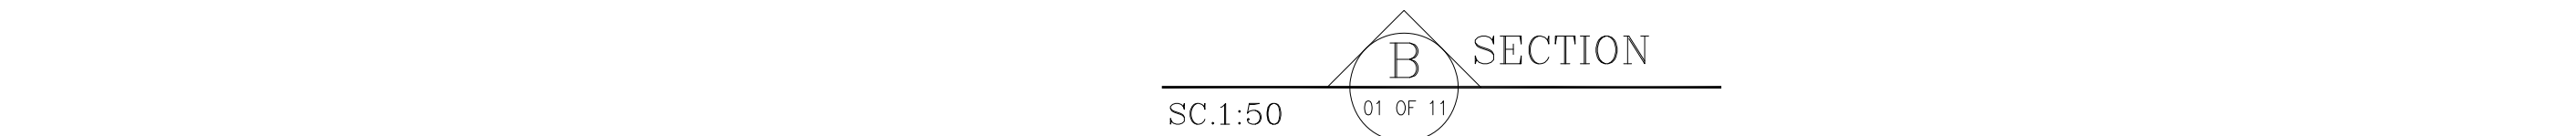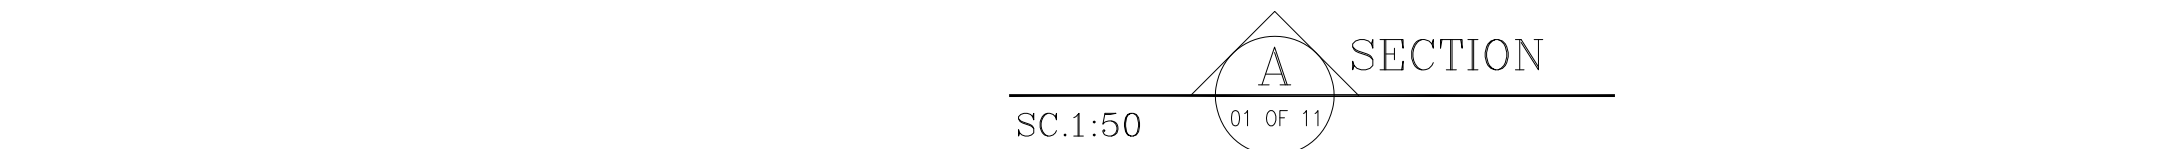

REFERENCE DRAWING	DRG. No.
STANDARD DRAWING FOR ARCHITECTURAL DETAILS	BK-GNRL-PEDCO-000-AR-DW-0001
SITE SEWAGEWAGE SYSTEM LAYOUT & DETAILS	BK-GCS-PEDCO-120-CV-PY-0001
CABLE TRENCH AND DUCT BANK LAYOUT	BK-GCS-PEDCO-120-CV-PY-0002
ROAD, PAVING AND PLANT FINISH GRADING LAYOUT & SECTIONS	BK-GCS-PEDCO-120-CV-PY-0005
ELECTRICAL CABLE ROUTE & SECTION LAYOUT FOR BUILDING & SHELTER	BK-GCS-PEDCO-120-EL-PY-0006
FOUNDATION DRAWING FOR CCTV CONTROL ROOM - BINAK GCS	BK-GCS-PEDCO-120-ST-DW-0075
STRUCTURAL DRAWING FOR CCTV CONTROL ROOM - BINAK GCS	BK-GCS-PEDCO-120-ST-DW-0076
STANDARD DETAILS FOR LADDER & SAFETY CAGE	BK-GNRL-PEDCO-000-ST-DW-0009
HVAC SYSTEM LAYOUT AND PLUMBING FOR CCTV CONTROL ROOM	BK-GCS-PEDCO-120-HV-PY-0009
PLUMBING & SEWAGE PIPING LAYOUT FOR CCTV CONTROL ROOM	BK-GCS-PEDCO-120-HV-PY-0013
UNIT PLOT PLAN DRAWING	BK-GCS-PEDCO-120-PI-PY-0001

Technical drawings of three window types with dimensions and optional features:

- Double Window:** Dimensions 1000 (width) x 1200 (height). Each pane is 500 wide. Includes a dashed line for optional glass pattern and double slashes (//) for optional glass.
- Square Window:** Dimensions 600 (width) x 600 (height). Includes a dashed line for optional glass pattern and double slashes (//) for optional glass.
- Single Window:** Dimensions 900 (width) x 1400 (height). Includes a grille labeled "FIX" and a flower ornament. Includes double slashes (//) for optional glass.

 TOTAL: 1 SC N.T.S. UPVC MATERIAL	 TOTAL: 1 SC N.T.S. UPVC MATERIAL	 TOTAL: 1 SC N.T.S. UPVC MATERIAL
---	---	---

FINISHING SCHEDULE						
NO.	AREA	FLOOR	MATERIAL DIMENSION	SKIRTING	WALL 	CEILING
(100)	CONTROL ROOM	GRANITE PLAQUE STONE	(60x60)	GRANITE STONE (H=100CM)	FIRST GRADE MDF WALL + CEMENT PLASTER LAYER + COVERING UP TO +2.80	GYPSUM BOARD 60x60 REMOVABLE SUSPENDED CEILING
(101)	RACK ROOM	ANTI-STATIC RAISED FLOOR TILES	(60x60)	GRANITE STONE (H=100CM)	MARBLE STONE UP TO 2.80	GYPSUM BOARD 60x60 REMOVABLE SUSPENDED CEILING
(102)	PANTRY	FIRST CLASS IRANIAN CERAMIC TILES	(30x30)	—	GLAZED TILE 25x30 UP TO +2.80	PVC SUSPENDED CEILING
(103)	WC	FIRST CLASS IRANIAN CERAMIC TILES	(30x30)	—	GLAZED TILE 25x30 UP TO +2.80	PVC SUSPENDED CEILING
(104)	ENTRANCE	GRANITE PLAQUE STONE	(60x60)	GRANITE STONE (H=100CM)	GYPSUM PLASTER + OIL PAINT + CEMENT PLASTER LAYER	GYPSUM BOARD 60x60 REMOVABLE SUSPENDED CEILING
—	ROOF	TERRAZZO TILE FIRST GRADE	(30x30)	TERRAZZO TILE (30x30x2.5)	CEMENT PLASTER	—

3 FINISHING SCHEDULE



PROJECT NAME:	BINAK OILFIELD DEVELOPMENT/SURFACE FACILITIES GAS COMPRESSOR STATION
---------------	---

EPC CONTRACTOR:   HIRGAN ENERGY – DESIGN & INSPECTION COMPANIES	EPD/EPC CONTRACTOR (GC):  PETROIRAN DEVELOPMENT COMPANY PEDCO
---	--

DRAWING TITLE:	Architectural Drawing For CCTV Control Room- Binak GCS SECTIONS AND DETAILS
----------------	--

SCALE	SIZE	DRAWING NO.	SHEET NO.	REV
AS SHOWN	A1	BK-GCS-PEDCO-120-AR-DW-0008	05 OF 11	D04

اصل و کلیه نسخ این نقشه و حق اقتباس متعلق به شرکت ملی مناطق نفت خیز جنوب میباشد.


THE ORIGINAL AND ALL COPIES OF THIS DRAWING TOGETHER WITH
THE COPYRIGHT THEREIN ARE THE SOLE PROPERTY OF
N.I.S.O.C./ FIELDS

BINAK OILFIELD DEVELOPMENT				
SURFACE FACILITIES				
GAS COMPRESSOR STATION				


DATE	SCALE	DRAWING BY	CHECKED BY	PROJECT ENG.

NO CONSTRUCTION PERMITTED UNLESS DRAWING APPROVED		
APPROVED FOR CONSTRUCTION	BY:	DATE:


BUDGET REF.	LOCATION	SIZE	CLASS	SERIAL NO.	SHEET	REVISION
053-073-9184	F	4	B	709396	05 OF 11	D04

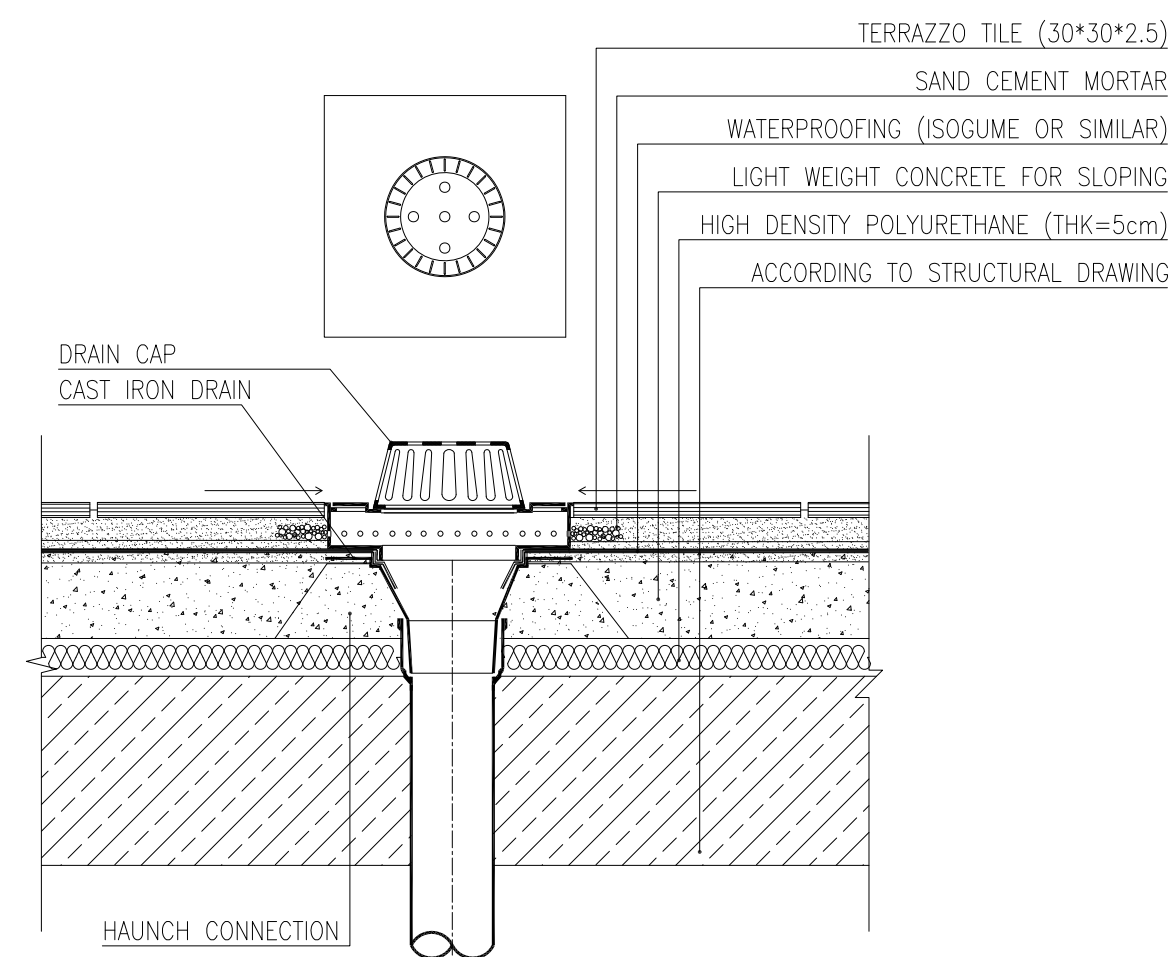


DETAIL 04
Sc:1/10

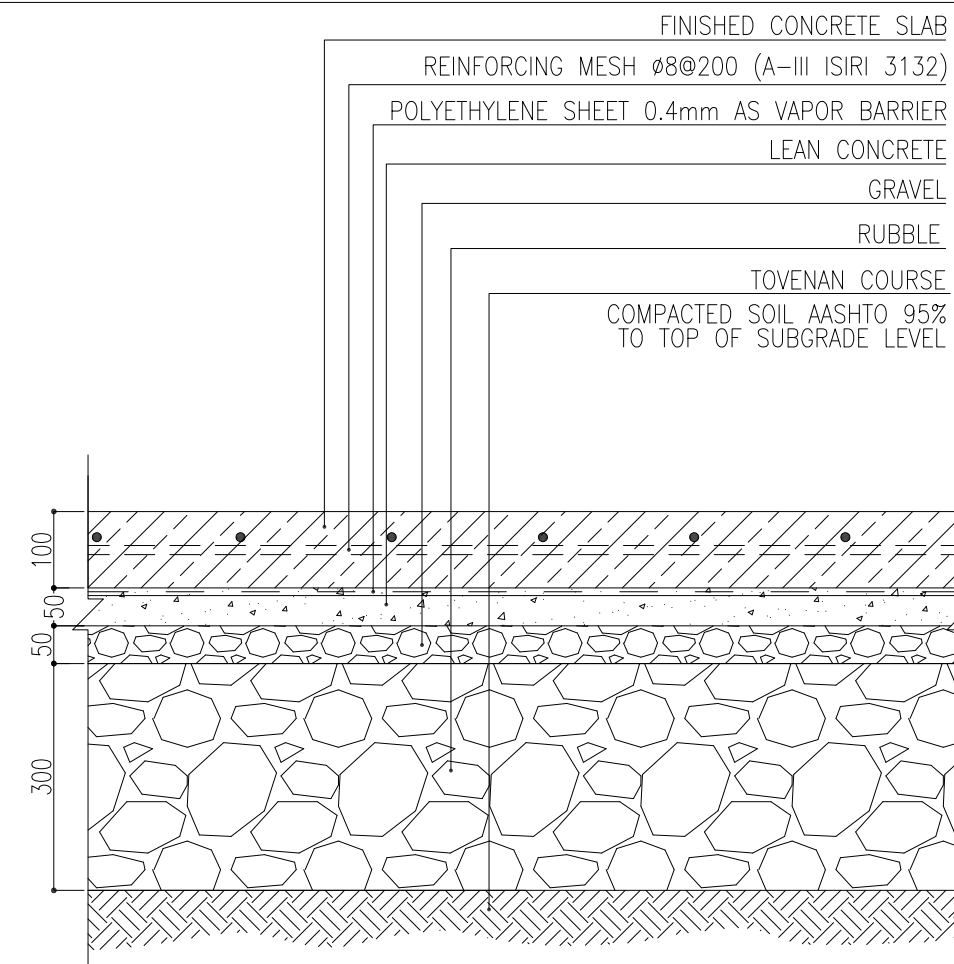


DETAIL 08
Sc:1/10

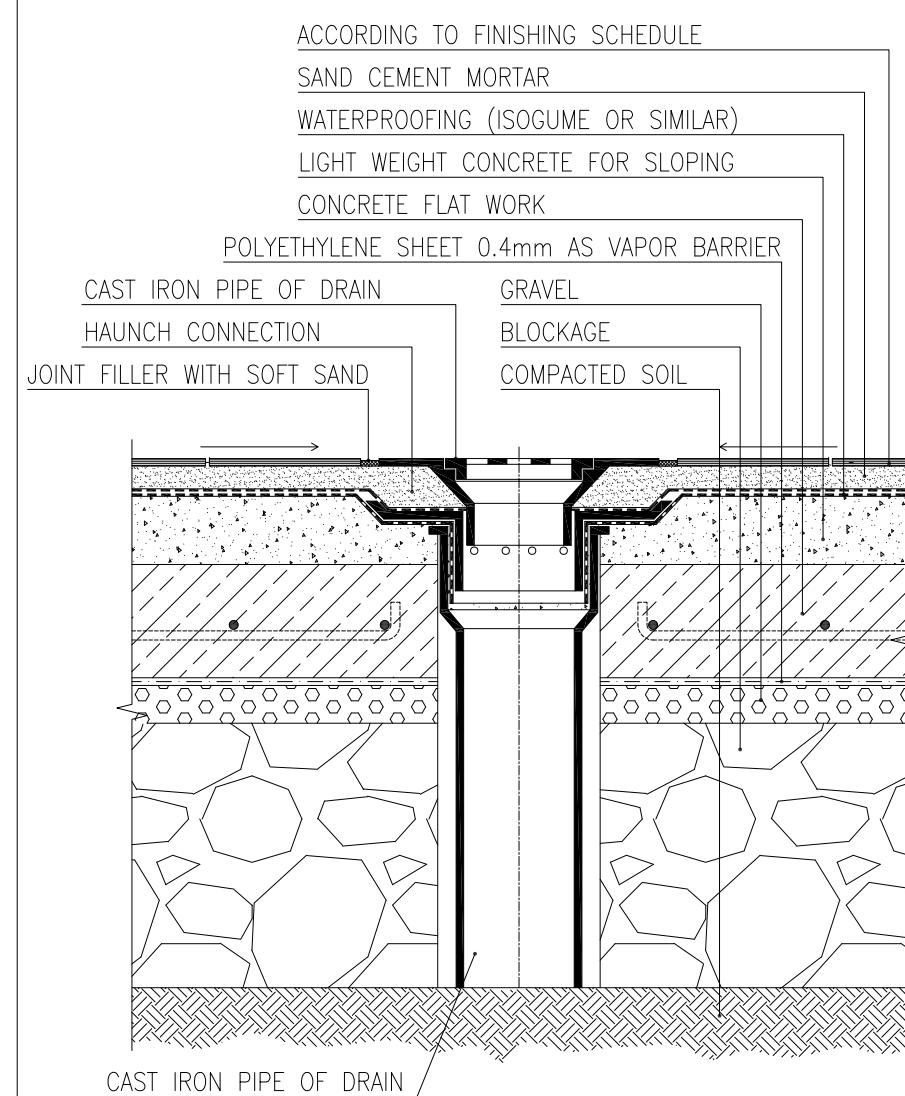


DETAIL 05
Sc:1/10

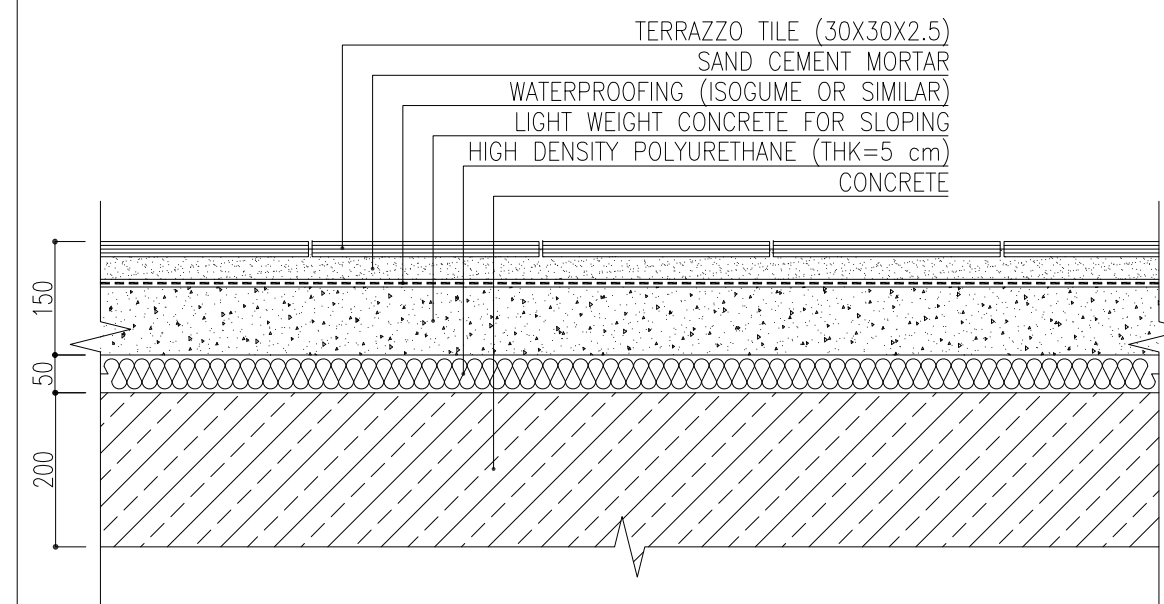

DETAIL 06
Sc:1/10

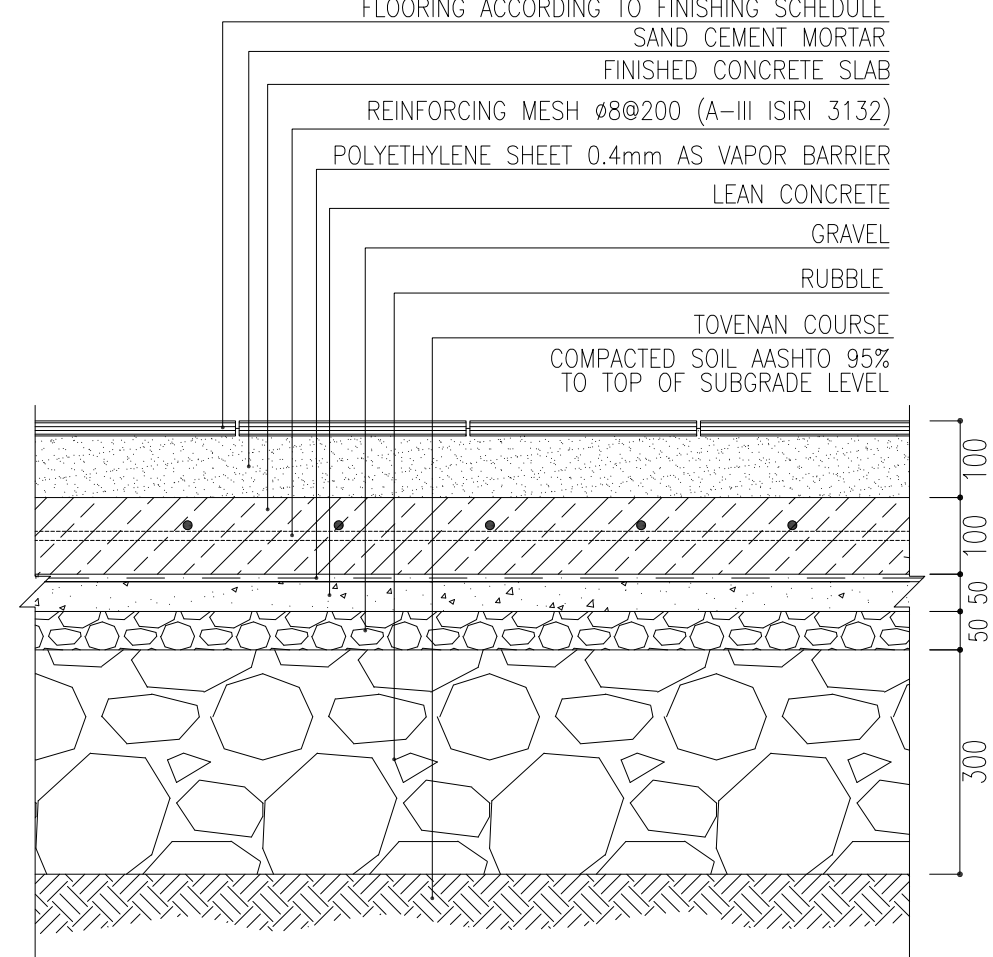


DETAIL 07
Sc:1/10

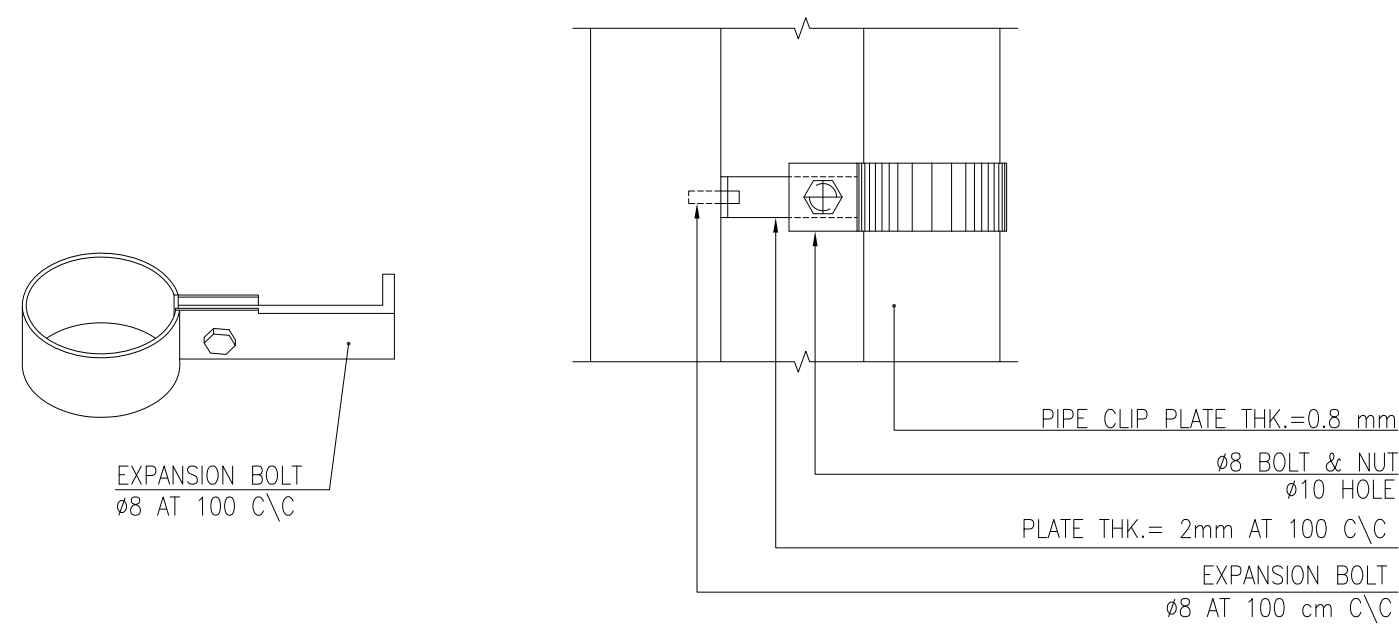


DETAIL 10

Sc:1/5

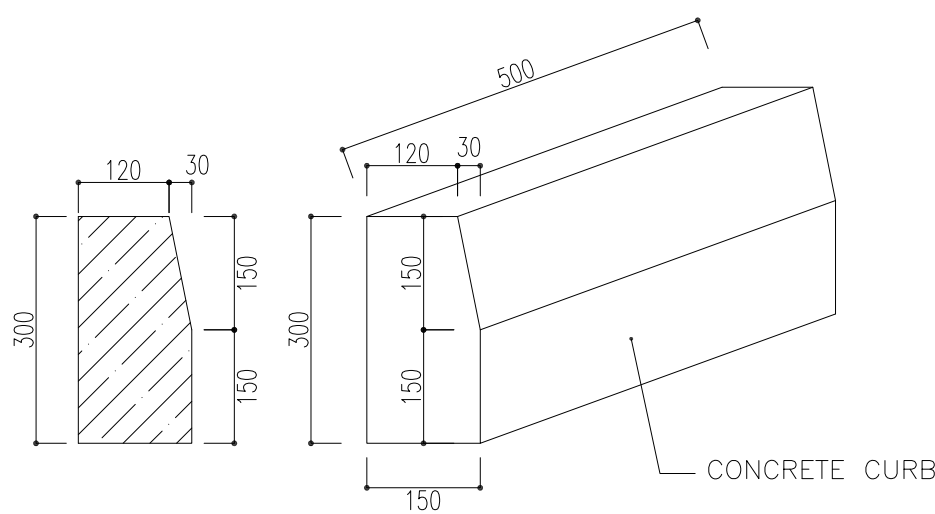






DETAIL 11

Sc:1/10

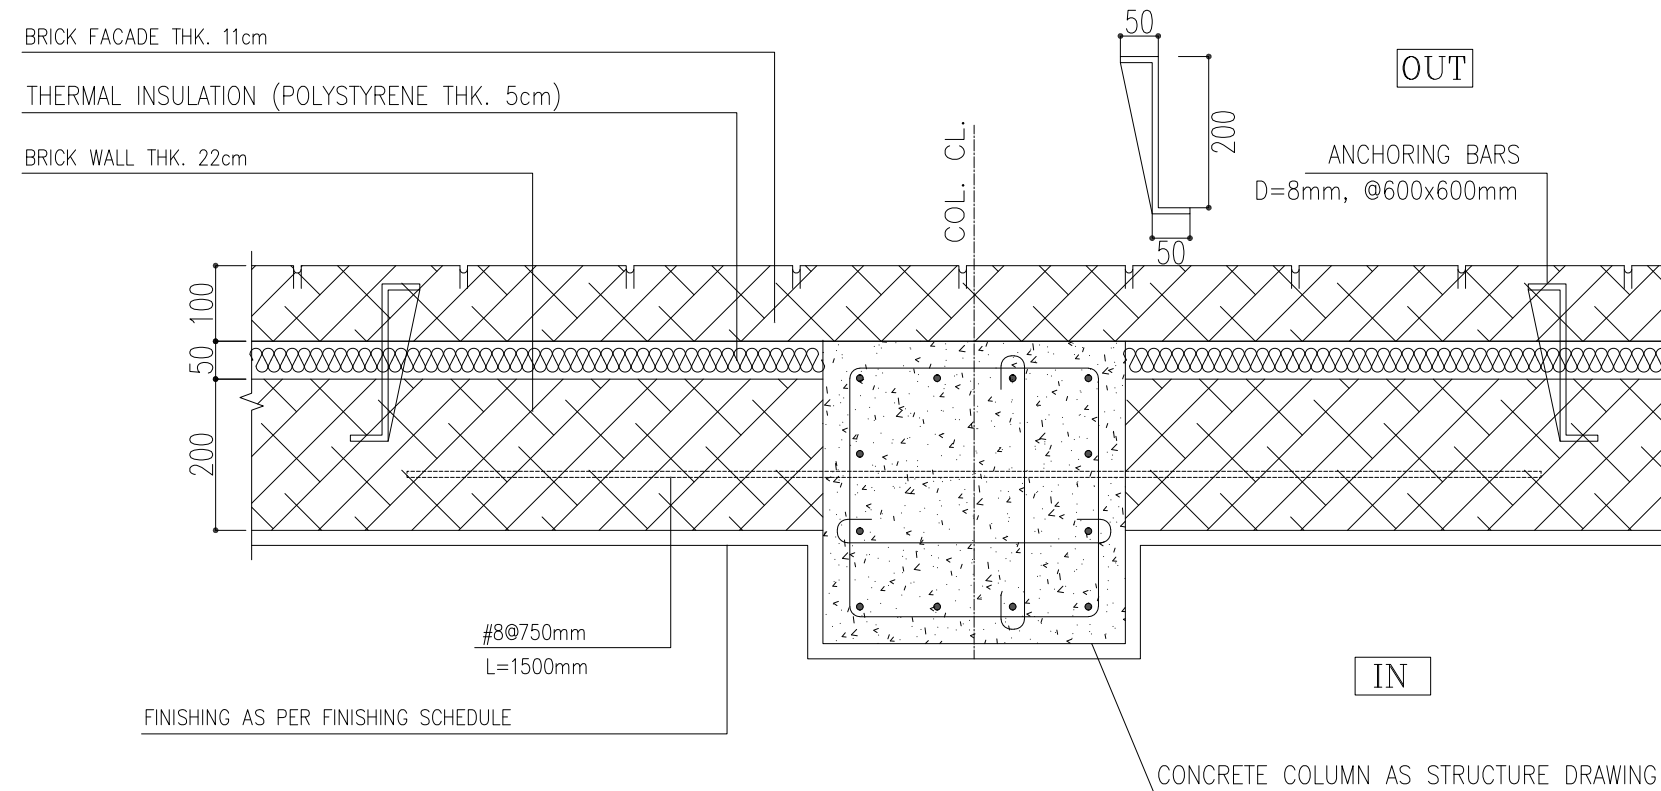

DETAIL 12

 
Sc:1/10

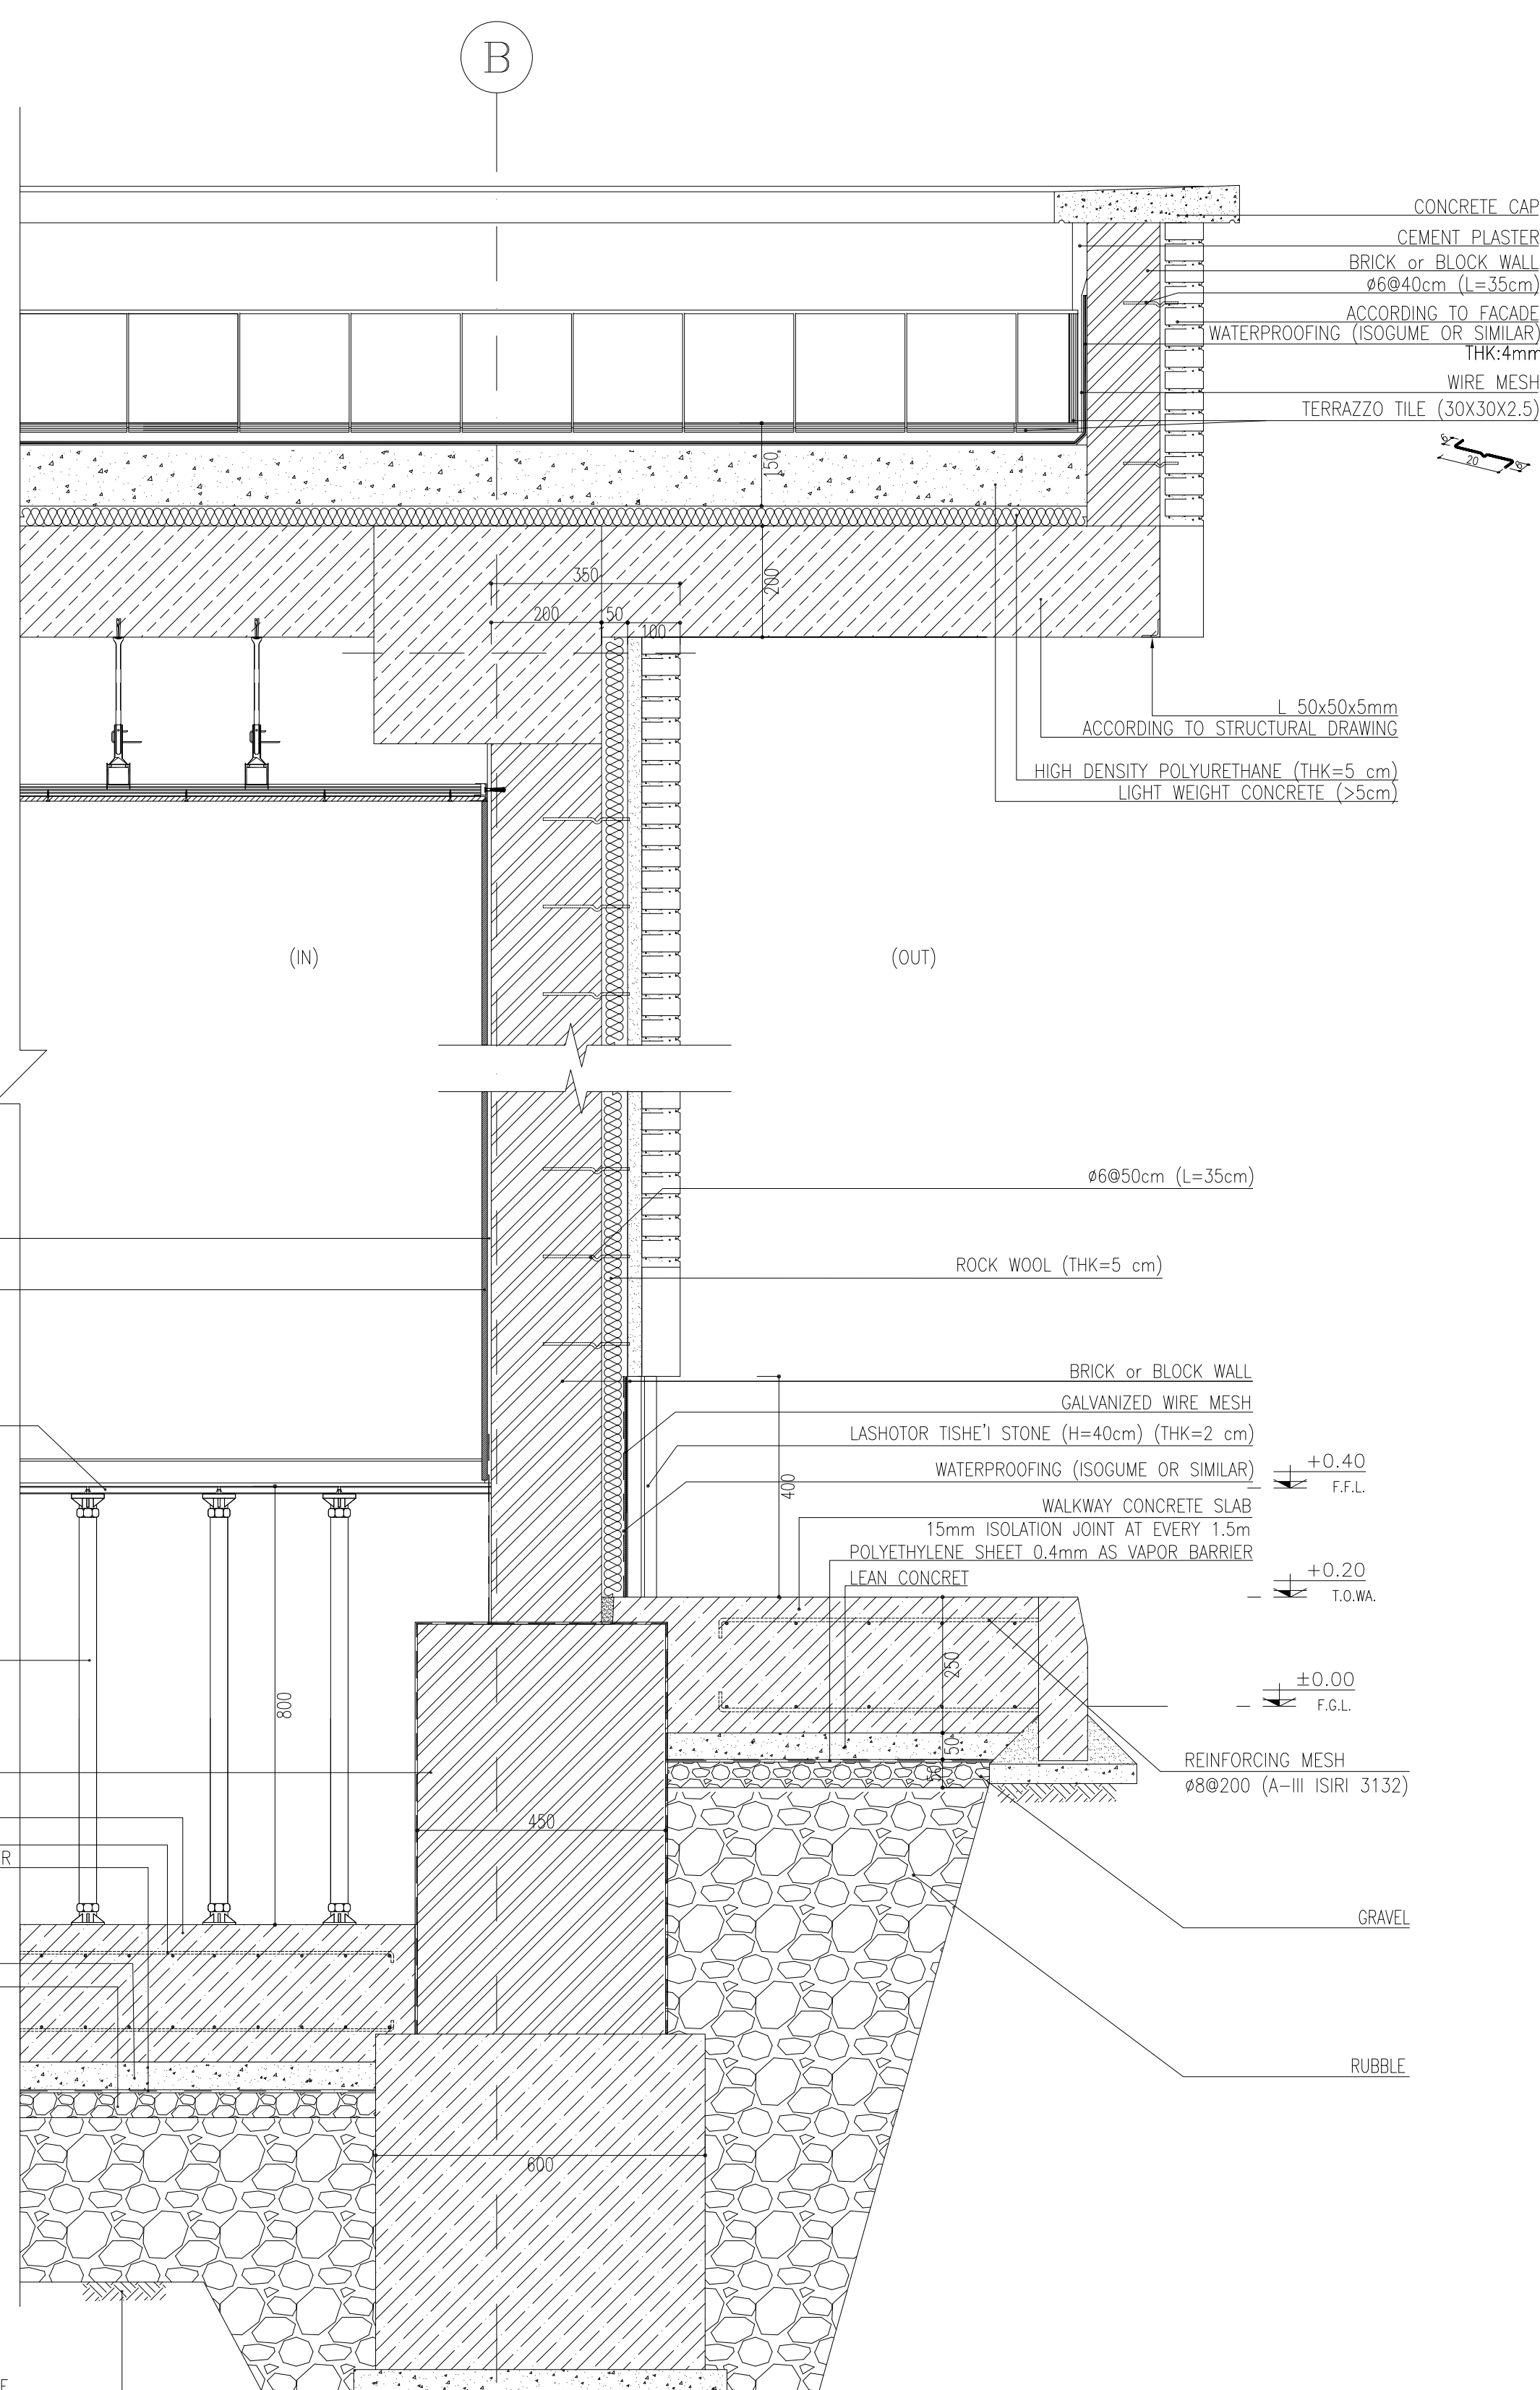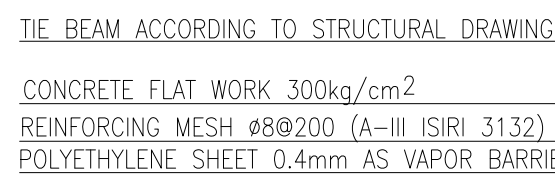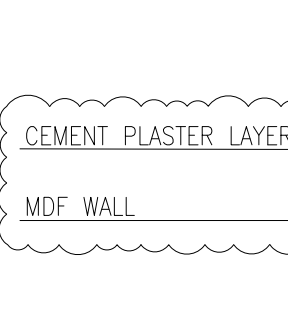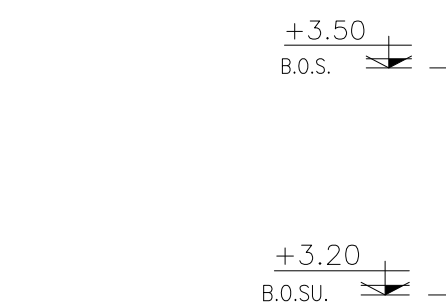

D04	SEP.2023	APC	R.BERLOUVE	M.PAKHARIAN	A.M.MOHSSENI	***
D03	AUG.2023	IFA	R.BERLOUVE	M.PAKHARIAN	A.M.MOHSSENI	***
D02	MAY.2023	IFA	R.BERLOUVE	M.PAKHARIAN	M.MEHRSHAD	***
D01	OCT.2022	IFA	R.BERLOUVE	M.PAKHARIAN	M.MEHRSHAD	***
D00	JUN.2022	IFC	R.BERLOUVE	M.PAKHARIAN	M.MEHRSHAD	***
REV.	DATE	P.O.I.S	PREP.	CHK.	APP.	AUT.

PROJECT NAME:	BINAK OILFIELD DEVELOPMENT/SURFACE FACILITIES GAS COMPRESSOR STATION
---------------	---

PROJECT NO.:	971020
--------------	--------

 EPC CONTRACTOR:   HIRGAN ENERGY – DESIGN & INSPECTION COMPANIES.	EPD/EPC CONTRACTOR (GC):  PETROIRAN DEVELOPMENT COMPANY
--	---

DRAWING TITLE:	Architectural Drawing For CCTV Control Room– Binak GCS WALL SECTION AND DETAILS
----------------	--

SCALE	SIZE	DRAWING NO.	SHEET NO.	REV
AS SHOWN	A1	BK-GCS-PEDCO-120-AR-DW-0008	06 OF 11	D04

NOTES

1. ALL DIMENSIONS ARE IN MILLIMETER & ALL ELEVATIONS ARE IN METER.
2. ALL DIMENSIONS AND ELEVATIONS SHALL BE CHECKED BY THE CONTRACTOR PRIOR TO CONSTRUCTION.
3. CONTRACTOR SHALL COMPILE ALL ARCHITECTURAL, MECHANICAL, ELECTRICAL, PIPING AND STRUCTURAL DRAWINGS AND IN CASE OF ANY CONFLICTS OR DISCREPANCY, INFORM THE ENGINEER.
4. ALL MATERIALS ARE SELECTED FROM THE HIGHEST QUALITY AND MUST BE APPROVED BY THE CLIENT.
5. ALL OPENINGS FOR PIPING/CABLING AND HVAC OPENINGS SHALL BE CONSIDERED AS PER RELATED DRAWINGS BEFORE CONSTRUCTION.
6. FINISH GRADE LEVEL (F.G.L.) = +11.20 (M.S.L.) $\pm$ 0.00 (LOCAL)

LEGEND	
F.F.L.	FINISHED FLOOR LEVEL
T.O.W.A.	TOP OF WALKWAY
T.O.P.	TOP OF PARAPET
T.O.S.	TOP OF SLAB
T.O.D.	TOP OF DOOR
T.O.W.	TOP OF WINDOW
B.O.W.	BOTTOM OF WINDOW
T.O.C.	TOP OF CAGE
B.O.C.	BOTTOM OF CAGE
B.O.F.	BOTTOM OF FALSE FLOOR
B.O.S.U.	BOTTOM OF SUSPENDED
B.O.S.	BOTTOM OF SLEEVE
F.G.L.	FINISH GROUND LEVEL

	BRICK WORK		BRICK FACING
	REINFORCED CONCRETE		
	LEAN CONCRETE		
	BLOCKAGE		
	GRAVEL		
	GYPSUM BOARD		
	PVC SUSPENDED CEILING		
	FALSE FLOOR		

REFERENCE DRAWING	DRG. No.
STANDARD DRAWING FOR ARCHITECTURAL DETAILS	BK-GNRL-PEDCO-000-AR-DW-0001
SITE SEWAGEAGE SYSTEM LAYOUT & DETAILS	BK-GCS-PEDCO-120-CV-PY-0001
CABLE TRENCH AND DUCT BANK LAYOUT	BK-GCS-PEDCO-120-CV-PY-0002
ROAD, PAVING AND PLANT FINISH GRADING LAYOUT & SECTIONS	BK-GCS-PEDCO-120-CV-PY-0005
ELECTRICAL CABLE ROUTE & SECTION LAYOUT FOR BUILDING & SHELTER	BK-GCS-PEDCO-120-EL-PY-0006
FOUNDATION DRAWING FOR CCTV CONTROL ROOM - BINAK GCS	BK-GCS-PEDCO-120-ST-DW-0075
STRUCTURAL DRAWING FOR CCTV CONTROL ROOM - BINAK GCS	BK-GCS-PEDCO-120-ST-DW-0076
STANDARD DETAILS FOR LADDER & SAFETY CAGE	BK-GNRL-PEDCO-000-ST-DW-0009
HVAC SYSTEM LAYOUT AND PLUMBING FOR CCTV CONTROL ROOM	BK-GCS-PEDCO-120-HV-PY-0009
PLUMBING & SEWAGE PIPING LAYOUT FOR CCTV CONTROL ROOM	BK-GCS-PEDCO-120-HV-PY-0013
UNIT PLOT PLAN DRAWING	BK-GCS-PEDCO-120-PI-PY-0001

KEY PLAN

***	*****	** **	*** ****	** **	*** ****
REV.	DESCRIPTION	BY	DATE	BY	DATE
		CHECKED		REV. APPR.	

اصل و کلیه نسخ این نقشه و حق اقتباس متعلق به شرکت ملی مناطق نفت خیز جنوب میباشد.


THE ORIGINAL AND ALL COPIES OF THIS DRAWING TOGETHER WITH
THE COPYRIGHT THEREIN ARE THE SOLE PROPERTY OF
N.I.S.O.C./ FIELDS

	BINAK OILFIELD DEVELOPMENT SURFACE FACILITIES GAS COMPRESSOR STATION
--	---


DATE	SCALE	DRAWING BY	CHECKED BY	PROJECT ENG.

NO CONSTRUCTION PERMITTED UNLESS DRAWING APPROVED			
APPROVED FOR CONSTRUCTION		BY:	DATE:


BUDGET REF.	LOCATION	SIZE	CLASS	SERIAL NO.	SHEET	REVISION
053-073-9184	F	4	B	709396	06 OF 11	D04

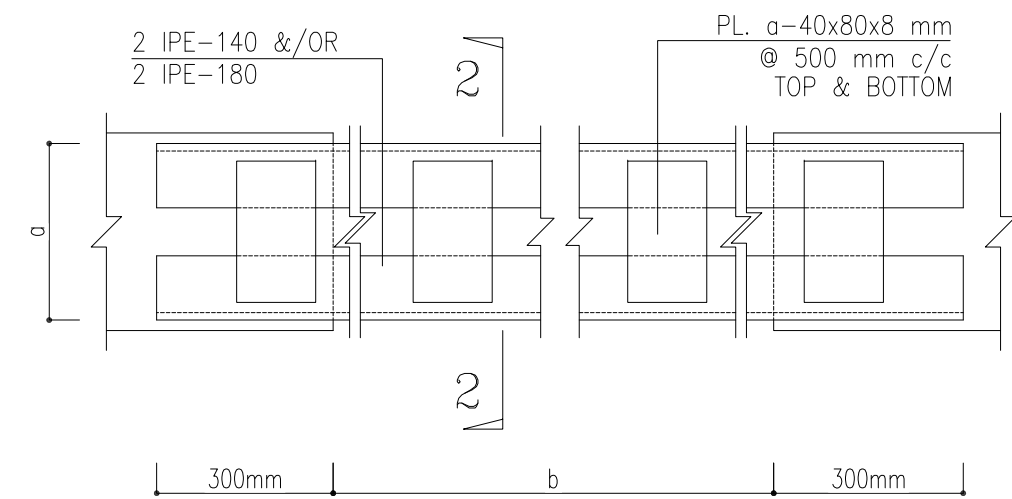

LINTEL PLAN -2 IPE
Sc: N.T.S.

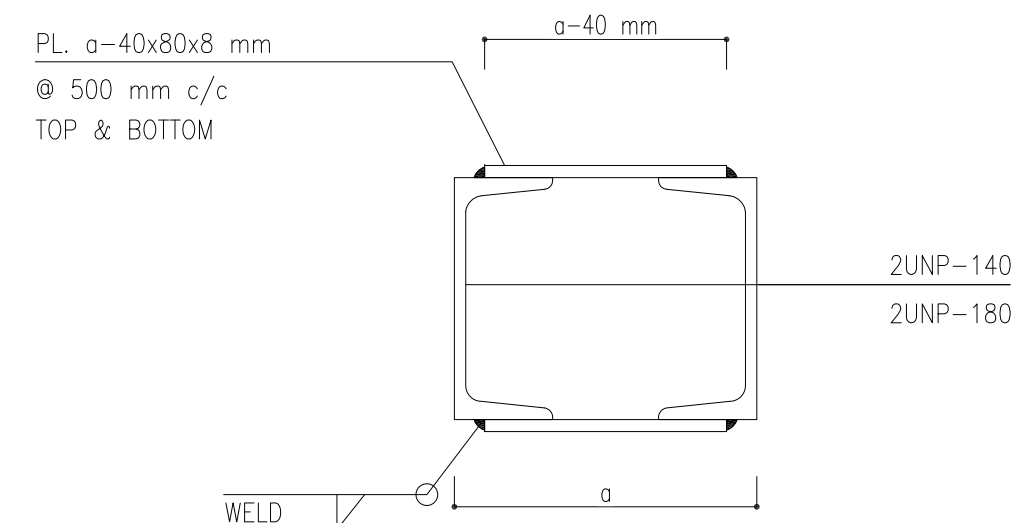

TYP. SECTION 2-2
Sc: 1:10

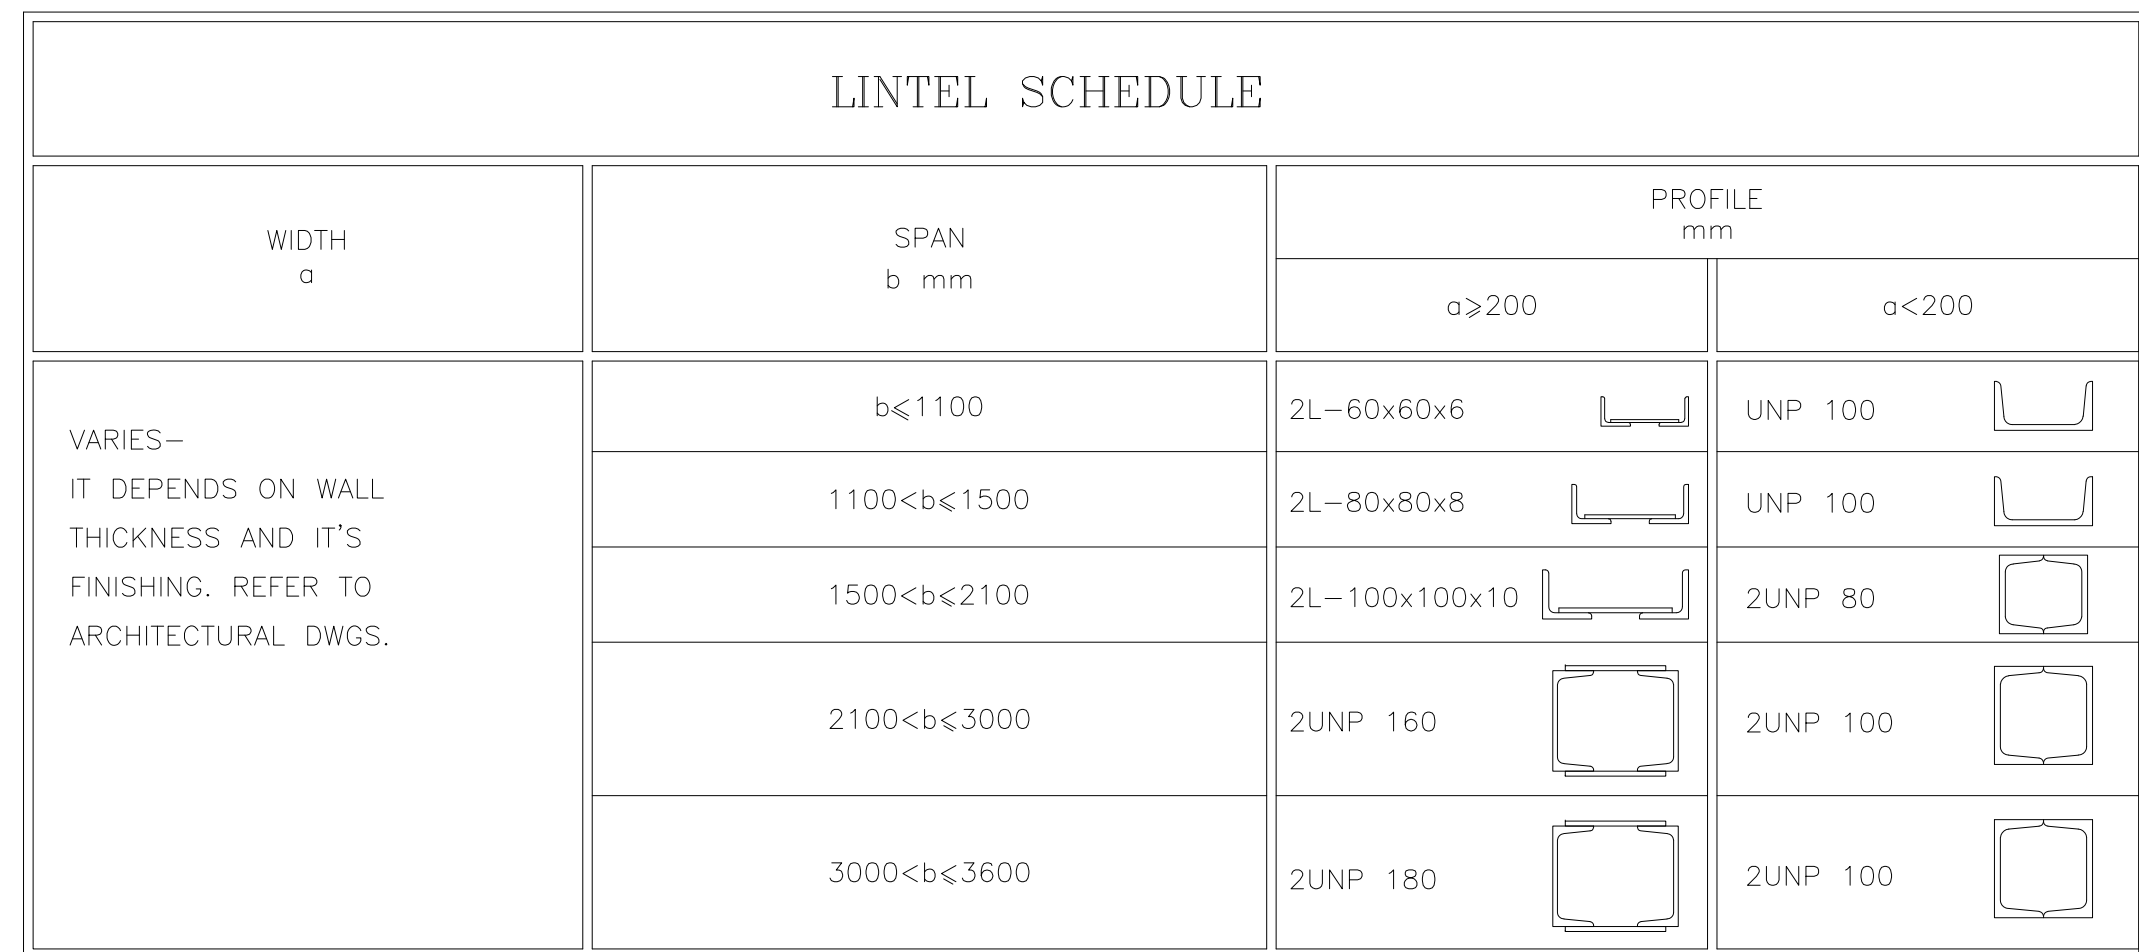

D04	SEP.2023	APC	R.BERLOUVE	M.PAKHARIAN	A.M.MOHSSENI	***
D03	AUG.2023	IFA	R.BERLOUVE	M.PAKHARIAN	A.M.MOHSSENI	***
D02	MAY.2023	IFA	R.BERLOUVE	M.PAKHARIAN	M.MEHRSHAD	***
D01	OCT.2022	IFA	R.BERLOUVE	M.PAKHARIAN	M.MEHRSHAD	***
D00	JUN.2022	IFC	R.BERLOUVE	M.PAKHARIAN	M.MEHRSHAD	***
REV.	DATE	P.O.I.S	PREP.	CHK.	APP.	AUT.

NOTES

1. ALL DIMENSIONS ARE IN MILLIMETER & ALL ELEVATIONS ARE IN METER.
2. ALL DIMENSIONS AND ELEVATIONS SHALL BE CHECKED BY THE CONTRACTOR PRIOR TO CONSTRUCTION.
3. CONTRACTOR SHALL COMPILE ALL ARCHITECTURAL, MECHANICAL, ELECTRICAL, PIPING AND STRUCTURAL DRAWINGS AND IN CASE OF ANY CONFLICTS OR DISCREPANCY, INFORM THE ENGINEER.
4. ALL MATERIALS ARE SELECTED FROM THE HIGHEST QUALITY AND MUST BE APPROVED BY THE CLIENT.
5. ALL OPENINGS FOR PIPING/CABLING AND HVAC OPENINGS SHALL BE CONSIDERED AS PER RELATED DRAWINGS BEFORE CONSTRUCTION.
6. FINISH GRAVEL LEVEL (F.G.L.) : +112.0 (M.S.L) = +0.00 (LOCAL)

LEGEND	
F.F.L.	FINISHED FLOOR LEVEL
T.O.WA.	TOP OF WALKWAY
T.O.P.	TOP OF PARAPET
T.O.S.	TOP OF SLAB
T.O.D.	TOP OF DOOR
T.O.W.	TOP OF WINDOW
B.O.W.	BOTTOM OF WINDOW
T.O.C.	TOP OF CAGE
B.O.C.	BOTTOM OF CAGE
B.O.F.	BOTTOM OF FALSE FLOOR
B.O.SU.	BOTTOM OF SUSPENDED
B.O.S.	BOTTOM OF SLEEVE
F.G.L.	FINISH GROUND LEVEL

	BRICK WORK		BRICK FACING
	REINFORCED CONCRETE		
	LEAN CONCRETE		
	BLOCKAGE		
	GRAVEL		
	GYPSUM BOARD		
	PVC SUSPENDED CEILING		
	FALSE FLOOR		

REFERENCE DRAWING	DRG. No.
STANDARD DRAWING FOR ARCHITECTURAL DETAILS	BK-GNRL-PEDCO-000-AR-DW-0001
SITE SEWAGE SYSTEM LAYOUT & DETAILS	BK-GCS-PEDCO-120-CV-PY-0001
CABLE TRENCH AND DUCT BANK LAYOUT	BK-GCS-PEDCO-120-ST-PY-0002
ROAD, PAVING AND PLANT FINISH GRADING LAYOUT & SECTIONS	BK-GCS-PEDCO-120-CV-PY-0005
ELECTRICAL CABLE ROUTE & SECTION LAYOUT FOR BUILDING & SHEETER	BK-GCS-PEDCO-120-EL-PY-0006
FOUNDATION DRAWING FOR CCTV CONTROL ROOM - BINAK GCS	BK-GCS-PEDCO-120-ST-DW-0075
STRUCTURAL DRAWING FOR CCTV CONTROL ROOM - BINAK GCS	BK-GCS-PEDCO-120-ST-DW-0076
STANDARD DETAILS FOR LADDER & SAFETY CAGE	BK-GNRL-PEDCO-000-ST-DW-0009
HVAC SYSTEM LAYOUT AND PLUMBING FOR CCTV CONTROL ROOM	BK-GCS-PEDCO-120-HV-PY-0009
PLUMBING & SEWAGE PIPING LAYOUT FOR CCTV CONTROL ROOM	BK-GCS-PEDCO-120-HV-PY-0013
UNIT PLOT PLAN DRAWING	BK-GCS-PEDCO-120-PI-PY-0001



KEY PLAN

***	*****	** **	*** ****	** **	*** ****
REV.	DESCRIPTION	BY	DATE	BY	DATE
		CHECKED		REV. APPR.	

REV.	DATE	P.O.I.S	PREP.	CHK.	APP.	AUT.
PROJECT NAME:		BINAK OILFIELD DEVELOPMENT/SURFACE FACILITIES GAS COMPRESSOR STATION				
PROJECT NO.:			971020			
EPC CONTRACTOR:			EPD/EPC CONTRACTOR (GC):			
 HIRGAN ENERGY - DESIGN & INSPECTION COMPANIES			  PETROIRAN DEVELOPMENT COMPANY			
DRAWING TITLE:						
Architectural Drawing for CCTV Control Room – Binak GCS WALL SECTION AND DETAILS						
SCALE	SIZE	DRAWING NO.			SHEET NO.	REV
AS SHOWN	A1	BK-GCS-PEDCO-120-AR-DW-0008			07 OF 11	D04

اصل و کاپیہ نے این نقشہ و حق امتیاز متعلق به شرکت ملی مناطق نفت خیز جنوب می باشد.							
THE ORIGINAL AND ALL COPIES OF THIS DRAWING TOGETHER WITH THE COPYRIGHT THEREIN ARE THE SOLE PROPERTY OF N.I.S.O.C./ FIELDS							
BINAK OILFIELD DEVELOPMENT SURFACE FACILITIES GAS COMPRESSOR STATION							
DATE	SCALE	DRAWING BY	CHECKED BY	PROJECT ENG.			
NO CONSTRUCTION PERMITTED UNLESS DRAWING APPROVED							
APPROVED FOR CONSTRUCTION				BY:	DATE:		
BUDGET REF.	LOCATION	SIZE	CLASS	SERIAL NO.	SHEET	REVISION	
053-073-9184	F	4	B	709396	07 OF 11	D04	

SC.1:10 02 OF 11

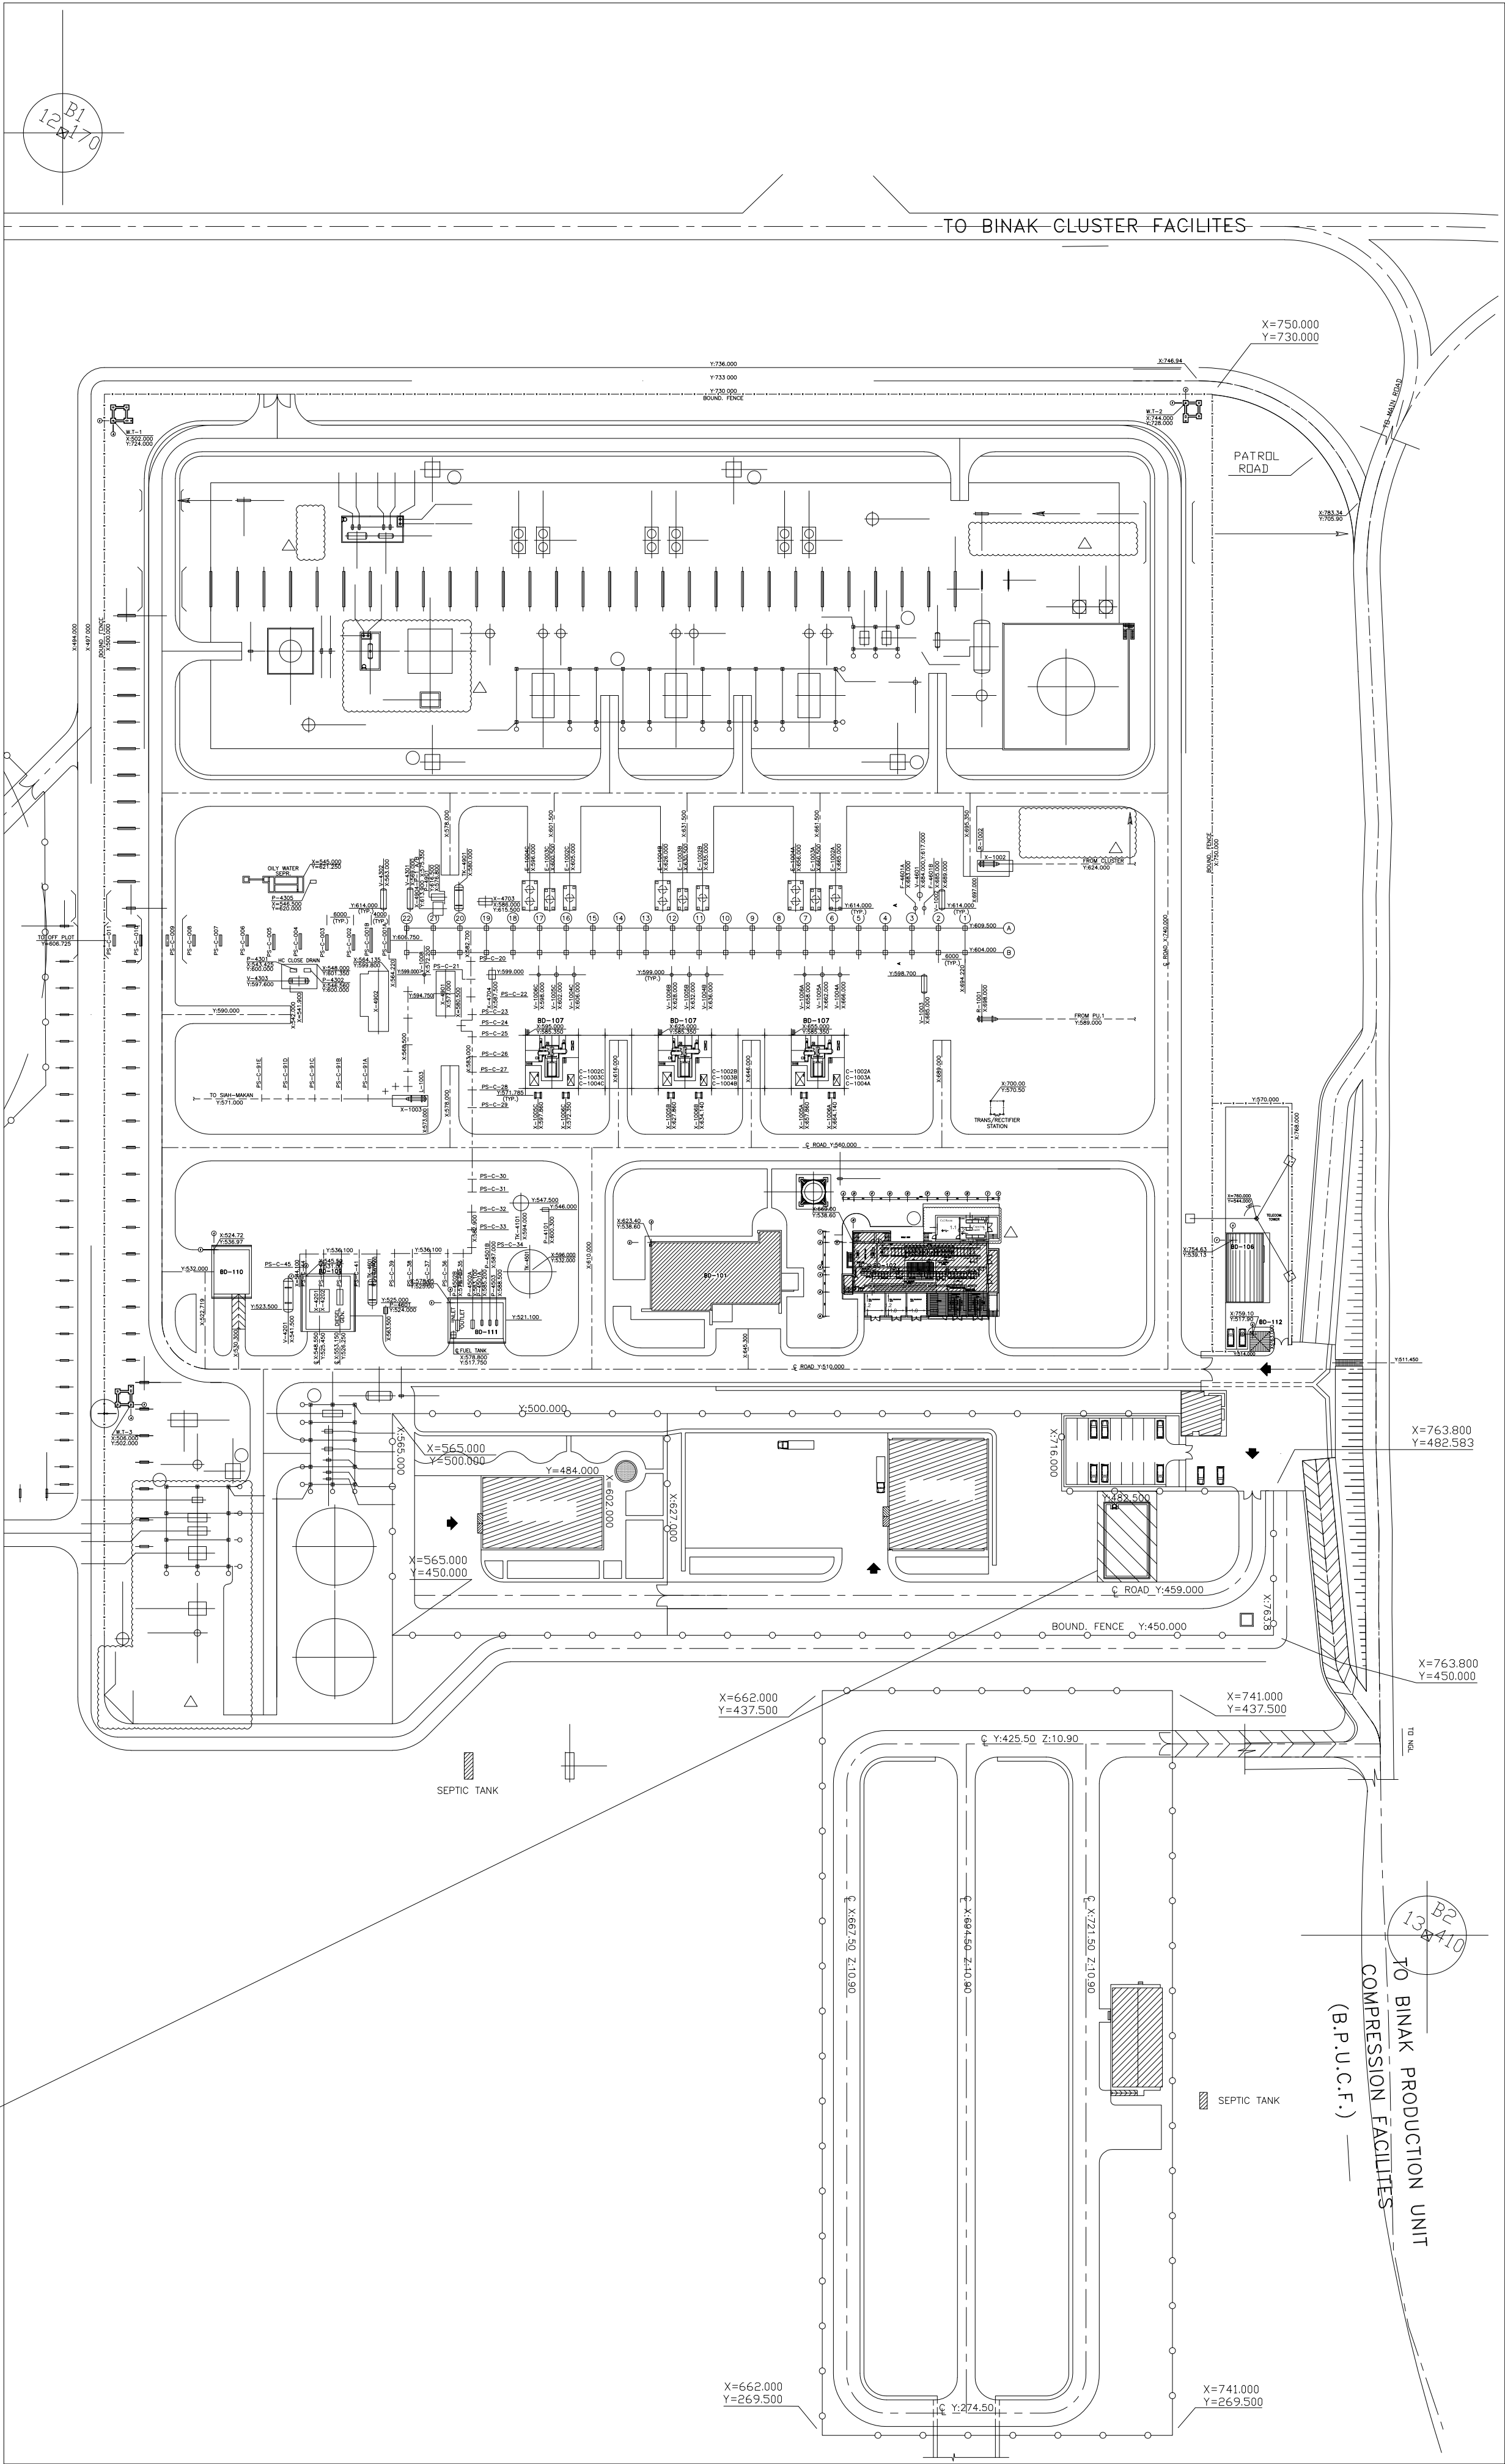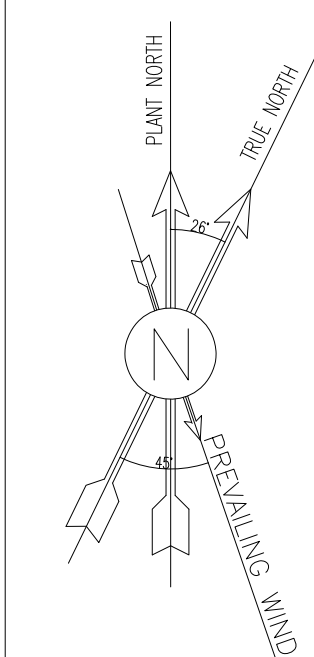

THIS AREA


N.T.S. 1 LOCATION PLAN

- NOTES
1. ALL DIMENSIONS ARE IN MILLIMETER & ALL ELEVATIONS ARE IN METER.
 2. ALL DIMENSIONS AND ELEVATIONS SHALL BE CHECKED BY THE CONTRACTOR PRIOR TO CONSTRUCTION.
 3. CONTRACTOR SHALL COMPARE ALL ARCHITECTURAL, MECHANICAL, ELECTRICAL, PIPING AND STRUCTURAL DRAWINGS AND IN CASE OF ANY CONFLICTS OR DISCREPANCY, INFORM THE ENGINEER.
 4. ALL MATERIALS ARE SELECTED FROM THE HIGHEST QUALITY AND MUST BE APPROVED BY THE CLIENT.
 5. ALL OPENINGS FOR PIPING/CABLING AND HVAC OPENINGS SHALL BE CONSIDERED AS PER RELATED DRAWINGS BEFORE CONSTRUCTION.
 6. FINISH GRADING LEVEL (F.G.L.) : +11.20 (M.S.L.) = ±0.00 (LOCAL)

LEGEND

REFERENCE DRAWING	DRG. No.
STANDARD DRAWING FOR ARCHITECTURAL DETAILS	BK-GNRL-PEDCO-000-AR-DW-0001
SITE SEWAGE SYSTEM LAYOUT & DETAILS	BK-GCS-PEDCO-120-CV-PY-0001
CABLE TRENCH AND DUCT BANK LAYOUT	BK-GCS-PEDCO-120-CV-PY-0002
ROAD, PAVING AND PLANT FINISH GRADING LAYOUT & SECTIONS	BK-GCS-PEDCO-120-CV-PY-0005
ELECTRICAL CABLE ROUTE & SECTION LAYOUT FOR BUILDING & SHELTER	BK-GCS-PEDCO-120-EL-PY-0006
FOUNDATION DRAWING FOR CCTV CONTROL ROOM - BINAK GCS	BK-GCS-PEDCO-120-ST-DW-0075
STRUCTURAL DRAWING FOR CCTV CONTROL ROOM - BINAK GCS	BK-GCS-PEDCO-120-ST-DW-0076
STANDARD DETAILS FOR LADDER & SAFETY CAGE	BK-GNRL-PEDCO-000-ST-DW-0009
HVAC SYSTEM LAYOUT AND PLUMBING FOR CCTV CONTROL ROOM	BK-GCS-PEDCO-120-HV-PY-0009
PLUMBING & SEWAGE PIPING LAYOUT FOR CCTV CONTROL ROOM	BK-GCS-PEDCO-120-HV-PY-0013
UNIT PLOT PLAN DRAWING	BK-GCS-PEDCO-120-PI-PY-0001

KEY PLAN

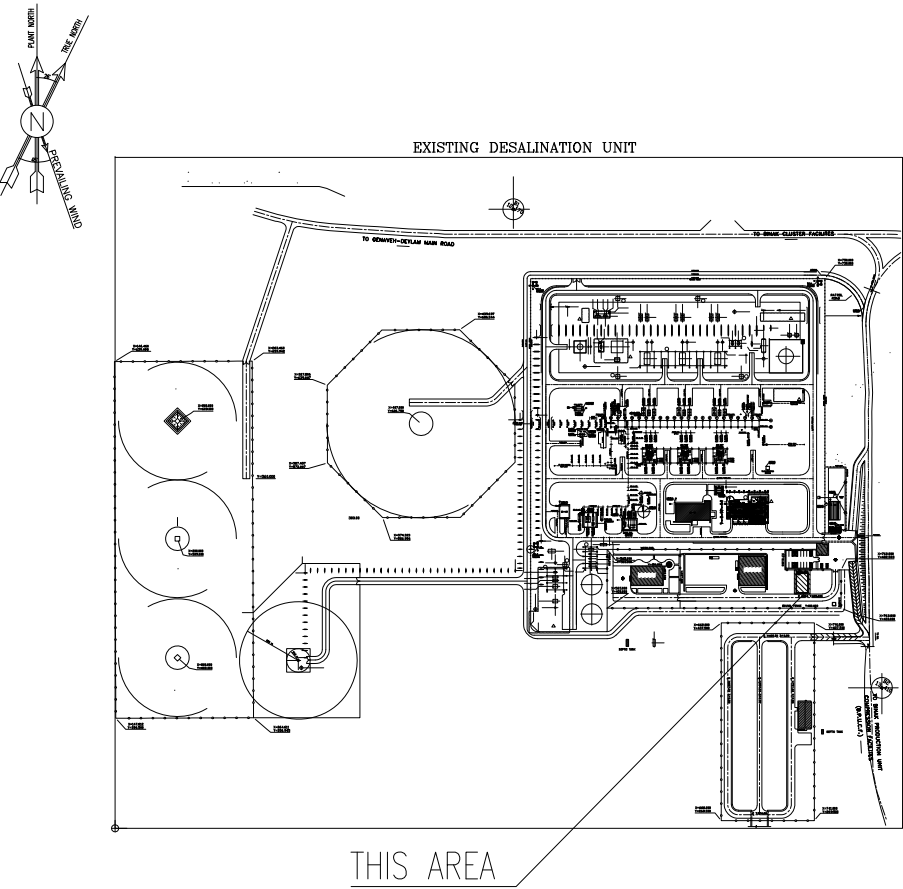

REV.	DATE	DESCRIPTION	BY	DATE	BY	DATE
D04	SEP. 2023	APC	R.BERLOUIE	M.PAKHARIAN	A.M.MOHSSENI	***
D03	AUG. 2023	IPA	R.BERLOUIE	M.PAKHARIAN	A.M.MOHSSENI	***
D02	MAY. 2023	IPA	R.BERLOUIE	M.PAKHARIAN	M.MEHRSHAD	***
D01	OCT. 2022	IPA	R.BERLOUIE	M.PAKHARIAN	M.MEHRSHAD	***
D00	JUN. 2022	IPC	R.BERLOUIE	M.PAKHARIAN	M.MEHRSHAD	***

PROJECT NAME: BINAK OILFIELD DEVELOPMENT/SURFACE FACILITIES GAS COMPRESSOR STATION

PROJECT NO.: 971020

EPC CONTRACTOR:	EPD/EPC CONTRACTOR (GC):
 HIRGAN ENERGY - DESIGN & INSPECTION COMPANIES	 PETROIRAN DEVELOPMENT COMPANY

DRAWING TITLE: Architectural Drawing For CCTV Control Room- Binak GCS PLAN




SCALE	SIZE	DRAWING NO.	SHEET NO.	REV.
AS SHOWN	A1	BK-GCS-PEDCO-120-AR-DW-0008	01 OF 11	D04

THE ORIGINAL AND ALL COPIES OF THIS DRAWING TOGETHER WITH THE COPYRIGHT THEREIN ARE THE SOLE PROPERTY OF N.I.S.O.C./ FIELDS

DATE	SCALE	DRAWING BY	CHECKED BY	PROJECT ENG.

NO CONSTRUCTION PERMITTED UNLESS DRAWING APPROVED				
APPROVED FOR CONSTRUCTION			BY:	DATE:
BUDGET REP.	LOCATION	SIZE CLASS	SERIAL NO.	SHEET REVISION

053-073-9184	F	4	B	709396	01 OF 11	D04
--------------	---	---	---	--------	----------	-----

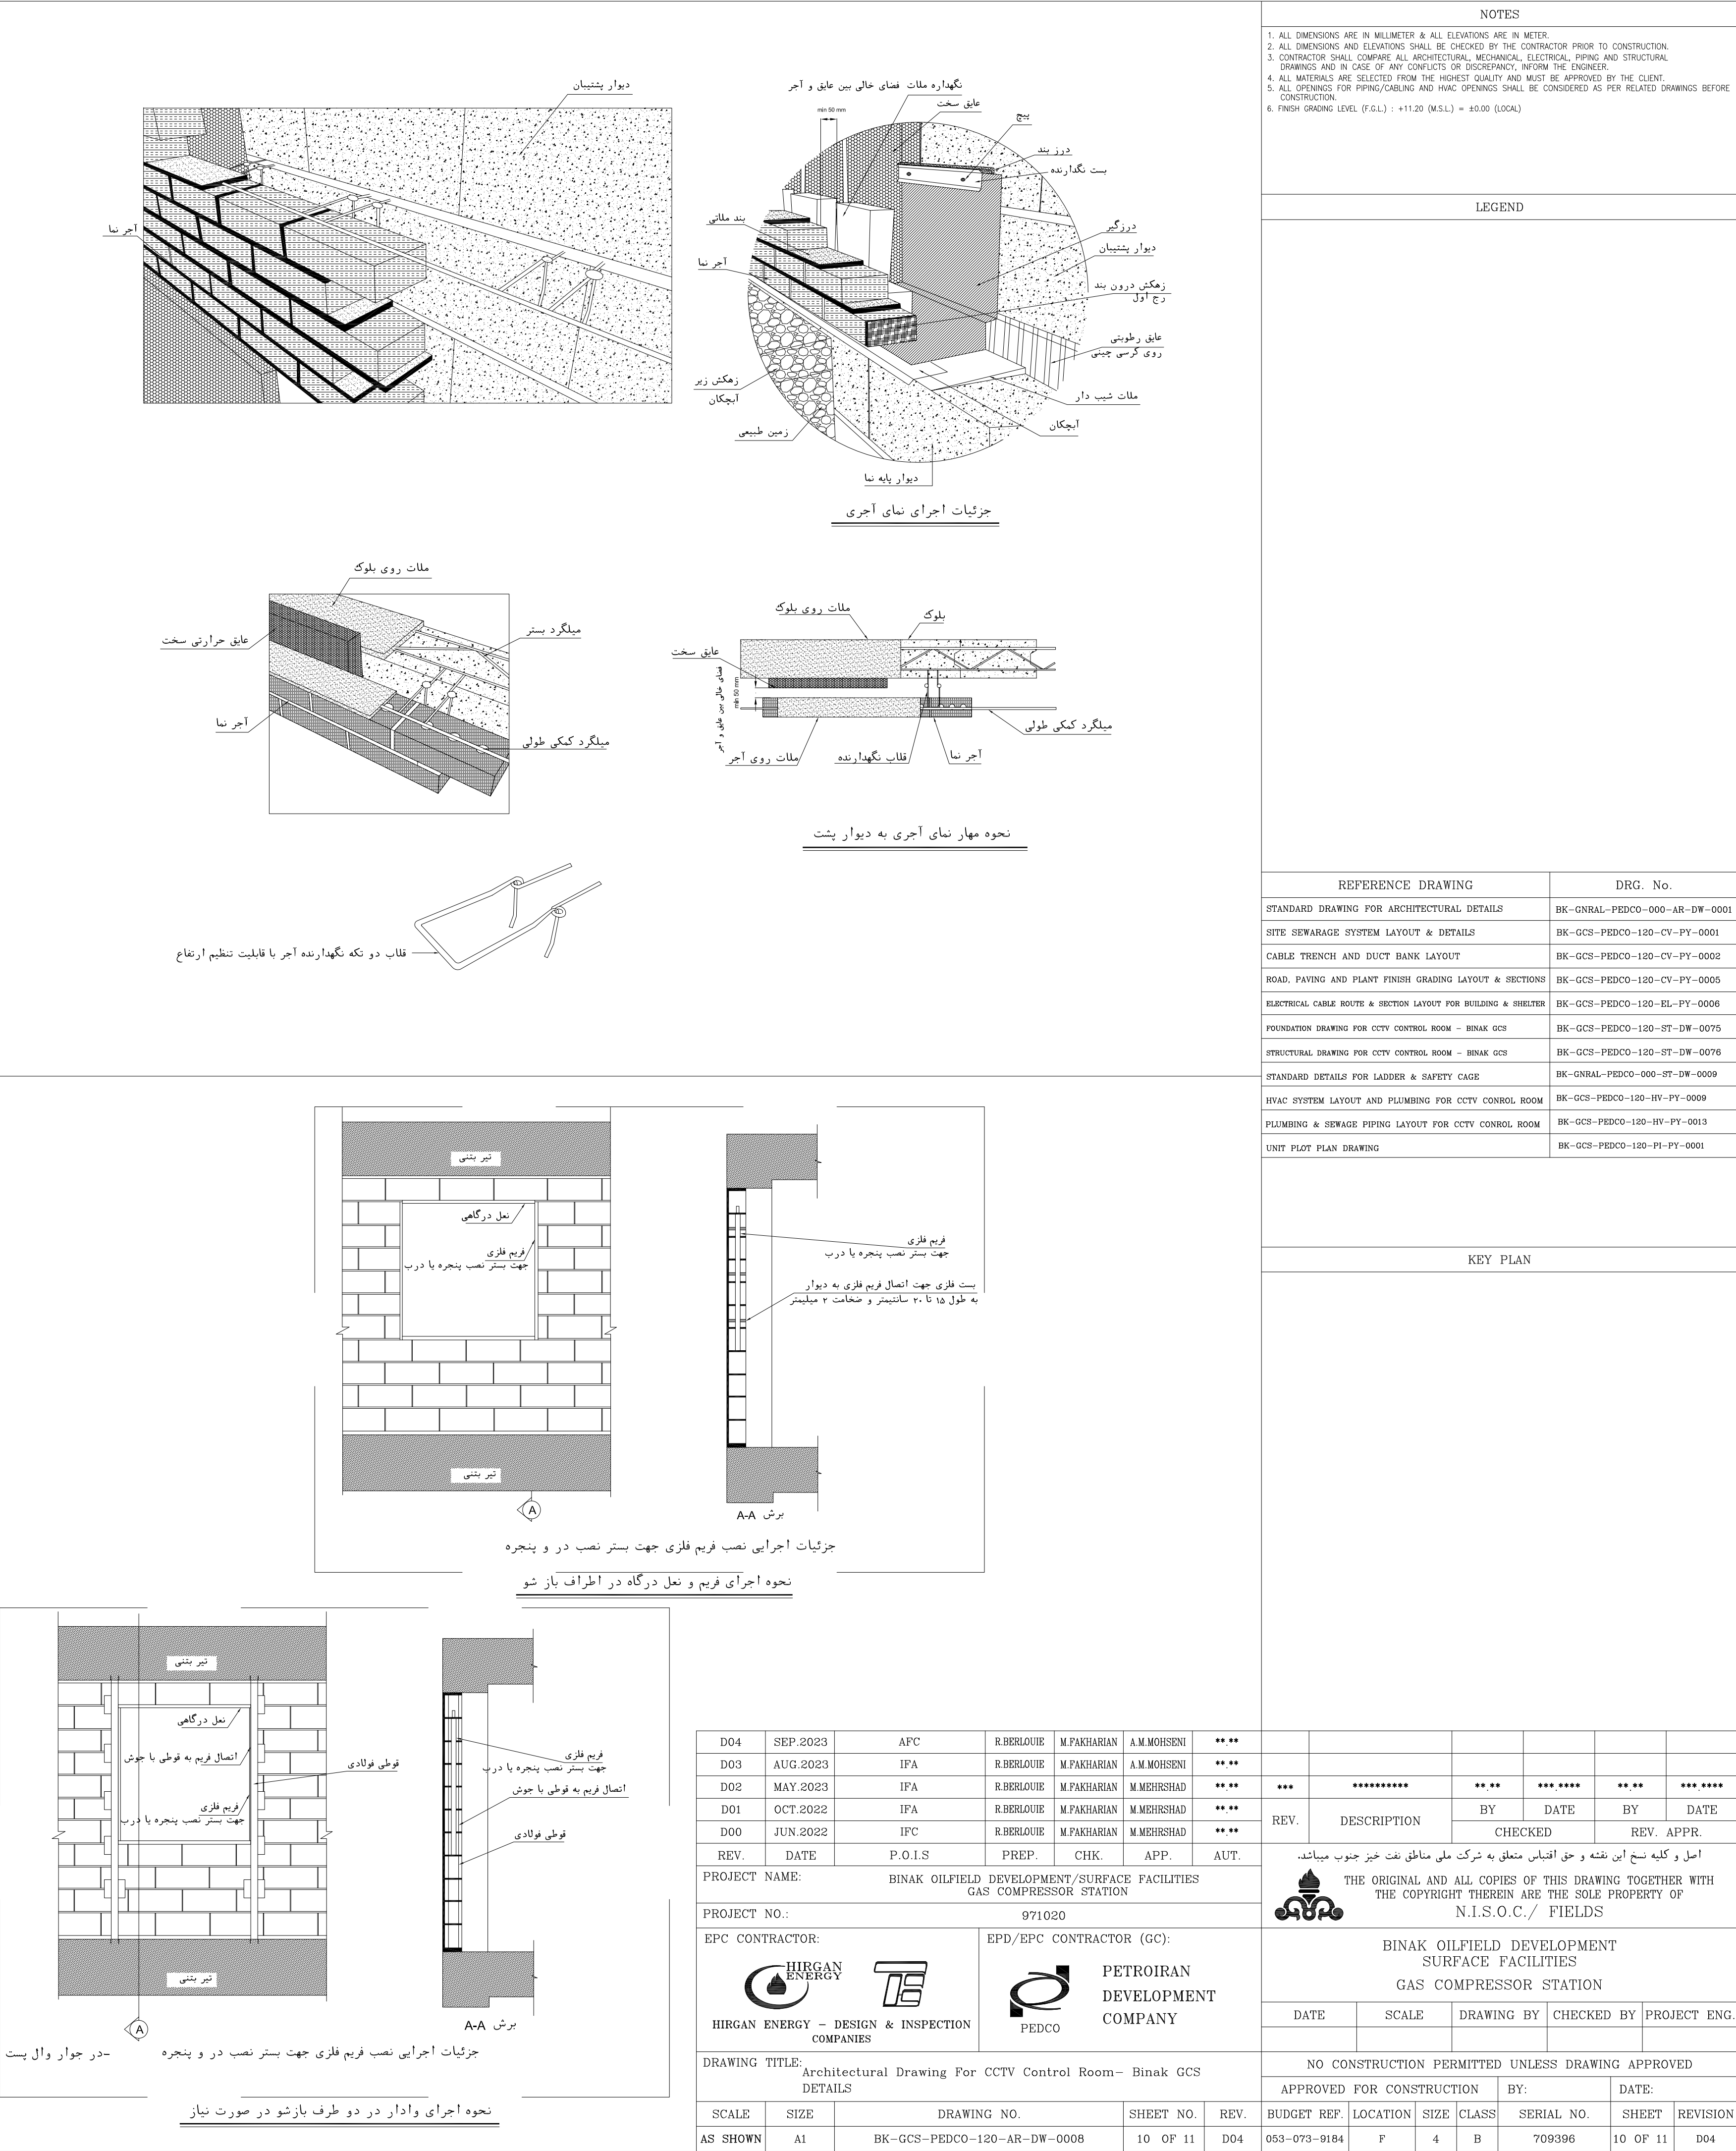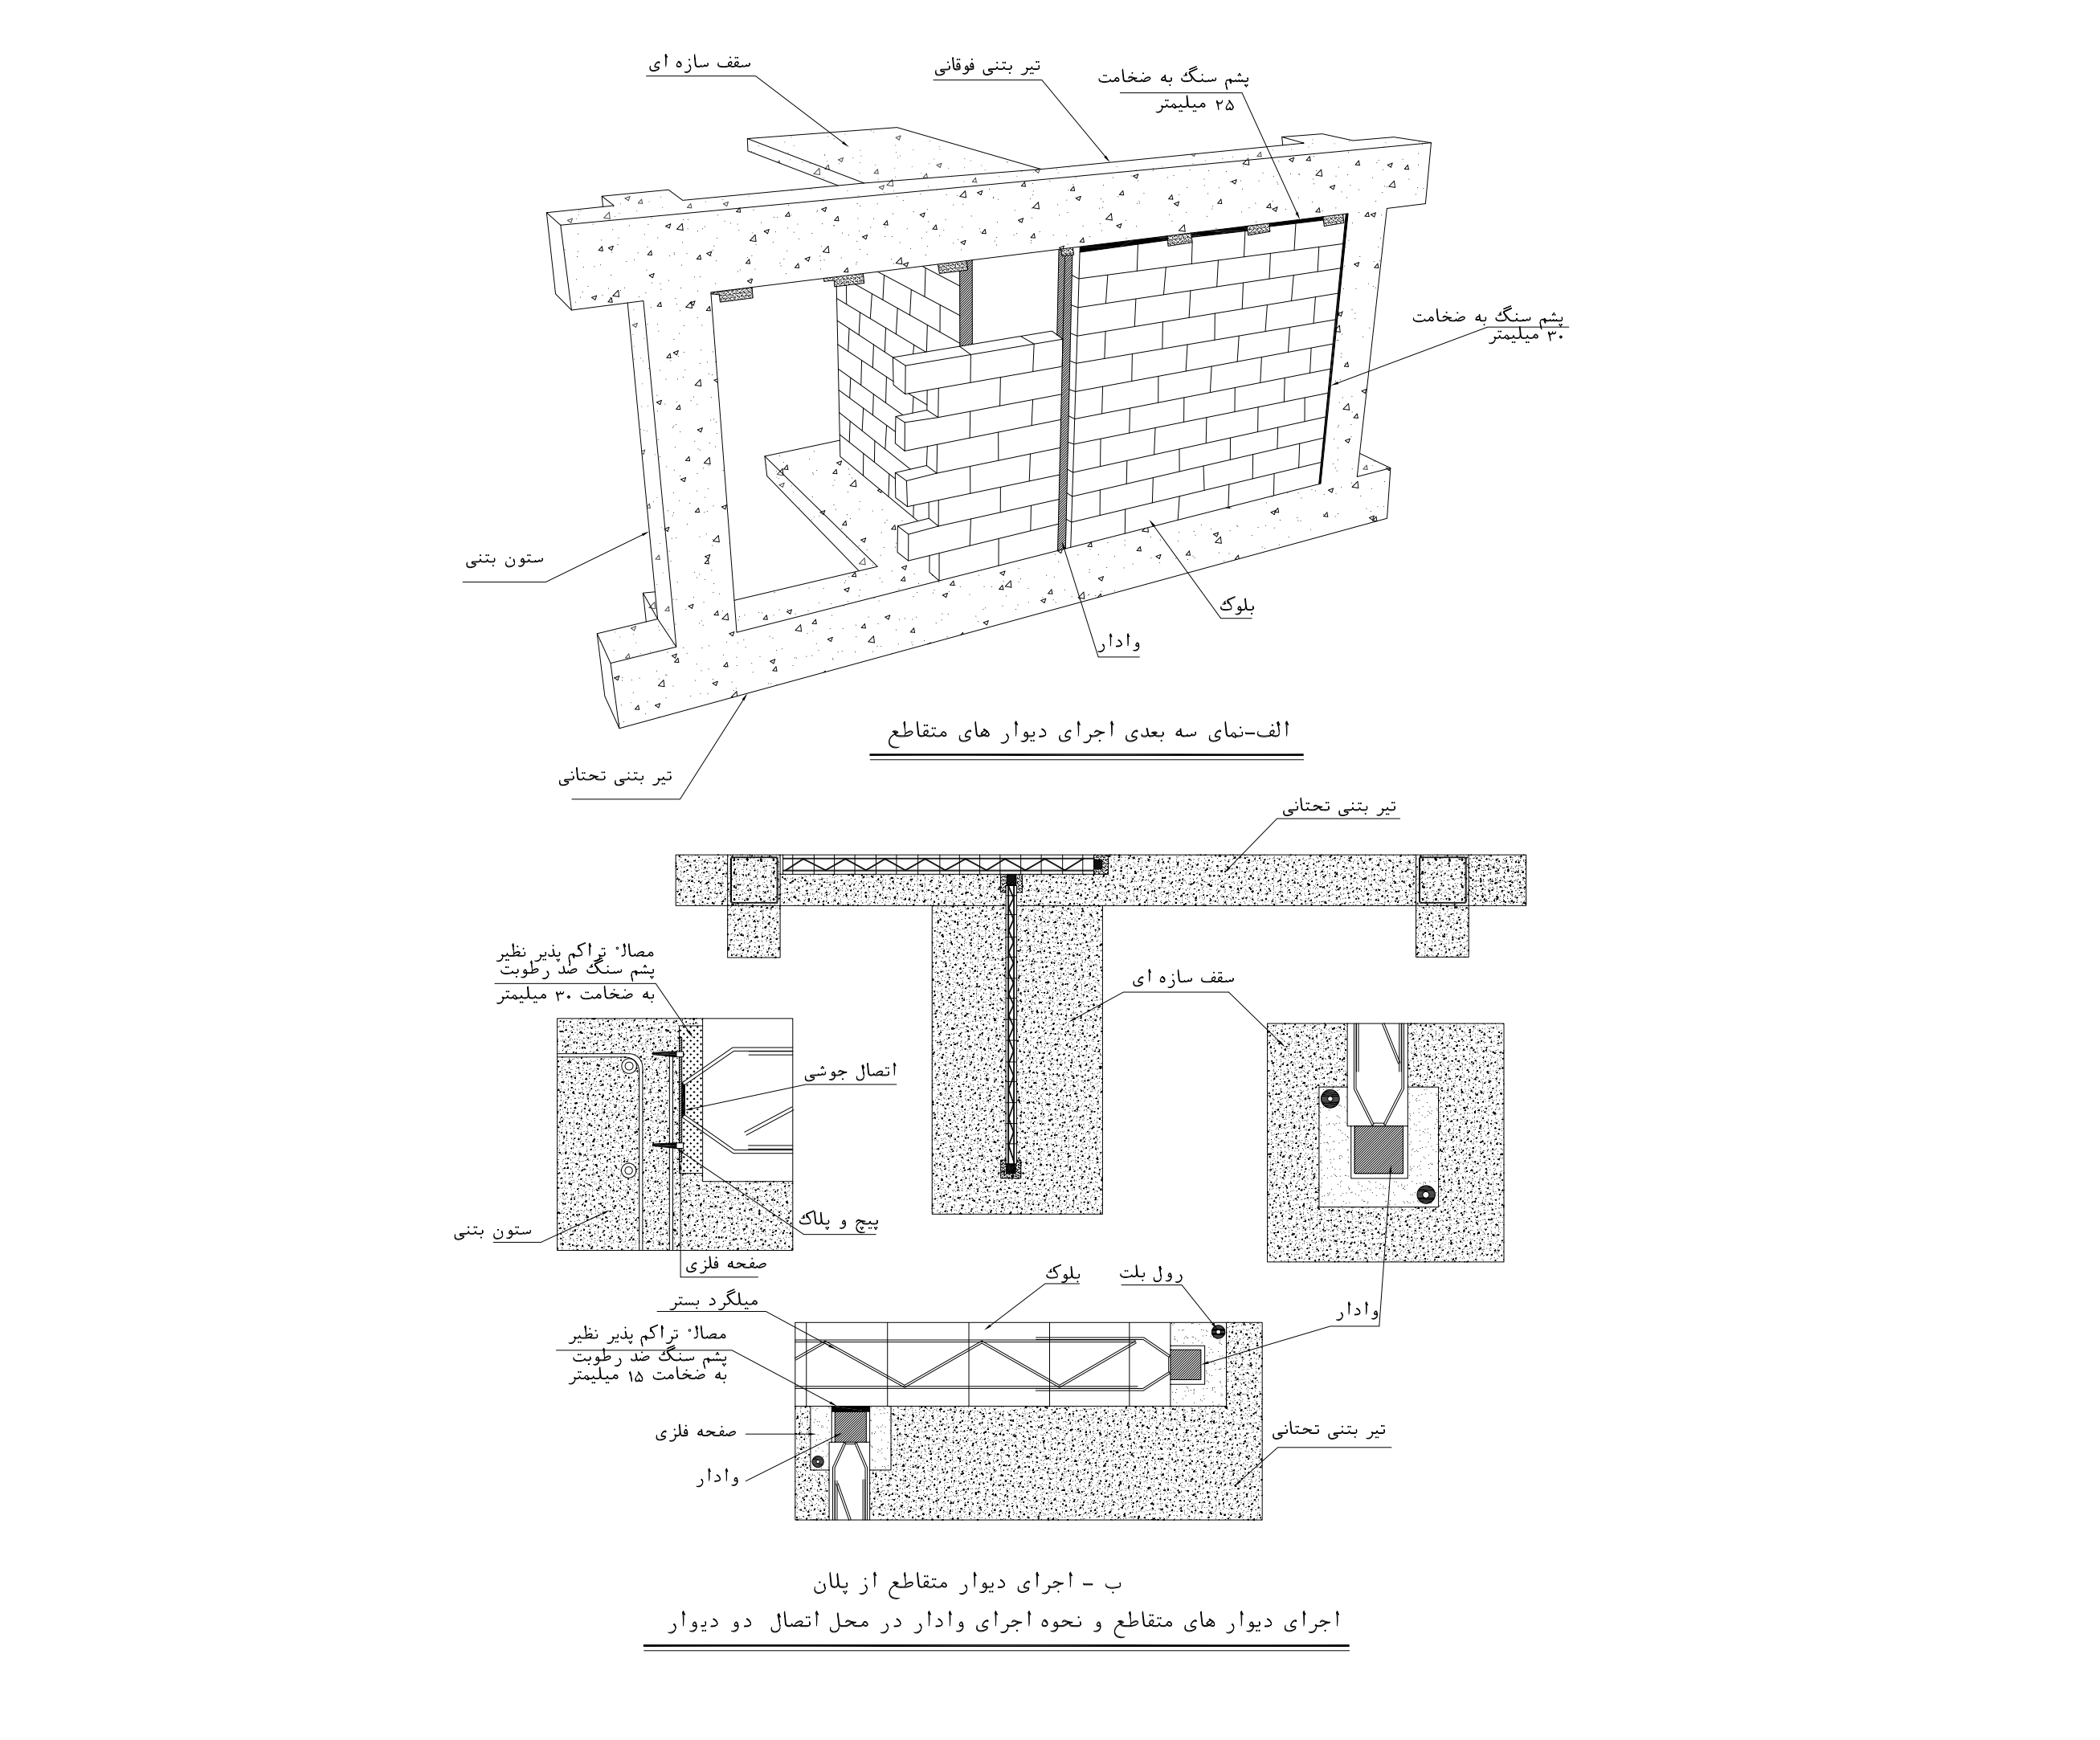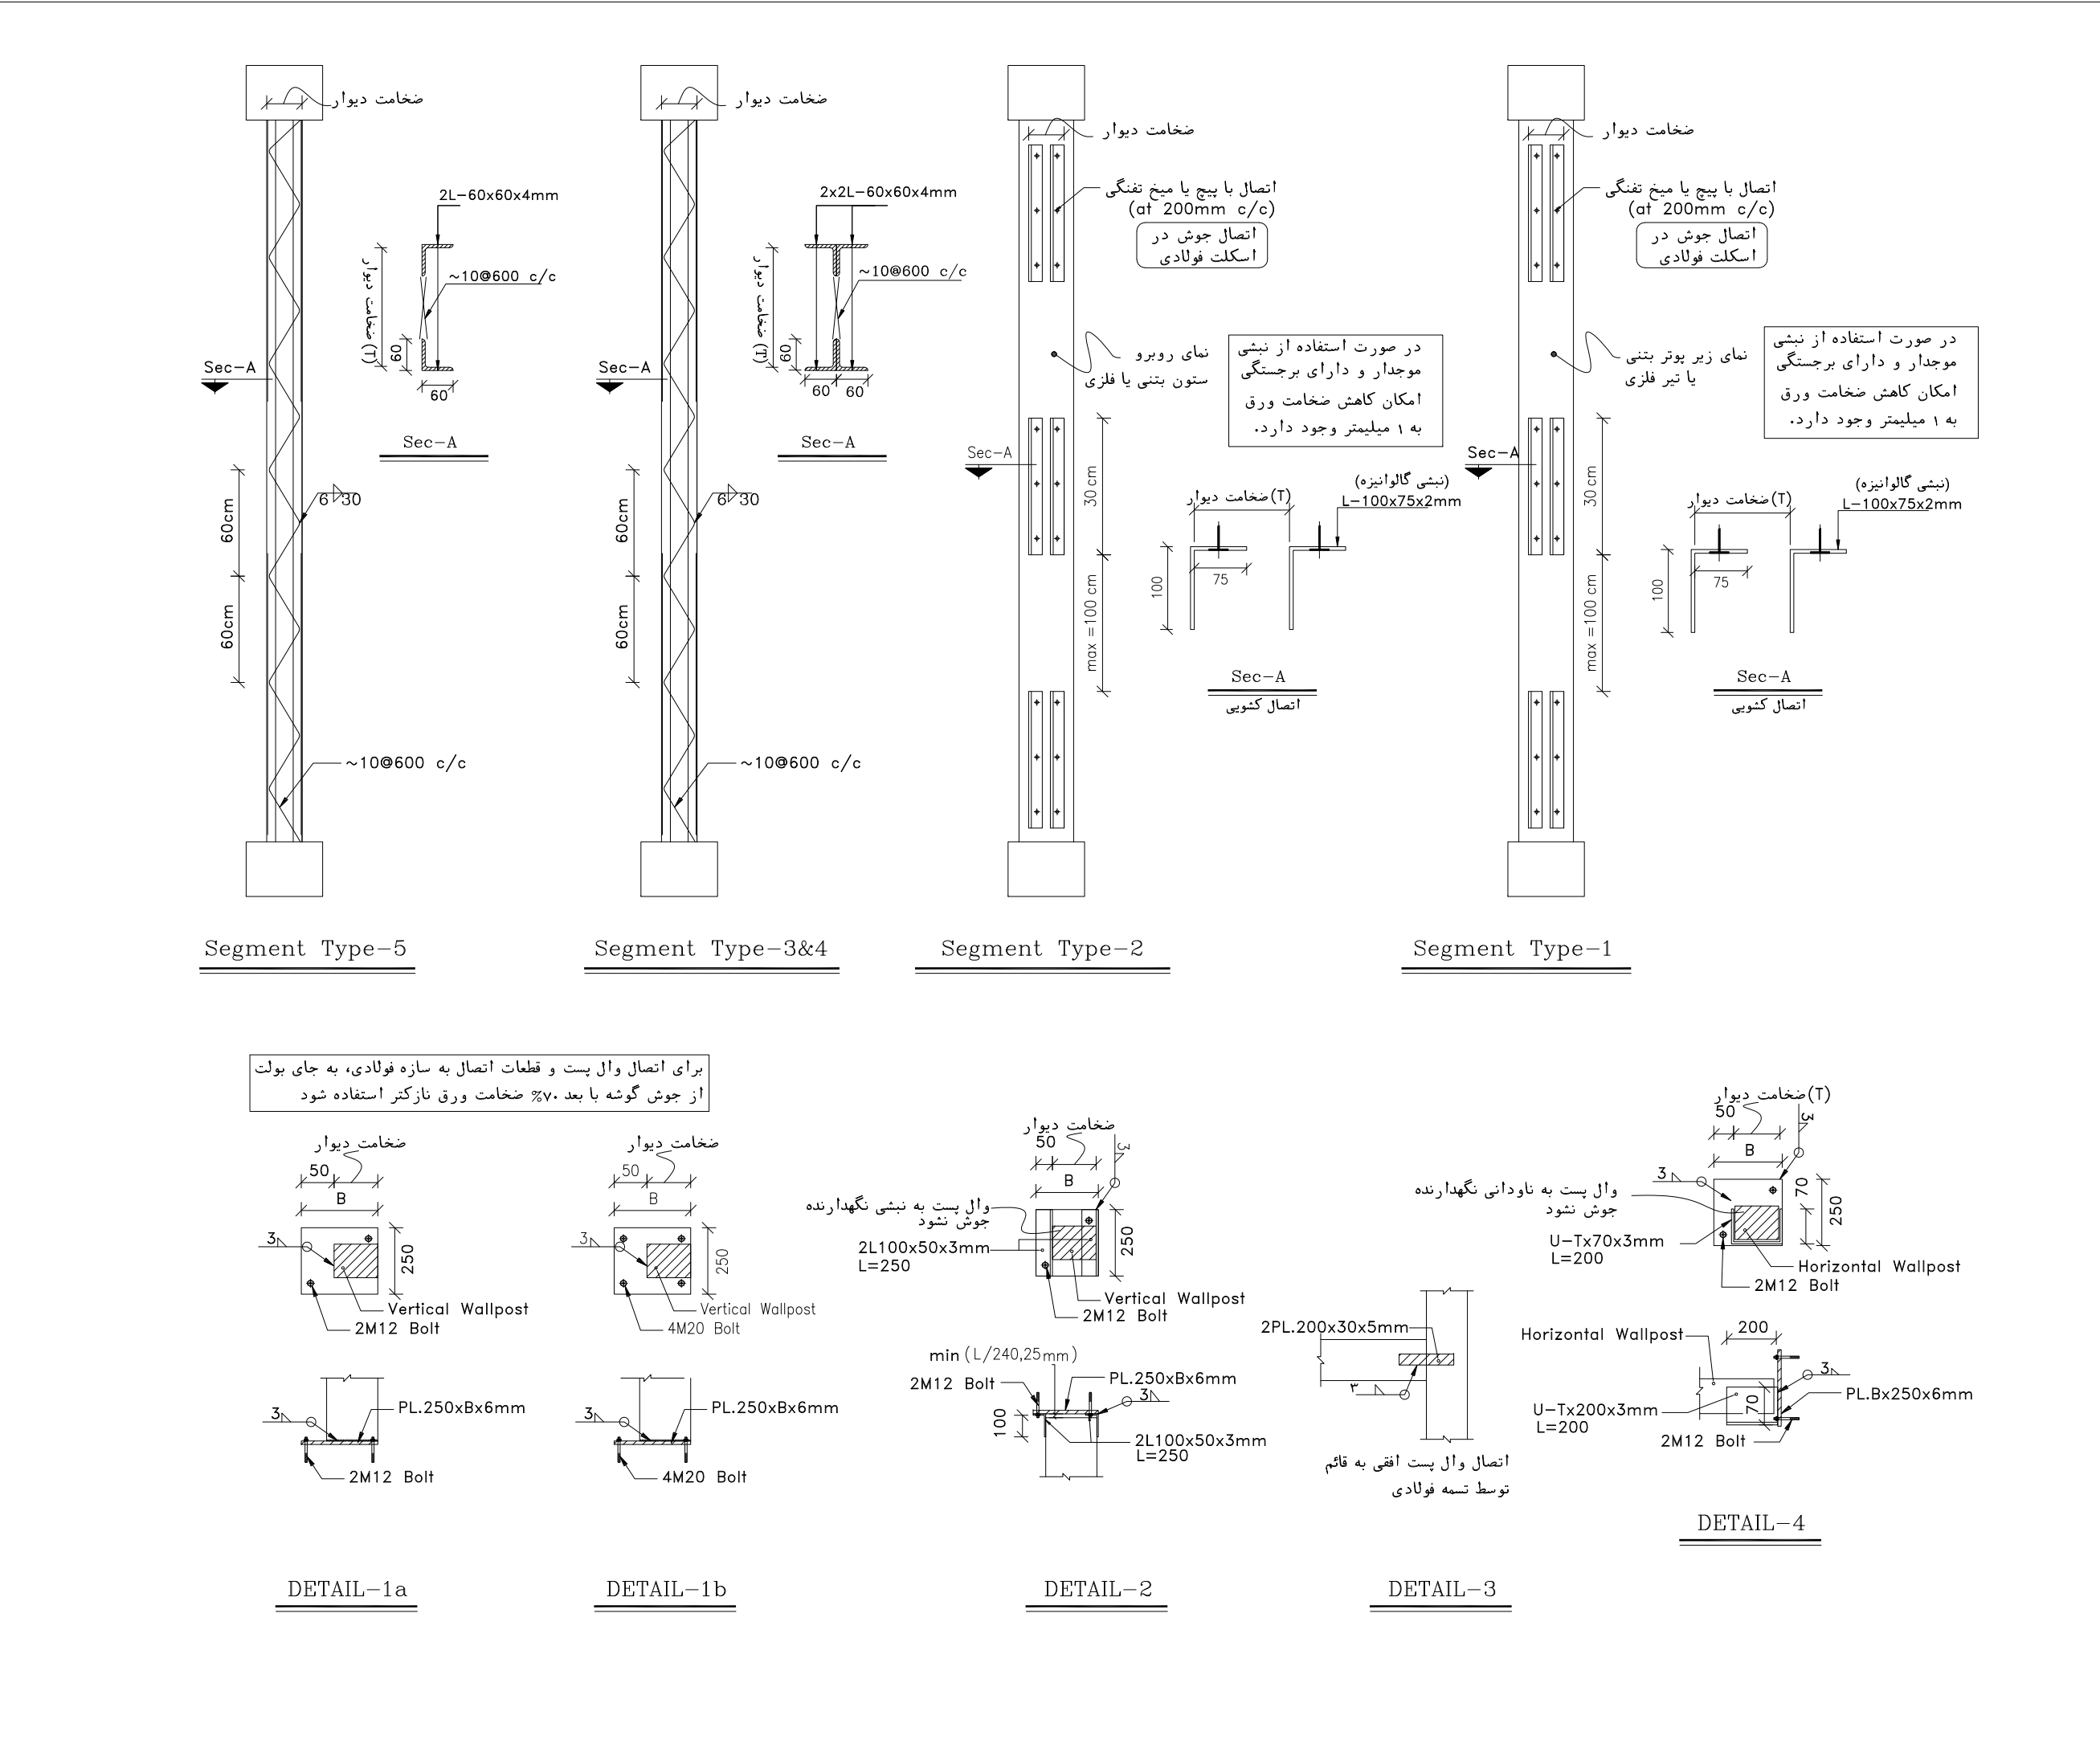

- NOTES
1. ALL DIMENSIONS ARE IN MILLIMETER & ALL ELEVATIONS ARE IN METER.
 2. ALL DIMENSIONS AND ELEVATIONS SHALL BE CHECKED BY THE CONTRACTOR PRIOR TO CONSTRUCTION.
 3. CONTRACTOR SHALL COMPARE ALL ARCHITECTURAL, MECHANICAL, ELECTRICAL, PIPING AND STRUCTURAL DRAWINGS AND IN CASE OF ANY CONFLICTS OR DISCREPANCY, INFORM THE ENGINEER.
 4. ALL MATERIALS ARE SELECTED FROM THE HIGHEST QUALITY AND MUST BE APPROVED BY THE CLIENT.
 5. ALL OPENINGS FOR PIPING/CABLING AND HVAC OPENINGS SHALL BE CONSIDERED AS PER RELATED DRAWINGS BEFORE CONSTRUCTION.
 6. FINISH GRADING LEVEL (F.G.L.) : +11.20 (M.S.L.) = ±0.00 (LOCAL)

LEGEND


REFERENCE DRAWING	DRG. No.
STANDARD DRAWING FOR ARCHITECTURAL DETAILS	BK-GNRL-PEDCO-000-AR-DW-0001
SITE SEWERAGE SYSTEM LAYOUT & DETAILS	BK-GCS-PEDCO-120-CV-PY-0001
CABLE TRENCH AND DUCT BANK LAYOUT	BK-GCS-PEDCO-120-CV-PY-0002
ROAD, PAVING AND PLANT FINISH GRADING LAYOUT & SECTIONS	BK-GCS-PEDCO-120-CV-PY-0005
ELECTRICAL CABLE ROUTE & SECTION LAYOUT FOR BUILDING & SHELTER	BK-GCS-PEDCO-120-EL-PY-0006
FOUNDATION DRAWING FOR CCTV CONTROL ROOM - BINAK GCS	BK-GCS-PEDCO-120-ST-DW-0075
STRUCTURAL DRAWING FOR CCTV CONTROL ROOM - BINAK GCS	BK-GCS-PEDCO-120-ST-DW-0076
STANDARD DETAILS FOR LADDER & SAFETY CAGE	BK-GNRL-PEDCO-000-ST-DW-0009
HVAC SYSTEM LAYOUT AND PLUMBING FOR CCTV CONTROL ROOM	BK-GCS-PEDCO-120-HV-PY-0009
PLUMBING & SEWAGE PIPING LAYOUT FOR CCTV CONTROL ROOM	BK-GCS-PEDCO-120-HV-PY-0013
UNIT PLOT PLAN DRAWING	BK-GCS-PEDCO-120-PI-PY-0001

KEY PLAN

اصل و کلیه نسخ این نقشه و حق اقتباس متعلق به شرکت ملی مناطق نفت خیز جنوب میباشد.
THE ORIGINAL AND ALL COPIES OF THIS DRAWING TOGETHER WITH THE COPYRIGHT THEREIN ARE THE SOLE PROPERTY OF N.I.S.O.C./ FIELDS



D04	SEP-2023	APC	R.BERLOUIE	M.PAKHARIAN	A.M.MOHSSENI	***										
D03	AUG-2023	IPA	R.BERLOUIE	M.PAKHARIAN	A.M.MOHSSENI	***										
D02	MAY-2023	IPA	R.BERLOUIE	M.PAKHARIAN	M.MEHRSHAD	***	***	*****	***	*****	***	*****				
D01	OCT-2022	IPA	R.BERLOUIE	M.PAKHARIAN	M.MEHRSHAD	***										
D00	JUN-2022	IPC	R.BERLOUIE	M.PAKHARIAN	M.MEHRSHAD	***	REV.	DESCRIPTION	BY	DATE	BY	DATE				
REV.	DATE	P.O.I.S	PREP.	CHK.	APP.	AUT.	اصل و کلیه نسخ این نقشه و نقشه و اقلام متعلق به شرکت ملی مناطق نفت خیز جنوب میباشد.									
PROJECT NAME:			BINAK OILFIELD DEVELOPMENT/SURFACE FACILITIES GAS COMPRESSOR STATION				 THE ORIGINAL AND ALL COPIES OF THIS DRAWING TOGETHER WITH THE COPYRIGHT THEREIN ARE THE SOLE PROPERTY OF N.I.S.O.C. / FIELDS									
PROJECT NO.:			971020													
EPC CONTRACTOR:			EPD/EPC CONTRACTOR (GC):				BINAK OILFIELD DEVELOPMENT SURFACE FACILITIES GAS COMPRESSOR STATION									
 HIRGAN ENERGY – DESIGN & INSPECTION COMPANIES			 PETROIRAN DEVELOPMENT COMPANY													
							DATE		SCALE		DRAWING BY		CHECKED BY		PROJECT ENG.	
DRAWING TITLE:							NO CONSTRUCTION PERMITTED UNLESS DRAWING APPROVED									
Architectural Drawing For CCTV Control Room– Binak GCS DETAILS							APPROVED FOR CONSTRUCTION									
							BY:									
							DATE:									
							BUDGET REF. LOCATION SIZE CLASS SERIAL NO. SHEET REVISION									
AS SHOWN		A1	BK–GCS–PEDCO–120–AR–DW–0008			11 OF 11	D04	053–073–9184		F	4	B	709396		11 OF 11	D04

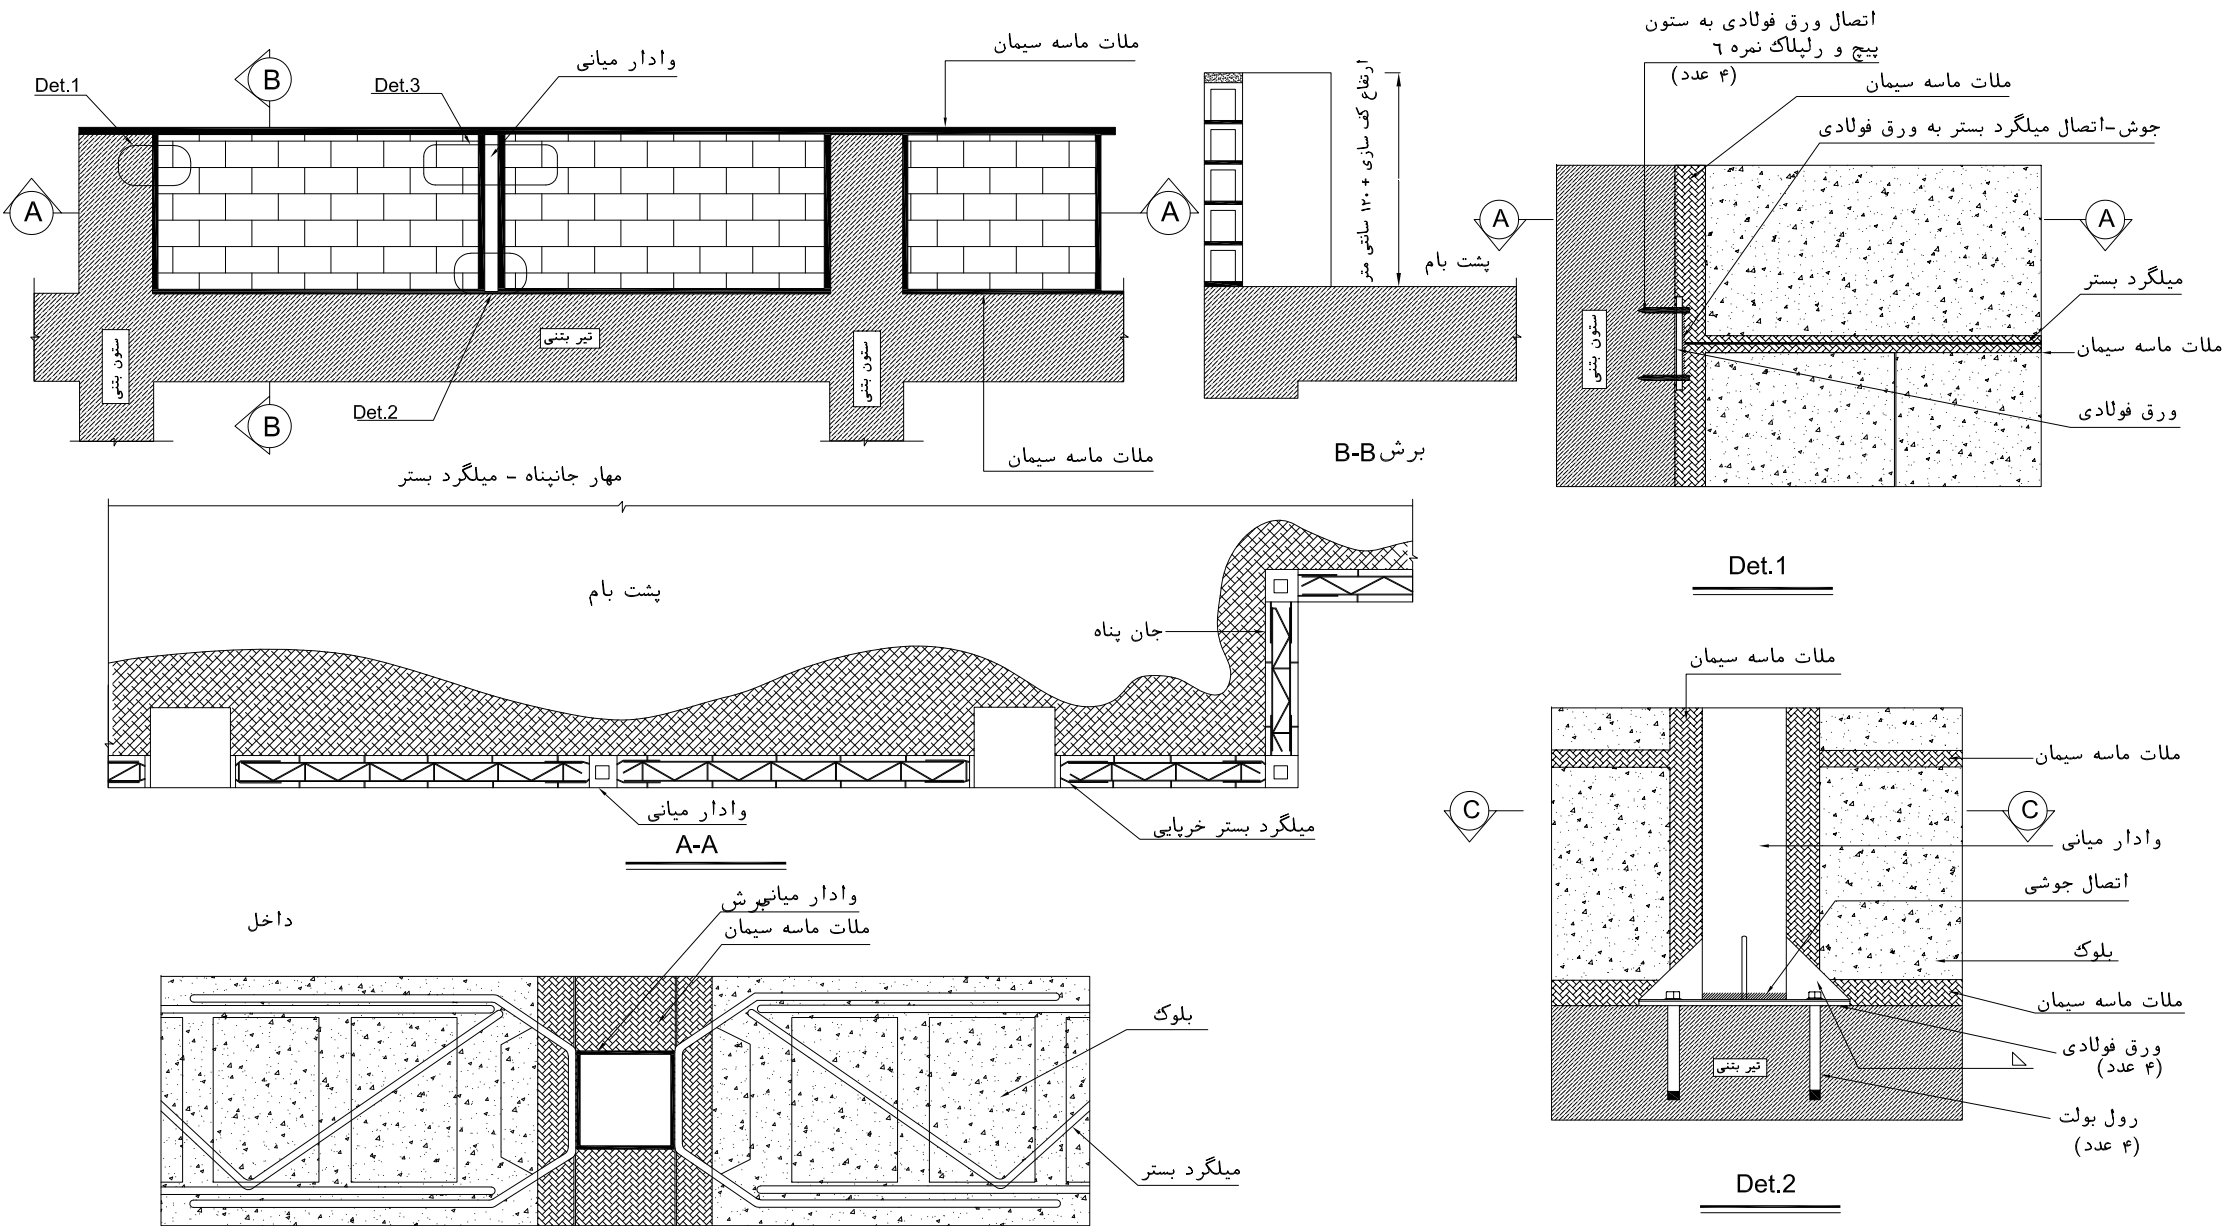


SECTION A-A

Det.3


نحوه مهار جان پناه غیر مسلح بتانی

ورق فولادی مستطیلاری تیر بتنی
رول بولت میشود
اتصال وادار میانی به ورق با جوش

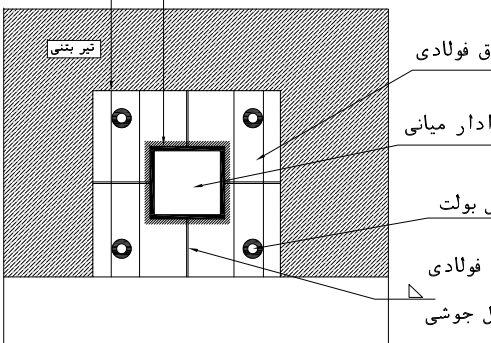


SECTION C-C

Det.2

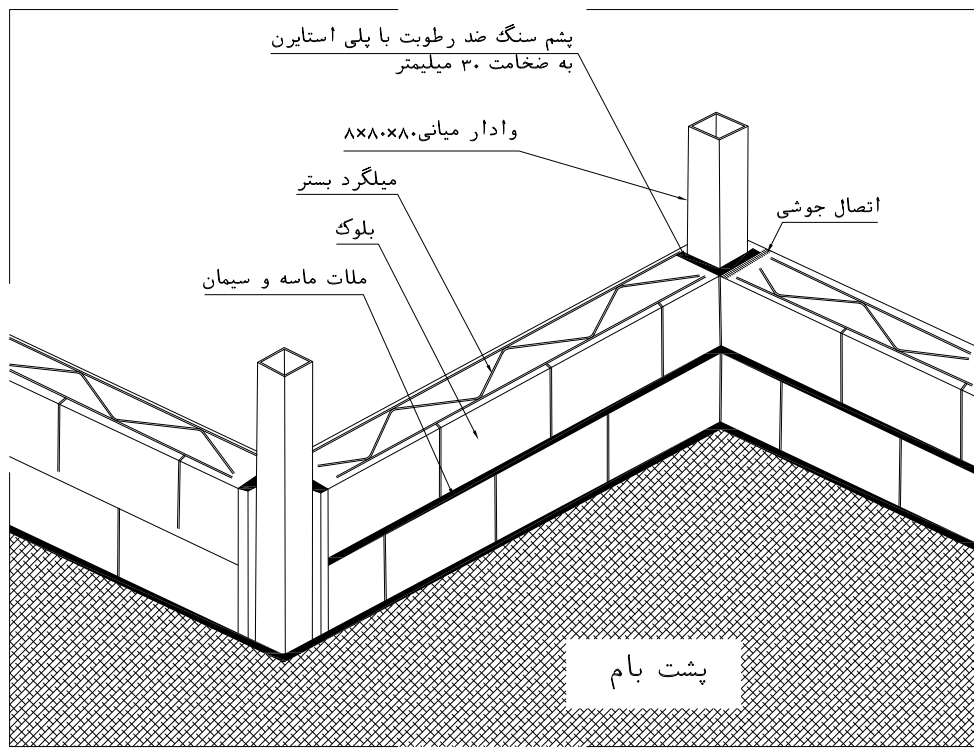

Perspective

مهار جان پناه بتانی توسط وادار فلزی

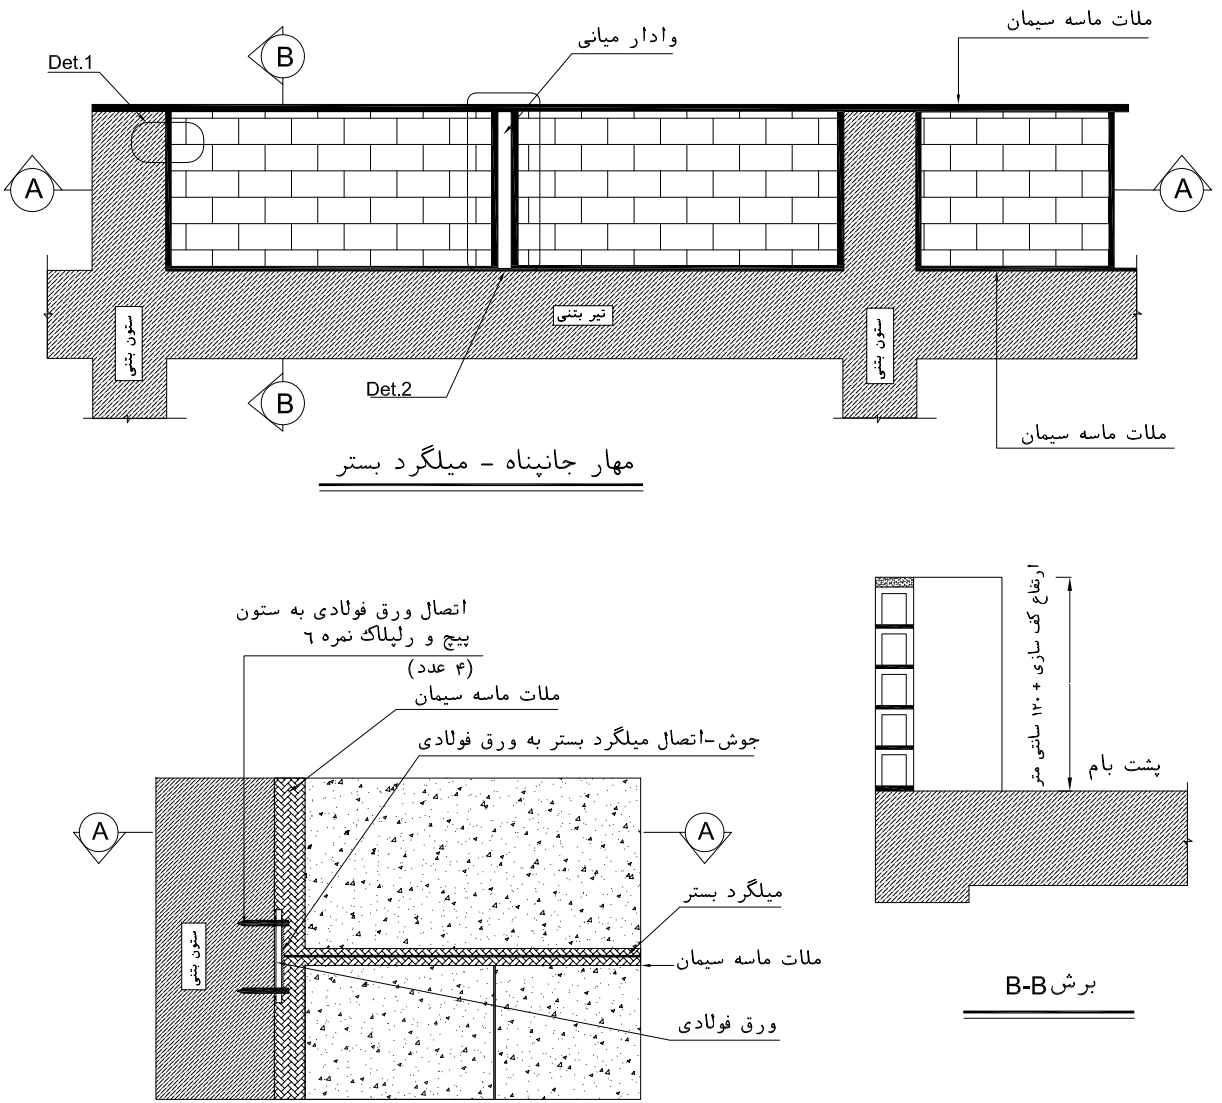

Det.1


Det.2

Det.3

SECTION C-C

Det.2


جزئیات اجرایی اتصالات جان پناه با وادار بتنی

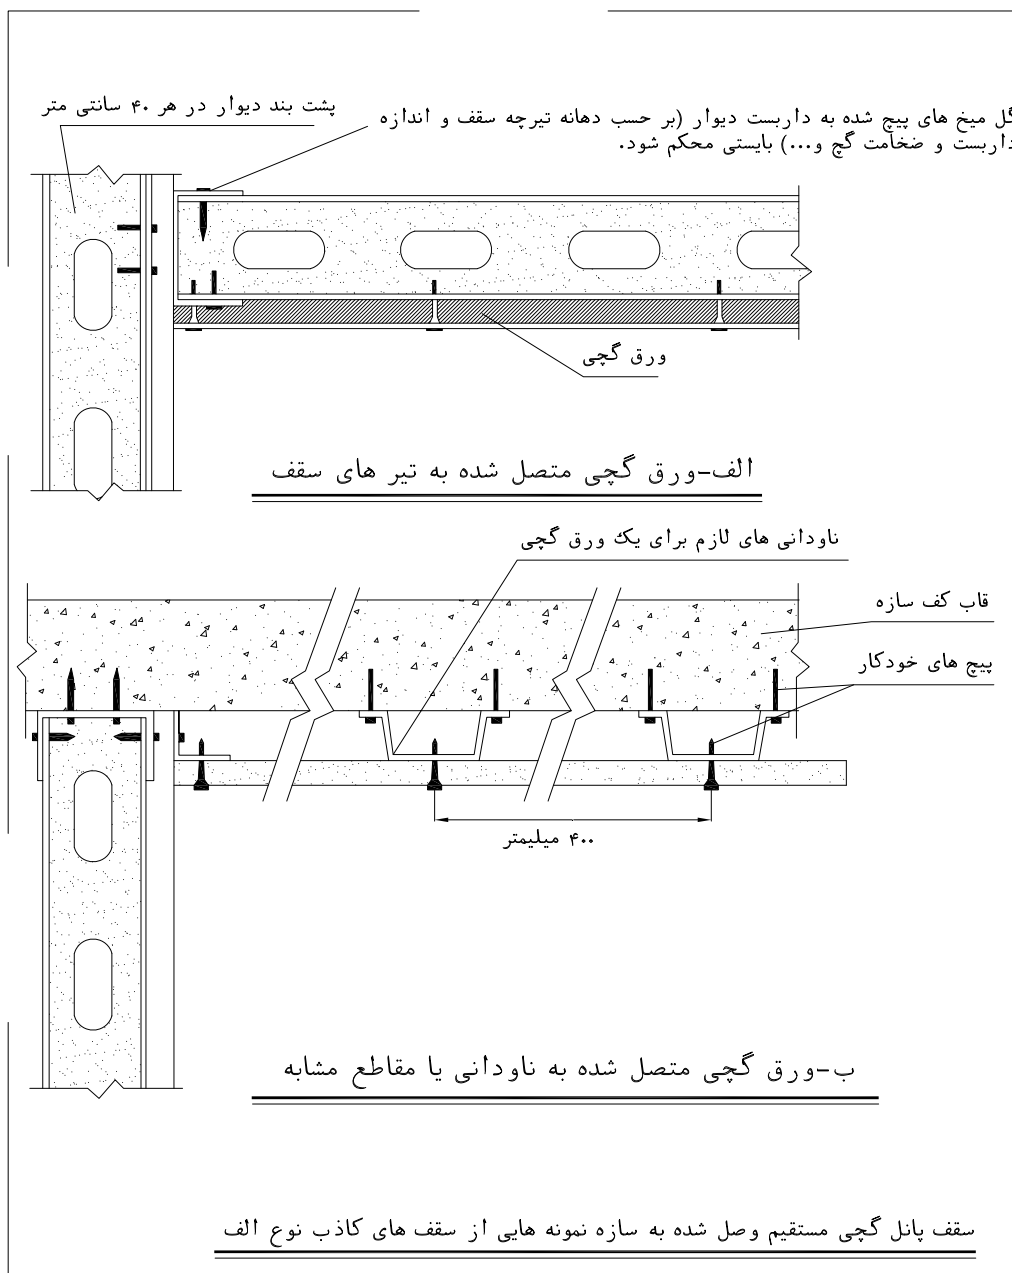

الف-ورق گچی متصل شده به تیر های سقف

ب-ورق گچی متصل شده به ناودانی یا مقاطع مشابه

سقف پانل گچی مستقیم وصل شده به سازه نمونه هایی از سقف های کاذب نوع الف

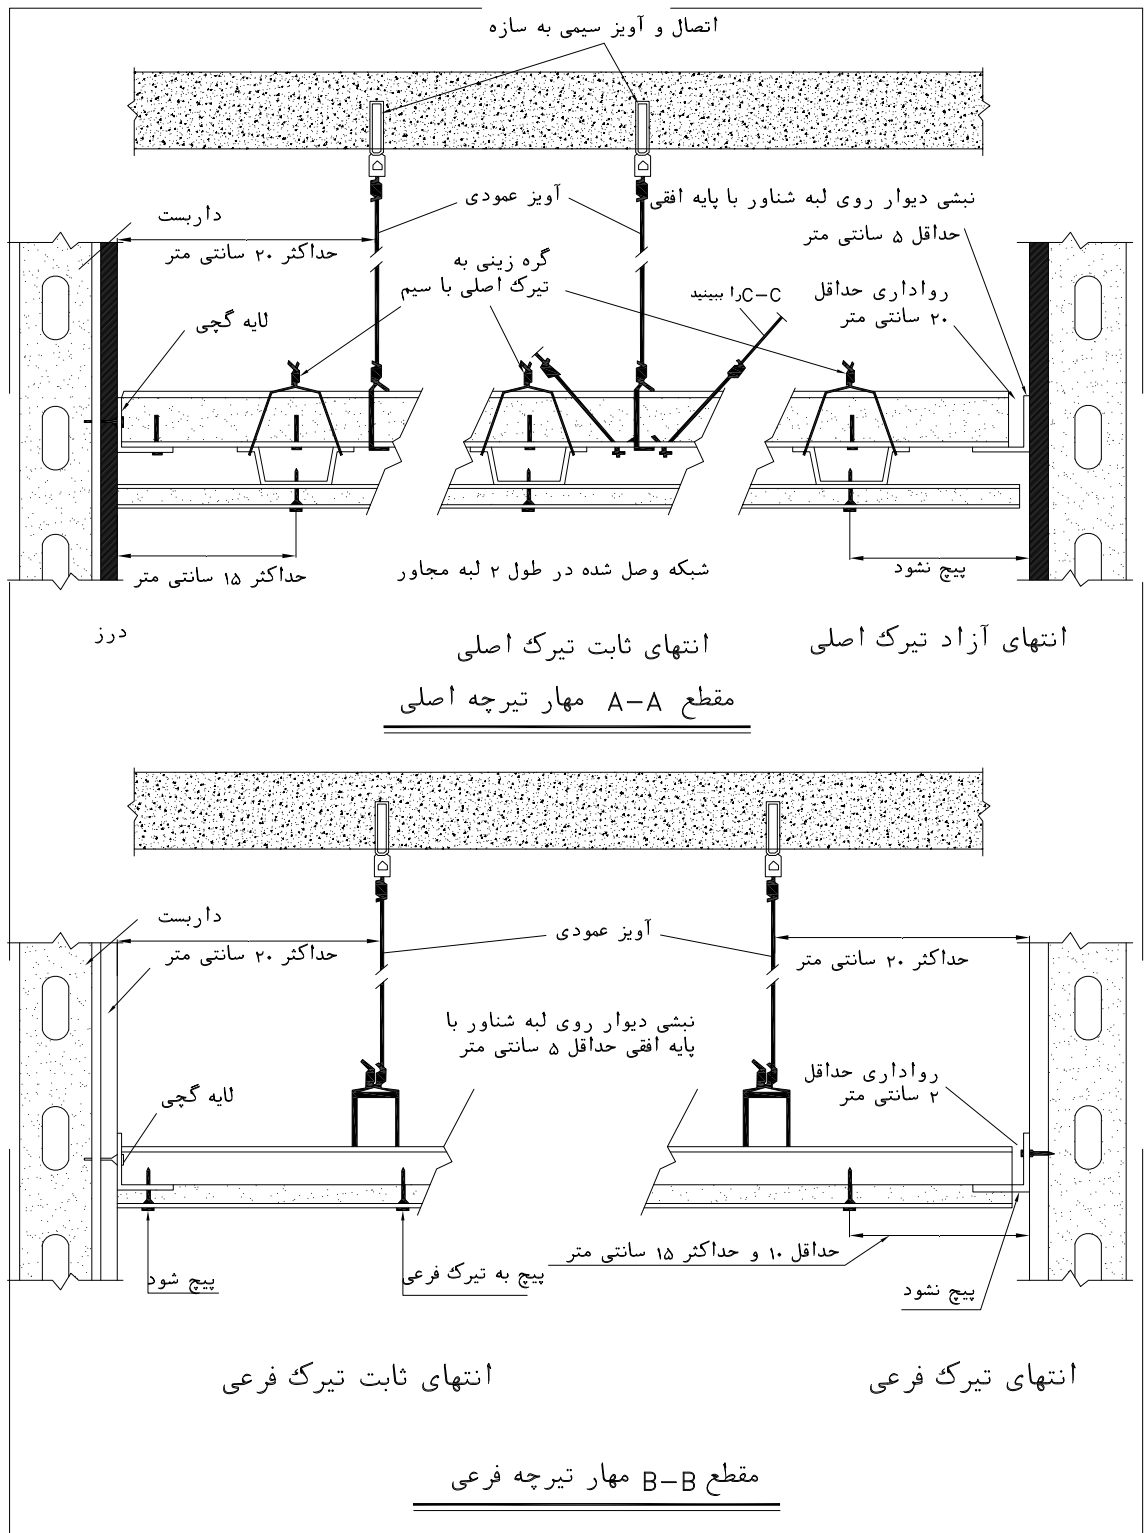

انتهای آزاد تیرک اصلی

انتهای ثابت تیرک اصلی

مقطع A-A مهار تیرچه اصلی

انتهای تیرک فرعی

مقطع B-B مهار تیرچه فرعی