


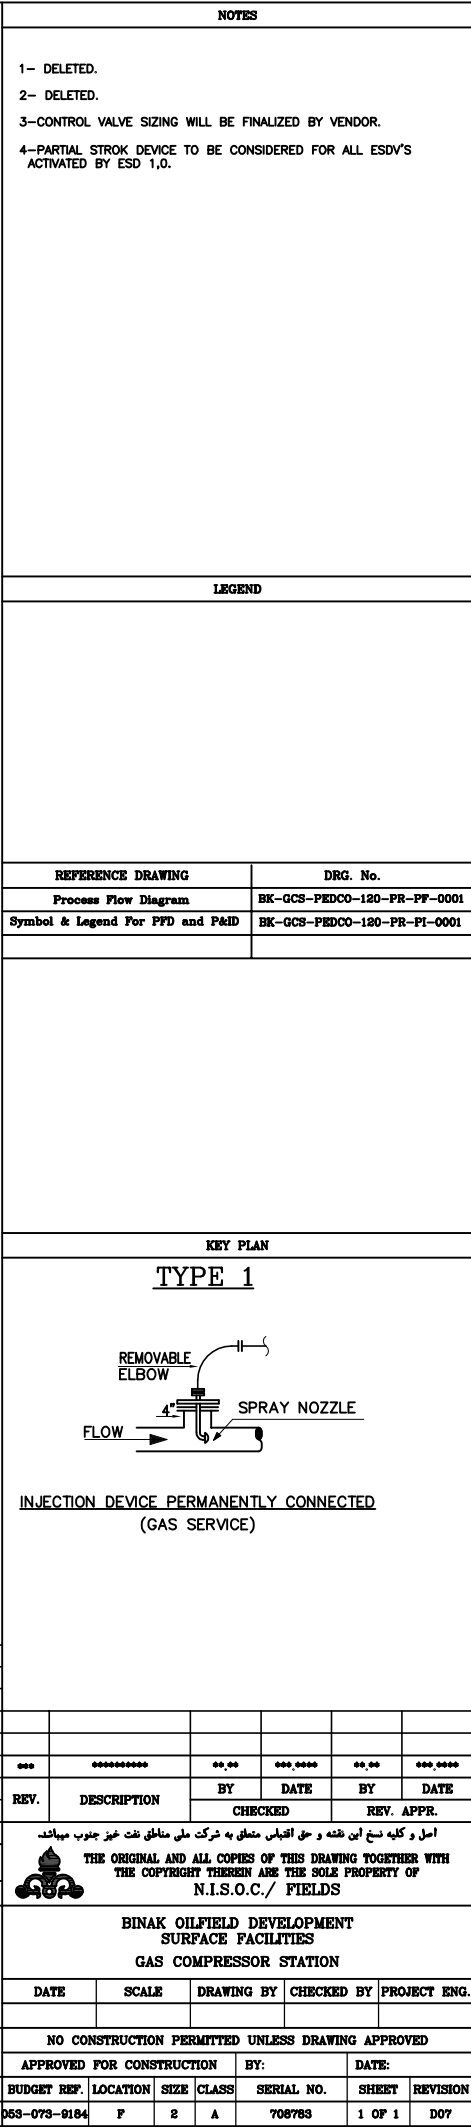

D07	SEP.2023	APC	M.ANTAPAR	M.PAKHABAN	A.M.MOHSEN	00.00
D06	APR.2023	IPA	M.ANTAPAR	M.PAKHABAN	M.MEHRISAD	00.00
D05	DEC.2022	IPA	M.ANTAPAR	M.PAKHABAN	M.MEHRISAD	00.00
D04	AUG.2022	IPA	M.ANTAPAR	M.PAKHABAN	M.MEHRISAD	00.00
D03	JUN.2022	IPA	M.ANTAPAR	M.PAKHABAN	M.MEHRISAD	00.00
D02	MAR.2022	IPA	M.ANTAPAR	M.PAKHABAN	M.MEHRISAD	00.00
D01	JAN.2022	IPA	M.ANTAPAR	M.PAKHABAN	M.MEHRISAD	00.00
D00	SEP.2021	IPC	M.ANTAPAR	M.PAKHABAN	M.MEHRISAD	00.00
REV.	DATE	P.O.I.S	PREP.	CHK.	APP.	AUT.

PROJECT NAME:	BINAK OILFIELD DEVELOPMENT/SURFACE FACILITIES GAS COMPRESSOR STATION
---------------	---

PROJECT NO.:	971020
--------------	--------

EPC CONTRACTOR:	EPD/EPC CONTRACTOR (GC):
-----------------	--------------------------

 	
HIRGAN ENERGY - DESIGN & INSPECTION COMPANIES	PETROIRAN DEVELOPMENT COMPANY

DRAWING TITLE:	
----------------	--

P&ID - GAS COMPRESSION INLET KNOCK OUT DRUM

SCALE	SIZE	DRAWING NO.	SHEET NO.	REV.
-------	------	-------------	-----------	------

NS	A3	BK-GCS-PEDCO-120-PR-PI-0005	1 OF 1	D07
----	----	-----------------------------	--------	-----

 THE ORIGINAL AND ALL COPIES OF THIS DRAWING TOGETHER WITH
THE COPYRIGHT THEREIN ARE THE SOLE PROPERTY OF
N.I.S.O.C./ FIELDS

**BINAK OILFIELD DEVELOPMENT
SURFACE FACILITIES
GAS COMPRESSOR STATION**

DATE	SCALE	DRAWING BY	CHECKED BY	PROJECT ENG.

NO CONSTRUCTION PERMITTED UNLESS DRAWING APPROVED

APPROVED FOR CONSTRUCTION	BY:	DATE:
---------------------------	-----	-------

BUDGET REF.	LOCATION	SIZE	CLASS	SERIAL NO.	SHEET	REVISION
-------------	----------	------	-------	------------	-------	----------

053-073-9184	F	2	A	708783	1 OF 1	D07
--------------	---	---	---	--------	--------	-----
