
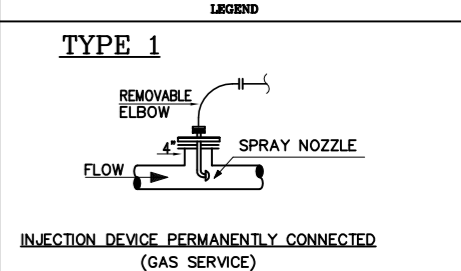


**PR-1002  
EXISTING GAS PIG RECEIVER**

TRIM LINE : TRM-PR-1002-0504-AN07-PT

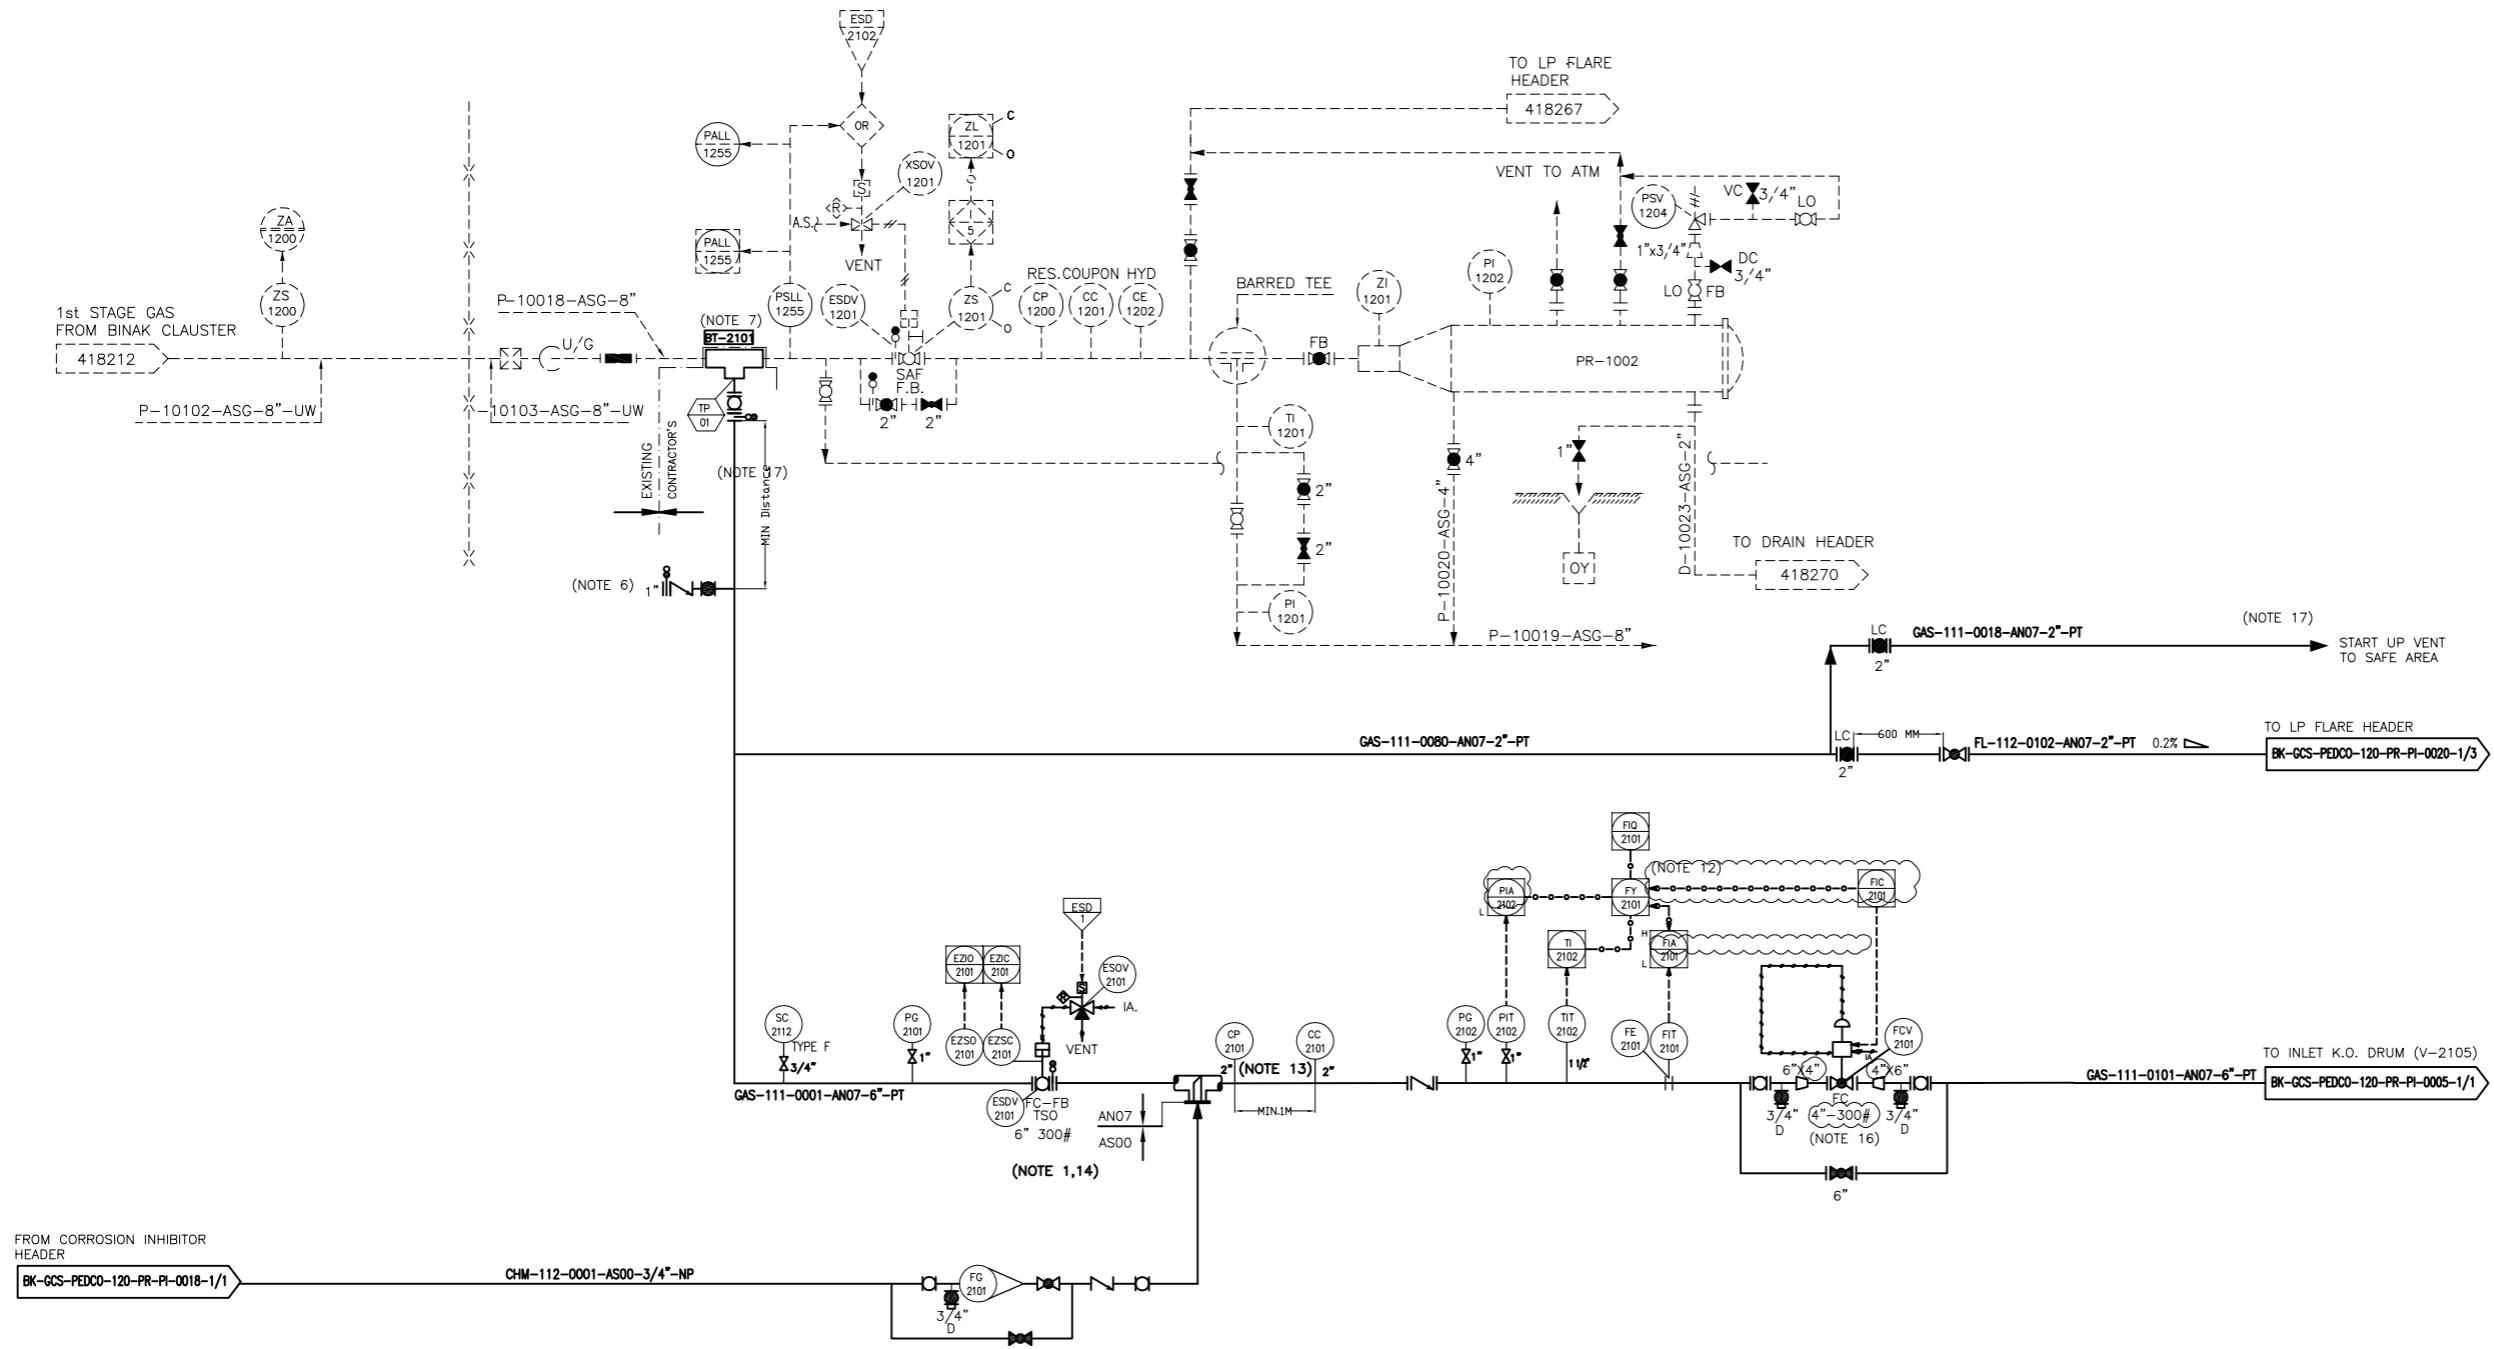

REFERENCE DRAWING	DRG. No.
Process Flow Diagram	BK-GCS-PEDCO-120-PR-PF-0001
Symbol & Legend For PFD and P&ID	BK-GCS-PEDCO-120-PR-PI-0001

**KEY PLAN**

FROM CORROSION INHIBITOR HEADER  
BK-GCS-PEDCO-120-PR-PI-0018-1/1

REV.	DATE	P.O.I.S	PREP.	CHK.	APP.	AUT.
D07	SEP.2023	APC	M.ARYAPAR	M.PAKHSHAN	A.M.MOHESEN	00.00
D06	APR.2023	APC	M.ARYAPAR	M.PAKHSHAN	M.MEHRSHAD	00.00
D05	DEC.2022	IFA	M.ARYAPAR	M.PAKHSHAN	M.MEHRSHAD	00.00
D04	AUG.2022	IFA	M.ARYAPAR	M.PAKHSHAN	M.MEHRSHAD	00.00
D03	JUN.2022	IFA	M.ARYAPAR	M.PAKHSHAN	M.MEHRSHAD	00.00
D02	MAR.2022	IFA	M.ARYAPAR	M.PAKHSHAN	M.MEHRSHAD	00.00
D01	JAN.2022	IFA	M.ARYAPAR	M.PAKHSHAN	M.MEHRSHAD	00.00
D00	SEP.2021	IPC	M.ARYAPAR	M.PAKHSHAN	SH.GHALEHAR	00.00

PROJECT NAME: BINAK OILFIELD DEVELOPMENT/SURFACE FACILITIES GAS COMPRESSOR STATION						
PROJECT NO.: 971020						
EPC CONTRACTOR: <b>HIRGAN ENERGY</b> HIRGAN ENERGY - DESIGN & INSPECTION COMPANIES			EPD/EPC CONTRACTOR (GC): <b>PETROIRAN DEVELOPMENT COMPANY</b> PEDCO			
DRAWING TITLE: P&ID - GAS COMPRESSION INLET GAS PIPELINE (BINAK)						
SCALE	SIZE	DRAWING NO.	SHEET NO.	REV.	BUDGET REF.	LOCATION
NS	AS	BK-GCS-PEDCO-120-PR-PI-0002	1 OF 1	D07	053-073-0184	F 2 A

THE ORIGINAL AND ALL COPIES OF THIS DRAWING TOGETHER WITH THE COPYRIGHT THEREIN ARE THE SOLE PROPERTY OF N.I.S.O.C./ FIELDS						
DATE	SCALE	DRAWING BY	CHECKED BY	PROJECT ENG.		
NO CONSTRUCTION PERMITTED UNLESS DRAWING APPROVED						
APPROVED FOR CONSTRUCTION			BY:	DATE:		
BUDGET REF.	LOCATION	SIZE	CLASS	SERIAL NO.	SHEET	REVISION
053-073-0184	F	2	A	706780	1 OF 1	D07