


V-2203
INSTRUMENT AIR RECEIVER
DIMENSION (ID X TL-TL) : 1500 X 5000 mm
DESIGN TEMP. : 85 °C
DESIGN PRESS. : 12.5 barg
TRIM LINE : TRM-V-2203-0507-AZ00-NP

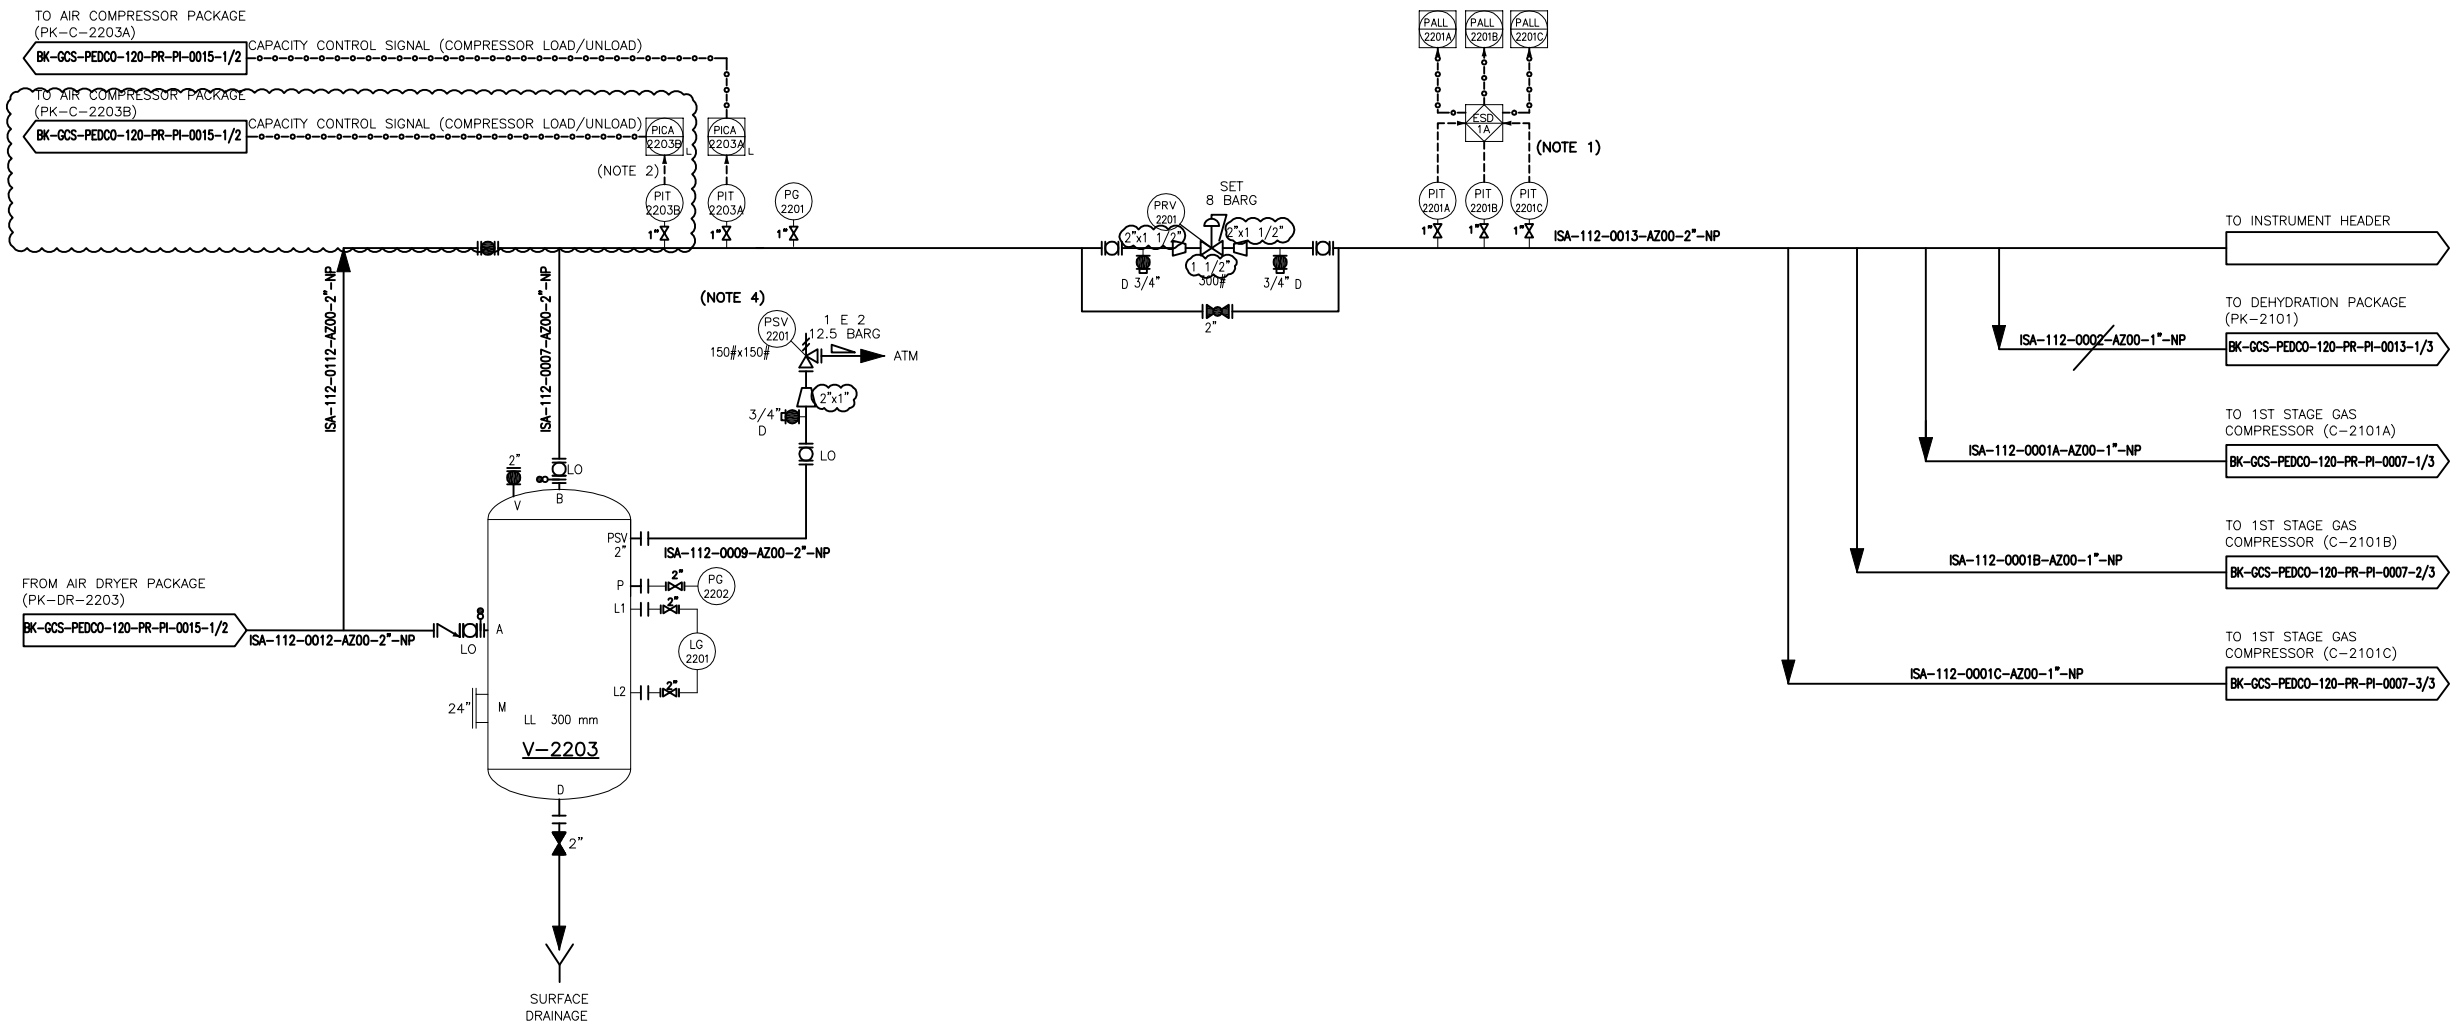

- NOTES
- 1- 2 OF 3 VOTING FOR SYSTEM SHUTDOWN.
 - 2- PRESSURE TRANSMITTER WILL START STANDBY COMPRESSOR ON LOW PRESSURE OF DUTY COMPRESSOR.
 - 3- PARTIAL STROKE DEVICE TO BE CONSIDERED FOR ALL ESDV'S ACTIVATED BY ESD 1,0.
 - 4- 2*100% PSV'S ONE DUTY AND ONE STANDBY.

GENERAL NOTE

LEGEND

REFERENCE DRAWING	DRG. No.
Utility Flow Diagram	BK-GCS-PEDCO-120-PR-UF-0001
Symbol & Legend For PFD & P&ID	BK-GCS-PEDCO-120-PR-PI-0001

KEY PLAN

D07	SEP.2023	IPA	M.ARTAPAR	M.PAKHMAN	A.M.MOHESEN	00.00
D06	APR.2023	IPA	M.ARTAPAR	M.PAKHMAN	M.MEHRSHAD	00.00
D05	DEC.2022	IPA	M.ARTAPAR	M.PAKHMAN	M.MEHRSHAD	00.00
D04	AUG.2022	IPA	M.ARTAPAR	M.PAKHMAN	M.MEHRSHAD	00.00
D03	JUN.2022	IPA	M.ARTAPAR	M.PAKHMAN	M.MEHRSHAD	00.00
D02	MAR.2022	IPA	M.ARTAPAR	M.PAKHMAN	M.MEHRSHAD	00.00
D01	JAN.2022	IPC	M.ARTAPAR	M.PAKHMAN	M.MEHRSHAD	00.00
D00	OCT.2021	IPC	M.ARTAPAR	M.PAKHMAN	M.MEHRSHAD	00.00
REV.	DATE	P.O.I.S	PREP.	CHK.	APP.	AUT.

PROJECT NAME: BINAK OILFIELD DEVELOPMENT/SURFACE FACILITIES GAS COMPRESSOR STATION					
PROJECT NO.: 971020					
EPC CONTRACTOR:  HIRGAN ENERGY - DESIGN & INSPECTION COMPANIES			EPD/EPC CONTRACTOR (GC):  PETROIRAN DEVELOPMENT COMPANY		

 THE ORIGINAL AND ALL COPIES OF THIS DRAWING TOGETHER WITH THE COPYRIGHT THEREIN ARE THE SOLE PROPERTY OF N.I.S.O.C./ FIELDS					
BINAK OILFIELD DEVELOPMENT SURFACE FACILITIES GAS COMPRESSOR STATION					
DATE	SCALE	DRAWING BY	CHECKED BY	PROJECT ENG.	
NO CONSTRUCTION PERMITTED UNLESS DRAWING APPROVED					
APPROVED FOR CONSTRUCTION			BY:	DATE:	
BUDGET REF.	LOCATION	SIZE	CLASS	SERIAL NO.	SHEET REVISION
053-073-0184	F	2	A	708793	2 OF 2 D07

(VENDOR TITLE BLOCK)**