




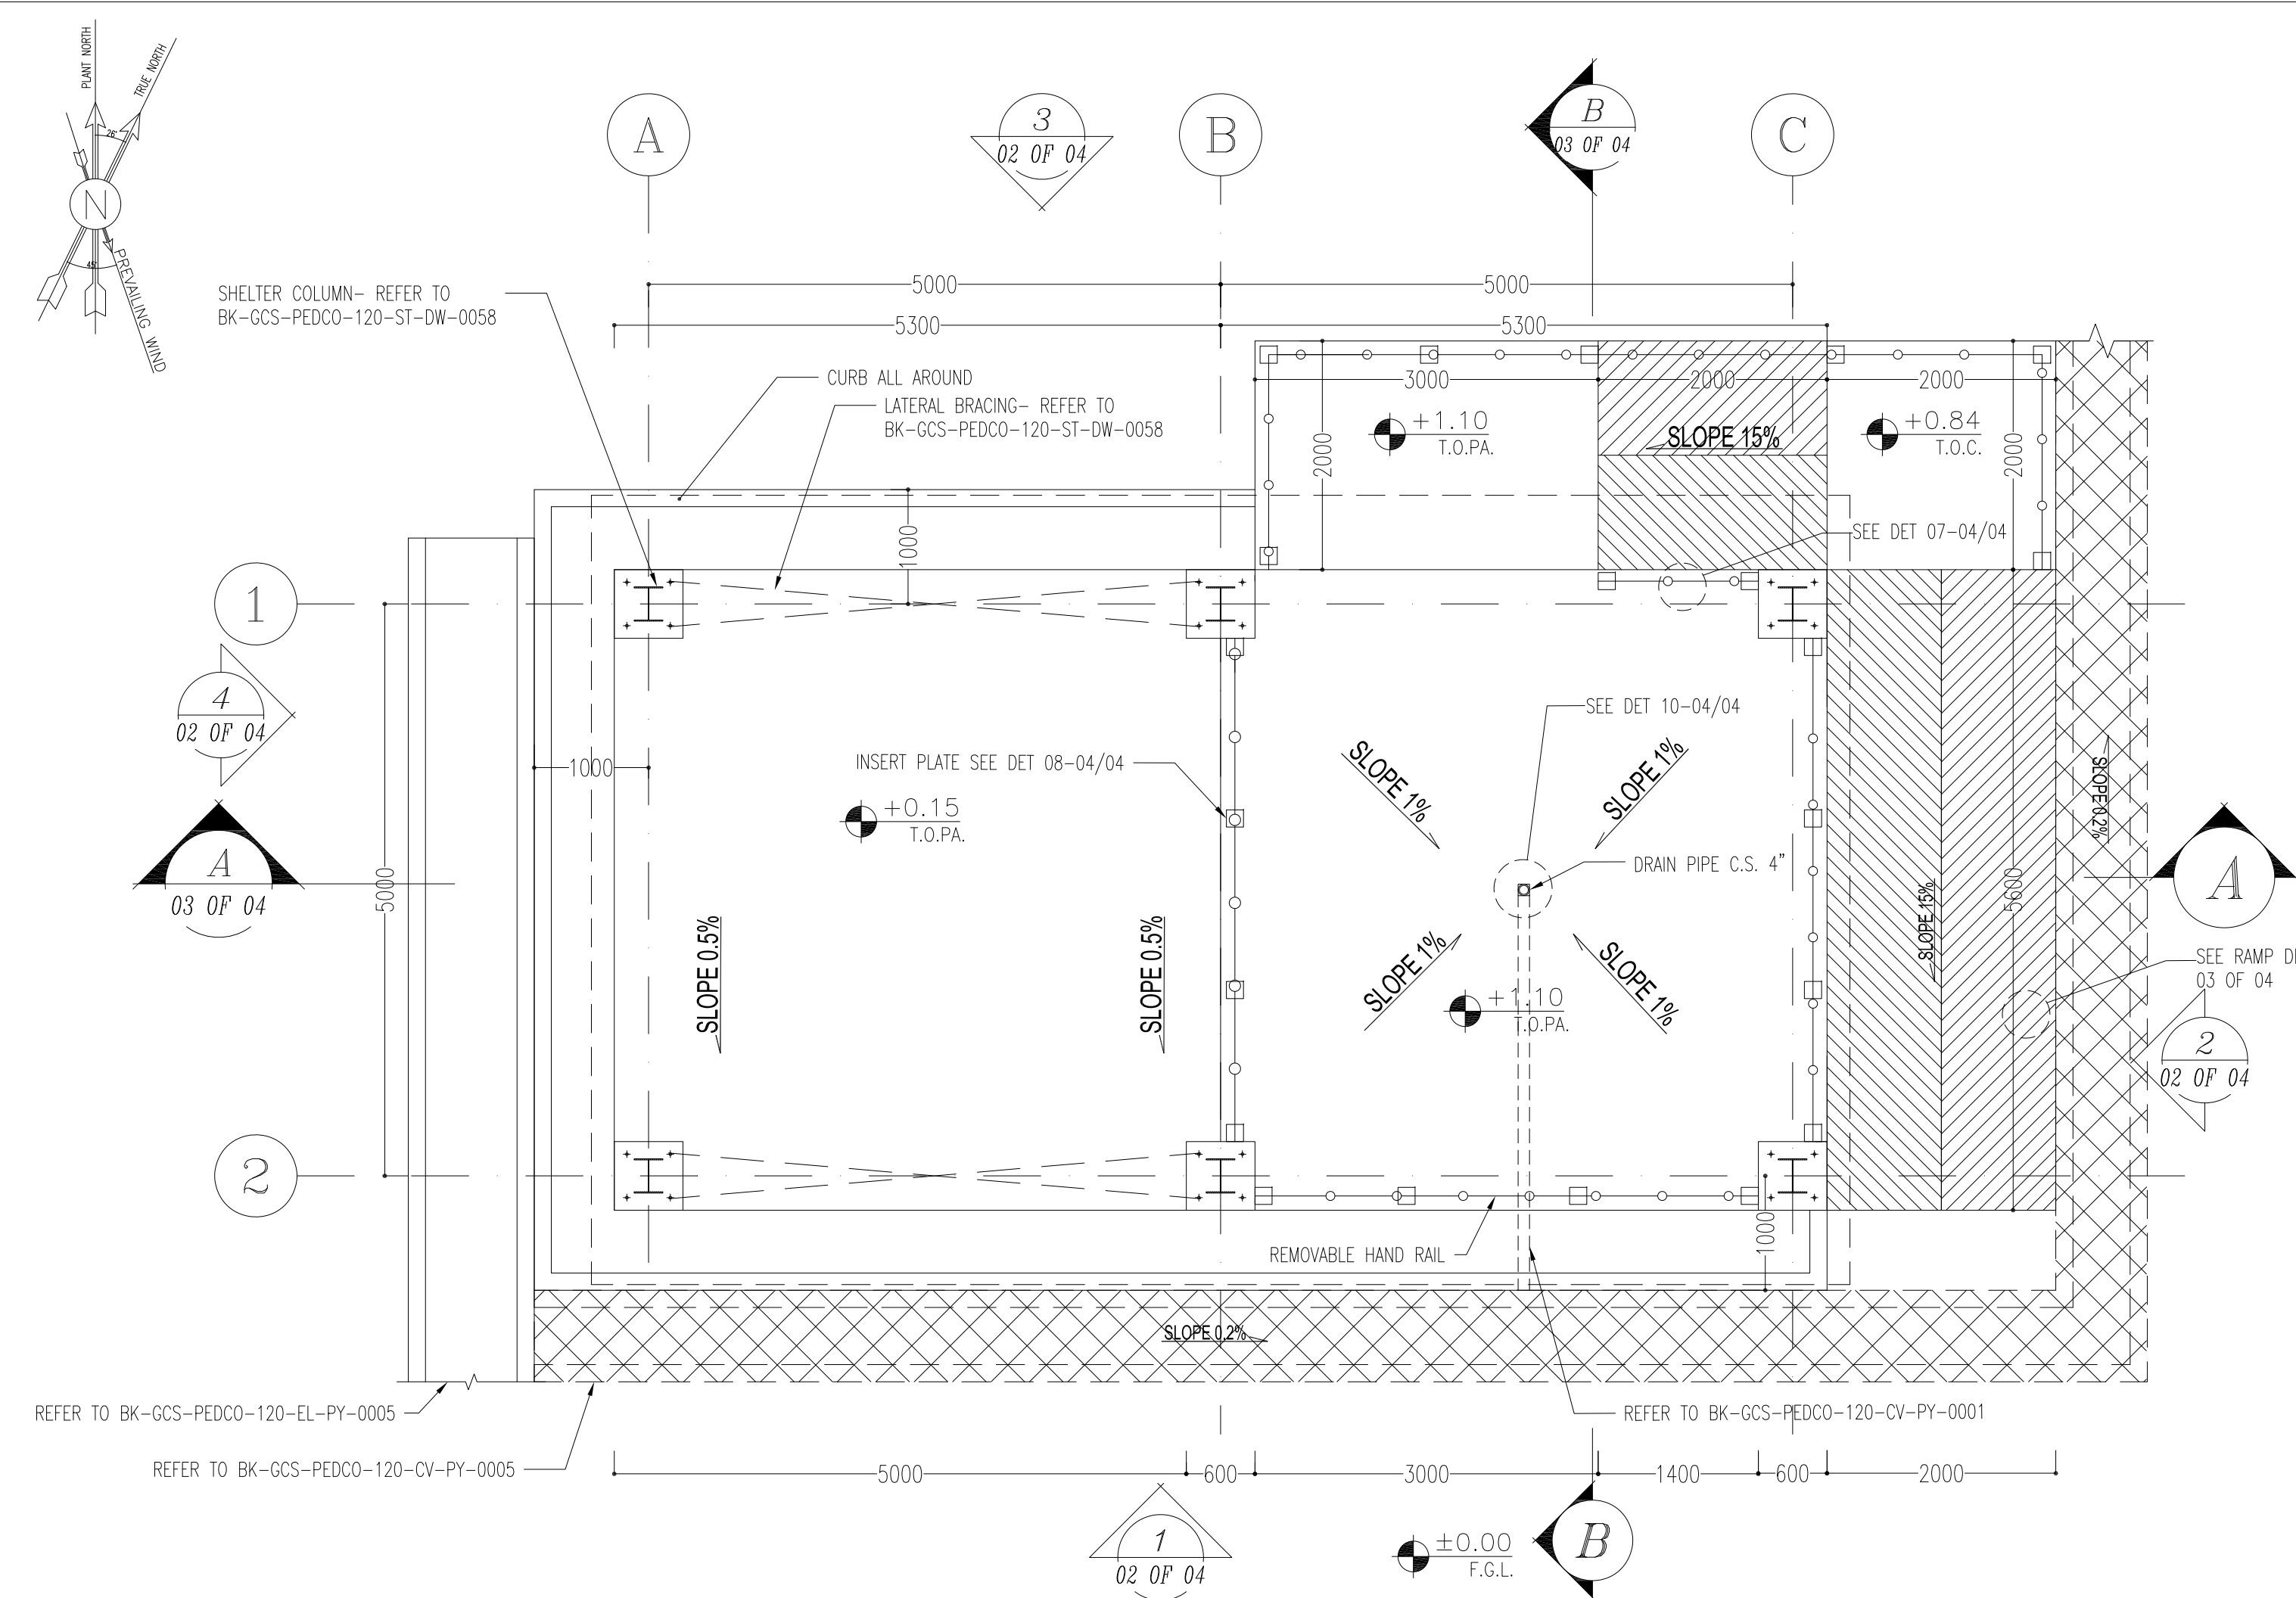

SC.1:50 1 FLOOR PLAN

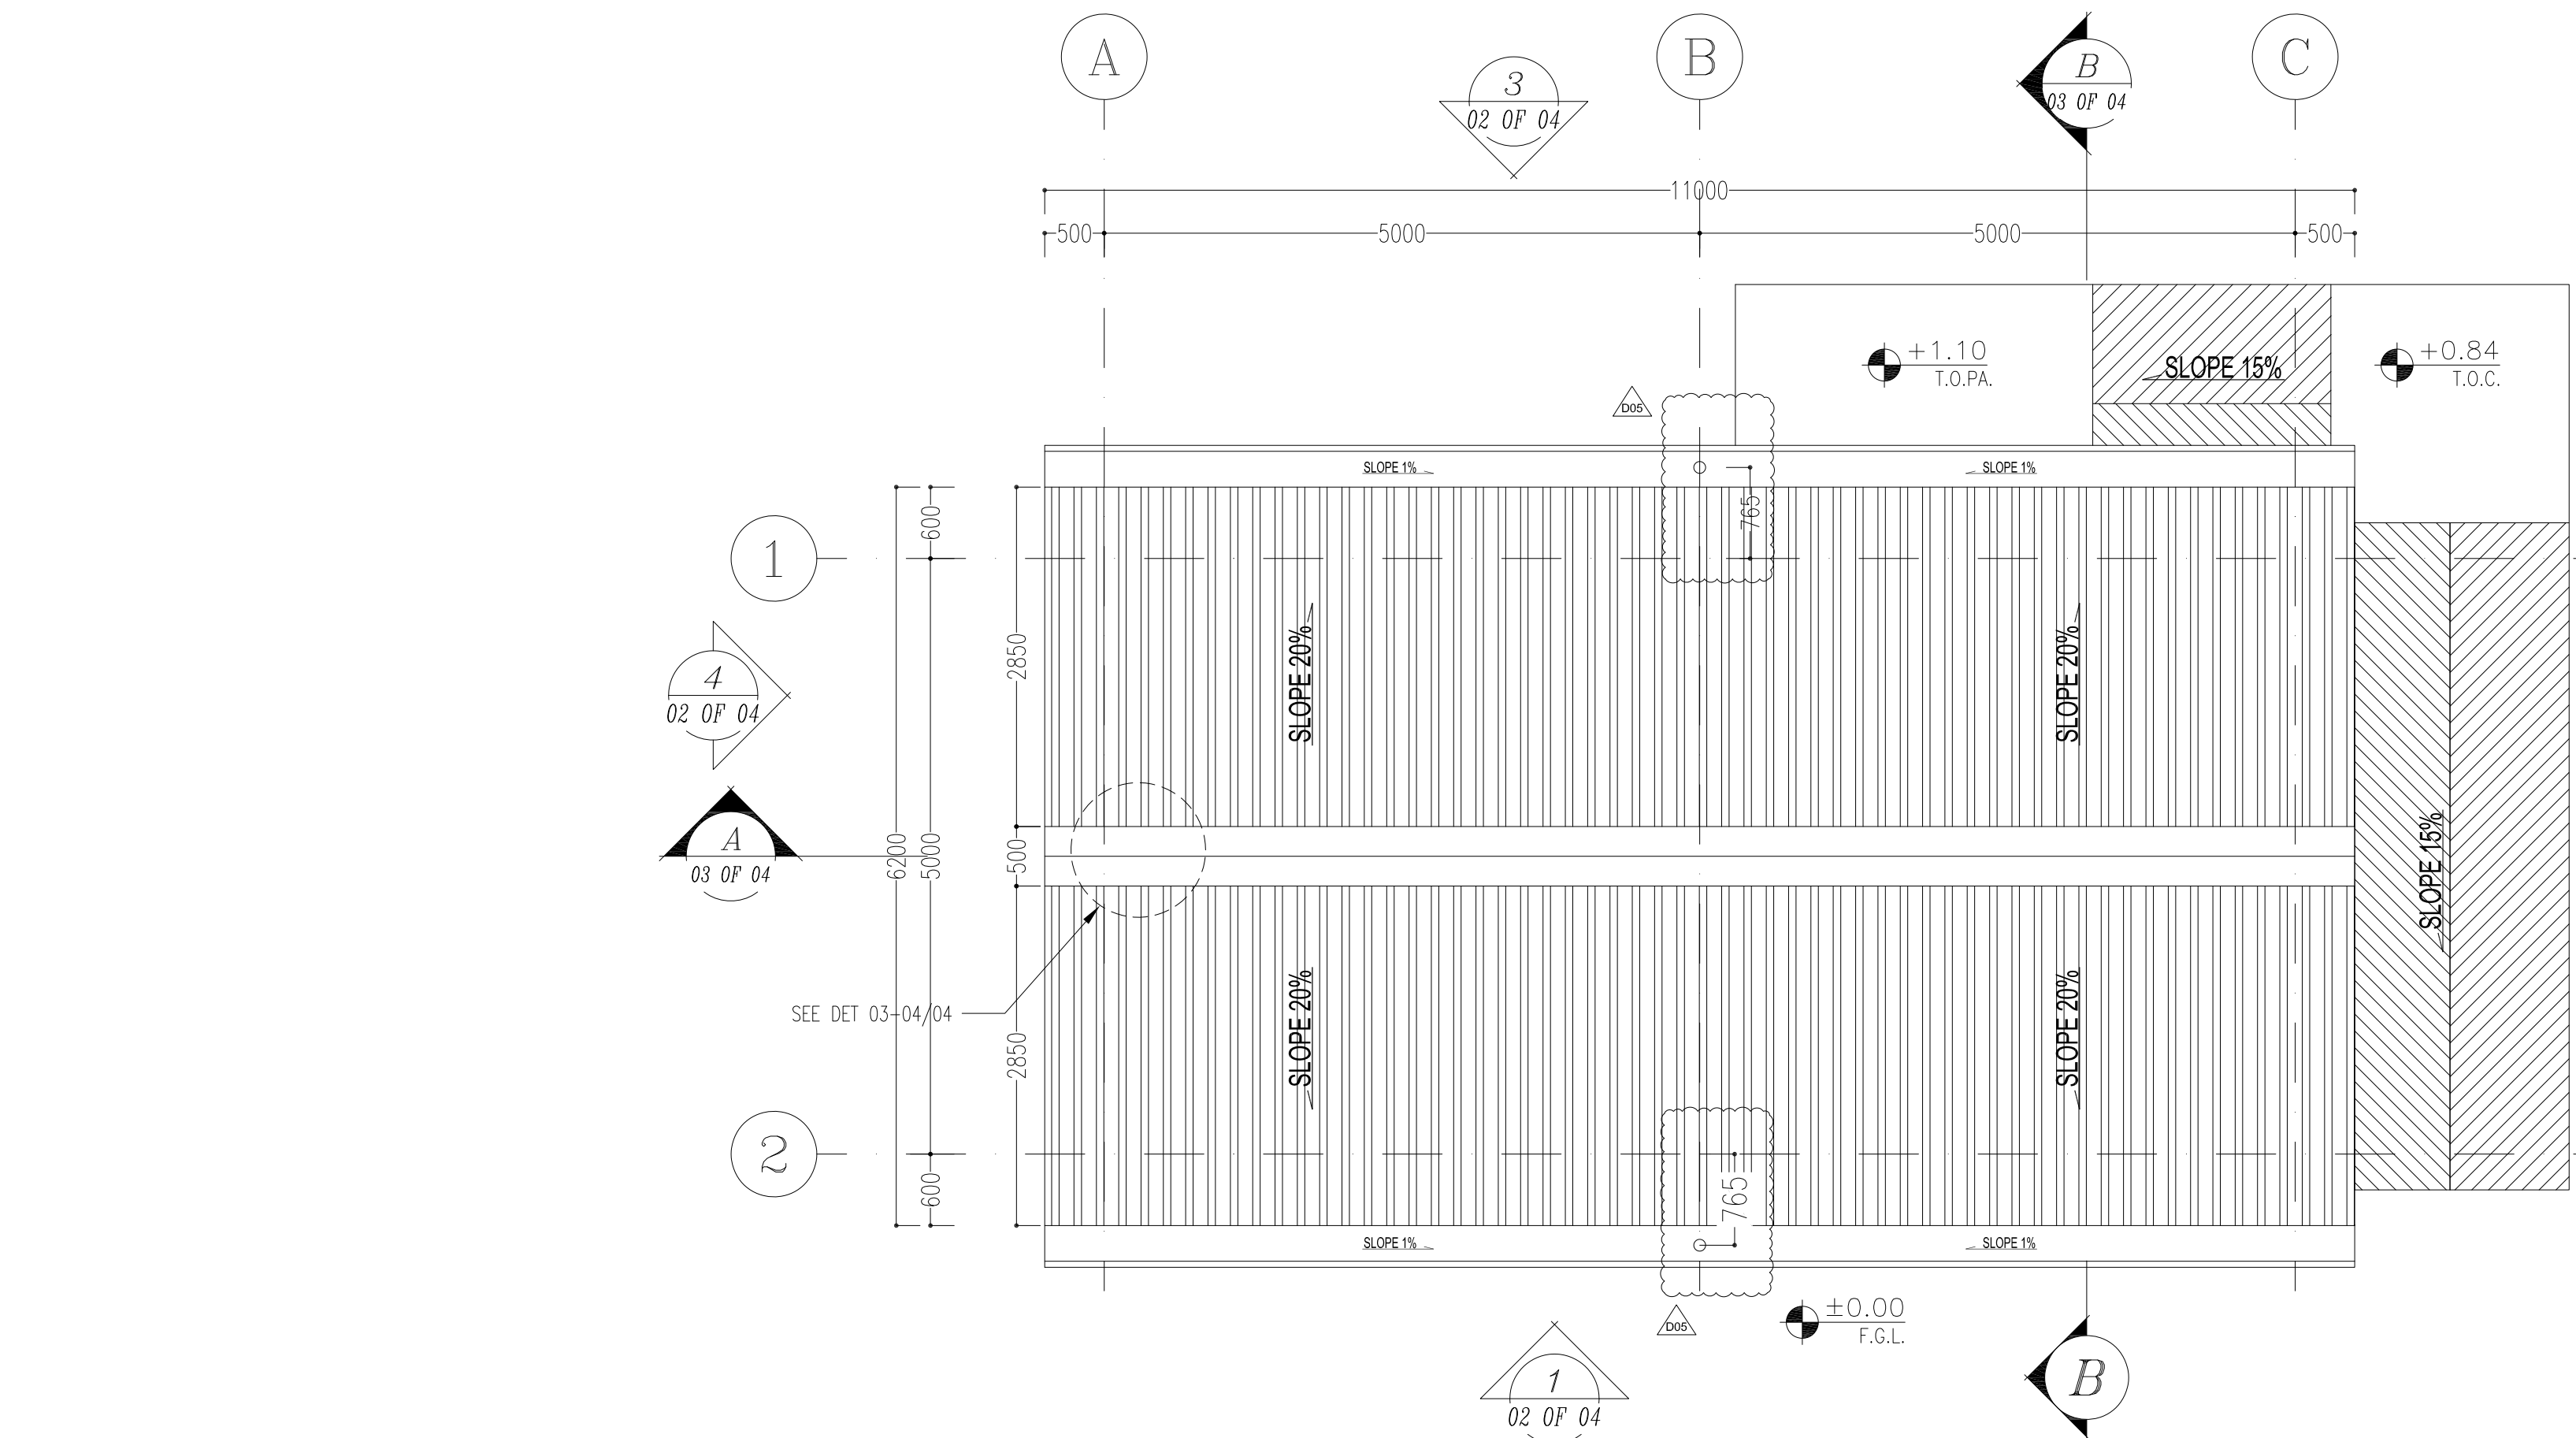

SC.1:50 2 ROOF PLAN

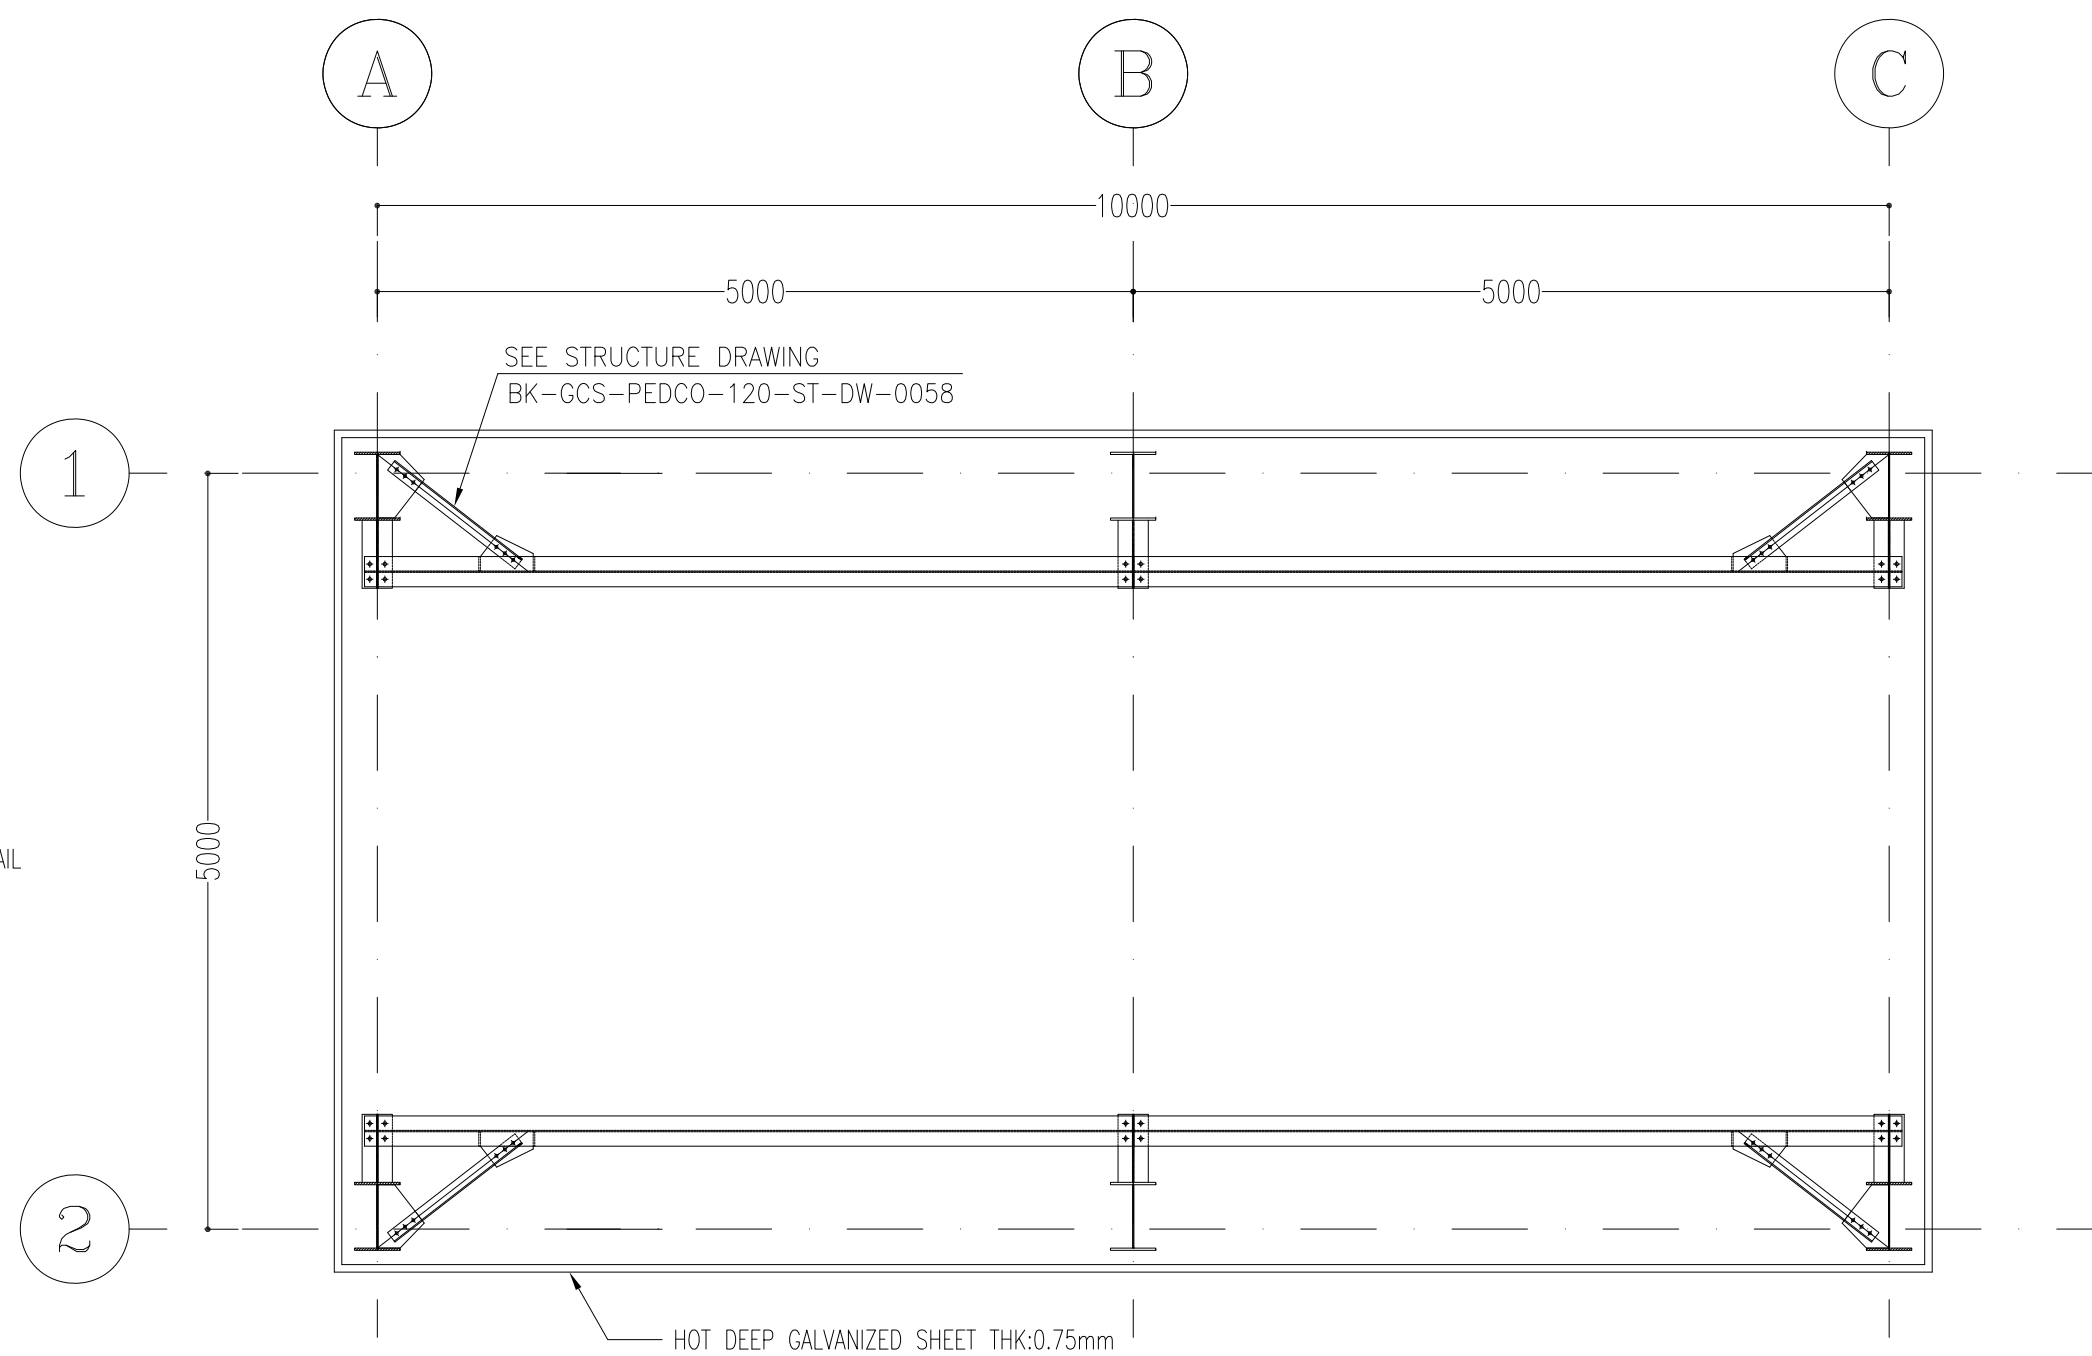


SC.1:50 3 RUNWAY BEAM LAYOUT PLAN

- NOTES
1. ALL DIMENSIONS ARE IN MILLIMETER & ALL ELEVATIONS ARE IN METER.
 2. ALL DIMENSIONS AND ELEVATIONS SHALL BE CHECKED BY THE CONTRACTOR PRIOR TO CONSTRUCTION.
 3. CONTRACTOR SHALL COMPARE ALL ARCHITECTURAL, MECHANICAL, ELECTRICAL, PIPING AND STRUCTURAL DRAWINGS AND IN CASE OF ANY CONFLICTS OR DISCREPANCY, INFORM THE ENGINEER.
 4. ALL MATERIALS ARE SELECTED FROM THE HIGHEST QUALITY AND MUST BE APPROVED BY THE CLIENT.
 5. ALL OPENINGS FOR PIPING/CABLING AND HVAC OPENINGS SHALL BE CONSIDERED AS PER RELATED DRAWINGS BEFORE CONSTRUCTION.
 6. ALL INTERNAL SLOPES FOR FLOOR DRAINS ARE 1% UNLESS STATED.
 7. FINISH GRADE LEVEL (F.G.L.) ±0.00=+11.20 (A.S.L.)

LEGEND	
CORRUGATED GALVANIZED SHEET - THK: 0.75mm	
HANDRAIL	
BRICK FACE	
REINFORCED CONCRETE	
LEAN CONCRETE	
BLOCKAGE	

T.O.B.	TOP OF BRACKET
H.P.G.	HIGHEST POINT OF PAVING
T.O.P.A.	TOP OF PAVEMENT
T.O.P.E.	TOP OF PEDESTAL
B.O.G.U.	BOTTOM OF GUTTER
L.P.L.	LOWEST POINT LEVEL
H.P.L.	HIGHEST POINT LEVEL
B.O.G.	BOTTOM OF GIRT
T.O.S.	TOP OF SHELTER
T.O.C.	TOP OF CONCRETE
T.O.F.	TOP OF FOUNDATION

REFERENCE DRAWING	DRG. No.
ROAD, PAVING AND PLANT FINISH GRADING LAYOUT & SECTIONS	BK-GCS-PEDCO-120-CV-PY-0005
FOUNDATION DRAWING FOR CHEMICAL INJECTION AND STORAGE SHELTER	BK-GCS-PEDCO-120-ST-DW-0057
STRUCTURAL DRAWING FOR CHEMICAL INJECTION AND STORAGE SHELTER	BK-GCS-PEDCO-120-ST-DW-0058
STANDARD DRAWING FOR ARCHITECTURAL DETAILS	BK-GNRL-PEDCO-000-ST-DW-0006
UNIT PLAT PLAN DRAWING	BK-GCS-PEDCO-120-PI-PY-0001
STANDARD DRAWING FOR PAVINGS	BK-GNRL-PEDCO-000-CV-DW-0035
STANDARD DRAWING FOR HANDRAIL	BK-GNRL-PEDCO-000-ST-DW-0006
SITE SEWERAGE SYSTEM LAYOUT & DETAILS	BK-GCS-PEDCO-120-CV-PY-0001
AREA ELECTRICAL CABLE ROUTE & SECTION LAYOUT	BK-GCS-PEDCO-120-EL-PY-0005

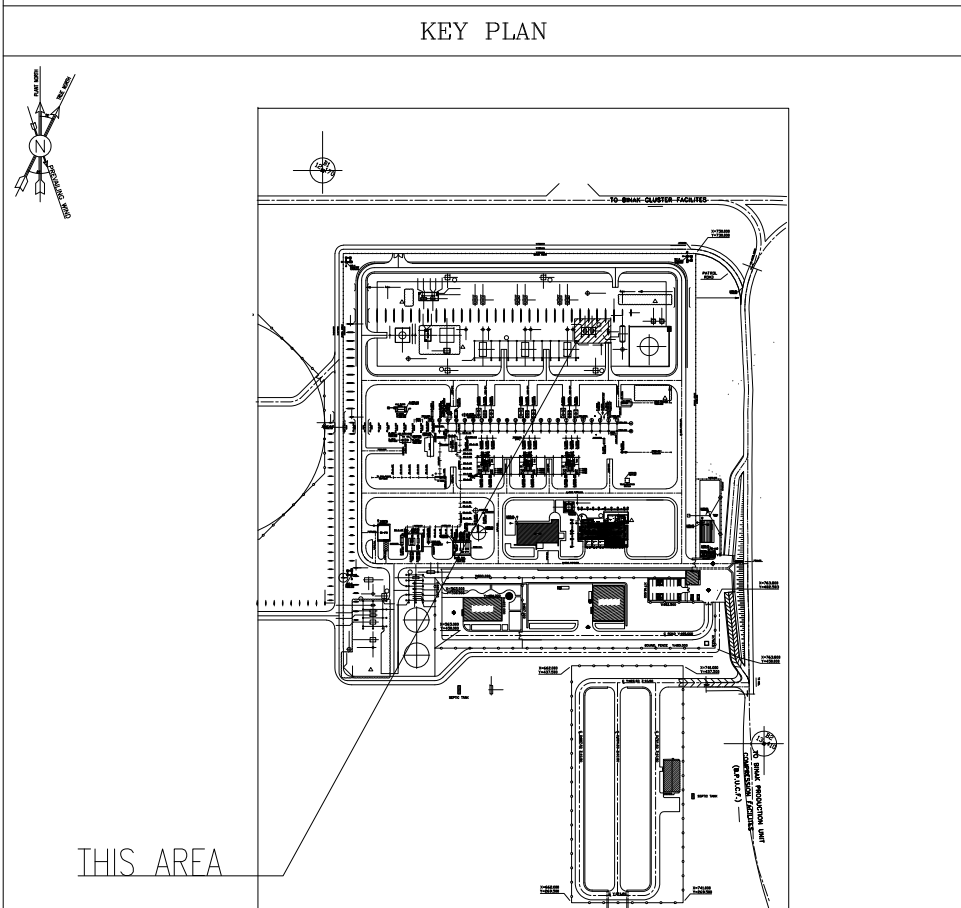

D05	SEP. 2023	APC	R.BERLOUIE	M.PAKHARIAN	A.M.MOHSSENI	***
D04	JUL. 2023	IFA	R.BERLOUIE	M.PAKHARIAN	A.M.MOHSSENI	**
D03	MAY. 2023	IFA	R.BERLOUIE	M.PAKHARIAN	M.Mehrshad	**
D02	JAN. 2023	IFA	R.BERLOUIE	M.PAKHARIAN	M.Mehrshad	**
D01	OCT. 2022	IPC	R.BERLOUIE	M.PAKHARIAN	M.Mehrshad	**
D00	AUG. 2022	IPC	R.BERLOUIE	M.PAKHARIAN	M.Mehrshad	**

REV.	DATE	P.O.I.S	PREP.	CHK.	APP.	AUT.
------	------	---------	-------	------	------	------

PROJECT NAME: BINAK OILFIELD DEVELOPMENT/SURFACE FACILITIES GAS COMPRESSOR STATION

PROJECT NO.:	971020
EPC CONTRACTOR:	EPD/EPC CONTRACTOR (GC):
 HIRGAN ENERGY - DESIGN & INSPECTION COMPANIES	 PETROIRAN DEVELOPMENT COMPANY



DRAWING TITLE:	ARCHITECTURAL DRAWING FOR CHEMICAL INJ. PACKAGES/CHEMICAL STORAGE SHELTER
PLANS	

SCALE	SIZE	DRAWING NO.	SHEET NO.	REV.
AS SHOWN	A1	BK-GCS-PEDCO-120-AR-DW-0004	01 OF 04	D05



THE ORIGINAL AND ALL COPIES OF THIS DRAWING TOGETHER WITH
THE COPYRIGHT THEREIN ARE THE SOLE PROPERTY OF
N.I.S.O.C./ FIELDS

BINAK OILFIELD DEVELOPMENT SURFACE FACILITIES GAS COMPRESSOR STATION						
DATE	SCALE	DRAWING BY	CHECKED BY	PROJECT ENG.		
NO CONSTRUCTION PERMITTED UNLESS DRAWING APPROVED						
APPROVED FOR CONSTRUCTION				BY:		DATE:
BUDGET REF.	LOCATION	SIZE	CLASS	SERIAL NO.	SHEET	REVISION
053-073-9184	F	4	B	709102	01 OF 04	D05

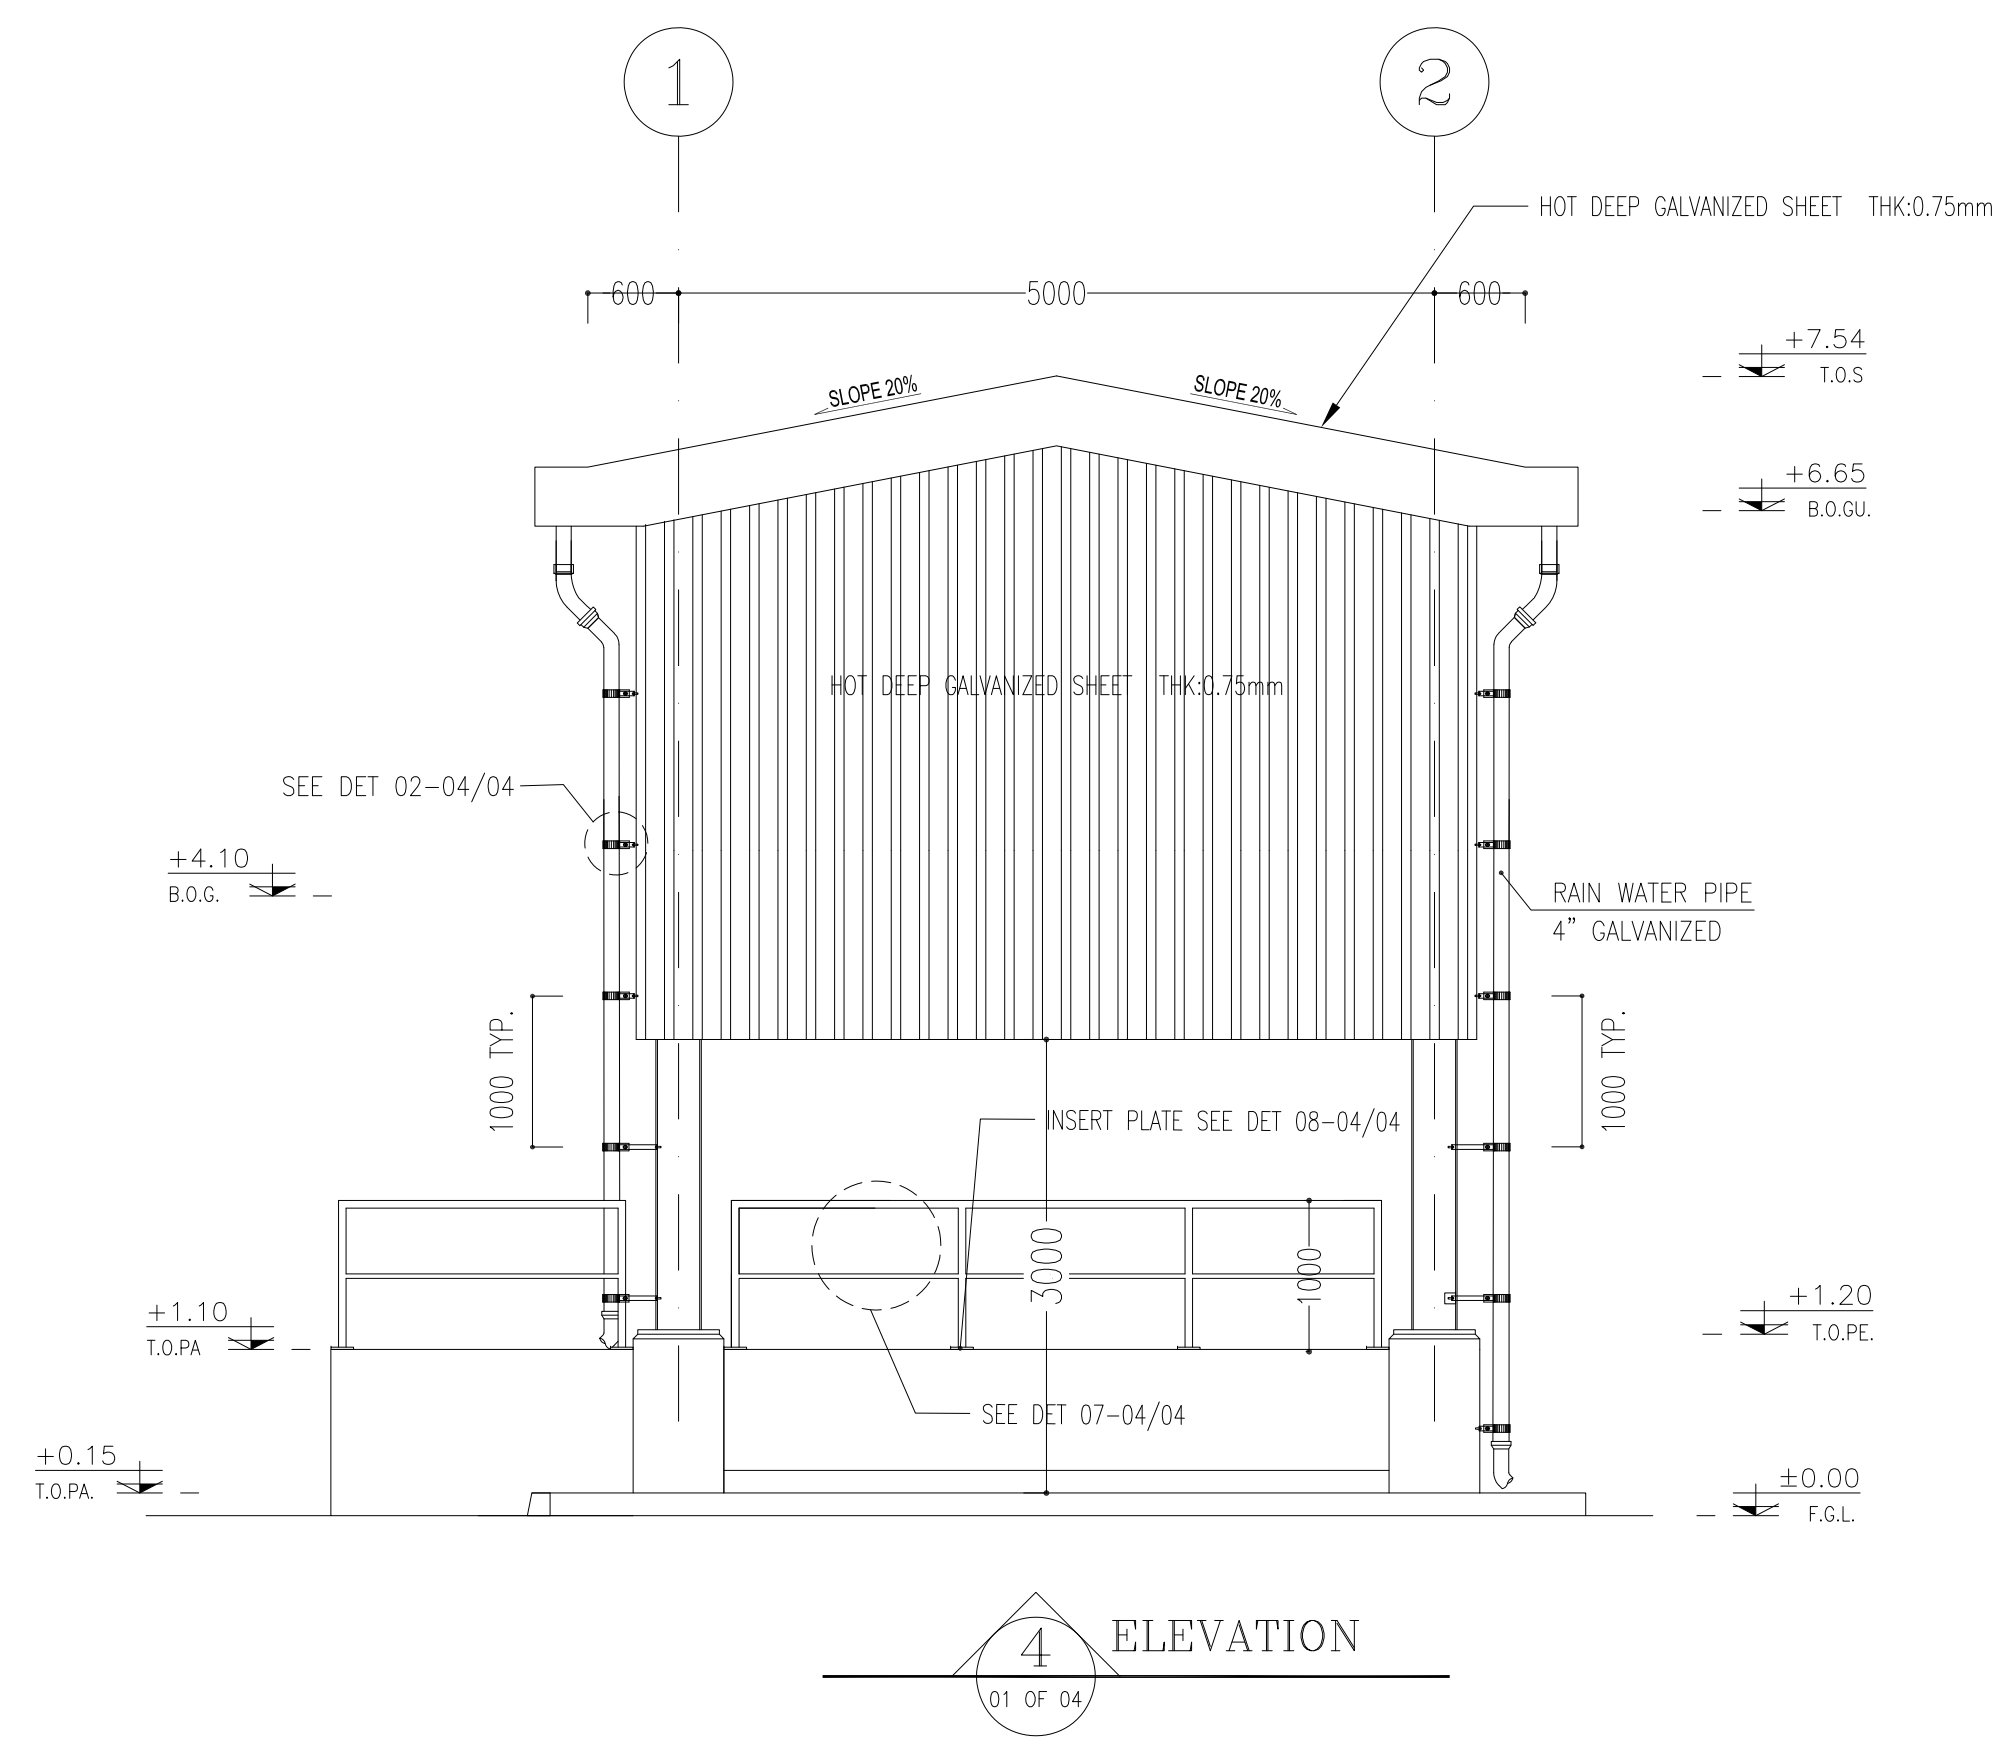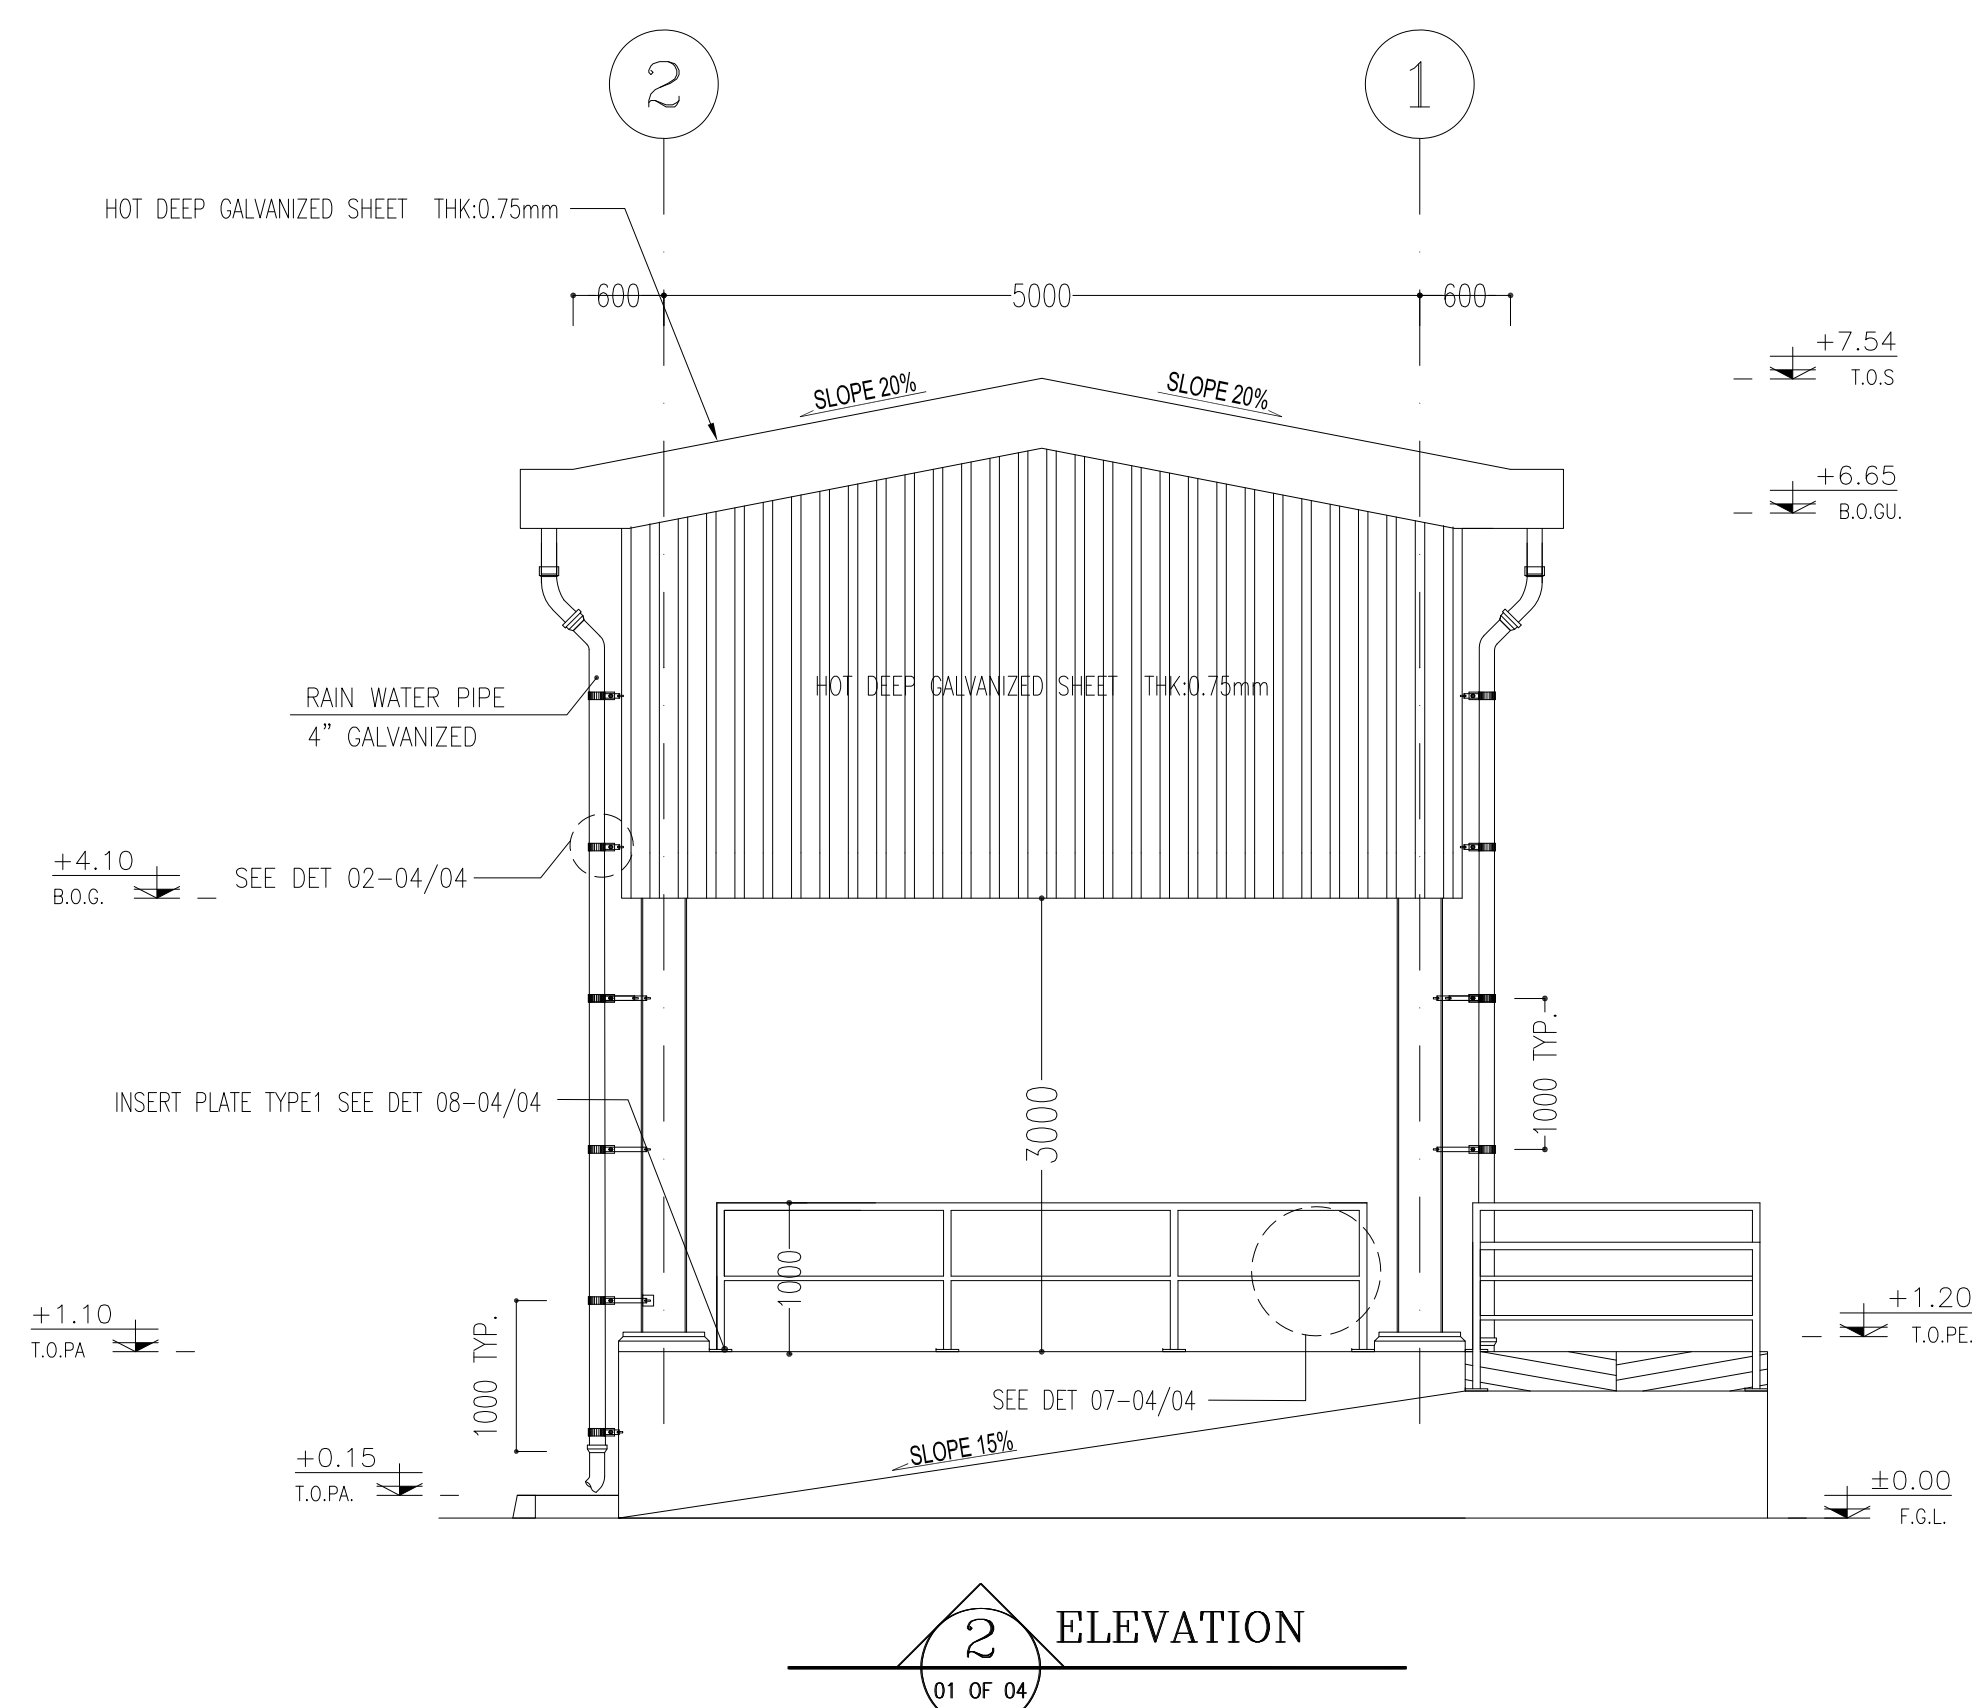

NOTES

1. ALL DIMENSIONS ARE IN MILLIMETER & ALL ELEVATIONS ARE IN METER.
2. ALL DIMENSIONS AND ELEVATIONS SHALL BE CHECKED BY THE CONTRACTOR PRIOR TO CONSTRUCTION.
3. CONTRACTOR SHALL COMPARE ALL ARCHITECTURAL, MECHANICAL, ELECTRICAL, PIPING AND STRUCTURAL DRAWINGS AND IN CASE OF ANY CONFLICTS OR DISCREPANCY, INFORM THE ENGINEER.
4. ALL MATERIALS ARE SELECTED FROM THE HIGHEST QUALITY AND MUST BE APPROVED BY THE CLIENT.
5. ALL OPENINGS FOR PIPING/CABLEING AND HVAC OPENINGS SHALL BE CONSIDERED AS PER RELATED DRAWINGS BEFORE CONSTRUCTION.
6. ALL INTERNAL SLOPES FOR FLOOR DRAINS ARE 1% UNLESS STATED.
7. FINISH GRADE LEVEL (F.G.L.) : ±0.00m=+11.20 (M.S.L.)

LEGEND

CORRUGATED GALVANIZED SHEET – THK. : 0.75mm	
HANDRAIL	
BRICK FACE	
REINFORCED CONCRETE	
LEAN CONCRETE	
BLOCKAGE	

T.O.B. TOP OF BRACKET	
H.P.G. HIGHEST POINT OF PAVING	
T.O.PA TOP OF PAVEMENT	
T.O.PE TOP OF PEDESTAL	
B.O.GU. BOTTOM OF GUTTER	
L.P.L. LOWEST POINT LEVEL	
H.P.L. HIGHEST POINT LEVEL	
B.O.G. BOTTOM OF GIRT	
T.O.S. TOP OF SHELTER	
T.O.C. TOP OF CONCRETE	
T.O.F. TOP OF FOUNDATION	

REFERENCE DRAWING	DRG. No.
ROAD, PAVING AND PLANT FINISH GRADING LAYOUT & SECTIONS	BK-GCS-PEDCO-120-CV-PY-0005
FOUNDATION DRAWING FOR CHEMICAL INJECTION AND STORAGE SHELTER	BK-GCS-PEDCO-120-ST-DW-0057
STRUCTURAL DRAWING FOR CHEMICAL INJECTION AND STORAGE SHELTER	BK-GCS-PEDCO-120-ST-DW-0058
STANDARD DRAWING FOR ARCHITECTURAL DETAILS	BK-GNRL-PEDCO-000-ST-DW-0006
UNIT PLAT PLAN DRAWING	BK-GCS-PEDCO-120-PI-PY-0001
STANDARD DRAWING FOR PAVINGS	BK-GNRL-PEDCO-000-CV-DW-0035
STANDARD DRAWING FOR HANDRAIL	BK-GNRL-PEDCO-000-ST-DW-0006
SITE SEWERAGE SYSTEM LAYOUT & DETAILS	BK-GCS-PEDCO-120-CV-PY-0001
AREA ELECTRICAL CABLE ROUTE & SECTION LAYOUT	BK-GCS-PEDCO-120-EL-PY-0005

KEY PLAN

***	*****	** **	*** ****	** **	*** ****				
REV.	DESCRIPTION	BY	DATE	BY	DATE				
		CHECKED		REV. APPR.					

اصل و کلیه نسخ این نقشه و حق اقتباس متعلق به شرکت ملی منابع نفت خیز جنوب میباشند.



THE ORIGINAL AND ALL COPIES OF THIS DRAWING TOGETHER WITH THE COPYRIGHT THEREIN ARE THE SOLE PROPERTY OF
N.I.S.O.C. / FIELDS

BINAK OILFIELD DEVELOPMENT
SURFACE FACILITIES
GAS COMPRESSOR STATION

DATE	SCALE	DRAWING BY	CHECKED BY	PROJECT ENG.

NO CONSTRUCTION PERMITTED UNLESS DRAWING APPROVED

APPROVED FOR CONSTRUCTION				BY:		DATE:	
BUDGET REF.	LOCATION	SIZE	CLASS	SERIAL NO.	SHEET	REVISION	
053-073-0184	F	4	B	709102	02 OF 04	D05	

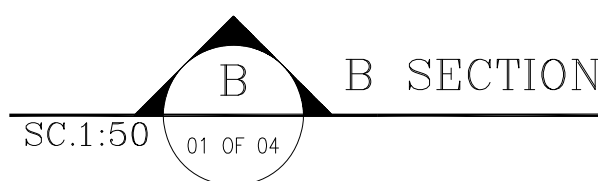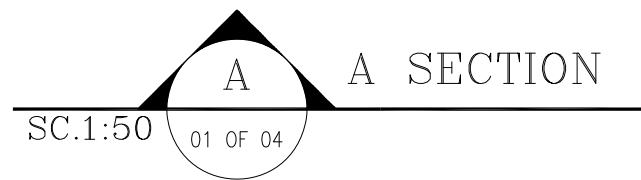

T.O.B.	TOP OF BRACKET
H.P.G.	HIGHEST POINT OF PAVING
T.O.PA	TOP OF PAVEMENT
T.O.PE.	TOP OF PEDESTAL
B.O.GU.	BOTTOM OF GUTTER
L.P.L.	LOWEST POINT LEVEL
H.P.L.	HIGHEST POINT LEVEL
B.O.G.	BOTTOM OF GIRT
T.O.S.	TOP OF SHELTER
T.O.C.	TOP OF CONCRETE
T.O.F.	TOP OF FOUNDATION

KEY PLAN










THIS AREA

اصل و کلیه نسخ این نقشه و حق اقتباس متعلق به شرکت ملی مناطق نفت خیز جنوب میباشد.


THE ORIGINAL AND ALL COPIES OF THIS DRAWING TOGETHER WITH
THE COPYRIGHT THEREIN ARE THE SOLE PROPERTY OF
N.I.S.O.C./ FIELDS

BINAK OILFIELD DEVELOPMENT
SURFACE FACILITIES
GAS COMPRESSOR STATION

R	NO CONSTRUCTION PERMITTED UNLESS DRAWING APPROVED						
	APPROVED FOR CONSTRUCTION				BY:	DATE:	
	BUDGET REF.	LOCATION	SIZE	CLASS	SERIAL NO.	SHEET	REVISION
	053-073-9184	F	4	B	709102	03 OF 04	D05

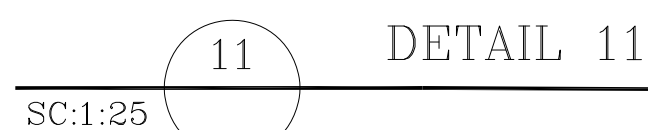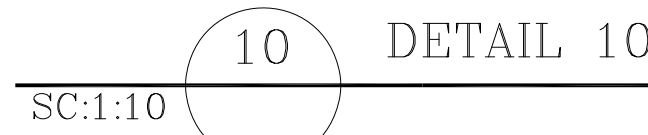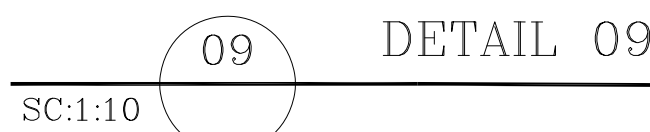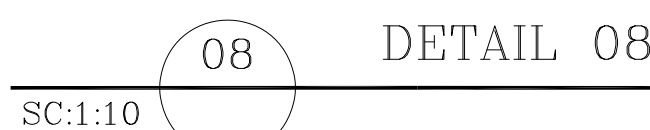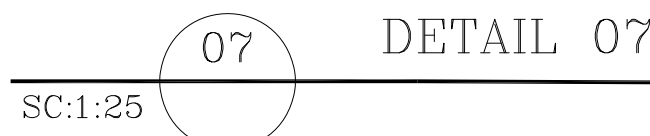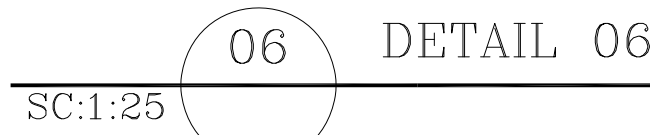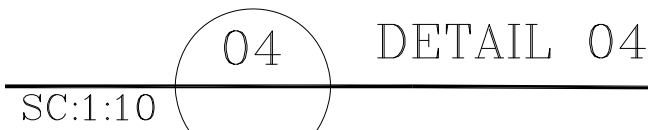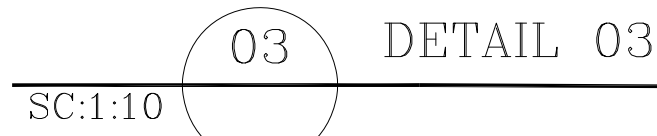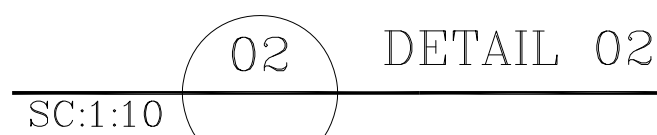

REFERENCE DRAWING	DRG. No.
ROAD, PAVING AND PLANT FINISH GRADING LAYOUT & SECTIONS	BK-GCS-PEDCO-120-CV-PY-0005
FOUNDATION DRAWING FOR CHEMICAL INJECTION AND STORAGE SHELTER	BK-GCS-PEDCO-120-ST-DW-0057
STRUCTURAL DRAWING FOR CHEMICAL INJECTION AND STORAGE SHELTER	BK-GCS-PEDCO-120-ST-DW-0058
STANDARD DRAWING FOR ARCHITECTURAL DETAILS	BK-GNWL-PEDCO-000-ST-DW-0006
UNIT PLAT PLAN DRAWING	BK-GCS-PEDCO-120-PI-PY-0001
STANDARD DRAWING FOR PAVINGS	BK-GNWL-PEDCO-000-CV-DW-0035
STANDARD DRAWING FOR HANDRAIL	BK-GNWL-PEDCO-000-ST-DW-0006
SITE SEWERAGE SYSTEM LAYOUT & DETAILS	BK-GCS-PEDCO-120-CV-PY-0001
AREA ELECTRICAL CABLE ROUTE & SECTION LAYOUT	BK-GCS-PEDCO-120-EL-PY-0005

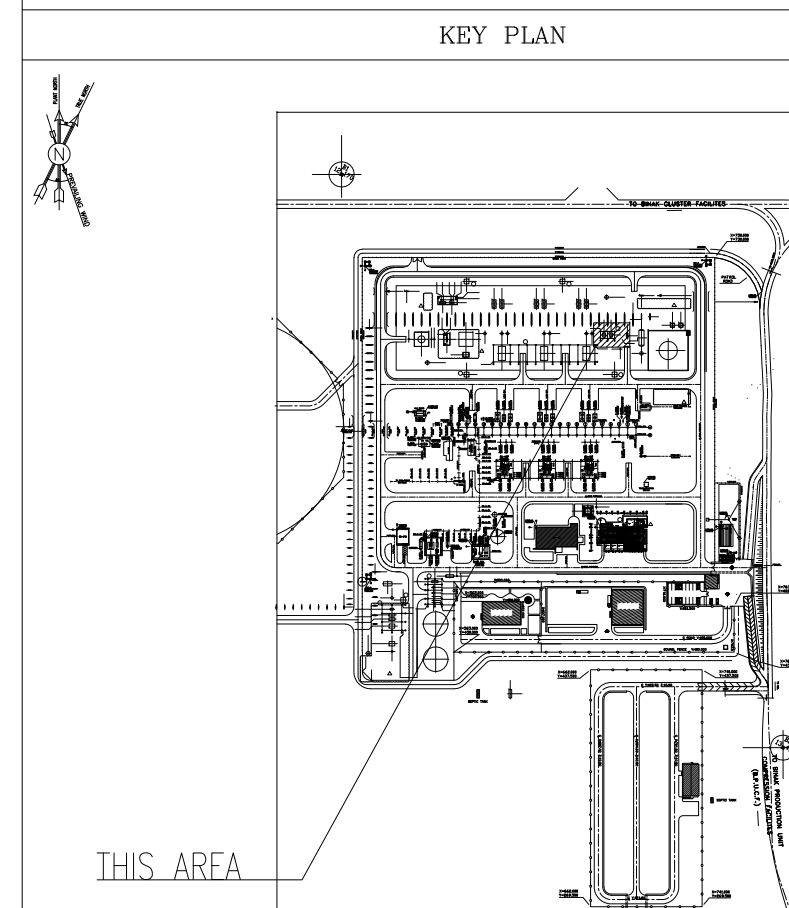

***	*****	** **	*** ****	** **	*** ****
REV.	DESCRIPTION	BY	DATE	BY	DATE
		CHECKED		REV. APPR.	

اصل و کلیه نسخ این نقشه و حق اقتباس متعلق به شرکت ملی مناطق نفت خیز جنوب میباشد.

THE ORIGINAL AND ALL COPIES OF THIS DRAWING TOGETHER WITH
THE COPYRIGHT THEREIN ARE THE SOLE PROPERTY OF
N.I.S.O.C./ FIELDS

BINAK OILFIELD DEVELOPMENT									
SURFACE FACILITIES									
GAS COMPRESSOR STATION									
DATE		SCALE		DRAWING BY		CHECKED BY		PROJECT ENG.	
NO CONSTRUCTION PERMITTED UNLESS DRAWING APPROVED									
APPROVED FOR CONSTRUCTION				BY:		DATE:			
BUDGET REF.		LOCATION	SIZE	CLASS	SERIAL NO.		SHEET		REVISION
053-073-9184		F	4	B	709102		04 OF 04		D05