
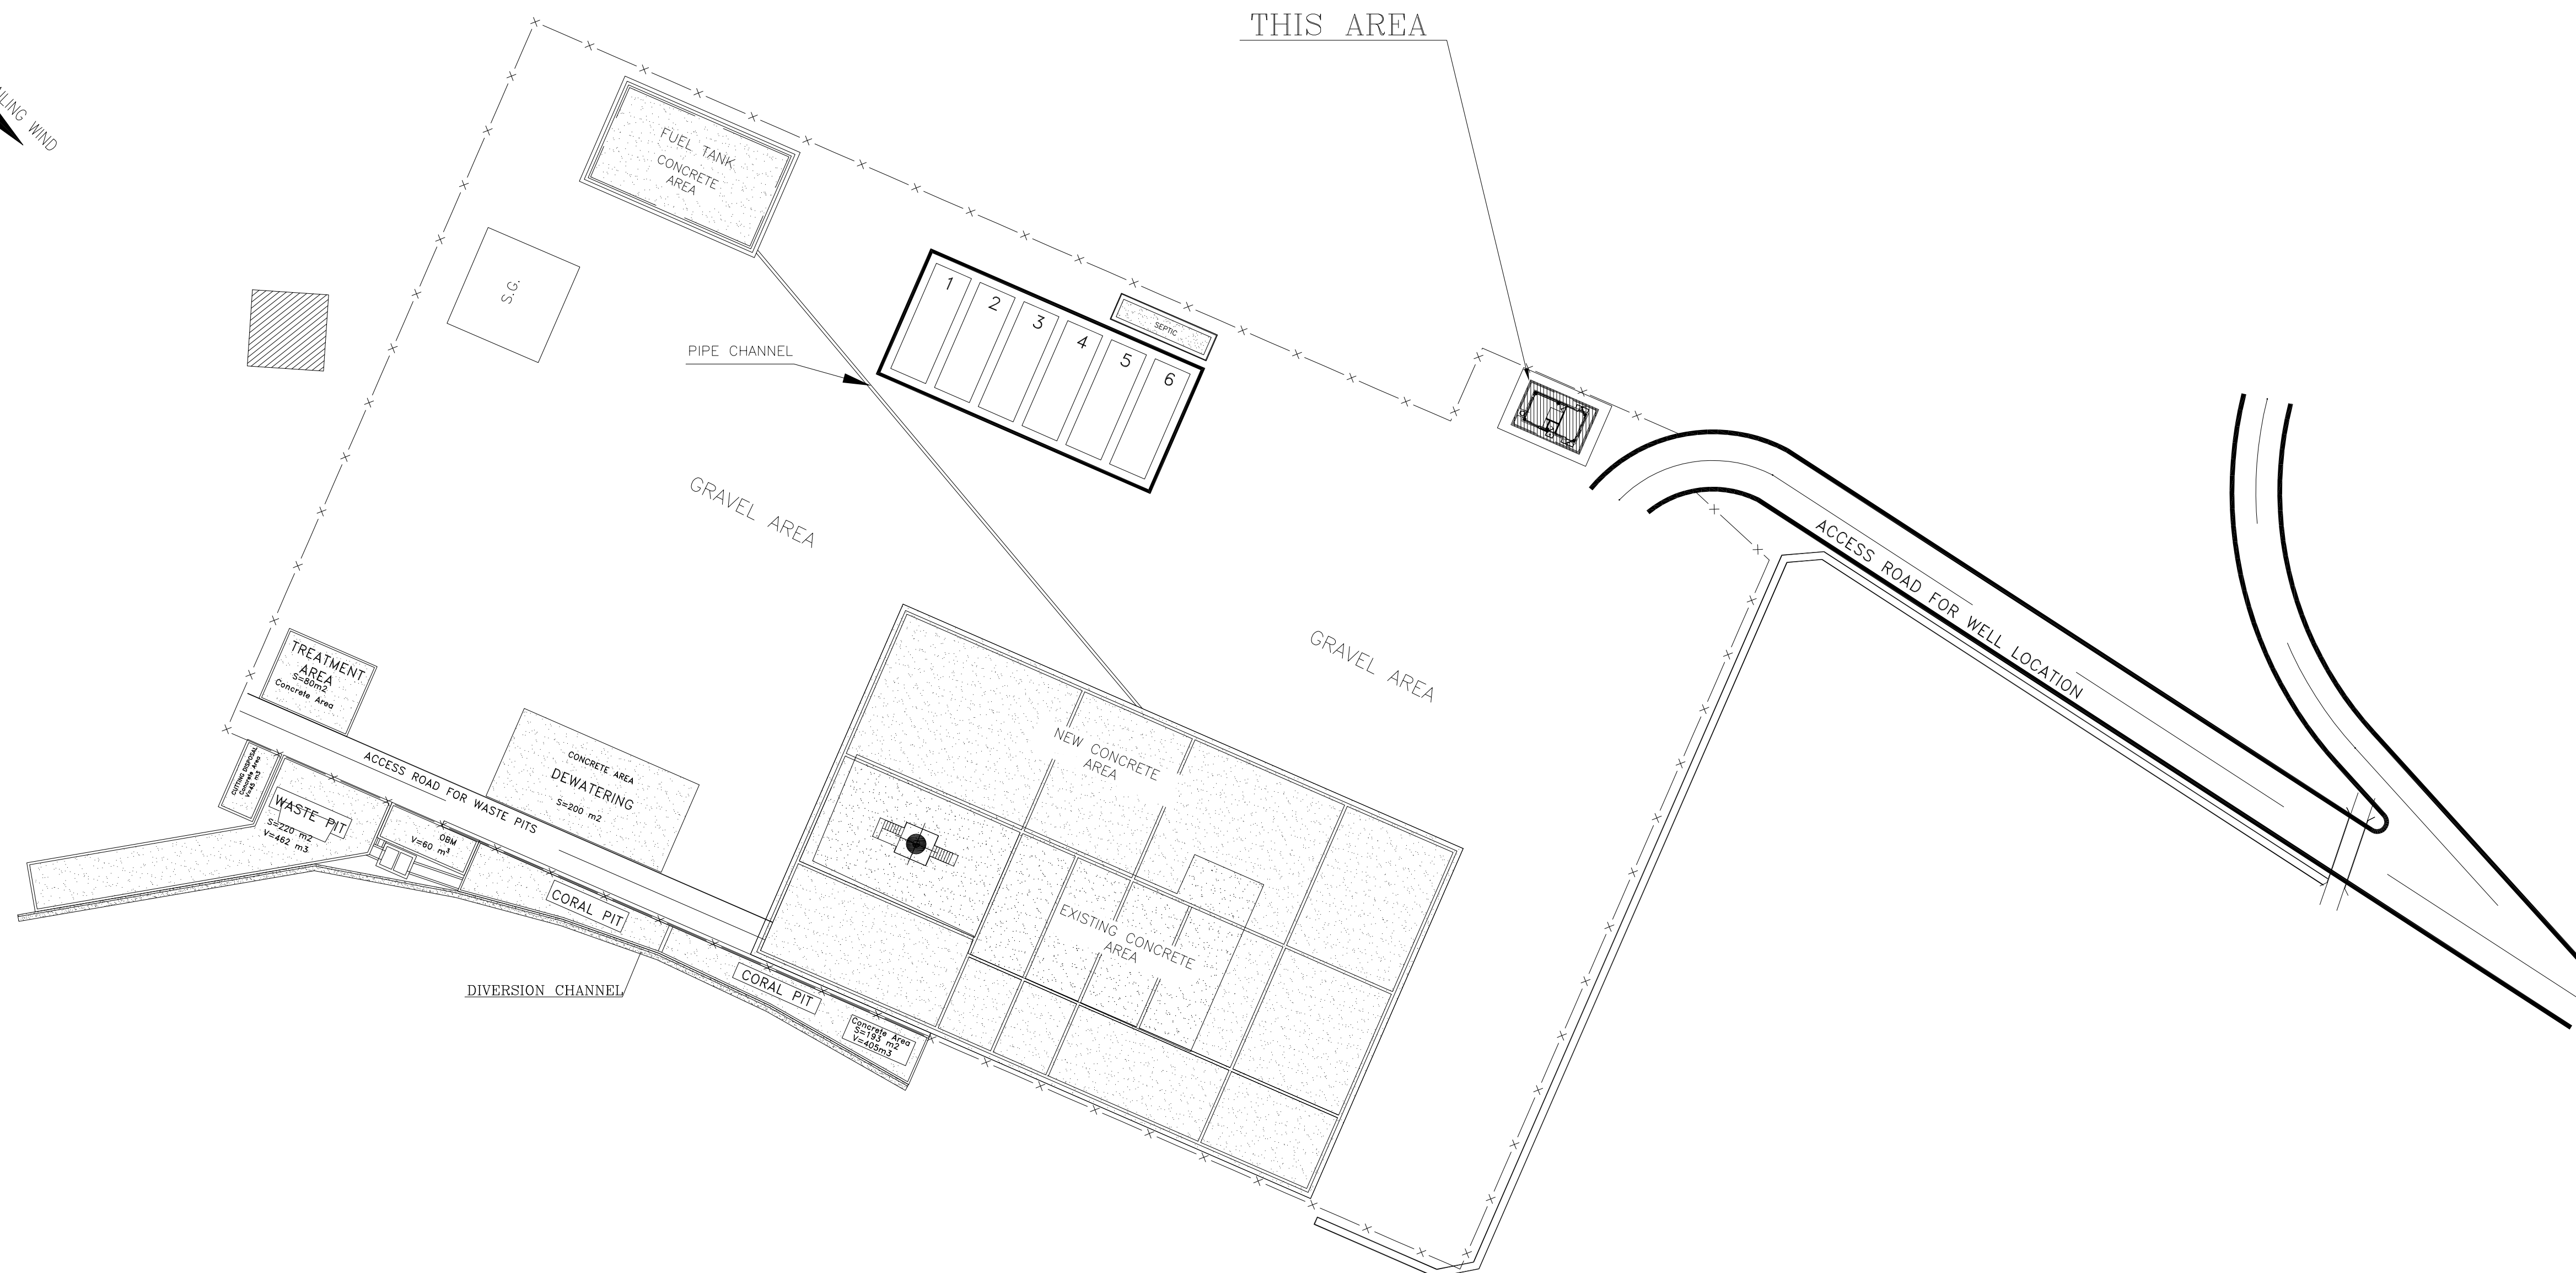


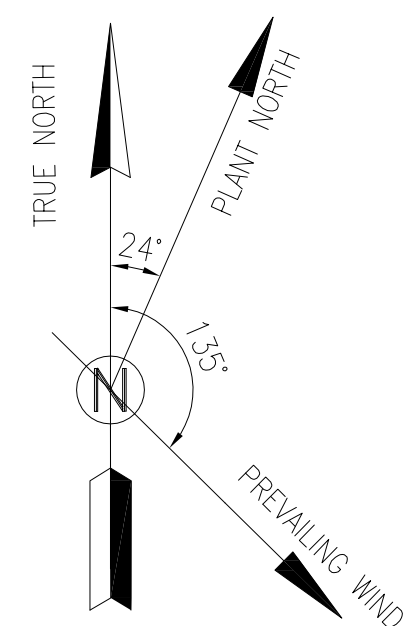

THIS AREA

PIPE CHANNEL

GRAVEL AREA

GRAVEL AREA

DIVERSION CHANNEL

1 LOCATION PLAN


NOTES


- 1- DIMENSIONS ARE IN "mm" and ELEVATIONS IN "m" UNLESS SPECIFIED.
- 2- ALL DIMENSIONS AND ELEVATIONS SHALL BE CHECKED BY THE CONTRACTOR PRIOR TO CONSTRUCTION.
- 3- CONTRACTOR SHALL COMPARE ALL ARCHITECTURAL, MECHANICAL, ELECTRICAL, PIPING AND STRUCTURAL DRAWINGS AND IN CASE OF ANY CONFLICTS OR DISCREPANCY, INFORM THE ENGINEER.
- 4- SLAB ON GRADE SHALL BE CONSTRUCTED AFTER EXECUTION OF CABLE TRENCH & EQUIPMENTS FOUNDATION.
- 5- ALL MATERIALS ARE SELECTED FROM THE HIGHEST QUALITY AND SHALL BE APPROVED BY THE CLIENT.
- 6- FOR COORDINATE REFER TO FINISH GRADING DOCUMENTS.
- 7- FINISH GRADING LEVEL (BK14) ELEVATION : +185.55 m (GLOBAL) = ±0.00 (LOCAL)
- 8- ALL EXTERNAL OPENINGS (WINDOWS AND DOORS) SHALL BE FIRE PROOF.
- 9- DOUBLE GLAZED WINDOW WITH 2mm² Reinforced GLASS AND 6mm GAS FILLED GAP.
- 10- WC DOORS SHALL BE WATERPROOF ABS TYPE WITH CLOSER MECHANISM.
- 11- KNAUF GYPSUM BOARD TILES (60*60) cm (REGULAR 9.5 mm THICKNESS) WITH (1063).
- 12- KNAUF PVC-COATED GYPSUM BOARD TILES (60*60)- (REGULAR 9.5mm THICKNESS) WITH (1063)- (PVC THICKNESS 0.55mm).

LEGEND			
	BRICK WORK		BRICK FACING
	REINFORCED CONCRETE		GRAVEL
	TERRAZZO TILE		LEAN CONCRETE
	GYPSUM BOARD		BLOCKAGE
	BRICK FACING		SAND CEMENT MORTAR
	PAINTED ALUMINUM STRIP (DUMPA)		
	CERAMIC TILES (30x30)		


F.F.L.	FINISHED FLOOR LEVEL
T.O.W.A.	TOP OF WALKWAY
T.O.P.	TOP OF PARAPET
B.O.D.	BOTTOM OF DOOR
T.O.W.	TOP OF WINDOW
B.O.W.	BOTTOM OF WINDOW
T.O.S.	TOP OF SLAB
T.O.D.	TOP OF DOOR
T.O.C.A.	TOP OF CAGE
B.O.C.A.	BOTTOM OF CAGE
B.O.O.	BOTTOM OF OPENING
B.O.S.	BOTTOM OF SUSPENDED CEILING

REFERENCE DRAWING	DRG. No.
STANDARD DRAWING FOR ARCHITECTURAL DETAILS	BK-GNRL-PEDCO-000-AR-DW-0000
STANDARD DETAILS FOR LADDER & SAFETY CAGE	BK-GNRL-PEDCO-000-ST-DW-0000
FOUNDATION DRAWING FOR SECURITY BUILDING FOR WELL PADS – BK-14	BK-BK14-PEDCO-110-ST-DW-0002
STRUCTURAL DRAWING FOR SECURITY BUILDING FOR WELL PADS – BK-14	BK-BK14-PEDCO-110-ST-DW-0002
HVAC SYSTEM LAYOUT FOR SECURITY BUILDING – BK-4	BK-BK14-PEDCO-110-HV-PY-0002
PLUMBING & SEWAGE PIPING LAYOUT FOR SECURITY BUILDING – BK14	BK-BK14-PEDCO-110-HV-PY-0004
LIGHTING & SMALL POWER LAYOUT FOR SECURITY BUILDING	BK-SSGR-PEDCO-110-EL-PY-0005

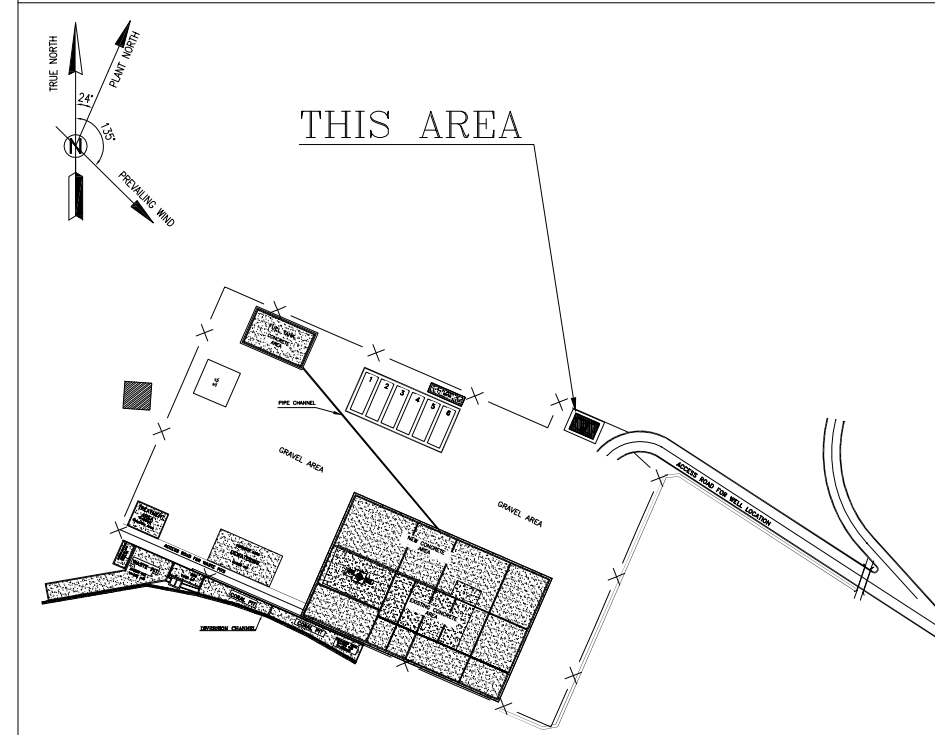
KEY PLAN[illegible]

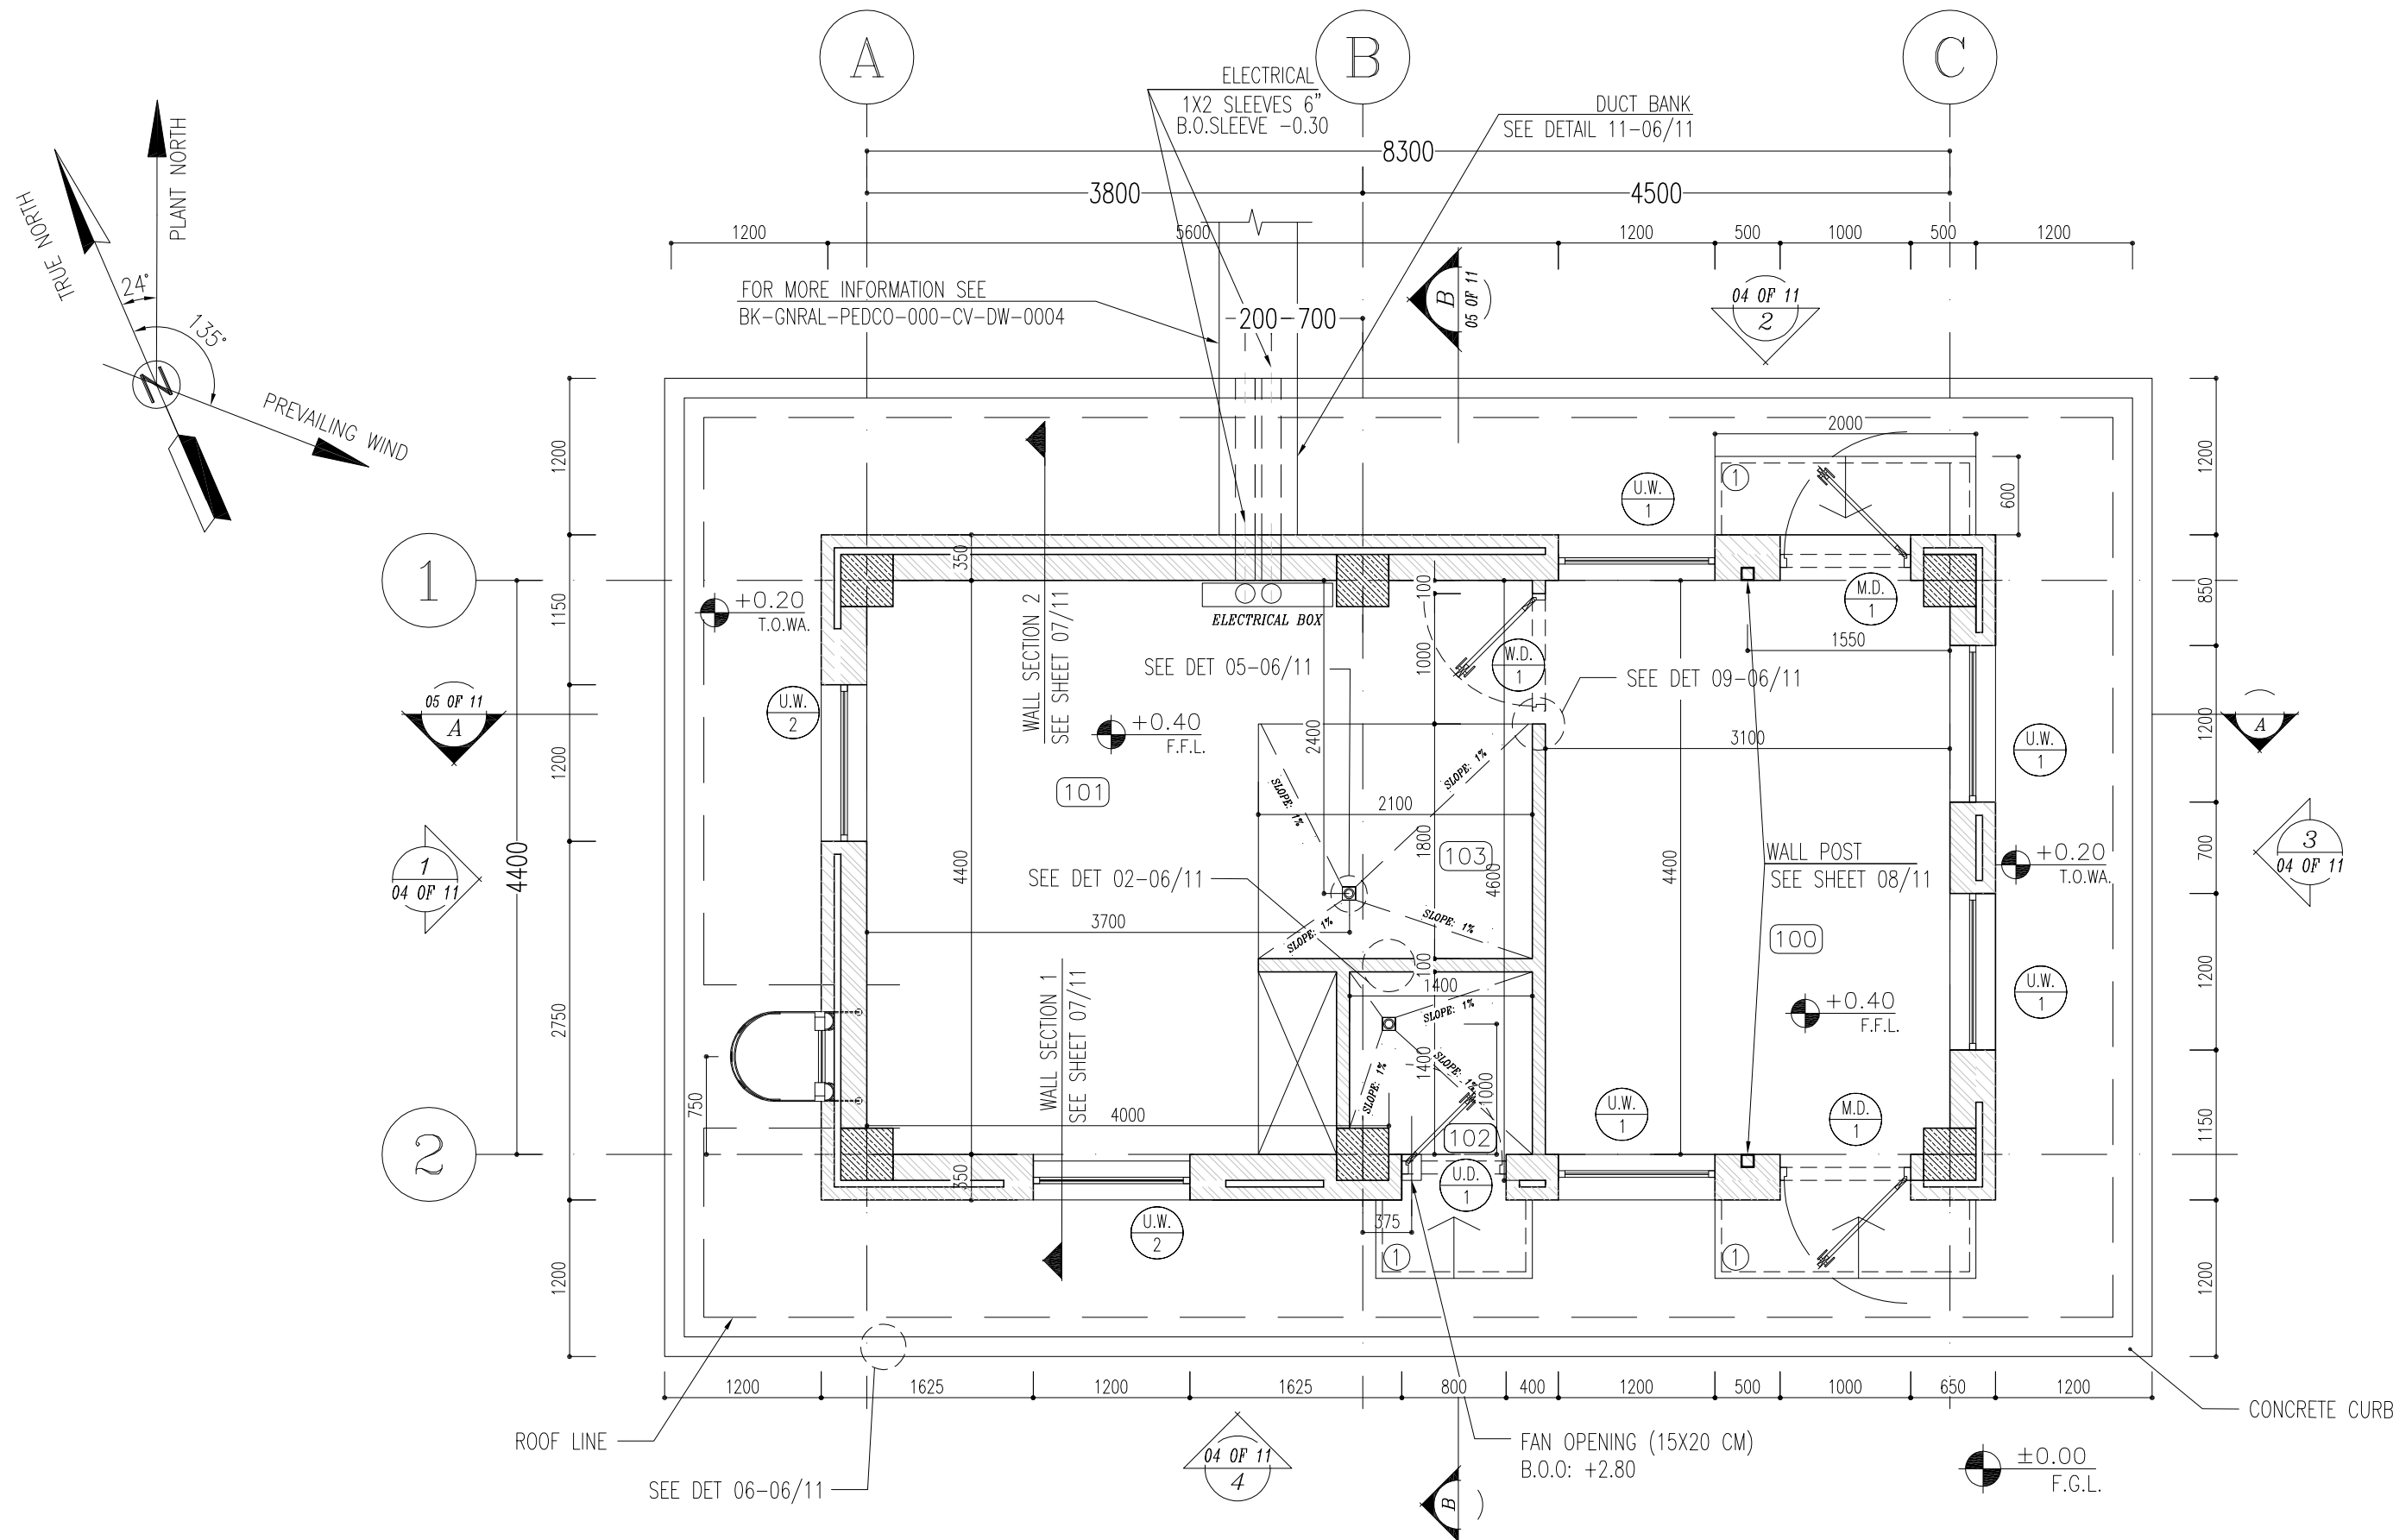

SC.1:50 2 DIMENSION PLAN

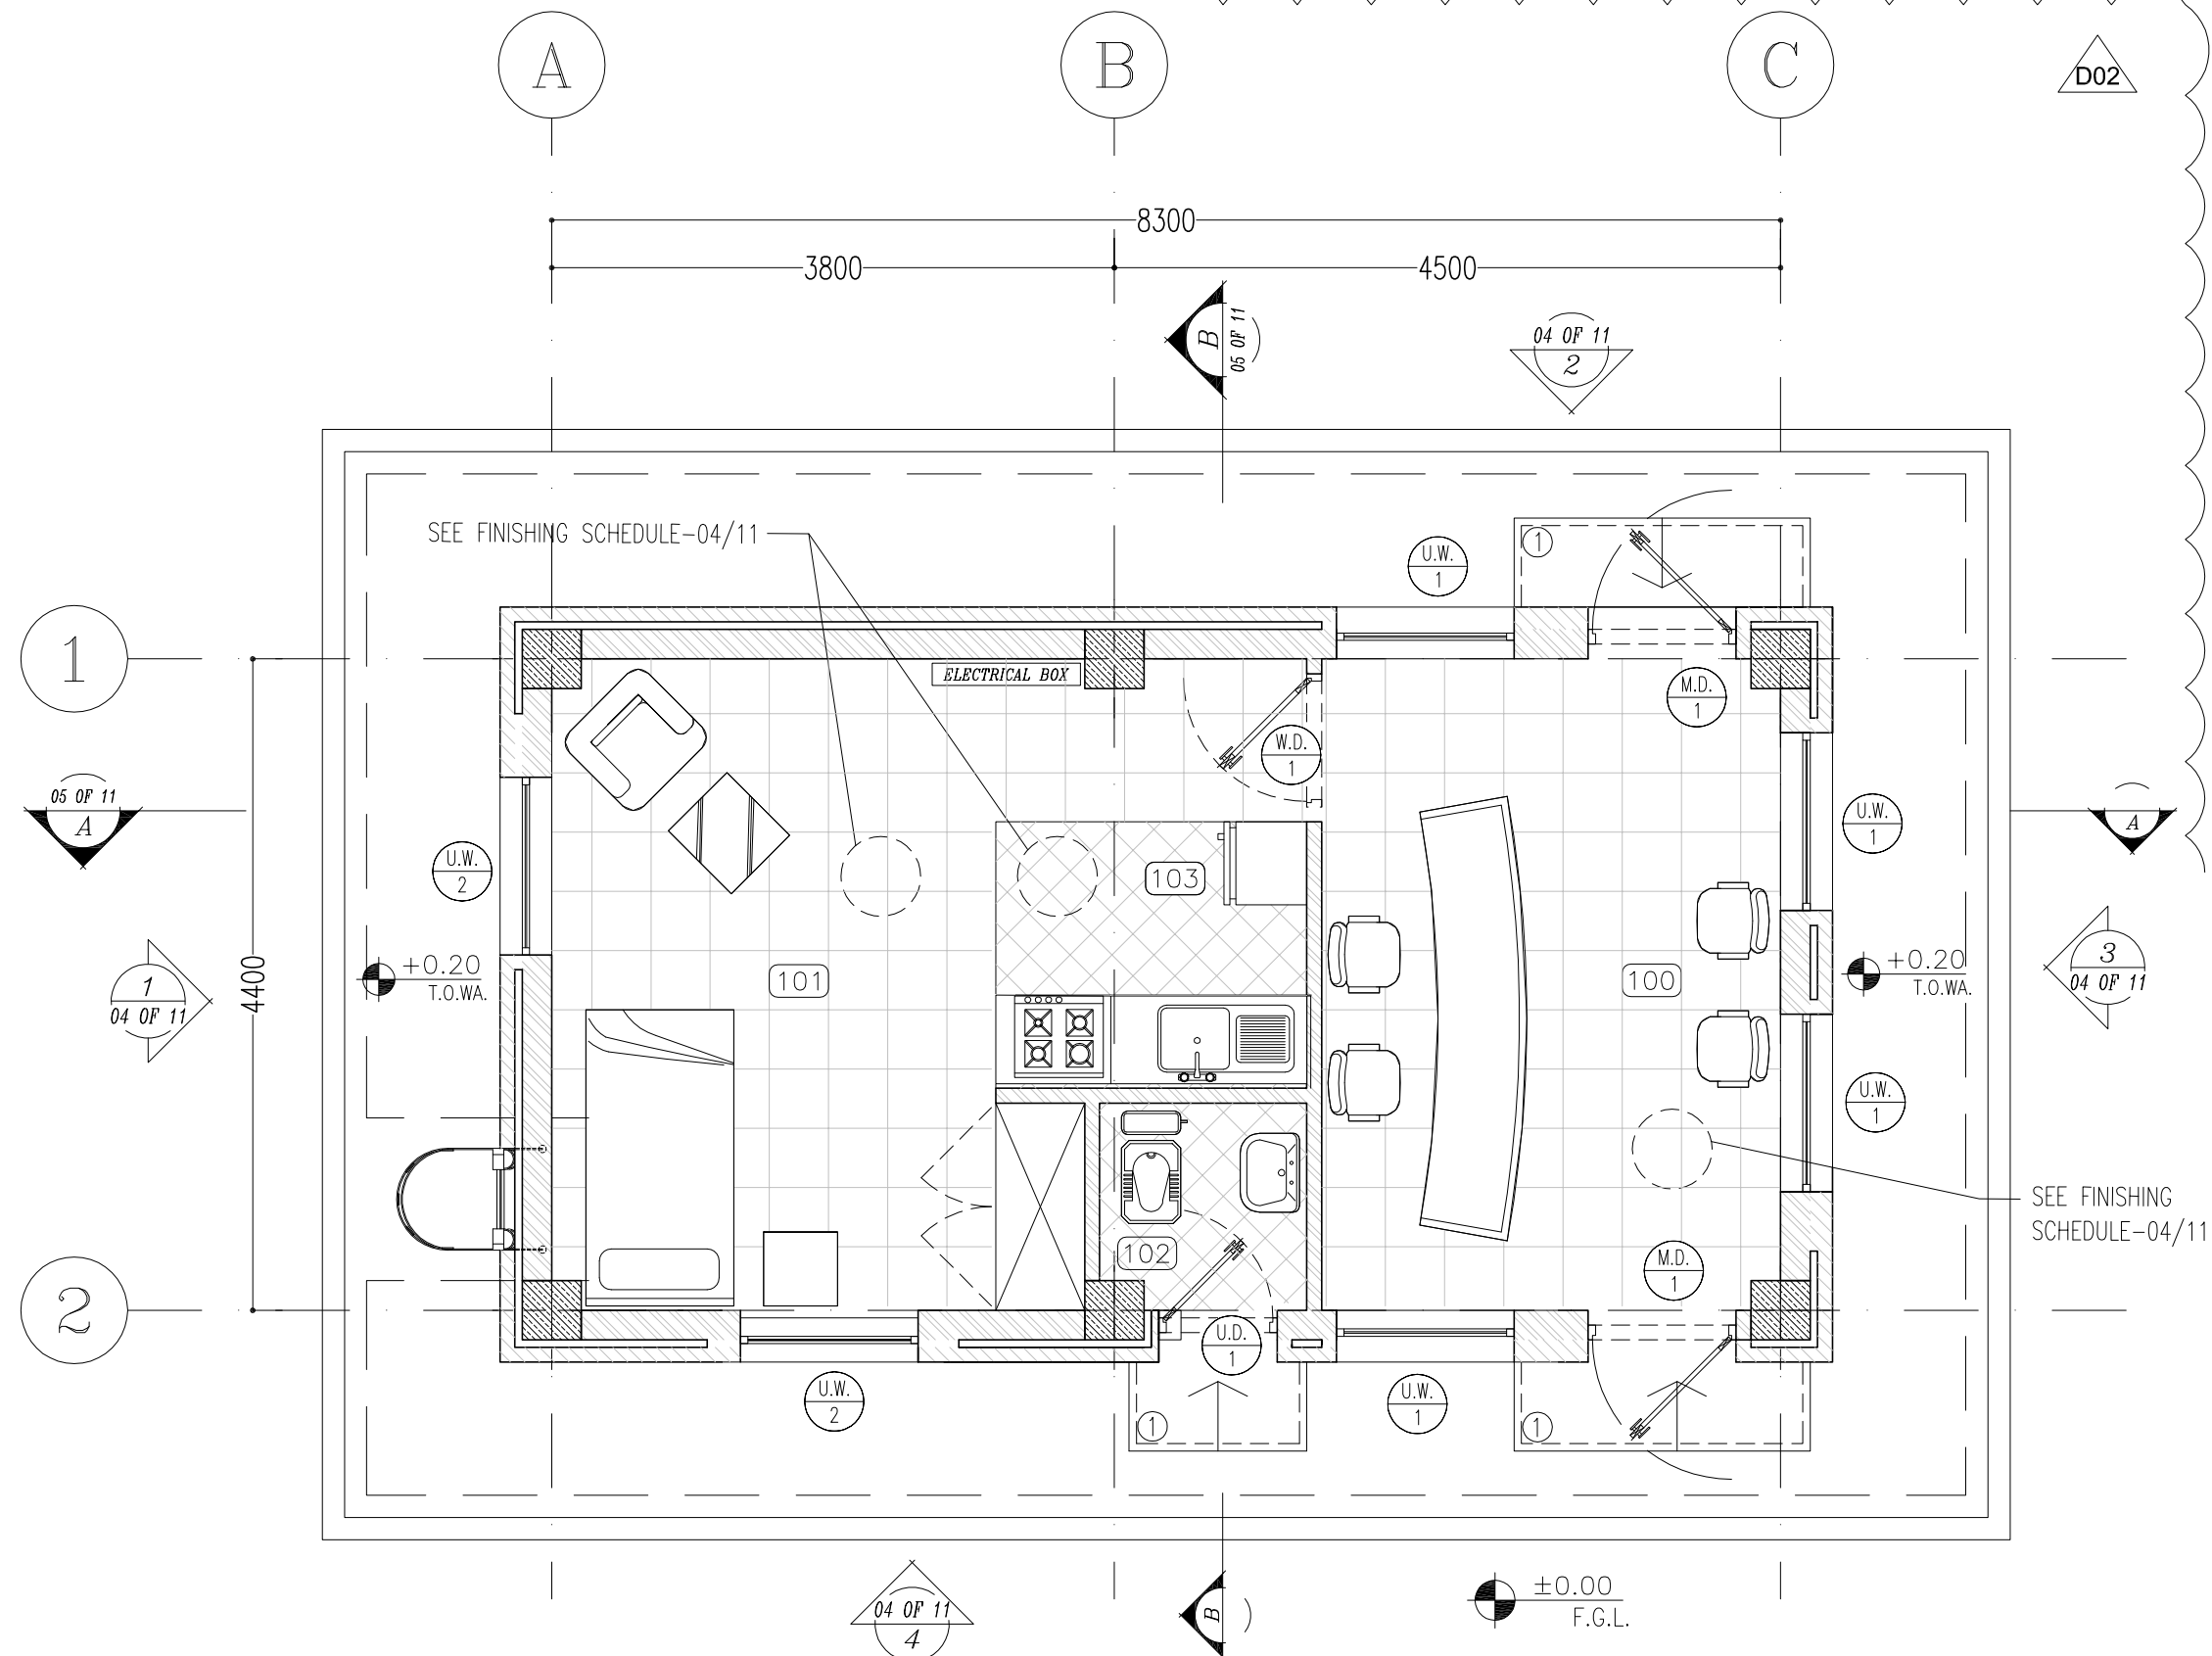

SC.1:50 3 FURNITURE & FLOORING PLAN

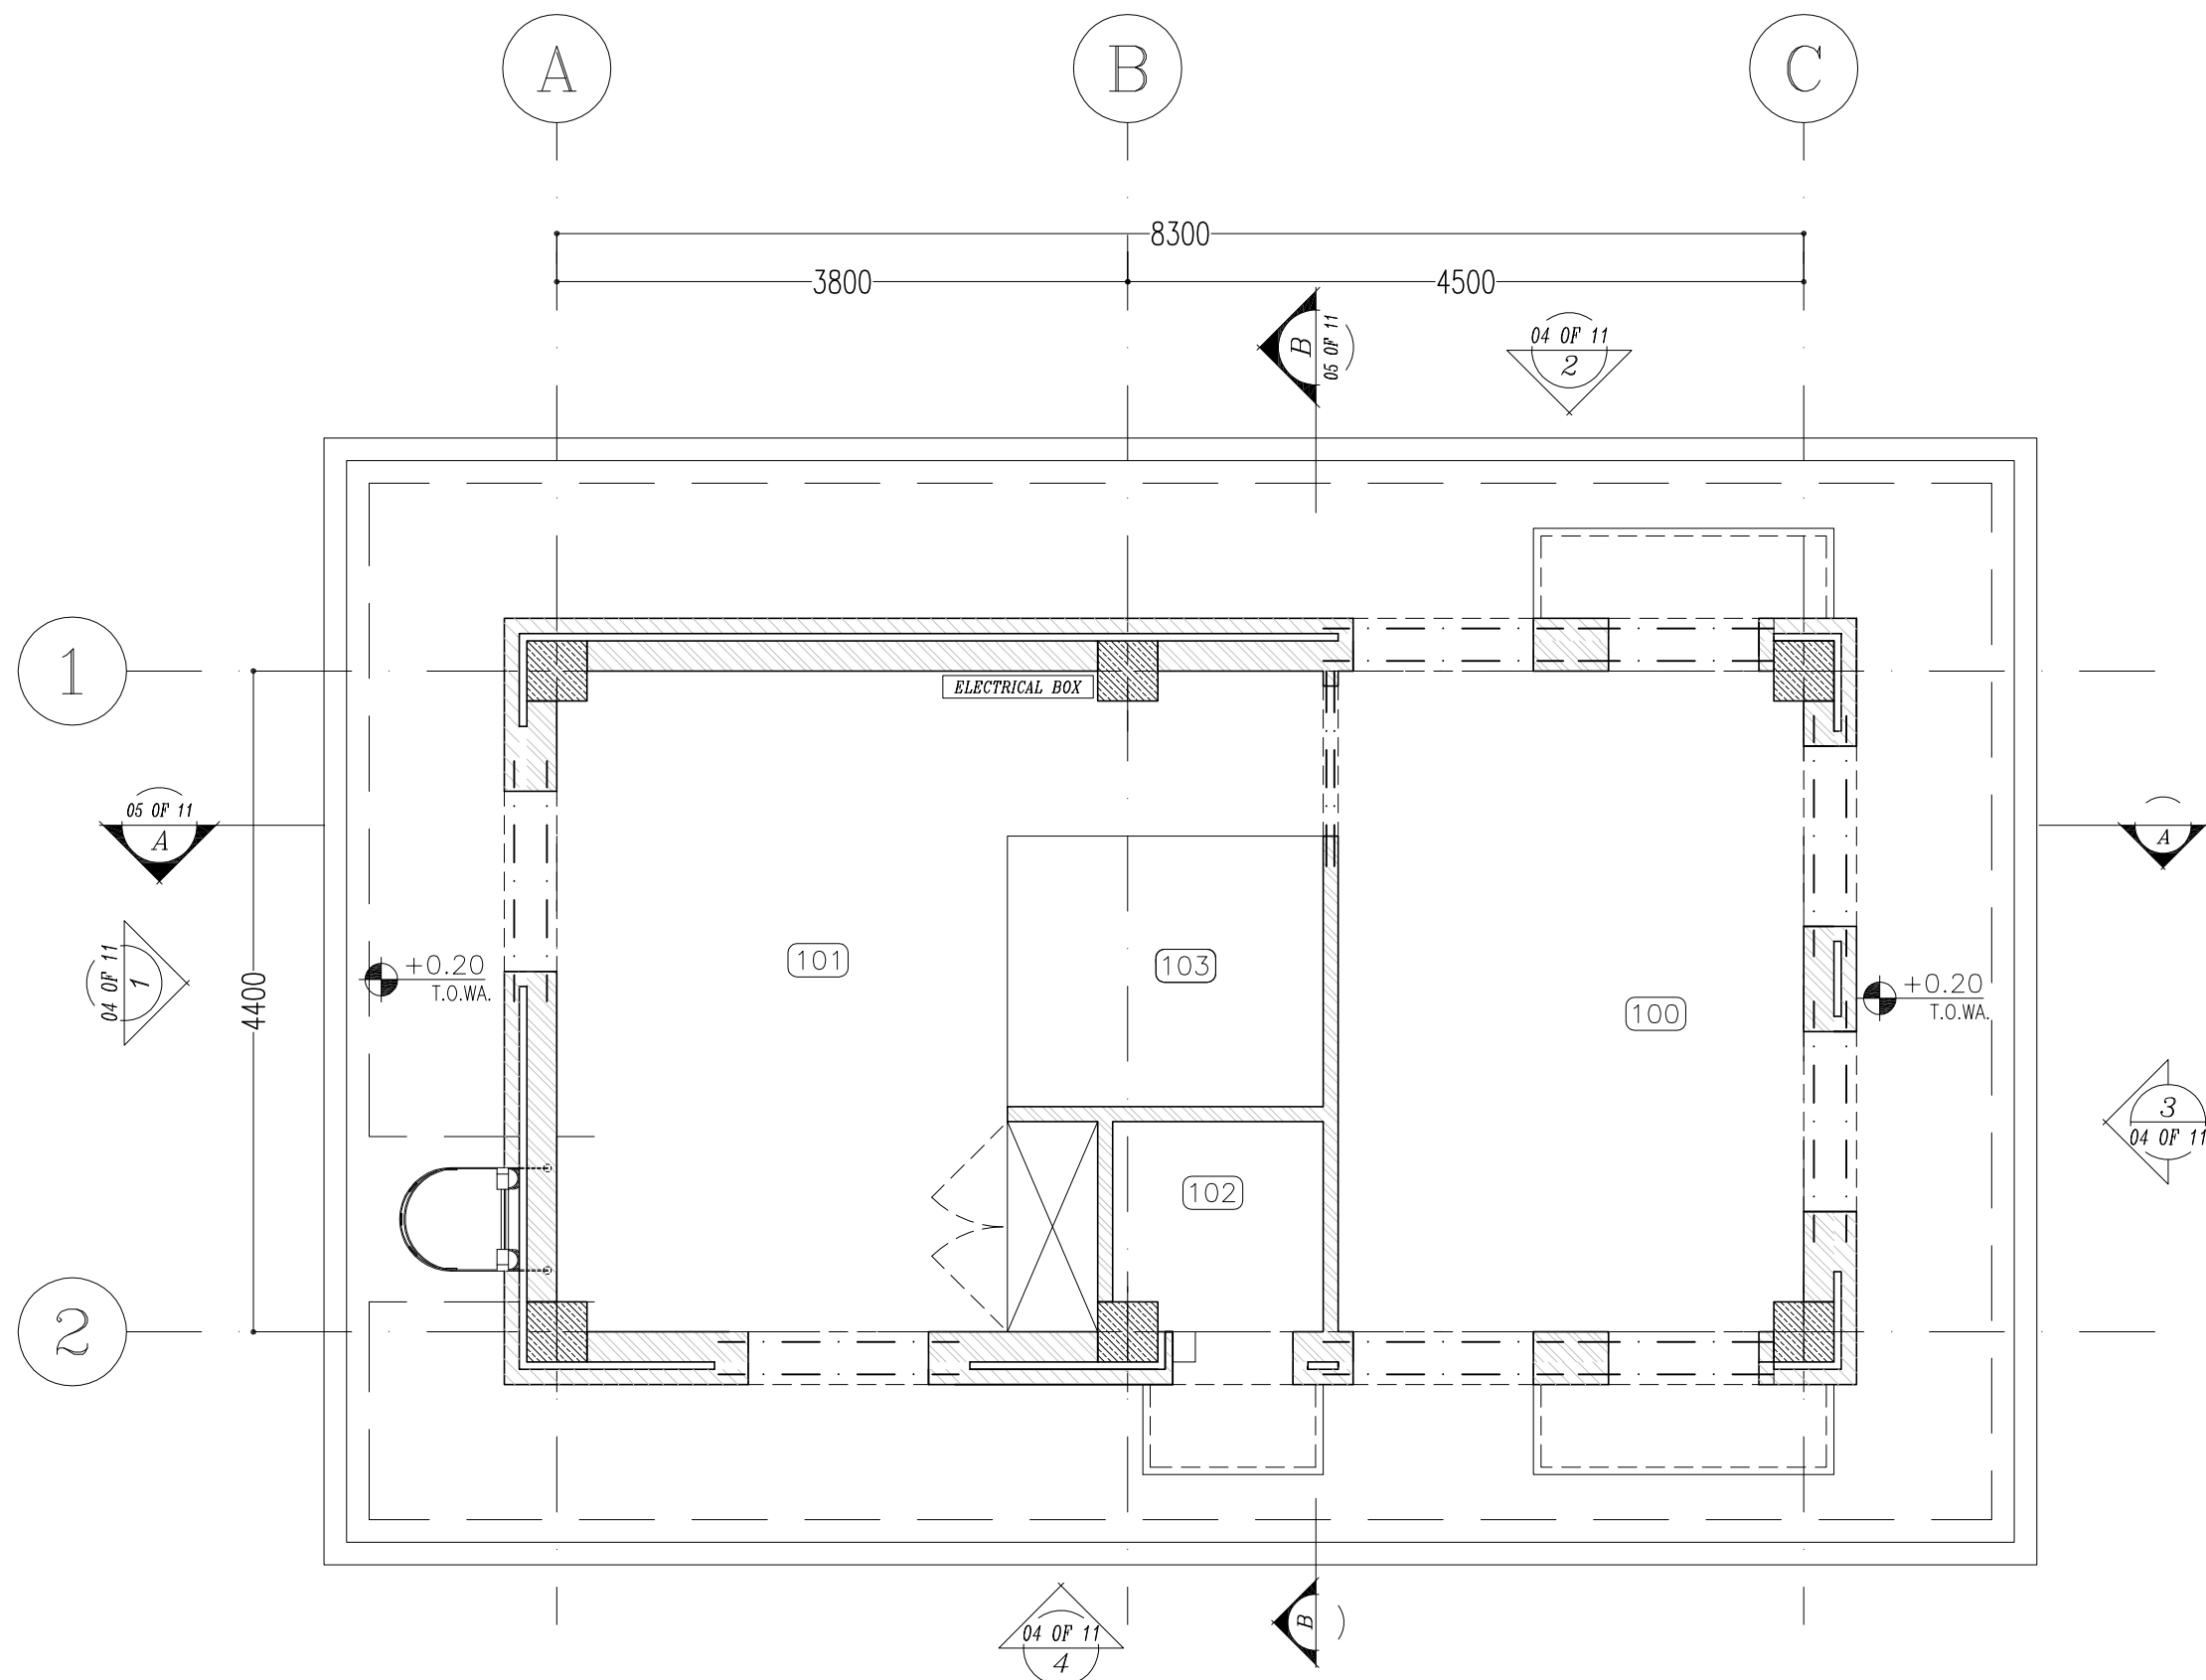

SC.1:50 4 LINTEL PLAN

100	SECURITY GUARD ROOM
101	RESTING AREA
102	WC
103	PANTRY


- NOTES
- 1- DIMENSIONS ARE IN "mm" AND ELEVATIONS IN "m" UNLESS SPECIFIED .
 - 2- ALL DIMENSIONS AND ELEVATIONS SHALL BE CHECKED BY THE CONTRACTOR PRIOR TO CONSTRUCTION.
 - 3- CONTRACTOR SHALL COMPARE ALL ARCHITECTURAL, MECHANICAL, ELECTRICAL, PIPING AND STRUCTURAL DRAWINGS AND IN CASE OF ANY CONFLICTS OR DISCREPANCY, INFORM THE ENGINEER.
 - 4- SLAB ON GRADE SHALL BE CONSTRUCTED AFTER EXECUTION OF CABLE TRENCH & EQUIPMENTS FOUNDATION.
 - 5- ALL MATERIALS ARE SELECTED FROM THE HIGHEST QUALITY AND SHALL BE APPROVED BY THE CLIENT.
 - 6- FOR COORDINATE REFER TO FINISH GRADING DOCUMENTS.
 - 7- FINISH GRADING LEVEL (BK14) ELEVATION : +185.55 m (GLOBAL) = ±0.00 (LOCAL)
 - 8- ALL EXTERNAL OPENINGS (WINDOWS AND DOORS) SHALL BE FIRE PROOF.
 - 9- DOUBLE GLAZED WINDOW WITH 2*6mm REINFORCED GLASS AND 6mm GAS FILLED GAP.
 - 10- WC DOORS SHALL BE WATERPROOF ABS TYPE WITH CLOSER MECHANISM.
 - 11- KNAUF GYPSUM BOARD TILES (60*60) cm (REGULAR 9.5 mm THICKNESS) WITH (1063).
 - 12- KNAUF PVC-COATED GYPSUM BOARD TILES (60*60)-(REGULAR 9.5mm THICKNESS) WITH (1063)-(PVC THICKNESS 0.35mm).

LEGEND


	BRICK WORK		BRICK FACING
	REINFORCED CONCRETE		GRAVEL
	TERRAZZO TILE		LEAN CONCRETE
	GYPSUM BOARD		BLOCKAGE
	BRICK FACING		SAND CEMENT MORTAR
	PAINTED ALUMIN STRIP (DUMPA)		
	CERAMIC TILES (30x30)		

F.F.L. FINISHED FLOOR LEVEL
T.O.WA. TOP OF WALKWAY
T.O.P. TOP OF PARAPET
B.O.D. BOTTOM OF DOOR
T.O.W. TOP OF WINDOW
B.O.W. BOTTOM OF WINDOW
T.O.S. TOP OF SLAB
T.O.D. TOP OF DOOR
T.O.CA. TOP OF CAGE
B.O.CA. BOTTOM OF CAGE
B.O.O. BOTTOM OF OPENING
B.O.S. BOTTOM OF SUSPENDED CEILING

REFERENCE DRAWING	DRG. No.
STANDARD DRAWING FOR ARCHITECTURAL DETAILS	BK-GNRL-PEDCO-000-AR-DW-0001
STANDARD DETAILS FOR LADDER & SAFETY CAGE	BK-GNRL-PEDCO-000-ST-DW-0009
FOUNDATION DRAWING FOR SECURITY BUILDING FOR WELL PADS - BK-14	BK-BK14-PEDCO-110-ST-DW-0002
STRUCTURAL DRAWING FOR SECURITY BUILDING FOR WELL PADS - BK-14	BK-BK14-PEDCO-110-ST-DW-0003
HVAC SYSTEM LAYOUT FOR SECURITY BUILDING - BK14	BK-BK14-PEDCO-110-HV-PY-0002
PLUMBING & SEWAGE PIPING LAYOUT FOR SECURITY BUILDING - BK14	BK-BK14-PEDCO-110-HV-PY-0004
LIGHTING & SMALL POWER LAYOUT FOR SECURITY BUILDING OF WELL PADS	BK-SSGRU-PEDCO-110-EL-PY-0005

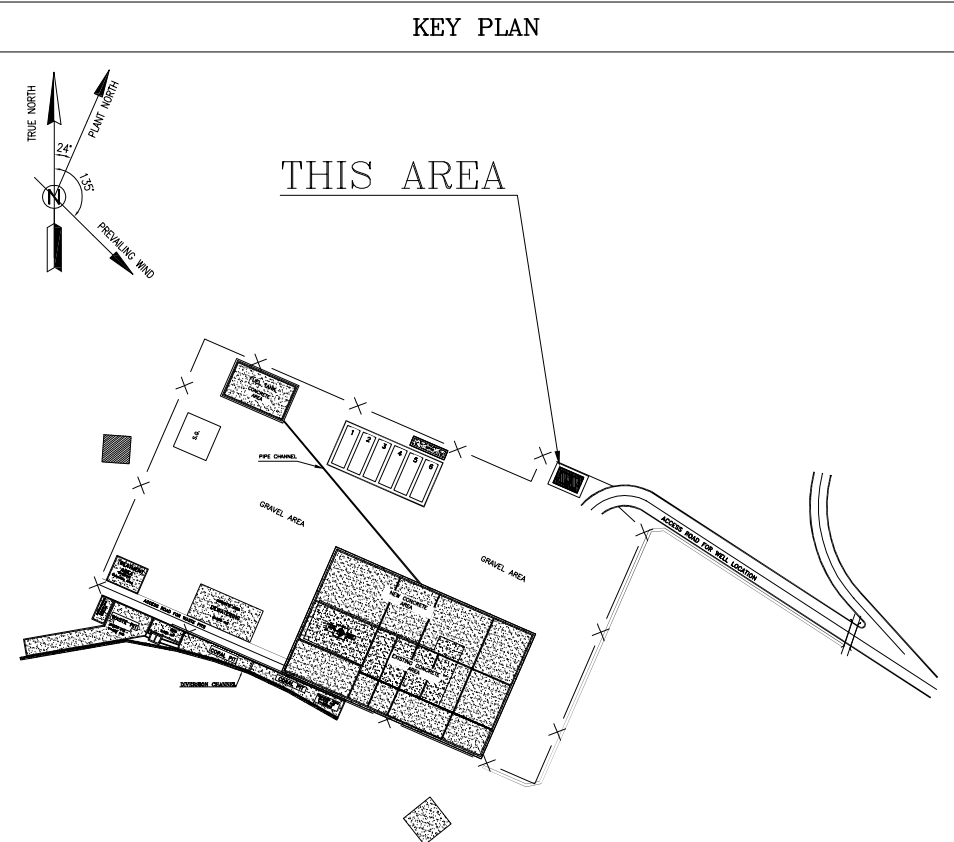


D02	SEP. 2023	APC	R.BERLOUIE	M.FAKHARIAN	S.Paramarspour	***	***	*****	***	*****	***	*****	
D01	FEB. 2023	IFA	R.BERLOUIE	M.FAKHARIAN	M.Mehrshad	***	REV.	DESCRIPTION	BY	DATE	BY	DATE	
D00	APR. 2022	IPC	R.BERLOUIE	M.FAKHARIAN	M.Mehrshad	***			CHECKED		REV. APPR.		
REV.	DATE	P.O.I.S	PREP.	CHK.	APP.	AUT.	اصل و کلیه نسخ این نقشه و حق امتیاز متعلق به شرکت ملی مناطق نفت خیز جنوب میباشد.						
PROJECT NAME: BINAK OILFIELD DEVELOPMENT/SUB-SURFACE WORK PACKAGES BK14 WHF MODIFICATIONS								THE ORIGINAL AND ALL COPIES OF THIS DRAWING TOGETHER WITH THE COPYRIGHT THEREIN ARE THE SOLE PROPERTY OF N.I.S.O.C. / FIELDS					
PROJECT NO.: 971020													
EPC CONTRACTOR:			EPD/EPC CONTRACTOR (GC):				BINAK OILFIELD DEVELOPMENT SUB-SURFACE WORK PACKAGES BK14 WHF MODIFICATIONS						
 HIRGAN ENERGY – DESIGN & INSPECTION COMPANIES			 PETROIRAN DEVELOPMENT COMPANY										
							DATE	SCALE	DRAWING BY	CHECKED BY	PROJECT ENG.		
DRAWING TITLE: ARCHITECTURAL DRAWING FOR SECURITY BUILDING OF WELL PADS – BK-14							NO CONSTRUCTION PERMITTED UNLESS DRAWING APPROVED						
							APPROVED FOR CONSTRUCTION			BY:	DATE:		
SCALE	SIZE	DRAWING NO.			SHEET NO.	REV.	BUDGET REF.	LOCATION	SIZE	CLASS	SERIAL NO.	SHEET	REVISION
AS SHOWN	A1	BK-BK14-PEDCO-110-AR-DW-0003			02 OF 11	D02	053-073-9184	F	4	B	708207	02 OF 11	D02


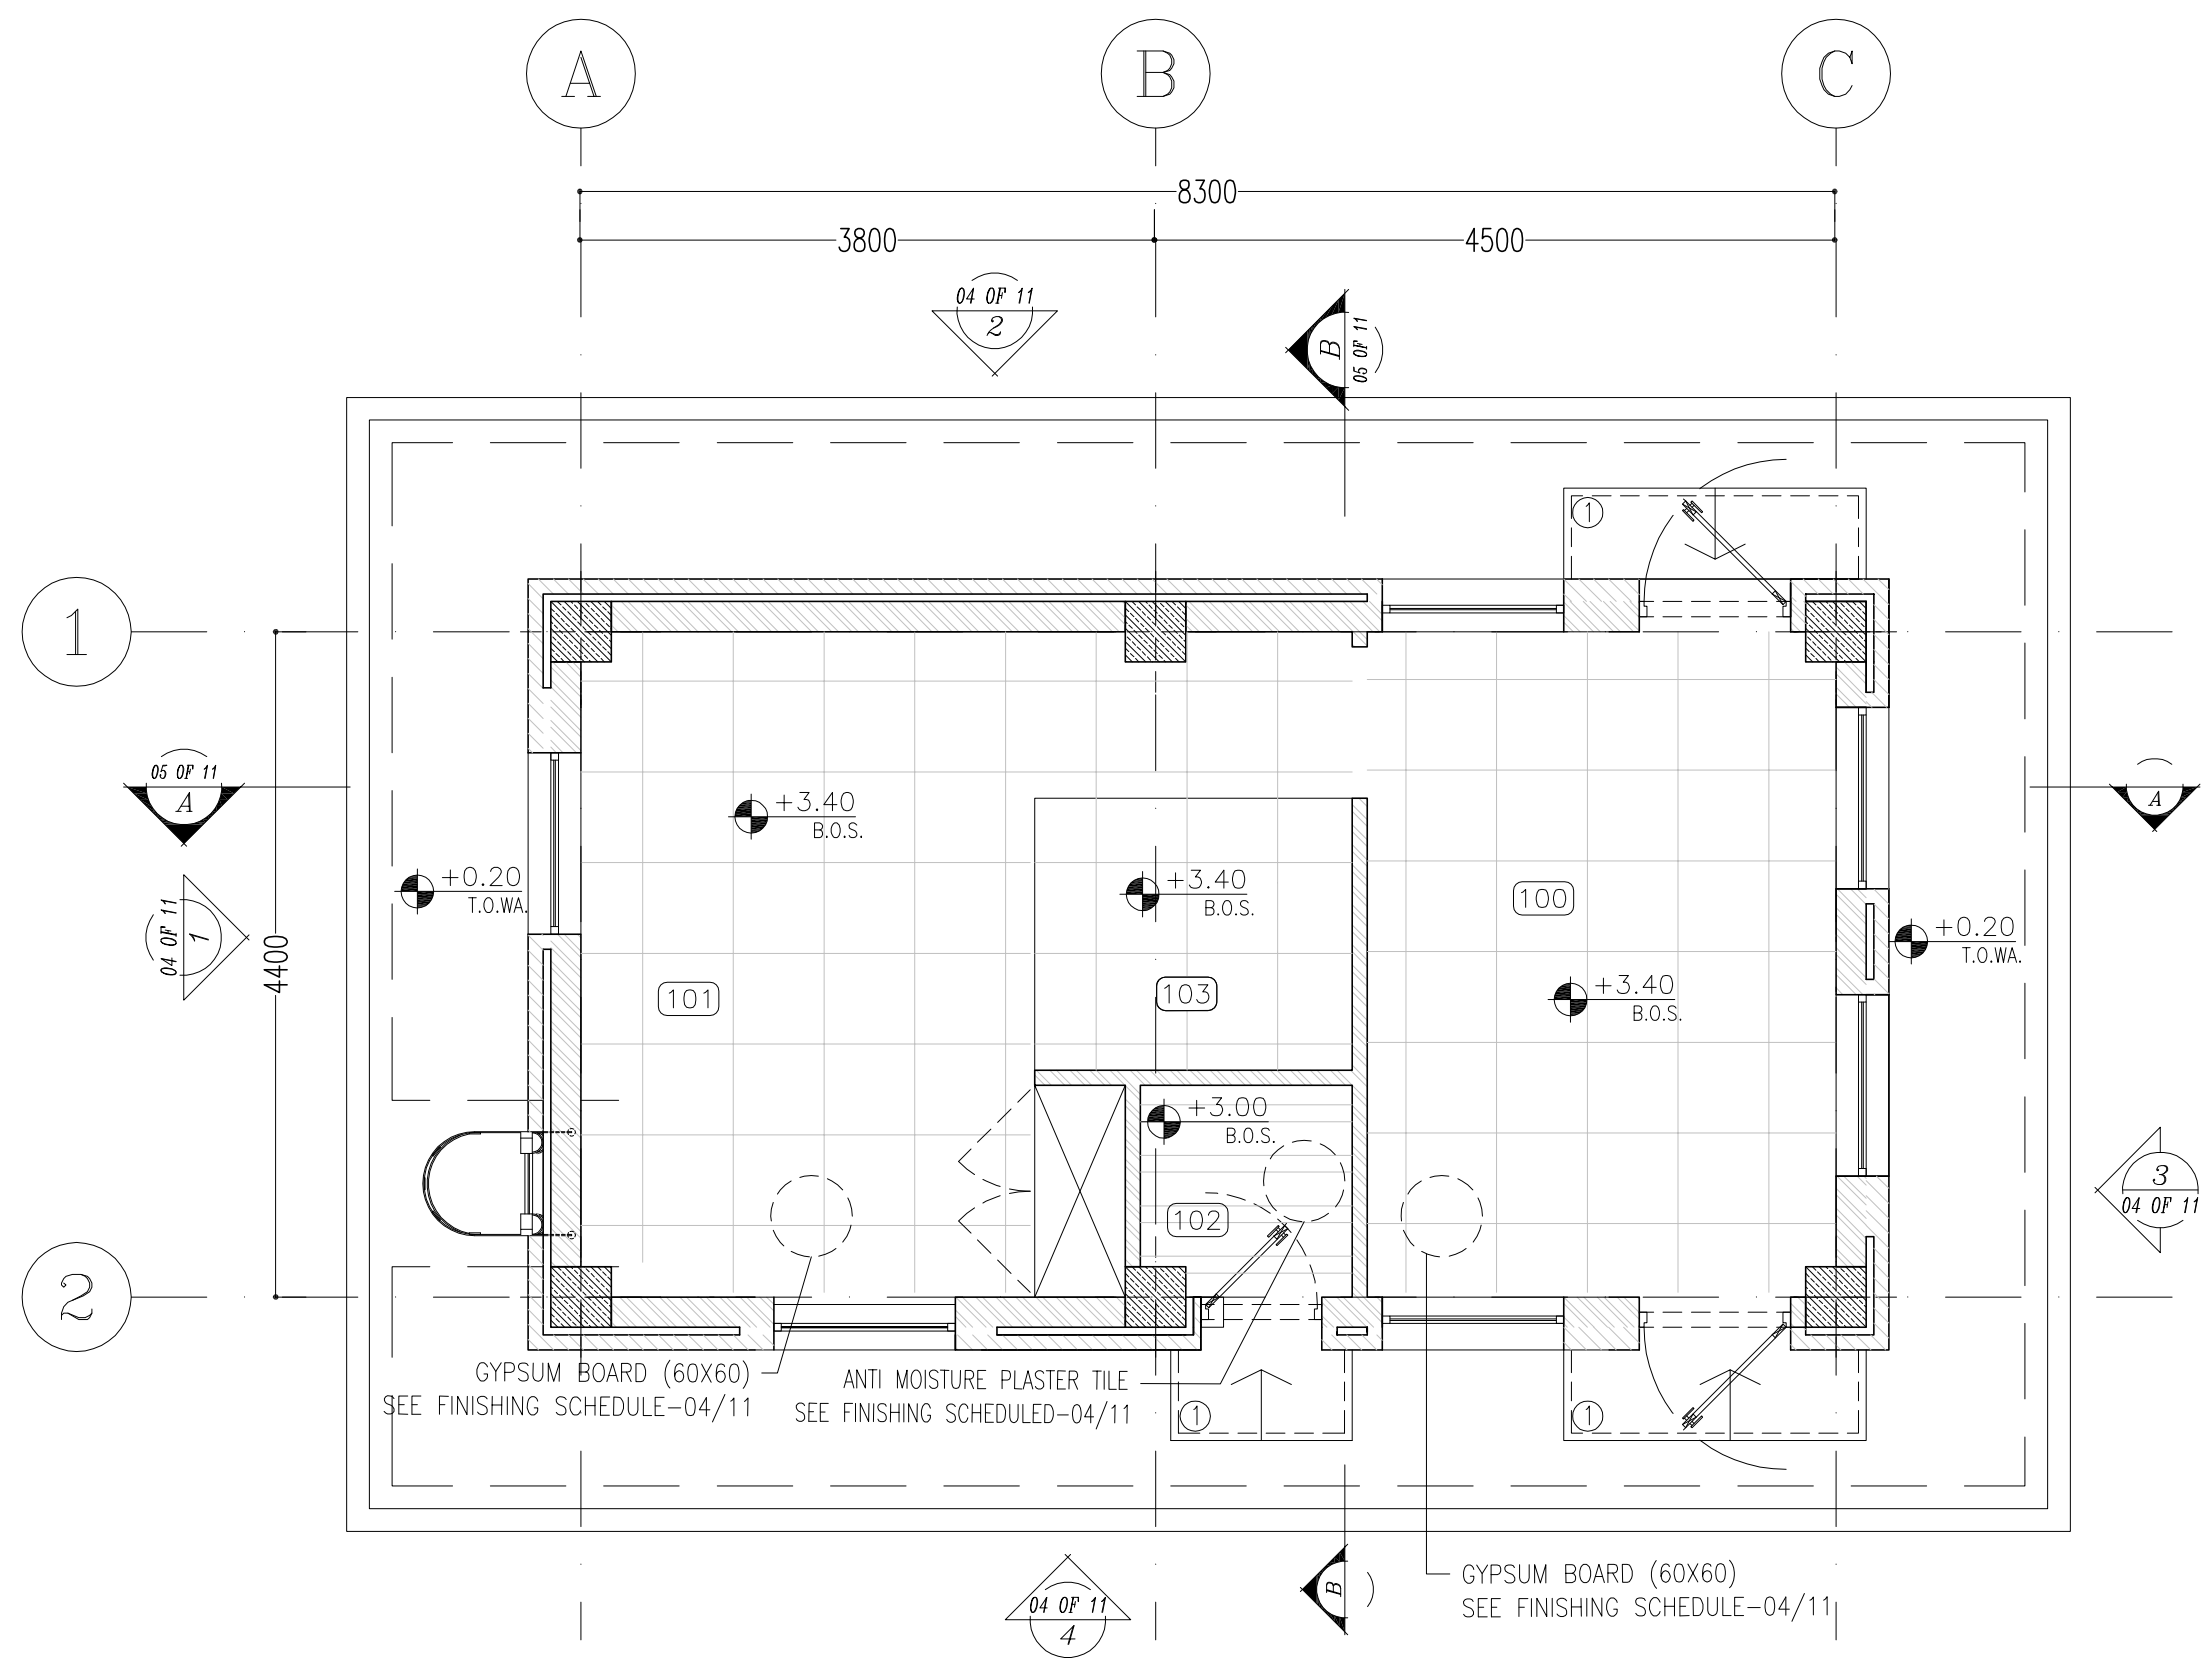


SC.1:50  6 SUSPENDED CEILING PLAN


[illegible]

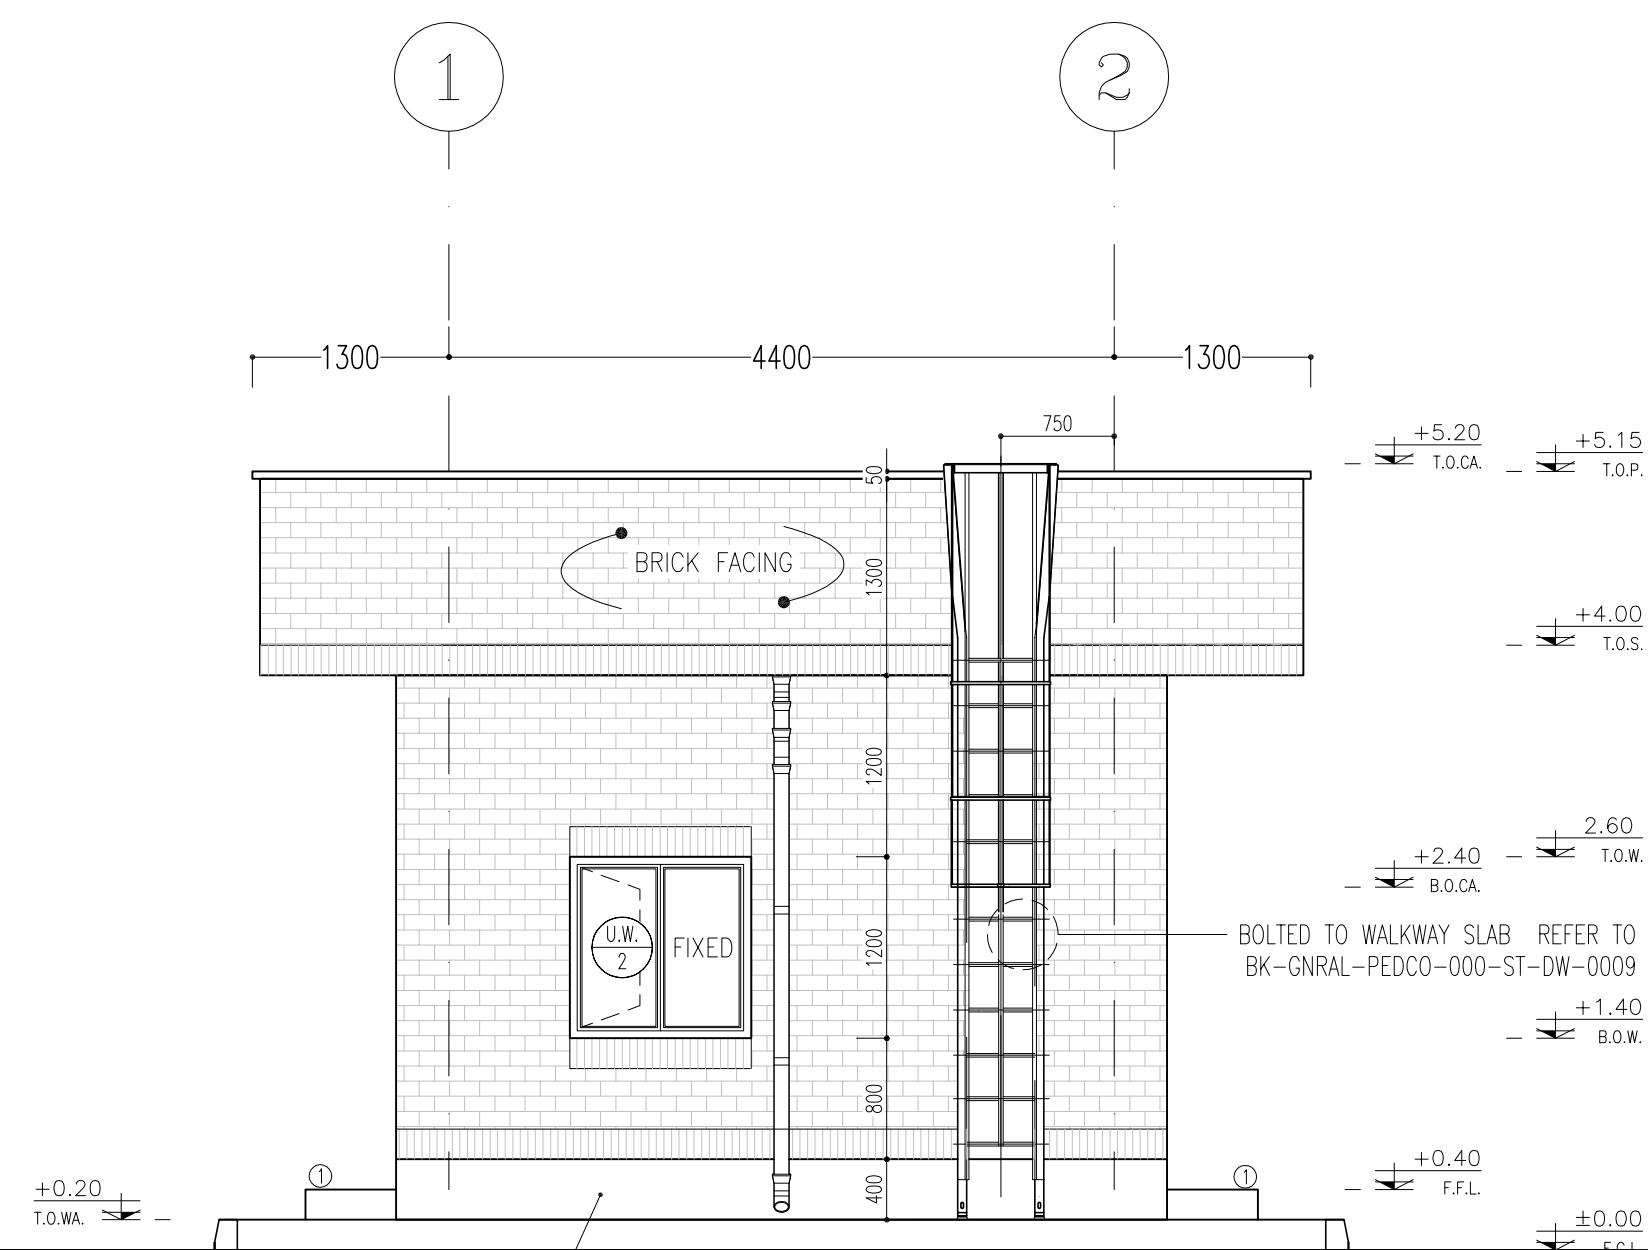

SC.1:50 01 OF 11 ELEVATION

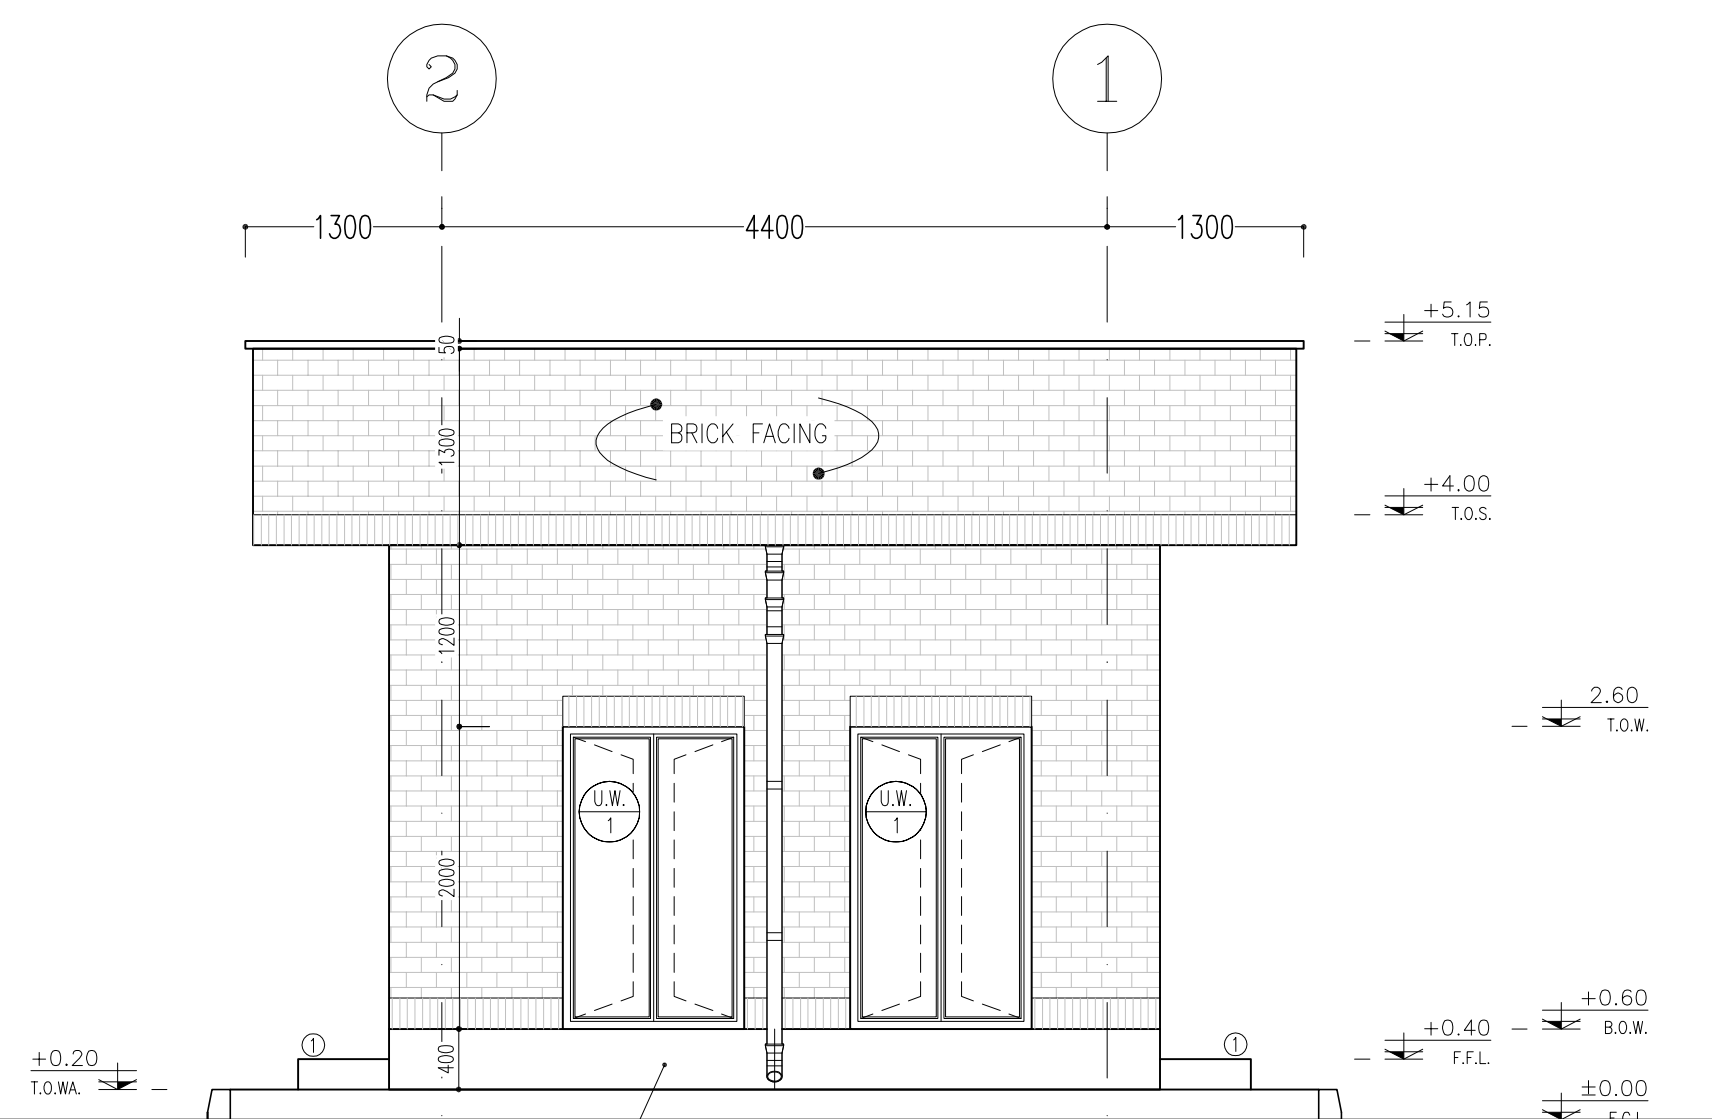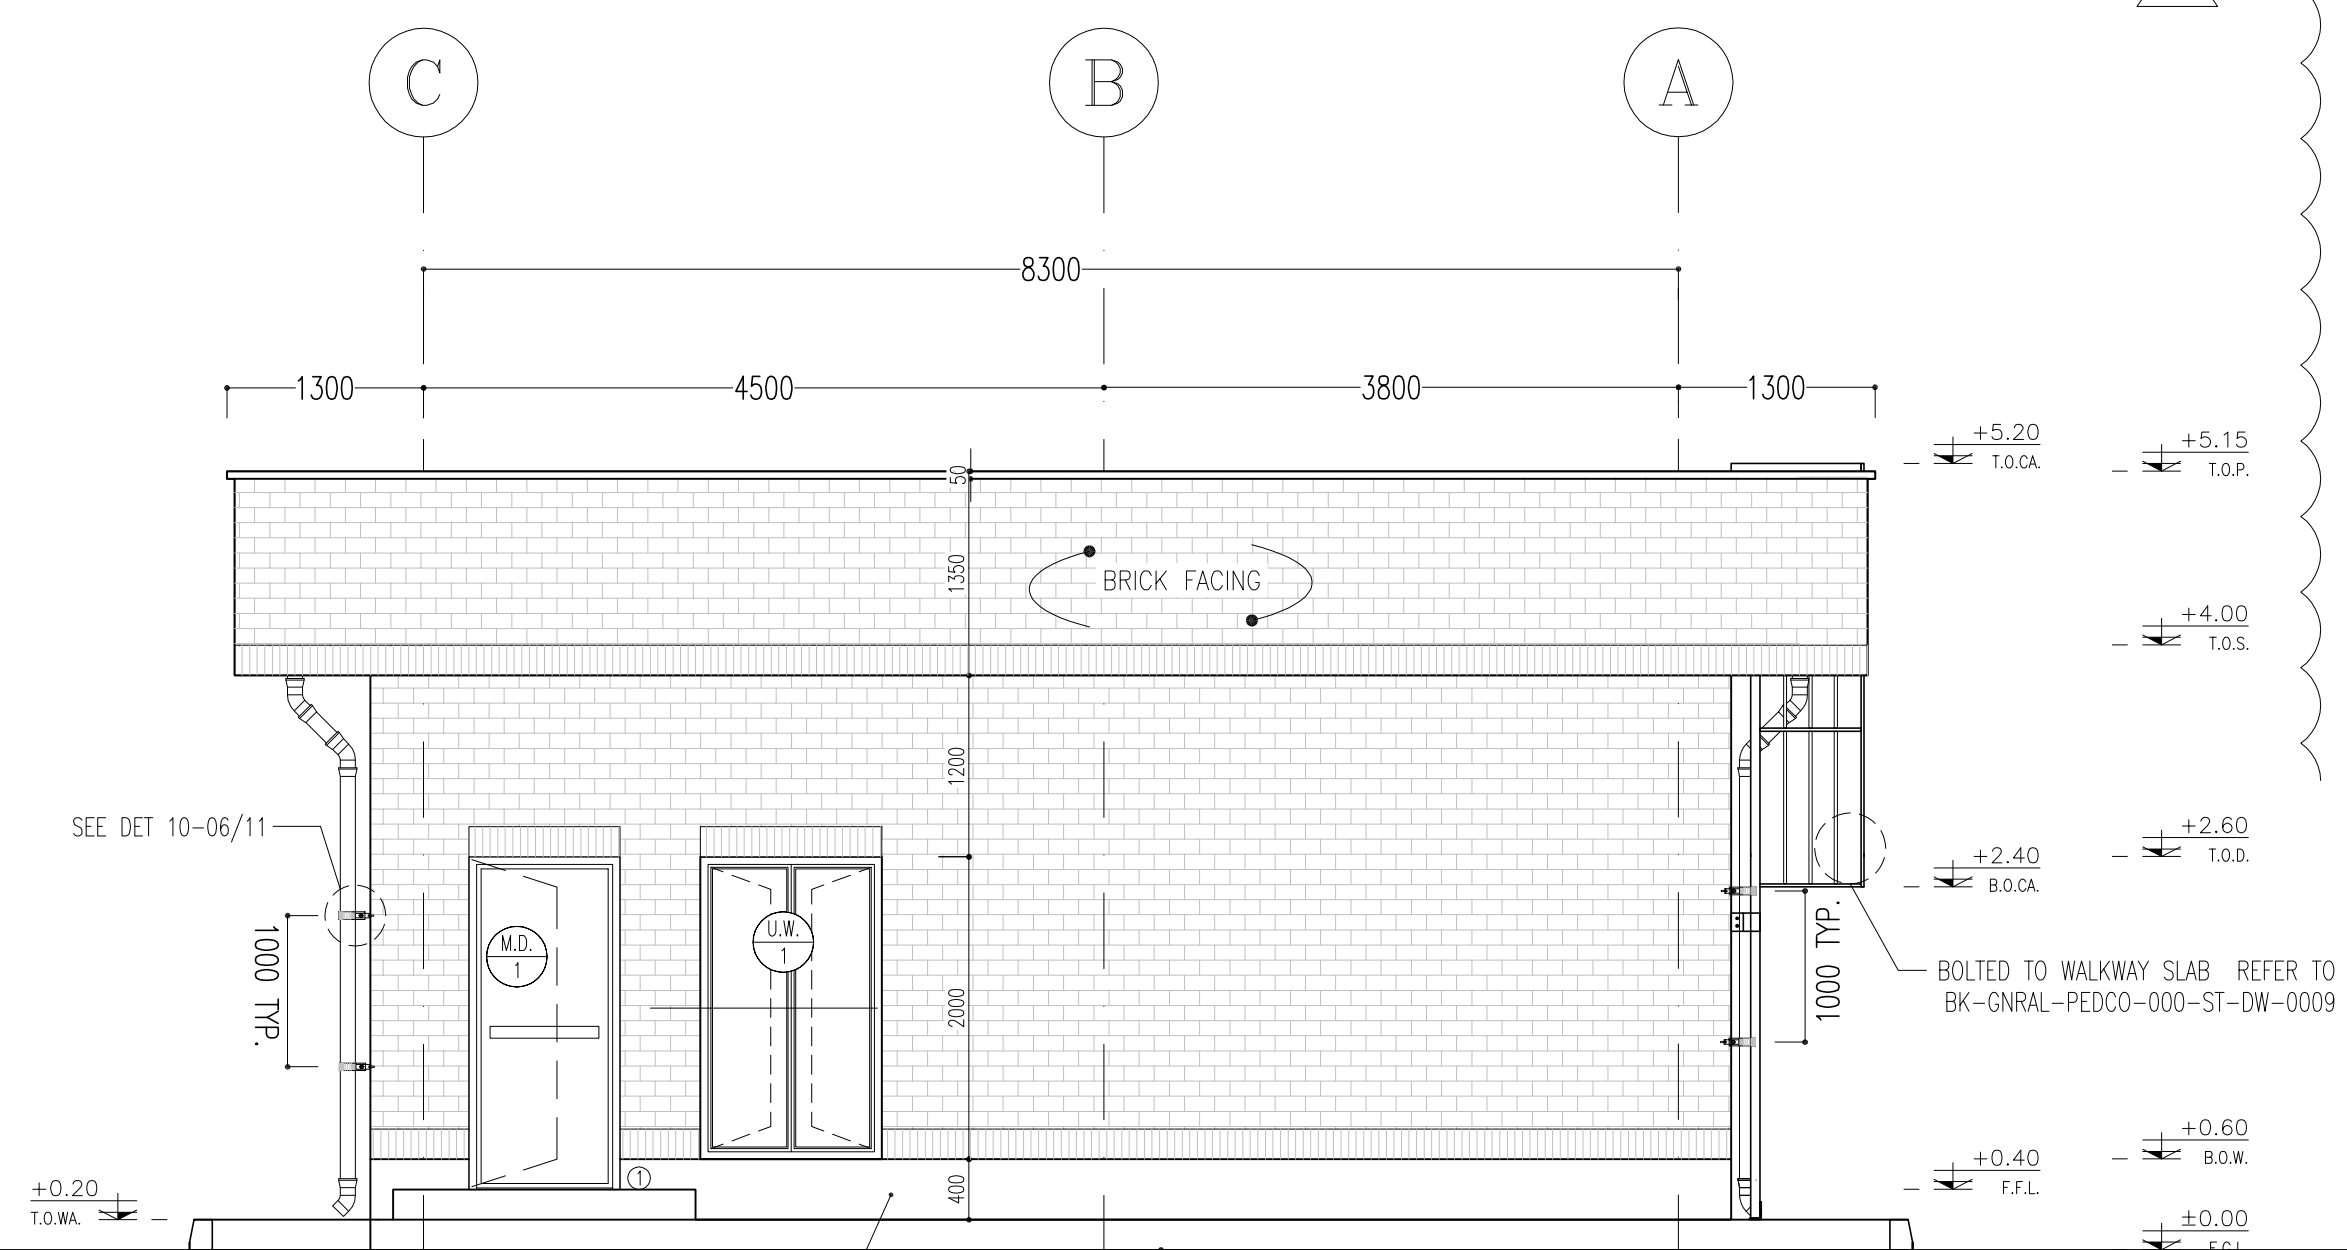

SC.1:50  ELEVATION

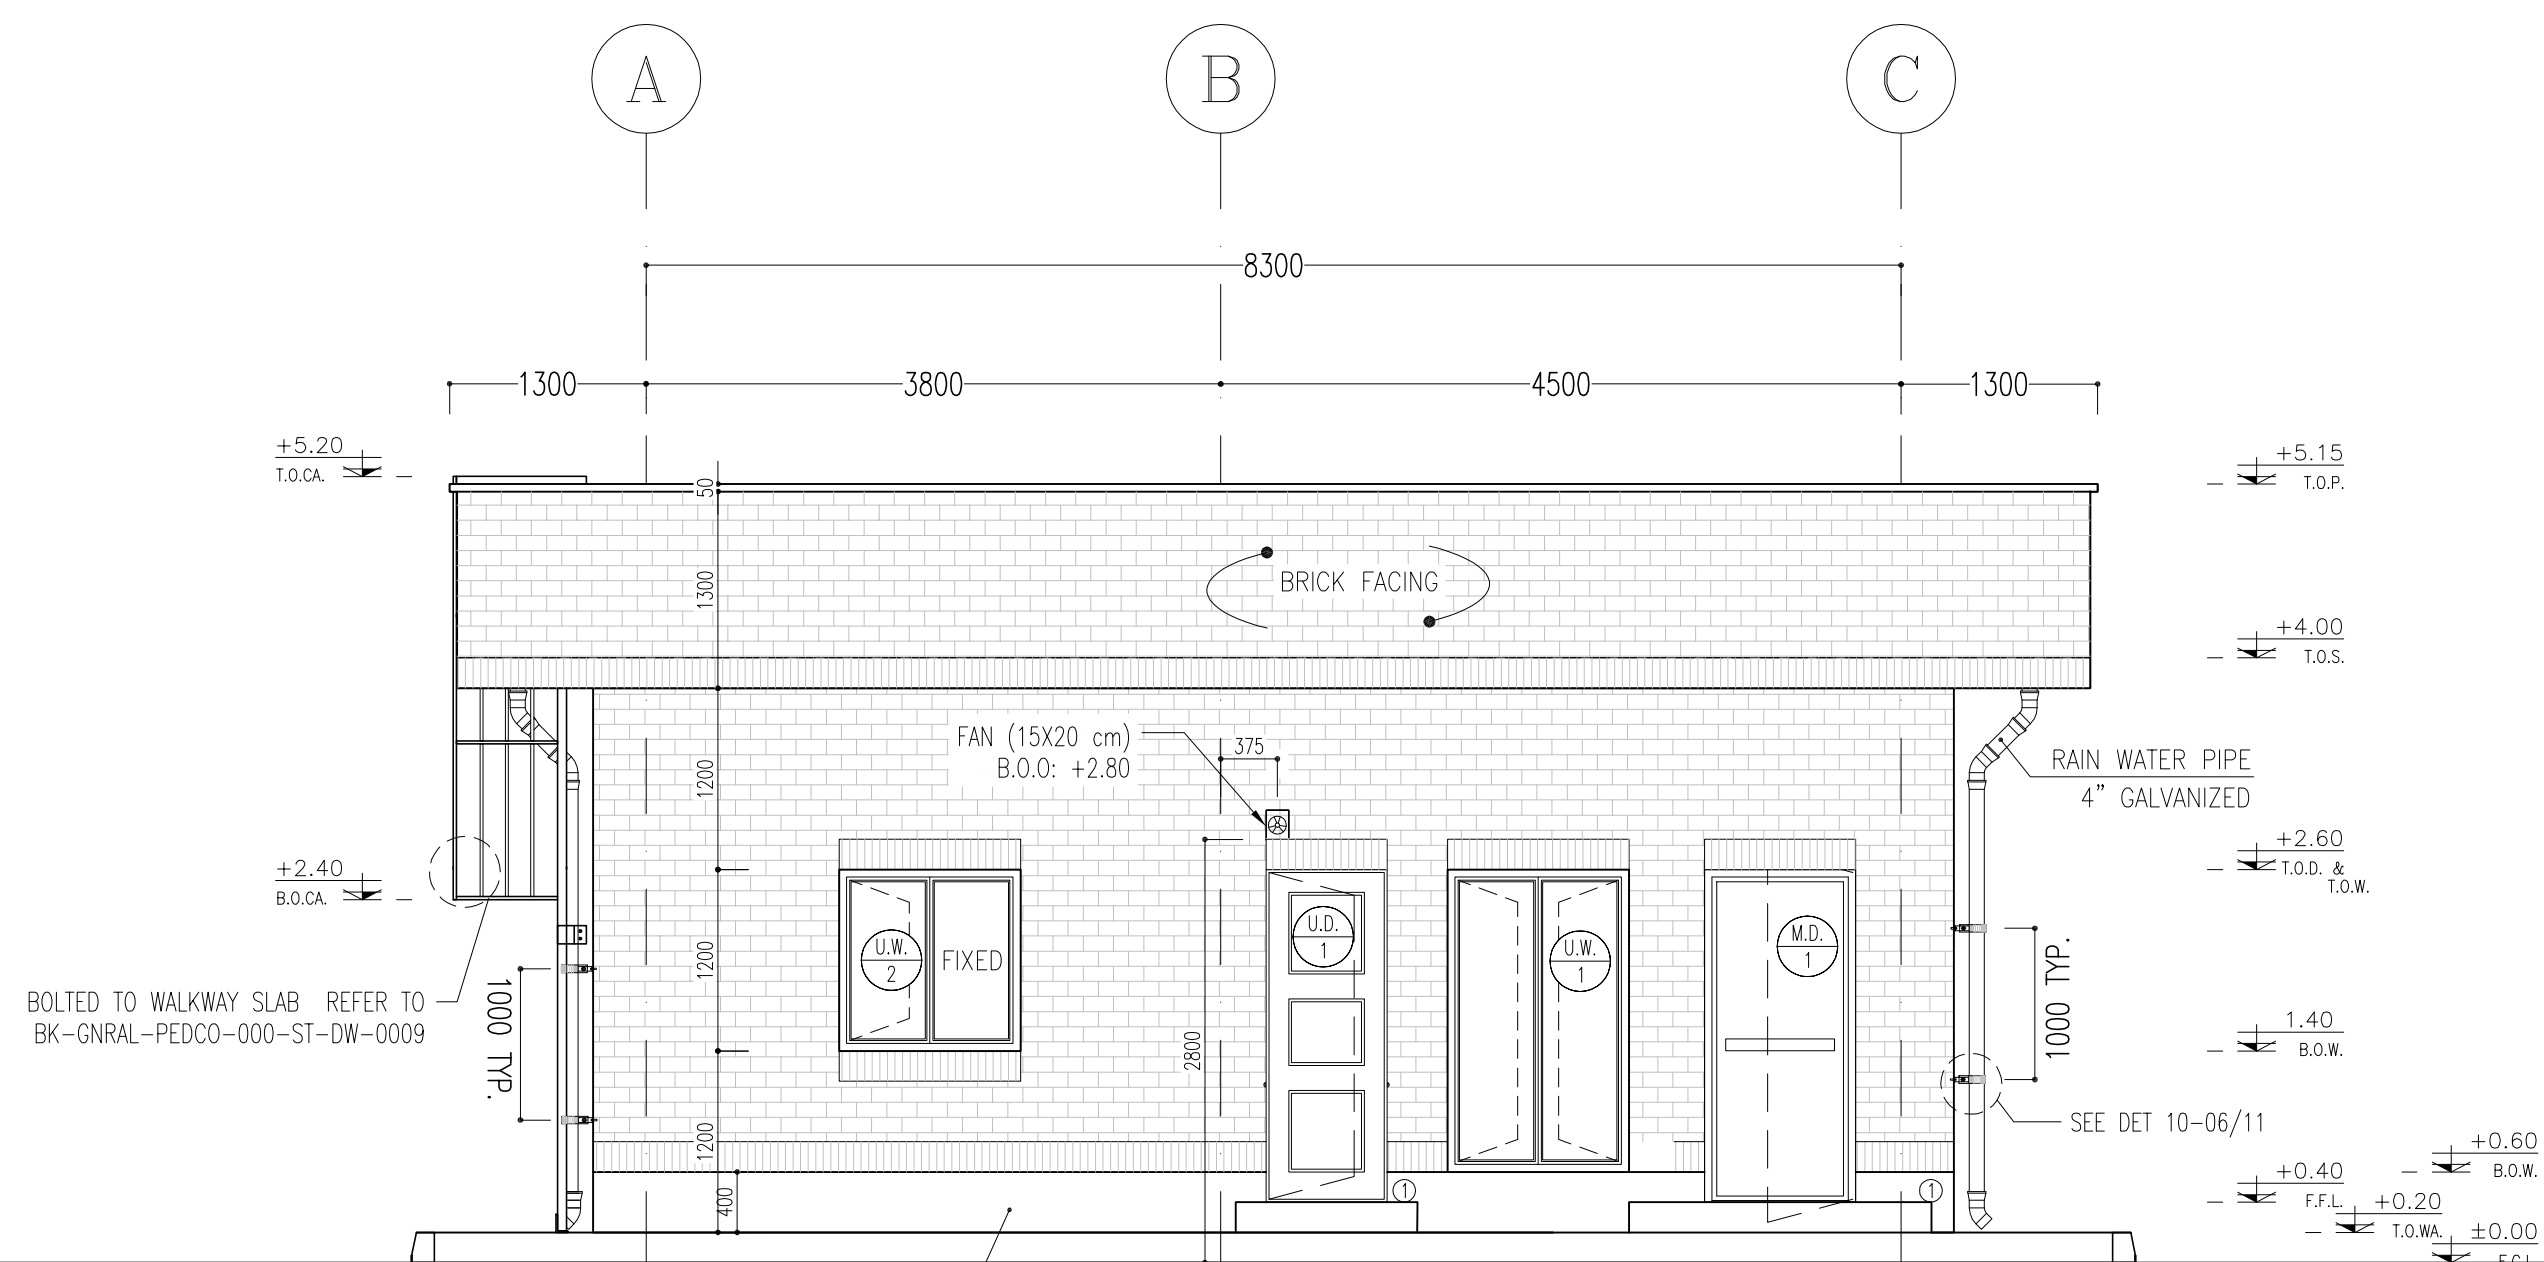

SC.1:50  ELEVATION


NOTES



- 1- DIMENSIONS ARE IN "MM" AND ELEVATIONS IN "M" UNLESS SPECIFIED.
- 2- ALL DIMENSIONS AND ELEVATIONS SHALL BE CHECKED BY THE CONTRACTOR PRIOR TO CONSTRUCTION.
- 3- CONTRACTOR SHALL COMPARE ALL ARCHITECTURAL, MECHANICAL, ELECTRICAL, PIPING AND STRUCTURAL DRAWINGS AND IN CASE OF ANY CONFLICTS OR DISCREPANCY, INFORM THE ENGINEER.
- 4- SLAB ON GRADE SHALL BE CONSTRUCTED AFTER EXECUTION OF CABLE TRENCH & EQUIPMENTS FOUNDATION.
- 5- ALL MATERIALS ARE SELECTED FROM THE HIGHEST QUALITY AND SHALL BE APPROVED BY THE CLIENT.
- 6- FOR COORDINATE REFER TO FINISH GRADING DOCUMENTS.
- 7- FINISH GRADING LEVEL (BK14) ELEVATION : +185.55 m (GDA84) = ±0.00 (LOCAL).
- 8- ALL EXTERNAL OPENINGS (WINDOWS AND DOORS) SHALL BE FIRE PROOF.
- 9- DOUBLE GLAZED WINDOW WITH 26mm RANFORD GLASS AND 6mm GAS FILLED GAP.
- 10- WC DOORS SHALL BE WATERPROOF ABS TYPE WITH CLOSER MECHANISM.
- 11- KNAUF GYPSUM BOARD TILES (60*60) cm (REGULAR 9.5 mm THICKNESS) WITH (1063).
- 12- KNAUF PVC-COATED GYPSUM BOARD TILES (60*60)-(REGULAR 9.5mm THICKNESS) WITH (1063)-(PVC THICKNESS 0.35mm).

LEGEND	
	BRICK WORK
	REINFORCED CONCRETE
	TERRAZZO TILE
	GYPSUM BOARD
	BRICK FACING
	PAINTED ALUMINUM STRIP (DUMPA)
	CERAMIC TILES (30x30)
	BRICK FACING
	GRAVEL
	LEAN CONCRETE
	BLOCKAGE
	SAND CEMENT MORTAR

F.F.L.	FINISHED FLOOR LEVEL
T.O.W.A.	TOP OF WALKWAY
T.O.P.	TOP OF PARAPET
B.O.D.	BOTTOM OF DOOR
T.O.W.	TOP OF WINDOW
B.O.W.	BOTTOM OF WINDOW
T.O.S.	TOP OF SLAB
T.O.D.	TOP OF DOOR
T.O.C.A.	TOP OF CAGE
B.O.C.A.	BOTTOM OF CAGE
B.O.O.	BOTTOM OF OPENING
B.O.S.	BOTTOM OF SUSPENDED CEILING

REFERENCE DRAWING	DRG. No.
STANDARD DRAWING FOR ARCHITECTURAL DETAILS	BK-GNRL-PEDCO-000-AR-DW-0001
STANDARD DETAILS FOR LADDER & SAFETY CAGE	BK-GNRL-PEDCO-000-ST-DW-0009
FOUNDATION DRAWING FOR SECURITY BUILDING FOR WELL PADS – BK-14	BK-BK14-PEDCO-110-ST-DW-0002
STRUCTURAL DRAWING FOR SECURITY BUILDING FOR WELL PADS – BK-14	BK-BK14-PEDCO-110-ST-DW-0003
HVAC SYSTEM LAYOUT FOR SECURITY BUILDING – BK14	BK-BK14-PEDCO-110-HV-PY-0004
PLUMBING & SEWAGE PIPING LAYOUT FOR SECURITY BUILDING – BK14	BK-BK14-PEDCO-110-HV-PY-0004
LIGHTING & SMALL POWER LAYOUT FOR SECURITY BUILDING – BK14	BK-BK14-PEDCO-110-EL-PY-0005

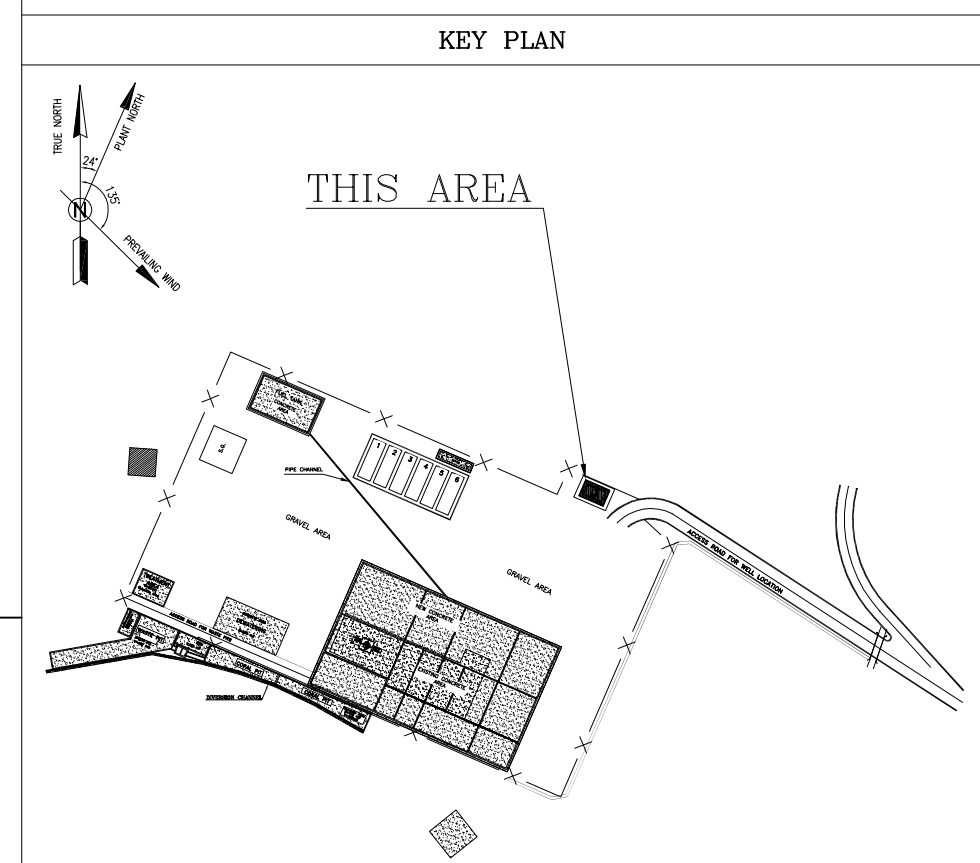[illegible]

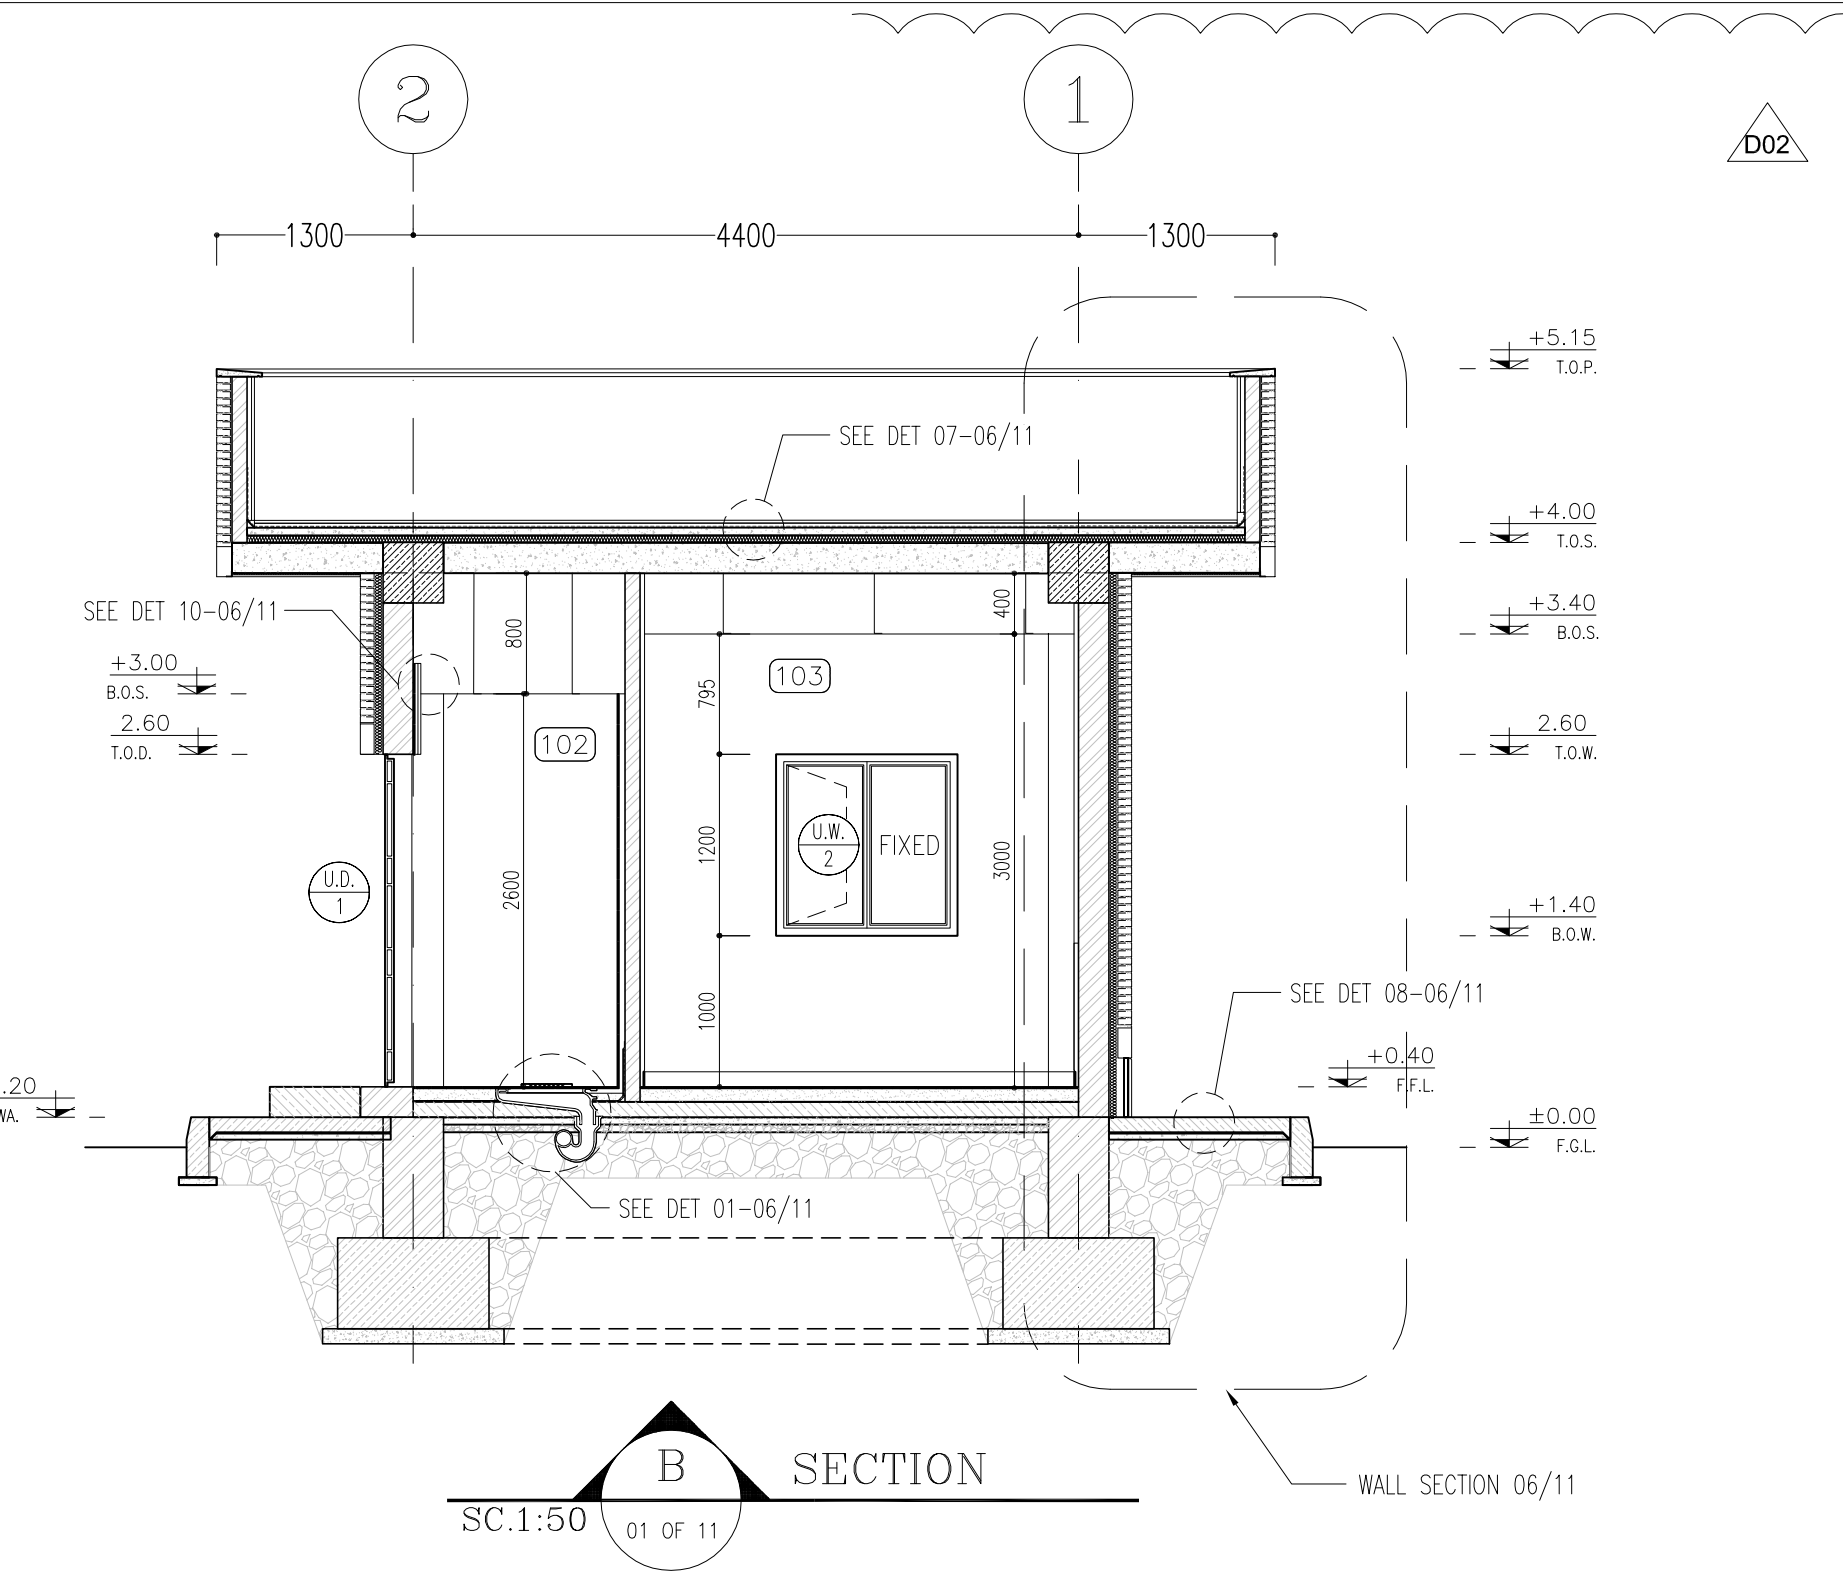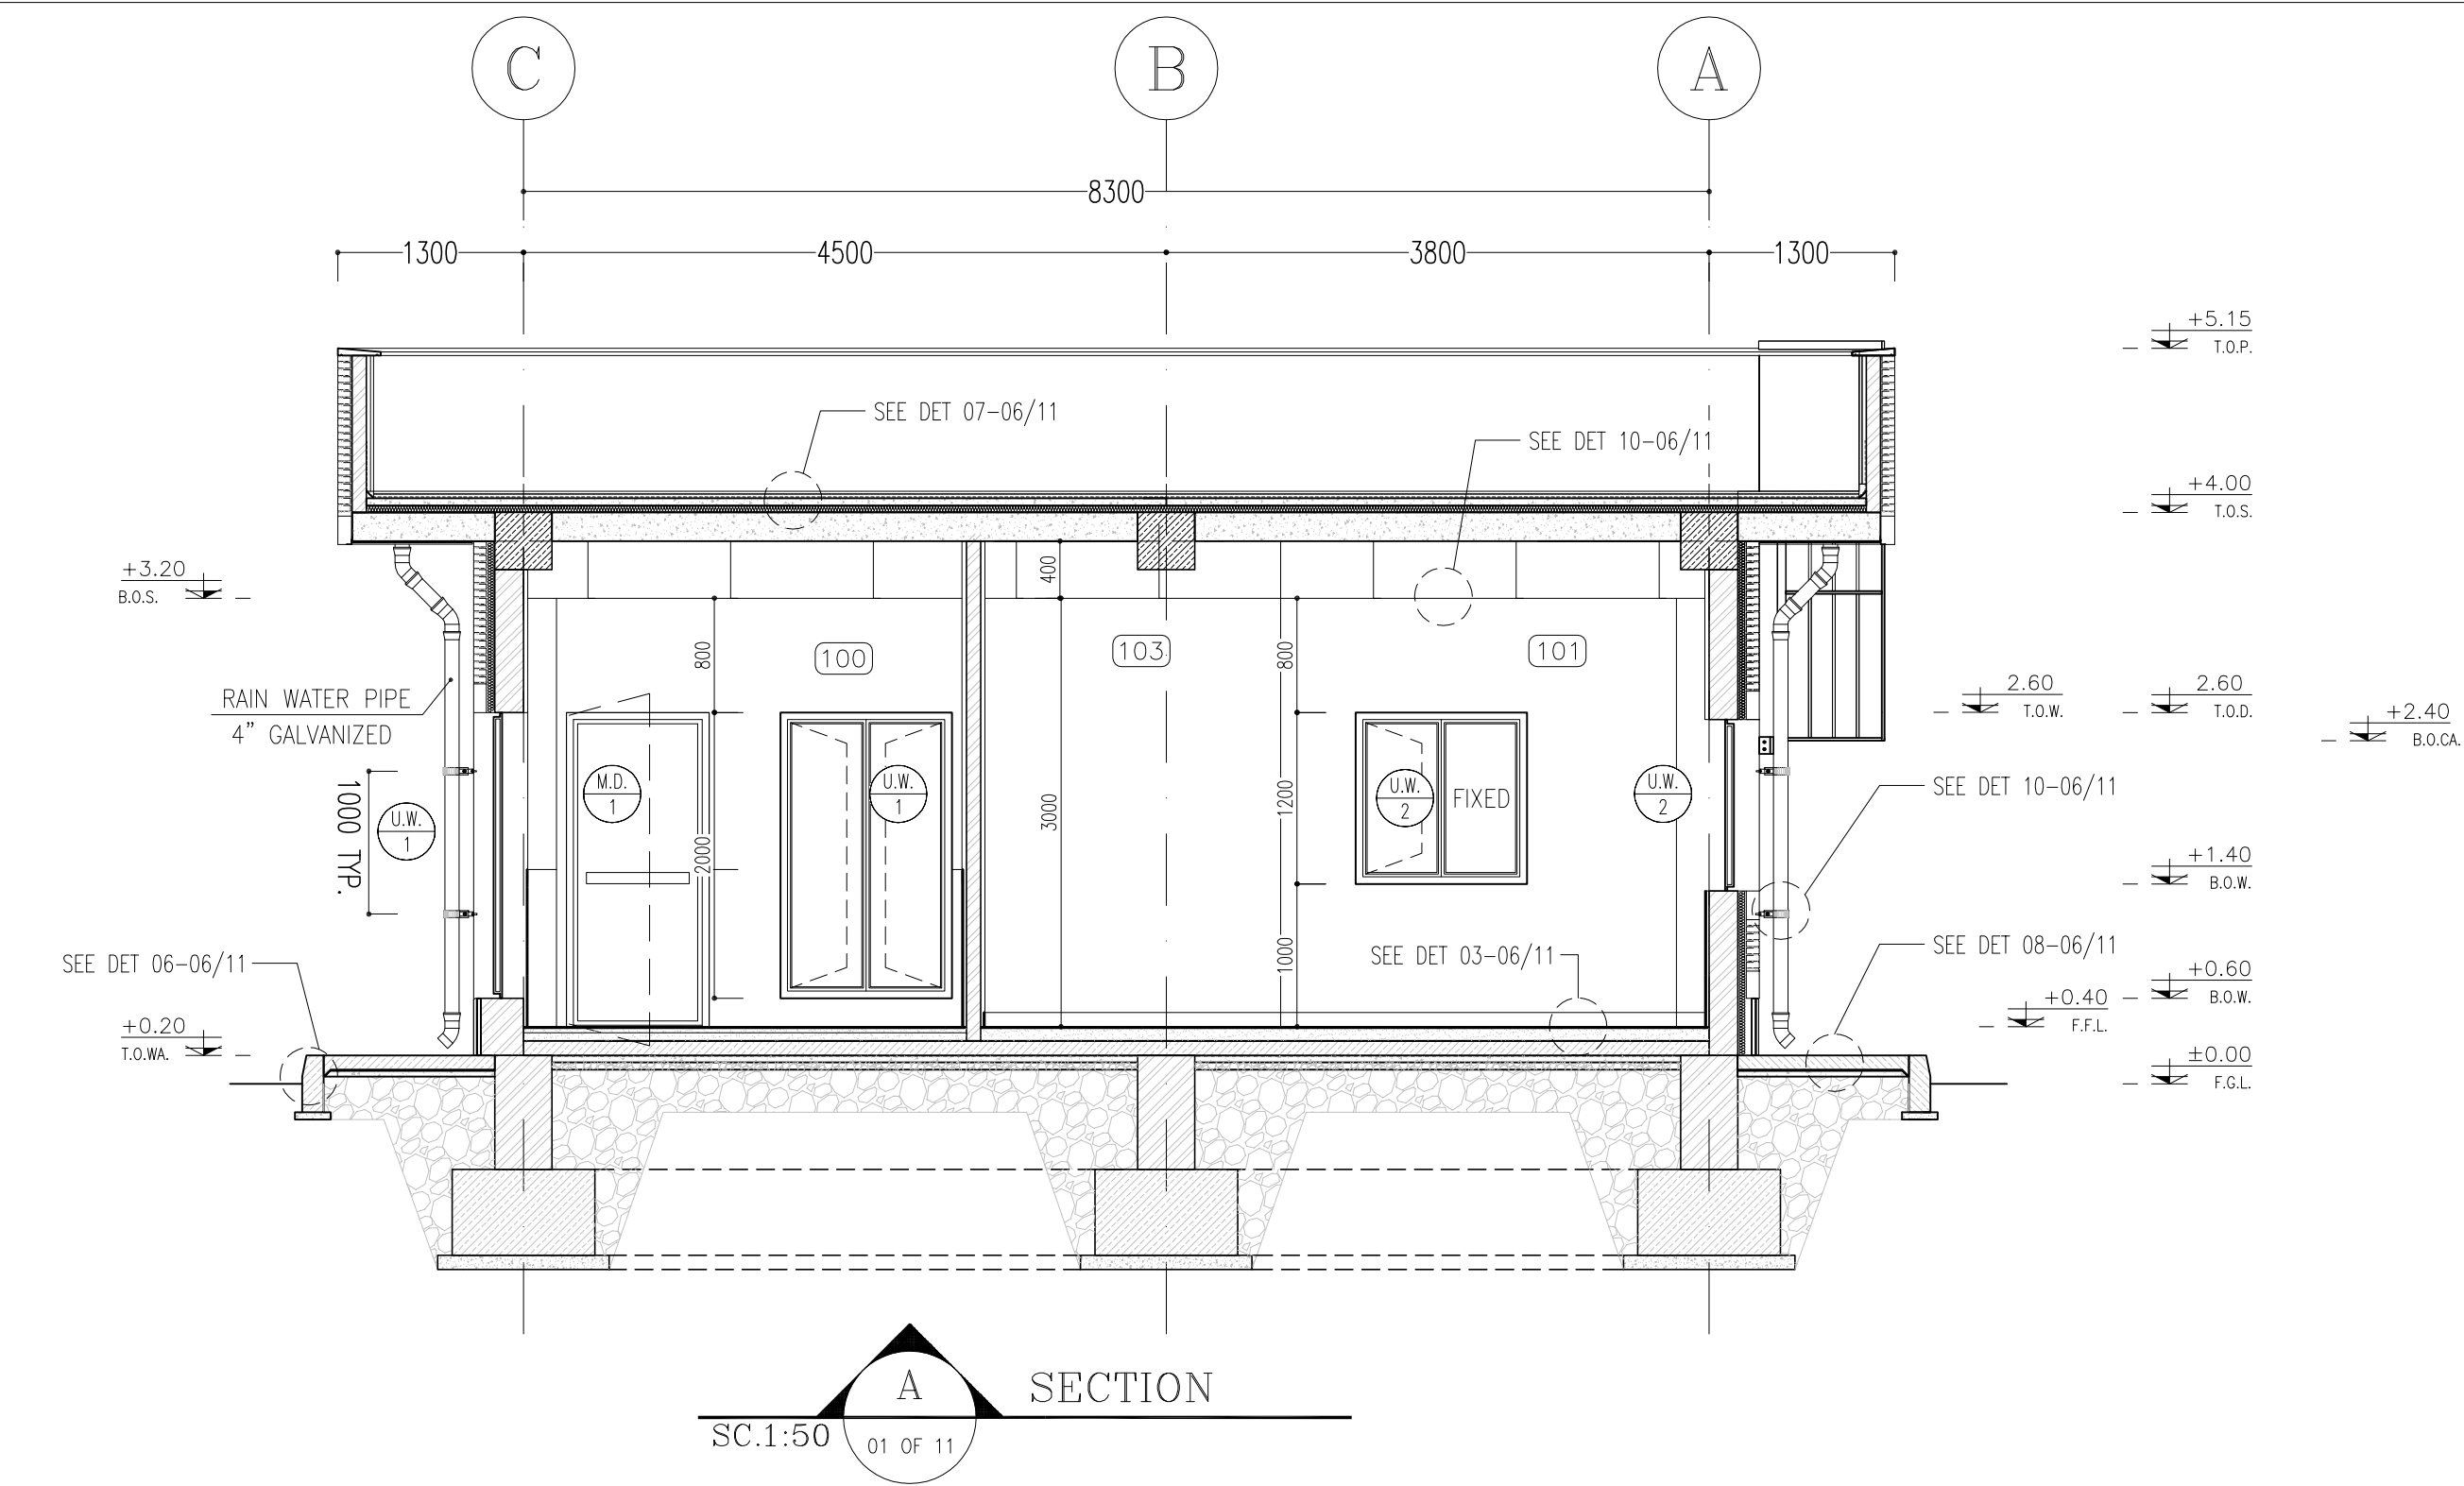


- NOTES**
- 1- DIMENSIONS ARE IN "mm" AND ELEVATIONS IN "m" UNLESS SPECIFIED .
 - 2- ALL DIMENSIONS AND ELEVATIONS SHALL BE CHECKED BY THE CONTRACTOR PRIOR TO CONSTRUCTION.
 - 3- CONTRACTOR SHALL COMPARE ALL ARCHITECTURAL, MECHANICAL, ELECTRICAL, PIPING AND STRUCTURAL DRAWINGS AND IN CASE OF ANY CONFLICTS OR DISCREPANCY, INFORM THE ENGINEER.
 - 4- SLAB ON GRADE SHALL BE CONSTRUCTED AFTER EXECUTION OF CABLE TRENCH & EQUIPMENTS FOUNDATION.
 - 5- ALL MATERIALS ARE SELECTED FROM THE HIGHEST QUALITY AND SHALL BE APPROVED BY THE CLIENT.
 - 6- FOR COORDINATE REFER TO FINISH GRADING DOCUMENTS.
 - 7- FINISH GRADING LEVEL (BK14) ELEVATION : +185.55 m (GLOBAL) = ±0.00 (LOCAL)
 - 8- ALL EXTERNAL OPENINGS (WINDOWS AND DOORS) SHALL BE FIRE PROOF.
 - 9- DOUBLE GLAZED WINDOW WITH 2*6mm REINFORCED GLASS AND 6mm GAS FILLED GAP.
 - 10- WC DOORS SHALL BE WATERPROOF ABS TYPE WITH CLOSER MECHANISM.
 - 11- KNAUF GYPSUM BOARD TILES (60*60) cm (REGULAR 9.5 mm THICKNESS) WITH (1063).
 - 12- KNAUF PVC-COATED GYPSUM BOARD TILES (60*60)-(REGULAR 9.5mm THICKNESS) WITH (1063)-(PVC THICKNESS 0.35mm).


LEGEND

	BRICK WORK		BRICK FACING
	REINFORCED CONCRETE		GRAVEL
	TERRAZZO TILE		LEAN CONCRETE
	GYPSUM BOARD		BLOCKAGE
	BRICK FACING		SAND CEMENT MORTAR
	PAINTED ALMINUM STRIP (DUMPA)		
	CERAMIC TILES (30x30)		

F.F.L. FINISHED FLOOR LEVEL
T.O.W.A. TOP OF WALKWAY
T.O.P. TOP OF PARAPET
B.O.D. BOTTOM OF DOOR
T.O.W. TOP OF WINDOW
B.O.W. BOTTOM OF WINDOW
T.O.S. TOP OF SLAB
T.O.D. TOP OF DOOR
T.O.C.A. TOP OF CAGE
B.O.C.A. BOTTOM OF CAGE
B.O.O. BOTTOM OF OPENING
B.O.S. BOTTOM OF SUSPENDED CEILING

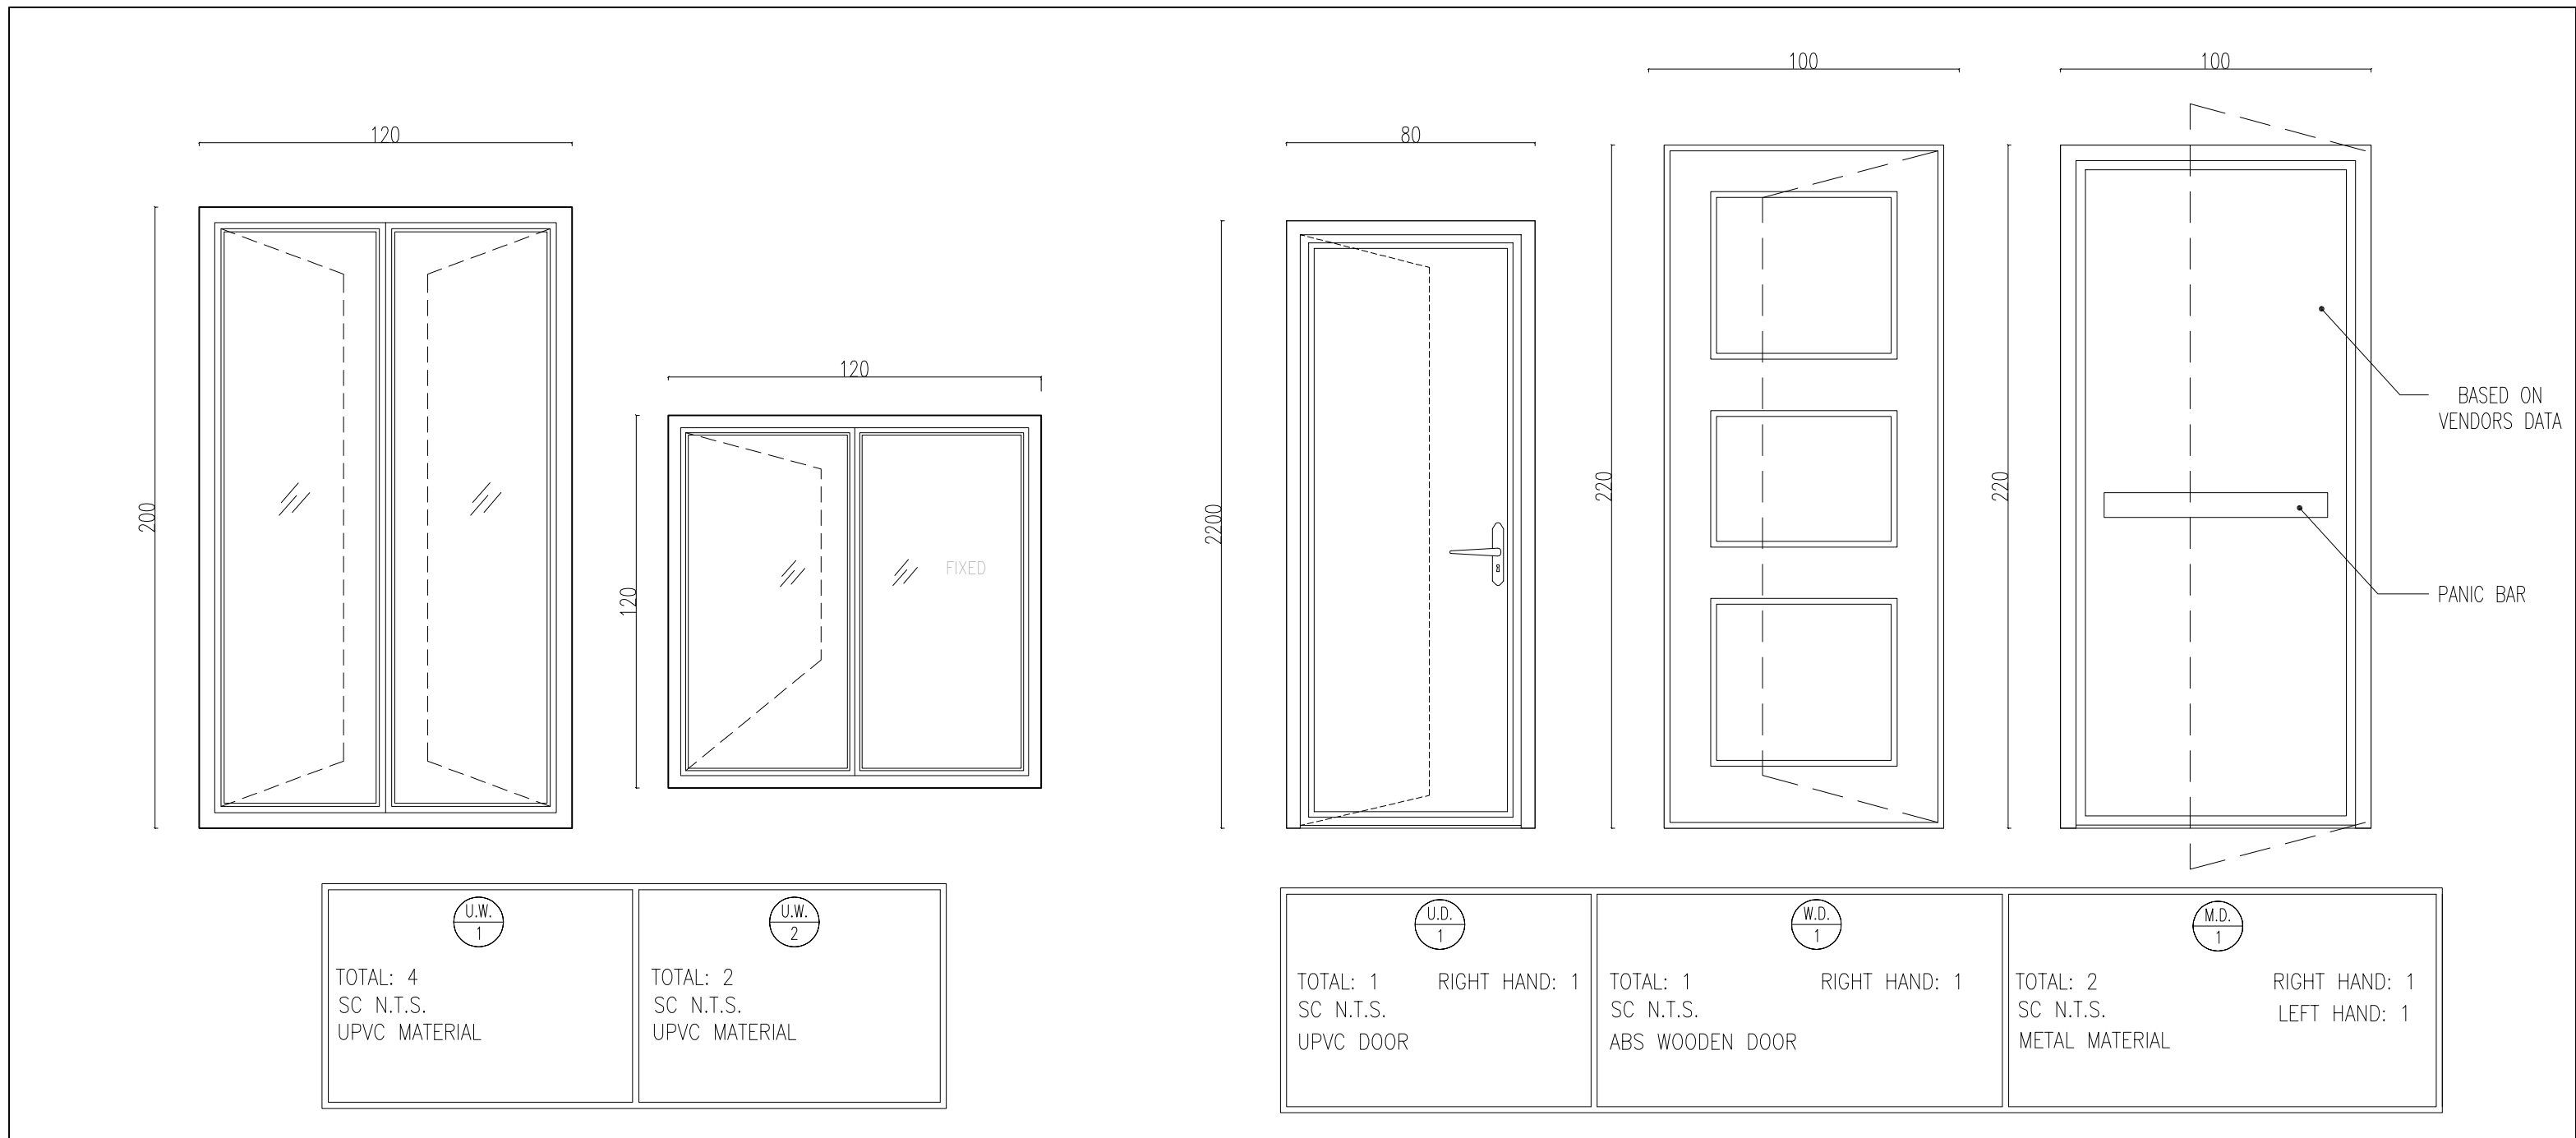

FINISHING SCHEDULE						
	AREA	FLOOR	MATERIAL DIMENSION	SKIRTING	WALL	CEILING
100	SECURITY GUARD ROOM	GRANITE PLAQUE STONE + REINFORCED CONCRETE	(60x60)	PLAQUE STONE (H=100cm)	GYPSUM PLASTER + CEMENT SAND PLASTER+OIL PAINT	GYPSUM BOARD (60X60)
101	RESTING AREA	GRANITE PLAQUE STONE	(60x60)	PLAQUE STONE (H=100cm)	GYPSUM PLASTER + CEMENT SAND PLASTER+OIL PAINT	GYPSUM BOARD (60X60)
102	WC	FIRST CLASS IRANIAN CERAMIC TILES	(30x30)	-	GLAZED TILE 25X30 UP TO +2.60	ANTI MOISTURE PLASTER TILE
103	PANTRY	FIRST CLASS IRANIAN CERAMIC TILES	(30x30)	-	GLAZED TILE 25X30 UP TO +2.60	ANTI MOISTURE PLASTER TILE
-	ROOF	TERRAZZO TILES	(30x30)	TERRAZZO TILES (H=100 cm)	-	-

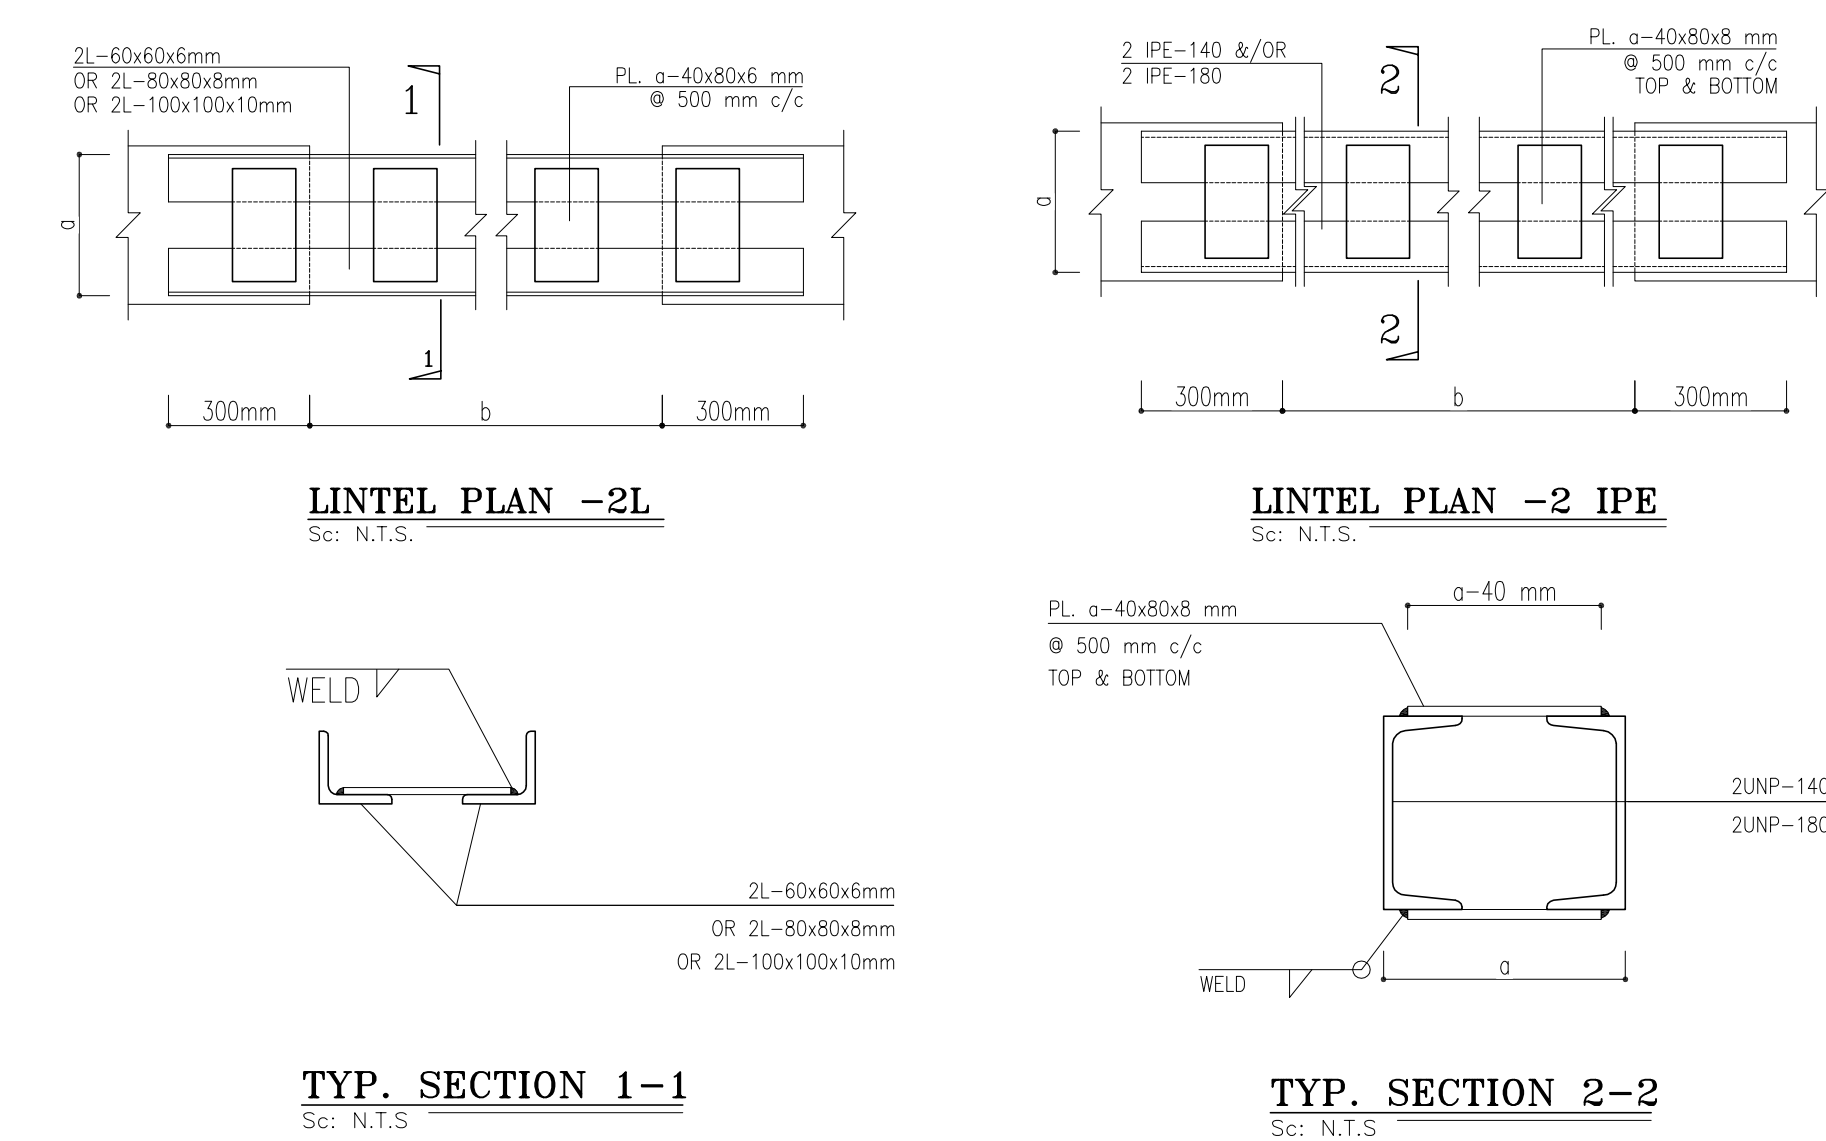

LINTEL SCHEDULE					
WIDTH a	SPAN b mm	PROFILE mm			
		a>200		a<200	
VARIES- IT DEPENDS ON WALL THICKNESS AND IT'S FINISHING. REFER TO ARCHITECTURAL DWGS.	b<1100	2L-60x60x6		UNP 100	
	1100<b<1500	2L-80x80x8		UNP 100	
	1500<b<2100	2L-100x100x10		2UNP 80	
	2100<b<3000	2UNP 160		2UNP 100	
	3000<b<3600	2UNP 180		2UNP 100	

7 FINISHING SCHEDULE

REV.	DATE	P.O.I.S	PREP.	CHK.	APP.	AUT.
D02	SEP.2023	APC	R.BERLOUIE	M.FAKHARIAN	S.Paramarspour	***
D01	FEB.2023	IFA	R.BERLOUIE	M.FAKHARIAN	M.Mehrshad	**
D00	APR.2022	IPC	R.BERLOUIE	M.FAKHARIAN	M.Mehrshad	**


PROJECT NAME: BINAK OILFIELD DEVELOPMENT/SUB-SURFACE WORK PACKAGES BK14 WHF MODIFICATIONS

PROJECT NO.: 971020

EPC CONTRACTOR:	EPD/EPC CONTRACTOR (GC):
HIRGAN ENERGY - DESIGN & INSPECTION COMPANIES	PEDCO

DRAWING TITLE: ARCHITECTURAL DRAWING FOR SECURITY BUILDING OF WELL PADS - BK-14 FINISHING, WINDOW AND DOOR TABLES

SCALE	SIZE	DRAWING NO.	SHEET NO.	REV.
AS SHOWN	A1	BK-BK14-PEDCO-110-AR-DW-0003	05 OF 11	D02

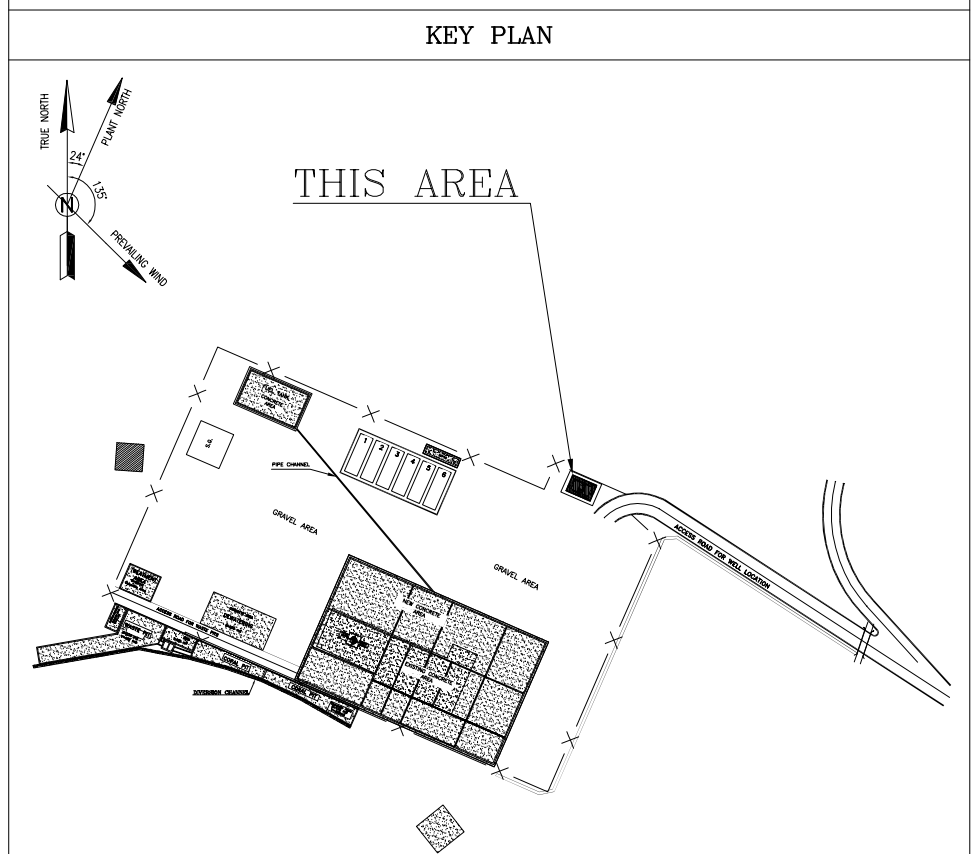

***	*****	** **	*** ****	** **	*** ****
REV.	DESCRIPTION	BY	DATE	BY	DATE
		CHECKED		REV. APPR.	

THE ORIGINAL AND ALL COPIES OF THIS DRAWING TOGETHER WITH THE COPYRIGHT THEREIN ARE THE SOLE PROPERTY OF N.I.S.O.C./ FIELDS












BINAK OILFIELD DEVELOPMENT SUB-SURFACE WORK PACKAGES BK14 WHF MODIFICATIONS

DATE	SCALE	DRAWING BY	CHECKED BY	PROJECT ENG.
------	-------	------------	------------	--------------

NO CONSTRUCTION PERMITTED UNLESS DRAWING APPROVED

APPROVED FOR CONSTRUCTION	BY:	DATE:
BUDGET REF.	LOCATION	SIZE CLASS
SHEET	SERIAL NO.	SHEET
REVISION		

8 LINTEL SCHEDULE

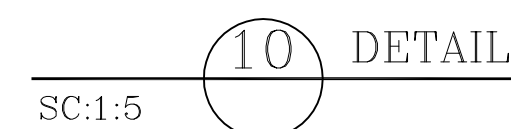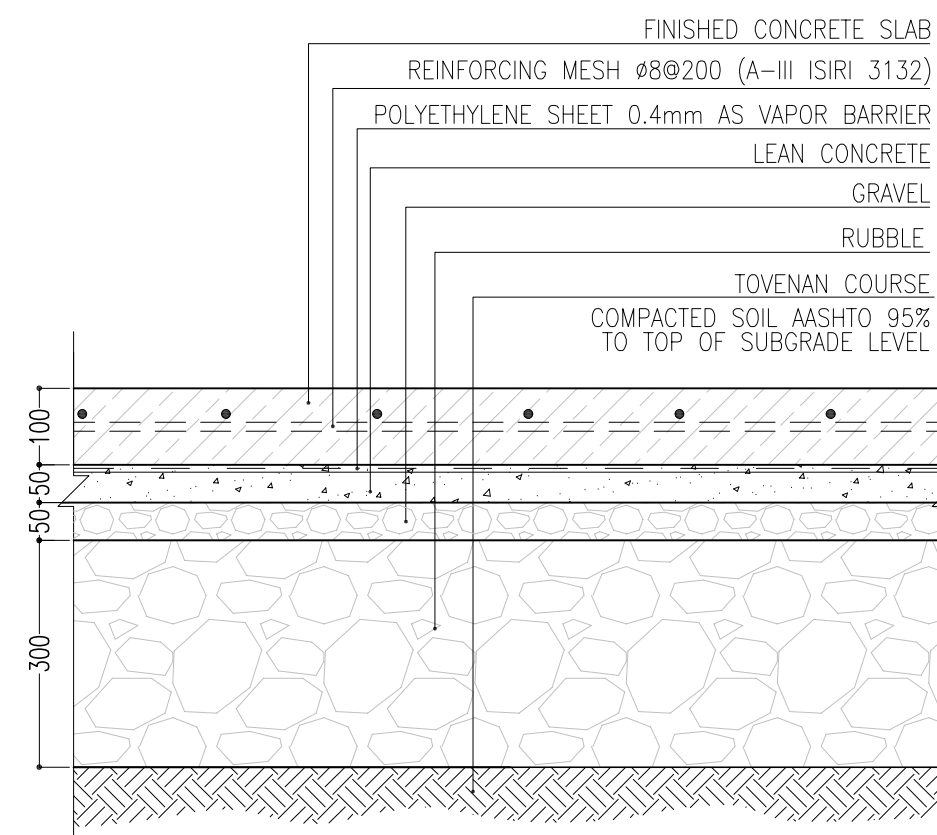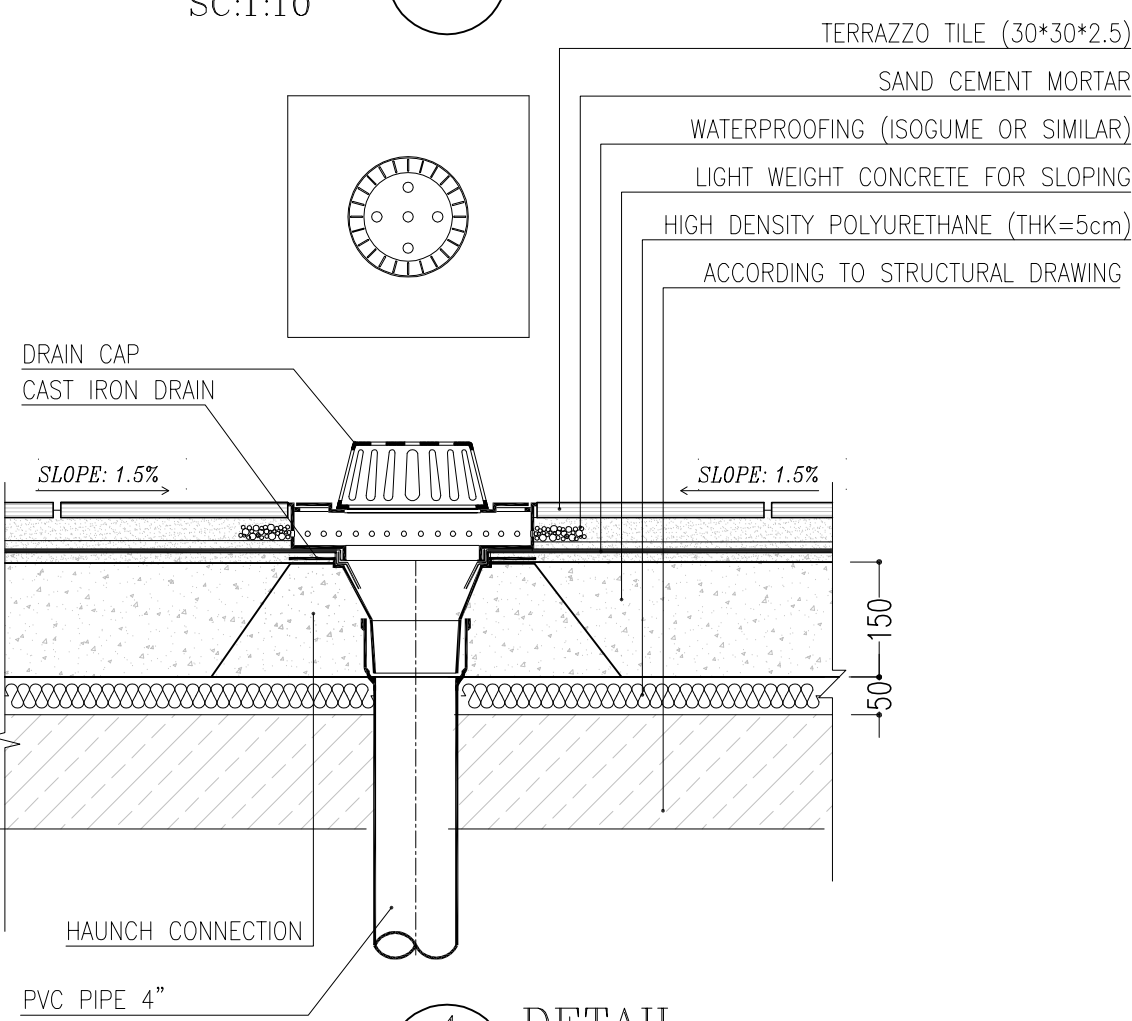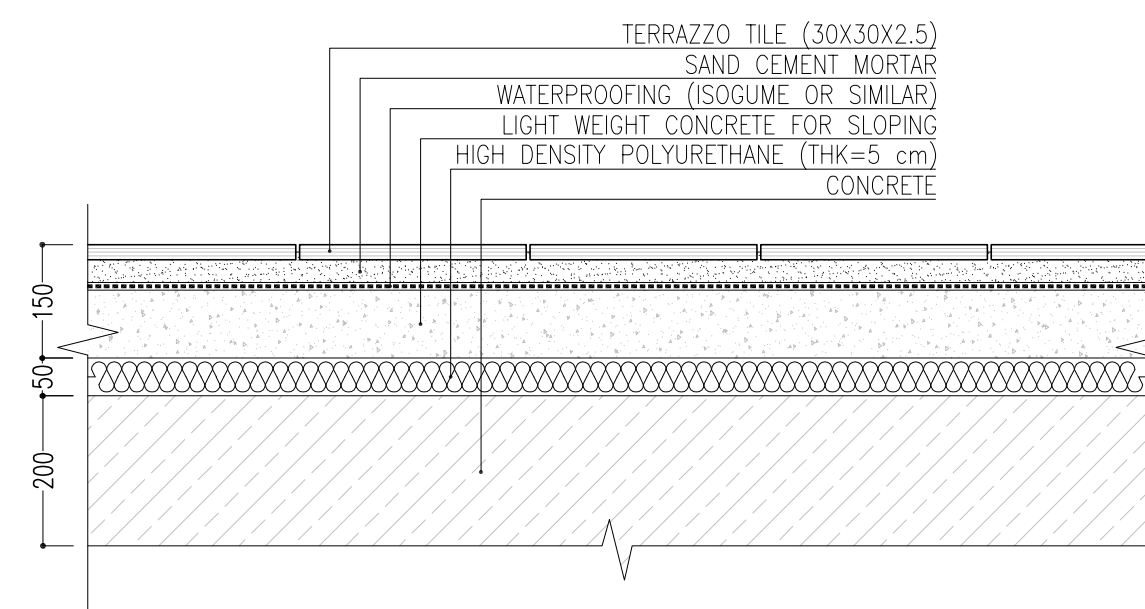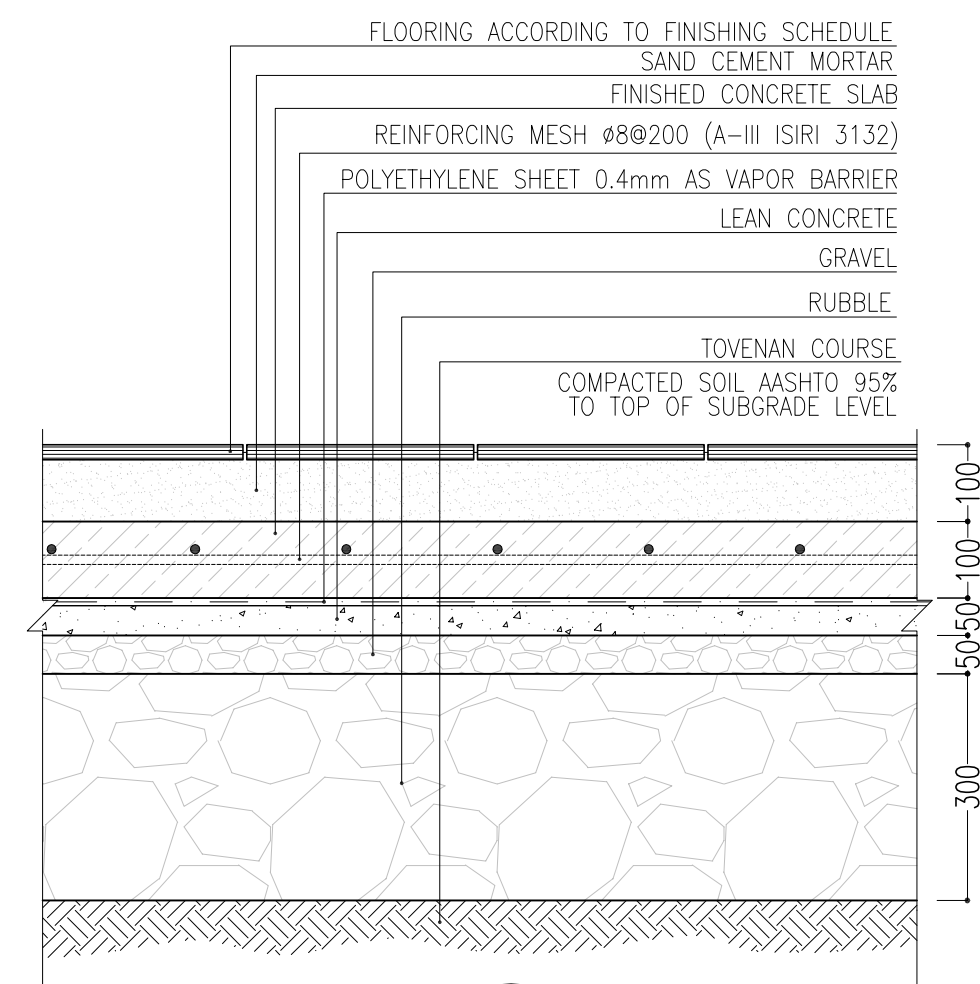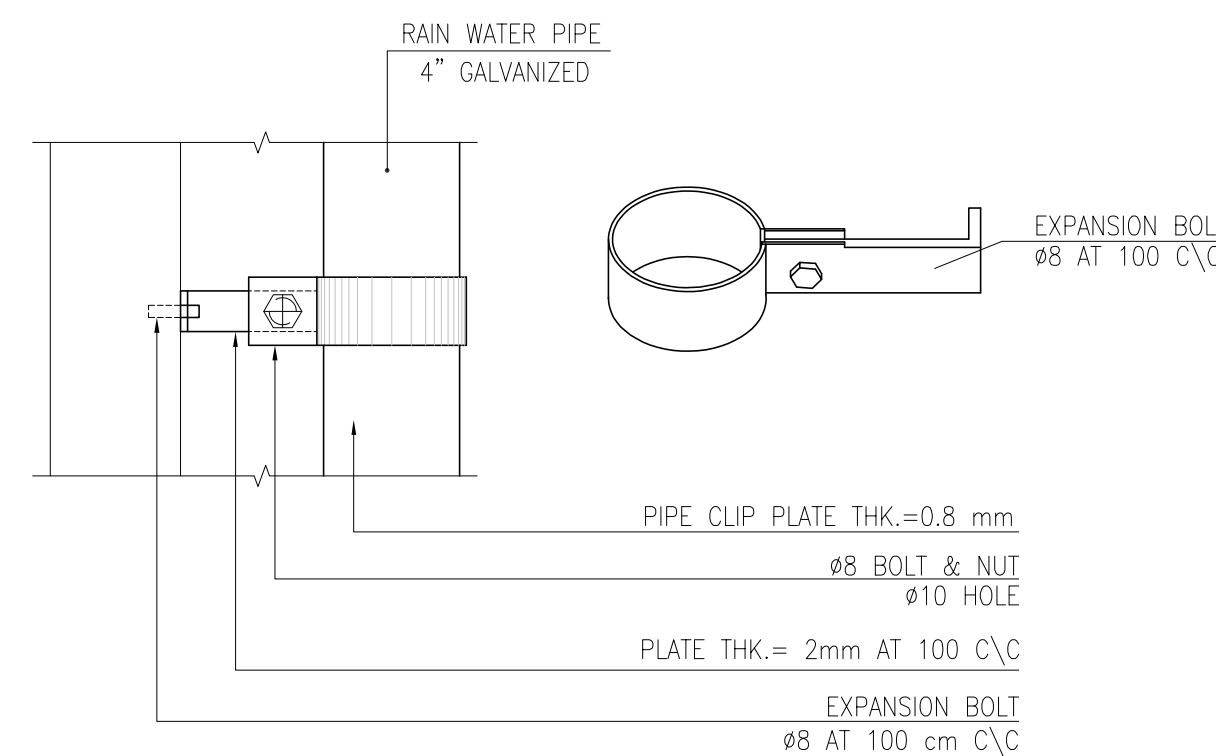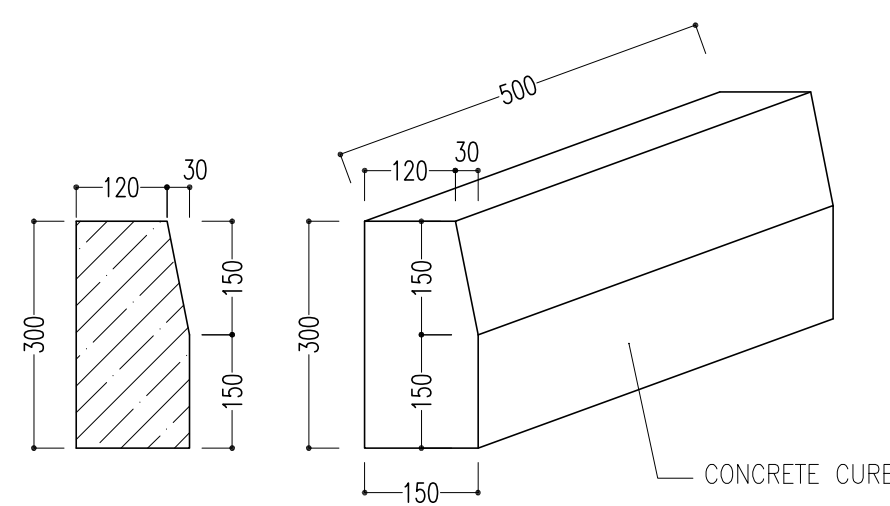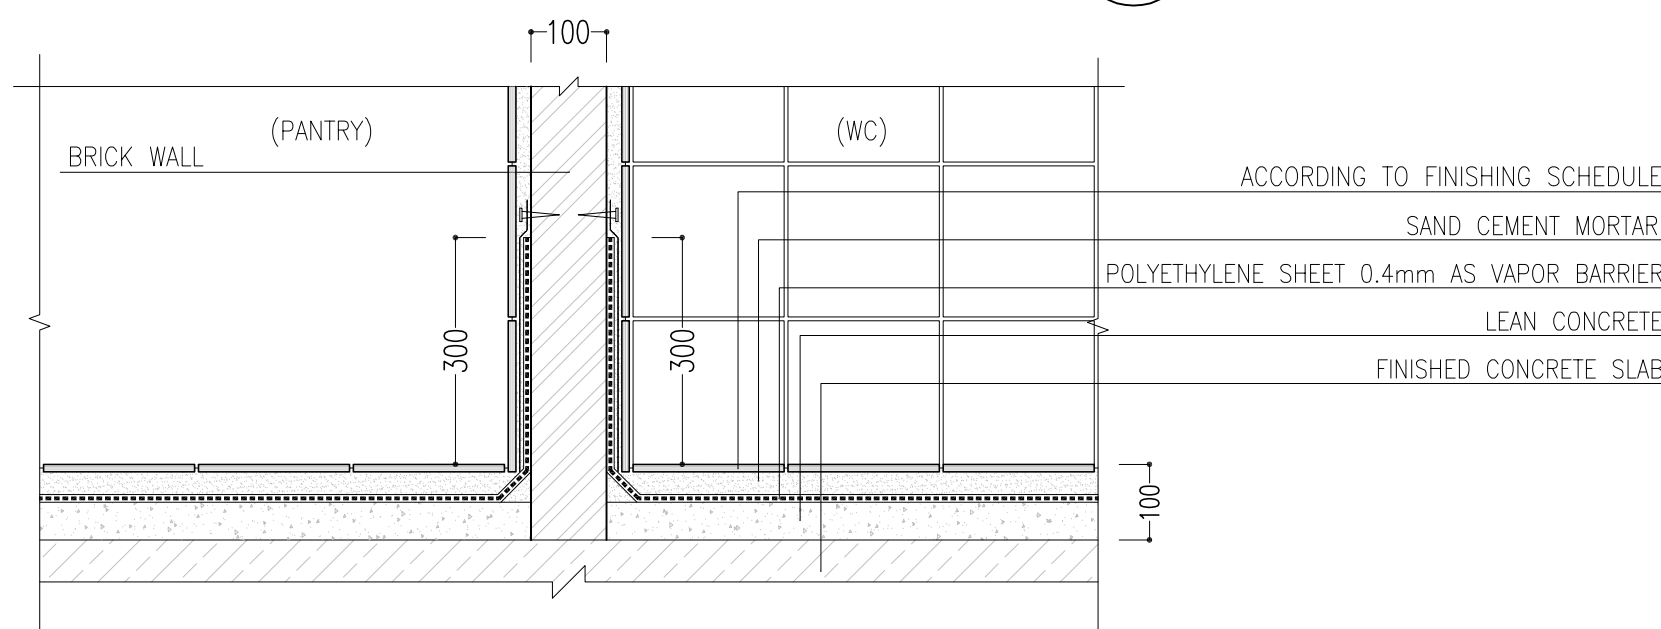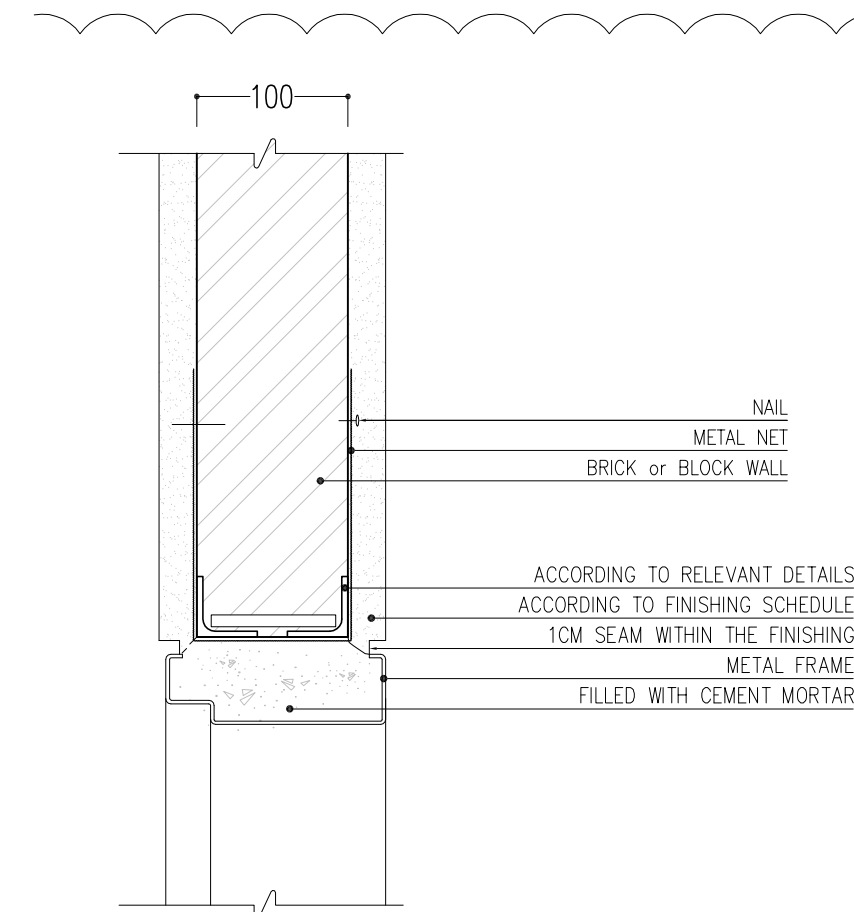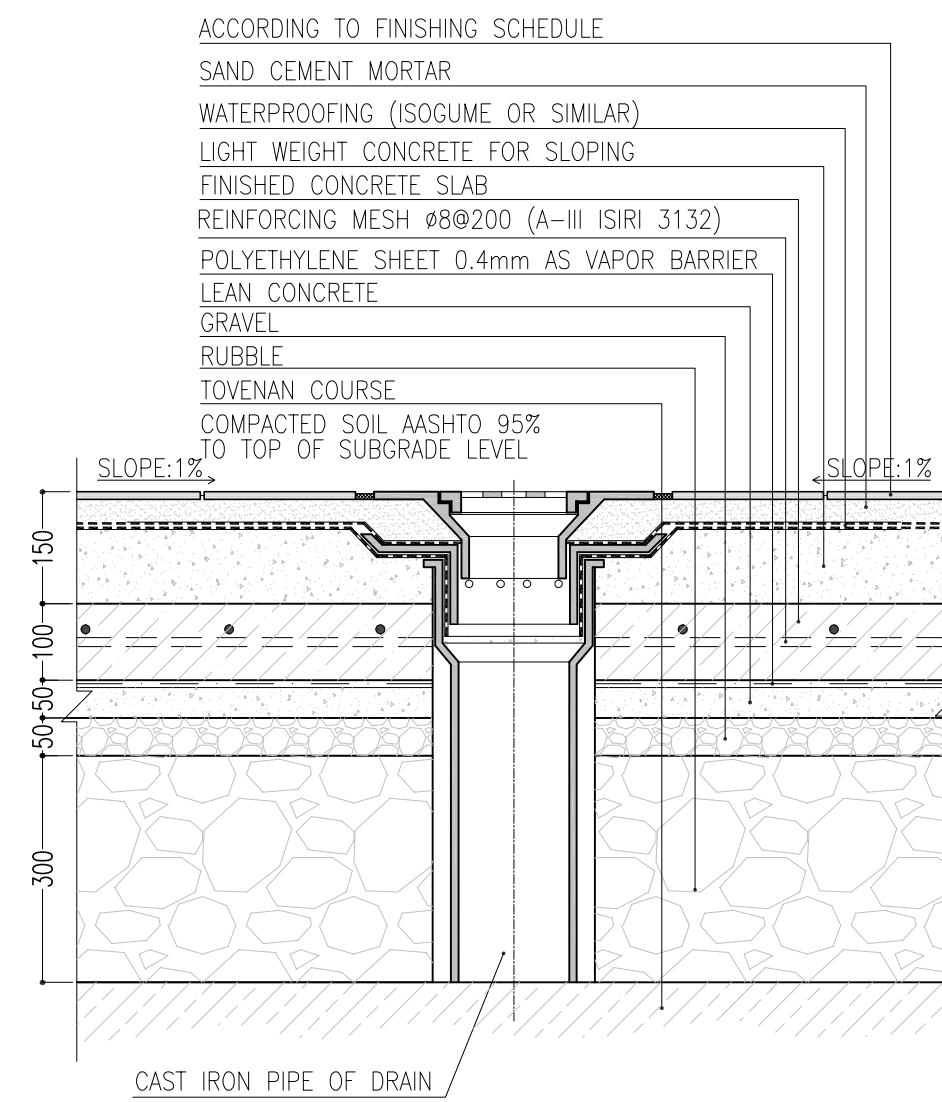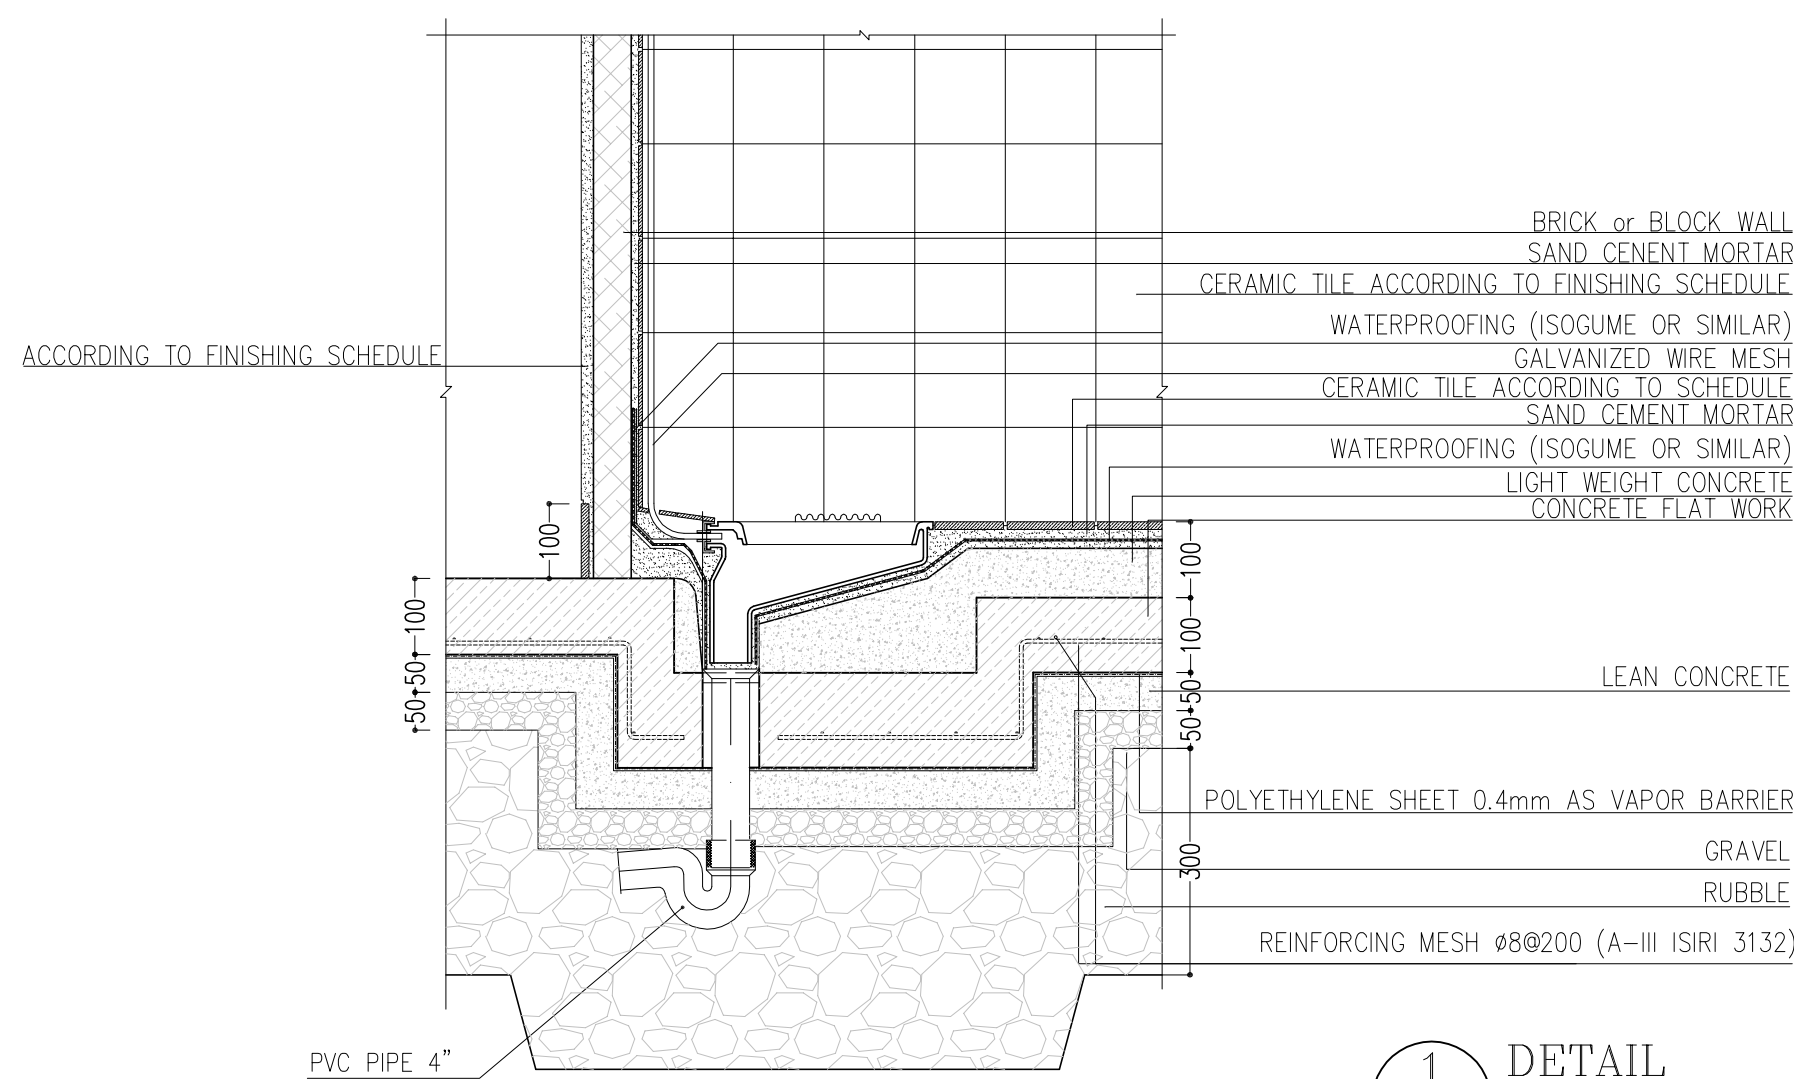

NOTES



- 1- DIMENSIONS ARE IN "mm" AND ELEVATIONS IN "m" UNLESS SPECIFIED .
- 2- ALL DIMENSIONS AND ELEVATIONS SHALL BE CHECKED BY THE CONTRACTOR PRIOR TO CONSTRUCTION.
- 3- CONTRACTOR SHALL COMPARE ALL ARCHITECTURAL, MECHANICAL, ELECTRICAL, PIPING, AND STRUCTURAL REQUIREMENTS IN CASE OF ANY CONFLICTS OR DISCREPANCIES, INFORM THE ENGINEER.
- 4- SLAB ON GRADE SHALL BE CONSTRUCTED AFTER EXECUTION OF CABLE TRENCH & EQUIPMENTS FOUNDATION.
- 5- ALL MATERIALS ARE SELECTED FROM THE HIGHEST QUALITY AND SHALL BE APPROVED BY THE CLIENT.
- 6- FOR COORDINATE REFER TO FINISH GRADING DOCUMENTS.
- 7- FINISH GRADING LEVEL (BK14) ELEVATION : +185.5 m (GLOBAL) = ±0.00 (LOCAL).
- 8- ALL EXTERNAL OPENINGS (WINDOWS AND DOORS) SHALL BE FIRE PROOF.
- 9- DOUBLE GLAZED WINDOW WITH 2mm² Reinforced GLASS and 6mm gas FILLED GAP.
- 10- WC DOORS SHALL BE WATERPROOF ABS TYPE WITH CLOSER MECHANISM.
- 11- KNAUF GYPSUM BOARD TILES (60*60 cm) (REGULAR 9.5 mm THICKNESS) WITH (1063).
- 12- KNAUF PVC-COATED GYPSUM BOARD TILES (60*60)-(REGULAR 9.5mm THICKNESS) WITH (1063)-(PVC THICKNESS 0.35mm).

LEGEND			
	BRICK WORK		BRICK FACING
	REINFORCED CONCRETE		GRAVEL
	TERRAZZO TILE		LEAN CONCRETE
	GYPSUM BOARD		BLOCKAGE
	BRICK FACING		SAND CEMENT MORTAR
	PAINTED ALUMINUM STRIP (DUMPA)		
	CERAMIC TILES (30x30)		

F.F.L.	FINISHED FLOOR LEVEL
T.O.W.A.	TOP OF WALKWAY
T.O.P.	TOP OF PARAPET
B.O.D.	BOTTOM OF DOOR
T.O.W.	TOP OF WINDOW
B.O.W.	BOTTOM OF WINDOW
T.O.S.	TOP OF SLAB
T.O.D.	TOP OF DOOR
T.O.C.A.	TOP OF CAGE
B.O.C.A.	BOTTOM OF CAGE
B.O.O.	BOTTOM OF OPENING
B.O.S.	BOTTOM OF SUSPENDED CEILING

REFERENCE DRAWING	DRG. No.
STANDARD DRAWING FOR ARCHITECTURAL DETAILS	BK-GNRL-PEDCO-000-AR-DW-0001
STANDARD DETAILS FOR LADDER & SAFETY CAGE	BK-GNRL-PEDCO-000-ST-DW-0009
FOUNDATION DRAWING FOR SECURITY BUILDING FOR WELL PADS - BK-14	BK-BK14-PEDCO-110-ST-DW-0002
STRUCTURAL DRAWING FOR SECURITY BUILDING FOR WELL PADS - BK-14	BK-BK14-PEDCO-110-ST-DW-0003
HVAC SYSTEM LAYOUT FOR SECURITY BUILDING - BK14	BK-BK14-PEDCO-110-HV-PY-0004
PLUMBING & SEWAGE PIPING LAYOUT FOR SECURITY BUILDING - BK14	BK-BK14-PEDCO-110-HY-PY-0004
LIGHTING & SMALL POWER WIRING FOR SECURITY BUILDING FOR WELL PADS - BK-14	BK-SGSR-PEDCO-110-EL-PY-0005

[illegible][illegible]

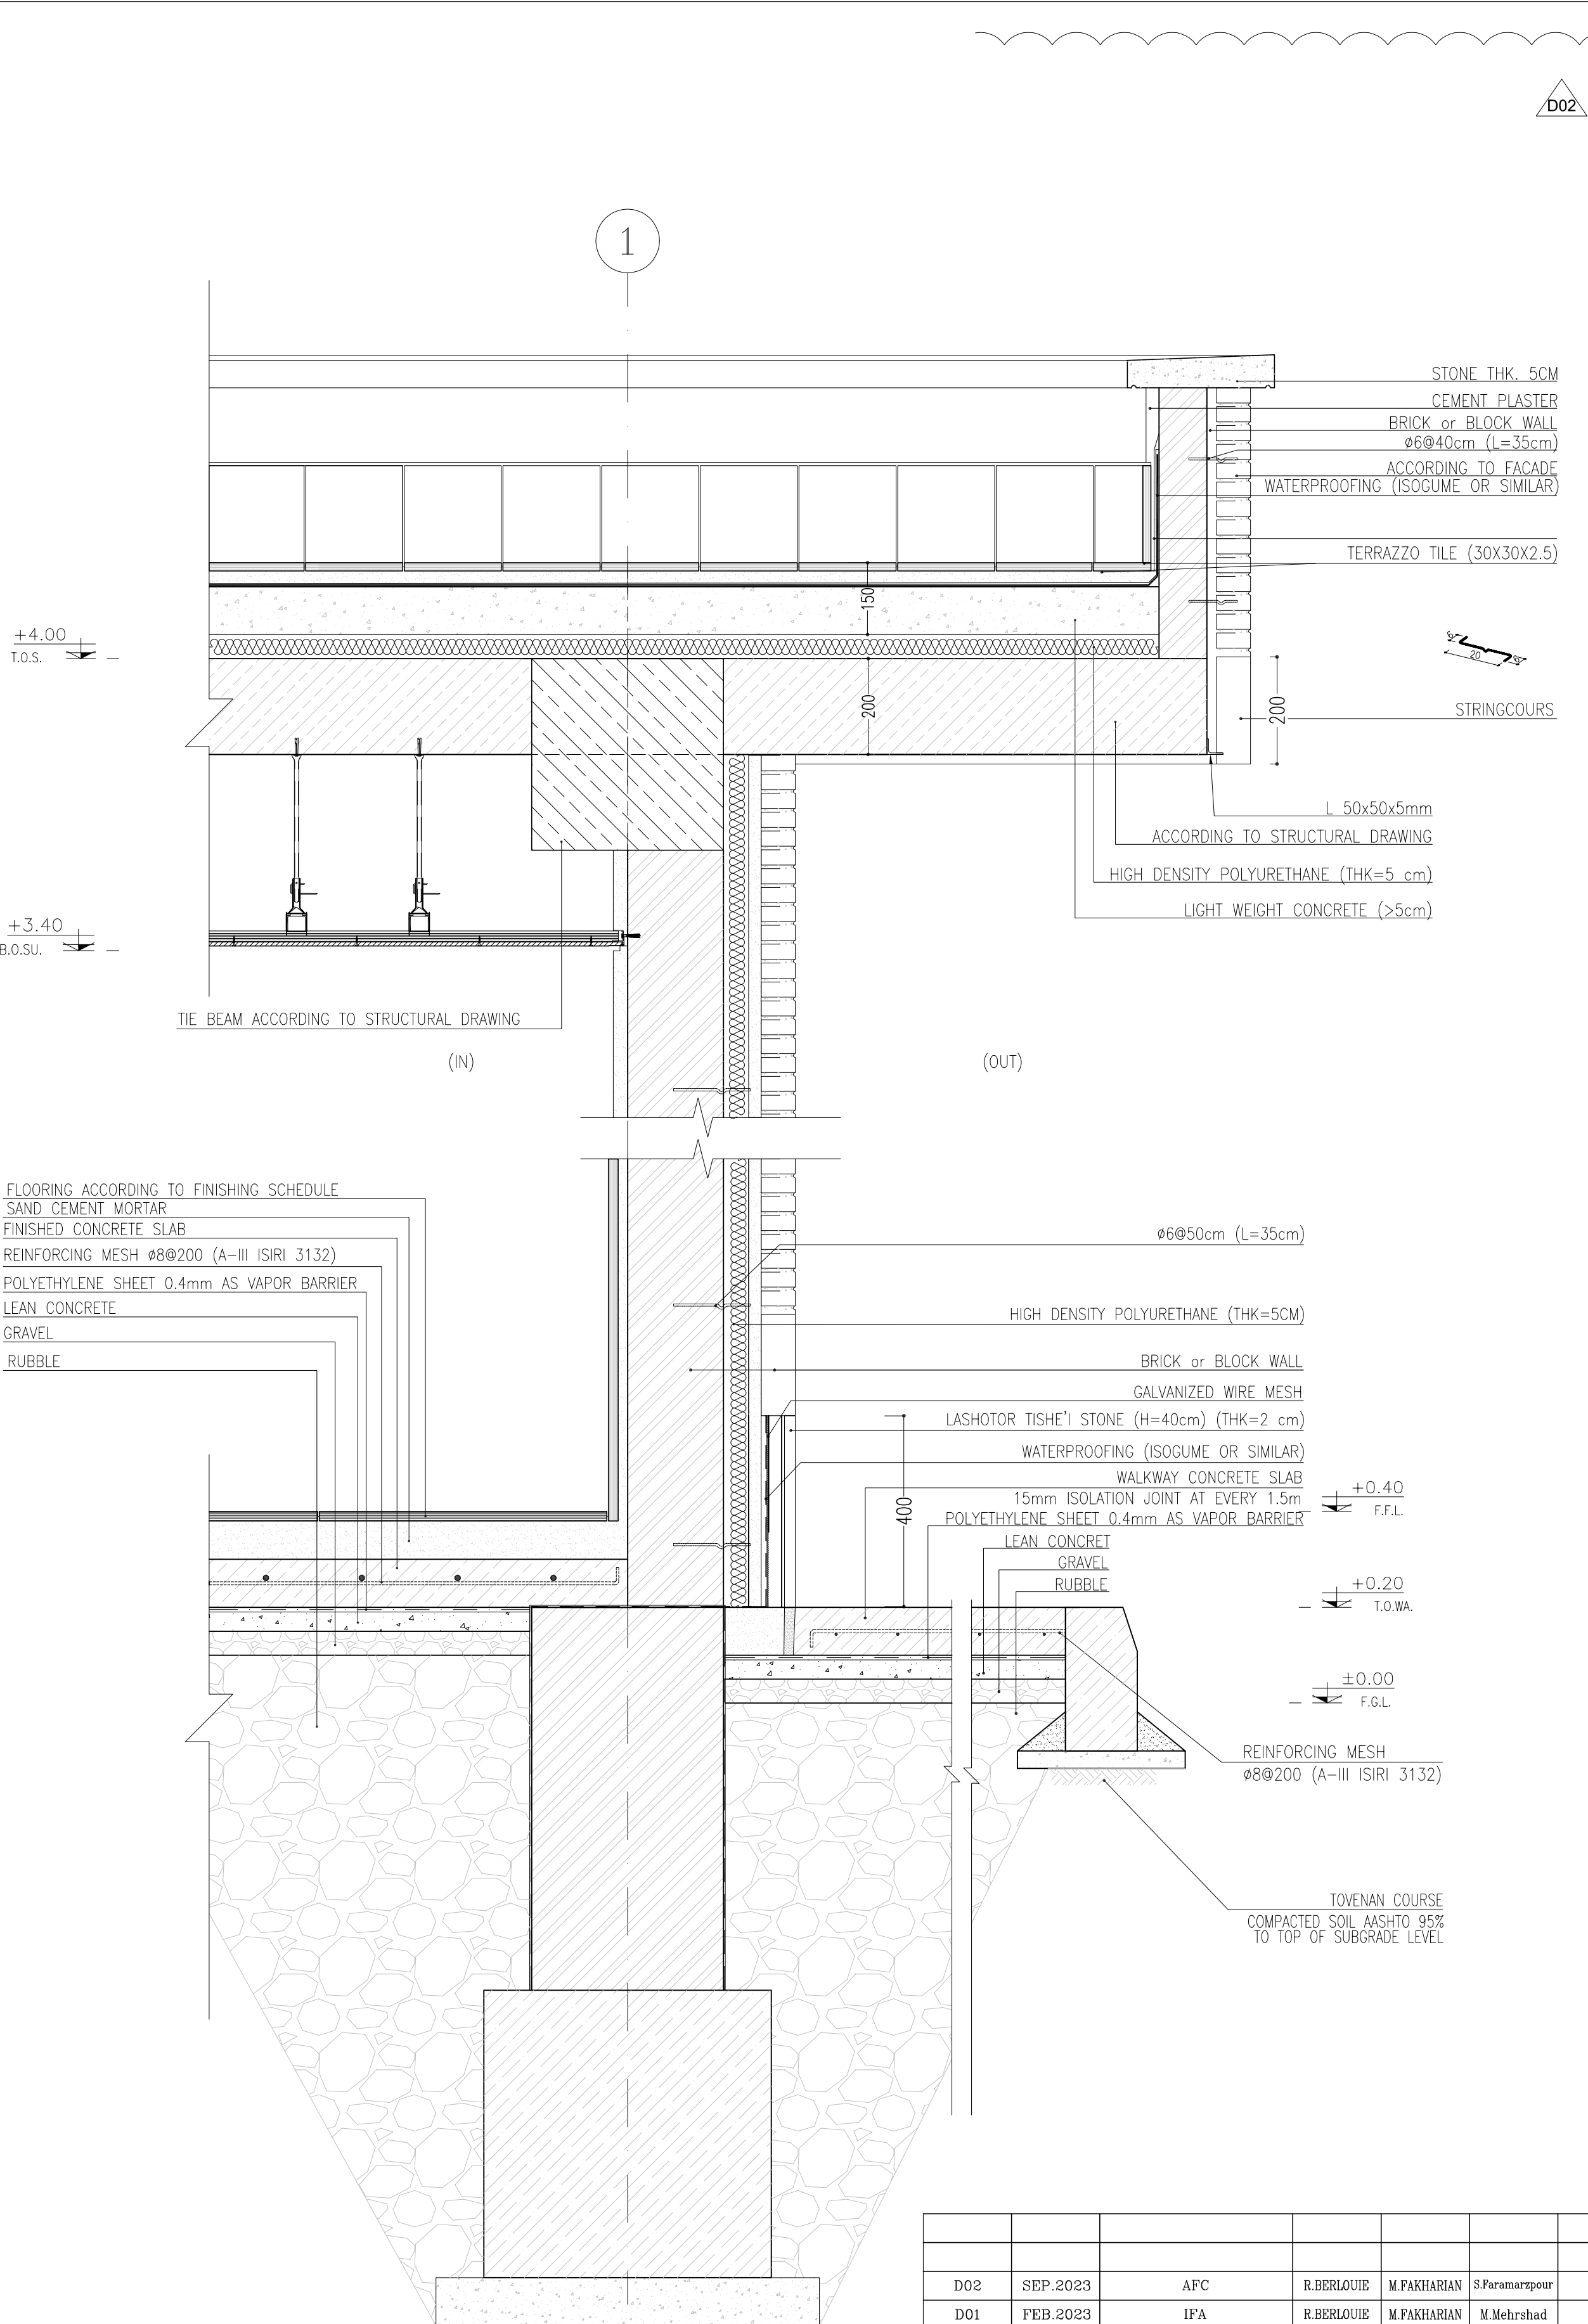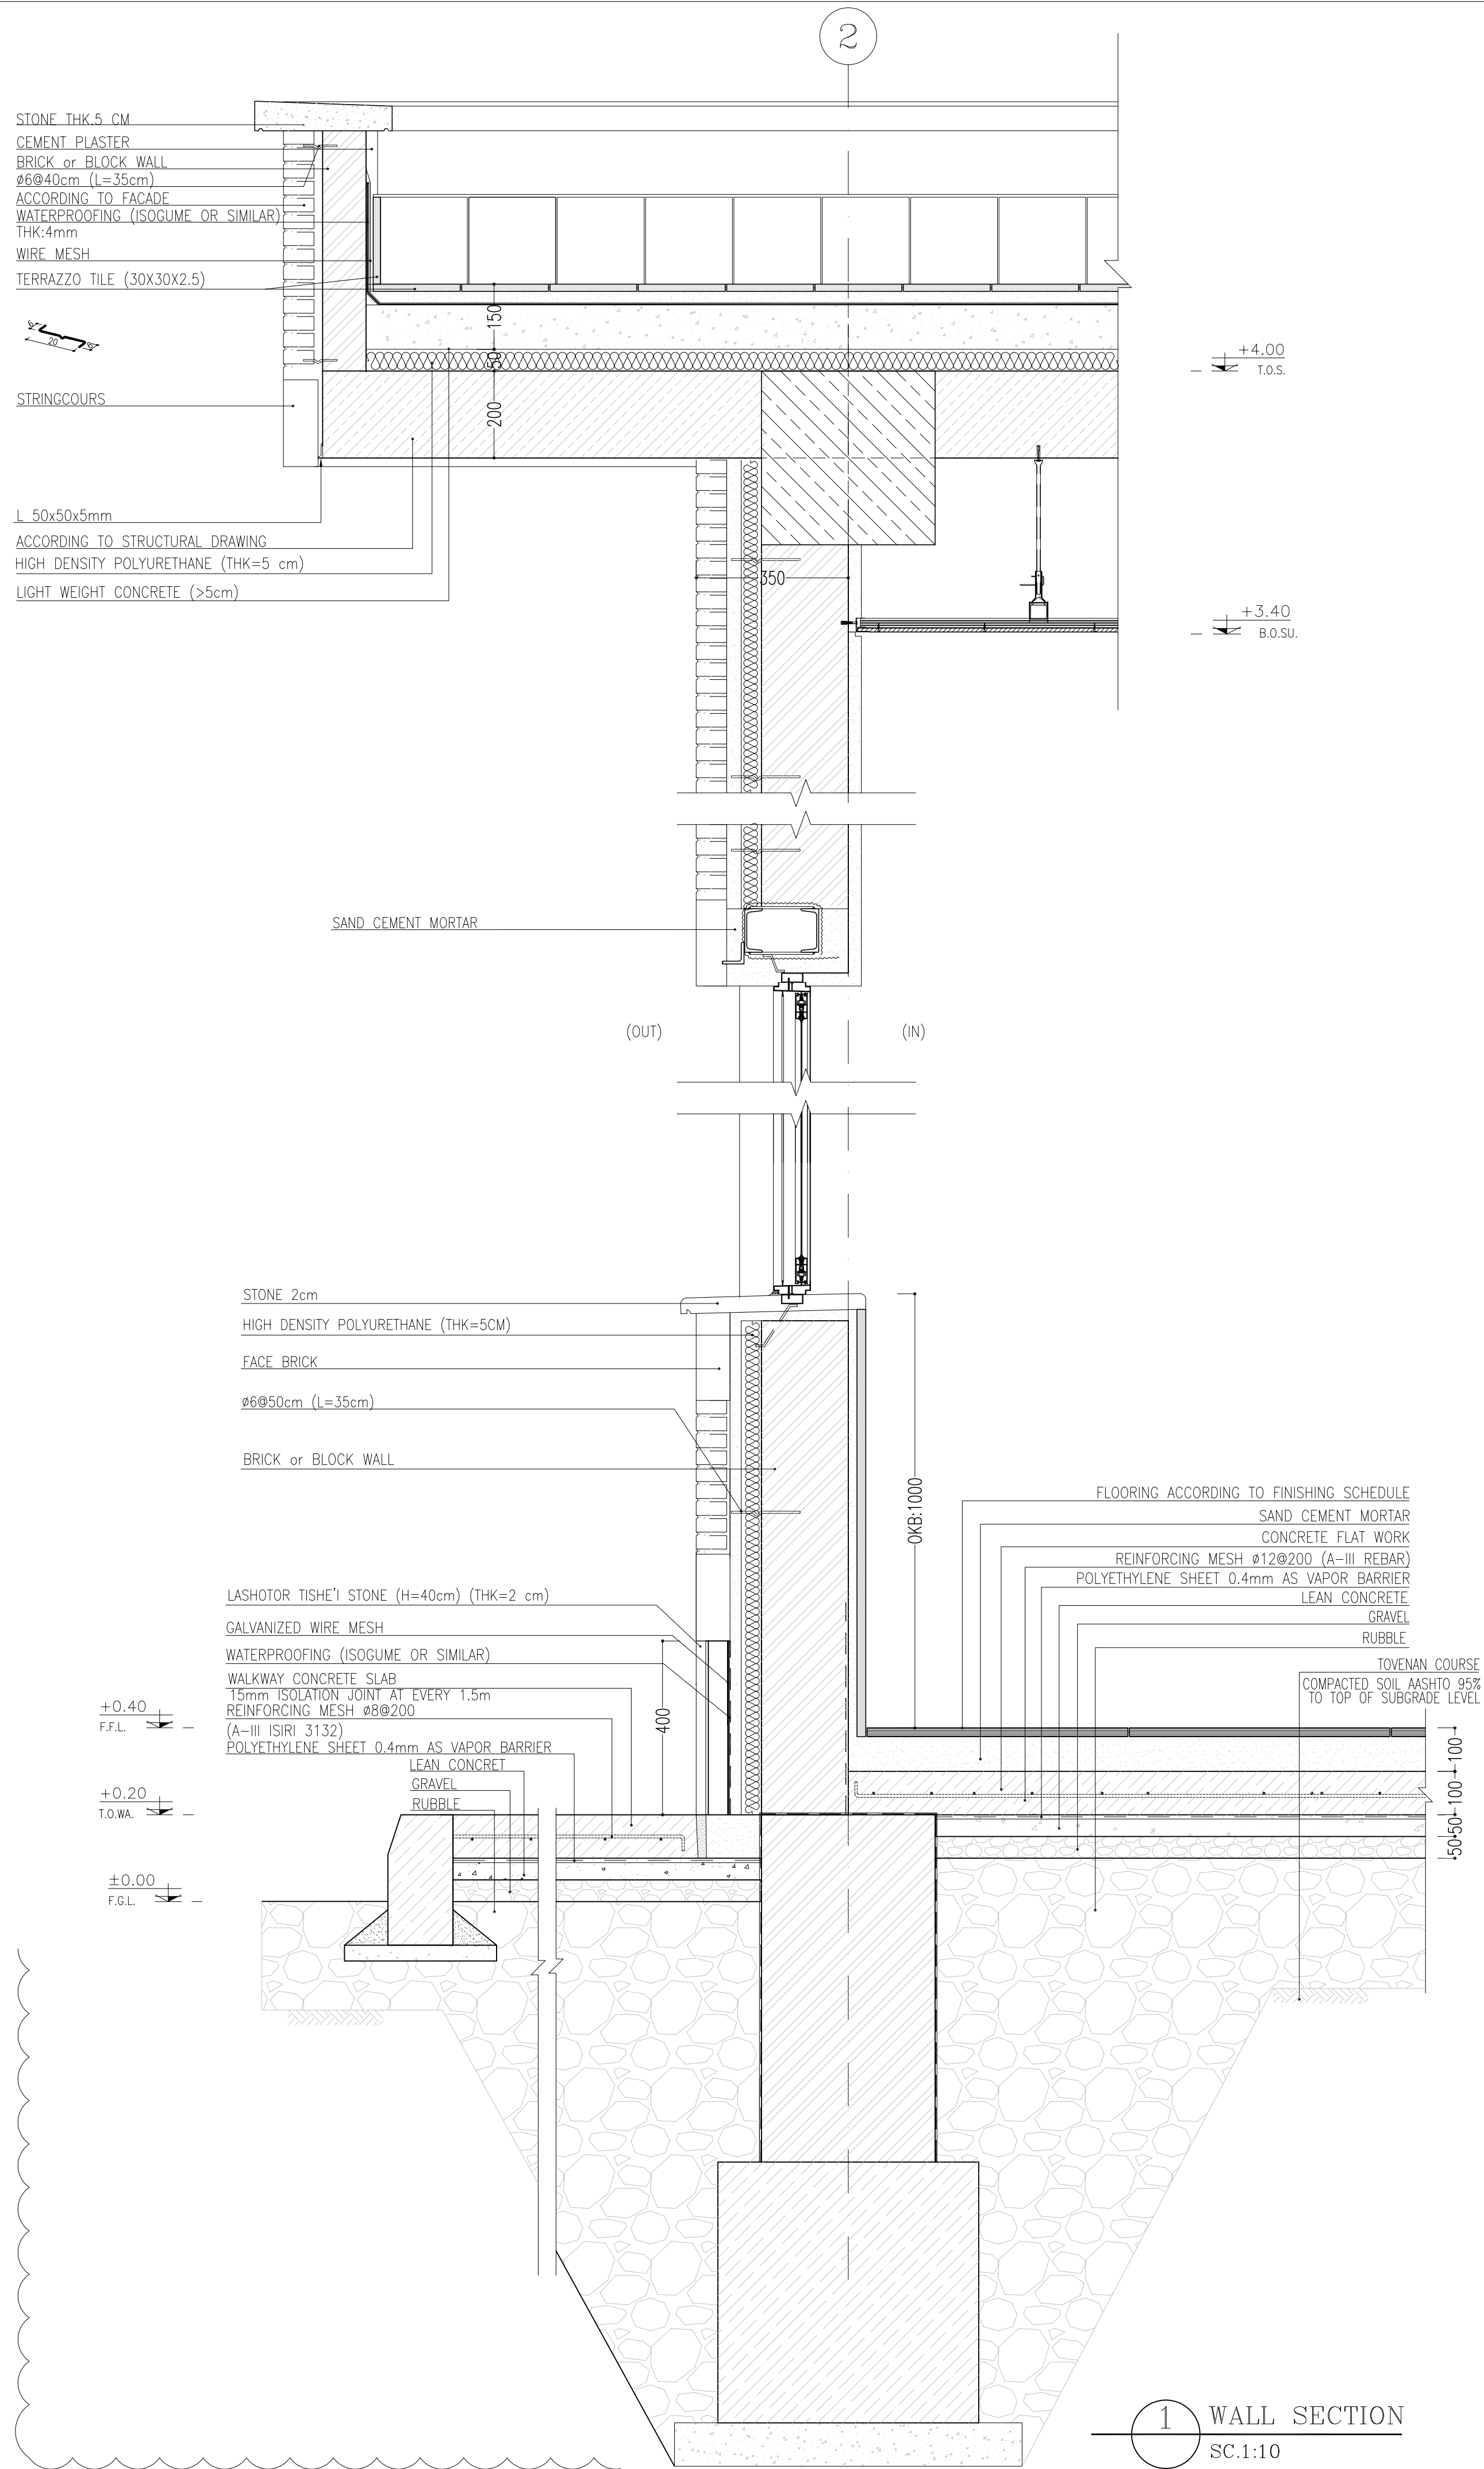

NOTES	
1-	DIMENSIONS ARE IN "mm" AND ELEVATIONS IN "m" UNLESS SPECIFIED .
2-	ALL DIMENSIONS AND ELEVATIONS SHALL BE CHECKED BY THE CONTRACTOR PRIOR TO CONSTRUCTION.
3-	CONTRACTOR SHALL COMPARE ALL ARCHITECTURAL, MECHANICAL, ELECTRICAL, PIPING AND STRUCTURAL DRAWINGS AND IN CASE OF ANY CONFLICTS OR DISCREPANCY, INFORM THE ENGINEER.
4-	SLAB ON GRADE SHALL BE CONSTRUCTED AFTER EXECUTION OF CABLE TRENCH & EQUIPMENTS FOUNDATION.
5-	ALL MATERIALS ARE SELECTED FROM THE HIGHEST QUALITY AND SHALL BE APPROVED BY THE CLIENT.
6-	FOR COORDINATE REFER TO FINISH GRADING DOCUMENTS.
7-	FINISH GRADING LEVEL (BK14) ELEVATION : +185.55 m (GLOBAL) = ±0.00 (LOCAL)
8-	ALL EXTERNAL OPENINGS (WINDOWS AND DOORS) SHALL BE FIRE PROOF.
9-	DOUBLE GLAZED WINDOW WITH 2*6mm RAINFORCED GLASS AND 6mm GAS FILLED GAP.
10-	WC DOORS SHALL BE WATERPROOF ABS TYPE WITH CLOSER MECHANISM.
11-	KNAUF GYPSUM BOARD TILES (60*60) cm (REGULAR 9.5 mm THICKNESS) WITH (1063).
12-	KNAUF PVC-COATED GYPSUM BOARD TILES (60*60)-(REGULAR 9.5mm THICKNESS) WITH (1063)-(PVC THICKNESS 0.35mm).

LEGEND			
	BRICK WORK		BRICK FACING
	REINFORCED CONCRETE		GRAVEL
	TERRAZZO TILE		LEAN CONCRETE
	GYPSUM BOARD		BLOCKAGE
	BRICK FACING		SAND CEMENT MORTAR
	PAINTED ALMINUM STRIP (DUMPA)		
	CERAMIC TILES (30x30)		

F.F.L.	FINISHED FLOOR LEVEL
T.O.WA.	TOP OF WALKWAY
T.O.P.	TOP OF PARAPET
B.O.D.	BOTTOM OF DOOR
T.O.W.	TOP OF WINDOW
B.O.W.	BOTTOM OF WINDOW
T.O.S.	TOP OF SLAB
T.O.D.	TOP OF DOOR
T.O.CA.	TOP OF CAGE
B.O.CA.	BOTTOM OF CAGE
B.O.O.	BOTTOM OF OPENING
B.O.S.	BOTTOM OF SUSPENDED CEILING

REFERENCE DRAWING	DRG. No.
STANDARD DRAWING FOR ARCHITECTURAL DETAILS	BK-GNRL-PEDCO-000-AR-DW-0001
STANDARD DETAILS FOR LADDER & SAFETY CAGE	BK-GNRL-PEDCO-000-ST-DW-0009
FOUNDATION DRAWING FOR SECURITY BUILDING FOR WELL PADS - BK-14	BK-BK14-PEDCO-110-ST-DW-0002
STRUCTURAL DRAWING FOR SECURITY BUILDING FOR WELL PADS - BK-14	BK-BK14-PEDCO-110-ST-DW-0003
HVAC SYSTEM LAYOUT FOR SECURITY BUILDING - BK14	BK-BK14-PEDCO-110-HV-PY-0002
PLUMBING & SEWAGE PIPING LAYOUT FOR SECURITY BUILDING - BK14	BK-BK14-PEDCO-110-HV-PY-0004
LIGHTING & SMALL POWER LAYOUT FOR SECURITY BUILDING OF WELL PADS	BK-SSGRU-PEDCO-110-EL-PY-0005

KEY PLAN	

***	*****	***	*****	***	*****
REV.	DESCRIPTION	BY	DATE	BY	DATE
		CHECKED		REV. APPR.	


اصل و کلیه نسخ این نقشه و حق اقتباس متعلق به شرکت ملی مناطق نفت خیز جنوب میباشد.

THE ORIGINAL AND ALL COPIES OF THIS DRAWING TOGETHER WITH THE COPYRIGHT THEREIN ARE THE SOLE PROPERTY OF N.I.S.O.C./ FIELDS








BINAK OILFIELD DEVELOPMENT
SUB-SURFACE WORK PACKAGES
BK14 WHF MODIFICATIONS

DATE	SCALE	DRAWING BY	CHECKED BY	PROJECT ENG.
------	-------	------------	------------	--------------

NO CONSTRUCTION PERMITTED UNLESS DRAWING APPROVED							
APPROVED FOR CONSTRUCTION				BY:	DATE:		
BUDGET REF.	LOCATION	SIZE	CLASS	SERIAL NO.	SHEET	REVISION	
053-073-9184	F	4	B	708207	07 OF 11	D02	

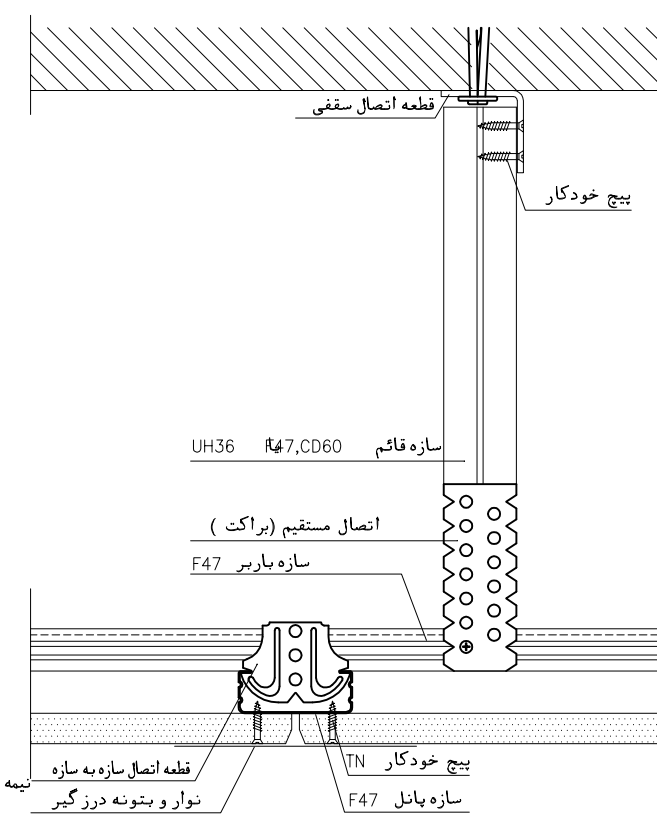


فواصل در زیرسازی فلزی حداکثر دانه (به میلی متر) بار سطحی P (KN/M ²)		
$0.30 < p \leq 0.50$	$0.15 < p \leq 0.30$	$p \leq 0.15$
600	750	900
فاصله دایره ها $-a-$		
750	1000	فاصله مرکز نامرکز بیرونی دایره ها با مرکز $-c-$

 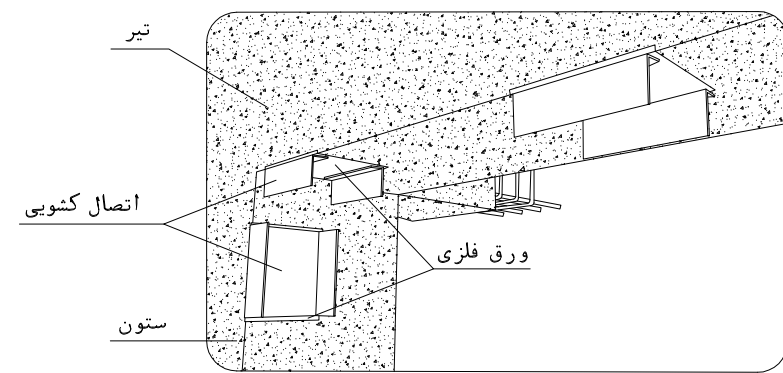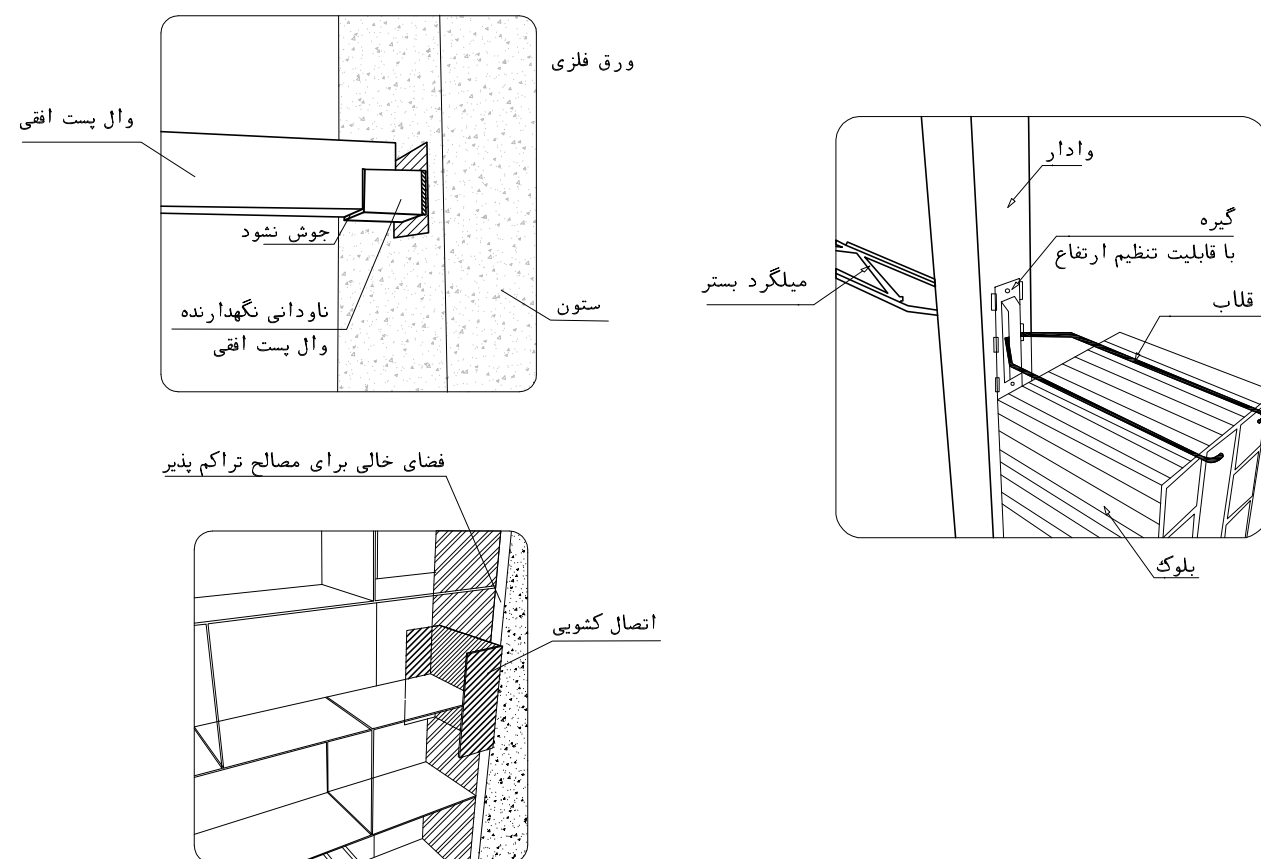 
 
 
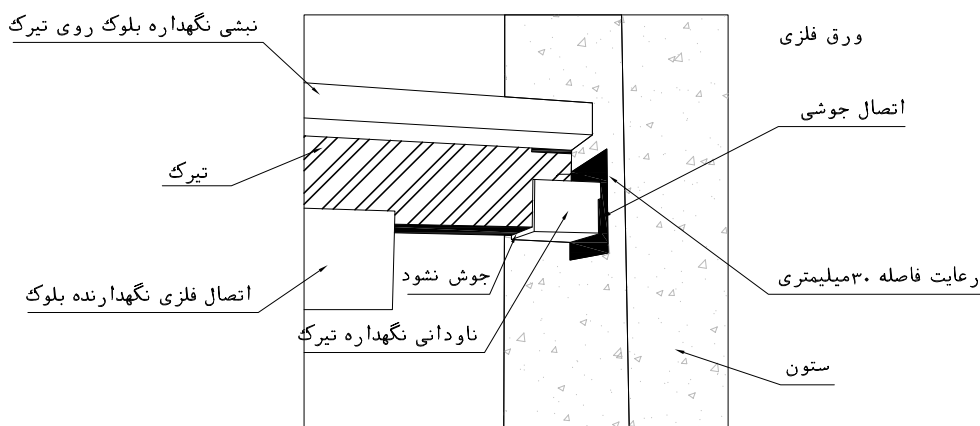


LEGEND			
	BRICK WORK		BRICK FACING
	REINFORCED CONCRETE		GRAVEL
	TERRAZZO TILE		LEAN CONCRETE
	GYPSUM BOARD		BLOCKAGE
	BRICK FACING		SAND CEMENT MORTAR
	PAINTED ALUMINUM STRIP (DUMPA)		
	CERAMIC TILES (30x30)		

F.F.L.	FINISHED FLOOR LEVEL
T.O.WA.	TOP OF WALKWAY
T.O.P.	TOP OF PARAPET
B.O.D.	BOTTOM OF DOOR
T.O.W.	TOP OF WINDOW
B.O.W.	BOTTOM OF WINDOW
T.O.S.	TOP OF SLAB
T.O.D.	TOP OF DOOR
T.O.CA.	TOP OF CAGE
B.O.CA.	BOTTOM OF CAGE
B.O.O.	BOTTOM OF OPENING
B.O.S.	BOTTOM OF SUSPENDED CEILING

REFERENCE DRAWING	DRG. No.
STANDARD DRAWING FOR ARCHITECTURAL DETAILS	BK-GNRL-PEDCO-000-AR-DW-0001
STANDARD DETAILS FOR LADDER & SAFETY CAGE	BK-GNRL-PEDCO-000-ST-DW-0009
FOUNDATION DRAWING FOR SECURITY BUILDING FOR WELLS PADS - BK-14	BK-BK14-PEDCO-110-ST-DW-0002
STRUCTURAL DRAWING FOR SECURITY BUILDING FOR WELLS PADS - BK-14	BK-BK14-PEDCO-110-ST-DW-0003
HVAC SYSTEM LAYOUT FOR SECURITY BUILDING - BK1	BK-BK14-PEDCO-110-HV-PY-0004
PLUMBING & SEWAGE PIPING LAYOUT FOR SECURITY BUILDING - BK14	BK-BK14-PEDCO-110-HV-PY-0004
LIGHTING & SMALL POWER LAYOUT FOR SECURITY BUILDING FOR WELLS PADS - BK14	BK-SSGR-PEDCO-110-EL-PY-0005

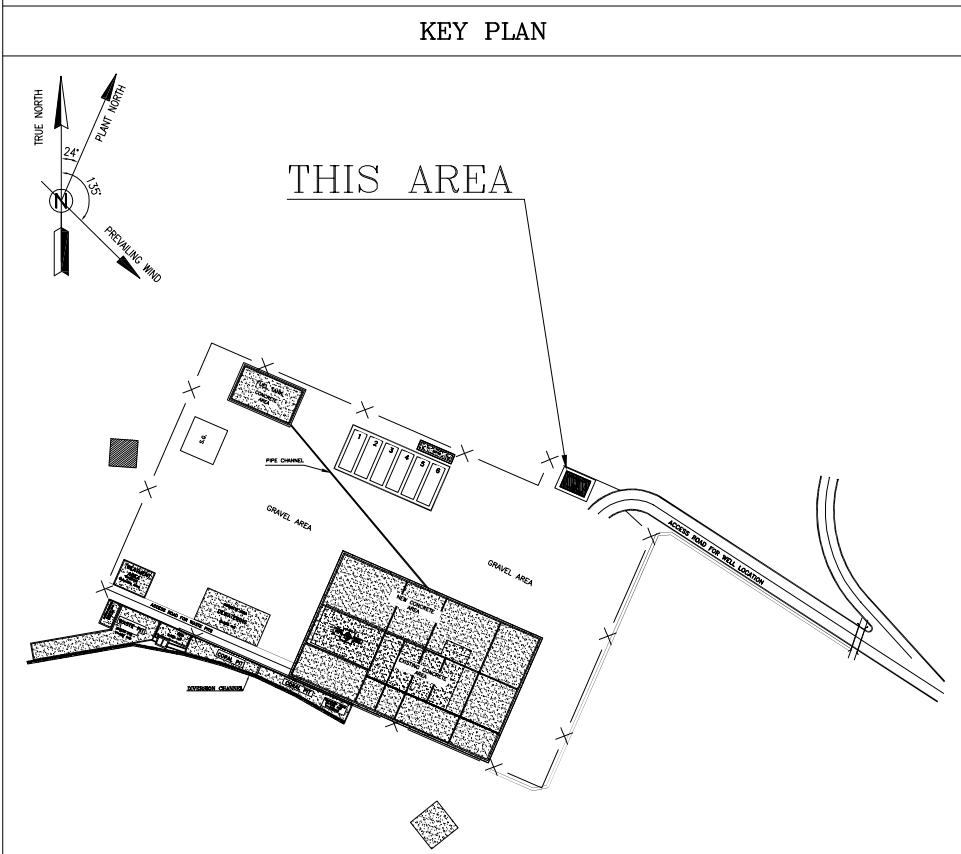[illegible]

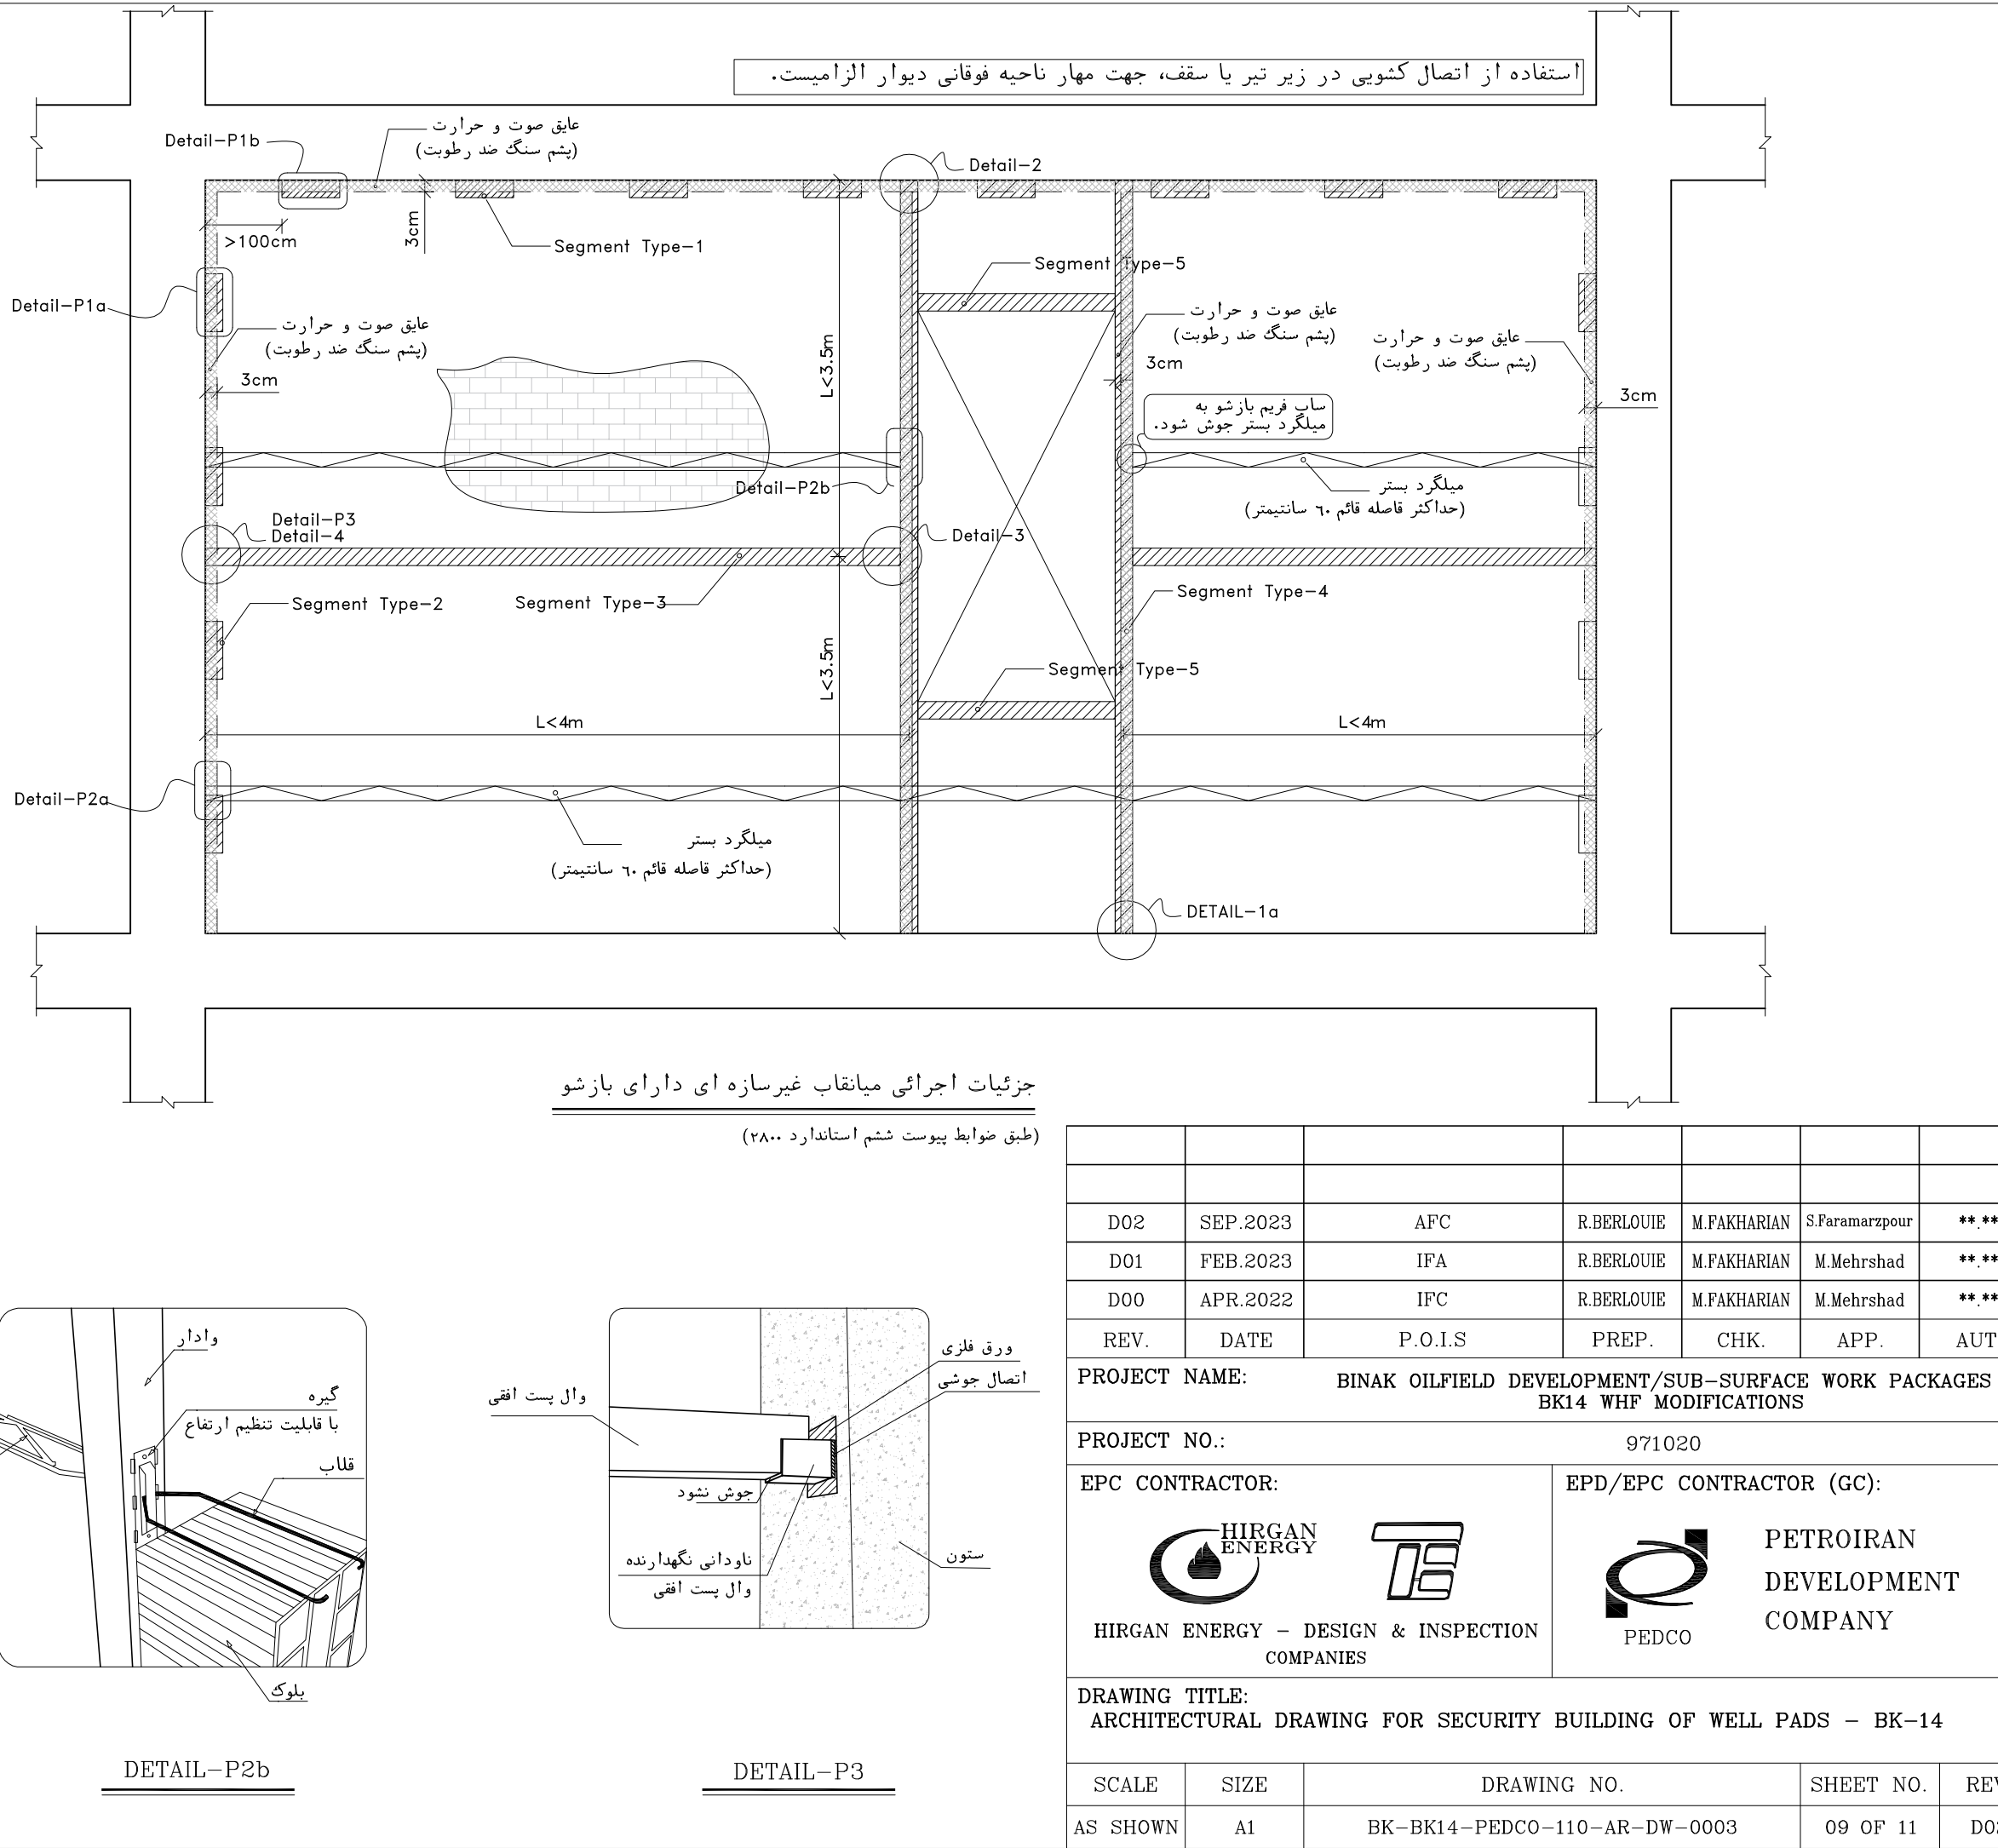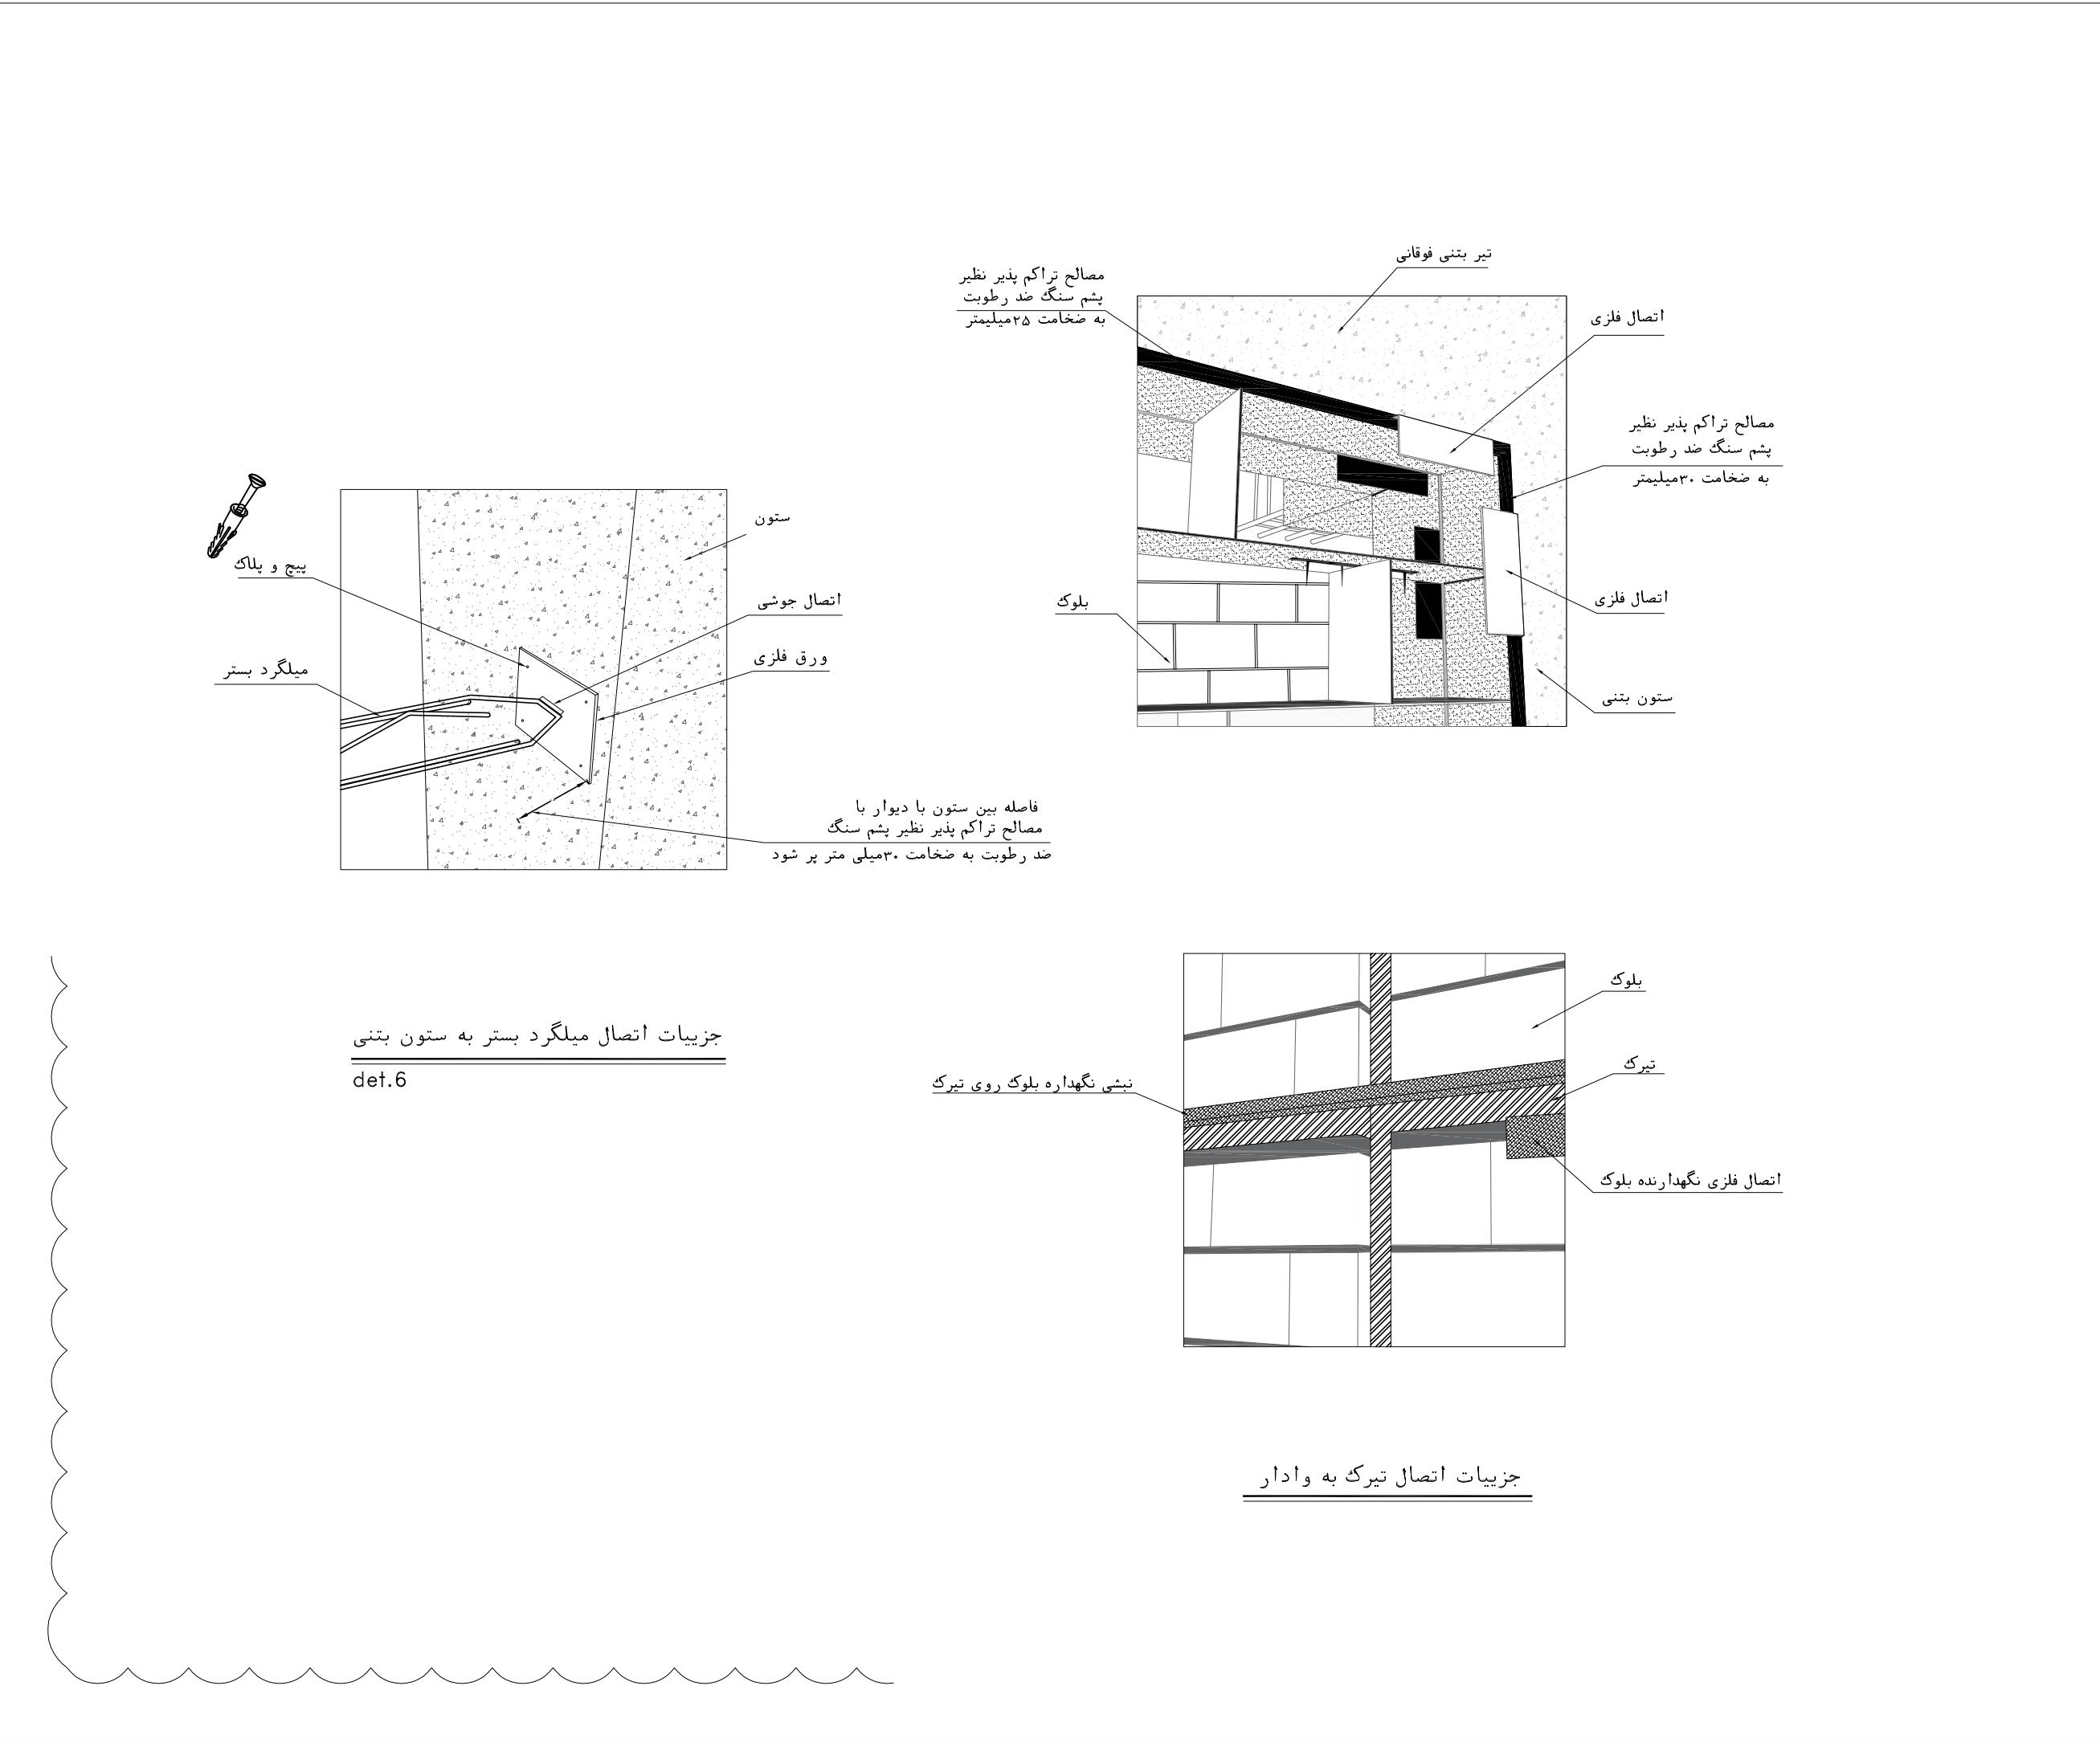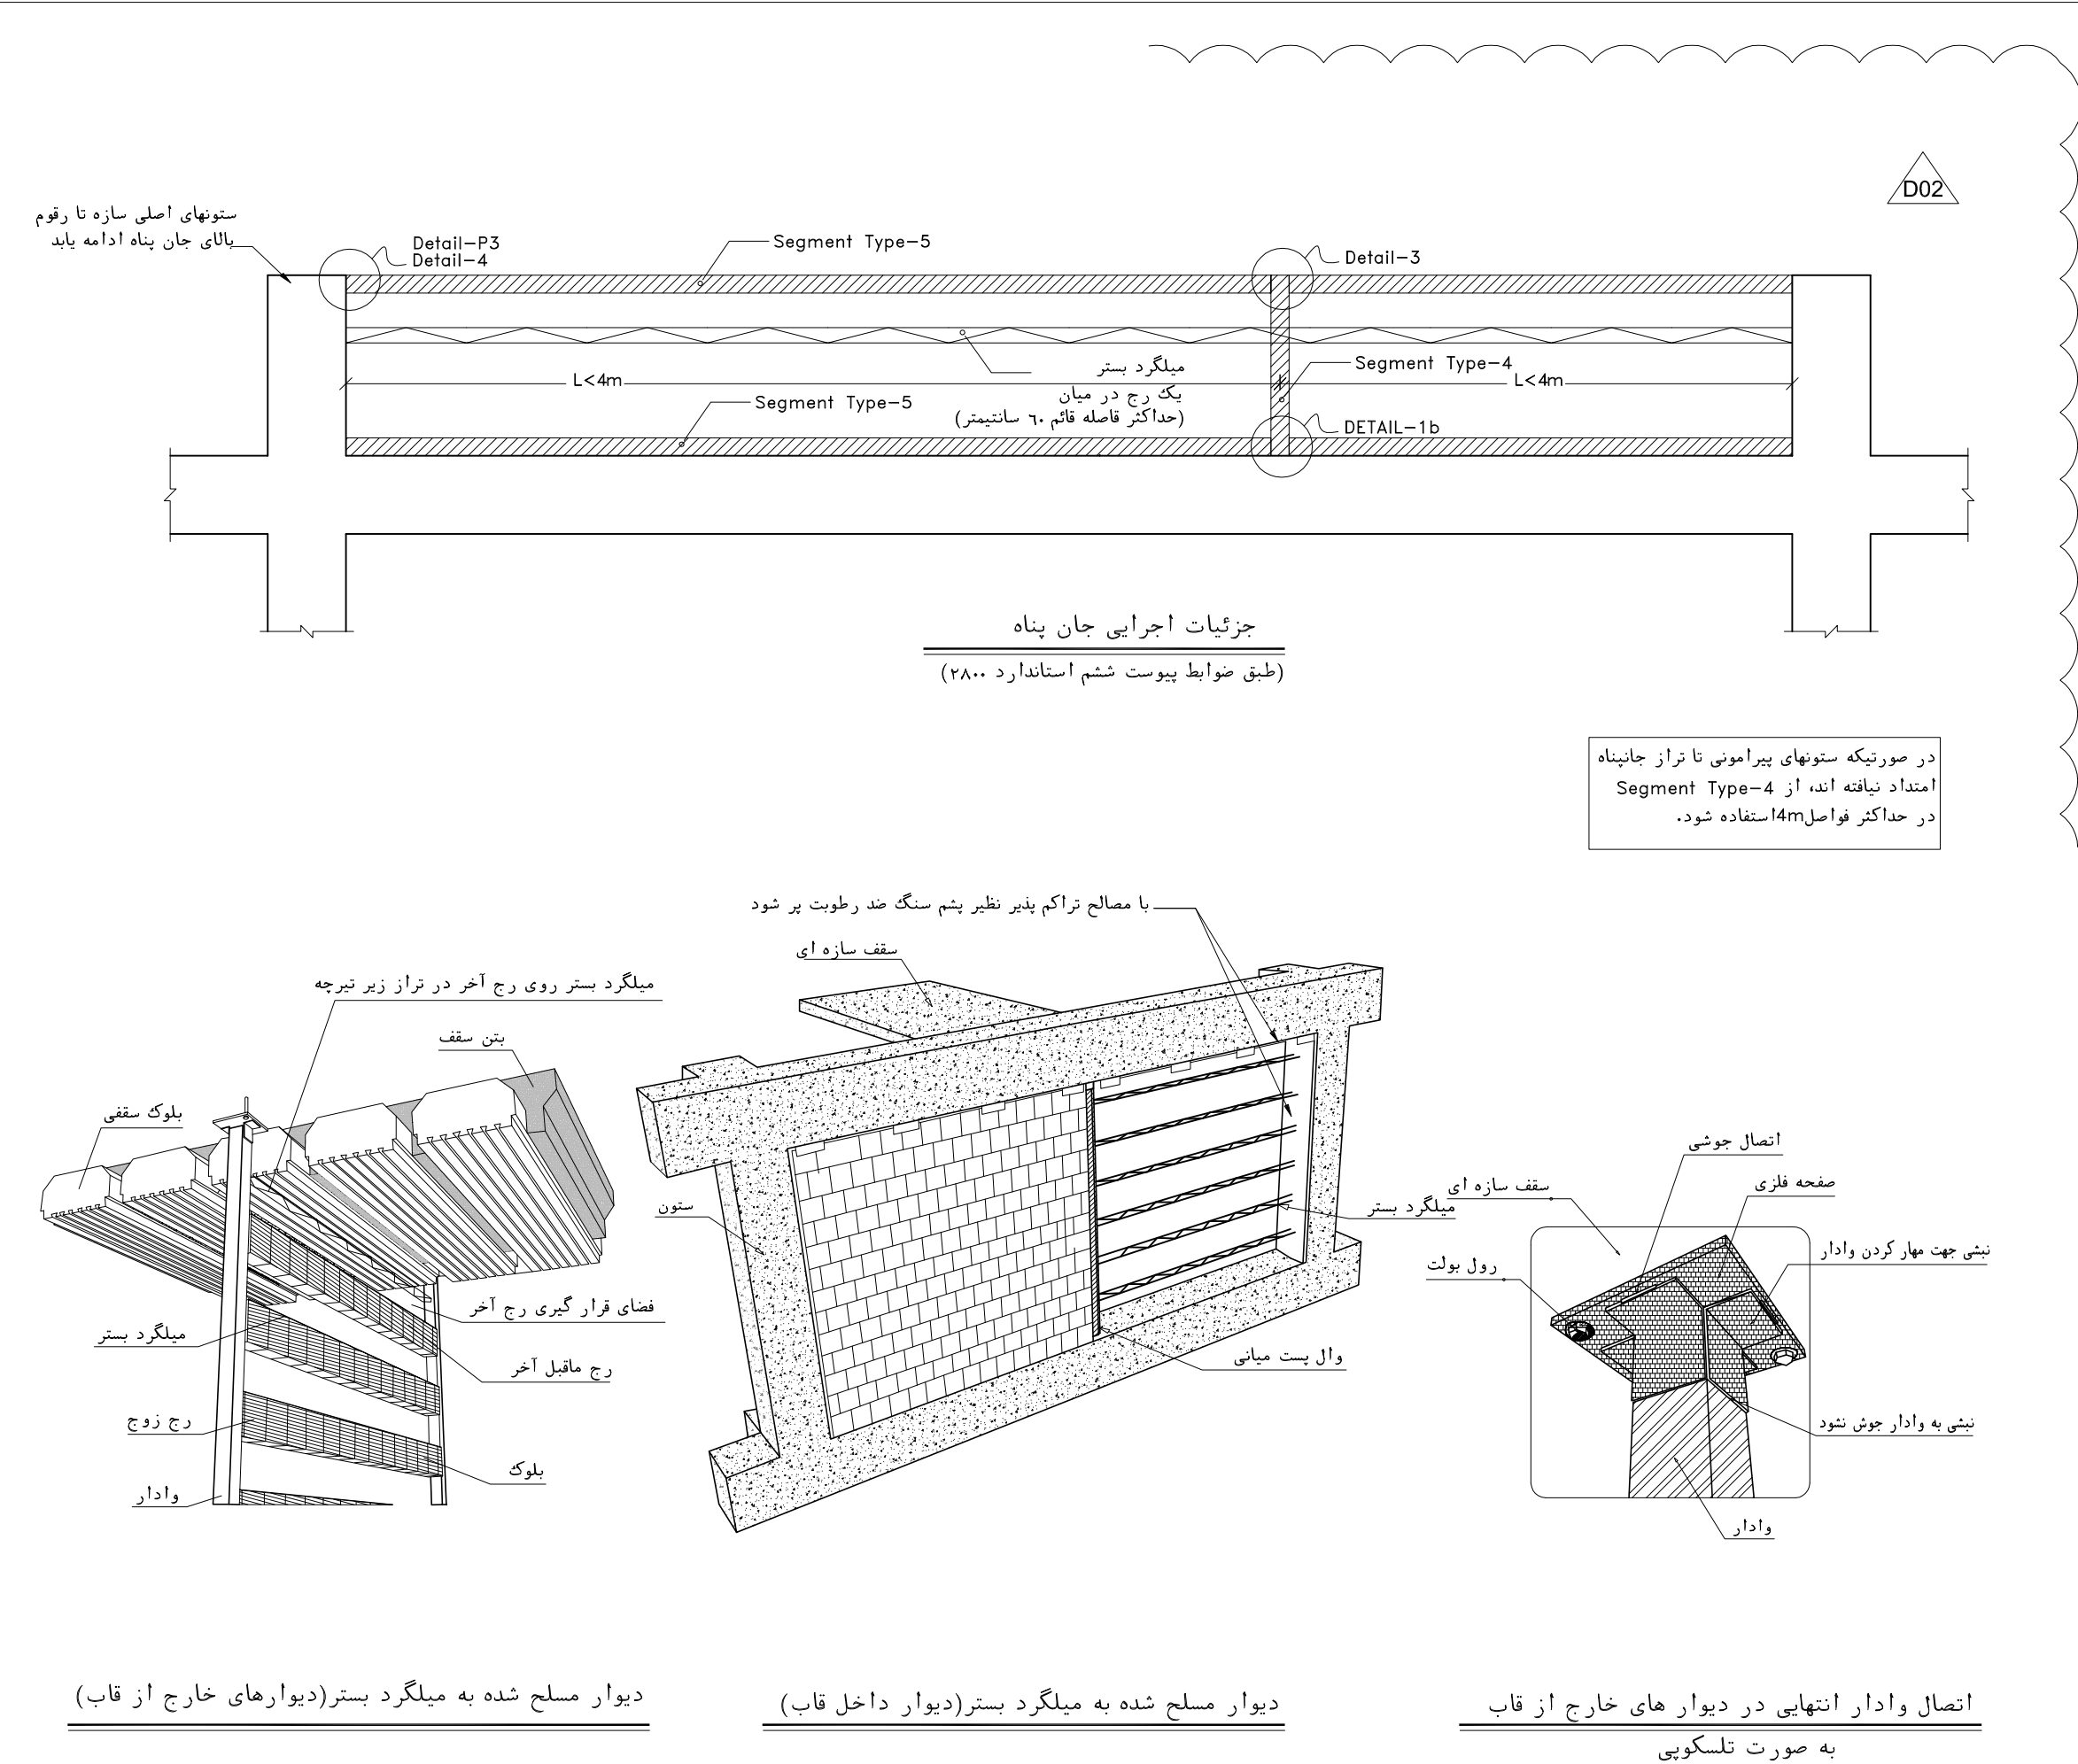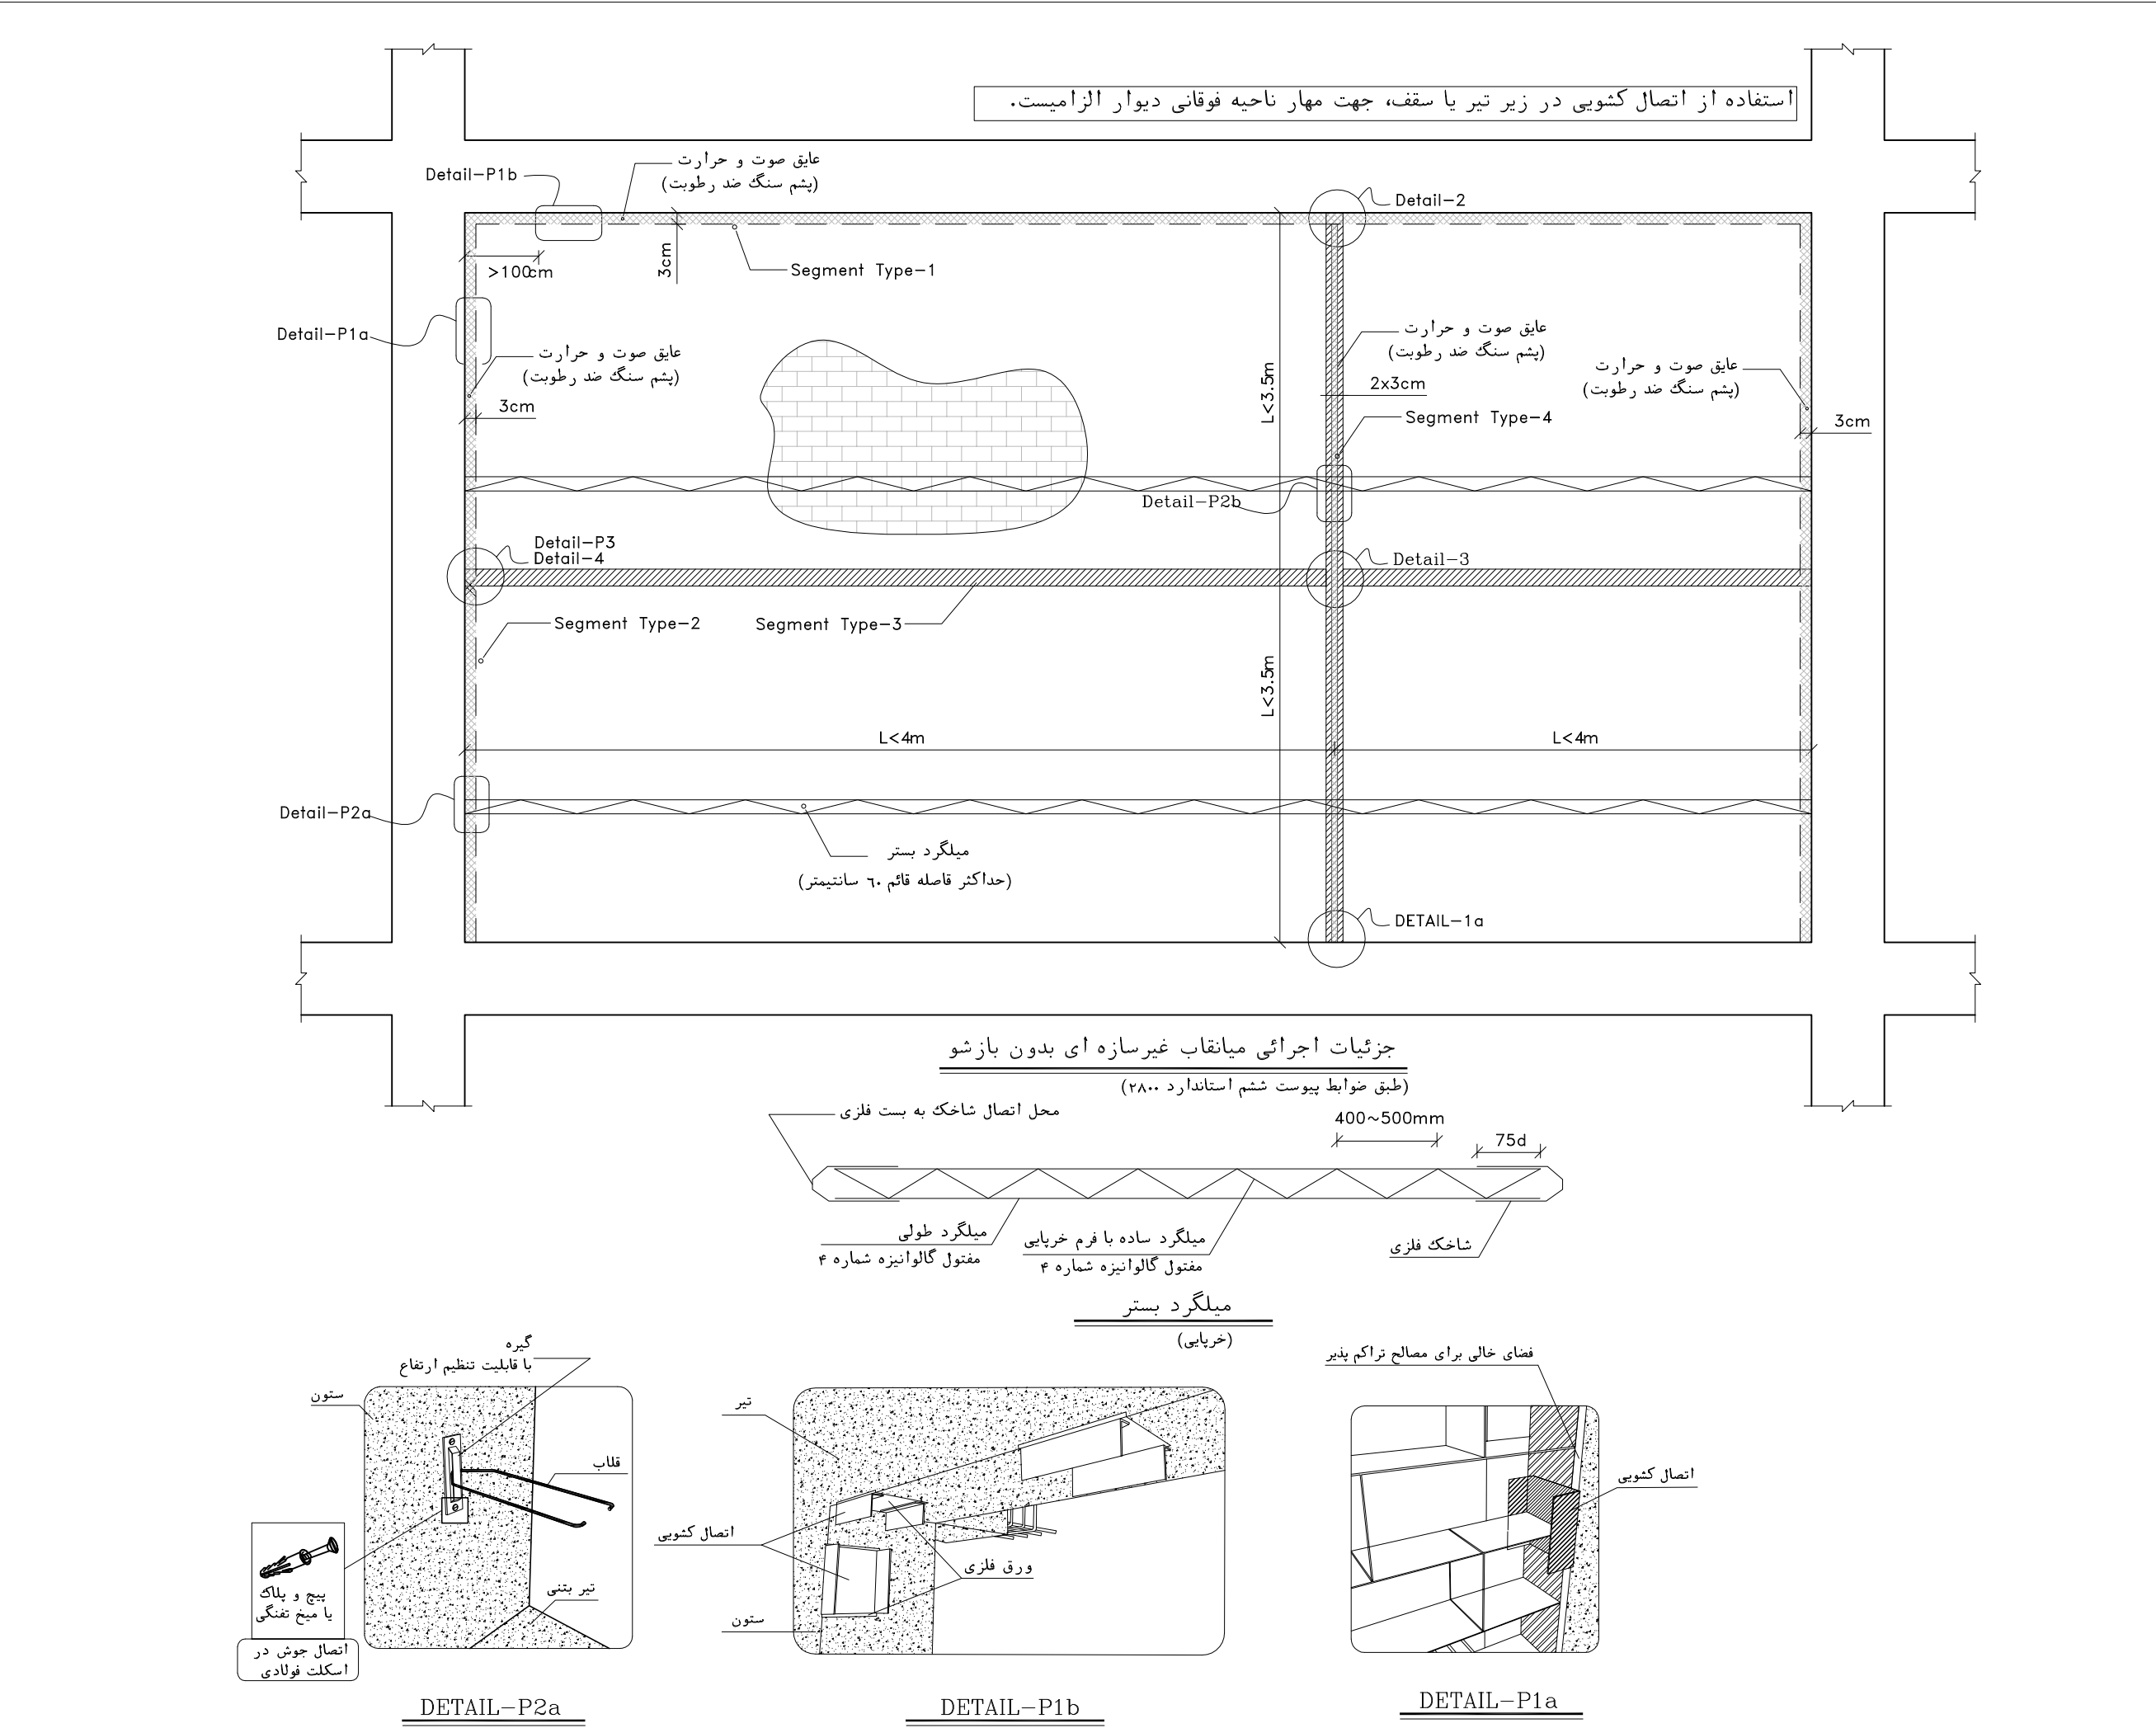

NOTES	
1- DIMENSIONS ARE IN "mm" AND ELEVATIONS IN "m" UNLESS SPECIFIED .	
2- ALL DIMENSIONS AND ELEVATIONS SHALL BE CHECKED BY THE CONTRACTOR PRIOR TO CONSTRUCTION.	
3- CONTRACTOR SHALL COMPARE ALL ARCHITECTURAL, MECHANICAL, ELECTRICAL, PIPING AND STRUCTURAL DRAWINGS AND IN CASE OF ANY CONFLICTS OR DISCREPANCY, INFORM THE ENGINEER.	
4- SLAB ON GRADE SHALL BE CONSTRUCTED AFTER EXECUTION OF CABLE TRENCH & EQUIPMENTS FOUNDATION.	
5- ALL MATERIALS ARE SELECTED FROM THE HIGHEST QUALITY AND SHALL BE APPROVED BY THE CLIENT.	
6- FOR COORDINATE REFER TO FINISH GRADING DOCUMENTS.	
7- FINISH GRADING LEVEL (BK14) ELEVATION : +185.55 m (GLOBAL) = ±0.00 (LOCAL)	
8- ALL EXTERNAL OPENINGS (WINDOWS AND DOORS) SHALL BE FIRE PROOF.	
9- DOUBLE GLAZED WINDOW WITH 2*6mm REINFORCED GLASS AND 6mm GAS FILLED GAP.	
10- WC DOORS SHALL BE WATERPROOF ABS TYPE WITH CLOSER MECHANISM.	
11- KNAUF GYPSUM BOARD TILES (60*60) cm (REGULAR 9.5 mm THICKNESS) WITH (1063).	
12- KNAUF PVC-COATED GYPSUM BOARD TILES (60*60)-(REGULAR 9.5mm THICKNESS) WITH (1063)-(PVC THICKNESS 0.35mm).	

LEGEND			
	BRICK WORK		BRICK FACING
	REINFORCED CONCRETE		GRAVEL
	TERRAZZO TILE		LEAN CONCRETE
	GYPSUM BOARD		BLOCKAGE
	BRICK FACING		SAND CEMENT MORTAR
	PAINTED ALMINUM STRIP (DUMPA)		
	CERAMIC TILES (30x30)		

F.F.L. FINISHED FLOOR LEVEL

T.O.W.A. TOP OF WALKWAY

T.O.P. TOP OF PARAPET

B.O.D. BOTTOM OF DOOR

T.O.W. TOP OF WINDOW

B.O.W. BOTTOM OF WINDOW

T.O.S. TOP OF SLAB

T.O.D. TOP OF DOOR

T.O.CA. TOP OF CAGE

B.O.CA. BOTTOM OF CAGE





B.O.O. BOTTOM OF OPENING

B.O.S. BOTTOM OF SUSPENDED CEILING

REFERENCE DRAWING	DRG. No.
STANDARD DRAWING FOR ARCHITECTURAL DETAILS	BK-GNRL-PEDCO-000-AR-DW-0001
STANDARD DETAILS FOR LADDER & SAFETY CAGE	BK-GNRL-PEDCO-000-ST-DW-0009
FOUNDATION DRAWING FOR SECURITY BUILDING FOR WELL PADS - BK-14	BK-BK14-PEDCO-110-ST-DW-0002
STRUCTURAL DRAWING FOR SECURITY BUILDING FOR WELL PADS - BK-14	BK-BK14-PEDCO-110-ST-DW-0003
HVAC SYSTEM LAYOUT FOR SECURITY BUILDING - BK14	BK-BK14-PEDCO-110-HV-PY-0002
PLUMBING & SEWAGE PIPING LAYOUT FOR SECURITY BUILDING - BK14	BK-BK14-PEDCO-110-HV-PY-0004
LIGHTING & SMALL POWER LAYOUT FOR SECURITY BUILDING OF WELL PADS	BK-SSGR-L-PEDCO-110-EL-PY-0005

KEY PLAN

***	*****	**	*** ****	***	*****
REV.	DESCRIPTION	BY	DATE	BY	DATE
		CHECKED		REV. APPR.	
اصل و کلیه نسخ این نقشه و حق اقتباس متعلق به شرکت ملی مناطق نفت خیز جنوب میباشد.					
THE ORIGINAL AND ALL COPIES OF THIS DRAWING TOGETHER WITH THE COPYRIGHT THEREIN ARE THE SOLE PROPERTY OF N.I.S.O.C./ FIELDS					
BINAK OILFIELD DEVELOPMENT SUB-SURFACE WORK PACKAGES BK14 WHF MODIFICATIONS					
DATE	SCALE	DRAWING BY	CHECKED BY	PROJECT ENG.	
NO CONSTRUCTION PERMITTED UNLESS DRAWING APPROVED					
APPROVED FOR CONSTRUCTION	BY:		DATE:		
BUDGET REF.	LOCATION	SIZE CLASS	SERIAL NO.	SHEET	REVISION
053-073-9184	F	4	B	708207	09 OF 11 D02

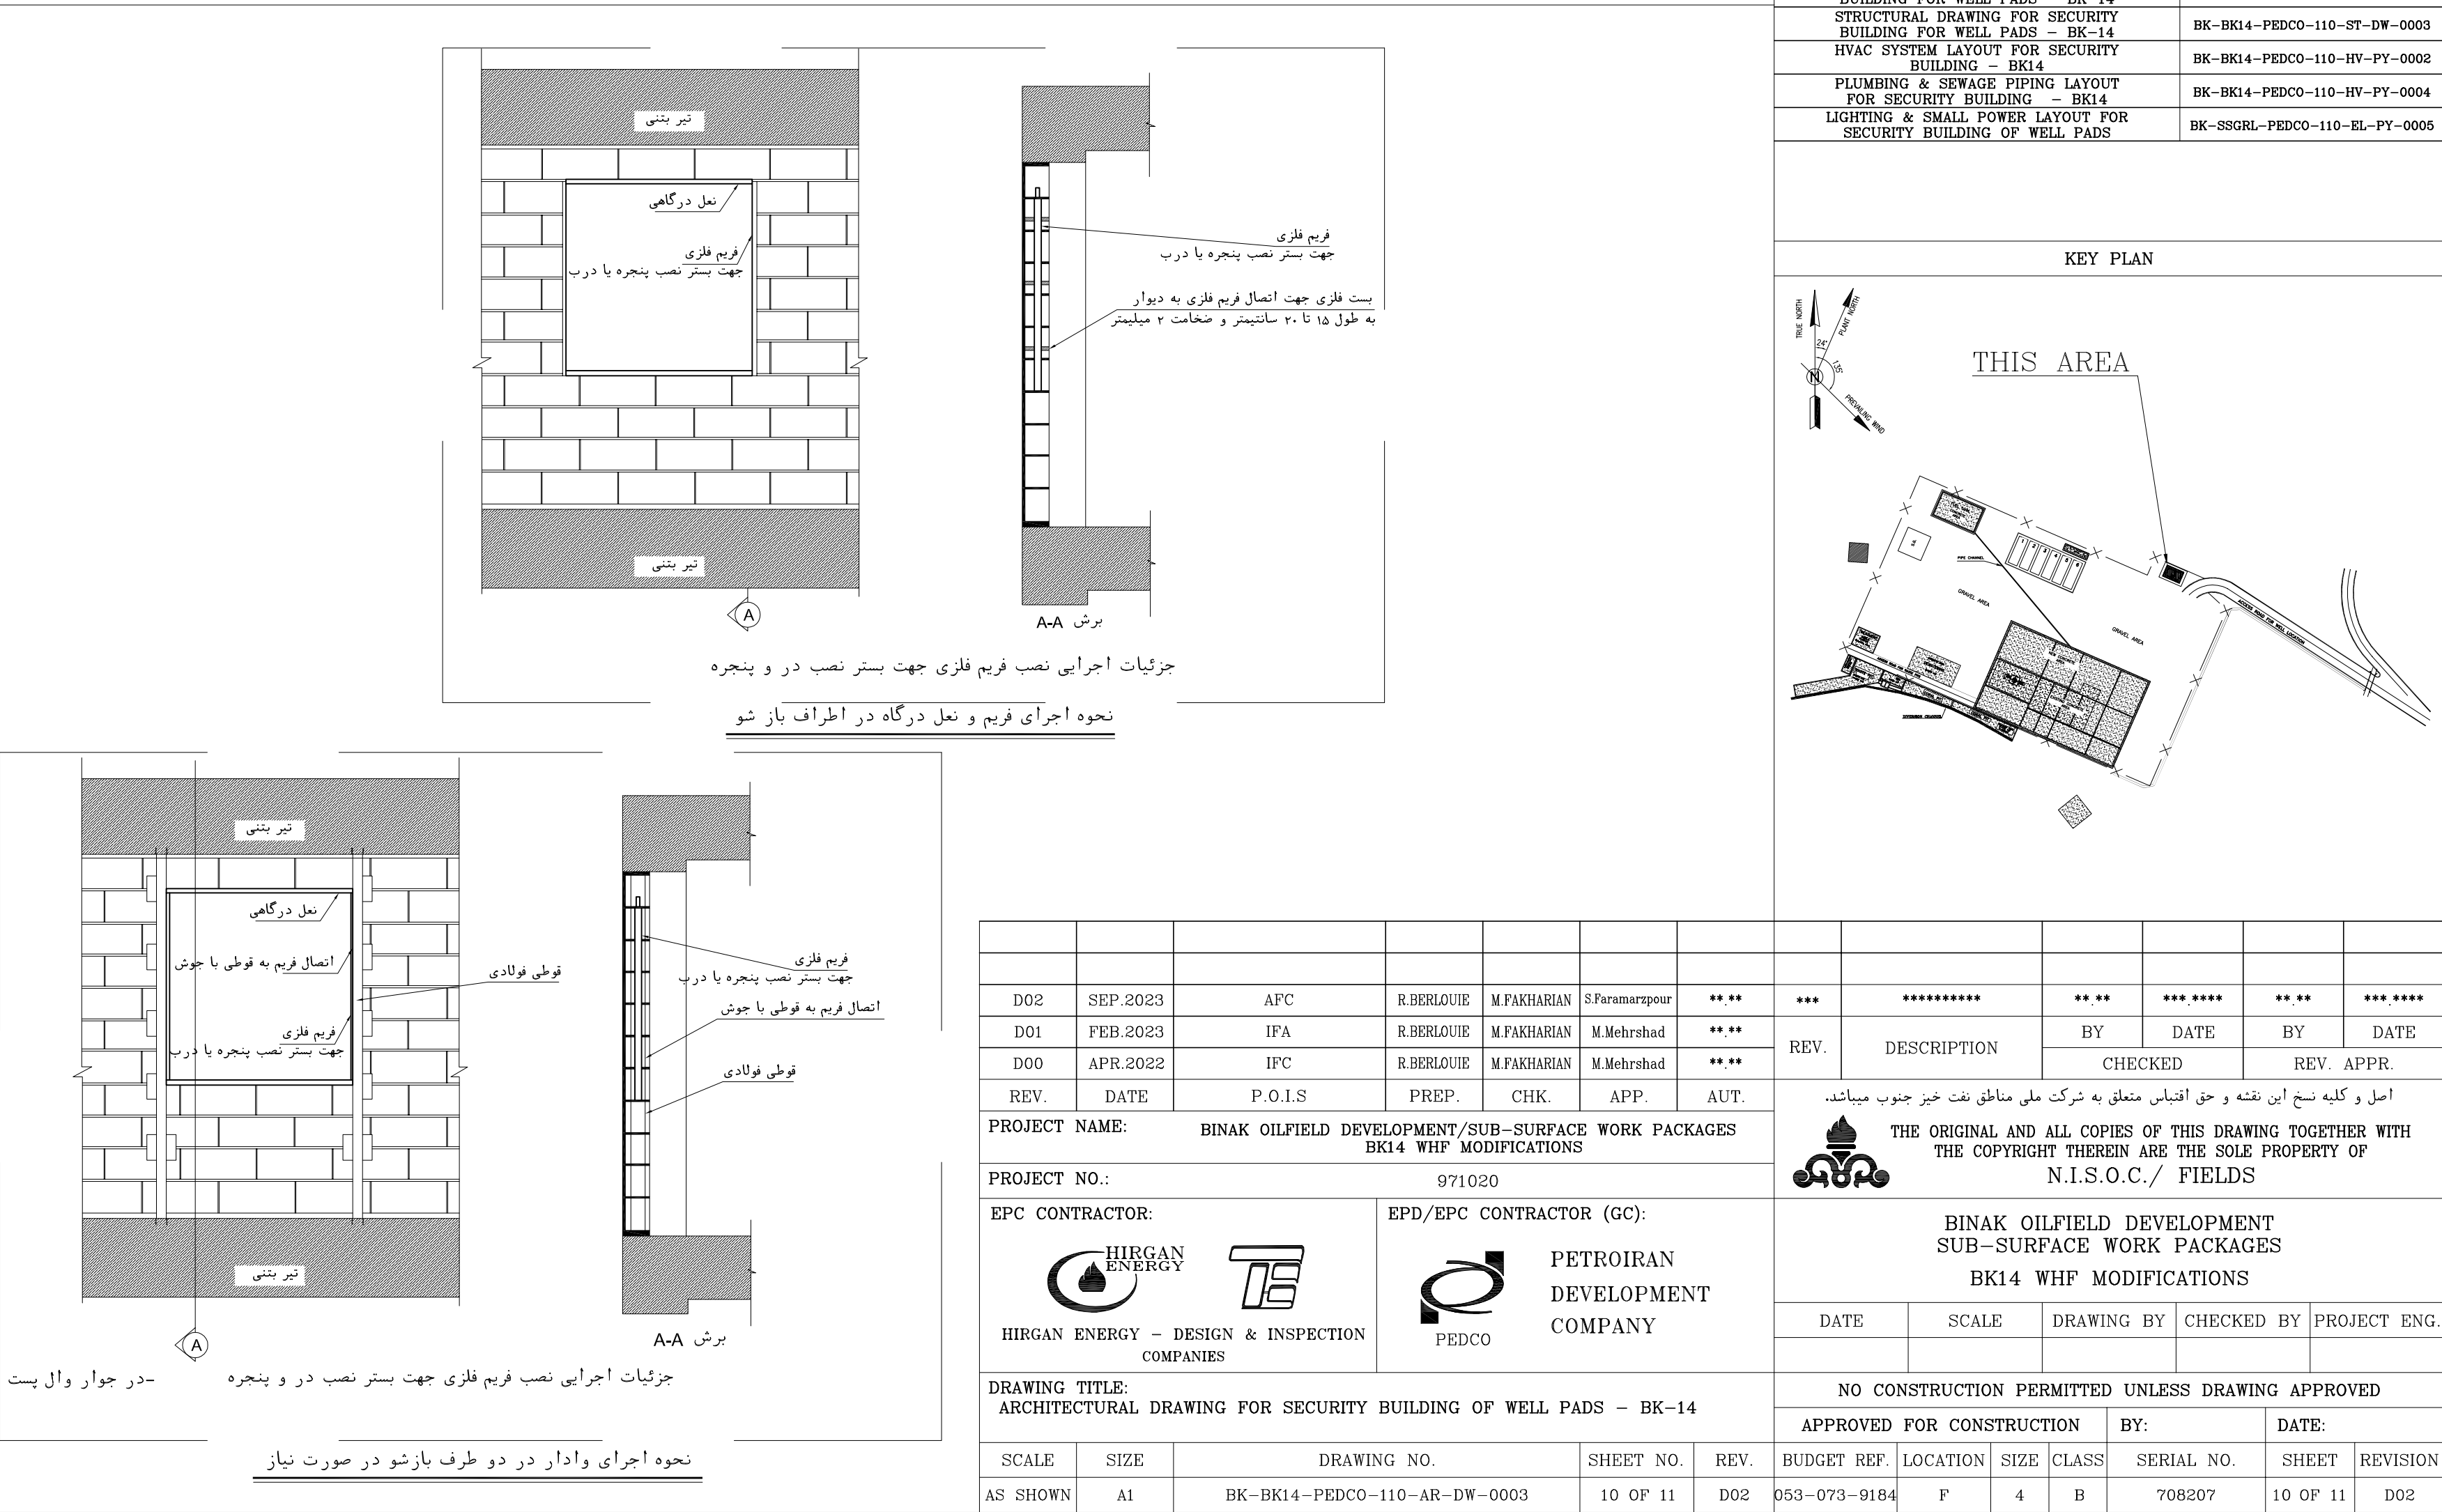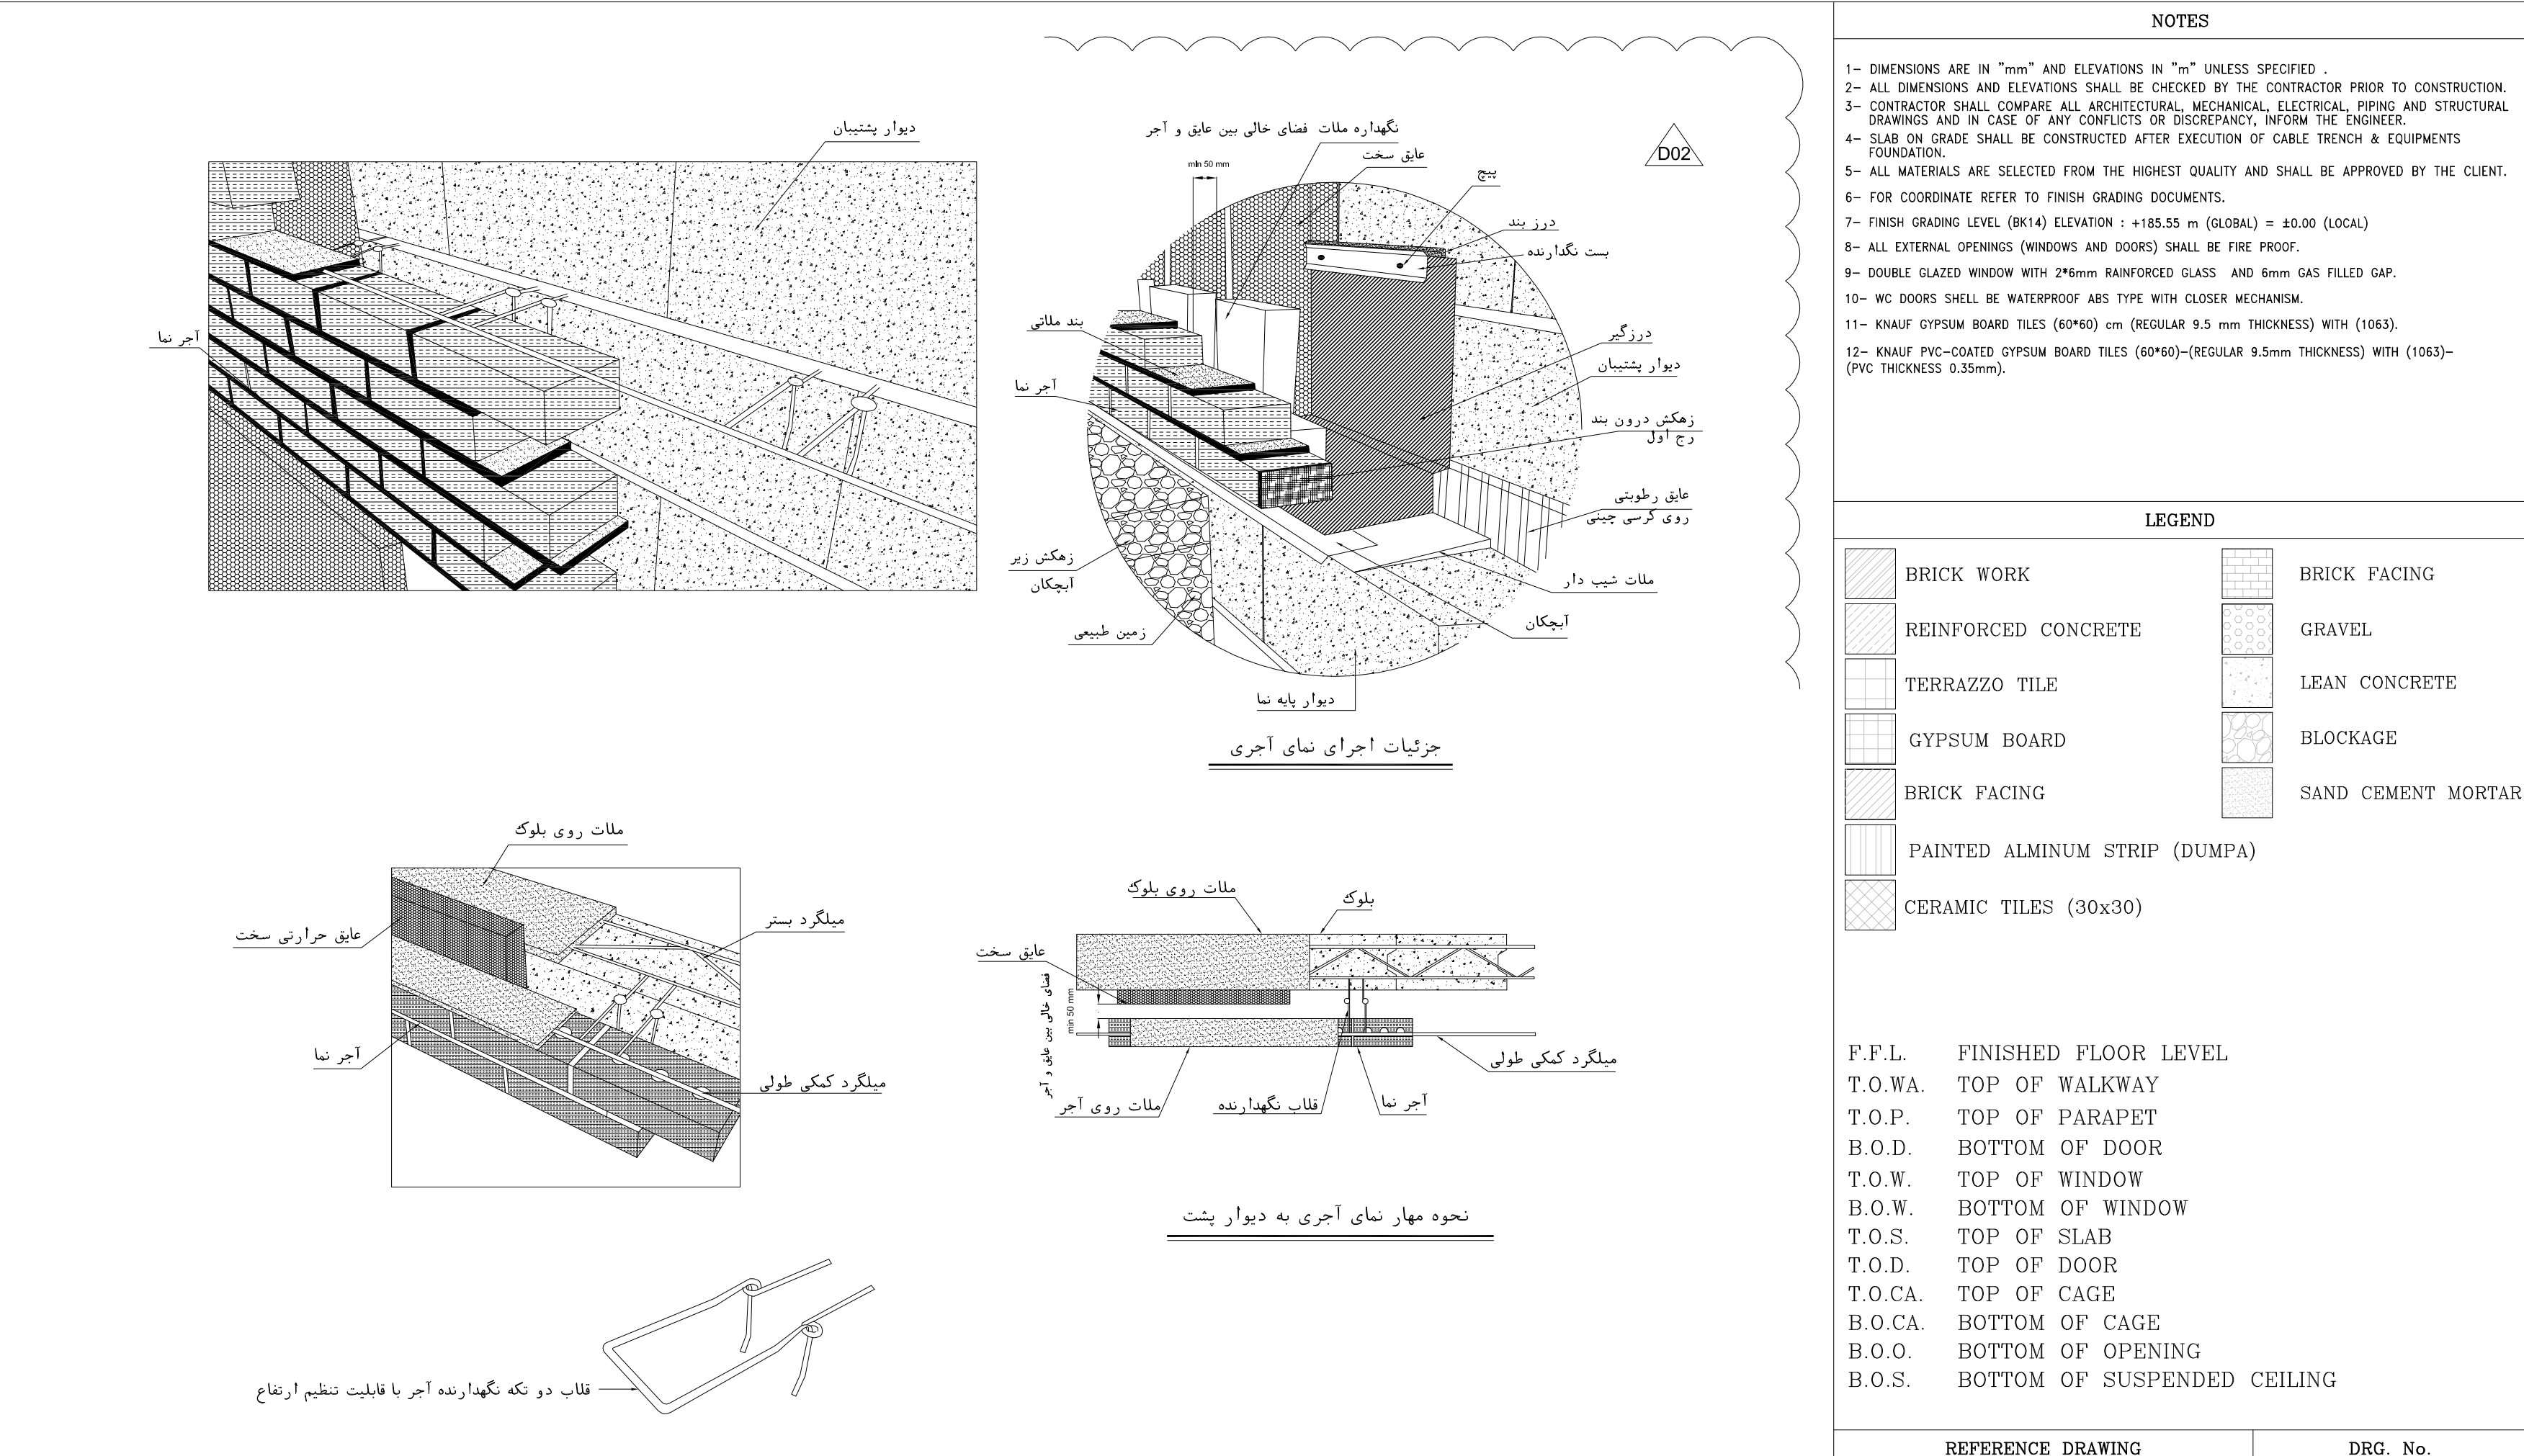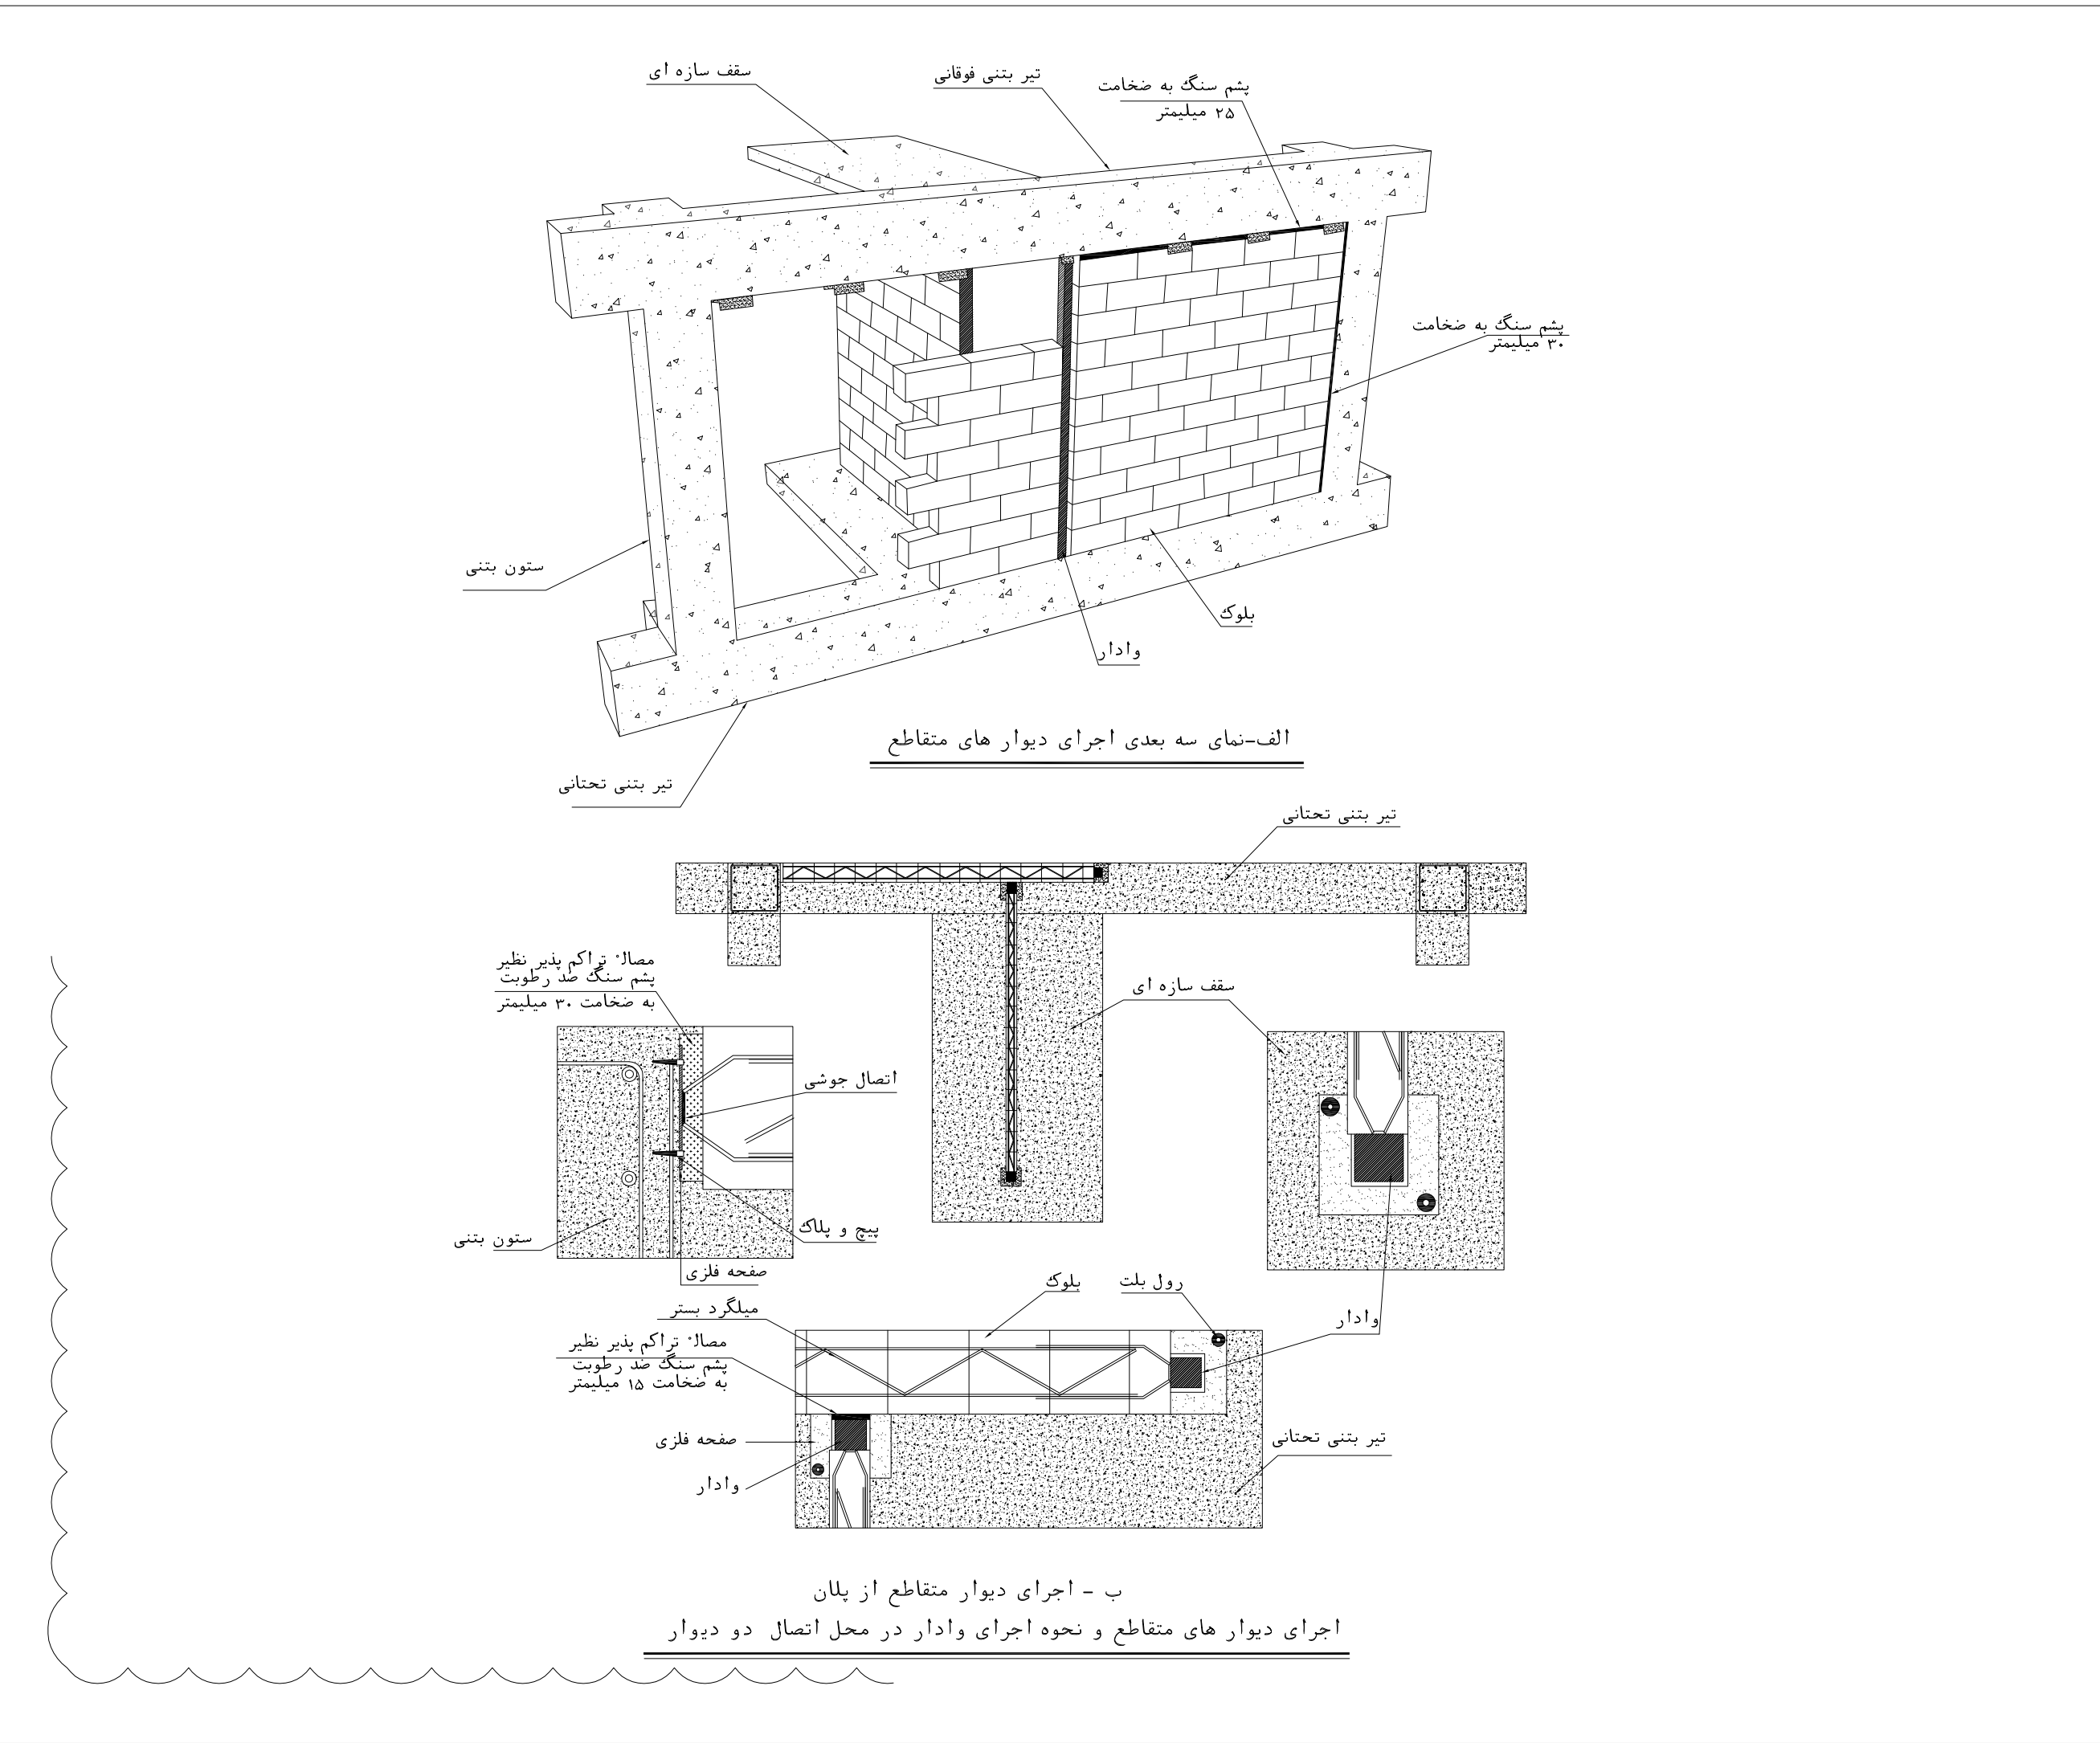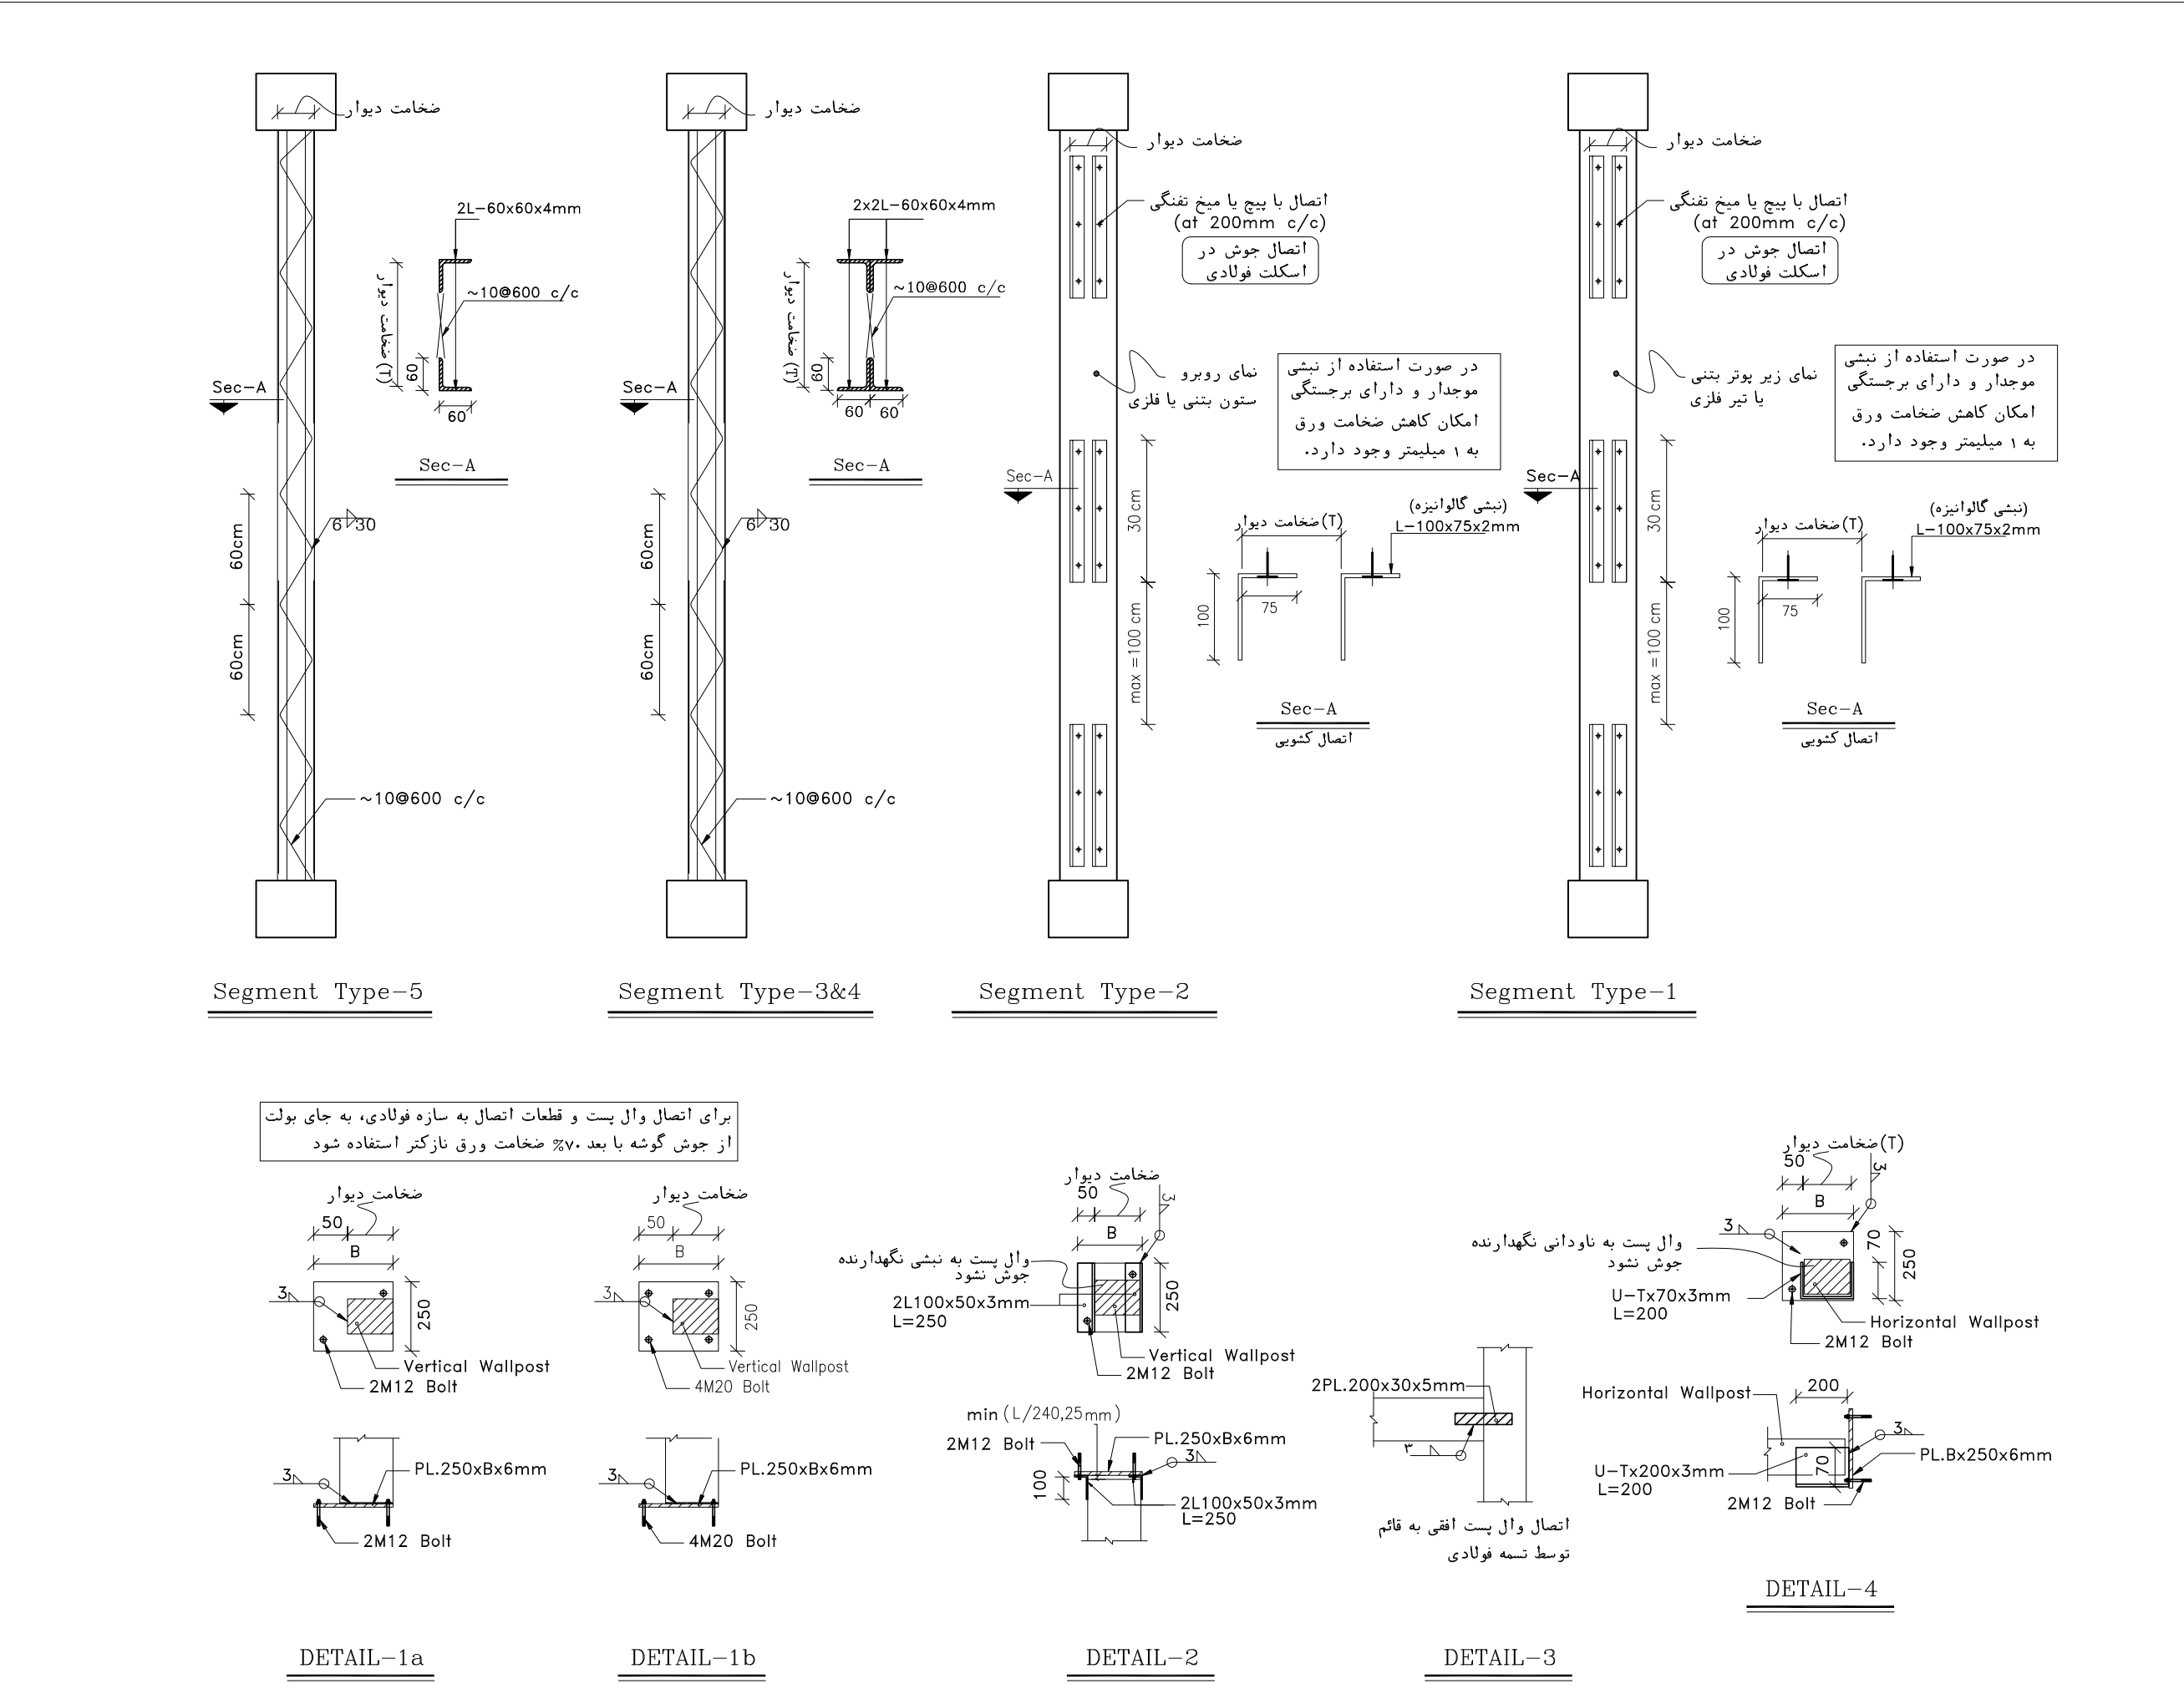

[illegible]